

SITE DATA		
NAME:	LAKE MYRA COUNTY PARK	
OWNER:	WAKE COUNTY	
DEVELOPER:	WAKE COUNTY	
CONTACT:	ERIC STAEHLE PLA, ASLA, SENIOR FACILITIES PROJECT MANAGER	
ADDRESS:	WAKE COUNTY OFFICE BUILDING, 11th FLOOR, RALEIGH, NC 27602	
PHONE NUMBER:	919.856.6369	
PROPERTY ADDRESS:	<u>WESTERN PARCEL:</u> 0 S SMITHFIELD ROAD	<u>EASTERN PARCEL:</u> 10505 POOLE ROAD
PARCEL ID NUMBER (PIN):	1763-51-9788	1763-84-1077
DEED BOOK AND PAGE:	DB: 12448, PG: 2075	DB: 12590, PG: 1251
ZONING DISTRICT:	WAKE COUNTY, ZONED R-40	WENDELL, ZONED R3
TOTAL LAND AREA:	91.81 ACRES	125.76 ACRES
PROPOSED DISTURBED AREA:	6.5 ACRES	12 ACRES
CURRENT USE:	UNDEVELOPED	UNDEVELOPED
PROPOSED USE:	PARK/RECREATION FACILITY	PARK/RECREATION FACILITY
EXISTING IMPERVIOUS AREA:		
PROPOSED IMPERVIOUS AREA:		
PROPOSED BUILDING:		
FLOOD INFORMATION:		
WATER AND SEWER SERVICE:		
ELECTRICAL SERVICE:		

Landscape Architect / Prime Consultant:
Susan Hatchell Landscape Architecture, PLLC
711 W. North Street
Raleigh, NC 27603
T: (919) 838-9600

Civil Engineer, Site Structural, and Surveyor:
NV5
3300 Regency Parkway, Suite 100
Cary, NC 27518

Architect:
Esse Architects
632 Pershing Road
Raleigh, NC 27608

Building Structural Engineer:
Lynch Mykins Structural Engineers, PC
301 N. West Street, Suite 105
Raleigh, NC 27603


MEP Engineer:
The Wooten Company
120 N Boylan Avenue
Raleigh, NC 27603

LAKE MYRA COUNTY PARK

EAST PARCEL SHELTER

Wake County, North Carolina

JULY 27, 2026 – CONSTRUCTION DOCUMENT SET

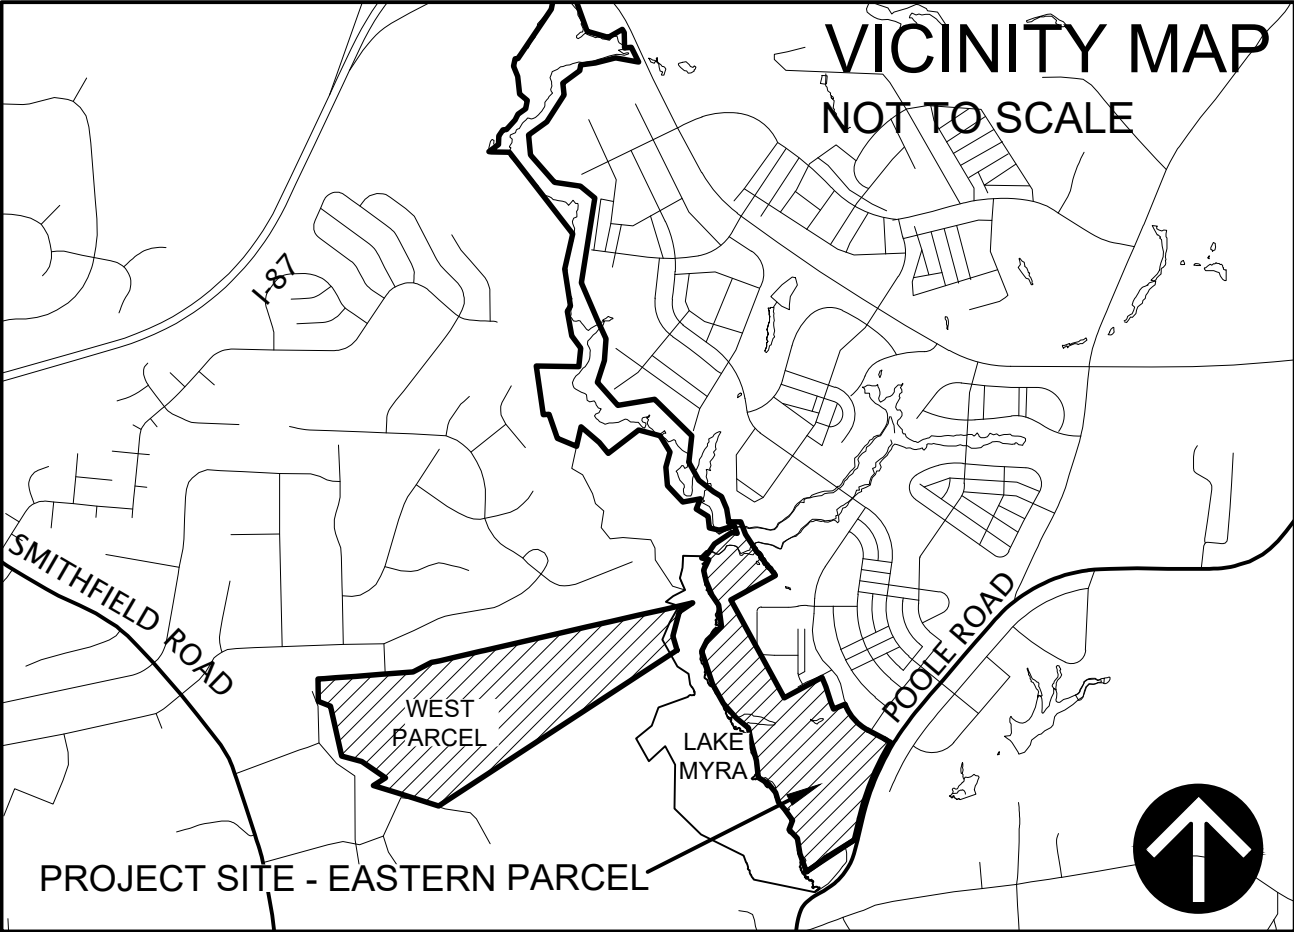

SHEET INDEX

COVER SHEET

ARCHITECTURE
ES-G001 – ABBREVIATIONS, SYMBOLS, AND GENERAL NOTES
ES-G101 – CODE SUMMARY
ES-A001 – PARTITIONS
ES-A101 – FLOOR PLANS
ES-A111 – REFLECTED CEILING AND ROOF PLANS
ES-A131 – FINISH PLAN, LEGEND & SCHEDULE
ES-A132 – SIGNAGE PLAN & DETAILS
ES-A201 – EXTERIOR ELEVATIONS
ES-A202 – EXTERIOR PANEL LAYOUT
ES-A203 – EXTERIOR PANEL LAYOUT
ES-A301 – BUILDING SECTIONS
ES-A400 – TYPICAL TOILET AND BATH ACCESSORIES
ES-A401 – ENLARGED TOILET PLANS AND ELEVATIONS
ES-A421 – WALL SECTIONS
ES-A422 – WALL SECTIONS
ES-A423 – WALL SECTIONS
ES-A501 – PLAN DETAILS
ES-A502 – BENCH DETAILS
ES-A505 – AIR BARRIER DETAILS
ES-A525 – ROOF DETAILS
ES-A526 – ROOF DETAILS
ES-A527 – ROOF DETAILS
ES-A601 – DOOR SCHEDULE

STRUCTURAL
ES-S001 – GENERAL NOTES
ES-S002 – GENERAL NOTES
ES-S003 – GENERAL NOTES
ES-S004 – GENERAL NOTES
ES-S101 – SHELTER A SLAB AND FOUNDATION PLANS
ES-S102 – SHELTER A AND B ROOF FRAMING PLAN
ES-S301 – SECTIONS
ES-S302 – SECTIONS
ES-S501 – TYPICAL DETAILS
ES-S502 – TYPICAL DETAILS
ES-S503 – TYPICAL DETAILS
ES-S504 – TYPICAL DETAILS

PLUMBING
ES-P001 – COVER SHEET
ES-P101 – FLOOR PLANS
ES-P700 – DETAILS

MECHANICAL
ES-M001 – COVER SHEET
ES-M101 – DUCTWORK PLANS
ES-M601 – DETAILS & SCHEDULES

ELECTRICAL
ES-E001 – COVER SHEET
ES-E101 – POWER AND LIGHTING PLANS
ES-E301 – RISERS
ES-E401 – DETAILS



Susan Hatchell
Landscape Architecture, PLLC


Esse Architects

lynchmykins
HOW **IMEG**

N|V|5 Delivering Solutions
Improving Lives

Wooten

AREA MAP

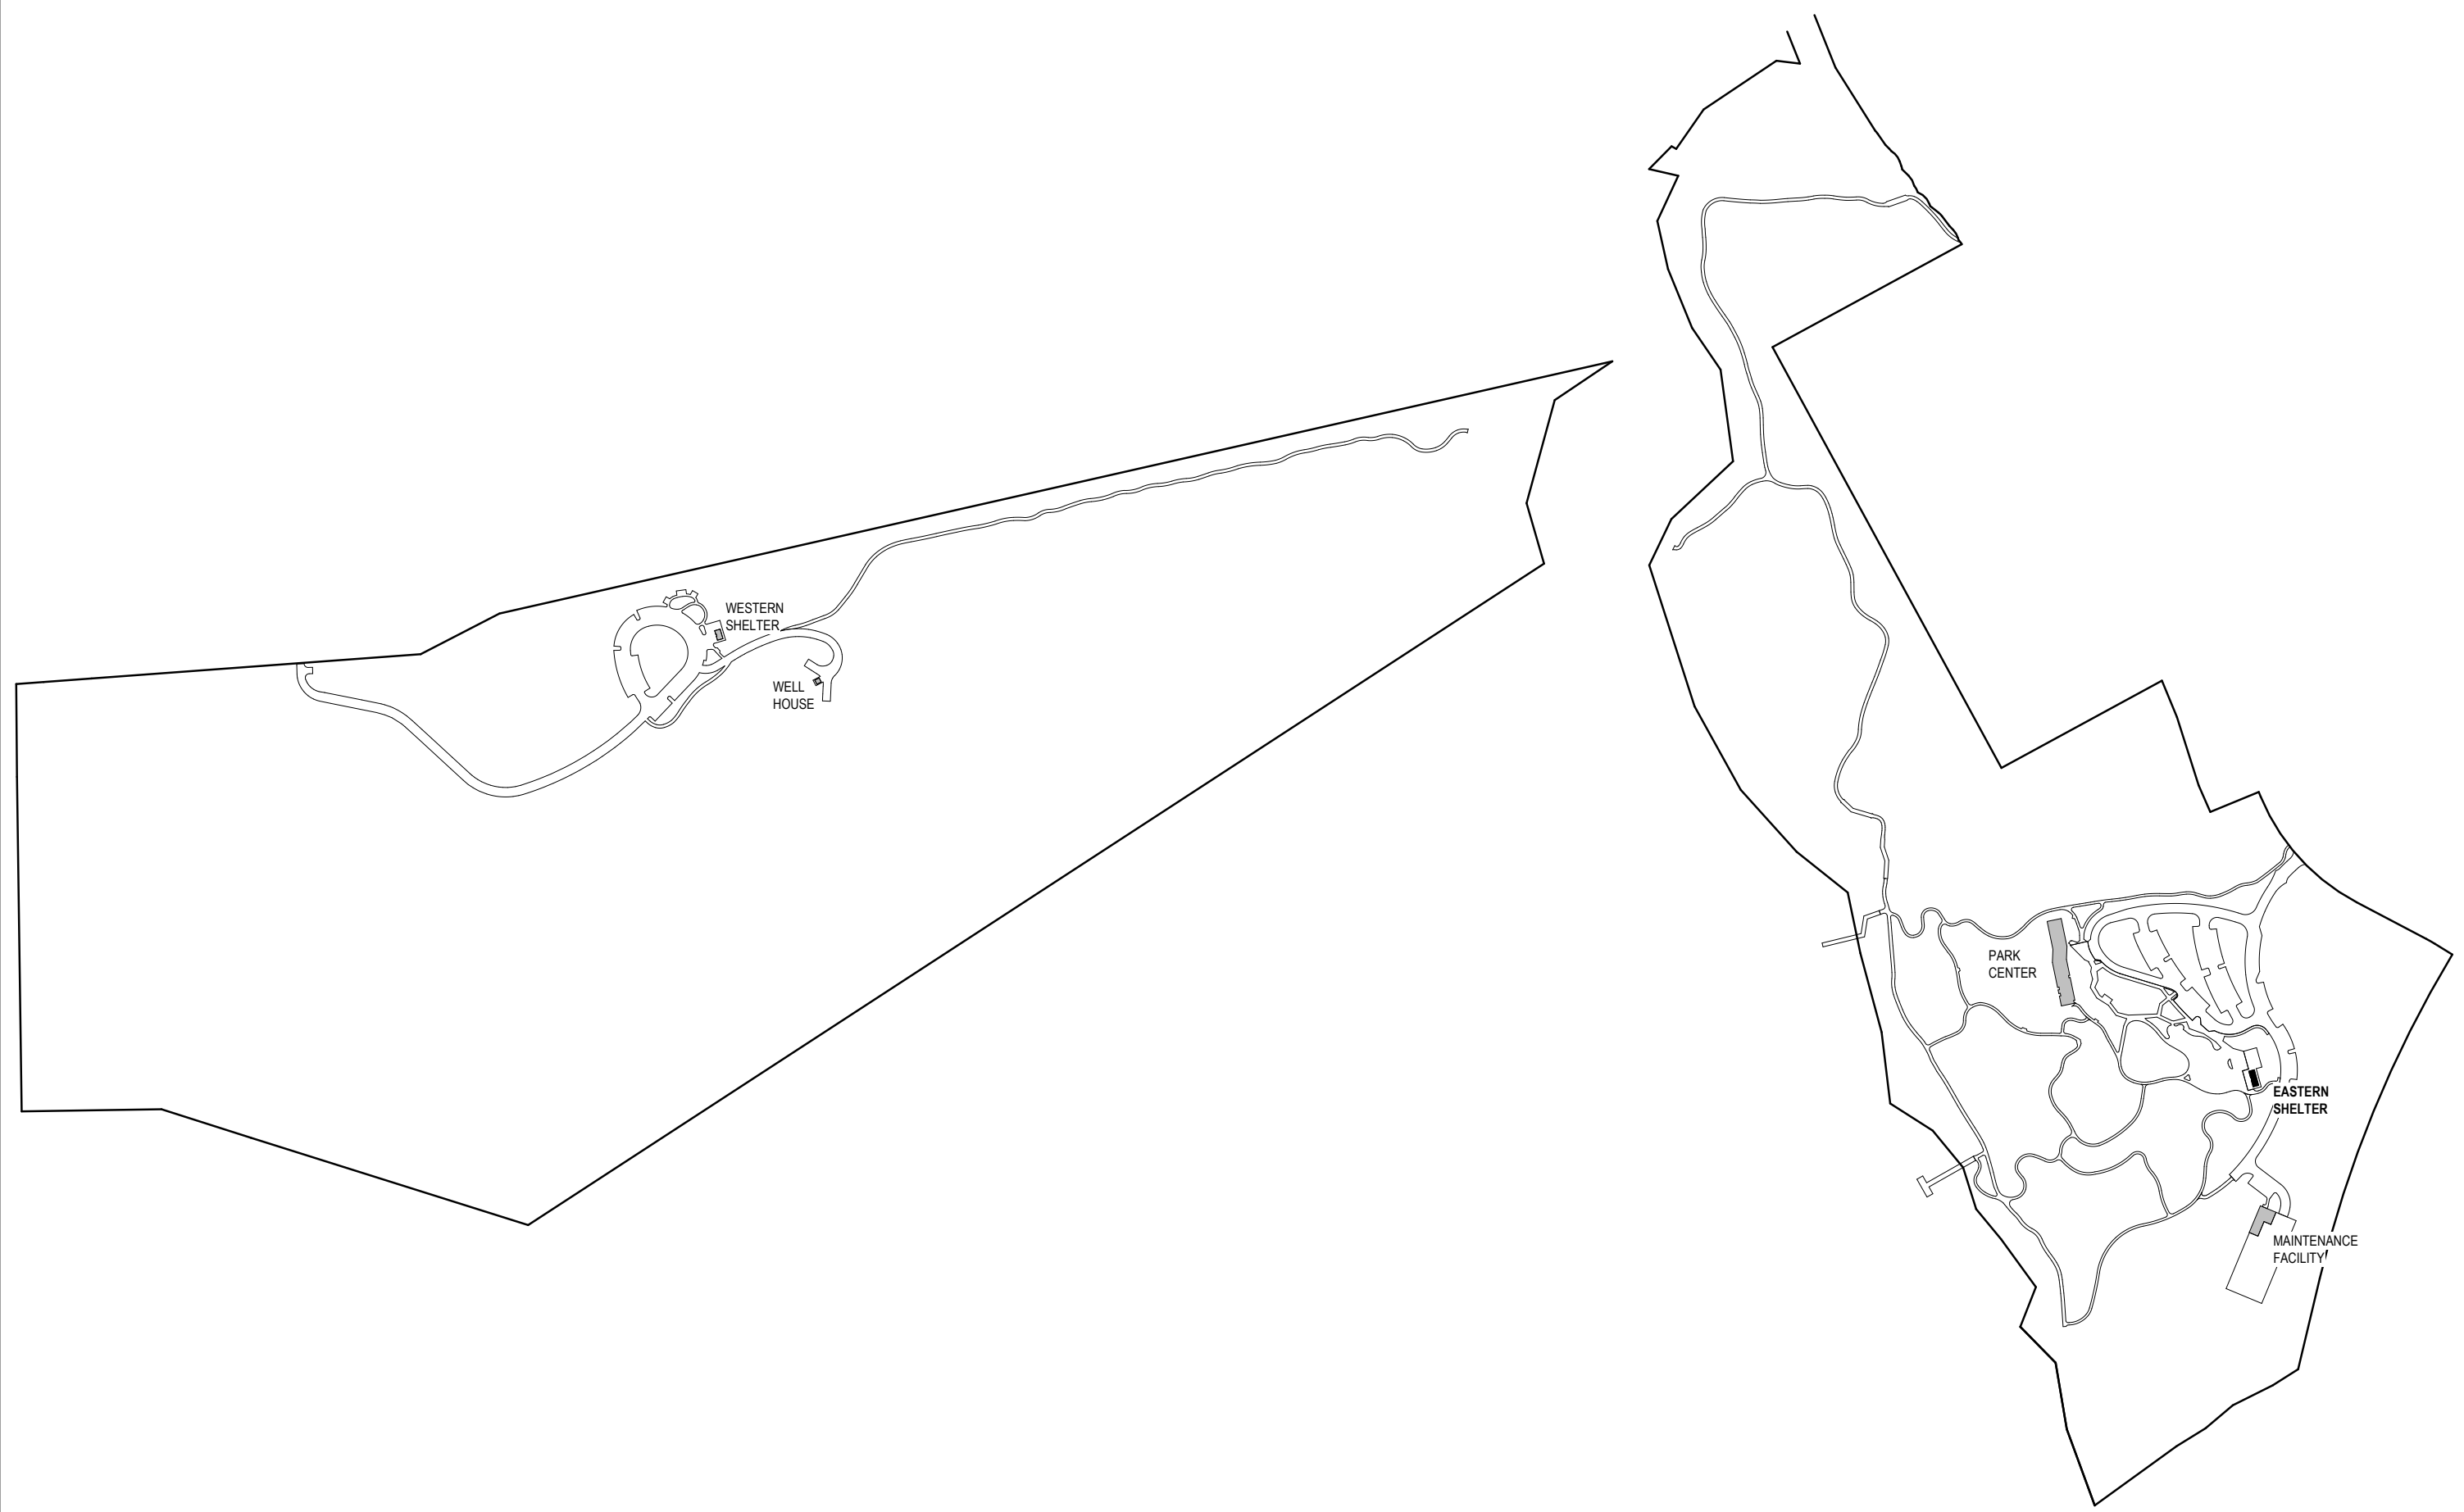

ABBREVIATIONS	
ABBR.	FULL DESCRIPTION
@	AT
A/C	AIR CONDITION(ER)ING)
AB	AIR BARRIER
ACC	ACCESSIBLE
ACM	ALUMINUM COMPOSITE MATERIAL
ADJ	ADJACENT
AFF	ABOVE FINISH FLOOR
AL	ALUMINUM
ALT	ALTERNATE
ARCH	ARCHITECT(URAL)
BD	BOARD
BFF	BELOW FINISH FLOOR
BLDG	BUILDING
BLKG	BLOCKING
BOS	BOTTOM OF STEEL
BRG	BEARING
CG	CORNERGUARD
CJ	CONTROL JOINT
CL	CENTERLINE
CLG	CEILING
CLR	CLEAR/CLEARANCE
CMU	CONCRETE MASONRY UNIT
COL	COLUMN
CONC	CONCRETE
CONT	CONTINUOUS
CPT	CARPET
CW	CURTAIN WALL
DEMO	DEMOLISH(ITION)
DF	DRINKING FOUNTAIN
DIA	DIAMETER
DIM	DIMENSION
DN	DOWN
DS	DOWNSPOUT
DTL	DETAIL
DWG	DRAWING
EA	EACH
EIFS	EXTERIOR INSULATION AND FINISH SYSTEM
ELEC	ELECTRICAL
EOD	EDGE OF DECK
EOS	EDGE OF STEEL
EQ	EQUAL
EW	ELECTRIC WATER COOLER
EXST	EXISTING
EXT	EXTERIOR
FD	FLOOR DRAIN
FE	FIRE EXTINGUISHER
FEC	FIRE EXTINGUISHER CABINET
FF	FINISH FLOOR
FIN	FINISH
FLR	FLOOR
FPRF	FIREPROOFING
FRT	FIRE RETARDANT TREATED
FT	FOOT/FEET

ABBREVIATIONS	
ABBR.	FULL DESCRIPTION
FV	FIELD VERIFY
GA	GAUGE
GALV	GALVANIZED
GC	GENERAL CONTRACTOR
GFRG	GLASS FIBER REINFORCED CONCRETE
GL	GLASS
GWB	GYPSUM WALLBOARD
GYP	GYPSUM
HGT	HEIGHT
HM	HOLLOW METAL
HR	HOOR
HVAC	HEATING, VENTILATION, AND AIR CONDITIONING
INFO	NFORMATION
INT	INTERIOR
JT	JOINT
LAV	LAVATORY
LB	POUND
LH	LEFT HAND
MAX	MAXIMUM
MECH	MECHANICAL
MFR	MANUFACTURER
MIN	MINIMUM
MISC	MISCELLANEOUS
MO	MASONRY OPENING
MTL	METAL
N	NORTH
NA	NOT APPLICABLE
NC	NON-COMBUSTIBLE
NCBC	NORTH CAROLINA STATE BUILDING CODE
NC	NOT IN CONTRACT
NO	NUMBER
NTS	NOT TO SCALE
OC	ON CENTER
OM	ORNAMENTAL METAL
OPP	OPPOSITE
PL	PLATE
PLAM	PLASTIC LAMINATE
PLBG	PLUMBING
PME	PLUMBING/MECHANICAL/ELECTRICAL
PT	PRESSURE-TREATED
PVC	POLYVINYL CHLORIDE
PWD	PLYWOOD
RCP	REFLECTED CEILING PLAN
RD	ROOF DRAIN
RDL	ROOF DRAIN LEADER
REF	REFRIGERATOR
REINF	REINFORCE(D)ING(MENT)
REQ	REQUIRED
RH	RIGHT HAND
RM	ROOM
RO	ROUGH OPENING
RTU	ROOF TOP UNIT
SCW	SOLID CORE WOOD

ABBREVIATIONS	
ABBR.	FULL DESCRIPTION
SF	SQUARE FOOT/FEET
SFT	STOREFRONT
SIM	SIMILAR
SPEC	SPECIFICATION
SPECS	SPECIFICATIONS
SQ	SQUARE
SS	STAINLESS STEEL
STD	STANDARD
STL	STEEL
SUSP	SUSPENDED
T&G	TONGUE AND GROOVE
THRU	THROUGH
TLT	TOILET
TOBB	TOP OF BOND BEAM
TOM	TOP OF MASONRY
TOP	TOP OF PARAPET
TOS	TOP OF STEEL
TSTAT	THERMOSTAT
TYP	TYPICAL
UL	UNDERWRITERS LABORATORY
UON	UNLESS OTHERWISE NOTED
VB	VAPOR BARRIER
VCT	VINYL COMPOSITION TILE
VIF	VERIFY IN FIELD
W/	WITH
W/I	WITHIN
W/O	WITHOUT
WC	WATER CLOSET
WD	WOOD
WT	WEIGHT
WWF	WELDED WIRE FABRIC

Susan Hatchell
Landscape Architecture, PLLC
711 W. North Street, Raleigh, NC 27603
p: 919-838-9600 f: 919-838-9700



ABBREVIATIONS,
SYMBOLS, AND
GENERAL NOTES

LAKE MYRA COUNTY PARK
Wake County, NC

REVISIONS

Date: 07/27/26

ES-G001

MATERIAL LEGEND


CMU	
BATT INSULATION	
WOOD	
BRICK	
STEEL	
GROUT, MORTAR, SAND, OR PRECAST	
ALUMINUM	
CONCRETE	
CARPET	
SOIL FILL	
ROCK FILL	
GYPSUM BOARD	
RIGID INSULATION	
PLYWOOD	
WOOD BLOCKING (CONTINUOUS)	
WOOD BLOCKING (INTERRUPTED)	

SYMBOL LEGEND

ROOM NAME AND NUMBER	ROOM NAME 101
DOOR NUMBER	101
WALL TYPE	1t
WINDOW TYPE	A
BUILDING ELEVATION	A101 SHEET WHERE ELEVATION IS DRAWN DRAWING NUMBER
INTERIOR ELEVATION	1 A101 4 2 3 SHEET WHERE ELEVATION IS DRAWN DRAWING NUMBER
BUILDING SECTION	1 A101 SHEET WHERE SECTION IS DRAWN DRAWING NUMBER
WALL SECTION	1 A101 SHEET WHERE SECTION IS DRAWN DRAWING NUMBER
EGRESS ARROW	50
COLUMN BUBBLE	0 COLUMN LINE NUMBER OR LETTER CENTERLINE
PLAN OR SECTION DETAIL	1 A101 DRAWING NUMBER AREA DETAILED SHEET WHERE DETAIL IS DRAWN
NORTH ARROW	

GENERAL NOTES

- GENERAL CONTRACTOR IS RESPONSIBLE FOR OBTAINING PERMITS AND INSPECTIONS REQUIRED BY PUBLIC AUTHORITIES GOVERNING THE WORK.
- REVIEW DOCUMENTS AND VERIFY DIMENSIONS AND FIELD CONDITIONS. REPORT ANY CONFLICTS OR OMISSIONS TO THE ARCHITECT FOR CLARIFICATION PRIOR TO PERFORMING ANY WORK IN QUESTION.
- CONTRACTOR TO NOTIFY ARCHITECT OF ANY DISCREPANCIES BETWEEN ARCHITECTURAL AND CONSULTANT DRAWINGS AND SHALL OBTAIN WRITTEN CLARIFICATION FROM ARCHITECT BEFORE PROCEEDING WITH THE WORK IN QUESTION OR RELATED WORK.
- SUBMIT REQUESTS FOR SUBSTITUTIONS, REVISIONS, OR CHANGES TO ARCHITECT FOR REVIEW PRIOR TO PURCHASE, FABRICATION, OR INSTALLATION.
- OWNER WILL PROVIDE WORK NOTED "BY OTHERS" OR "NIC" UNDER SEPARATE CONTRACT. INCLUDE SCHEDULE REQUIREMENTS IN CONSTRUCTION PROGRESS SCHEDULE AND COORDINATE TO ASSURE ORDERLY SEQUENCE OF INSTALLATION, UNLESS OTHERWISE DIRECTED. NOTIFY ARCHITECT OF ANY CONFLICTS OR DISCREPANCIES WITH NIC ITEMS.
- COORDINATE TELECOMMUNICATIONS, DATA, AND SECURITY SYSTEM INSTALLATIONS.
- DO NOT SCALE DRAWINGS. WRITTEN DIMENSIONS GOVERN. IN CASE OF CONFLICT, CONSULT THE ARCHITECT.
- PROVIDE A PORTABLE FIRE EXTINGUISHER WITHIN 75 FOOT TRAVEL DISTANCE TO ALL PORTIONS OF THE BUILDING ON EACH FLOOR, AND ADDITIONAL FIRE EXTINGUISHERS AS REQUIRED BY FIRE OR BUILDING FIELD INSPECTORS.
- PROVIDE ILLUMINATED EXIT SIGN OVER REQUIRED EXITS, WHERE SHOWN ON DRAWINGS, AND ADDITIONAL SIGNS AS REQUIRED BY FIRE OR BUILDING FIELD INSPECTORS. CONNECT EXIT SIGNS TO EMERGENCY POWER CIRCUITS. SEE ELECTRICAL DRAWINGS.
- PRIOR TO CORING SLAB FOR FLOOR POWER OR DATA, OR POURING AROUND POWER/DATA LOCATIONS, REVIEW LOCATIONS WITH ARCHITECT AND OWNER.
- GANG ADJACENT LIGHT SWITCHES AND COVER WITH A SINGLE PLATE.
- MAINTAIN INTEGRITY OF FIRE RESISTANCE RATING OF ALL RATED SHAFT ENCLOSURES AND RATED PARTITIONS BEHIND RECESSED WALL ACCESSORIES, SUCH AS FIRE EXTINGUISHER CABINETS, TOILET ACCESSORIES, AND ELECTRICAL BOXES.
- NO EXPOSED CONDUIT, WIRING, PIPING, OR BOXES ARE PERMITTED WITHOUT ARCHITECT AND OWNER APPROVAL, UNLESS SPECIFICALLY NOTED OTHERWISE.
- GENERAL CONTRACTOR WILL BE RESPONSIBLE FOR COORDINATION BETWEEN THE TRADES PROVIDING SYSTEMS IN OPEN CEILING CONDITIONS. COORDINATION DRAWINGS AND ANY CONFLICTS ARE TO BE REVIEWED WITH THE ARCHITECT PRIOR TO INSTALLATION.
- REFER TO THE PROJECT MANUAL FOR COMPLETE GENERAL REQUIREMENTS AND CONDITIONS OF THE CONTRACT. THE PROJECT MANUAL SHALL TAKE PRECEDENCE OVER THESE GENERAL NOTES IN THE EVENT OF A CONFLICT.
- IF PROVIDED, REFER TO ENLARGED PLANS AND PLAN DETAILS FOR ADDITIONAL INFORMATION AND DIMENSIONS.
- TYPICAL DETAILS SHOWN ON THE DRAWINGS SHALL BE INCORPORATED AT ALL APPROPRIATE LOCATIONS WHETHER OR NOT SPECIFICALLY REFERENCED AT EACH LOCATION.
- IN AREAS OF HARD CEILING, BUILDING SYSTEMS SHALL BE CONFIGURED TO AVOID OR MINIMIZE ABOVE-CEILING ACCESS. THE LOCATION OF ALL ACCESS DOORS MUST BE COORDINATED WITH AND APPROVED BY ARCHITECT PRIOR TO THE INSTALLATION OF ANY ABOVE-CEILING EQUIPMENT, DAMPERS, VALVES, JUNCTION BOXES, ETC. ANY ACCESS DOORS OR PANELS REQUIRED IN WALLS MUST ALSO BE COORDINATED WITH AND APPROVED BY THE ARCHITECT PRIOR TO THE INSTALLATION OF THE EQUIPMENT REQUIRING ACCESS.
- CONTRACTOR SHALL BE SOLELY RESPONSIBLE FOR THE ACCURACY OF HIS MEASUREMENTS AND TAKE-OFFS FOR MATERIAL ORDERS.
- VARIATIONS IN FLOOR LEVEL IN EXCESS OF 1/8" FOR EVERY 10'-0" (U.O.N.) SHALL BE LEVELED BY CONTRACTOR.

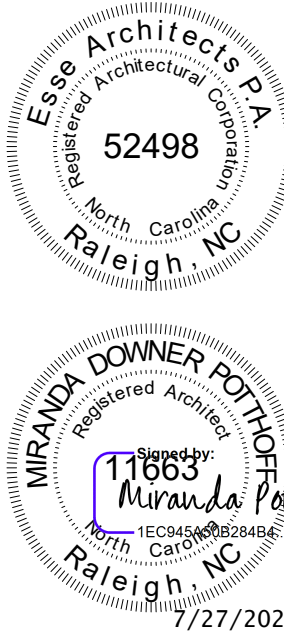

2018 APPENDIX B - EASTERN SHELTER
BUILDING CODE SUMMARY FOR ALL COMMERCIAL PROJECTS
(EXCEPT 1 AND 2-FAMILY DWELLINGS AND TOWNHOUSES)

NAME OF PROJECT: LAKE MYRA COUNTY PARK
ADDRESS: EASTERN PARCEL - 10505 POOLE ROAD, WENDELL, NC 27591

OWNER: ERIC STAEHLE PHONE #: (919)856-6369 E-MAIL: eric.staehle@wake.gov
AUTHORIZED AGENT: JENNIFER STEED PHONE #: (919)845-8397 E-MAIL: jennifer@susanhatchell.com

OWNED BY: ☐ COUNTY ☐ PRIVATE ☐ STATE
CODE ENFORCEMENT JURISDICTION: ☐ CITY: RALEIGH, NC ☒ COUNTY: WAKE ☐ STATE

CONTACT: JENNIFER STEED, SUSAN HATCHELL LANDSCAPE ARCHITECTURE

DESIGNER	FIRM	NAME	LICENSE #	PHONE #	EMAIL
ARCHITECTURAL	ESSE ARCHITECTS	MIRANDA POTTHOFF	11663	(919)270-6455	miranda@esse-architects.com
LANDSCAPE	SUSAN HATCHELL LANDSCAPE ARCH.	SUSAN HATCHELL	528	(919)845-8397	susan@susanhatchell.com
CIVIL	NVS	MICHAEL ALLEN	22514	(919)858-1888	michael.allen@nvs.com
ELECTRICAL	THE WOOTEN COMPANY	ROBERT EGAN	16765	(919)828-0531	egan@thewootencompany.com
FIRE ALARM	THE WOOTEN COMPANY	ROBERT EGAN	16765	(919)828-0531	egan@thewootencompany.com
PLUMBING	THE WOOTEN COMPANY	SCOTT ENNIS	029728	(919)828-0531	sennis@sigmaes.com
MECHANICAL	THE WOOTEN COMPANY	SCOTT ENNIS	029728	(919)828-0531	sennis@sigmaes.com
SPRINKLER	N/A				
STRUCTURAL	LYNCH MYKINS / IMEG	SCOTT FRANCIS	044996	(757) 502-8527	scott.m.francis@imegcorp.com
RETAINING WALLS	N/A				

2018 NC BUILDING CODE: ☒ NEW CONSTRUCTION ☐ PHASED CONSTRUCTION
☐ 1ST TIME INTERIOR COMPLETION ☐ RENOVATION
☐ SHELL/CORE ☐ ADDITION

2018 NC EXISTING BUILDING CODE: ☐ PRESCRIPTIVE ☐ REPAIR ☐ CHAPTER 14

ALTERATION: ☐ LEVEL I ☐ LEVEL II ☐ LEVEL III
☐ HISTORIC ☐ CHANGE OF USE

CONSTRUCTED N/A CURRENT OCCUPANCY (CHAPTER 3) N/A
RENOVATED N/A PROPOSED OCCUPANCY (CHAPTER 3) N/A

OCCUPANCY CATEGORY: (TABLE 1604.5) CURRENT: ☐ I ☐ II ☐ III ☐ IV
PROPOSED: ☐ I ☐ II ☐ III ☐ IV

BASIC BUILDING DATA

CONSTRUCTION TYPE: ☐ I-A ☐ II-A ☐ III-A ☐ IV ☐ V-A
☐ I-B ☒ II-B ☐ III-B

SPRINKLERS: ☐ N/A ☐ YES ☒ NO ☐ PARTIAL

☒ N/A ☐ NFPA 13 ☐ NFPA 13R ☐ NFPA 13 D

STANDPIPES: ☒ NO ☐ CLASS 1 WET ☐ CLASS 1 DRY ☐ CLASS II WET ☐ CLASS II DRY

☐ CLASS III WET ☐ CLASS III DRY

FIRE DISTRICT: ☒ NO ☐ YES FLOOD HAZARD AREA: ☒ NO ☐ YES

SPECIAL INSPECTIONS REQUIRED: ☐ NO ☒ YES

GROSS BUILDING AREA TABLE:

FLOOR	EXISTING (SQ FT)	NEW (SQ FT)	SUB-TOTAL
6TH FLOOR	N/A	N/A	N/A
5TH FLOOR	N/A	N/A	N/A
4TH FLOOR	N/A	N/A	N/A
3RD FLOOR	N/A	N/A	N/A
2ND FLOOR	N/A	N/A	N/A
MEZZANINE	N/A	N/A	N/A
1ST FLOOR	N/A	3,168	3,168
BASEMENT	N/A	N/A	N/A
TOTAL			3,168

ALLOWABLE AREA

PRIMARY OCCUPANCY: ASSEMBLY ☐ A-1 ☐ A-2 ☒ A-3 ☐ A-4 ☐ A-5
☐ BUSINESS ☐ EDUCATIONAL ☐ FACTORY ☐ F-1 MODERATE ☐ F-2 LOW
HAZARDOUS ☐ H-1 DETONATE ☐ H-2 DEFLAGRATE ☐ H-3 COMBUST ☐ H-4 HEALTH ☐ H-5 HPM
INSTITUTIONAL ☐ I-1 CONDITION 1 ☐ I-1 CONDITION 2 ☐ I-2 CONDITION 1 ☐ I-2 CONDITION 2
I-3 CONDITION ☐ 1 ☐ 2 ☐ 3 ☐ 4 ☐ 5 ☐ I-4
MERCANTILE ☐ RESIDENTIAL ☐ R-1 ☐ R-2 ☐ R-3 ☐ R-4
STORAGE ☒ S-1 ☐ S-1 HIGH PILED ☐ S-2 ☐ S-2 HIGH-PILED ☐ STORAGE GARAGE OPEN
☐ UTILITY AND MISCELLANEOUS ☐ REPAIR GARAGE ☐ PARKING GARAGE ENCLOSED
ACCESSORY OCCUPANCY CLASSIFICATION: N/A
INCIDENTAL USES: TABLE 509 N/A
SPECIAL USES (CHAPTER 4 - LIST CODE SECTIONS): N/A
SPECIAL PROVISIONS (CHAPTER 5 - LIST CODE SECTIONS): N/A
MIXED OCCUPANCY: ☐ NO ☒ YES SEPARATION: 0 EXCEPTION

ACTUAL AREA OF OCCUPANCY A * ACTUAL AREA OF OCCUPANCY B < .1
ALLOWABLE AREA OF OCCUPANCY A ALLOWABLE AREA OF OCCUPANCY B

STORY NO.	DESCRIPTION AND USE	(A) BLDG AREA PER STORY (ACTUAL)	(B) TABLE 506.2 AREA	(C) AREA FOR FRONTAGE INCREASE	(D) AREA FOR SPRINKLER INCREASE	(E) ALLOWABLE BUILDING AREA UNLIMITED	(F) MAXIMUM BUILDING AREA *
1	ASSEMBLY A-3	3,168	9,500	75%	0%	16,625	33,250

OCCUPANCY A-3 IS THE MOST RESTRICTIVE AND CONTROLS.

1. FRONTAGE AREA INCREASES FROM SECTION 506.2 ARE COMPUTED THUS:
A. PERIMETER WHICH FRONTS A PUBLIC WAY OR OPEN SPACE HAVING 20 FEET MINIMUM WIDTH = 298 FT
B. TOTAL BUILDING PERIMETER = 298 FT (P)
C. RATIO (F/P) = 298 / 298 = 1 (F/P)
D. W = MINIMUM WIDTH OF PUBLIC WAY = 30 T (W)
E. PERCENT OF FRONTAGE INCREASE $I = 100 [298 / 298 - 0.25] \times 30 / 30 = 75 \%$

2. UNLIMITED AREA APPLICABLE UNDER CONDITIONS OF SECTION 507.

3. MAXIMUM BUILDING AREA = TOTAL NUMBER OF STORIES IN BUILDING X D (MAXIMUM 2 STORIES) (504.4)

4. THE MAXIMUM AREA OF PARKING GARAGES MUST COMPLY WITH TABLE 406.5.4.

5. FRONTAGE INCREASE IS BASED ON THE UNSPRINKLERED AREA VALUE IN TABLE 506.2.

ALLOWABLE HEIGHT

		ALLOWABLE	SHOWN ON PLANS	CODE REFERENCE ¹
BLDG HEIGHT IN FEET	TABLE 504.3 ²	55	16'	TABLE 504.3
BLDG HEIGHT IN STORIES	TABLE 504.4 ³	2	1	TABLE 504.4

¹ PROVIDE CODE REFERENCE IF THE "SHOWN ON PLANS" QUANTITY IS NOT BASED ON TABLE 504.3 OR 504.4.

² THE MAXIMUM HEIGHT OF AIR TRAFFIC CONTROL TOWERS MUST COMPLY WITH TABLE 412.3.1.

³ THE MAXIMUM HEIGHT OF OPEN PARKING GARAGES MUST COMPLY WITH TABLE 406.5.4.

FIRE PROTECTION REQUIREMENTS

BUILDING ELEMENT	FIRE SEPARATION DISTANCE (FEET)	RECD	RATING PROVIDED (W/ REDUCTION)	DETAIL # AND SHEET #	DESIGN # FOR RATED ASSEMBLIES	DESIGN # FOR RATED PENETRATION	DESIGN # FOR RATED JOINTS
STRUCTURAL FRAME, INCL. COLUMNS, GIRDERS, TRUSSES	OVER 30'	0	0				
BEARING WALLS							
EXTERIOR							
NORTH	OVER 30'	0	0				
EAST	OVER 30'	0	0				
WEST	OVER 30'	0	0				
SOUTH	OVER 30'	0	0				
INTERIOR							
NON-BEARING WALLS & PARTITIONS							
EXTERIOR	N/A						
NORTH	OVER 30'	N/A					
EAST	OVER 30'	N/A					
WEST	OVER 30'	N/A					
SOUTH	OVER 30'	N/A					
INTERIOR WALLS & PARTITIONS	N/A	N/A	N/A				
FLOOR CONSTRUCTION INCLUDING SUPPORTING BEAMS AND JOISTS	N/A	N/A	0				
FLOOR CEILING ASSEMBLY		0	0				
COLUMNS SUPPORTING FLOORS		0	0				
ROOF CONSTRUCTION INCLUDING SUPPORTING BEAMS AND JOISTS	N/A		0				
ROOF CEILING ASSEMBLY	N/A		0				
COLUMNS SUPPORTING ROOF	N/A		0				
SHAFT ENCLOSURES - EXIT	N/A		0				
SHAFT ENCLOSURES - OTHER	N/A		0				
CORRIDOR SEPARATION	N/A		0				
OCCUPANCY/FIRE BARRIER SEPARATION	N/A		0				
PARTY/FIRE WALL SEPARATION	N/A		0				
SMOKE BARRIER SEPARATION	N/A		0				
SMOKE PARTITION	N/A		0				
TENANT/DWELLING UNITS/SLEEPING UNIT SEPARATION	N/A		0				
INCIDENTAL USE SEPARATION	N/A		0				

* INDICATE SECTION NUMBER PERMITTING REDUCTION

PERCENTAGE OF WALL OPENING CALCULATIONS

FIRE SEP DISTANCE (FEET) FROM PROPERTY LINES	DEGREE OF OPENINGS PROTECTION (TABLE 705.8)	ALLOWABLE AREA (%)	ACTUAL SHOWN ON PLANS (%)
OVER 30'	NO LIMIT		

LIFE SAFETY SYSTEM REQUIREMENTS

EMERGENCY LIGHTING: ☒ NO ☐ YES
EXIT SIGNS: ☒ NO ☐ YES
FIRE ALARM: ☒ NO ☐ YES
SMOKE DETECTION SYSTEMS: ☒ NO ☐ YES ☐ PARTIAL
CARBON MONOXIDE DETECTION: ☒ NO ☐ YES

LIFE SAFETY PLAN REQUIREMENTS

LIFE SAFETY PLAN SHEET # NONE PROVIDED - ALL DOORS OPEN DIRECTLY TO THE EXTERIOR - SEE ES-A101

☐ FIRE AND/OR SMOKE WALL LOCATIONS (CHAPTER 7) N/A
☐ ASSUMED AND REAL PROPERTY LINE LOCATIONS (IF NOT ON THE SITE PLAN) N/A
☐ EXTERIOR WALL OPENING AREA WITH RESPECT TO DISTANCE TO ASSUMED PROPERTY LINES (705.8) N/A
☐ OCCUPANCY USE FOR EACH AREA AS IT RELATES TO OCCUPANT LOAD CALCULATIONS (TABLE 1004.1.2) N/A
☐ OCCUPANT LOADS FOR EACH AREA N/A
☐ EXIT ACCESS TRAVEL DISTANCES (1017) N/A
☐ COMMON PATH OF TRAVEL DISTANCES (TABLES 1006.2.1 & 1006.3.2(1)) N/A
☐ DEAD END LENGTHS (1020.4) N/A
☐ CLEAR EXIT WIDTHS FOR EACH EXIT DOOR N/A
☐ MAXIMUM CALCULATED OCCUPANT LOAD CAPACITY EACH EXIT DOOR CAN ACCOMMODATE BASED ON EGRESS WIDTH (1005.3) N/A
☐ ACTUAL OCCUPANT LOAD FOR EACH EXIT DOOR N/A
☐ A SEPARATE SCHEMATIC PLAN INDICATING WHERE FIRE RATED FLOOR/CEILING AND /OR ROOF STRUCTURE IS PROVIDED FOR OCCUPANCY SEPARATION N/A
☐ LOCATION OF DOORS WITH PANIC HARDWARE (1010.1.10) N/A
☐ LOCATION OF DOORS WITH DELAYED EGRESS LOCKS AND THE AMOUNT OF DELAY (1010.1.9.7) N/A
☐ LOCATION OF DOORS WITH ELECTROMAGNETIC EGRESS LOCKS (1010.1.9.9) N/A
☐ LOCATION OF DOORS EQUIPPED WITH HOLD OPEN DEVICES N/A
☐ LOCATION OF EMERGENCY ESCAPE WINDOWS (1030) N/A
☐ THE SQUARE FOOTAGE OF EACH FIRE AREA (202) N/A
☐ THE SQUARE FOOTAGE OF EACH SMOKE COMPARTMENT FOR OCCUPANCY CLASSIFICATION I-2 (407.5) N/A
☐ NOTE ANY CODE EXCEPTIONS OR TABLE NOTES THAT MAY HAVE BEEN UTILIZED REGARDING THE ITEMS ABOVE NONE

ACCESSIBLE DWELLING UNITS (SECTION 1107) N/A

TOTAL UNITS	ACCESSIBLE UNITS REQUIRED	ACCESSIBLE UNITS PROVIDED	TYPE-A UNITS REQUIRED	TYPE A UNITS PROVIDED	TYPE-B UNITS REQUIRED	TYPE B UNITS REQUIRED	TOTAL ACCESSIBLE UNITS PROVIDED

ACCESSIBLE PARKING (SECTION 1106) - SEE COVER SHEET OF EASTERN PARCEL SITE DRAWING SET.

LOT OR PARKING AREA	TOTAL # PARKING REQUIRED	PROVIDED	# OF ACCESSIBLE SPACES PROVIDED	REGULAR W/ 5' ACCESS AISLE	VAN SPACE WITH 132" ACC. AISLE	8' ACC. AISLE	TOTAL # ACCESSIBLE UNITS PROVIDED
PARK CENTER	24						
MAINTENANCE FAC.	6						
PICNIC SHELTER	8						
PLAYGROUND	34						
BOATING	4						
FISHING	4						
TOTAL	80	103	8		2		10

PARKING SPACES LISTED HERE INCLUDES ALL STANDARD VEHICLE SPACES REQUIRED AND PROVIDED FOR THE EASTERN PARCEL. SEE SHEET COVERSHEET OF EASTERN PARCEL SITE DRAWING SET FOR ADDITIONAL PARKING INFO.

PLUMBING FIXTURE REQUIREMENTS (TABLE 2902.1) EASTERN SHELTER ONLY

USE	WATER CLOSETS			URINALS	LAVATORIES			SHOWERS & TUBS		DRINKING FOUNTAINS	
	MALE	FEMALE	UNISEX		MALE	FEMALE	UNISEX	MALE	FEMALE	REGULAR	ACCESSIBLE
PICNIC AREA	.67	1.29			.43	.43					
REQUIRED	1	2	0	0	1	1	0	0	0	1	1
PROVIDED	2	2	4*	0	2	2	4*	0	0	1	1

*4 UNISEX TOILET ROOMS ARE PROVIDED IN LIEU OF SEPARATE FACILITIES. 2 ARE FULLY ACCESSIBLE.

SPECIAL APPROVALS
LOCAL JURISDICTION, DEPARTMENT OF INSURANCE, OSC, DPI, DHHS, ETC., DESCRIBE BELOW.

ENERGY SUMMARY

ENERGY REQUIREMENTS:

THE FOLLOWING DATA SHALL BE CONSIDERED MINIMUM AND ANY SPECIAL ATTRIBUTE REQUIRED TO MEET THE ENERGY CODE SHALL ALSO BE PROVIDED. EACH DESIGNER SHALL FURNISH THE REQUIRED PORTIONS OF THE PROJECT INFORMATION FOR THE PLAN DATA SHEET. IF PERFORMANCE METHOD, STATE THE ANNUAL ENERGY COST FOR THE STANDARD REFERENCE DESIGN VS. ANNUAL ENERGY FOR THE PROPOSED DESIGN.

EXISTING BUILDING ENVELOPE COMPLIES WITH CODE: ☐ YES (REMAINDER OF THIS SECTION IS NOT APPLICABLE) ☐ NO

EXEMPT BUILDING: ☐ YES ☒ NO PROVIDE CODE OR STATUTORY REFERENCE:

CLIMATE ZONE: ☐ N/A ☐ 3A ☒ 4A ☐ 5A

METHOD COMPLIANCE: ☐ ENERGY CODE PERFORMANCE ☒ ENERGY CODE PRESCRIPTIVE ☐ OTHER - PERFORMANCE
☐ ASHRAE 90.1 PERFORMANCE ☐ ASHRAE 90.1 PRESCRIPTIVE ☐

(IF "OTHER" SPECIFY SOURCE HERE)

THERMAL ENVELOPE (PRESCRIPTIVE METHOD ONLY)

ROOF/CEILING ASSEMBLY - STANDING SEAM SEE ES-421 THROUGH ES-423. STANDING SEAM ROOF / MIN. R-30

DESCRIPTION OF ASSEMBLY: CONTINUOUS RIGID INSULATION / NOMINAL 2" WOOD DECK

U-VALUE OF TOTAL ASSEMBLY: U-0.02

R-VALUE OF INSULATION: MIN. R-30 CONTINUOUS INSULATION. R-43 SHOWN IN DETAILS

SKYLIGHTS IN EACH ASSEMBLY: N/A

U-VALUE OF SKYLIGHT: N/A

SKYLIGHTS AREA IN EACH ASSEMBLY: N/A

EXTERIOR WALLS - FIBER CEMENT CLADDING

DESCRIPTION OF ASSEMBLY: SEE ES-421 THROUGH ES-423: 8" CMU / AIR-WEATHER BARRIER / MIN. R-10 CONT. RIGID INSULATION / AIRSPACE / FIBER CEMENT CLADDING

U-VALUE OF TOTAL ASSEMBLY: U-0.05

R-VALUE OF INSULATION: R-10 CONTINUOUS INSULATION, R-15 SHOWN IN DETAILS

OPENINGS (WINDOWS & DOORS):

U-VALUE OF ASSEMBLY: U-0.45

SOLAR HEAT GAIN COEF: 0.25

PROJECTION FACTOR: 0.00

DOOR R-VALUES: HOLLOW METAL - R-2.0

WALLS ADJACENT TO UNCONDITIONED SPACE (EACH ASSEMBLY):

DESCRIPTION OF ASSEMBLY: N/A

U-VALUE OF TOTAL ASSEMBLY:

R-VALUE OF INSULATION:

OPENINGS (WINDOWS & DOORS):

U-VALUE OF ASSEMBLY: N/A

SOLAR HEAT GAIN COEF:

PROJECTION FACTOR:

DOOR R-VALUES:

WALLS BELOW GRADE:

DESCRIPTION OF ASSEMBLY: N/A

U-VALUE OF TOTAL ASSEMBLY:

R-VALUE OF INSULATION:

FLOORS - UNCONDITIONED:

DESCRIPTION OF ASSEMBLY: N/A

U-VALUE OF TOTAL ASSEMBLY:

R-VALUE OF INSULATION:

FLOOR SLAB ON GRADE:

DESCRIPTION OF ASSEMBLY: SEE ES-421 THROUGH ES-423: 4" OR 6" CONCRETE ON A VAPOR BARRIER ON DRAINAGE STONE ON GRADE

U-VALUE OF TOTAL ASSEMBLY:

R-VALUE OF INSULATION:

HORIZONTAL/VERTICAL REQMT: VERTICAL TO TOP OF FOOTING AT WALLS / 2'-0" HORIZONTAL AT ENTRANCES AND DOORS

SLAB HEATED: N/A

STRUCTURAL DESIGN

DESIGN LOADS:

IMPORTANCE FACTORS: SNOW (Is): ☐ 0.8 ☒ 1.0 ☐ 1.1 ☐ 1.2

SEISMIC (Is): ☒ 1.0 ☐ 1.25 ☐ 1.5

LIVE LOADS:

ROOF 20 _PSF


MEZZANINE N/A _PSF

FLOOR 100 _PSF

GROUND SNOW LOAD: 15 _PSF

WIND LOAD:

ULTIMATE W

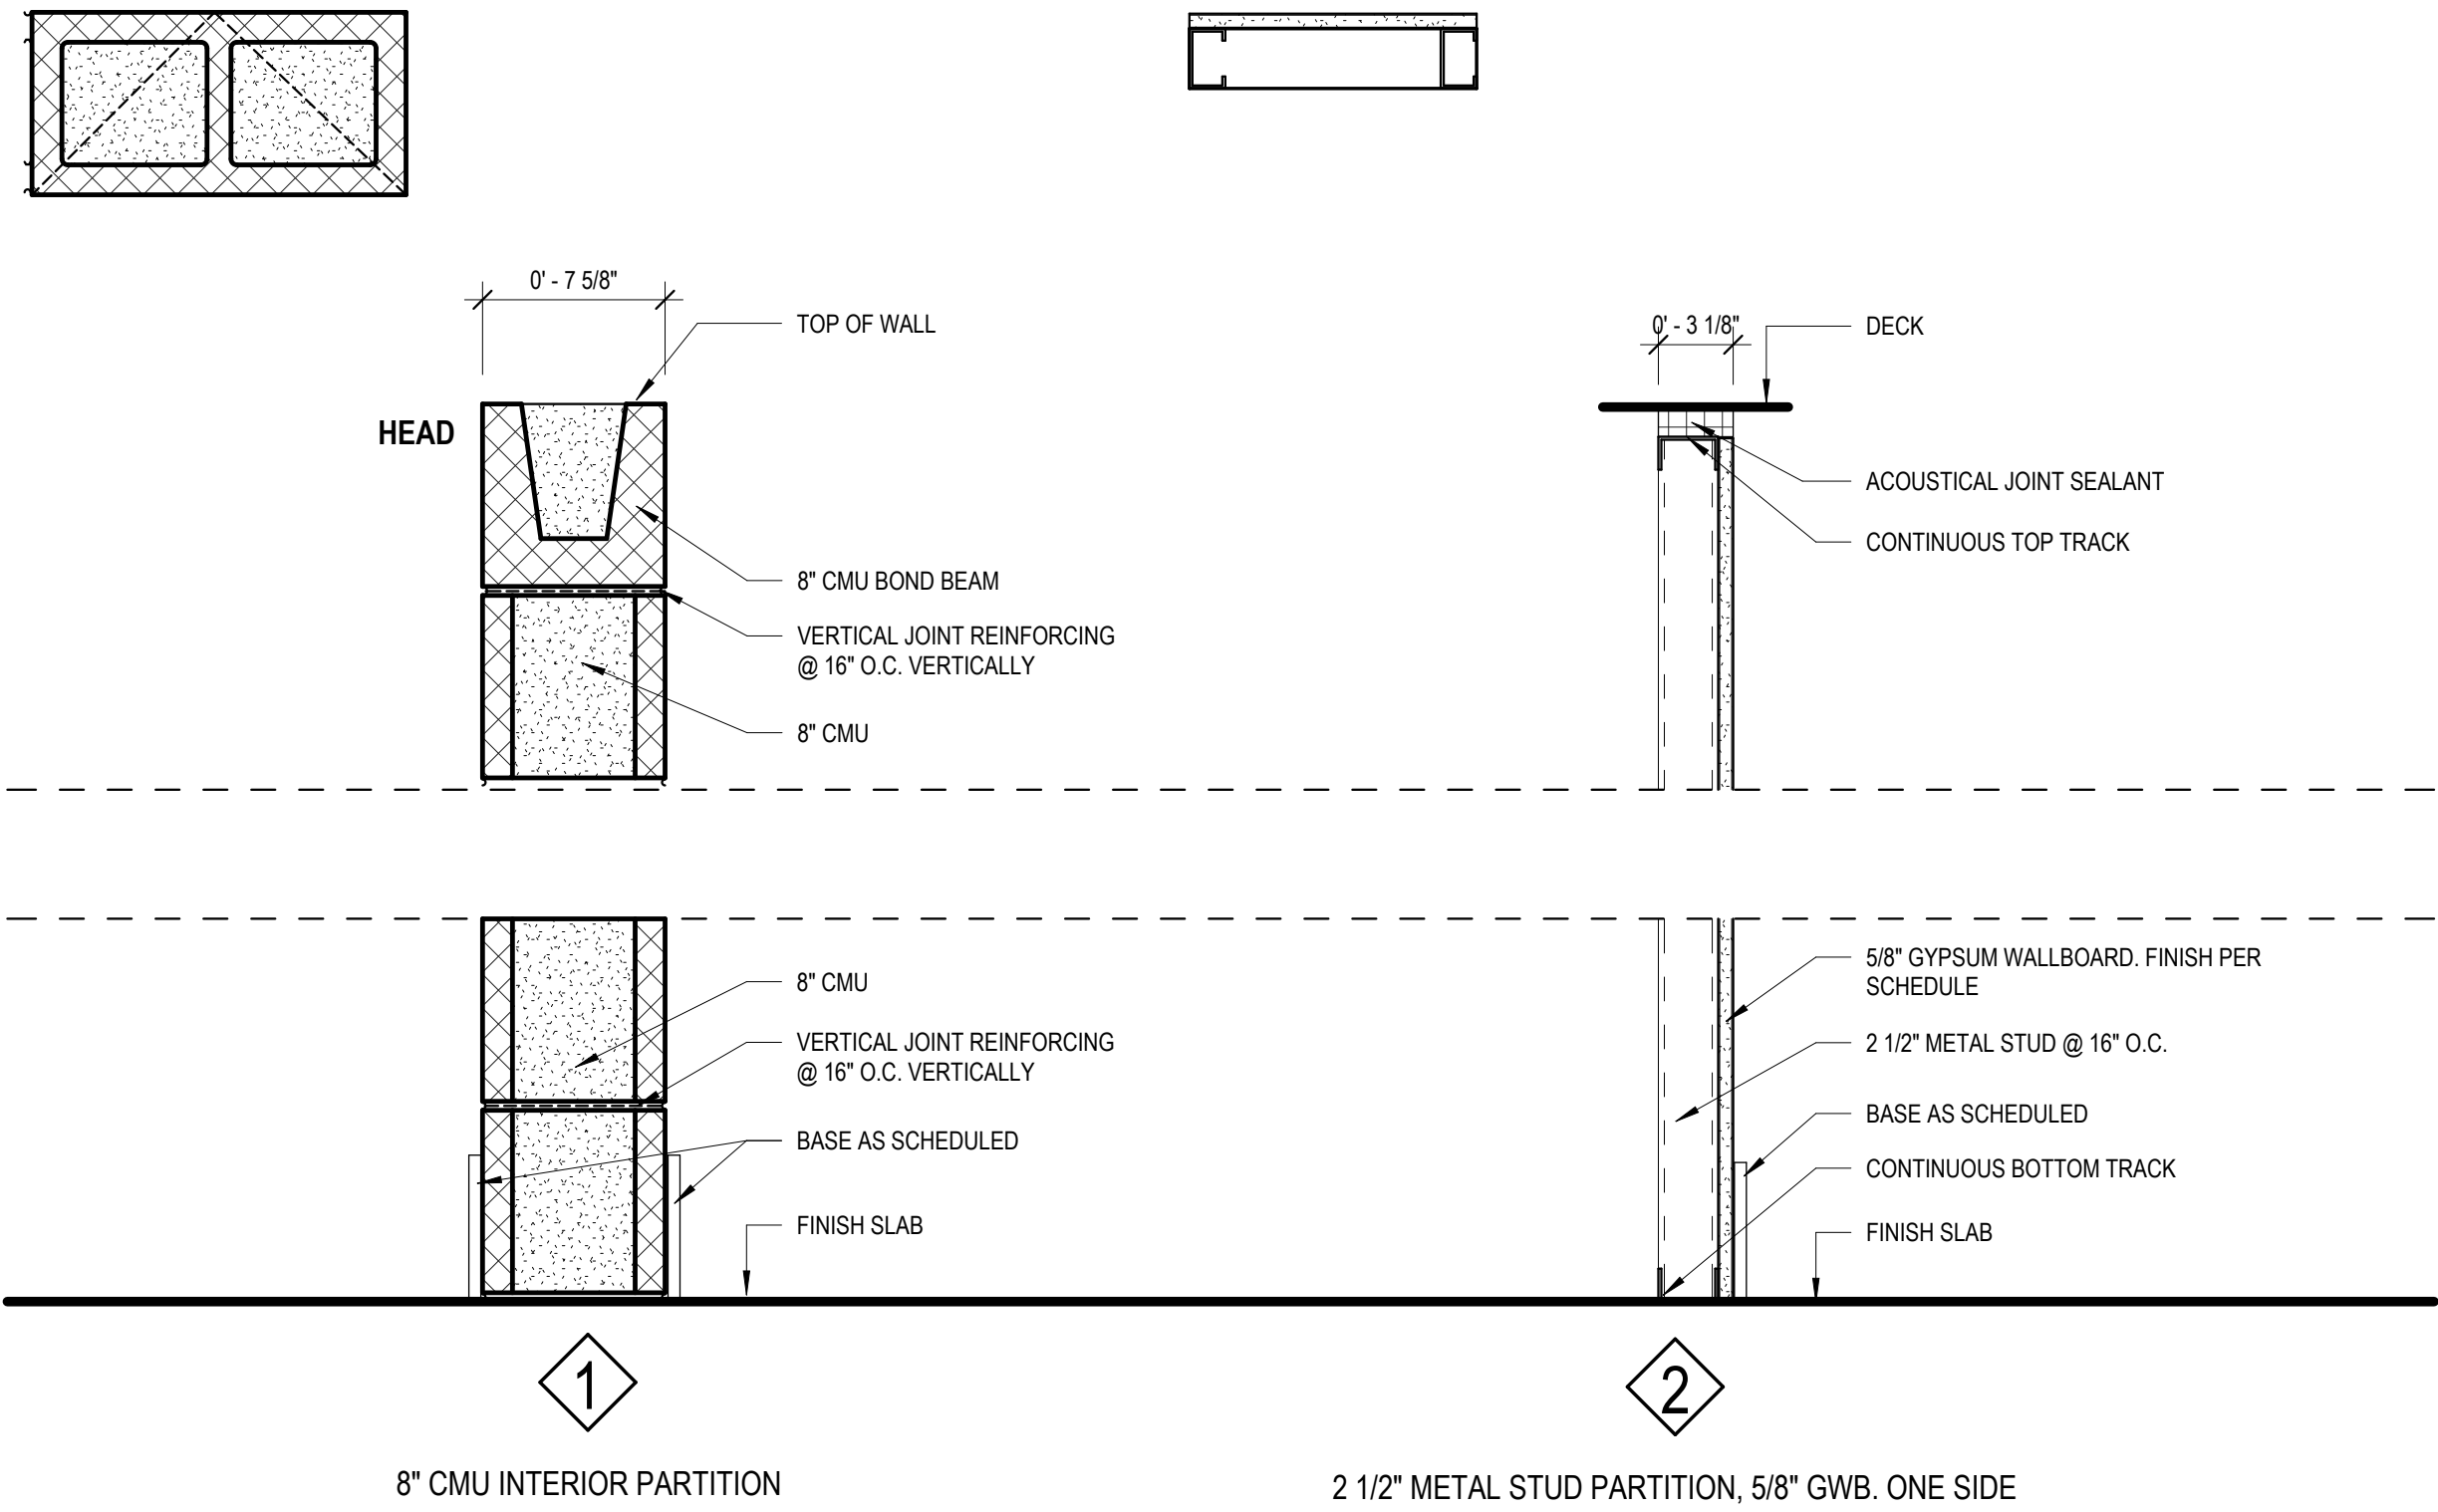


SYMBOL LEGEND	
#	PARTITION TAG
GENERAL PARTITION NOTES	
1. COORDINATE ADJACENT WALLS OF DIFFERENT TYPES SO THAT GYP. BOARD WALL FACES ALIGN. RESILIENT CHANNELS TO BE ON THE SAME SIDE OF THE WALL, TYP.	
2. SEAL PERIMETER OF ALL WALLS, TYP. USE 5/8" CEMENTITIOUS TILE BACKING SHEETS IN LIEU OF 5/8" GWB BEHIND ALL WALL TILE, TYP.	
3. SEE FINISH SCHEDULE AND FINISH PLANS FOR WALL TILE AND WALL FINISHES.	

Susan Hatchell
Landscape Architecture, PLLC
711 W. North Street, Raleigh, NC 27603
p: 919-838-9600 f: 919-838-9700



PARTITIONS


LAKE MYRA COUNTY PARK
Wake County, NC

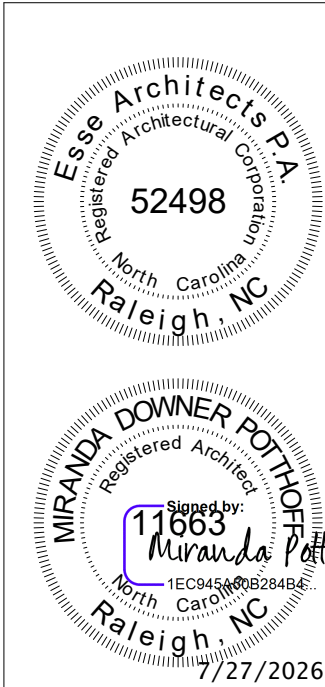



REVISIONS


Date: 07/27/26

 
ES-A001

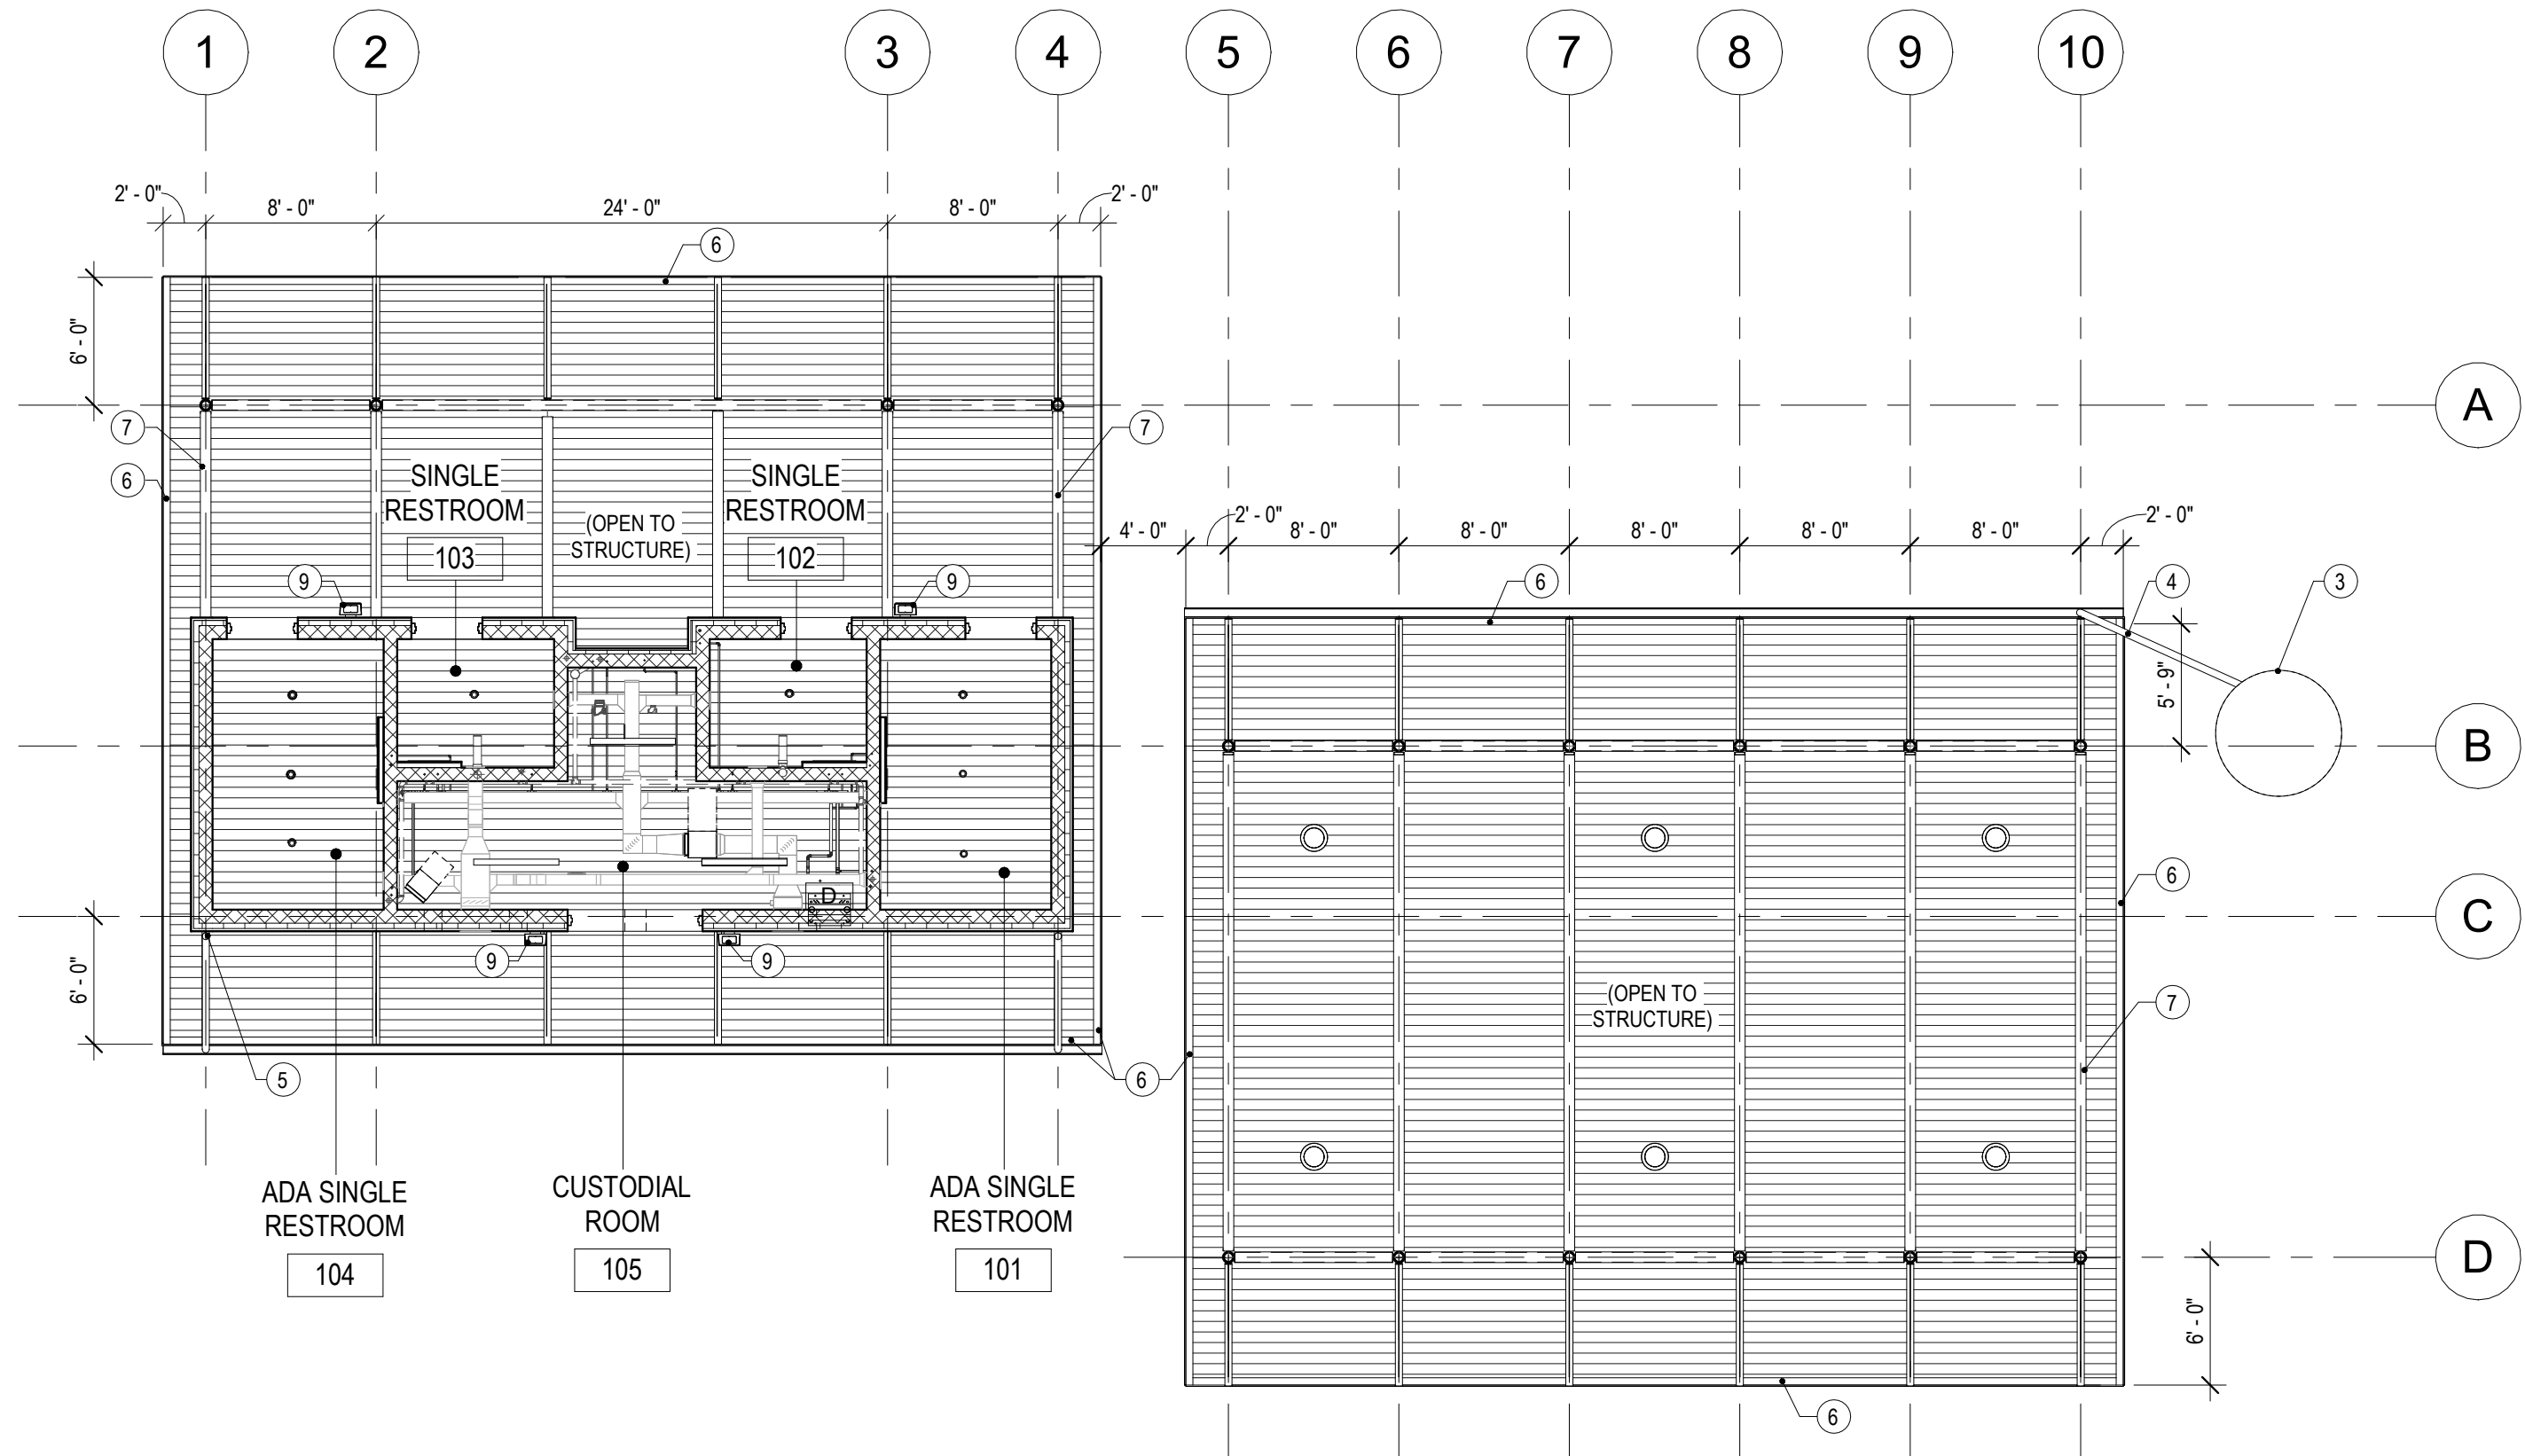

 
 1 EAST PARCEL SHELTER - REFLECTED CEILING PLAN
ES-A111 1/8" = 1'-0"

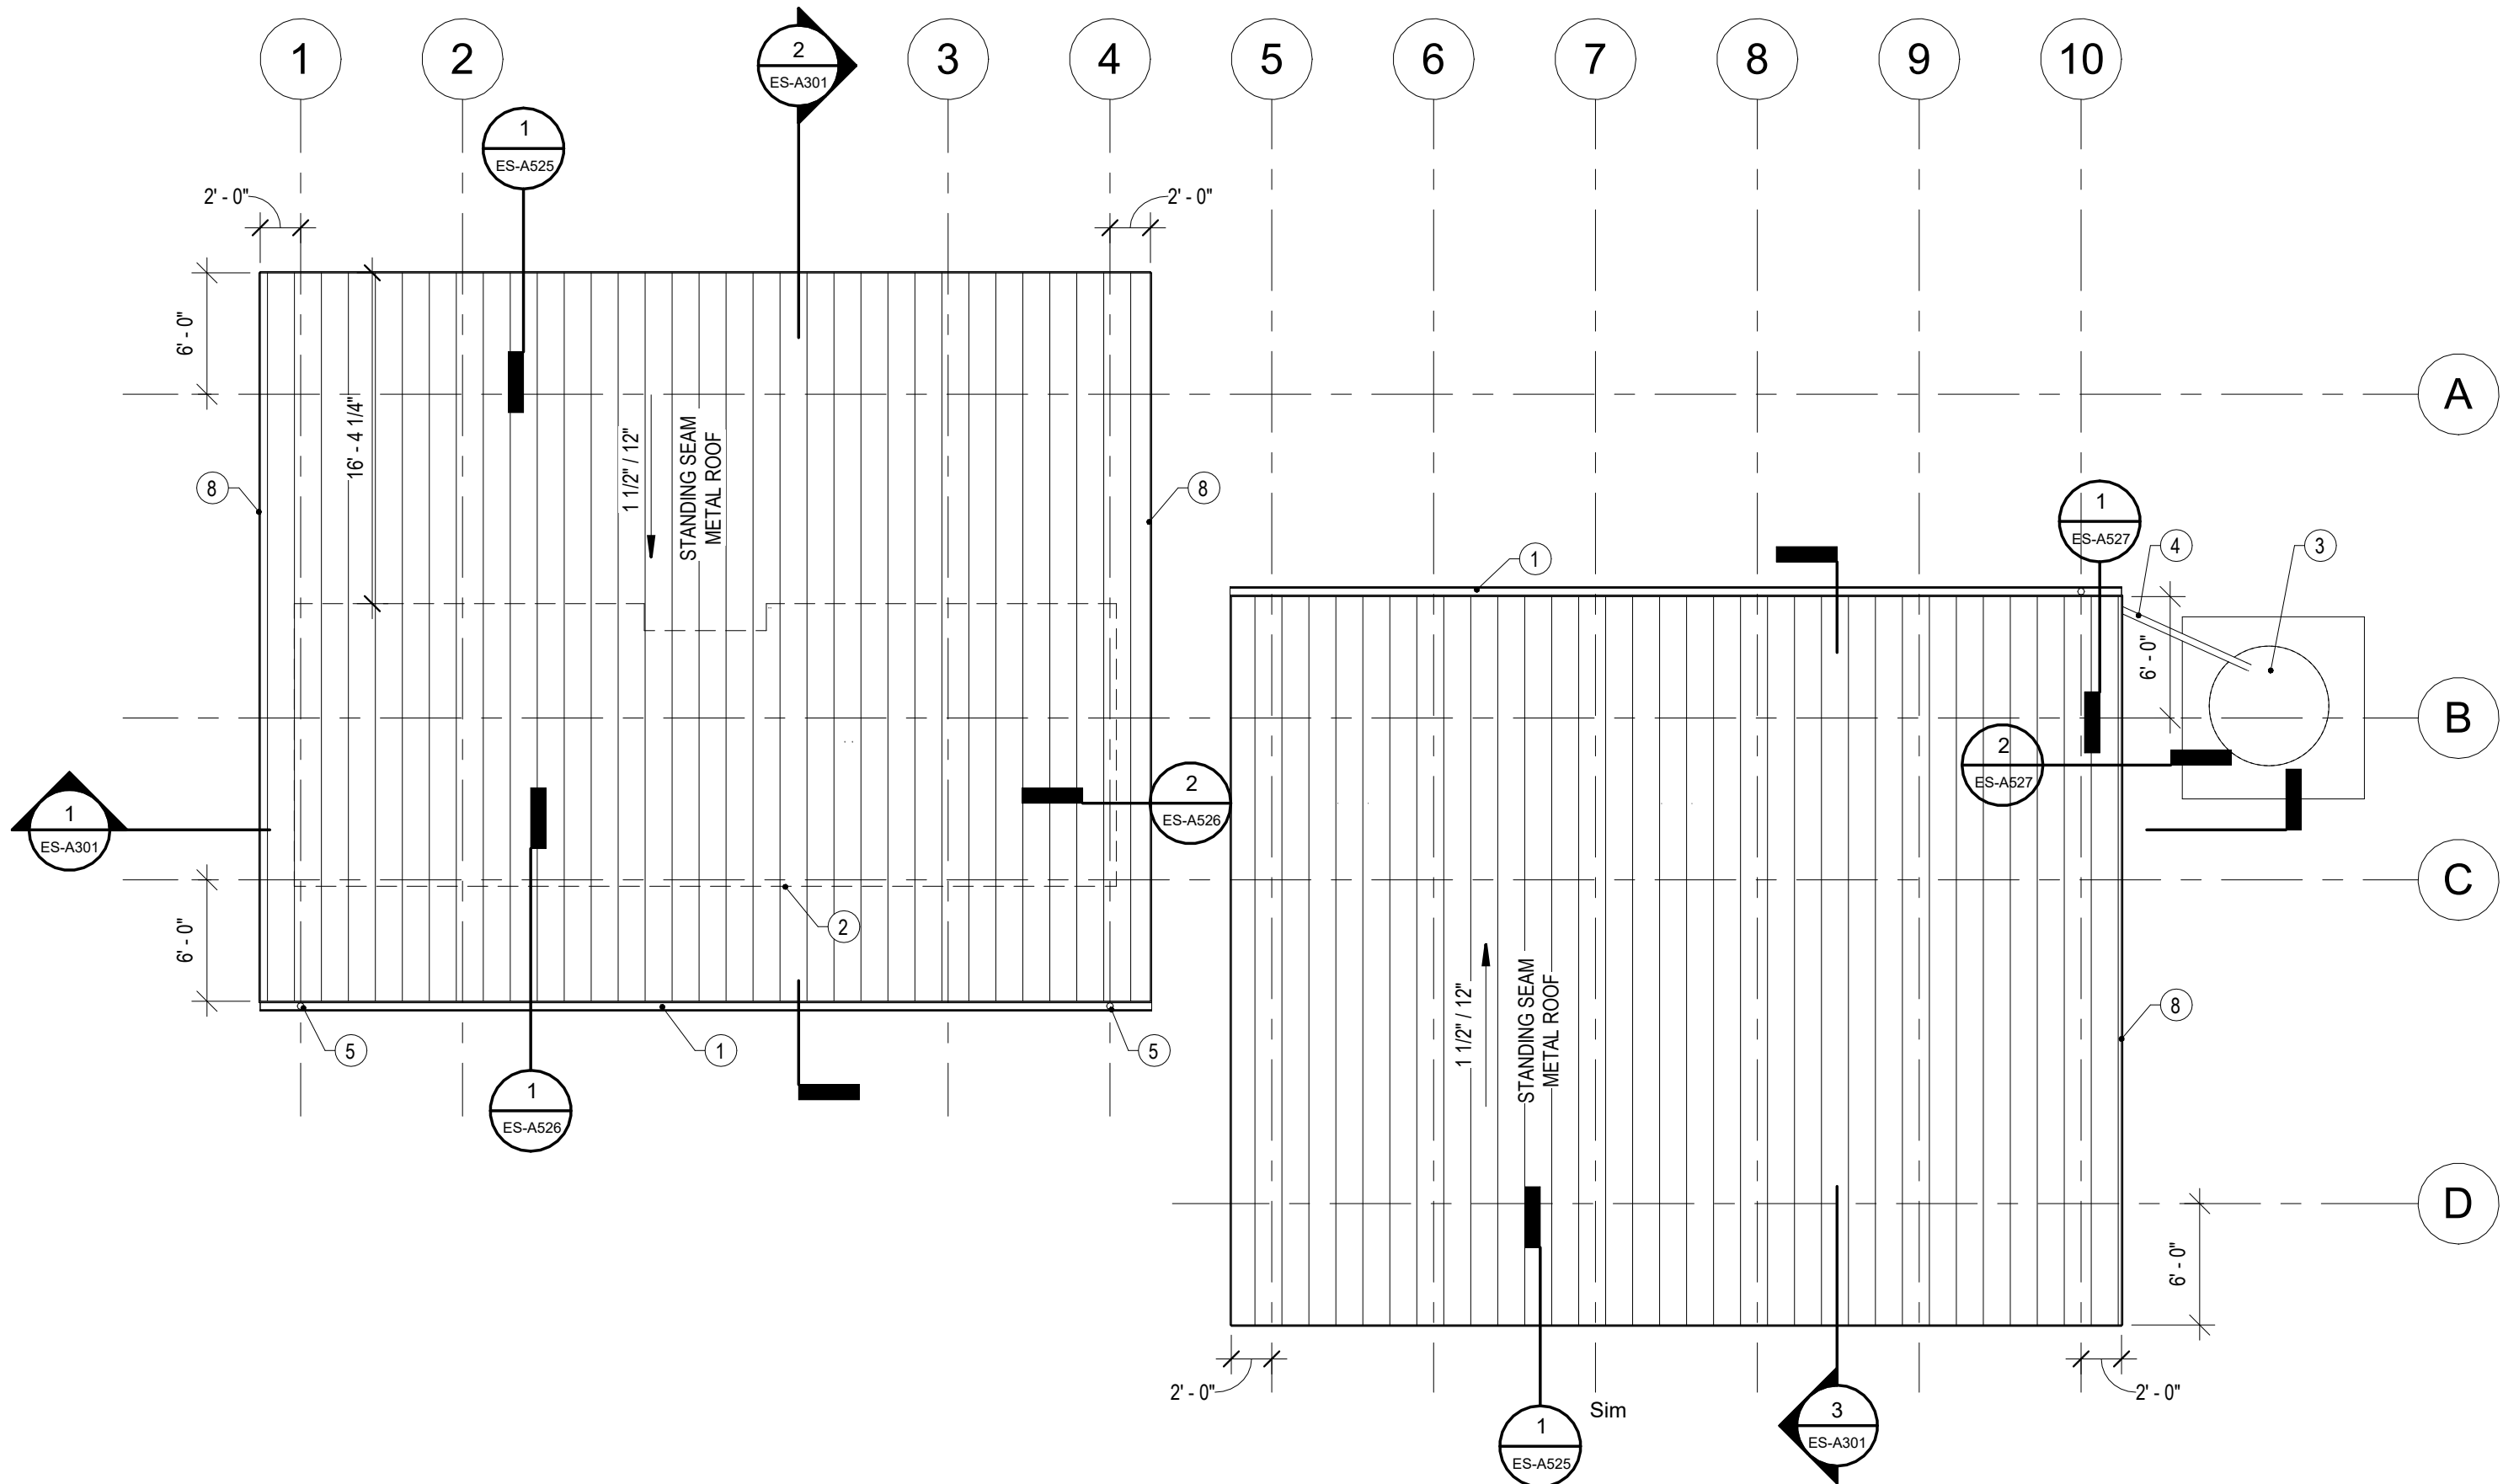

  2 EAST PARCEL SHELTER - ROOF PLAN
ES-A111 1/8" = 1'-0"


CEILING LEGEND		
CEILING TYPE		CEILING HEIGHT
PATTERN KEY CEILING MATERIAL		
	A	EXPOSED 2x WOOD DECKING W/ THREE COATS OF CLEAR SEALER
SYMBOL		DESCRIPTION
		SUSPENDED LINEAR FIXTURE
		SUSPENDED LIGHT FIXTURE
		SUSPENDED 15' LIGHT FIXTURE
		WALL RECTANGULAR LIGHT

 - CEILING NOTES:**
- SEE ELECTRICAL AND MECHANICAL PLANS FOR MORE INFORMATION.
 - WHERE CEILING KEYNOTE IS NOT NOTED, ROOM HAS EXPOSED STRUCTURE.
 - ALL DIMENSIONS ARE TO CENTERLINE OF FIXTURE UNLESS OTHERWISE NOTED.
 - ALL EXTERIOR SUSPENDED LIGHTS TO BE MOUNTED W/ EQUAL CORD LENGTH - SEE ELECTRICAL DRAWINGS

ROOF PLAN LEGEND	
	2' TALL STANDING SEAM METAL ROOF WITH 16" WIDE PANELS W/ PENCIL RIBS AND ICE AND WATER SHIELD UNDER FULL ROOF AREA
	1 1/2' / 12" SLOPE

- ROOF PLAN NOTES**
- STRUCTURAL WOOD ROOF DECK IS ALSO FINISHED CEILING - NO FASTENERS SHALL PENETRATE DECKING
 - NO EXPOSED CONDUIT SHALL BE RUN ACROSS UNDERSIDE OF WOOD DECKING WITHOUT REVIEW AND COORDINATION WITH THE ARCHITECT. COORDINATE FOR LIGHTING, SECURITY, ETC.

#	GENERAL ROOF NOTES
KEY	DESCRIPTION
1	5'x5' ALUMINUM GUTTER
2	OUTSIDE FACE OF BLOCK BELOW
3	CISTERN - SEE SITE DRAWINGS
4	4" DIAMETER DOWNSPOUT TO CISTERN - SEE SITE DRAWINGS
5	4" DIAMETER DOWNSPOUT
6	STEEL BENT PLATE AROUND PERIMETER OF ROOF - SEE STRUCTURAL - PAINT PER SPEC 09 9600
7	STEEL BEAMS WITH HIGH PERFORMANCE COATING PER SPEC SECTION 09 9600
8	CONTINUOUS METAL FASCIA - FULL PERIMETER
9	EXTERIOR WALL MOUNTED LIGHT - SEE ELECTRICAL DRAWINGS

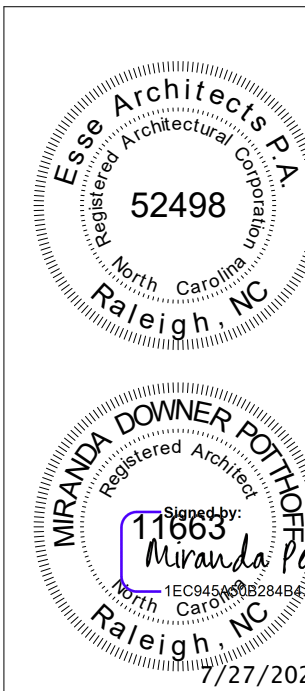

Susan Hatchell
Landscape Architecture, PLLC
711 W. North Street, Raleigh, NC 27603
p. 919-838-9600 f. 919-838-9700




REFLECTED CEILING AND ROOF PLANS

LAKE MYRA COUNTY PARK
Wake County, NC

REVISIONS	


Date: 07/27/26
ES-A111

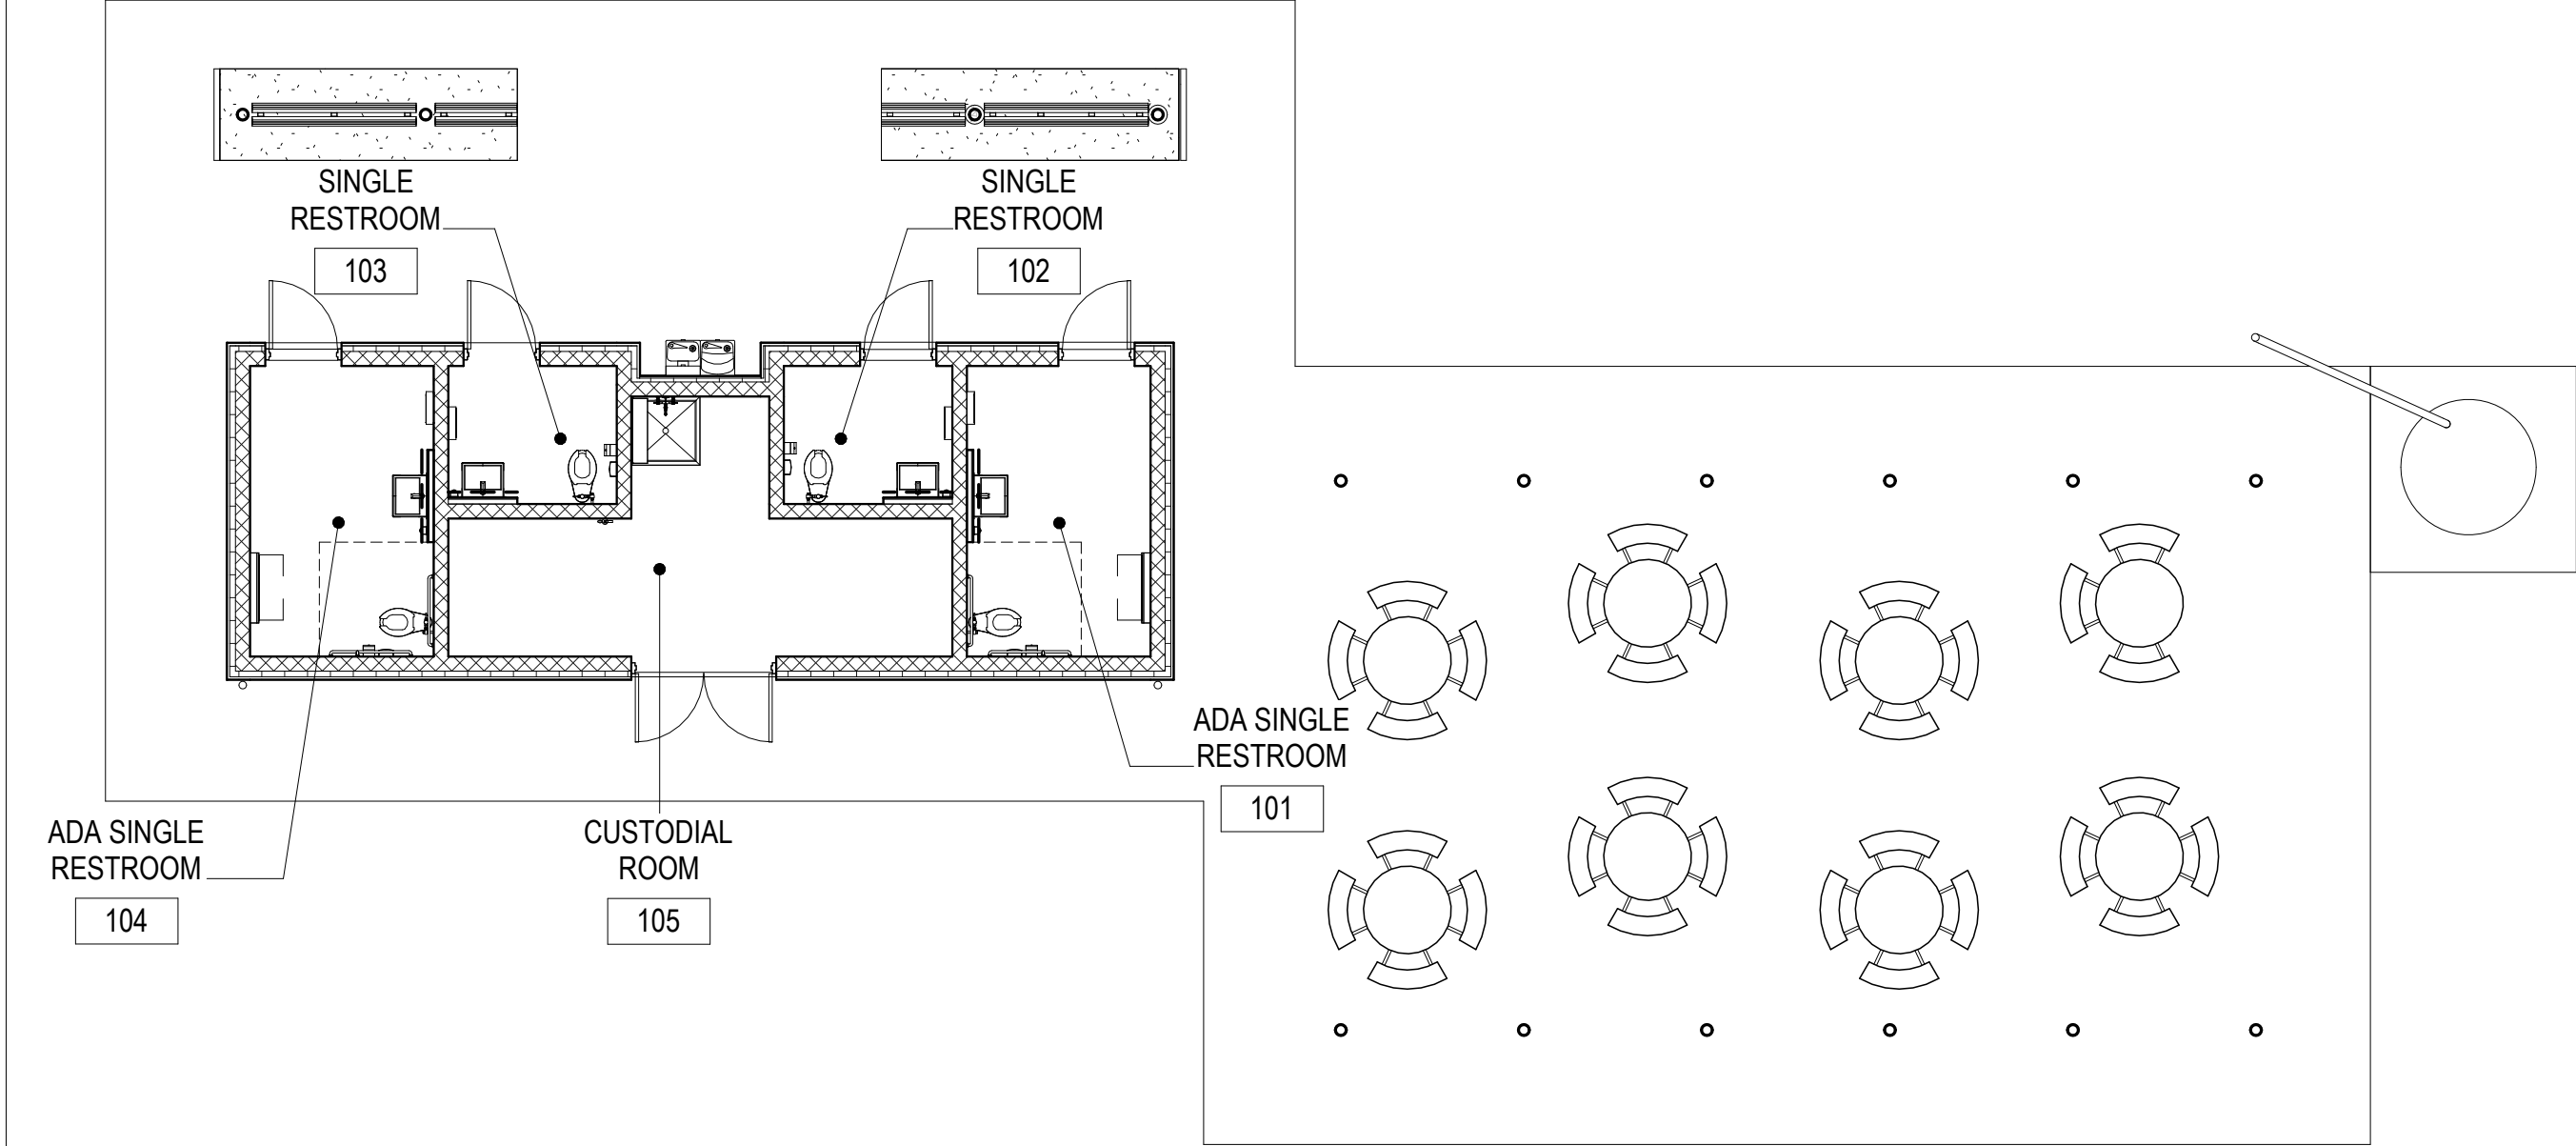

EAST PARCEL SHELTER - FINISH PLAN
1
ES-A131
1/8" = 1'-0"

NOTE: WALL FINISH LOCATIONS NOTED IN THE SCHEDULE ARE ORIENTED USING PLAN NORTH AS THE REFERENCE DIRECTION.

FINISH SCHEDULE										
ROOM NUMBER	ROOM NAME	FLOOR		WALLS				CEILING	MILLWORK	
		FLOOR	BASE	NORTH	EAST	SOUTH	WEST		CABINETRY	COUNTERTOP
101	ADA SINGLE RESTROOM	EPX-1	EPX-1	PT-1	PT-1	PT-1	PT-1; WT-5	A	--	--
102	SINGLE RESTROOM	EPX-1	EPX-1	PT-1	PT-1	PT-1; WT-5	PT-1	A	--	--
103	SINGLE RESTROOM	EPX-1	EPX-1	PT-1	PT-1	PT-1; WT-5	PT-1	A	--	--
104	ADA SINGLE RESTROOM	EPX-1	EPX-1	PT-1	PT-1; WT-5	PT-1	PT-1	A	--	--
105	CUSTODIAL ROOM	EPX-1	EPX-1	PT-1	PT-1	PT-1	PT-1	A	--	--

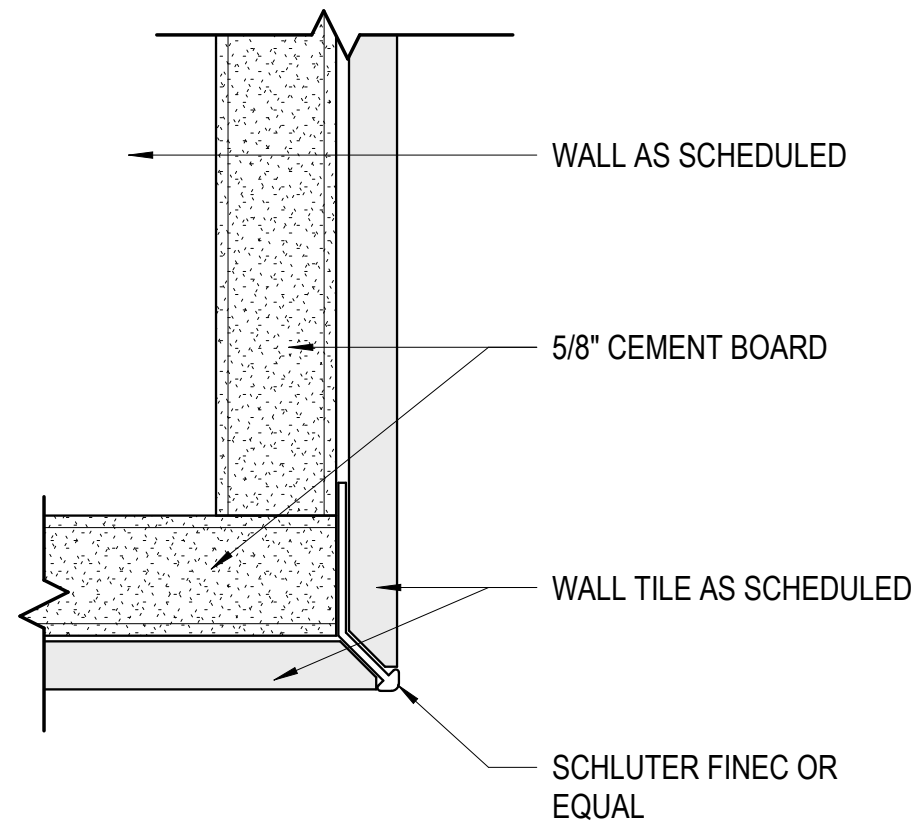

TYP. WALL TILE OUTSIDE CORNER
2
ES-A131
12" = 1'-0"

FINISH LEGEND

BASIS OF DESIGN:			EQUAL 1:	EQUAL 2:
FLOORING 096723.01 EPX-1 RESINOUS FLOORING	MANUFACTURER:	SHERWIN WILLIAMS	AMERICAN HI-TECH FLOORING COMPANY	EPOXY SYSTEMS, INC.
	COLLECTION:	DECO QUARTZ	MATCH BOD	MATCH BOD
	COLOR:	GRASSLAND	MATCH BOD	MATCH BOD
	INSTALL METHOD:	POURED; 6" INTEGRAL COVE BASE	POURED; 6" INTEGRAL COVE BASE	POURED; 6" INTEGRAL COVE BASE
WALLS 093013.07 WT-5 WALL TILE	MANUFACTURER:	MOSAIC	SPECIALTY TILE PRODUCTS	STONE SOURCE
	COLLECTION:	EARTHEN	EARTH	FIRENZE BEPAINT
	COLOR:	JADE; MATTE	LEAF	MOSS
	TYPE/SIZE:	3" X 12"	2" X 8"	3" X 10"
PAINTS 099123.01 PT-1 FIELD	MANUFACTURER:	SHERWIN WILLIAMS	BENJAMIN MOORE	PPG
	COLOR:	SW 6203 SPARE WHITE	MATCH BOD	MATCH BOD
	SHEEN:	EGGSHELL	EGGSHELL	EGGSHELL
	099123.03 PT-3 FIELD	MANUFACTURER:	BENJAMIN MOORE	PPG
099123.05 PT-5 GREEN HM DOORS & TRIM	MANUFACTURER:	SHERWIN WILLIAMS	BENJAMIN MOORE	PPG
	COLOR:	SW 7048 URBANE BRONZE	MATCH BOD	MATCH BOD
	SHEEN:	EGGSHELL	EGGSHELL	EGGSHELL
	COLOR:	SW 6438 DILL	MATCH BOD	MATCH BOD
	SHEEN:	SEMI-GLOSS	SEMI-GLOSS	SEMI-GLOSS

SYMBOL LEGEND	
X-X	FINISH TAG
TXT	ROLLER SHADE TAG
----	TILED WALL
GENERAL FINISH NOTES	
- ALL DIMENSIONS TO BE FIELD VERIFIED PRIOR TO ORDERING. DO NOT SCALE FROM DRAWINGS. - ALL MATERIALS SHALL BE INSTALLED PER MANUFACTURER'S RECOMMENDATIONS WITH APPROVED ADHESIVES OR OTHER FASTENERS. - IF THERE ARE QUESTIONS ABOUT THE DESIGN INTENT OF ANY PATTERN OR MATERIAL TO BE INSTALLED, THE G.C. SHALL SUBMIT A REQUEST FOR INFORMATION TO THE DESIGNER FOR CLARIFICATION PRIOR TO ORDERING THE MATERIALS. - THE G.C. SHALL PROVIDE ALL FINISHING PIECES AND TRANSITIONS WHERE DIFFERENT FLOORING THICKNESSES MEET, U.N.O. THE G.C. SHALL SUBMIT A SAMPLE OF THE COLOR/FINISH TO THE DESIGNER FOR APPROVAL. - ALL WALLS TO BE FIELD PAINT, PT-1, U.N.O. ALL GYP. BD. PARTITIONS TO RECEIVE A LEVEL 4 FINISH. - EXPOSED ADA THERMAL INSULATED KITS AT SINKS TO BE PAINTED TO MATCH ADJACENT WALL. - IN INTERIOR CONDITIONS, FLOORING TO TRANSITION UNDER CLOSED DOOR. FLOORING TO TRANSITION IN CENTER OF CASED OPENING WHEN NO DOOR IS SCHEDULED. - ALL COVER PLATES (DATA, LIGHTS, TELEPHONE, ETC.) AND ALL DEVICES TO COORDINATE WITH WAKE COUNTY STANDARDS.	

FINISH PLAN,
LEGEND &
SCHEDULE

LAKE MYRA COUNTY PARK
Wake County, NC

REVISIONS

Date: 07/27/26


ES-A131


Susan
Hatchell

Landscape Architecture, PLLC
711 W. North Street, Raleigh, NC 27603
p: 919-838-9600 f: 919-838-9700

Esse
Architects

832 FISHING ROAD | RALEIGH, NORTH CAROLINA 27608

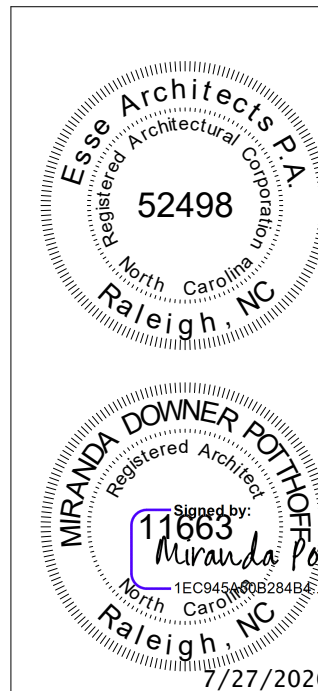

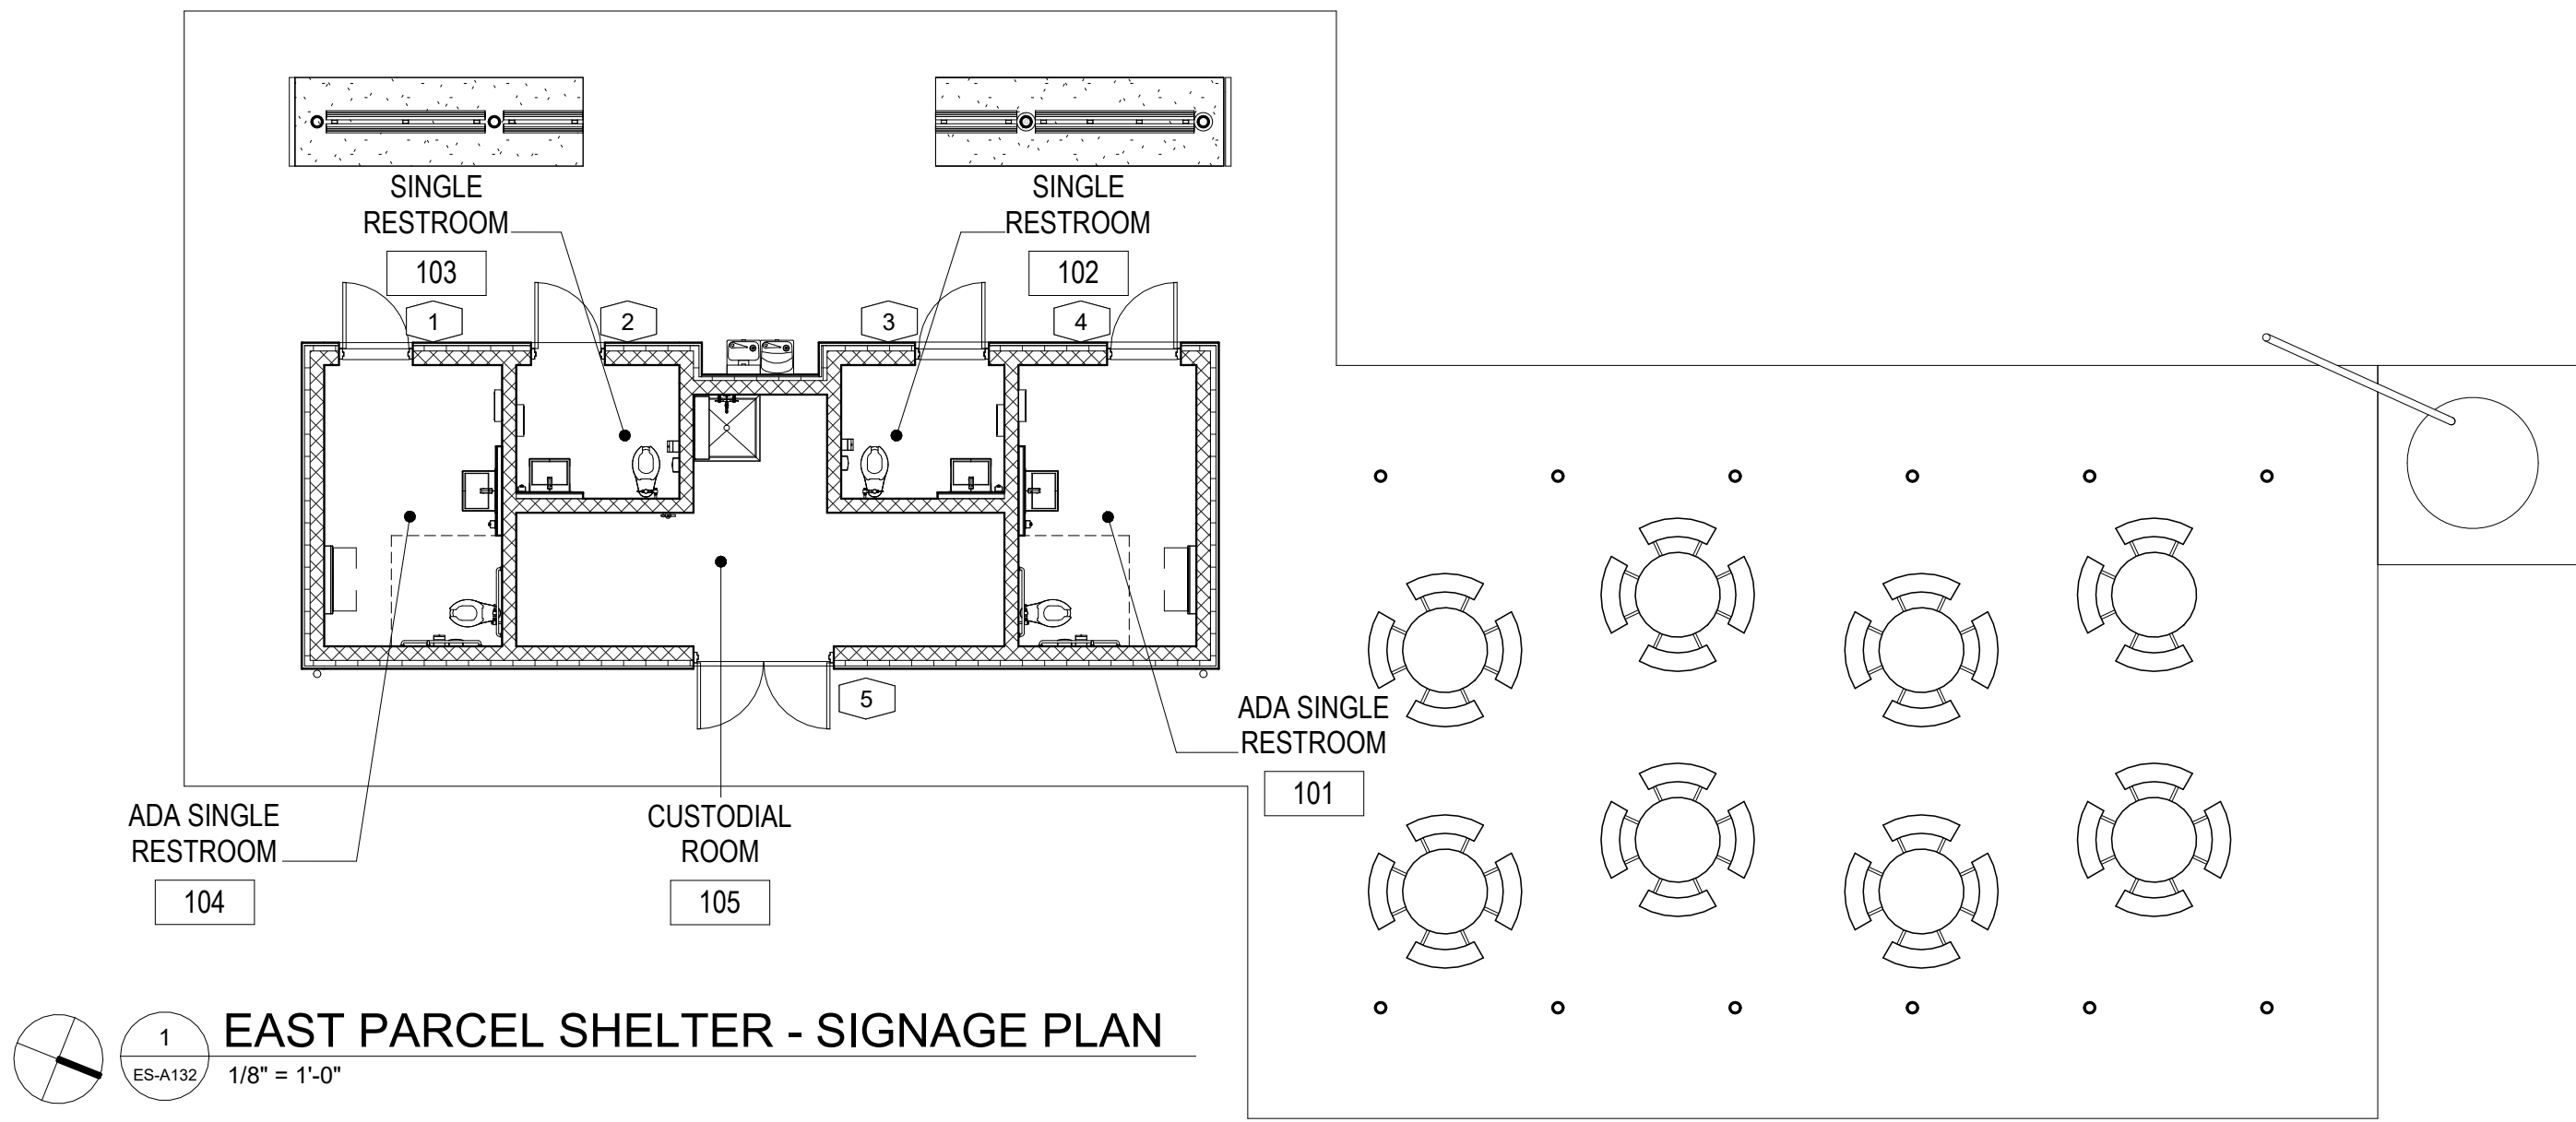

#	SIGNAGE SCHEDULE			
SIGN NO.	ROOM NO.	SIGNAGE TEXT	SIGN TYPE	COMMENTS
1	104	RESTROOM	R.3	
2	103	RESTROOM	R.5	
3	102	RESTROOM	R.5	
4	101	RESTROOM	R.3	
5	105	CUSTODIAL	ID.3	

ALL BUILDING SIGNAGE TO BE PROVIDED BY THE OWNER UNLESS OTHERWISE NOTED.

SPECIFICATIONS

GENERAL SIGNAGE NOTES
BRAILLE CHARACTERS ARE FOR GRAPHIC REPRESENTATION ONLY - ACTUAL BRAILLE CHARACTERS TO BE DETERMINED BY SIGN FABRICATOR

ADA COMPLIANT 1/8" THERMOFORM SIGN CONSISTING OF INTEGRAL RAISED COPY, GRADE II BRAILLE WITH SUBSURFACE COPY AND PAINT. SIGN TO BE CLEARCOATED AFTER PAINT AND FOIL STAMP HAS BEEN APPLIED.

ROOM NUMBER, BRAILLE, AND ACCENTS ARE RAISED.

WHERE SIGN IS MOUNTED TO GLASS, PLACE A THERMOFORM BLANK SIGN MOUNTED ON OPPOSITE SIDE OF GLASS. BACK PANEL TO MATCH BACKGROUND COLOR.

COPY STYLE: OPTIMA MEDIUM

COPY COLOR: BLACK; ARCHITECT TO SELECT FROM MANUFACTURERS FULL LINE OF COLORS.

BACKGROUND COLOR: ROWMARK BLACK FOREST GREEN OR EQUAL; ARCHITECT TO SELECT FROM MANUFACTURERS FULL RANGE OF COLORS.

BRAILLE COLOR: CLEAR

SYMBOL COLOR: WHITE; ARCHITECT TO SELECT FROM MANUFACTURERS FULL RANGE OF COLORS.


NOTE: ALL SIGN TYPES TO MEET ADA REQUIREMENTS FOR COLOR CONTRAST RATIO

CORNERS: SQUARE


SIGN MOUNTING: 3M #4910 CLEAR VHB DOUBLE-SIDED TAPE AND CLEAR SILICONE ADHESIVE




SIGNAGE TYPE R.3 - UNISEX ADA

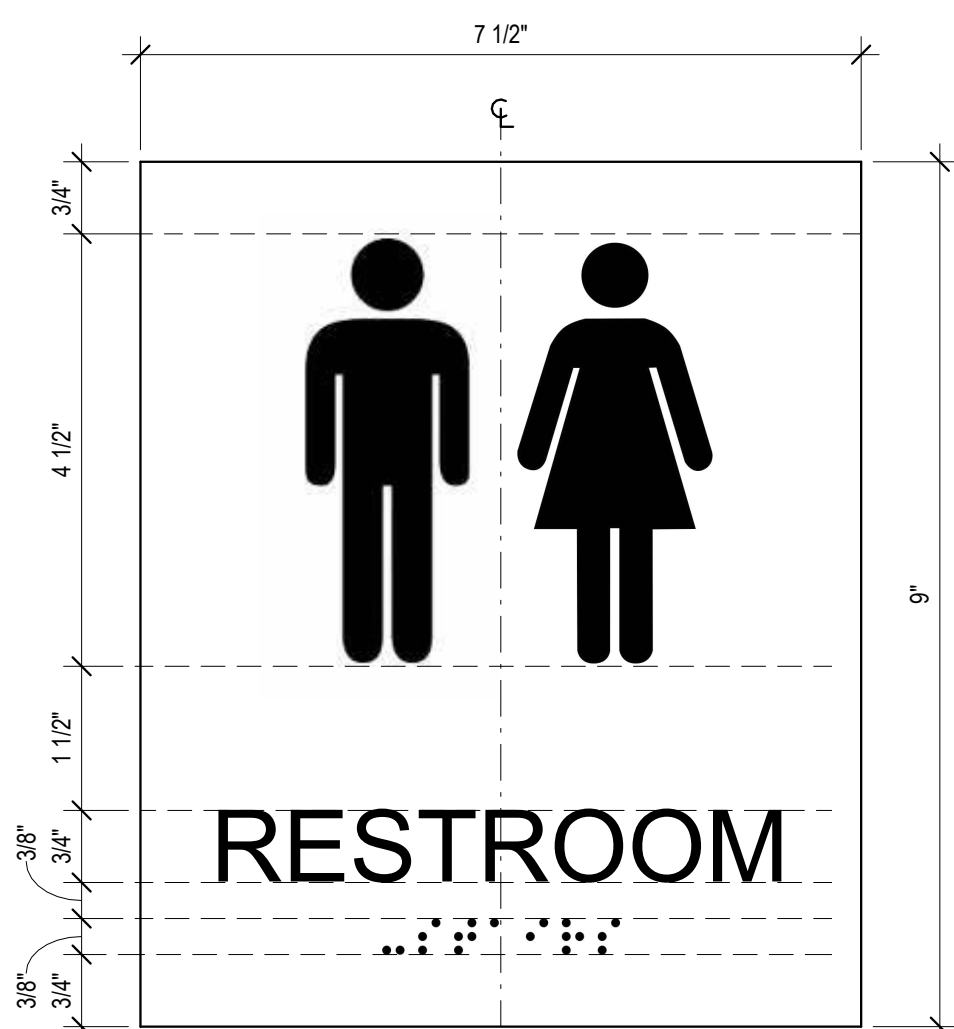


SIGNAGE TYPE R.5 - UNISEX NON-ADA

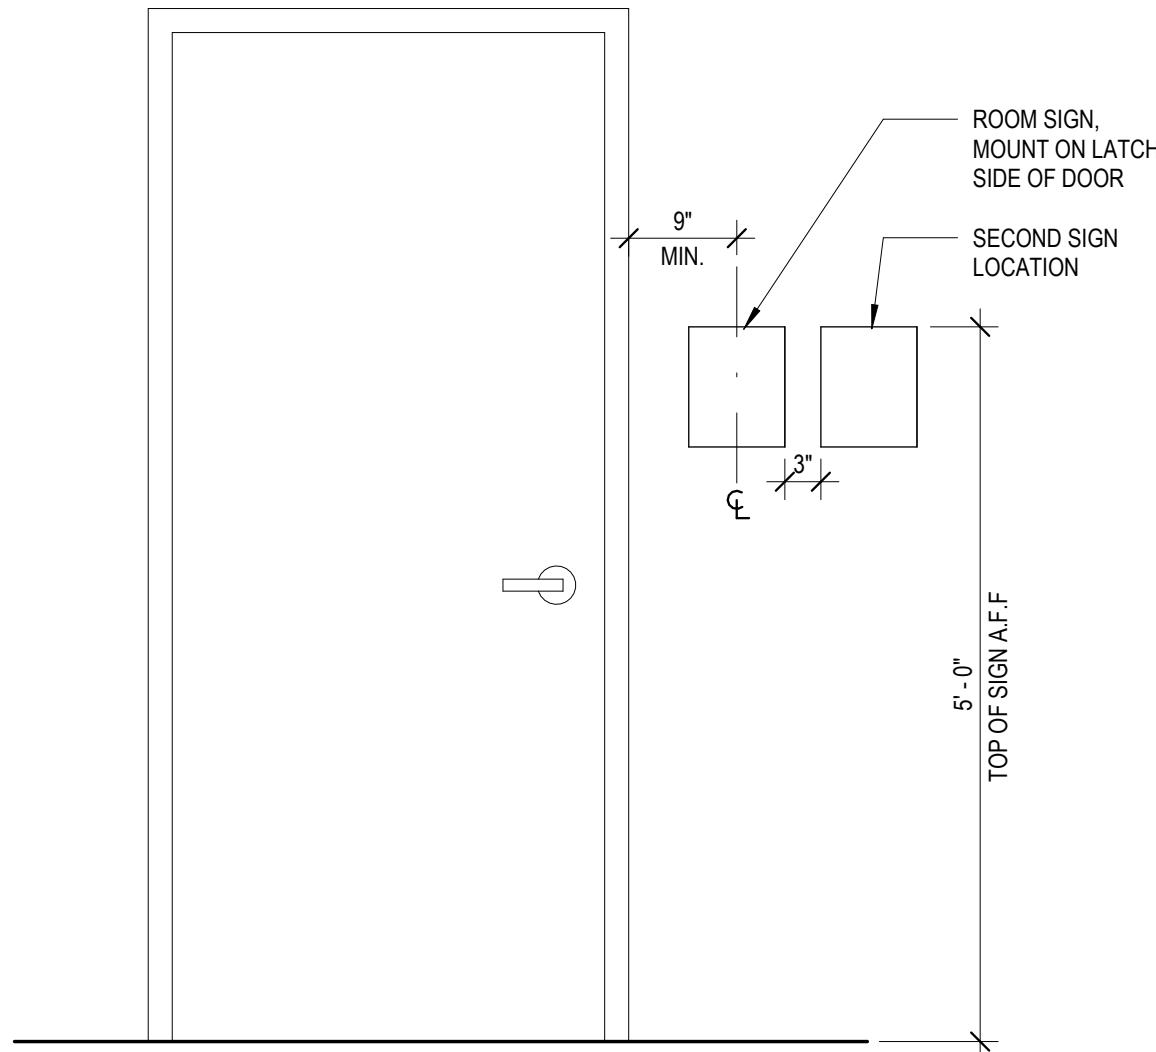


SIGNAGE MOUNTING HEIGHTS

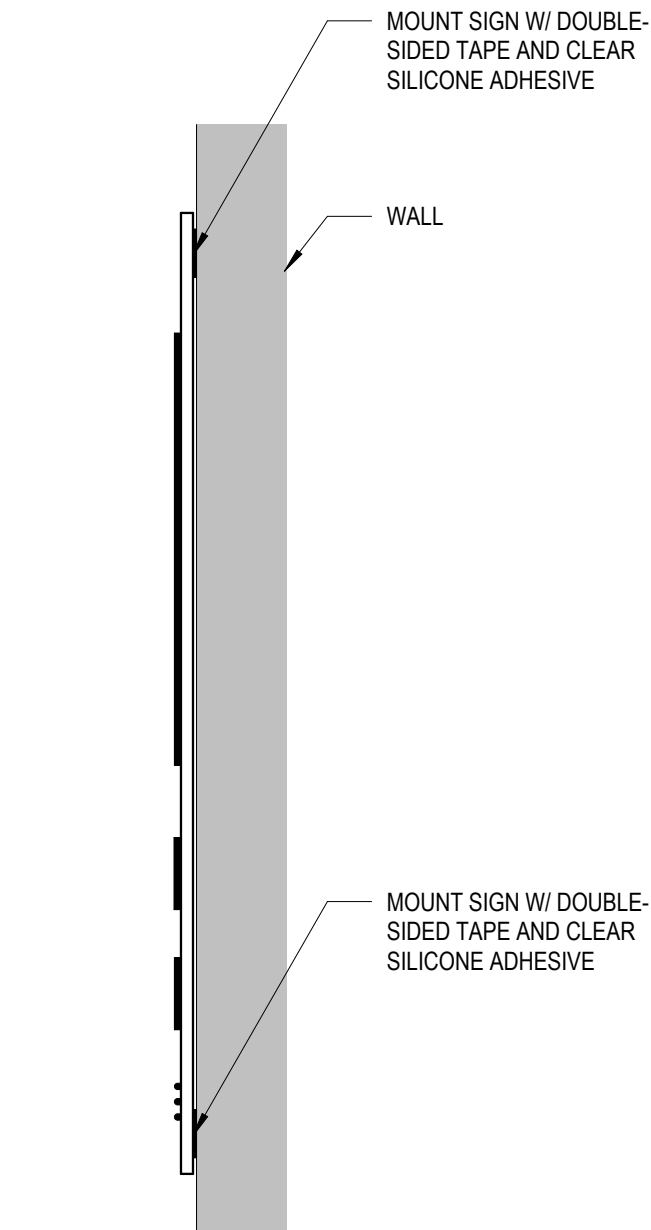

SIGNAGE MOUNTING TYPES

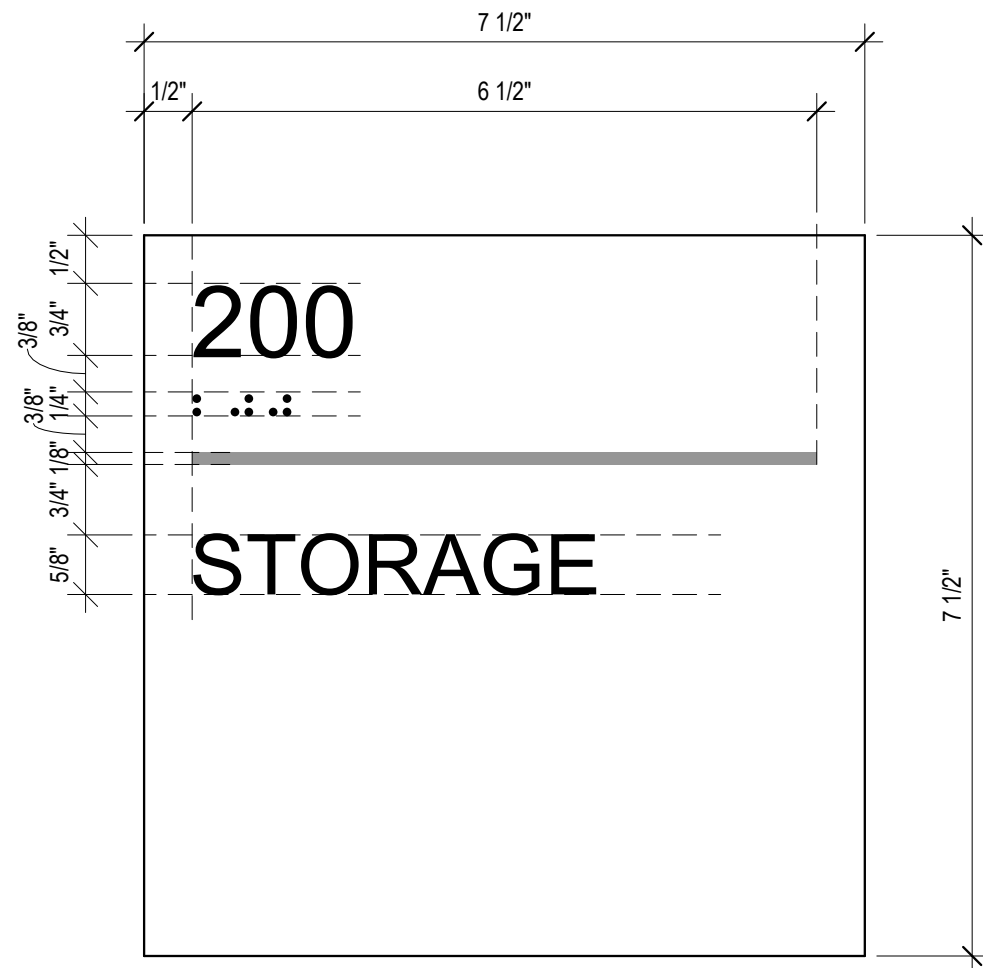

SIGNAGE TYPE ID.3 - ROOM INDICATOR VINYL TEXT

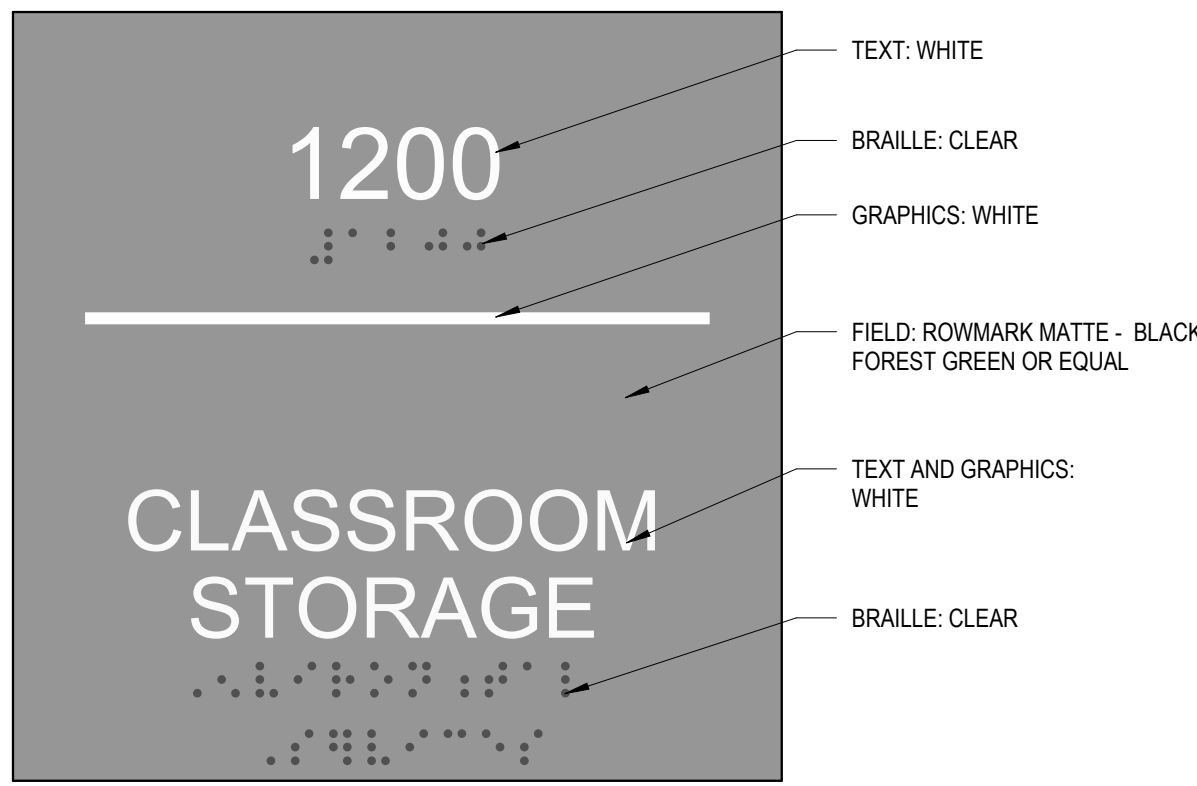

SIGNAGE COLOR SAMPLE

Susan Hatchell
Landscape Architecture, PLLC
711 W. North Street, Raleigh, NC 27603
p: 919-838-9600 f: 919-838-9700

Esse Architects
832 PERSHING ROAD | RALEIGH, NORTH CAROLINA 27608


SIGNAGE PLAN & DETAILS


LAKE MYRA COUNTY PARK
Wake County, NC

REVISIONS


Date: 07/27/26

ES-A132

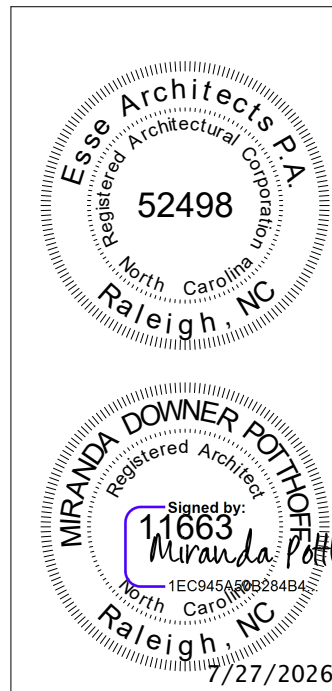


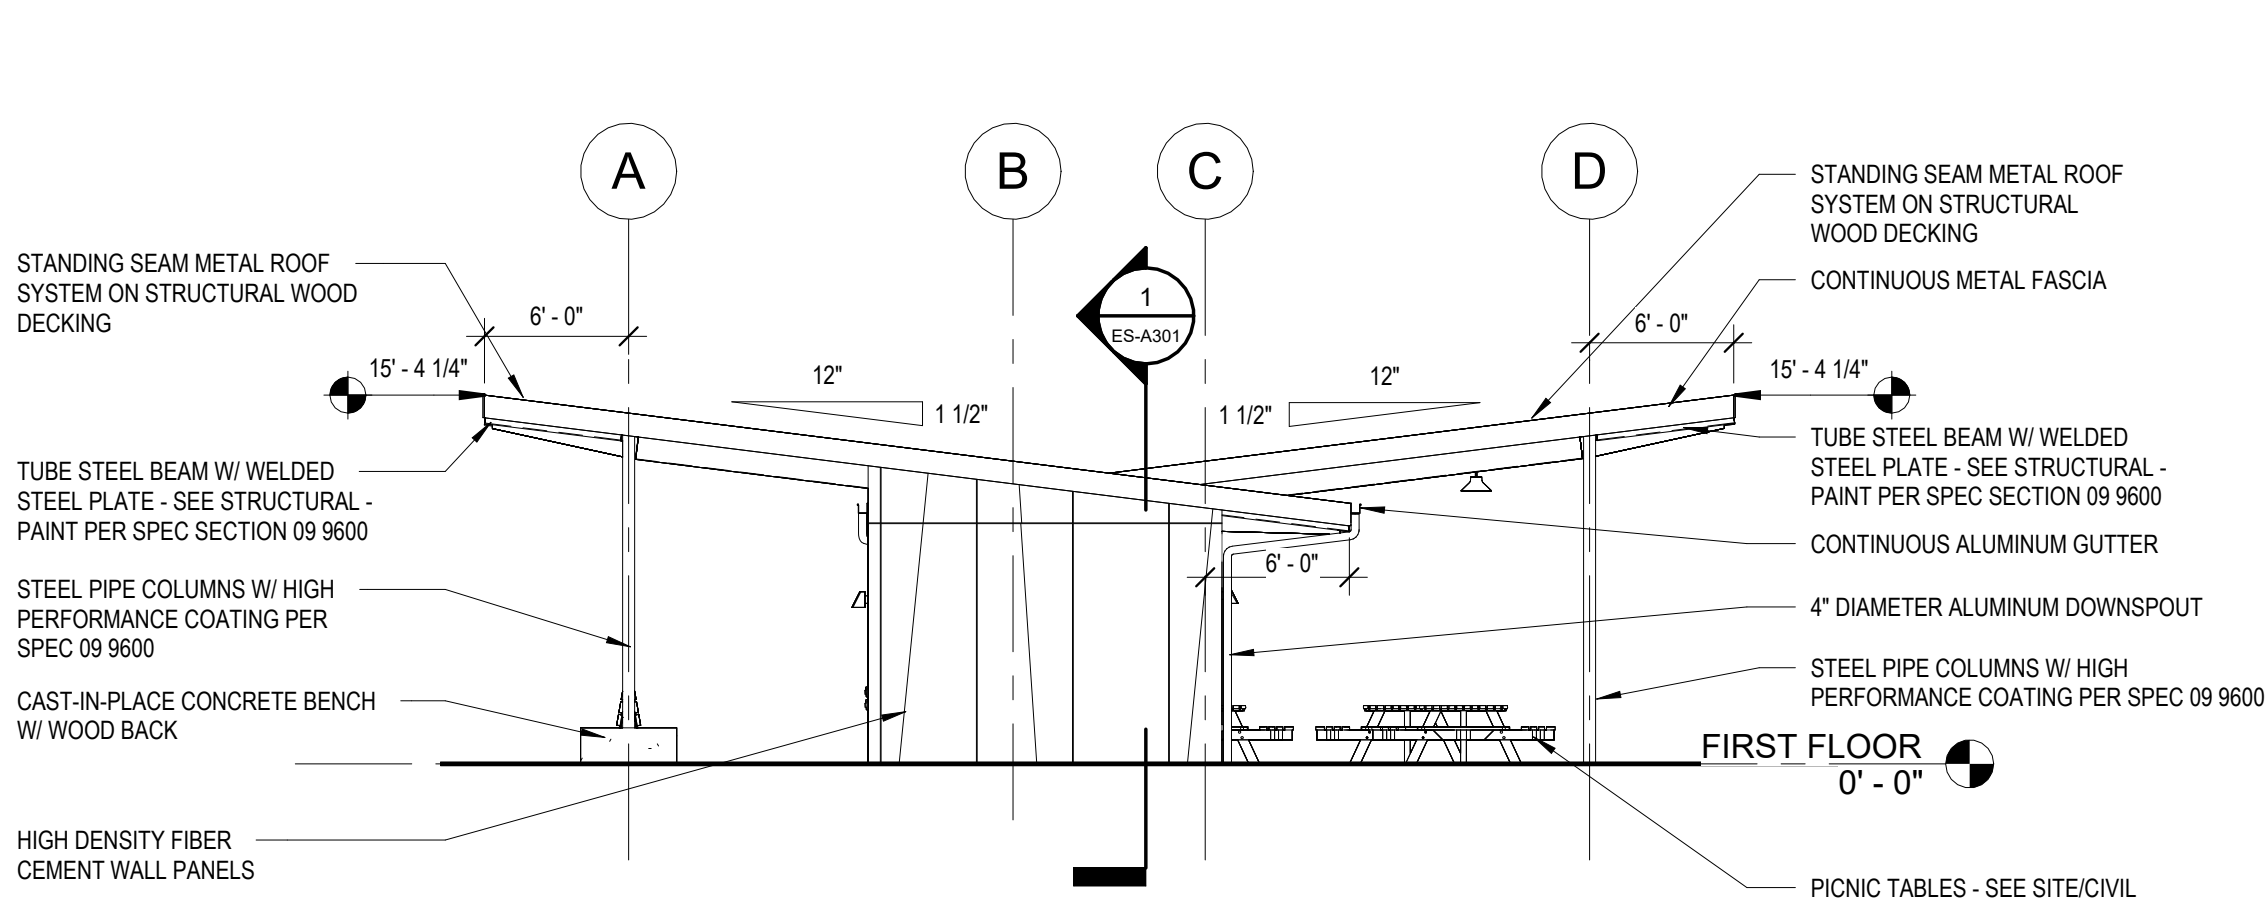


1 EAST PARCEL SHELTER - NORTH ELEVATION
ES-A201 / 1/8" = 1'-0"

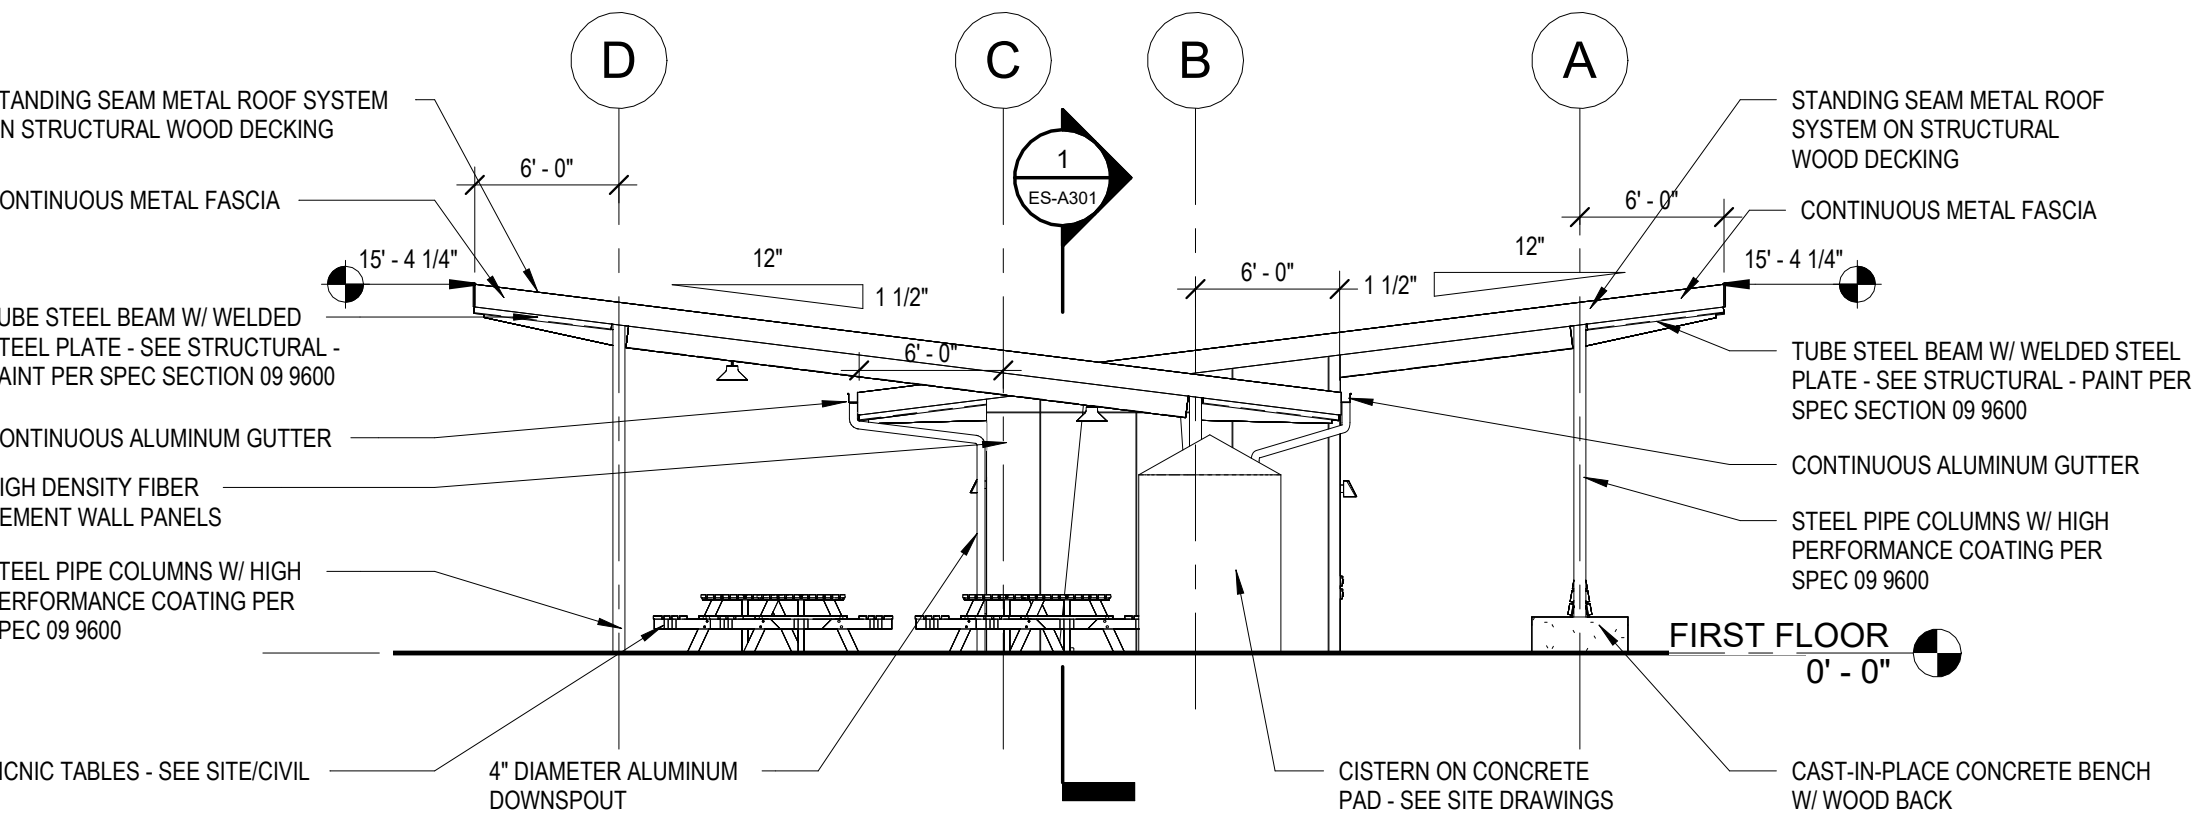

3 EAST PARCEL SHELTER - SOUTH ELEVATION
ES-A201 / 1/8" = 1'-0"

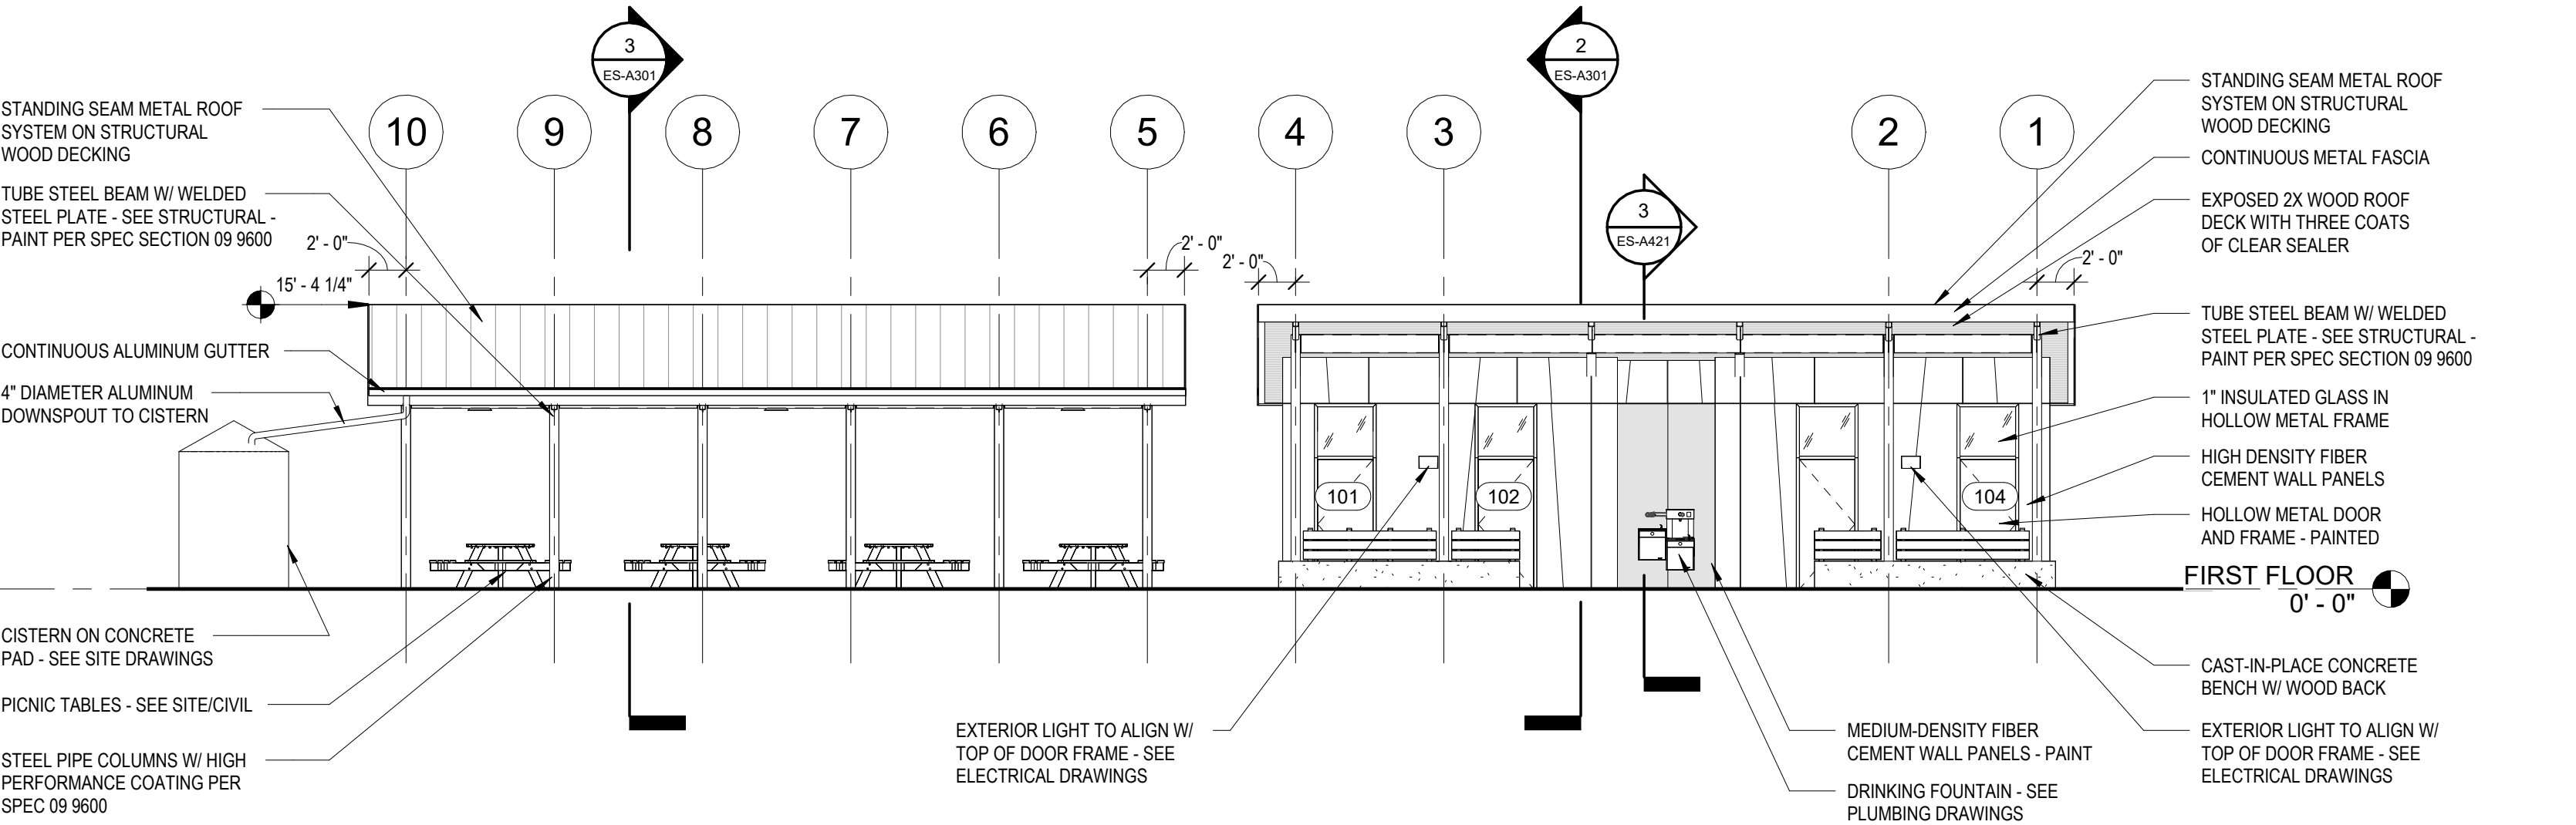


2 EAST PARCEL SHELTER - EAST ELEVATION
ES-A201 / 1/8" = 1'-0"

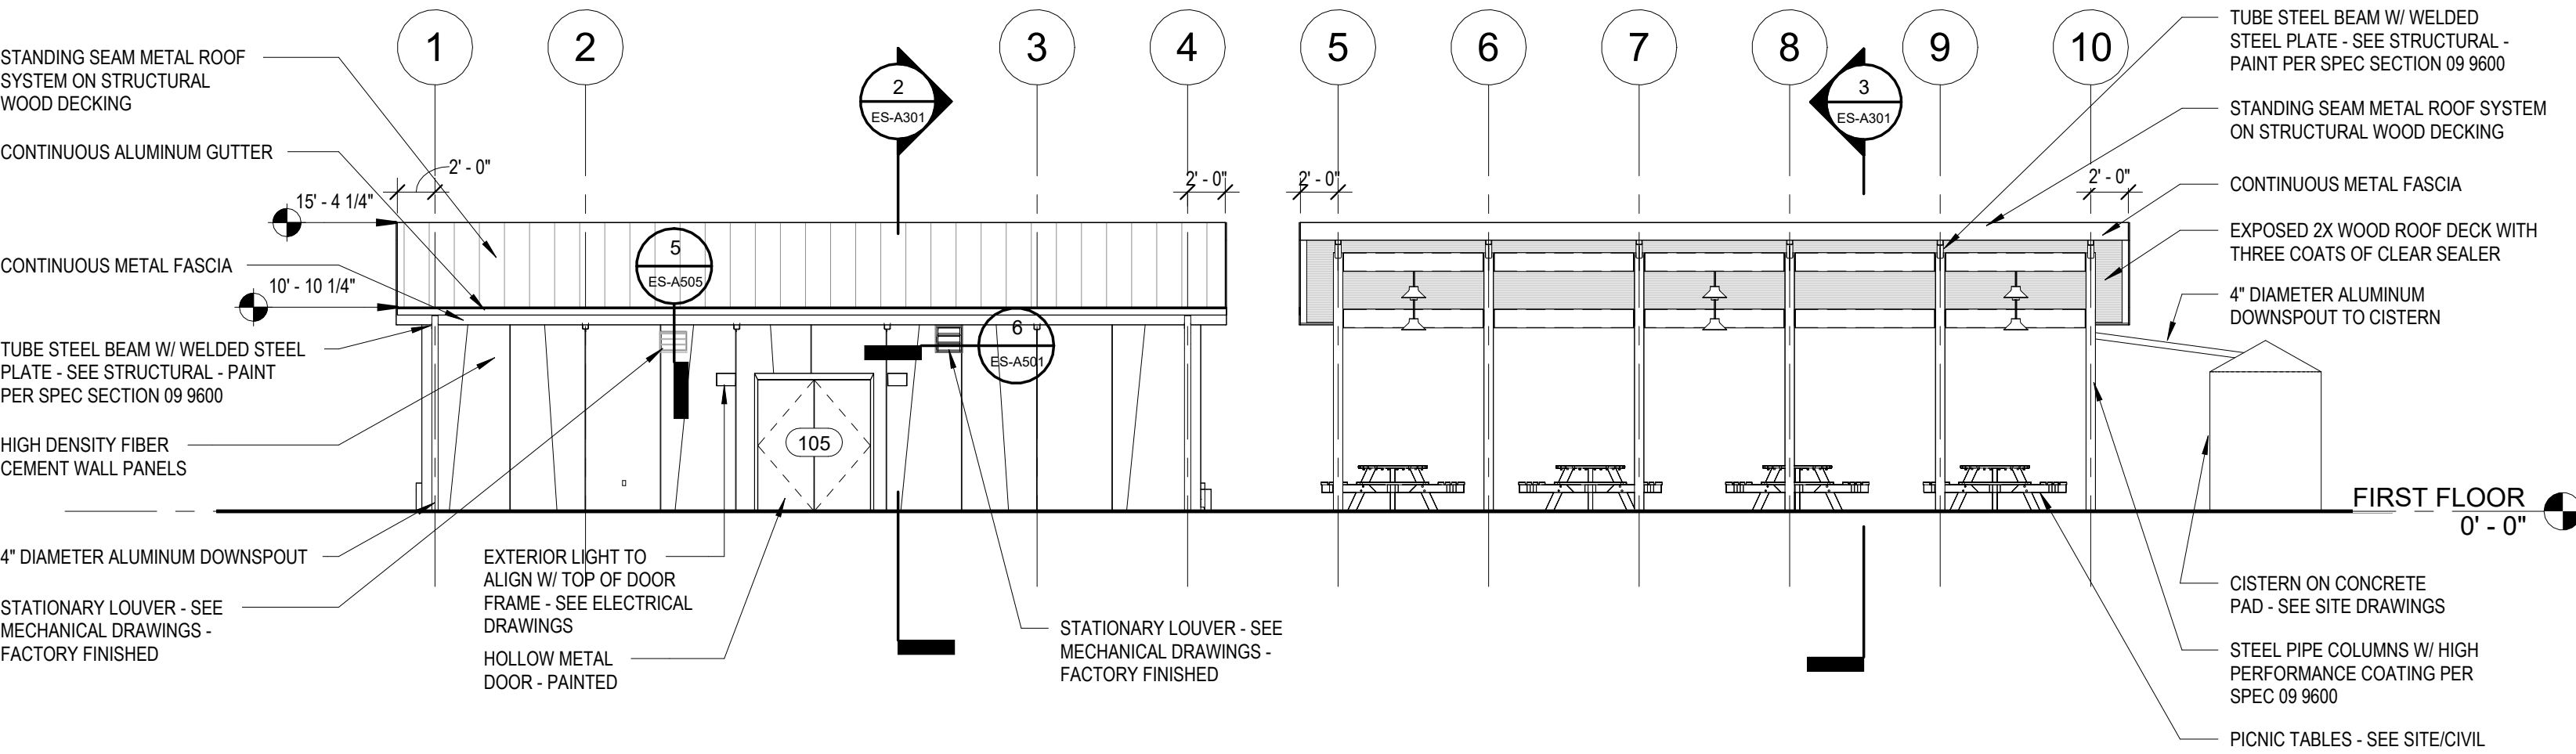

4 EAST PARCEL SHELTER - WEST ELEVATION
ES-A201 / 1/8" = 1'-0"

EXTERIOR MATERIAL SCHEDULE - EAST PARCEL SHELTER			
WALLS		STEEL	
HIGH DENSITY FIBER CEMENT PANELS	SWISSPEARL - AVERA - AV100-AV060	EXPOSED STRUCTURE	HIGH PERFORMANCE COATING - SW 7048 - URBANE BRONZE
MEDIUM DENSITY FIBER CEMENT PANELS	HIGH PERFORMANCE COATING - SW 7048 - URBANE BRONZE	HM DOORS AND FRAMES	HIGH PERFORMANCE COATING - SEE DOOR SCHEDULE FOR FINISH
ROOF		GLAZING	
STANDING SEAM METAL PANELS	PAC-CLAD - TITE-LOCK - GRANITE	VISION GLASS	LOW-E CLEAR INSULATED GLASS
SOFFITS	EXPOSED WOOD DECKING WITH THREE COATS CLEAR SEAL		
GUTTERS, DOWNSPOUTS, AND TRIM			
GUTTERS AND DOWNSPOUTS	HIGH PERFORMANCE COATING - SW 7048 - URBANE BRONZE		
NOTES:			
1. ALL FINISHES NOTED HERE REPRESENT THE BASIS OF DESIGN - SEE SPECIFICATIONS FOR THREE EQUALS			
2. ALL EXTERIOR PAINTS TO BE HIGH-PERFORMANCE COATINGS PER SPEC SECTION 09 9600.			

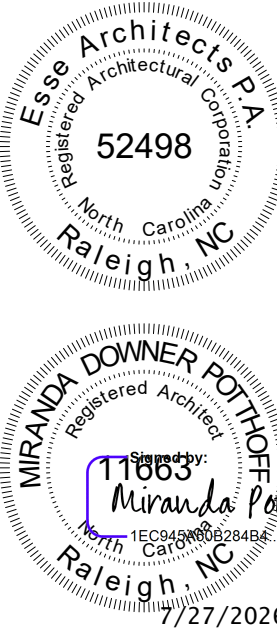

Susan Hatchell
Landscape Architecture, PLLC
711 W. North Street, Raleigh, NC 27603
p: 919-838-9600 f: 919-838-9700







EXTERIOR
ELEVATIONS

LAKE MYRA COUNTY PARK
Wake County, NC


REVISIONS

Date: 07/27/26


ES-A201

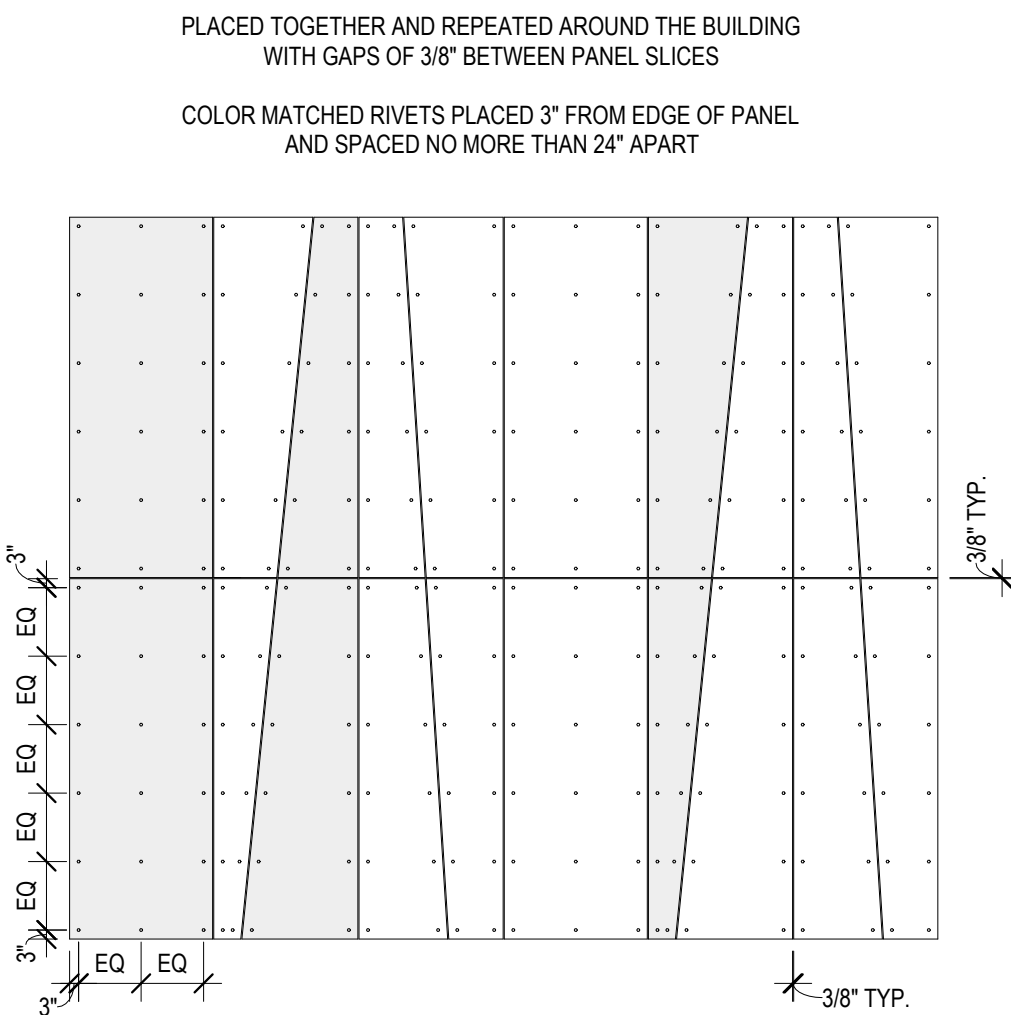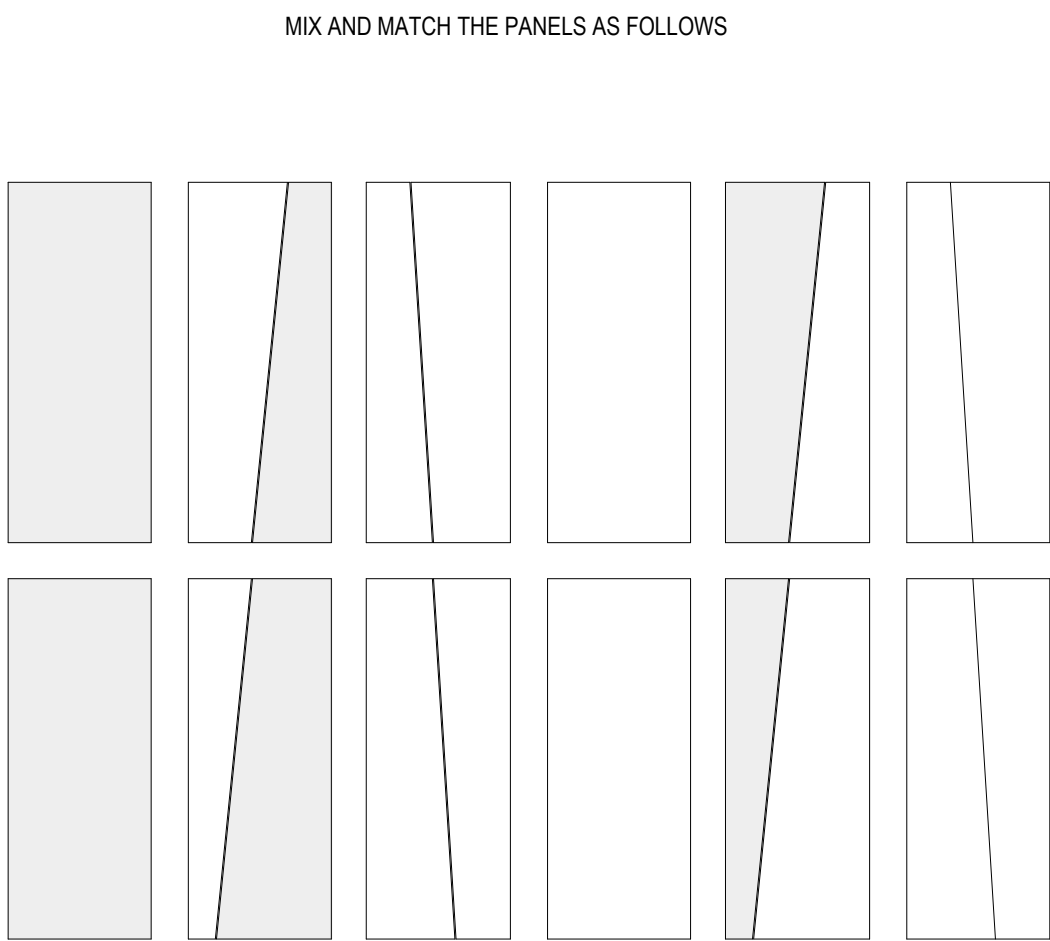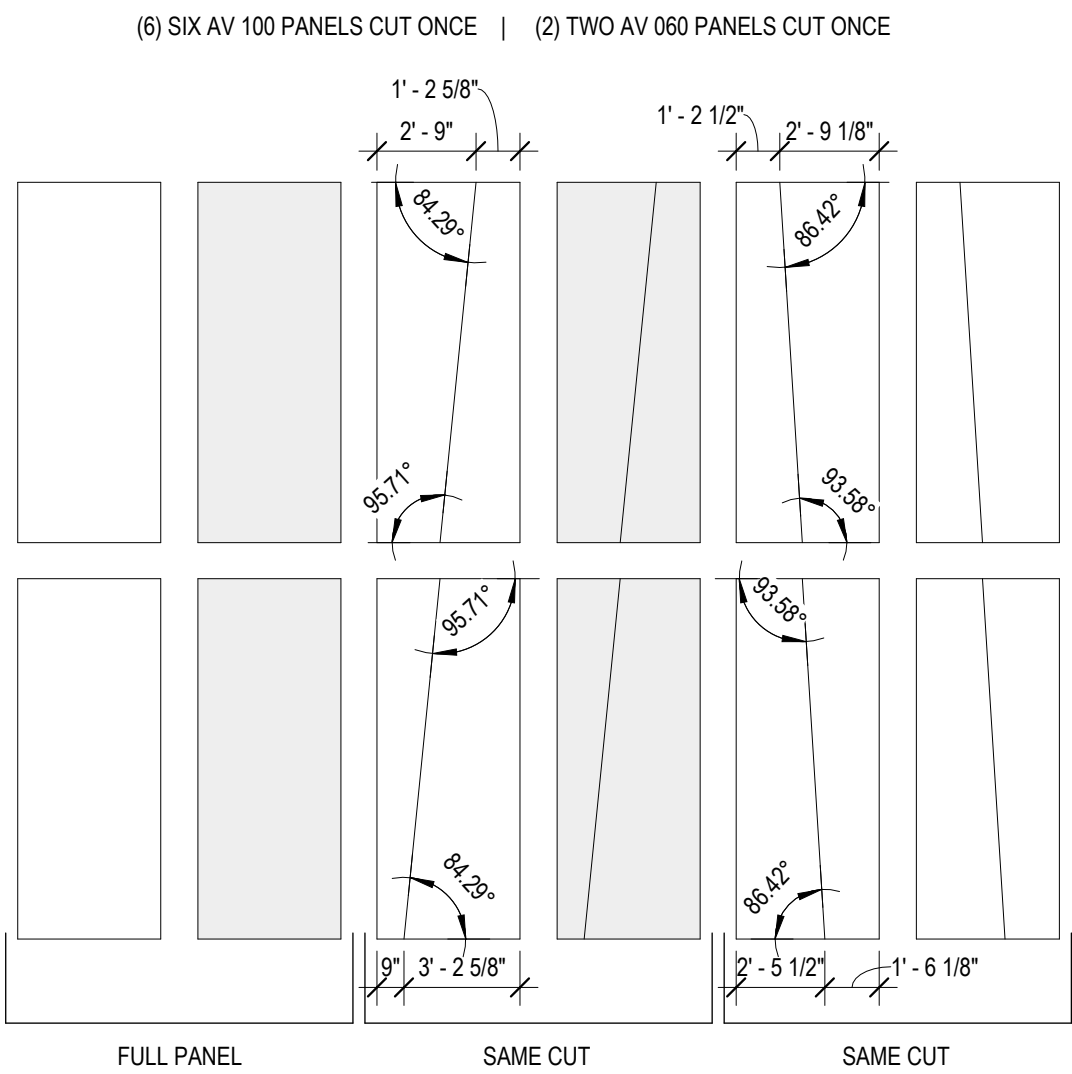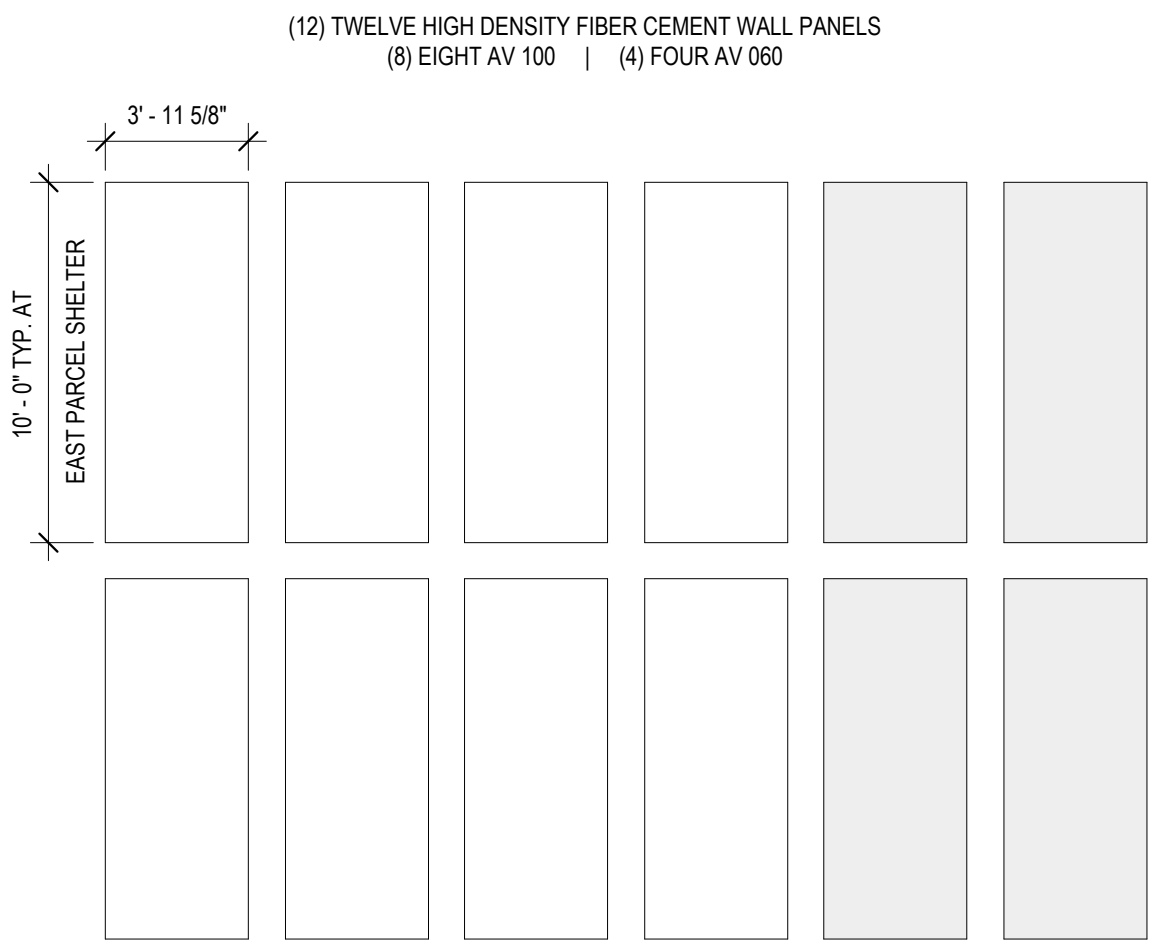


1 EAST PARCEL SHELTER EXTERIOR WALL PATTERN - EXPLODED
ES-A202/ 3/16" = 1'-0"

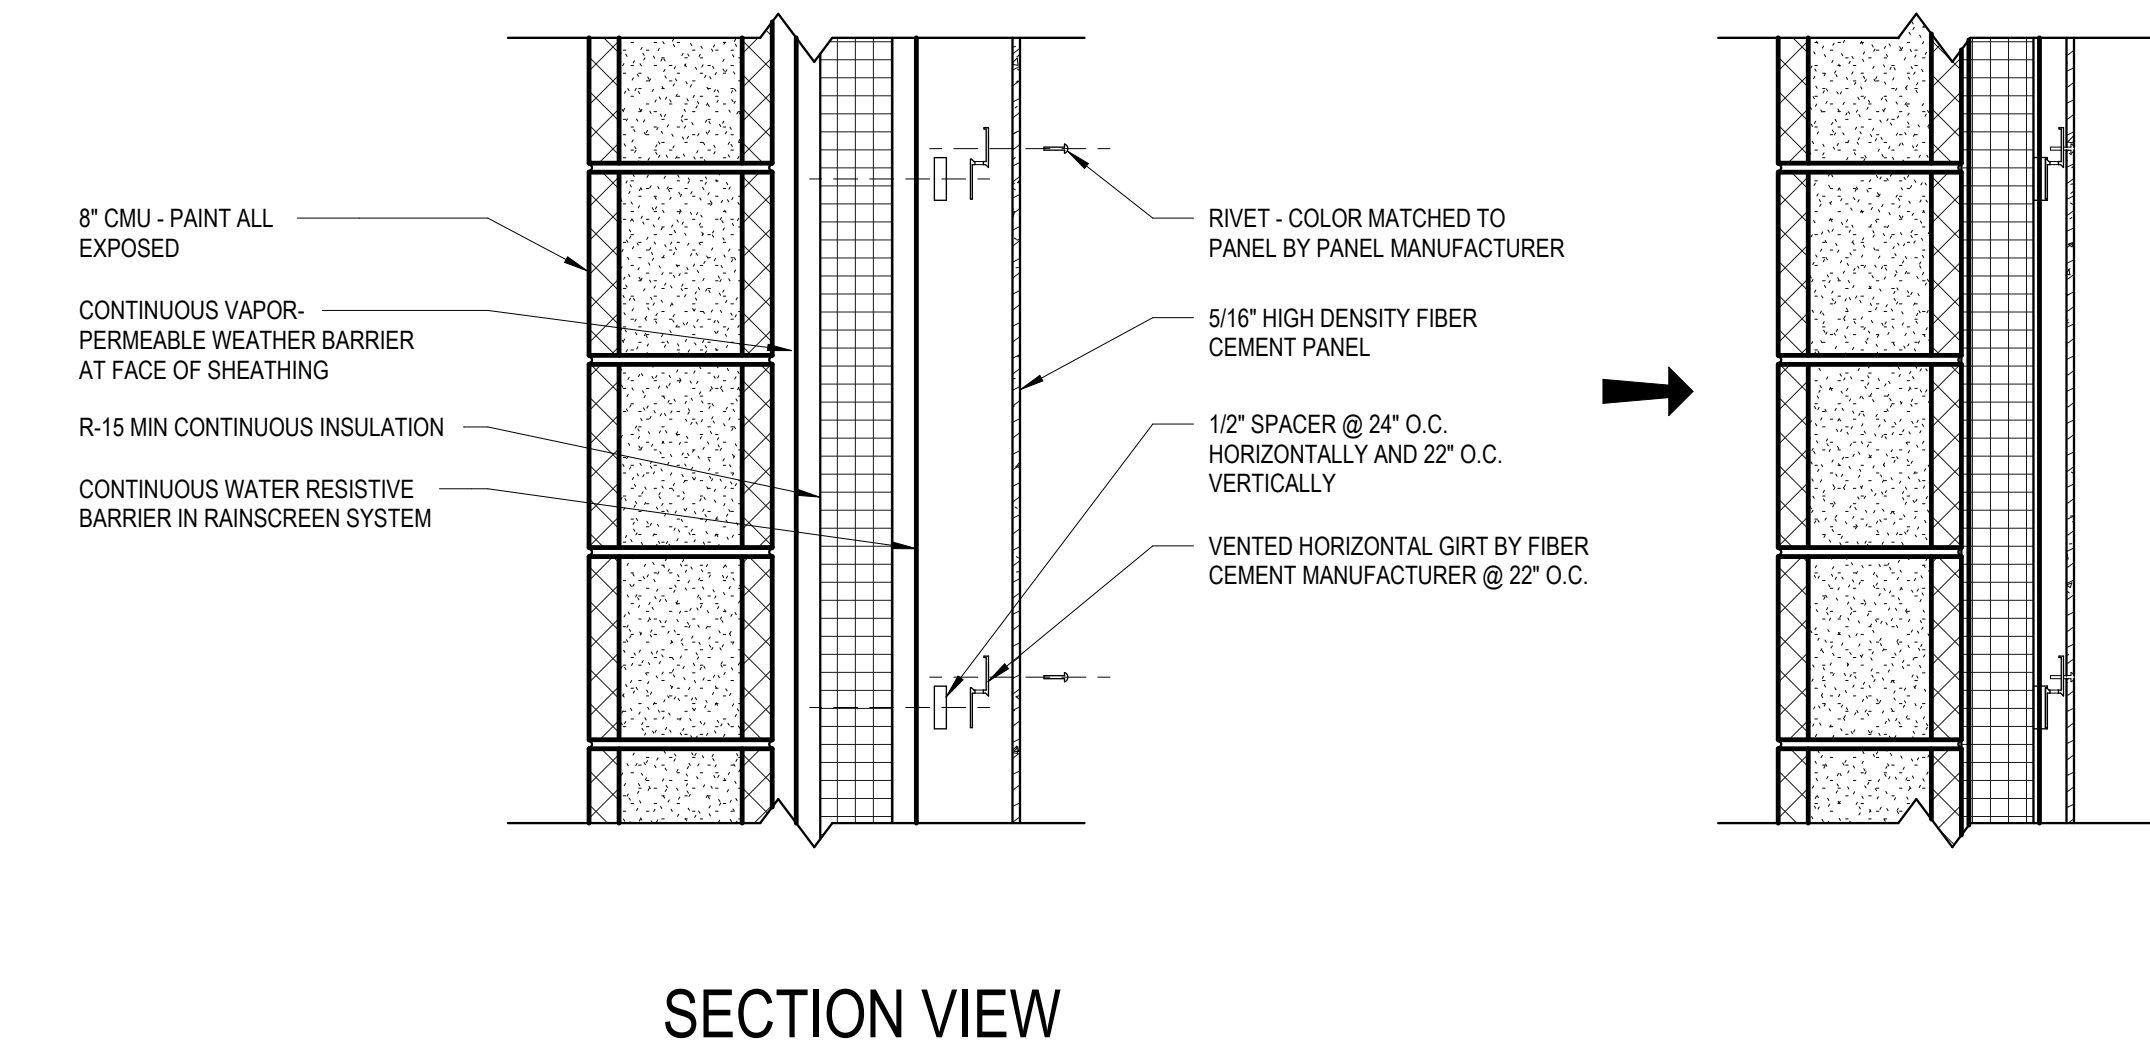

2 EXPLODED PANEL ATTACHMENT
ES-A202/ 1 1/2" = 1'-0"

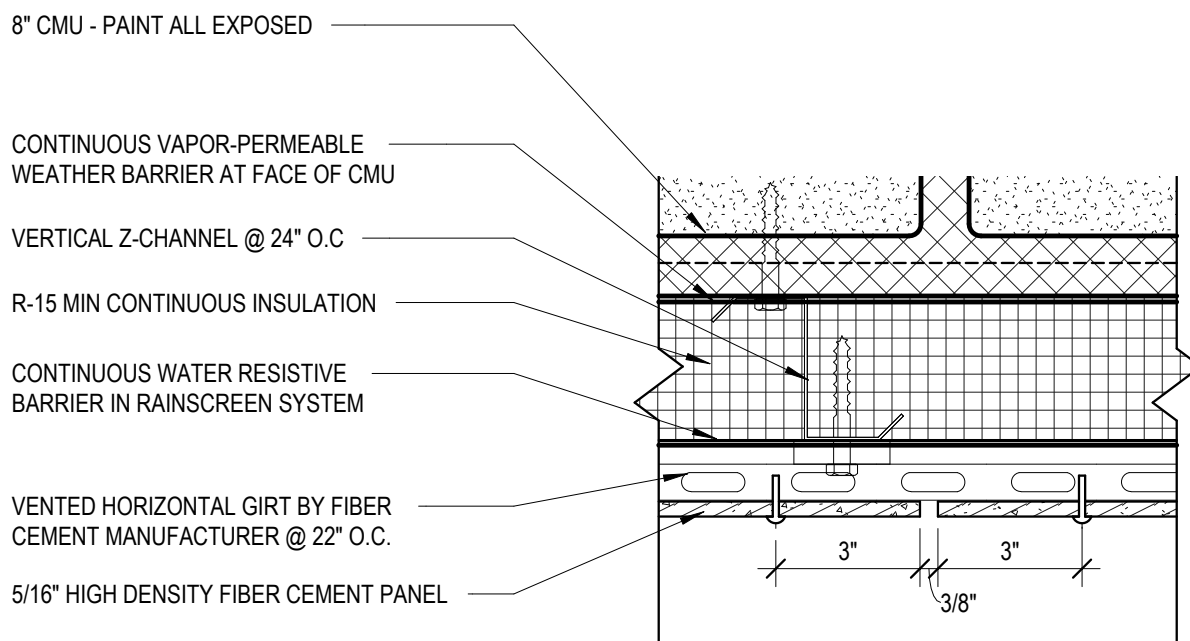


3 DETAIL @ VERTICAL PANEL JOINT
ES-A202/ 3" = 1'-0"

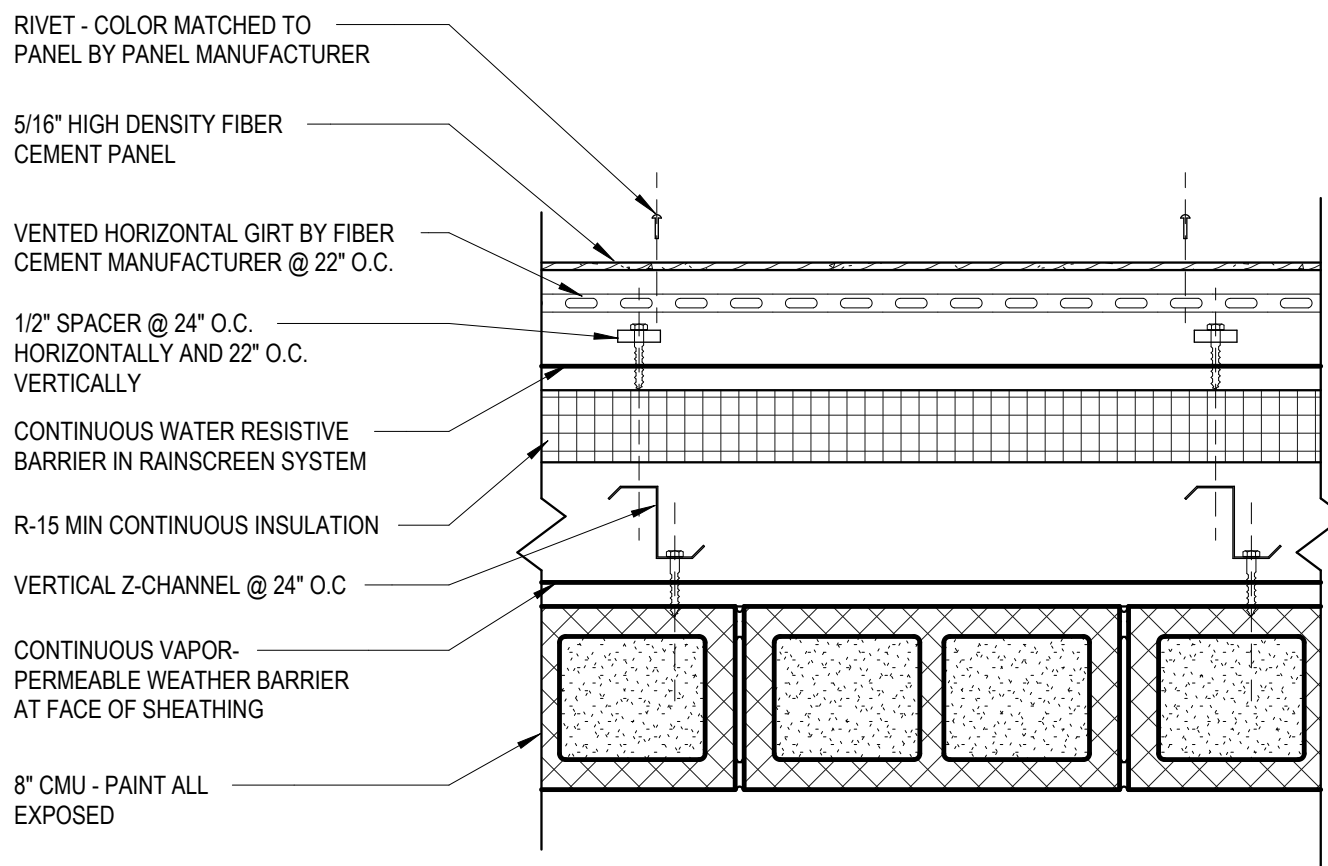

PLAN VIEW

NOTE: PROVIDE CONTINUOUS POWDER COATED ALUMINUM TRIM ON ALL OUTSIDE CORNERS. SEE FLOOR PLAN AND DETAILS FOR LOCATION CALLOUTS.

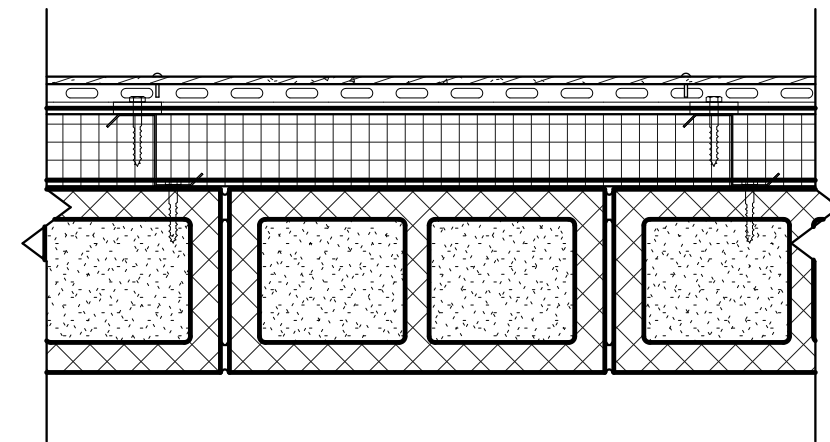

Susan Hatchell
Landscape Architecture, PLLC
711 W. North Street, Raleigh, NC 27603
p: 919-838-9600 f: 919-838-9700

Esse Architects
832 PERSHING ROAD | RALEIGH, NORTH CAROLINA 27608


EXTERIOR PANEL LAYOUT

LAKE MYRA COUNTY PARK
Wake County, NC




REVISIONS

Date: 07/27/26

ES-A202

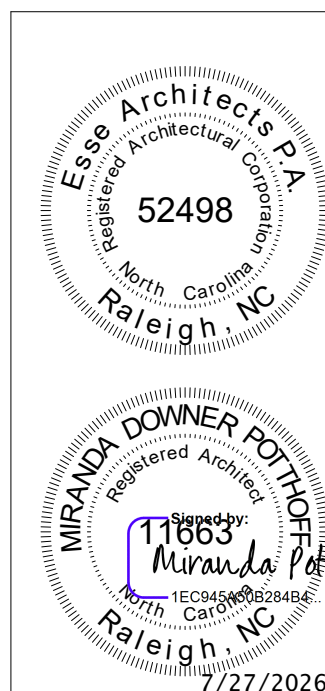

- NOTES:
1. IMAGE IS FOR REFERENCE, CONFIRM LAYOUT THROUGH SHOP DRAWINGS
 2. CENTER VERTICAL PANEL JOINTS WITH THE CENTER OF STEEL BEAMS ABOVE
 3. SEE ES-202 FOR HIGH DENSITY FIBER CEMENT PANEL PATTERN AND PLACEMENT

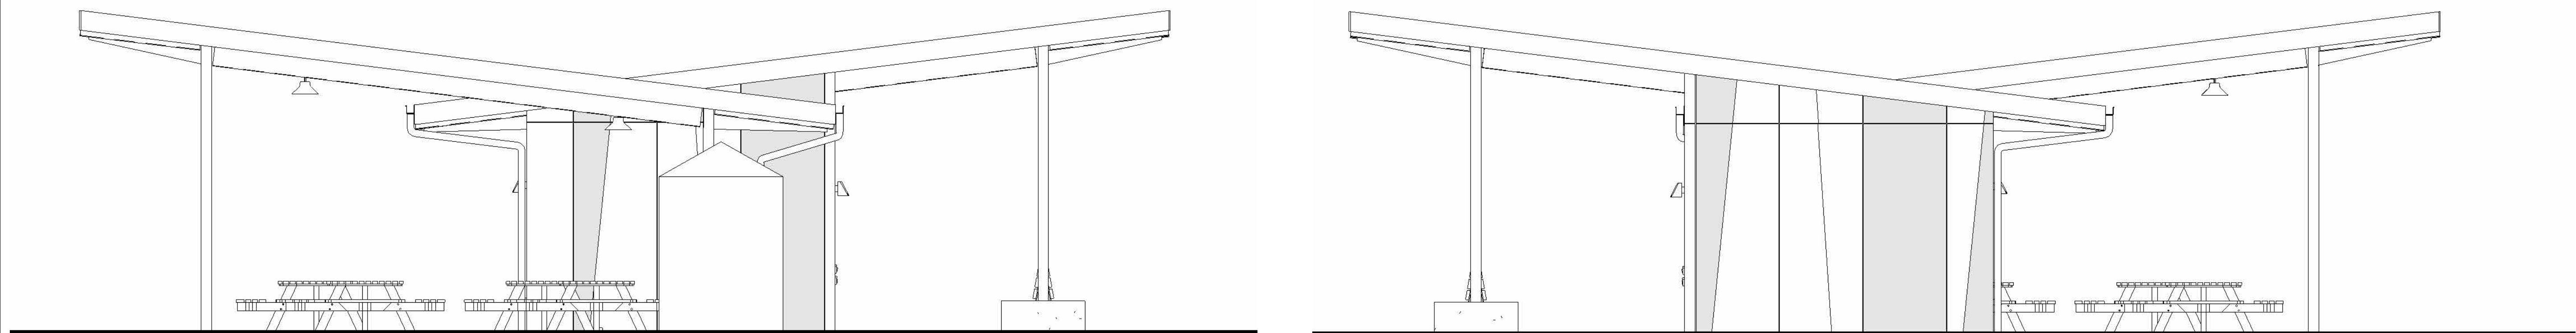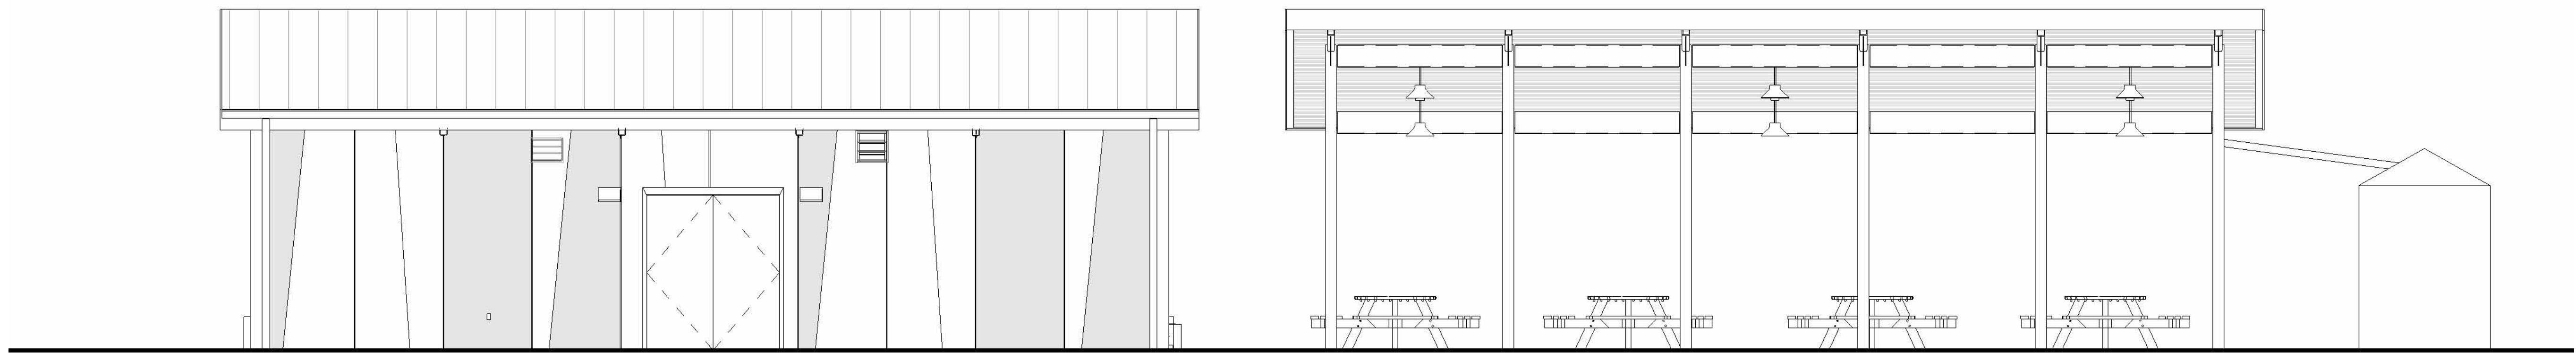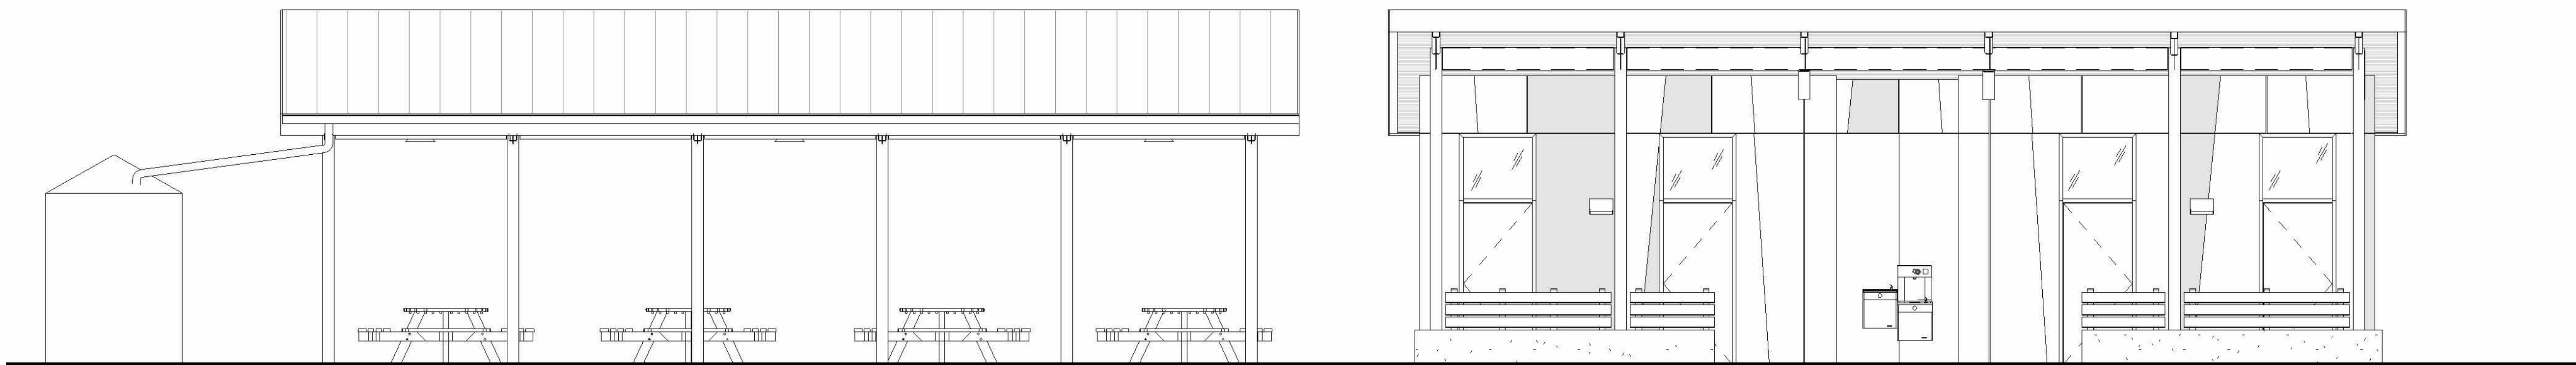


Susan
Hatchell
Landscape Architecture, PLLC
711 W. North Street, Raleigh, NC 27603
p: 919-838-9600 f: 919-838-9700



EXTERIOR PANEL
LAYOUT


LAKE MYRA COUNTY PARK
Wake County, NC

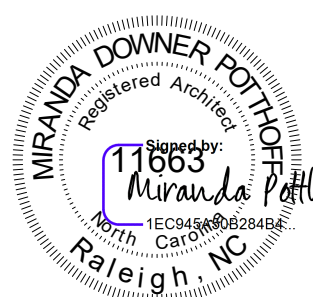


REVISIONS

Date: 07/27/26


ES-A203

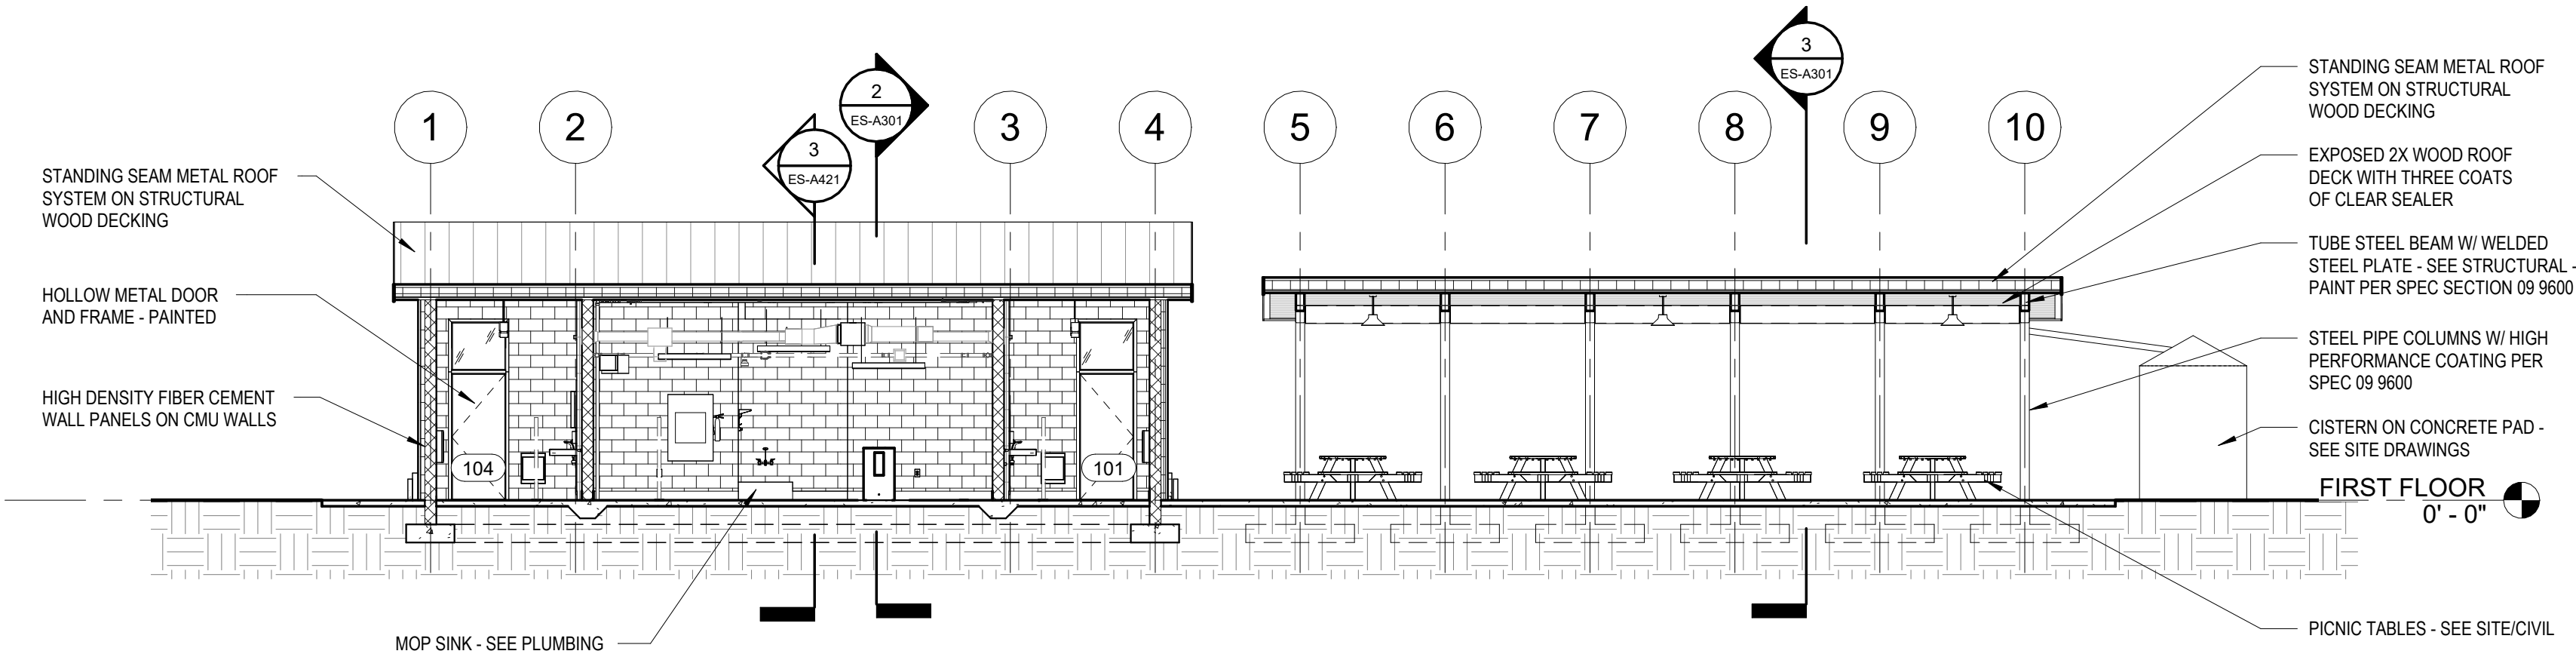

1 EAST PARCEL SHELTER - RESTROOM LONGITUDINAL SECTION
1/8" = 1'-0"

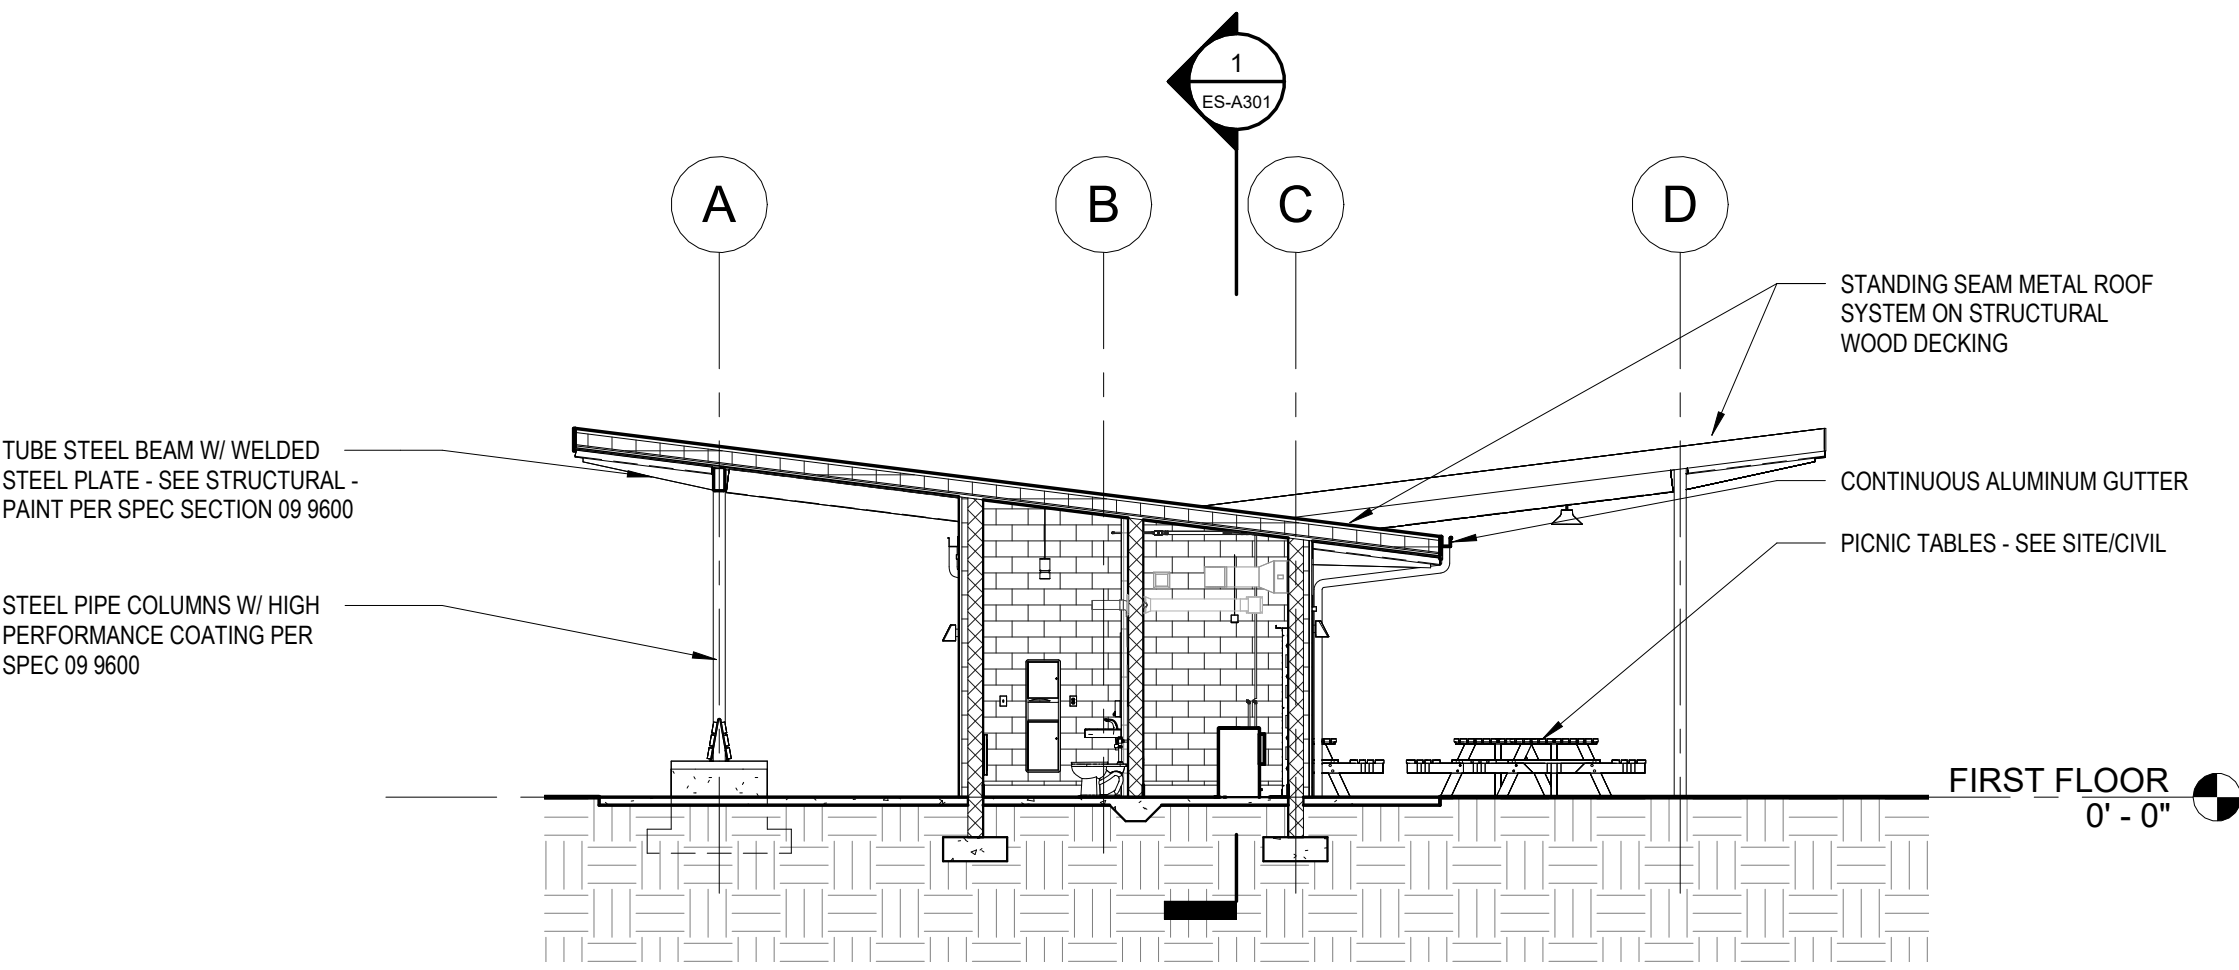

2 EAST PARCEL SHELTER - RESTROOM SECTION
1/8" = 1'-0"

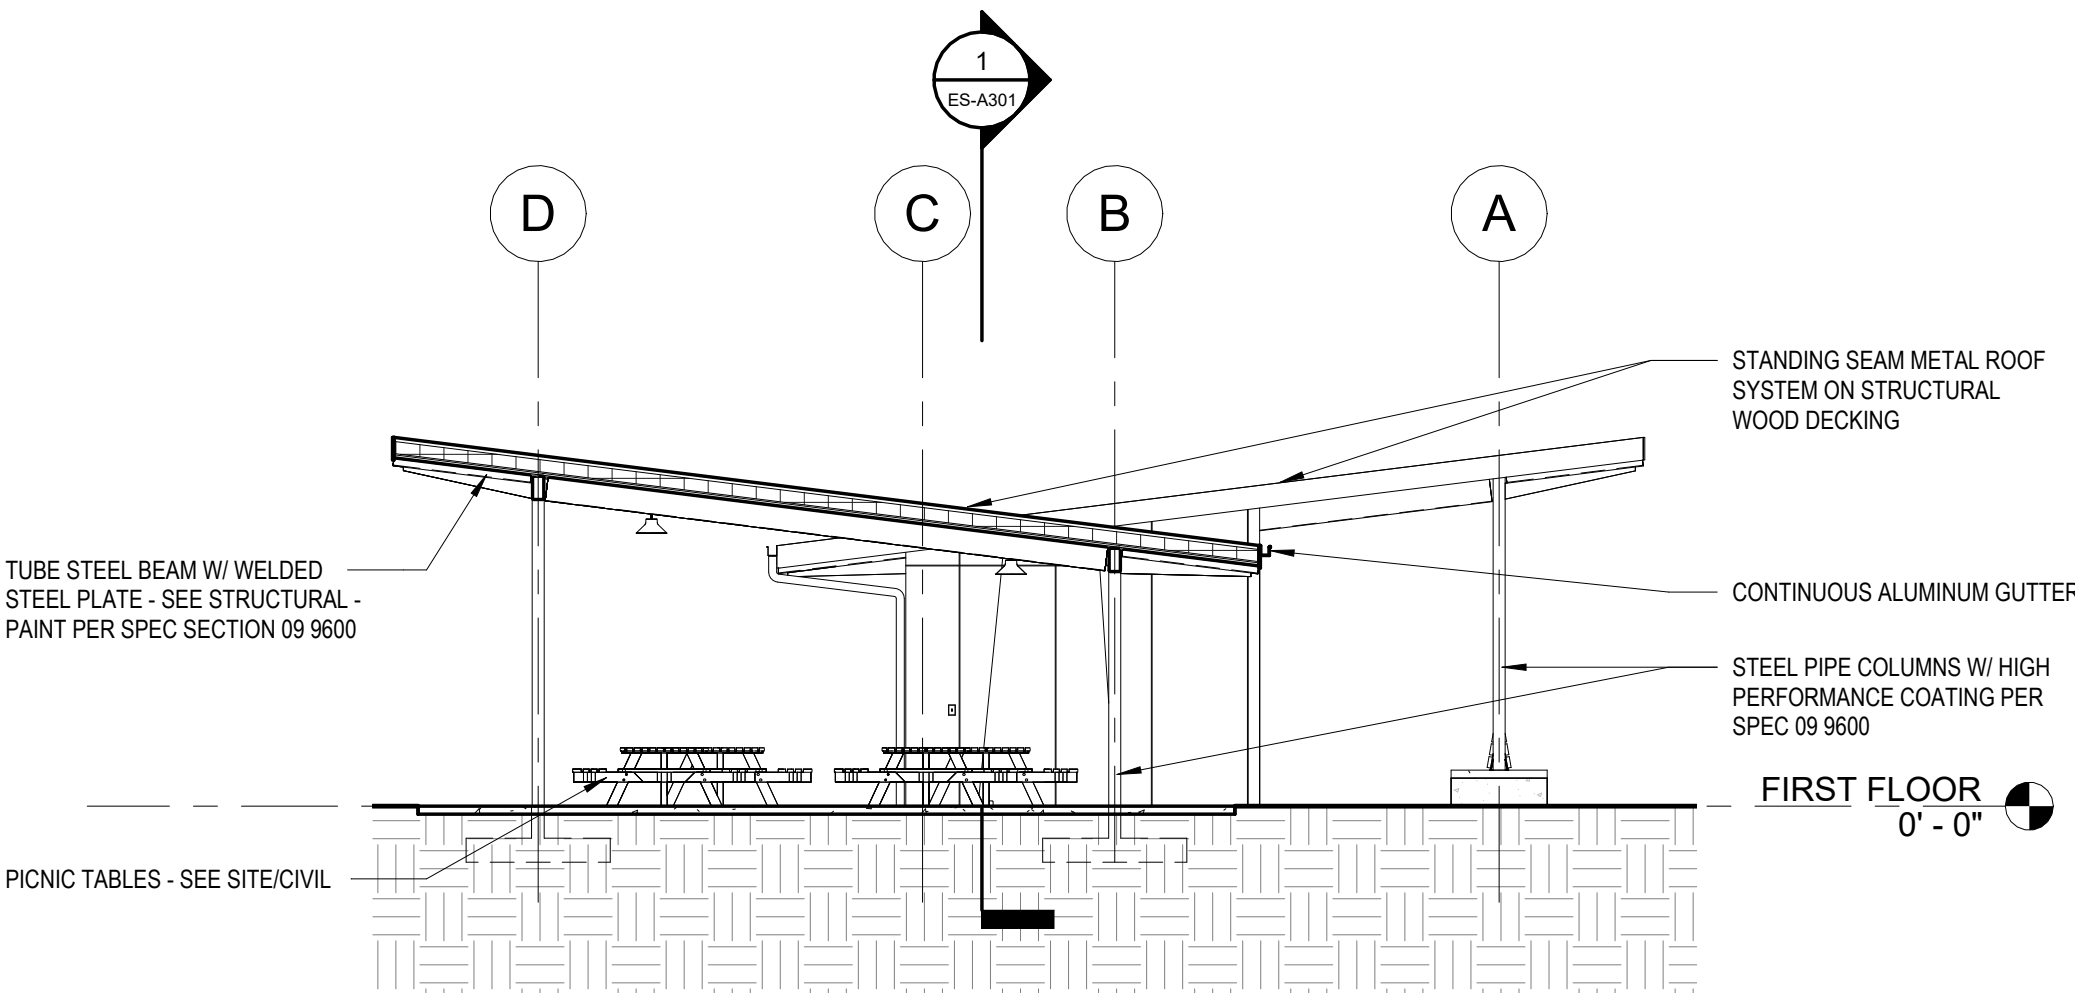

3 EAST PARCEL SHELTER - PICNIC SHELTER SECTION
1/8" = 1'-0"

Susan Hatchell
Landscape Architecture, PLLC
711 W. North Street, Raleigh, NC 27603
p: 919-838-9600 f: 919-838-9700


Esse Architects
832 FRESHING ROAD | RALEIGH, NORTH CAROLINA 27608

BUILDING SECTIONS


LAKE MYRA COUNTY PARK
Wake County, NC

REVISIONS


Date: 07/27/26
ES-A301

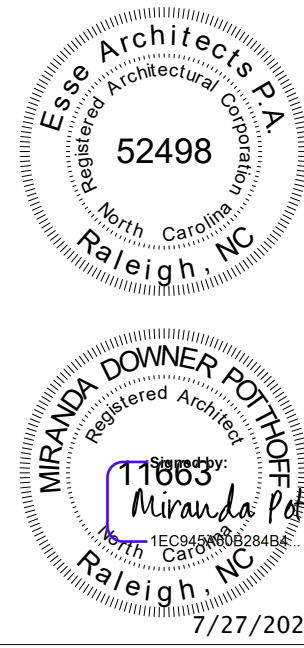


NOTE: FLUSH VALVE
MUST BE MOUNTED
TO THE WIDE SIDE
OF THE STALL.

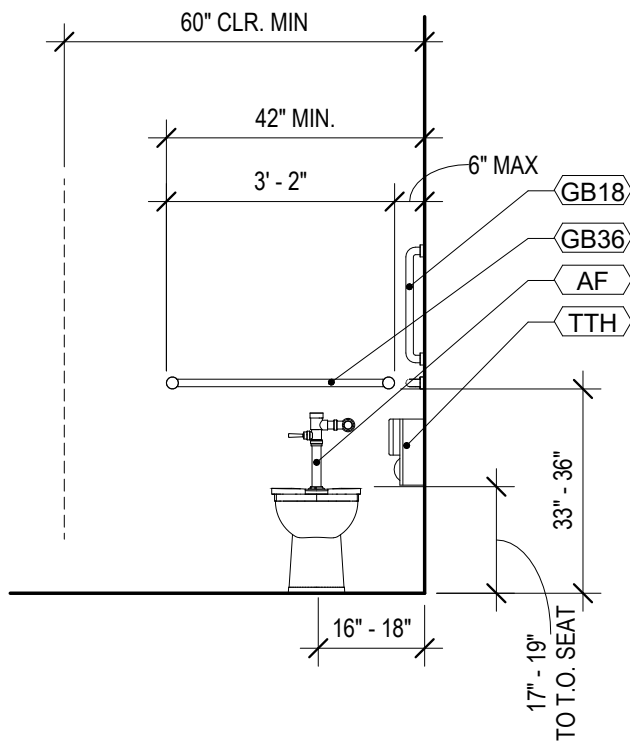


A
ADA TOILET STALL,
FRONT ELEVATION

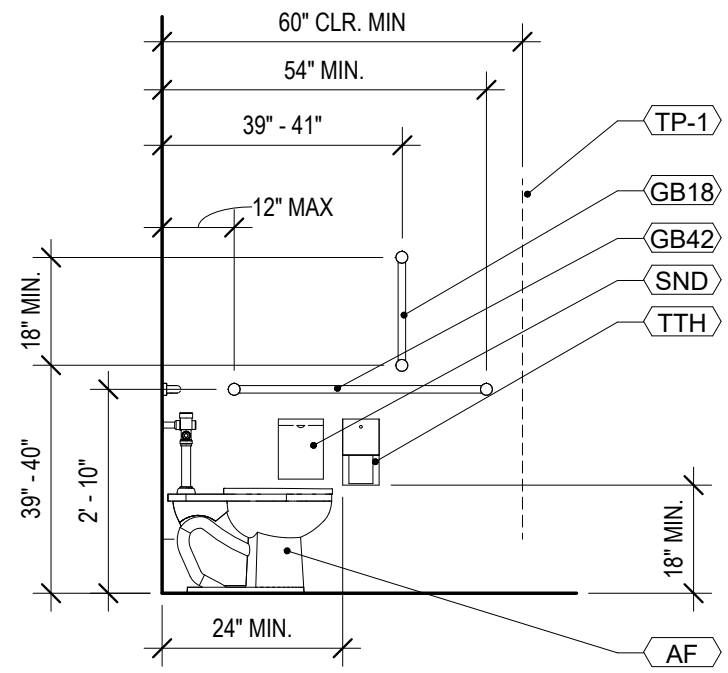


A
ADA TOILET STALL,
SIDE ELEVATION

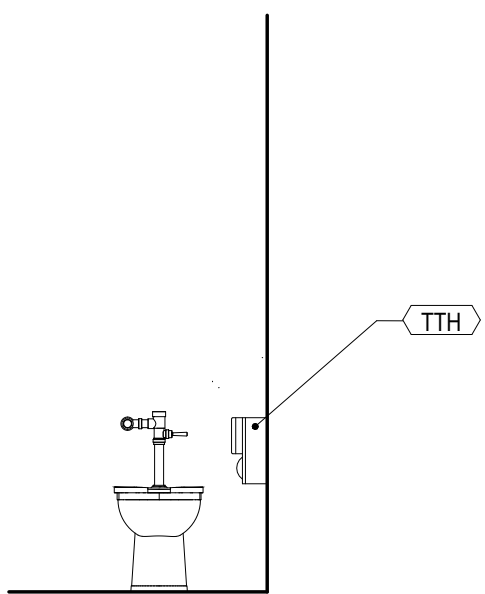


B
NON - ADA TOILET STALL,
FRONT ELEVATION

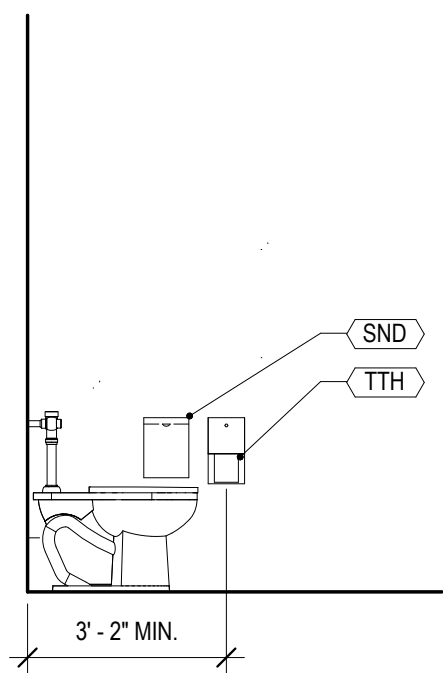


B
NON - ADA TOILET STALL,
SIDE ELEVATION

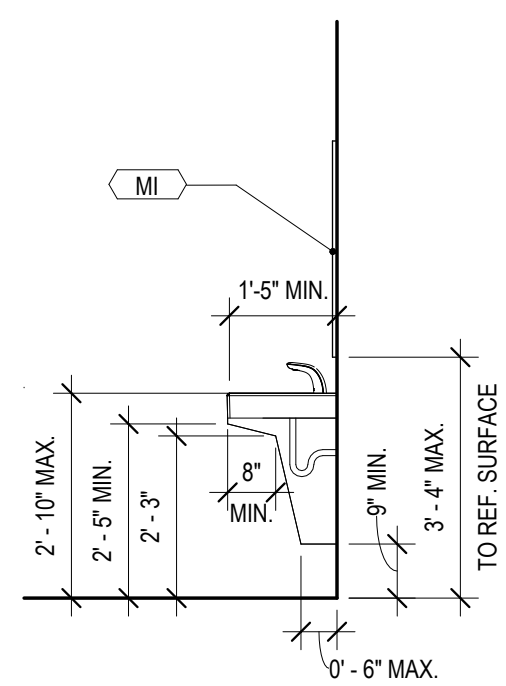


E
ADA WALL - MOUNTED SINK,
SIDE ELEVATION

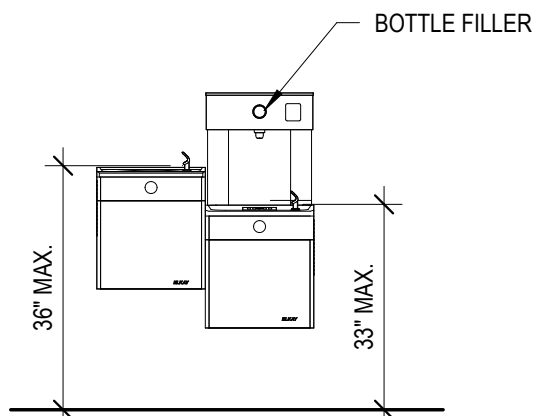

J
ADA WATER FOUNTAIN,
FRONT ELEVATION

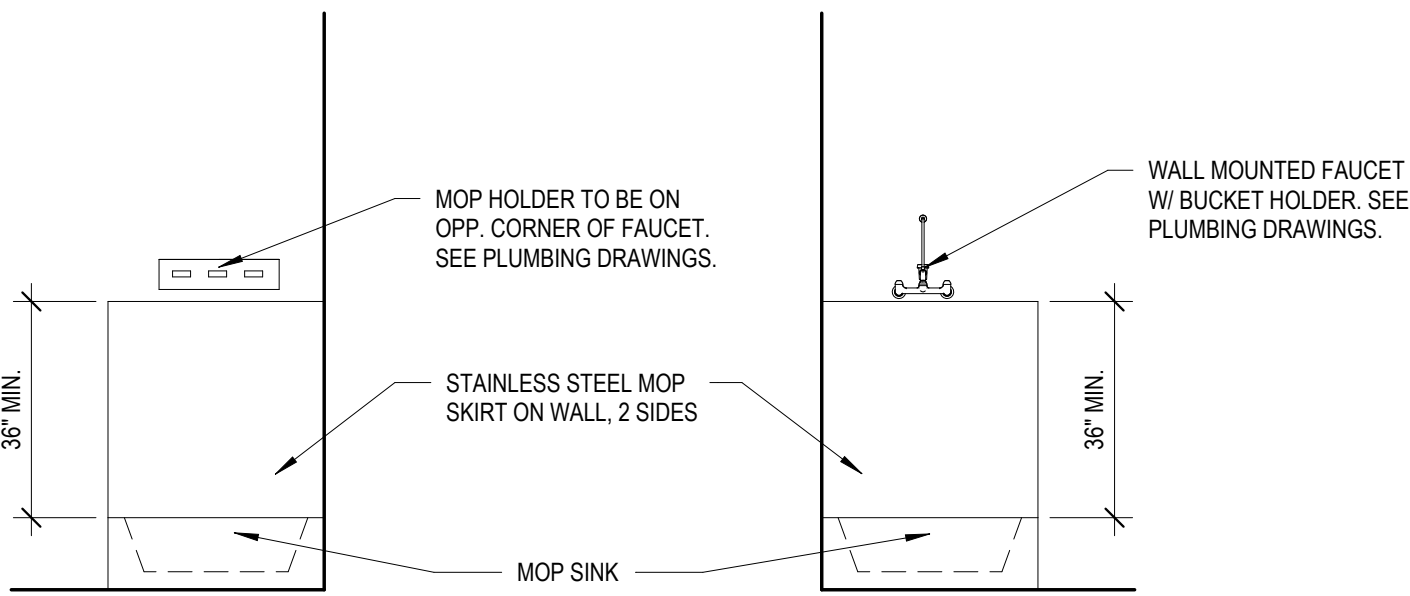

K
MOP SINK,
TYPICAL SIDE ELEVATIONS

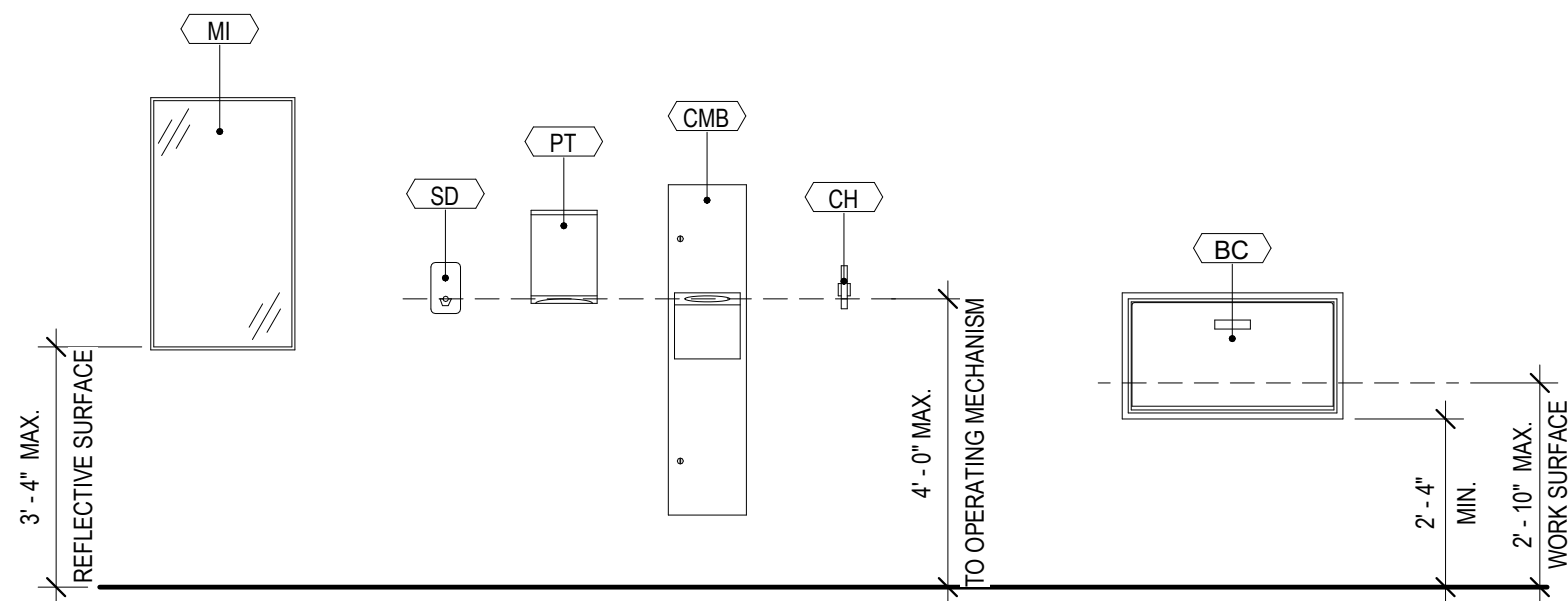

TOILET ACCESSORY MOUNTING HEIGHTS

SYMBOL LEGEND	
X-X	FINISH TAG
X	TOILET ASSEMBLY TAG. SEE A400 FOR ADDITIONAL INFORMATION
#	TOILET ACCESSORIES LEGEND
AF	ACCESSIBLE FIXTURE
BC	BABY CHANGING STATION - SURFACE MOUNTED
CF	CLEAR FLOOR SPACE 30" x 52"
CH	COAT HOOK
CMB	COMBINED PAPER TOWEL/TRASH
FD	FLOOR DRAIN - SEE PLUMBING DRAWINGS
GB18	GRAB BAR 18" LONG (VERTICAL)
GB32	GRAB BAR 32" LONG (REAR WALLS)
GB36	GRAB BAR 36" LONG (REAR WALLS)
GB42	GRAB BAR 42" LONG (SIDE WALLS)
MI	MIRROR 24" X 36"
PT	PAPER TOWEL DISPENSER
SD	SOAP DISPENSER
SND	SANITARY NAPKIN DISPOSAL
TD	67" ACCESSIBLE TURNING DIAMETER
TR	TRASH RECEPTACLE
TTH	TOILET TISSUE HOLDER
NOTES:	
1. PLUMBING CONTRACTOR TO PROVIDE PROTECTIVE INSULATION AT HOT PIPES BELOW LAVATORY PER ACCESSIBILITY CODE.	
2. FLUSH CONTROL VALVES AT ACCESSIBLE TOILETS TO BE MOUNTED ON THE WIDE SIDE OF TOILET STALL OR ROOM. SEE SPECIFICATIONS FOR DETAILS OF TOILET ACCESSORIES	
4. ALL TOILET PARTITIONS ARE FLOOR MOUNTED AND OVERHEAD BRACED.	
5. SLOPE SLAB TO DRAIN INTO FLOOR DRAINS. THRESHOLDS SLOPE IN DOOR OPENINGS SHALL NOT EXCEED 1:8 SLOPE OR 1/2" IN HEIGHT PER ACCESSIBILITY CODE.	

Susan
Hatchell
Landscape Architecture, PLLC
711 W. North Street, Raleigh, NC 27603
p: 919-838-9600 f: 919-838-9700




TYPICAL TOILET AND
BATH ACCESSORIES


LAKE MYRA COUNTY PARK
Wake County, NC

REVISIONS


Date: 07/27/26

ES-A400

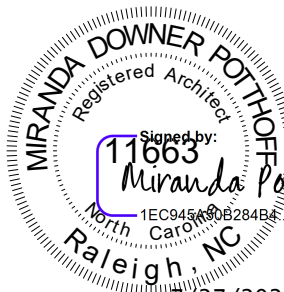


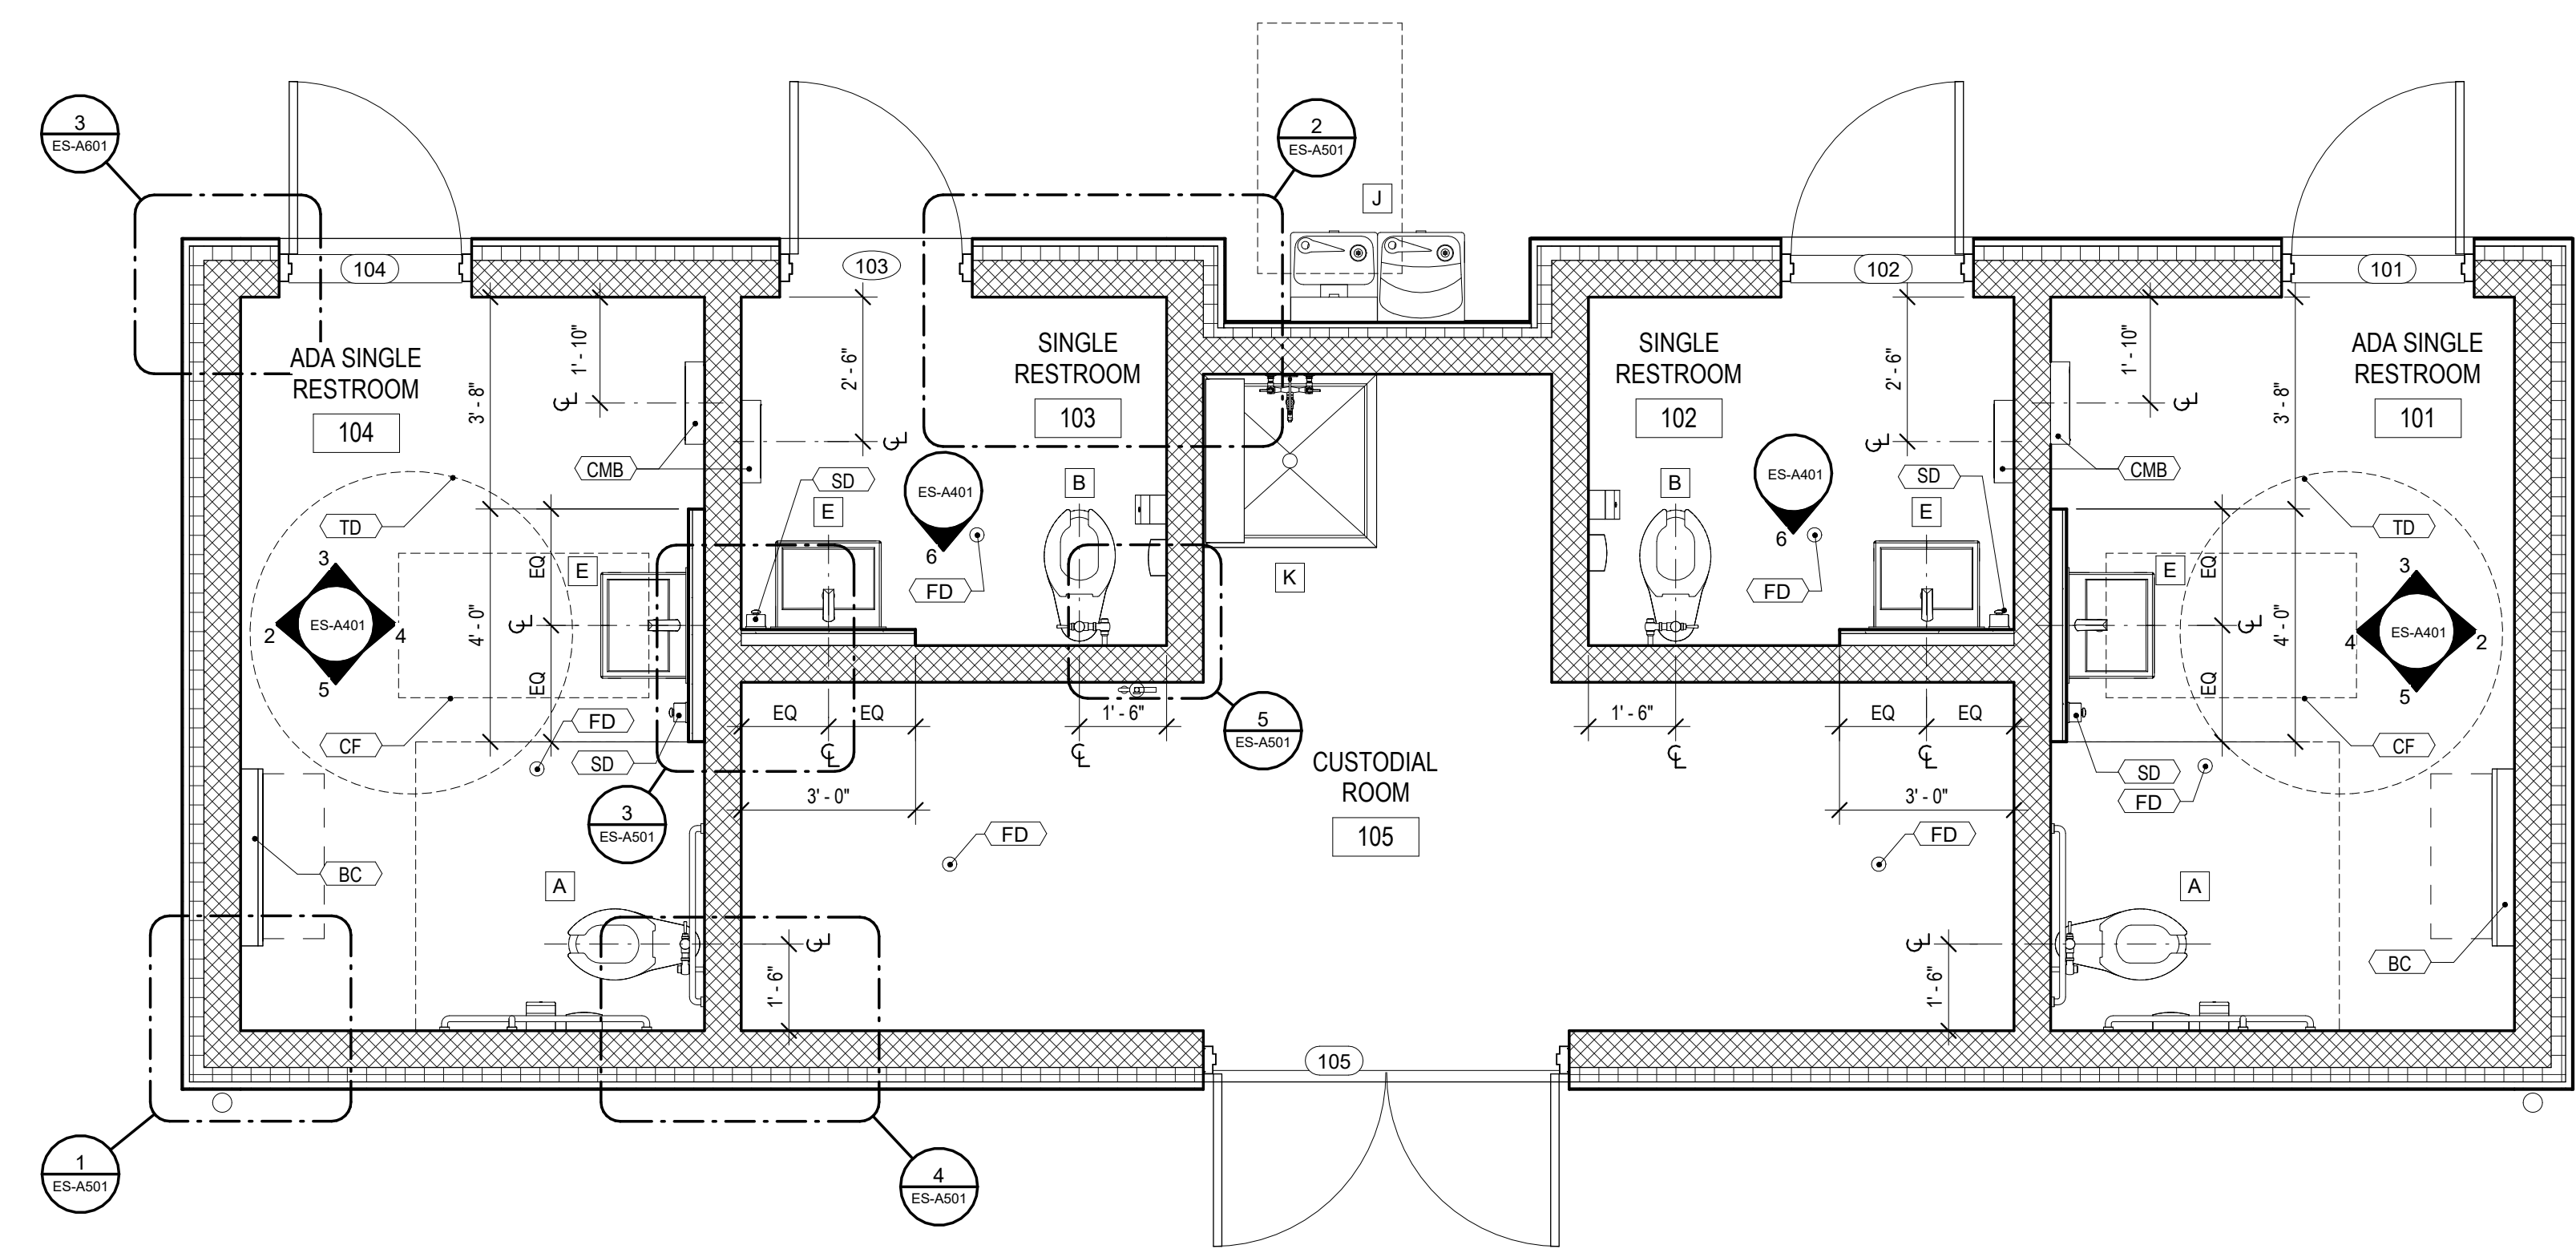


1 ENLARGED TOILET PLAN
ES-A401 3/8" = 1'-0"

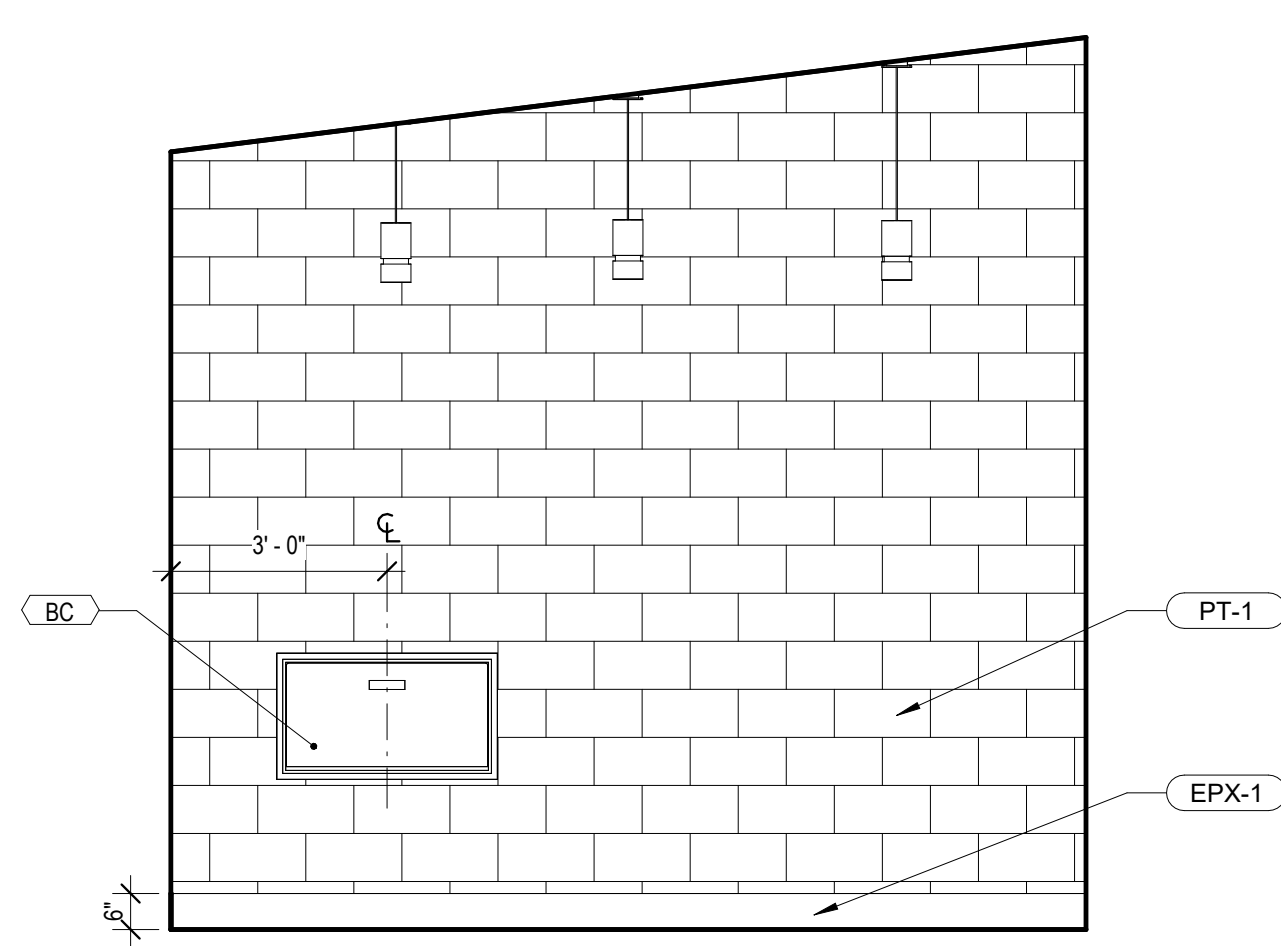


2 ADA SINGLE RESTROOM (101 & 104) - CHANGING STATION
ES-A401 3/8" = 1'-0"

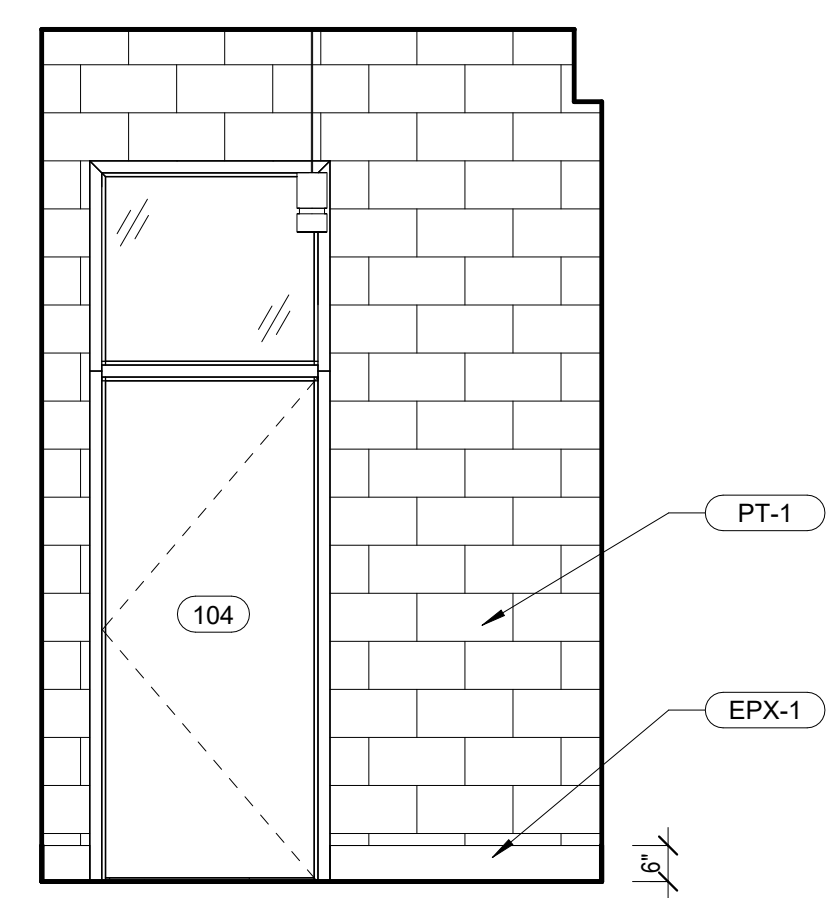


3 ADA SINGLE RESTROOM (101 & 104) - ENTRY
ES-A401 3/8" = 1'-0"

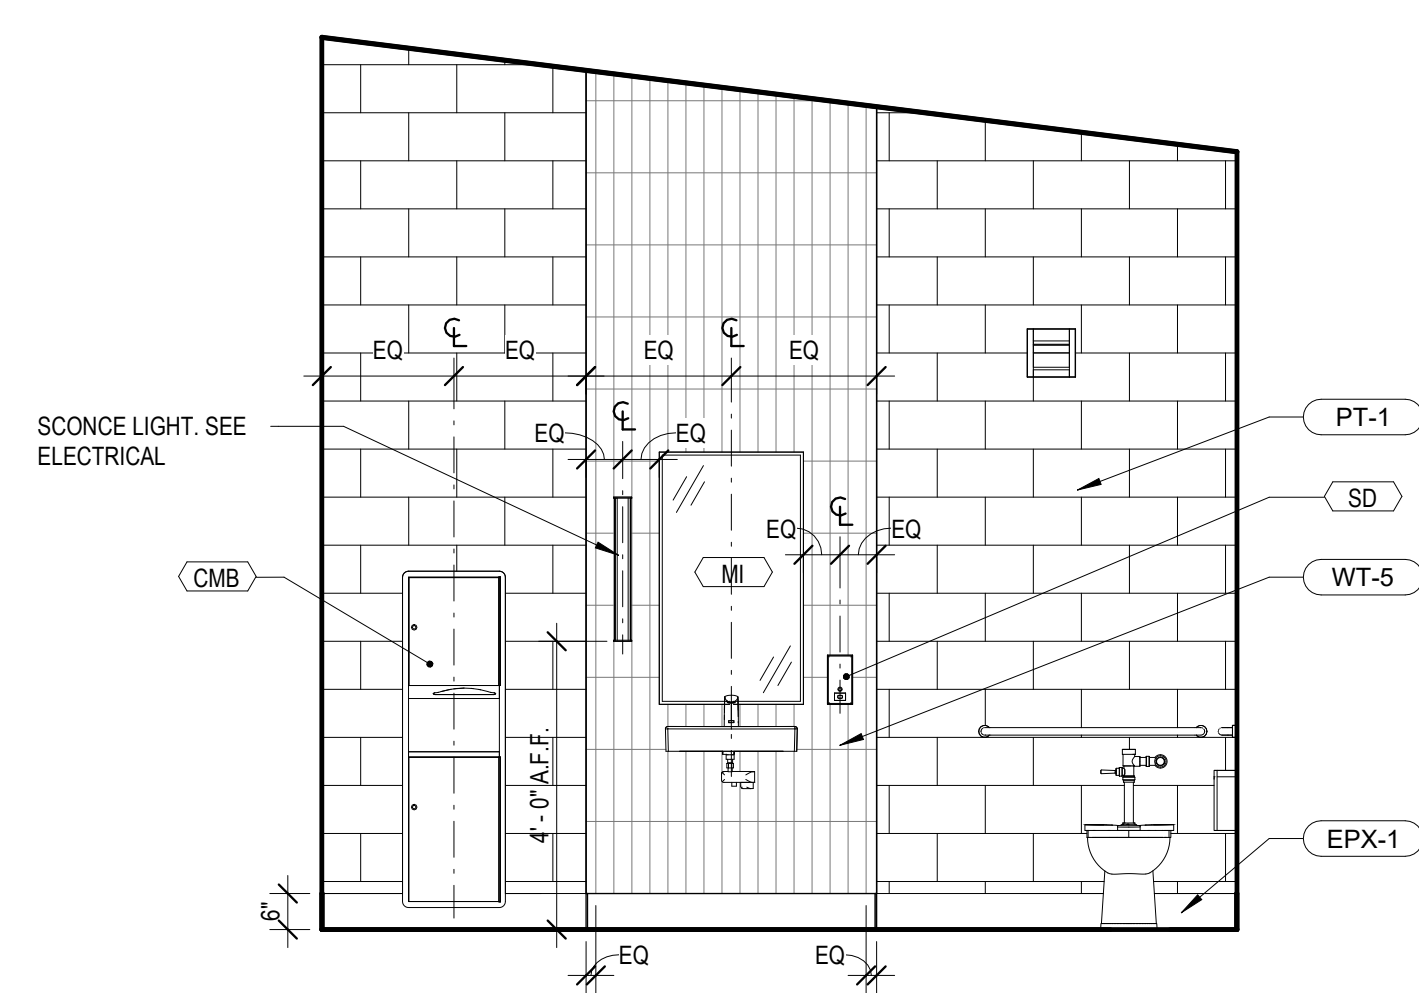


4 ADA SINGLE RESTROOM (101 & 104) - WET WALL
ES-A401 3/8" = 1'-0"


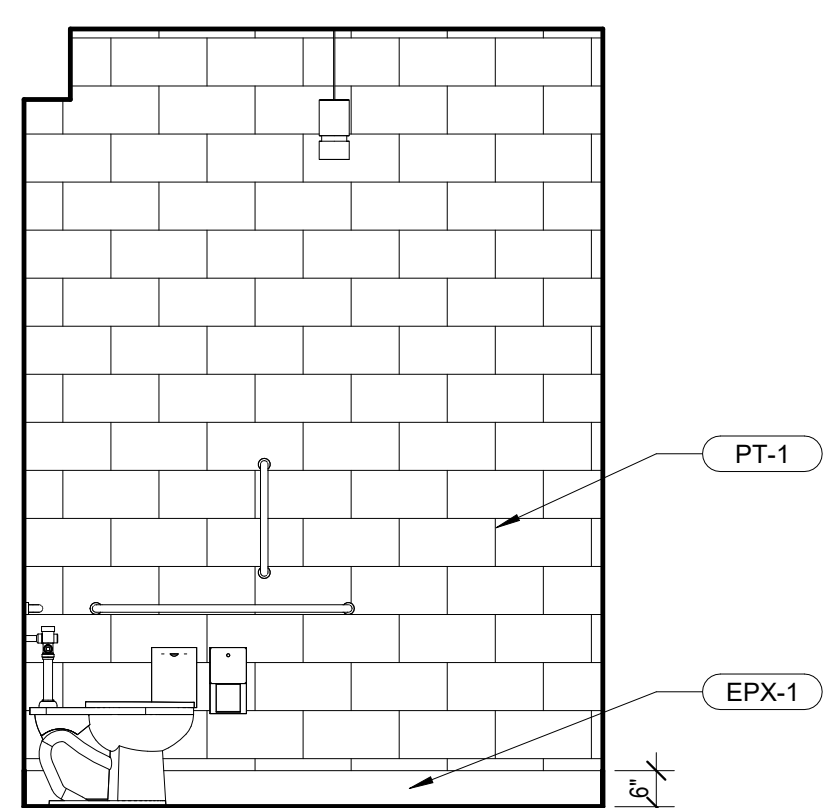



5 ADA SINGLE RESTROOM (101 & 104) - BACK WALL
ES-A401 3/8" = 1'-0"

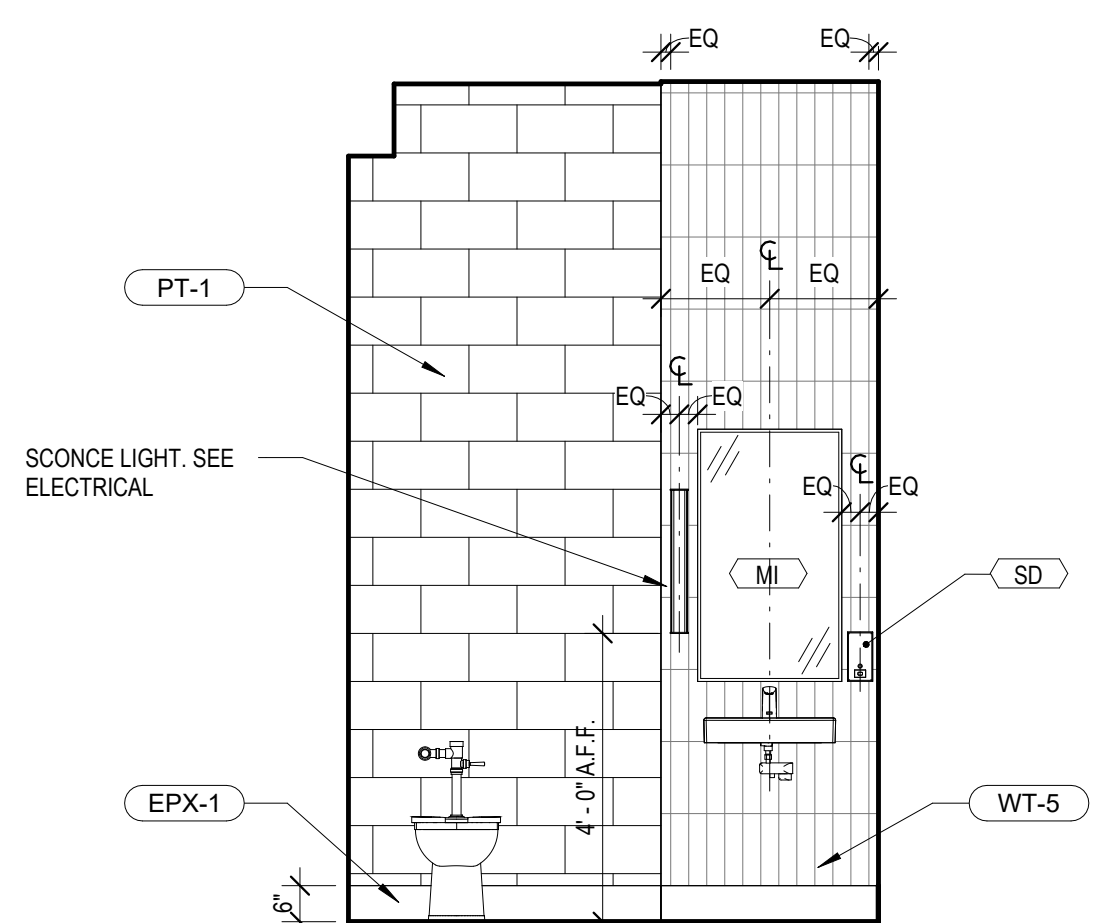

 6 SINGLE RESTROOM (102 & 103) - WET WALL
ES-A401 3/8" = 1'-0"

SYMBOL LEGEND	
	FINISH TAG
	TOILET ASSEMBLY TAG. SEE A400 FOR ADDITIONAL INFORMATION
# TOILET ACCESSORIES LEGEND	
AF	ACCESSIBLE FIXTURE
BC	BABY CHANGING STATION - SURFACE MOUNTED
CF	CLEAR FLOOR SPACE 30" x 52"
CH	COAT HOOK
CMB	COMBINED PAPER TOWEL/TRASH
FD	FLOOR DRAIN - SEE PLUMBING DRAWINGS
GB18	GRAB BAR 18" LONG (VERTICAL)
GB32	GRAB BAR 32" LONG (REAR WALLS)
GB36	GRAB BAR 36" LONG (REAR WALLS)
GB42	GRAB BAR 42" LONG (SIDE WALLS)
MI	MIRROR 24" X 36"
PT	PAPER TOWEL DISPENSER
SD	SOAP DISPENSER
SND	SANITARY NAPKIN DISPOSAL
TD	67" ACCESSIBLE TURNING DIAMETER
TR	TRASH RECEPTACLE
TTH	TOILET TISSUE HOLDER
NOTES: 1. PLUMBING CONTRACTOR TO PROVIDE PROTECTIVE INSULATION AT HOT PIPES BELOW LAVATORY PER ACCESSIBILITY CODE. 2. FLUSH CONTROL VALVES AT ACCESSIBLE TOILETS TO BE MOUNTED ON THE WIDE SIDE OF TOILET STALL OR ROOM. 3. SEE SPECIFICATIONS FOR DETAILS OF TOILET ACCESSORIES 4. ALL TOILET PARTITIONS ARE FLOOR MOUNTED AND OVERHEAD BRACED. 5. SLOPE SLAB TO DRAIN INTO FLOOR DRAINS. THRESHOLDS SLOPE IN DOOR OPENINGS SHALL NOT EXCEED 1/8 SLOPE OR 1/2" IN HEIGHT PER ACCESSIBILITY CODE.	

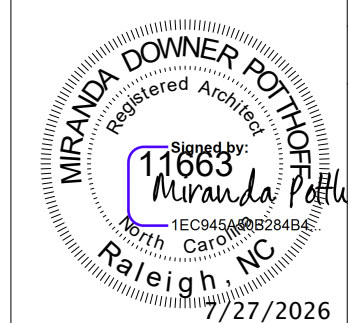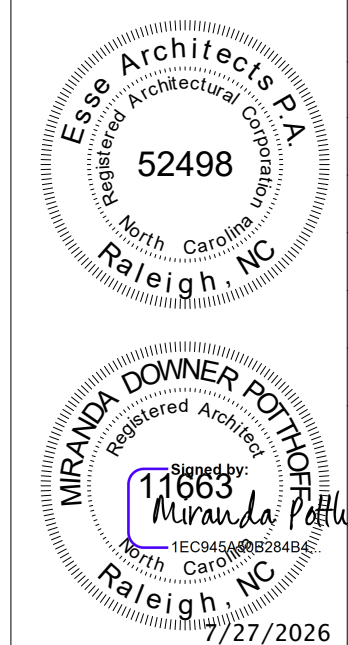

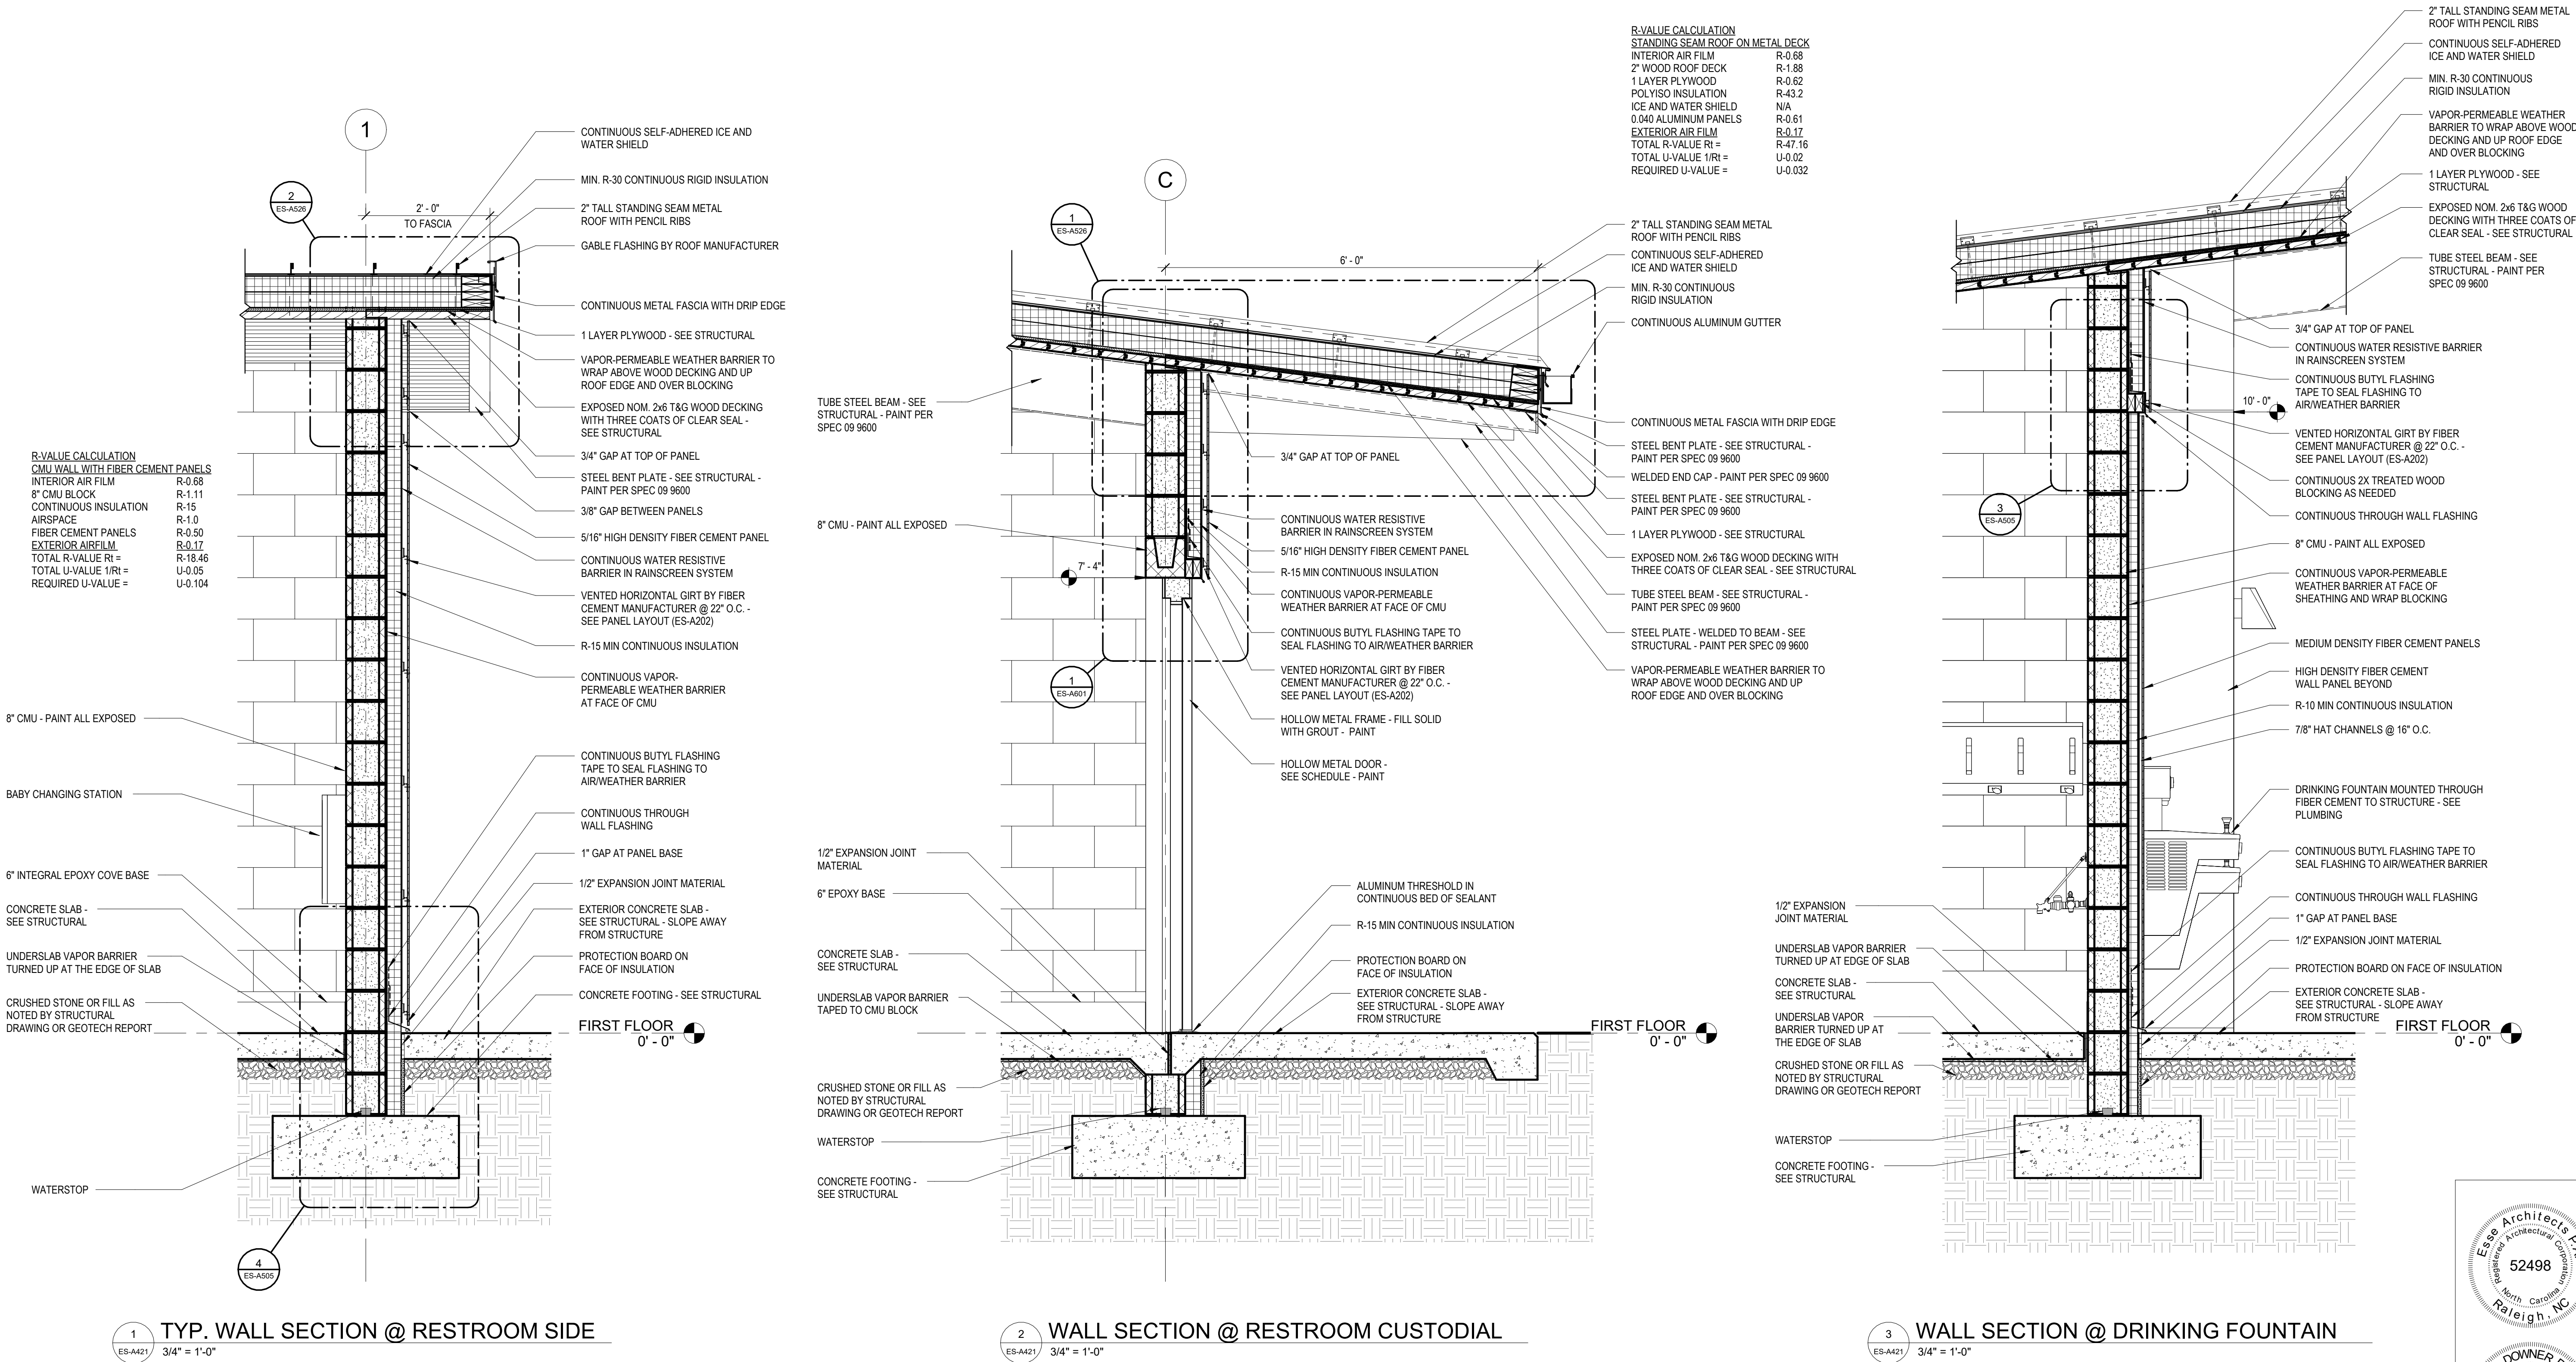

Susan Hatchell
Landscape Architecture, PLLC
711 W. North Street, Raleigh, NC 27603
p: 919-838-9600 f: 919-838-9700

Esse Architects
632 FISHING ROAD | RALEIGH, NORTH CAROLINA 27608


WALL SECTIONS


LAKE MYRA COUNTY PARK
Wake County, NC

REVISIONS

Date: 07/27/26

ES-A421

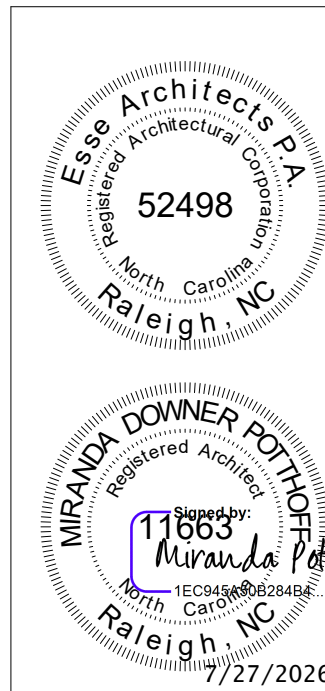

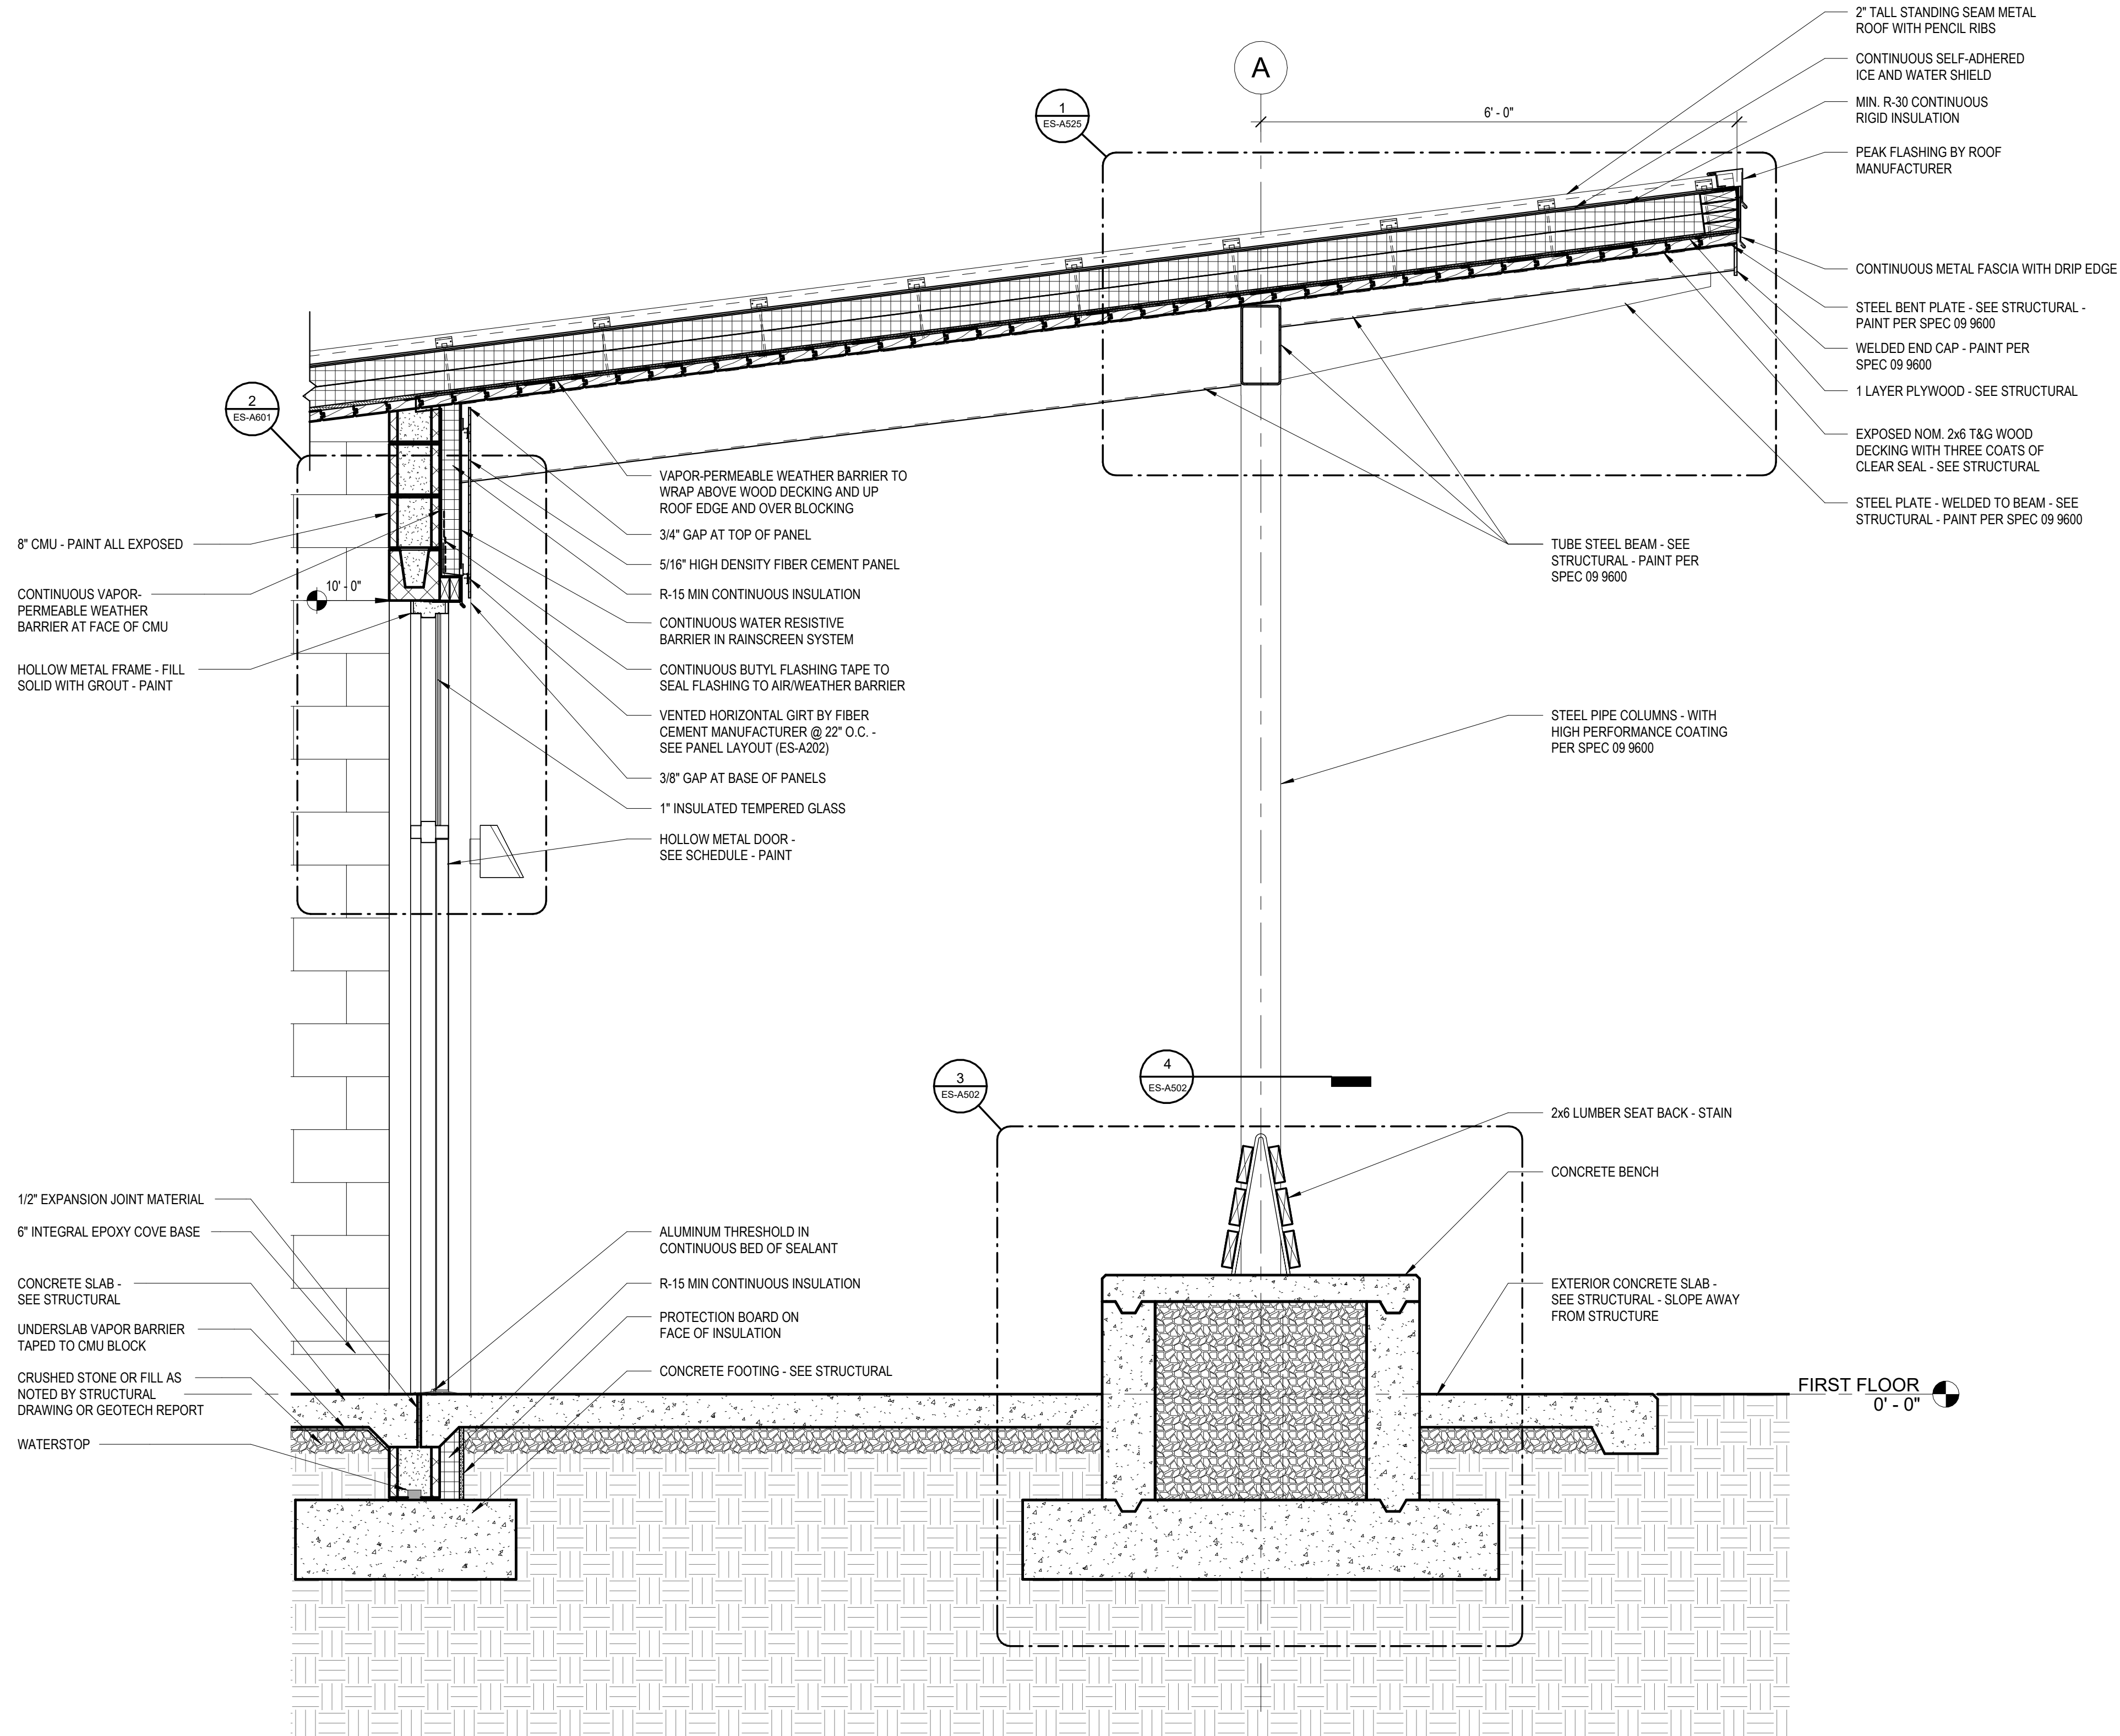

1 WALL SECTION @ RESTROOM ENTRIES
ES-A422 3/4" = 1'-0"

ROOF DECKING NOTES

1. STRUCTURAL WOOD ROOF DECK IS ALSO FINISHED CEILING - **NO FASTENERS SHALL PENETRATE DECKING**
2. NO EXPOSED CONDUIT SHALL BE RUN ACROSS UNDERSIDE OF WOOD DECKING WITHOUT REVIEW AND COORDINATION WITH THE ARCHITECT. COORDINATE FOR LIGHTING, SECURITY, ETC.

Susan Hatchell
Landscape Architecture, PLLC
711 W. North Street, Raleigh, NC 27603
p: 919-838-9600 f: 919-838-9700

Esse Architects
832 PERSHING ROAD | RALEIGH, NORTH CAROLINA 27608

WALL SECTIONS

LAKE MYRA COUNTY PARK
Wake County, NC

REVISIONS

Date: 07/27/26

ES-A422




WALL SECTIONS

LAKE MYRA COUNTY PARK
Wake County, NC

REVISIONS

Date: 07/27/26


ES-A423

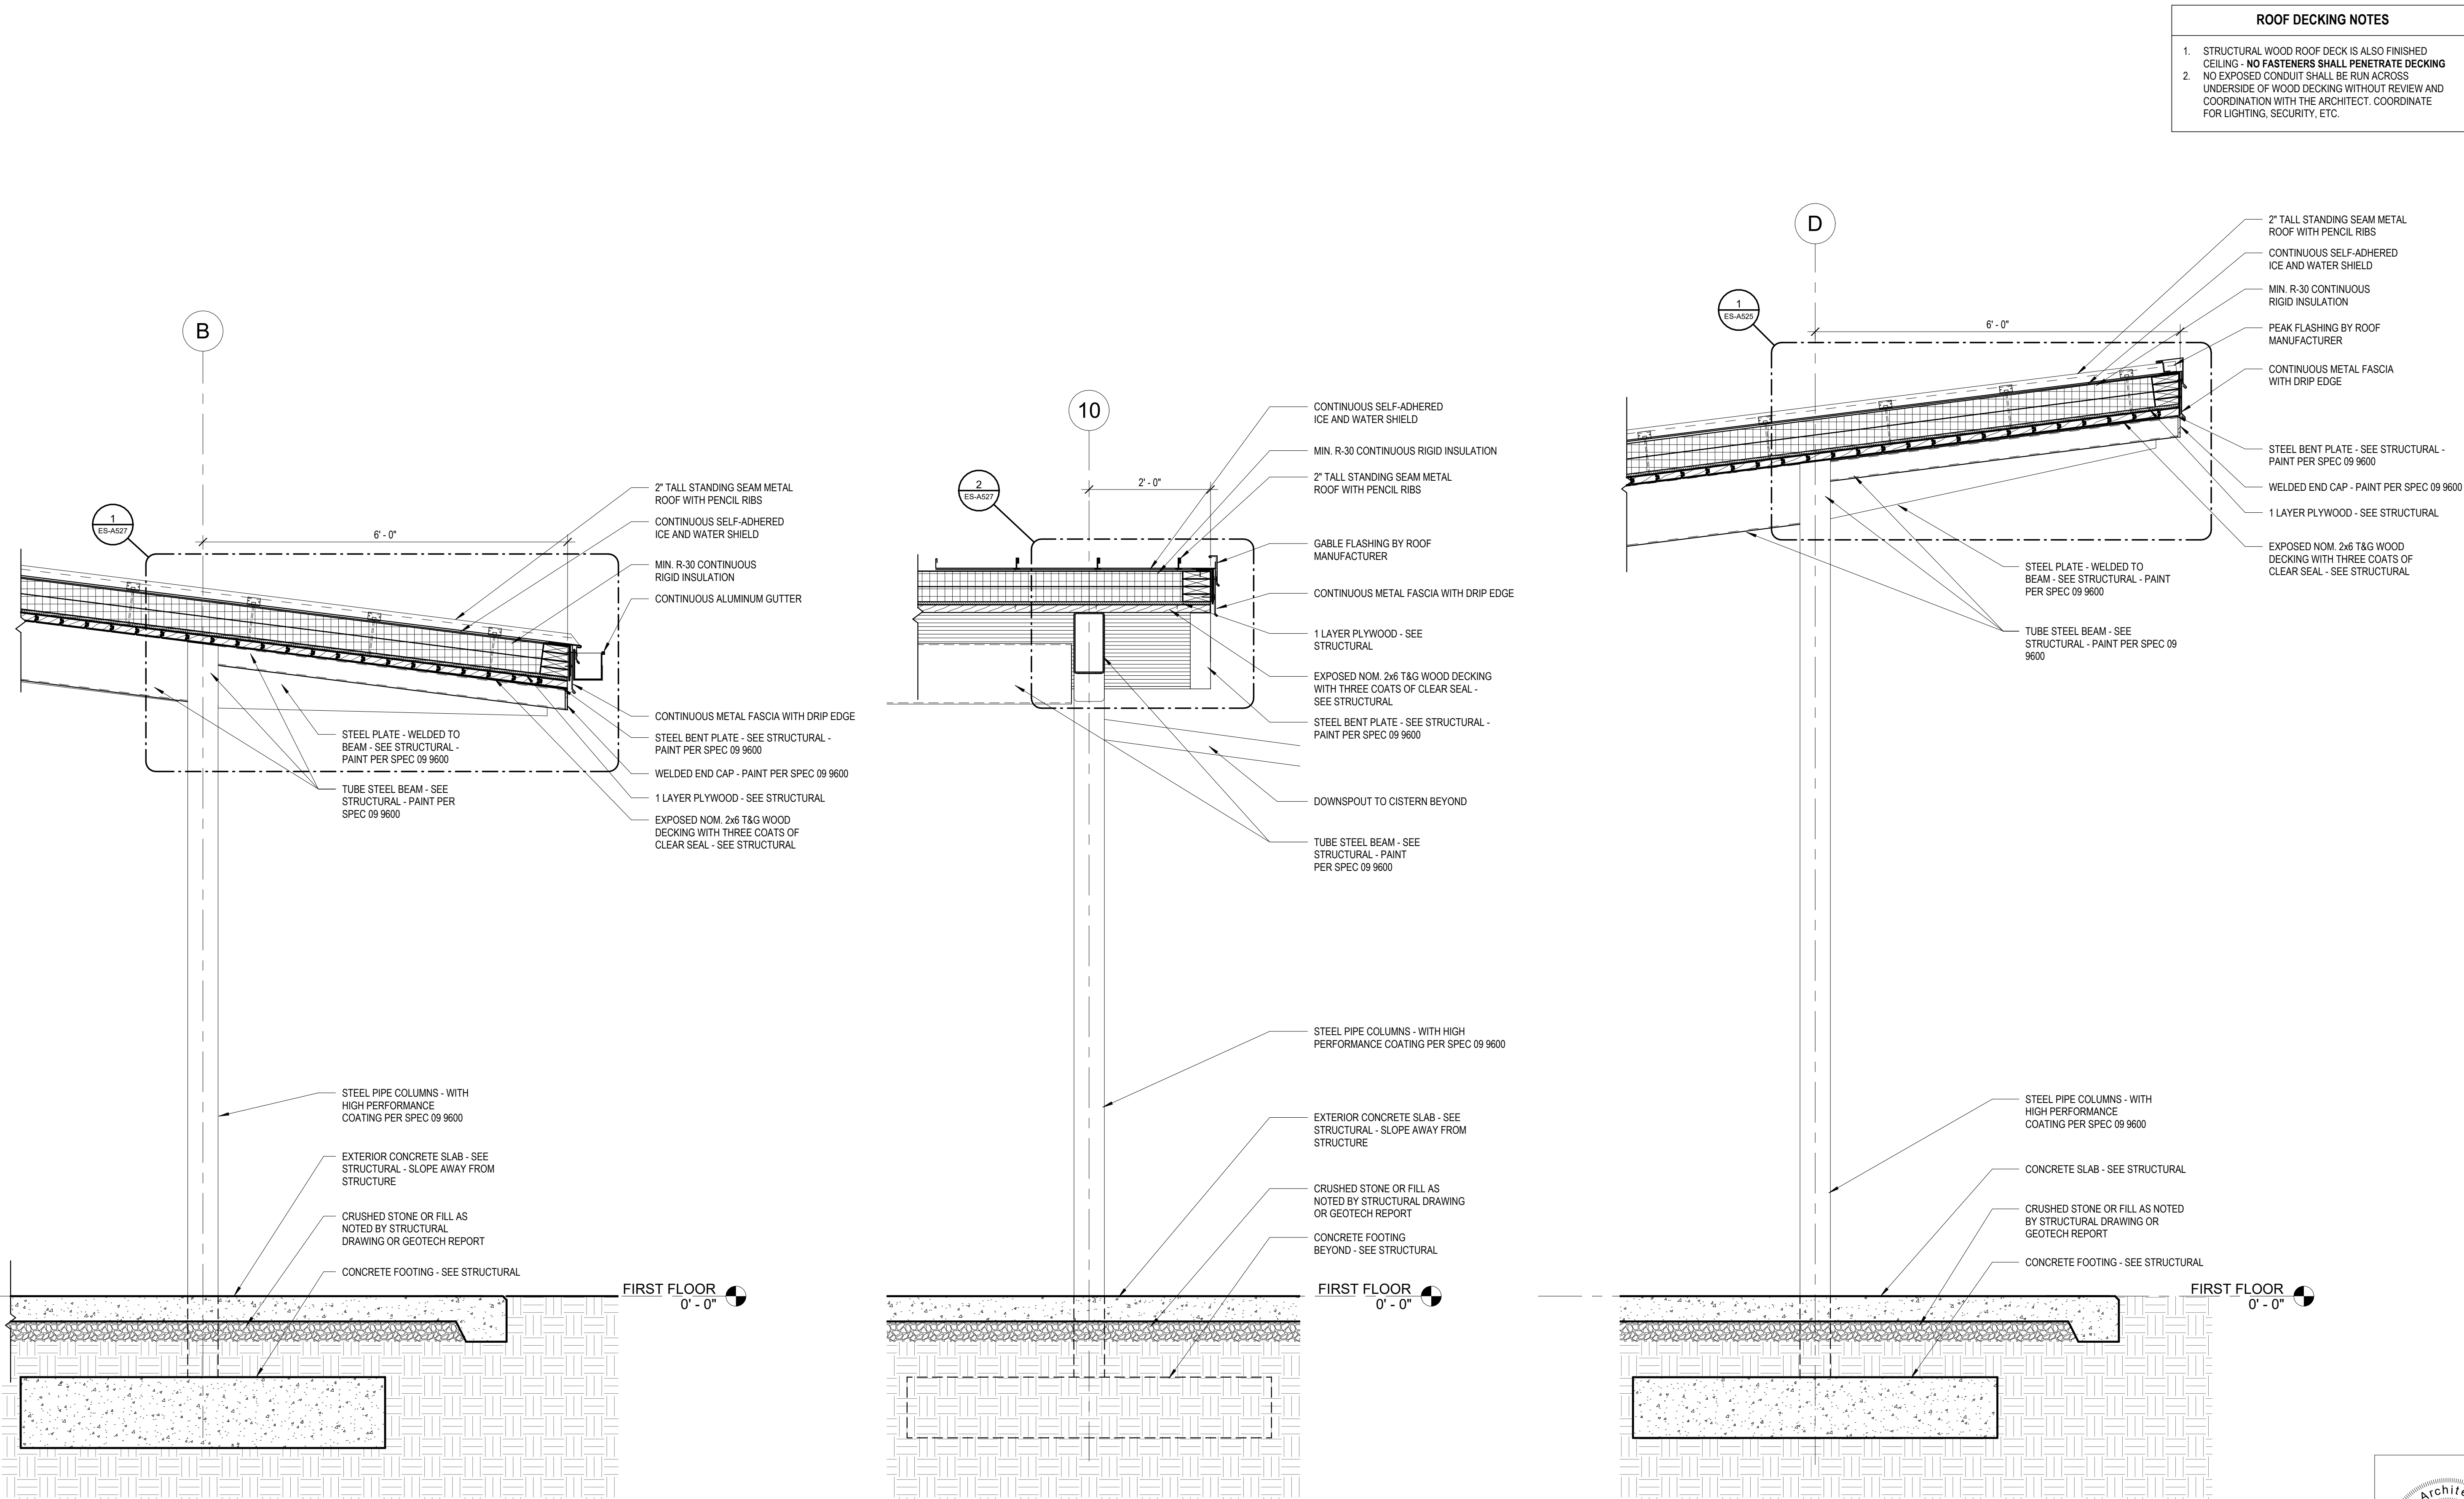


1 WALL SECTION @ PICNIC SHELTER LOW ROOF
ES-A423 3/4" = 1'-0"


2 WALL SECTION @ PICNIC SHELTER SIDE
ES-A423 3/4" = 1'-0"

3 WALL SECTION @ PICNIC SHELTER HIGH ROOF
ES-A423 3/4" = 1'-0"

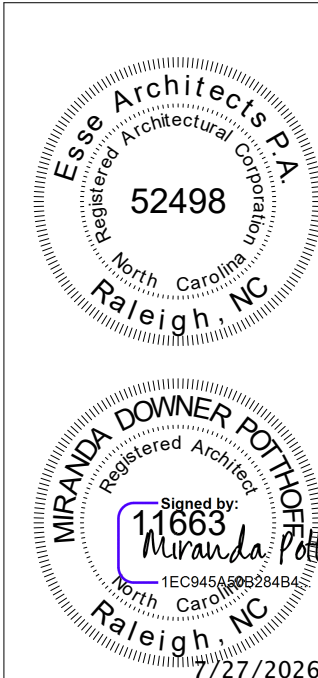


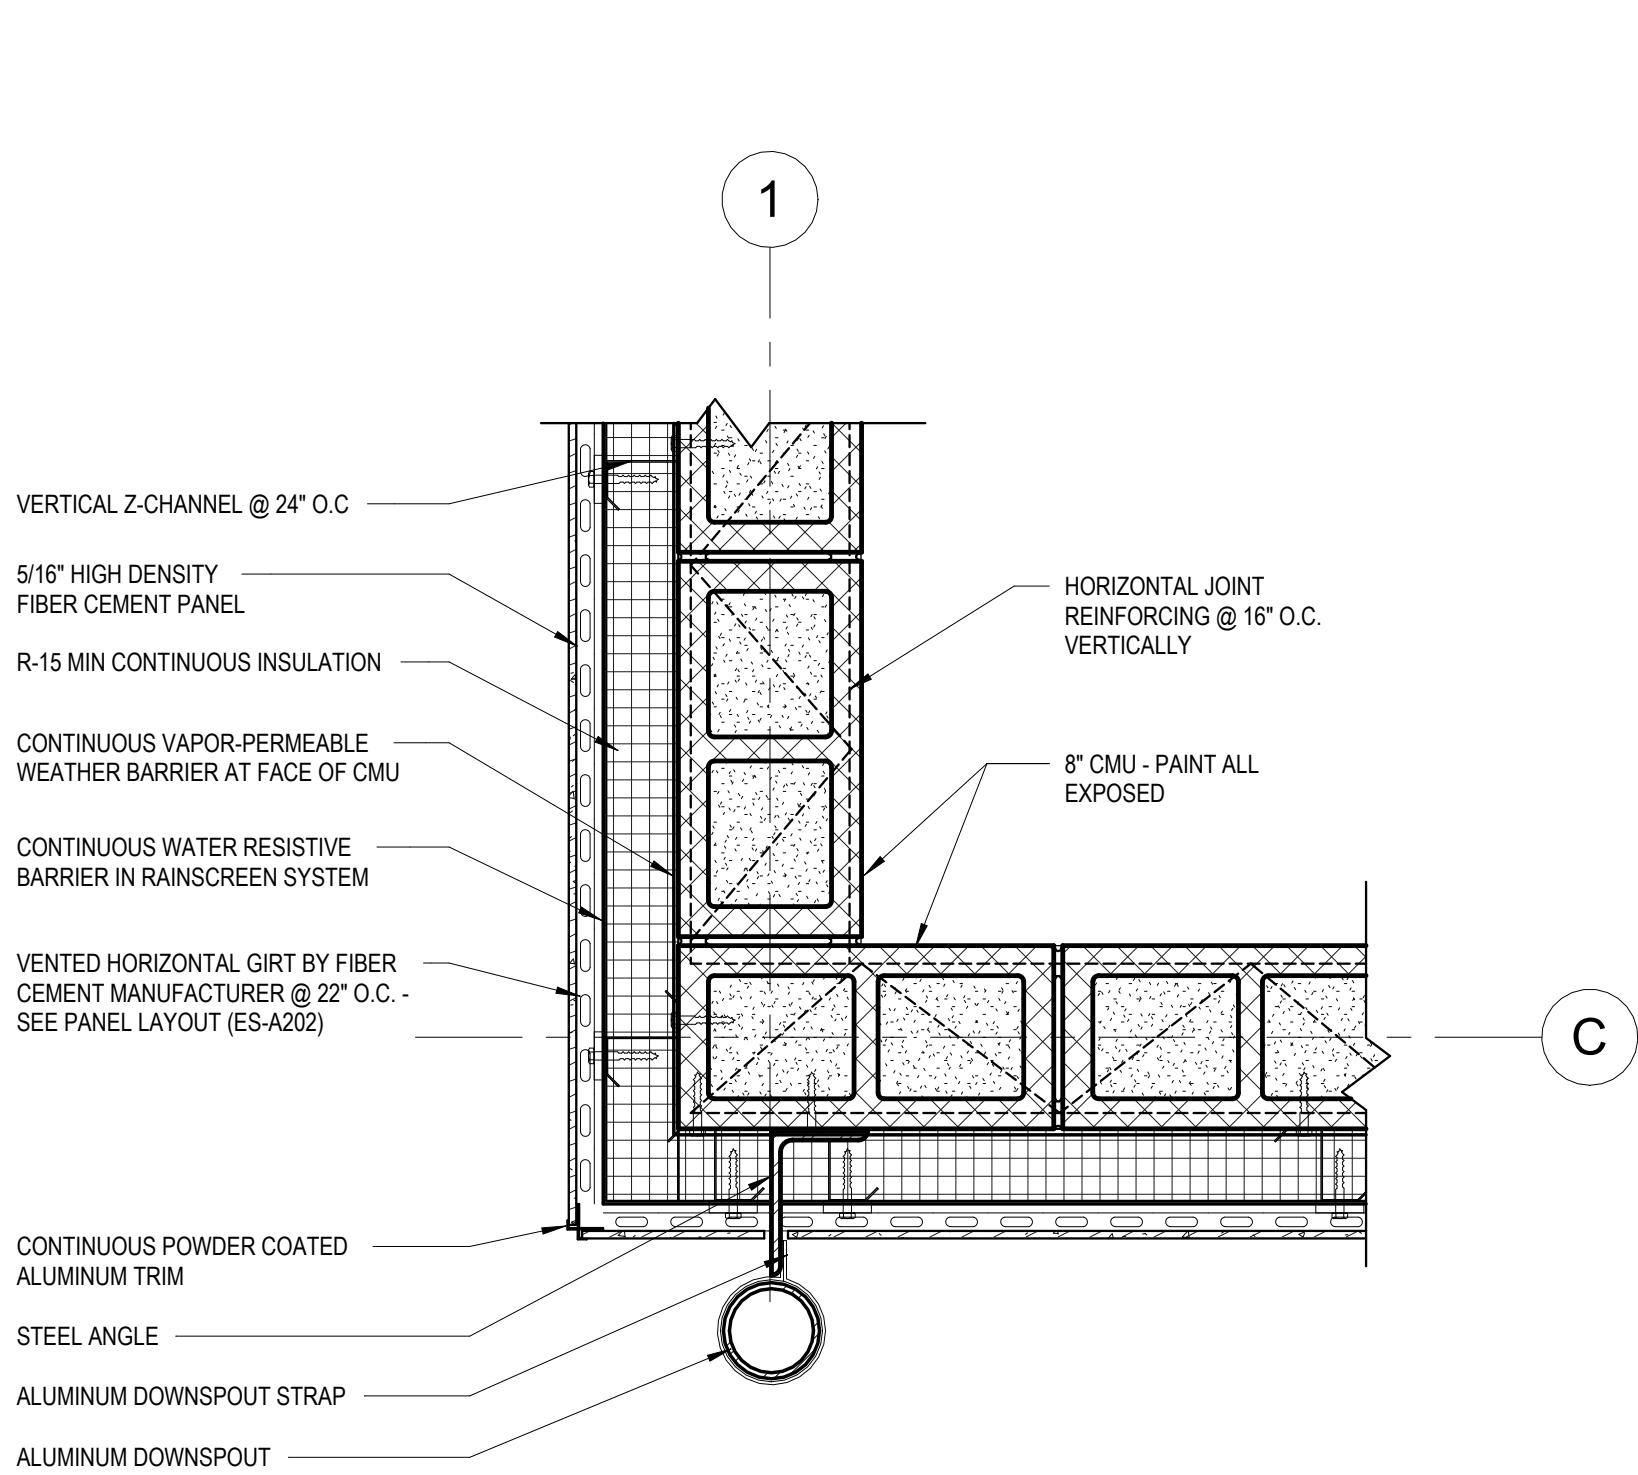


1 PLAN DETAIL @ OUTSIDE CORNER

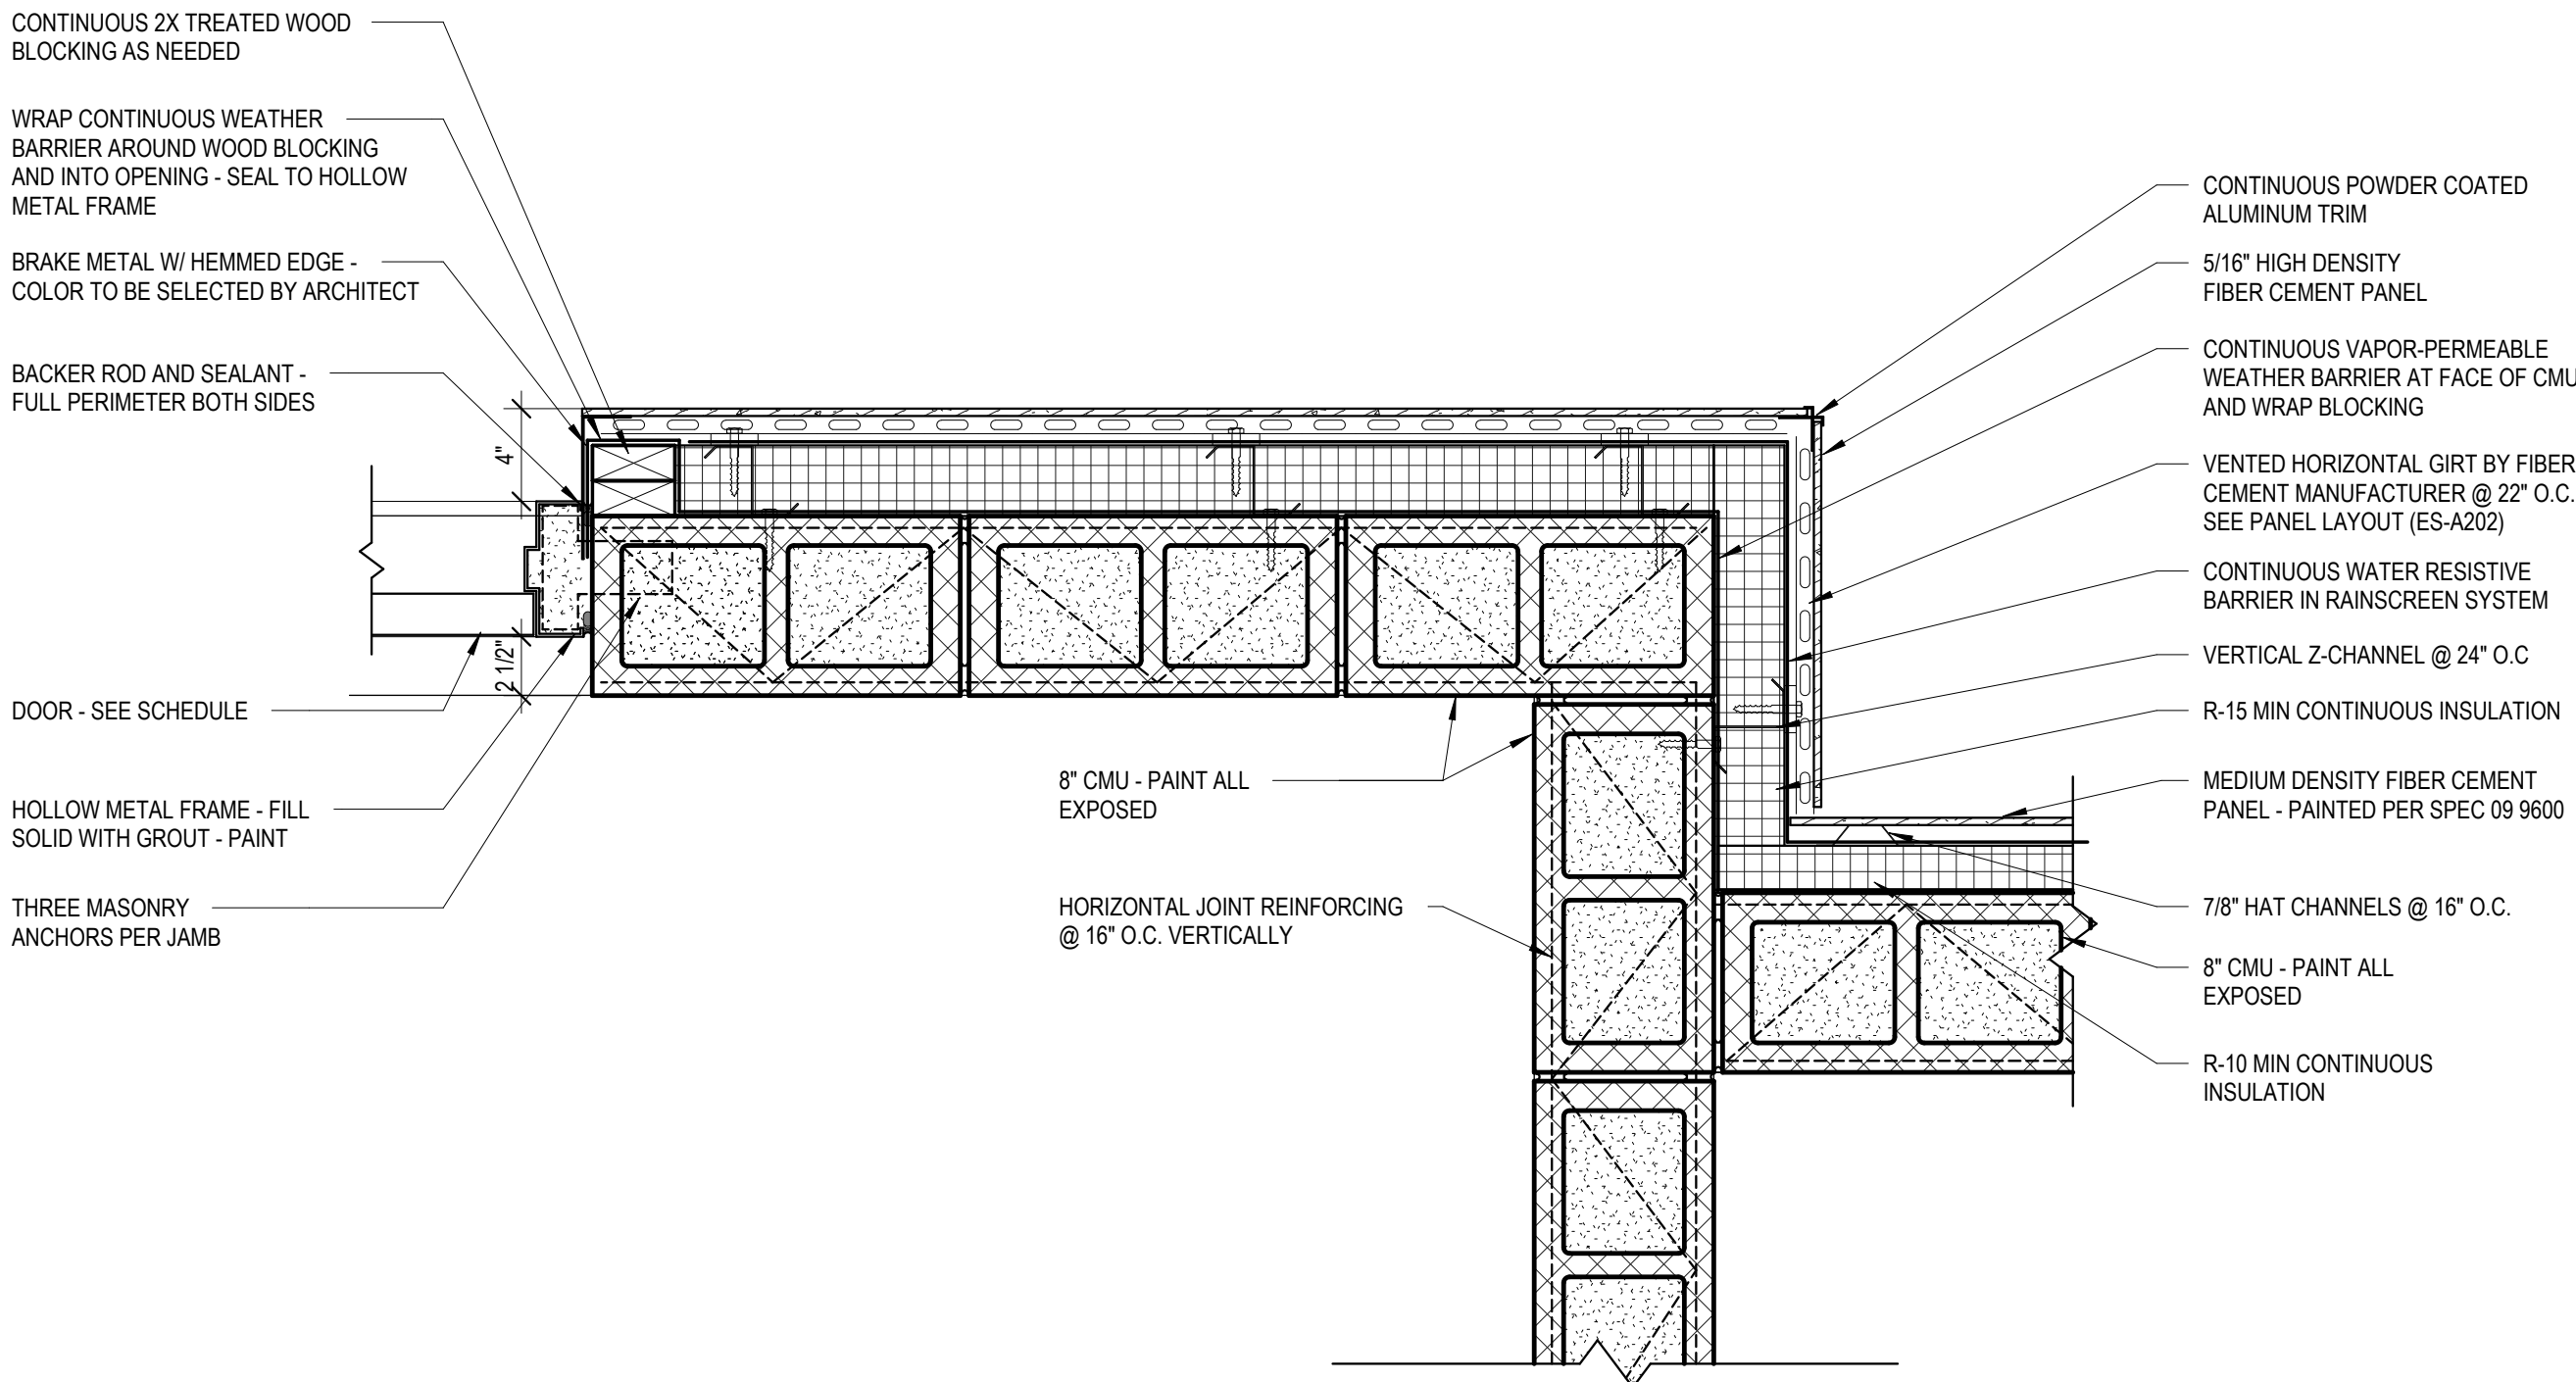


2 PLAN DETAIL @ DRINKING FOUNTAIN CORNER

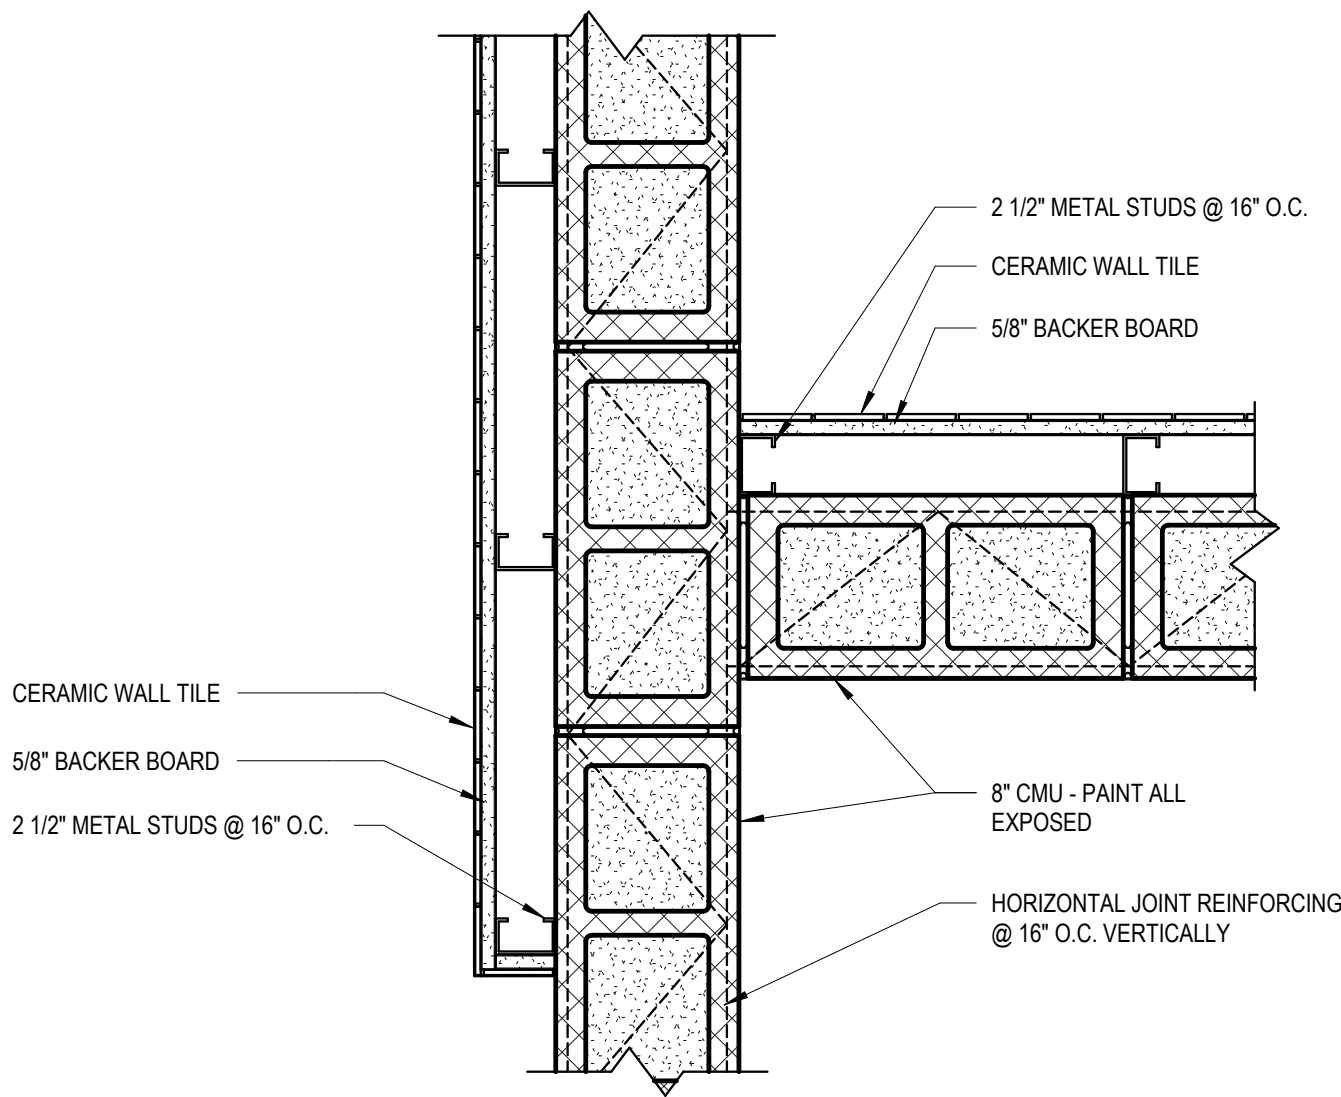


3 PLAN DETAIL @ RESTROOM 2

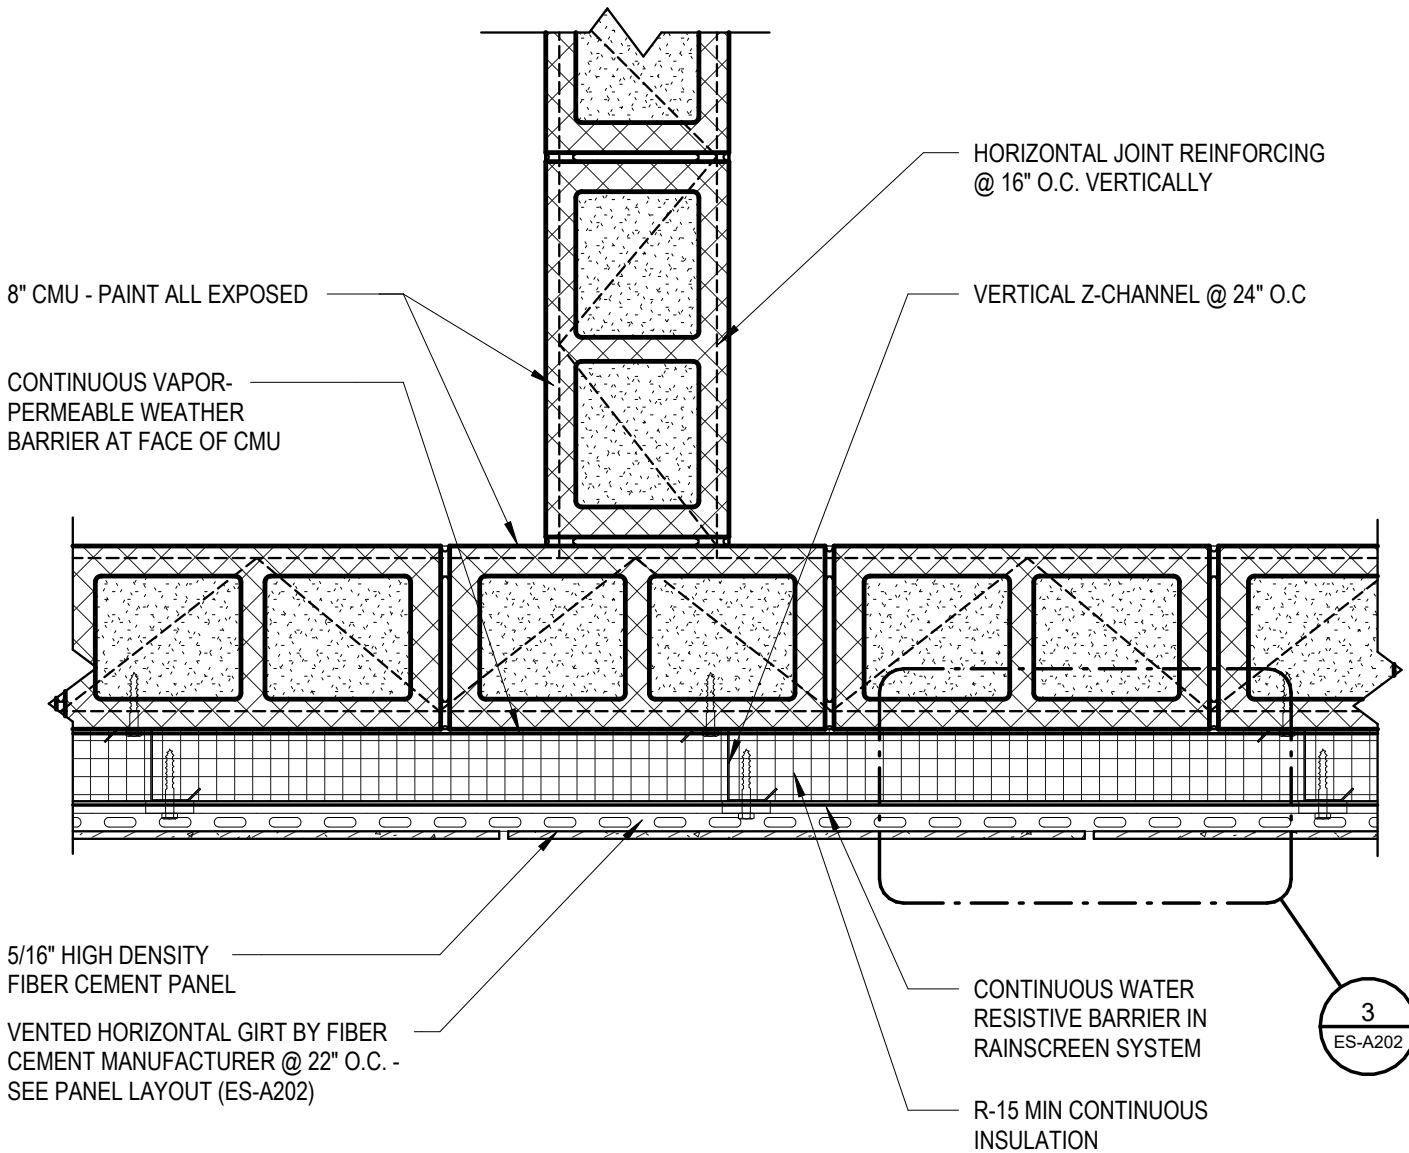


4 PLAN DETAIL @ CUSTODIAL ROOM

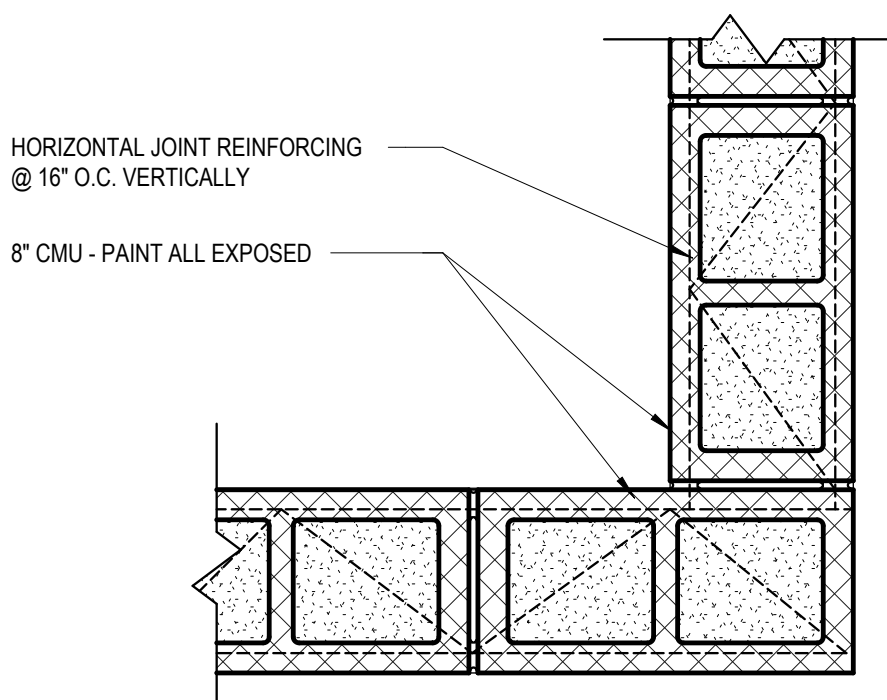


5 PLAN DETAIL @ CUSTODIAL ROOM 2

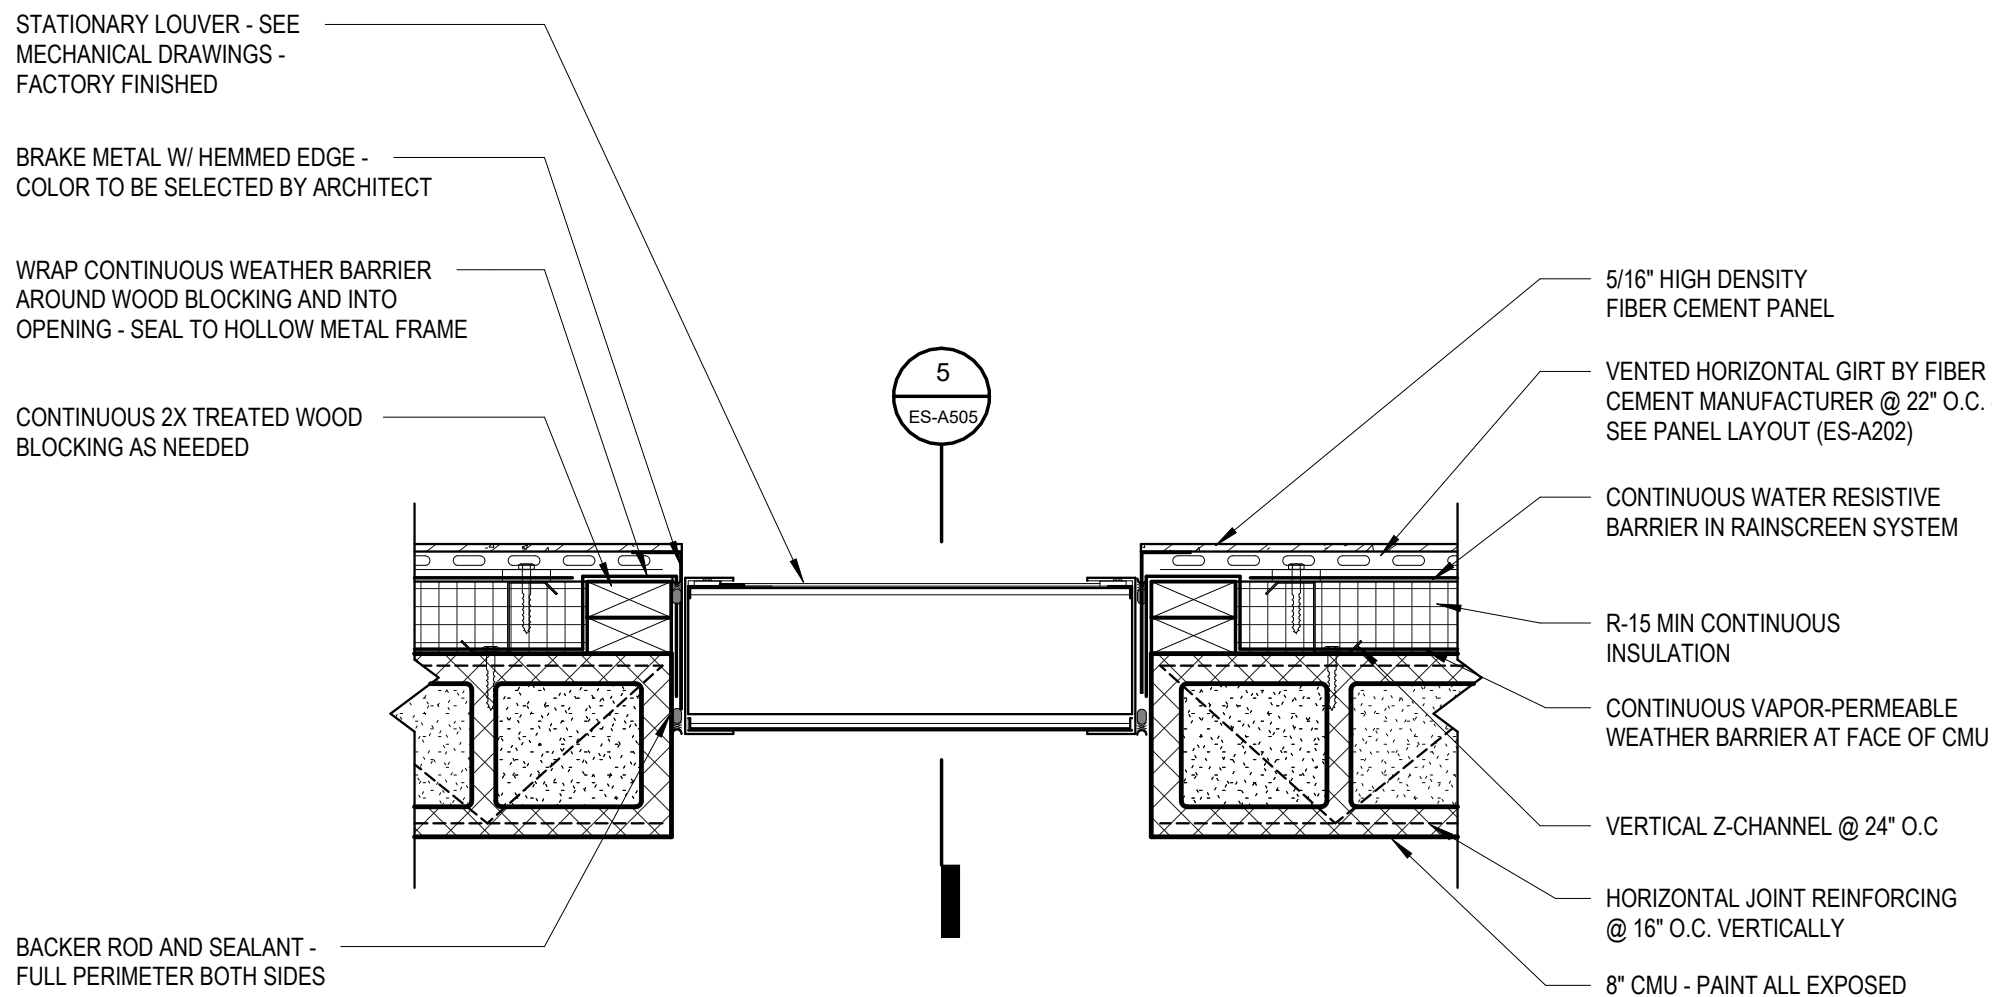


6 LOUVER PLAN DETAIL

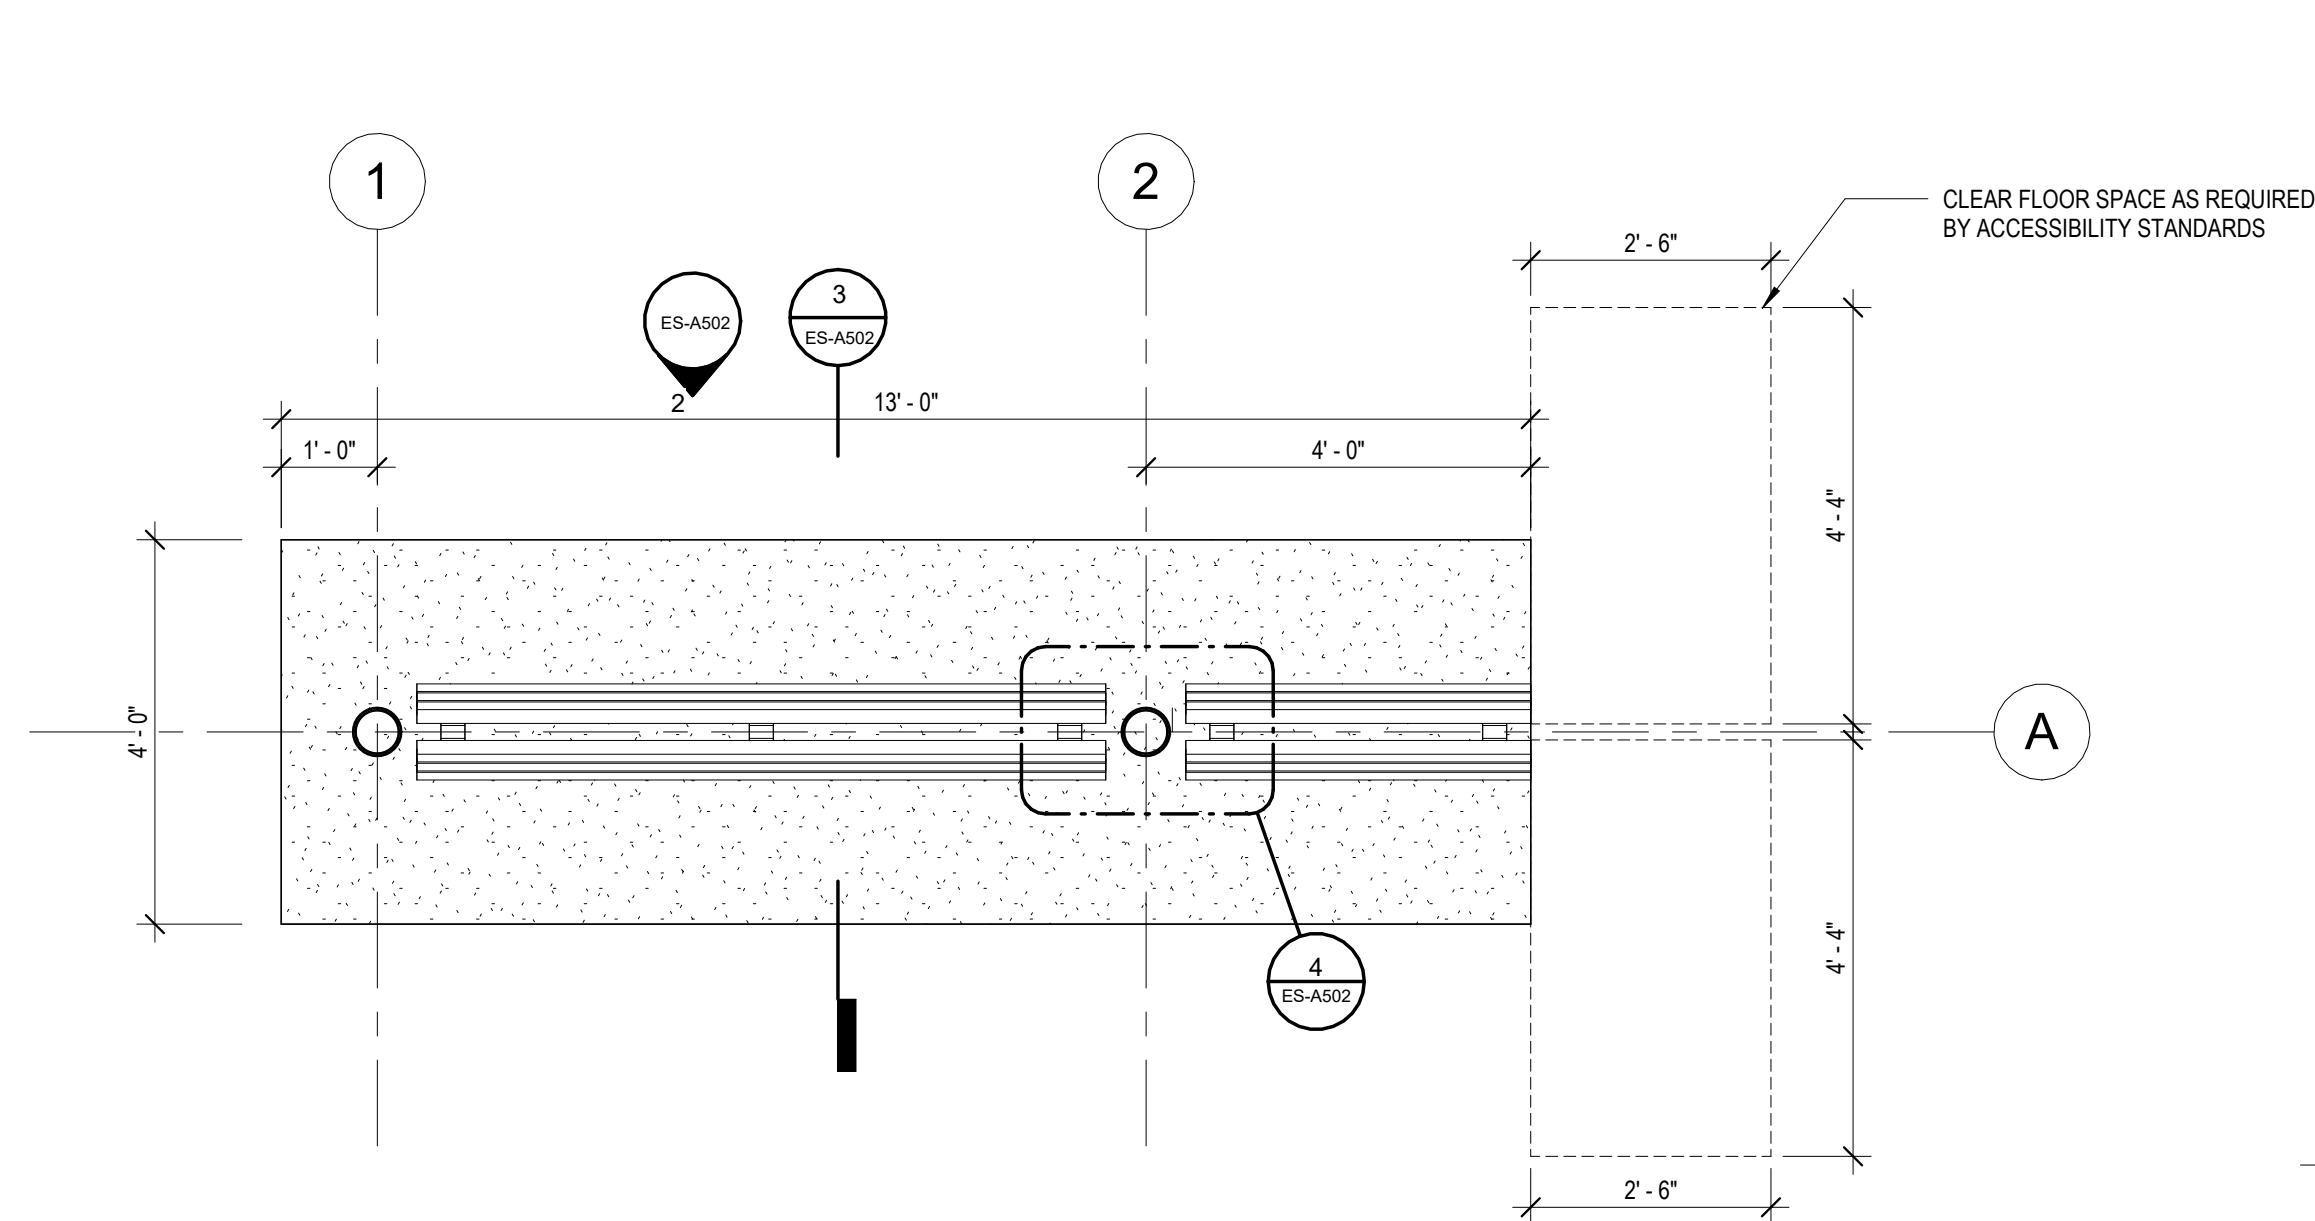


1 ENLARGED BENCH PLAN
ES-A502 1/2" = 1'-0"

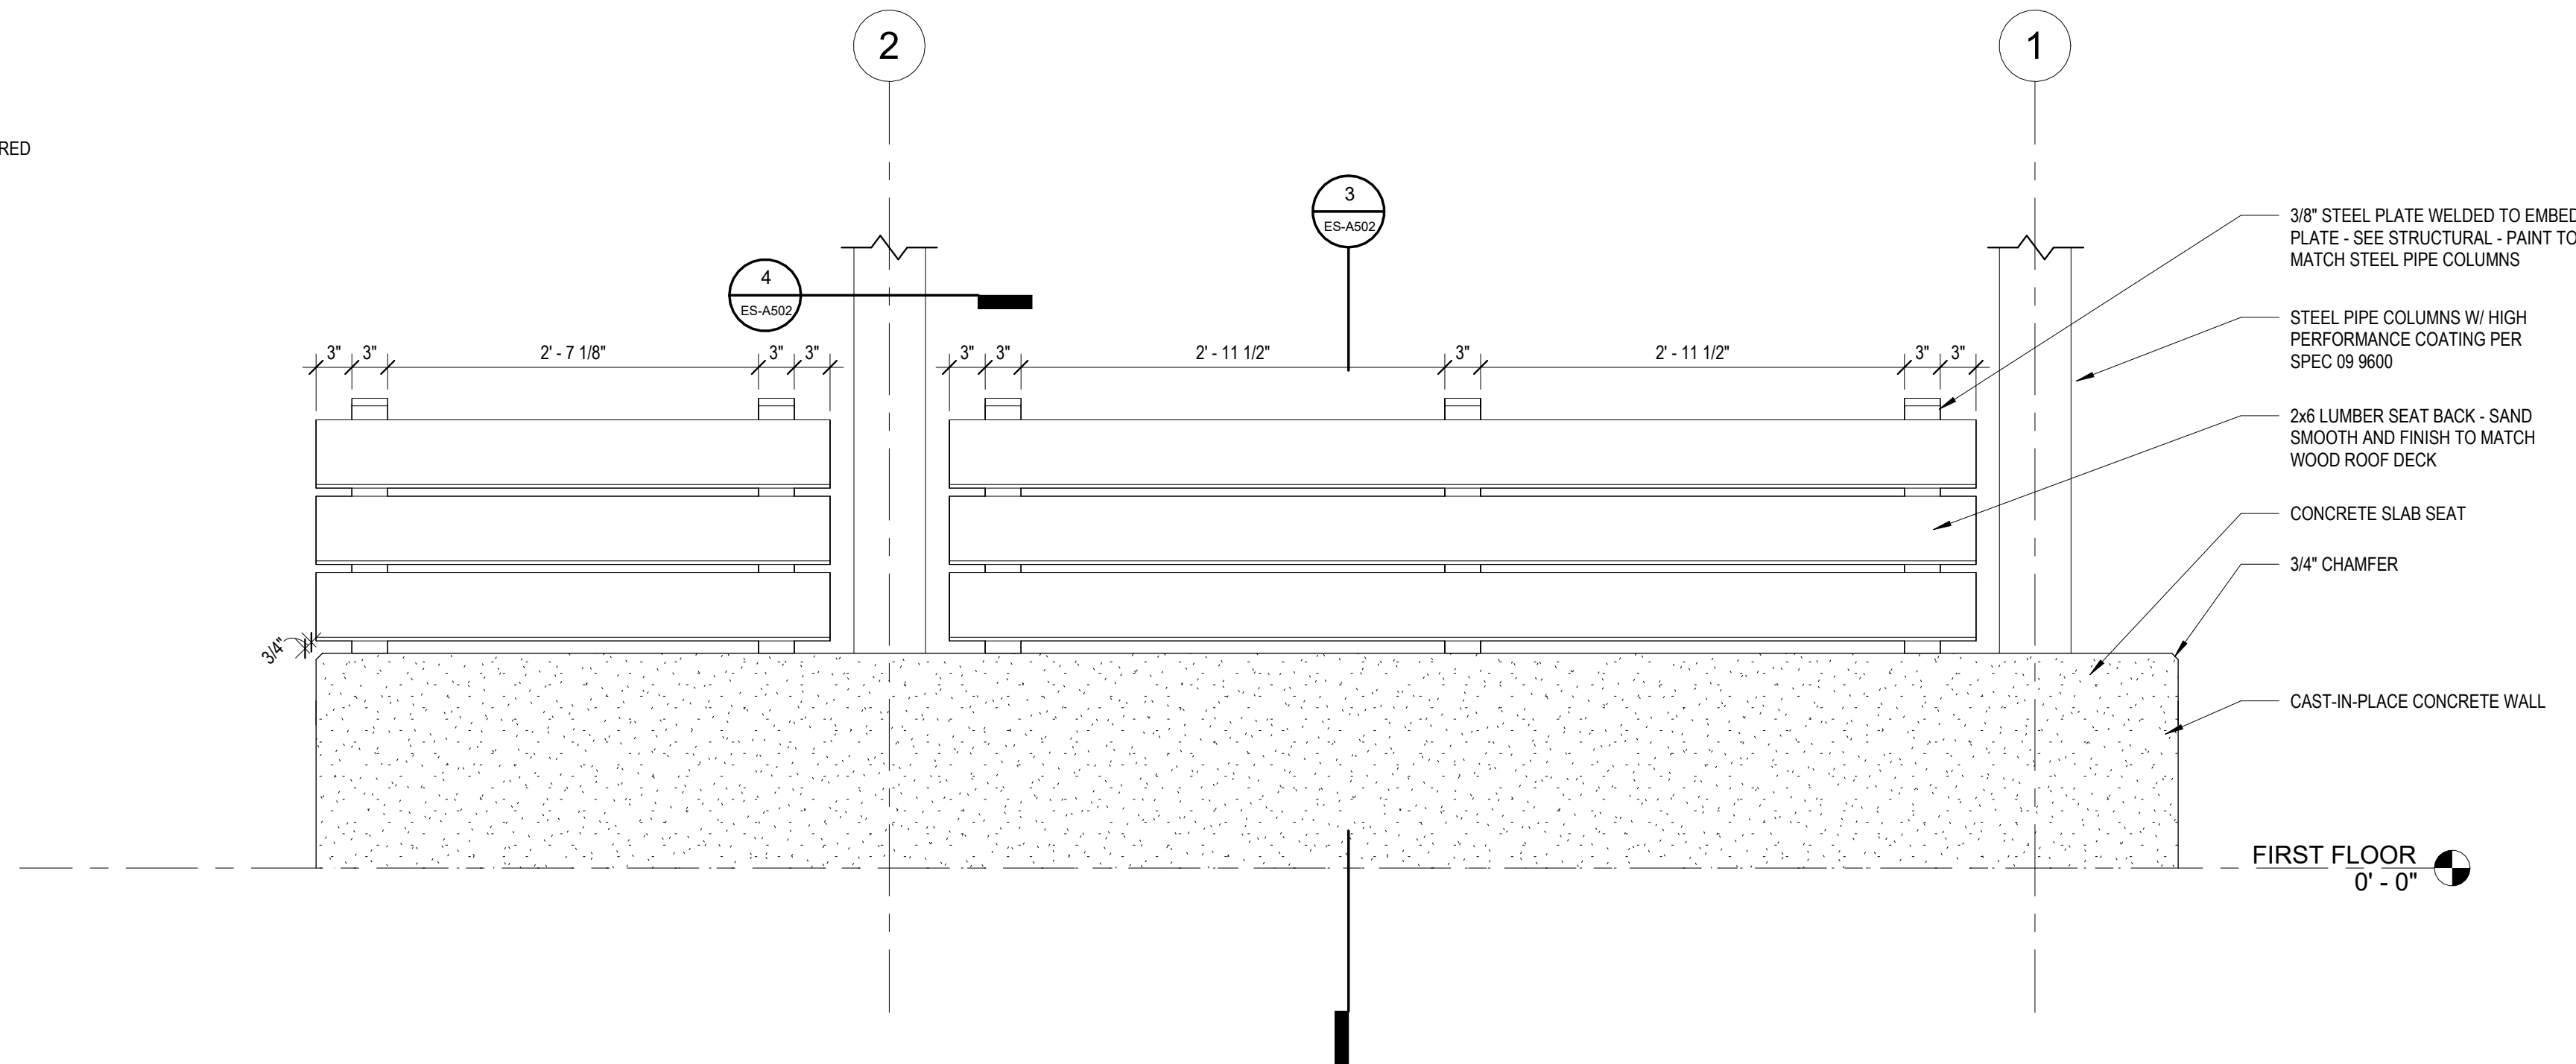

2 BENCH ELEVATION
ES-A502 1" = 1'-0"

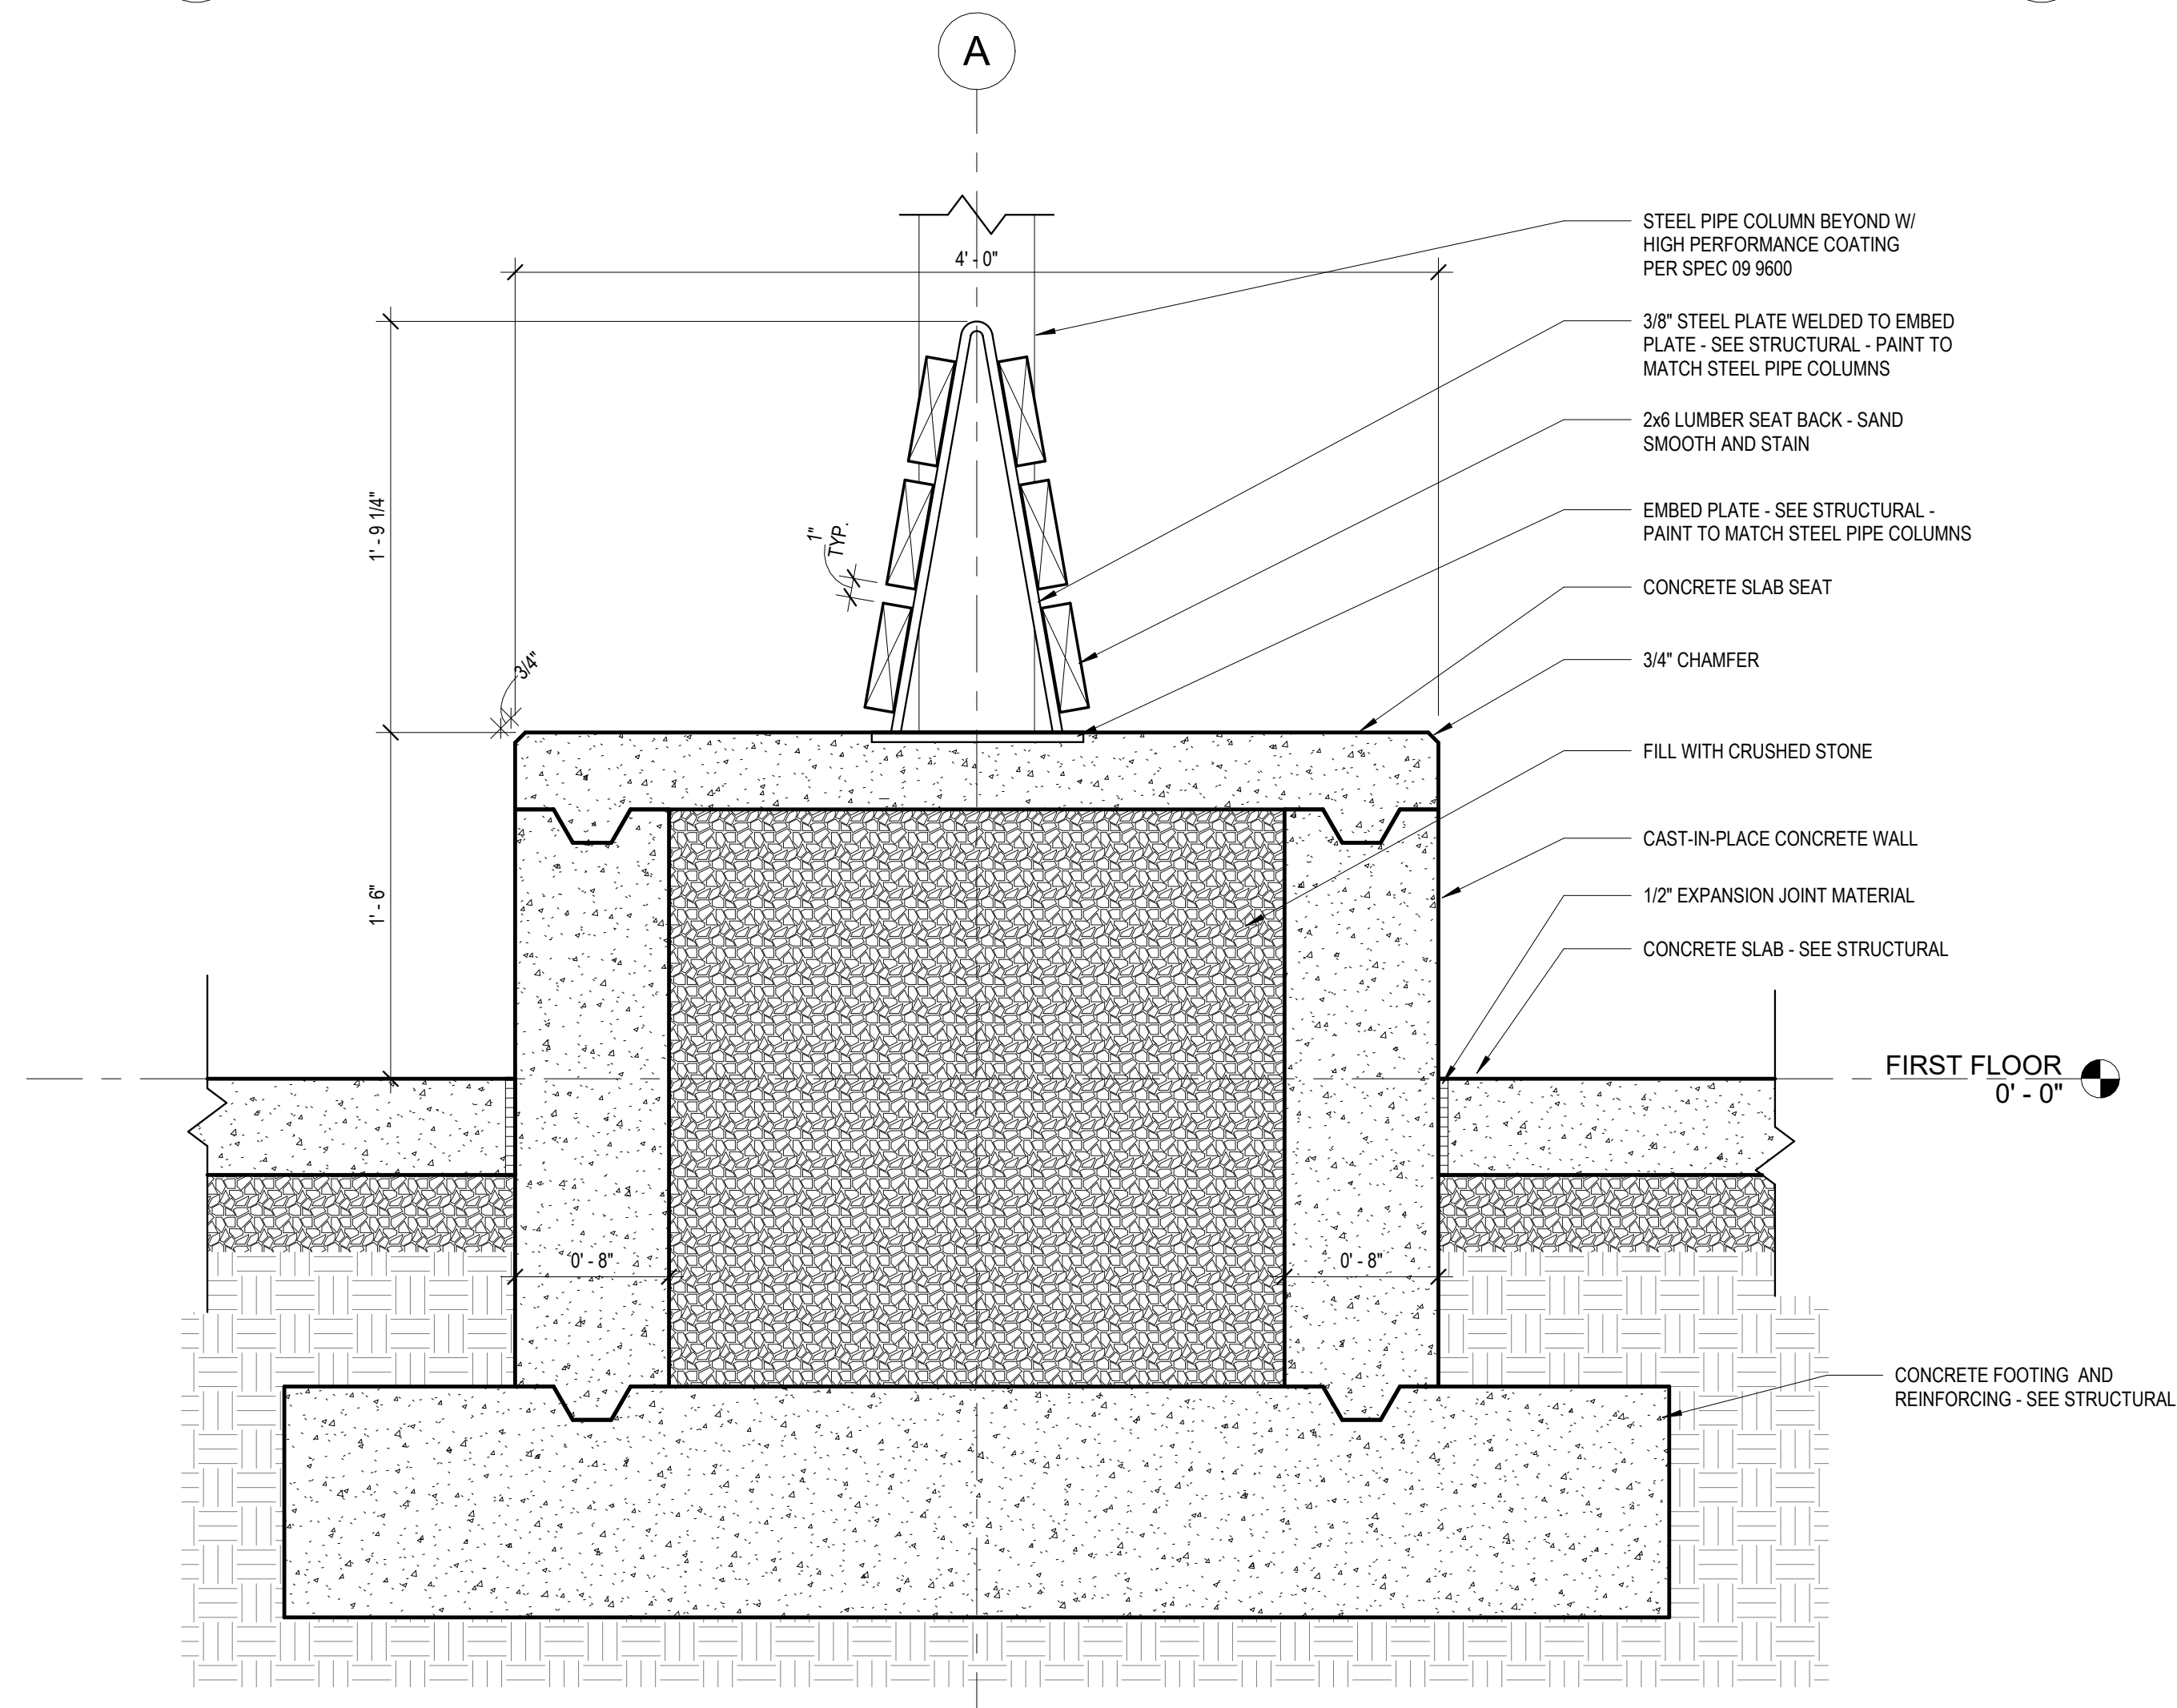

3 BENCH SECTION
ES-A502 1 1/2" = 1'-0"

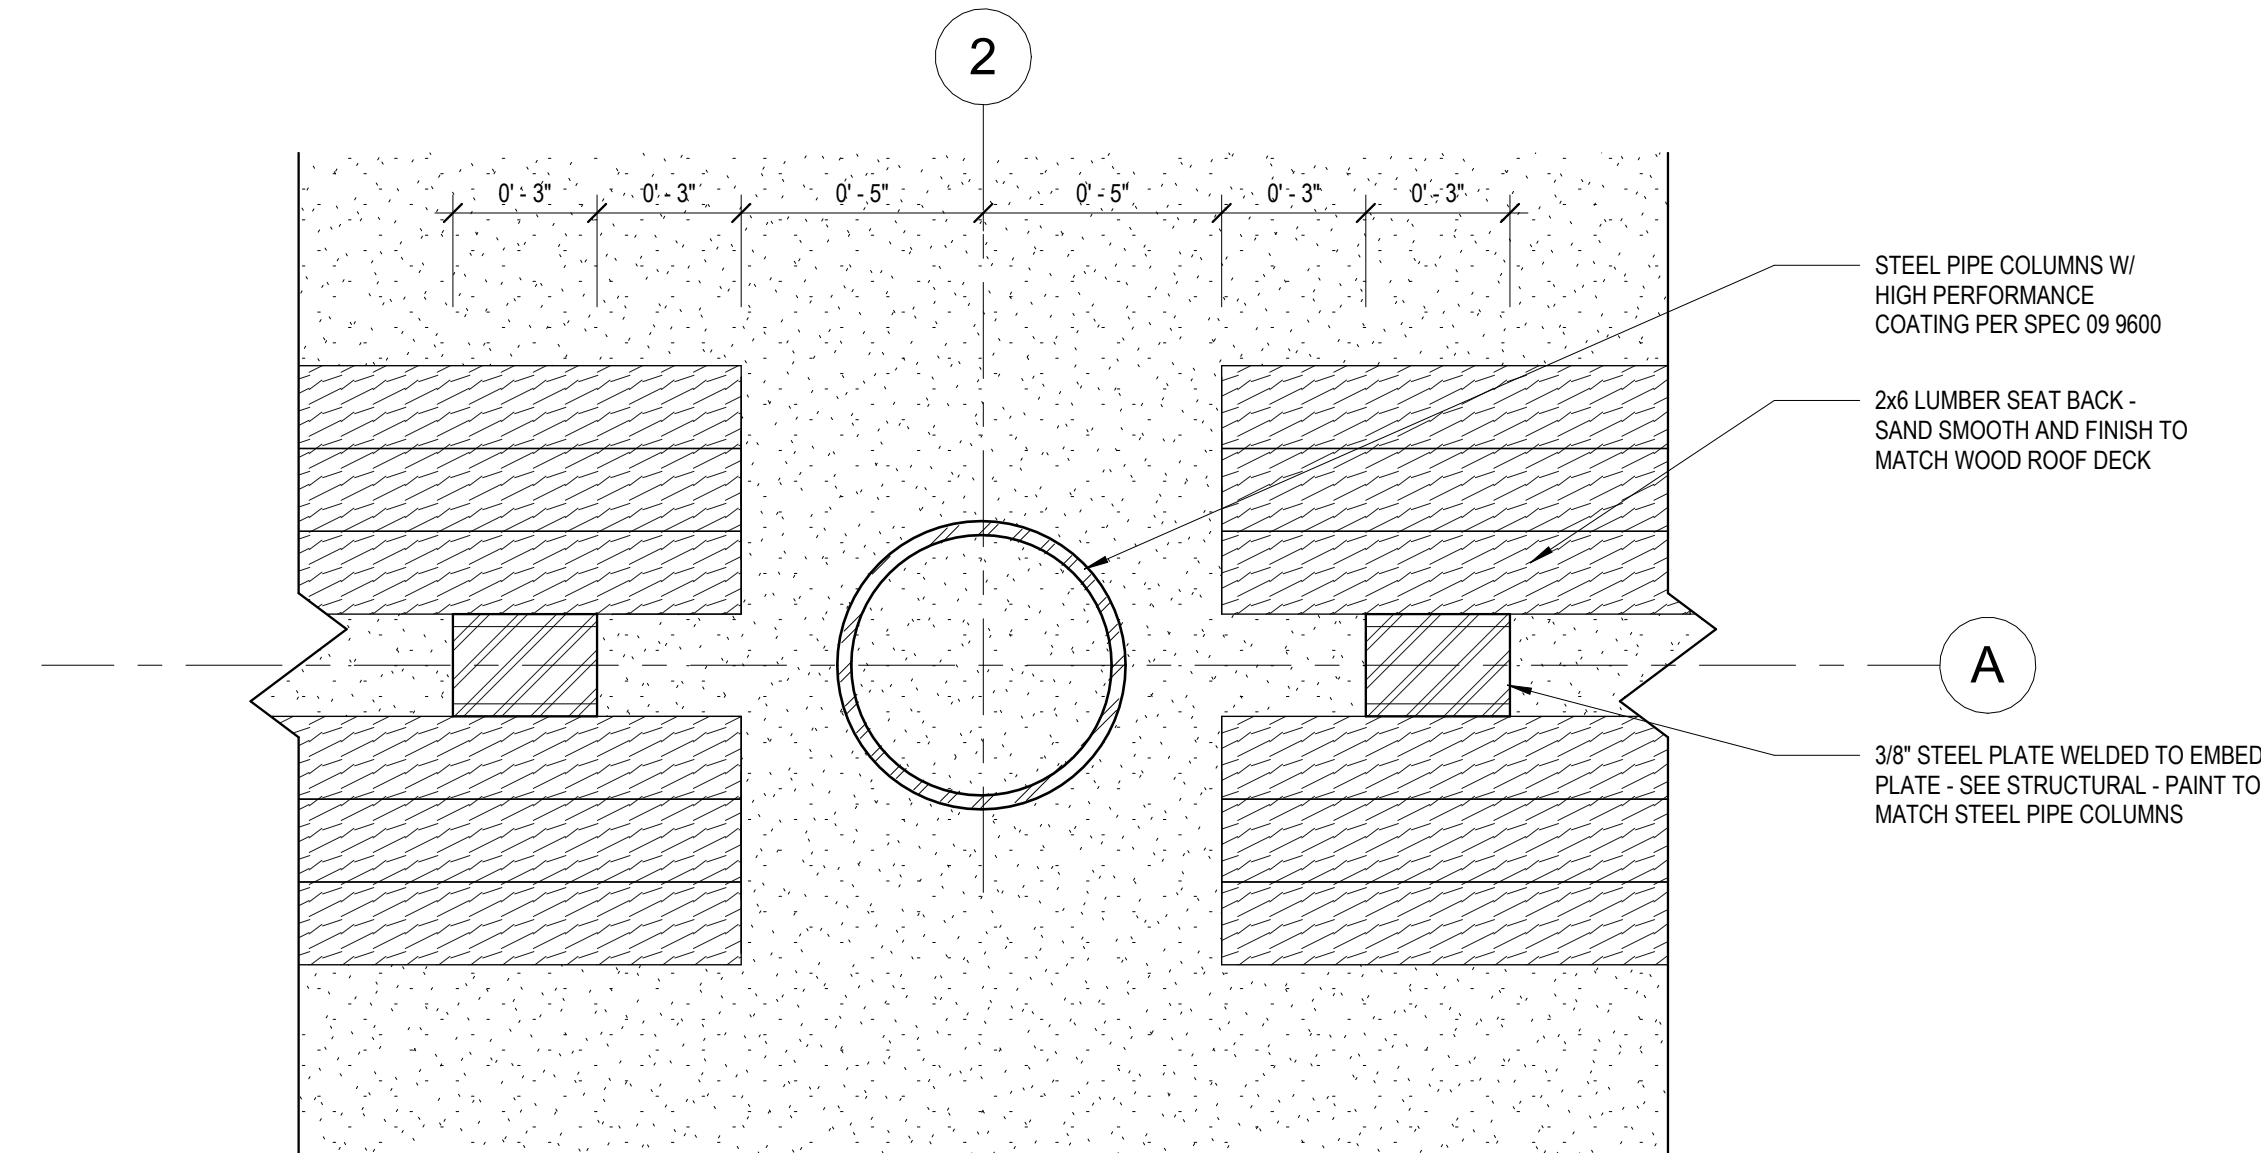

4 BENCH BACK DETAIL
ES-A502 3" = 1'-0"

Susan Hatchell
Landscape Architecture, PLLC
711 W. North Street, Raleigh, NC 27603
p: 919-838-9600 f: 919-838-9700



BENCH DETAILS


LAKE MYRA COUNTY PARK
Wake County, NC


REVISIONS

NO.	DESCRIPTION	DATE


Date: 07/27/26

ES-A502

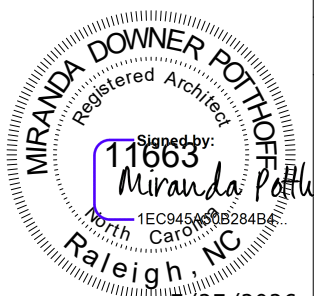


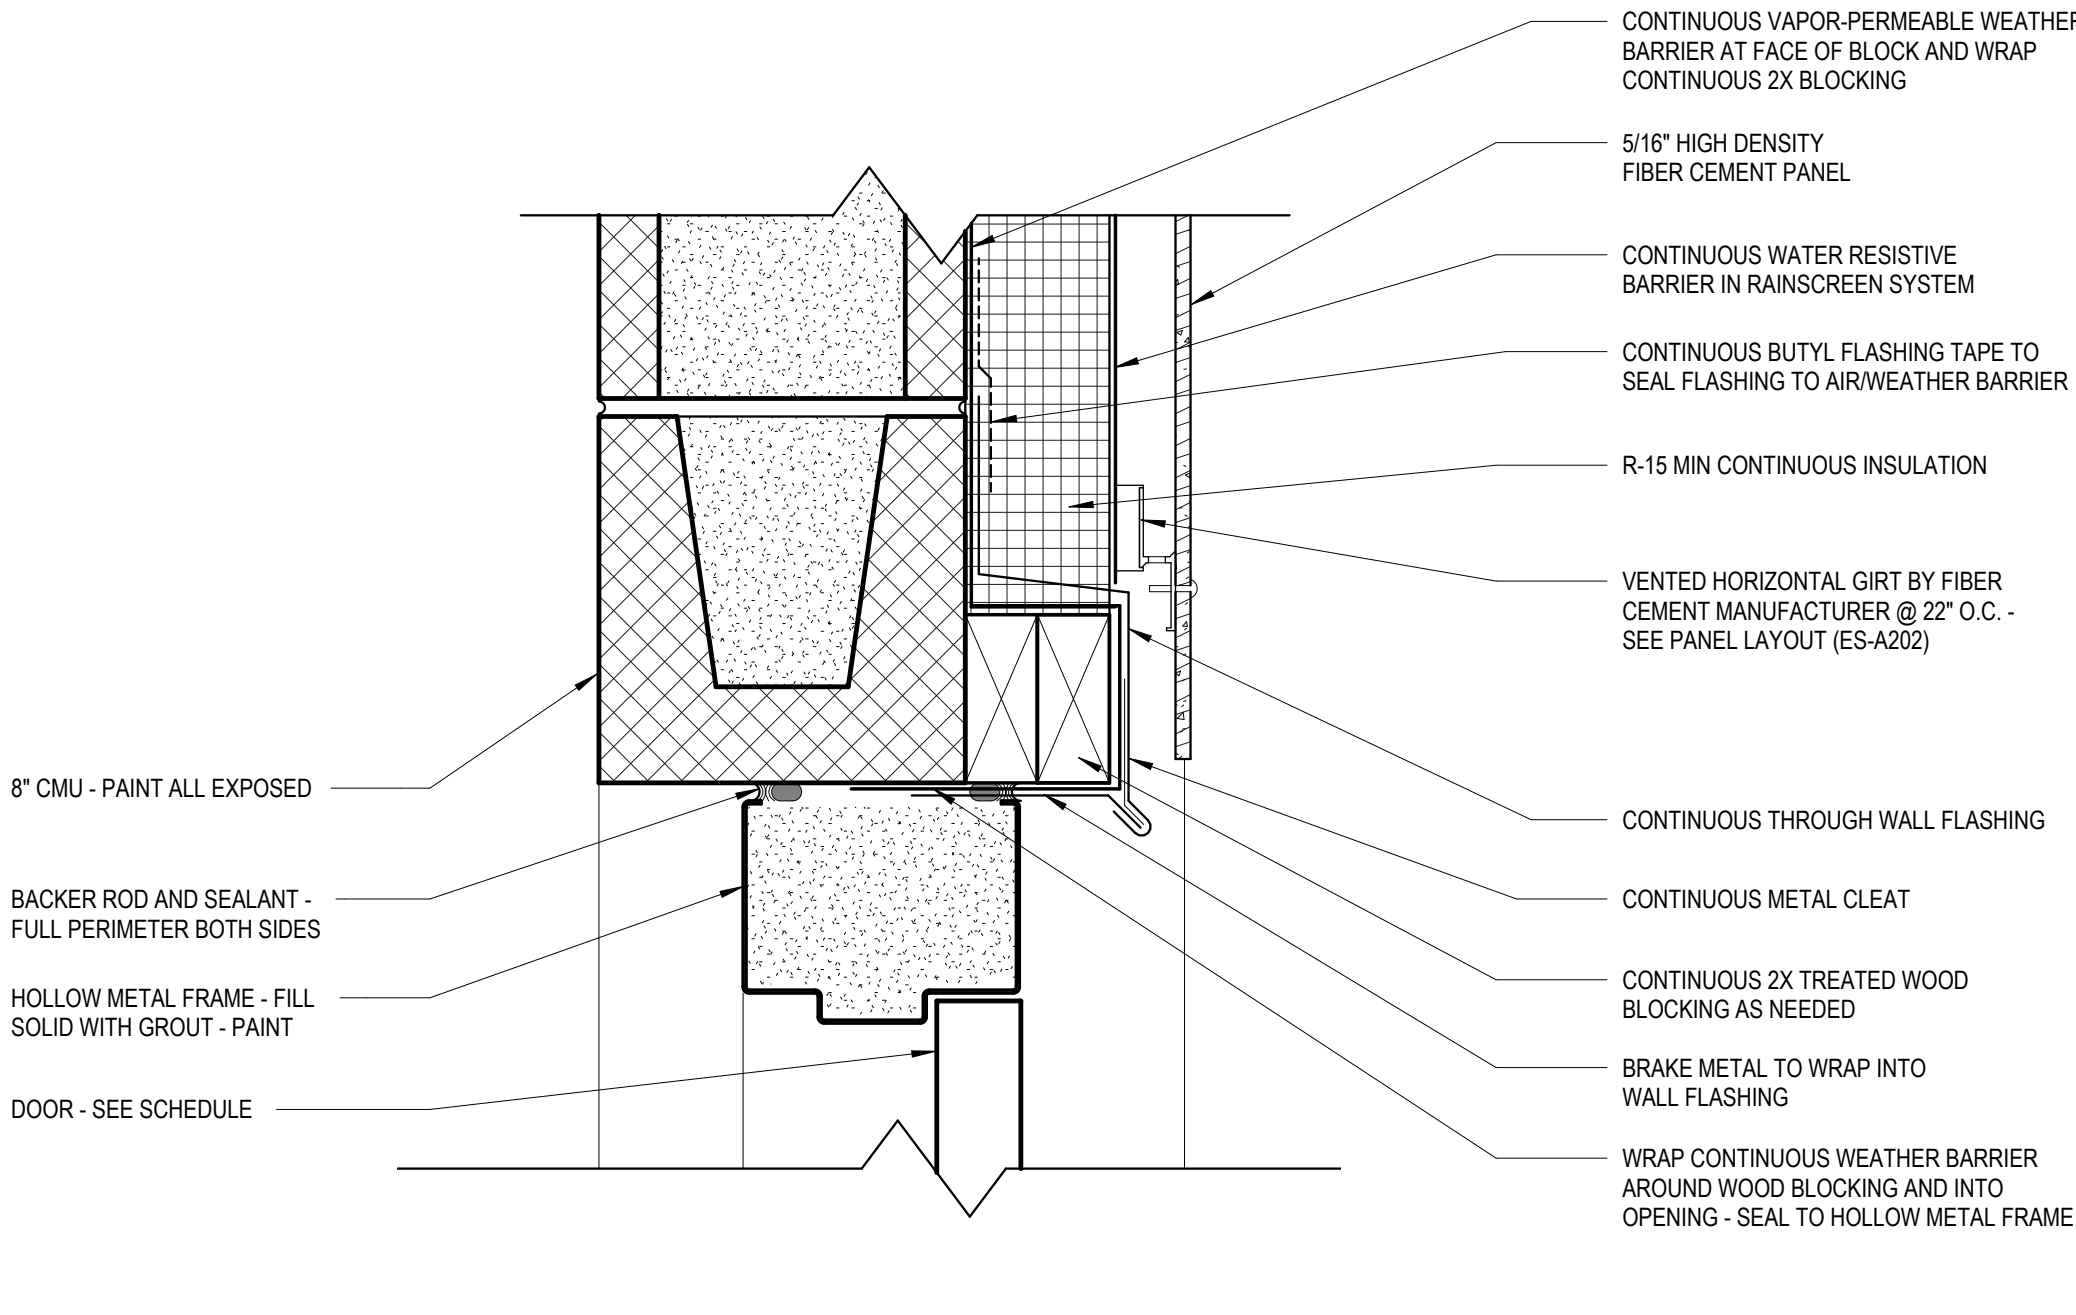


1 AIR BARRIER DETAIL @ HM DOOR HEAD
ES-A505 3" = 1'-0"

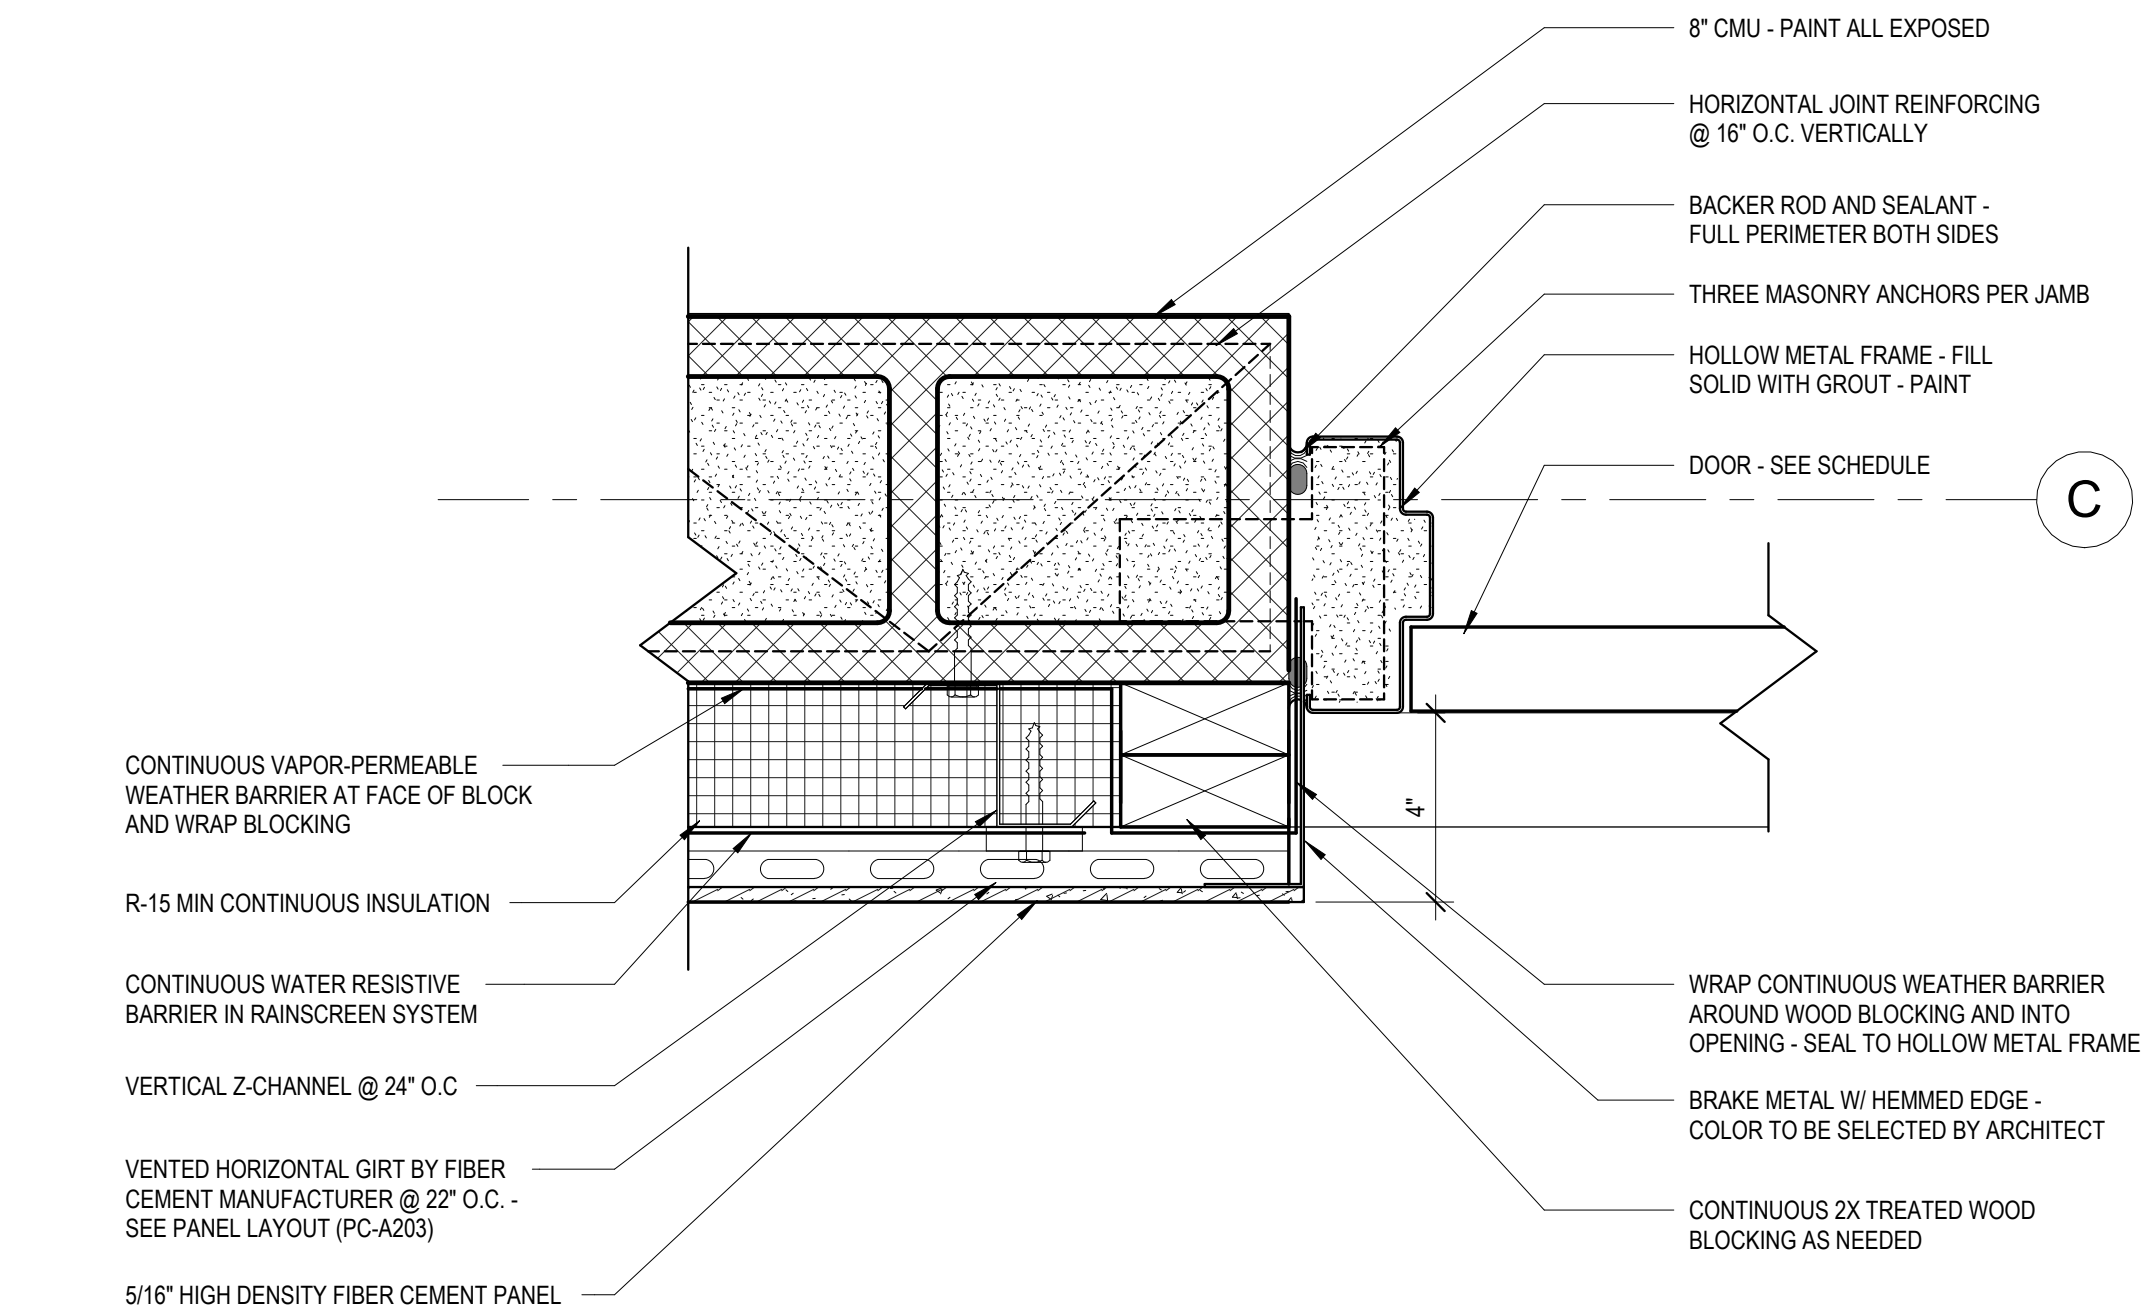


2 AIR BARRIER DETAIL @ HM DOOR JAMB
ES-A505 3" = 1'-0"

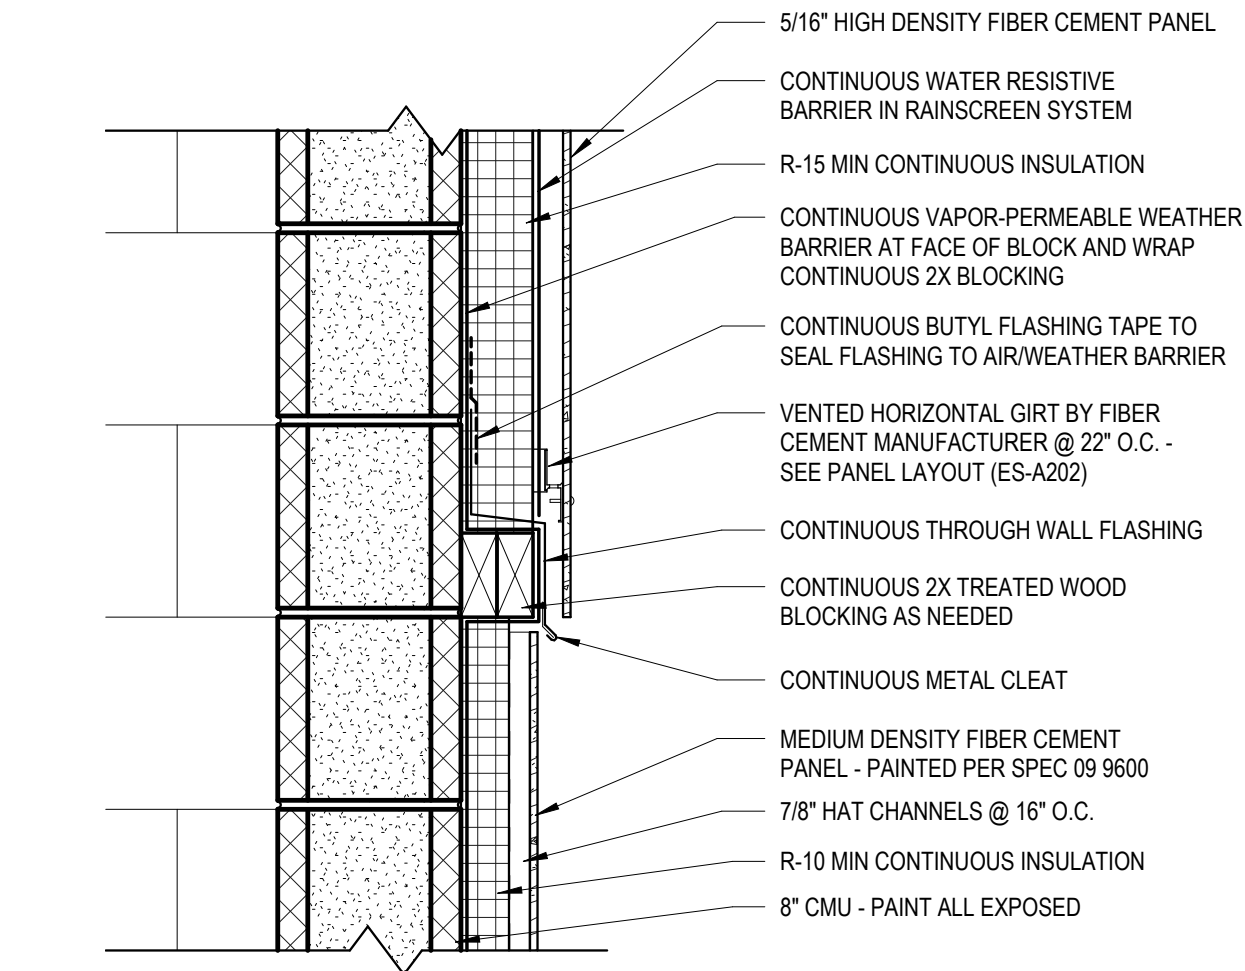

3 HEAD DETAIL @ DRINKING FOUNTAIN WALL
ES-A505 1 1/2" = 1'-0"

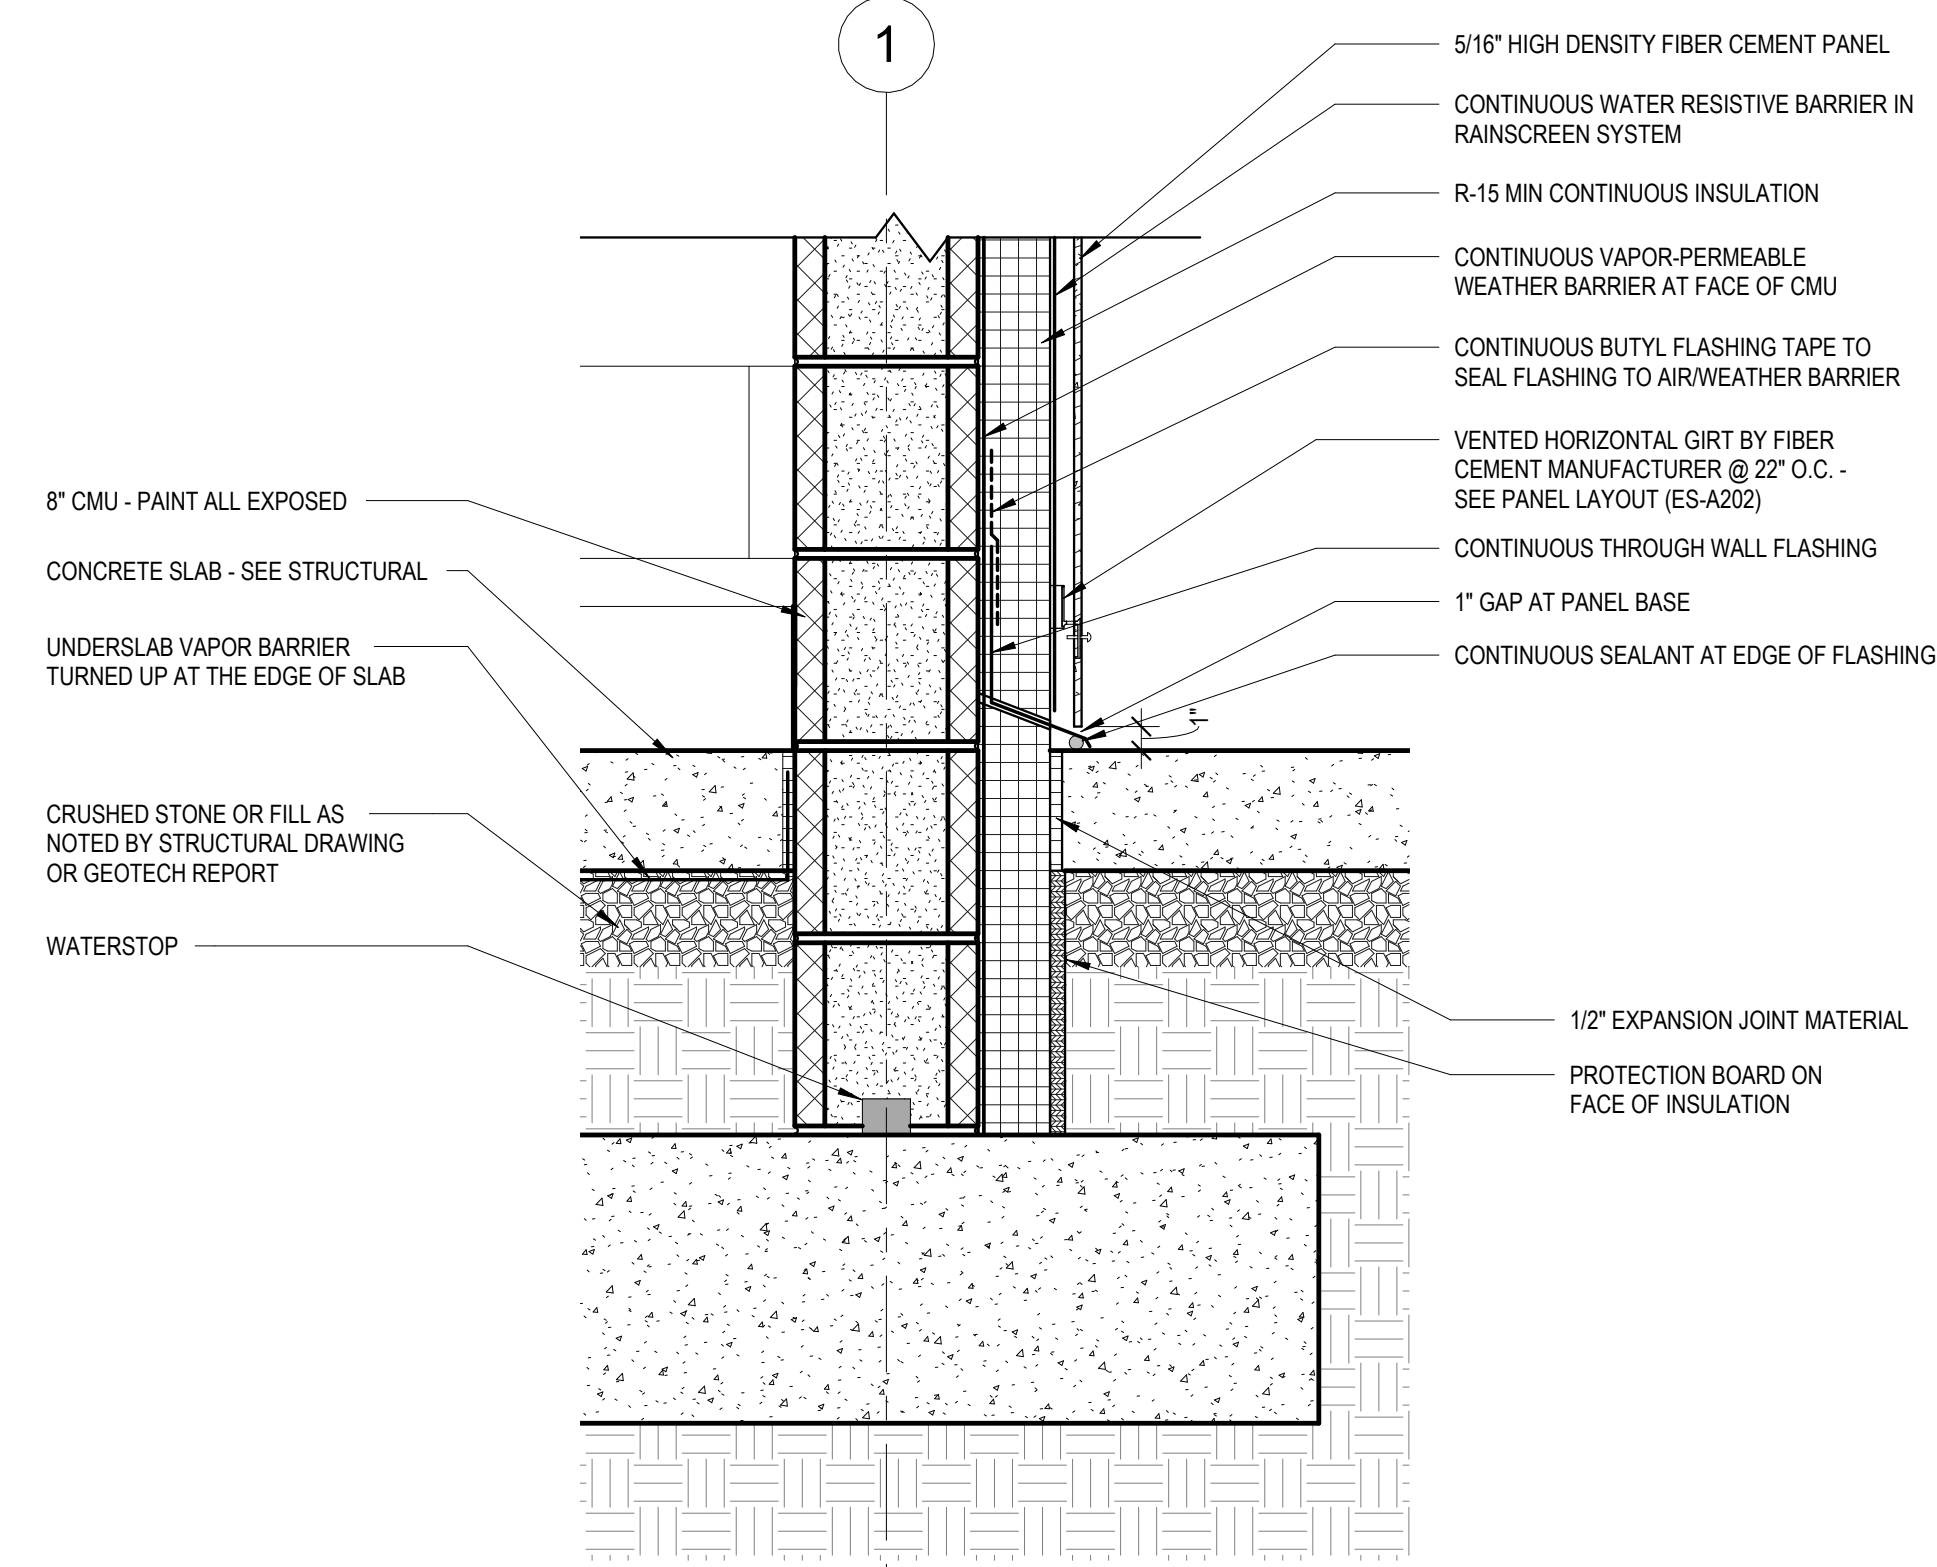

4 DETAIL @ PANEL BASE
ES-A505 1 1/2" = 1'-0"

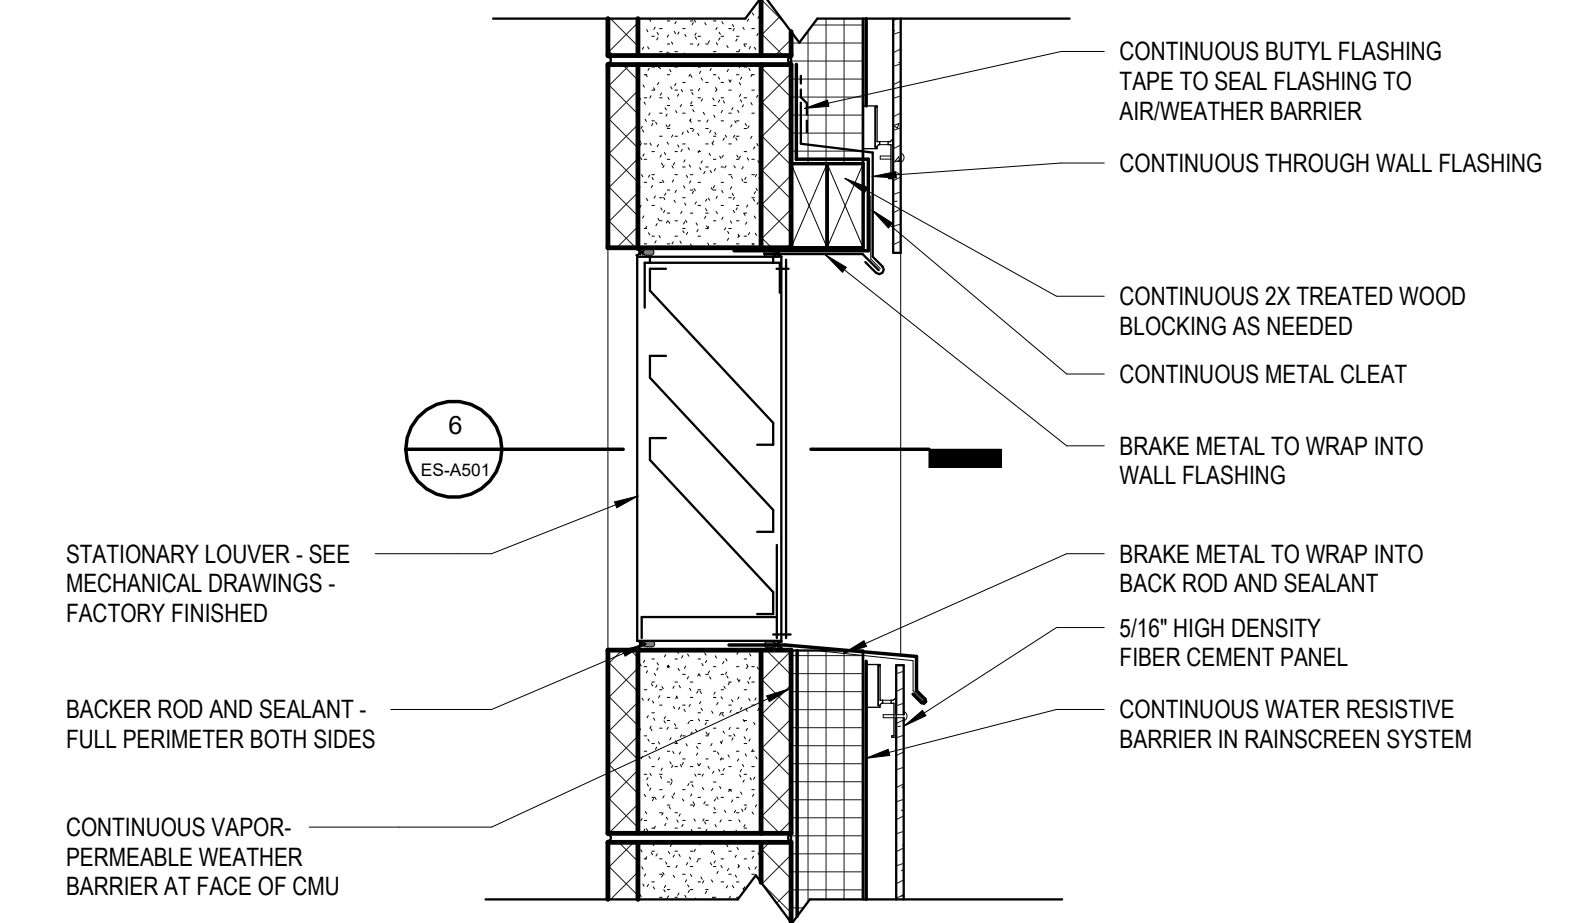

5 LOUVER SECTION DETAIL
ES-A505 1 1/2" = 1'-0"


Susan Hatchell
Landscape Architecture, PLLC
711 W. North Street, Raleigh, NC 27603
p: 919-838-9600 f: 919-838-9700




AIR BARRIER DETAILS

LAKE MYRA COUNTY PARK
Wake County, NC

REVISIONS		Date: 07/27/26
NO.	DESCRIPTION	

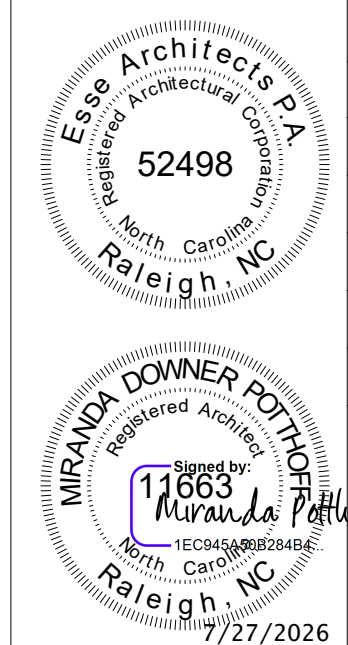

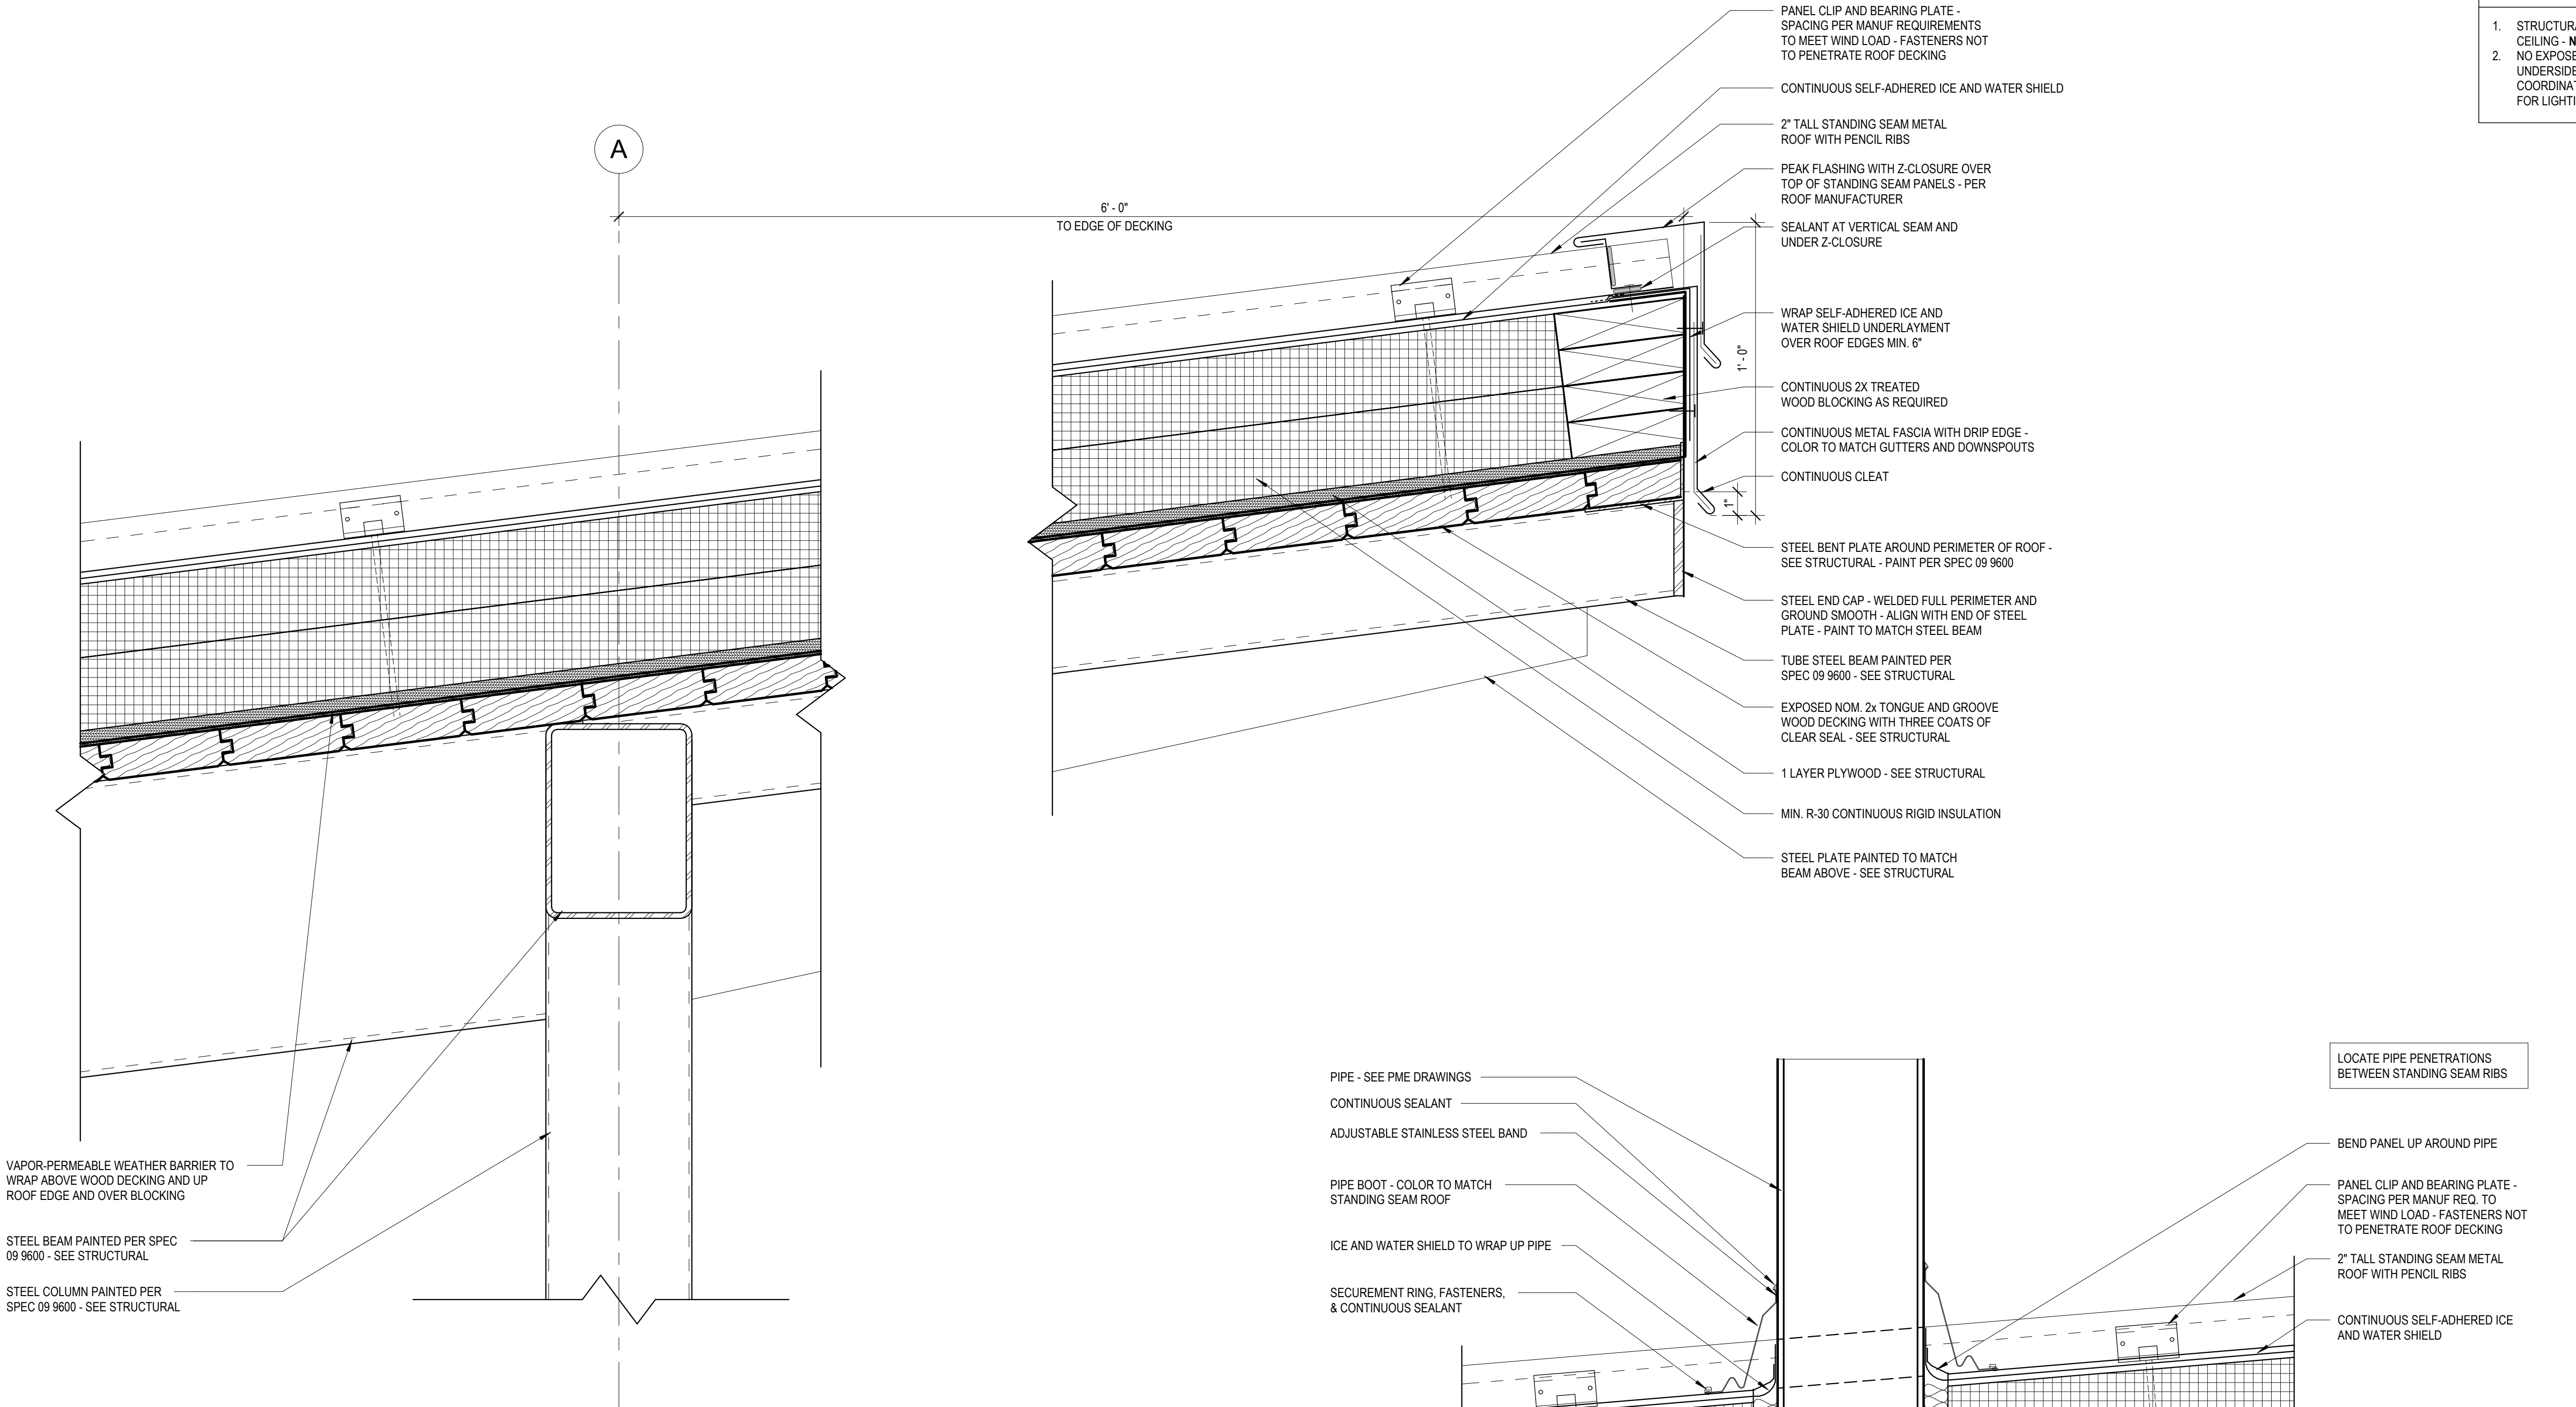

1 ROOF DETAIL @ HIGH SIDE
3" = 1'-0"

3 ROOF DETAIL @ PENETRATION
3" = 1'-0"

Susan Hatchell
Landscape Architecture, PLLC
711 W. North Street, Raleigh, NC 27603
p: 919-838-9600 f: 919-838-9700




ROOF DETAILS


LAKE MYRA COUNTY PARK
Wake County, NC

REVISIONS


Date: 07/27/26

ES-A525

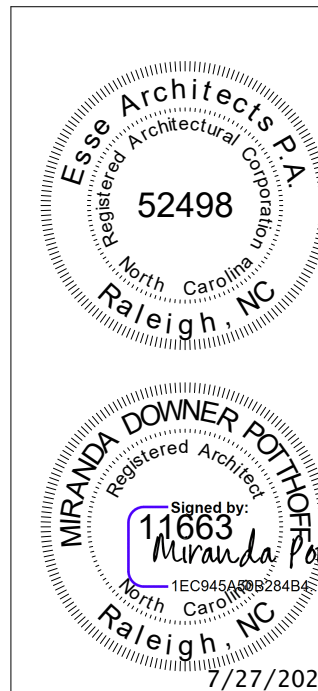


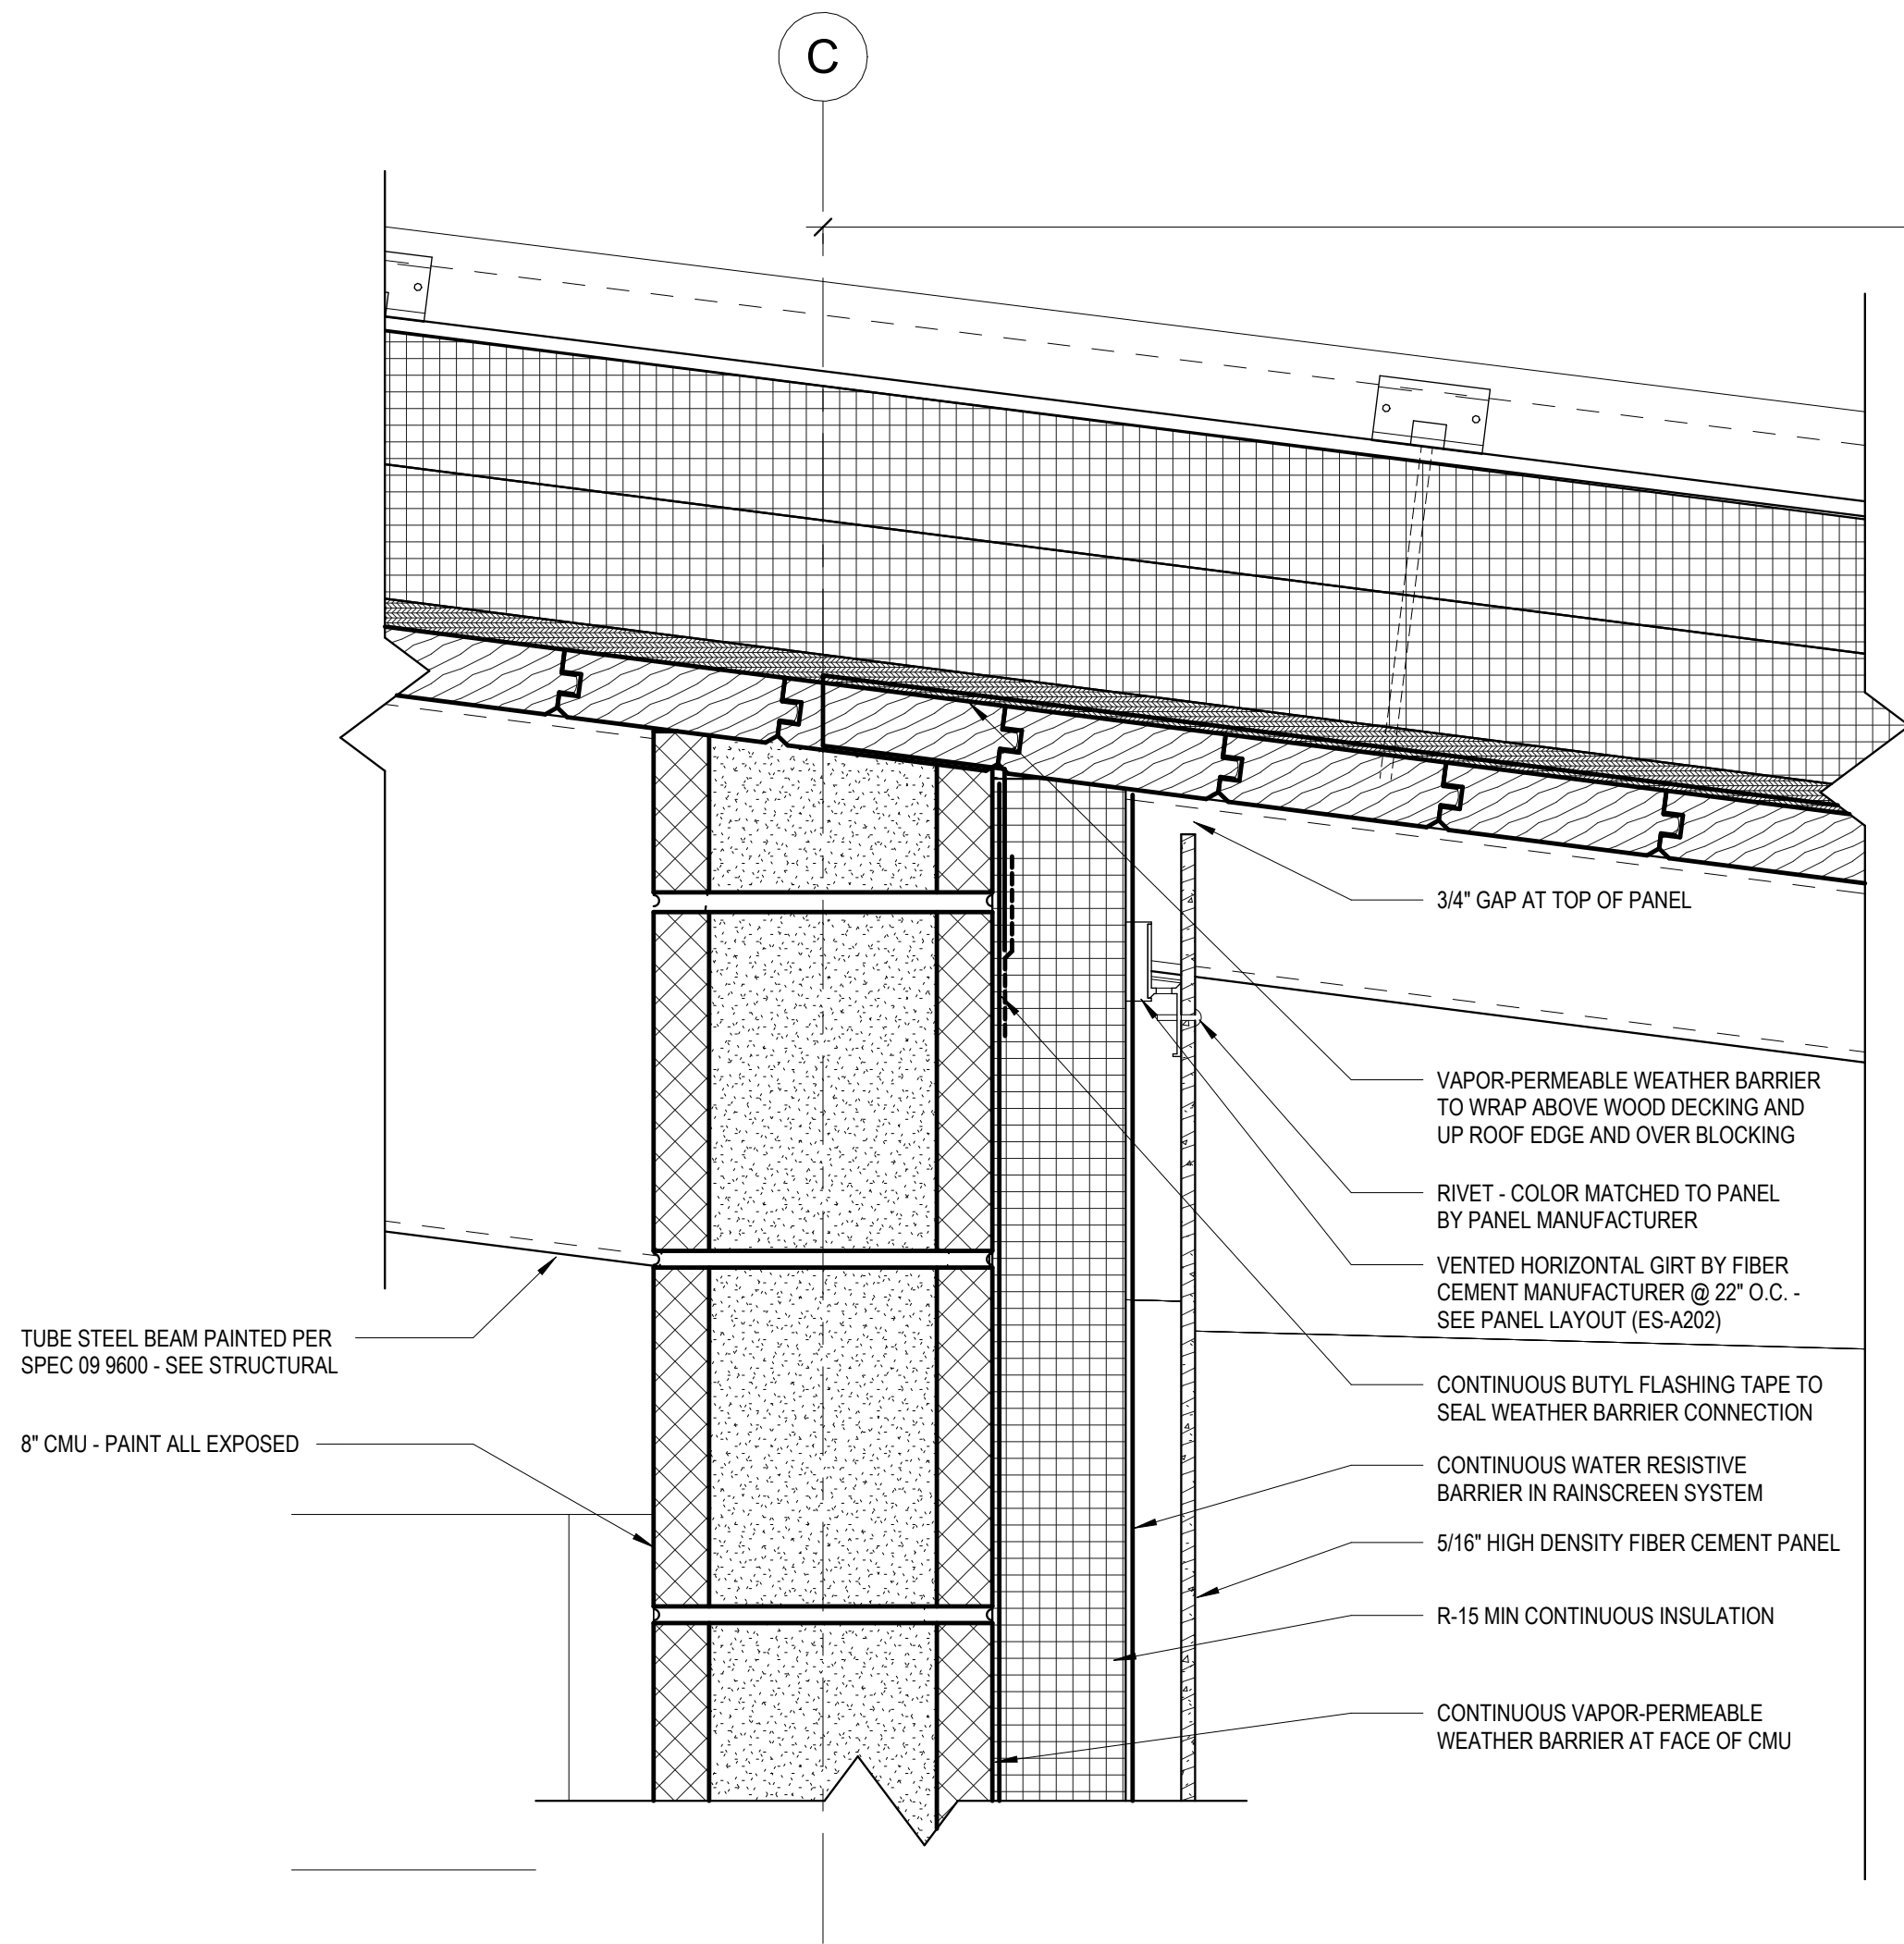


1 ROOF DETAIL @ LOW SIDE
ES-A526 3" = 1'-0"

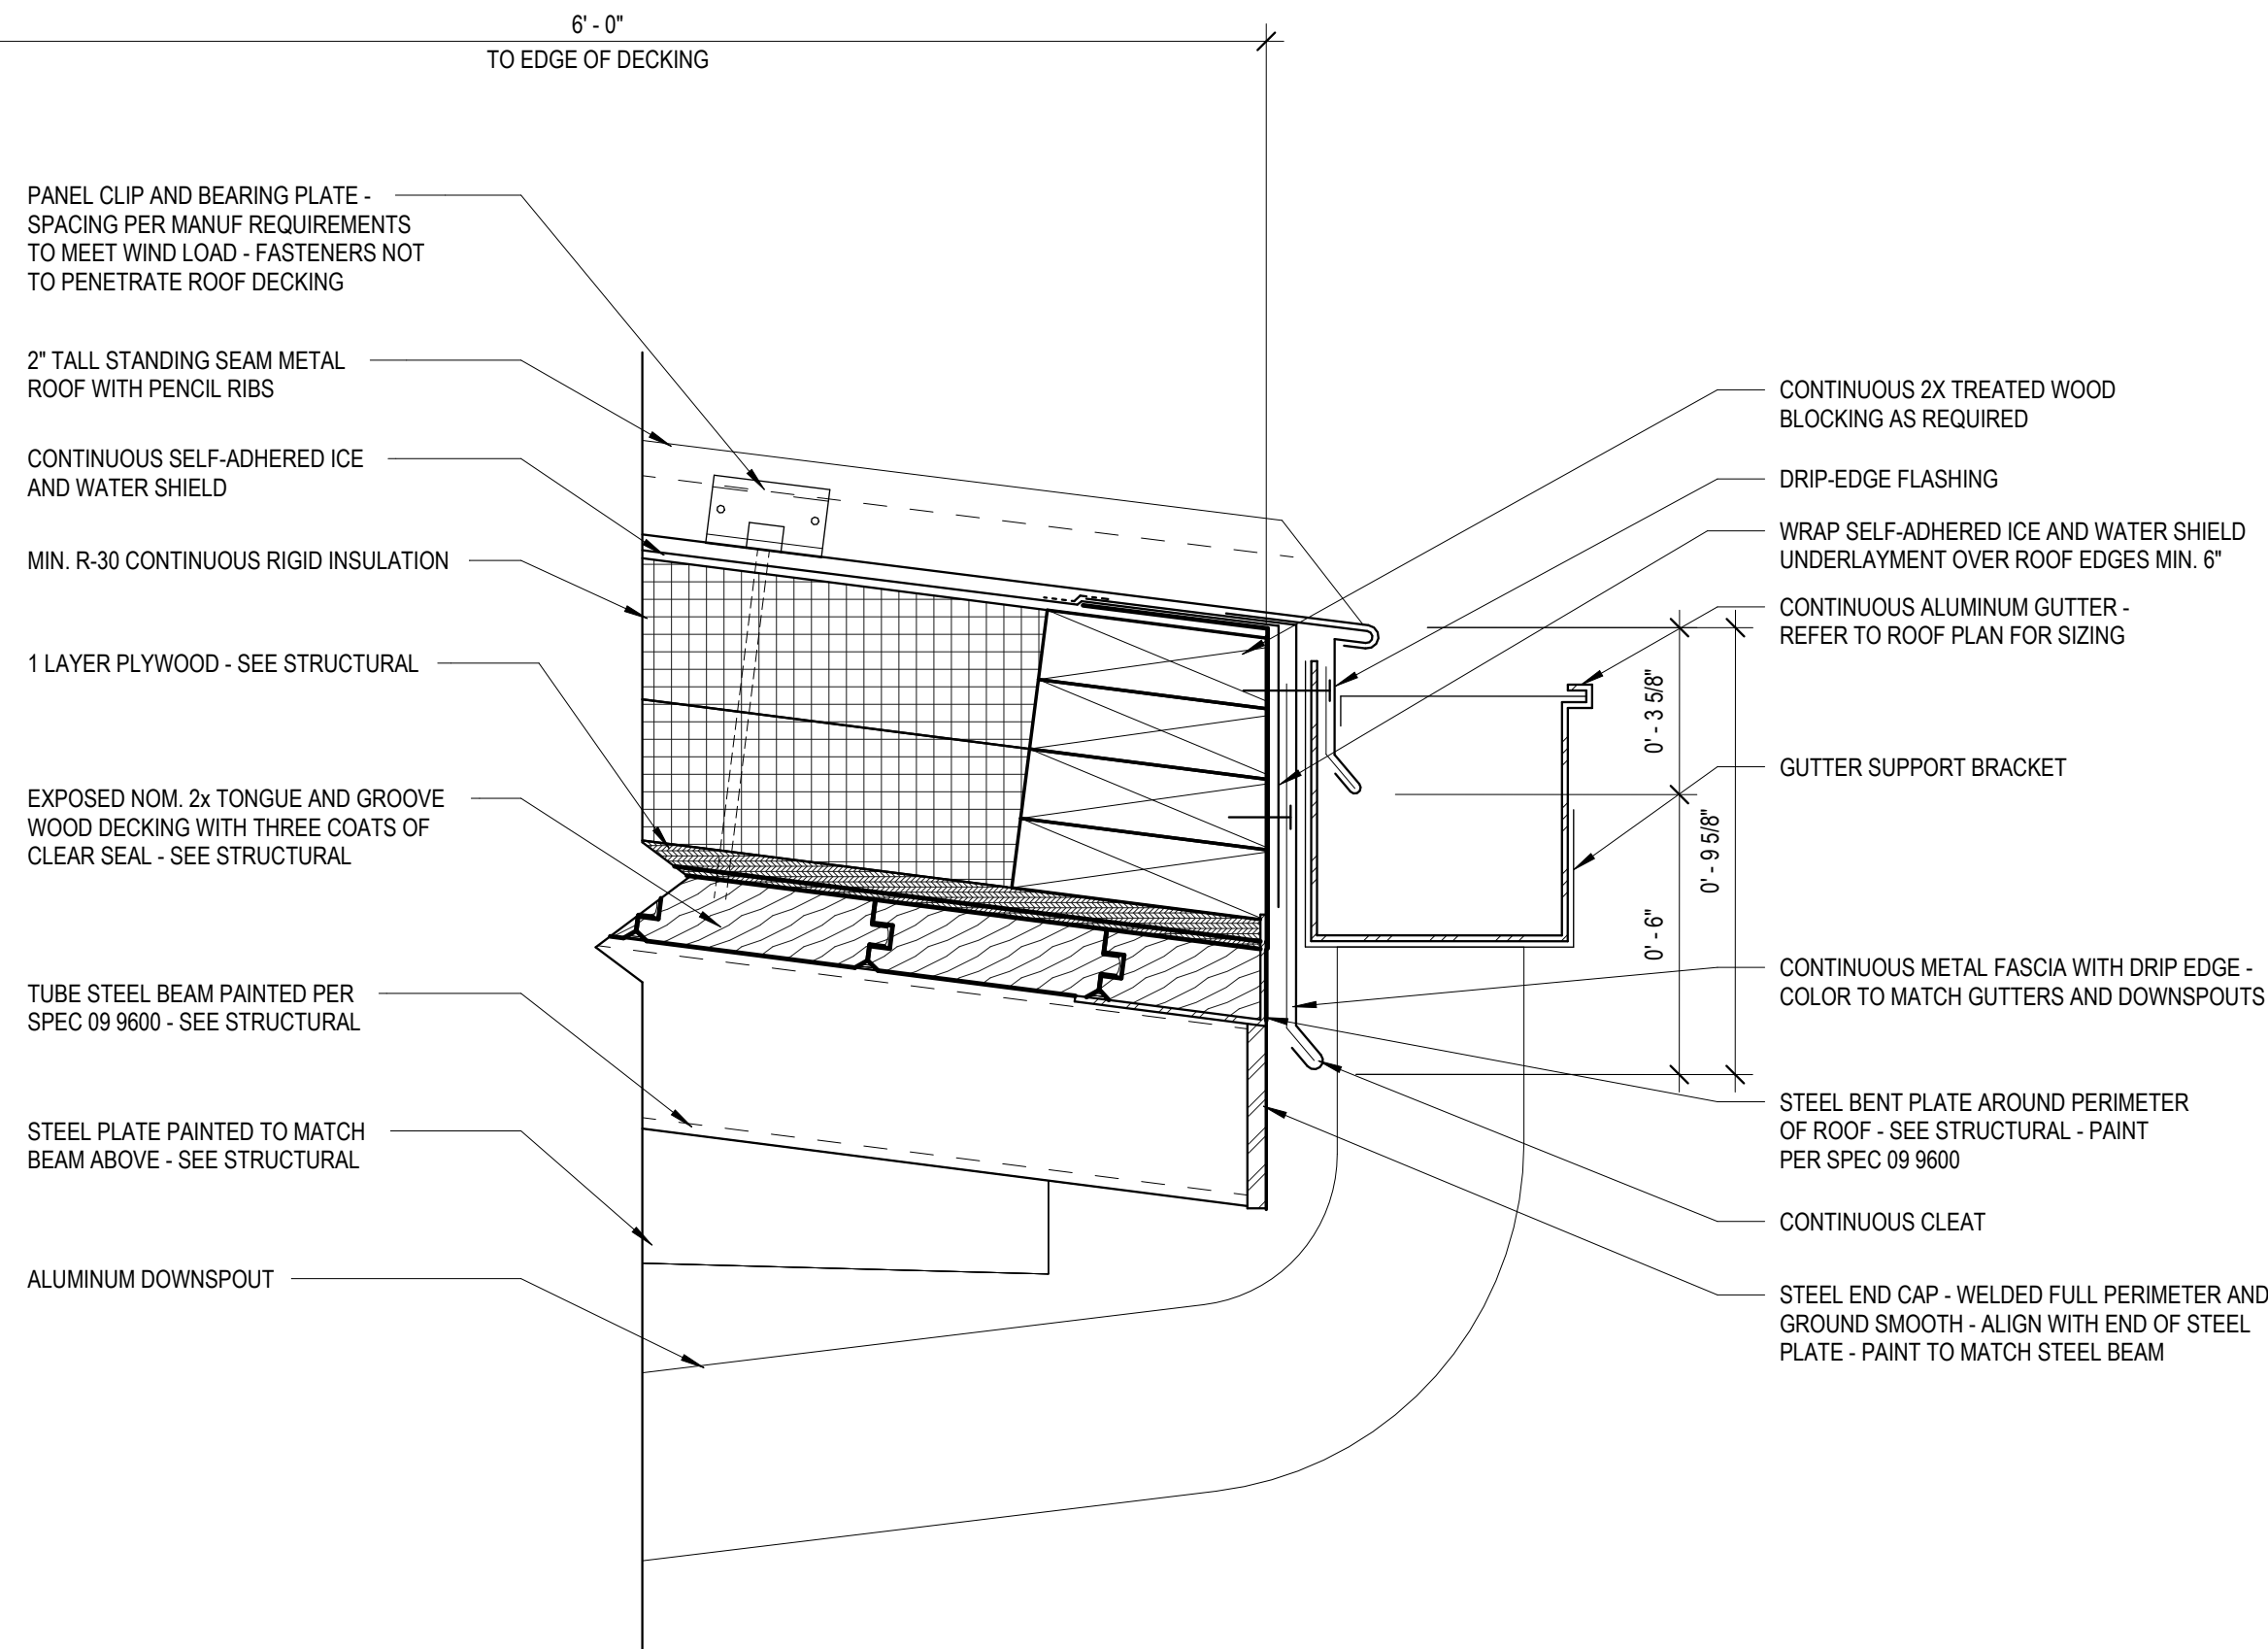

2 ROOF DETAIL @ SINGLE RESTROOM
ES-A526 3" = 1'-0"

- ROOF DECKING NOTES**
- STRUCTURAL WOOD ROOF DECK IS ALSO FINISHED CEILING - **NO FASTENERS SHALL PENETRATE DECKING**
 - NO EXPOSED CONDUIT SHALL BE RUN ACROSS UNDERSIDE OF WOOD DECKING WITHOUT REVIEW AND COORDINATION WITH THE ARCHITECT. COORDINATE FOR LIGHTING, SECURITY, ETC.

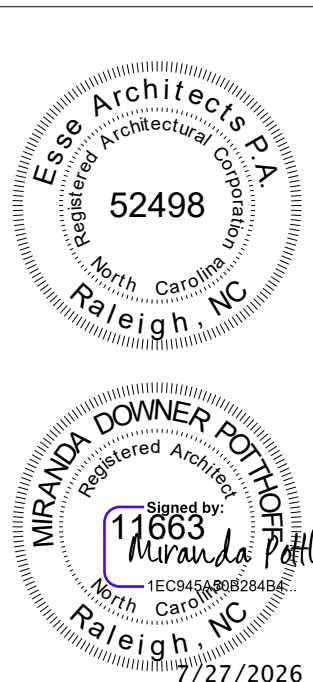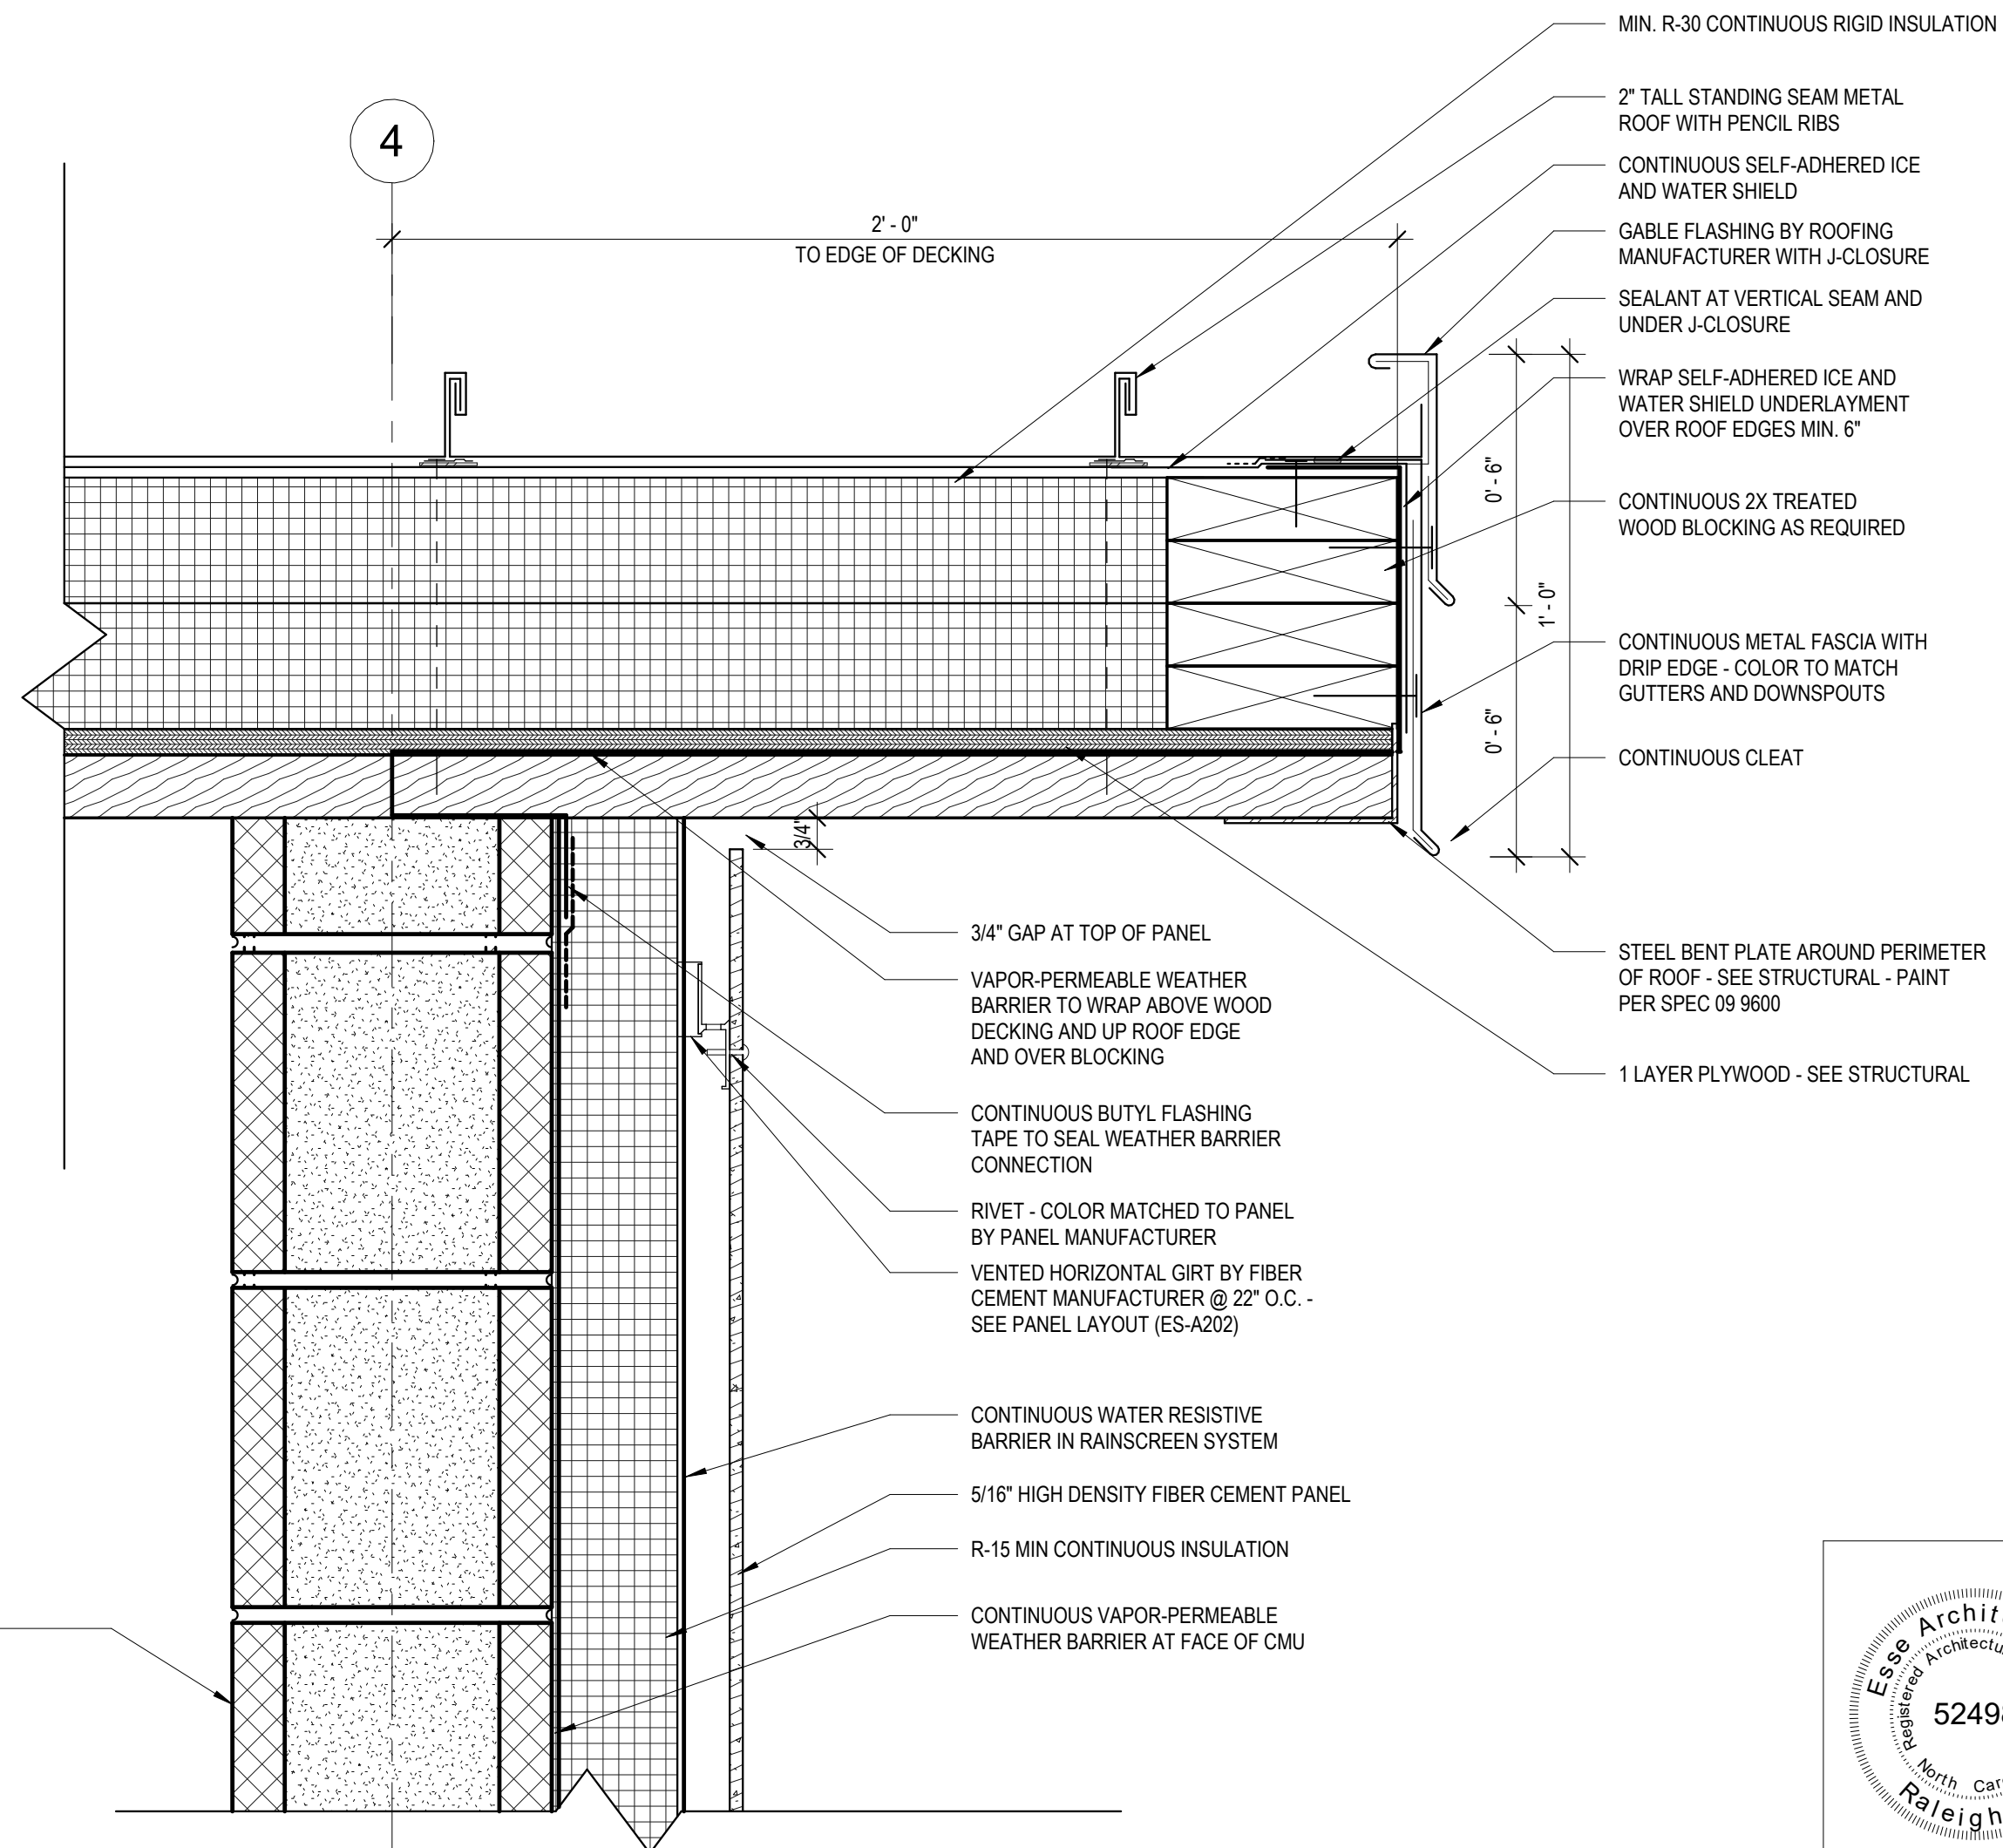

Susan Hatchell
Landscape Architecture, PLLC
711 W. North Street, Raleigh, NC 27603
p: 919-838-9600 f: 919-838-9700




ROOF DETAILS

LAKE MYRA COUNTY PARK
Wake County, NC

REVISIONS

Date: 07/27/26


ES-A526

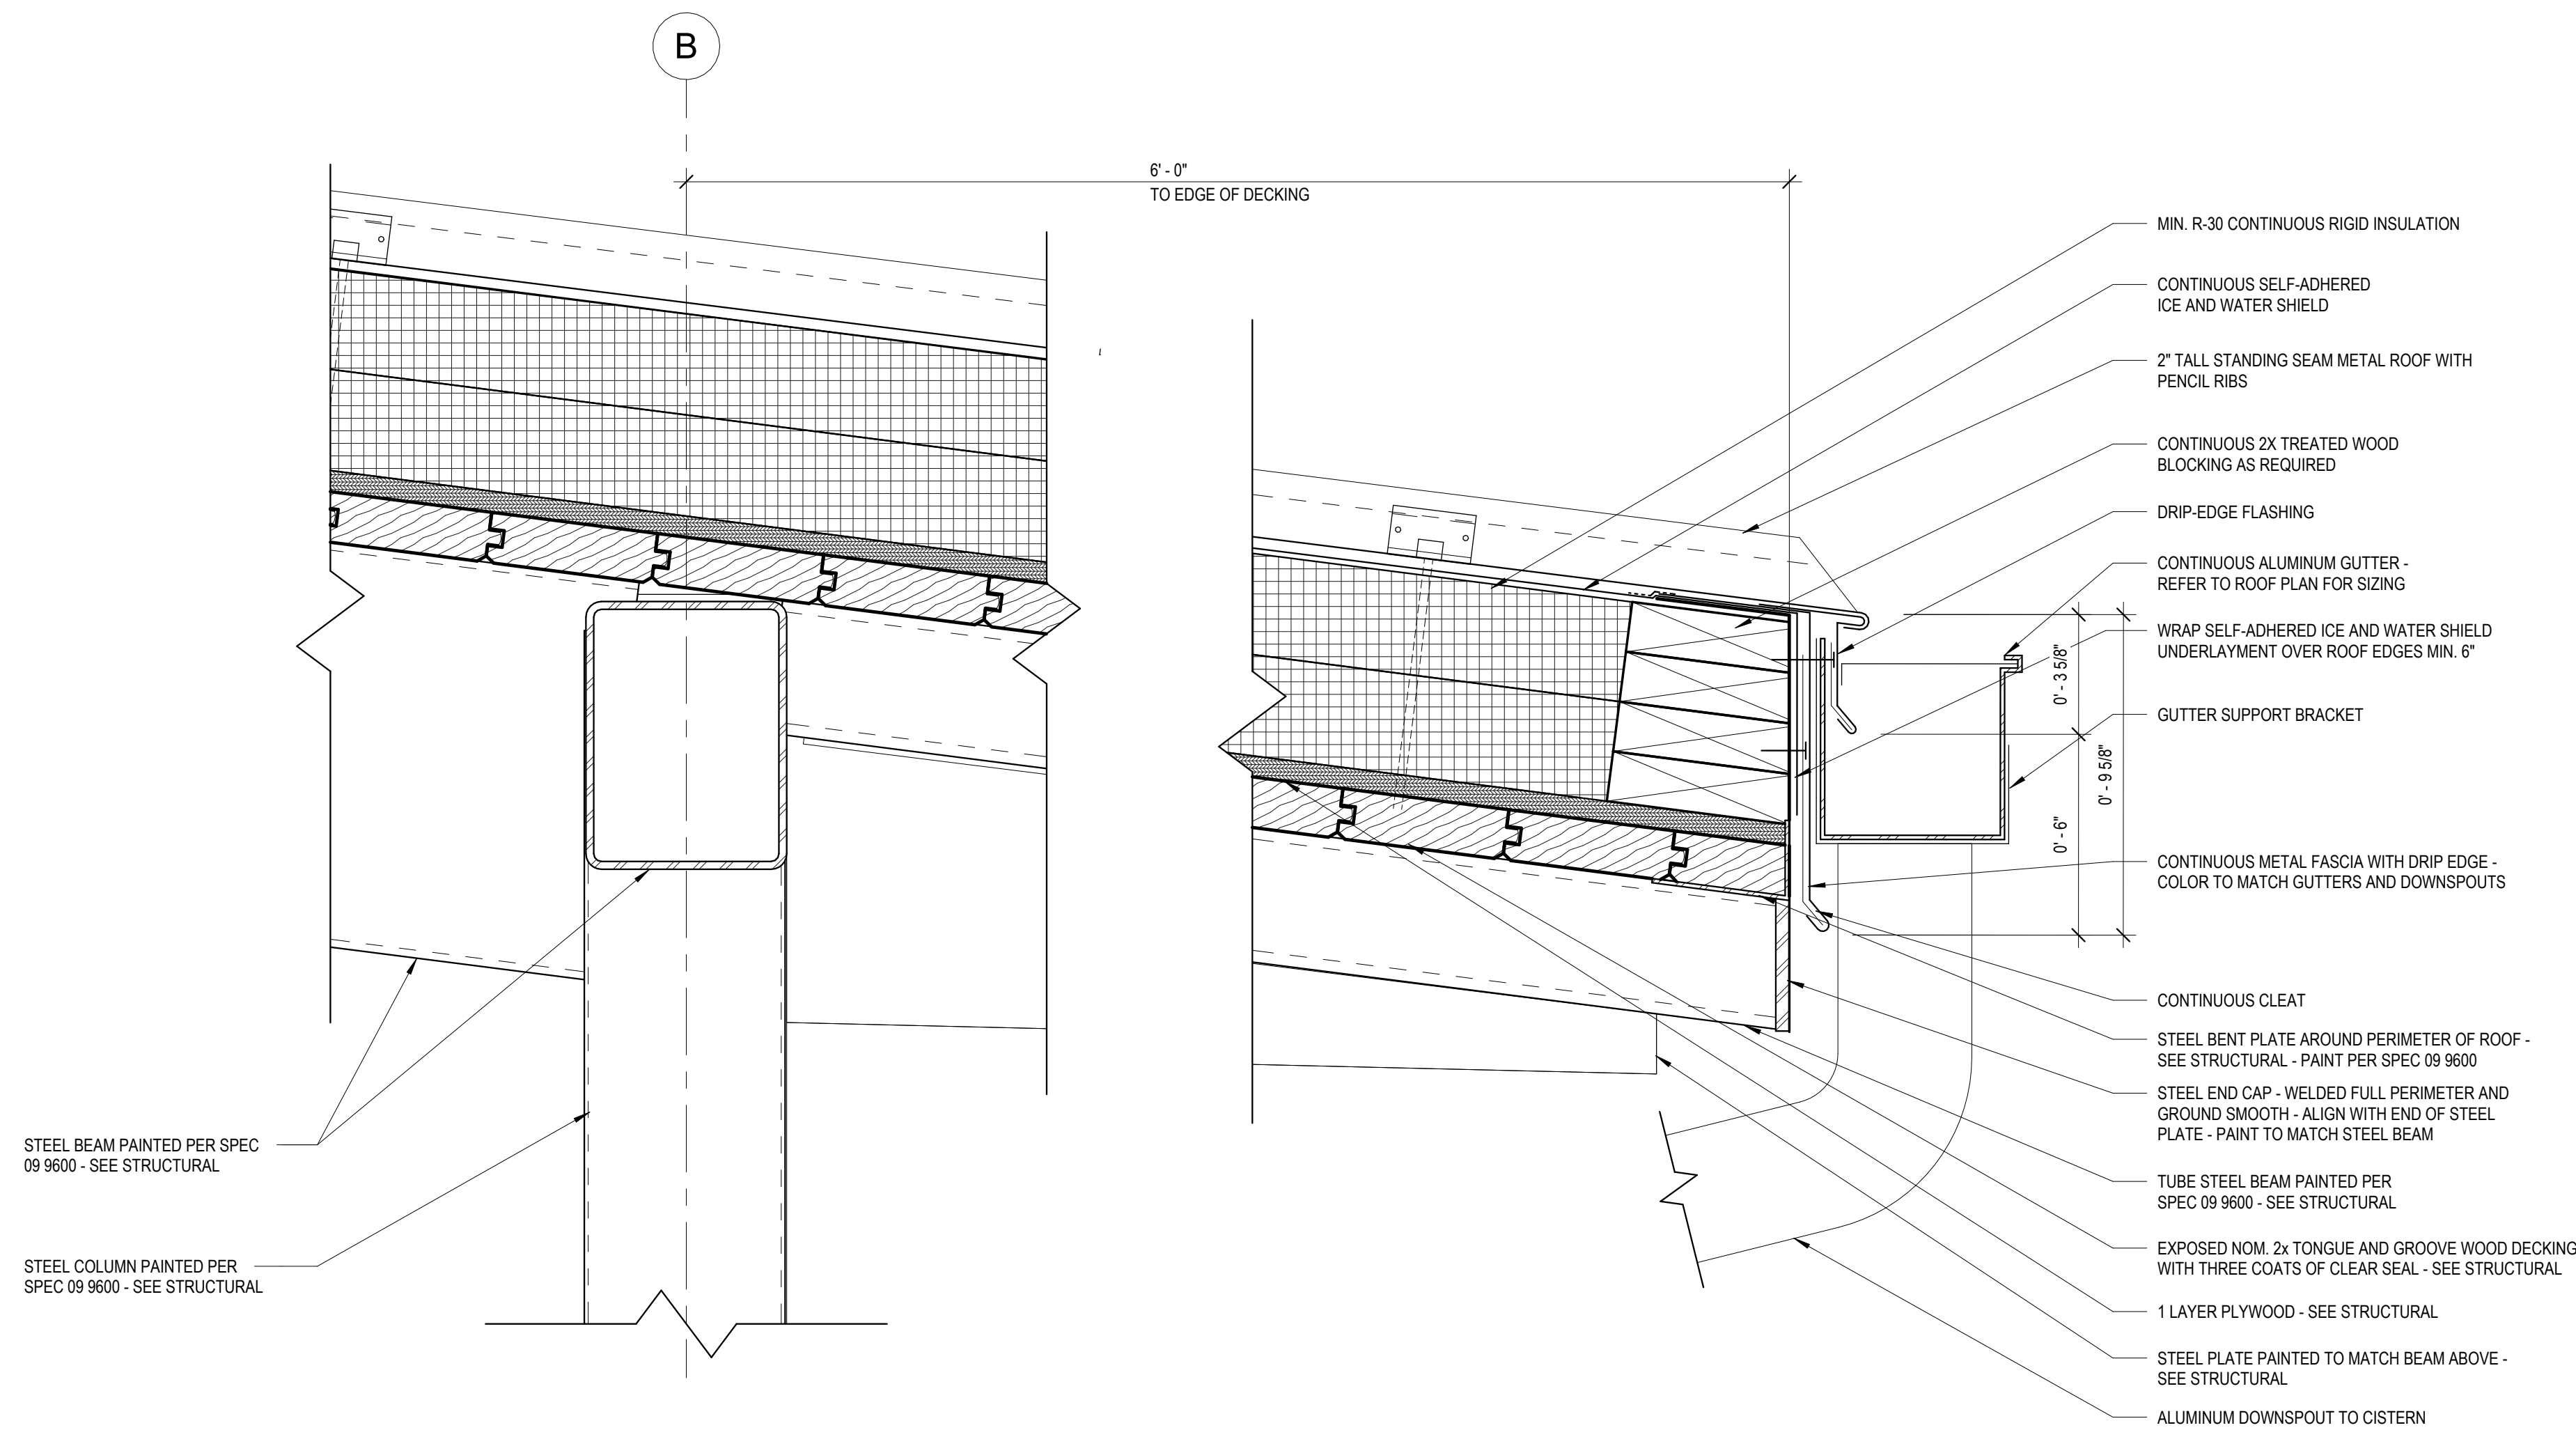

- ROOF DECKING NOTES**
1. STRUCTURAL WOOD ROOF DECK IS ALSO FINISHED CEILING - **NO FASTENERS SHALL PENETRATE DECKING**
 2. NO EXPOSED CONDUIT SHALL BE RUN ACROSS UNDERSIDE OF WOOD DECKING WITHOUT REVIEW AND COORDINATION WITH THE ARCHITECT. COORDINATE FOR LIGHTING, SECURITY, ETC.

1
ES-A527
3" = 1'-0"

ROOF DETAIL @ LOW SIDE PICNIC SHELTER

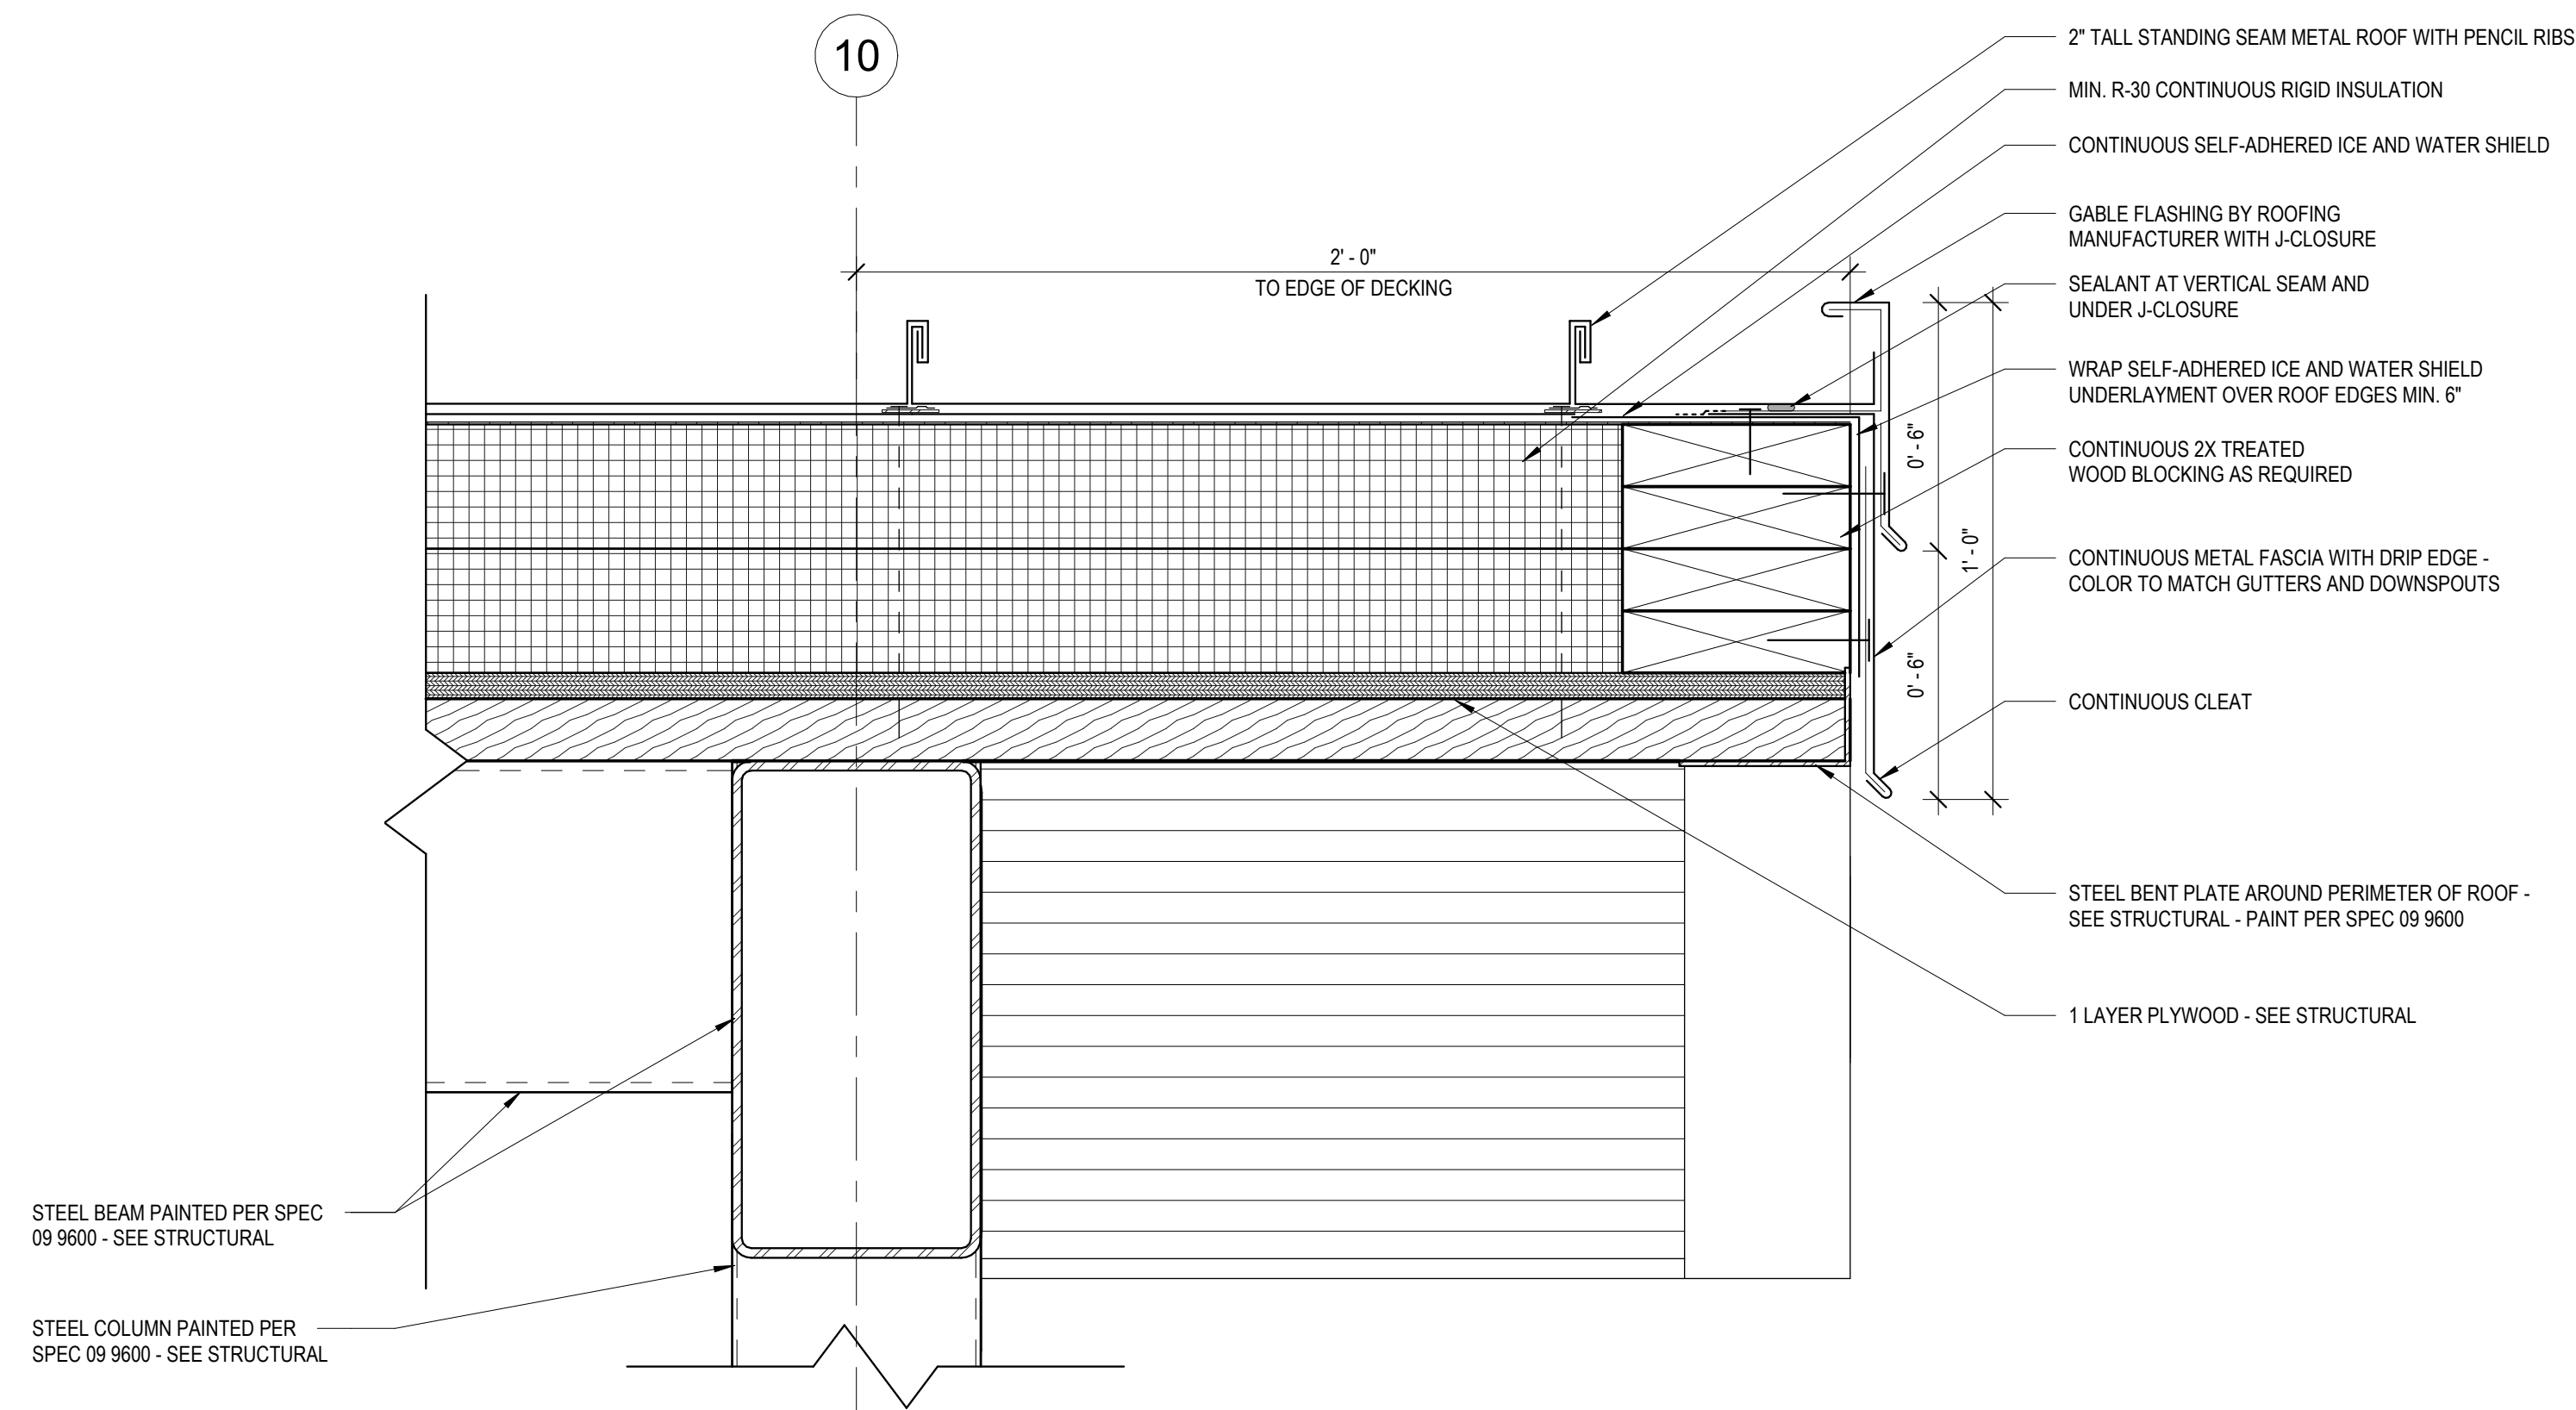

2
ES-A527
3" = 1'-0"

ROOF DETAIL @ PICNIC SHELTER

Susan Hatchell
Landscape Architecture, PLLC
711 W. North Street, Raleigh, NC 27603
p: 919-838-9600 f: 919-838-9700




ROOF DETAILS

LAKE MYRA COUNTY PARK
Wake County, NC

REVISIONS

Date: 07/27/26

ES-A527

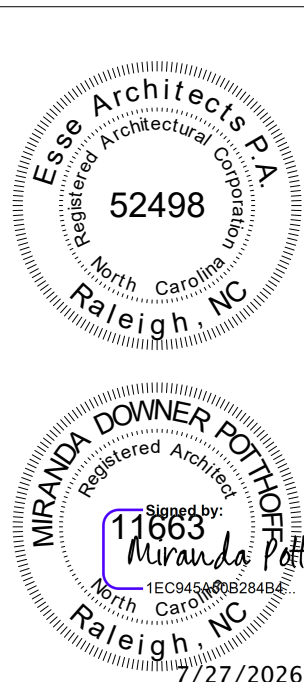


SHELTERS DOOR SCHEDULE														
NUMBER	DOOR					FRAME			DETAIL			HW Set	RATING	COMMENTS
	HEIGHT	WIDTH	MATERIAL	FINISH	ELEVATION	MATERIAL	FINISH	ELEVATION	HEAD	JAMB	SILL			
101	7'-0"	3'-0"	HM	PT-5	A	HM	PT-5	1	2/ES-A601	3/ES-A601	4/ES-A601	5/ES-A601	ES - 1.0	EXTERIOR DOOR, DOOR CONTACT, ELECTRIC MORTISE TIMER LOCK
102	7'-0"	3'-0"	HM	PT-5	A	HM	PT-5	1	2/ES-A601	4/ES-A601	5/ES-A601	ES - 1.0		EXTERIOR DOOR, DOOR CONTACT, ELECTRIC MORTISE TIMER LOCK
103	7'-0"	3'-0"	HM	PT-5	A	HM	PT-5	1	2/ES-A601	2/ES-A601	4/ES-A601	5/ES-A601	ES - 1.0	EXTERIOR DOOR, DOOR CONTACT, ELECTRIC MORTISE TIMER LOCK
104	7'-0"	3'-0"	HM	PT-5	A	HM	PT-5	1	2/ES-A601	3/ES-A601	4/ES-A601	5/ES-A601	ES - 1.0	EXTERIOR DOOR, DOOR CONTACT, ELECTRIC MORTISE TIMER LOCK
105	7'-0"	6'-0"	HM	PT-3	B	HM	PT-3	2	1/ES-A601	4/ES-A601	5/ES-A601	ES - 2.0		EXTERIOR DOOR, DOOR CONTACT, PAINT TO BE SEMI-GLOSS FINISH


DOOR HARDWARE NOTES:

- CARD READERS, DOOR CONTACTS, AND POWER SUPPLIES TO BE BY THE OWNER'S SECURITY VENDOR
- THE BALANCE OF DOOR HARDWARE IS IN THE GENERAL CONTRACTOR'S SCOPE.
- THE OWNER WILL CONTROL THE LOCKED/UNLOCKED TIMING OF RESTROOM DOORS THROUGH THEIR SECURITY SYSTEM. (PREP AS THOUGH RECEIVING CARD READER, BUT NO CARD READER)


DOOR ELEVATIONS

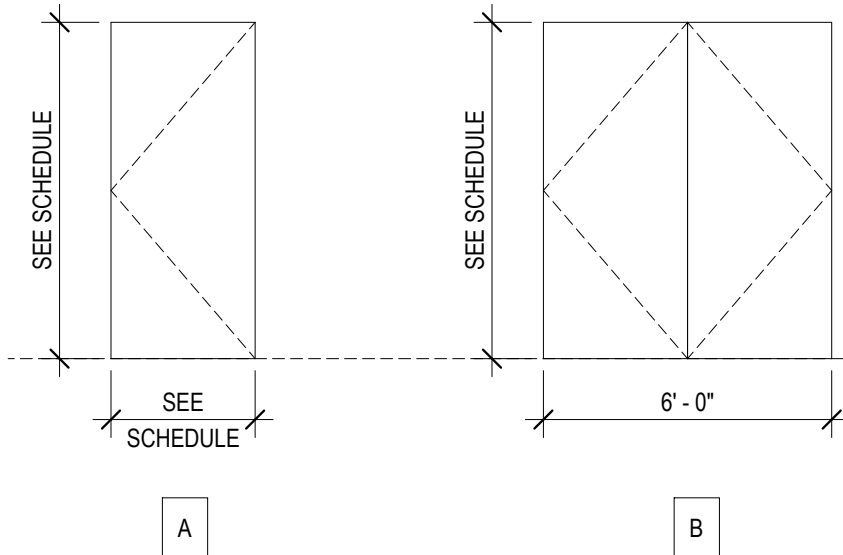


FRAME ELEVATIONS

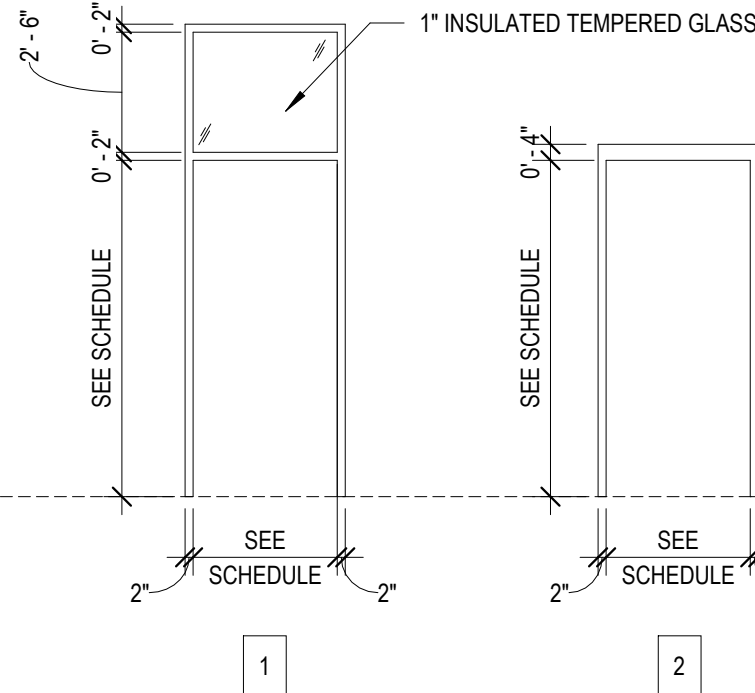


- GLAZING NOTES:
- ALL EXTERIOR GLAZING TO BE 1" INSULATED GLASS W/ LOW-E AND ARGON FILL
 - ALL HOLLOW METAL FRAMES TO BE FIELD PAINTED
 - ALL GLASS TO BE FULLY TEMPERED.

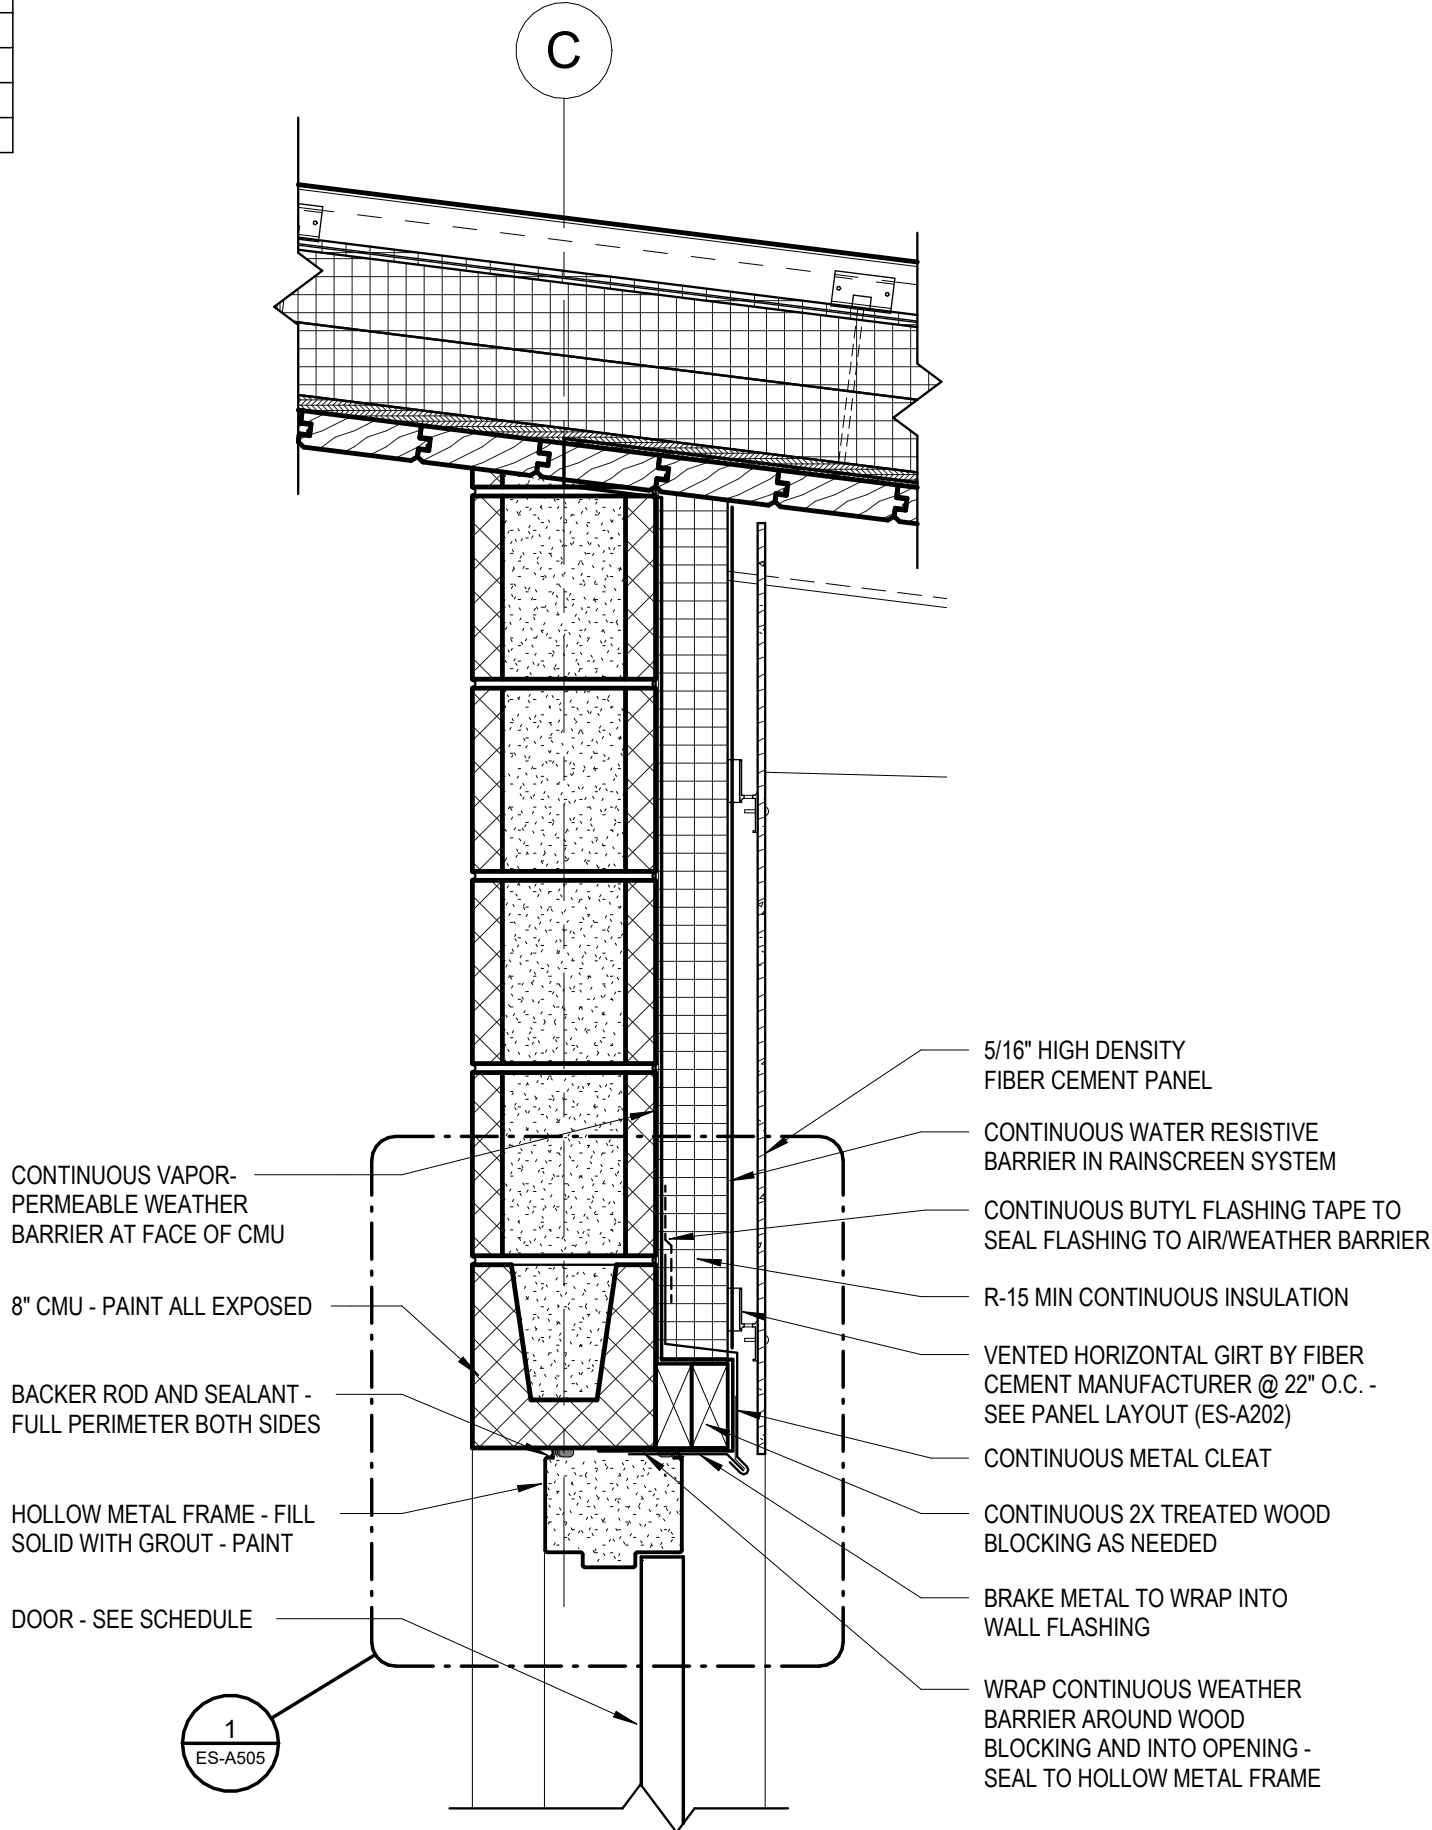


1 HEAD DETAIL @ CUSTODIAL DOOR
1 1/2" = 1'-0"

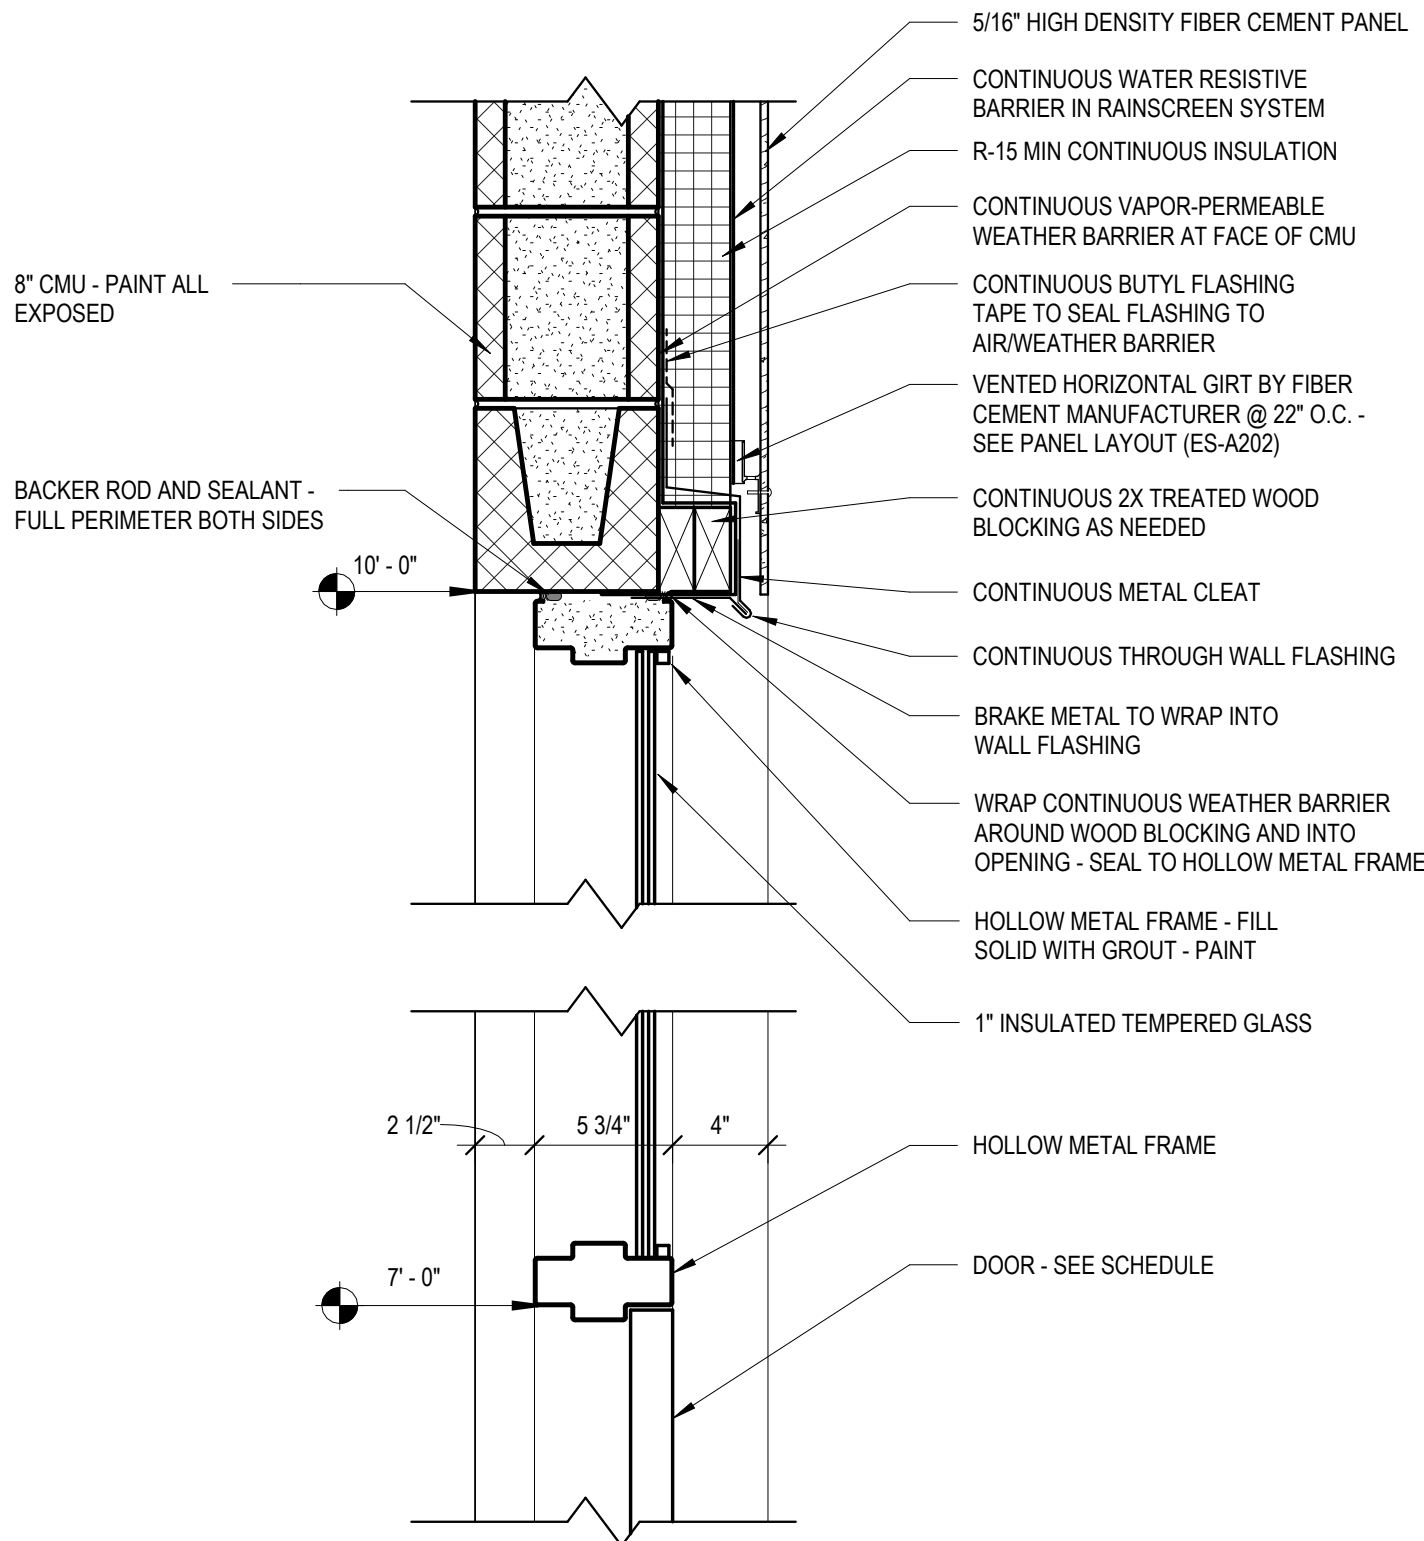


2 HEAD DETAIL @ TYP. RESTROOM DOOR
1 1/2" = 1'-0"

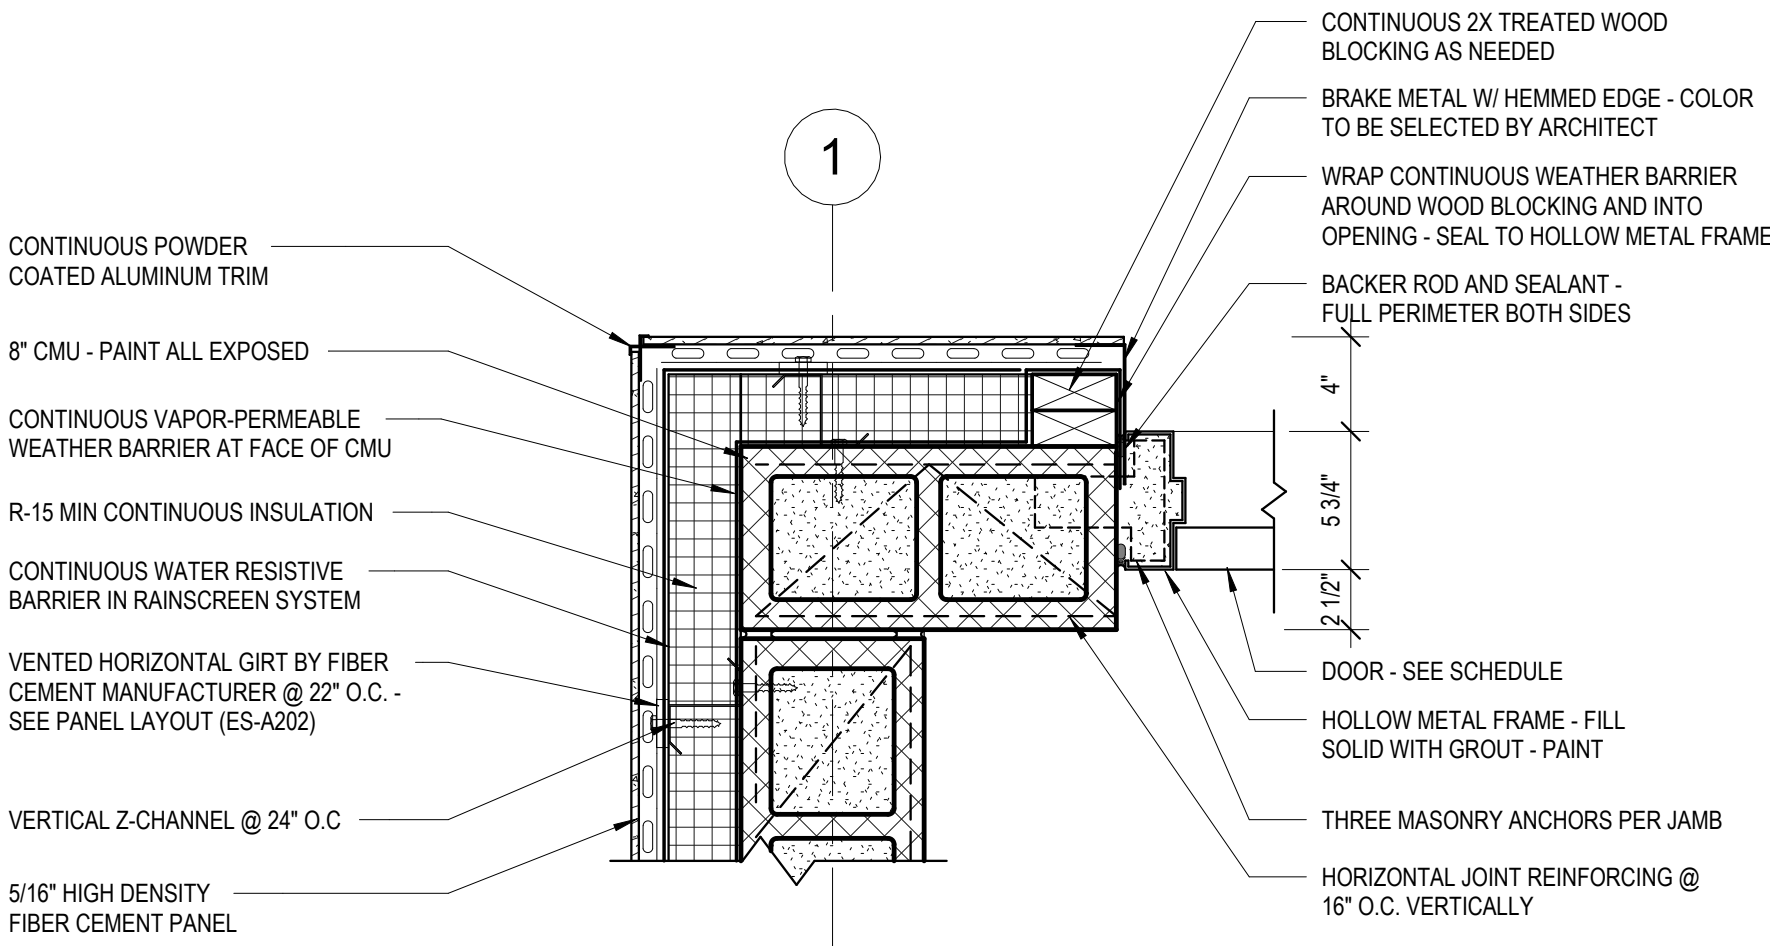

3 JAMB DETAIL @ OUTSIDE CORNER
1 1/2" = 1'-0"

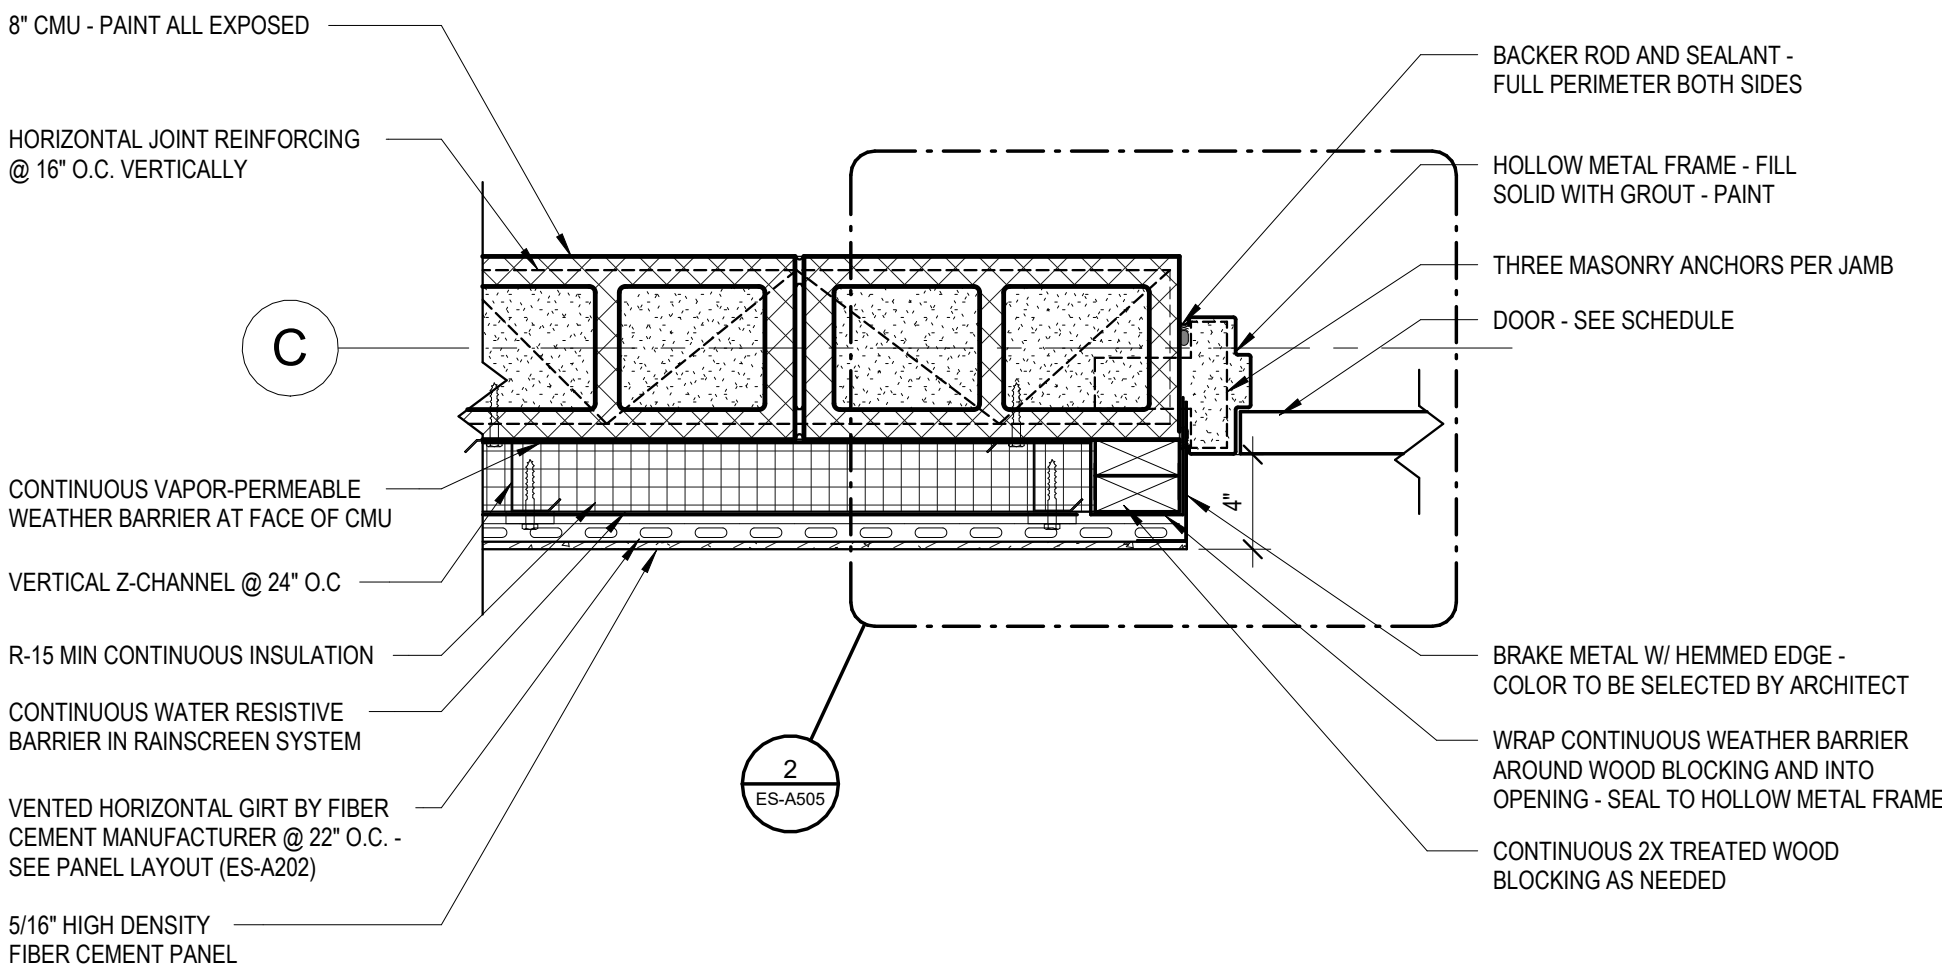

4 JAMB DETAIL @ TYP. SHELTER DOORS
1 1/2" = 1'-0"

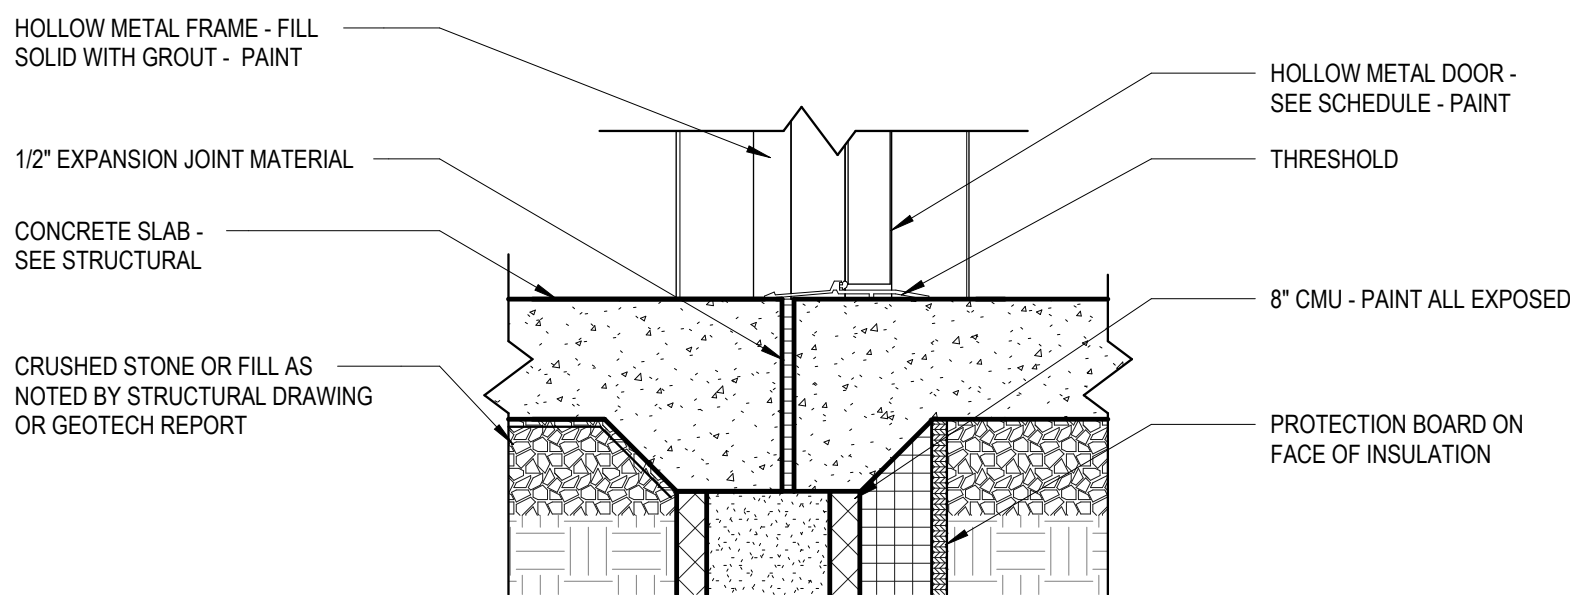

5 TYPICAL THRESHOLD DETAIL
1 1/2" = 1'-0"

Susan Hatchell
Landscape Architecture, PLLC
711 W. North Street, Raleigh, NC 27603
p: 919-838-9600 f: 919-838-9700

Esse Architects
632 FISHING ROAD | RALEIGH, NORTH CAROLINA 27608


DOOR SCHEDULE

LAKE MYRA COUNTY PARK
Wake County, NC

REVISIONS

Date: 07/27/26

ES-A601

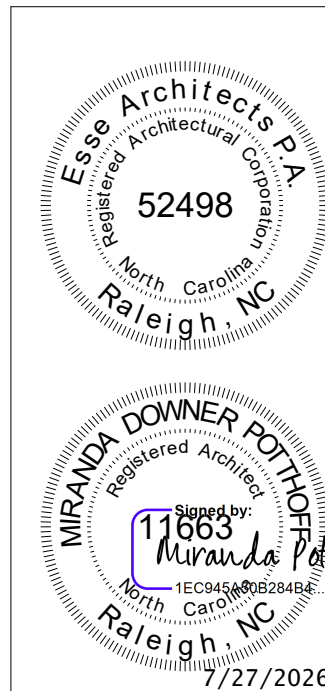

GENERAL NOTES:

1.

THE STRUCTURAL DRAWINGS MUST BE USED IN CONJUNCTION WITH THE ARCHITECTURAL, CIVIL, MECHANICAL, PLUMBING, AND ELECTRICAL DRAWINGS, AND THE SPECIFICATIONS. THE CONTRACTOR MUST VERIFY THE REQUIREMENTS OF OTHER TRADES AS TO SLEEVES, CHASES, HANGERS, INSERTS, ANCHORS, HOLES, AND ADDITIONAL ITEMS TO BE PLACED OR SET IN THE STRUCTURAL WORK.
2.

THIS STRUCTURE HAS BEEN DESIGNED IN ACCORDANCE WITH THE PROVISIONS OF THE NORTH CAROLINA STATE BUILDING CODE, 2018 EDITION.
3.

THE CONTRACTOR MUST PROVIDE TEMPORARY SHORING AND BRACING REQUIRED TO ERECT AND HOLD THE STRUCTURE IN PROPER ALIGNMENT UNTIL PERMANENT SUPPORTS AND LATERAL BRACING ARE IN PLACE.
4.

DISCREPANCIES WITHIN DRAWINGS, BETWEEN THE SPECIFICATIONS AND THE DRAWINGS, OR WITHIN THE SPECIFICATIONS, MUST BE BROUGHT TO THE ATTENTION OF THE ARCHITECT AND ENGINEER DURING THE BIDDING PROCESS IN TIME TO PERMIT CLARIFICATION BY ADDENDUM. IF INCONSISTENCIES, DISCREPANCIES OR CONTRADICTIONS IN THE CONTRACT DOCUMENTS ARE DISCOVERED AFTER THE CLOSE OF BIDDING QUESTIONS, THE CONTRACTOR MUST BE DEEMED BY SUBMITTAL OF THEIR BID, TO HAVE BID THE MOST COSTLY AS TO LABOR, MATERIALS, DURATION, SEQUENCE AND METHOD OF CONSTRUCTION TO PROVIDE THE WORK.
5.

THESE STRUCTURAL DRAWINGS ARE ISSUED ON THE DATE INDICATED FOR THE PURPOSE DESIGNATED. THESE DRAWINGS MUST NOT BE ISSUED OR RELEASED FOR ANY OTHER PURPOSE WITHOUT THE WRITTEN AUTHORIZATION OF THE STRUCTURAL ENGINEER OF RECORD.
6.

DETAILS LABELED "TYPICAL DETAIL" WITHIN THE DOCUMENTS APPLY TO SITUATIONS ON THE PROJECT THAT MAY OCCUR THROUGHOUT THE PROJECT. SUCH DETAILS APPLY WHETHER OR NOT THE DETAIL IS SPECIFICALLY REFERENCED AT EACH INSTANCE. NOTIFY ENGINEER IF CLARIFICATIONS ARE REQUIRED REGARDING THE APPLICABILITY OF THE "TYPICAL DETAIL."
7.

DESIGN CRITERIA:

CLASSIFICATION OF BUILDING
RISK CATEGORY..... II

SUPERIMPOSED ROOF DEAD LOADS - UNIFORM:
INSULATION AND ROOF MEMBRANE..... 3 PSF
CEILING..... 2 PSF
DUCTS, LIGHTS, MISC. MECHANICAL..... 3 PSF
SOLAR PANEL ALLOWANCE..... 10 PSF

SUPERIMPOSED FLOOR DEAD LOADS - UNIFORM:
FLOOR FINISH..... 3 PSF
CEILING..... 2 PSF
DUCTS, LIGHTS, MISC. MECHANICAL..... 3 PSF

LIVE LOADS - UNIFORM:
SLAB ON GRADE..... 100 PSF
FLOOR..... 80 PSF
ROOF..... 20 PSF
CLASSROOMS..... 40 PSF
OFFICES..... 50 PSF
PARTITION ALLOWANCE..... 15 PSF
BALCONIES AND DECKS..... 100 PSF

STORAGE..... 125 PSF
MECHANICAL SPACE..... 150 PSF
STAIRWAYS..... 100 PSF

LIVE LOAD REDUCTION OF THE UNIFORMLY DISTRIBUTED FLOOR
LIVE LOADS HAS BEEN UTILIZED WHERE PERMITTED BY CODE.

LIVE LOADS - CONCENTRATED:
ROOFS..... 300#

UNLESS OTHERWISE NOTED, CONCENTRATED LOADS ARE APPLIED
UNIFORMLY OVER 2'-6" x 2'-6" AREA.

RAIN LOADS:
RAIN INTENSITY (15 MINUTE)..... 6.21 IN/HR

SNOW LOADS:
GROUND SNOW LOAD (Pg)..... 15 PSF
SLOPED ROOF LOAD (Pf)..... 11 PSF
IMPORTANCE FACTOR (Is)..... 1.0
THERMAL FACTOR (Ct)..... 1.0
EXPOSURE FACTOR (Ce)..... 1.0
DRIFT SURCHARGE (Pd)..... REF PLAN

GENERAL NOTES (CONT):

WIND LOADS:
BASIC WIND SPEED (Vult)..... 116 MPH
ALLOWABLE STRESS DESIGN WIND SPEED (Vasd)..... 90 MPH
EXPOSURE CATEGORY..... B
INTERNAL PRESSURE COEFFICIENT..... ±0.18
COMPONENT AND CLADDING PRESSURES:
WALLS, ZONE 5 (10 SF)..... 29 PSF
ROOF, ZONE 3 (10 SF)..... 56 PSF
ULTIMATE WIND BASE SHEARS (FOR MWFRS):
Vx..... 11 KIPS
Vy..... 16 KIPS

SEISMIC LOADS:
SITE CLASSIFICATION..... D
SEISMIC DESIGN CATEGORY..... B
IMPORTANCE FACTOR (IE)..... 1.0
SPECTRAL RESPONSE ACCELERATIONS:
Ss..... 0.149 S1..... 0.057
SMS..... 0.146 SM1..... 0.085
SDS..... 0.097 SD1..... 0.057
ANALYSIS PROCEDURE..... EQUIVALENT LATERAL FORCE

LATERAL FORCE RESISTING SYSTEM

STEEL SYSTEMS NOT SPECIFICALLY DETAILED..... R=3
FOR SEISMIC REISTANCE
RESPONSE MODIFICATION COEFFICIENT (R)..... 3.0
SEISMIC RESPONSE COEFFICIENT (Cs)..... 0.05
ULTIMATE SEISMIC BASE SHEAR (V)..... 4 KIPS

LATERAL DESIGN CONTROL
CONTROLLING LATERAL LOADS..... WIND

SHOP DRAWINGS AND SUBMITTALS:

1.

SHOP DRAWINGS AND SUBMITTALS MUST BEAR THE CONTRACTOR'S REVIEW STAMP WITH CHECKER'S INITIALS BEFORE BEING SUBMITTED TO THE ARCHITECT FOR APPROVAL.
2.

WHEN THE CONTRACTOR HAS BEEN AUTHORIZED TO USE THE ARCHITECT'S AND / OR ENGINEER'S DRAWINGS AS SHOP DRAWINGS, THE CONTRACTOR MUST REMOVE ALL TITLE BLOCKS, PROFESSIONAL SEALS, AND ANY OTHER REFERENCE TO THE ARCHITECT AND / OR ENGINEER FROM THAT SHOP DRAWING.

SITE PREPARATION, CONTROLLED FILL AND SURCHARGE NOTES:

1.

OBTAIN AND BECOME THOROUGHLY FAMILIAR WITH THE CONDITIONS AND RECOMMENDATIONS DESCRIBED IN THE SUBSURFACE EXPLORATION AND GEOTECHNICAL ENGINEERING REPORT. THIS REPORT IS NOT A PART OF THE CONTRACT DOCUMENTS, AND MAY NOT BE REPRESENTATIVE OF ALL SITE CONDITIONS WHICH MAY BE ENCOUNTERED.
2.

SITE PREPARATION AND CONTROLLED FILL MUST INCLUDE THE AREA ENCLOSED BY A LINE DRAWN 5 FEET OUTSIDE THE BUILDING FOOTPRINT.
3.

REMOVE ALL VEGETATION, ROOT MAT, TOPSOIL, ASPHALT PAVING AND AGGREGATE BASE MATERIAL. BASE BID ON 10 INCHES AVERAGE DEPTH.
4.

THE EXPOSED SUBGRADE MUST BE PROOFROLLED WITH A LARGE RUBBER-TIRED ROLLER OR LOADED DUMP TRUCK; PERFORM AT LEAST TWO PASSES IN EACH OF TWO PERPENDICULAR DIRECTIONS.
5.

EXCAVATE SOFT SPOTS REVEALED BY PROOFROLLING AS DIRECTED.
6.

PRIOR TO PLACEMENT OF ANY FILL MATERIAL, SETTLEMENT PLATES MUST BE INSTALLED ON THE PREPARED SUBGRADE. SEE PLAN FOR LOCATIONS AND DETAILS.
7.

FILL WITH SATISFACTORY STRUCTURAL FILL MATERIALS TO THE SPECIFIED ELEVATIONS.
8.

FILL MUST BE PLACED IN LOOSE LIFTS NOT EXCEEDING 8 INCHES, WHEN MECHANICAL COMPACTION EQUIPMENT IS USED OR 4 INCHES WHEN HAND COMPACTION EQUIPMENT IS USED AND MUST BE COMPACTED TO AT LEAST 95 PERCENT OF THE STANDARD PROCTOR MAXIMUM DRY DENSITY (ASTM D698).
9.

PLACE SURCHARGE FILL IN ONE FOOT LOOSE LIFTS, UP TO THE SPECIFIED ELEVATION. THE DEPTH OF SURCHARGE IS BASED ON A SOIL UNIT WEIGHT OF 120 POUNDS PER CUBIC FOOT. FOR LESS DENSE MATERIALS, PROVIDE ADDITIONAL SURCHARGE OR PROVIDE COMPACTION AS REQUIRED TO YIELD THE EQUIVALENT TOTAL WEIGHT OF SURCHARGE.
10.

THE CONTRACTOR MUST SECURE AND PAY FOR THE SERVICES OF A LICENSED LAND SURVEYOR TO MONITOR THE SETTLEMENT PLATES. ELEVATION READINGS MUST BE TAKEN ON THE SURFACE OF THE PLATE AND THE TOP OF THE BAR AT THE TIME OF INSTALLATION. SUBSEQUENT READINGS MUST BE OBTAINED ON TOP OF THE BAR A MINIMUM OF THREE TIMES PER WEEK DURING THE PLACEMENT OF ANY FILL, TWO TIMES PER WEEK FOR A PERIOD OF TWO WEEKS AFTER COMPLETION OF FILL, AND ONE TIME PER WEEK THEREAFTER.
11.

DURATION OF THE READINGS MUST BE ASSUMED TO BE 90 DAYS AFTER COMPLETION OF THE FILL. SUBMIT ELEVATION READINGS TO THE [ARCHITECT] [ENGINEER] [CONTRACTING OFFICER] ON A WEEKLY BASIS.

FOUNDATION NOTES:

1.

FOUNDATIONS HAVE BEEN DESIGNED IN ACCORDANCE WITH THE RECOMMENDATIONS IN THE [SUBSURFACE EXPLORATION AND GEOTECHNICAL ENGINEERING REPORT PREPARED BY ESP ASSOCIATES, INC., DATED AUGUST 29, 2025].
2.

FOUNDATIONS HAVE BEEN DESIGNED FOR A NET ALLOWABLE SOIL BEARING PRESSURE OF 2,000 PSF.
3.

TOP OF FOOTING ELEVATIONS MUST BE A MINIMUM DEPTH OF 1'-0" BELOW LOWEST ADJACENT SOIL GRADE.
4.

PRIOR TO PLACING FOUNDATION CONCRETE, ALL FOUNDATION EXCAVATIONS MUST BE INSPECTED BY THE OWNER'S GEOTECHNICAL TESTING AGENCY [SPECIAL INSPECTOR] TO EXPLORE THE EXTENT OF LOOSE, SOFT, EXPANSIVE, OR OTHERWISE UNSATISFACTORY SOIL MATERIAL AND TO VERIFY DESIGN BEARING PRESSURE. DIRECTION FOR CORRECTIVE ACTION WILL BE PROVIDED BY THE OWNER'S GEOTECHNICAL TESTING AGENCY [SPECIAL INSPECTOR] WHERE UNSATISFACTORY SOILS ARE PRESENT.
5.

NO UNBALANCED BACKFILLING MUST BE DONE AGAINST MASONRY OR CONCRETE WALLS UNLESS WALLS ARE SECURELY BRACED AGAINST OVERTURNING, EITHER BY TEMPORARY CONSTRUCTION BRACING OR BY PERMANENT CONSTRUCTION.
6.

CONTROL GROUNDWATER AND SURFACE RUNOFF THROUGHOUT THE CONSTRUCTION PROCESS. INUNDATION AND LONG TERM EXPOSURE OF BEARING SURFACES WHICH RESULT IN DETERIORATION OF BEARING MUST BE PREVENTED.

CAST-IN-PLACE CONCRETE NOTES:

1.

CONCRETE MUST BE IN ACCORDANCE WITH AMERICAN CONCRETE INSTITUTE (ACI) 301 AND 318.
2.

CONCRETE MUST BE NORMAL WEIGHT UNLESS OTHERWISE DENOTED AS LW (LIGHTWEIGHT) AND MUST OBTAIN 28 DAY COMPRESSIVE STRENGTHS AS FOLLOWS:
A. SLAB-ON-GRADE..... 3,500 PSI
B. COLUMNS AND WALLS..... 4,000 PSI
C. CONCRETE NOT OTHERWISE NOTED..... 3,000 PSI
3.

REINFORCING MATERIALS MUST BE AS FOLLOWS:
A. REINFORCING BARS - ASTM A615, GRADE 60, DEFORMED.
B. WELDED REINFORCING BARS - ASTM A706, GRADE 60.
C. WELDED WIRE REINFORCEMENT - ASTM A1064, WELDED STEEL WIRE REINFORCEMENT; PROVIDE SHEET TYPE, ROLL TYPE IS NOT ACCEPTABLE.
4.

ALL REINFORCING STEEL AND EMBEDDED ITEMS SUCH AS ANCHOR RODS AND WELD PLATES MUST BE ACCURATELY PLACED AND ADEQUATELY TIED AND SUPPORTED BEFORE CONCRETE IS PLACED TO PREVENT DISPLACEMENT BEYOND PERMITTED TOLERANCES.
5.

CONCRETE COVER TO REINFORCING STEEL MUST EQUAL THE FOLLOWING, UNLESS OTHERWISE NOTED:
A. SURFACES AGAINST EARTH..... 3"
B. SURFACES NOT CAST AGAINST EARTH, BUT EXPOSED TO EARTH OR WEATHER IN THE FINAL CONDITION
#5 AND SMALLER..... 1 1/2"
#6 AND LARGER..... 2"
C. BEAMS, GIRDERS, COLUMNS, AND WALLS ABOVE FINISHED FIRST FLOOR..... 1 1/2"
D. ELEVATED SLABS..... 3/4"
6.

LAP CONTINUOUS REINFORCING STEEL 57 X BAR DIAMETER, TYPICAL UNLESS OTHERWISE NOTED.
7.

LAP CONTINUOUS REINFORCING STEEL PER SCHEDULES AND TYPICAL DETAILS.
8.

DO NOT EMBED CONDUIT AND PIPING IN OR PENETRATE THROUGH CAST-IN-PLACE CONCRETE ELEMENTS UNLESS OTHER NOTED.

CONCRETE MIX DESIGN NOTES:


1.

MIX DESIGNS COMPRESSIVE STRENGTHS (fc) BASED ON 28 DAY DESIGN STRENGTH, UNLESS OTHERWISE NOTED.
2.

CONCRETE NOT OTHERWISE NOTED:
A. MINIMUM COMPRESSIVE STRENGTH (fc) = 4000 PSI
3.

FOUNDATIONS (SPREAD FOOTINGS, MAT FOOTINGS):
A. EXPOSURE CLASS = ACI 318 F0, S0, W0, C1
B. MINIMUM COMPRESSIVE STRENGTH (fc) = 3,000PSI
C. MAXIMUM W/CM = 0.5
D. BLENDED HYDRAULIC CEMENT = ASTM C595 TYPE 1L
E. SLUMP = 5" MAX PLUS OR MINUS 1", OR 8" MAX, PLUS OR MINUS 1" FOR CONCRETE WITH A VERIFIED SLUMP OF 3" PLUS OR MINUS 1" BEFORE ADDING HIGH-RANGE WATER-REDUCING OR PLASTICIZING ADMIXTURE
F. AIR CONTENT = NO REQUIREMENTS
G. AGGREGATE = NORMAL WEIGHT, ¾" NOMINAL
H. LIMIT WATER-SOLUBLE, CHLORIDE-ION CONTENT IN HARDENED CONCRETE TO 0.1 PERCENT BY WEIGHT OF CEMENT
4.

INTERIOR FLOOR SLAB-ON-GRADE:
A. EXPOSURE CLASS = ACI 318 F0, S0, W0, C0
B. MINIMUM COMPRESSIVE STRENGTH (fc) = 3,500PSI
C. MAXIMUM W/CM = 0.5
D. BLENDED HYDRAULIC CEMENT = ASTM C595 TYPE 1L
E. SLUMP = 5" MAX PLUS OR MINUS 1", OR 8" MAX, PLUS OR MINUS 1" FOR CONCRETE WITH A VERIFIED SLUMP OF 3" PLUS OR MINUS 1" BEFORE ADDING HIGH-RANGE WATER-REDUCING OR PLASTICIZING ADMIXTURE
F. AIR CONTENT = DO NOT ALLOW AIR CONTENT IN TROWEL FINISHED FLOORS TO EXCEED 3%
G. AGGREGATE = NORMAL WEIGHT, ¾" NOMINAL
H. LIMIT WATER-SOLUBLE, CHLORIDE-ION CONTENT IN HARDENED CONCRETE TO 0.3 PERCENT BY WEIGHT OF CEMENT

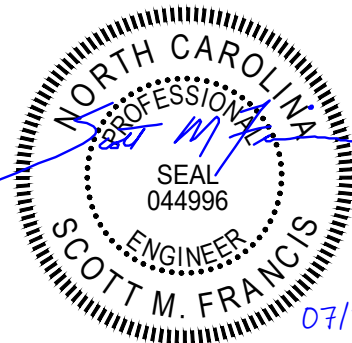

IMEG RESERVES PROPRIETARY RIGHTS, INCLUDING COPYRIGHTS, TO THIS DRAWING AND THE DATA SHOWN THEREON. SAID DRAWING AND/OR DATA ARE THE EXCLUSIVE PROPERTY OF IMEG AND SHALL NOT BE USED OR REPRODUCED FOR ANY OTHER PROJECT WITHOUT THE EXPRESS WRITTEN APPROVAL AND PARTICIPATION OF IMEG. ©2025 IMEG CONSULTANTS CORP. North Carolina Design Registration #F-1507

Susan Hatchell
Landscape Architecture, PLLC
711 W. North Street, Raleigh, NC 27603
p. 919-838-9600 f. 919-838-9700



GENERAL NOTES

LAKE MYRA COUNTY PARK
Wake County, NC

REVISIONS

Date07/27/2026

ES-S001

CONCRETE MASONRY NOTES:

1.

CONCRETE MASONRY MATERIALS AND CONSTRUCTION MUST CONFORM TO THE AMERICAN CONCRETE INSTITUTE (ACI) "BUILDING CODE REQUIREMENTS FOR MASONRY STRUCTURES" (TMS 402 / ACI 530 / ASCE 5) AND "SPECIFICATIONS FOR MASONRY STRUCTURES" (TMS 602 / ACI 530.1 / ASCE 6).
2.

CONCRETE MASONRY UNITS MUST CONFORM TO ASTM C90 AND MUST BE MADE WITH NORMAL WEIGHT AGGREGATE.
3.

COMPRESSIVE STRENGTH OF MASONRY MUST BE DETERMINED BY THE UNIT STRENGTH METHOD AS SET FORTH IN ACI 530.1. THE NET AREA COMPRESSIVE STRENGTH OF MASONRY, f_m, MUST BE 2,000 PSI AT 28 DAYS.
4.

MORTAR MUST BE TYPE 'M' OR 'S' AND MUST COMPLY WITH ASTM C270, PROPORTIONS OR PROPERTIES SPECIFICATION.
5.

GROUT MUST COMPLY WITH EITHER THE PROPORTIONS OR PROPERTIES SPECIFICATION OF ASTM C476 AND AS FOLLOWS:

A.

PROPORTIONS SPECIFICATION: THIS MIX CANNOT CONTAIN ADMIXTURES. WATER MUST BE ADDED IN THE FIELD IN ORDER TO ACHIEVE A SLUMP OF 8-11 INCHES WHEN PLACED IN THE CONCRETE MASONRY UNITS. MORTAR, PEA-GRAVEL CONCRETE, OR "CHAT" MIXES ARE NOT ACCEPTABLE SUBSTITUTES FOR THE SPECIFIED GROUT.

B.

PROPERTIES SPECIFICATION: THIS MIX MUST BE PROPORTIONED TO OBTAIN A DOCUMENTED 28 DAY COMPRESSIVE STRENGTH OF 2,500 PSI, WITH 3/8" MAX AGGREGATE AND AN 8-11 INCH SLUMP WHEN PLACED IN THE CONCRETE MASONRY UNITS.
6.

REINFORCING STEEL MUST COMPLY WITH ASTM A615, GRADE 60. SHOP FABRICATE REINFORCING BARS WHICH ARE SHOWN TO BE BENT OR HOOKED.
7.

ALL BOND BEAMS, REINFORCED CELLS AND CELLS WITH EXPANSION BOLTS, EMBED PLATES OR OTHER ANCHORS AND ALL CELLS BELOW GRADE MUST BE GROUTED SOLID. GROUT PROCEDURE MUST COMPLY WITH ACI 530.1.
8.

ALL CMU WALLS MUST BE REINFORCED CONTINUOUSLY FROM FOUNDATION TO TOP OF WALL. WHERE REINFORCING IS INTERRUPTED, OFFSET AND LAP ADDITIONAL BARS PER THE "TYPICAL OFFSET SPLICE AT MASONRY WALL DETAILS."
9.

LAP ALL REINFORCING PER SCHEDULE BELOW, TYPICAL UNLESS OTHERWISE NOTED:

MASONRY LAP SCHEDULE		
REINF SIZE	52 x BAR DIAMETER	72 x BAR DIAMETER
#4	26"	36"
#5	33"	45"
#6	39"	54"
#7	46"	63"
#8	52"	72"

10.

PROVIDE MECHANICAL SPLICES FOR ALL #9 BARS AND LARGER AND FOR ALL BARS AT CONTRACTOR'S OPTION.
11.

PROVIDE REINFORCING STEEL DOWELS OF THE SAME SIZE AND SPACING AS VERTICAL REINFORCING FROM THE SUPPORTING STRUCTURE. DOWELS MUST HAVE STANDARD ACI HOOKS.
12.

PROVIDE STANDARD 9 GAGE TRUSS TYPE HORIZONTAL JOINT REINFORCING IN CMU WALLS AT 16 INCHES ON-CENTER VERTICALLY AND AT 8 INCHES ON-CENTER VERTICALLY AT PARAPETS. ADDITIONALLY PROVIDE IN THE TWO JOINTS IMMEDIATELY ABOVE AND BELOW ALL OPENINGS, EXTENDING A MINIMUM OF 2 FEET BEYOND THE JAMB ON EACH SIDE OF THE OPENING, EXCEPT AT CONTROL JOINTS.
13.

PROVIDE VERTICAL CONTROL JOINTS AT 25 FEET ON-CENTER MAXIMUM, OR NOT MORE THAN 1.5 TIMES THE HEIGHT OF THE WALL AT CONTROL JOINTS. PROVIDE CONTINUOUS HORIZONTAL BOND BEAM REINFORCEMENT AS SHOWN IN THE SECTIONS AND DETAILS CONTINUOUS THROUGH CONTROL JOINTS. DO NOT PLACE GROUT CONTINUOUSLY AT CONTROL JOINTS.
14.

DO NOT LOCATE CONTROL JOINTS WITHIN TWO FEET OF STEEL BEAM BEARING LOCATIONS.
15.

PLACE GROUT WITH POUR HEIGHT NOT EXCEEDING 5 FEET. CONSOLIDATE EACH POUR BY MECHANICAL VIBRATION. RECONSOLIDATE AFTER INITIAL WATER LOSS AND SETTLEMENT OCCUR.

CONCRETE MASONRY NOTES (CONT):

19.

GROUT POUR HEIGHT MAY BE INCREASED WHERE THE FOLLOWING CONDITIONS ARE MET:

A.

LIMIT POUR HEIGHT BASED ON A MINIMUM WIDTH OF GROUT SPACE IN ACCORDANCE WITH TABLE 7 OF ACI 530.1 / ASCE 6 / TMS 602.

B.

PLACE GROUT IN LIFTS NOT EXCEEDING THE LIMITATIONS SPECIFIED IN ACE 530.1/ASCE 6/TMS 602.

C.

CONSOLIDATE EACH POUR BY MECHANICAL VIBRATION. RECONSOLIDATE AFTER INITIAL WATER LOSS AND SETTLEMENT HAS OCCURRED.

D.

FORM A GROUT KEY BETWEEN POURS ACCORDING TO ACI 530.1 / ASCE 6 / TMS 602.

E.

PROVIDE AN INSPECTION PORT (CLEANOUT) AT EACH CELL TO BE GROUTED AT THE BASE OF EACH POUR.

F.

SUBMIT SHOP DRAWINGS DETAILING THE PROPOSED GROUTING PROCEDURE ALONG WITH (3) REFERENCES OF PREVIOUS SUCCESSFUL PROJECTS.
20.

MASONRY SHALL BE CONSTRUCTED IN RUNNING BOND PATTERN AND ALL CORNERS TO BE TIED BY MASONRY BOND.
21.

SUBMITTALS FOR CONCRETE MASONRY MUST INCLUDE THE FOLLOWING:

A.

PRODUCT DATA/MATERIAL CERTIFICATES: SUBMIT DATA AND CERTIFICATES FOR MASONRY UNITS, CEMENTITIOUS MATERIALS, MORTAR ADMIXTURES, PRE-BLENDED DRY MORTAR MIXES, REINFORCING BARS, JOINT REINFORCEMENT, ANCHORS, TIES, AND METAL ACCESSORIES.

B.

REINFORCEMENT SHOP DRAWINGS: SHOW ELEVATIONS OF REINFORCED WALLS. MUST COMPLY WITH ACI DETAILING MANUAL: DETAIL BENDING, LAP LENGTHS, AND PLACEMENT OF UNIT MASONRY REINFORCING BARS.

C.

MIX DESIGNS: SUBMIT MIX DESIGNS FOR EACH TYPE OF MORTAR AND GROUT AND INCLUDE DESCRIPTION OF TYPE AND PROPORTIONS OF INGREDIENTS. INCLUDE TEST REPORTS FOR GROUT MIXES ACCORDING TO ASTM C1019

D.

SHOP DRAWINGS MUST INDICATE THE DATE OF THE STRUCTURAL DRAWINGS THAT WERE USED IN PREPARATION.

STRUCTURAL STEEL NOTES:

1.

STRUCTURAL STEEL MUST BE IN ACCORDANCE WITH THE AMERICAN INSTITUTE OF STEEL CONSTRUCTION (AISC) 360.
2.

STRUCTURAL STEEL FABRICATOR MUST PARTICIPATE IN THE AISC QUALITY CERTIFICATION PROGRAM AND BE A DESIGNATED AISC-CERTIFIED PLANT.
3.

STRUCTURAL STEEL INSTALLER MUST PARTICIPATE IN THE AISC QUALITY CERTIFICATION PROGRAM AND BE A DESIGNATED AISC-CERTIFIED ERECTOR.
4.

STRUCTURAL STEEL MUST COMPLY WITH THE FOLLOWING SPECIFICATIONS:

A.

STRUCTURAL STEEL SHAPES, PLATES AND BARS UNLESS OTHERWISE NOTED - ASTM A572, Fy = 50 KSI

B.

STRUCTURAL STEEL W-SHAPES - ASTM A992, Fy = 50 KSI

C.

HOLLOW STRUCTURAL SECTIONS (HSS):

a.

SQUARE & RECTANGULAR - ASTM A500, GRADE C, Fy = 50 KSI

b.

ROUND - ASTM A500, GRADE C, Fy = 46 KSI

D.

ANCHOR RODS - ASTM F1554, GRADE [36] [55]

E.

HIGH STRENGTH BOLTS - ASTM F3125, TYPE A325 (TYPICAL UON)

F.

FULLY PRETENSIONED BOLTS - ASTM F1852 (TWIST-OFF TYPE)

G.

WASHERS - ASTM F436

H.

NUTS - ASTM A563

I.

HEADED STUDS - ASTM A29, GRADE 1010 THROUGH 1020
5.

UNLESS OTHERWISE NOTED, ALL REQUIRED DESIGN STRENGTHS AND REACTIONS INDICATED ARE BASED ON THE "LOADING COMBINATIONS USING STRENGTH DESIGN OR LOAD AND RESISTANCE FACTOR DESIGN" PER SECTION 1605.2 OF THE BUILDING CODE.
6.

STRUCTURAL STEEL FRAME IS CONSIDERED AS UNRESTRAINED FOR FIRE PROTECTION PURPOSES.
7.

ALL STEEL CONNECTIONS AND MEMBER REINFORCEMENT MUST BE DESIGNED BY FABRICATOR'S QUALIFIED PROFESSIONAL ENGINEER FOR LOADS INDICATED ON THE DRAWINGS, PER OPTION 3B OF ANSI/AISC 303 AND COMPLETE THE FOLLOWING:

A.

SUBMIT STRUCTURAL CALCULATIONS SIGNED AND SEALED BY THE QUALIFIED PROFESSIONAL ENGINEER REGISTERED IN THE NORTH CAROLINA RESPONSIBLE FOR THEIR PREPARATION.

B.

THE PROFESSIONAL ENGINEER RESPONSIBLE FOR CONNECTION DESIGN MUST REVIEW THE SHOP DRAWINGS PRIOR TO SUBMITTAL TO VERIFY THAT THE CONNECTIONS AS DETAILED ON THE SHOP DRAWINGS COMPLY WITH THE CONNECTION DESIGN REQUIREMENTS OF THE FINAL CALCULATIONS.

C.

A REVIEW LETTER, SIGNED AND SEALED BY THE PROFESSIONAL ENGINEER RESPONSIBLE FOR CONNECTION DESIGN MUST BE PROVIDED WITH THE SHOP DRAWINGS AND CALCULATION SUBMITTAL STATING THAT THIS REVIEW AND VERIFICATION HAS BEEN COMPLETED.
8.

HIGH STRENGTH BOLTS MAY BE TIGHTENED TO THE "SNUG TIGHT" CONDITION, UNLESS OTHERWISE NOTED.
9.

BOLTED CONNECTIONS MAY USE NON-STANDARD HOLES, EXCEPT IN THE FOLLOWING LOCATIONS:

A.

AXIAL CONNECTIONS IDENTIFIED ON PLAN.

B.

ALL FRAMING CONNECTIONS AT BRACED FRAMES AND MOMENT FRAMES.

C.

CONNECTIONS IDENTIFIED ON PLAN WITH FULL DEPTH STIFFENER PLATES.

STRUCTURAL STEEL NOTES (CONT):

10.

PROVIDE ANGLE FRAMING AROUND OPENINGS LARGER THAN 6 INCHES IN ANY DIMENSION (INCLUDING ROOF DRAINS) TO SUPPORT STEEL DECK. REFERENCE PLANS AND TYPICAL DETAILS FOR SIZING REQUIREMENTS.
11.

WELDING MUST BE IN ACCORDANCE WITH AWS D1.1, "STRUCTURAL WELDING CODE - STEEL." WELD ELECTRODES MUST BE E70XX LOW HYDROGEN. UNLESS OTHERWISE NOTED, PROVIDE CONTINUOUS FILLET WELDS WITH MINIMUM SIZE REQUIRED BY TABLE J2.4 AISC 360.
12.

INSTALLATION OF HEADED COMPOSITE STUDS MUST CONFORM TO THE REQUIREMENTS OF AWS D1.1, SECTIONS 9.4 AND 9.5. HEADED COMPOSITE STUDS MUST BE TESTED IN ACCORDANCE WITH AWS D1.1, SECTIONS 9.6, 9.7, AND 9.8 BY A QUALIFIED TESTING AGENCY.
13.

COORDINATE ALL MEMBER LOCATIONS, UNIT WEIGHTS, OPENING SIZES, AND CURB DIMENSIONS FOR MECHANICAL EQUIPMENT WITH THE ACTUAL EQUIPMENT FURNISHED.
14.

SHOP PRIME STEEL SURFACES, EXCEPT THE FOLLOWING:

A.

SURFACES EMBEDDED IN CONCRETE OR MORTAR. EXTEND PRIMING OF PARTIALLY EMBEDDED MEMBERS TO A DEPTH OF 2 INCHES.

B.

SURFACES TO BE WELDED.

C.

SURFACES TO RECEIVE SPRAYED FIRE-RESISTIVE MATERIALS.

D.

GALVANIZED SURFACES.

E.

SURFACES ENCLOSED IN INTERIOR CONSTRUCTION.
15.

CLEAN ALL STEEL SURFACES TO BE PAINTED. REMOVE LOOSE RUST, MILL SCALE, SPATTER, SLAG, OR FLUX DEPOSITS. PREPARE SURFACES IN ACCORDANCE WITH SSPC-SP3 SPECIFICATION AND STANDARD.
16.

HOT-DIP GALVANIZE AFTER FABRICATION THE FOLLOWING:

A.

ANGLES AND PLATES SUPPORTING MASONRY IN EXTERIOR WALLS.

B.

LINTELS AND LINTEL ASSEMBLIES SUPPORTING MASONRY IN EXTERIOR WALLS.

C.

ALL STEEL EXPOSED TO WEATHER IN THE FINAL CONSTRUCTION

D.

ITEMS IDENTIFIED AS GALVANIZED ON ARCHITECTURAL OR STRUCTURAL DRAWINGS.

E.

STEEL IN CONTACT WITH PT WOOD.
17.

STEEL MEMBERS MUST BE SPLICED ONLY WHERE INDICATED.
18.

LOCATE CONSTRUCTION JOINTS FOR SLABS ON METAL DECK MIDWAY BETWEEN BEAMS WHERE THE JOINT IS PARALLEL TO THE BEAM SPAN. LOCATE JOINTS WITHIN THE MIDDLE THIRD SPAN WHERE THE JOINT IS PERPENDICULAR TO THE BEAM SPAN. ANY STOP IN CONCRETE WORK MUST BE MADE WITH VERTICAL BULKHEADS, UNLESS OTHERWISE SHOWN. REINFORCING TO BE CONTINUOUS THROUGH JOINTS.
19.

ALL STAIR LANDINGS, STAIRS, AND STAIR SUPPORTS TO BE DESIGNED BY STAIR MANUFACTURER. LAYOUT OF STAIRS, LANDINGS, HANDRAILS, ETC. SHALL COMPLY WITH ARCHITECTURAL DRAWINGS. STRUCTURAL DESIGN CALCULATIONS AND DRAWINGS STAMPED BY A REGISTERED ENGINEER SHALL BE SUBMITTED TO THE STRUCTURAL EOR FOR REVIEW OF LOADING. ARCHITECT AND STAIR MANUFACTURER ARE RESPONSIBLE TO REVIEW FOR CODE AND ADA COMPLIANCE. STAIR MANUFACTURER SHALL PROVIDE ALL POSTS AND CONNECTIONS TO SUPPORT STAIRS. POSTS AND HANGERS MUST BE LOCATED IN PARTITION WALLS AND LOAD THE STRUCTURE CONCENTRICALLY.

WOOD DECK NOTES:

1.

ROOF DECKING SHALL BE AS NOTED ON PLANS, TONGUE AND GROOVE CONTINUOUS LAY UP (NO LAPS).
2.

ALL EXTERIOR EXPOSED STRUCTURAL WOOD DECKING AND BLOCKING, AND SHEATHING IS TO BE EXTERIOR GRADE PRESSURE PRESERVATIVE TREATED, MIN. RETENTION 0.25 PCF.
3.

WOOD DECKING TO BE STRESS RATED DOUG FIR OR SPRUCE-PINE-FIR #1 OR BETTER.
4.

SCREW LENGTH TO FIT APPLICATION. ALL SCREWS SHALL PENETRATE A MINIMUM OF 1 3/4" BUT NOT MORE THAN THE FULL THICKNESS OF THE MEMBER. INSTALL PER MANUFACTURER'S INSTRUCTIONS. NOTE: SIMPSON STRONG DRIVE SCREWS ARE DEFINED AS SELF-TAPPING. OTHER SCREWS TYPES MAY REQUIRE PRE-DRILLING. MINIMUM SCREW/BOLT SIZE #12, U.O.N.
5.

STRUCTURAL MEMBERS WHOSE STRENGTH IS IMPAIRED BY IMPROPER CUTTING, DRILLING, OR EXCESSIVE DEFECTS SHALL BE REPLACED OR REINFORCED IN A MANNER ACCEPTABLE TO THE ARCHITECT.
6.

FASTEN WOOD DECKING TO SUPPORTS WITH NOT LESS THAN #14 SCREWS AT 4" O.C.
7.

WOOD STRUCTURAL PANELS (WSP) MUST COMPLY WITH PS 1 "U.S. PRODUCT STANDARD FOR CONSTRUCTION AND INDUSTRIAL PLYWOOD" FOR PLYWOOD CONSTRUCTION PANELS AND THE FOLLOWING REQUIREMENTS:


A.

EXTERIOR WALL SHEATHING, SIZE INDICATED ON THE DRAWINGS APA RATED SHEATHING, EXPOSURE 1 DURABILITY CLASSIFICATION.
8.

FIELD TREAT ALL CUTS AND ABRASIONS IN TREATED TIMBERS IN ACCORDANCE WITH THE AMERICAN WOOD PRESERVERS ASSOCIATION STANDARD M4. TRIM ALL CUTS AND ABRASIONS BEFORE FIELD TREATMENT. COAT ALL DEPRESSIONS OR OPENINGS AROUND BOLT HOLES, JOINTS OR GAPS INCLUDING RECESSES FORMED BY COUNTER BORING, WITH PRESERVATIVE TREATMENT USED FOR TIMBER
9.

UNLESS OTHERWISE NOTED, ATTACHED BLOCKING AND NAILERS TO THE STEEL FRAMING USING 3/16 INCH DIAMETER POWDER ACTUATED FASTENERS AT 24 INCHES ON CENTER, STAGGER FASTENERS AT ALTERNATE SIDES OF BEAM WEB.
10.

WHERE MULTIPLE FRAMING MEMBERS ARE INDICATED: SCAB CONTINGENT MEMBERS TOGETHER WITH 16d NAILS AT 12 INCHES ON CENTER, ALTERNATING AT 2 INCHES FROM EACH EDGE.

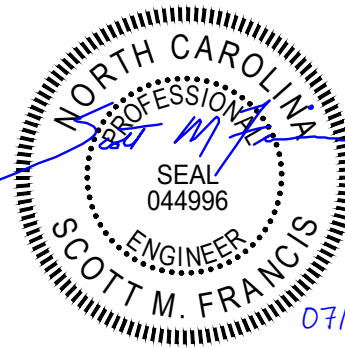

IMEG RESERVES PROPRIETARY RIGHTS, INCLUDING COPYRIGHTS, TO THIS DRAWING AND THE DATA SHOWN THEREON. SAID DRAWING AND/OR DATA ARE THE EXCLUSIVE PROPERTY OF IMEG AND SHALL NOT BE USED OR REPRODUCED FOR ANY OTHER PROJECT WITHOUT THE EXPRESS WRITTEN APPROVAL AND PARTICIPATION OF IMEG. ©2025 IMEG CONSULTANTS CORP. North Carolina Design Registration #F-1507

Susan Hatchell
Landscape Architecture, PLLC
711 W. North Street, Raleigh, NC 27603
p: 919-838-9600 f: 919-838-9700



GENERAL NOTES

LAKE MYRA COUNTY PARK
Wake County, NC

REVISIONS

Date07/27/2026

ES-S002

ROUGH CARPENTRY NOTES:

1.

ROUGH CARPENTRY MUST BE IN ACCORDANCE WITH THE AMERICAN WOOD COUNCIL (AWC) "NATIONAL DESIGN SPECIFICATION FOR WOOD CONSTRUCTION."
2.

UNLESS OTHERWISE NOTED, USE 'COMMON' NAILS AND ALL NAILING MUST CONFORM TO THE "FASTENING SCHEDULE" TABLE 2304.10.1 OF THE BUILDING CODE.
3.

WOOD FRAMING MEMBERS MUST COMPLY WITH PS 20 "AMERICAN SOFTWOOD LUMBER STANDARD" AND THE FOLLOWING REQUIREMENTS:

A.

MOISTURE CONTENT - SEASONED, WITH 19 PERCENT MAXIMUM MOISTURE CONTENT.

B.

GRADE - NO. 2, OR BETTER UNLESS OTHERWISE NOTED.

C.

SPECIES - [SPRUCE-PINE-FIR UNDER NLGA RULES] [SPRUCE-PINE-FIR (SOUTH) UNDER WWPA RULES] [SOUTHERN PINE GRADED UNDER SPIB RULES].
4.

WOOD STRUCTURAL PANELS (WSP) MUST COMPLY WITH PS 1 "U.S. PRODUCT STANDARD FOR CONSTRUCTION AND INDUSTRIAL PLYWOOD" FOR PLYWOOD CONSTRUCTION PANELS AND THE FOLLOWING REQUIREMENTS:

A.

ROOF SHEATHING: 9/16" INCH, APA RATED SHEATHING, EXTERIOR EXPOSURE DURABILITY CLASSIFICATION. PROVIDE TONGUE-AND-GROOVE EDGES OR USE "PLY-CLIPS" AT MID-SPAN BETWEEN EACH SUPPORT.
5.

ALL WOOD FRAMING MEMBERS PERMANENTLY EXPOSED TO THE WEATHER AND ALL SILL PLATES IN CONTACT WITH CONCRETE MUST BE PRESERVATIVE-TREATED. REFER TO THE SPECIFICATIONS.
6.

STEEL PLATE CONNECTORS MUST COMPLY WITH ASTM A 36 SPECIFICATIONS (Fy= 36 KSI). BOLTS CONNECTING WOOD MEMBERS MUST COMPLY WITH ASTM A307 COMMON STEEL BOLTS, AND MUST BE 1/2 INCH DIAMETER, UNLESS OTHERWISE NOTED.
7.

METAL FRAMING ANCHORS, HOLD DOWNS, HURRICANE TIES, HANGERS, ETC. MUST COMPLY WITH ASTM A653 AND BE CAPABLE OF SUPPORTING THE REACTIONS SHOWN. WHERE PRODUCTS OF A SPECIFIC MANUFACTURER ARE SHOWN, EQUAL PRODUCTS OF ANOTHER MANUFACTURER MAY BE USED IF APPROVED.
8.

PROVIDE HEADERS OF THE SAME CROSS SECTION AS JOISTS OR RAFTERS TO FRAME AROUND ALL OPENINGS TO SUPPORT SHEATHING, UNLESS OTHERWISE NOTED OR DETAILED ON THE DRAWINGS.
9.

UNLESS OTHERWISE NOTED, ATTACH BLOCKING AND NAILERS TO STEEL FRAMING USING 3/16 INCH DIAMETER POWDER ACTUATED FASTENERS AT 24 INCHES ON CENTER OR 1/2 INCH DIAMETER BOLTS AT 48 INCHES ON CENTER. STAGGER FASTENERS TO ALTERNATE SIDES OF BEAM WEB.
10.

WHERE MULTIPLE FRAMING MEMBERS ARE INDICATED, SCAB CONTINGENT MEMBERS TOGETHER WITH 16d NAILS AT 12 INCHES ON CENTER, ALTERNATING AT 2 INCHES FROM EACH EDGE.
11.

ALL CONNECTION HARDWARE IN CONTACT WITH PRESERVATIVE TREATED WOOD MUST BE HOT-DIP GALVANIZED COATED.
12.

POWDER ACTUATED FASTENERS (PAF) MUST HAVE A MINIMUM ALLOWABLE CAPACITY INTO THE BASE MATERIAL AS FOLLOWS

A.

STEEL: SHEAR = 600 LBS
 TENSION = 250 LBS

B.

CONCRETE: SHEAR = 260 LBS
 TENSION = 255 LBS

STRUCTURAL DELEGATED DESIGN ELEMENT NOTES:

1.

THE FOLLOWING BUILDING ELEMENTS REQUIRE DELEGATED DESIGN AND ENGINEERING BY A SPECIALTY STRUCTURAL ENGINEER:

A.

GLAZING ASSEMBLY CONNECTIONS TO THE STRUCTURE

B.

STRUCTURAL STEEL CONNECTIONS

C.

MECHANICAL, ELECTRICAL, AND PLUMBING SUPPORTS AND DISTRIBUTIONS SYSTEMS, INCLUDING BRACING AND ATTACHMENTS

REFERENCE SPECIFICATIONS FOR COMPLETE REQUIREMENTS

2.

SUBMIT COMPLETE CALCULATIONS AND SHOP DRAWINGS, SIGNED AND SEALED BY THE PROFESSIONAL ENGINEER REGISTERED IN THE STATE OF NORTH CAROLINA RESPONSIBLE FOR THE DESIGN, INCLUDING DESIGN LOADINGS AND REACTIONS APPLIED TO THE SUPPORTING STRUCTURE. INCLUDE A SUMMARY OF THE CONTROLLING LOAD CASES FOR EACH LOCATION.

3.

IN ADDITION TO THEIR OWN DEAD WEIGHT AND THE DEAD LOADS SHOWN OR INDICATED IN THE DRAWINGS, MEMBERS MUST BE DESIGNED TO SUPPORT THE LOADS INDICATED IN THE GENERAL NOTES.

4.

CONNECTION DETAILS SHOWN ARE SCHEMATIC ONLY. ALL CONNECTIONS MUST BE DESIGNED AND DETAILED BY THE MANUFACTURER TO SUIT THE SPECIFIED LOADS. CONNECTIONS MUST ACCOUNT FOR THERMAL MOVEMENT, DEFLECTION, CREEP, MANUFACTURING TOLERANCES, AND ERECTION TOLERANCES. DETAIL ALL CONNECTIONS ON SHOP DRAWINGS.

5.

THE CONTRACTOR MUST BE RESPONSIBLE FOR THE COORDINATION OF ALL SPECIALTY STRUCTURAL ELEMENTS AND COST ASSOCIATED WITH A CONTRACTOR INITIATED CHANGE IN BUILDING STRUCTURE, INCLUDING CONSTRUCTION COSTS AND RE-ENGINEERING COSTS.
- WOOD DECK NOTES:
1.

ROOF DECKING SHALL BE AS NOTED ON PLANS, TONGUE AND GROOVE CONTINUOUS LAY UP (NO LAPS).

2.

ALL EXTERIOR EXPOSED STRUCTURAL WOOD DECKING AND BLOCKING, AND SHEATHING IS TO BE EXTERIOR GRADE PRESSURE PRESERVATIVE TREATED, MIN. RETENTION 0.25 PCF.

3.

WOOD DECKING TO BE STRESS RATED DOUG FIR OR SPRUCE-PINE-FIR #1 OR BETTER.

4.

SCREW LENGTH TO FIT APPLICATION. ALL SCREWS SHALL PENETRATE A MINIMUM OF 1 3/4" BUT NOT MORE THAN THE FULL THICKNESS OF THE MEMBER. INSTALL PER MANUFACTURER'S INSTRUCTIONS. NOTE: SIMPSON STRONG DRIVE SCREWS ARE DEFINED AS SELF-TAPPING. OTHER SCREWS TYPES MAY REQUIRE PRE-DRILLING. MINIMUM SCREW/BOLT SIZE #12, U.O.N.

5.

STRUCTURAL MEMBERS WHOSE STRENGTH IS IMPAIRED BY IMPROPER CUTTING, DRILLING, OR EXCESSIVE DEFECTS SHALL BE REPLACED OR REINFORCED IN A MANNER ACCEPTABLE TO THE ARCHITECT.

6.

FASTEN WOOD DECKING TO SUPPORTS WITH NOT LESS THAN #14 SCREWS AT 4" O.C.

7.

WOOD STRUCTURAL PANELS (WSP) MUST COMPLY WITH PS 1 "U.S. PRODUCT STANDARD FOR CONSTRUCTION AND INDUSTRIAL PLYWOOD" FOR PLYWOOD CONSTRUCTION PANELS AND THE FOLLOWING REQUIREMENTS:

A.

EXTERIOR WALL SHEATHING, SIZE INDICATED ON THE DRAWINGS APA RATED SHEATHING, EXPOSURE 1 DURABILITY CLASSIFICATION.

8.

FIELD TREAT ALL CUTS AND ABRASIONS IN TREATED TIMBERS IN ACCORDANCE WITH THE AMERICAN WOOD PRESERVERS ASSOCIATION STANDARD M4. TRIM ALL CUTS AND ABRASIONS BEFORE FIELD TREATMENT. COAT ALL DEPRESSIONS OR OPENINGS AROUND BOLT HOLES, JOINTS OR GAPS INCLUDING RECESSES FORMED BY COUNTER BORING, WITH PRESERVATIVE TREATMENT USED FOR TIMBER

9.

UNLESS OTHERWISE NOTED, ATTACHED BLOCKING AND NAILERS TO THE STEEL FRAMING USING 3/16 INCH DIAMETER POWDER ACTUATED FASTENERS AT 24 INCHES ON CENTER, STAGGER FASTENERS AT ALTERNATE SIDES OF BEAM WEB.

10.

WHERE MULTIPLE FRAMING MEMBERS ARE INDICATED: SCAB CONTINGENT MEMBERS TOGETHER WITH 16d NAILS AT 12 INCHES ON CENTER, ALTERNATING AT 2 INCHES FROM EACH EDGE.
- POST-INSTALLED ANCHOR NOTES:
1.

ANCHORS TO BE POST-INSTALLED ONLY WHERE INDICATED ON CONSTRUCTION DOCUMENTS. ANY SUBSTITUTE OF CAST-IN ANCHOR TO POST-INSTALLED ANCHORS MUST BE SUBMITTED AS A REQUEST FOR DEVIATION TO THE ENGINEER OF RECORD PRIOR TO CONSTRUCTION.

2.

ALL POST INSTALLED ANCHORS INDICATED ON THE DRAWINGS ARE BY HILTI, INC. AND MUST BE CONSIDERED THE BASIS OF DESIGN PRODUCT. WHERE NOT EXPLICITLY INDICATED IN THE DRAWINGS, THE FOLLOWING ANCHORS/ADHESIVES MUST BE USED:

A.

ANCHORAGE TO CONCRETE

1.

ADHESIVE ANCHORS FOR CRACKED AND UNCRACKED CONCRETE USE:

a.

HILTI HIT-HY 200 SAFE SET SYSTEM WITH HILTI HOLLOW DRILL BIT (TE-CD OR TE-YD) AND VC 20/40 VACUUM SYSTEM (VC 20-U OR VC40U) WITH STEEL THREADED ROD PER ICC ESR-3187.

2.

SCREW ANCHORS FOR CRACKED AND UNCRACKED CONCRETE USE:

a.

HILTI KWIK HUS EZ SCREW ANCHORS PER ICC ESR-3027.

B.

REBAR DOWELING INTO CONCRETE

1.

ADHESIVE ANCHORS FOR CRACKED AND UNCRACKED CONCRETE USE:

a.

HILTI HIT-HY 200 SAFE SET SYSTEM WITH HILTI HOLLOW DRILL BIT (TE-CD OR TE-YD) AND VC 20/40 VACUUM SYSTEM (VC 20-U OR VC 40-U) WITH CONTINUOUSLY DEFORMED REBAR PER ICC ESR-3187.

2.

ANCHORAGE TO SOLID GROUTED MASONRY

1.

ADHESIVE ANCHORS USE:

a.

HILTI HIT-HY 270 MASONRY ADHESIVE ANCHORING SYSTEM (ICC PENDING).

b.

STEEL ANCHOR ELEMENT MUST BE HILTI HAS-E CONTINUOUSLY THREADED ROD OR CONTINUOUSLY DEFORMED STEEL REBAR.

c.

THE APPROPRIATE SIZE SCREEN TUBE MUST BE USED PER ADHESIVE MANUFACTURER'S RECOMMENDATION.

2.

MECHANICAL ANCHORS USE:

a.

HILTI KWIK HUS EZ SCREW ANCHORS PER ICC ESR 3056.

D.

ANCHORAGE TO HOLLOW / MULTI-WYTHE MASONRY

1.

ADHESIVE ANCHORS USE:

a.

HILTI HIT-HY 270 MASONRY ADHESIVE ANCHORING SYSTEM PER ICC ESR-3342.

b.

STEEL ANCHOR ELEMENT MUST BE HILTI HAS-E CONTINUOUSLY THREADED ROD OR CONTINUOUSLY DEFORMED STEEL REBAR.

c.

THE APPROPRIATE SIZE SCREEN TUBE MUST BE USED PER ADHESIVE MANUFACTURER'S RECOMMENDATION.

3.

ALTERNATE POST INSTALLED ANCHOR PRODUCTS MAY BE SUBMITTED TO THE ENGINEER FOR REVIEW AND POSSIBLE APPROVAL. ALL SUBSTITUTION REQUESTS MUST BE ACCOMPANIED BY AN ICC ESR SHOWING COMPLIANCE WITH THE RELEVANT BUILDING CODE FOR SEISMIC USES, LOAD RESISTANCE, INSTALLATION CATEGORY, AND COMPREHENSIVE INSTALLATION INSTRUCTIONS. ADHESIVE ANCHOR EVALUATION WILL ALSO CONSIDER CREEP, IN-SERVICE TEMPERATURE AND INSTALLATION TEMPERATURE. ALTERNATE PRODUCTS MAY REQUIRE MODIFICATIONS TO ANCHOR DIAMETER, SPACING, AND EMBEDMENT.

4.

INSTALL ANCHORS PER THE MANUFACTURER INSTRUCTIONS, AS INCLUDED IN THE ANCHOR PACKAGING.

5.

THE CONTRACTOR MUST ARRANGE FOR AN ANCHOR MANUFACTURER'S REPRESENTATIVE TO PROVIDE ONSITE INSTALLATION TRAINING FOR ALL OF THEIR ANCHORING PRODUCTS SPECIFIED. THE STRUCTURAL ENGINEER OF RECORD MUST RECEIVE DOCUMENTED CONFIRMATION THAT ALL OF THE CONTRACTOR'S PERSONNEL WHO INSTALL ANCHORS ARE TRAINED PRIOR TO THE COMMENCEMENT OF ANCHOR INSTALLATION.

6.

ANCHOR CAPACITY IS DEPENDANT UPON SPACING BETWEEN ADJACENT ANCHORS AND PROXIMITY OF ANCHORS TO EDGE OF CONCRETE. INSTALL ANCHORS IN ACCORDANCE WITH SPACING AND EDGE CLEARANCES INDICATED ON THE DRAWINGS.

7.

EXISTING REINFORCING BARS IN THE CONCRETE STRUCTURE MAY CONFLICT WITH SPECIFIC ANCHOR LOCATIONS. UNLESS NOTED ON THE DRAWINGS THAT THE BARS CAN BE CUT, THE CONTRACTOR MUST LOCATE THE POSITION OF THE REINFORCING BARS AT THE LOCATIONS OF THE CONCRETE ANCHORS, BY FERROSCAN OR GPR.

8.

ALL POST INSTALLED ANCHORS REQUIRE CONTINUOUS INSPECTIONS BY THE OWNER'S MATERIALS TESTING AGENCY TO VERIFY INSTALLATION HAS BEEN PERFORMED IN ACCORDANCE WITH THE MANUFACTURER'S WRITTEN INSTRUCTIONS.

IMEG RESERVES PROPRIETARY RIGHTS, INCLUDING COPYRIGHTS, TO THIS DRAWING AND THE DATA SHOWN THEREON. SAID DRAWING AND/OR DATA ARE THE EXCLUSIVE PROPERTY OF IMEG AND SHALL NOT BE USED OR REPRODUCED FOR ANY OTHER PROJECT WITHOUT THE EXPRESS WRITTEN APPROVAL AND PARTICIPATION OF IMEG. ©2025 IMEG CONSULTANTS CORP. North Carolina Design Registration #F-1507

Susan Hatchell
Landscape Architecture, PLLC
711 W. North Street, Raleigh, NC 27603
p: 919-838-9600 f: 919-838-9700

GENERAL NOTES


LAKE MYRA COUNTY PARK
Wake County, NC

REVISIONS

Date07/27/2026

ES-S003

ABBREVIATIONS			
AFF	ABOVE FINISHED FLOOR	KCJ	KEYED CONSTRUCTION JOINT
ARCH	ARCHITECT	Ld	REBAR TENSION
BD	BAR DIAMETER		DEVELOPMENT LENGTH
BF	BRACED FRAME	Ldc	REBAR COMPRESSION
BEJ	BUILDING EXPANSION JOINT		DEVELOPMENT LENGTH
BLDG	BUILDING	Ldh	HOOKED REBAR TENSION
BM	BEAM		DEVELOPMENT LENGTH
BOD	BOTTOM OF DECK	Ls	REBAR TENSION SPLICE
BOS	BOTTOM OF STEEL		LENGTH
BOT, B	BOTTOM	Lsc	REBAR COMPRESSION SPLICE
BRG	BEARING		LENGTH
BTWN	BETWEEN	L	LOW
C TO C	CENTER TO CENTER	LLH	LONG LEG HORIZONTAL
CFMF	COLD-FORMED METAL	LLV	LONG LEG VERTICAL
	FRAMING	LSH	LONG SIDE HORIZONTAL
CJ	CONTROL JOINT	LSV	LONG SIDE VERTICAL
CL	CENTERLINE	LTWT	LIGHTWEIGHT
CLR	CLEAR	LWC	LIGHTWEIGHT CONCRETE
CMU	CONCRETE MASONRY UNIT	MAS	MASONRY
COL	COLUMN	MATL	MATERIAL
CONC	CONCRETE	MAX	MAXIMUM
CONN	CONNECTION	MECH	MECHANICAL
CONSTR	CONSTRUCTION	MF	MOMENT FRAME
CONT	CONTINUOUS	MFR	MANUFACTURER
COORD	COORDINATE	MID	MIDDLE
CTR	CENTER	MIN	MINIMUM
CTRD	CENTERED	MOD	MODIFY
DBA	DEFORMED BAR ANCHOR	MOS	MIDDEPTH OF SLAB
DBL	DOUBLE	NOM	NOMINAL
DC	DIAPHRAGM CHORD	NS	NEAR SIDE
DCJ	DOWELED CONSTRUCTION	NTS	NOT TO SCALE
	JOINT	OC	ON CENTER
DIA, Ø	DIAMETER	OPH	OPPOSITE HAND
DIST	DISTANCE	OPNG	OPENING
DJ	DOUBLE JOIST	PAF	POWDER ACTUATED
DWGS	DRAWINGS		FASTENER
EA	EACH	PAR	PARALLEL
EF	EACH FACE	PC	PIECE
EJ	EXPANSION JOINT	PEMB	PRE-ENGINEERED METAL
EL	ELEVATION		BUILDING
ELEV	ELEVATOR	PEN	PENETRATE, PENETRATION
EMBED	EMBEDMENT	PERP	PERPENDICULAR
EOD	EDGE OF DECK	PL	PLATE
EOS	EDGE OF SLAB	PT	POST-TENSIONED (CONC)
EQ	EQUAL		PRESSURE TREATED (WOOD)
EW	EACH WAY	R	RADIUS
EXIST	EXISTING	REF	REFERENCE, REFER TO
EXP	EXPANSION	REINF	REINFORCE, REINFORCED,
EXT	EXTERIOR		REINFORCING
FD	FLOOR DRAIN	REQD	REQUIRED
FDN	FOUNDATION	REQMTS	REQUIREMENTS
FO	FACE OF	SCHED	SCHEDULE
FF EL	FINISHED FLOOR	SF	STEPPED FOOTING
	ELEVATION	SGB	STEPPED GRADE BEAM
FIN	FINISH	SIM	SIMILAR
FIN FLR	FINISHED FLOOR	SJ	SAWED JOINT
FOB	FACE OF BUILDING	SL	SLOPE
FOC	FACE OF CONCRETE	SOG	SLAB-ON-GRADE
FOM	FACE OF MASONRY	SPF	SIDEPLATE FRAME
FOS	FACE OF SLAB/ STUD	STD	STANDARD
FRMG	FRAMING	STIFF	STIFFENER
FTG	FOOTING	TBE	TRUSS BEARING ELEVATION
FS	FAR SIDE	T&B	TOP & BOTTOM
FV, ±	FIELD VERIFY	T&G	TONGUE AND GROOVE
GALV	GALVANIZED	THK	THICKNESS
GC	GENERAL CONTRACTOR	TOC	TOP OF CONCRETE
GEN	GENERAL	TOF	TOP OF FOOTING
GR BM	GRADE BEAM	TOM	TOP OF MASONRY
H	HIGH	TOCP	TOP OF CONCRETE PEDESTAL
HK	HOOK	TOS	TOP OF STEEL
HORIZ	HORIZONTAL	TS	THICKENED SLAB
HSS	HOLLOW STRUCTURAL	TS/STR	THICKENED SLAB AT STAIR
	SECTION	TYP	TYPICAL
HSA	HEADED STUD ANCHOR	UON	UNLESS OTHERWISE NOTED
HT	HEIGHT	VERT	VERTICAL
HVY	HEAVY	W/	WITH
INT	INTERIOR	WP	WORKING POINT
JBE	JOIST BEARING ELEVATION	WSP	WOOD STRUCTURAL PANEL(S)
JT	JOINT	WWR	WELDED WIRE REINFORCING
KCJ	KEYED CONSTRUCTION		
	JOINT		

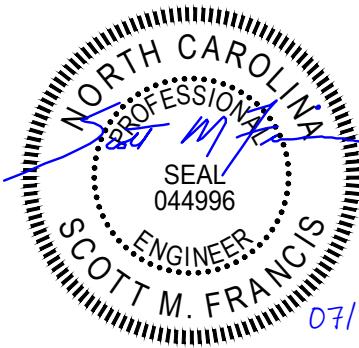

IMEG RESERVES PROPRIETARY RIGHTS, INCLUDING COPYRIGHTS, TO THIS DRAWING AND THE DATA SHOWN THEREON. SAID DRAWING AND/OR DATA ARE THE EXCLUSIVE PROPERTY OF IMEG AND SHALL NOT BE USED OR REPRODUCED FOR ANY OTHER PROJECT WITHOUT THE EXPRESS WRITTEN APPROVAL AND PARTICIPATION OF IMEG. ©2025 IMEG CONSULTANTS CORP. North Carolina Design Registration #F-1507

Susan Hatchell
Landscape Architecture, PLLC
711 W. North Street, Raleigh, NC 27603
p: 919-838-9600 f: 919-838-9700




GENERAL NOTES

LAKE MYRA COUNTY PARK
Wake County, NC


REVISIONS

Date07/27/2026

ES-S004

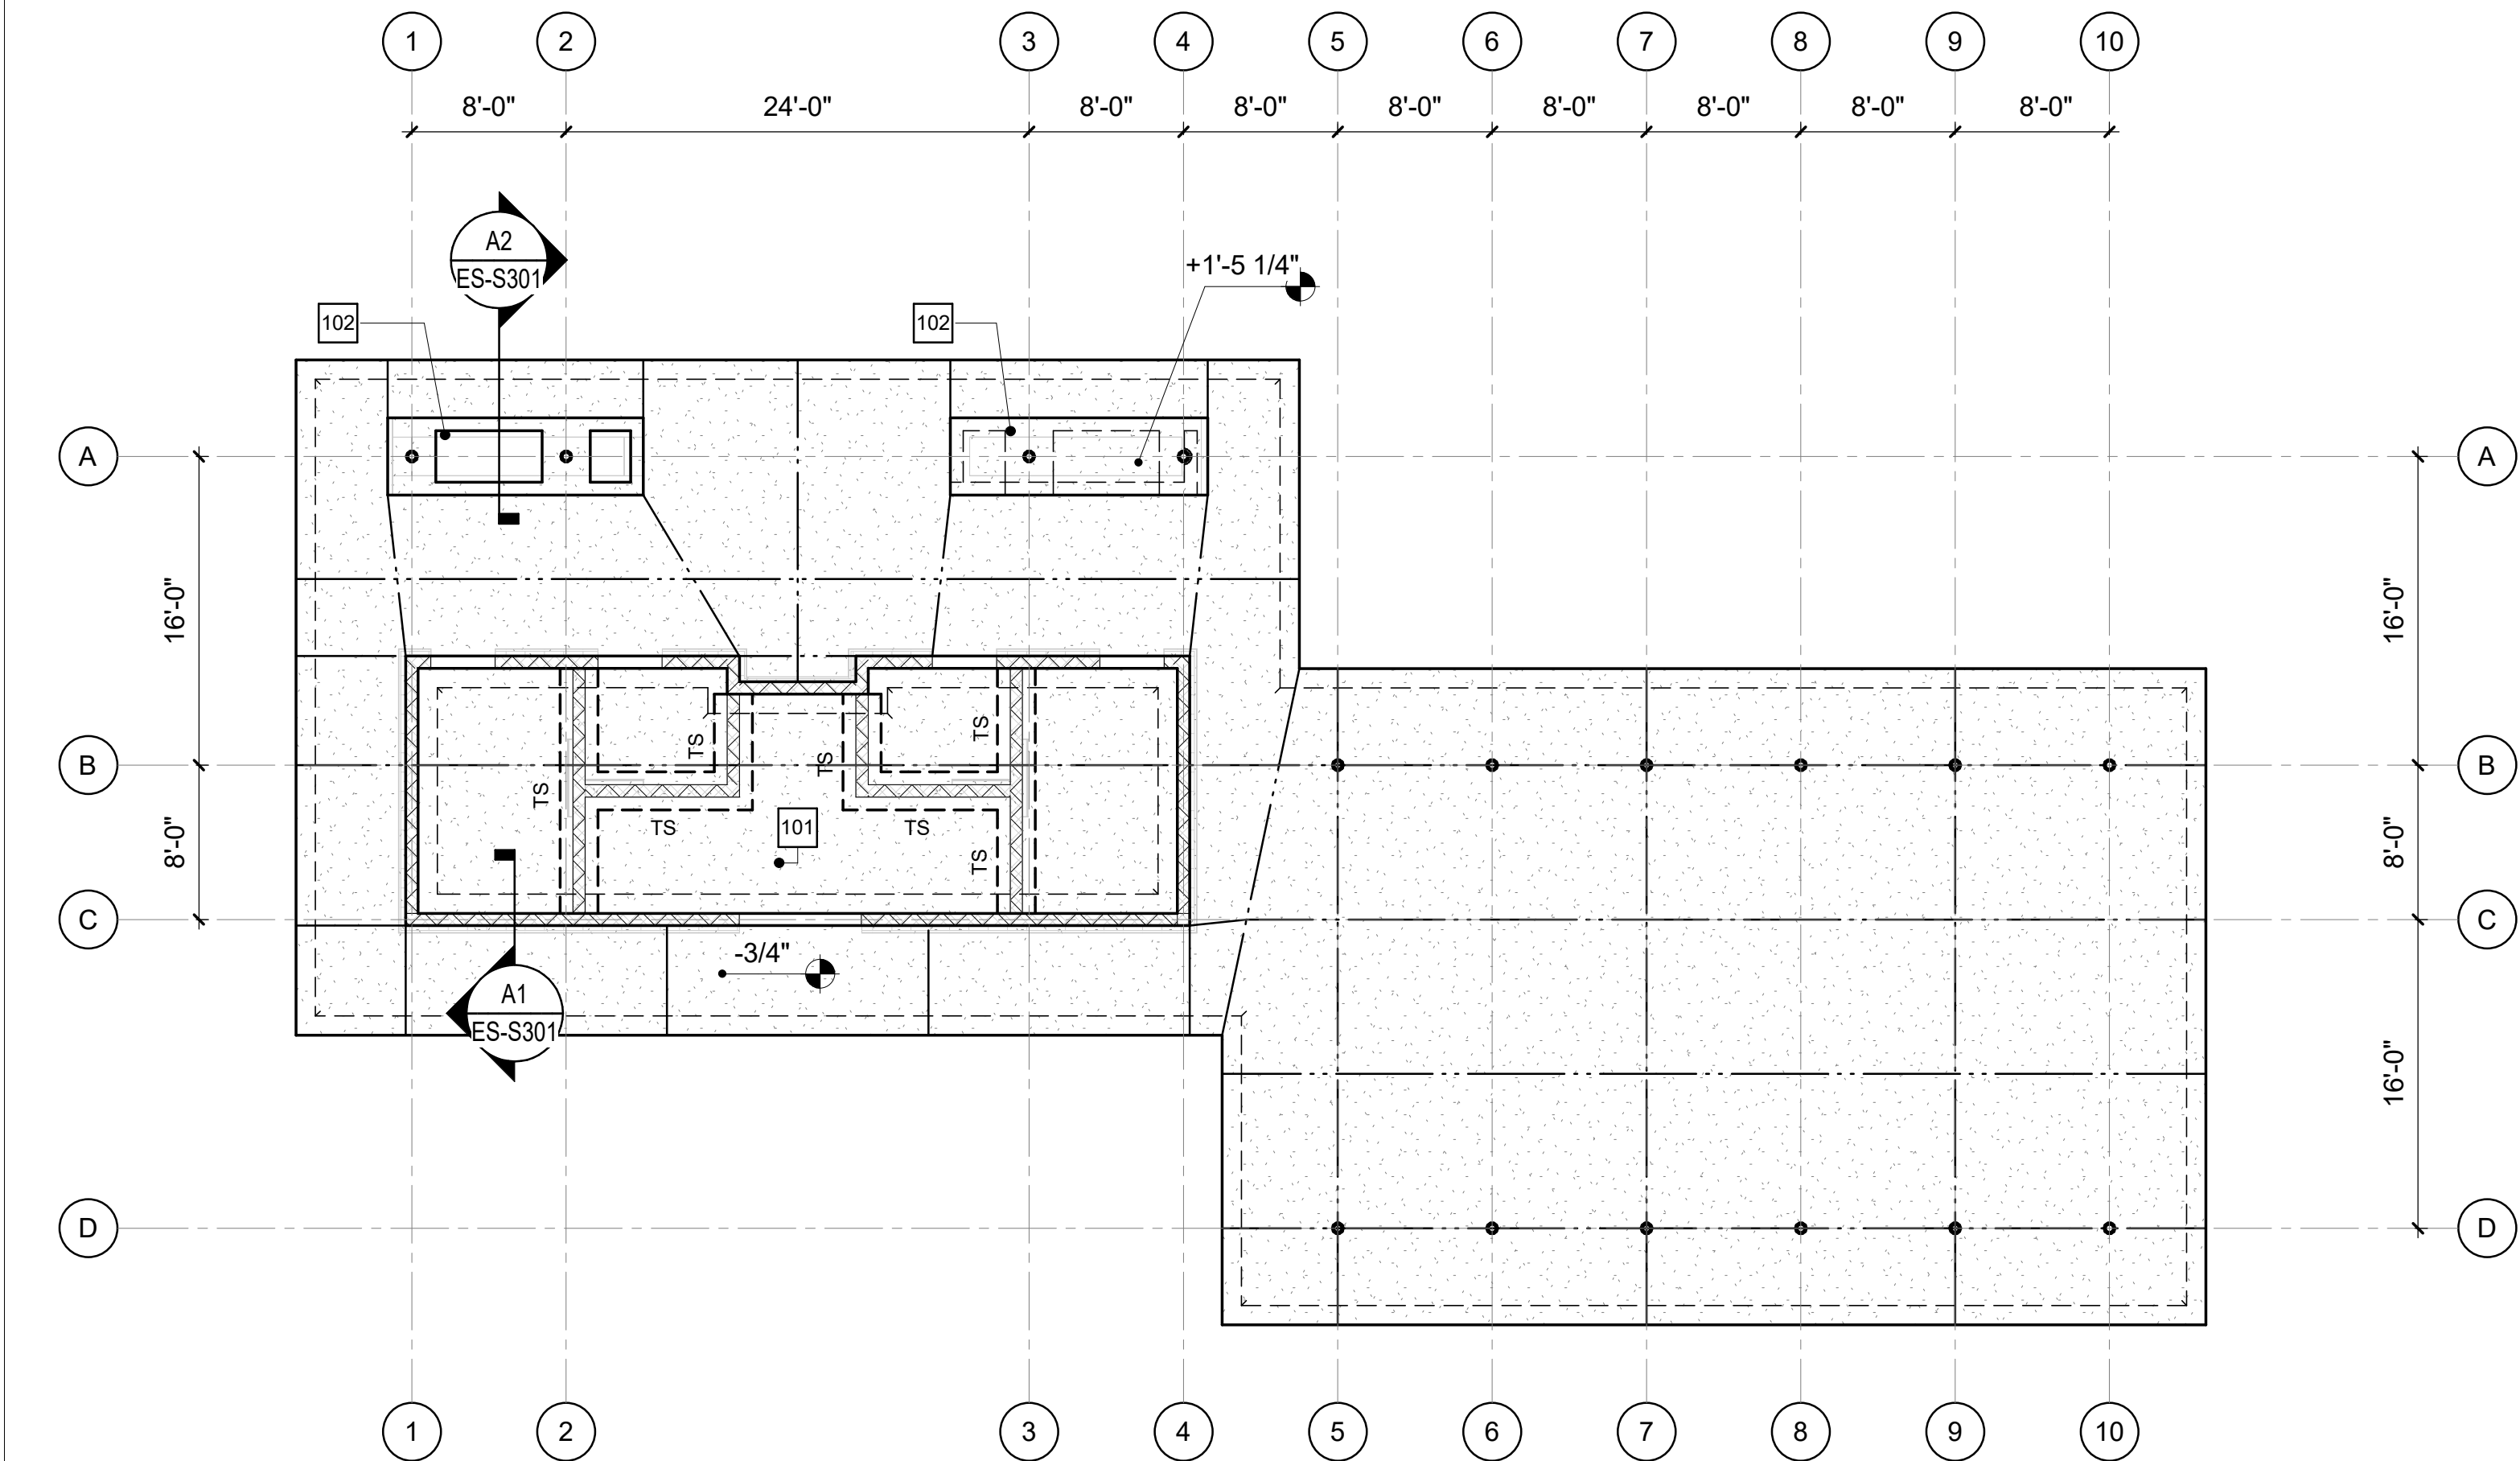

C1 SHELTER A - SLAB PLAN
1/8" = 1'-0"

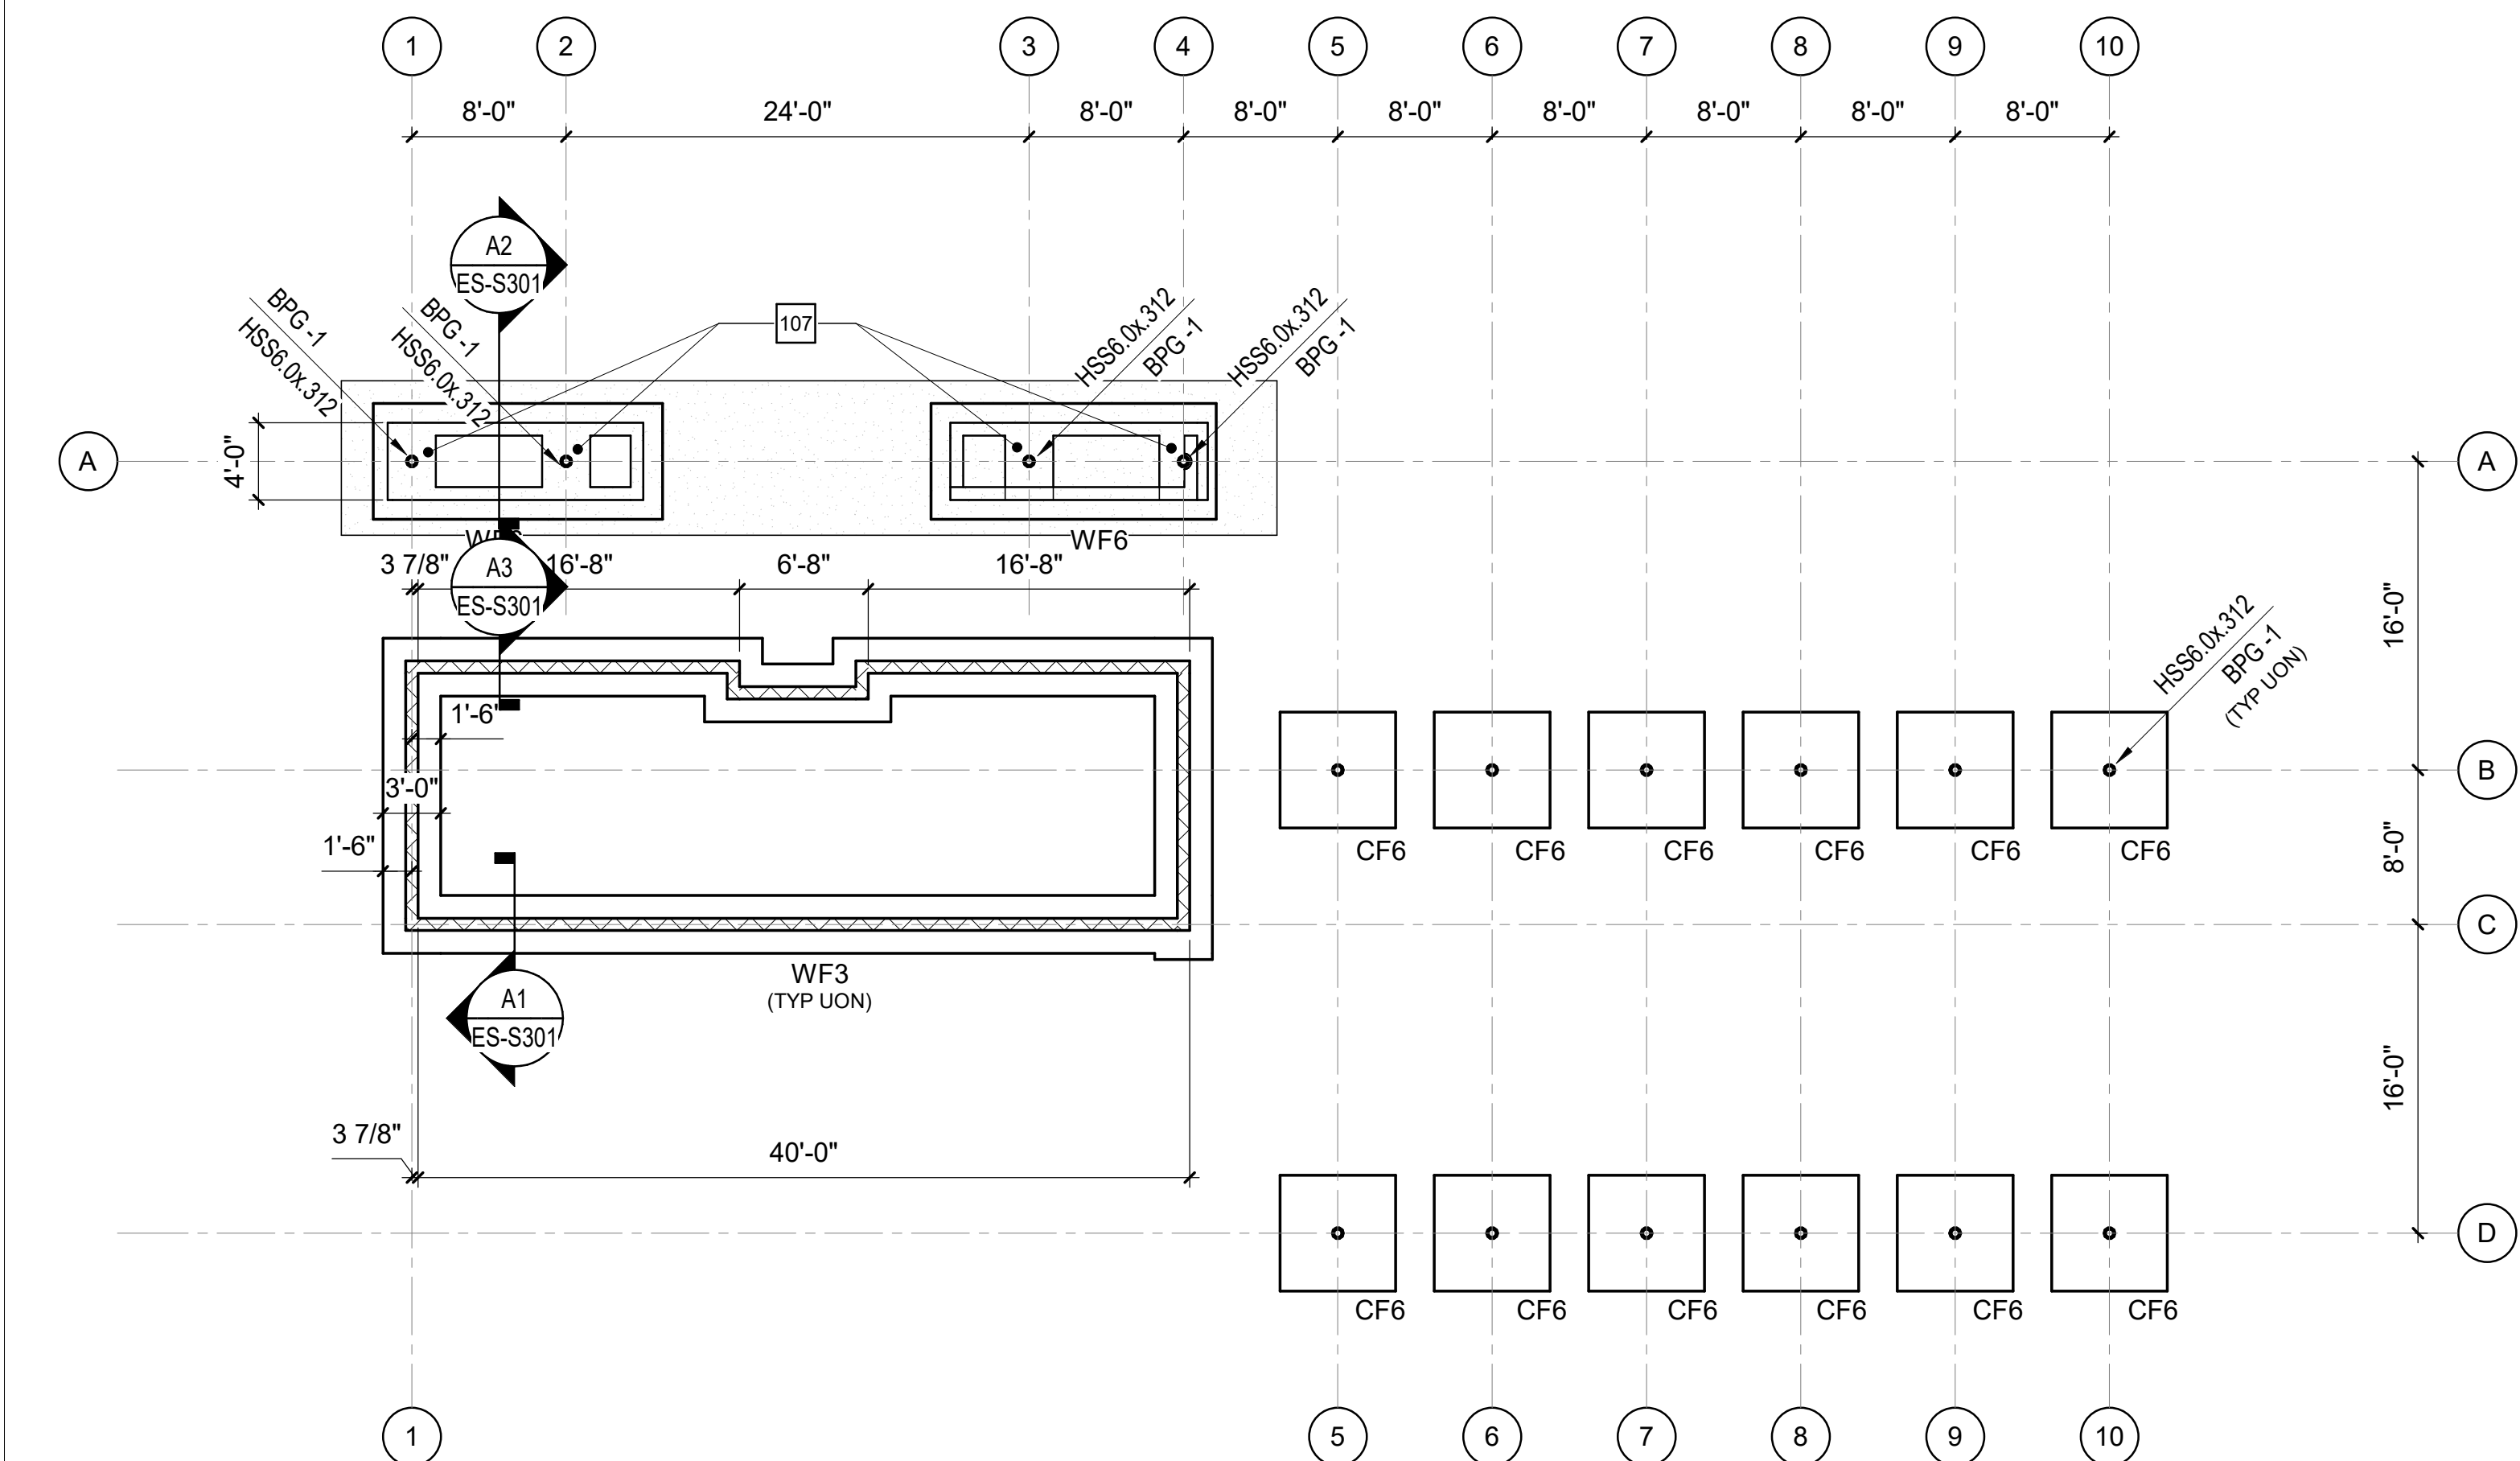

A1 SHELTER A - FOUNDATION PLAN
1/8" = 1'-0"

FOUNDATION PLAN NOTES

- REFERENCE ARCHITECTURAL DRAWINGS FOR DIMENSIONS TO NONBEARING WALLS, WALL CONTROL JOINTS AND OPENINGS.
- UNLESS OTHERWISE NOTED, ALL ELEVATIONS ARE BASED ON A FINISHED FIRST FLOOR REFERENCE OF 0'-0". ACTUAL FINISHED FLOOR ELEVATION IS XX.XX'. FINISHED FLOOR ELEVATIONS AT EACH LEVEL ARE INDICATED ON SLAB PLANS. REFERENCE ARCHITECTURAL DRAWINGS FOR FINISHED FLOOR MATERIALS.
- TOP OF ALL COLUMN AND WALL FOOTINGS MUST BE AT THE FOLLOWING ELEVATIONS UNLESS OTHERWISE NOTED ON PLAN. EXTERIOR WALL AND COLUMN FOOTINGS -1'-4". INTERIOR WALL FOOTINGS -0'-8".
- NOT ALL UTILITY LOCATIONS ARE SHOWN ON PLAN. THE CONTRACTOR MUST COORDINATE THE LOCATIONS, SIZES, AND INVERTS OF UTILITIES. AT LOCATIONS WHERE UTILITIES PASS BELOW THE TOP OF FOOTING ELEVATION, STEP THE TOP OF FOOTING DOWN ON EACH SIDE PER THE "TYPICAL STEPPED FOOTING DETAIL" AND SLEEVE THE UTILITY THROUGH THE FOUNDATION WALL. THE CONTRACTOR MAY, AT HIS/HER OPTION, SLEEVE THE UTILITY THROUGH THE FOUNDATION PER THE "TYPICAL PIPE SLEEVE AT WALL FOOTING DETAILS."
- UNLESS OTHERWISE INDICATED, EXTEND WALL FOOTINGS A MINIMUM OF 6 INCHES BEYOND ENDS OF WALLS.
- NOT ALL SITE WALLS ARE SHOWN ON PLAN. CONTRACTOR MUST COORDINATE CIVIL AND LANDSCAPE DRAWINGS FOR SITE WALL INFORMATION.
- DIMENSIONS SHOWN ON FOUNDATION PLAN ARE TO COLUMN GRIDLINES AND FACE OF FOUNDATION WALLS, UNLESS OTHERWISE NOTED.

SLAB PLAN NOTES

- REFERENCE ARCHITECTURAL DRAWINGS FOR EXACT LIMITS OF SLAB DEPRESSIONS AND OMITTED SLABS.
- FLOOR SINKS AND DRAINS ARE NOT SHOWN ON PLAN. REFERENCE PME DRAWINGS FOR LOCATIONS.
- REFERENCE CIVIL AND LANDSCAPE DRAWINGS FOR EXTERIOR CONCRETE SLABS AND PAVING.
- SLAB-ON-GRADE JOINTS MUST BE SAWED JOINTS OR KEYED CONSTRUCTION JOINTS, UNLESS OTHERWISE NOTED. CONTRACTOR MUST COORDINATE ALL SLAB JOINTS WITH JOINTS IN BONDED FLOOR FINISHES. REFERENCE ARCHITECTURAL DRAWINGS FOR FLOOR FINISH JOINT LOCATIONS.
- PLACE (1) #4 x 3'-0" IN MIDDEPTH OF SLAB AT RE-ENTRANT CORNERS WHERE A SLAB JOINT DOES NOT OCCUR.

KEY NOTES


- 5" CONCRETE SLAB-ON-GRADE OVER VAPOR RETARDER AND 4" DEPTH OF POROUS FILL. REINFORCE WITH 6x6 W2.1xW2.1 WELDED WIRE REINFORCING.
- 4" CONCRETE BENCH SLAB REINFORCED WITH 6x6 W2.1xW2.1 WELDED WIRE REINFORCING..
- 30" CONCRETE PLINTH REINFORCED WITH (10) #6 VERTICAL, #3 TIES AT 9" ON CENTER.

COLUMN FOOTING SCHEDULE

MARK	SIZE			REINFORCING		REMARKS
	LENGTH	WIDTH	DEPTH	BOTTOM	TOP	
CF4	4' - 0"	4' - 0"	1'-3"	(4) #5 EW	-	-
CF5	5' - 0"	5' - 0"	1'-3"	(5) #5 EW	-	-
CF6	6' - 0"	6' - 0"	1'-2"	(6) #6 EW	-	-

WALL FOOTING SCHEDULE

MARK	SIZE		REINFORCING		REMARKS
	WIDTH	DEPTH	CONTINUOUS	TRANSVERSE	
WF2.5	2' - 6"	1'-0"	(3) #5 BOT	#_AT_ " OC BOT	-
WF3	3' - 0"	1'-0"	(4) #5 BOT	#_AT_ " OC BOT	-
WF4	4' - 0"	1'-0"	(5) #5 BOT	#_AT_ " OC BOT	-
WF6	6' - 0"	1'-0"	(7) #5 BOT	#_AT_ " OC BOT	-

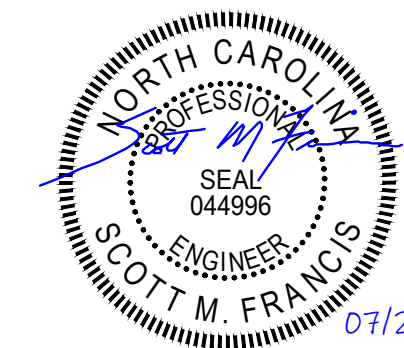

301 N WEST STREET, SUITE 105
RALEIGH, NC 27603
919.782.1833 www.imegcorp.com

IMEG RESERVES PROPRIETARY RIGHTS, INCLUDING COPYRIGHTS, TO THIS DRAWING AND THE DATA SHOWN THEREON. SAID DRAWING AND/OR DATA ARE THE EXCLUSIVE PROPERTY OF IMEG AND SHALL NOT BE USED OR REPRODUCED FOR ANY OTHER PROJECT WITHOUT THE EXPRESS WRITTEN APPROVAL AND PARTICIPATION OF IMEG.
©2025 IMEG CONSULTANTS CORP.
North Carolina Design Registration #F-1507

Susan Hatchell
Landscape Architecture, PLLC
711 W. North Street, Raleigh, NC 27603
p. 919-838-9600 f. 919-838-9700




SHELTER A SLAB
AND FOUNDATION
PLANS

LAKE MYRA COUNTY PARK
Wake County, NC


REVISIONS

Date 07/27/2026

ES-S101

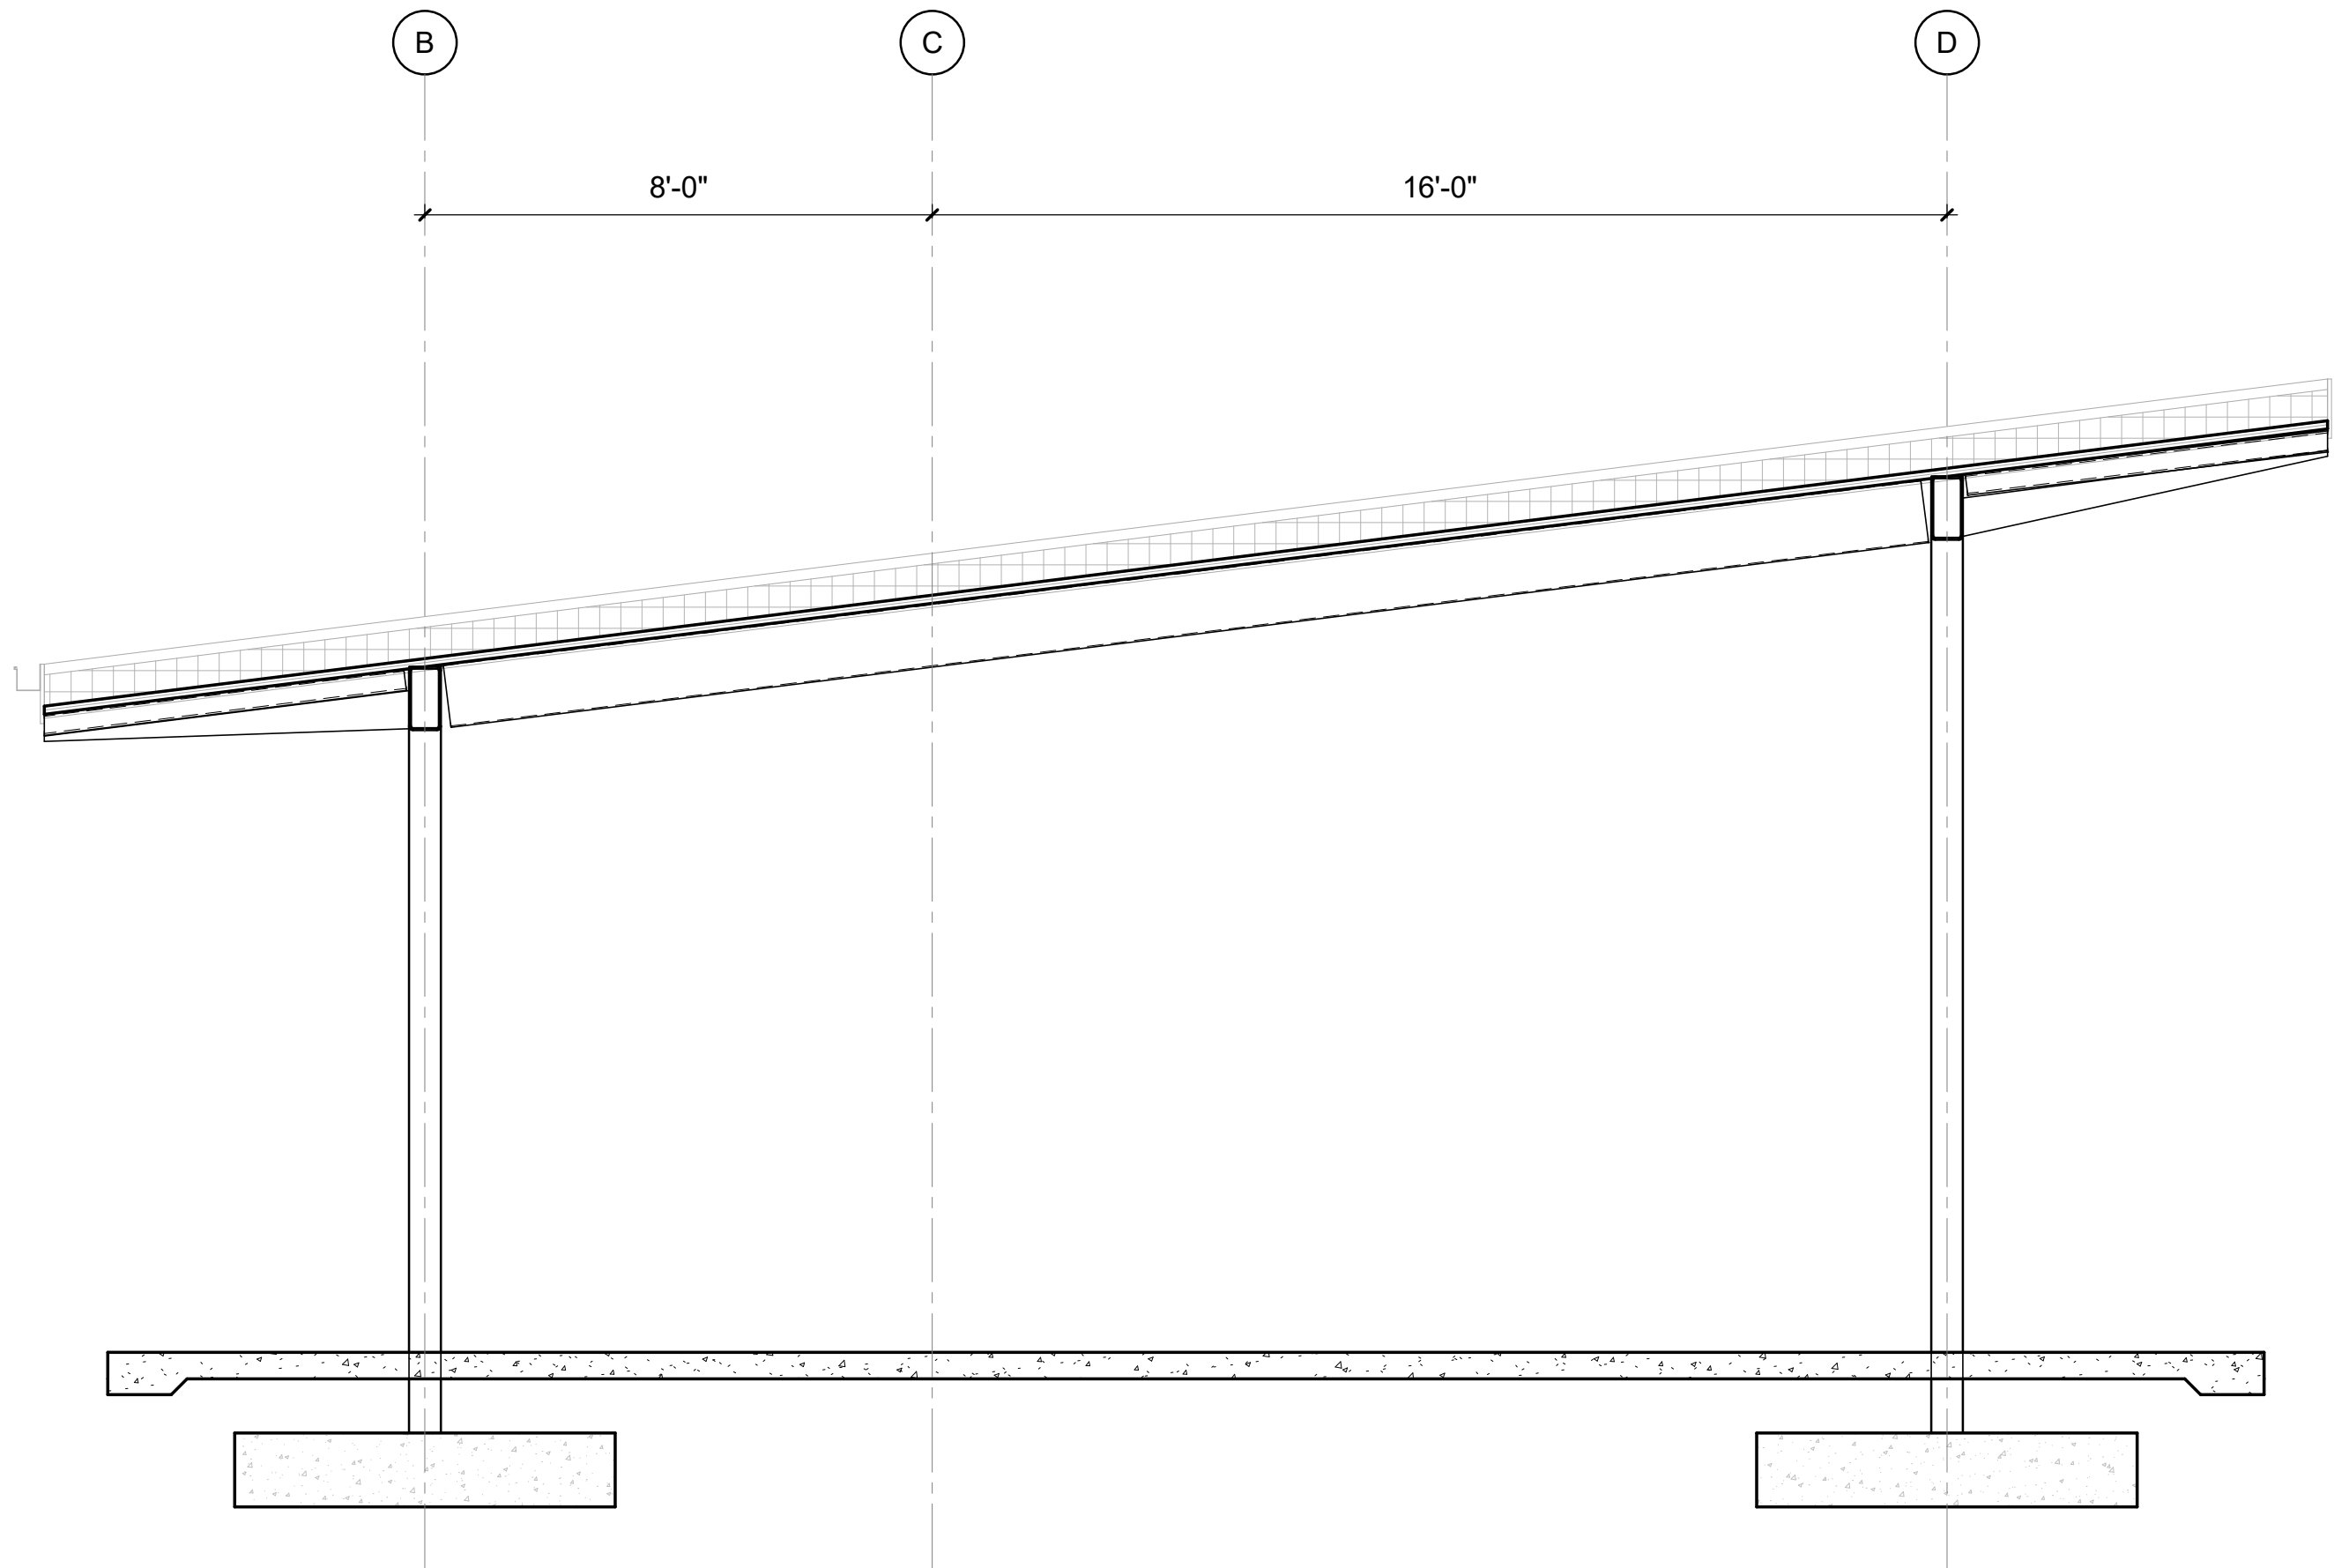

A2 SECTION
3/8" = 1'-0"

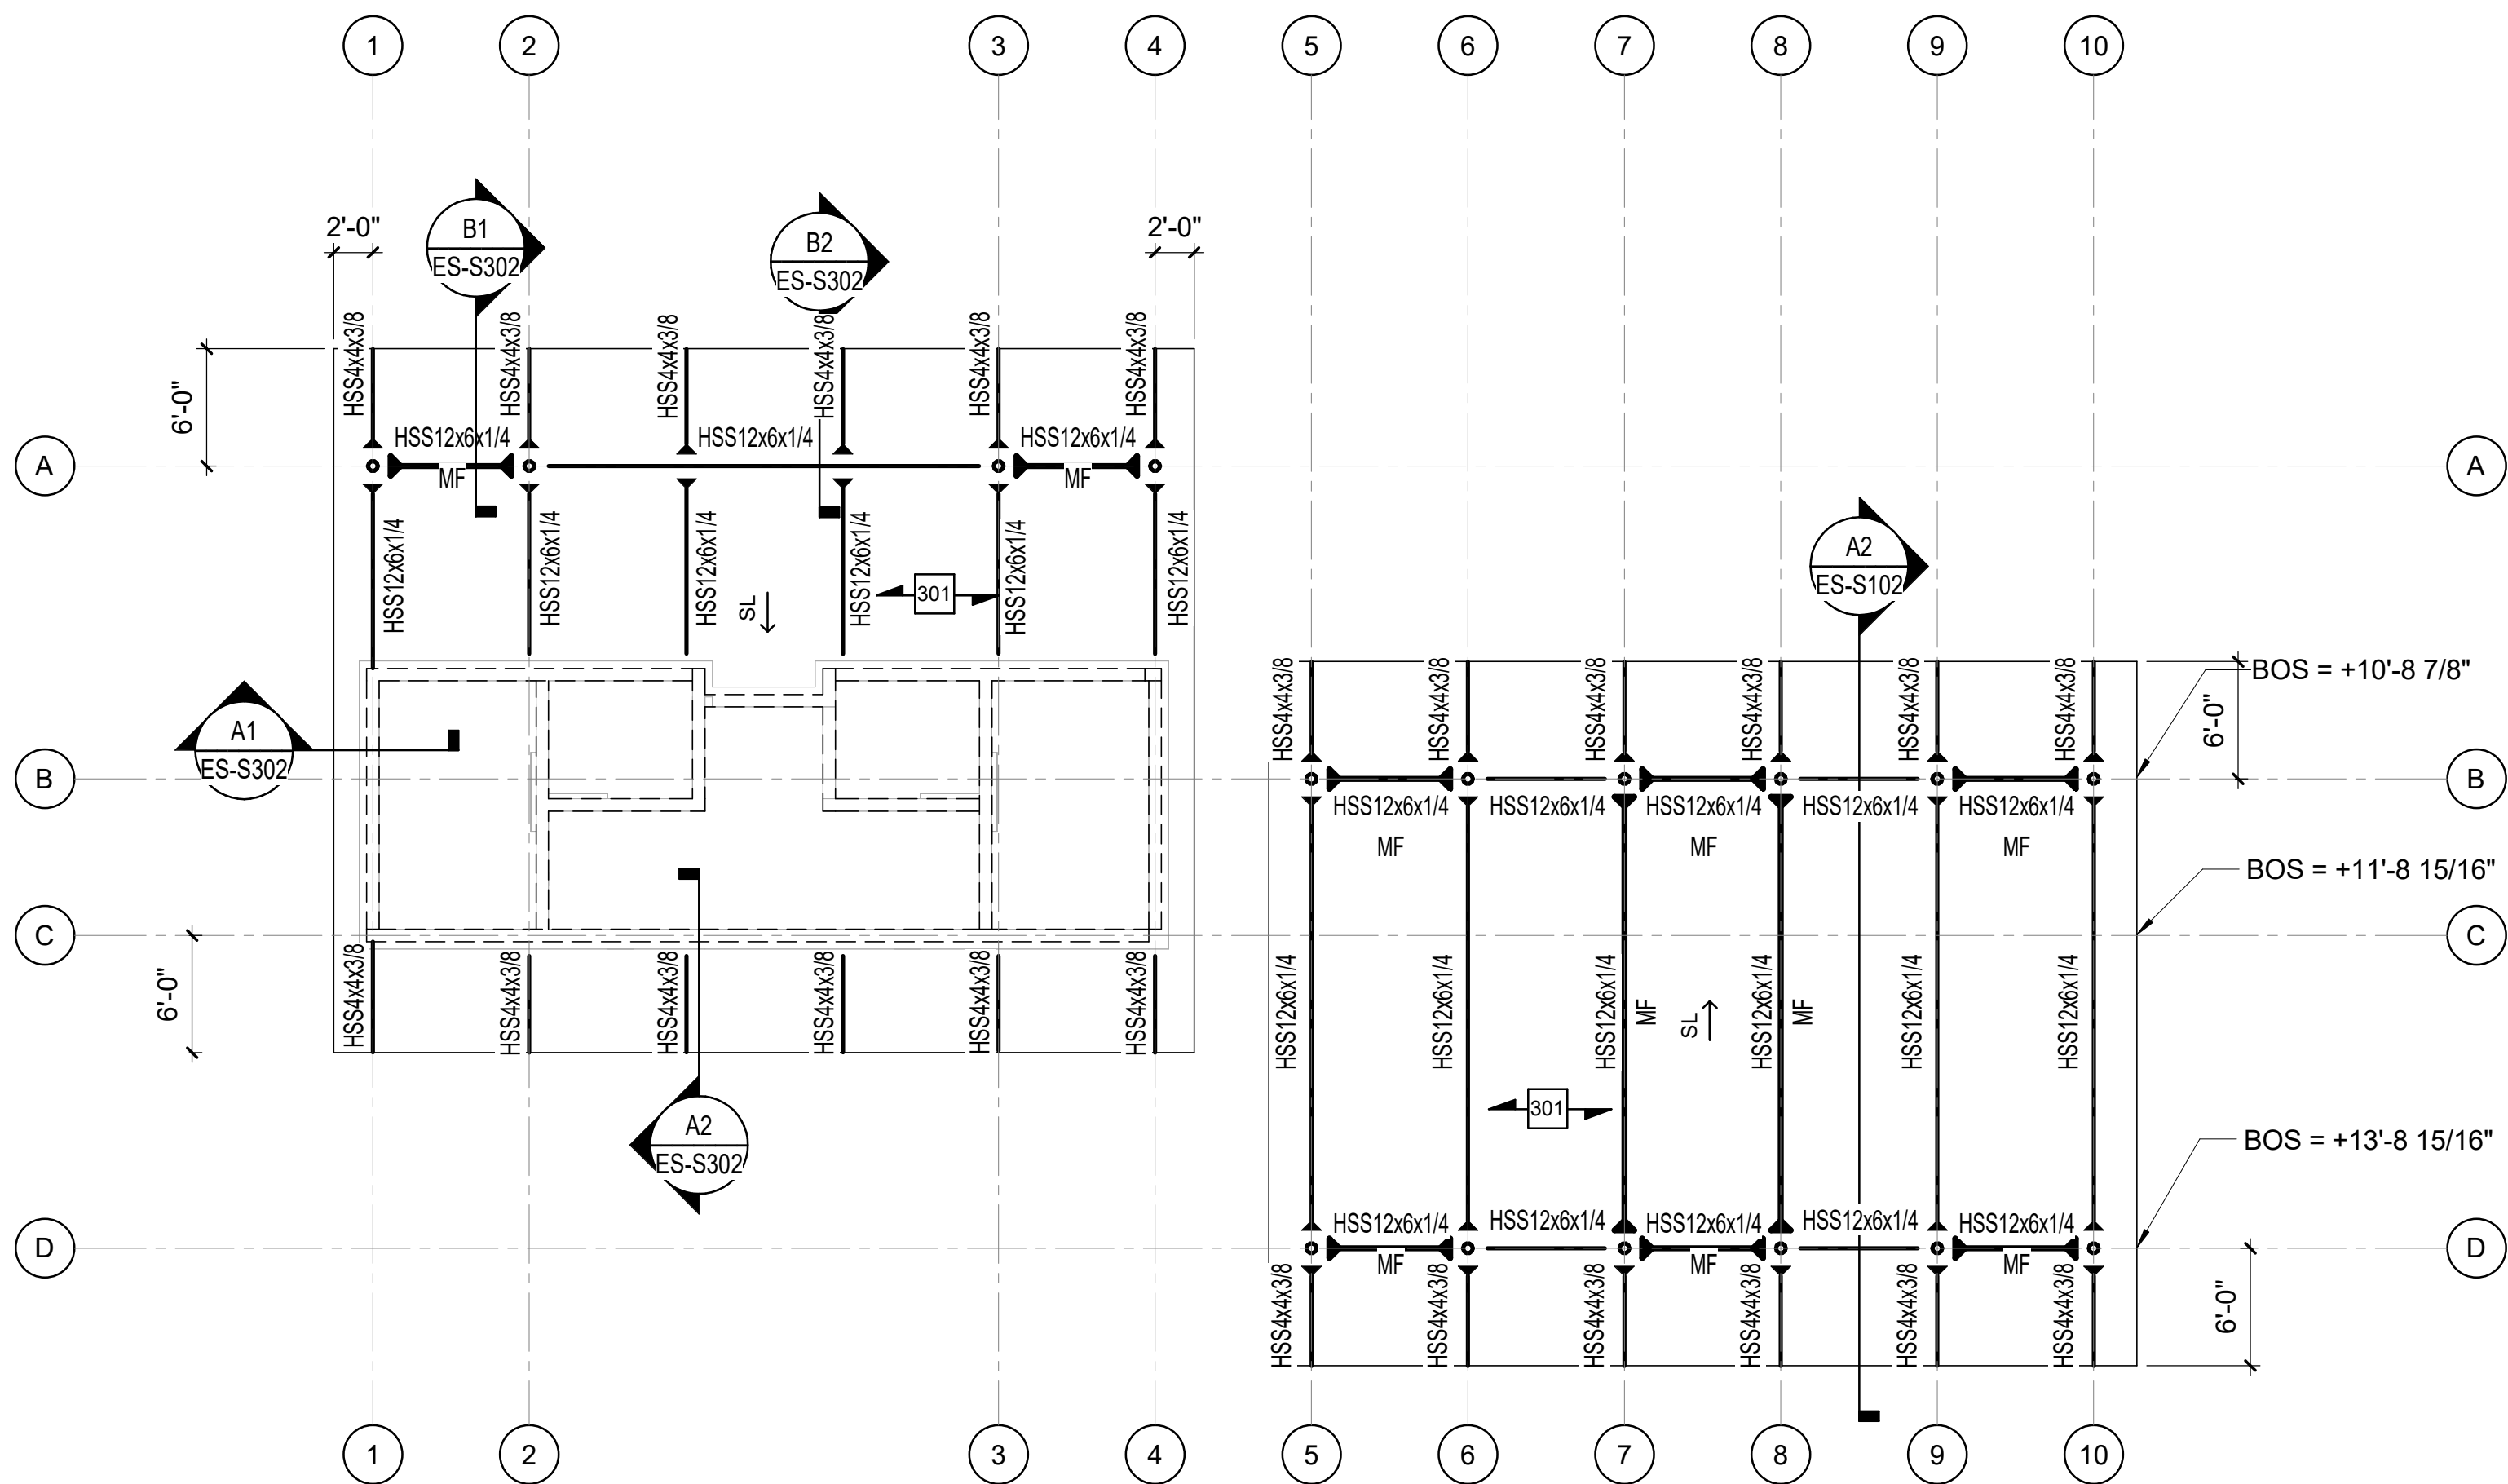


A1 SHELTER BLDG A ROOF PLAN
1/8" = 1'-0"

FRAMING PLAN NOTES

- REFERENCE FOUNDATION PLAN AND ARCHITECTURAL DRAWINGS FOR DIMENSIONS NOT SHOWN.
- TOP OF FINISHED FLOOR ELEVATION MUST BE AS NOTED ON SLAB PLANS.
- COMPOSITE STEEL BEAM FRAMING MUST BE EQUALLY SPACED BETWEEN POINTS OF KNOWN DIMENSIONS (NOT TO EXCEED [10'-0"] ON-CENTER).
- CONCRETE ON ELEVATED METAL DECKS MUST BE POURED TO THE THICKNESS INDICATED.
- AT STEEL ROOF FRAMING, BOTTOM OF DECK ELEVATIONS ARE SHOWN ON PLAN. INTERMEDIATE ELEVATIONS MUST BE STRAIGHT LINES BETWEEN GIVEN ELEVATIONS. INTERPOLATE AS REQUIRED FOR INTERMEDIATE BEARING ELEVATIONS, UNLESS OTHERWISE NOTED.
- COORDINATE AND VERIFY ALL MEMBER LOCATIONS, DIMENSIONS, WEIGHTS, OPENING SIZES, AND CURB DIMENSIONS FOR ALL MECHANICAL EQUIPMENT WITH THE ACTUAL EQUIPMENT FURNISHED. INCLUDE THIS INFORMATION ON THE JOIST AND STRUCTURAL STEEL SHOP DRAWINGS.

KEY NOTES

- 301 2x6 TONGUE AND GROOVE WOOD DECKING WITH 9/16" PLYWOOD.

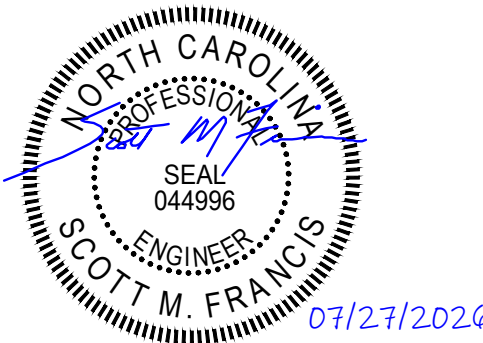

lynchmykins
now **IMEG**

301 N WEST STREET, SUITE 105
RALEIGH, NC 27603
919.782.1833 www.imegcorp.com

IMEG RESERVES PROPRIETARY RIGHTS, INCLUDING COPYRIGHTS, TO THIS DRAWING AND THE DATA SHOWN THEREON. SAID DRAWING AND/OR DATA ARE THE EXCLUSIVE PROPERTY OF IMEG AND SHALL NOT BE USED OR REPRODUCED FOR ANY OTHER PROJECT WITHOUT THE EXPRESS WRITTEN APPROVAL AND PARTICIPATION OF IMEG. ©2025 IMEG CONSULTANTS CORP. North Carolina Design Registration #F-1507

Susan Hatchell
Landscape Architecture, PLLC
711 W. North Street, Raleigh, NC 27603
p: 919-838-9600 f: 919-838-9700




**SHELTER A AND B
ROOF FRAMING
PLAN**

LAKE MYRA COUNTY PARK
Wake County, NC


REVISIONS

Date 07/27/2026


ES-S102

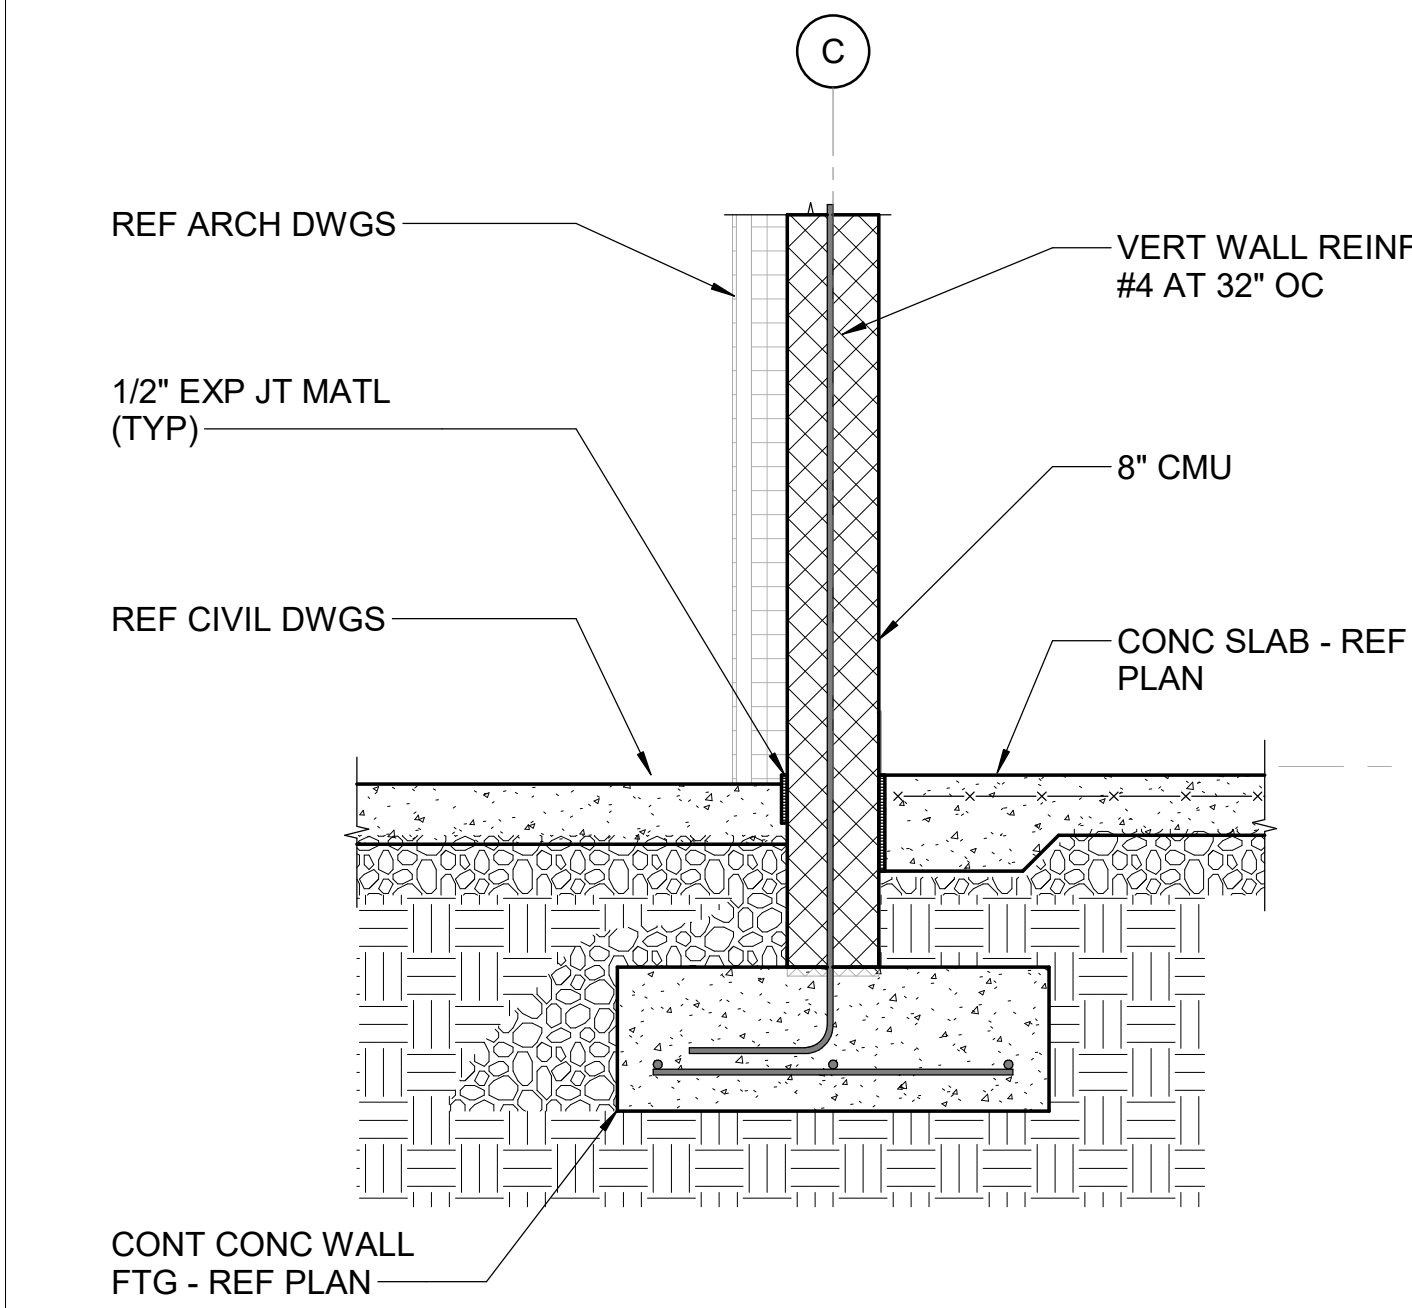


A1 SECTION
3/4" = 1'-0"

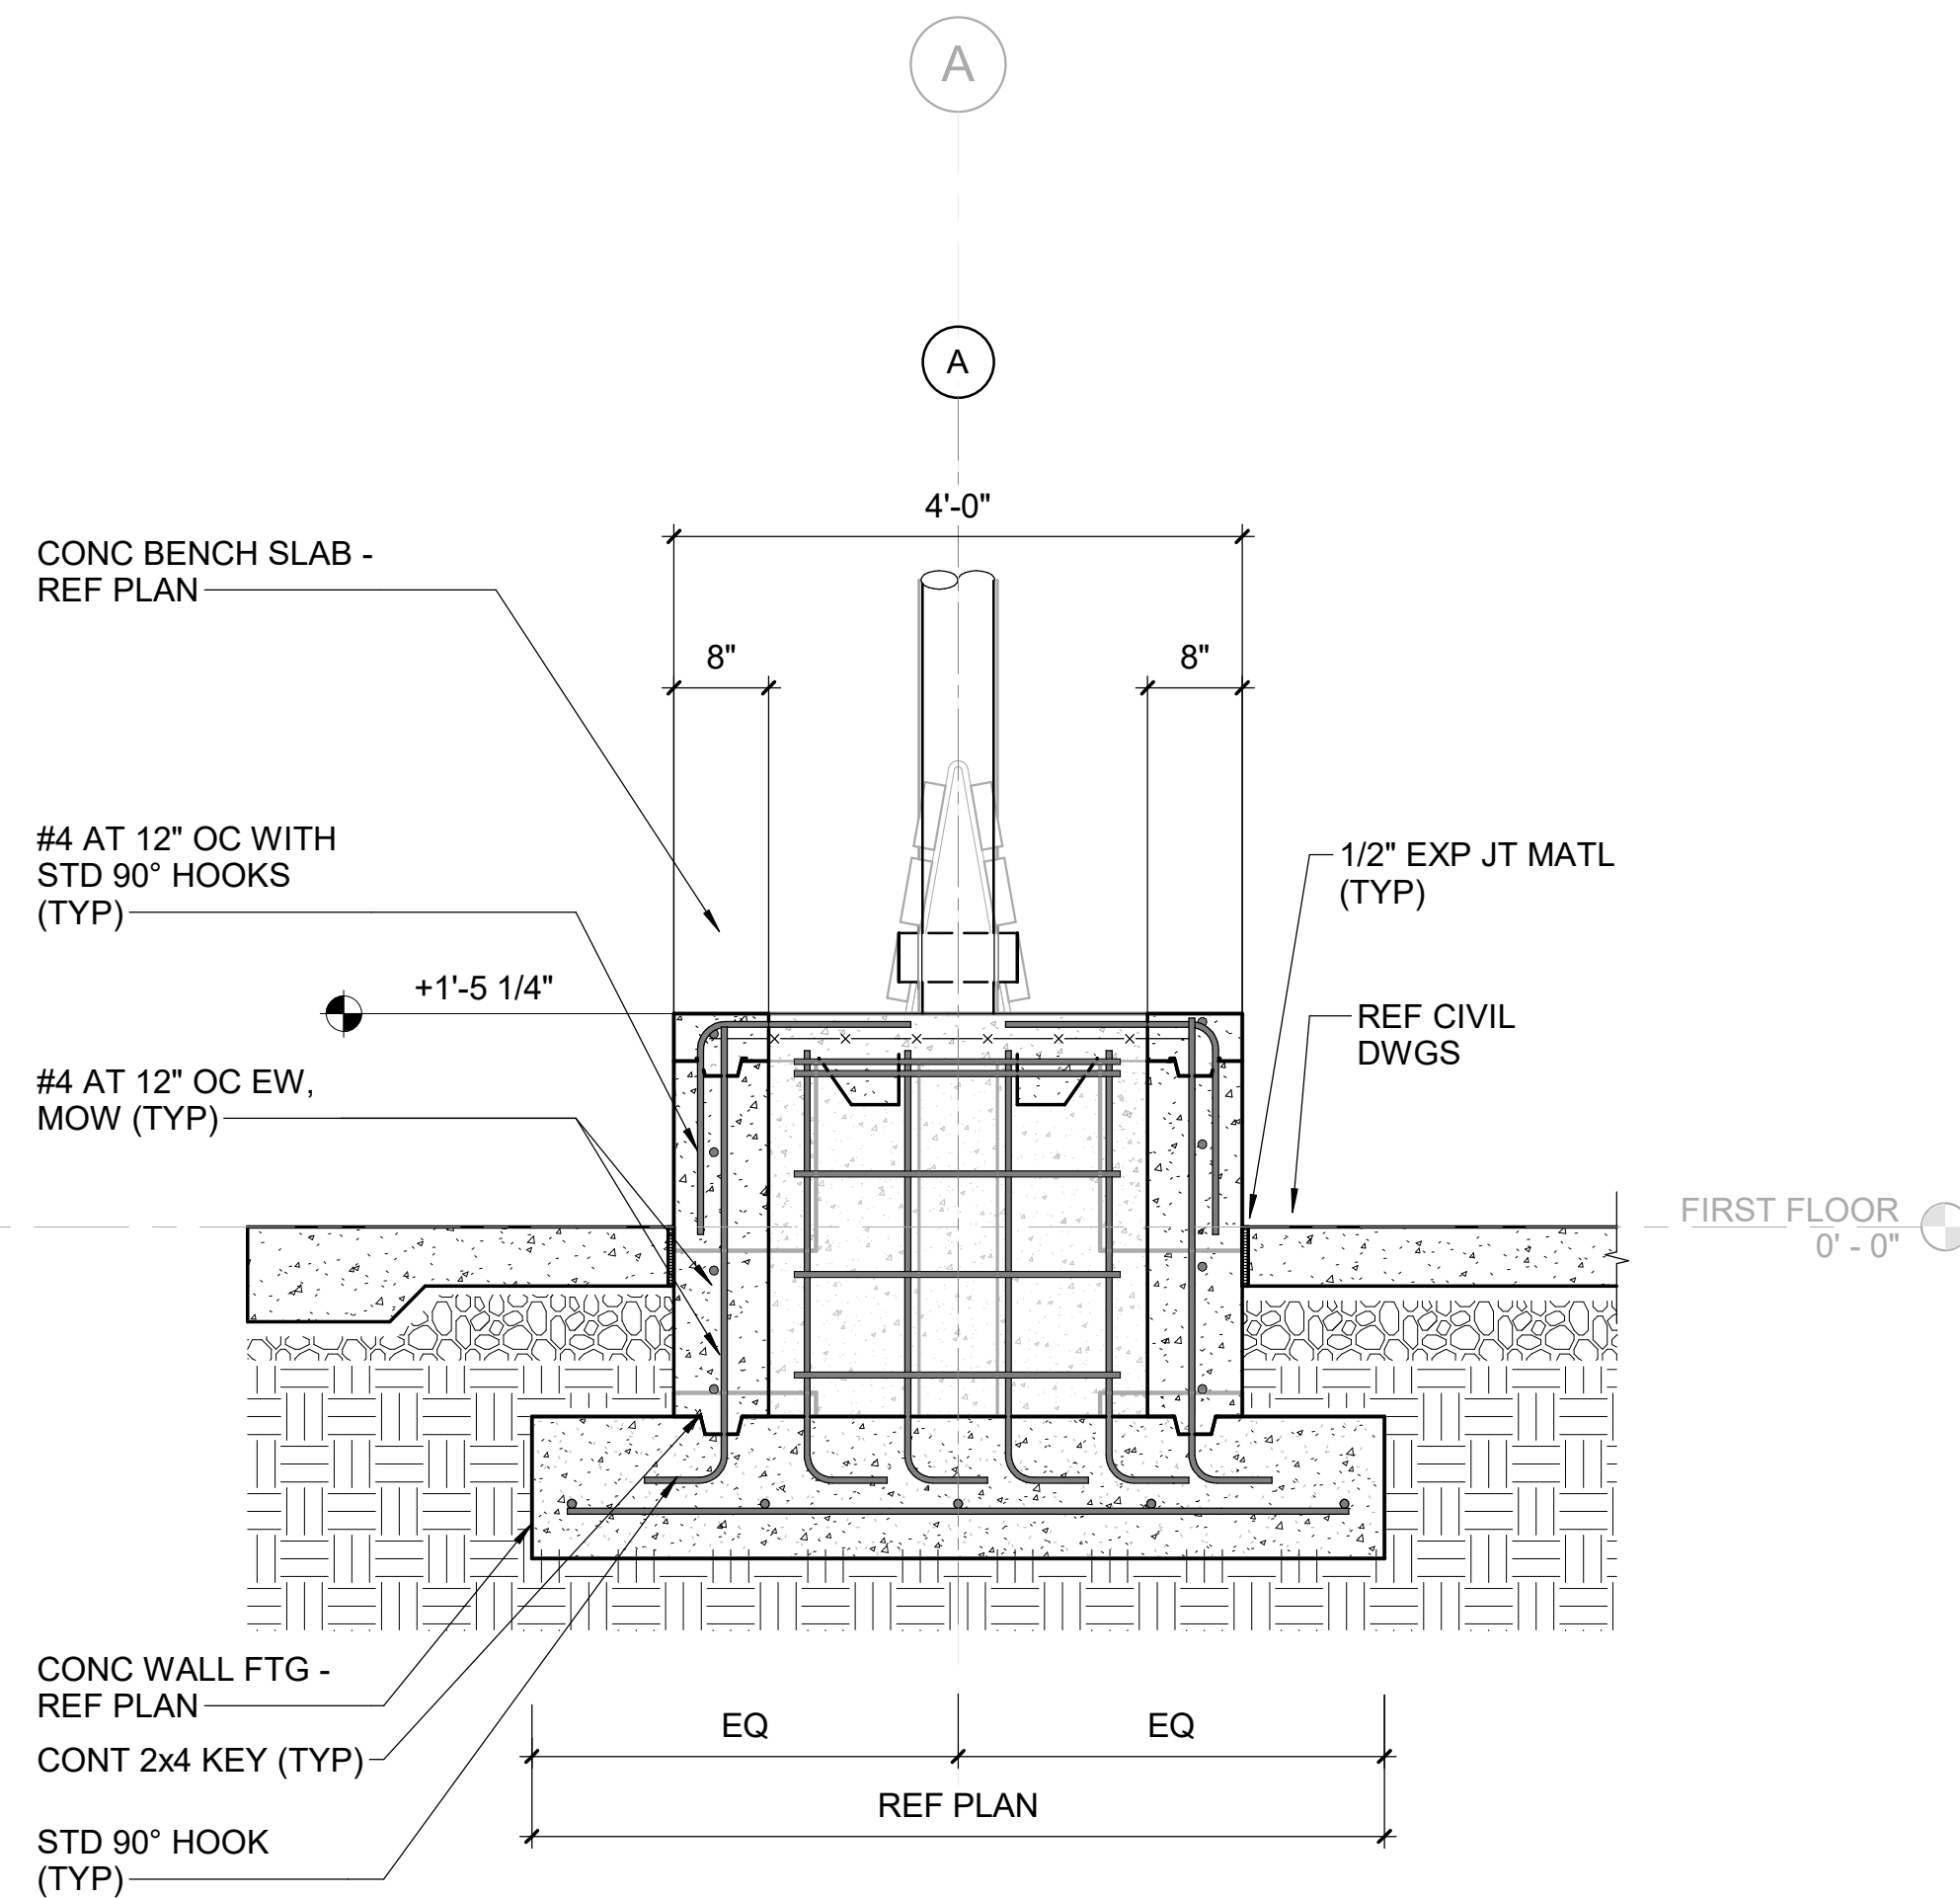

A2 SECTION
3/4" = 1'-0"

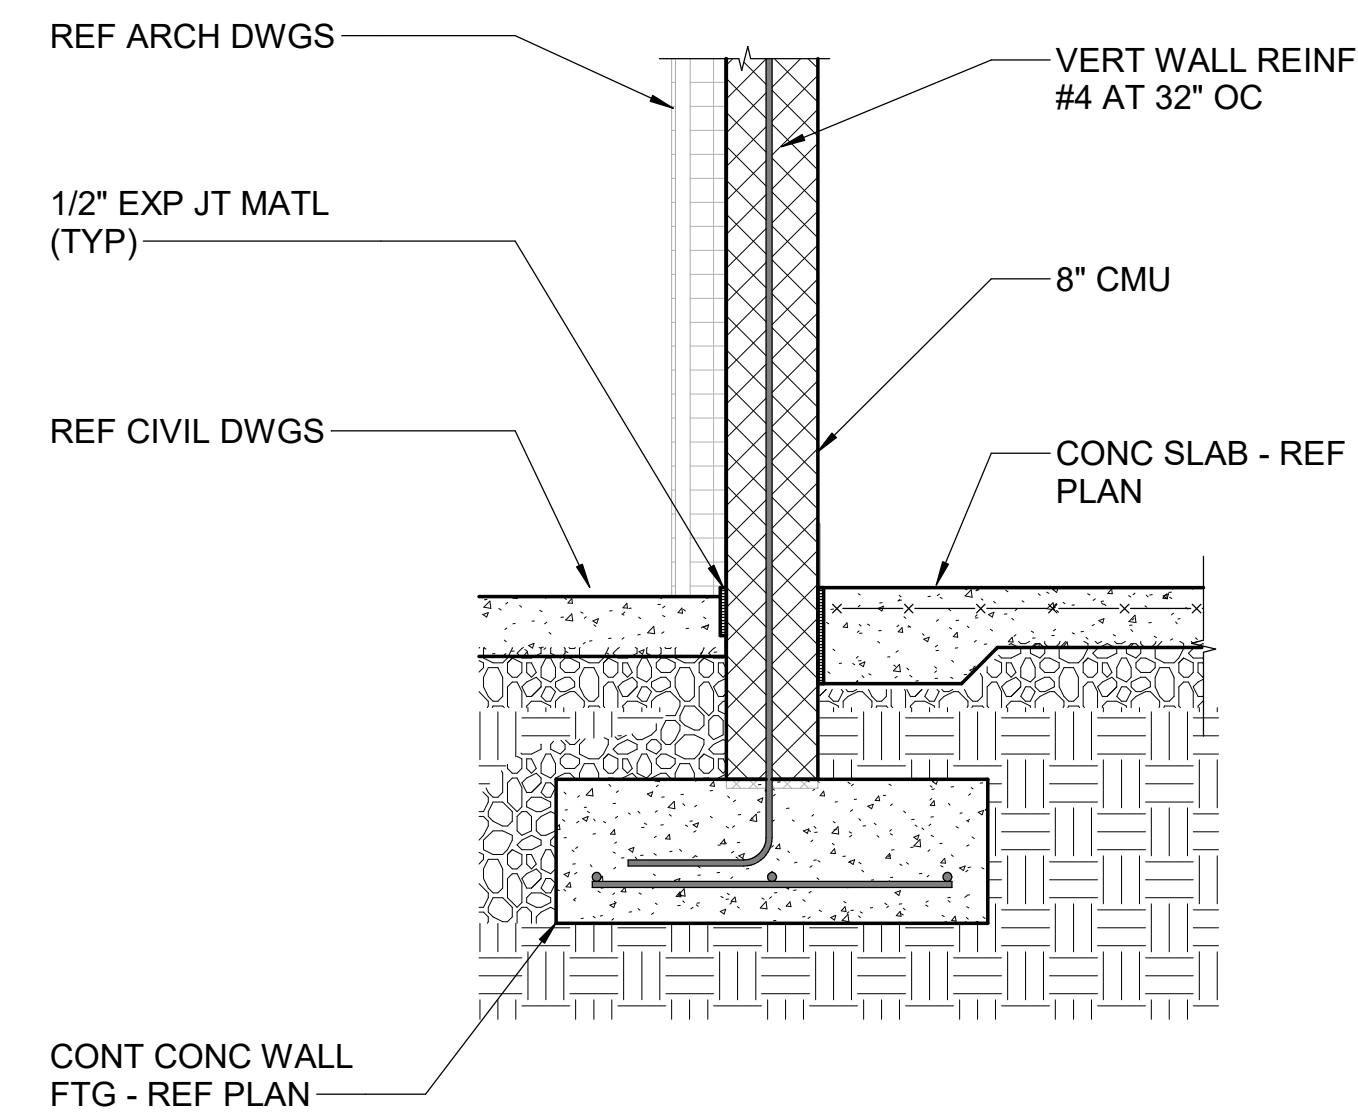

A3 SECTION
3/4" = 1'-0"

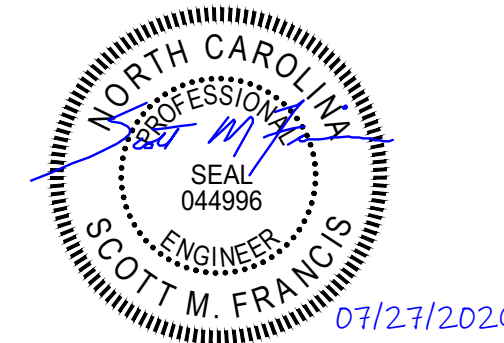


now 
 301 N WEST STREET, SUITE 105
 RALEIGH, NC 27603
 919.782.1833 www.imegcorp.com
IMEG RESERVES PROPRIETARY RIGHTS, INCLUDING COPYRIGHTS, TO THIS DRAWING AND THE DATA SHOWN THEREON. SAID DRAWING AND/OR DATA ARE THE EXCLUSIVE PROPERTY OF IMEG AND SHALL NOT BE USED OR REPRODUCED FOR ANY OTHER PROJECT WITHOUT THE EXPRESS WRITTEN APPROVAL AND PARTICIPATION OF IMEG. ©2025 IMEG CONSULTANTS CORP. North Carolina Design Registration #F-1507

SECTIONS

LAKE MYRA COUNTY PARK Wake County, NC


REVISIONS

Date 07/27/2026

ES-S301


Susan Hatchell
 Landscape Architecture, PLLC
 711 W. North Street, Raleigh, NC 27603
 p: 919-838-9600 f: 919-838-9700


now 
 301 N WEST STREET, SUITE 105
 RALEIGH, NC 27603
 919.782.1833 www.imegcorp.com

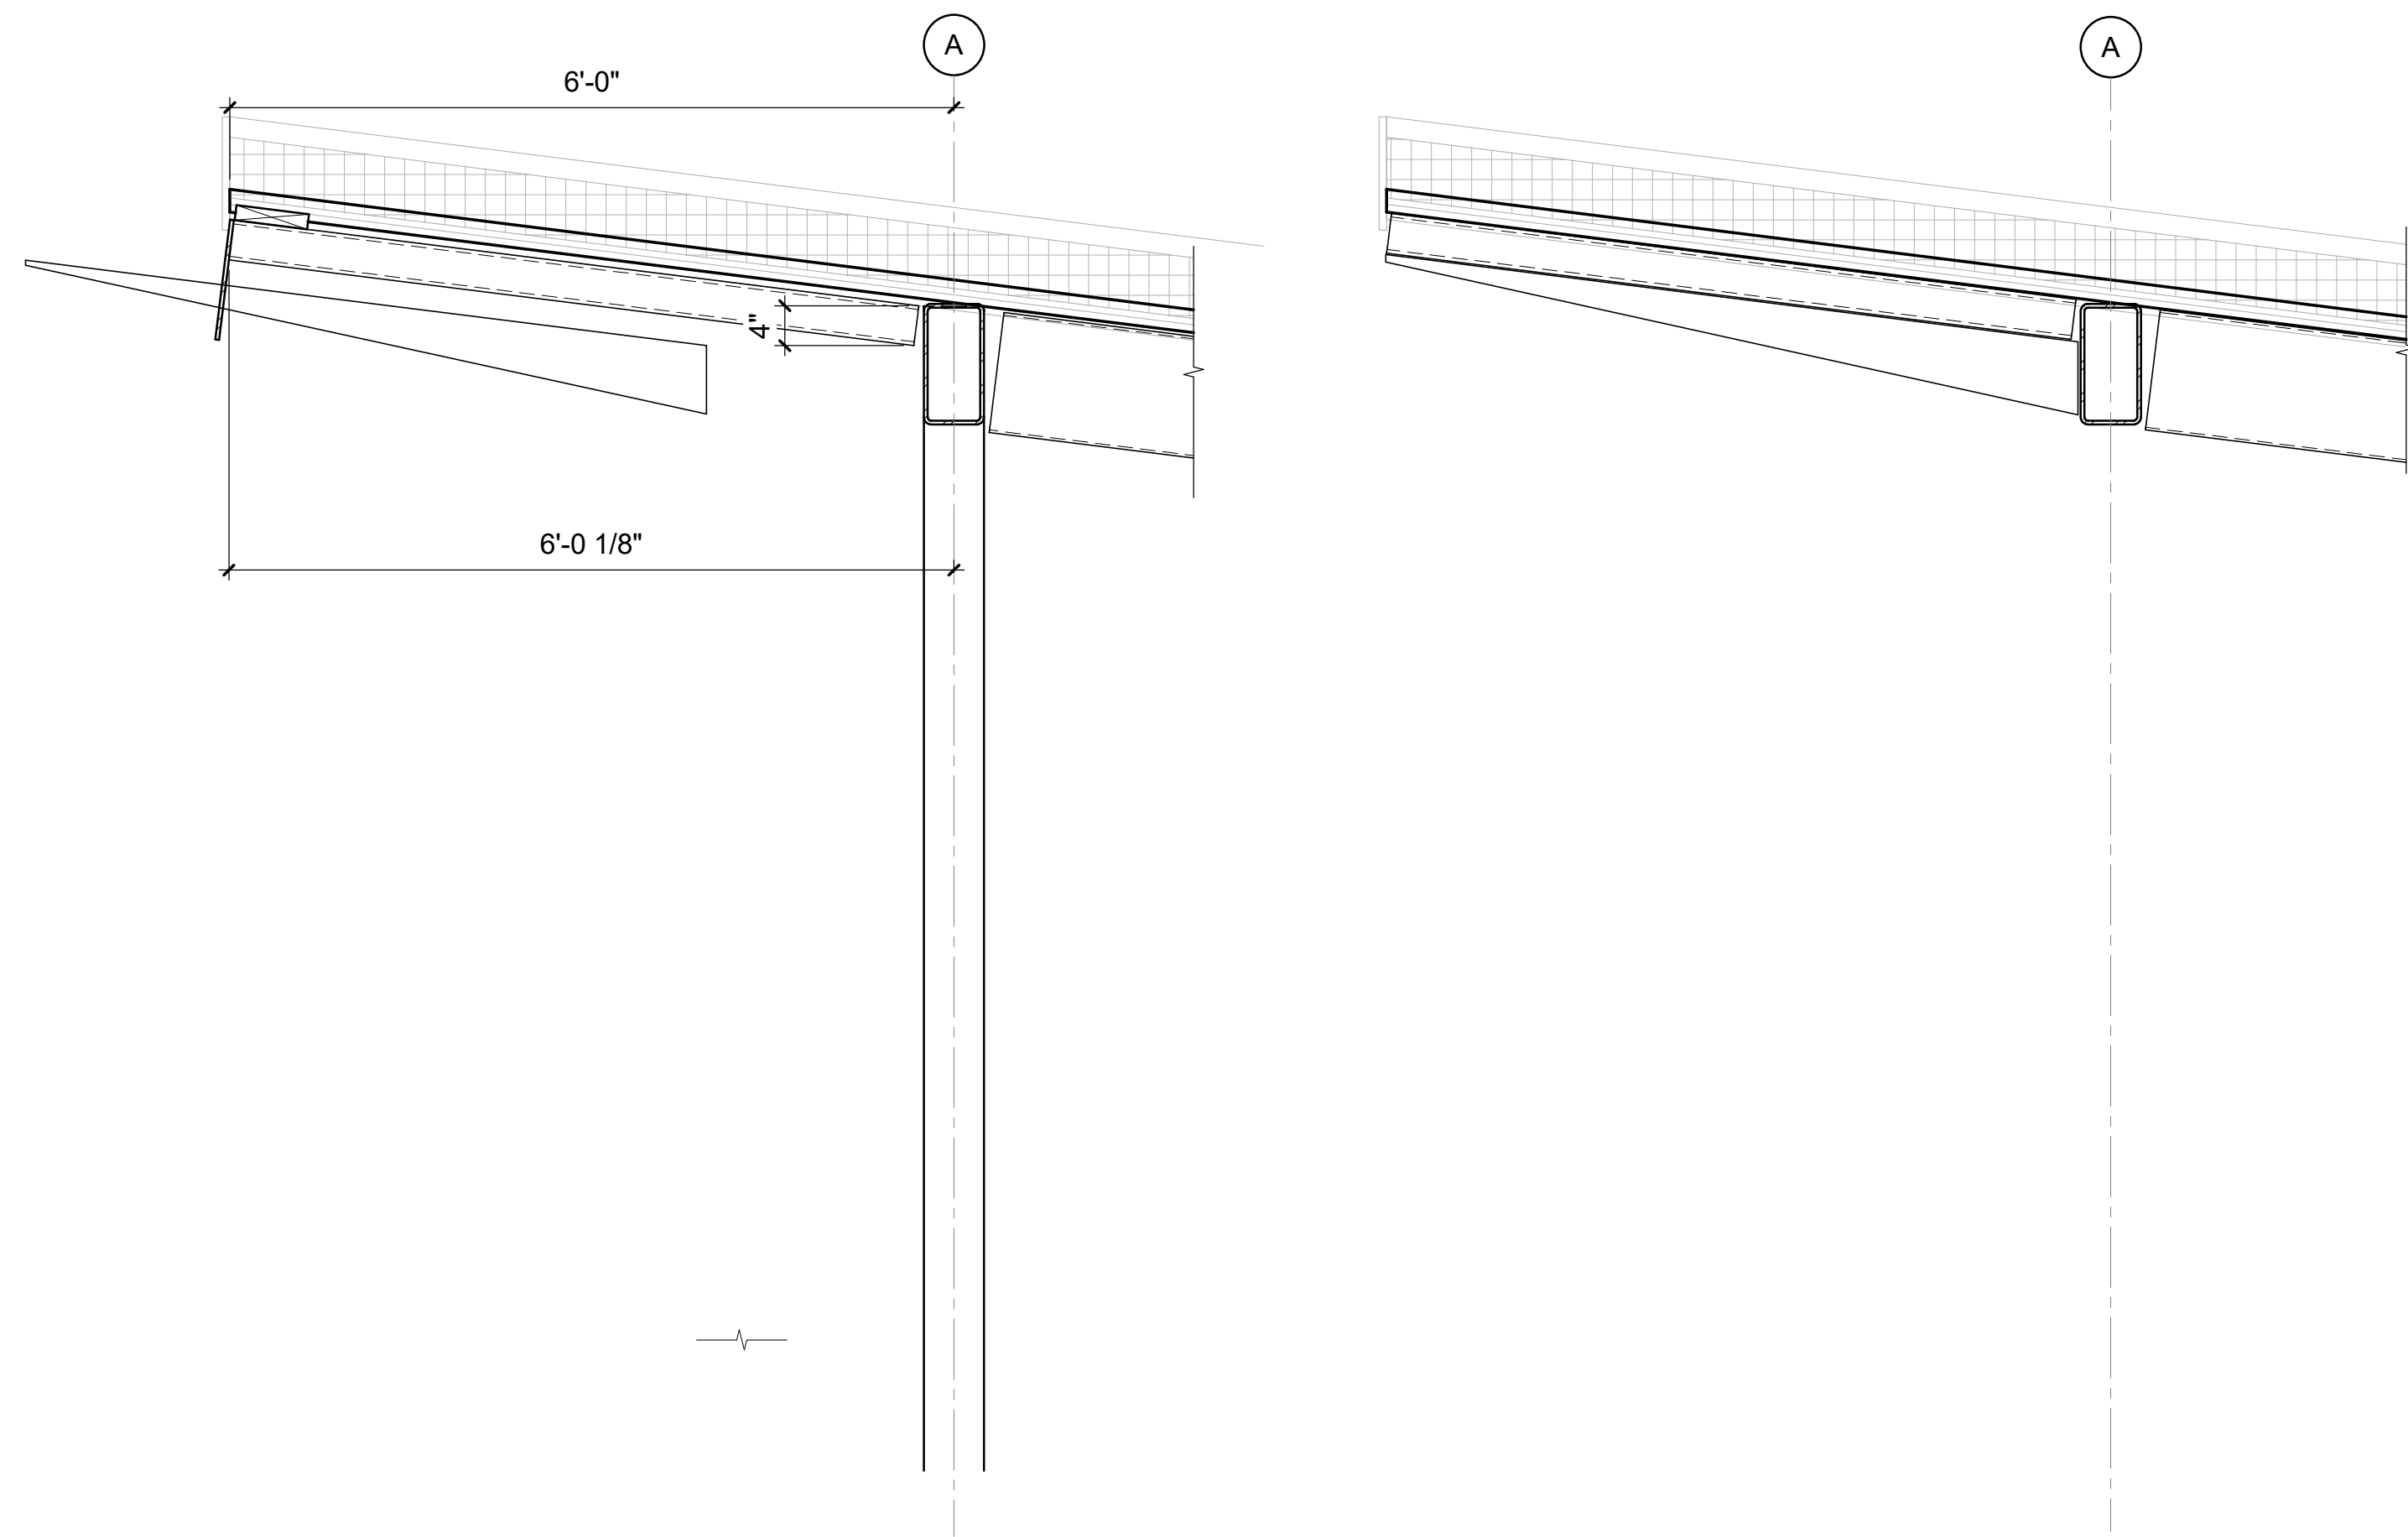


B1 SECTION
3/4" = 1'-0"

B2 SECTION
3/4" = 1'-0"

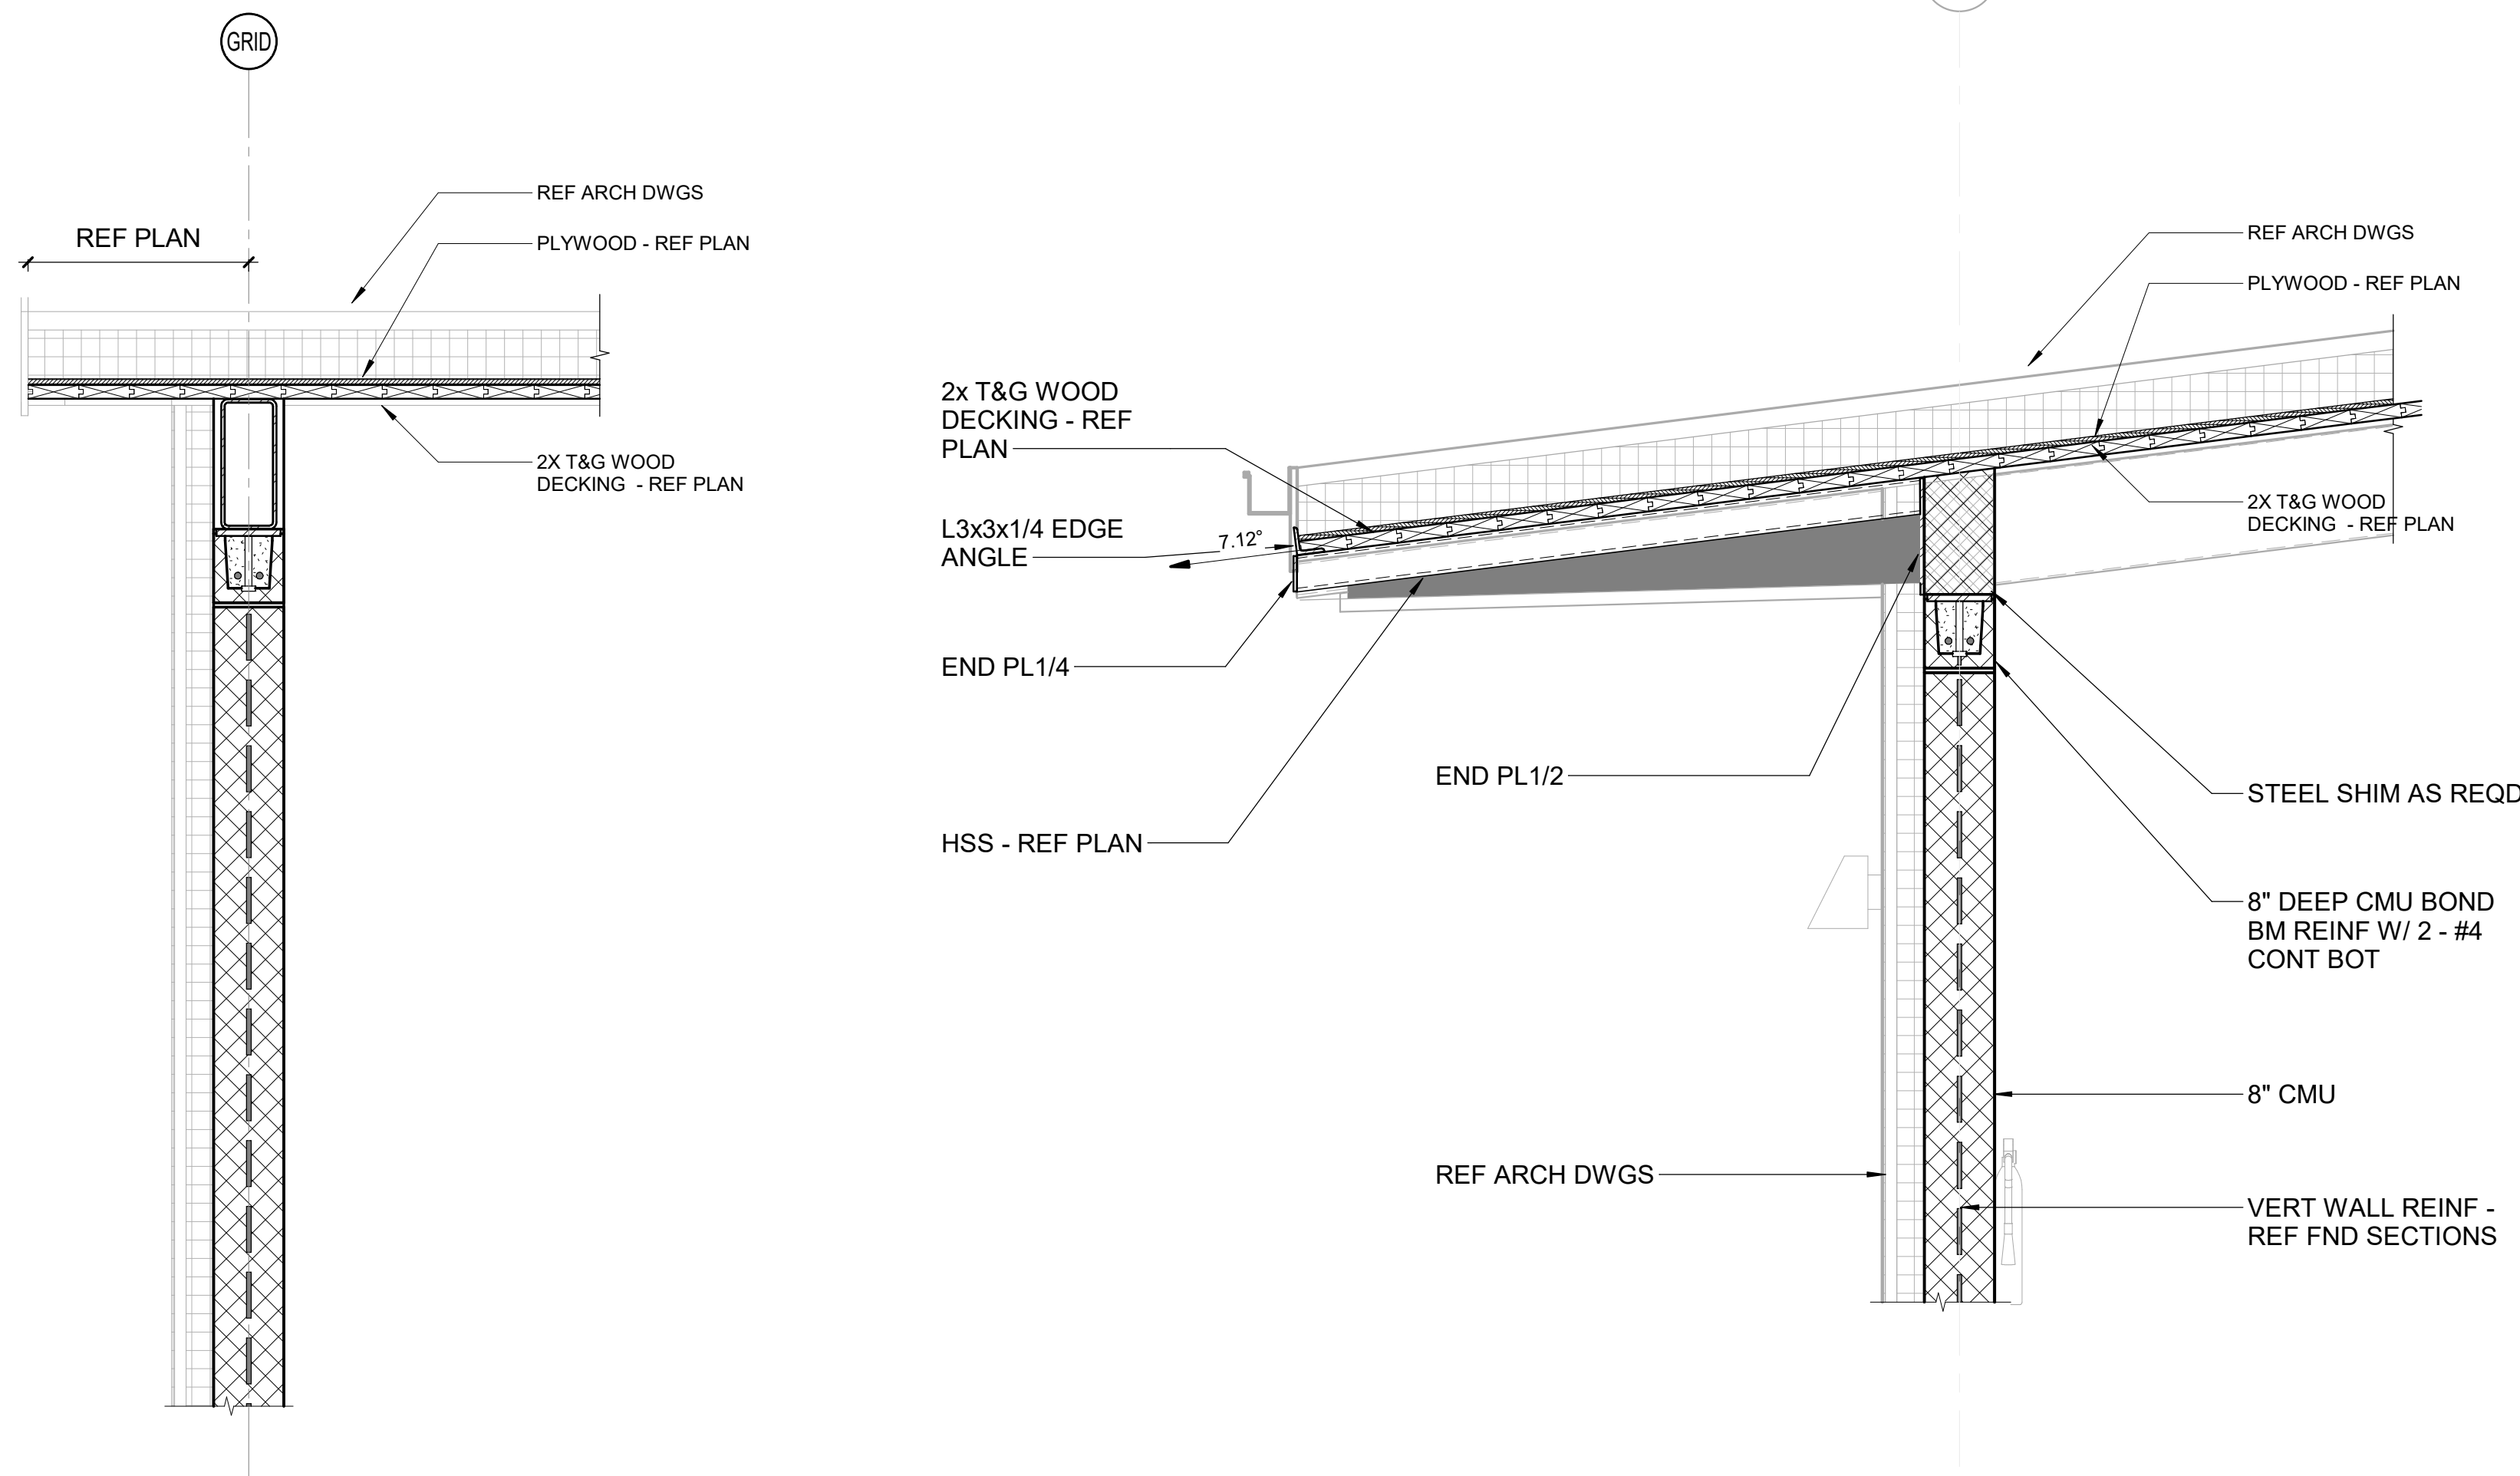

A1 SECTION
3/4" = 1'-0"

A2 SECTION
3/4" = 1'-0"

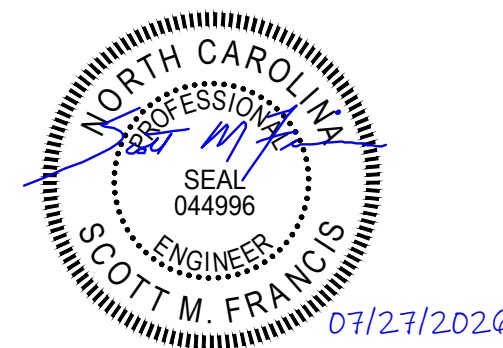

IMEG RESERVES PROPRIETARY RIGHTS, INCLUDING COPYRIGHTS, TO THIS DRAWING AND THE DATA SHOWN THEREON. SAID DRAWING AND/OR DATA ARE THE EXCLUSIVE PROPERTY OF IMEG AND SHALL NOT BE USED OR REPRODUCED FOR ANY OTHER PROJECT WITHOUT THE EXPRESS WRITTEN APPROVAL AND PARTICIPATION OF IMEG. ©2025 IMEG CONSULTANTS CORP. North Carolina Design Registration #F-1507

Susan Hatchell
Landscape Architecture, PLLC
711 W. North Street, Raleigh, NC 27603
p: 919-838-9600 f: 919-838-9700




SECTIONS

LAKE MYRA COUNTY PARK
Wake County, NC


REVISIONS

Date 07/27/2026

ES-S302

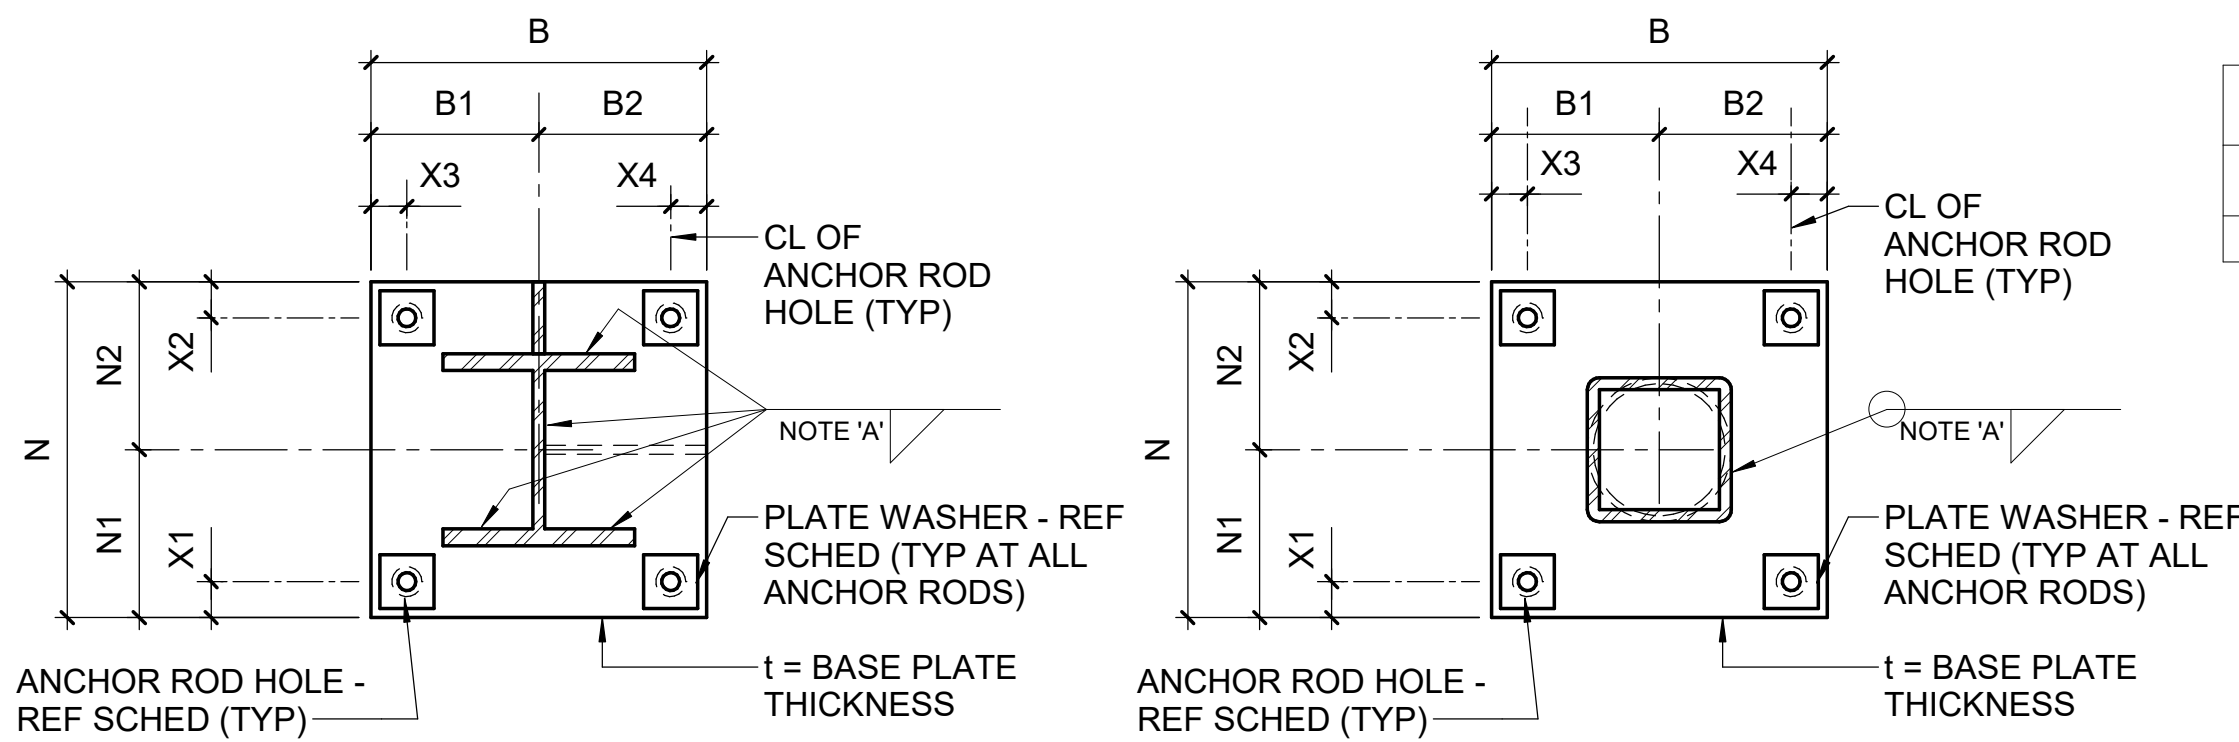


COLUMN BASE PLATE SCHEDULE - GRAVITY COLUMNS															
MARK	BASE PLATE DIMENSIONS										ANCHOR RODS			REMARKS	
	B	N	t	B1	B2	N1	N2	X1	X2	X3	X4	DIAMETER	QUANTITY		EMBED
BPG-1	16"	16"	3/4"	8"	8"	8"	8"	1 1/2"	1 1/2"	1 1/2"	1 1/2"	3/4"	4	9"	

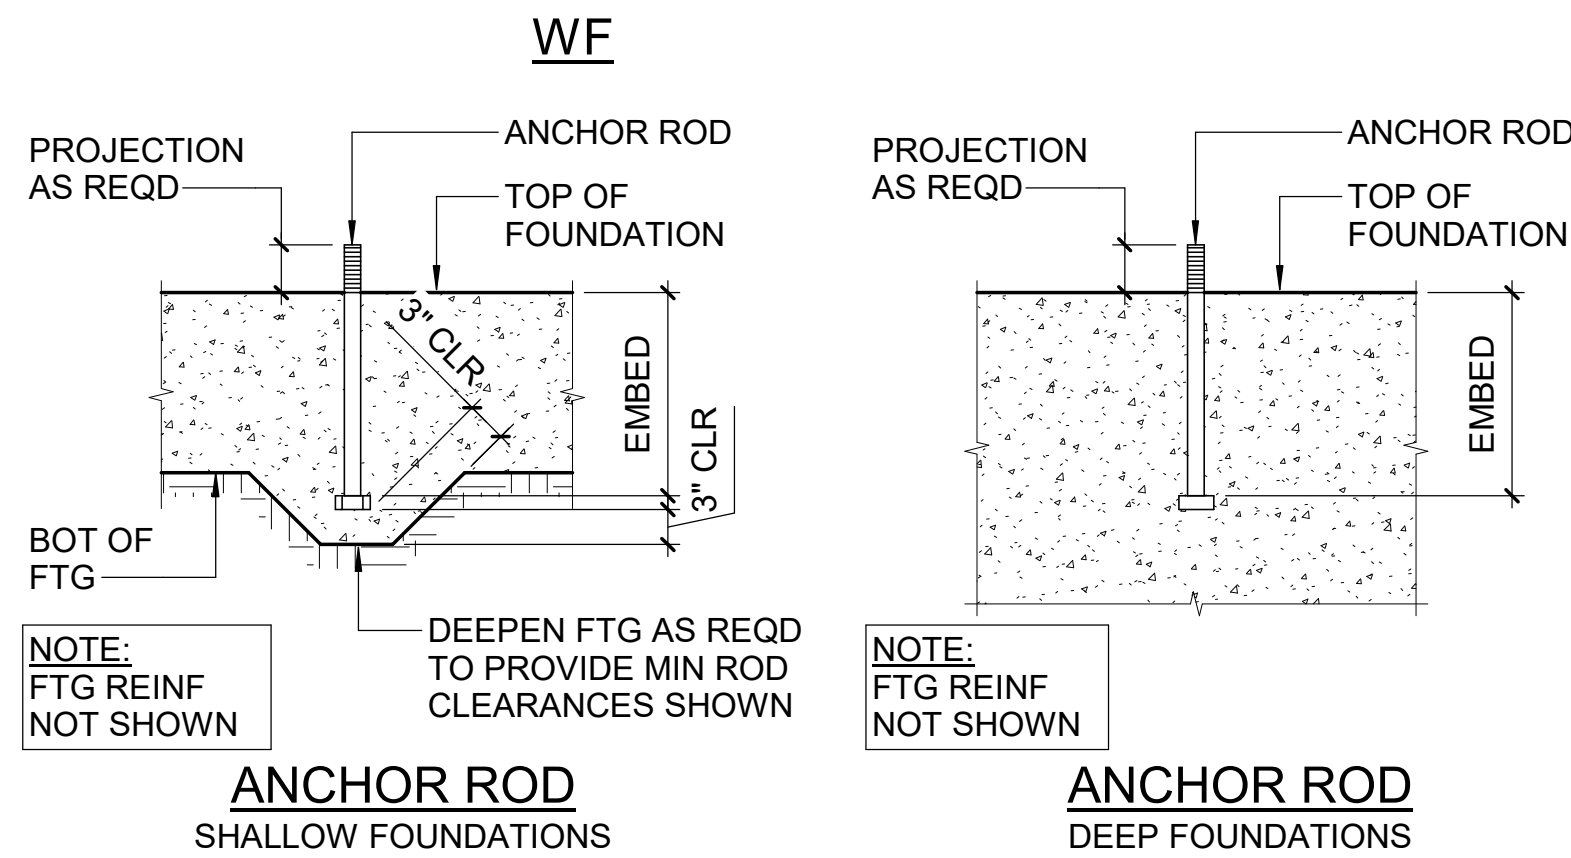





ANCHOR ROD HOLES AND WASHER SCHEDULE						
ANCHOR ROD	OVERSIZED HOLE WITH PLATE WASHER				STANDARD HOLE	
	BASE PLATE HOLE	WASHER SIZE	WASHER HOLE	WASHER THICKNESS	BASE PLATE HOLE	WASHER
3/4"Ø	1 5/16"Ø	2" SQ	13/16"Ø	1/4"	1 1/16"Ø	ASTM F844
1"Ø	1 13/16"Ø	3" SQ	1 1/16"Ø	3/8"	1 1/2"Ø	ASTM F844

NOTE:
A. PROVIDE MINIMUM SIZE WELD PER AISC TABLE J2.4.
B. GENERAL CONTRACTOR'S OPTION TO USE STANDARD OR OVERSIZED HOLES IN GRAVITY COLUMN BASE PLATES. NO WELDING REQUIRED AT PLATE WASHERS USED WITH OVERSIZED HOLES.

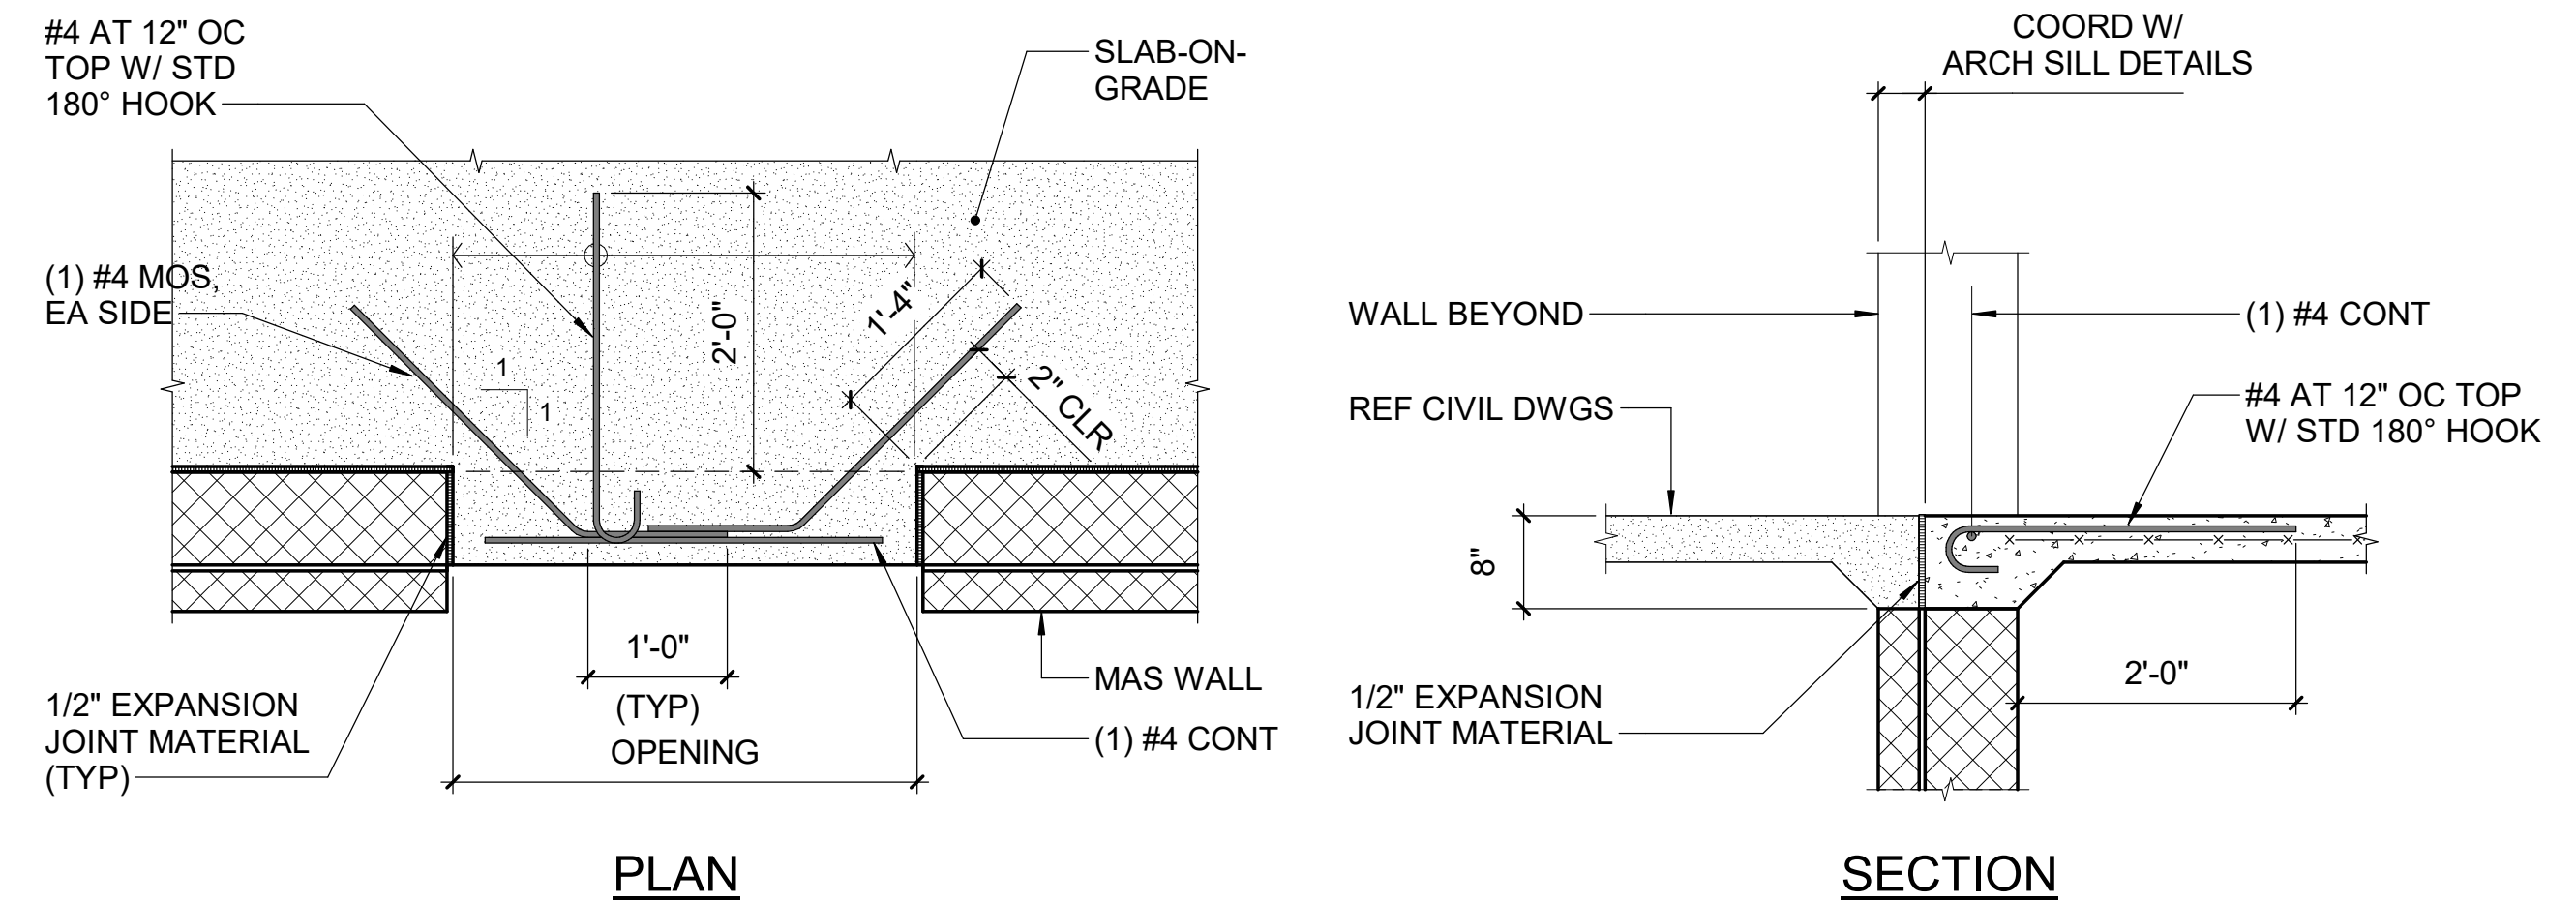

C1 GRAVITY COLUMN BASE PLATE AND ANCHOR ROD DETAILS
NTS

C2 TYPICAL EXTERIOR DOORS / OPENINGS DETAIL
NTS

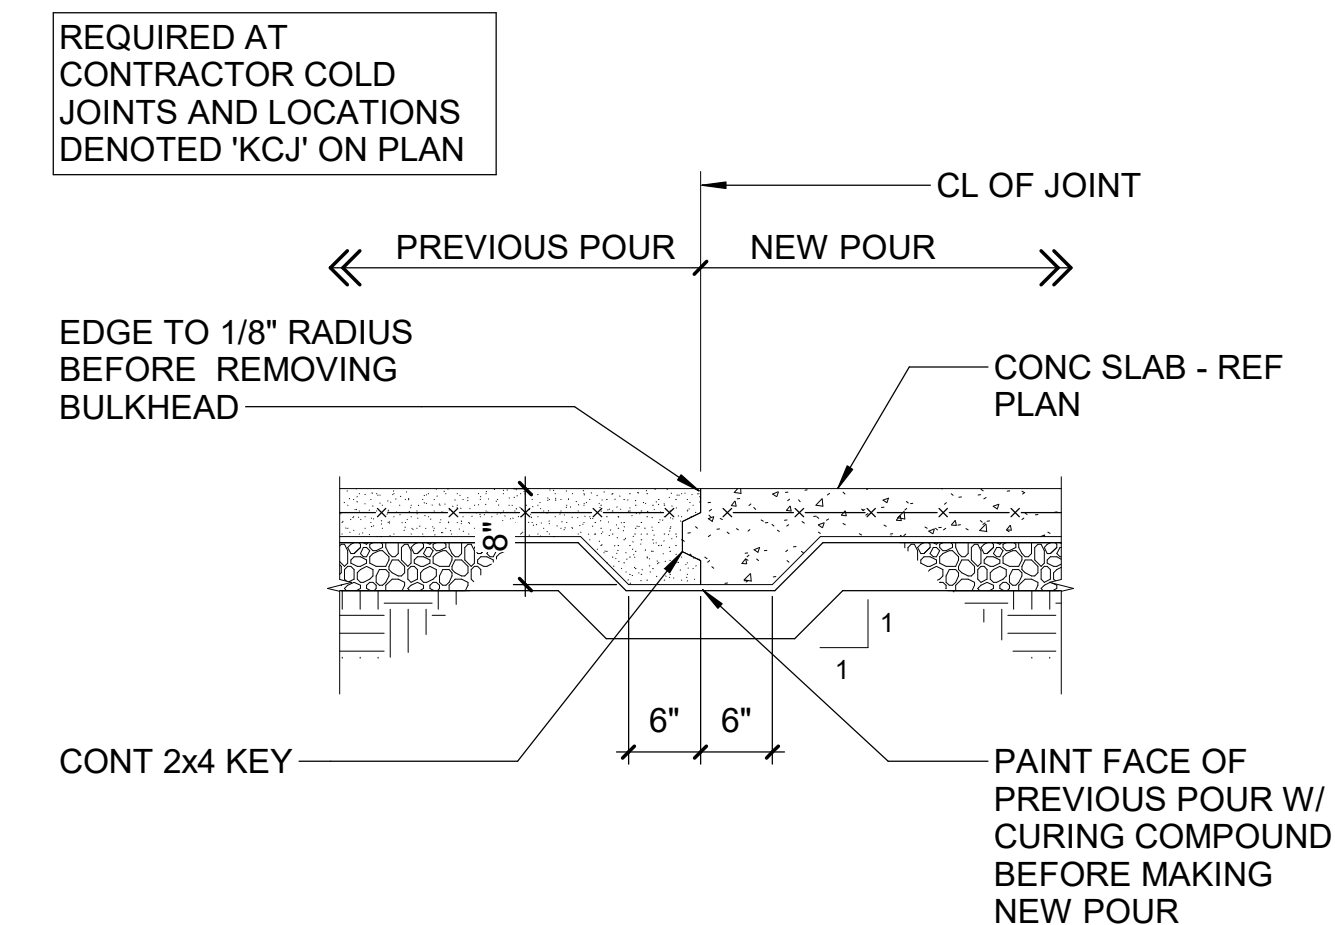
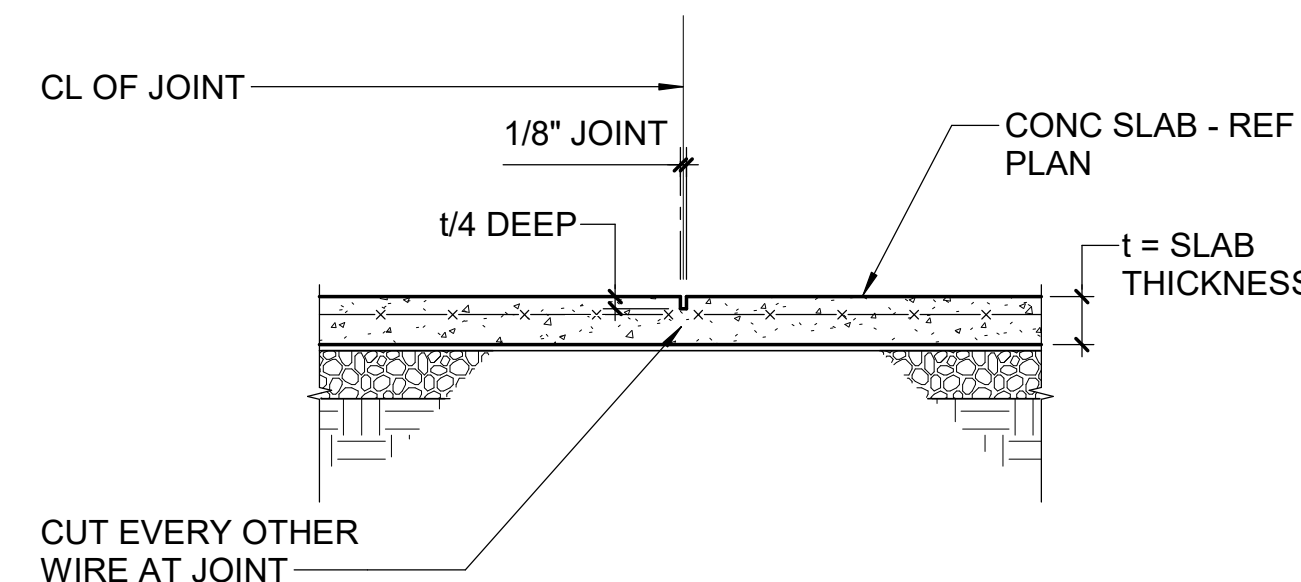
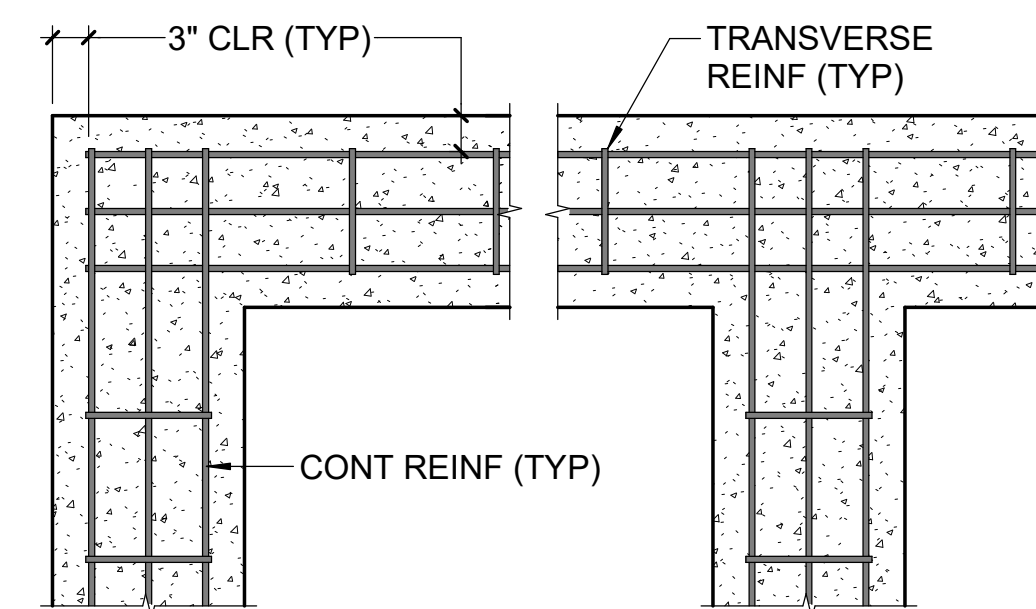
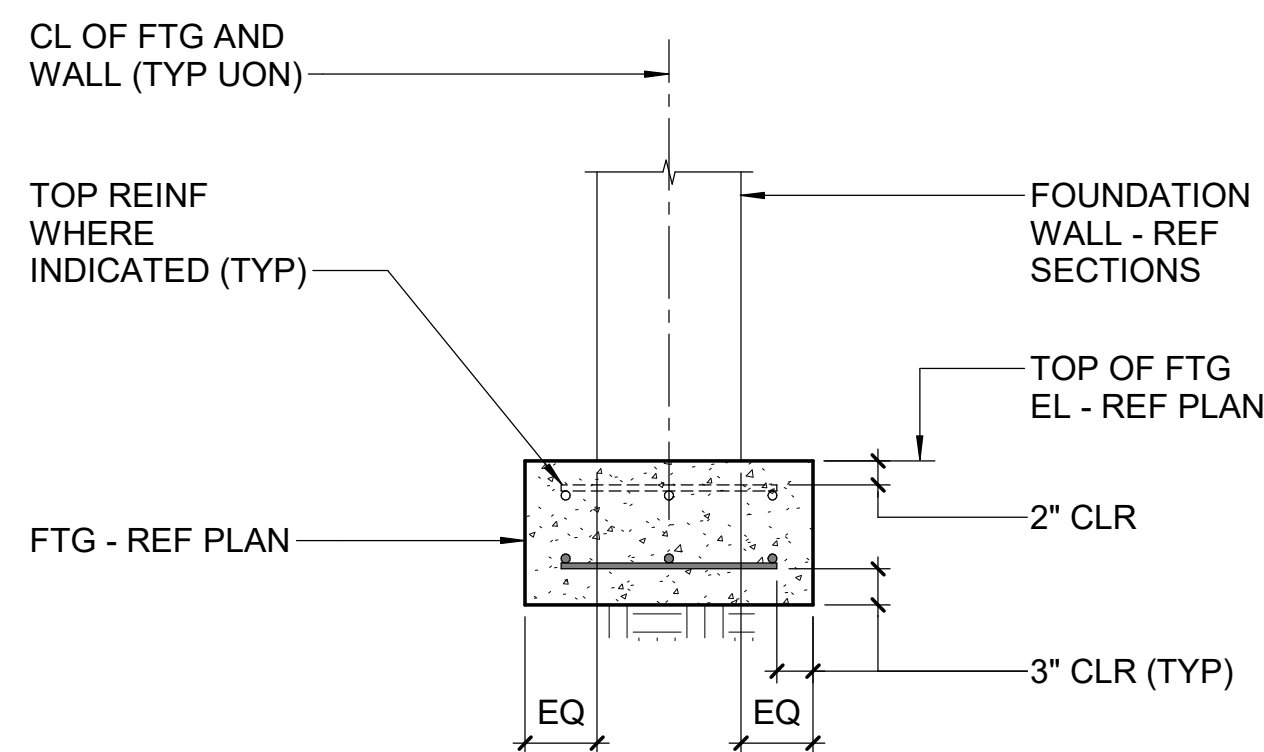


B1 TYPICAL WALL FOOTING DETAIL
NTS

B2 TYPICAL WALL FOOTING CORNER & INTERSECTION DETAILS
NTS

B3 TYPICAL SAWED JOINT DETAIL
NTS


B4 TYPICAL KEYED CONSTRUCTION JOINT DETAIL
NTS

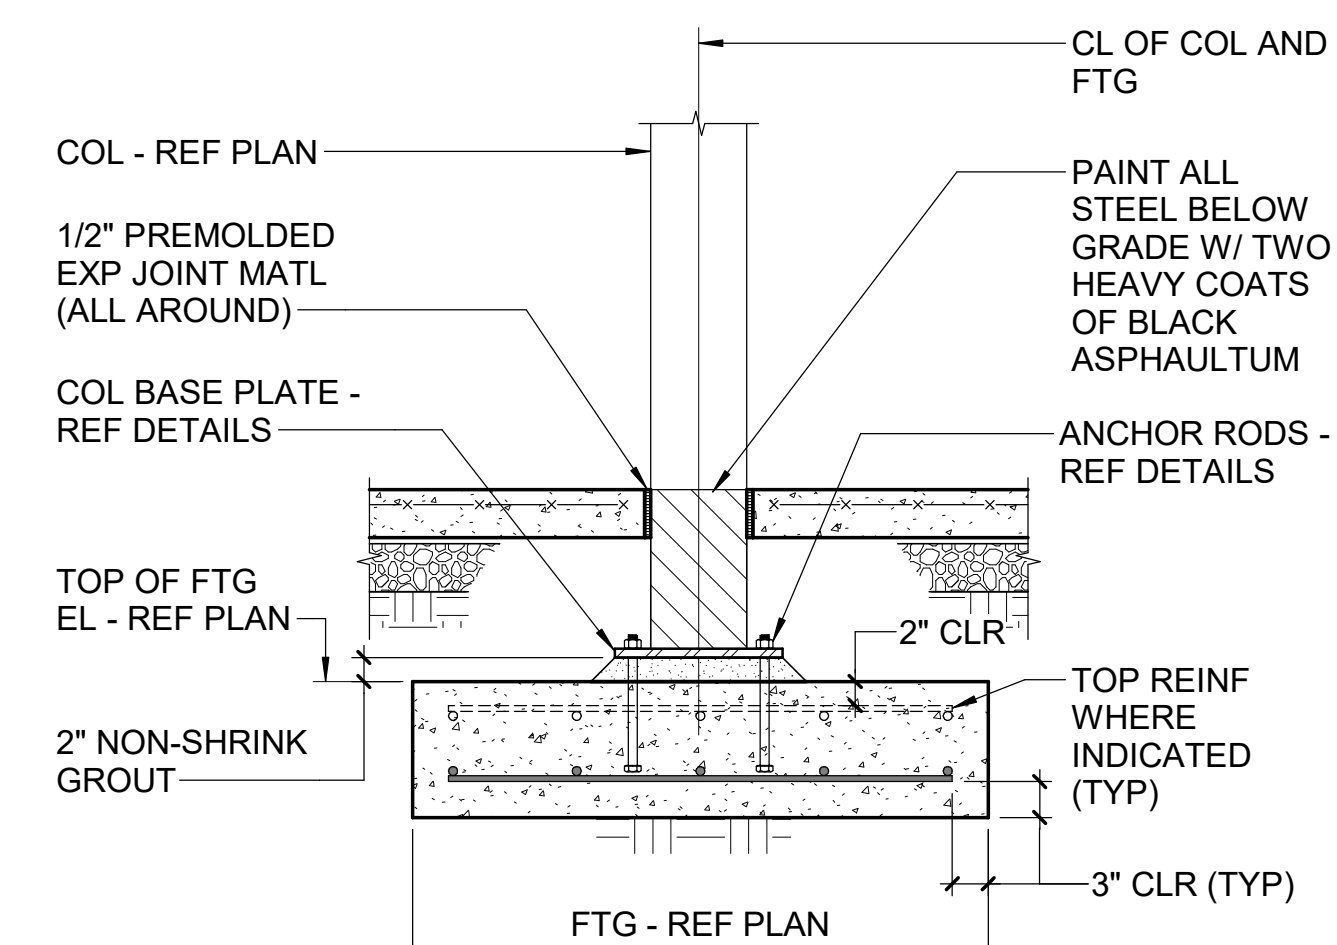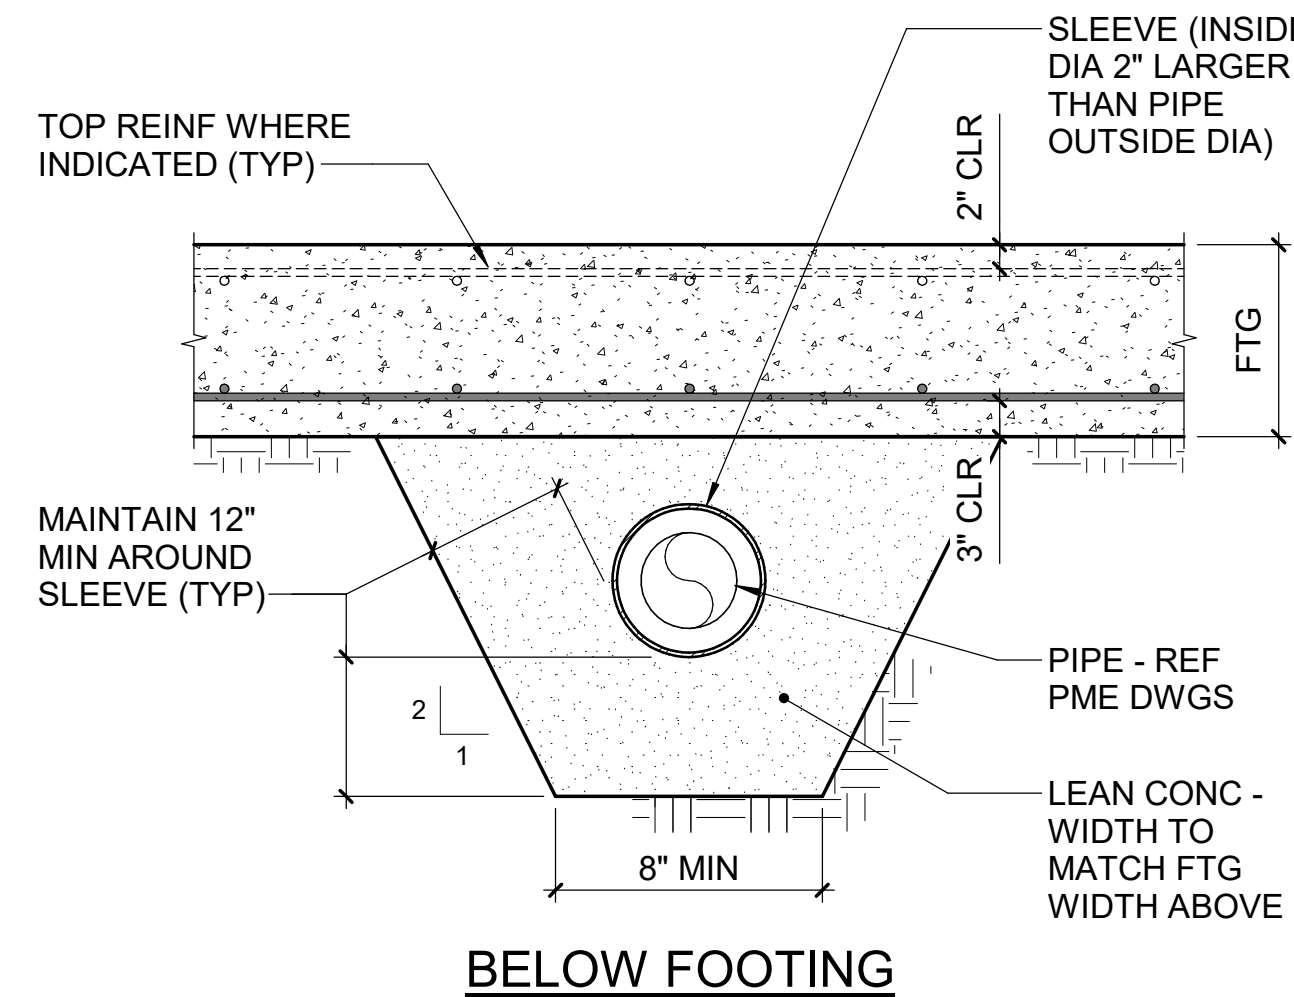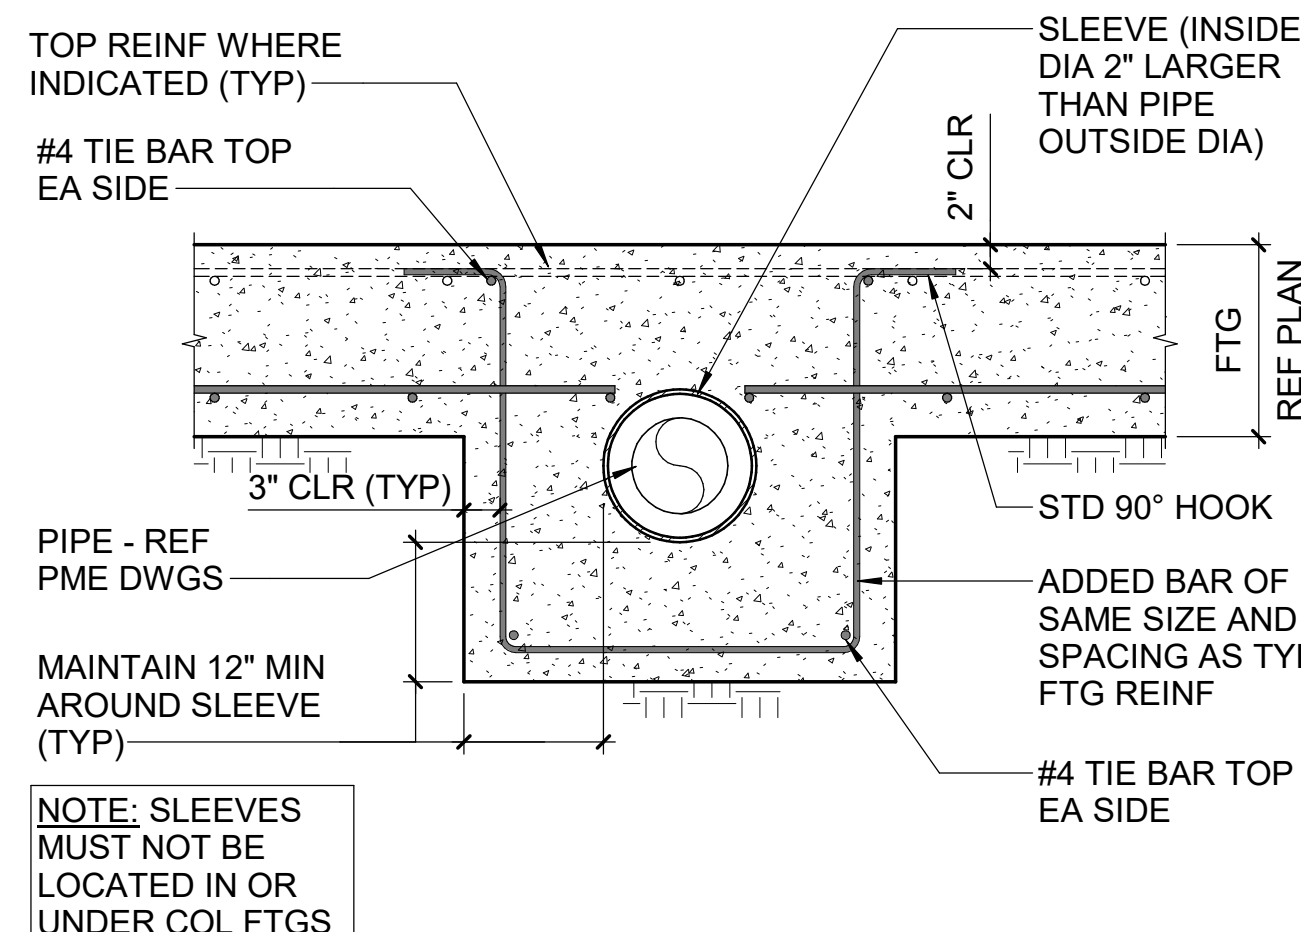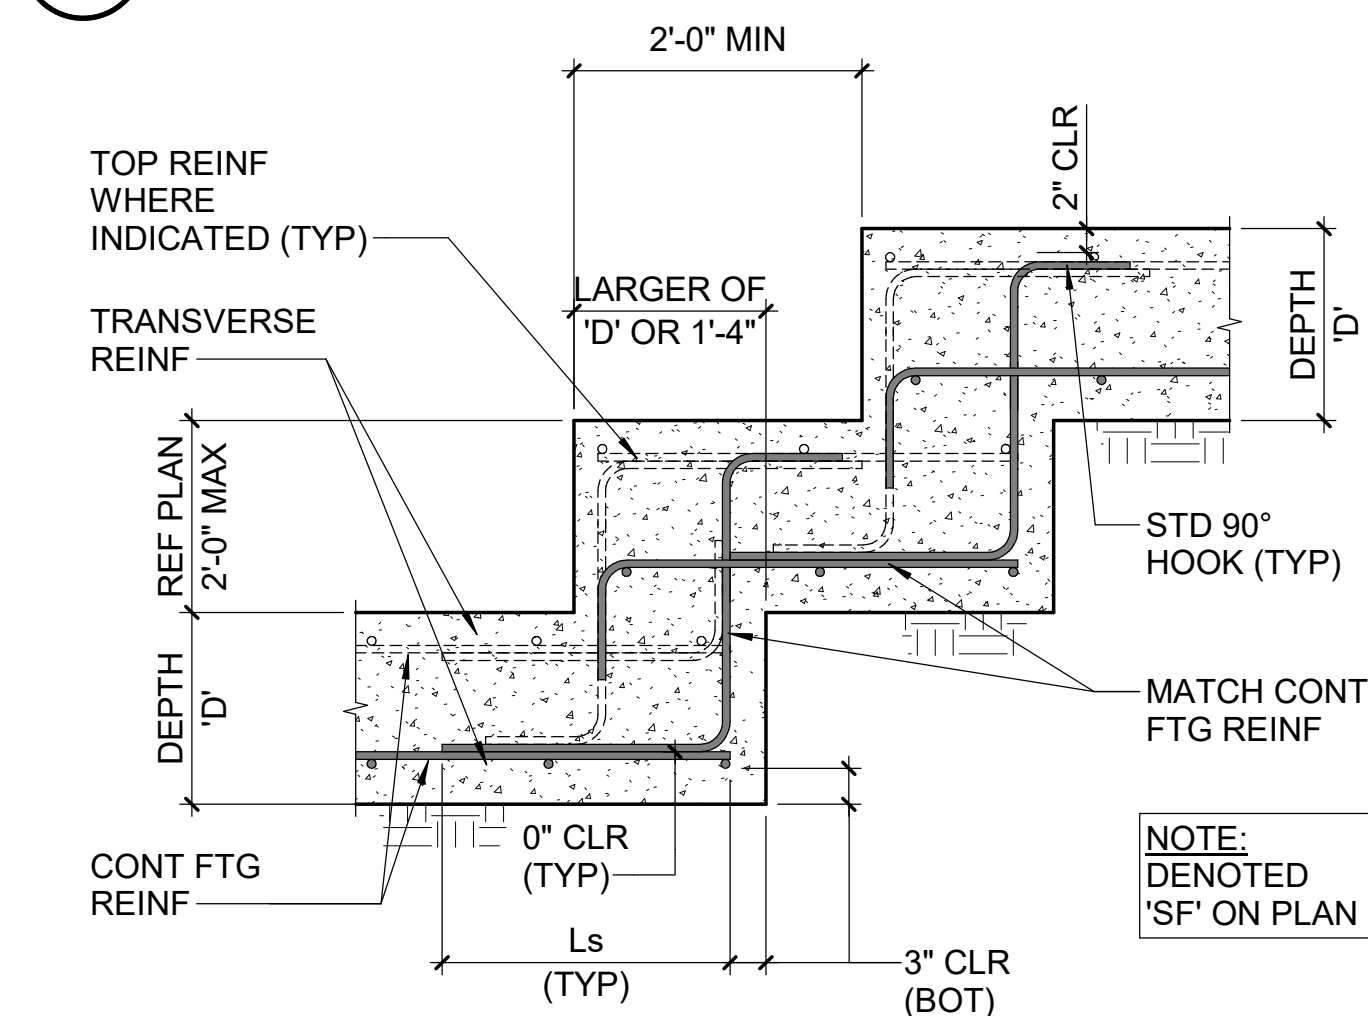

A1 TYPICAL STEPPED WALL FOOTING DETAIL
NTS

A2 TYPICAL PIPE SLEEVE AT WALL FOOTING DETAILS
NTS

A3 TYPICAL COLUMN & FOOTING DETAIL
NTS

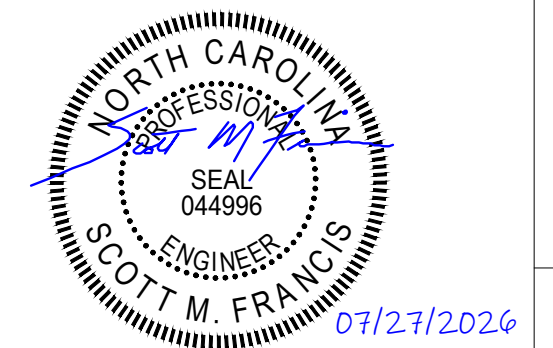

lynchmykins
now **IMEG**
301 N WEST STREET, SUITE 105
RALEIGH, NC 27603
919.782.1833 www.imegcorp.com

IMEG RESERVES PROPRIETARY RIGHTS, INCLUDING COPYRIGHTS, TO THIS DRAWING AND THE DATA SHOWN THEREON. SAID DRAWING AND/OR DATA ARE THE EXCLUSIVE PROPERTY OF IMEG AND SHALL NOT BE USED OR REPRODUCED FOR ANY OTHER PROJECT WITHOUT THE EXPRESS WRITTEN APPROVAL AND PARTICIPATION OF IMEG.
©2025 IMEG CONSULTANTS CORP.
North Carolina Design Registration #F-1507

Susan Hatchell
Landscape Architecture, PLLC
711 W. North Street, Raleigh, NC 27603
p: 919-838-9600 f: 919-838-9700

lynchmykins
now **IMEG**
301 N WEST STREET, SUITE 105
RALEIGH, NC 27603
919.782.1833 www.imegcorp.com

TYPICAL DETAILS

LAKE MYRA COUNTY PARK
Wake County, NC

REVISIONS

Date 07/27/2026
ES-S501


TYPICAL DETAILS

LAKE MYRA COUNTY PARK
Wake County, NC


REVISIONS

Date 07/27/2026


ES-S502

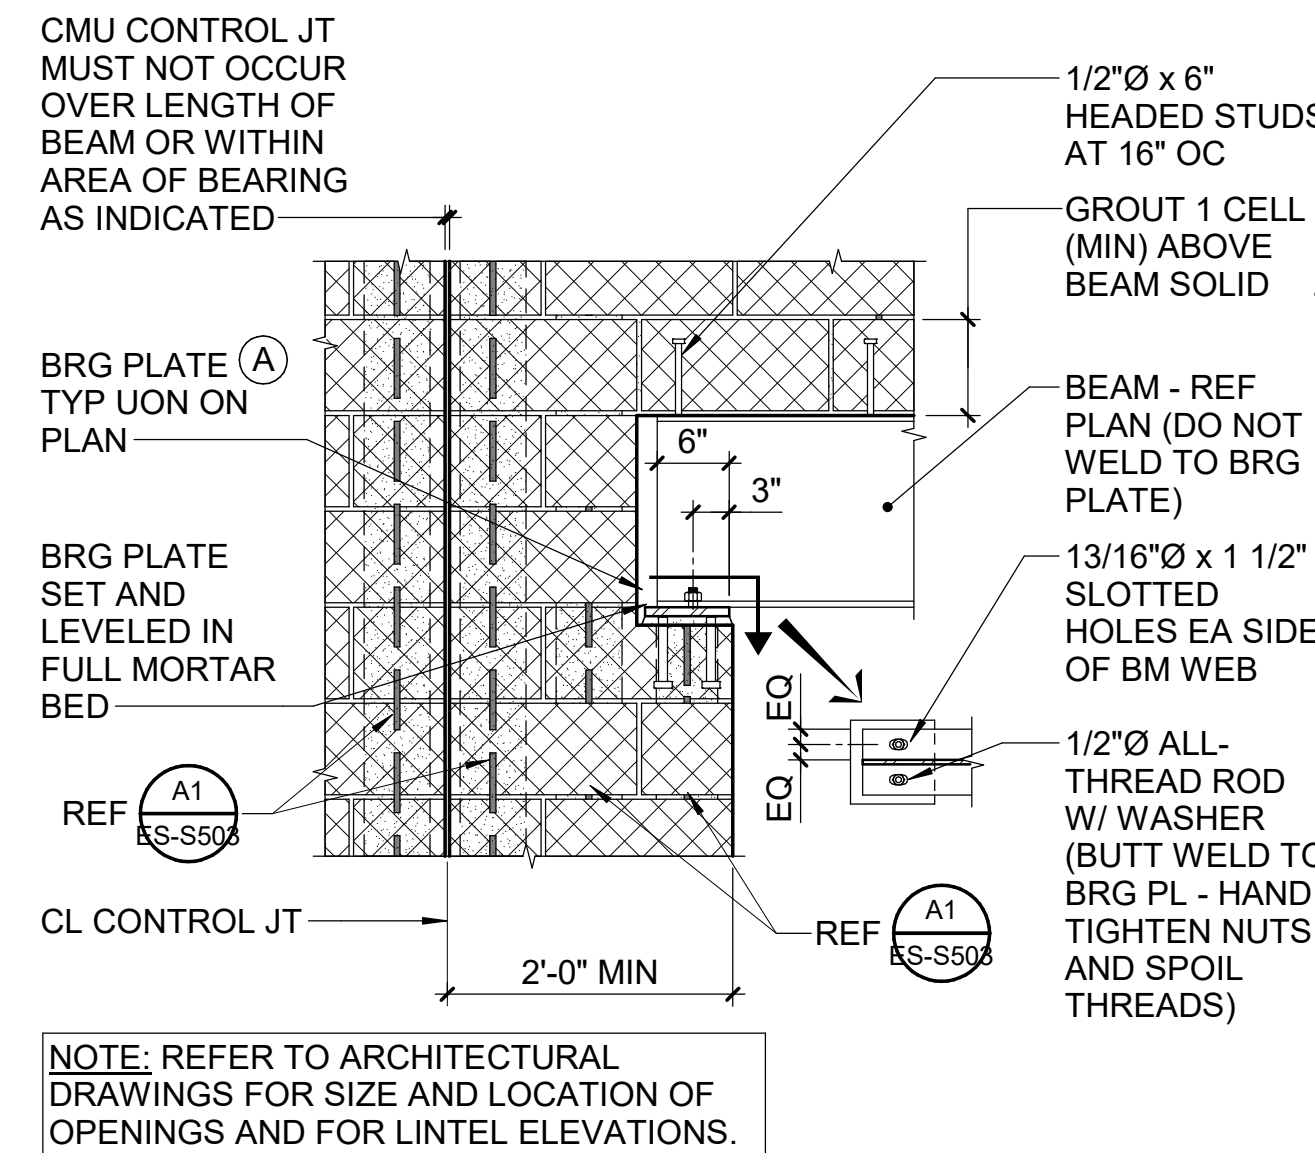


PARALLEL TO WALL ELEVATION
(TYPICAL WF)

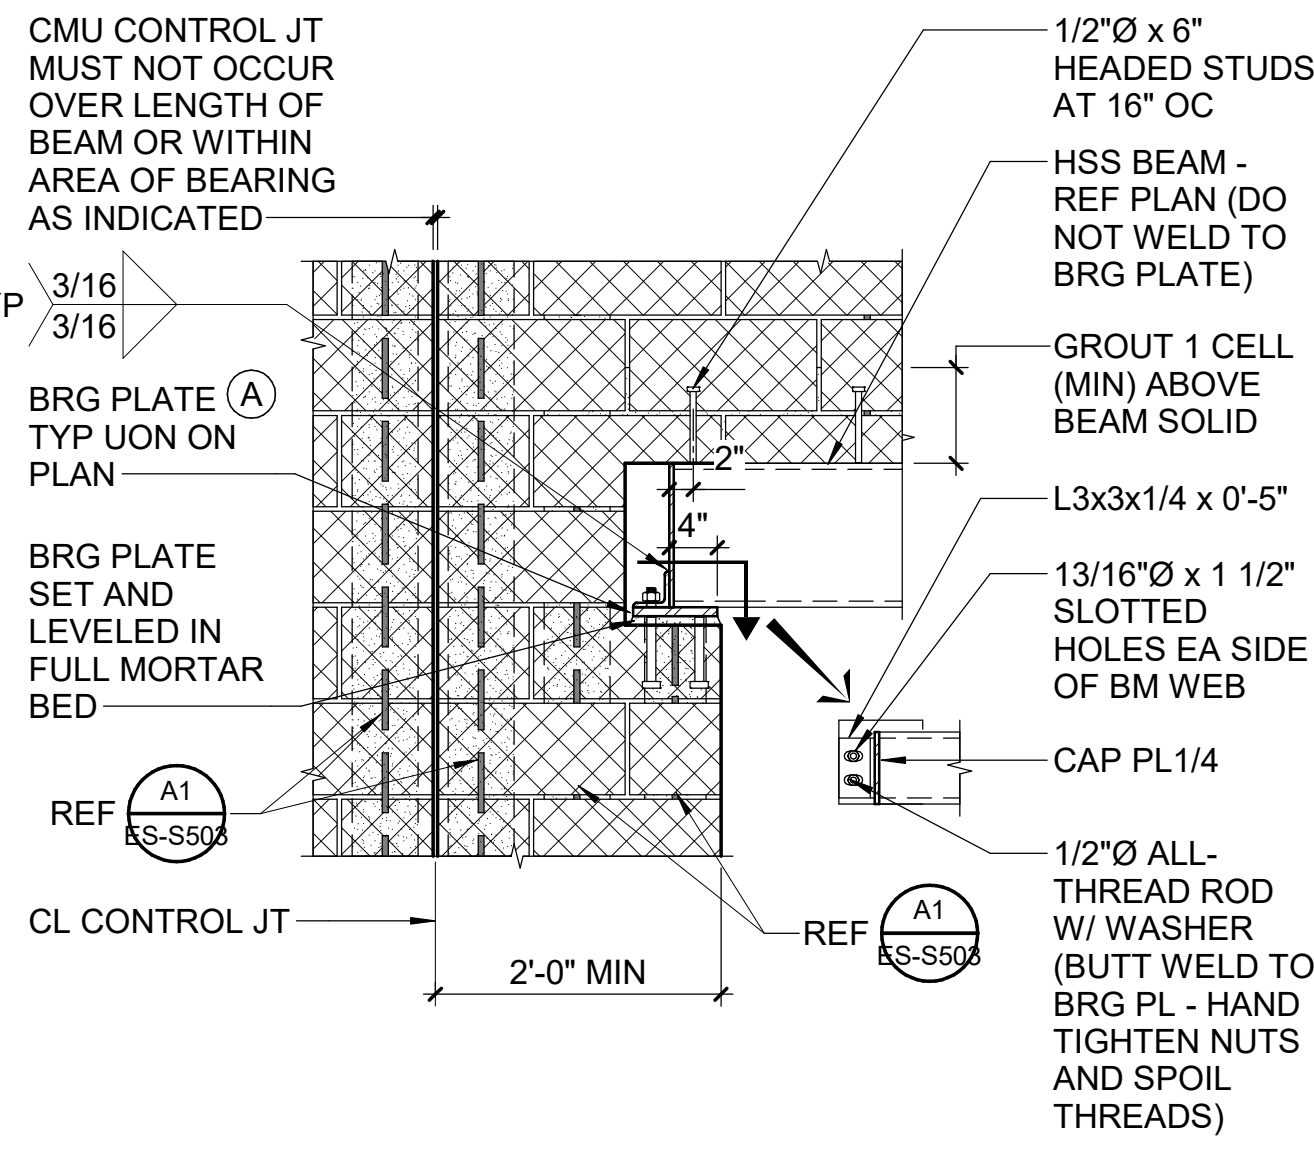


PARALLEL TO WALL ELEVATION
(TYPICAL HSS)

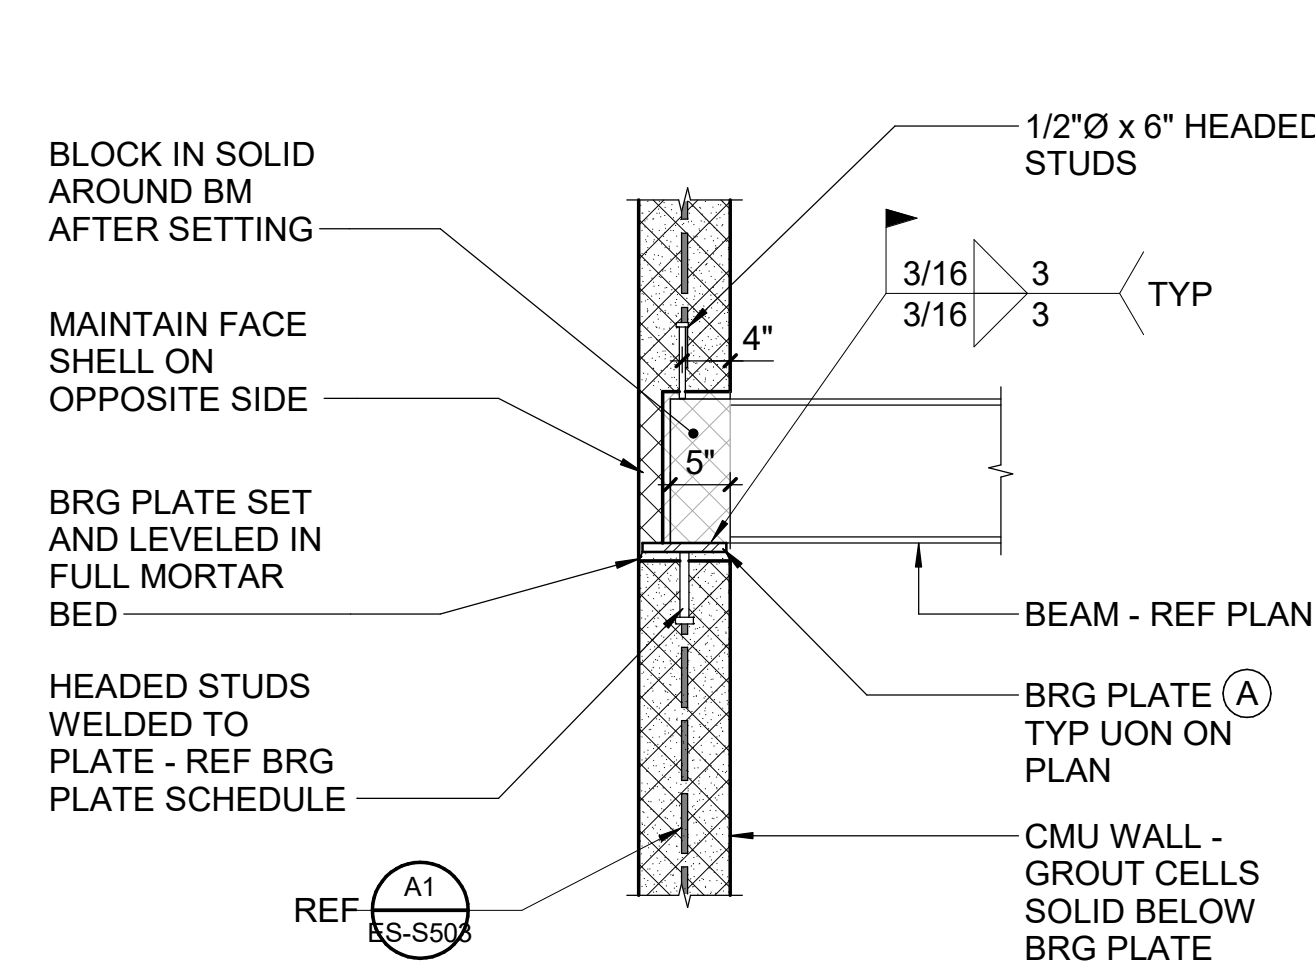


PERPENDICULAR TO WALL
SECTION (TYPICAL)

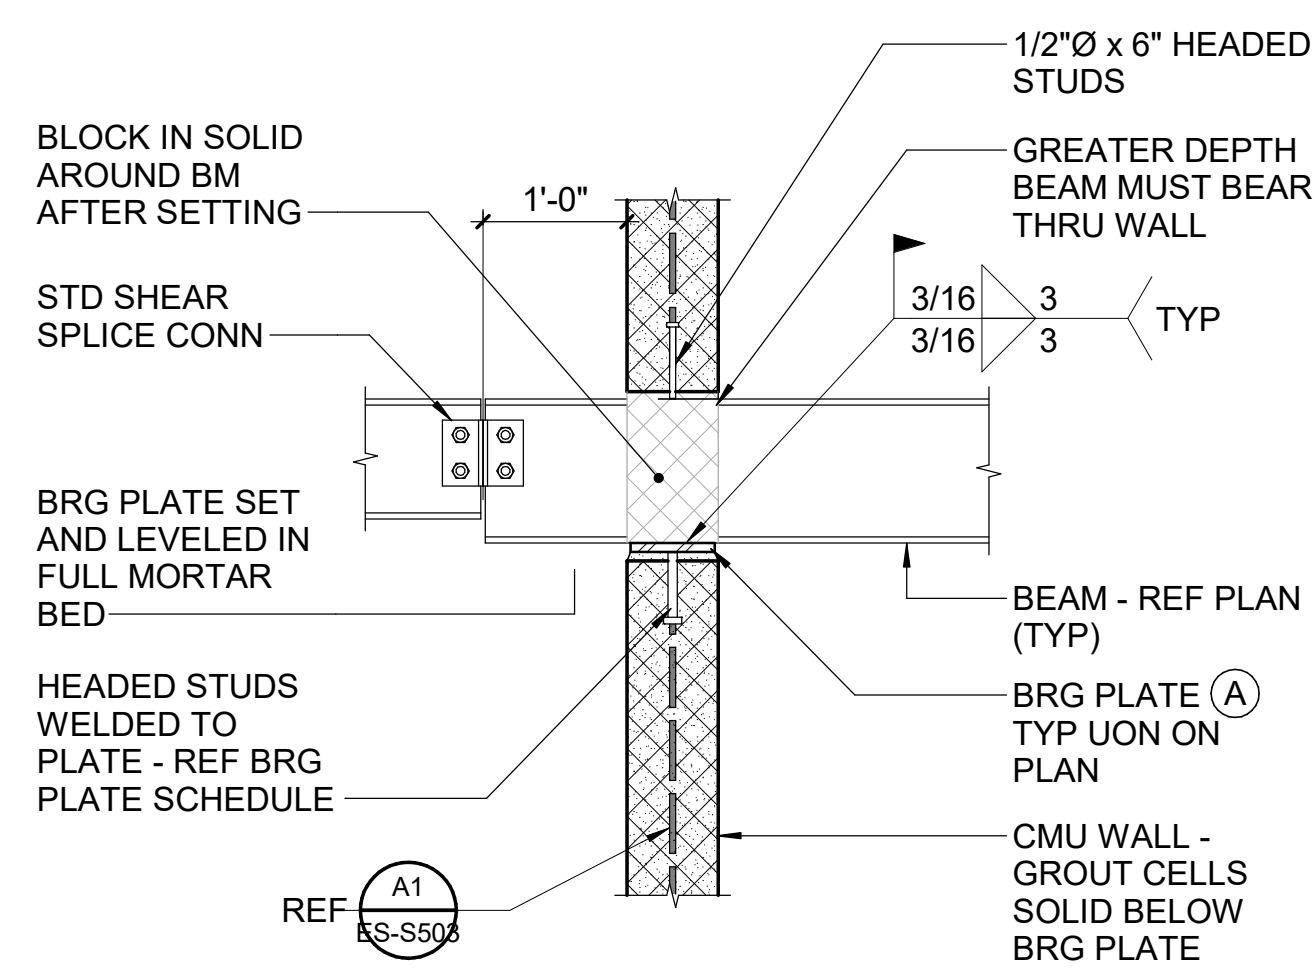

PERPENDICULAR TO WALL
SECTION (COMMON BEARING)

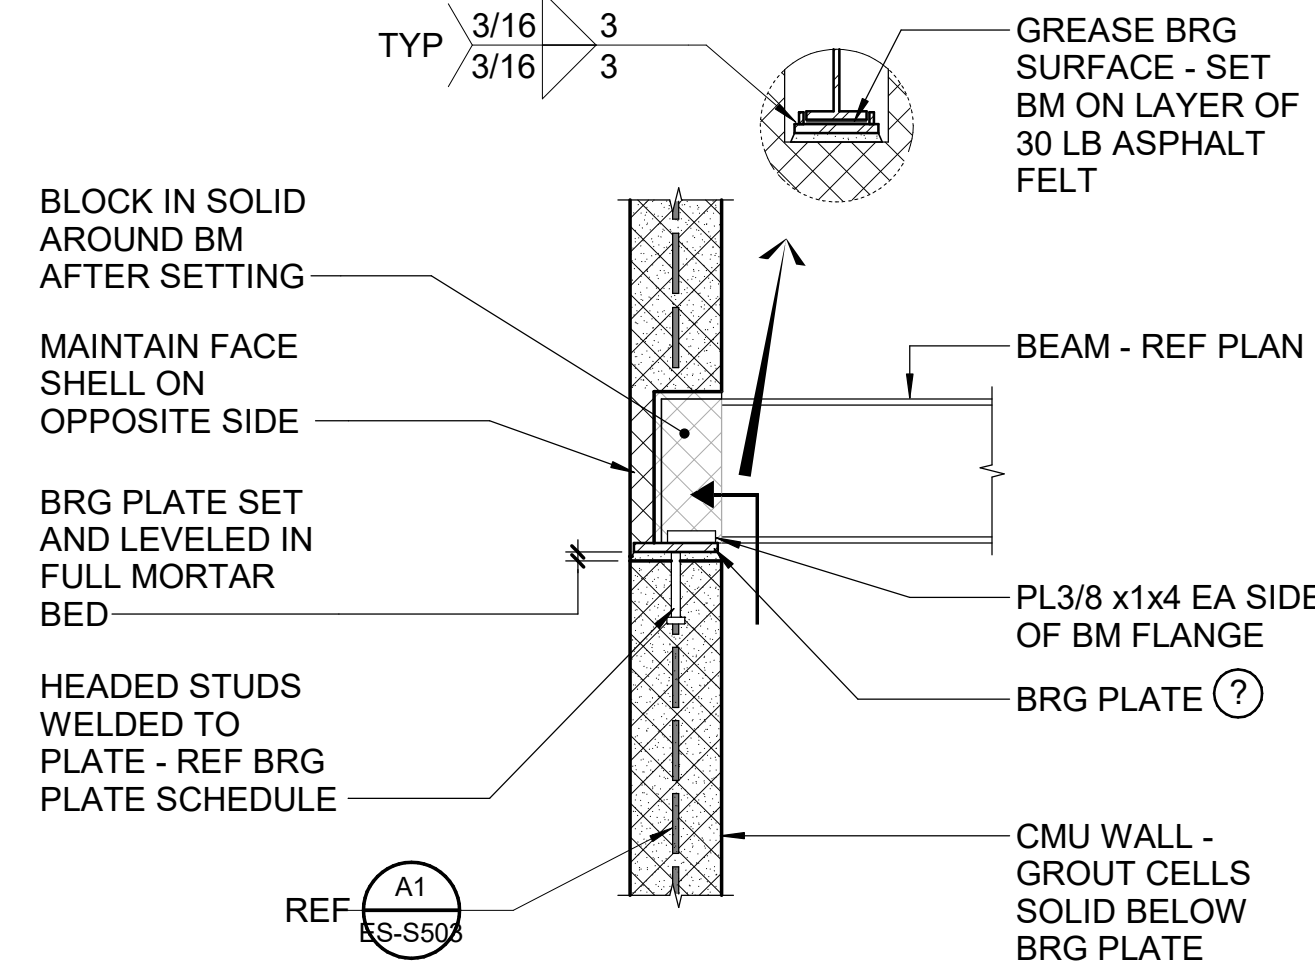

PERPENDICULAR TO WALL
SECTION (SLIP CONNECTION)

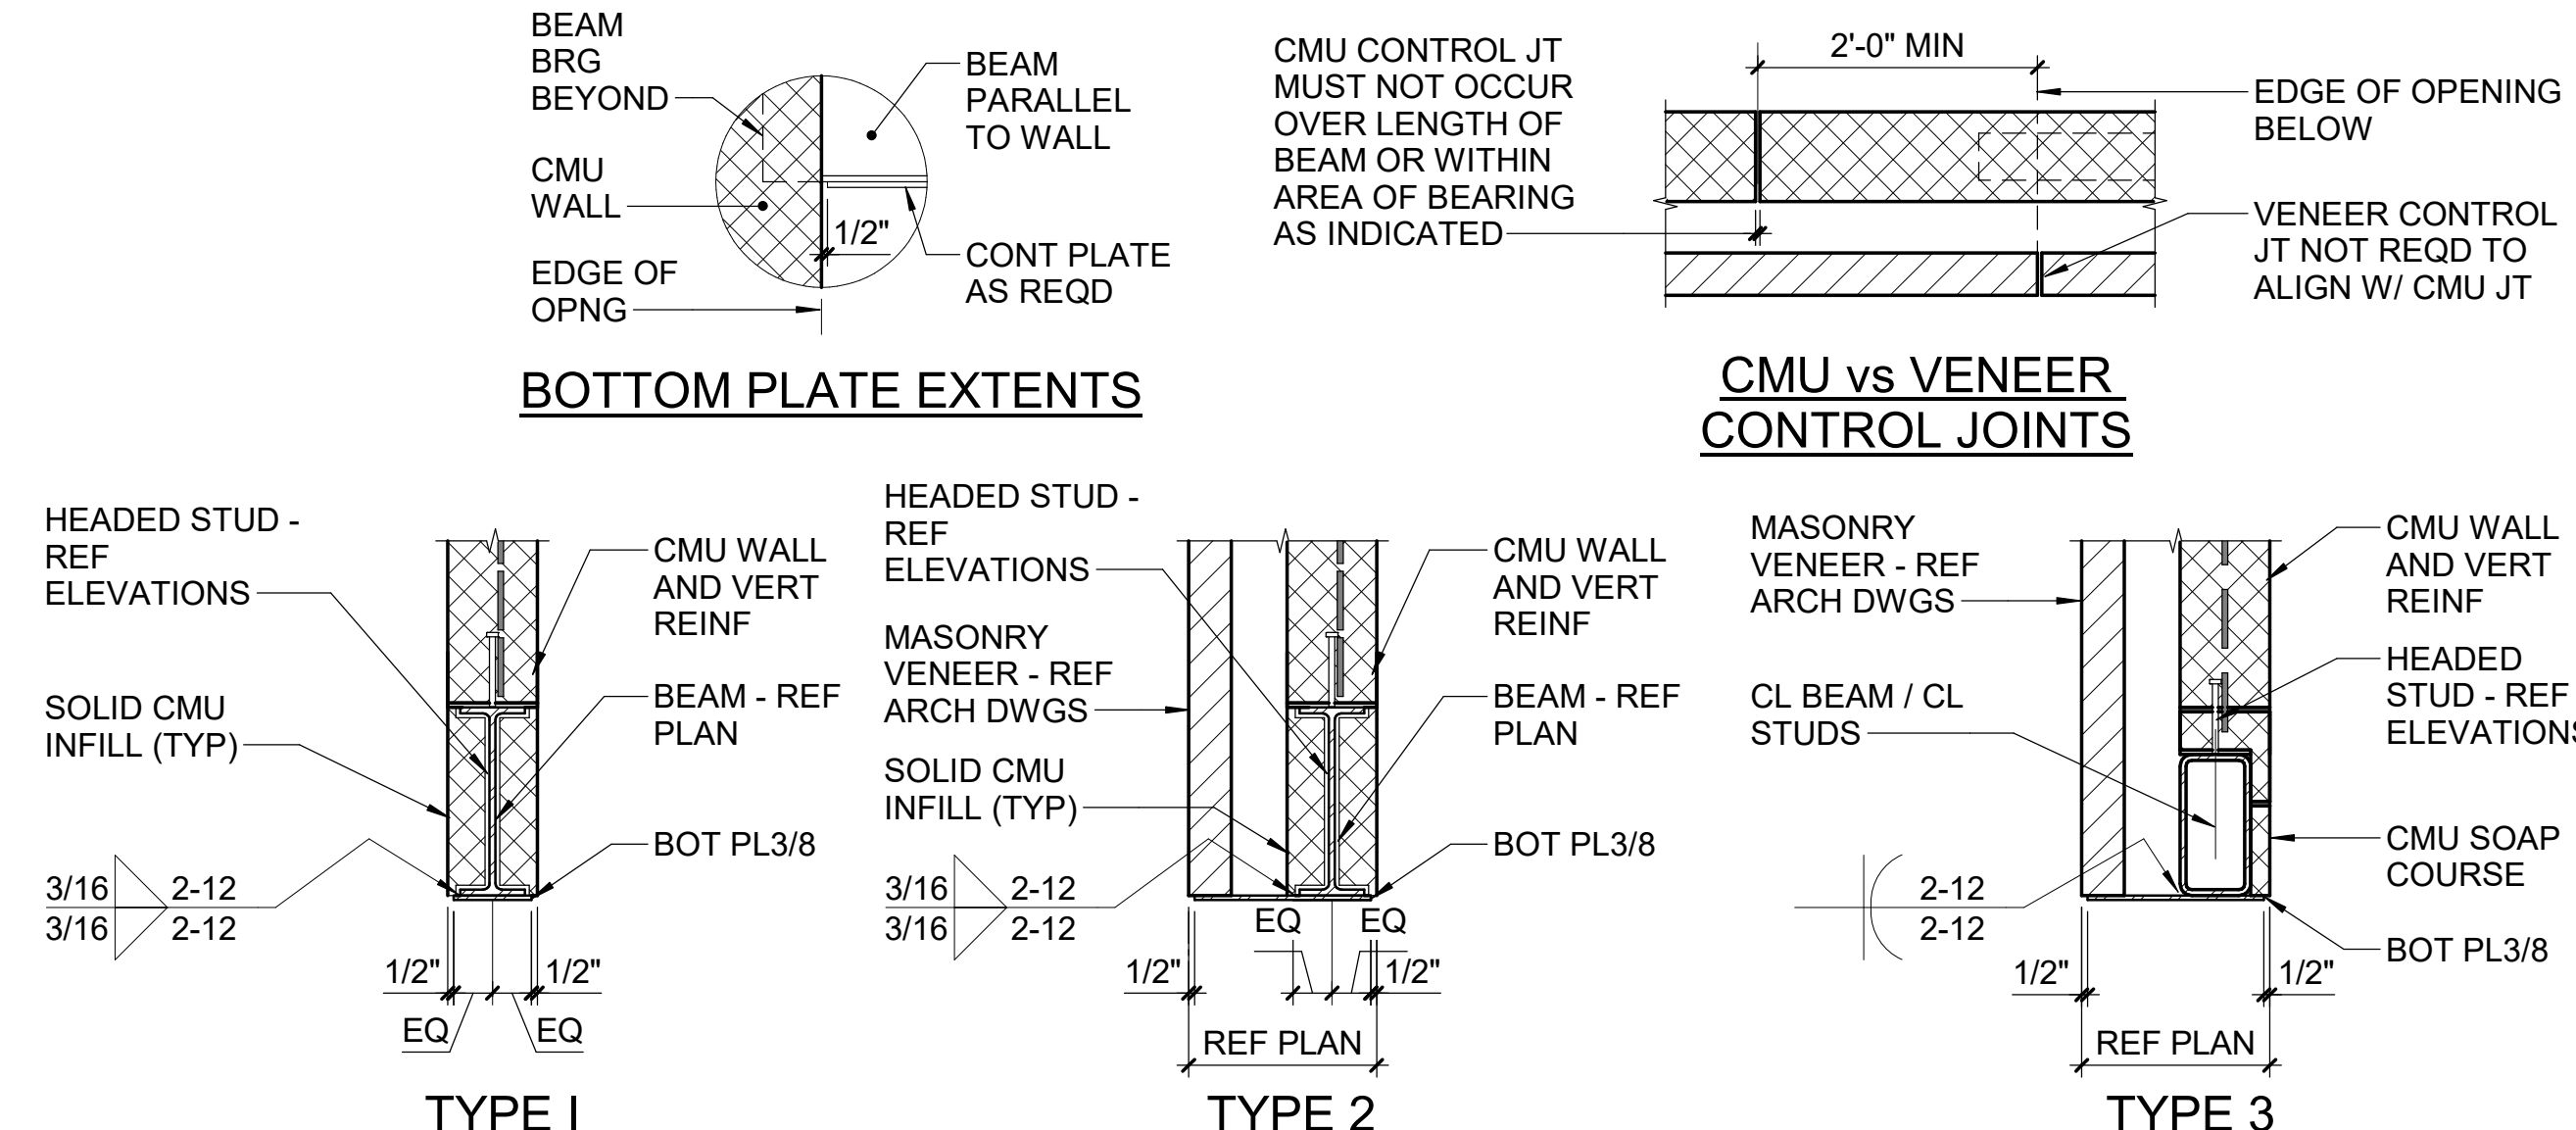


BOTTOM PLATE EXTENTS


CMU vs VENEER
CONTROL JOINTS

TYPICAL BOTTOM PLATE DETAILS

(A) (B) (C) (D) (E) (F)

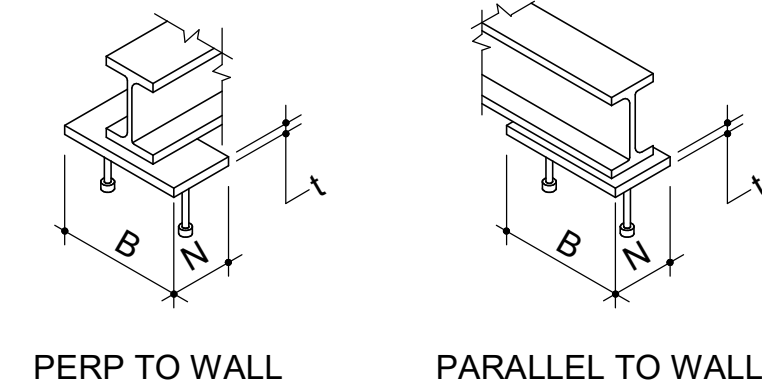


ISOMETRIC VIEW BEARING PLATES

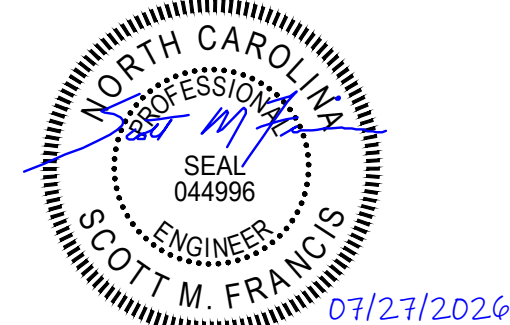


301 N WEST STREET, SUITE 105
RALEIGH, NC 27603
919.782.1833 www.imegcorp.com


IMEG RESERVES PROPRIETARY RIGHTS, INCLUDING COPYRIGHTS, TO THIS DRAWING AND THE DATA SHOWN THEREON. SAID DRAWING AND/OR DATA ARE THE EXCLUSIVE PROPERTY OF IMEG AND SHALL NOT BE USED OR REPRODUCED FOR ANY OTHER PROJECT WITHOUT THE EXPRESS WRITTEN APPROVAL AND PARTICIPATION OF IMEG. ©2025 IMEG CONSULTANTS CORP. North Carolina Design Registration #F-1507

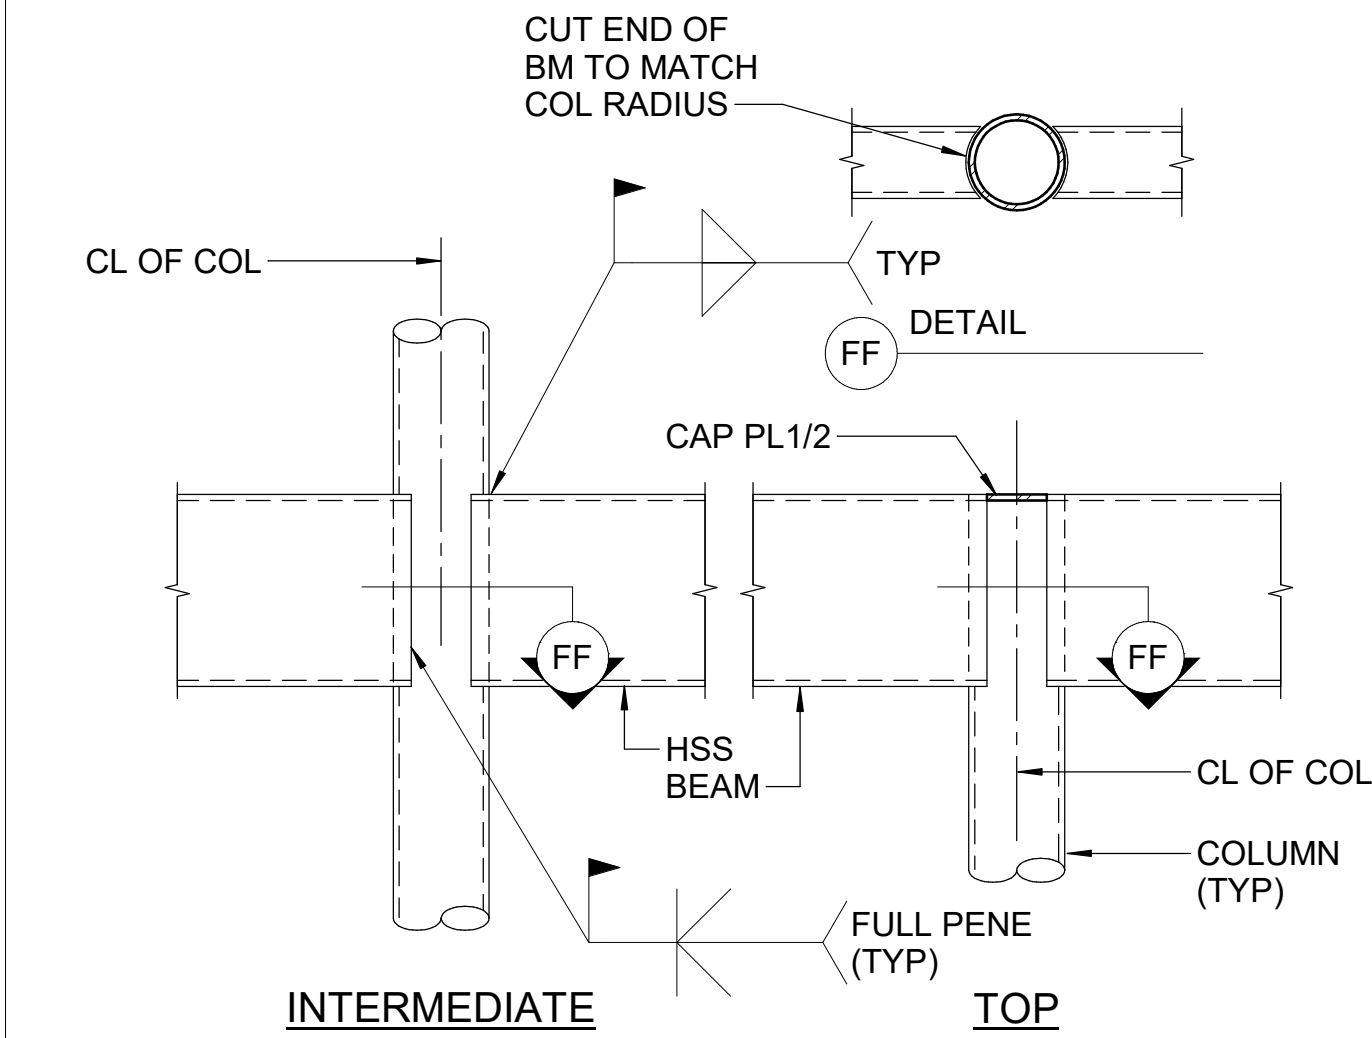


B1 TYPICAL HSS BEAM TO HSS ROUND COLUMN MOMENT CONNECTION DETAILS
NTS

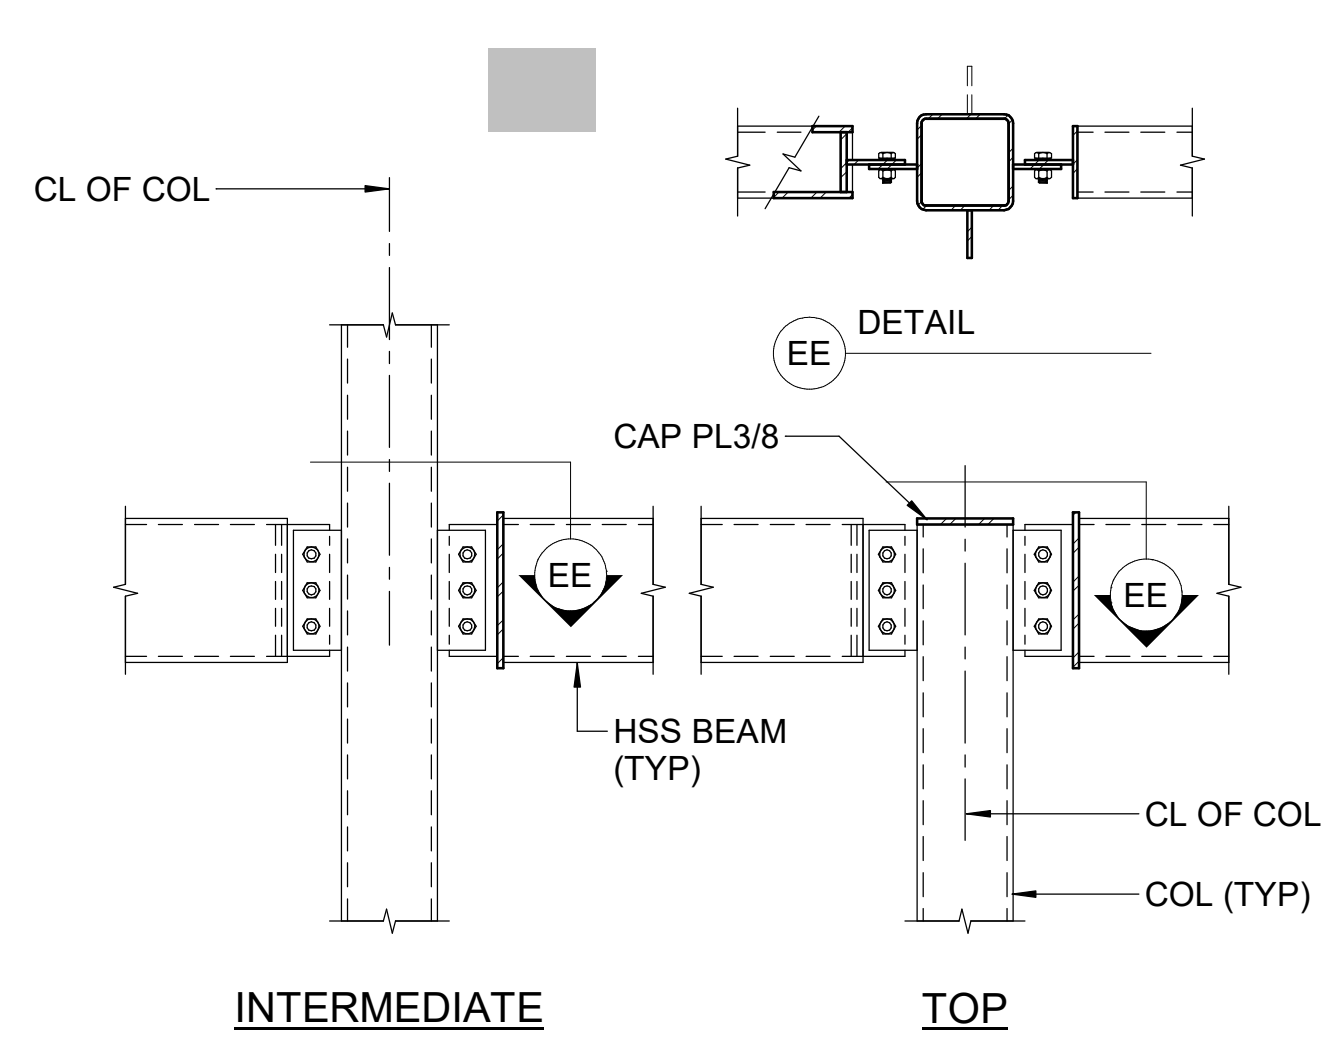


B2 TYPICAL HSS BEAM TO HSS COLUMN CONNECTION DETAILS
NTS

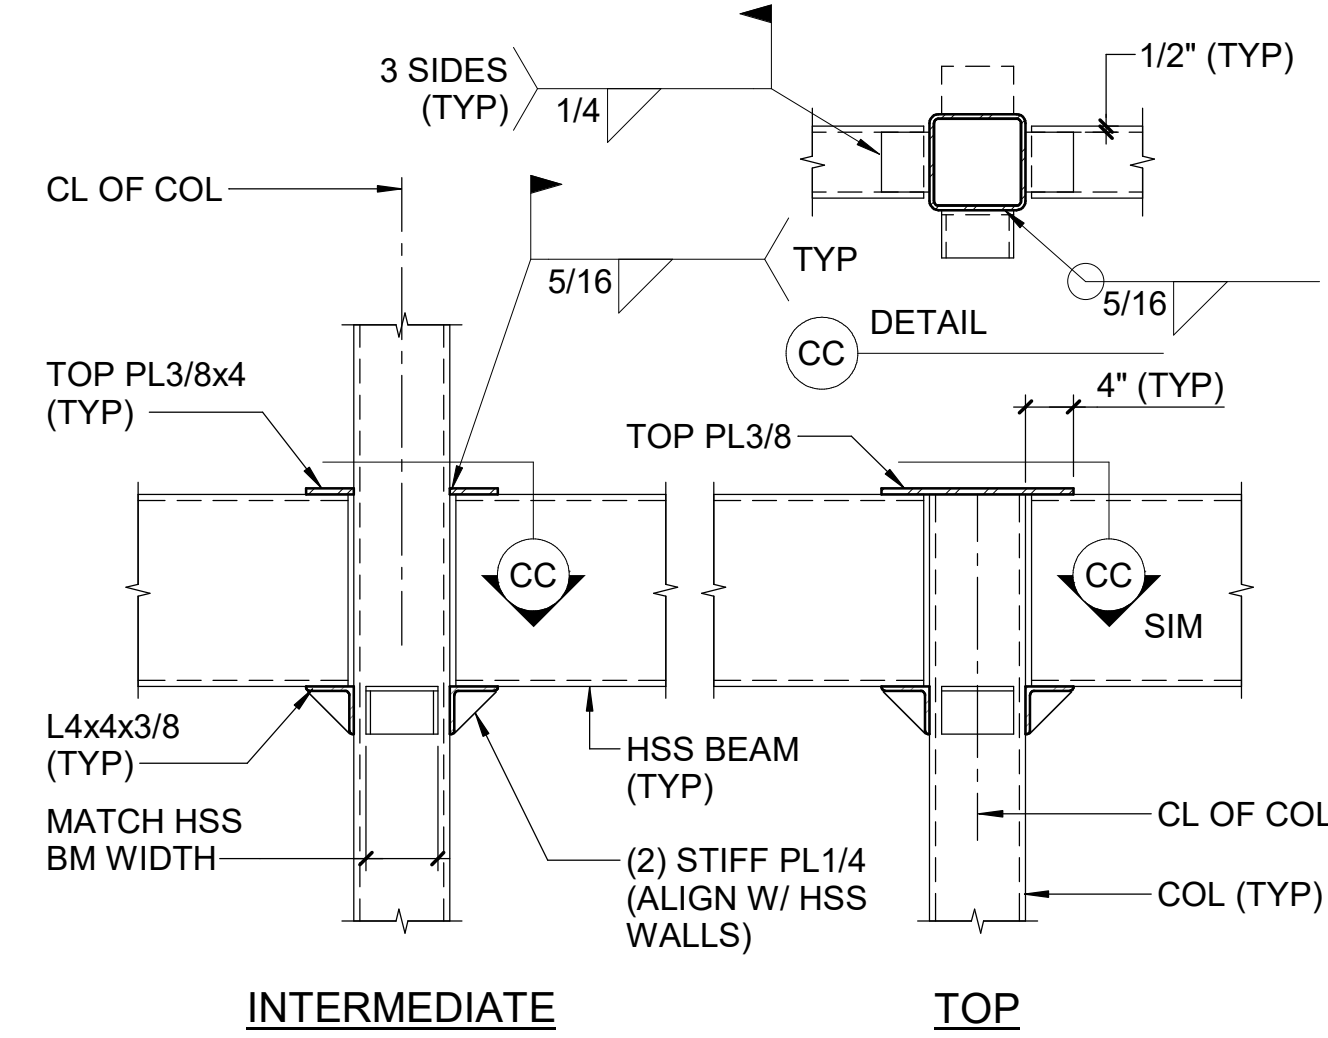


B3 TYPICAL HSS BEAM TO HSS COLUMN CONNECTION DETAILS
NTS

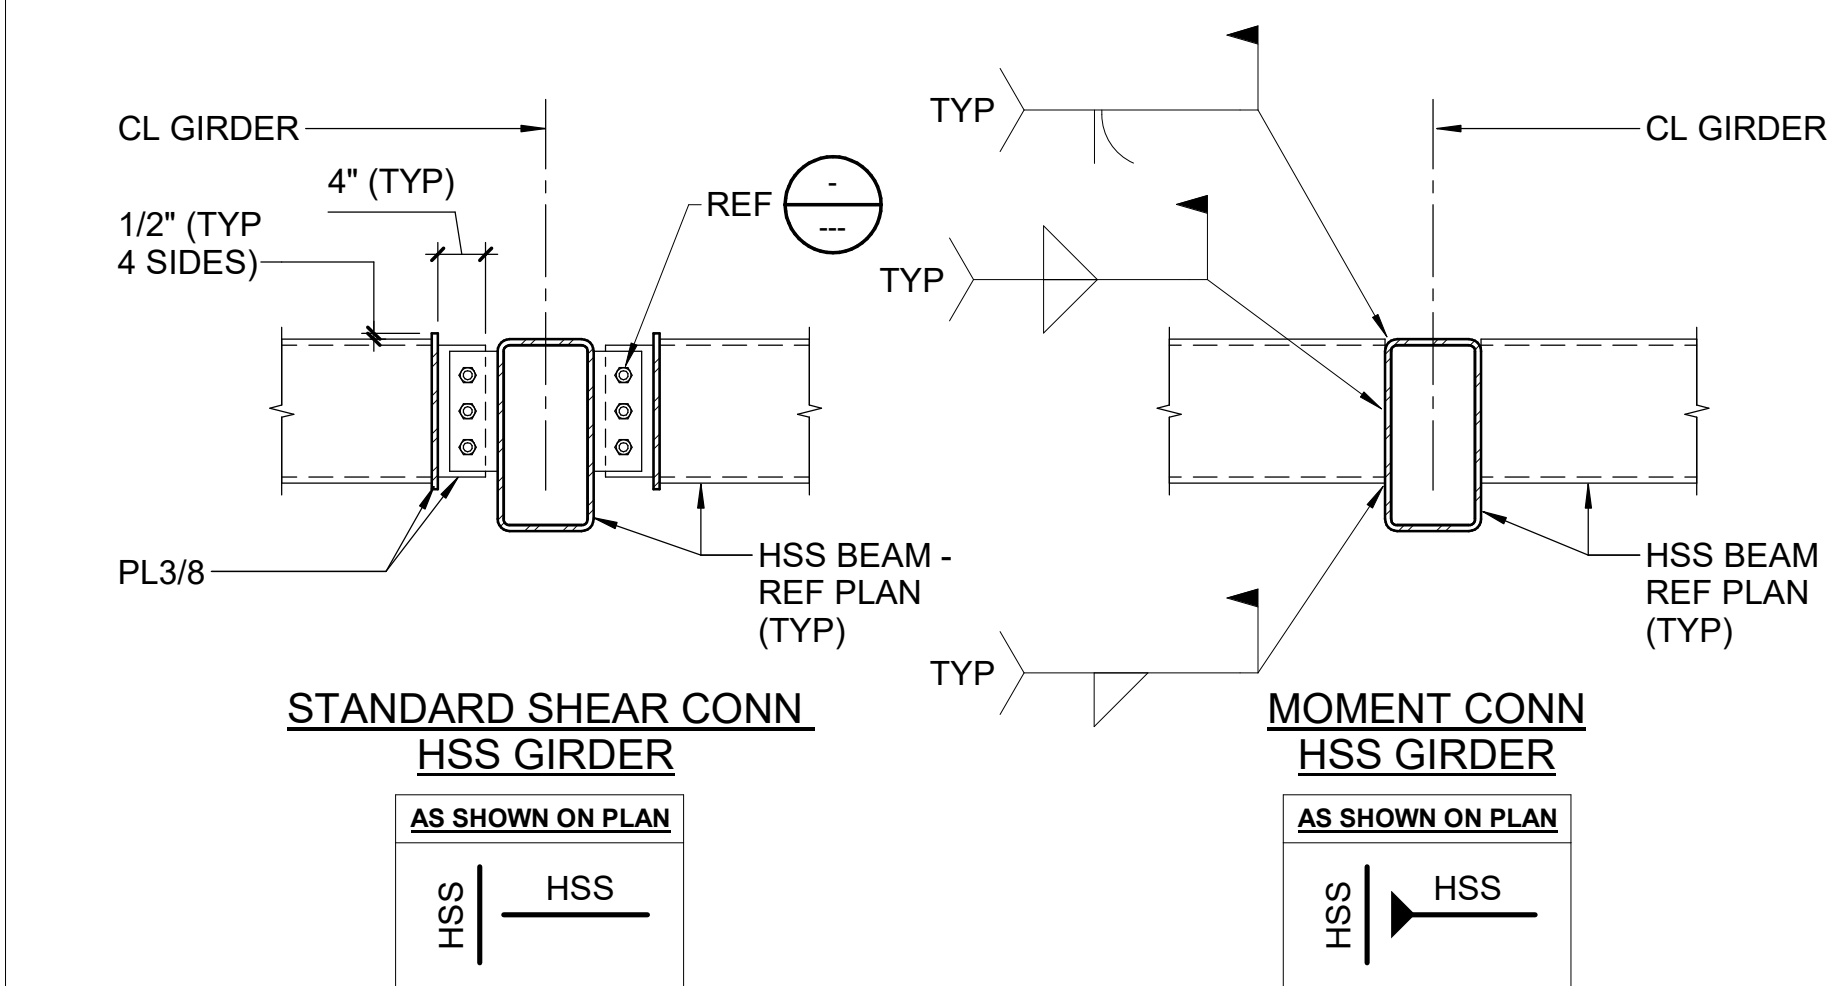

A1 TYPICAL HSS BEAM TO GIRDER CONNECTION DETAILS
NTS

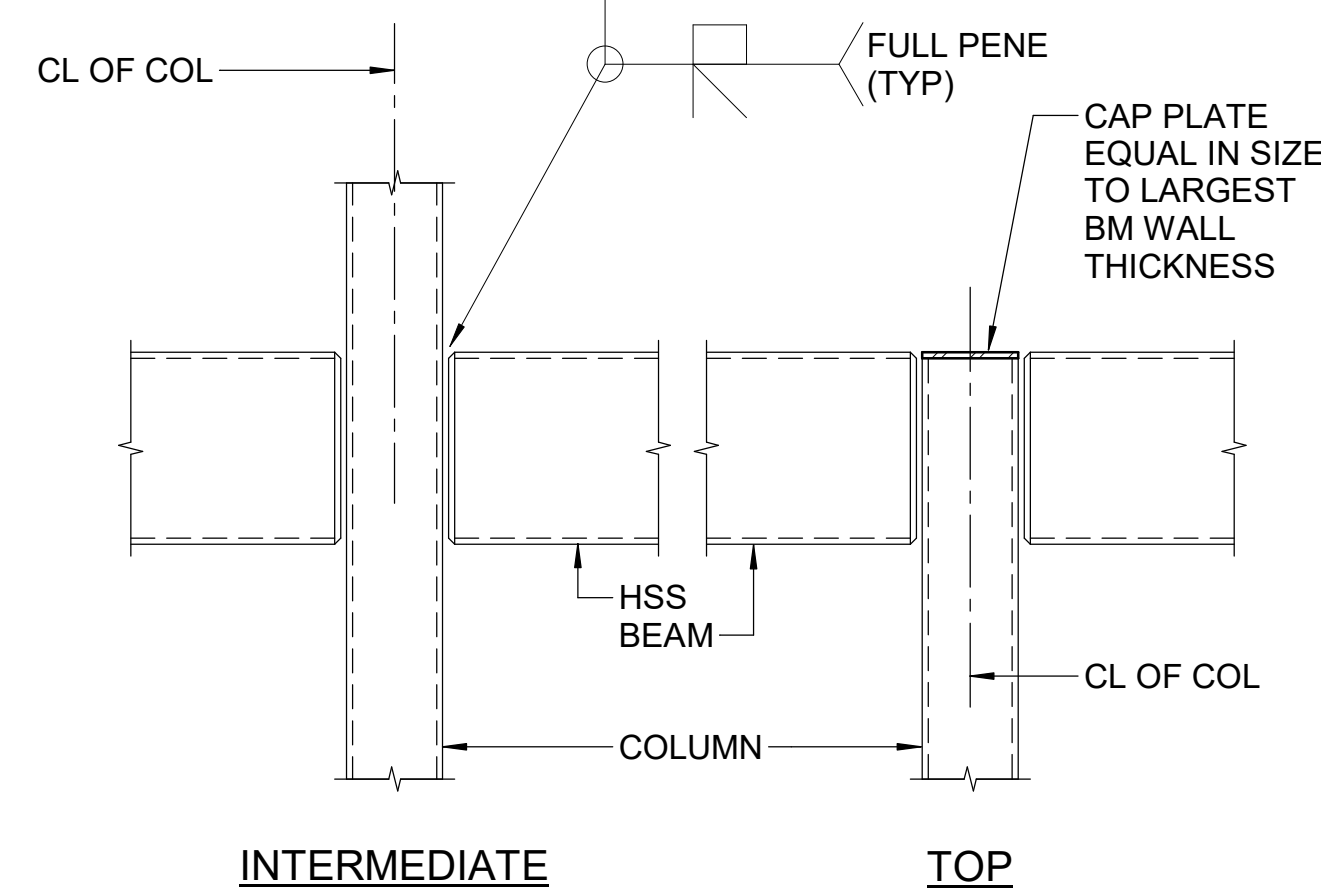

A2 TYPICAL HSS BEAM TO HSS COLUMN MOMENT CONNECTION DETAILS
NTS

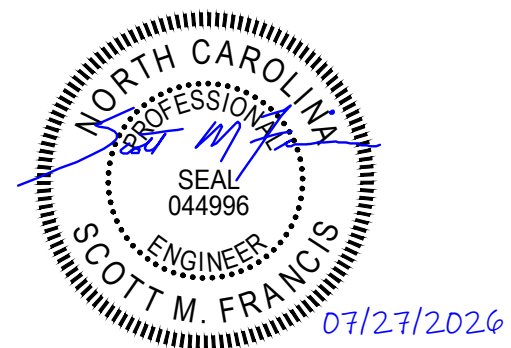

IMEG RESERVES PROPRIETARY RIGHTS, INCLUDING COPYRIGHTS, TO THIS DRAWING AND THE DATA SHOWN THEREON. SAID DRAWING AND/OR DATA ARE THE EXCLUSIVE PROPERTY OF IMEG AND SHALL NOT BE USED OR REPRODUCED FOR ANY OTHER PROJECT WITHOUT THE EXPRESS WRITTEN APPROVAL AND PARTICIPATION OF IMEG. ©2025 IMEG CONSULTANTS CORP. North Carolina Design Registration #F-1507

Susan Hatchell
Landscape Architecture, PLLC
711 W. North Street, Raleigh, NC 27603
p: 919-838-9600 f: 919-838-9700




TYPICAL DETAILS

LAKE MYRA COUNTY PARK
Wake County, NC


REVISIONS

Date 07/27/2026


ES-S504

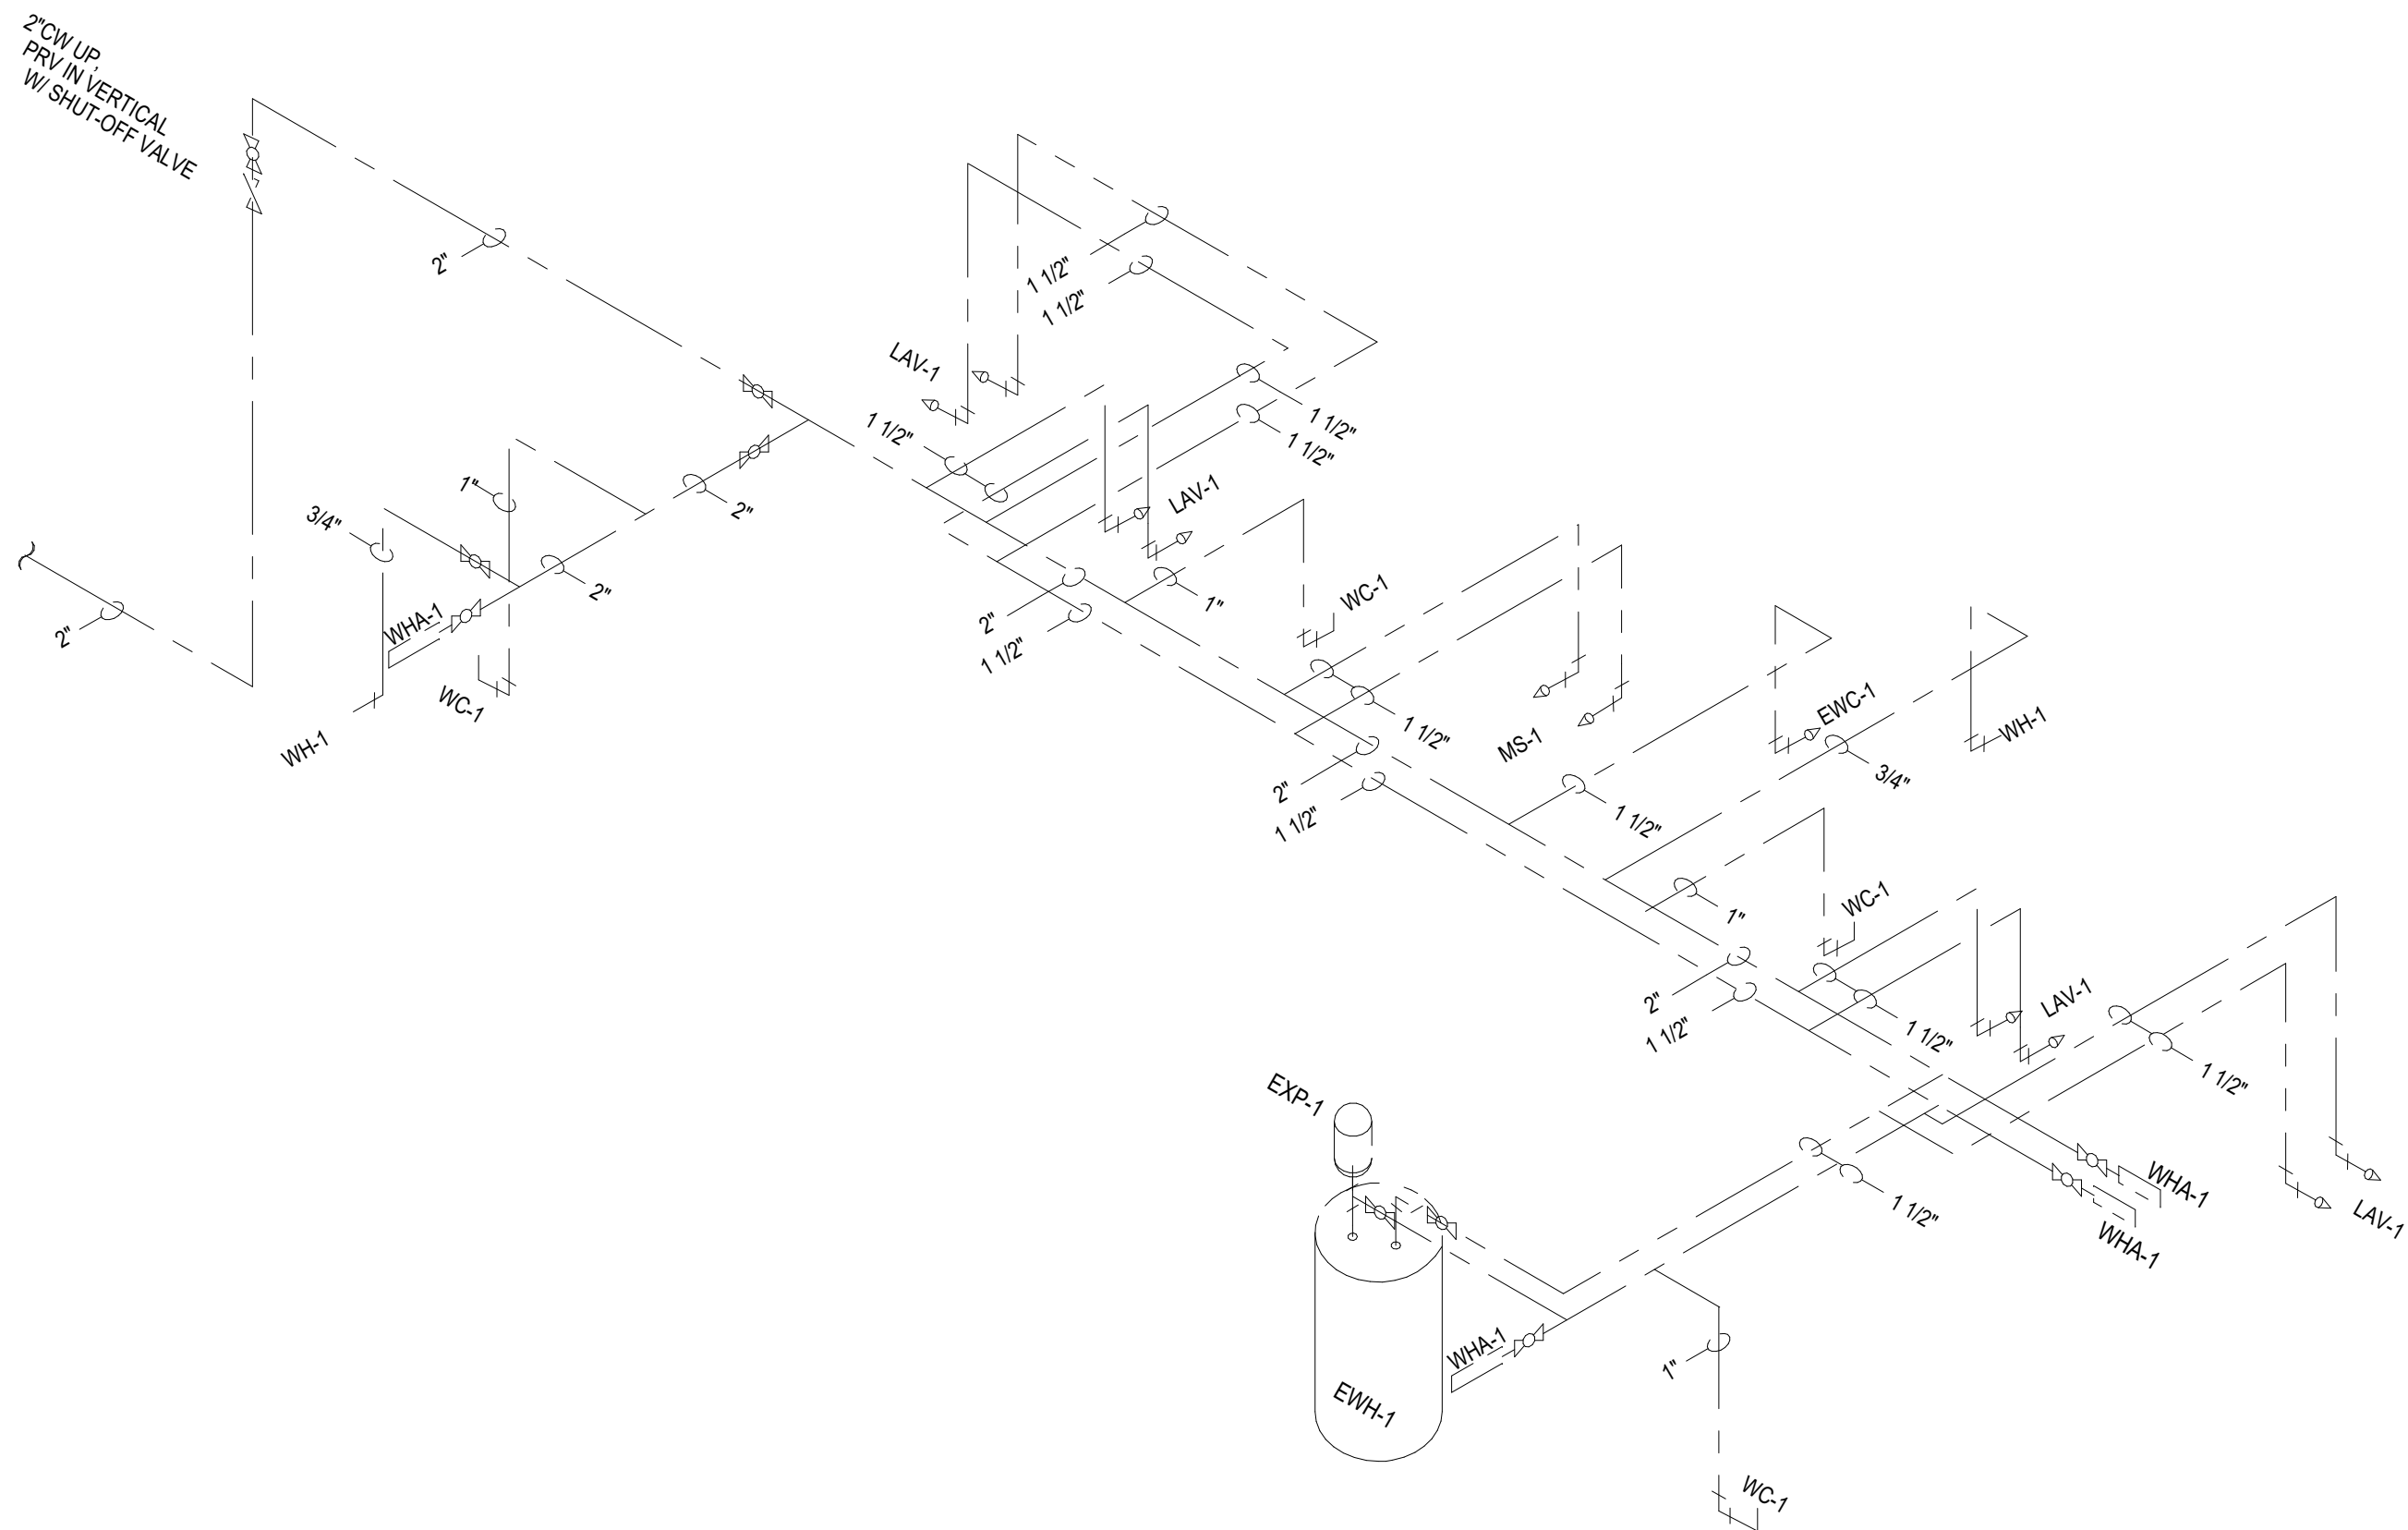


4 WATER SUPPLY RISER DIAGRAM
ES-P101/ NOT TO SCALE

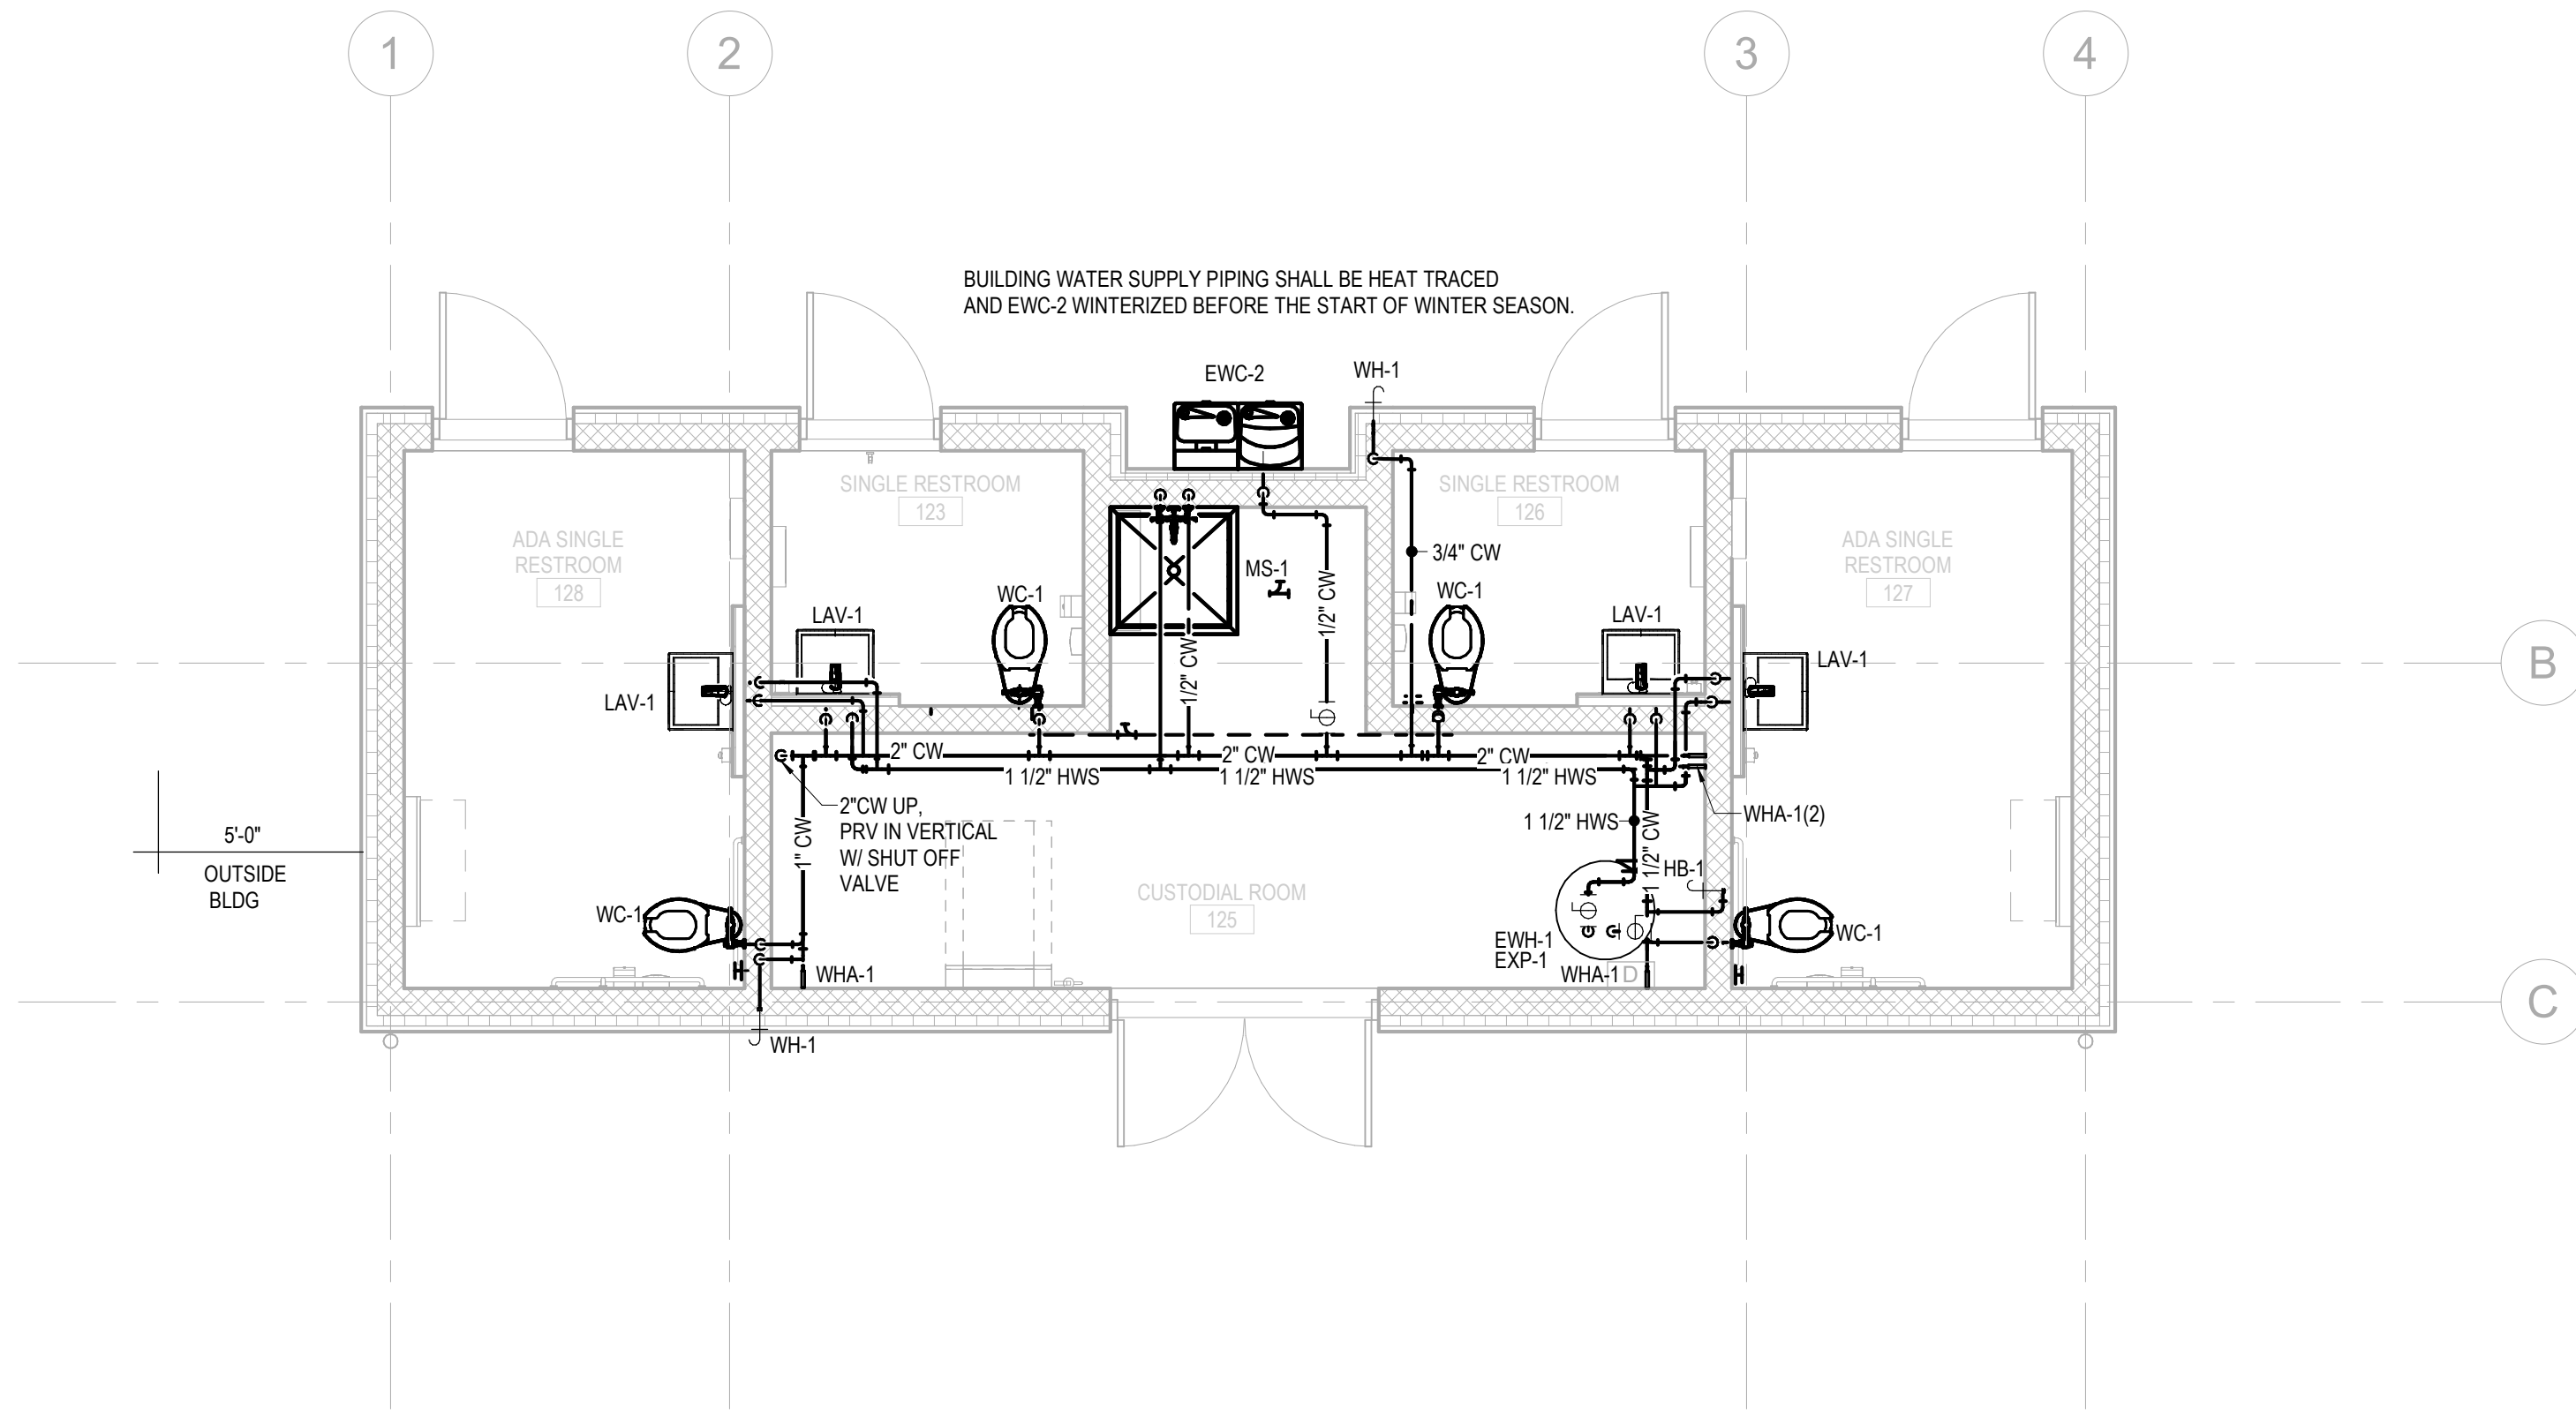

2 DOMESTIC WATER PLAN
ES-P101/ 1/4" = 1'-0"

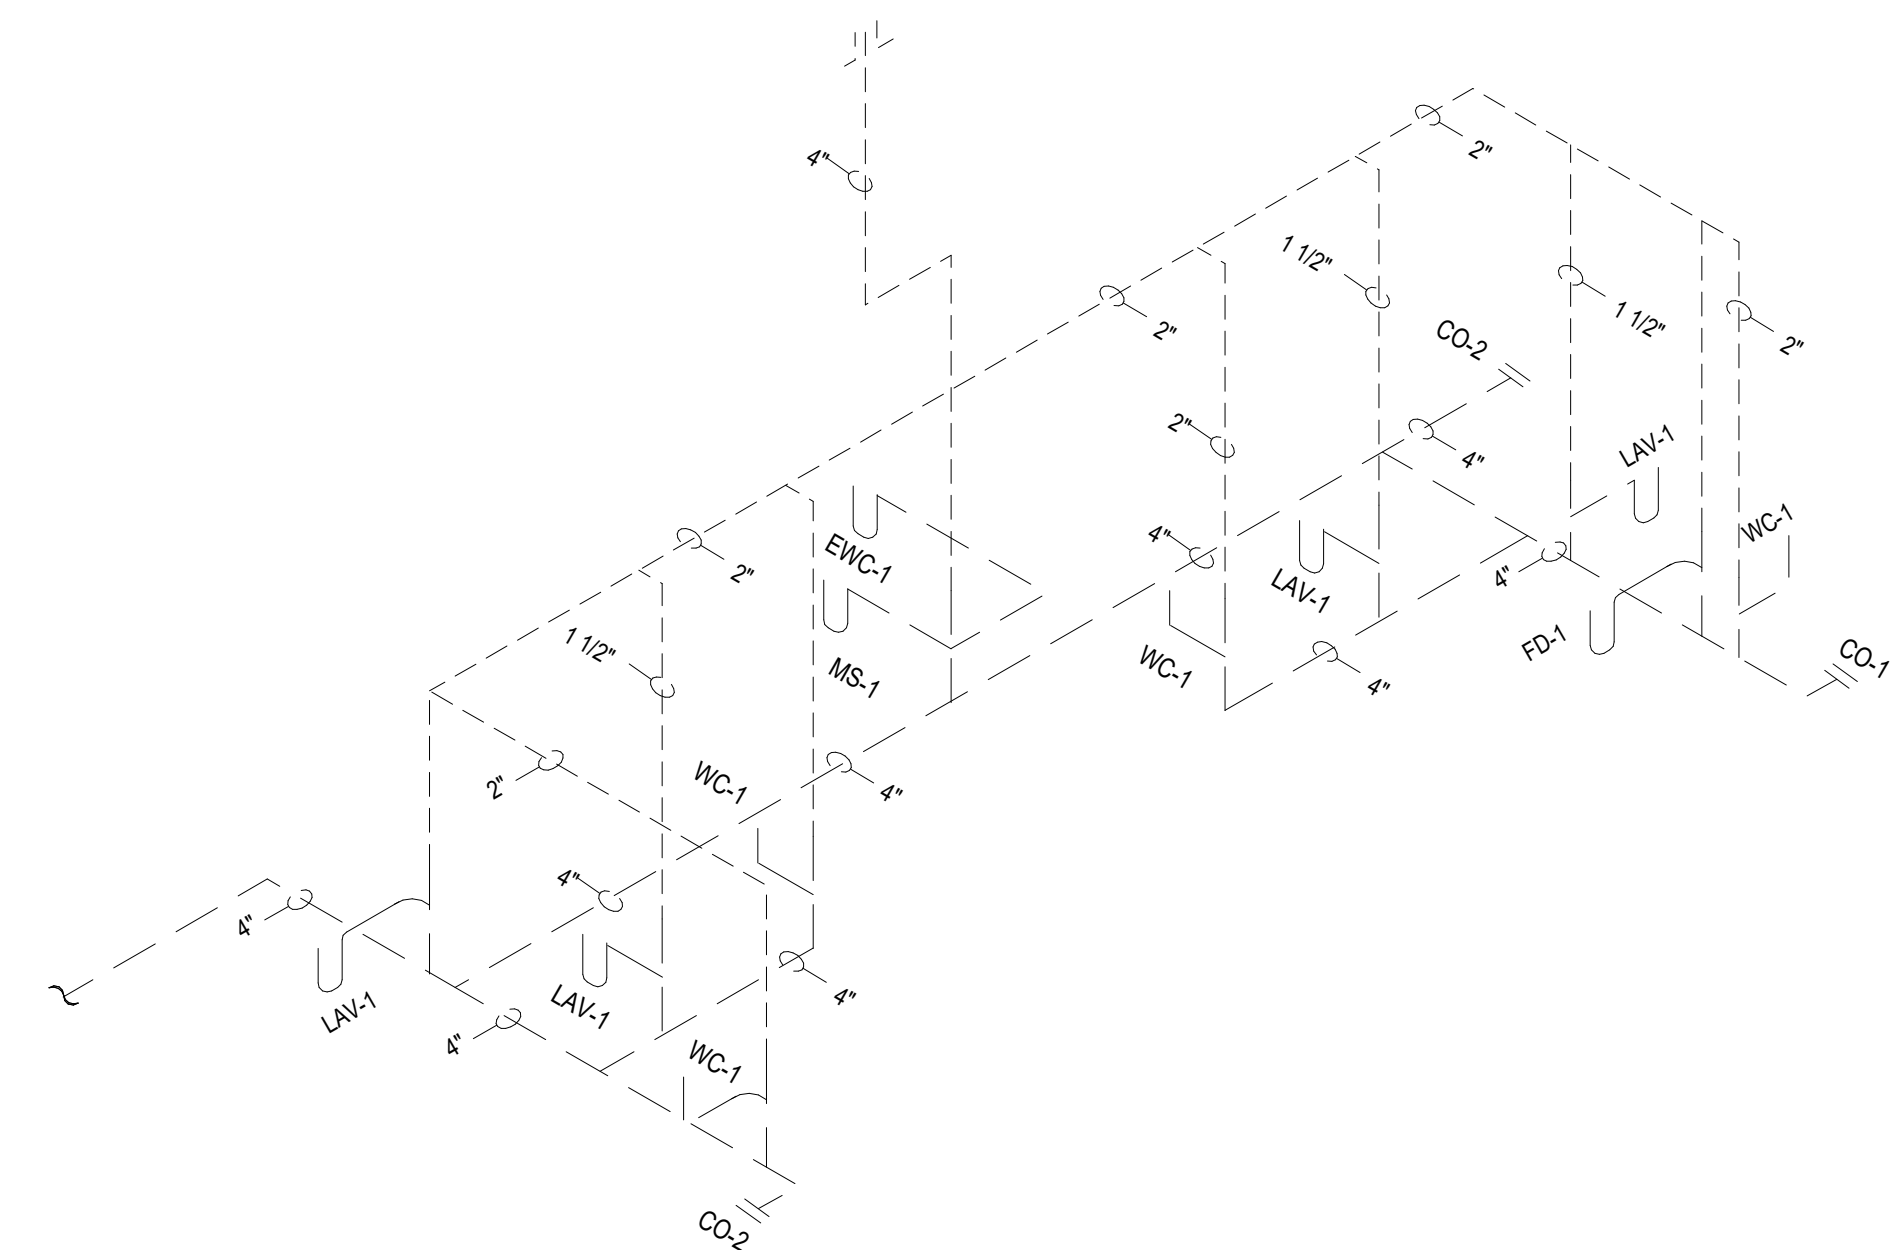

3 WASTE AND VENT RISER DIAGRAM
ES-P101/ NOT TO SCALE

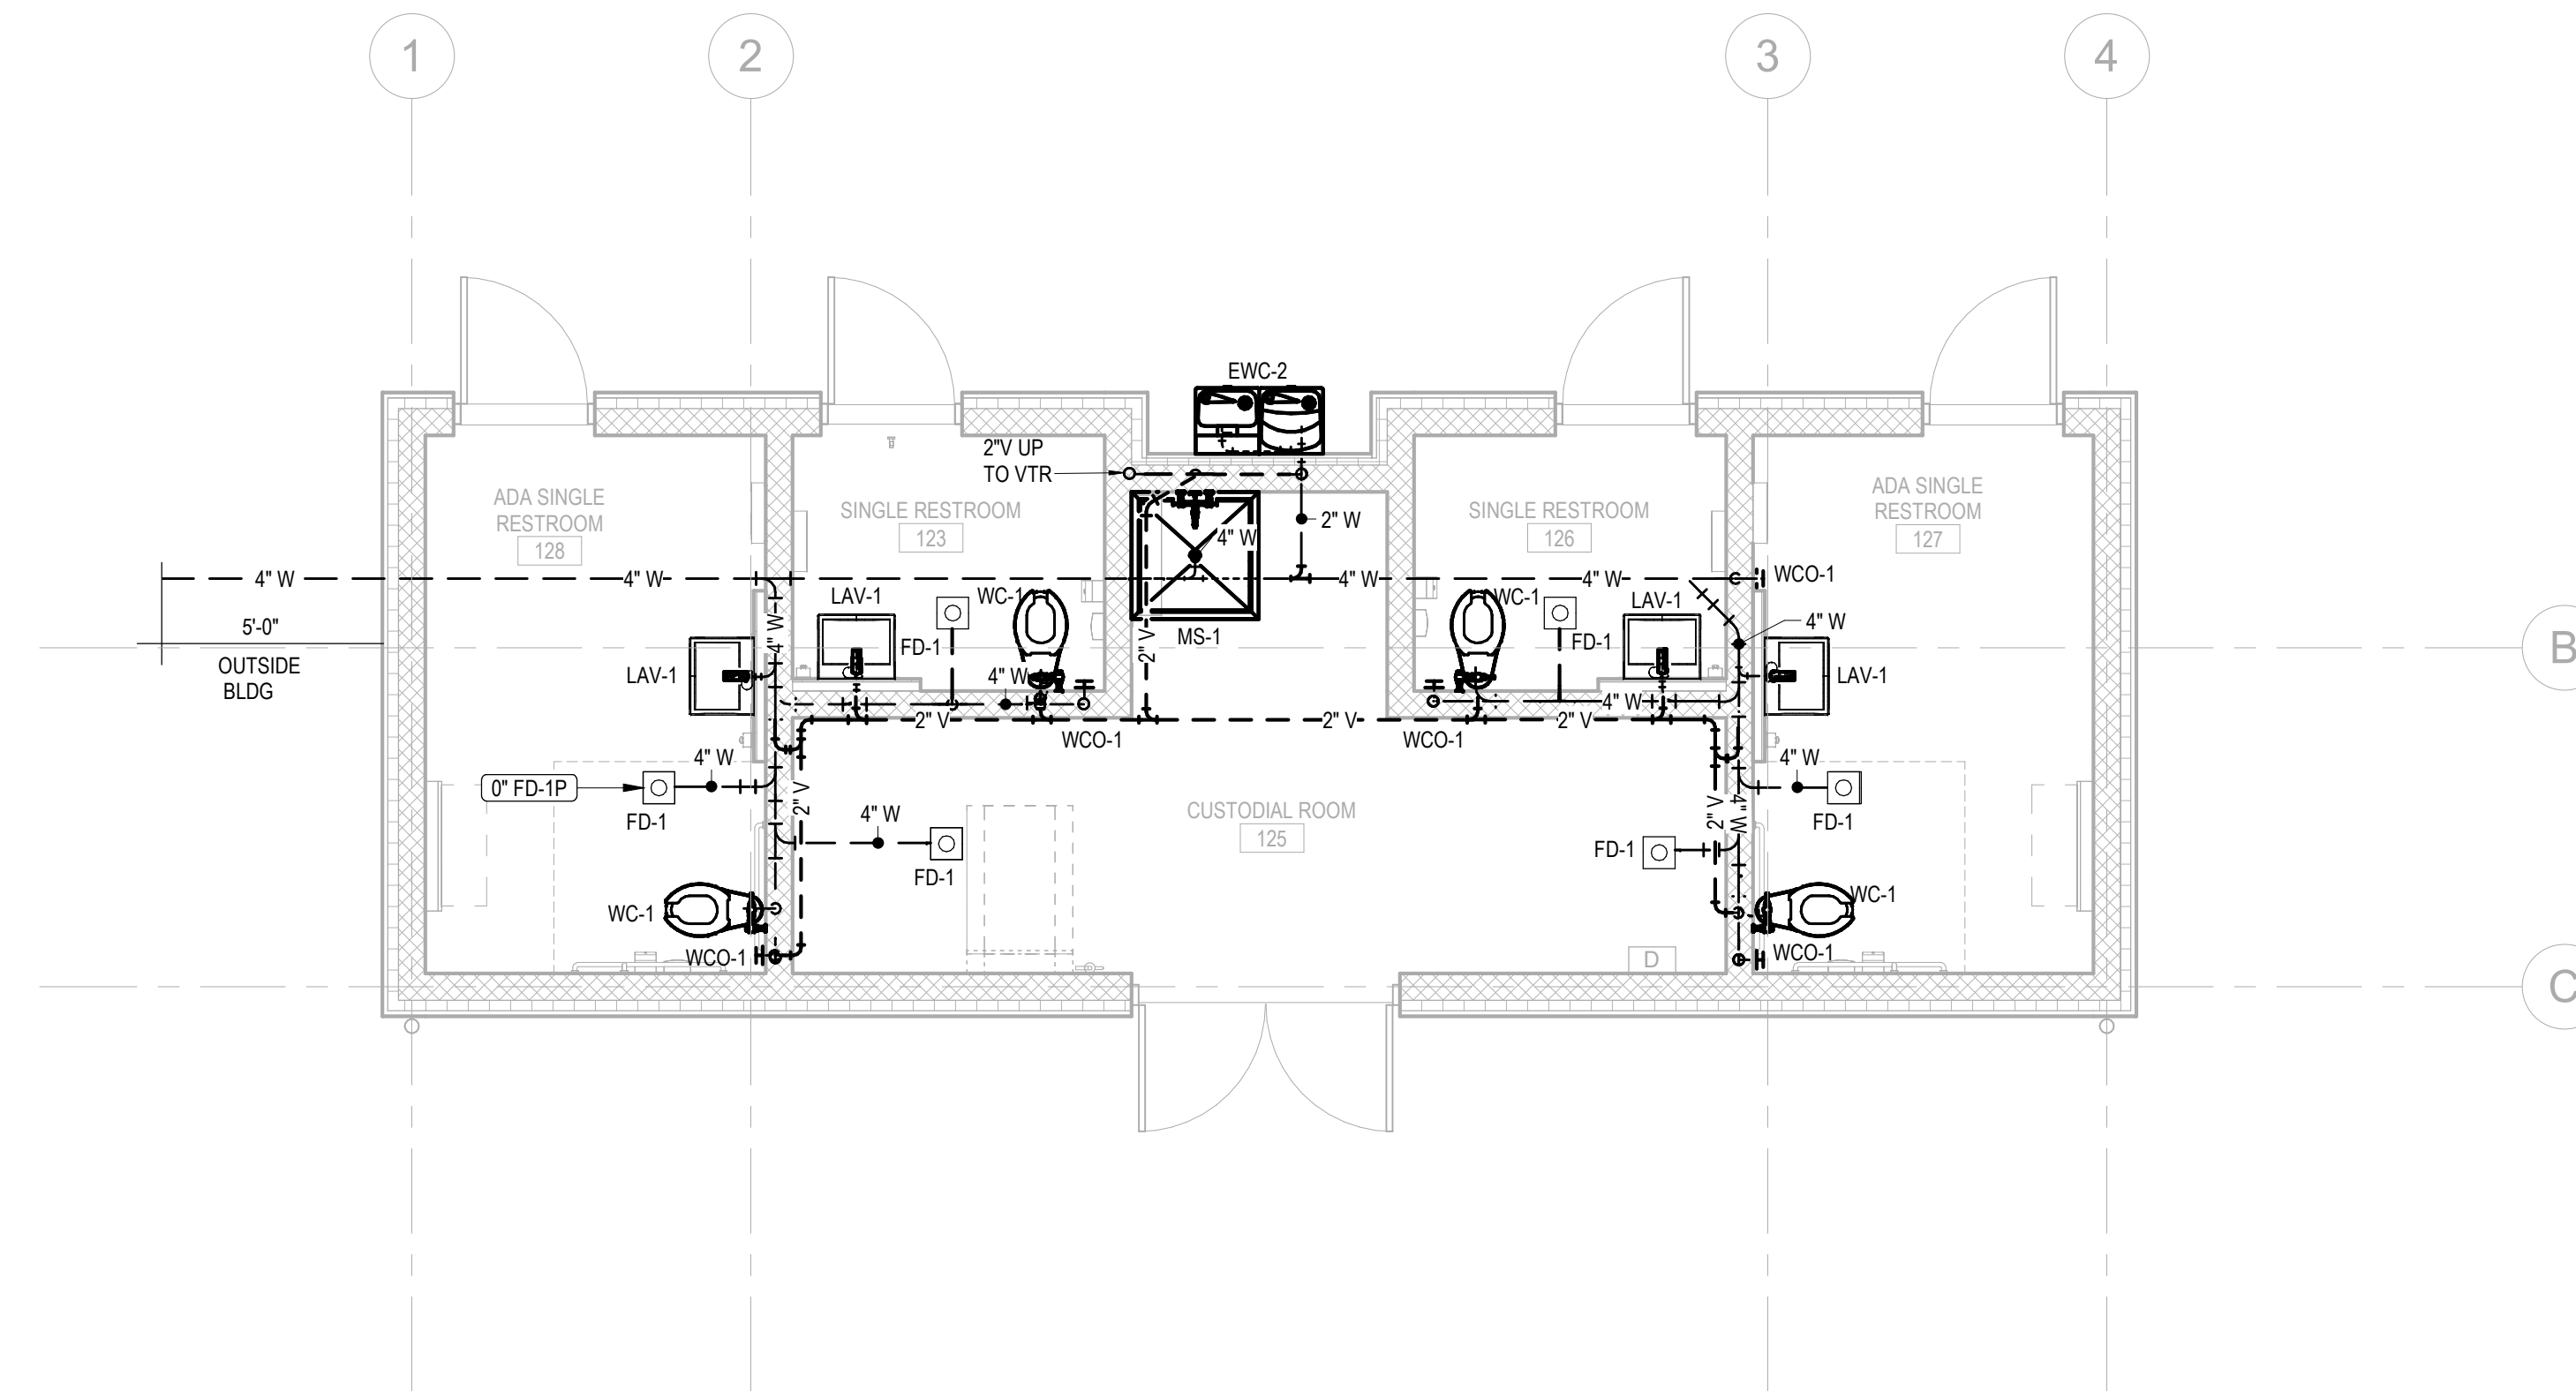


1 DWV PIPING PLAN
ES-P101/ 1/4" = 1'-0"

Susan Hatchell
Landscape Architecture, PLLC
711 W. North Street, Raleigh, NC 27603
p: 919-838-9600 f: 919-838-9700

Wooten
120 North Boylan Avenue • Raleigh, NC 27603-1423
(919) 828-0331 • newwoodcompany.com
License Number: 74915

FLOOR
PLANS

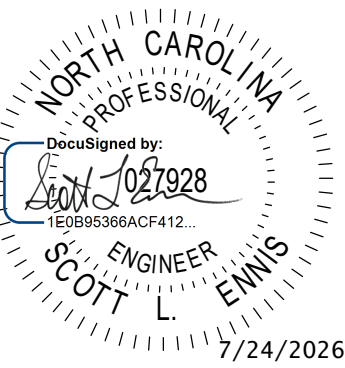


LAKE MYRA COUNTY PARK
Wake County, NC


REVISIONS

Date: 07/27/26


ES-P101

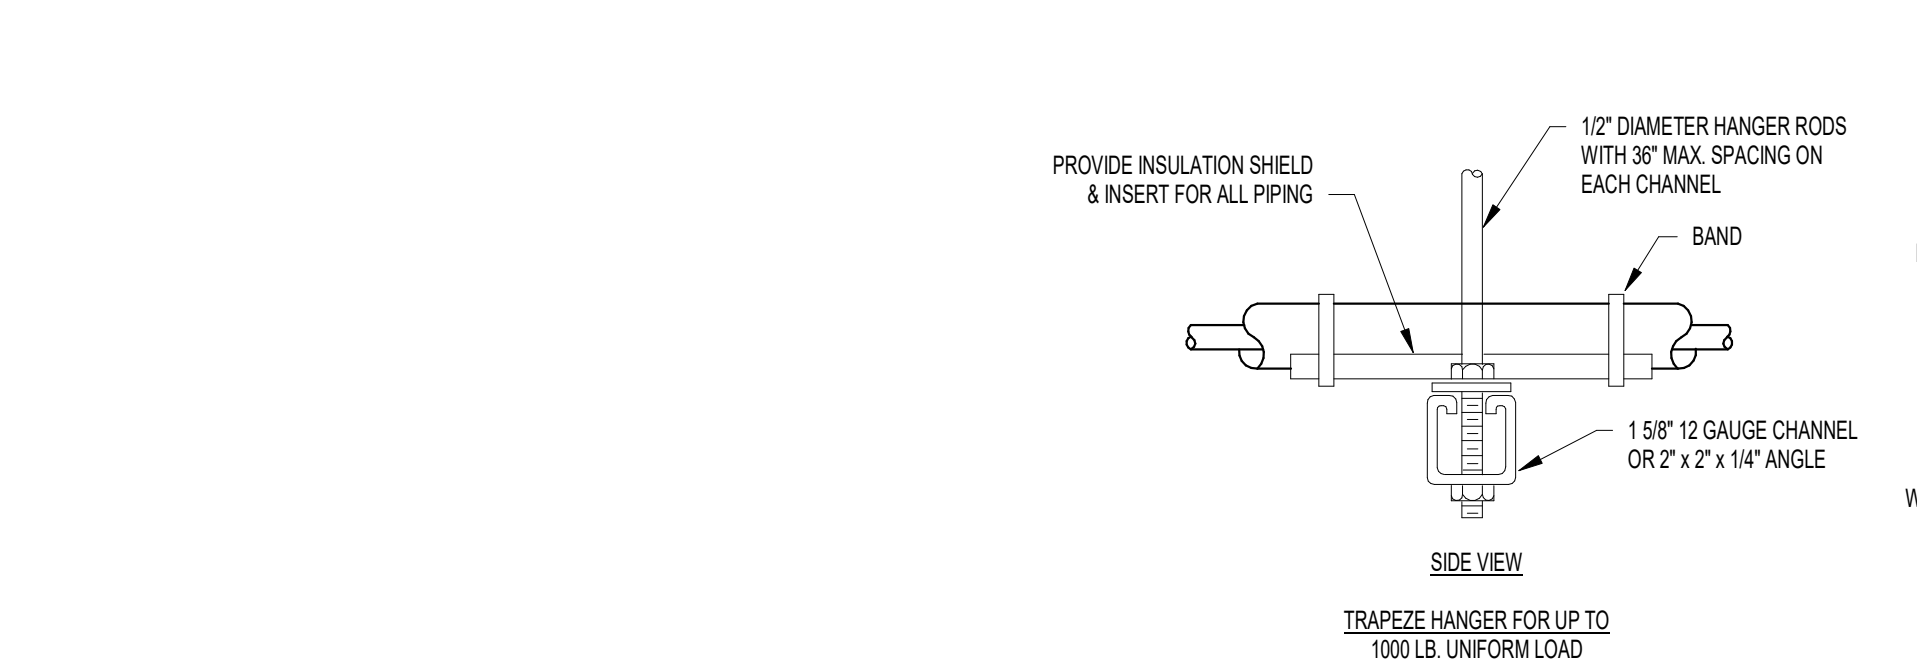



6
ES-P700 PIPE HANGER DETAIL - A
NOT TO SCALE

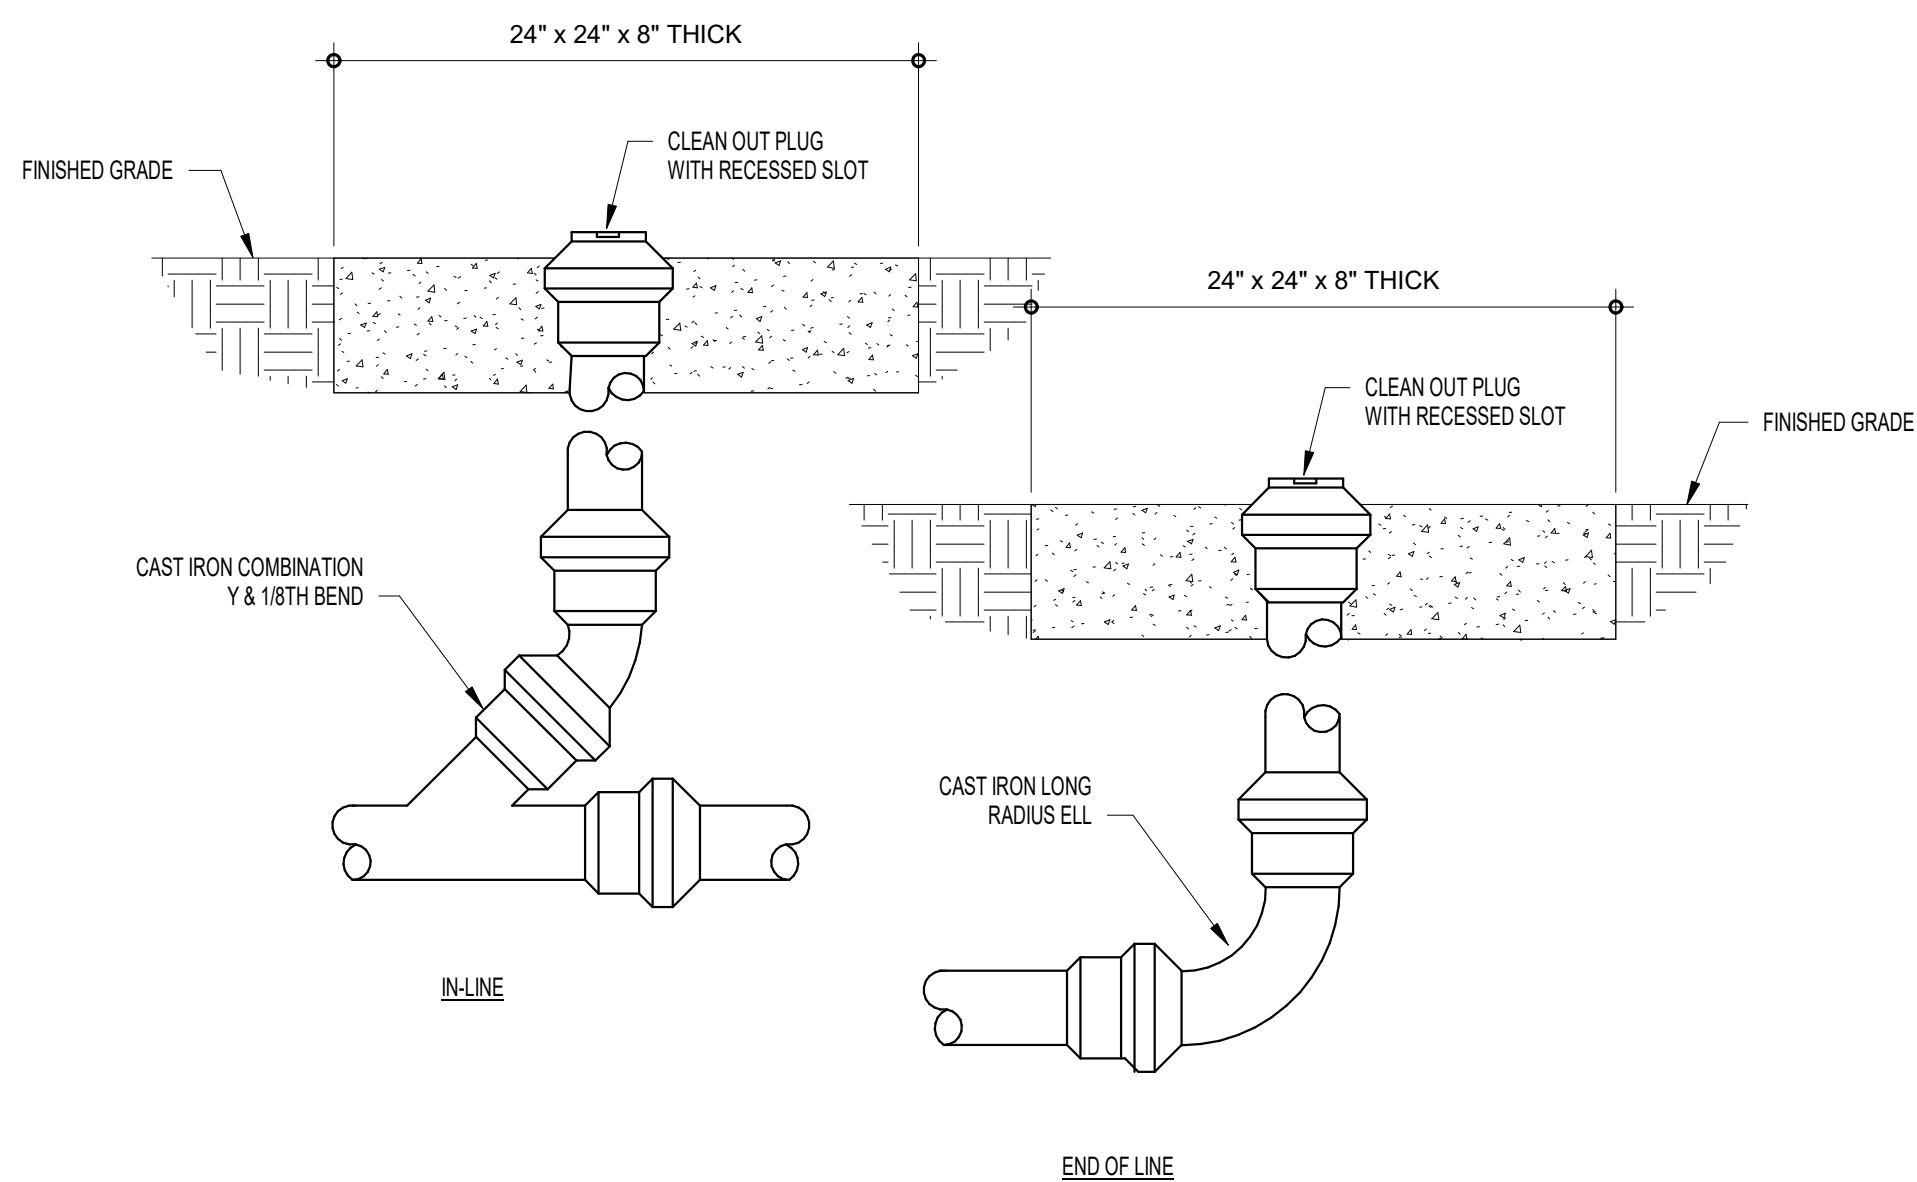


4
ES-P700 EXTERIOR CLEANOUT DETAIL
NOT TO SCALE

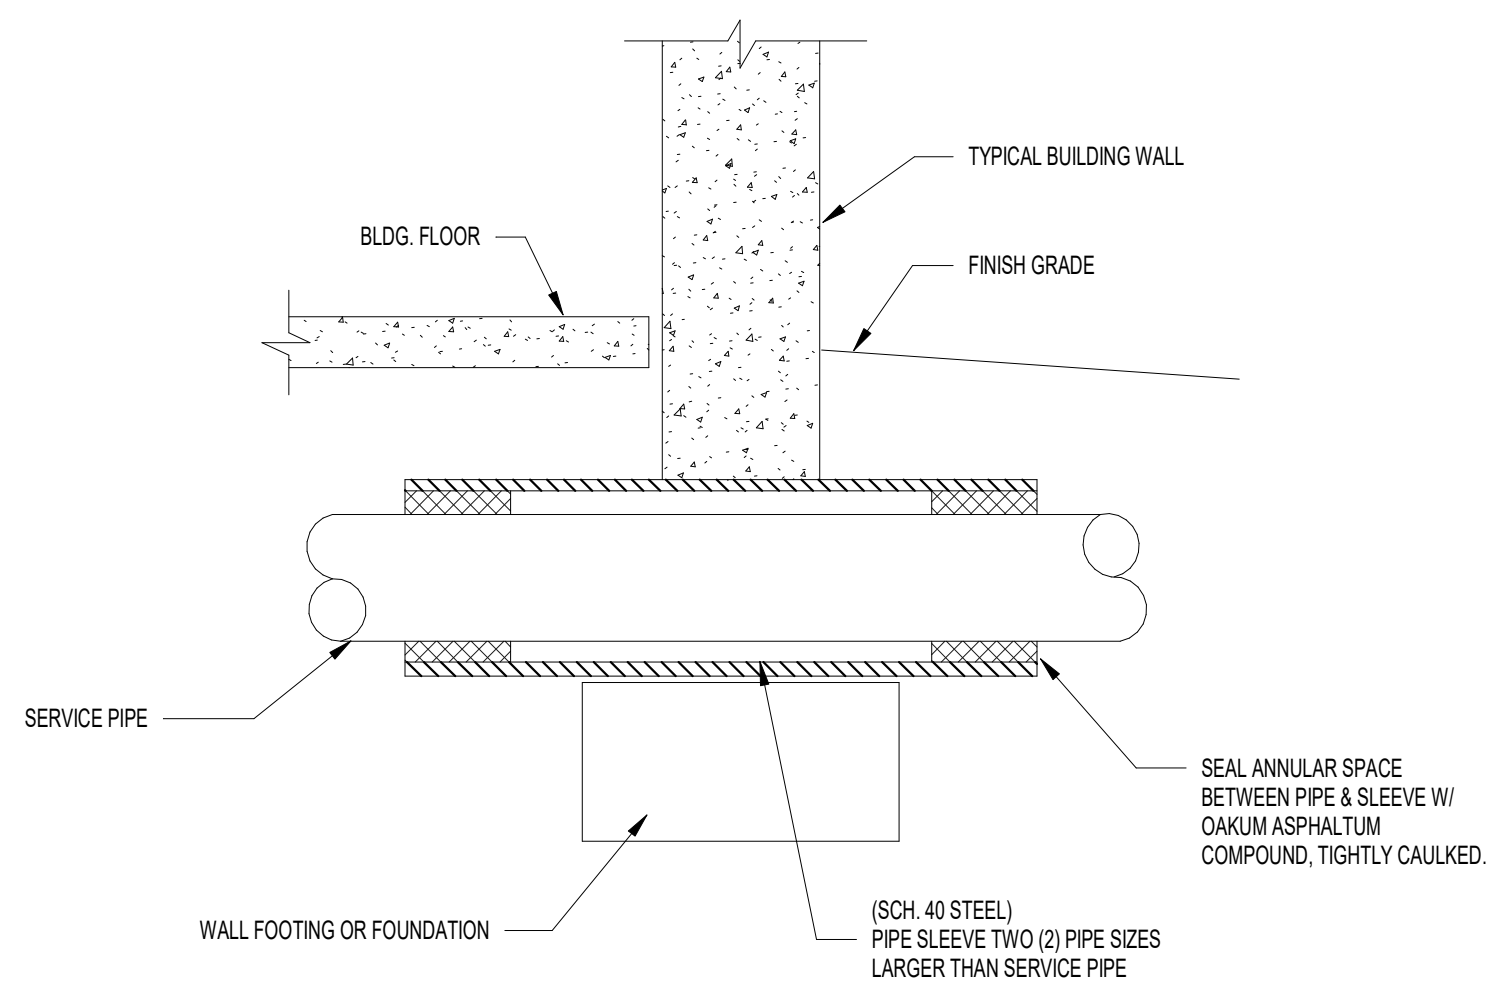



1
ES-P700 TYPICAL PIPE SLEEVE DETAIL - EASTERN PARCEL
NOT TO SCALE

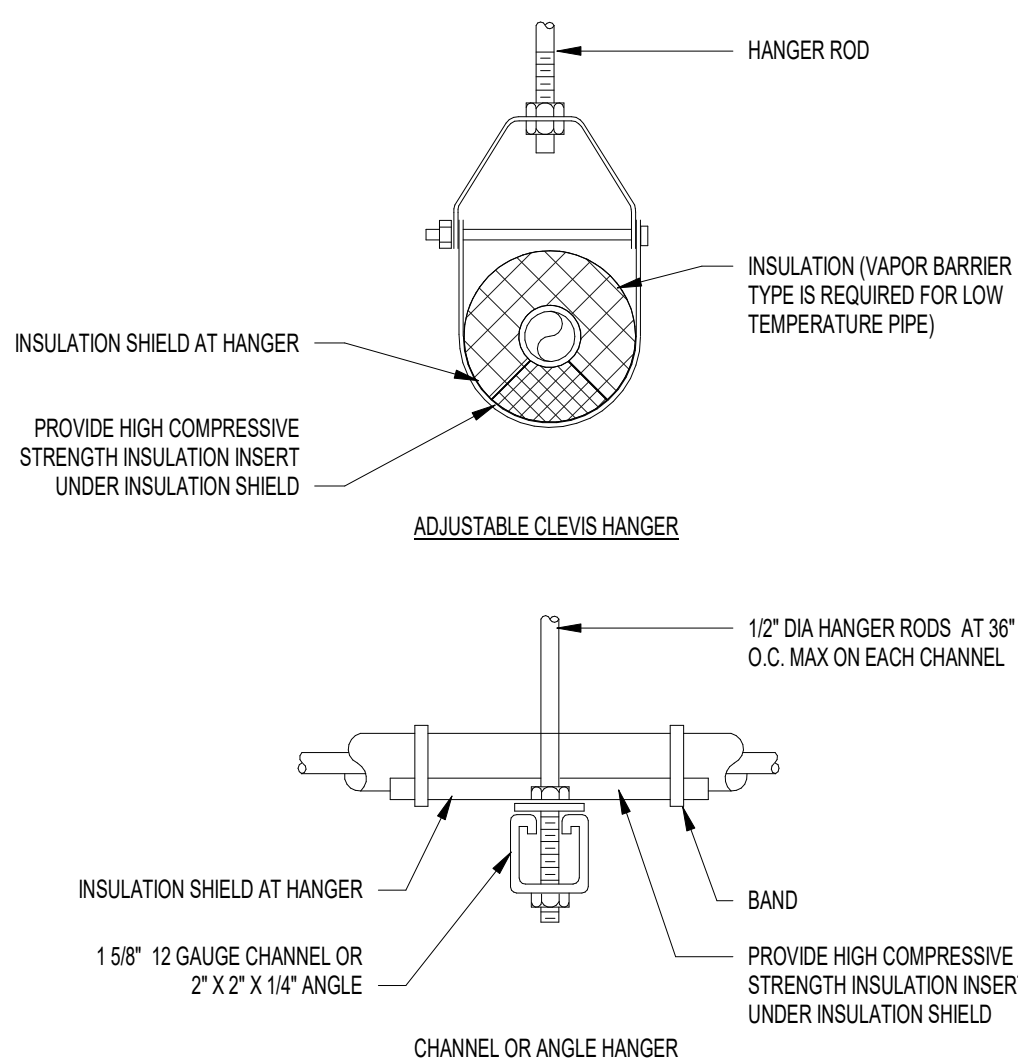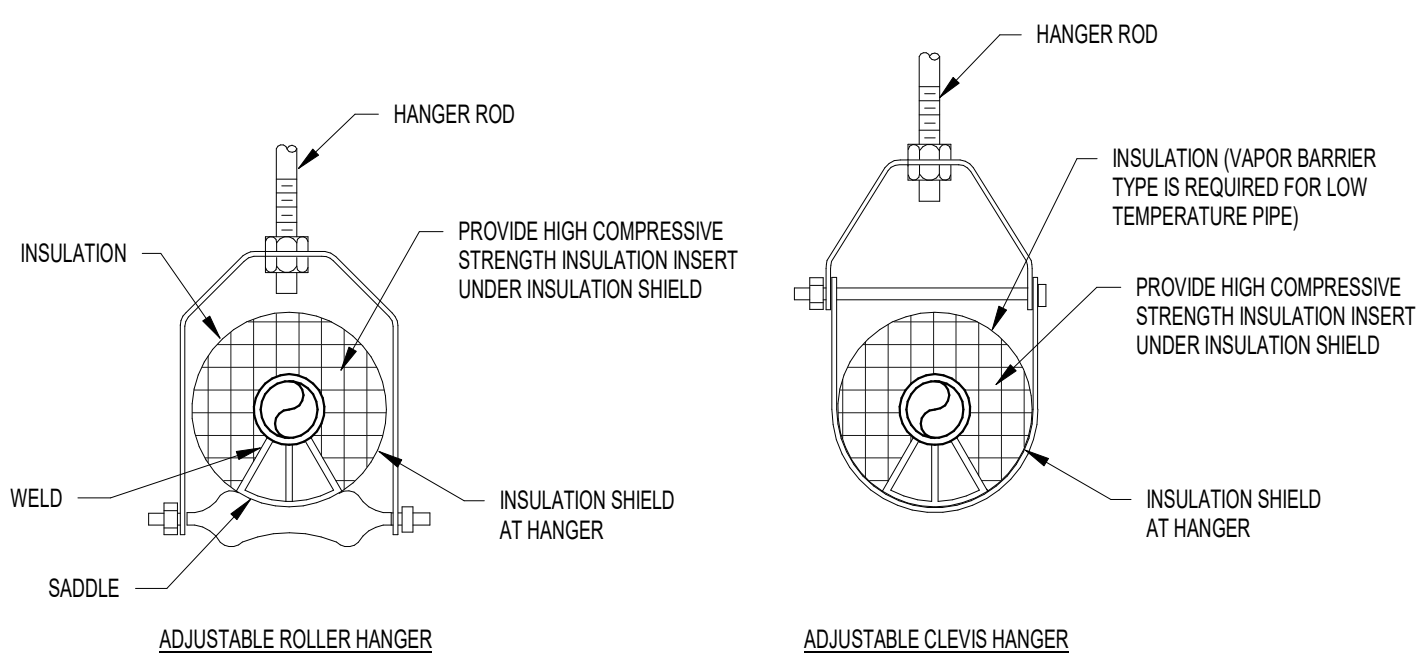


5
ES-P700 PIPE HANGER DETAIL
NOT TO SCALE

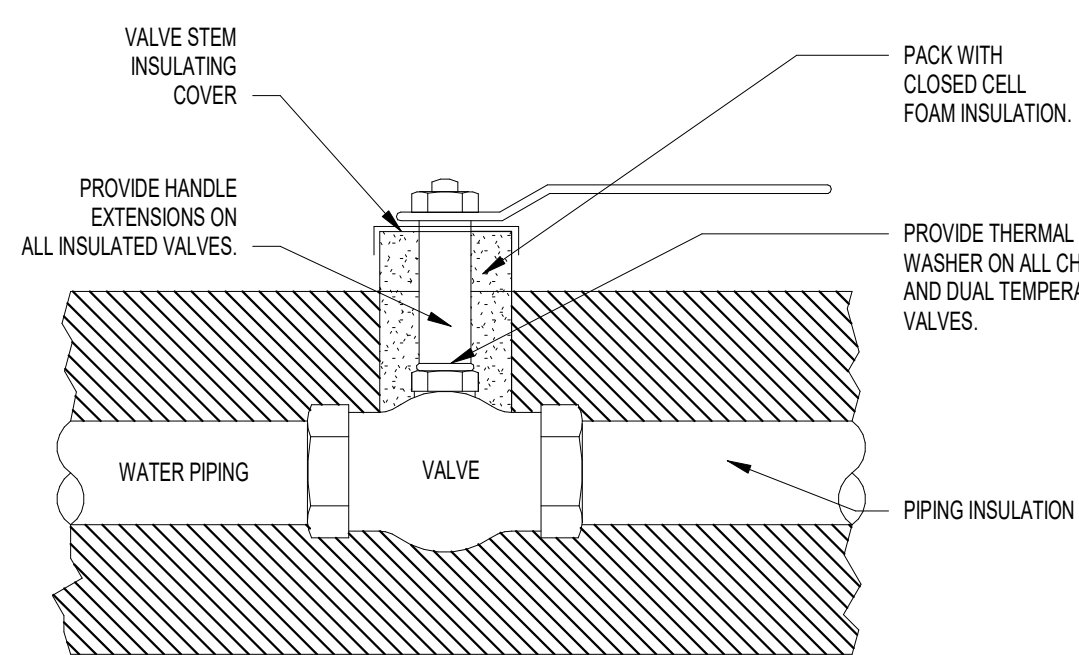

3
ES-P700 TYPICAL BALL VALVE INSTALLATION DETAIL
NOT TO SCALE

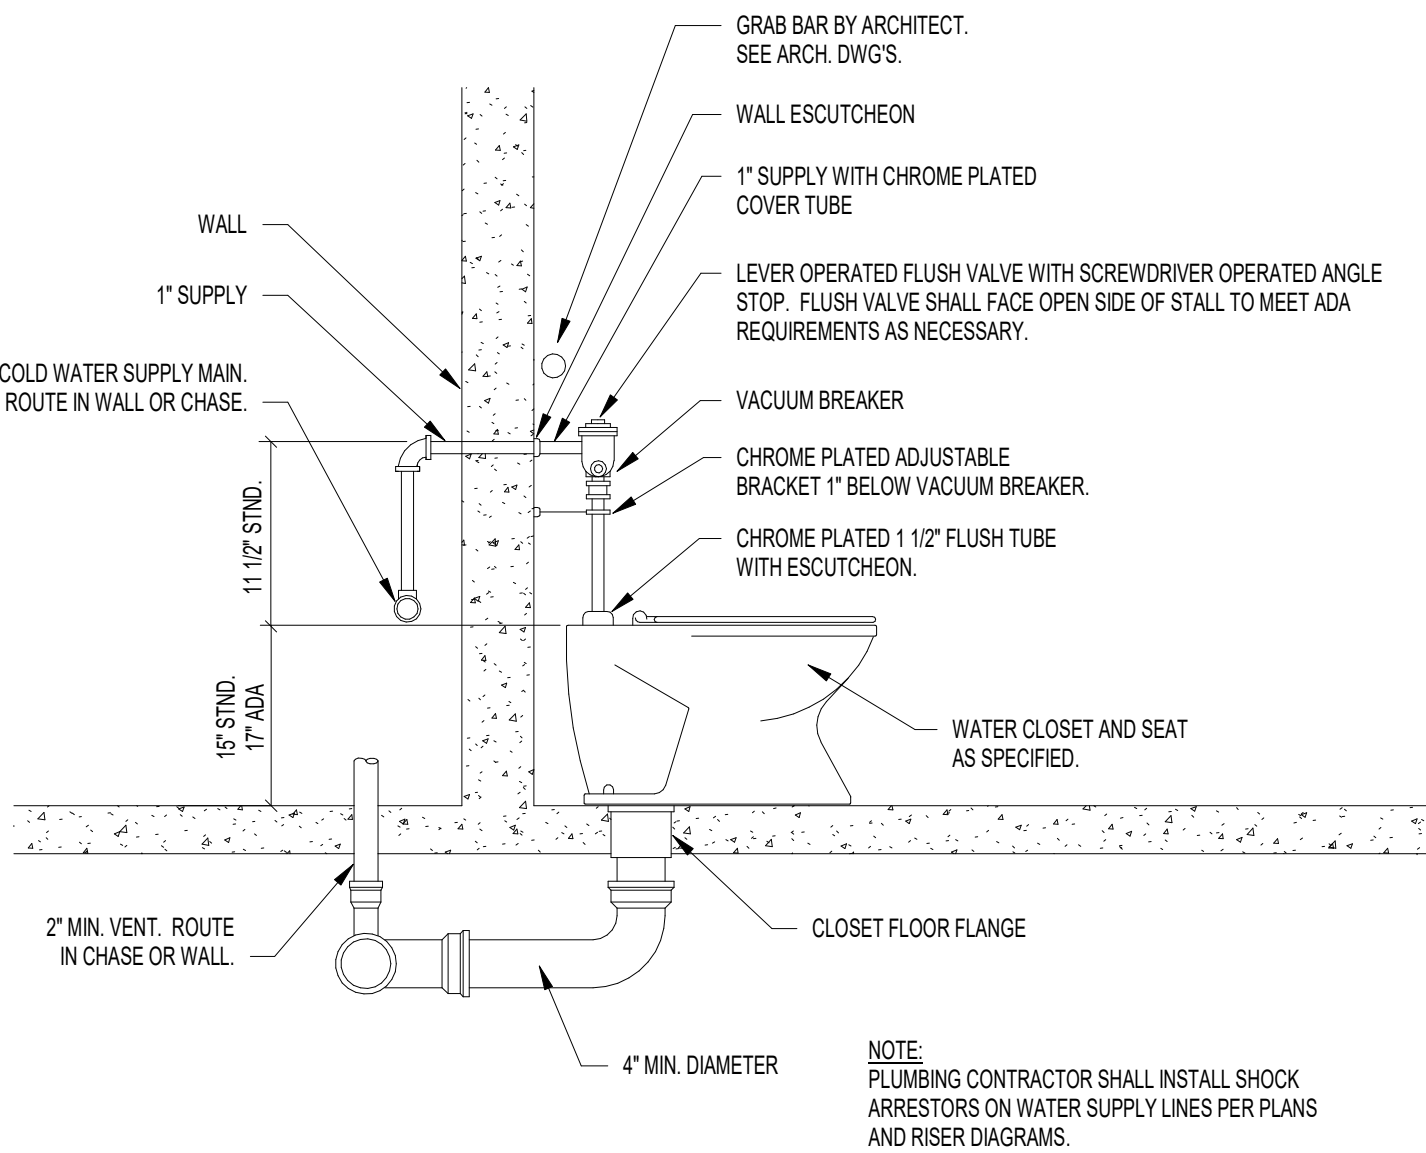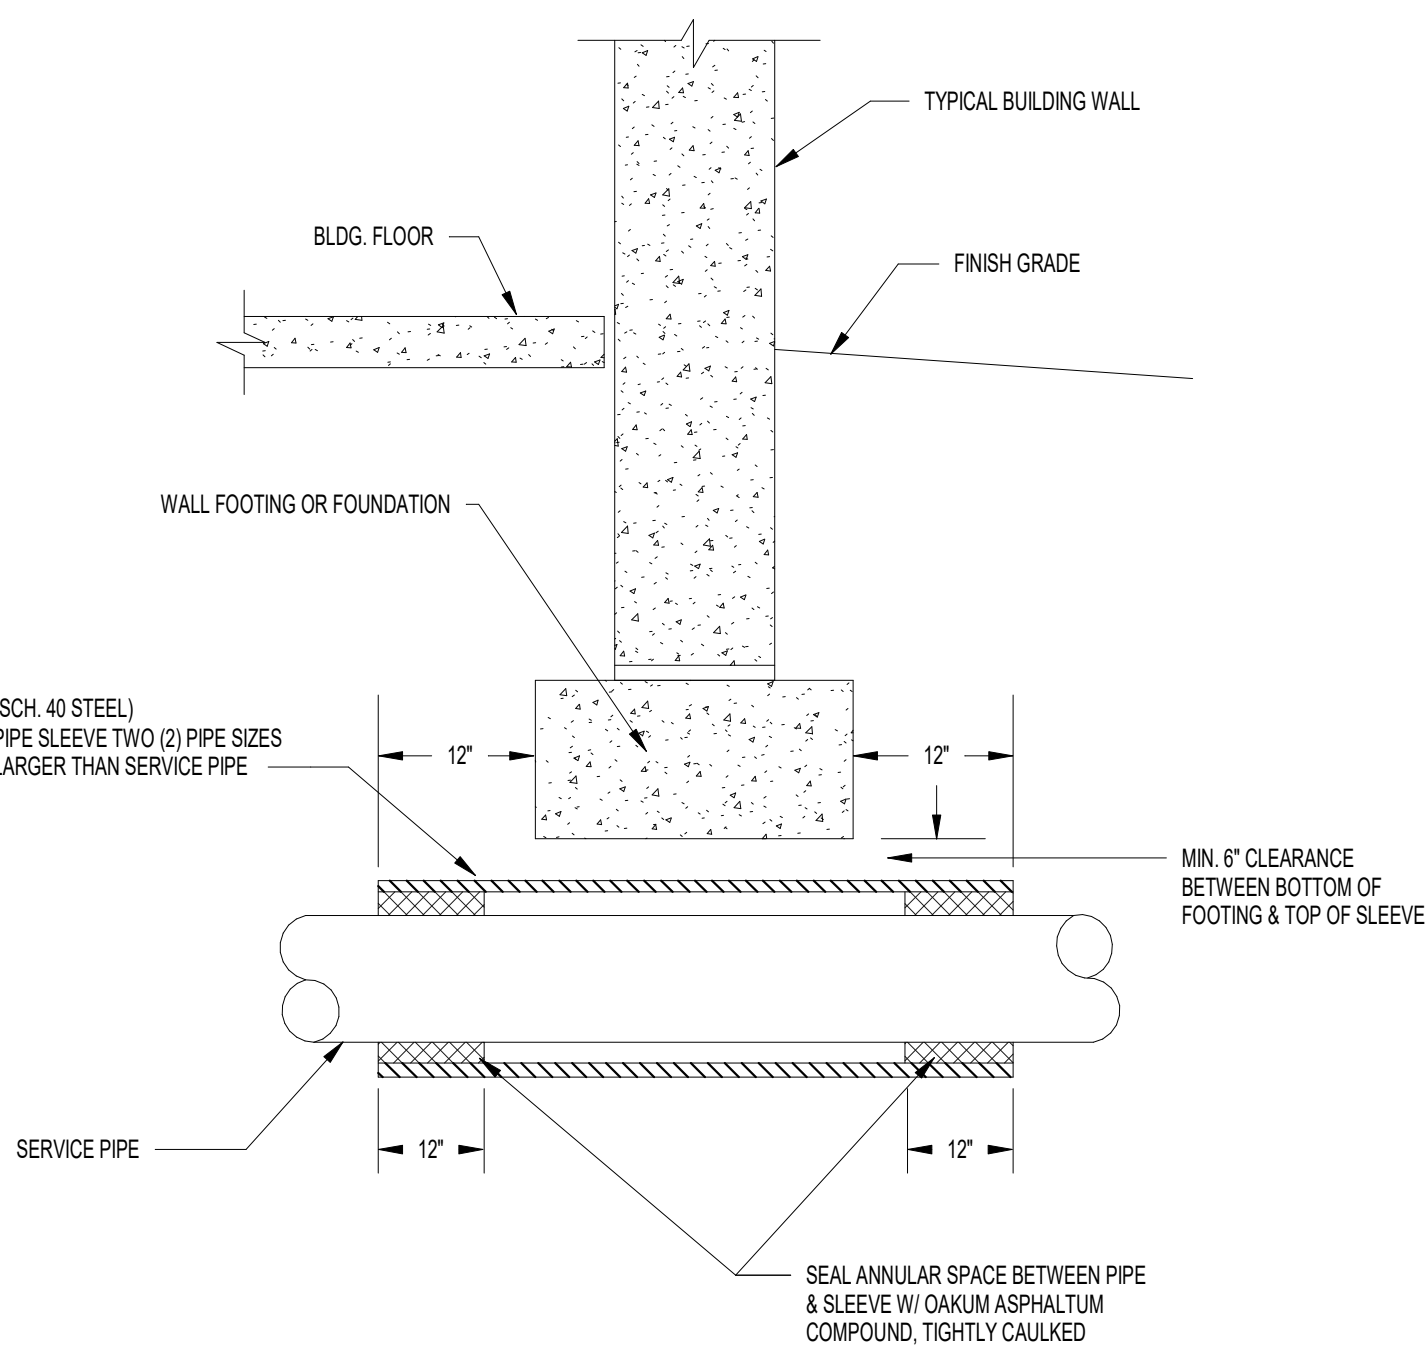


2
ES-P700 FLOOR MOUNTED WATER CLOSET DETAIL
NOT TO SCALE

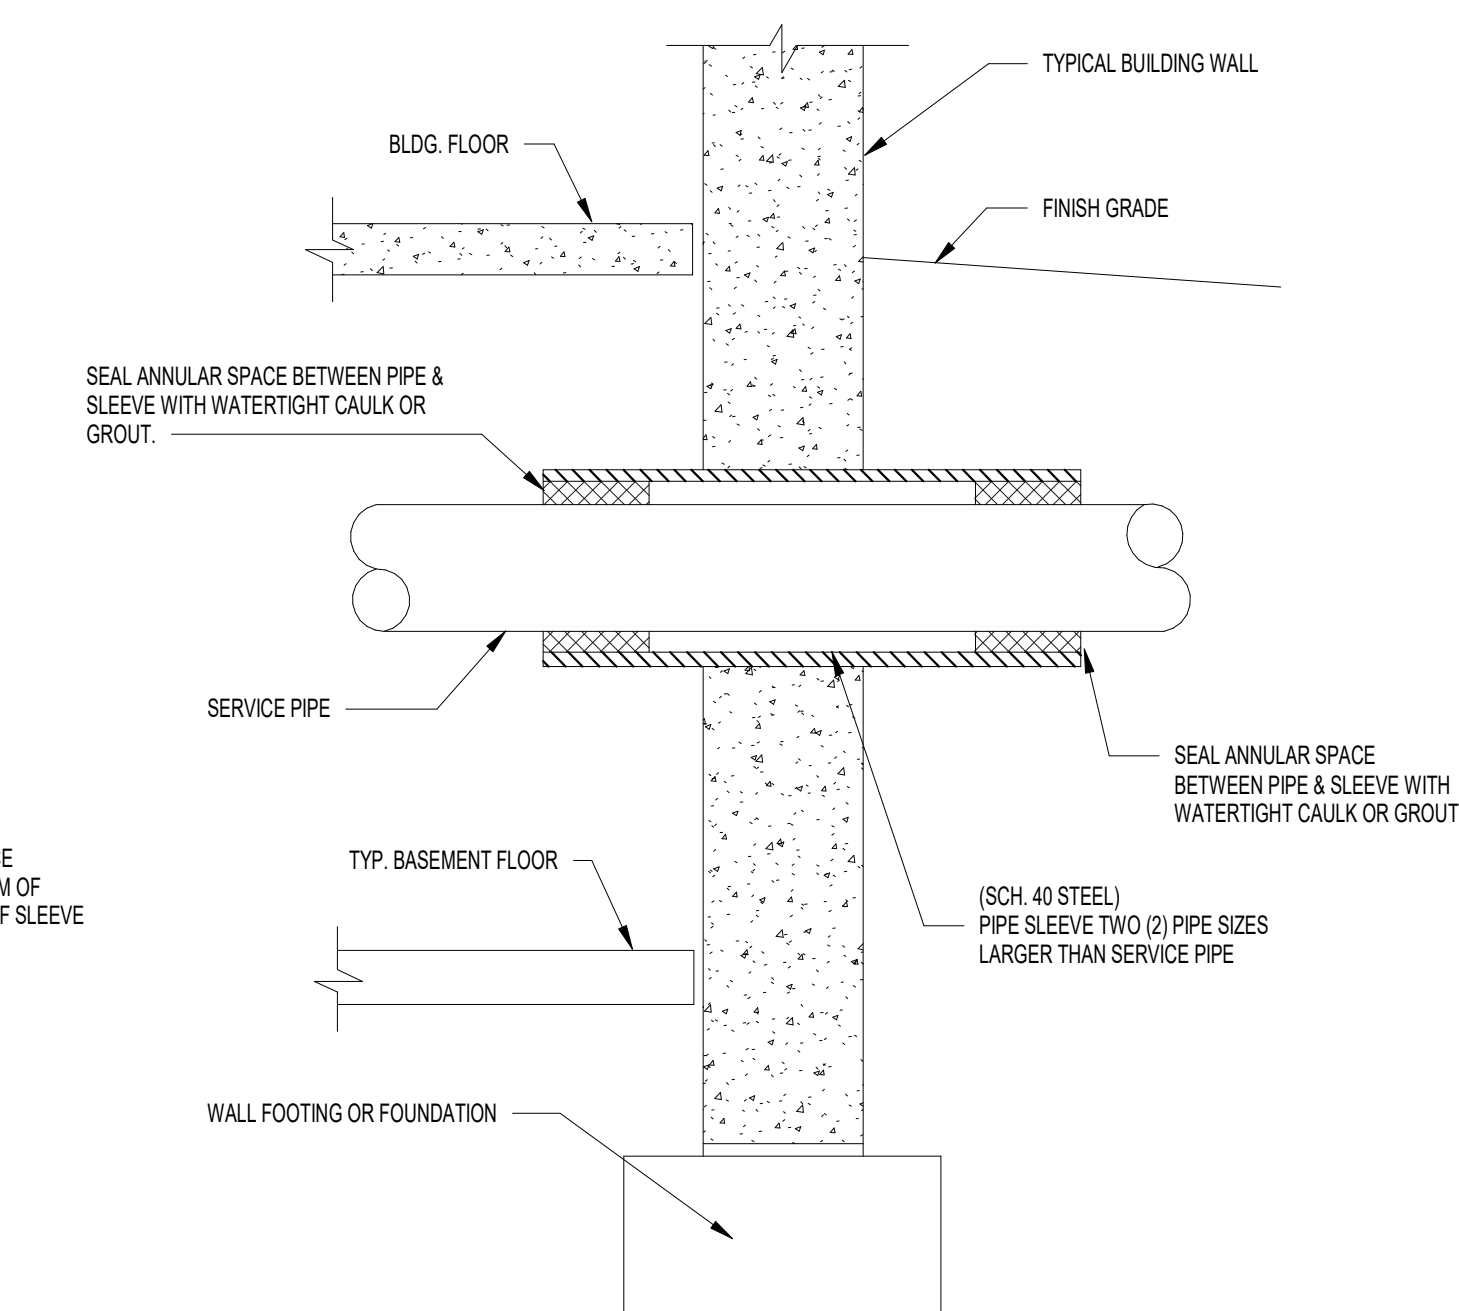

Susan Hatchell
Landscape Architecture, PLLC
711 W. North Street, Raleigh, NC 27603
p: 919-838-9600 f: 919-838-9700

Wooten
120 North Boylan Avenue • Raleigh, NC 27603-1423
(919) 828-0031 • www.wootencompany.com
License Number: 7-9715

DETAILS

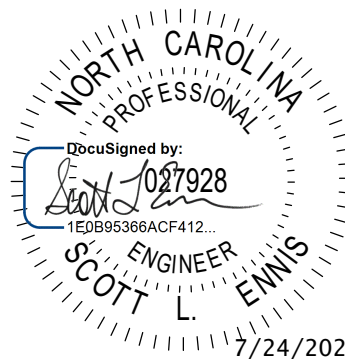


LAKE MYRA COUNTY PARK
Wake County, NC

REVISIONS

Date: 07/27/26

ES-P700

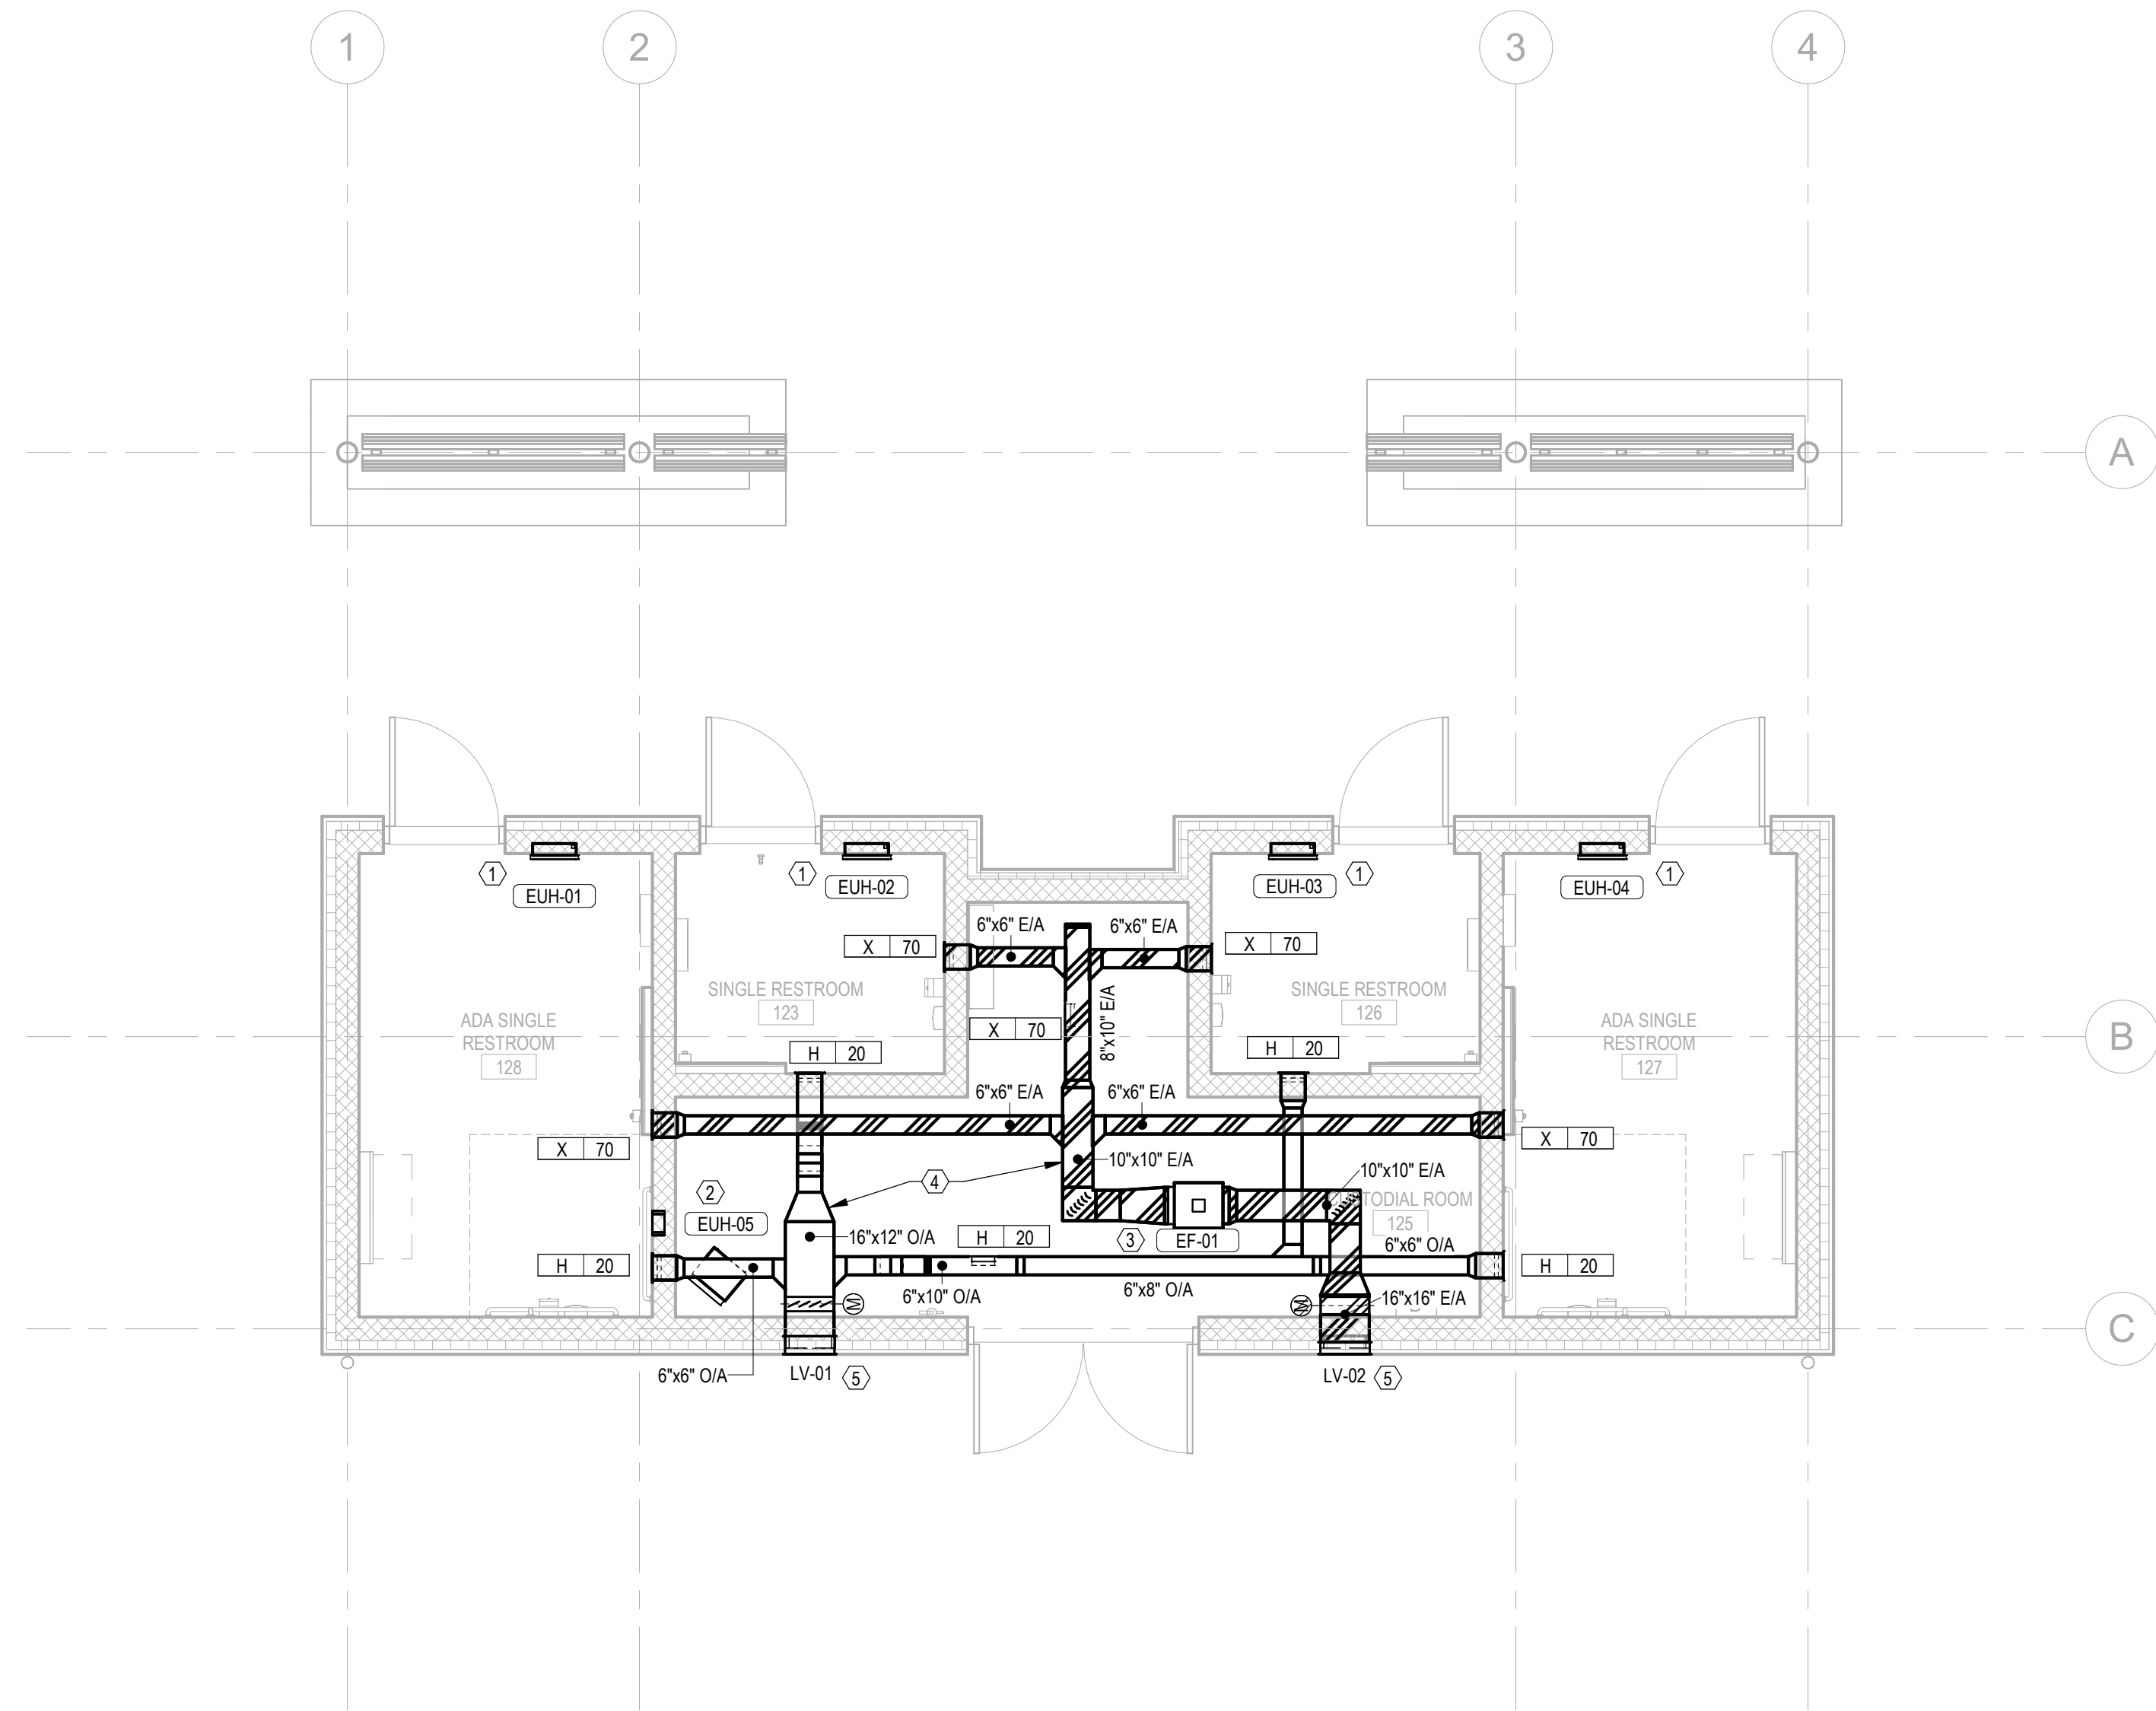

1 HVAC PLAN
ES-M101 1/4" = 1'-0"


KEY NOTES

- 1 INSTALL WALL HEATER PER MANUFACTURER'S INSTALLATION INSTRUCTIONS AND CLEARANCES. INSTALL AT 10" A.F.F. AS MEASURED TO BOTTOM OF UNIT.
- 2 INSTALL UNIT HEATER PER MANUFACTURER'S INSTALLATION INSTRUCTIONS AND CLEARANCES.
- 3 INSTALL EXHAUST FAN PER MANUFACTURER'S INSTALLATION INSTRUCTIONS AND CLEARANCES.
- 4 ROUTE EXHAUST AND OUTSIDE AIR DUCTWORK HIGH THROUGH CUSTODIAL ROOM SPACE. ENSURE MINIMUM 6'-8" CLEAR BELOW ALL DUCTWORK.
- 5 LOUVER TO BE MOUNTED AT 8'-6" A.F.F. AS MEASURED TO BOTTOM OF LOUVER. MAINTAIN 10' BETWEEN EXHAUST DISCHARGE AND OUTSIDE AIR INTAKE.

Susan Hatchell
Landscape Architecture, PLLC
711 W. North Street, Raleigh, NC 27603
p: 919-838-9600 f: 919-838-9700

Wooten
120 North Boylan Avenue • Raleigh, NC 27603-1423
(919) 828-0031 • www.wootencompany.com
License Number: 7-9715

DUCTWORK PLANS

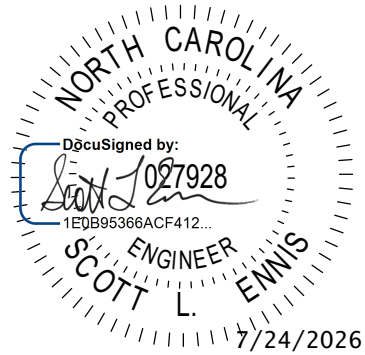


LAKE MYRA COUNTY PARK
Wake County, NC


REVISIONS

Date: 07/27/26


ES-M101

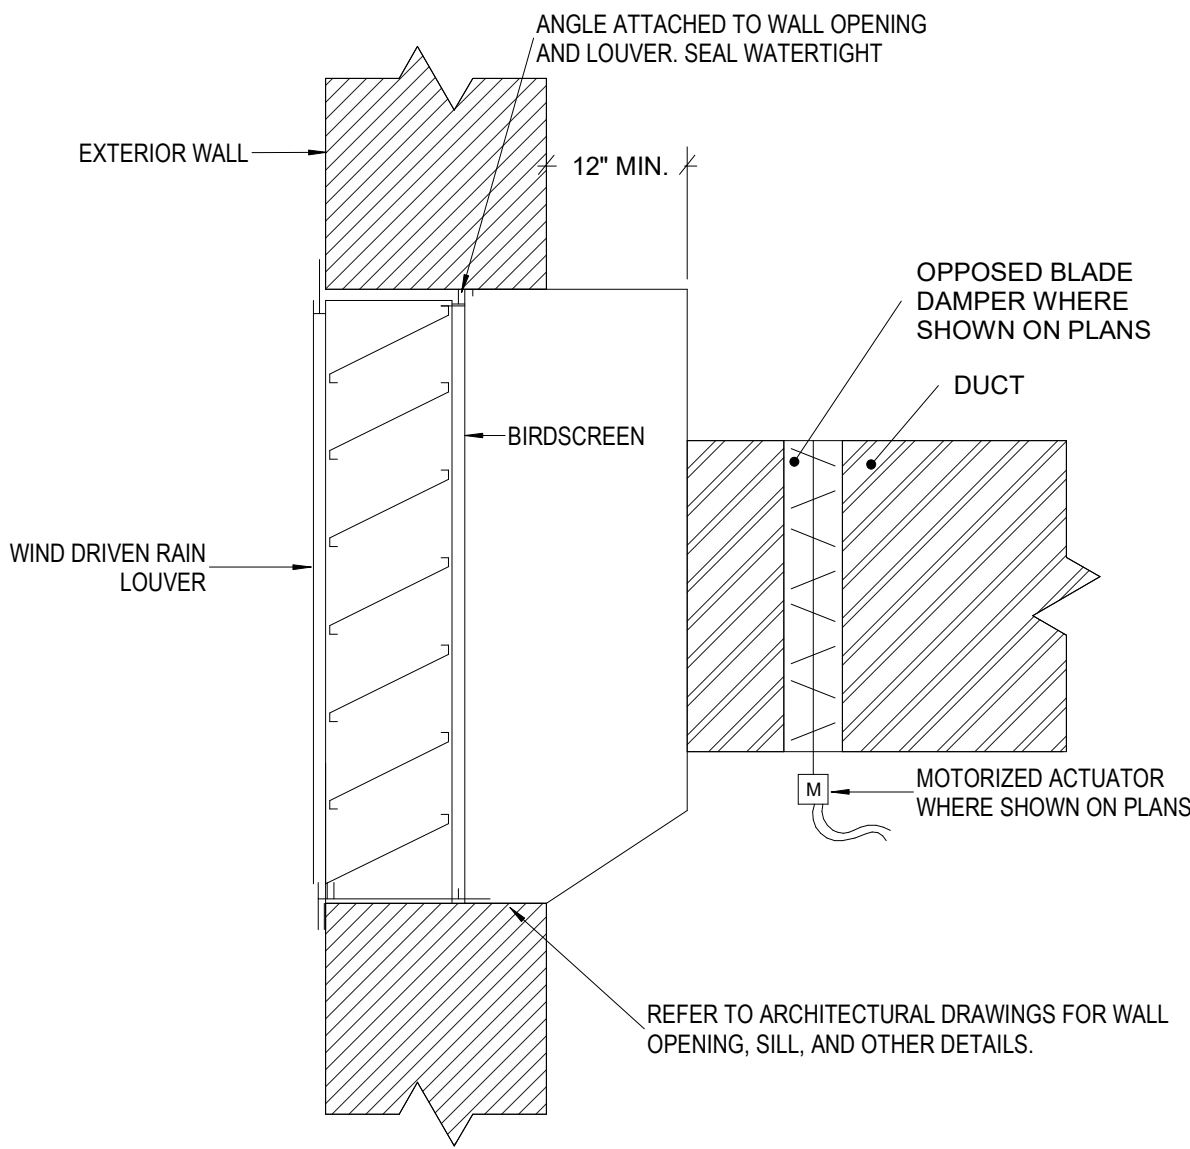


5
ES-M601
DETAIL - OUTSIDE AIR/EXHAUST LOUVER
1/8" = 1'-0"

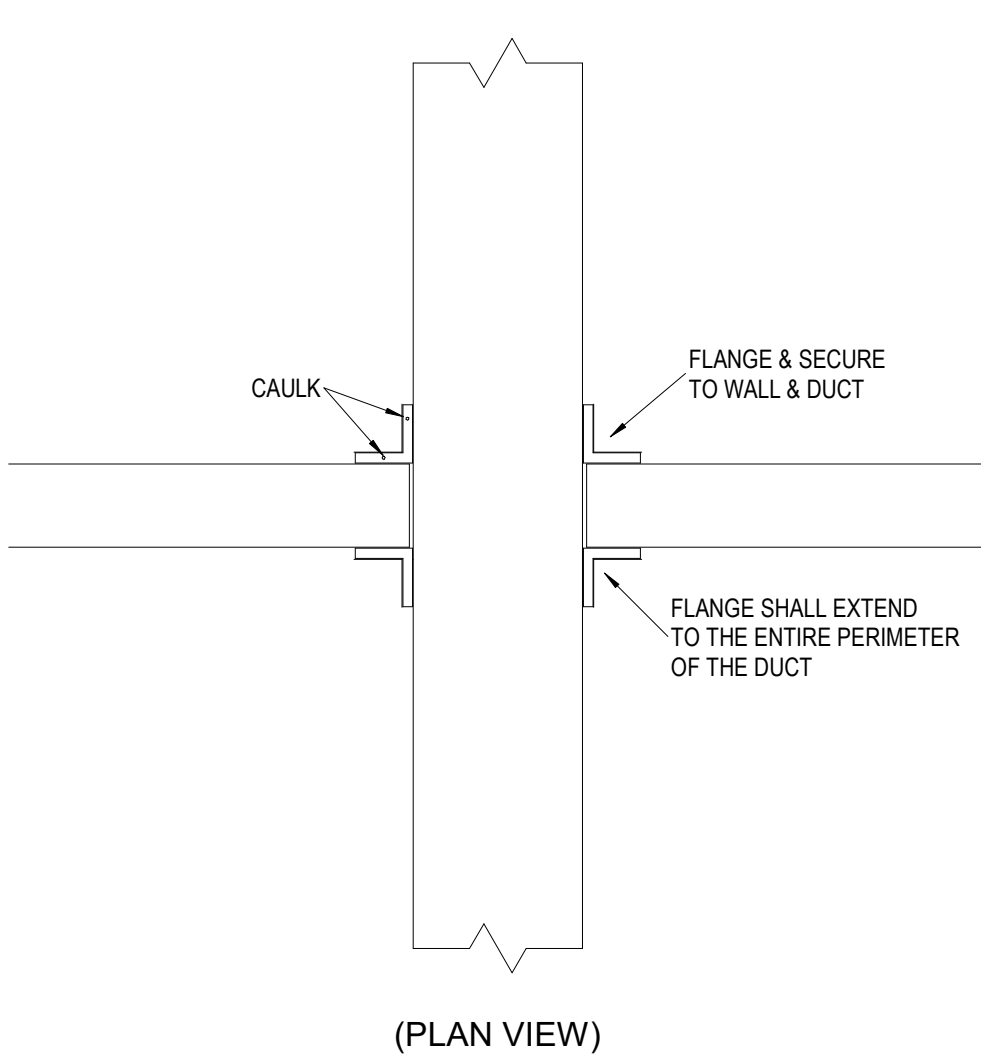


4
ES-M601
DETAIL - NON-RATED DUCT PENETRATION
NOT TO SCALE

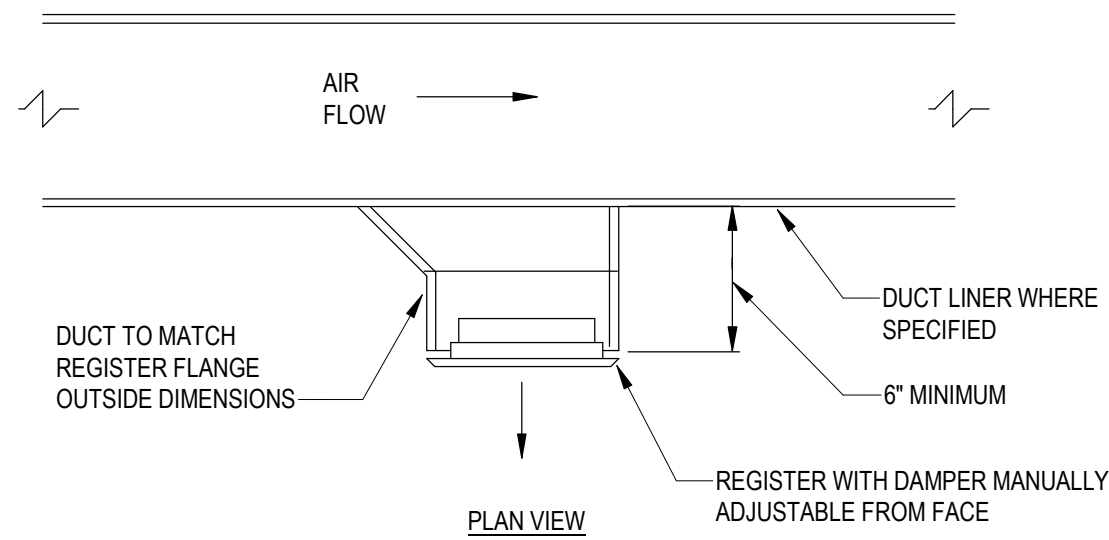

3
ES-M601
TYPICAL DUCT MOUNTED REGISTER (RECTANGULAR DUCT)
NOT TO SCALE

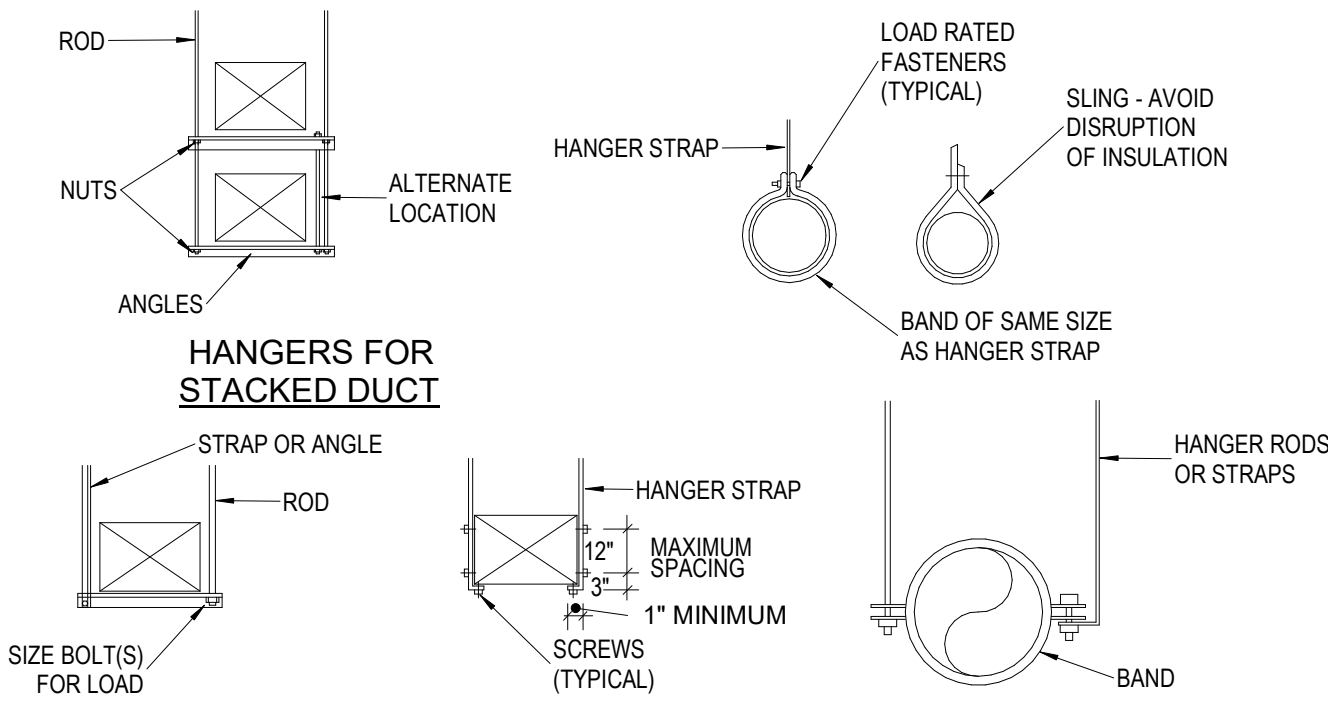

2
ES-M601
DETAIL - TYPICAL DUCT HANGERS
NOT TO SCALE

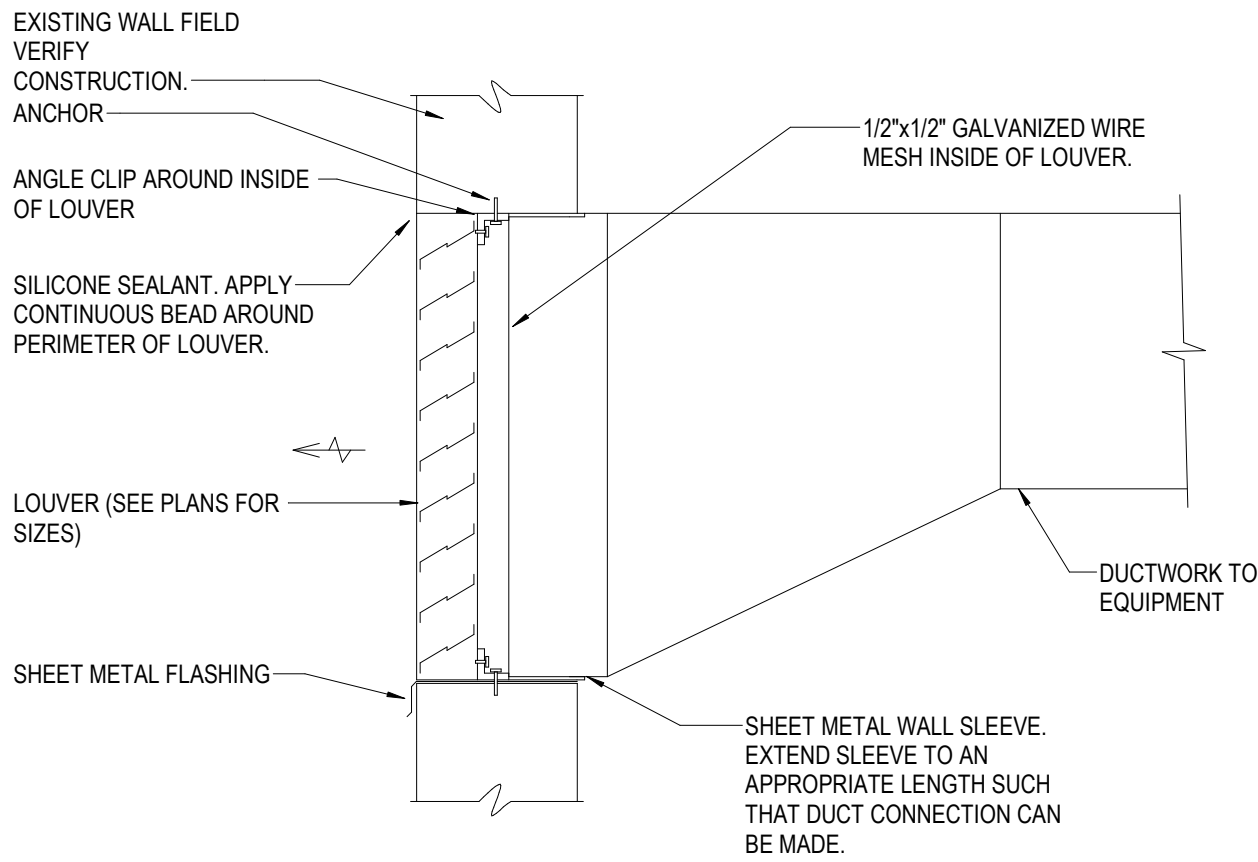

1
ES-M601
LOUVER ASSEMBLY DETAIL
NOT TO SCALE

Eastern Parcel Louver Schedule									
Tag	Manf.	Model	Purpose	CFM	Size	Max APD	Minimum Free Area (Sq.ft.)	Max FPM	Remarks
LV-01	GREENHECK	EHH-601	INTAKE	100	16X12	0.1	0.16	600	1
LV-02	GREENHECK	ESD-435	EXHAUST	200	14X14	0.1	0.4	750	1

GENERAL NOTES:

- PROVIDE FRAMED 1/2" x 1/2" ALUMINUM BIRD SCREEN FOR ALL LOUVERS.
- ALL LOUVERS SHALL BE RATED FOR THE PROJECT WIND ZONE. REFER TO STRUCTURAL DRAWINGS.
- LOUVERS SHALL HAVE 3-COAT 70% PVDF FINISH (AAMA 2605) WITH A DRY FILM THICKNESS OF 2.0 mil MINIMUM. PROVIDE STANDARD AND CUSTOM COLOR CHARTS WITH SUBMITTAL. COLOR SHALL BE SELECTED BY ARCHITECT FROM THE FULL RANGE.
- ALL LOUVERS SHALL BE AMCA 500-L CERTIFIED FOR AIR PERFORMANCE, WATER PENETRATION, AND WIND DRIVEN RAIN AND BEAR APPROPRIATE SEAL. ALL LOUVERS SHALL BE RATED AS RAIN PENETRATION CLASS A FOR THE FACE VELOCITY AT THE CFM SCHEDULED.
- EQUIVALENTS BY RUSKIN, ARROW, AIROLITE, NAILOR, RELIABLE, POTTORFF, OR AS LISTED IN THE SPECIFICATIONS.

REMARKS:

- PROVIDE MOTORIZED DAMPER TO OPEN WHEN ASSOCIATED FAN RUNS

Eastern Parcel Shelter Fan Schedule										
Identity	Manufacturer	Model	Fan Design		Fan Arrangement	Fan Drive Type	Weight	Electrical		Remarks
			Capacity	ESP				Voltage	Phase	
EF-01	Greenheck	SQ 90-95	350 CFM	0.25 in-wg	Inline	Direct	34 lb	115 V	1	1

GENERAL NOTES:

- PROVIDE ALL DUCT TRANSITIONS FOR FANS.
- THE UNIT HOUSING SHALL BE CONSTRUCTED OF ALUMINUM.
- ALL FANS TO BE UL LISTED.
- PROVIDE WITH INTEGRAL DISCONNECT.
- EXTERNALLY OR INTERNALLY MOUNTED DISCONNECT SWITCH FURNISHED BY DIVISION 23 AND INSTALLED BY DIVISION 26.
- EXTERNALLY MOUNTED STARTER FURNISHED BY DIVISION 23 INSTALLED BY DIVISION 26.
- PROVIDE OVERLOAD PROTECTION FOR ALL FANS. COORDINATE WITH DIVISION 26.
- PROVIDE SPEED CONTROLLERS FOR ALL DIRECT DRIVE FANS.
- ESP DOES NOT INCLUDE FACTORY BACKDRAFT DAMPER. THIS PRESSURE DROP SHALL BE ADDED BY THE MANUFACTURER TO THE ESP LISTED WHEN SELECTING FANS.

REMARKS:

- PROVIDE HANGING VIBRATION ISOLATION KIT WITH NEOPRENE ISOLATORS.
- FAN SHALL BE PROVIDED TIME CLOCK TO OPERATE DURING PARK OPEN HOURS.

Eastern Parcel Shelter Electric Unit Heater Schedule										
Identity	Manufacturer	Model	Bottom Elevation	CFM Capacity	Size	Electric Heat Element(s)	Voltage	Phase	Product Weight	Notes
EUH-01	Berko	FRC	1'-0"	100 CFM	1.00 kW	1	120 V	1	25 lb	1, 2, 3
EUH-02	Berko	FRC	1'-0"	100 CFM	1.00 kW	1	120 V	1	25 lb	1, 2, 3
EUH-03	Berko	FRC	1'-0"	100 CFM	1.00 kW	1	120 V	1	25 lb	1, 2, 3
EUH-04	Berko	FRC	1'-0"	100 CFM	1.00 kW	1	120 V	1	25 lb	1, 2, 3
EUH-05	Markel	F1FUH03003	7'-0"	400 CFM	3.30 kW	1	208 V	1	36 lb	1, 2, 3, 5

GENERAL NOTES:

- UNITS BASED ON MARKEL 5100 AND 3420 SERIES.
- EQUIVALENTS: REZNOR, BERKO, INDECO OR AS LISTED IN SPECIFICATIONS.
- WHERE A REMOTE WALL MOUNTED THERMOSTAT IS INDICATED, PROVIDE 24V THERMOSTAT AND CONTROLS TRANSFORMER.
- MOUNTING HEIGHTS ARE TO BOTTOM OF UNIT.

REMARKS:

- PROVIDE SEMI-RECESSED SLEEVE.
- PROVIDE FACTORY CIRCUIT BREAKER.
- PROVIDE BUILT-IN TAMPERPROOF THERMOSTAT.
- PROVIDE WALL-MOUNTED 24V THERMOSTAT.
- PROVIDE HANGING BRACKET.
- PROVIDE FACTORY MOUNTED DISCONNECT SWITCH.
- BAS CONTRACTOR TO PROVIDE T-STAT.

Eastern Parcel Shelters Grilles, Registers & Diffusers Schedule								
ID Type	Description	Manf.	Type	Model	Border Application	Design Airflow Rate	Size	Remarks
H	Supply Grille	PRICE	Sidewall	620	Surface Mount	20 CFM	8"x8"	1, 2, 3
X	Exhaust	PRICE	Sidewall	530	Surface Mount	70 CFM	8"x8"	1, 5, 6

GENERAL NOTES:

- BASIS OF DESIGN IS PRICE. EQUIVALENTS BY TITUS, KRUEGER, TUTTLE AND BAILEY, NAILOR, OR AS LISTED IN SPECIFICATIONS.
- PROVIDE VOLUME DAMPERS AT TAKE-OFF FOR EACH GRILLE.
- ALL AIR DISTRIBUTION DEVICES SHALL BE ALUMINUM.
- FOR SIDE WALL GRILLES, PROVIDE REMOTE CABLE OPERATED, GEAR DRIVEN BALANCING DAMPER OPERABLE FROM FACE OF DIFFUSER.


REMARKS:

- COLOR SHALL BE SELECTED BY THE ARCHITECT AT THE TIME OF SUBMITTAL REVIEW.
- PROVIDE OPPOSED BLADE ALUMINUM DAMPER.
- WHERE MOUNTED ON A WALL OR OTHER FINISHED ARCHITECTURAL SURFACE, PROVIDE CONCEALED MOUNTING BRACKET OPTION IN LIEU OF COUNTERSUNK SCREW TYPE.

Susan Hatchell
Landscape Architecture, PLLC
711 W. North Street, Raleigh, NC 27603
p: 919-838-9600 f: 919-838-9700

Wooten
120 North Boylan Avenue • Raleigh, NC 27603-1423
(919) 828-0031 • info@wootencompany.com
License Number: 749715

DETAILS &
SCHEDULES

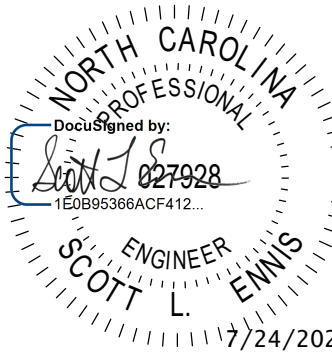




LAKE MYRA COUNTY PARK
Wake County, NC

REVISIONS

Date: 07/27/26

ES-M601

Electrical Abbreviations		
1P A, Amp AC ACLG ADO AF AFF AFG AFI AHU AL ALT AMP AMPL ANNUN APPROX AQ-STAT ARCH AS AT ATS AUTO AUX AV AWG BATT BD BLDG BMS C CAB CAT CATV CB CCTV CKT CLG COMB CMPR CONN CONST CONT CONTR CONV CP CRT CT CTR CU DCP DEPT DET DIA DISC DIST DN DPR DS DT DWG EC ELEC ELEV ELU EM EMS EMT EP EQUIP EWC EXIST EXH EXP FA FABP FACP FCU FIXT FLR FLUOR FU FUDS GA GAL GALV GC GEN GFI GFP GND GRS GYP BD HOA HORIZ HP HPF HT HTG HTR HV HVAC IC IG IMC INCAND IR IW J-BOX KV KVA KVAR KW KVH LOC LT LTG LTNG LV MAX MAG-S M/C MC	1 Pole (2P, 3P, 4P, ETC.) Ampere Above Counter Above Ceiling Automatic Door Opener Amp Frame Above Finished Floor Above Finished Grade Arc Fault Circuit Interrupter Air Handling Unit Aluminum Alternate Ampere Amplifier Annunciator Approximately Approximate Architect, Architectural Amp Switch Amp Trip Automatic Transfer Switch Automatic Auxiliary Audio Visual American Wire Gauge Battery Board Building Building Management System Conduit Cabinet Catalog Cable Television Circuit Breaker Closed Circuit Television Circuit Ceiling Combination Compressor Connection Construction Continuation Or Continuous Contractor Convector Circulating Pump Cathode-Ray Tube Current Transformer Center Copper Domestic Water Circulating Pump Department Detail Diameter Disconnect Distribution Down Dampener Safety Disconnect Switch Double Throw Drawing Electrical Contractor Electric, Electrical Elevator Emergency Lighting Unit Emergency Energy Management System Electrical Metallic Tubing Electric Pneumatic Equipment Electric Water Cooler Existing Exhaust Explosion Proof Fire Alarm Fire Alarm Booster Power Supply Panel Fire Alarm Control Panel Fan Coil Unit Fixture Floor Fluorescent Fuse Fused Safety Disconnect Switch Gauge Gallon Galvanized General Contractor Generator Ground Fault Circuit Interrupter Ground Fault Protector Ground Galvanized Rigid Steel (Conduit) Gypsum Board Hands-Off Automatic Switch Horizontal Horsepower High Power Factor Height Heating Heater High Voltage Heating, Ventilating And Air Conditioning Interrupting Capacity Isolated Ground Intermediate Metal Conduit Incandescent Infrared Interlock With Junction Box Kilovolt Kilovolt-Ampere Kilovolt-Ampere Reactive Kilowatt Kilowatt Hour Locate Or Location Light Lighting Lightning Low Voltage Maximum Magnetic Starter Momentary Contact Mechanical Contractor	MCB MCC MDC MDP MFR MFS MH MIC MIN MISC MLO MMS MOA MSP MSBD MSS MT MT.C MTS MTR N.C. NEC NEMA NFD5 NIC NL N.O. NPF NTS OC OH OL PA PB PE PED PF PH PIV PNL PP PR PRI PROJ PRV PT PVC PWR QUAN RCPT REQD RM RSC RTU SC SEC SHT SIM SLD S/N SPEC SPKR SP SPP SR SS SSW S/S STA STD SURF SW SWBD SYM SYS TEL TERM TL TR T-STAT TTC TV TYTC TYP UC UE UG UH UT UTIL UV V VA VDT VERT VFD VOL W Watt W/ With WG WH W/O WP XFMR XFR

   ELECTRICAL SYMBOL LEGEND	
	TYPICAL FIXTURE DESIGNATIONS "A" INDICATES FIXTURE TYPE, SEE LIGHT FIXTURE SCHEDULE FOR DESCRIPTION.
	"E" INDICATES EMERGENCY BATTERY W/ LIGHT FIXTURE
	LIGHT FIXTURES, WITH FIXTURE DESIGNATION
	WALL MOUNTED EXIT SIGN, SHADED AREAS INDICATE NUMBER OF FACES, DIRECTION ARROWS AS INDICATED.
	CEILING MOUNTED EXIT SIGN, SHADED AREAS INDICATE NUMBER OF FACES, DIRECTION ARROWS AS INDICATED.
	WALL MOUNTED EMERGENCY BATTERY UNIT.
	TOGGLE SWITCH, MOUNT CENTER AT 46" AFF.
	THREE-WAY SWITCH, MOUNT CENTER AT 46" AFF.
	DIMMING SWITCH 0-10V, MOUNT CENTER AT 46" AFF.
	OCCUPANCY SENSOR WALL SWITCH, MOUNT CENTER AT 46" AFF.
	CEILING MOUNTED OCCUPANCY SENSOR
	HOME RUN TO PANEL WITH PANEL DESIGNATION (SBPG) & CIRCUIT NUMBER (B), 3/4" UNLESS NOTED OTHERWISE. SEE RISER DIAGRAM & PANELBOARD SCHEDULES FOR WIRE & CONDUIT SIZES.
	WIRING IN CONDUIT CONCEALED IN WALLS AND ABOVE CEILING.
	WIRING IN CONDUIT UNDERFLOOR OR UNDERGROUND.
	10'-0" DRIVEN GROUND ROD
	DUPLEX RECEPTACLE, MOUNT CENTER AT 18" AFF UNLESS NOTED OTHERWISE
	SINGLE RECEPTACLE, RATING SHALL MATCH BREAKER SIZE
	PANELBOARD, SEE SCHEDULES & DETAILS.
	DISCONNECT SWITCH
	JUNCTION BOX
	CONCEALED SERVICE FLOOR BOX WITH DUPLEX RECEPTACLE
	CONCEALED SERVICE FLOOR BOX WITH DUPLEX RJ45
	DATA/DATA JACK, DATA JACK, CENTER AT 18" AFF.

15cd

Electrical General Notes	
A	Conductors operating at 50 volts or greater shall be in raceway. Raceway within the structure above the floor slab shall be metal. Raceway below the floor slab and underground raceway outside the structure shall be PVC.
B	Low voltage cables or conductors operating at less than 50 volts shall be in metal raceway where installed within walls or inaccessible spaces. Low voltage cables may be in cable tray where noted. Low voltage cables may be run in cable support hooks above accessible ceilings where noted. Low voltage cable shall be plenum rated in plenum spaces.
B	Low voltage cables or conductors operating at less than 50 volts shall be in metal raceway. Low voltage cables may be run in cable tray where noted. Low voltage cable shall be plenum rated in plenum spaces.
C	Coordinate locations of devices with architectural elevations and details. Architectural elevations and details take precedence over locations shown on electrical drawings.
D	Provide cable or conduit and wire as required to achieve circuiting shown. Size conductors per NEC ampacity and wire fill criteria. Provide dedicated neutral and ground conductors for circuiting, unless noted otherwise. Increase branch circuit and/or feeder conductors including equipment grounding conductors proportionally for no more than 3% voltage drop on branch circuits and 2% on feeders per energy code.
E	It is the responsibility of this contractor to coordinate installation of electrical systems and those requiring electrical connections to maintain NEC required clearances, included but not limited to areas above accessible ceilings.
F	Coordinate with other trades for proper installation of equipment. Consult the drawings of other trades or crafts to avoid conflicts with equipment, etc. Conflicts shall be resolved prior to rough-in and at no additional cost to the owner.
G	Leave the site clean and ready for occupancy. Remove dirt, debris, empty cartons, tools, conduit and wire scraps, and miscellaneous spare equipment and materials used in this division of the work during construction. Components shall be free of dust, grit, and foreign materials and left as new before final acceptance of work.
H	The symbols and abbreviations shown on this sheet may or may not be used in this set of drawings.
I	Perform work to comply with the standard practices for good workmanship published by National Electrical Contractors Association (NECA). Comply with the latest enforced edition of the National Electrical Code (NEC), local codes, amendments, and ordinances.
J	Field coordinate final mechanical and equipment locations along with connection requirements and control wiring prior to rough-in. Adjust corresponding circuit breaker ratings and branch circuiting accordingly.
K	Electrical work shall be performed under the supervision of a licensed master electrician. Procure permits and licenses and pay fees associated with this work.
L	Materials furnished for this project shall be new, commercial grade, free of defects, and listed by a nationally recognized testing laboratory unless noted otherwise.
M	Provide complete operation & maintenance manual including approved submittal drawings, warranty information for product supplied, and manufactures operation and maintenance instructions.
N	The contractor is responsible for making final wiring terminations to pre-installed receptacles in office furniture. Contractor is responsible for wiring and installing voice/data devices in office furniture. Coordinate placement of devices with furniture layout.
O	Security system to be provided under separate contract. It is the responsibility of this contractor to provide conduit provisions, back boxes, rough-ins, sleeves and power to head end equipment for exact requirements prior to start of work.
P	Conduit and wire shall not be installed below floor slab unless indicated on plan by dashed conduit.
Q	Contractor shall be responsible for wiring electrical items shown on drawings except for items listed in note 'R' below.
R	TV outlets, volume controls, nurse call dome lights, nurse call devices, telephone outlets, data outlets, and fire alarm devices shall consist of a back box with conduit stubbed above the accessible ceiling, see stub up detail. Verify size of back box required with device to be installed. Locate back boxes 6" from adjacent power receptacle intended for computer use.
S	Furnish and install conduit from back boxes for the following devices into the accessible ceiling space in the corridor, unless noted otherwise: 1/2" TV outlets 1/2" Volume controls 1/2" Door security devices (card readers, door strikes etc.) 1/2" Nurse call dome lights 3/4" Nurse call devices 3/4" Telephone outlets 3/4" Information outlets 3/4" Fire alarm devices

EAST PARCEL ELECTRICAL SHEET INDEX	
ES-E001	COVER SHEET
ES-E101	POWER AND LIGHTING PLANS
ES-E301	RISERS
ES-E401	DETAILS

EAST SHELTER

ELECTRICAL SYSTEM AND EQUIPMENT

METHOD OF COMPLIANCE:

ENERGY CODE: PRESCRIPTIVE_ X _ PERFORMANCE_

ASHRAE 90.1: PRESCRIPTIVE_ PERFORMANCE_

LIGHTING SCHEDULE

Lamp type required in fixture - See Fixture Schedule.
Number of lamps in fixture - See Fixture Schedule.
Ballast type used in the fixture - See Specifications.
Number of ballasts in fixture - See Specifications.
Total wattage per fixture - Varies - See Fixture Schedule

Total interior wattage specified versus allowed: 309 watts versus 437 watts (whole building)

Total exterior wattage specified versus allowed: 314 watts versus 1747 watts

ADDITIONAL PRESCRIPTIVE COMPLIANCE

— 406.2 More Efficient HVAC Performance
— X 406.3 Reduced Lighting Power Density
— 406.4 Enhanced Lighting Controls
— 406.5 On-Site Supply of Renewable Energy
— 406.6 Provision of Dedicated Outdoor HVAC Air System
— 406.7 High Efficiency Service Water Heating

DESIGNER STATEMENT:


To the best of my knowledge and belief, the design of this building complies with the electrical system and equipment requirements of the 2018 North Carolina State Building Code, Energy Conservation Code.

LIGHT FIXTURE SCHEDULE									
MARK	FIXTURE DESCRIPTION	MOUNTING	TYPE		TOTAL WATTS	VOLTS	MODEL # (OR EQUAL)	NOTE NO.	
A4P	4' X 2.5" RECTANGULAR LINEAR PENDANT FIXTURE	PENDANT	LED	2000	15	120	FOCAL POINT # FSM2LS-BW-500LF-935K-120LD1-C48-WH-4	1,7	
A6P	6' X 2.5" RECTANGULAR LINEAR PENDANT FIXTURE	PENDANT	LED	3000	23	120	FOCAL POINT # FSM2LS-BW-500LF-935K-120LD1-C48-WH-6	1,7	
A8P	8' X 2.5" RECTANGULAR LINEAR PENDANT FIXTURE	PENDANT	LED	4000	29	120	FOCAL POINT # FSM2LS-BW-500LF-935K-120LD1-C48-WH-8	1,7	
A6F	8' X 2.5" RECTANGULAR LINEAR RECESSED FIXTURE	RECESSED IN GYP	LED	4000	29	120	FOCAL POINT # FSM2LS-BW-500LF-935K-120LD1-TF-WH-8	7	
B2	2' X 2' LED LAY-IN FIXTURE	LAY-IN	LED	4000	51	120	FOCAL POINT # FEQ2-22-AC- 5000L-92765T-1C-UNV-LD1-G-WH	7	
C6	6" ROUND RECESSED DOWNLIGHT	RECESSED	LED	2000	23	120	FOCAL POINT # FLC6D-RF-2000L-120-LD1-T-LC6-RD-935K-DN-CD-WH	7	
D	8'X4' THREE GLOBE OVAL PENDANT	PENDANT	LED	4500	57	120	BUZZISURF #LED TRIO GLOBE120V 3500K	7	
CP4	4.5" ROUND PENDANT CYLINDER FIXTURE	PENDANT	LED	2000	26	120	FOCAL POINT # FLCY4-RD-WHG- 2000L-935K-1C-120-SC-LH1-C72-G-WFL-CD-WH		
CX	6" ROUND RECESSED EXTERIOR DOWNLIGHT	RECESSED IN GYP	LED	2500	30	120	FOCAL POINT # FLC6D-RF-2500L-120-LD1-T-LC6-RD-935K-DN-CD-WH-WL	5	
PF	15" ROUND PENDANT CANOPY FIXTURE	PENDANT TO 10'	LED	4087	50	120	LUMINIS #EG151-L2L40-SYM-35K-MVOLT-SPG-24-BZT	5	
H1	22" ROUND PENDANT SHADE	PENDANT	LED	959	10	120	LIGHT ART # ACC-SHPE-EMP-22D-VL-ZN-STD-RWPC-WH-WPF-935CK-900LM-WFL-LV01		
H2	8'X4' RECTANGULAR PENDANT WING	PENDANT	LED	4400	46	120	LIGHT ART # ACC-SHPE-WING-96L-0CH-FELT-STD--935CK-550LM-PO1-STD -WPC-WH		
V1	24"W LINEAR VANITY FIXTURE	WALL	LED	1500	18	120	LITHONIA # FMVTSL 24IN MVOLT 30K 90CRI BN M4	3	
V2	24"W VANDAL RESISTANT VANITY FIXTURE	WALL	LED	1500	18	120	LITHONIA # LVP524 2FT MIN1 15W 35K 120 CLP WHT	3	
W2	6"x 10"x4" EXTERIOR WALL SCONCE	WALL	LED	465	12	120	LITHONIA # WDGE1 LED P2 35K 80CRI VF MVOLT SRM PE E4WH DDBXD	1,5	
L2	POLE MOUNTED AREA DOWN LIGHT NEMA II DISTRIBUTION	POLE	LED	24500	194	208	LITHONIA #RSX3 LED P1 40K R3 MVOLT SPA PE DDBXD	2,6	
L1	POLE MOUNTED AREA DOWN LIGHTS WITH NEMA II DISTRIBUTION	POLE	LED	6259	57	208	LUMINIS # BVA21-L1L60-LD2-35K-MVOLTNLTMSSH-BKT	6	
S4	4'X6" LED SERVICE LIGHT	SURFACE	LED	3000	25	120	LITHONIA #ZL1N L48 3000LM FST MVOLT 40K 80CRI		
S8	8'X6" LED SERVICE LIGHT	SURFACE	LED	3000	25	120	LITHONIA #ZL1N L96 6000LM FST MVOLT 40K 80CRI		
CR4	4'X5" LED CORROSION RESISTANT LIGHT	SURFACE	LED	5300	40	120	NUVO #65-821R1		
X	LED EGDE LIT EXIT SIGN	WALL- 8" ABOVE DOOR	LED	3000	25	120	LITHONIA #EDG-X-G-EL		
NOTES: 1 - SEE ARCHITECTURAL ELEVATIONS & COORD. W/ G.C. FOR MOUNTING HEIGHT. 2 - PROVIDE 16' 4" SQUARE ALUMINUM POLE, ASSOCIATED MOUNTING ARMS AND ACCESSORIES 3 - MOUNT FIXTURE ABOVE MIRROR 4 - PROVIDE INTEGRAL MOTION SENSING CONTROL 5 - WET LABEL 6 - PROVIDE PHOTCELL CONTROL 7 - 0-10V DIMMING									

Susan Hatchell
Landscape Architecture, PLLC
711 W. North Street, Raleigh, NC 27603
p: 919-838-9600 f: 919-838-9700

Wooten
120 North Boylan Avenue • Raleigh, NC 27603-1423
(919) 828-0331 • thewootencompany.com
License Number: 7-9715

COVER SHEET

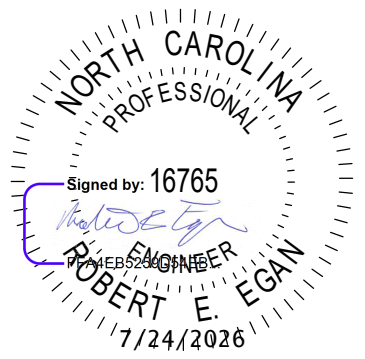


LAKE MYRA COUNTY PARK
Wake County, NC


REVISIONS

Date: 07/27/26

ES-E001

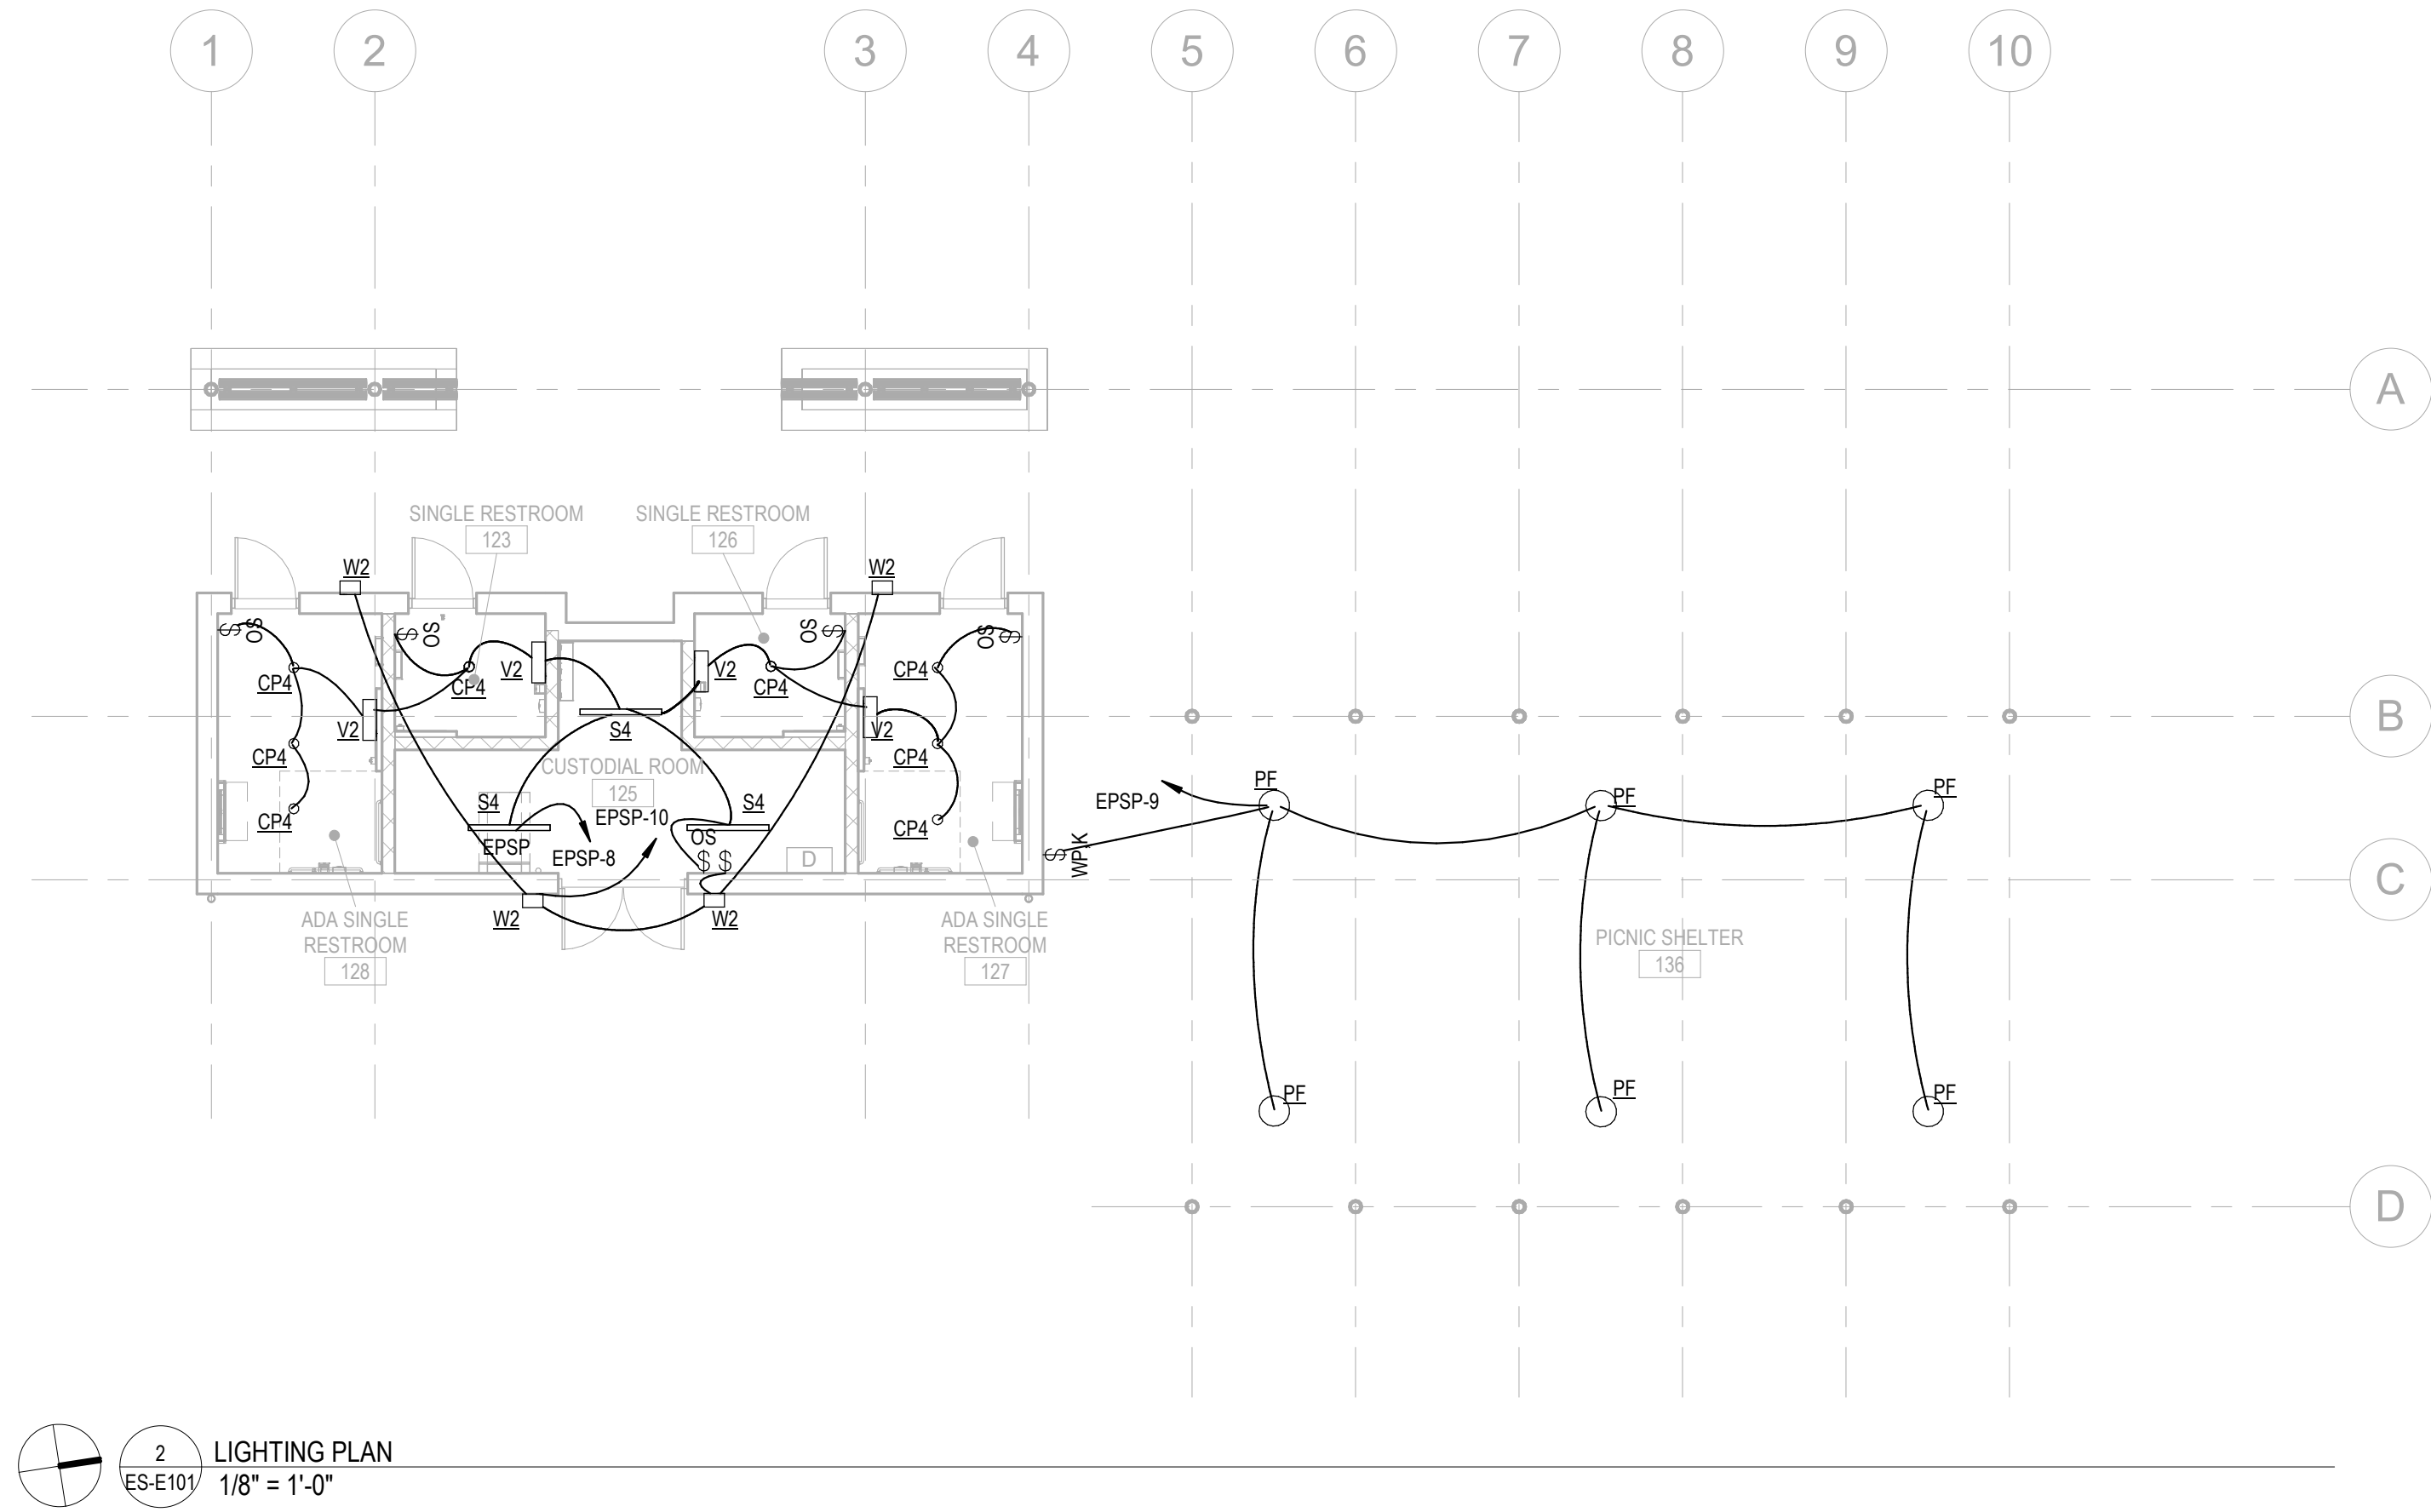







2 LIGHTING PLAN
ES-E101 1/8" = 1'-0"

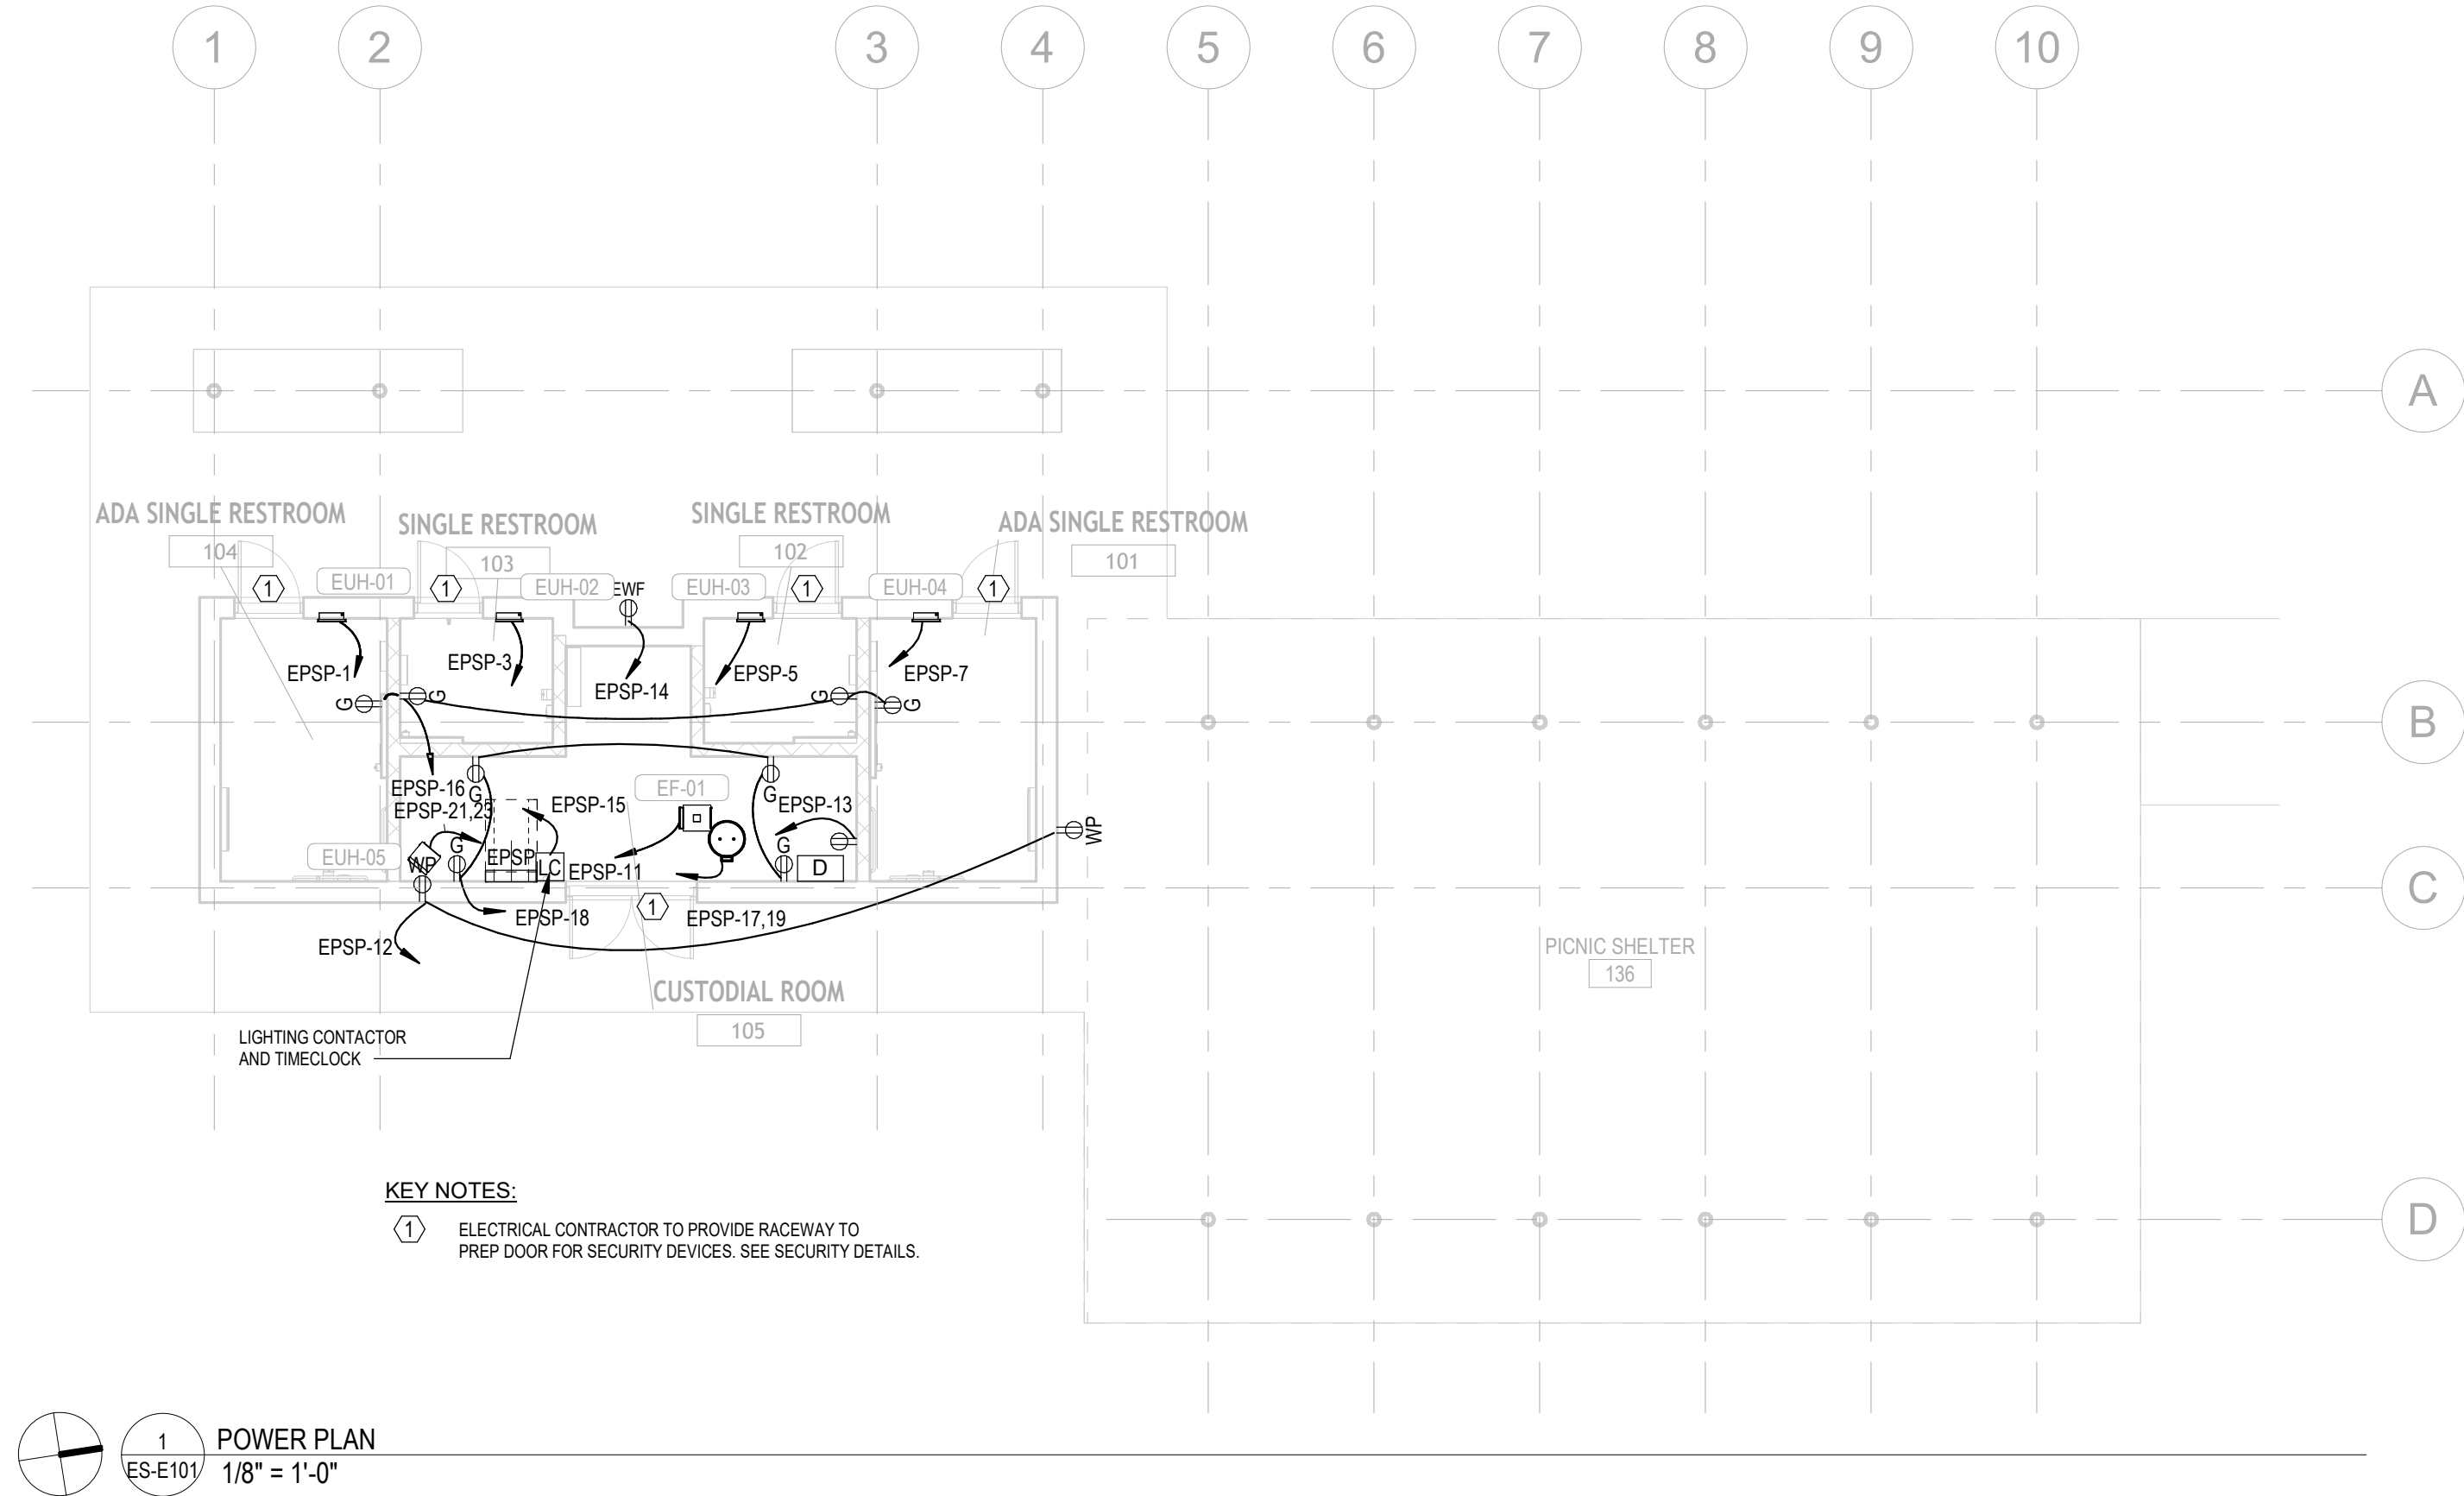

KEY NOTES:
① ELECTRICAL CONTRACTOR TO PROVIDE RACEWAY TO PREP DOOR FOR SECURITY DEVICES. SEE SECURITY DETAILS.

1 POWER PLAN
ES-E101 1/8" = 1'-0"


Panel Name: EPSP										Voltage: 208Y/120/3Ø, 4W				Mains Type: MCB			
Location: CUSTODIAL ROOM 125														Mains Rating: 150 A			
Supply: MFP1														SCCR: 10000			
Mounting Surface																	
Enclosure: NEMA 1																	
Ckt	Description	Rating	Poles	Wire Size	A		B		C		Wire Size	Poles	Rating	Description	Ckt		
1	UNIT HEATER RESTROOM 128	20	1	2#12, #12G, 3/4"C	1000	180					5#10, #12G, 3/4"C	2	20	SITE LIGHTS	2		
3	UNIT HEATER RESTROOM 123	20	1	2#12, #12G, 3/4"C			1000	180							4		
5	UNIT HEATER RESTROOM 126	20	1	2#12, #12G, 3/4"C					1000	360	WITH CIRCUIT ABOVE	1	20	POLE CAMERAS	6		
7	UNIT HEATER RESTROOM 127	20	1	2#12, #12G, 3/4"C	1000	309					2#12, #12G, 3/4"C	1	20	LTS -125, 127, 128, 123, 126	8		
9	LTS PICNIC SHELTER 136	20	1	2#12, #12G, 3/4"C			333	67			2#12, #12G, 3/4"C	1	20	WALL PACK LTS	10		
11	EF CUSTODIAL ROOM 125	20	1	2#12, #12G, 3/4"C					85	360	2#12, #12G, 3/4"C	1	20	REC - EXT	12		
13	DATA CABINET 125	20	1	2#12, #12G, 3/4"C	180	350					2#12, #12G, 3/4"C	1	20	REC - EWC	14		
15	TIME CLOCK/CONTACTOR	20	1	2#12, #12G, 3/4"C			150	720			2#12, #12G, 3/4"C	1	20	REC-CUST 105	16		
17									2250	720	2#12, #12G, 3/4"C	1	20	REC-RESTROOMS	18		
19	WATER HEATER 125	30	2	2#10, #10G, 3/4"C	2250	3600					2#6, #10G, 1"C	2	50	FOOD TRUCK PEDESTAL	20		
21							1650	3600							22		
23	UNIT HEATER	60	2	2#4, #10G, 1"C					1650	0	--	1	20	SPARE	24		
25	SPARE	20	1	--	0	0					--	1	20	SPARE	26		
27	SPARE	20	1	--			0	0			--	1	20	SPARE	28		
29	SPACE	--	1	--					--	--	--	1	--	SPACE	30		
Connected Load:					9 kVA		8 kVA		6 kVA								
Connected Current:					76 A		66 A		54 A								
Load Classification				Connected	Factor		Demand										
Motor				85 VA	125.00%		106 VA										
Other				8070 VA	100.00%		8070 VA										
Lighting - Interior				709 VA	125.00%		886 VA										
Receptacle - General				2330 VA	100.00%		2330 VA										
Electric Water Heating				4500 VA	125.00%		5625 VA										
Electric Heat				7300 VA	125.00%		9125 VA										

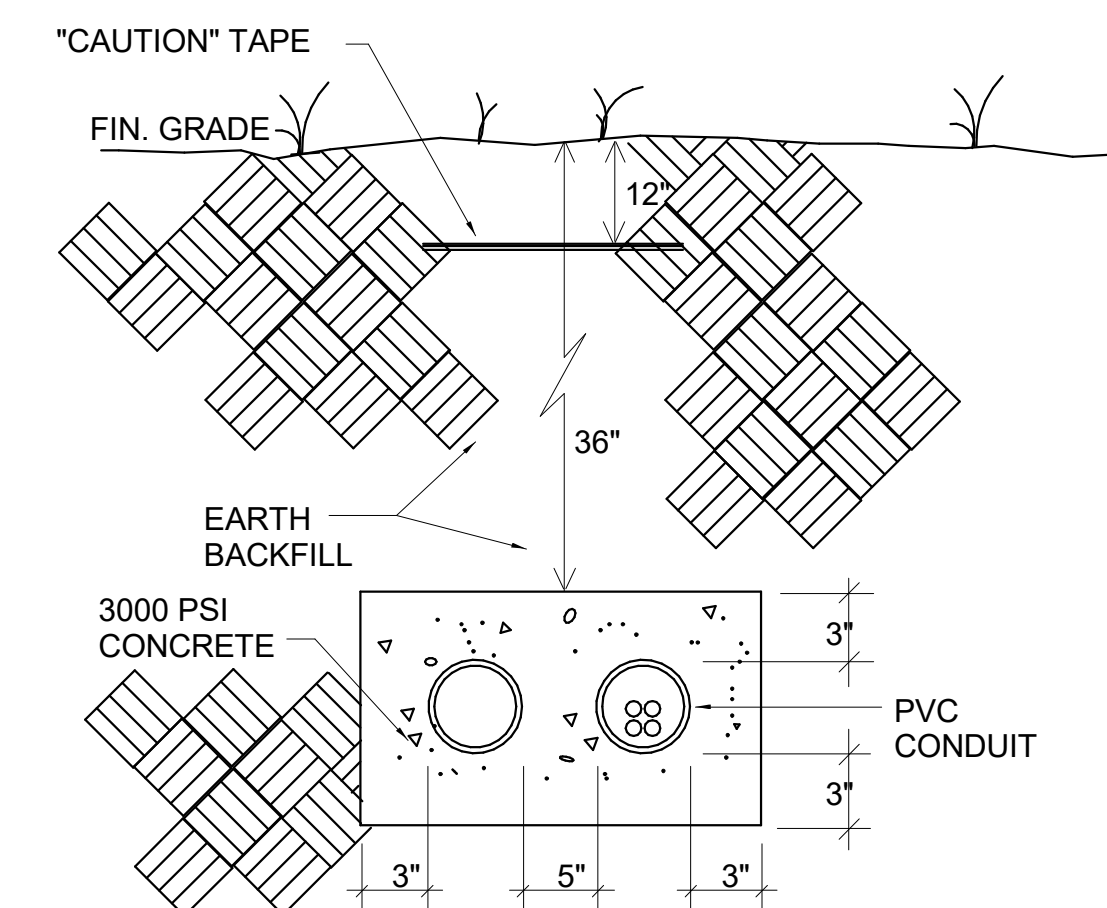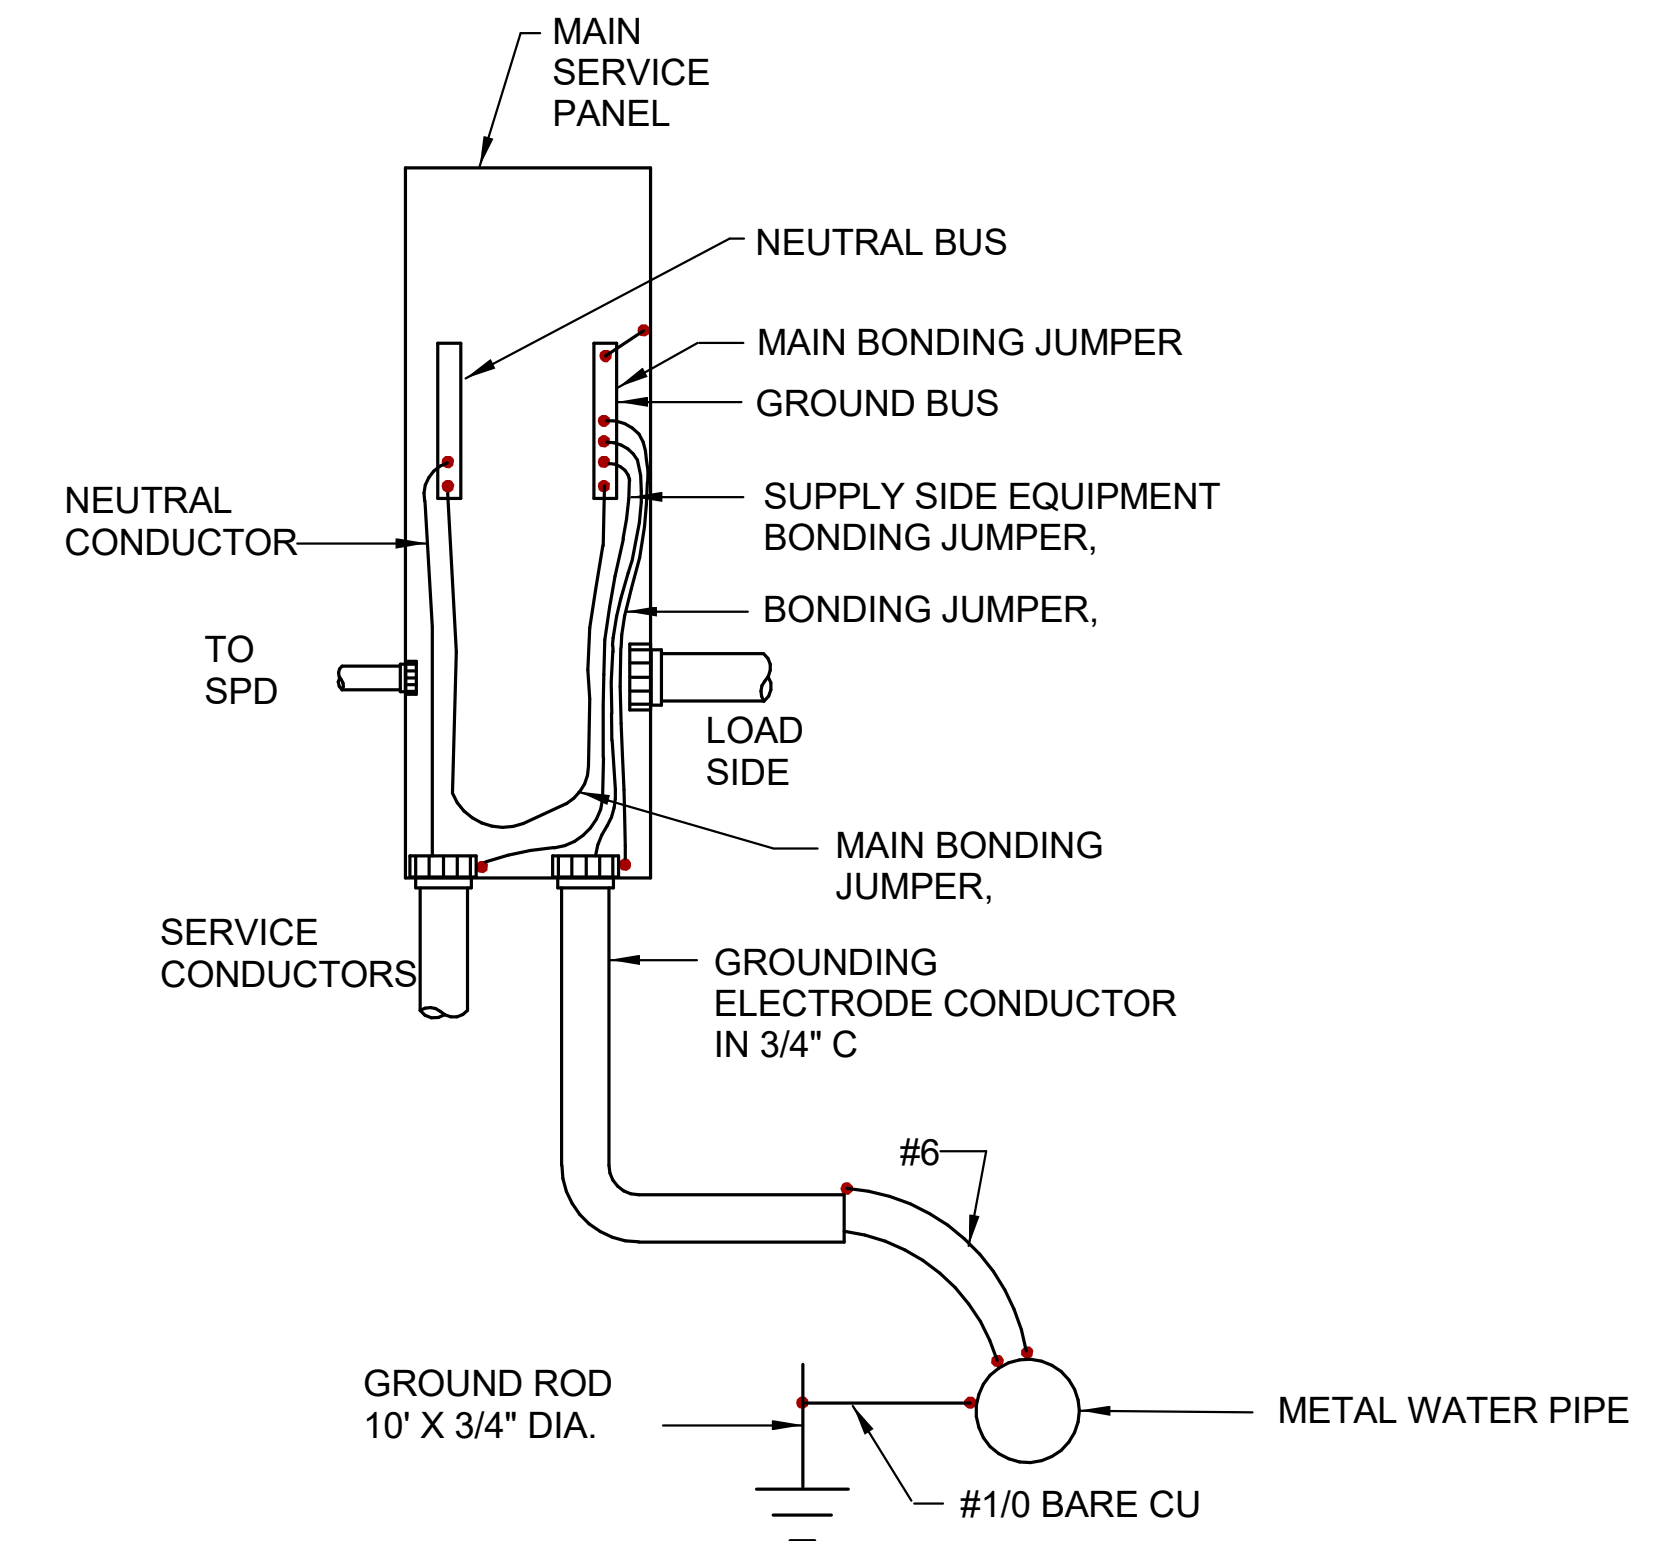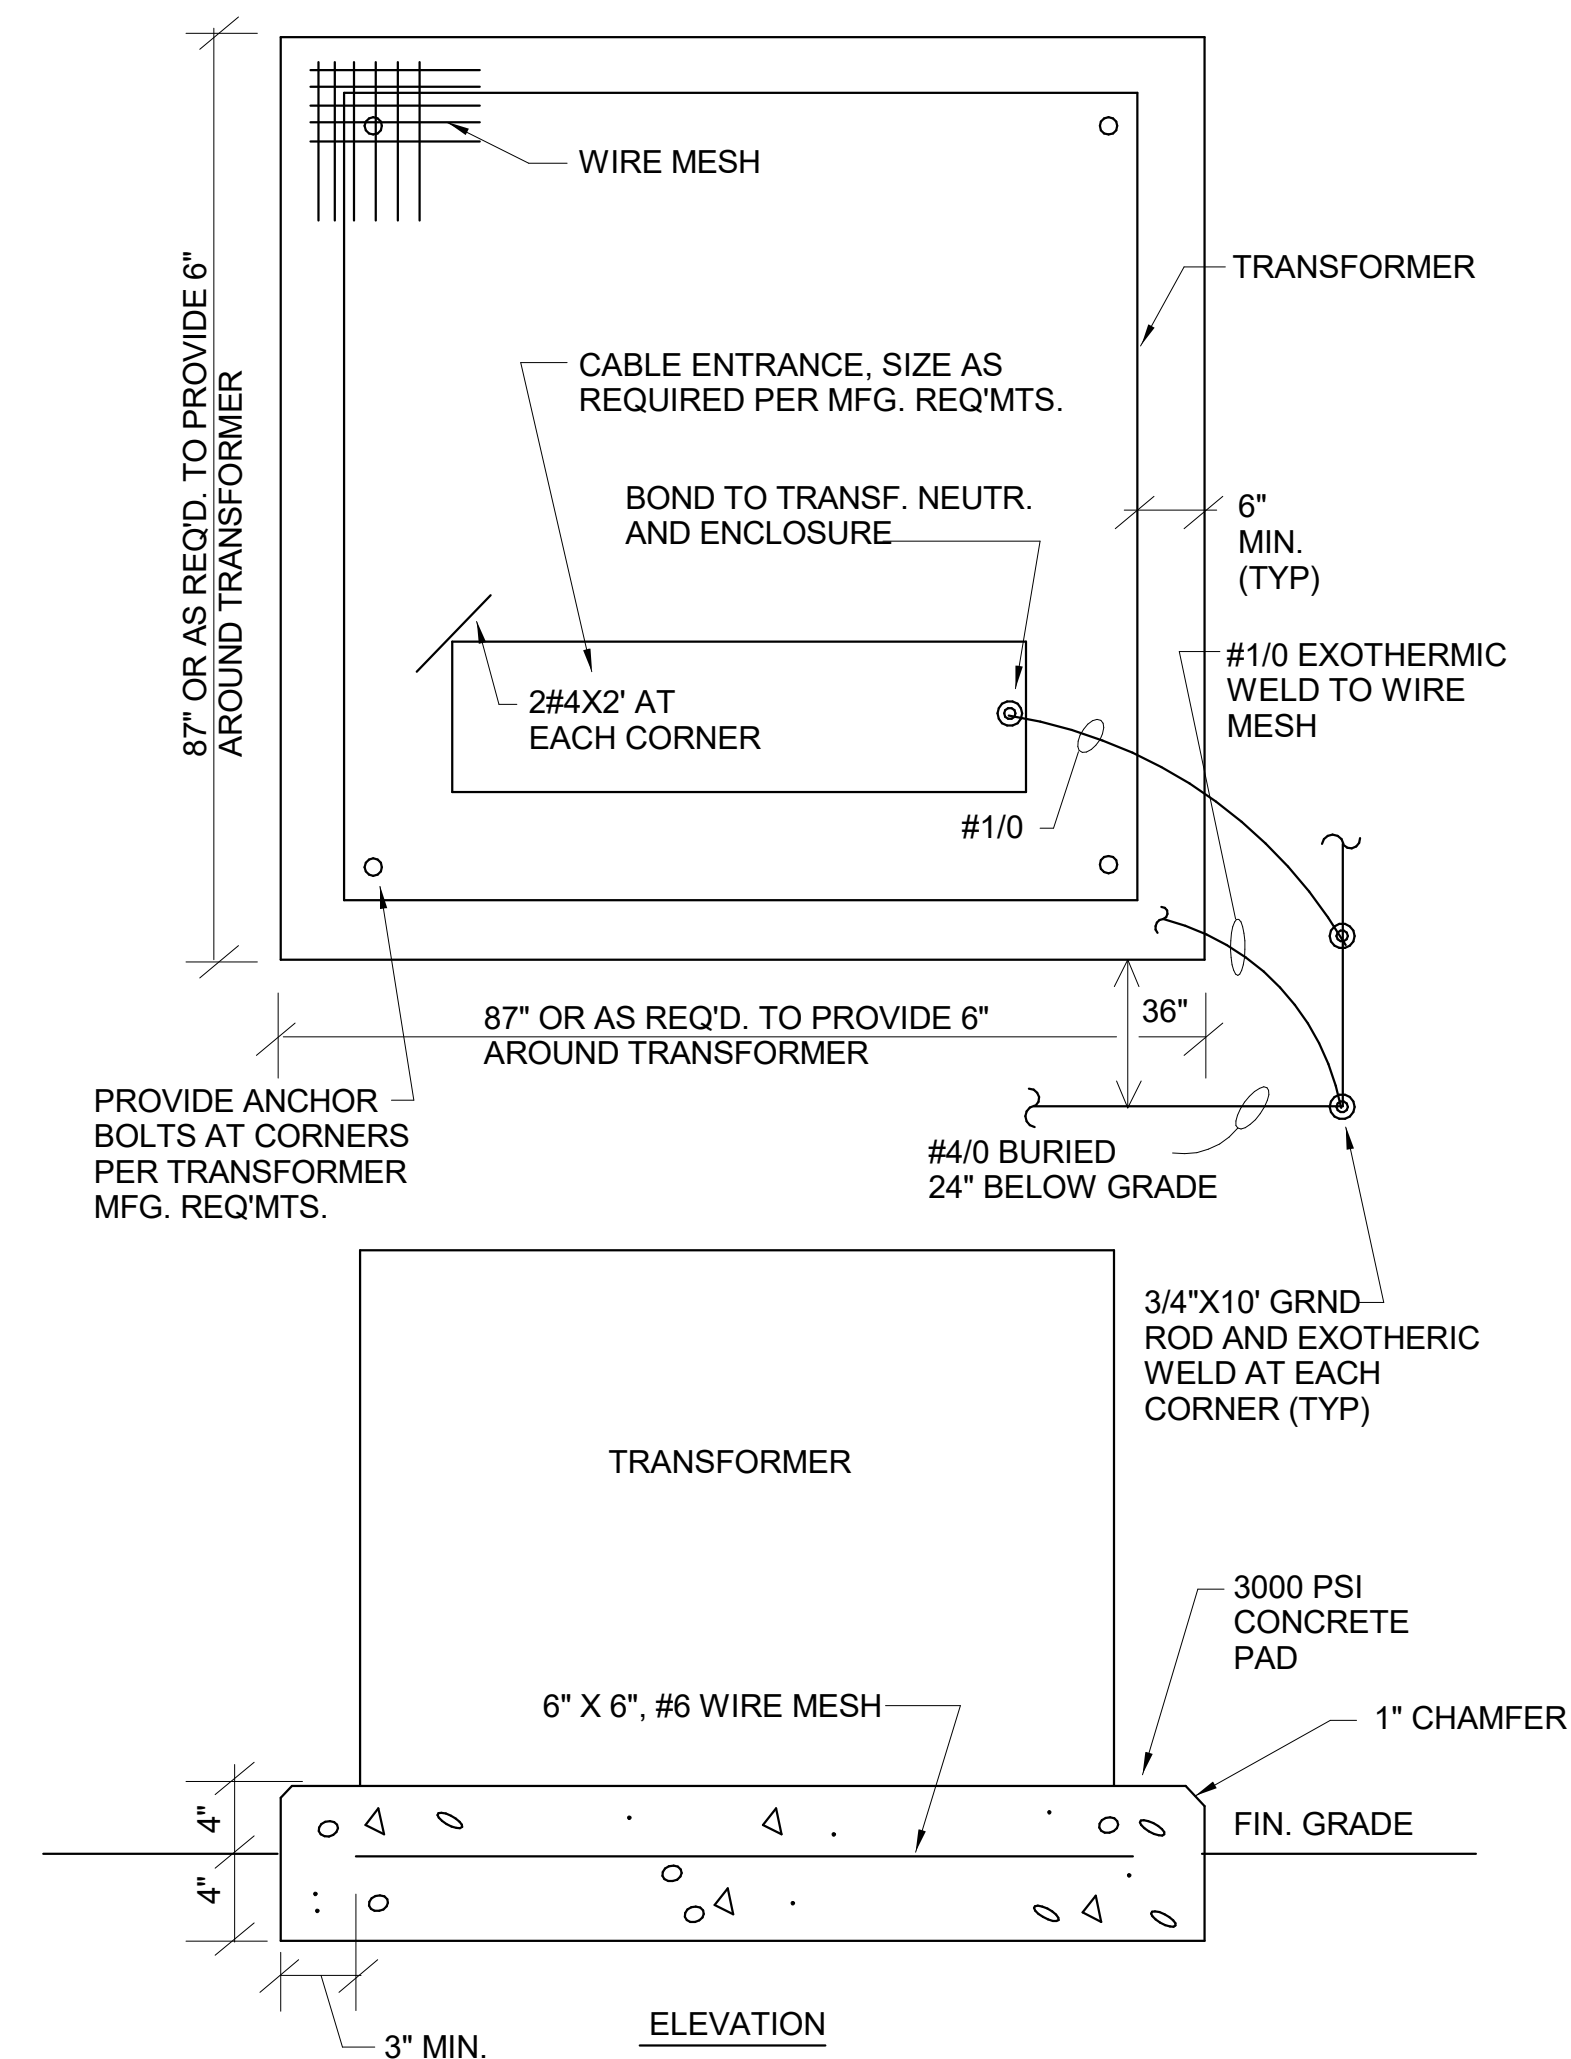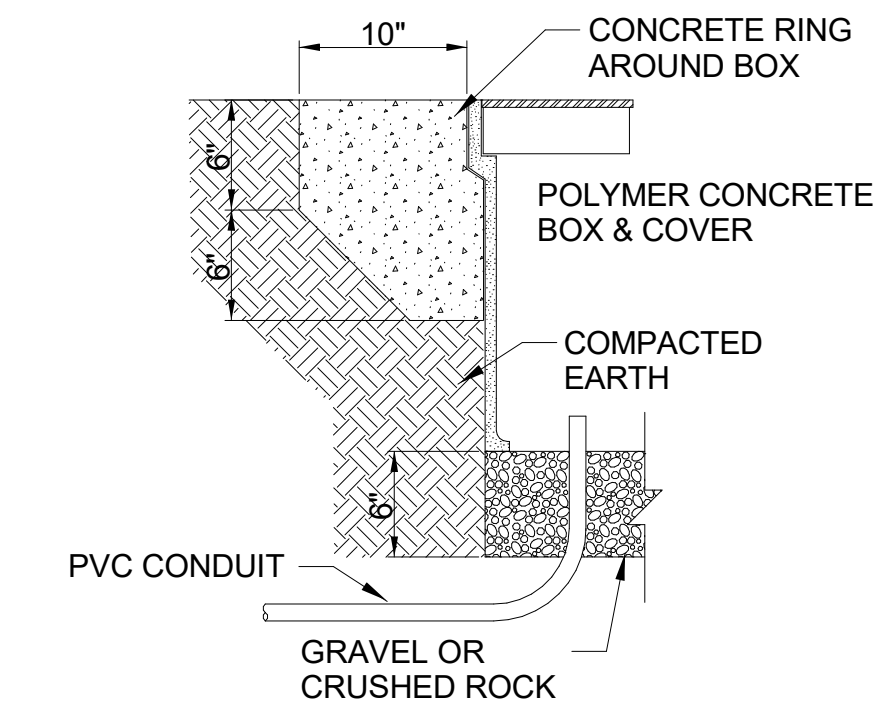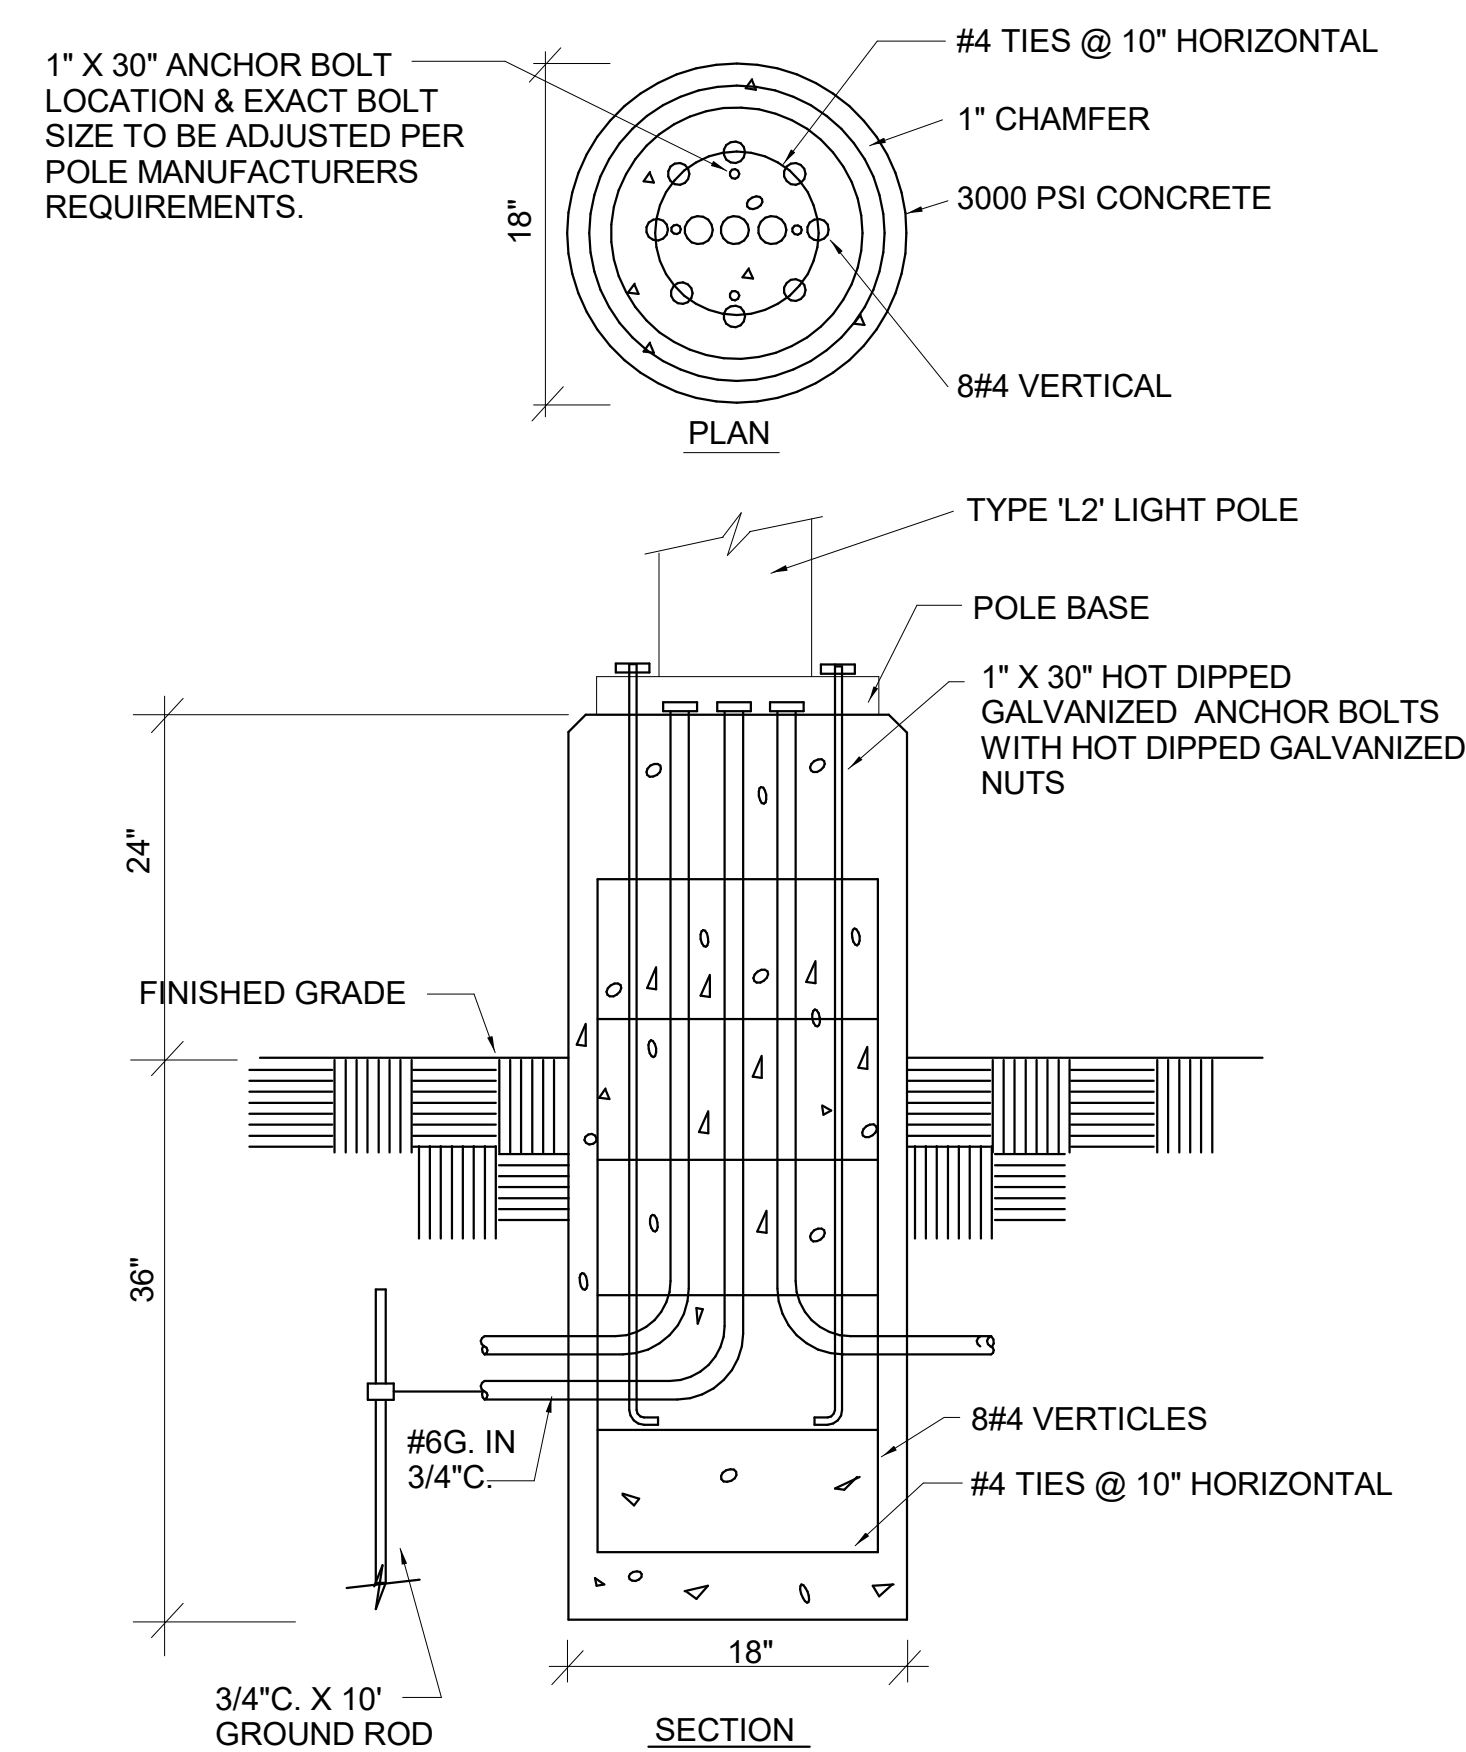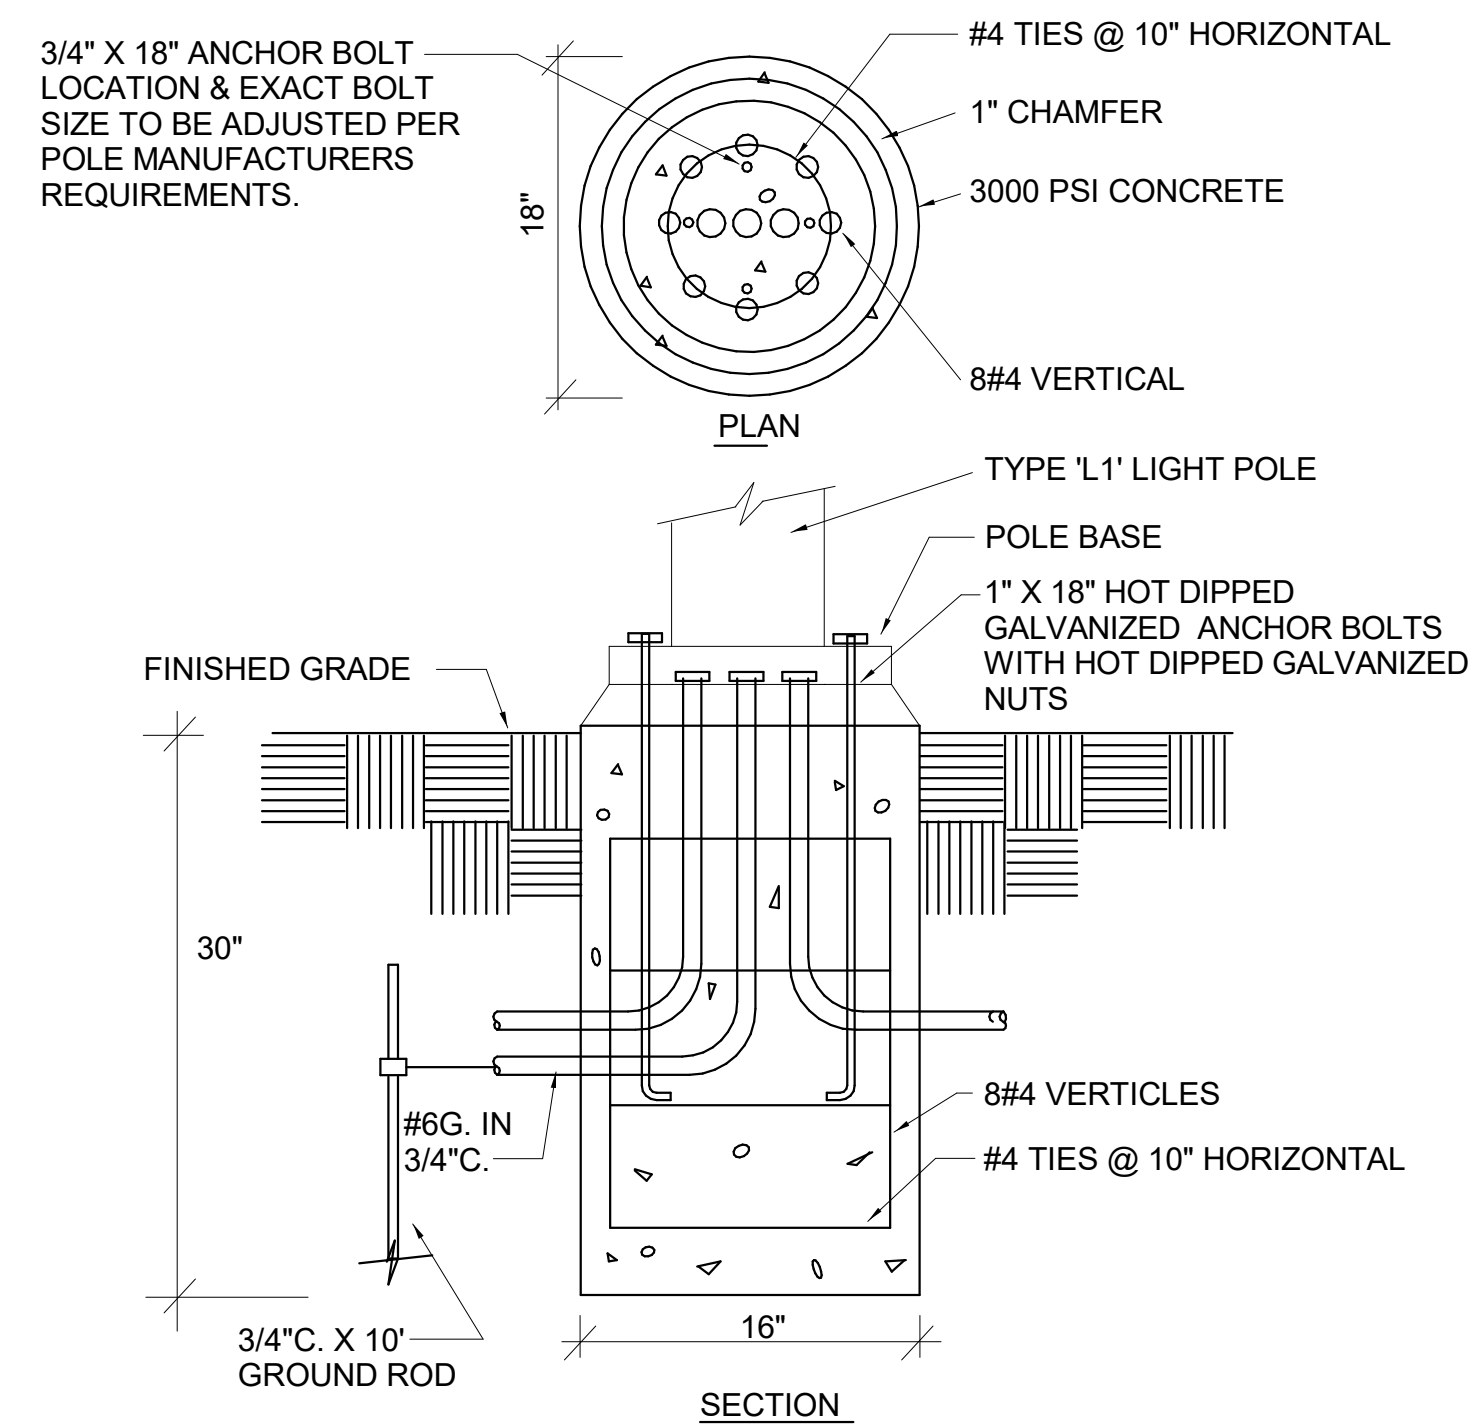

Susan Hatchell
Landscape Architecture, PLLC
711 W. North Street, Raleigh, NC 27603
p: 919-838-9600 f: 919-838-9700

Wooten
120 North Boylan Avenue • Raleigh, NC 27603-1423
(919) 828-0531 • thewootencompany.com
License Number : F-0115

DETAILS

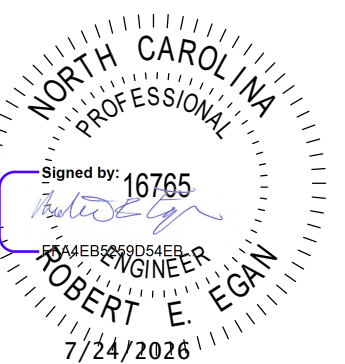

LAKE MYRA COUNTY PARK
Wake County, NC

REVISIONS

Date: 07/27/26

ES-E401