

SITE DATA		
NAME:	LAKE MYRA COUNTY PARK	
OWNER:	WAKE COUNTY	
DEVELOPER:	WAKE COUNTY	
CONTACT:	ERIC STAEHLE PLA, ASLA, SENIOR FACILITIES PROJECT MANAGER	
ADDRESS:	WAKE COUNTY OFFICE BUILDING, 11th FLOOR, RALEIGH, NC 27602	
PHONE NUMBER:	919.856.6369	
PROPERTY ADDRESS: PARCEL ID NUMBER (PIN): DEED BOOK AND PAGE: ZONING DISTRICT:	<u>WESTERN PARCEL:</u> 0 S SMITHFIELD ROAD 1763-51-9788 DB: 12448, PG: 2075 WAKE COUNTY, ZONED R-40	<u>EASTERN PARCEL:</u> 10505 POOLE ROAD 1763-84-1077 DB: 12590, PG: 1251 WENDELL, ZONED R3
TOTAL LAND AREA:	91.81 ACRES	125.76 ACRES
PROPOSED DISTURBED AREA:	6.5 ACRES	12 ACRES
CURRENT USE:	UNDEVELOPED	UNDEVELOPED
PROPOSED USE:	PARK/RECREATION FACILITY	PARK/RECREATION FACILITY
EXISTING IMPERVIOUS AREA:		
PROPOSED IMPERVIOUS AREA:		
PROPOSED BUILDING:		
FLOOD INFORMATION:		
WATER AND SEWER SERVICE:		
ELECTRICAL SERVICE:		

Landscape Architect / Prime Consultant:
Susan Hatchell Landscape Architecture, PLLC
711 W. North Street
Raleigh, NC 27603
T: (919) 838-9600

Civil Engineer, Site Structural, and Surveyor:
NV5
3300 Regency Parkway, Suite 100
Cary, NC 27518

Architect:
Esse Architects
632 Pershing Road
Raleigh, NC 27608


Building Structural Engineer:
Lynch Mykins Structural Engineers, PC
301 N. West Street, Suite 105
Raleigh, NC 27603

MEP Engineer:
The Wooten Company
120 N Boylan Avenue
Raleigh, NC 27603

LAKE MYRA COUNTY PARK MAINTENANCE FACILITY

Wake County, North Carolina

JULY 27, 2026 – CONSTRUCTION DOCUMENT SET

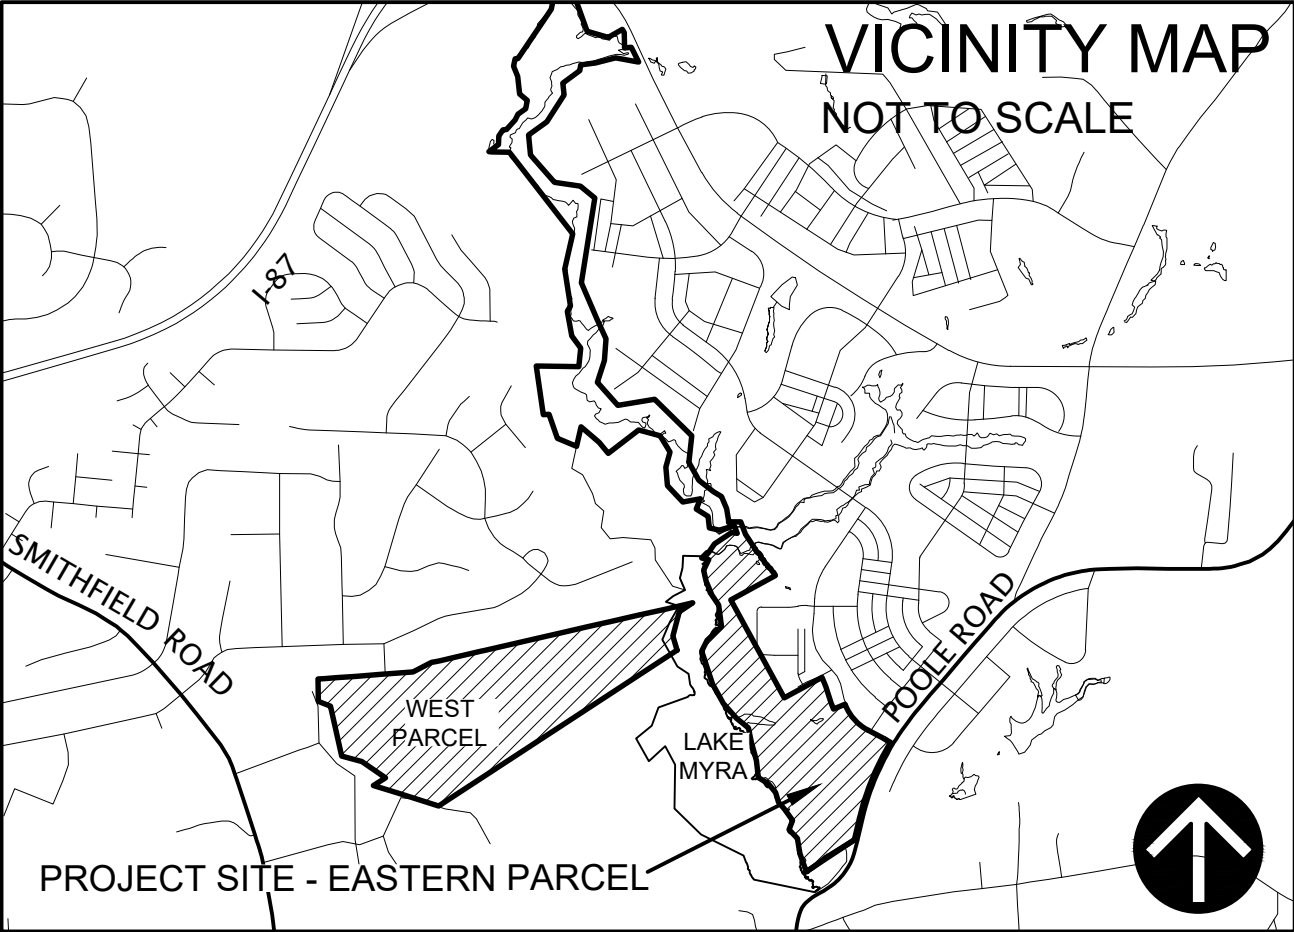

SHEET INDEX

COVER SHEET

ARCHITECTURE
MF-G001 – ABBREVIATIONS, SYMBOLS, AND GENERAL NOTES
MF-G101 – CODE SUMMARY
MF-G102 – LIFE SAFETY PLAN
MF-A000 – 3D VIEW
MF-A001 – PARTITIONS
MF-A101 – FLOOR PLAN & DIMENSIONED PLAN
MF-A102 – DUMPSTER ENCLOSURE PLANS AND DETAILS
MF-A111 – REFLECTED CEILING AND ROOF PLANS
MF-A130 – FINISH LEGEND
MF-A131 – FINISH PLAN, LEGEND AND SCHEDULE
MF-A132 – SIGNAGE PLAN & DETAILS
MF-A140 – FURNITURE PLAN
MF-A201 – EXTERIOR ELEVATIONS
MF-A202 – EXTERIOR PANEL LAYOUT
MF-A203 – EXTERIOR PANEL LAYOUT
MF-A301 – BUILDING SECTIONS
MF-A400 – TYPICAL TOILET AND BATH ACCESSORIES
MF-A401 – TOILET PLANS AND ELEVATIONS
MF-A402 – INTERIOR ELEVATIONS
MF-A421 – WALL SECTIONS
MF-A422 – WALL SECTIONS
MF-A501 – PLAN DETAILS
MF-A505 – AIR BARRIER DETAILS
MF-A506 – AIR BARRIER DETAILS
MF-A510 – MILLWORK DETAILS
MF-A511 – INTERIOR DETAILS
MF-A521 – HEAD, JAMB AND SILL DETAILS
MF-A522 – HEAD, JAMB AND SILL DETAILS
MF-A525 – ROOF DETAILS
MF-A526 – ROOF DETAILS
MF-A527 – ROOF DETAILS
MF-A601 – DOOR AND WINDOW SCHEDULES

STRUCTURAL
MF-S001 – GENERAL NOTES
MF-S002 – GENERAL NOTES
MF-S003 – GENERAL NOTES
MF-S004 – GENERAL NOTES
MF-S101 – MAINTENANCE FACILITY SLAB AND FOUNDATION PLAN
MF-S102 – MAINTENANCE FACILITY ROOF FRAMING PLAN
MF-S301 – SECTIONS
MF-S302 – SECTIONS
MF-S501 – TYPICAL DETAILS
MF-S502 – TYPICAL DETAILS
MF-S503 – TYPICAL DETAILS

PLUMBING
MF-P001 – COVER SHEET
MF-P105 – FLOOR PLANS
MF-P700 – DETAILS

MECHANICAL
MF-M001 – COVER SHEET
MF-M101 – FLOOR PLAN
MF-M601 – DETAILS & SCHEDULES

ELECTRICAL
MF-E001 – COVER SHEET
MF-E101 – POWER AND LIGHTING PLANS
MF-E102 – ROOF PLAN
MF-E501 – DETAILS




Susan Hatchell
Landscape Architecture, PLLC

Esse Architects

lynchmykins
HOW **IMEG**

N|V|5 Delivering Solutions
Improving Lives

Wooten

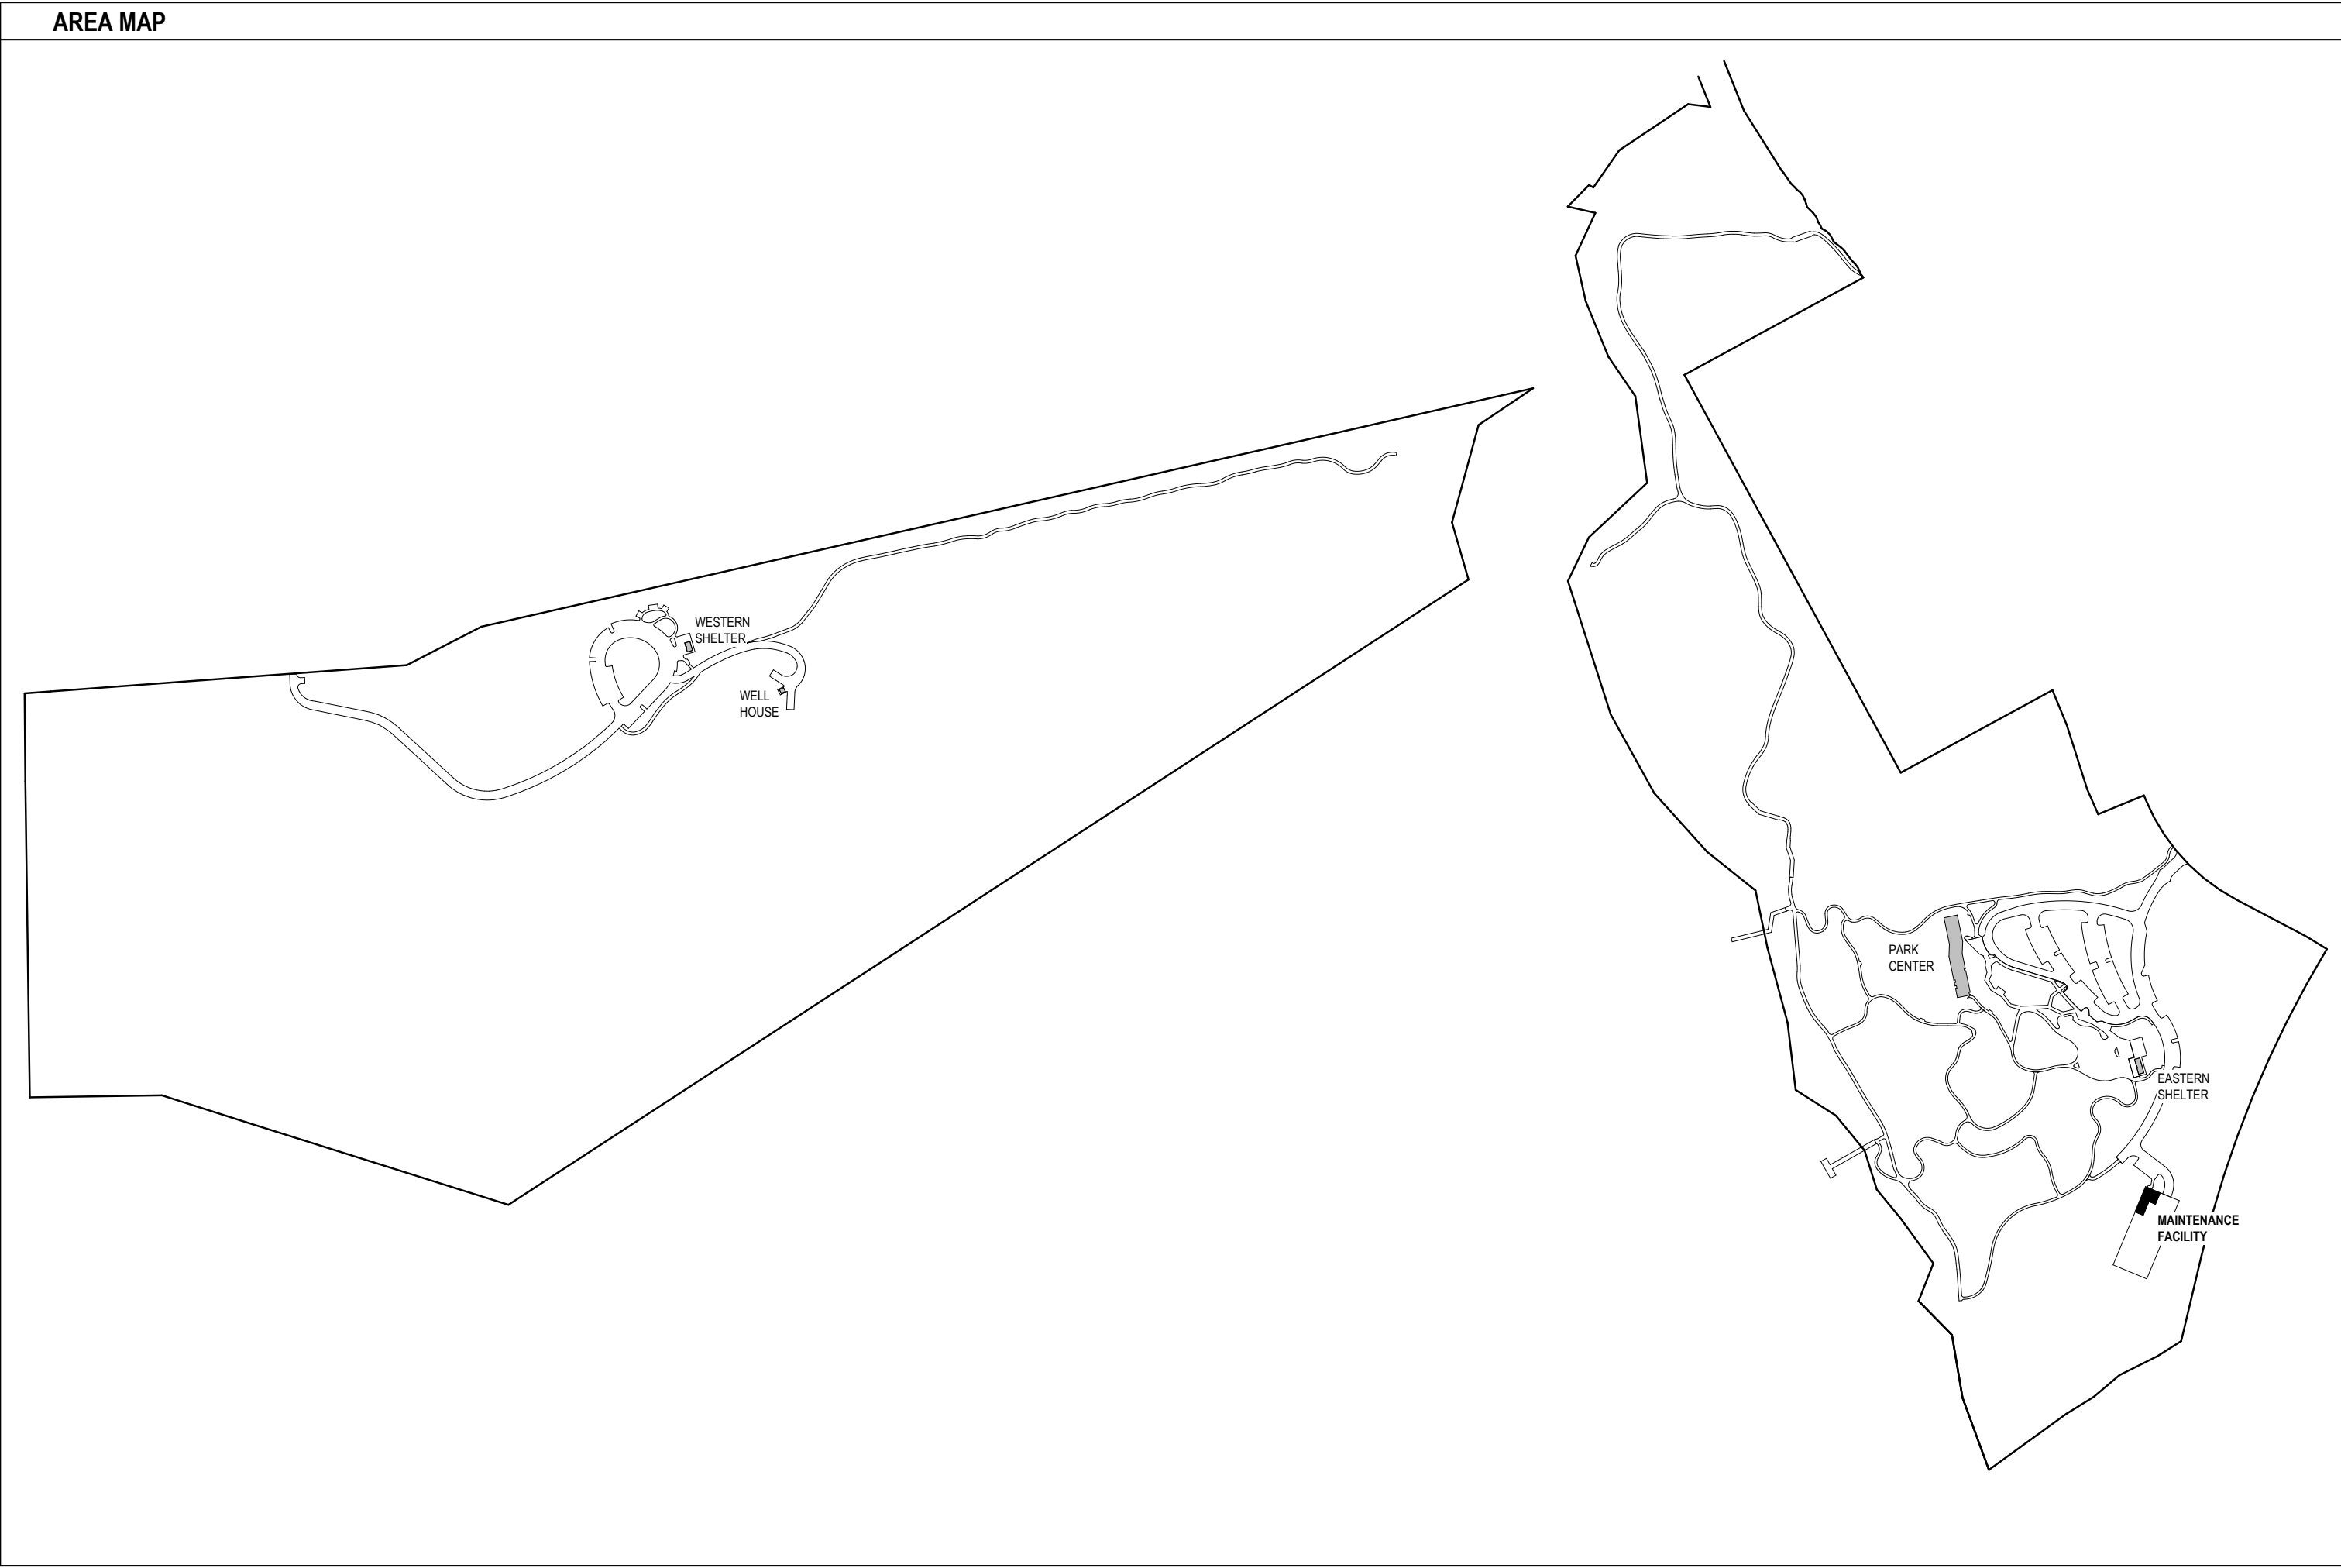

ABBREVIATIONS	
ABBR.	FULL DESCRIPTION
@	AT
A/C	AIR CONDITION(ER)(ING)
AB	AIR BARRIER
ACC	ACCESSIBLE
ACM	ALUMINIUM COMPOSITE MATERIAL
ADJ	ADJACENT
AFF	ABOVE FINISH FLOOR
AL	ALUMINUM
ALT	ALTERNATE
ARCH	ARCHITECT(URAL)
BD	BOARD
BFF	BELOW FINISH FLOOR
BLDG	BUILDING
BLKG	BLOCKING
BOS	BOTTOM OF STEEL
BRG	BEARING
CG	CORNERGUARD
CJ	CONTROL JOINT
CL	CENTERLINE
CLG	CEILING
CLR	CLEAR/CLEARANCE
CMU	CONCRETE MASONRY UNIT
COL	COLUMN
CONC	CONCRETE
CONT	CONTINUOUS
CPT	CARPET
CM	CURTAIN WALL
DEMO	DEMOL(ISH)(ITION)
DF	DRINKING FOUNTAIN
DIA	DIAMETER
DIM	DIMENSION
DN	DOWN
DS	DOWNSPOUT
DTL	DETAIL
DWG	DRAWING
EA	EACH
EIFS	EXTERIOR INSULATION AND FINISH SYSTEM
ELEC	ELECTRICAL
EOD	EDGE OF DECK
EOS	EDGE OF STEEL
EQ	EQUAL
EW	ELECTRIC WATER COOLER
EXST	EXISTING
EXT	EXTERIOR
FD	FLOOR DRAIN
FE	FIRE EXTINGUISHER
FEC	FIRE EXTINGUISHER CABINET
FF	FINISH FLOOR
FIN	FINISH
FLR	FLOOR
PPRF	FIREPROOFING
FRT	FIRE RETARDANT TREATED
FT	FOOT/FEET

ABBREVIATIONS	
ABBR.	FULL DESCRIPTION
FV	FIELD VERIFY
GA	GAUGE
GALV	GALVANIZED
GC	GENERAL CONTRACTOR
GFRC	GLASS FIBER REINFORCED CONCRETE
GL	GLASS
GWB	GYPSUM WALLBOARD
GYP	GYPSUM
HGT	HEIGHT
HM	HOLLOW METAL
HR	HOOR
HVAC	HEATING, VENTILATION, AND AIR CONDITIONING
INFO	INFORMATION
INT	INTERIOR
JT	JOINT
LAV	LAVATORY
LB	POUND
LH	LEFT HAND
MAX	MAXIMUM
MECH	MECHANICAL
MFR	MANUFACTURER
MIN	MINIMUM
MISC	MISCELLANEOUS
MO	MASONRY OPENING
MTL	METAL
N	NORTH
NA	NOT APPLICABLE
NC	NON-COMBUSTIBLE
NCSBC	NORTH CAROLINA STATE BUILDING CODE
NIC	NOT IN CONTRACT
NO	NUMBER
NTS	NOT TO SCALE
OC	ON CENTER
OM	ORNAMENTAL METAL
OPP	OPPOSITE
PL	PLATE
PLAM	PLASTIC LAMINATE
PLBG	PLUMBING
PME	PLUMBING/MECHANICAL/ELECTRICAL
PT	PRESSURE-TREATED
PVC	POLY(VINYL CHLORIDE
PWD	PLYWOOD
RCP	REFLECTED CEILING PLAN
RD	ROOF DRAIN
RDL	ROOF DRAIN LEADER
REF	REFRIGERATOR
REINF	REINFORCE(D)(ING)(MENT)
REQ	REQUIRED
RH	RIGHT HAND
RM	ROOM
RO	ROUGH OPENING
RTU	ROOF TOP UNIT
SCW	SOLID CORE WOOD

ABBREVIATIONS	
ABBR.	FULL DESCRIPTION
SF	SQUARE FOOT/FEET
SFT	STOREFRONT
SIM	SIMILAR
SPEC	SPECIFICATION
SPECS	SPECIFICATIONS
SQ	SQUARE
SS	STAINLESS STEEL
STD	STANDARD
STL	STEEL
SUSP	SUSPENDED
T&G	TONGUE AND GROOVE
THRU	THROUGH
TLT	TOILET
TOBB	TOP OF BOND BEAM
TOM	TOP OF MASONRY
TOP	TOP OF PARAPET
TOS	TOP OF STEEL
TSTAT	THERMOSTAT
TYP	TYPICAL
UL	UNDERWRITERS LABORATORY
UON	UNLESS OTHERWISE NOTED
VB	VAPOR BARRIER
VCT	VINYL COMPOSITION TILE
VIF	VERIFY IN FIELD
W	WITH
WI	WITHIN
W/O	WITHOUT
WC	WATER CLOSET
WD	WOOD
WT	WEIGHT
WWF	WELDED WIRE FABRIC

Susan Hatchell
Landscape Architecture, PLLC
711 W. North Street, Raleigh, NC 27603
p: 919-838-9600 f: 919-838-9700



ABBREVIATIONS,
SYMBOLS, AND
GENERAL NOTES

LAKE MYRA COUNTY PARK
Wake County, NC

REVISIONS


Date: 07/27/26


MF-G001

MATERIAL LEGEND	
CMU	
BATT INSULATION	
WOOD	
BRICK	
STEEL	
GROUT, MORTAR, SAND, OR PRECAST	
ALUMINUM	
CONCRETE	
CARPET	
SOIL FILL	
ROCK FILL	
GYPSUM BOARD	
RIGID INSULATION	
PLYWOOD	
WOOD BLOCKING (CONTINUOUS)	
WOOD BLOCKING (INTERRUPTED)	

SYMBOL LEGEND	
ROOM NAME AND NUMBER	ROOM NAME 101
DOOR NUMBER	101
WALL TYPE	1
WINDOW TYPE	A
BUILDING ELEVATION	A101 SHEET WHERE ELEVATION IS DRAWN DRAWING NUMBER
INTERIOR ELEVATION	1 A101 SHEET WHERE ELEVATION IS DRAWN DRAWING NUMBER
BUILDING SECTION	1 A101 DRAWING NUMBER SHEET WHERE SECTION IS DRAWN
WALL SECTION	1 A101 DRAWING NUMBER SHEET WHERE SECTION IS DRAWN
EGRESS ARROW	50
COLUMN BUBBLE	0 COLUMN LINE NUMBER OR LETTER CENTERLINE
PLAN OR SECTION DETAIL	1 A101 DRAWING NUMBER AREA DETAILED SHEET WHERE DETAIL IS DRAWN
NORTH ARROW	

- GENERAL NOTES
- GENERAL CONTRACTOR IS RESPONSIBLE FOR OBTAINING AND PAYING FOR PERMITS AND INSPECTIONS REQUIRED BY PUBLIC AUTHORITIES GOVERNING THE WORK.
 - REVIEW DOCUMENTS AND VERIFY DIMENSIONS AND FIELD CONDITIONS. REPORT ANY CONFLICTS OR OMISSIONS TO THE ARCHITECT FOR CLARIFICATION PRIOR TO PERFORMING ANY WORK IN QUESTION.
 - CONTRACTOR TO NOTIFY ARCHITECT OF ANY DISCREPANCIES BETWEEN ARCHITECTURAL AND CONSULTANT DRAWINGS AND SHALL OBTAIN WRITTEN CLARIFICATION FROM ARCHITECT BEFORE PROCEEDING WITH THE WORK IN QUESTION OR RELATED WORK.
 - SUBMIT REQUESTS FOR SUBSTITUTIONS, REVISIONS, OR CHANGES TO ARCHITECT FOR REVIEW PRIOR TO PURCHASE, FABRICATION, OR INSTALLATION.
 - OWNER WILL PROVIDE WORK NOTED "BY OTHERS" OR "NIC" UNDER SEPARATE CONTRACT. INCLUDE SCHEDULE REQUIREMENTS IN CONSTRUCTION PROGRESS SCHEDULE AND COORDINATE TO ASSURE ORDERLY SEQUENCE OF INSTALLATION, UNLESS OTHERWISE DIRECTED. NOTIFY ARCHITECT OF ANY CONFLICTS OR DISCREPANCIES WITH NIC ITEMS.
 - COORDINATE TELECOMMUNICATIONS, DATA, AND SECURITY SYSTEM INSTALLATIONS.
 - DO NOT SCALE DRAWINGS; WRITTEN DIMENSIONS GOVERN. IN CASE OF CONFLICT, CONSULT THE ARCHITECT.
 - PROVIDE A PORTABLE FIRE EXTINGUISHER WITHIN 75 FOOT TRAVEL DISTANCE TO ALL PORTIONS OF THE BUILDING ON EACH FLOOR, AND ADDITIONAL FIRE EXTINGUISHERS AS REQUIRED BY FIRE OR BUILDING FIELD INSPECTORS.
 - PROVIDE ILLUMINATED EXIT SIGN OVER REQUIRED EXITS, WHERE SHOWN ON DRAWINGS, AND ADDITIONAL SIGNS AS REQUIRED BY FIRE OR BUILDING FIELD INSPECTORS. CONNECT EXIT SIGNS TO EMERGENCY POWER CIRCUITS. SEE ELECTRICAL DRAWINGS.
 - PRIOR TO CORING SLAB FOR FLOOR POWER OR DATA, OR POURING AROUND POWER/DATA LOCATIONS, REVIEW LOCATIONS WITH ARCHITECT AND OWNER.
 - GANG ADJACENT LIGHT SWITCHES AND COVER WITH A SINGLE PLATE.
 - MAINTAIN INTEGRITY OF FIRE RESISTANCE RATING OF ALL RATED SHAFT ENCLOSURES AND RATED PARTITIONS BEHIND RECESSED WALL ACCESSORIES, SUCH AS FIRE EXTINGUISHER CABINETS, TOILET ACCESSORIES, AND ELECTRICAL BOXES.
 - NO EXPOSED CONDUIT, WIRING, PIPING, OR BOXES ARE PERMITTED WITHOUT ARCHITECT APPROVAL, UNLESS SPECIFICALLY NOTED OTHERWISE.
 - GENERAL CONTRACTOR WILL BE RESPONSIBLE FOR COORDINATION BETWEEN THE TRADES PROVIDING SYSTEMS IN OPEN CEILING CONDITIONS. COORDINATION DRAWINGS AND ANY CONFLICTS ARE TO BE REVIEWED WITH THE ARCHITECT PRIOR TO INSTALLATION.
 - REFER TO THE PROJECT MANUAL FOR COMPLETE GENERAL REQUIREMENTS AND CONDITIONS OF THE CONTRACT. THE PROJECT MANUAL SHALL TAKE PRECEDENCE OVER THESE GENERAL NOTES IN THE EVENT OF A CONFLICT.
 - IF PROVIDED, REFER TO ENLARGED PLANS AND PLAN DETAILS FOR ADDITIONAL INFORMATION AND DIMENSIONS.
 - ANY DIMENSIONS OF, OR TYING IN TO, EXISTING BUILDING COMPONENTS ARE TO BE FIELD VERIFIED PRIOR TO COMMENCEMENT OF WORK. REVIEW ANY DISCREPANCIES WITH ARCHITECT PRIOR TO COMMENCEMENT OF WORK.
 - TYPICAL DETAILS SHOWN ON THE DRAWINGS SHALL BE INCORPORATED AT ALL APPROPRIATE LOCATIONS WHETHER OR NOT SPECIFICALLY REFERENCED AT EACH LOCATION.
 - IN AREAS OF HARD CEILING, BUILDING SYSTEMS SHALL BE CONFIGURED TO AVOID OR MINIMIZE ABOVE-CEILING ACCESS. THE LOCATION OF ALL ACCESS DOORS MUST BE COORDINATED WITH AND APPROVED BY ARCHITECT PRIOR TO THE INSTALLATION OF ANY ABOVE-CEILING EQUIPMENT, DAMPERS, VALVES, JUNCTION BOXES, ETC. ANY ACCESS DOORS OR PANELS REQUIRED IN WALLS MUST ALSO BE COORDINATED WITH AND APPROVED BY THE ARCHITECT PRIOR TO THE INSTALLATION OF THE EQUIPMENT REQUIRING ACCESS.
 - CONTRACTOR SHALL BE SOLELY RESPONSIBLE FOR THE ACCURACY OF HIS MEASUREMENTS AND TAKE-OFFS FOR MATERIAL ORDERS.
 - VARIATIONS IN FLOOR LEVEL, IN EXCESS OF 1/8" FOR EVERY 10'-0" (1.0 N.) SHALL BE LEVELED BY CONTRACTOR.

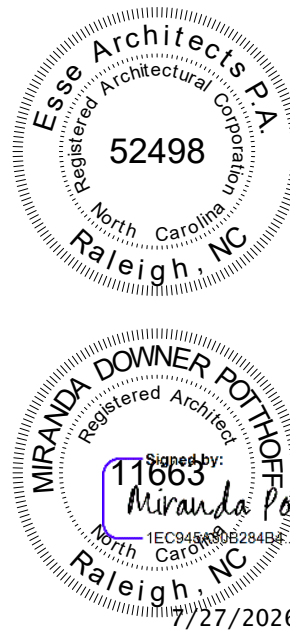


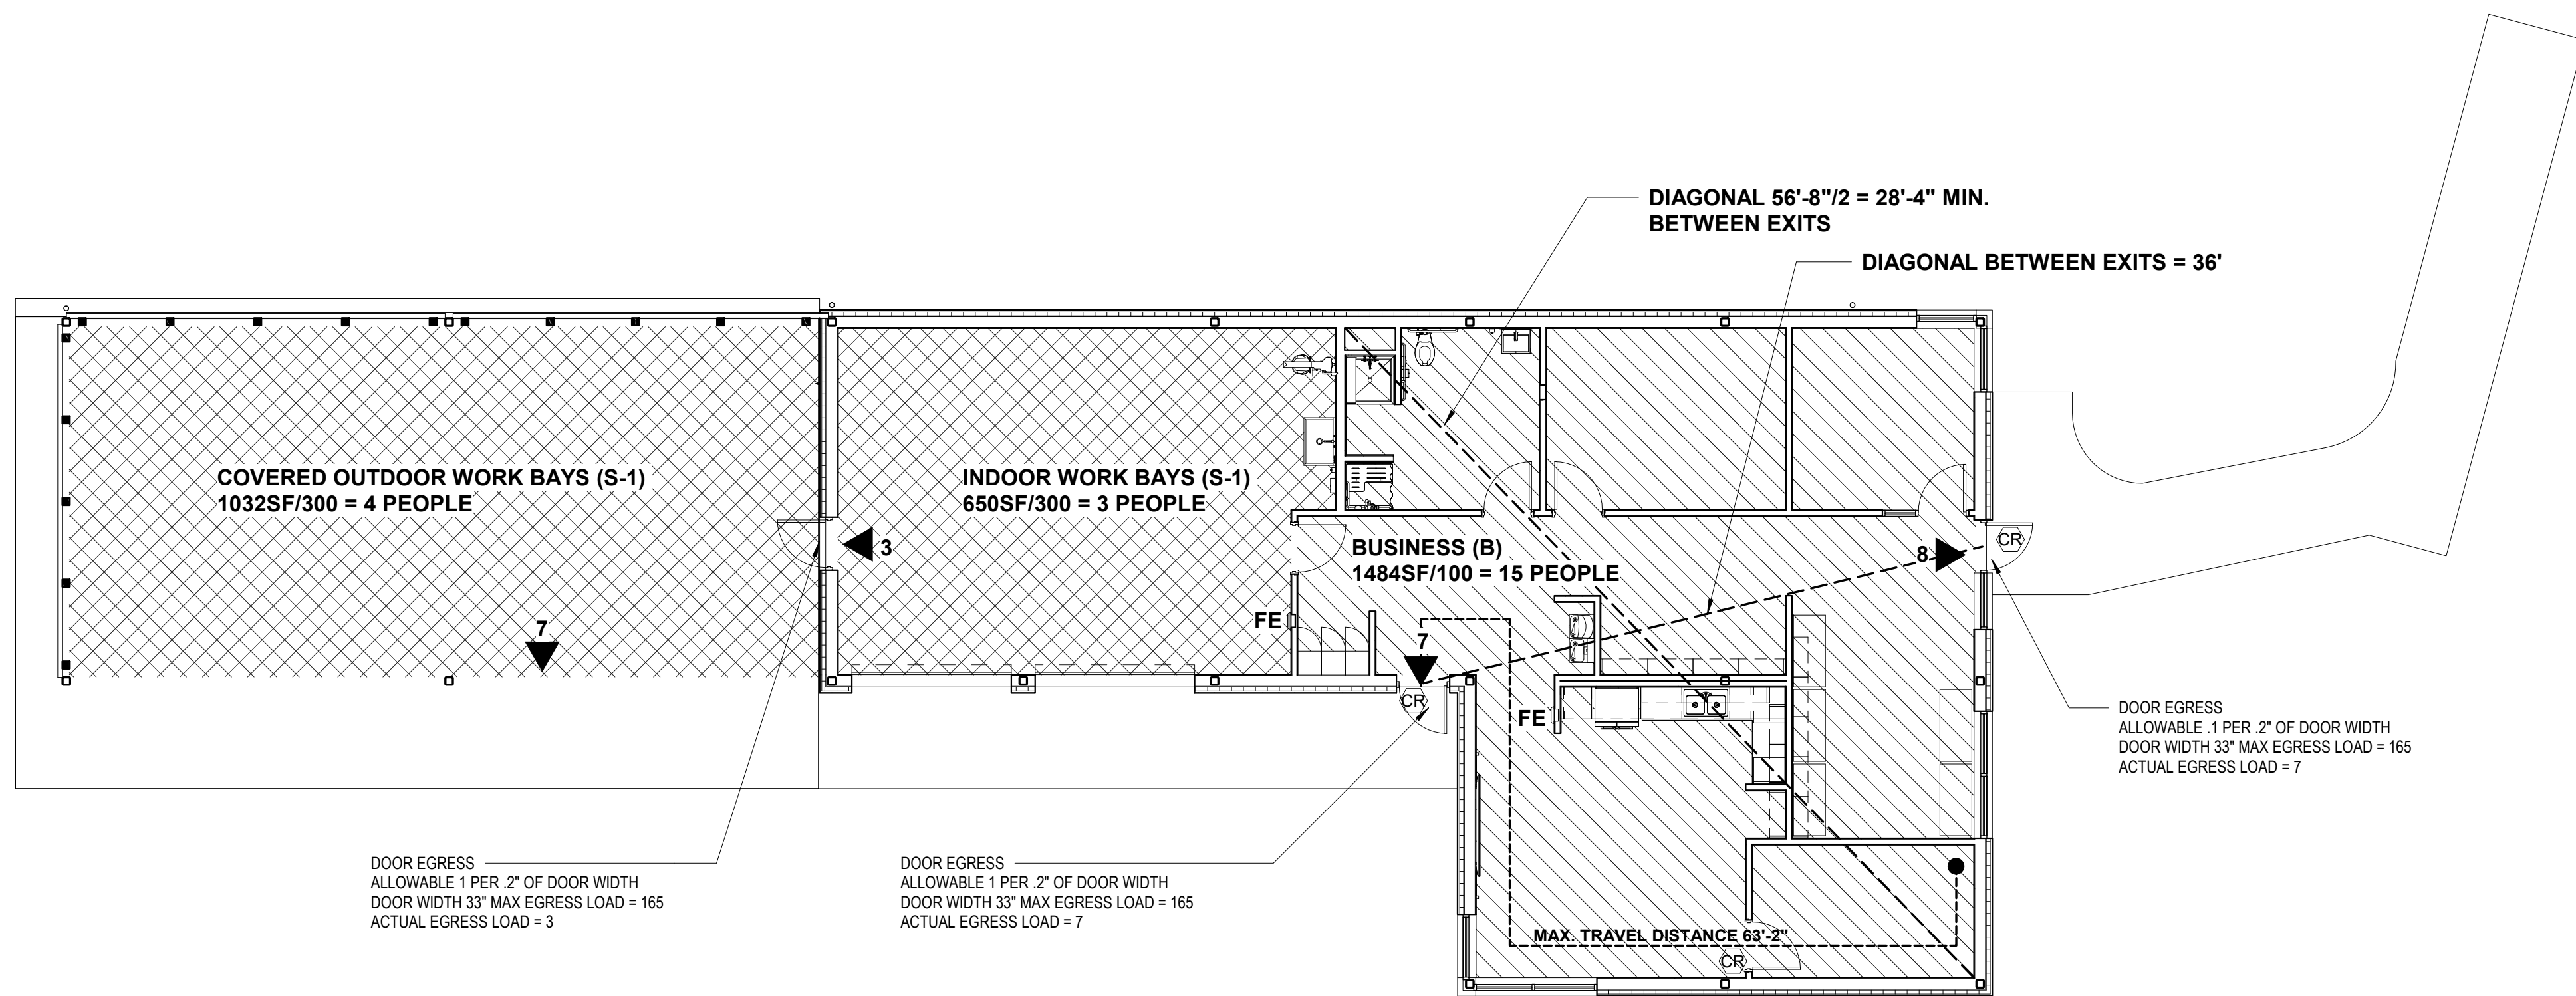

TOTAL BUILDING OCCUPANT LOAD = 22
SEPARATE RESTROOM FACILITIES ARE NOT REQUIRED.

MAINTENANCE FACILITY LIFE SAFETY PLAN
1/8" = 1'-0"

LIFE SAFETY PLAN LEGEND AND NOTES				
UNRATED CONSTRUCTION OCCUPANTS EGRESSING DOORS WITH CARD READERS (FREE EGRESS) SEMI RECESSED FIRE EXTINGUISHER CABINET	AREA SCHEDULE			
	NAME	AREA	LOAD FACTOR	OCCUPANTS
	BUSINESS (B)			
	STAFF AREAS	1484 SF	100	15
	STORAGE (S-1)			
NOTES 1. SEE ELECTRICAL DRAWINGS FOR EXIT SIGN LOCATIONS.	INDOOR WORK BAY	650 SF	300	3
	OUTDOOR WORK BAYS	1032 SF	300	4
	FIRE AREAS			
BUSINESS (B) STORAGE (S-1)		FIRE AREA 1 3,166 SF THERE IS ONLY ONE FIRE AREA.		

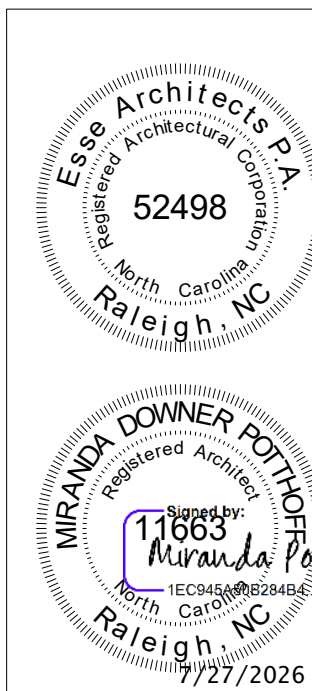

Susan Hatchell
Landscape Architecture, PLLC
711 W. North Street, Raleigh, NC 27603
p: 919-838-9600 f: 919-838-9700




LIFE SAFETY PLAN

LAKE MYRA COUNTY PARK
Wake County, NC


REVISIONS

Date: 07/27/26


MF-G102

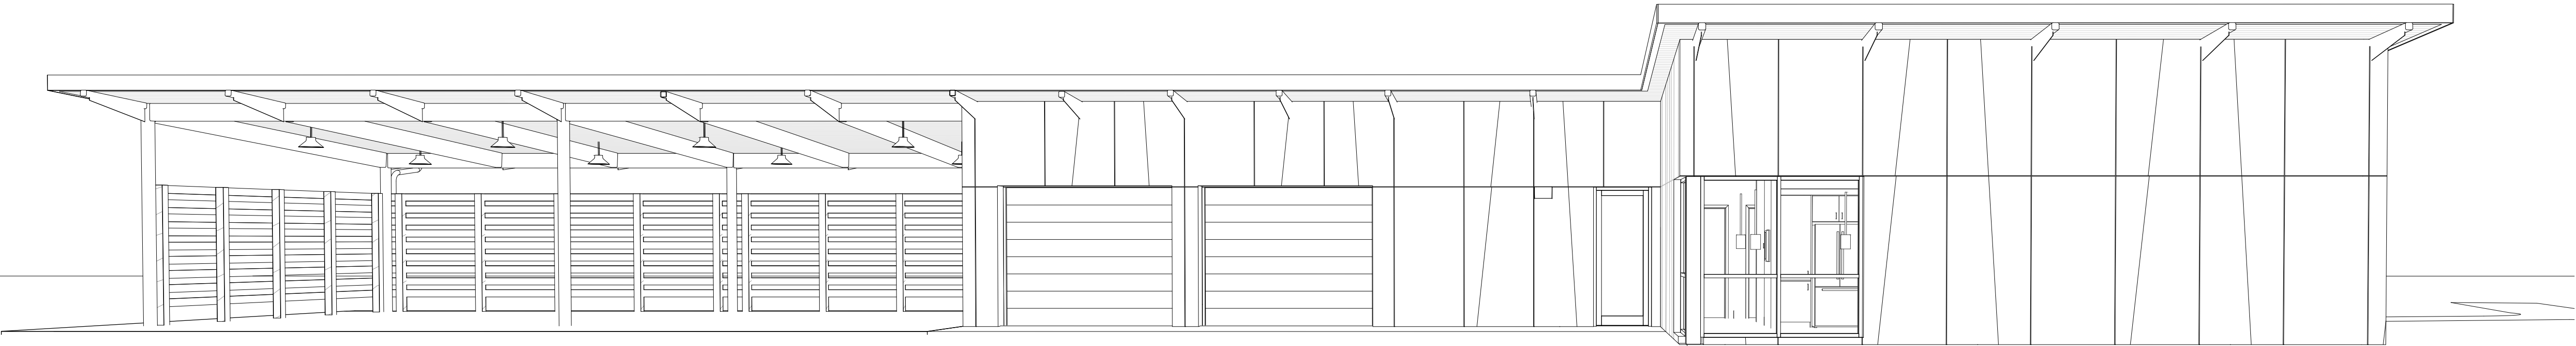

1 MAINTENANCE FACILITY - FRONT VIEW

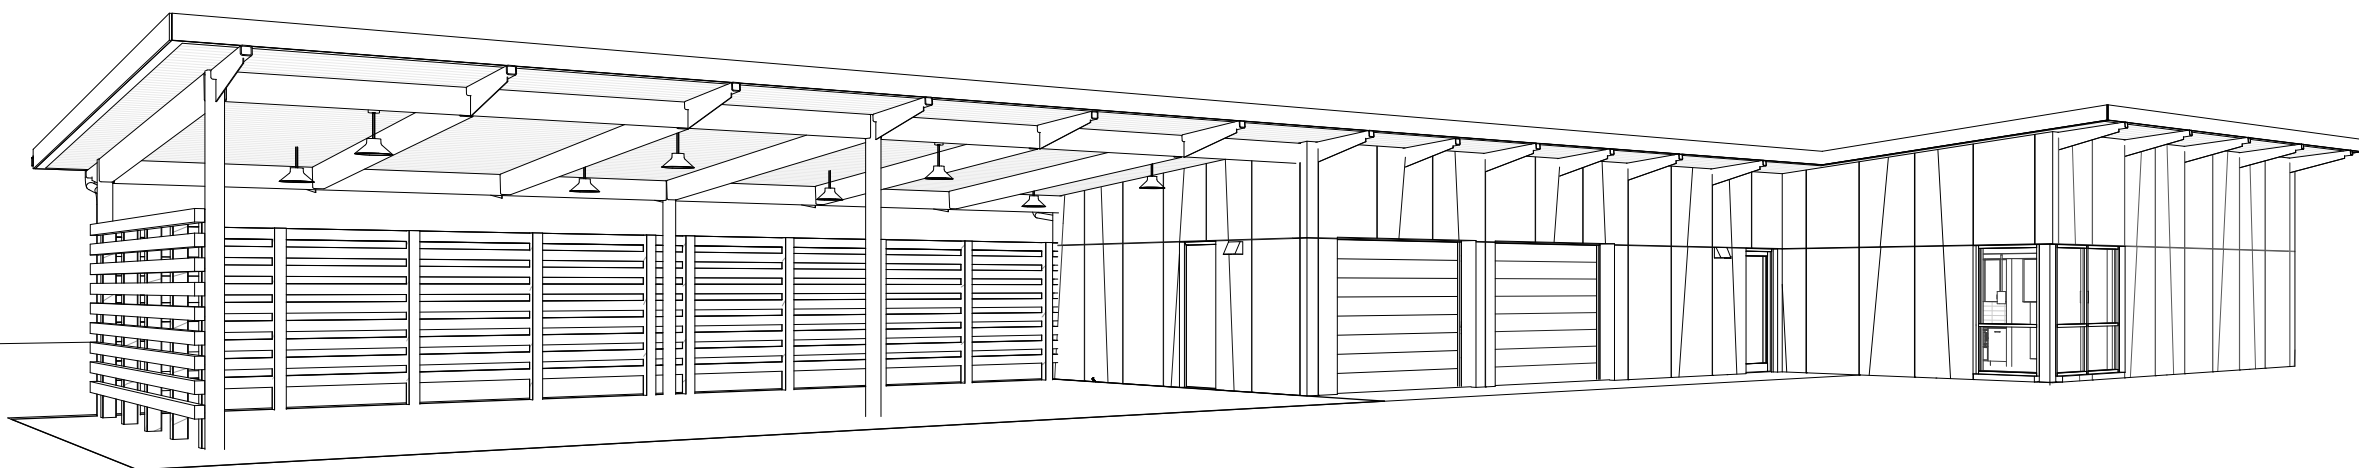

2 MAINTENANCE FACILITY - ENTRY VIEW

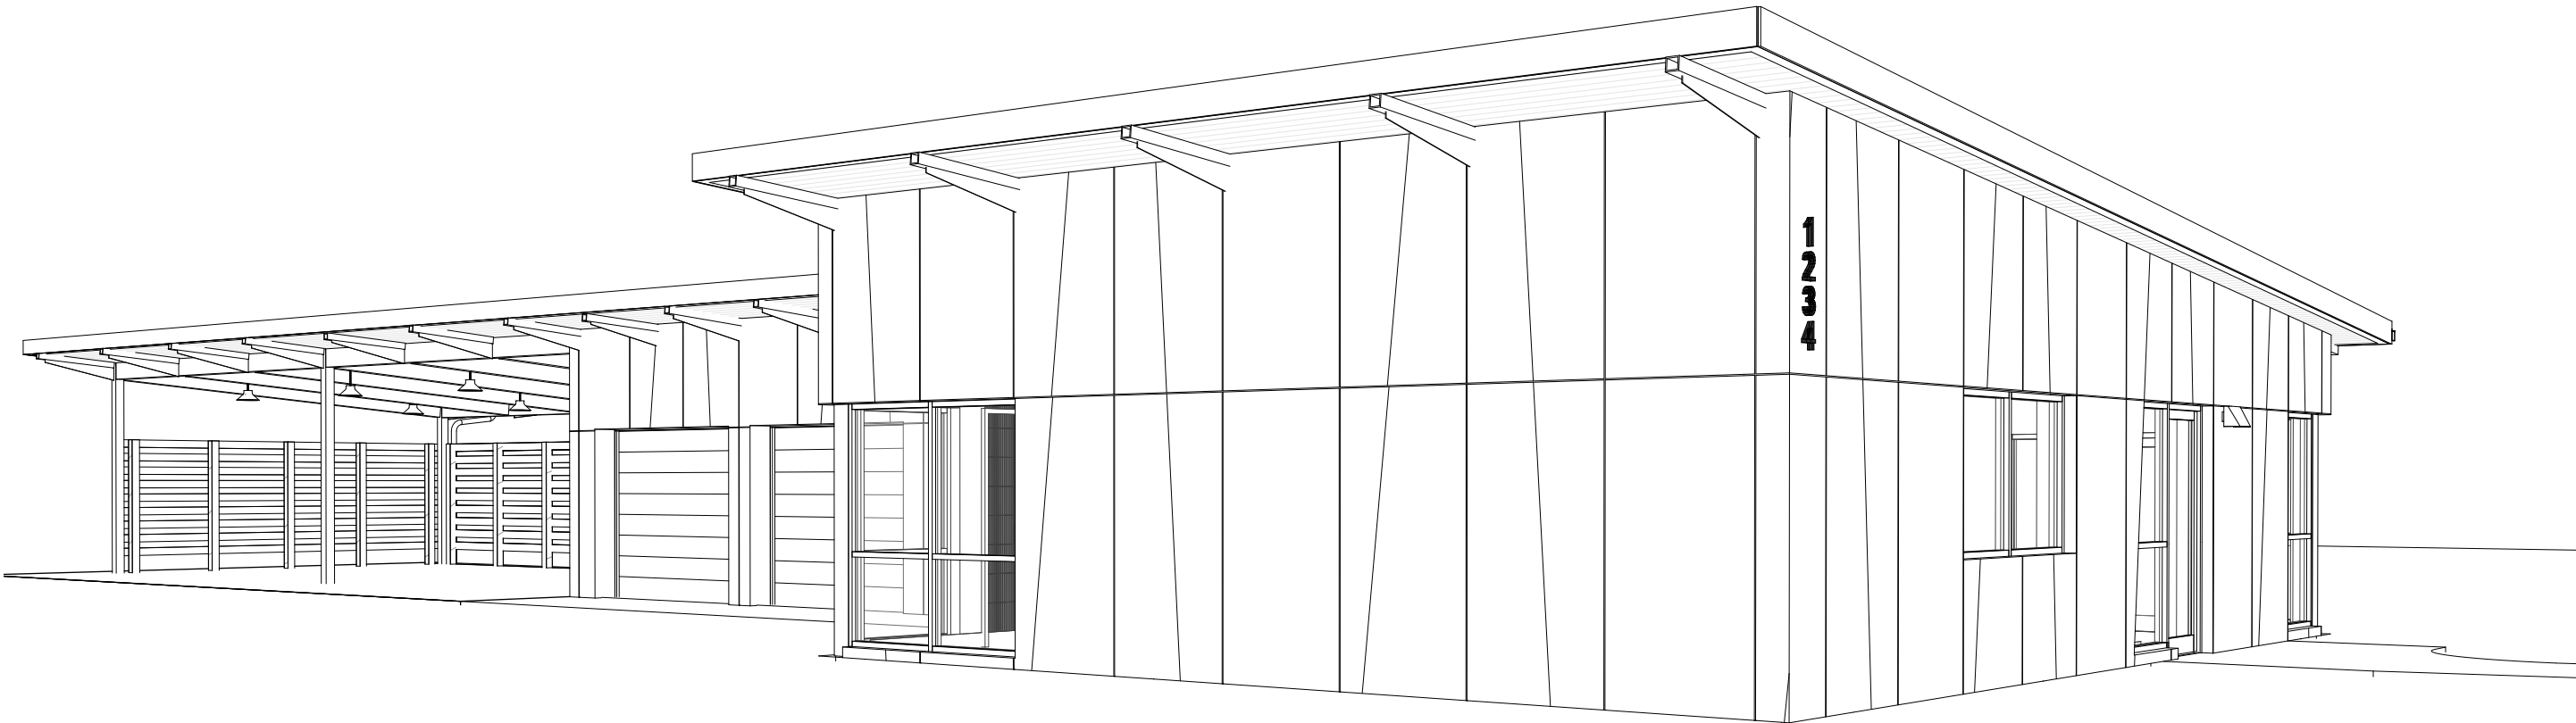

3 MAINTENANCE FACILITY - APPROACH

Susan Hatchell
Landscape Architecture, PLLC
711 W. North Street, Raleigh, NC 27603
p: 919-838-9600 f: 919-838-9700




3D VIEWS

LAKE MYRA COUNTY PARK
Wake County, NC


REVISIONS

Date: 07/27/26
MF-A000



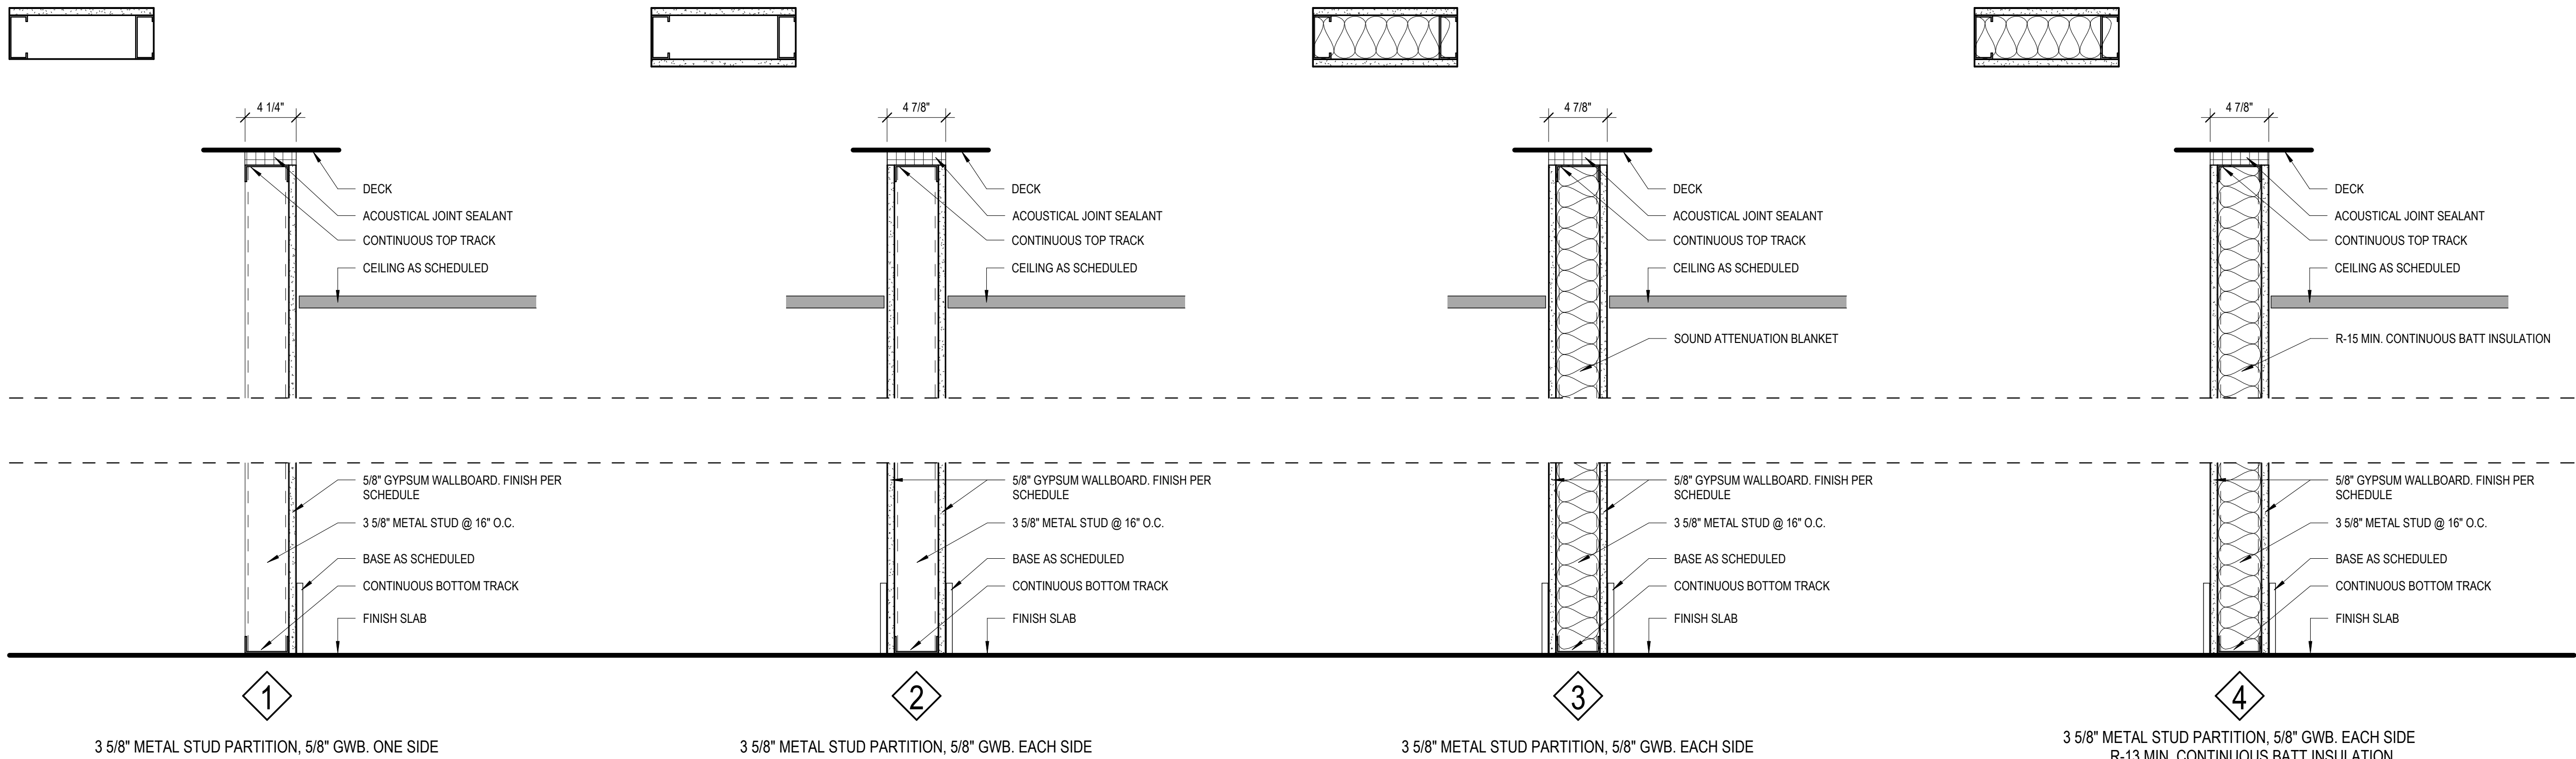

SYMBOL LEGEND	
#	PARTITION TAG
GENERAL PARTITION NOTES	
1. ALL RATED WALLS ARE TO BE STENCIL PAINTED IN RED AS FOLLOWS: "1-HOUR RATED WALL SMOKE BARRIER; SEAL ALL PENETRATIONS" WITH THE APPLICABLE RATING NOTED, PER PLANS. LETTERS TO BE 6" HIGH. STENCILS TO BE 12" ABOVE CEILING AND SPACED AT 48" O.C. MAX. BOTH SIDES OF WALL.	
2. COORDINATE ADJACENT WALLS OF DIFFERENT TYPES SO THAT GYP. BOARD WALL FACES ALIGN. RESILIENT CHANNELS TO BE ON THE SAME SIDE OF THE WALL, TYP.	
3. ALL INTERIOR PARTITIONS TO BE TYPE "3", U.N.O.	
4. SEAL PERIMETER OF ALL WALLS, TYP.	
5. PROVIDE FIRE SEALANT AT BASE, PENETRATIONS, AND TOP OF ALL WALLS REQUIRING FIRE RATING.	
6. USE 5/8" CEMENTITIOUS TILE BACKING SHEETS IN LIEU OF 5/8" GWB BEHIND ALL WALL TILE, TYP.	
7. SEE FINISH SCHEDULE AND FINISH PLANS FOR WALL TILE AND WALL FINISHES.	
8. ALL RATED WALLS TO BE CONTINUOUS SYSTEMS. G.C. TO COORDINATE CORRECT SEQUENCING OF RATED WALL CONSTRUCTION.	

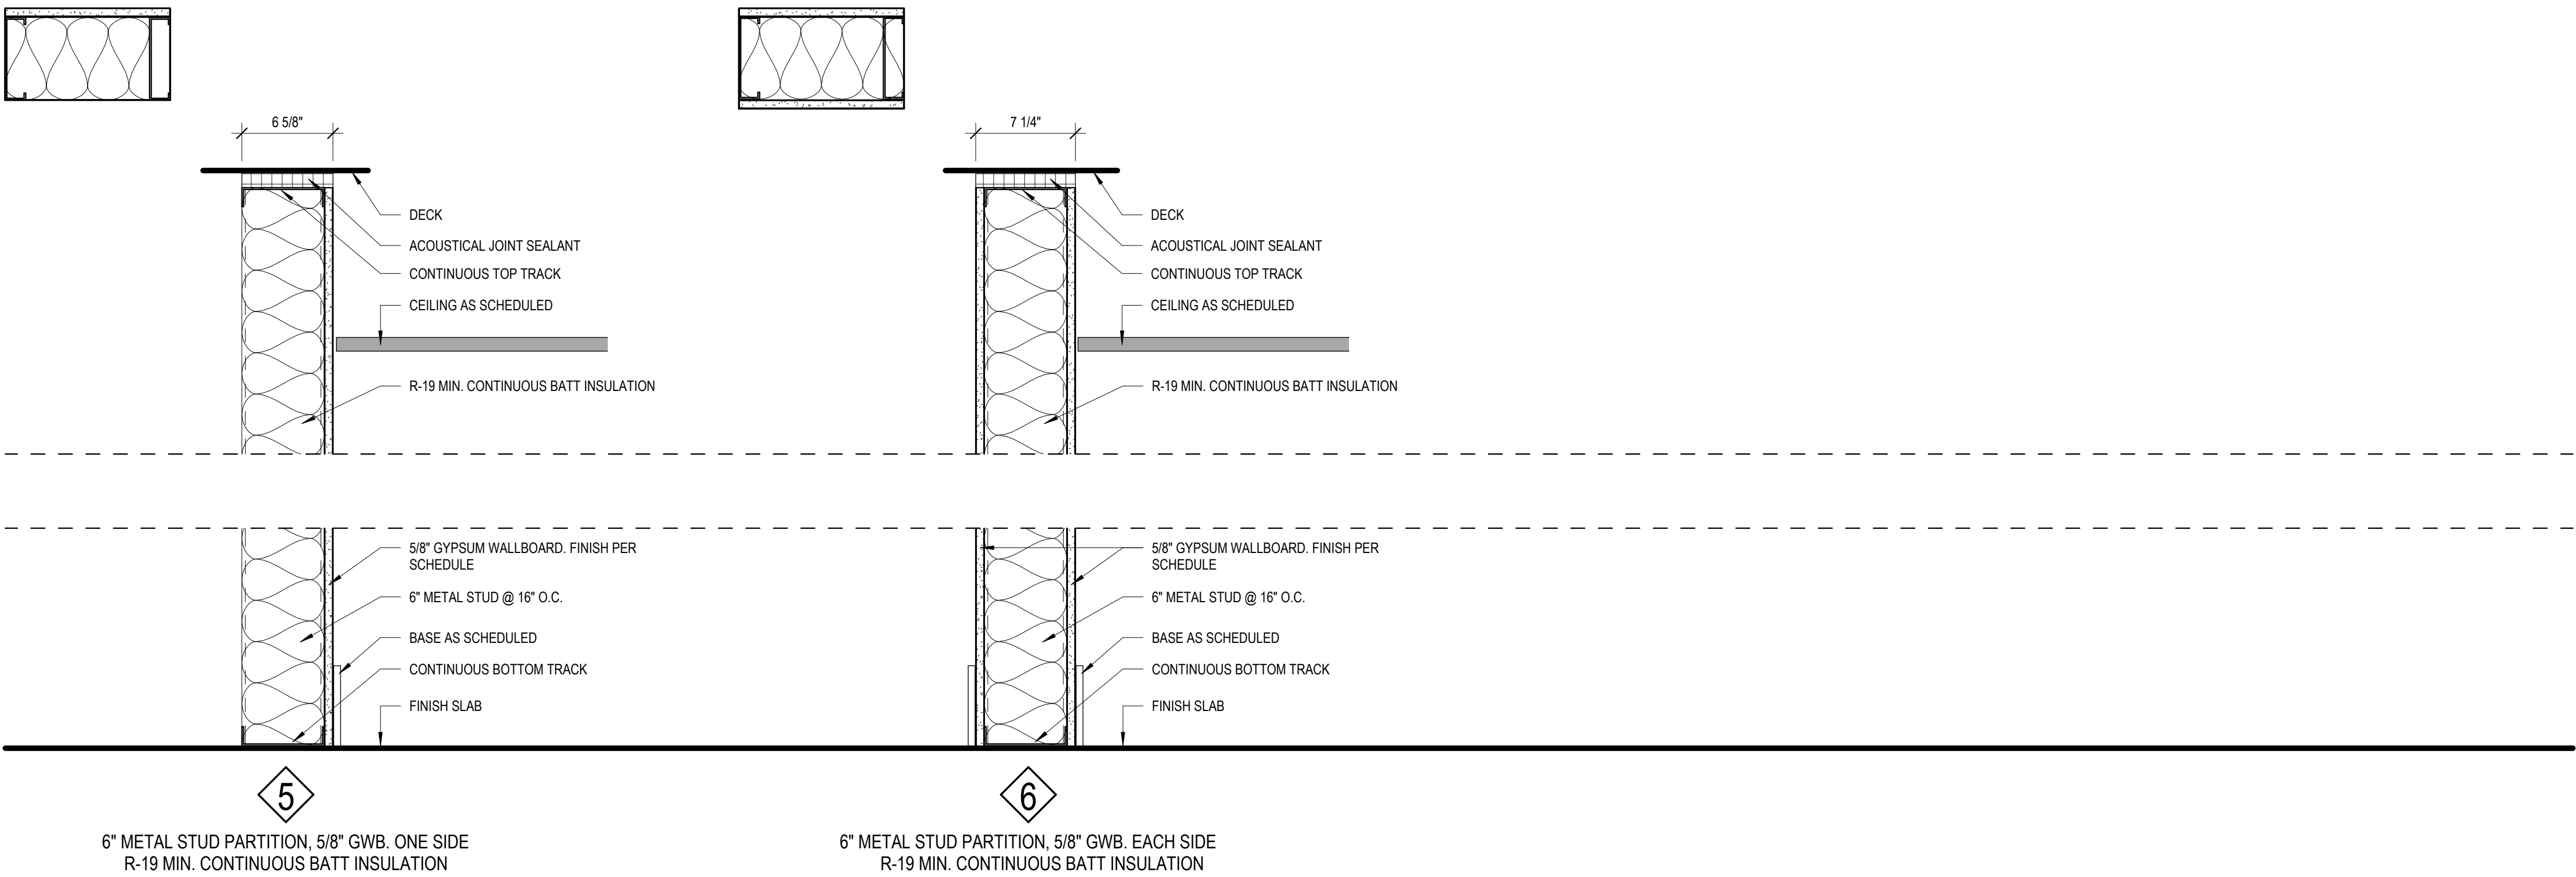


Susan
Hatchell
Landscape Architecture, PLLC
711 W. North Street, Raleigh, NC 27603
p: 919-838-9600 f: 919-838-9700

Esse
Architects
832 FRESHING ROAD | RALEIGH, NORTH CAROLINA 27608

PARTITIONS


LAKE MYRA COUNTY PARK
Wake County, NC

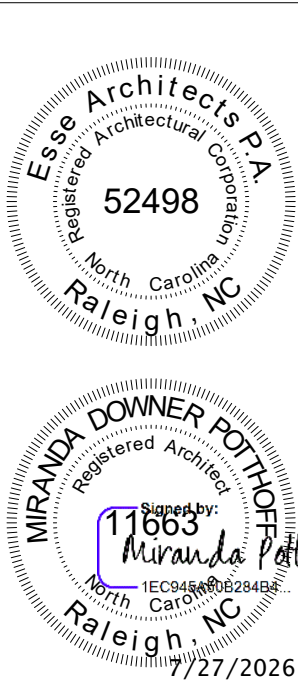

REVISIONS


Date: 07/27/26

MF-A001

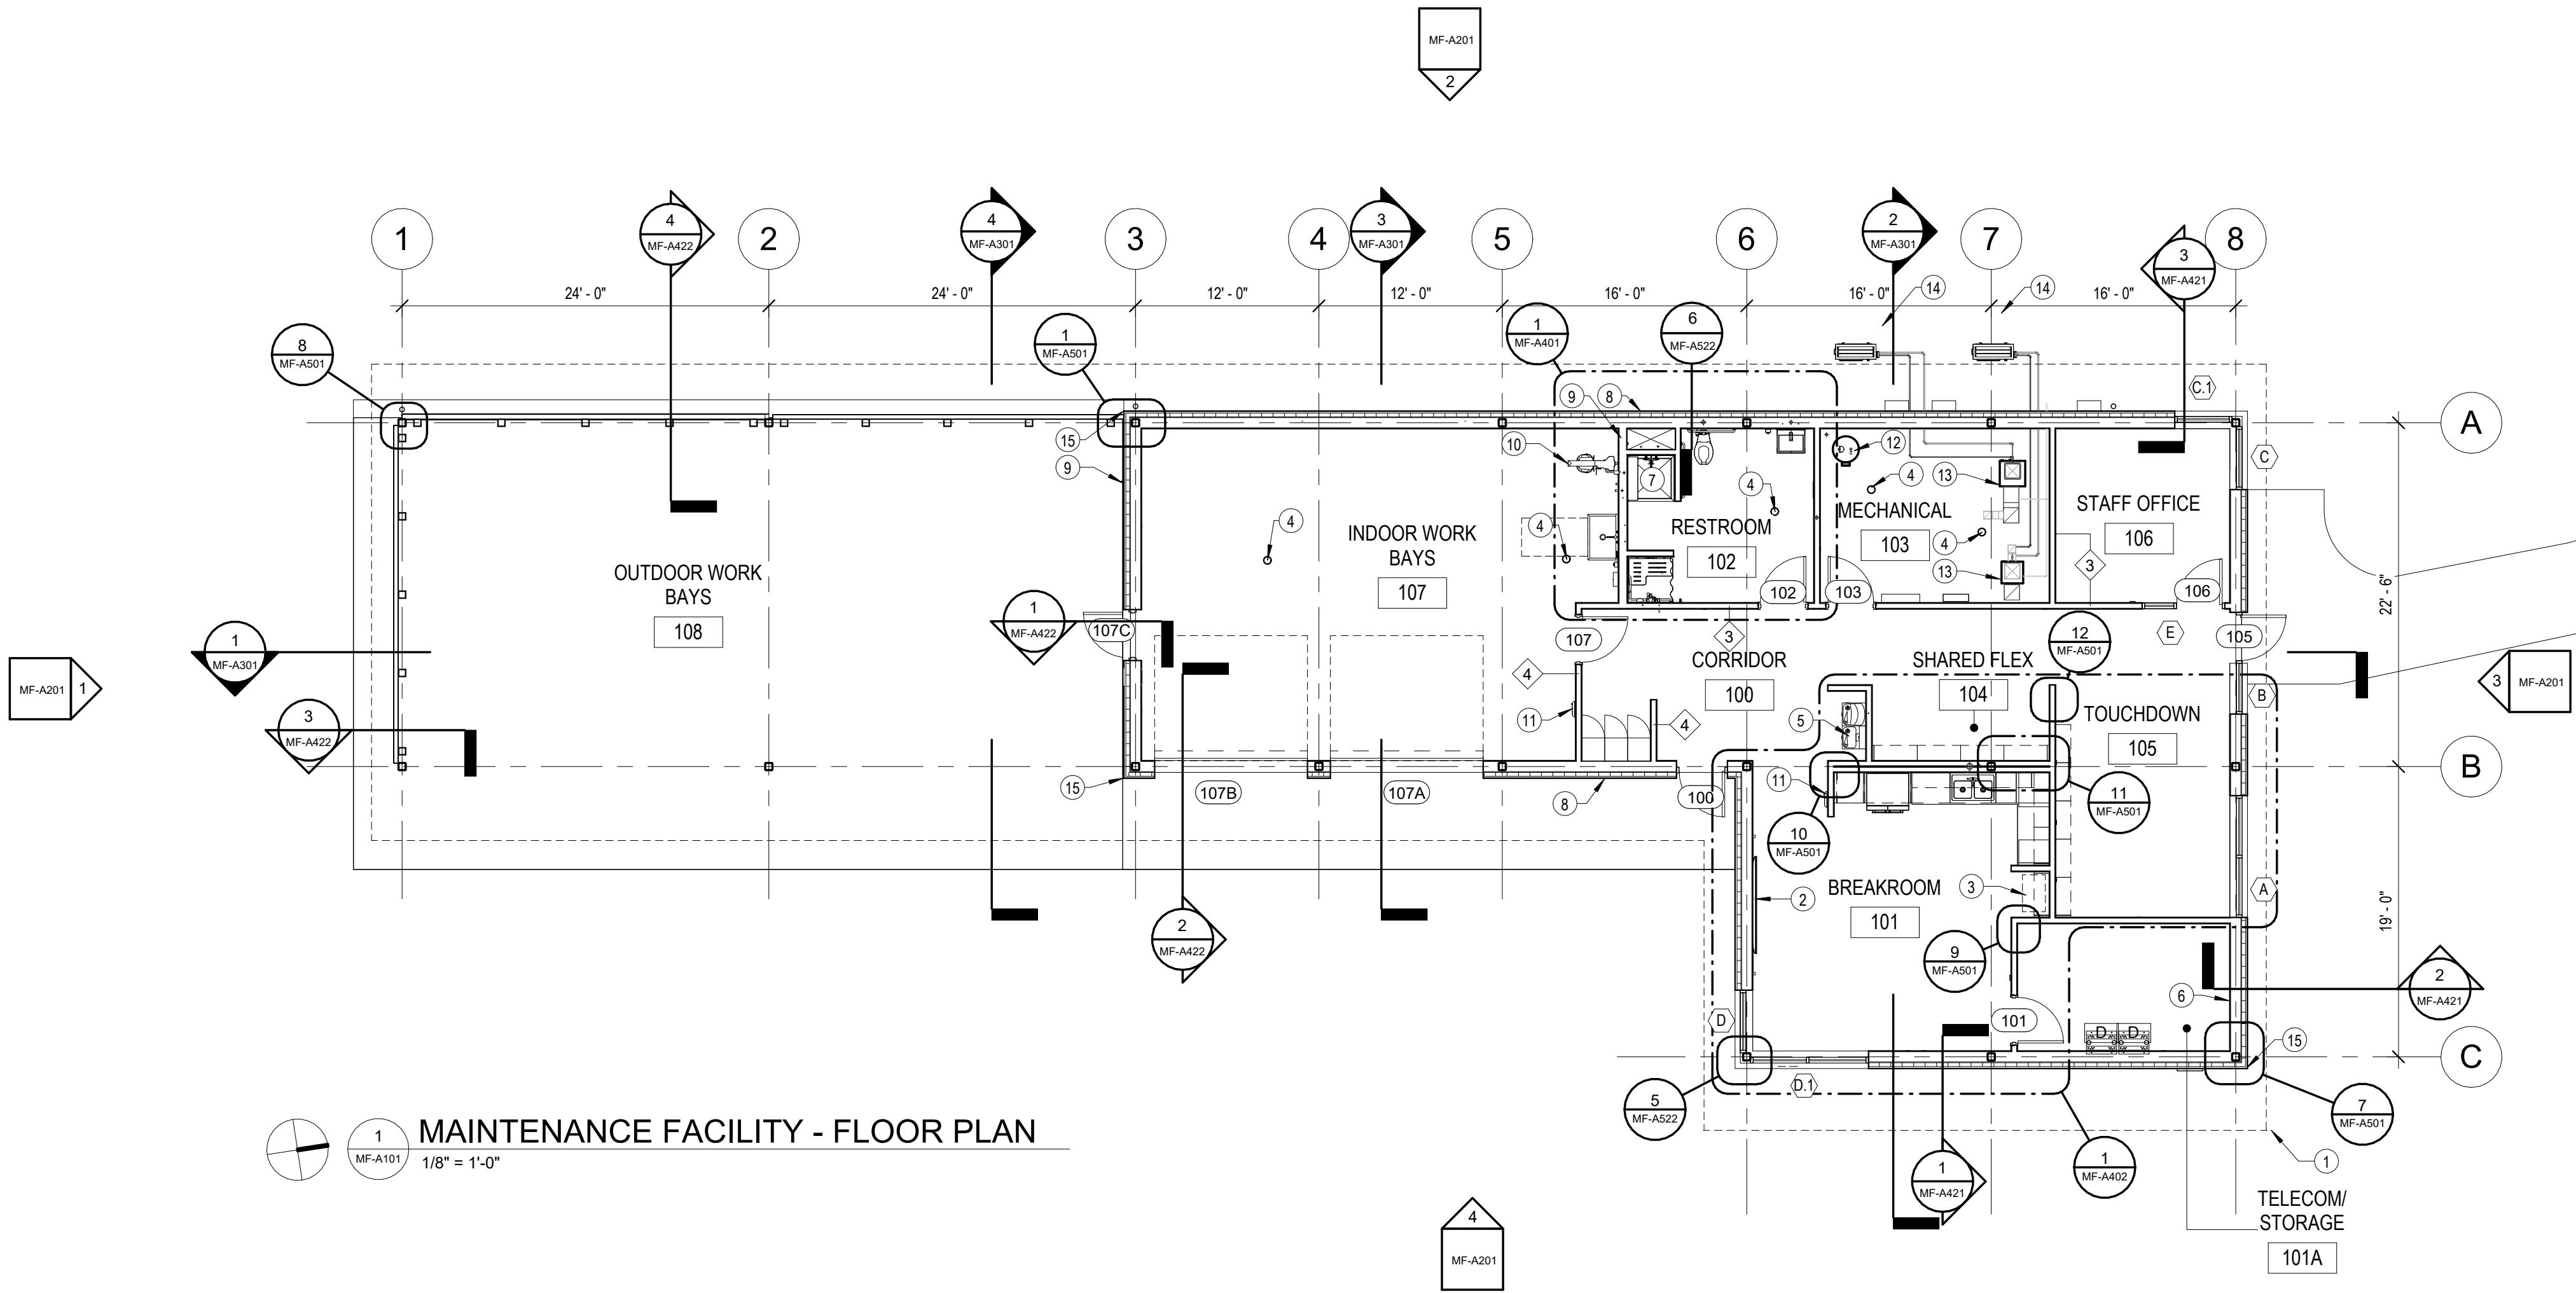

1 MF-A101
1/8" = 1'-0"

MAINTENANCE FACILITY - FLOOR PLAN

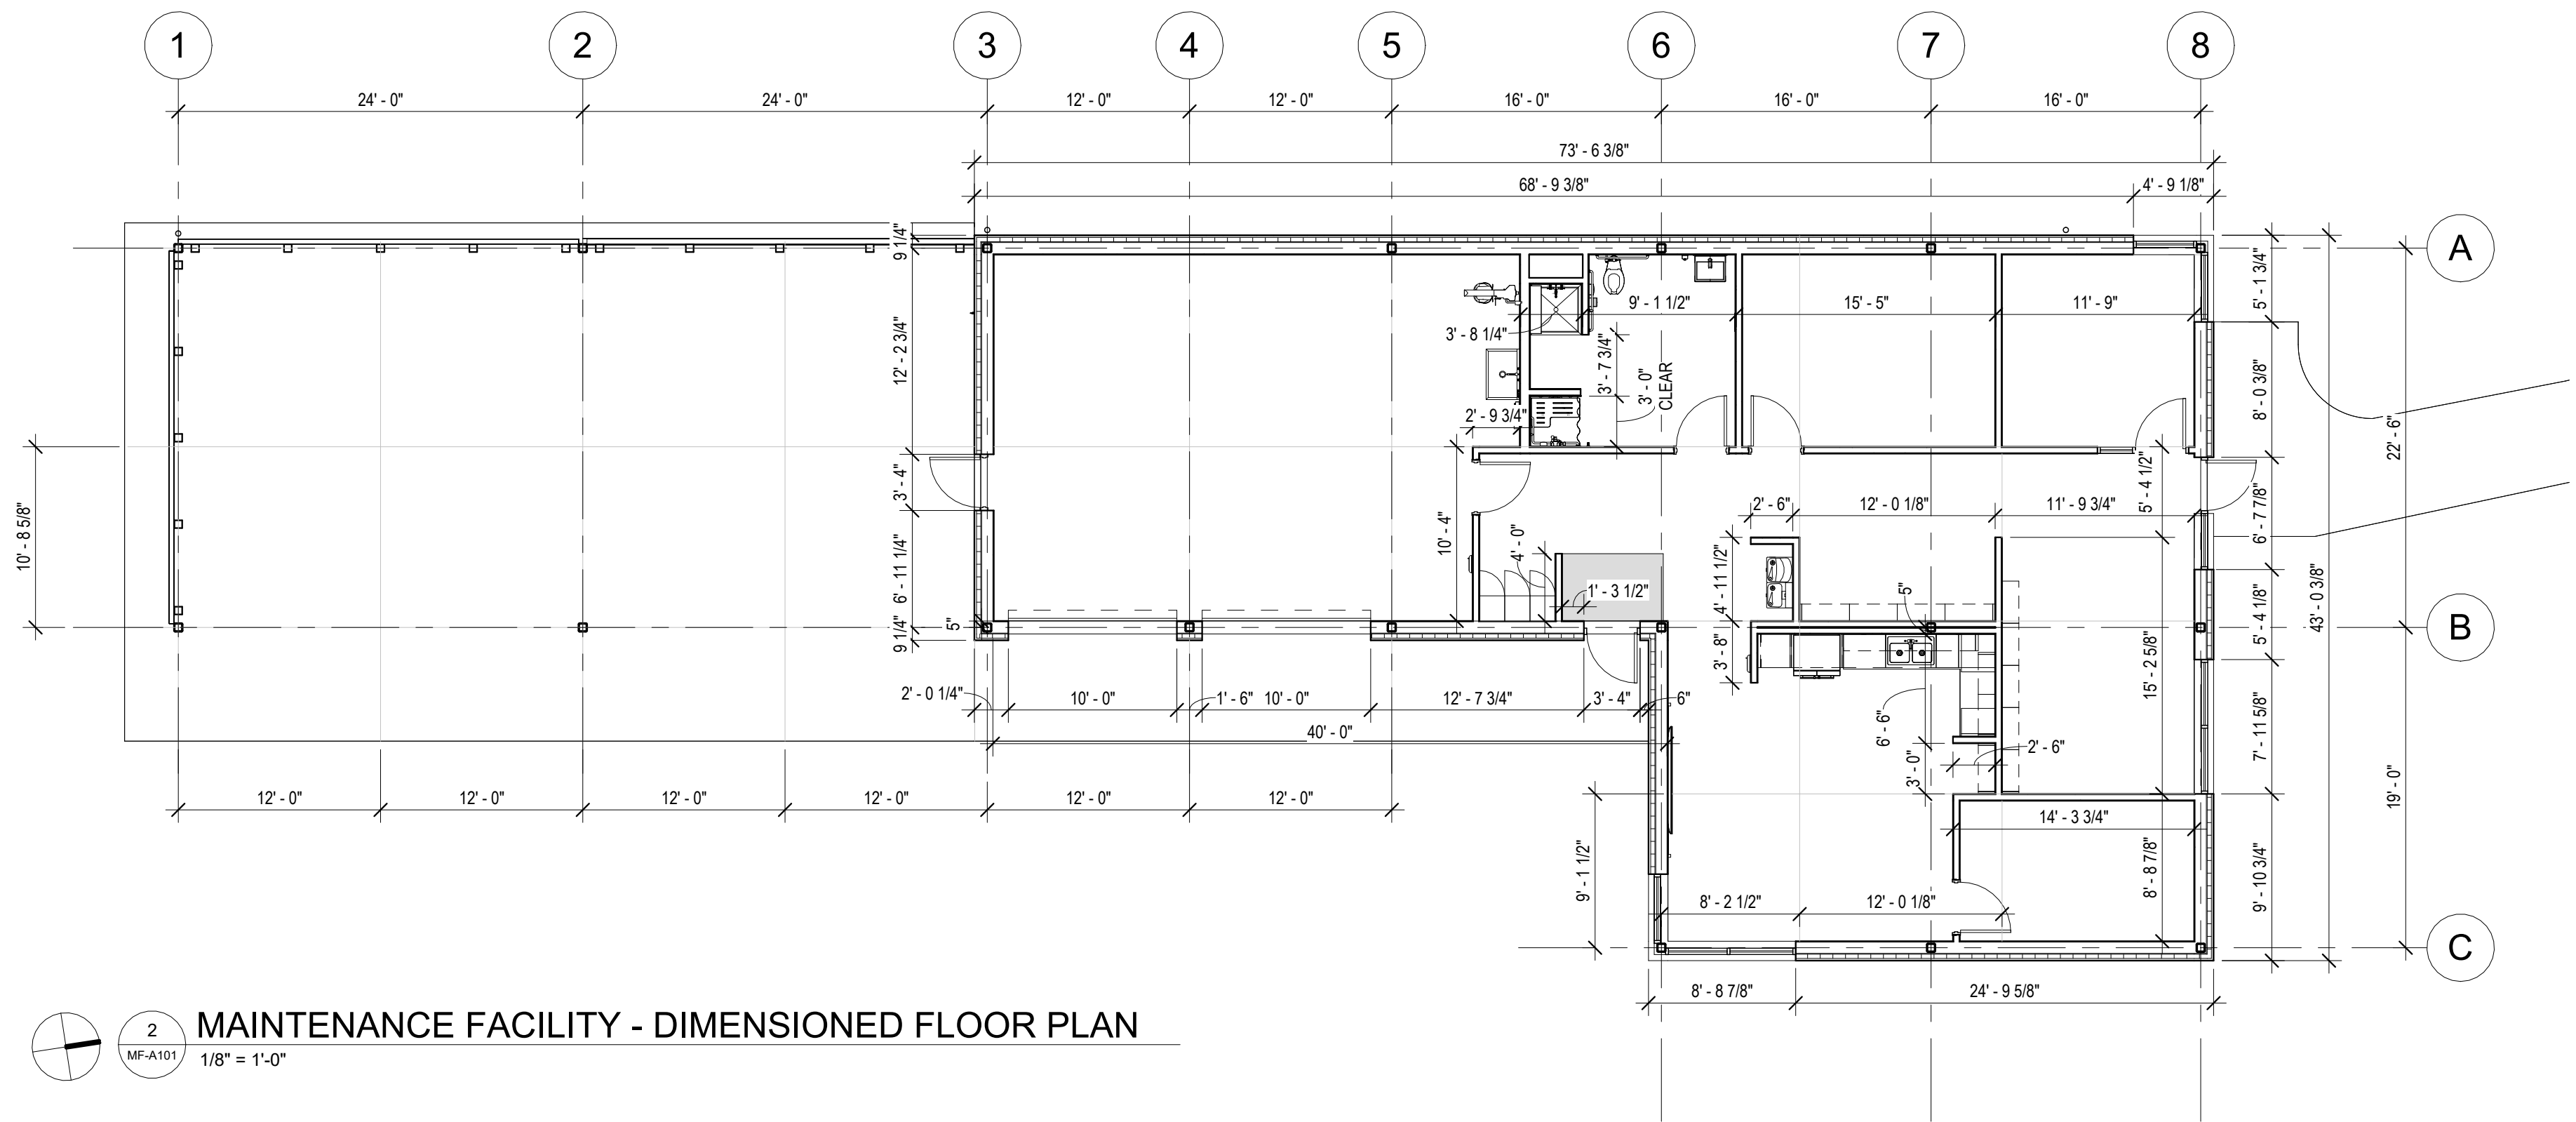

2 MF-A101
1/8" = 1'-0"

MAINTENANCE FACILITY - DIMENSIONED FLOOR PLAN

WALL LEGEND	
	UNRATED CONSTRUCTION
	PARTITION TAG
NOTES 1. DIMENSIONS ARE TO CENTERLINE OF COLUMN LINES. FACE OF INTERIOR STUDS AND FACE OF EXTERIOR WALL SHEATHING, UNLESS NOTED OTHERWISE. 2. COORDINATE AND PROVIDE BACKING/BLOCKING FOR MILLWORK AND ITEMS ATTACHED OR MOUNTED TO WALLS OR CEILINGS. 3. LOCATE DOOR OPENINGS 4" OFF PERPENDICULAR WALL, U.O.N. 4. SEE DIMENSION PLAN FOR SLAB CONTROL JOINT LOCATIONS DEPICTED BY HALFTONE LINE. 5. SEE PLAN FOR SLAB CONTROL JOINT LOCATIONS DEPICTED BY HALFTONE LINES. 6. FINISH WALL TO FLOOR FOR BASE ADHESION. 7. SEE ENLARGED PLANS FOR ADDITIONAL DETAIL LOCATIONS.	

GENERAL KEY NOTES	
KEY	DESCRIPTION
1	ROOF OVERHANG ABOVE
2	AVIDATA WALL
3	COPIER LOCATION - COPIER TO BE OWNER PROVIDED
4	FLOOR DRAIN - SEE PLUMBING DRAWINGS
5	DRINKING FOUNTAIN - SEE PLUMBING DRAWINGS
6	INSTALL 3/4" FIRE RESISTANT PLYWOOD ON INDICATED WALL. RUN FROM BASE TO CLG.
7	MOP SINK - SEE PLUMBING DRAWINGS
8	WALL HYDRANT - SEE PLUMBING DRAWINGS
9	HOSE BIBB - SEE PLUMBING - CONFIRM LOCATION WITH OWNER
10	EMERGENCY EYEWASH - SEE PLUMBING DRAWINGS
11	FIRE EXTINGUISHER CABINET
12	ELECTRIC WATER HEATER - SEE PLUMBING DRAWINGS
13	AIR HANDLING UNIT - SEE MECHANICAL DRAWINGS
14	CONDENSING UNIT WITH CONCRETE HOUSEKEEPING PAD - SEE MECHANICAL DRAWINGS
15	CONTINUOUS POWDER COATED VERTICAL ALUMINUM TRIM

Susan Hatchell
Landscape Architecture, PLLC
711 W. North Street, Raleigh, NC 27603
p: 919-838-9600 f: 919-838-9700

Esse Architects
832 FERRISS ROAD | RALEIGH, NORTH CAROLINA 27608


FLOOR PLAN &
DIMENSIONED PLAN








LAKE MYRA COUNTY PARK
Wake County, NC

REVISIONS

Date: 07/27/26

MF-A101

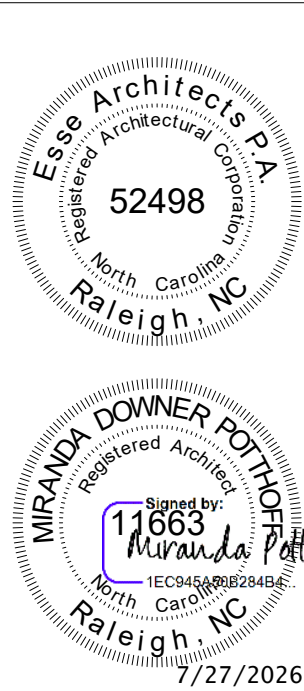

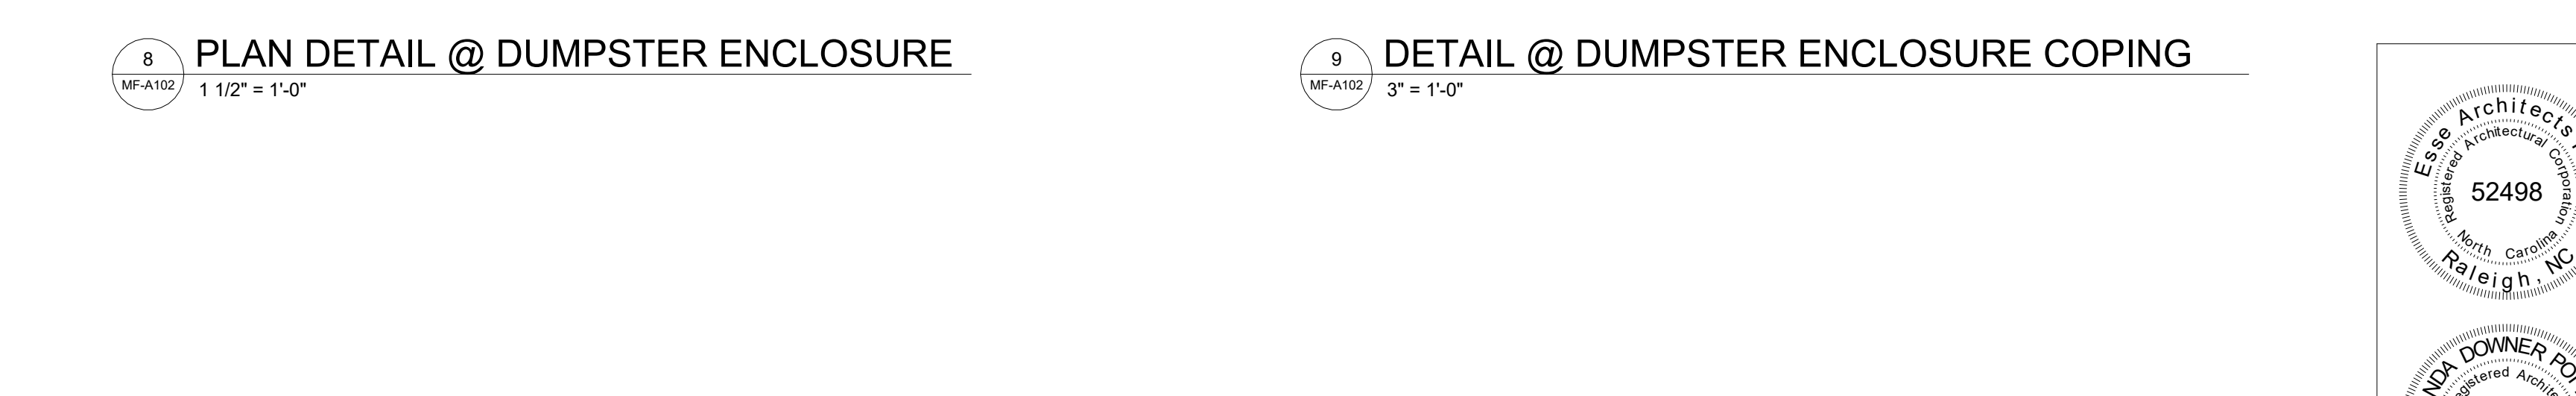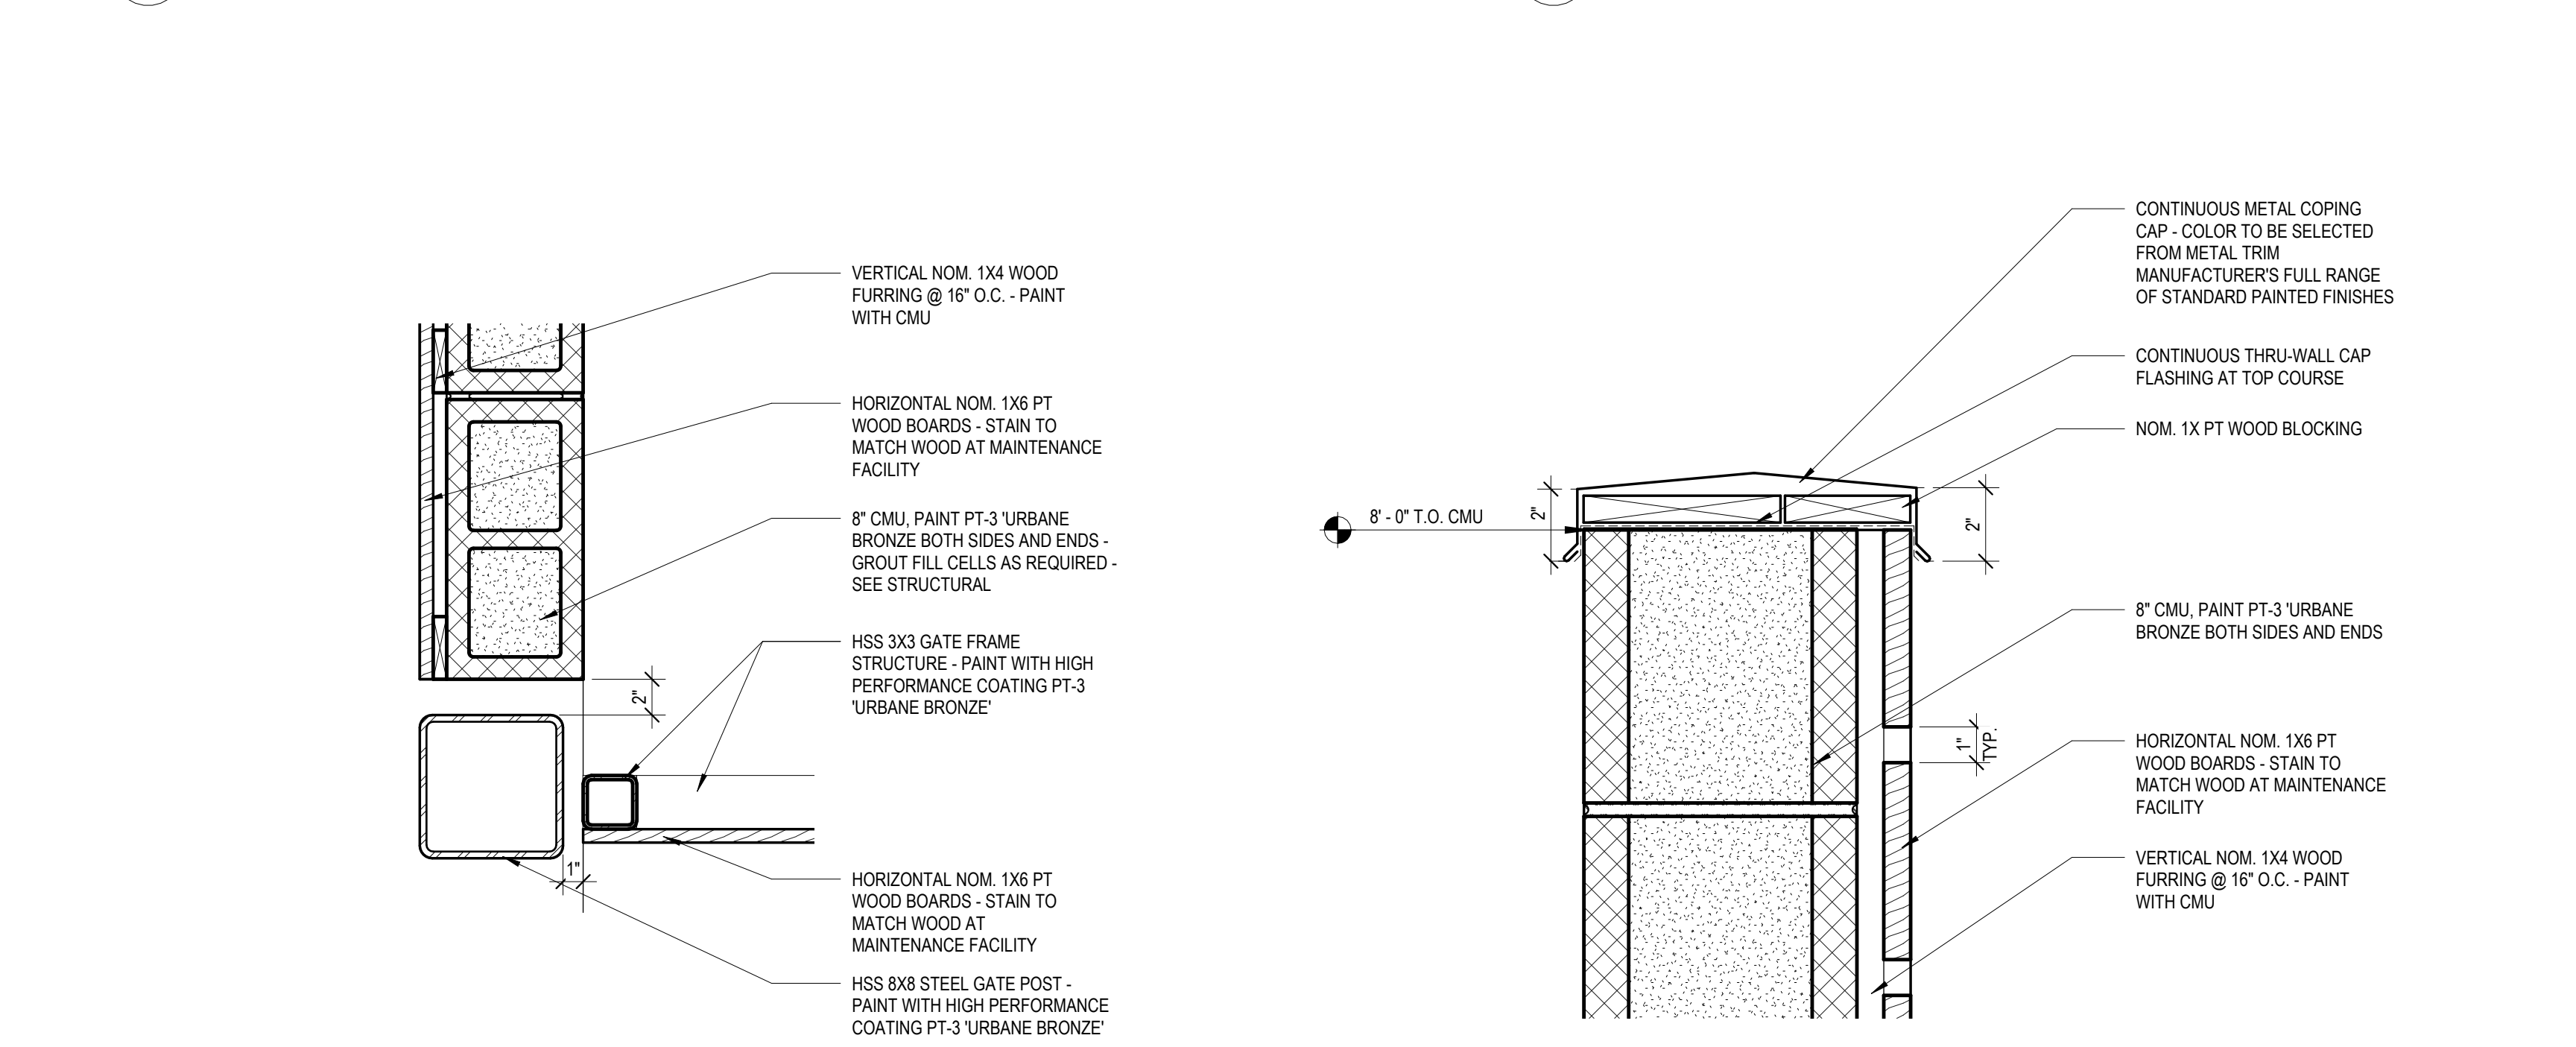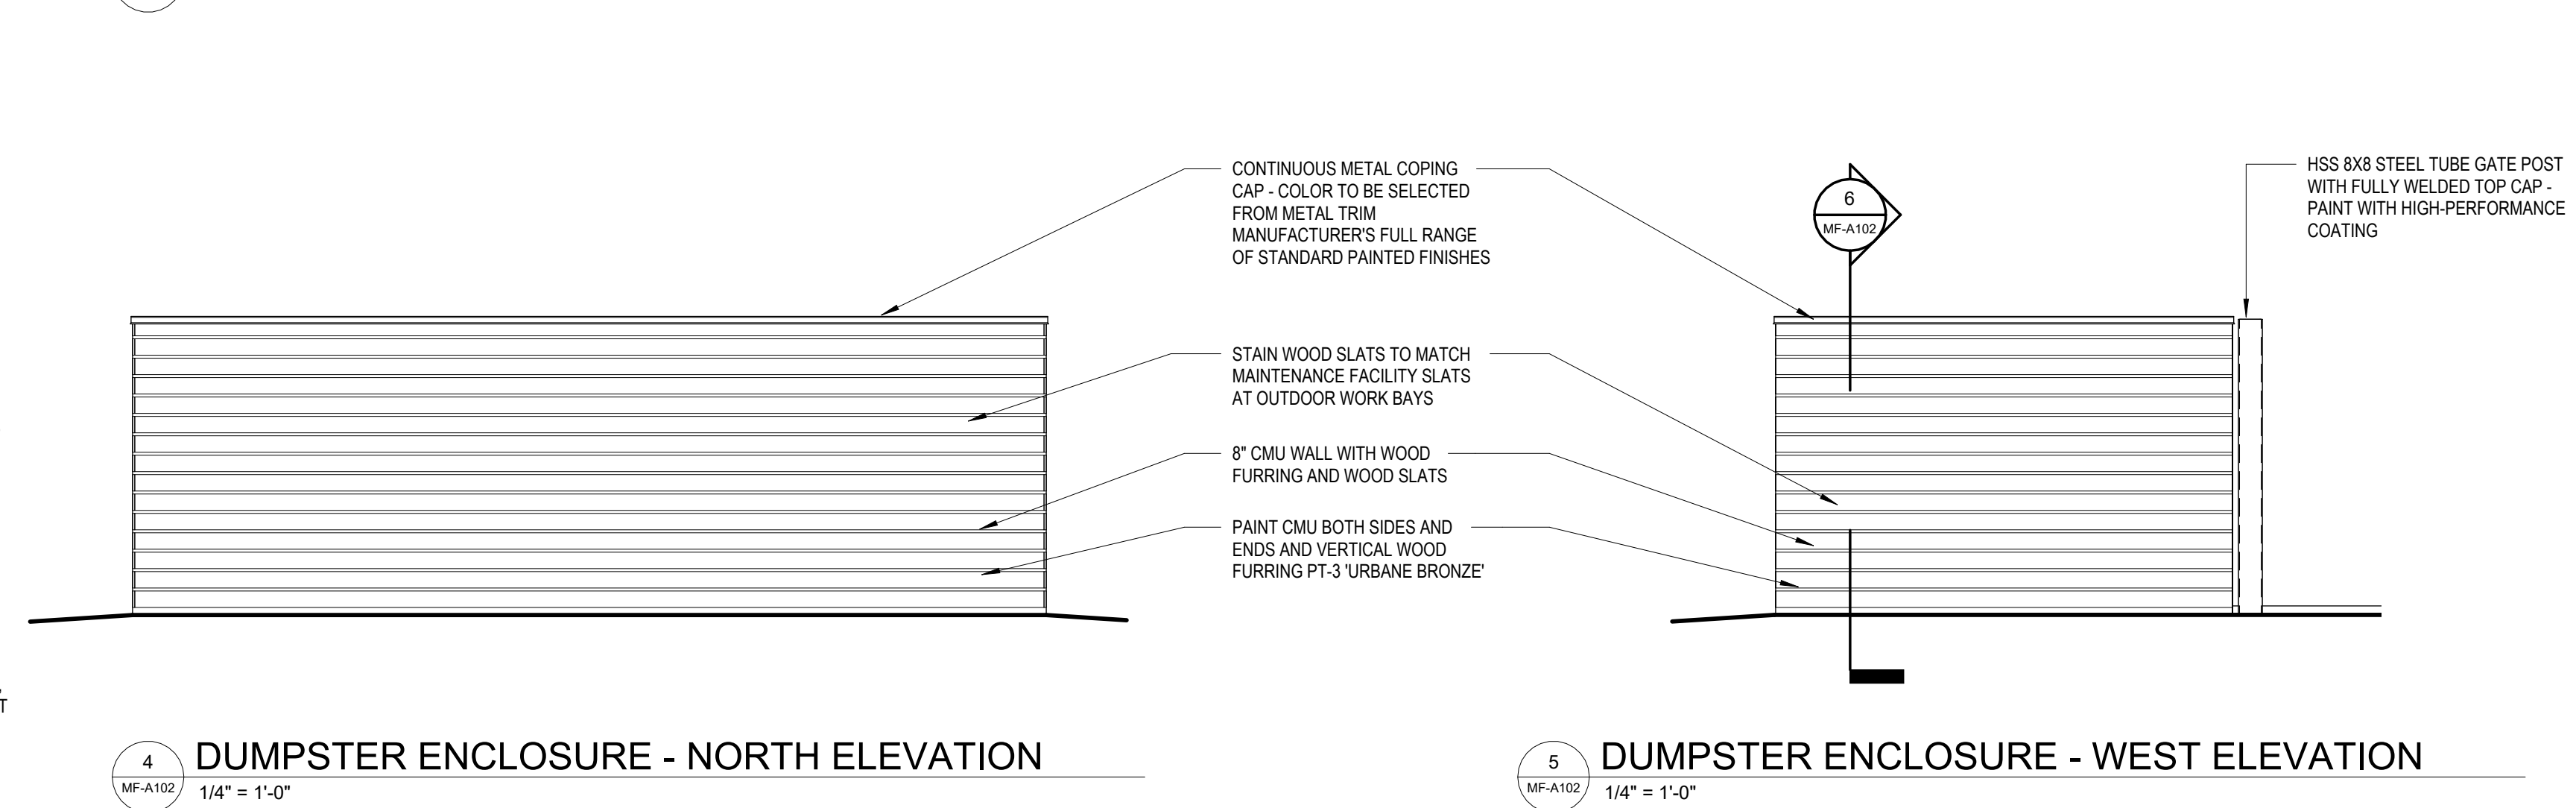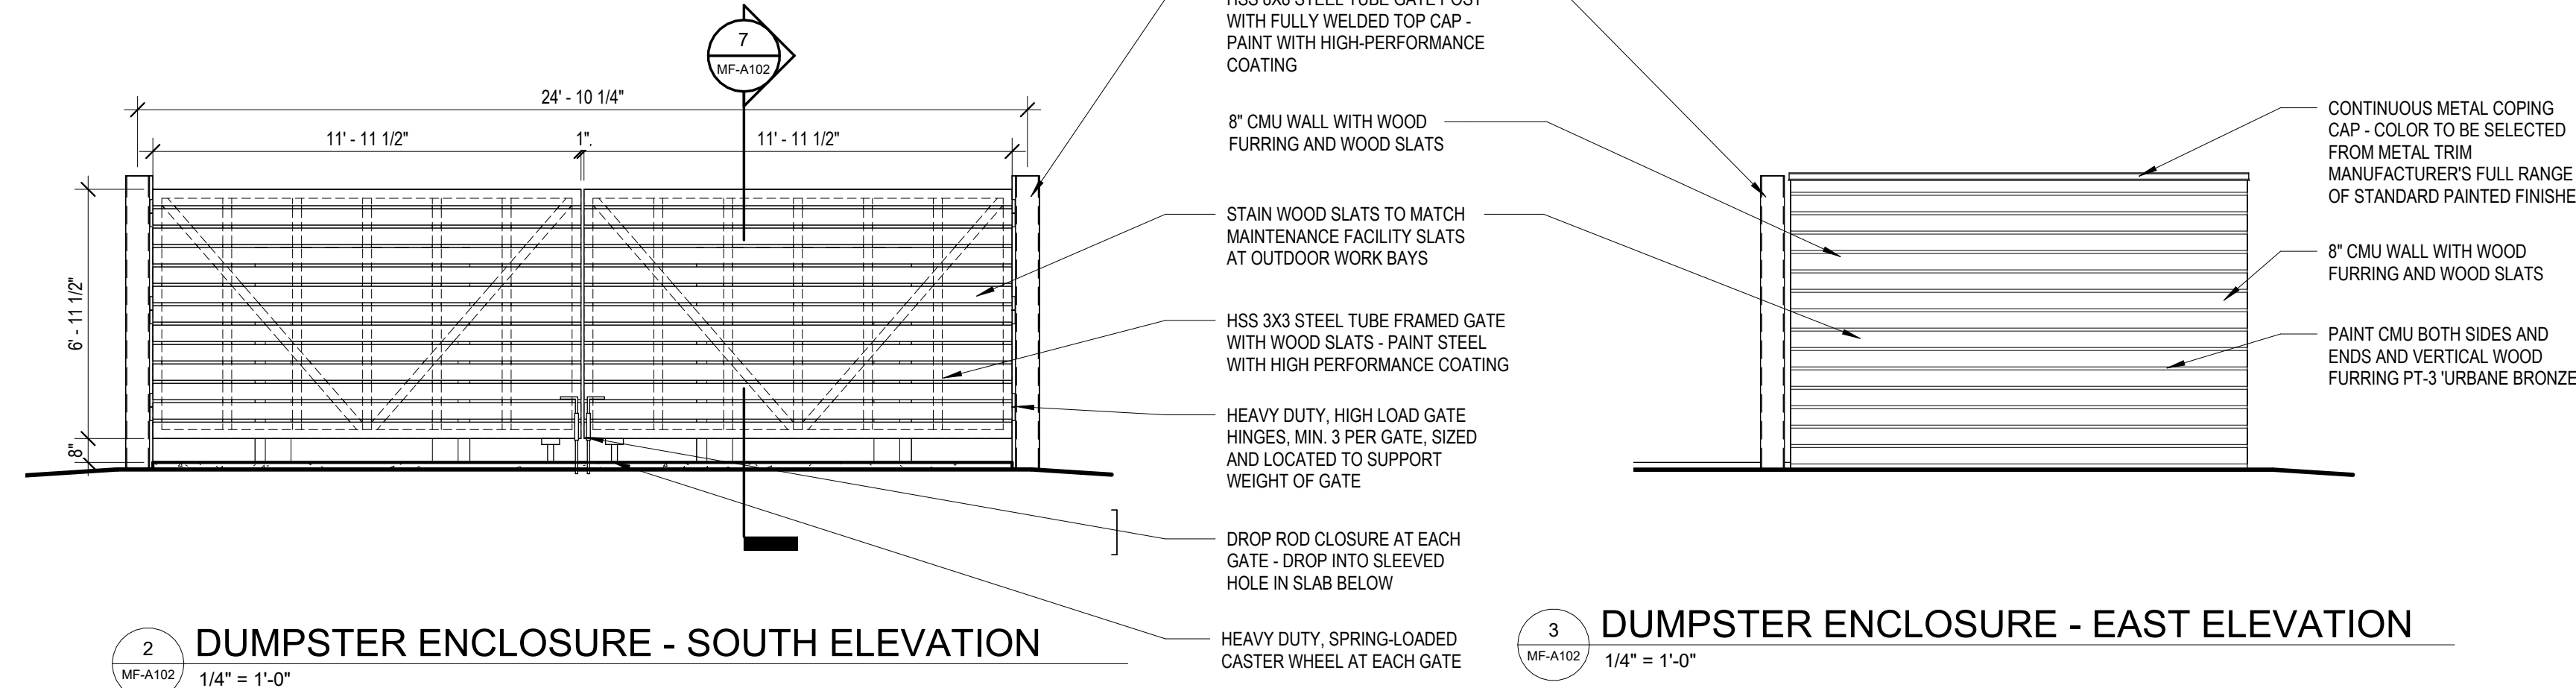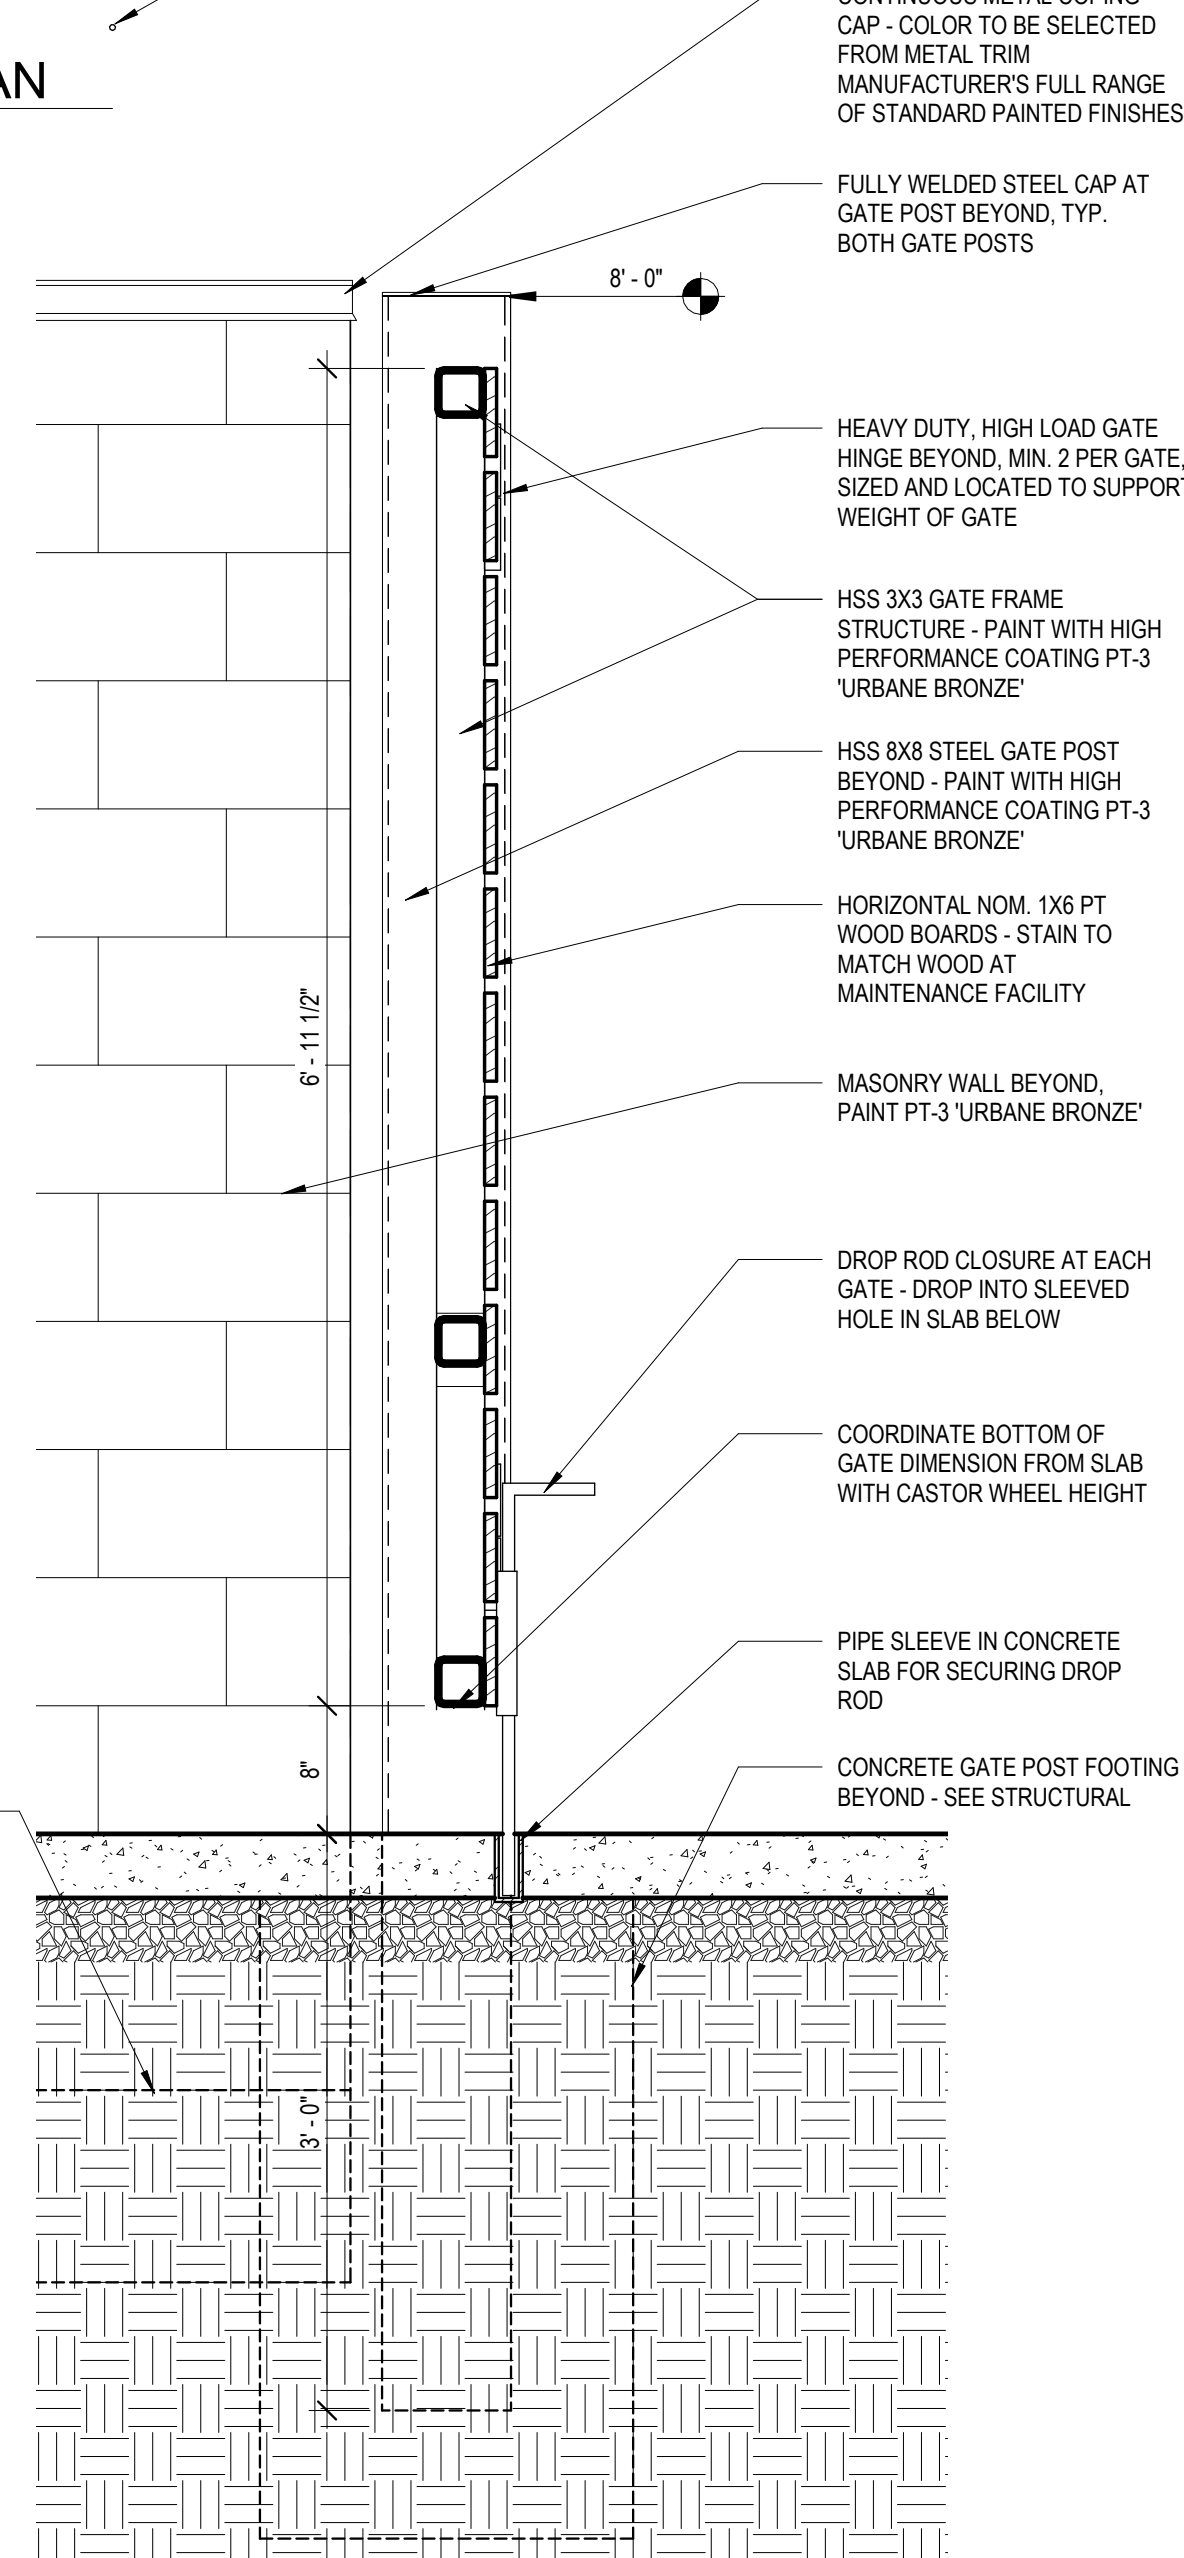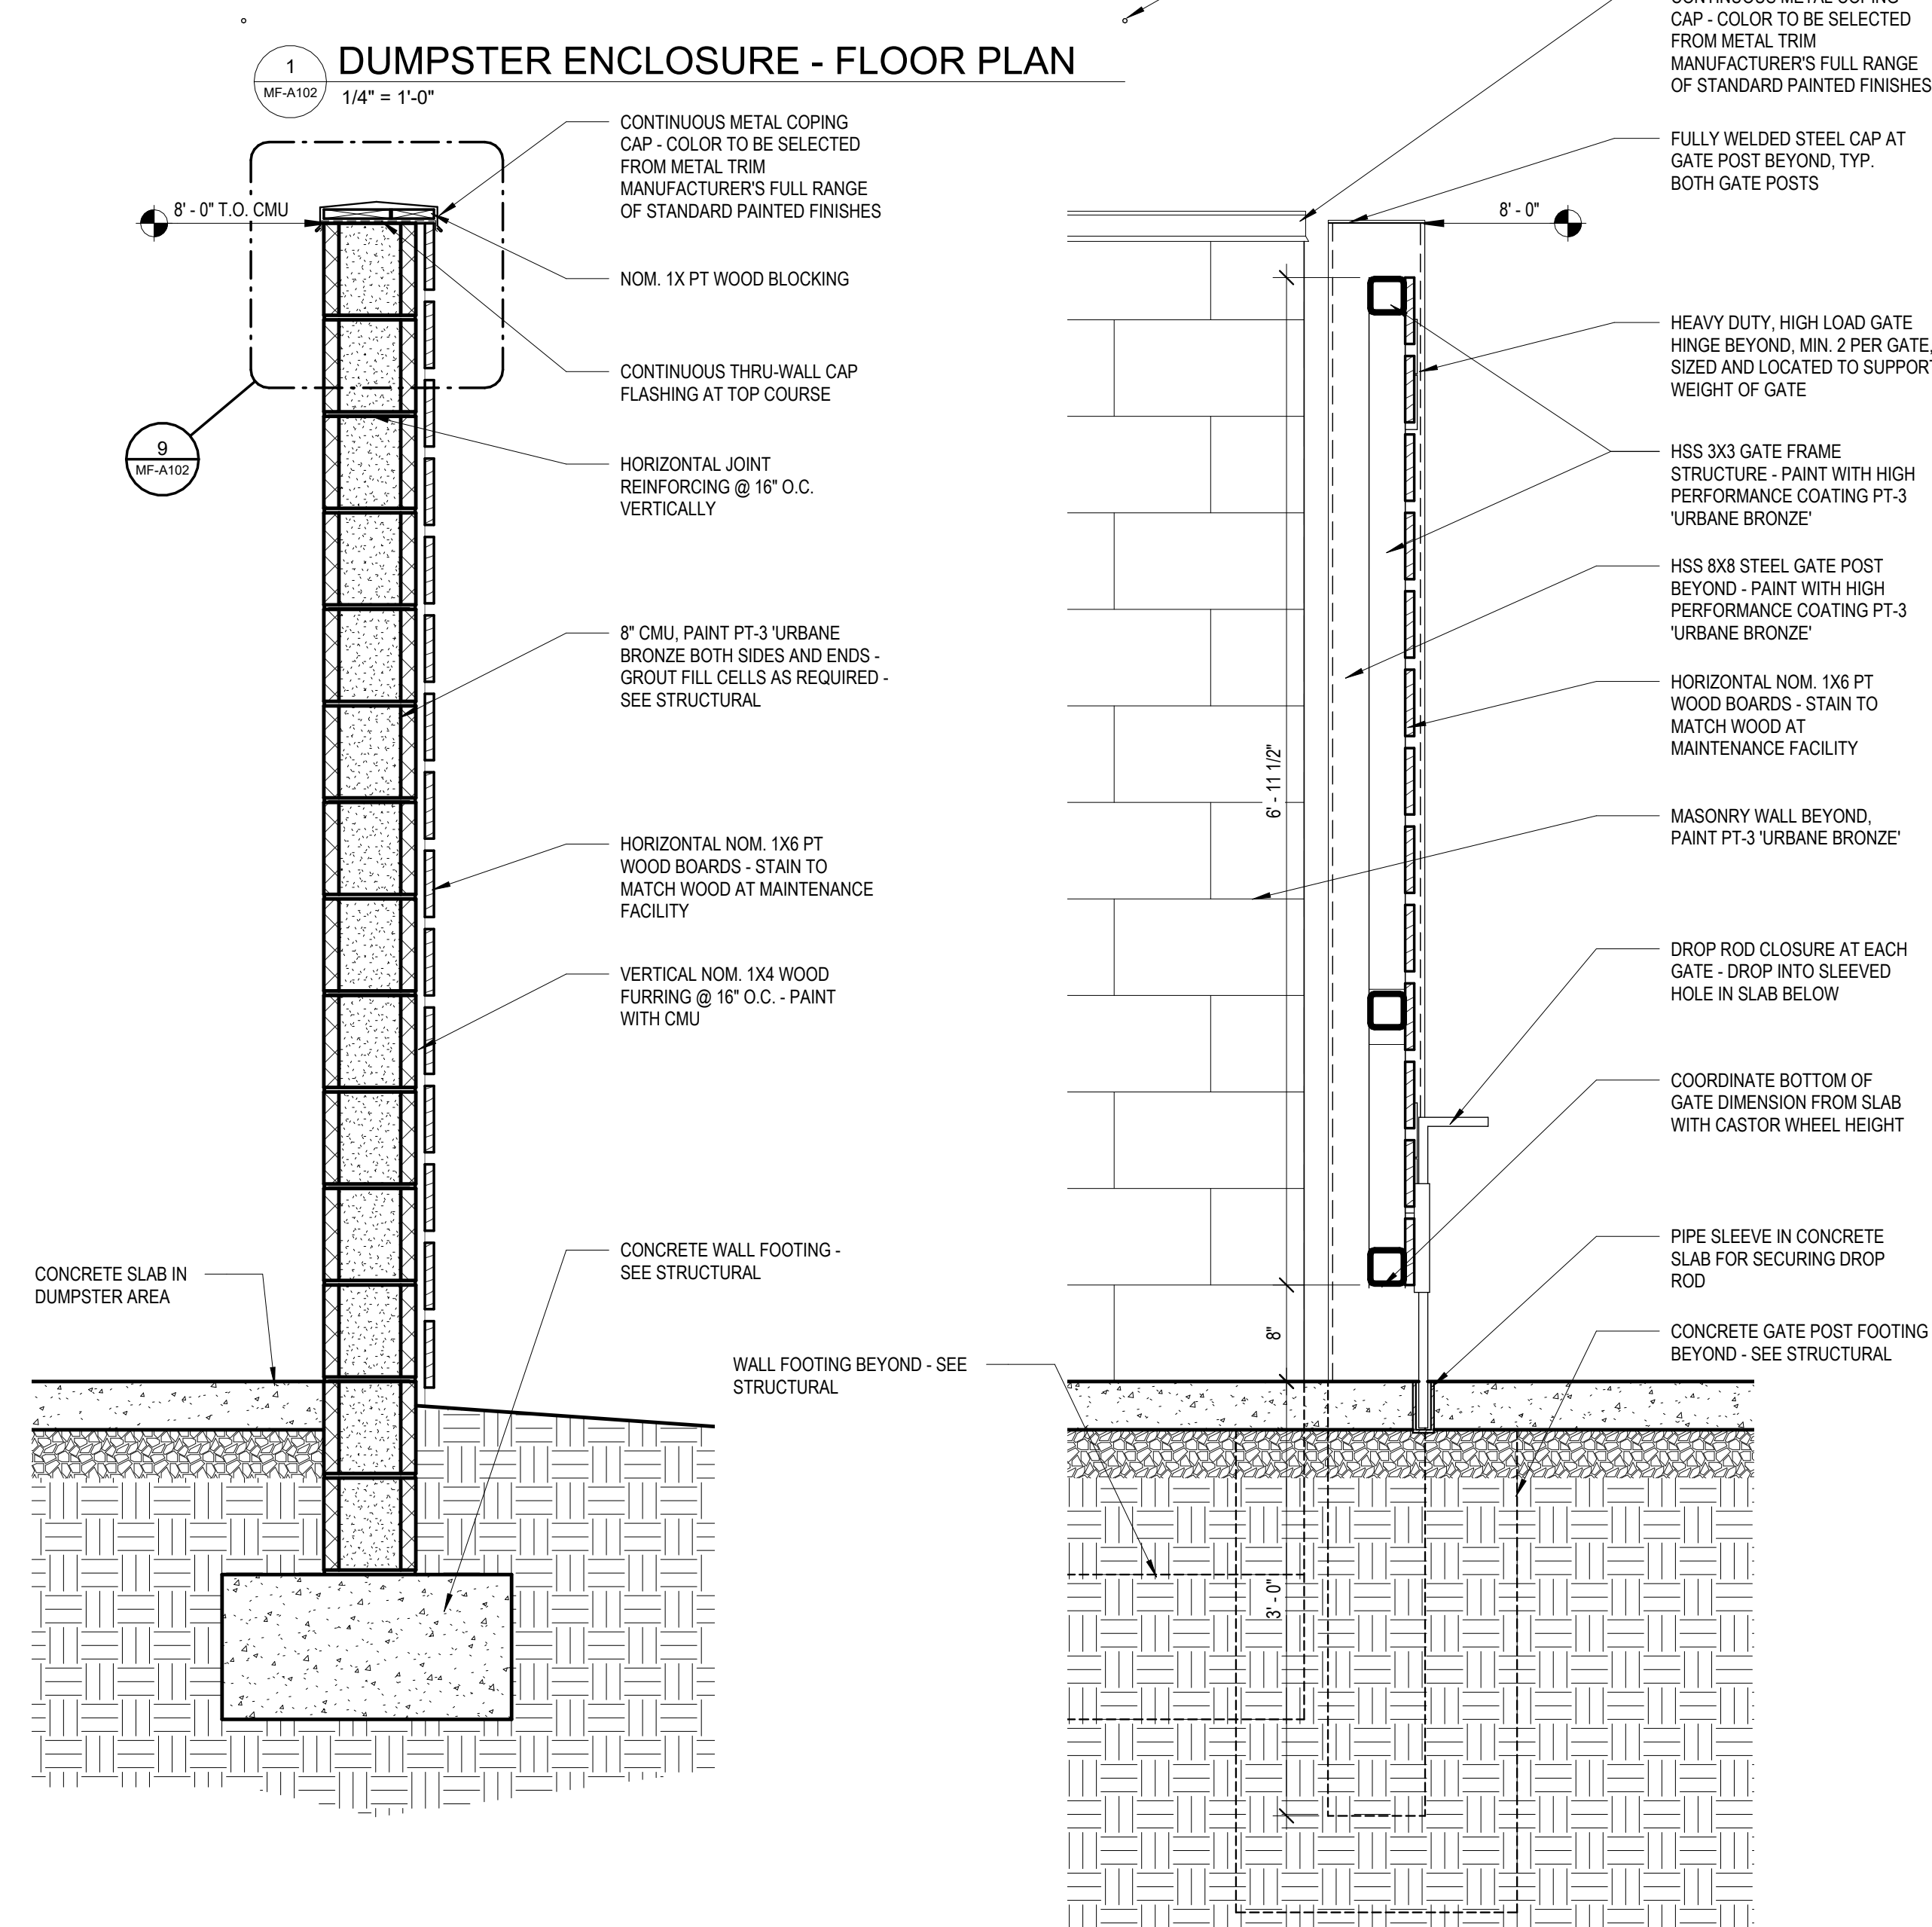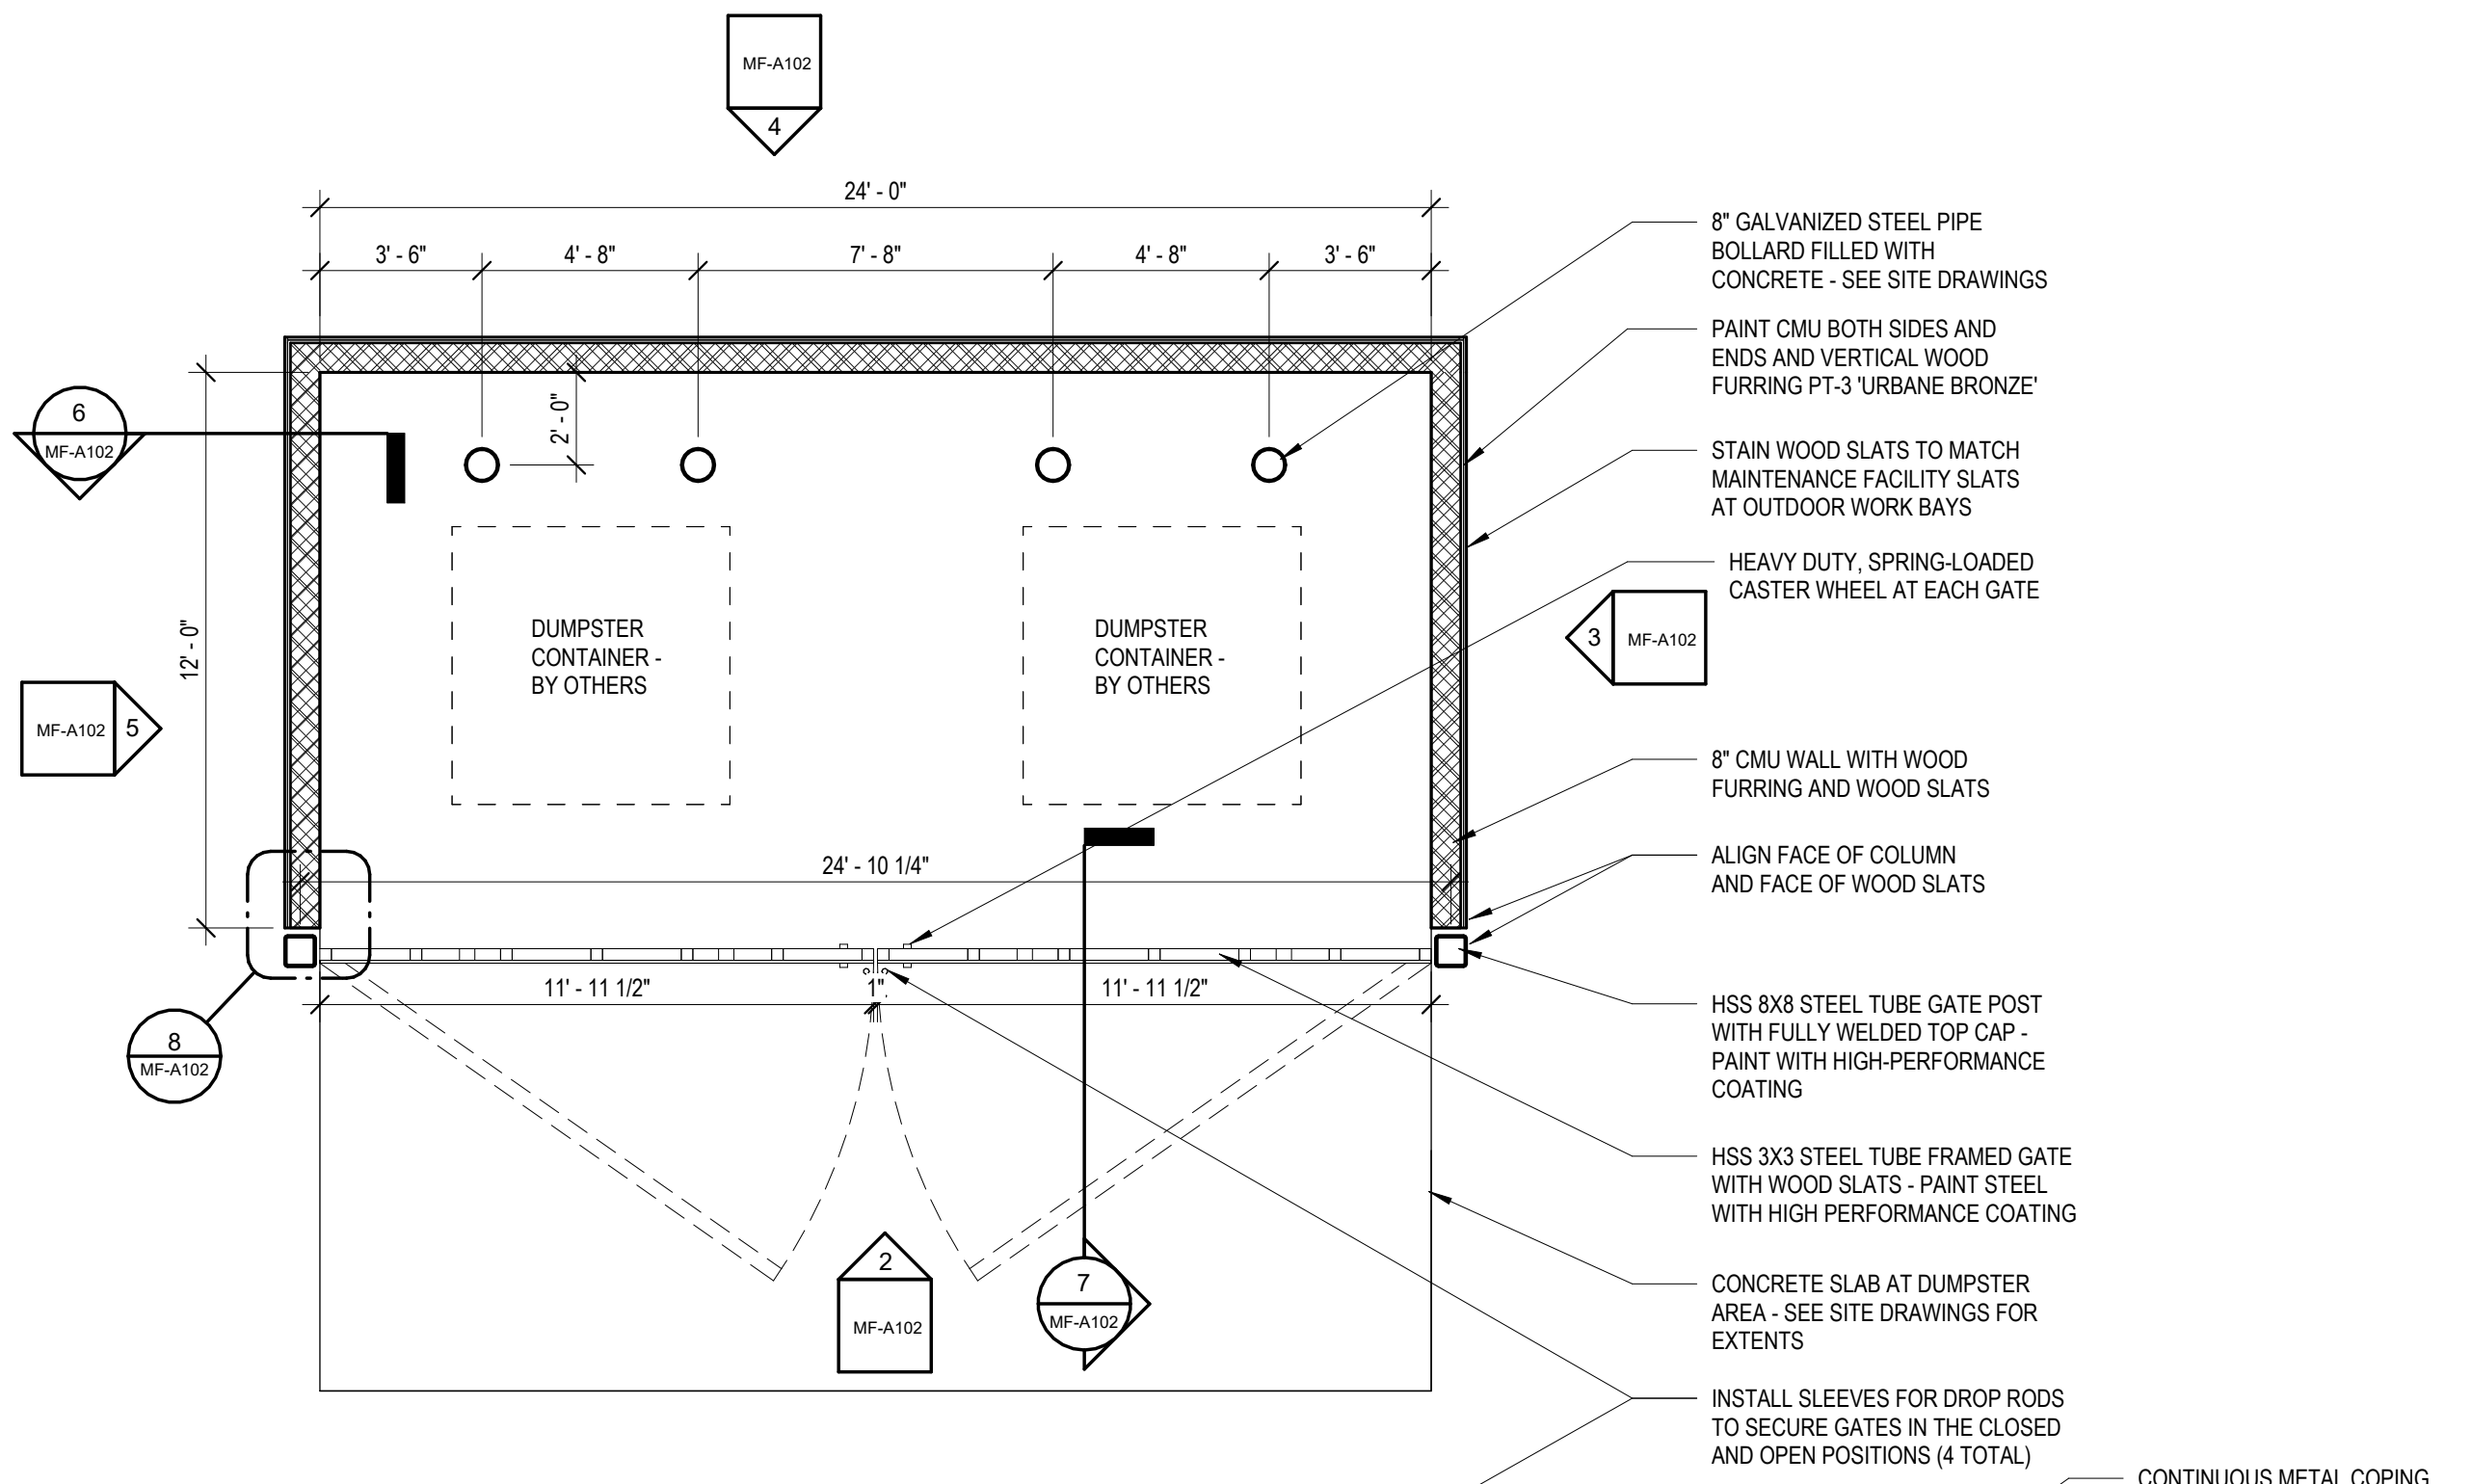

8 PLAN DETAIL @ DUMPSTER ENCLOSURE
1 1/2" = 1'-0"

9 DETAIL @ DUMPSTER ENCLOSURE COPING
3" = 1'-0"

6 WALL SECTION @ DUMPSTER ENCLOSURE
1" = 1'-0"

7 SECTION @ DUMPSTER GATE
1" = 1'-0"

Susan Hatchell
Landscape Architecture, PLLC
711 W. North Street, Raleigh, NC 27603
p: 919-838-9600 f: 919-838-9700




DUMPSTER ENCLOSURE PLANS AND DETAILS


LAKE MYRA COUNTY PARK
Wake County, NC

REVISIONS


Date: 07/27/26

MF-A102

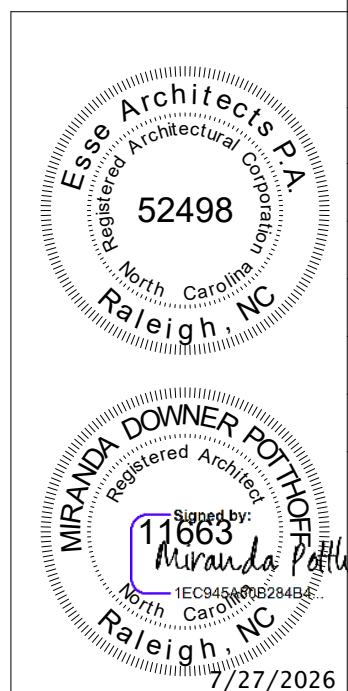


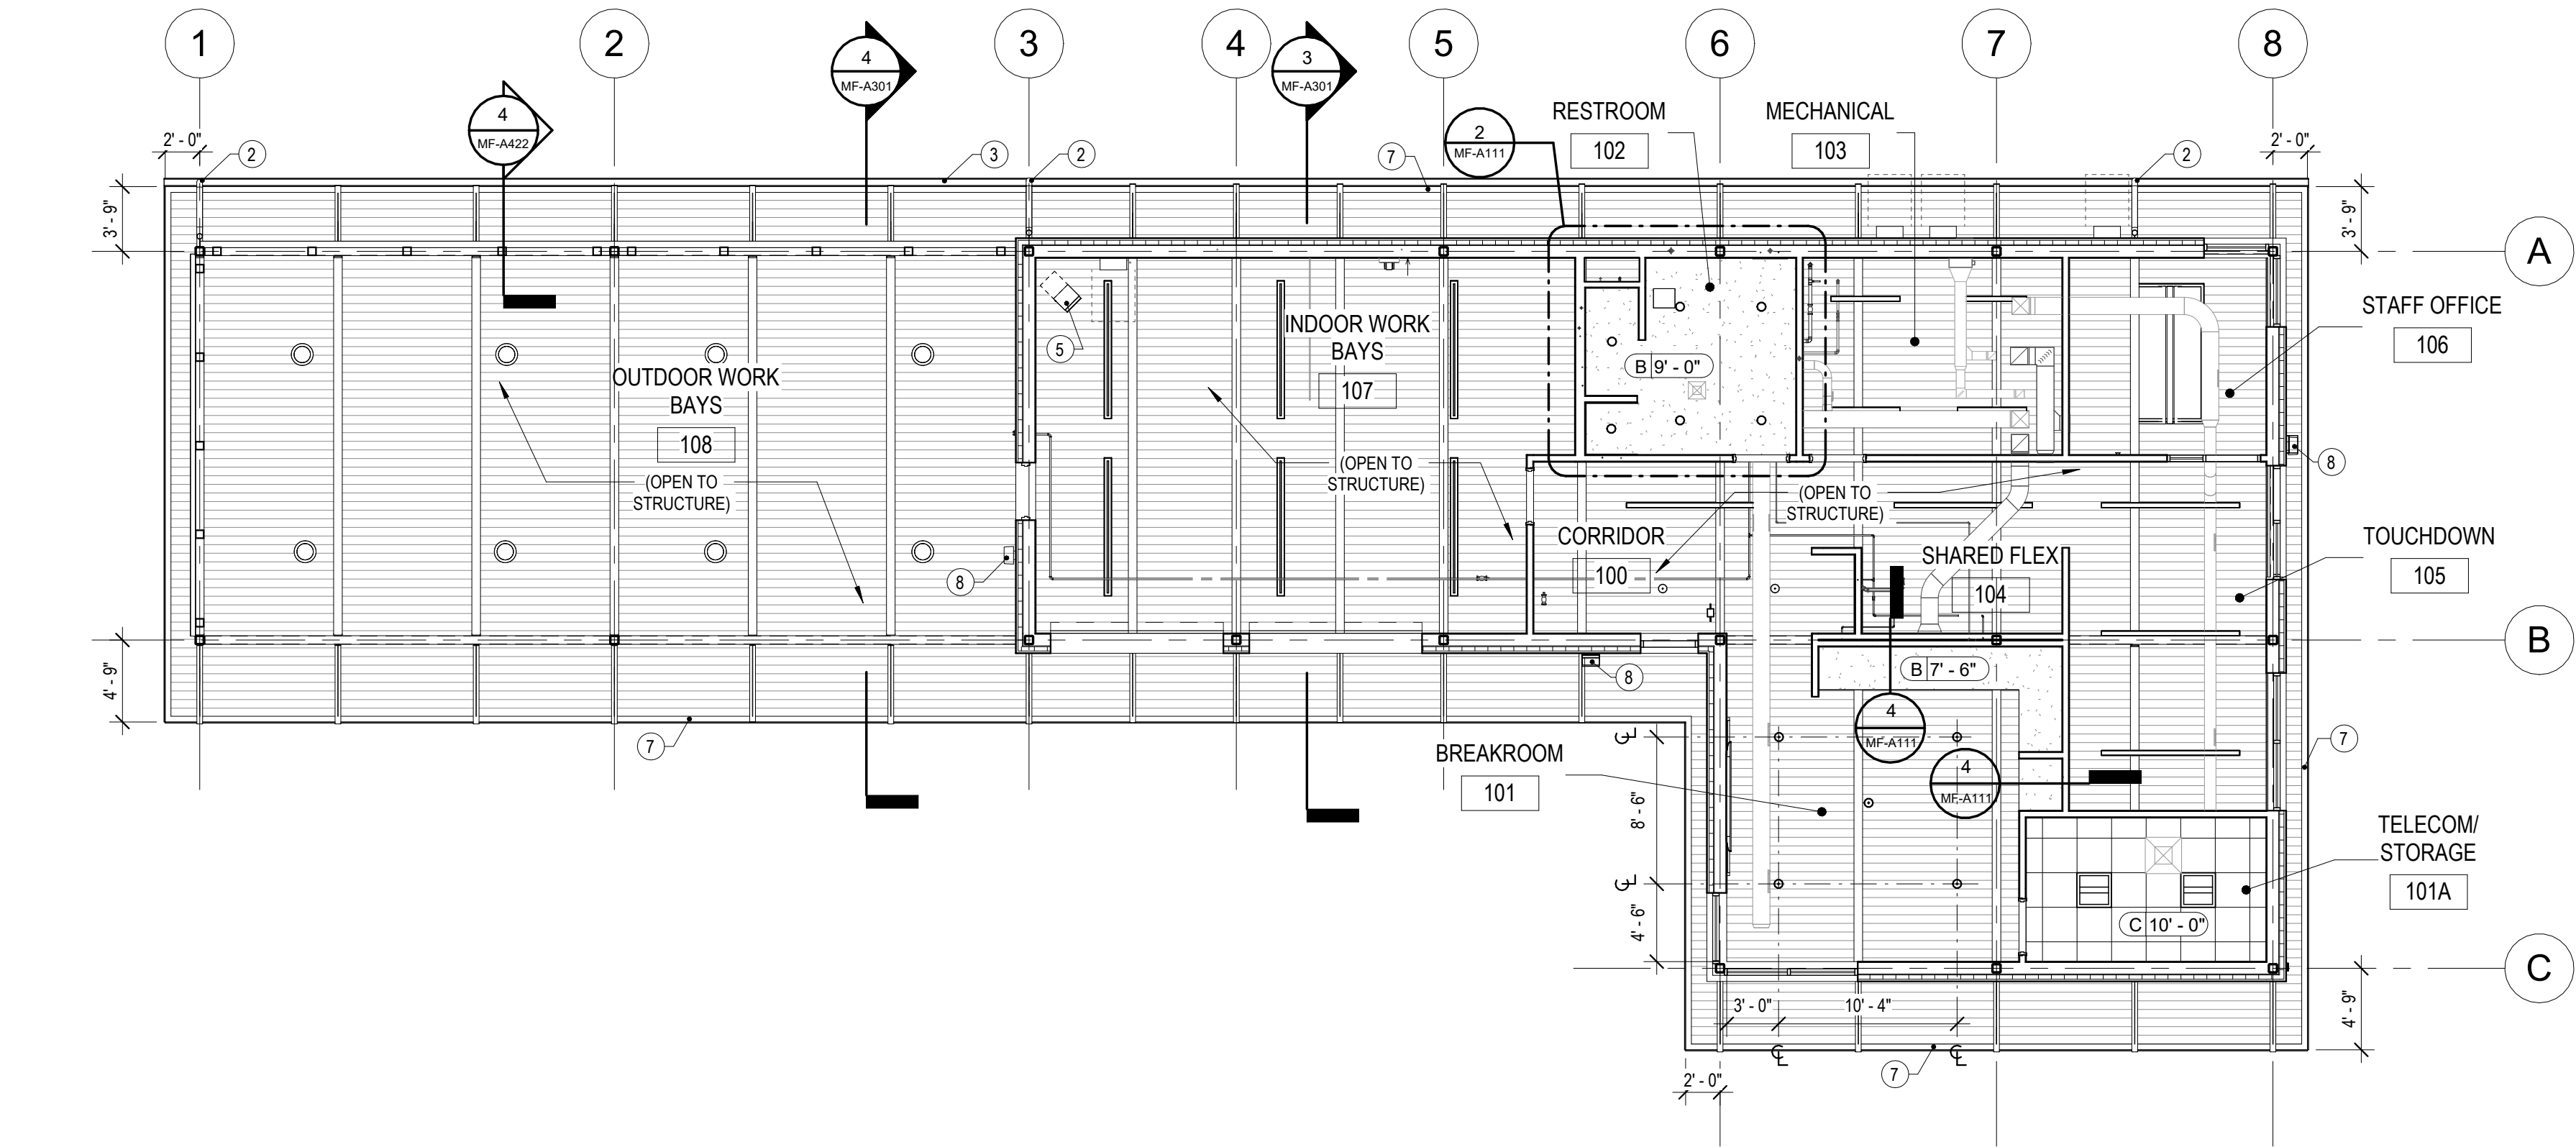


1 MAINTENANCE FACILITY - REFLECTED CEILING PLAN
MF-A111 1/8" = 1'-0"

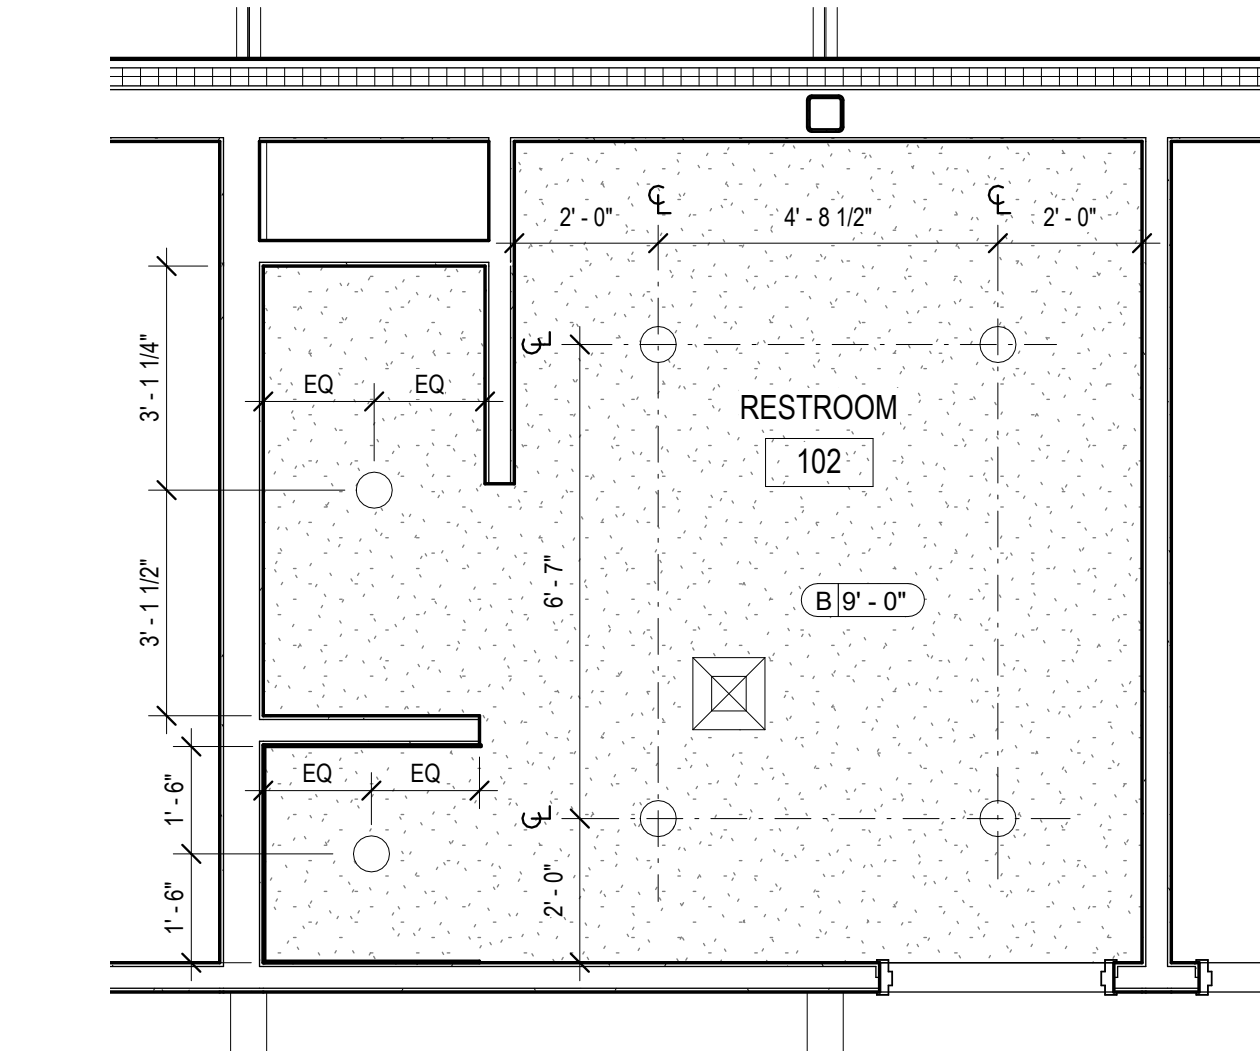

2 RESTROOM (102) - ENLARGED CEILING PLANS
MF-A111 3/8" = 1'-0"

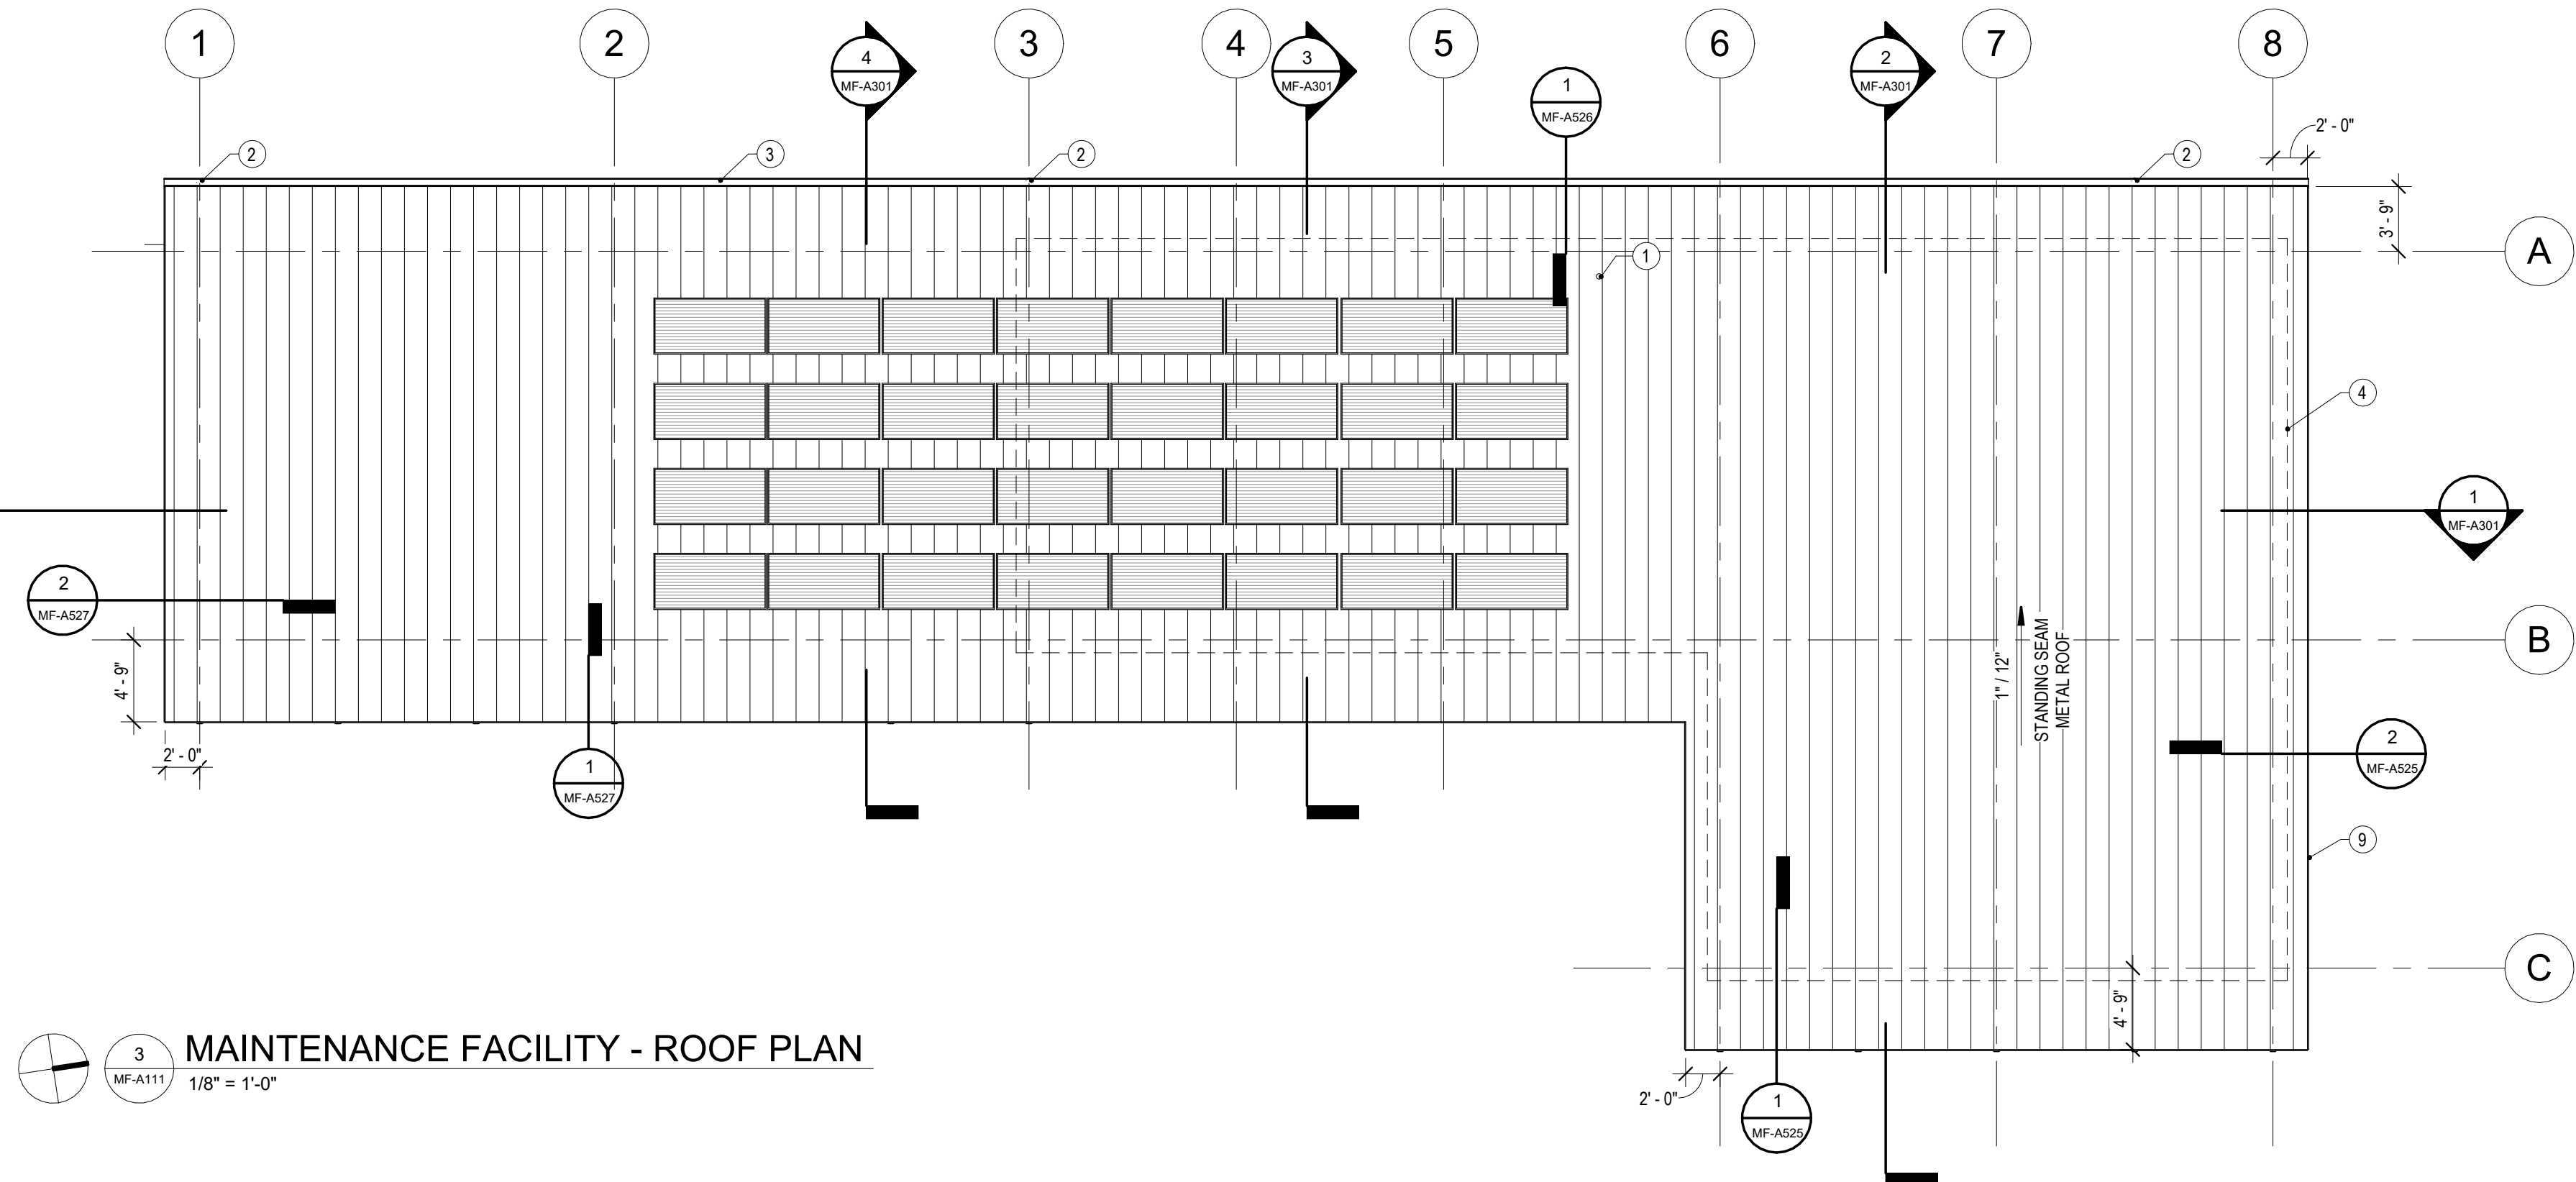

3 MAINTENANCE FACILITY - ROOF PLAN
MF-A111 1/8" = 1'-0"

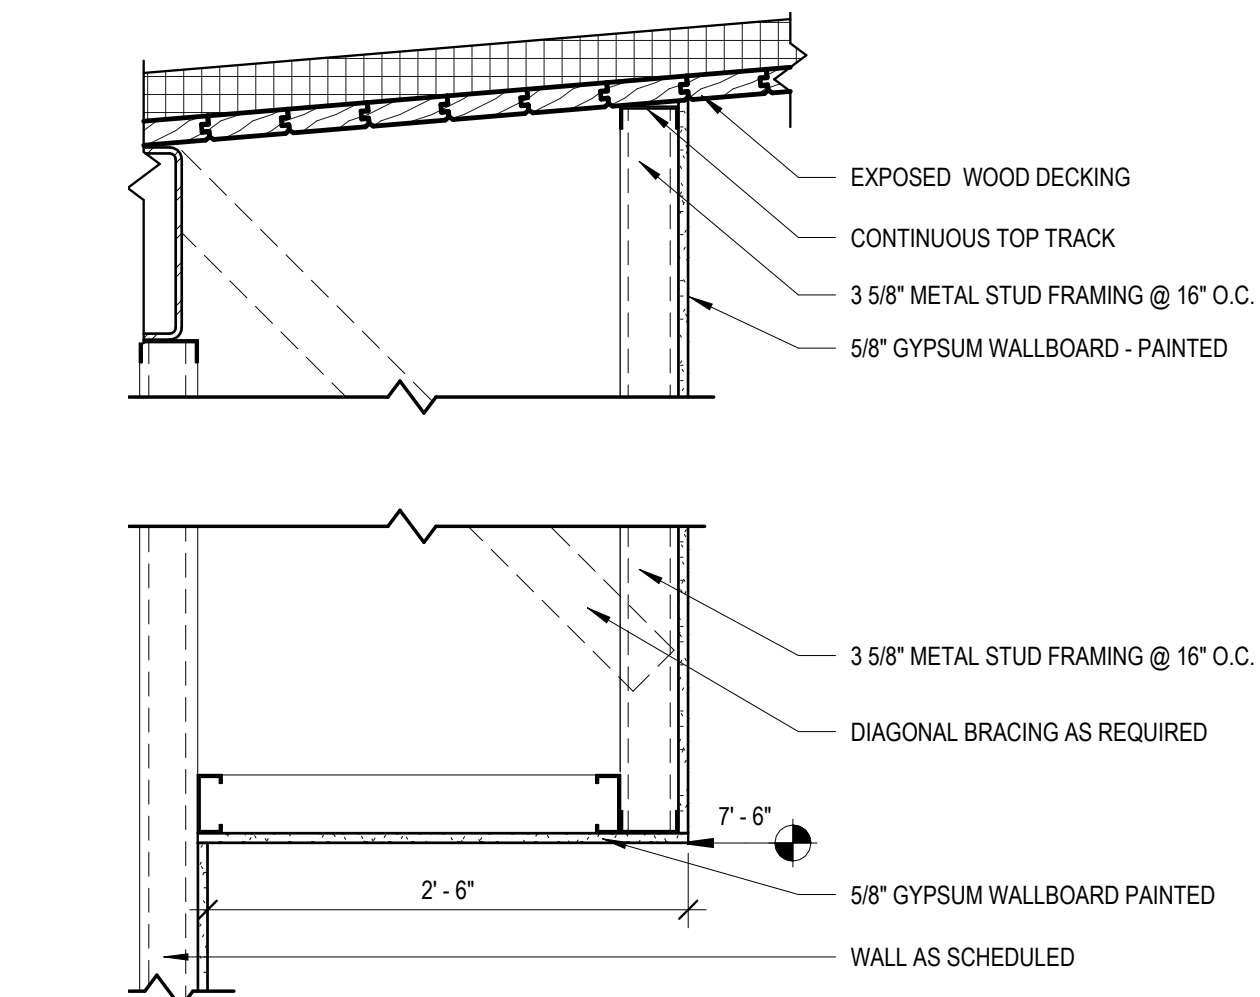


4 TYP. SOFFIT @ CASEWORK
MF-A111 1" = 1'-0"

CEILING LEGEND		
CEILING TYPE		CEILING HEIGHT
PATTERN	KEY	CEILING MATERIAL
	A	2X6 EXPOSED WOOD DECKING
	B	GYPSUM BOARD, PT-1
	C	2X2 ACOUSTIC CEILING TILES
SYMBOL	DESCRIPTION	
	ACOUSTICAL LINEAR DIRECT SUSPENDED FIXTURE	
	LINEAR RECESSED OR PENDANT LIGHT FIXTURE	
	PENDANT CAN LIGHT	
	PENDANT CAN LIGHT	
	ACOUSTICAL BAFFLE PENDANT LIGHT	
	EMERGENCY LIGHT	
	FIRE ALARM AUDIO VISUAL	
	FIRE ALARM VISUAL	
	EXIT SIGN	
	AIR SUPPLY	
	AIR RETURN	
CEILING NOTES:		
1. SEE ELECTRICAL AND MECHANICAL PLANS FOR MORE INFORMATION.		
2. WHERE CEILING KEYNOTE IS NOT NOTED, ROOM HAS EXPOSED STRUCTURE.		
3. CENTER CEILING GRID IN ROOM UNLESS SHOWN OTHERWISE. CENTER LIGHTS AS INDICATED. NOTIFY ARCHITECT OF ANY CONFLICTS OF LOCATIONS PRIOR TO INSTALLATION.		
4. ALL DIMENSIONS ARE TO CENTERLINE OF FIXTURE UNLESS OTHERWISE NOTED.		
5. SEE FINISH PLANS FOR PAINT COLORS OF CEILING SOFFITS.		
6. CONTRACTOR IS NOT TO INSTALL ANY ACCESS PANELS IN GWB CEILING WITHOUT PRIOR APPROVAL AND COORDINATION WITH ARCHITECT.		
7. ALL EXPOSED DUCTWORK TO BE PAINTED, PT-3, IN SEMI-GLOSS FINISH.		
8. ALL INTERIOR SUSPENDED LIGHTS TO BE MOUNTED AT 9'-0" AFF U.N.O.		
9. ALL EXTERIOR SUSPENDED LIGHTS TO BE MOUNTED W/ EQUAL CORD LENGTH - SEE ELECTRICAL DRAWINGS		

ROOF PLAN LEGEND	
	2" TALL STANDING SEAM METAL ROOF WITH 16" WIDE PANELS W/ PENCIL RIBS AND ICE AND WATER SHIELD UNDER FULL ROOF AREA
	SLOPE
	SOLAR PANELS - SEE ELECTRICAL DRAWINGS
ROOF PLAN NOTES	
1. STRUCTURAL WOOD ROOF DECK IS ALSO FINISHED CEILING - NO FASTENERS SHALL PENETRATE DECKING NO EXPOSED CONDUIT SHALL BE RUN ACROSS UNDERSIDE OF WOOD DECKING WITHOUT REVIEW AND COORDINATION WITH THE ARCHITECT. COORDINATE FOR LIGHTING, SECURITY, ETC.	

#	GENERAL CELING AND ROOF NOTES
KEY	DESCRIPTION
1	VENT THRU ROOF - SEE PLUMBING DRAWINGS
2	4" DIAMETER DOWNSPOUT
3	5X5" ALUMINUM GUTTER
4	WALL OUTLINE BELOW
5	UNIT HEATER - SEE MECHANICAL DRAWINGS
7	STEEL BENT PLATE AROUND PERIMETER OF ROOF - SEE STRUCTURAL - PAINT PER SPEC 09 9600
8	EXTERIOR WALL MOUNTED LIGHT - SEE ELECTRICAL DRAWINGS
9	CONTINUOUS METAL FASCIA - FULL PERIMETER

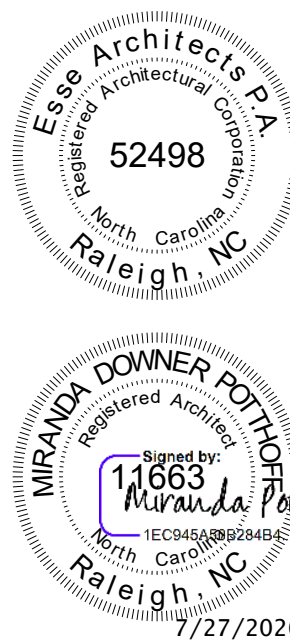

Susan Hatchell
Landscape Architecture, PLLC
711 W. North Street, Raleigh, NC 27603
p: 919-838-9600 f: 919-838-9700



REFLECTED CEILING
AND ROOF PLANS

LAKE MYRA COUNTY PARK
Wake County, NC

REVISIONS

Date: 07/27/26

MF-A111

FINISH LEGEND

BASIS OF DESIGN:		
FLOORING		
096813.04 WOC-1 WALK OFF CARPET	MANUFACTURER: COLLECTION: PATTERN: COLOR: SIZE: INSTALL METHOD:	MOHAWK TUFF STUFF II STEP UP II 983 IRON ORE 24" X 24" MONOLITHIC
093013.06 PORF-2 FLOOR TILE	MANUFACTURER: COLLECTION: COLOR: TYPE/SIZE: GROUT: INSTALL METHOD:	MILESTONE URBAN LIVING TITANIUM, RAW FINISH 24" x 24" MOSAIC @ SHOWER LATICRETE SPECTRALOCK: TBD MONOLITHIC
033901.01 SC-1 SEALED CONCRETE	MANUFACTURER:	SEE SPECIFICATION
BASE		
096513.01 RB-1 RUBBER BASE	MANUFACTURER: COLOR: PROFILE/HEIGHT:	ROPPE 175 SLATE 6"; TOELESS @ CPT , STANDARD TOE @ PC
093013.07 TB-2 TILE BASE	MANUFACTURER: COLLECTION: COLOR: TYPE/SIZE: GROUT: INSTALL METHOD:	MILESTONE URBAN LIVING TITANIUM, RAW FINISH 24" x 24"; FIELD CUT TO 6" H LATICRETE SPECTRALOCK: TBD MONOLITHIC
WALLS		
093013.05 WT-3 WALL TILE	MANUFACTURER: COLLECTION: COLOR: TYPE/SIZE: GROUT: INSTALL METHOD:	BEST TILE MAREA ARCTIC; MATTE 4" X 12" LATICRETE SPECTRALOCK: TBD VARIES; SEE ELEVATIONS
093013.06 WT-4 WALL TILE	MANUFACTURER: COLLECTION: COLOR: TYPE/SIZE: GROUT: INSTALL METHOD:	BEST TILE MAREA LEAF; MATTE 4" X 12" LATICRETE SPECTRALOCK: TBD VARIES; SEE ELEVATIONS
098433.01 AWP-1 ACOUSTICAL WALL PANEL	MANUFACTURER: COLLECTION: PATTERN: COLOR: TYPE/SIZE: INSTALL METHOD:	TURF WALLSCAPE TUBULAR 50 IVORY 12" X 12" TILE MOUNT WITH LIQUID NAILS LN-903
098433.02 AWP-2 ACOUSTICAL WALL PANEL	MANUFACTURER: COLLECTION: PATTERN: COLOR: TYPE/SIZE: INSTALL METHOD:	ARMSTRONG FELTWORKS N/A WHITE (FWH) 24" X 48"; SEE ELEVATION MOUNT WITH Z-CLIPS
097201.01 AF-1 ACOUSTICAL FELT	MANUFACTURER: COLLECTION: PATTERN: COLOR: TYPE/SIZE: INSTALL METHOD:	MOMENTUM NUFELT NON-REVERSE HANG, RANDOM MATCH LEGEND 63" W, ROLLED ADHESIVE PER MANUFACTURER GUIDELINES
CEILING		
095113.01 ACT-1 ACOUSTICAL CEILING TILE	MANUFACTURER: STYLE: COLOR: SIZE: GRID:	ARMSTRONG ULTIMA WHITE (WH) 24" X 24" BEVELED TEGULAR 15/16

EQUAL 1:	
SHAW CONTRACT STEPPIN OUT WELCOM E II TILE BLAK CHOCOLATE 24" X 24" QUARTER TURN	
MOSAIC ARGENT 2.0 CLEAN SLATE 12" x 12"; 2" X 2" MOSAIC @ SHOWER LATICRETE SPECTRALOCK: TBD MONOLITHIC	
SPECIALTY TILE PRODUCTS RECONCRETE STORM 24" x 24"; 2" X 2" MOSAIC @ SHOWER LATICRETE SPECTRALOCK: TBD MONOLITHIC	
JOHNSONITE COLONIAL GREY 6"; TOELESS @ CPT , STANDARD TOE @ PC	
MOSAIC ARGENT 2.0 CLEAN SLATE 12" x 24"; FIELD CUT TO 6" H LATICRETE SPECTRALOCK: TBD MONOLITHIC	
SPECIALTY TILE PRODUCTS EARTH BONE 2" X 8" LATICRETE SPECTRALOCK: TBD VARIES; SEE ELEVATIONS	
MOSAIC KREA 2.0 LEAF; MATTE 4" X 12" LATICRETE SPECTRALOCK: TBD VARIES; SEE ELEVATIONS	
ACOUFELT PREMIER FILTER ALMOND 12" X 12" TILE MOUNT WITH LIQUID NAILS LN-903	
ACOUFELT SOLID N/A ALMOND 24" X 48"; SEE ELEVATION MOUNT WITH Z-CLIPS	
ACOUFELT WALLCOVERING STRAIGHT HANG, STRAIGHT MATCH RAVEN 54" W, ROLLED ADHESIVE PER MANUFACTURER GUIDELINES	
USG MARS FLAT WHITE 24" X 24" FINELINE BEVEL 15/16	

BASIS OF DESIGN:		
MILLWORK		
064116.01 PL-1 PLASTIC LAMINATE	MANUFACTURER: COLOR: FINISH:	WILSONART LANDMARK WOOD SOFTGRAIN
064116.02 PL-2 PLASTIC LAMINATE	MANUFACTURER: COLOR: FINISH:	WILSONART SILK MIST MATTE FINISH
123663.01 SS-1 SOLID SURFACE	MANUFACTURER: COLOR: THICKNESS: EDGE:	WILSONART YUKON RIVERSTONE 1/2" SQUARE WITH EASED CORNERS
064193 CABINET PULL	MANUFACTURER: PRODUCT: FINISH:	RICHELIEU BP2102128170 STAINLESS STEEL
PAINTS		
099123.01 PT-1 FIELD	MANUFACTURER: COLOR: SHEEN:	SHERWIN WILLIAMS SW 6203 SPARE WHITE EGGSHELL
099123.03 PT-3 FIELD	MANUFACTURER: COLOR: SHEEN:	SHERWIN WILLIAMS SW 7048 URBANE BRONZE EGGSHELL
099123.04 PT-4 HM DOORS & TRIM	MANUFACTURER: COLOR: SHEEN:	SHERWIN WILLIAMS SW 9167 POLISHED CONCRETE SEMI-GLOSS
099123.05 PT-5 HM DOORS & TRIM	MANUFACTURER: COLOR: SHEEN:	SHERWIN WILLIAMS SW 6438 DILL SEMI-GLOSS
099323.01 ST-1 WOOD STAIN	MANUFACTURER: COLOR: SHEEN:	SHERWIN WILLIAMS MATCH PL-1 SATIN
MISC.		
122413.01 RWS-1 ROLLER WINDOW SHADES	MANUFACTURER: COLLECTION: FASCIA COLOR: FABRIC COLOR: SIZE:	MECHOSHADE MANUAL URBANSHADE ROLLER SHADES WHITE ECOSHEER 3% - METAL VARIES; FIELD VERIFY

EQUAL 1:	
FORMICA AGED ASH WOODBUSH	
FORMICA OASTER GRAY MATTE	
HILMACS ANDROMEDA 1/2" SQUARE WITH EASED CORNERS	
HAFELE MATCH BOD STAINLESS STEEL	
BENJAMIN MOORE MATCH BOD EGGSHELL	
BENJAMIN MOORE MATCH BOD EGGSHELL	
BENJAMIN MOORE MATCH BOD SEMI-GLOSS	
BENJAMIN MOORE MATCH BOD SEMI-GLOSS	
BENJAMIN MOORE MATCH BOD SATIN	
HUNTER DOUGLAS ARCHITECTURAL RB 500+ MANUAL ROLLER SHADES WHITE SHEERWEAVE INFINITY2 3% - SLATE VARIES; FIELD VERIFY	
EQUAL 2:	
ARBORITE NATURAL CROSSFIRE PEAR EVERGRAIN EV	
NEVAMAR PORCELAIN TEXTURED/SUEDE	
MEGANITE BLANCA GRANITE 1/2" SQUARE WITH EASED CORNERS	
AMEROCK MATCH BOD STAINLESS STEEL	
PPG MATCH BOD EGGSHELL	
PPG MATCH BOD EGGSHELL	
PPG MATCH BOD SEMI-GLOSS	
PPG MATCH BOD SEMI-GLOSS	
PPG MATCH BOD SATIN	
ROLL A SHADE INFINITY SHADE - MANUAL WHITE PHIFER 3% - OYSTER/PEWTER VARIES; FIELD VERIFY	

Susan Hatchell
Landscape Architecture, PLLC
711 W. North Street, Raleigh, NC 27603
p: 919-838-9600 f: 919-838-9700




FINISH LEGEND


LAKE MYRA COUNTY PARK
Wake County, NC

REVISIONS

Date: 07/27/26

MF-A130

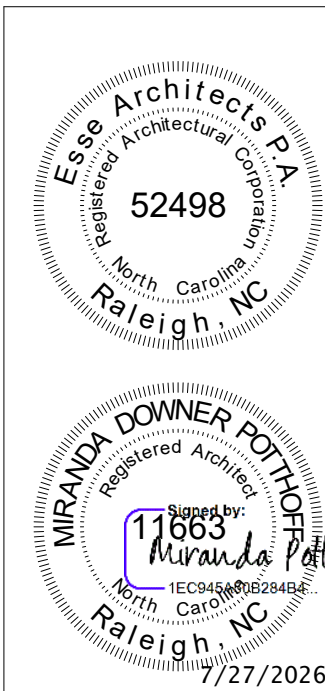

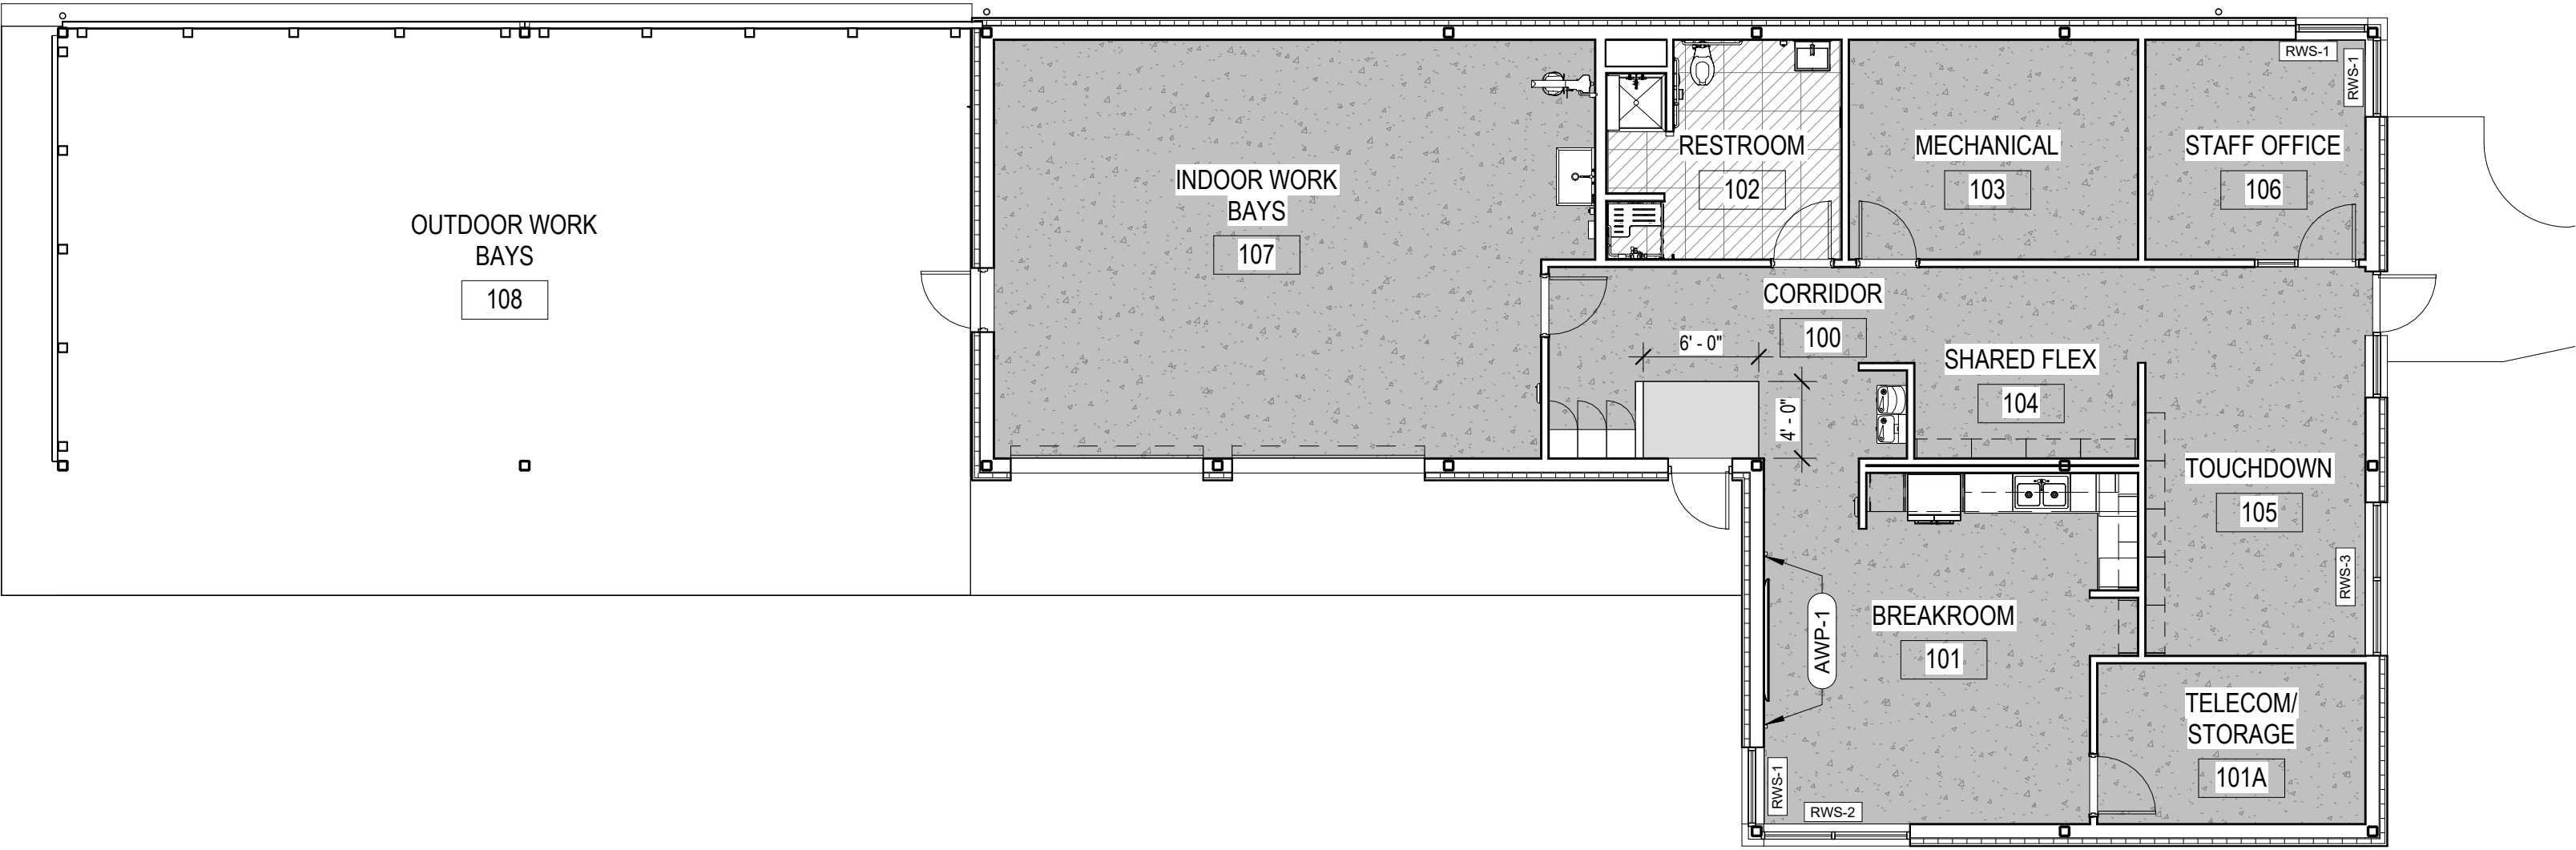

SYMBOL LEGEND

X-X

FINISH TAG

TXT

ROLLER SHADE TAG

GENERAL FINISH NOTES

1. ALL DIMENSIONS TO BE FIELD VERIFIED PRIOR TO ORDERING. DO NOT SCALE FROM DRAWINGS.

2. ALL MATERIALS SHALL BE INSTALLED PER MANUFACTURER'S RECOMMENDATIONS WITH APPROVED ADHESIVES OR OTHER FASTENERS.

3. IF THERE ARE QUESTIONS ABOUT THE DESIGN INTENT OF ANY PATTERN OR MATERIAL TO BE INSTALLED, THE G.C. SHALL SUBMIT A REQUEST FOR INFORMATION TO THE DESIGNER FOR CLARIFICATION PRIOR TO ORDERING THE MATERIALS.

4. THE G.C. SHALL PROVIDE ALL FINISHING PIECES AND TRANSITIONS WHERE DIFFERENT FLOORING THICKNESSES MEET. U.N.O. THE G.C. SHALL SUBMIT A SAMPLE OF THE COLOR/FINISH TO THE DESIGNER FOR APPROVAL.

5. ALL WALLS TO BE FIELD PAINT. PT-1, U.N.O. ALL GYP. BD. PARTITIONS TO RECEIVE A LEVEL 4 FINISH.

6. ALL INTERIOR HM DOOR FRAMES TO RECEIVE PAINT IN SEMI-GLOSS FINISH. PT-4, U.N.O.

7. ALL INTERIOR GYP. BD. PARTITIONS TO RECEIVE RUBBER BASE. RB-1, U.N.O.

8. EXPOSED ADA THERMAL INSULATED KITS AT SINKS TO BE PAINTED TO MATCH ADJACENT WALL.

9. IN INTERIOR CONDITIONS, FLOORING TO TRANSITION UNDER CLOSED DOOR. FLOORING TO TRANSITION IN CENTER OF CASED OPENING WHEN NO DOOR IS SCHEDULED.

10. ALL COVER PLATES (DATA, LIGHTS, TELEPHONE, ETC.) AND ALL DEVICES TO COORDINATE WITH WAKE COUNTY STANDARDS.

1

MF-A131

1/8" = 1'-0"


MAINTENANCE FACILITY - FINISH PLAN

NOTE: WALL FINISH LOCATIONS NOTED IN THE SCHEDULE ARE ORIENTED USING PLAN NORTH AS THE REFERENCE DIRECTION.

FINISH SCHEDULE											
ROOM NUMBER	ROOM NAME	FLOOR		WALLS				CEILING	MILLWORK		COMMENTS
		FLOOR	BASE	NORTH	EAST	SOUTH	WEST		CABINETRY	COUNTERTOP	
100	CORRIDOR	WOC-1; SC-1	RB-1	PT-1	PT-1	PT-1	PT-1	EXPOSED; PT-1	--	--	
101	BREAKROOM	SC-1	RB-1	PT-1, WT-3	PT-1	PT-1	PT-1	EXPOSED; PT-1	PL-1	SS-1	
101A	TELECOM / STORAGE	SC-1	RB-1	PT-1	PT-1	PT-1	PT-1	ACT-1	--	--	
102	RESTROOM	PORF-2	TB-2	WT-4;PT-1	WT-4;PT-1	WT-4;PT-1	WT-4;PT-1	PT-6	--	--	
103	MECHANICAL	SC-1	RB-1	PT-1	PT-1	PT-1	PT-1	EXPOSED; PT-1	--	--	
104	SHARED FLEX	SC-1	RB-1	PT-1	PT-1	PT-1; AWP-2	PT-1	EXPOSED; PT-1	PL-2	--	
105	TOUCHDOWN	SC-1	RB-1	PT-1	PT-1; AWP-2	PT-1	PT-1; AWP-2	EXPOSED; PT-1	PL-2	--	
106	STAFF OFFICE	SC-1	RB-1	PT-1	PT-1	PT-1	PT-1	EXPOSED; PT-1	--	--	
107	INDOOR WORK BAYS	SC-1	RB-1	PT-1	PT-1	PT-1	PT-1	EXPOSED; PT-1	--	--	HIGH PERFORMANCE PAINT
108	OUTDOOR WORK BAYS	--	--	--	--	--	--	--	--	--	

ROLLER SHADE SCHEDULE	
MARK	LENGTH (VERIFY)
RWS-1	4' - 0"
RWS-2	7' - 0"
RWS-3	8' - 0"

 FLOOR FINISH LEGEND

WALK-OFF CARPET, WOC-1

SEALED CONCRETE, SC-1

PORCELAIN TILE, PORF-2

FINISH PLAN,
LEGEND AND
SCHEDULE

LAKE MYRA COUNTY PARK
Wake County, NC

REVISIONS

Date: 07/27/26


MF-A131


Susan Hatchell

Landscape Architecture, PLLC

711 W. North Street, Raleigh, NC 27603

p: 919-838-9600 f: 919-838-9700

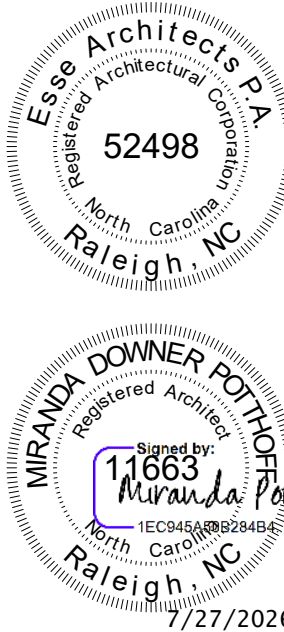

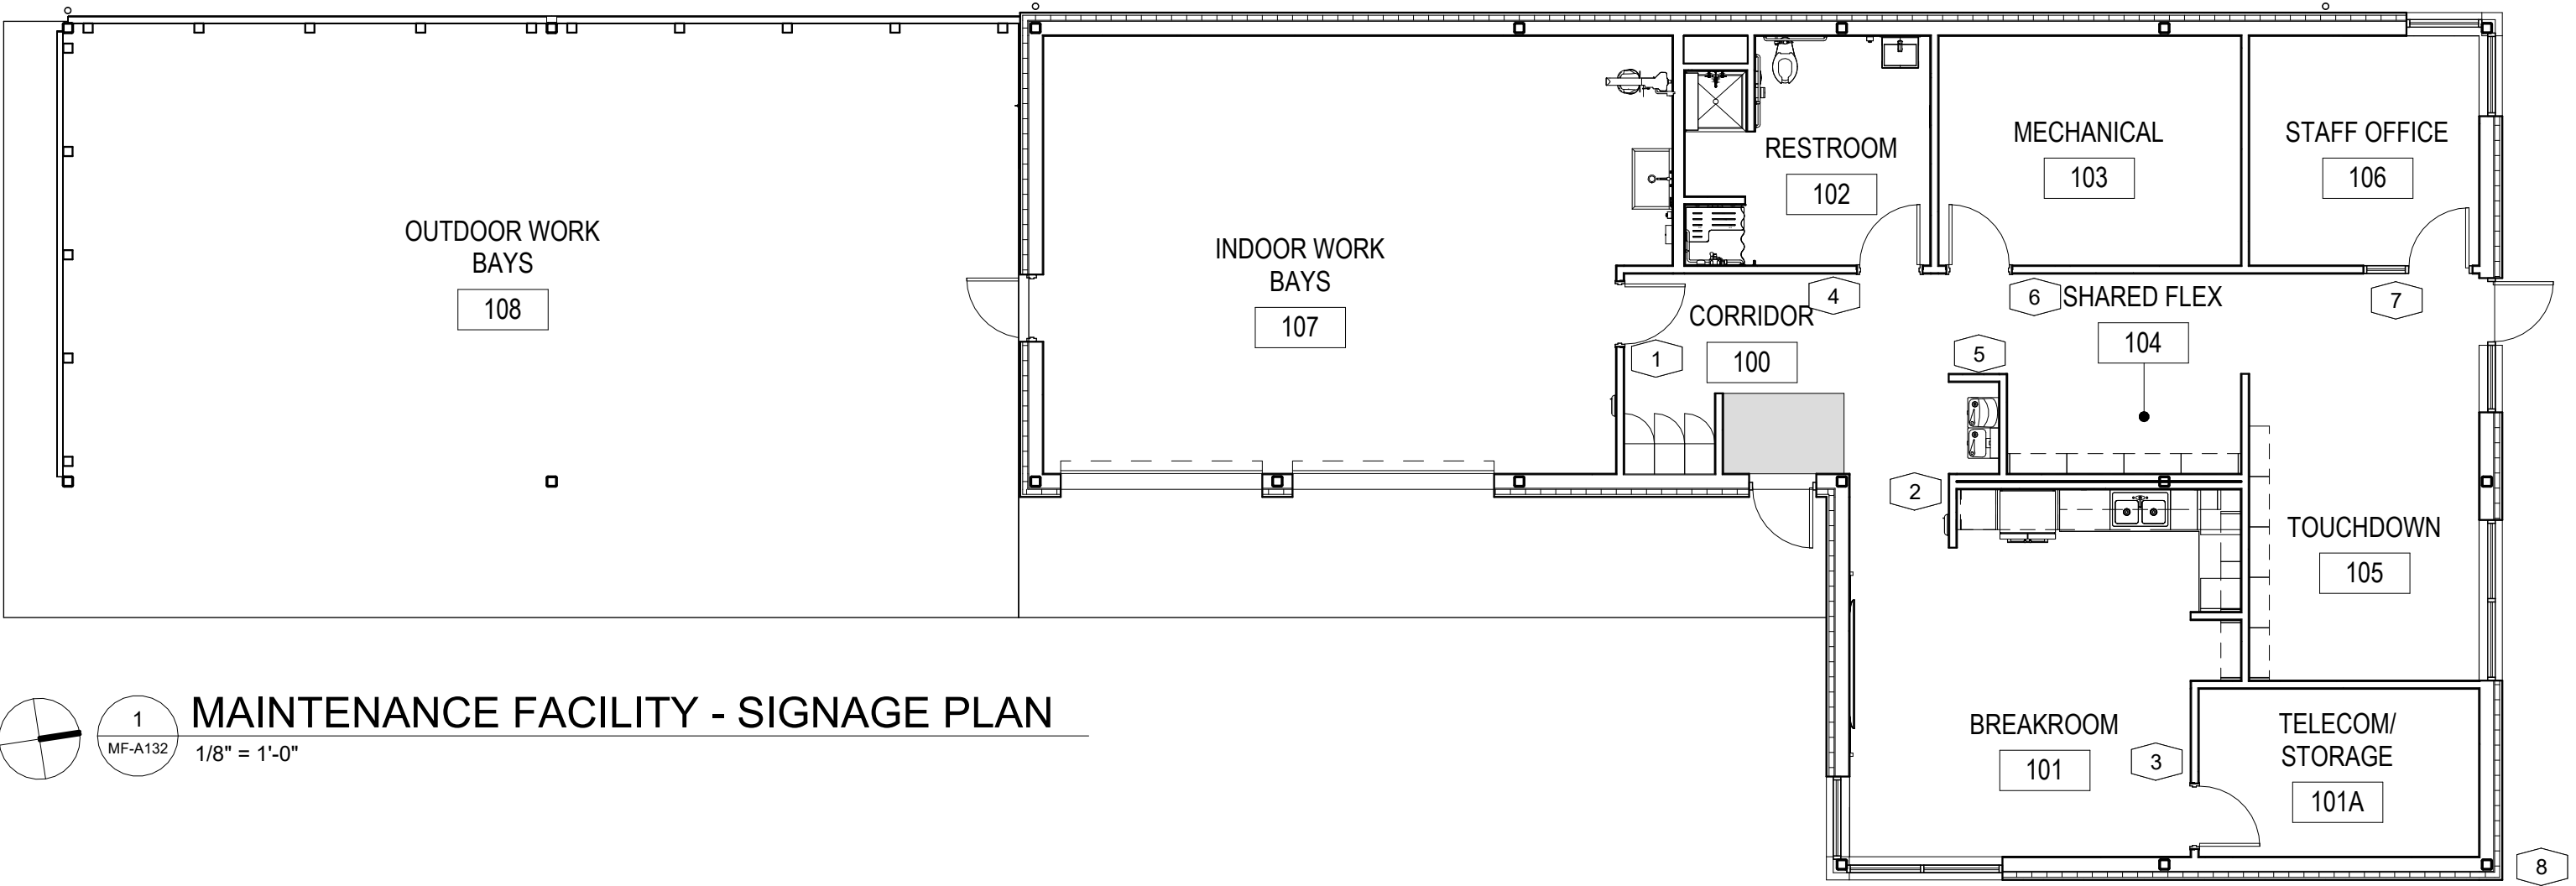

SIGNAGE SCHEDULE				
SIGN NO.	ROOM NO.	SIGNAGE TEXT	SIGN TYPE	COMMENTS
1	107	INDOOR WORK BAYS	ID.2	
2	101	BREAKROOM	ID.1	
3	101A	TELECOM / STORAGE	ID.2	
4	102	RESTROOM	R.3	
5	--	EVACUATION MAP	E.1	
6	103	MECHANICAL	ID.1	
7	106	OFFICE	ID.1	
8	EXTERIOR	SEE SIGNAGE DETAIL	D.1	GC PROVIDED

ALL BUILDING SIGNAGE TO BE PROVIDED BY THE OWNER UNLESS OTHERWISE NOTED.

SPECIFICATIONS

GENERAL SIGNAGE NOTES

BRAILLE CHARACTERS ARE FOR GRAPHIC REPRESENTATION ONLY - ACTUAL BRAILLE CHARACTERS TO BE DETERMINED BY SIGN FABRICATOR

ADA COMPLIANT 1/8" THERMOFORM SIGN CONSISTING OF INTEGRAL RAISED COPY, GRADE II BRAILLE WITH SUBSURFACE COPY AND PAINT, SIGN TO BE CLEARCOATED AFTER PAINT AND FOIL STAMP HAS BEEN APPLIED.

ROOM NUMBER, BRAILLE, AND ACCENTS ARE RAISED.

WHERE SIGN IS MOUNTED TO GLASS, PLACE A THERMOFORM BLANK SIGN MOUNTED ON OPPOSITE SIDE OF GLASS. BACK PANEL TO MATCH BACKGROUND COLOR.

COPY STYLE: OPTIMA MEDIUM

COPY COLOR: BLACK; ARCHITECT TO SELECT FROM MANUFACTURERS FULL LINE OF COLORS.

BACKGROUND COLOR: ROWMARK BLACK FOREST GREEN OR EQUAL; ARCHITECT TO SELECT FROM MANUFACTURERS FULL RANGE OF COLORS.

BRAILLE COLOR: CLEAR

SYMBOL COLOR: WHITE ; ARCHITECT TO SELECT FROM MANUFACTURERS FULL RANGE OF COLORS.

NOTE: ALL SIGN TYPES TO MEET ADA REQUIREMENTS FOR COLOR CONTRAST RATIO

CORNERS: SQUARE

SIGN MOUNTING: 3M #4910 CLEAR VHB DOUBLE-SIDED TAPE AND CLEAR SILICONE ADHESIVE

SIGN TYPE E.1 SPECIFICATIONS

1/16" NON-GLARE ACRYLIC ON BOTH SIDES.

BACKGROUND COLOR: RED; ARCHITECT TO SELECT FROM MANUFACTURERS FULL RANGE OF COLORS.

SURFACE APPLIED GRAPHICS, DOUBLE SIDED, COLOR WHITE; ARCHITECT TO SELECT FROM MANUFACTURERS FULL RANGE OF COLORS.

SIGN MOUNTING: EXTRUDED ALUMINUM - CORRIDOR BRACKET SILVER ANODIZED FINISH, MECHANICALLY MOUNTED TO WALL

DIMENSIONAL SIGNAGE NOTES

FABRICATED METAL SIGNS


TYPEFACE: ARIAL

COLOR: SW 6438 DILL

MOUNTING: DETACHABLE MOUNTING STUDS

SIGN TO BE PROVIDED BY THE GC

BUILDING NUMBER TO BE CONFIRMED WITH OWNER PRIOR TO SUBMITTALS

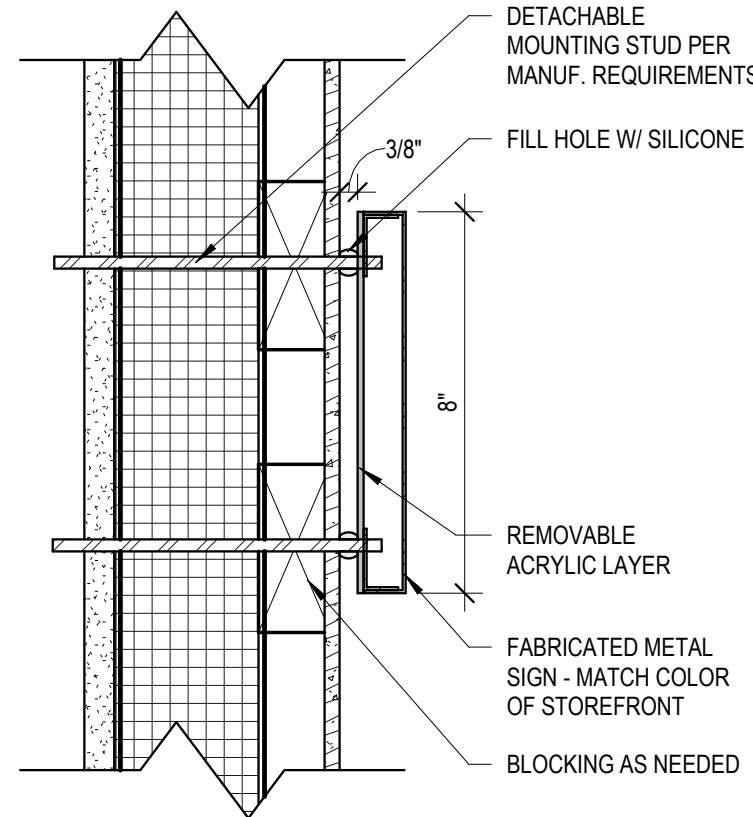

11'-8"

6"

1'-5"

6"

1'-5"

6"

1'-5"


6"

1


2

3

4

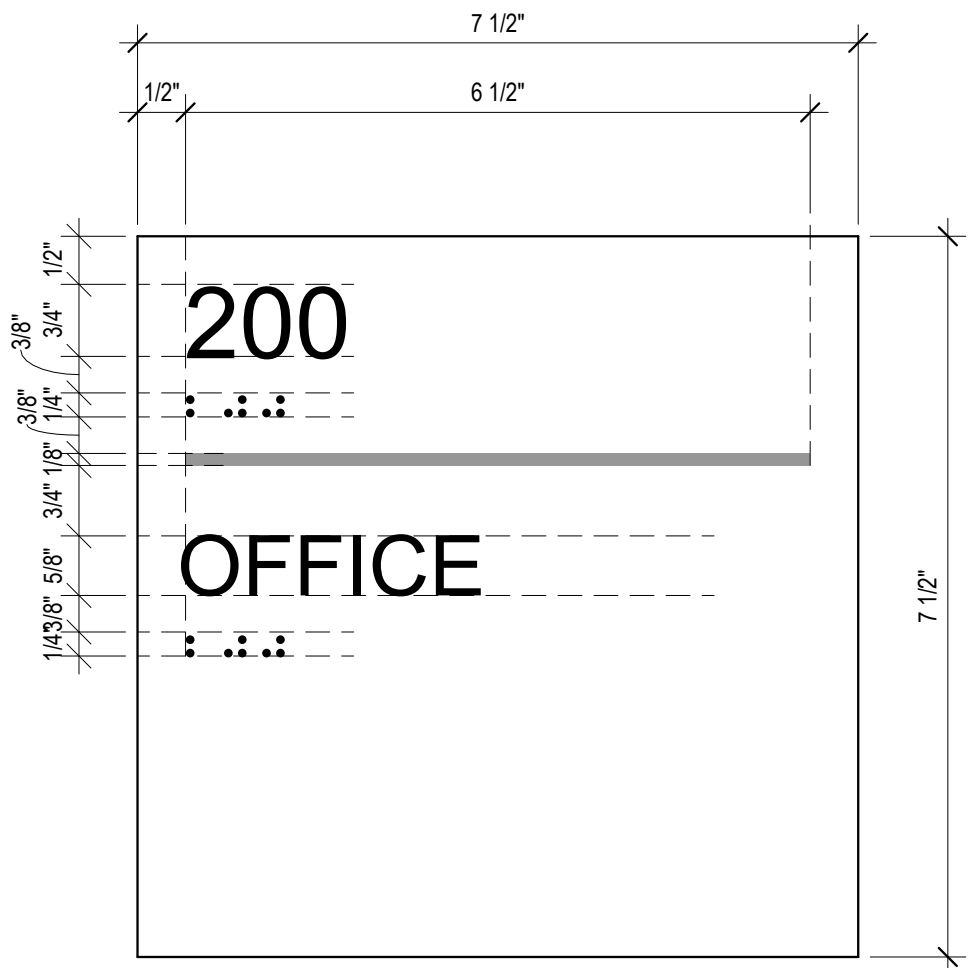

SIGNAGE TYPE ID.1 - ROOM INDICATOR 1 LINE

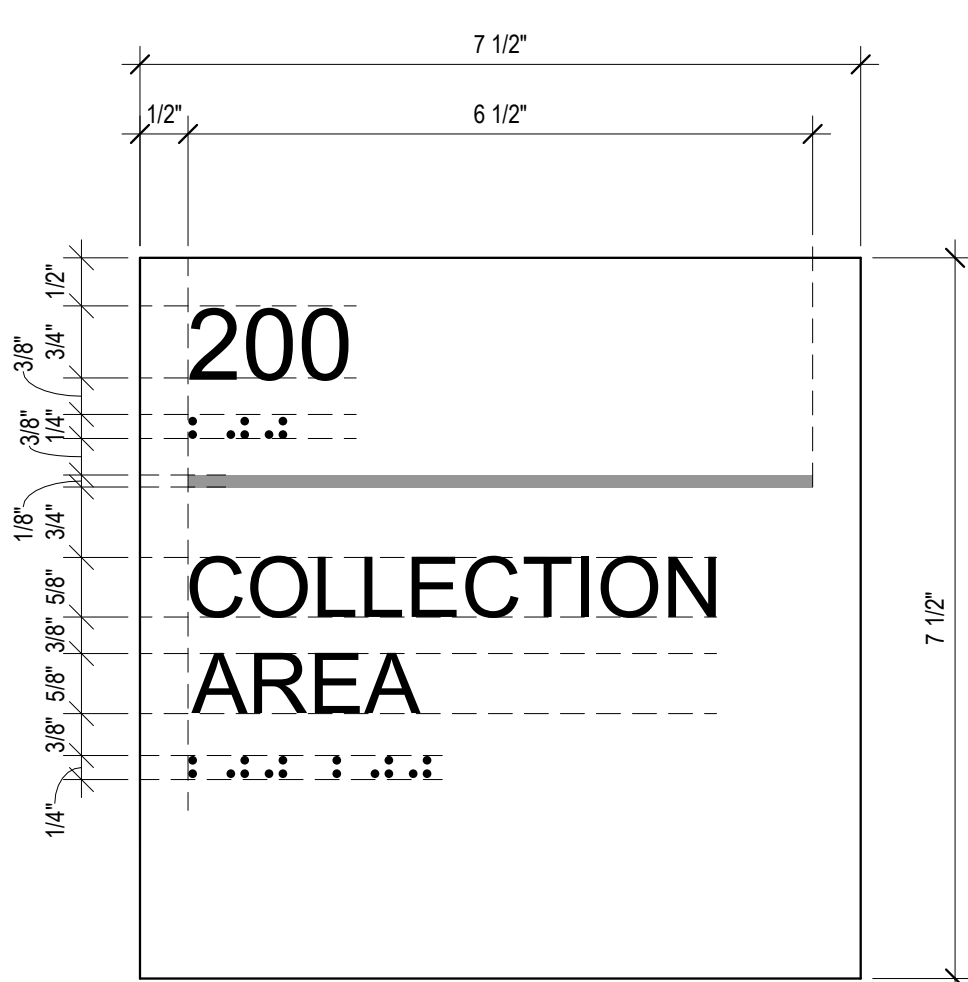

SIGNAGE TYPE ID.2 - ROOM INDICATOR 2 LINE





SIGNAGE TYPE R.3 - UNISEX ADA

SIGNAGE TYPE D.1 - EXTERIOR BUILDING ADDRESS - GC PROVIDED




SIGNAGE TYPE E.1 - EVACUATION PLAN

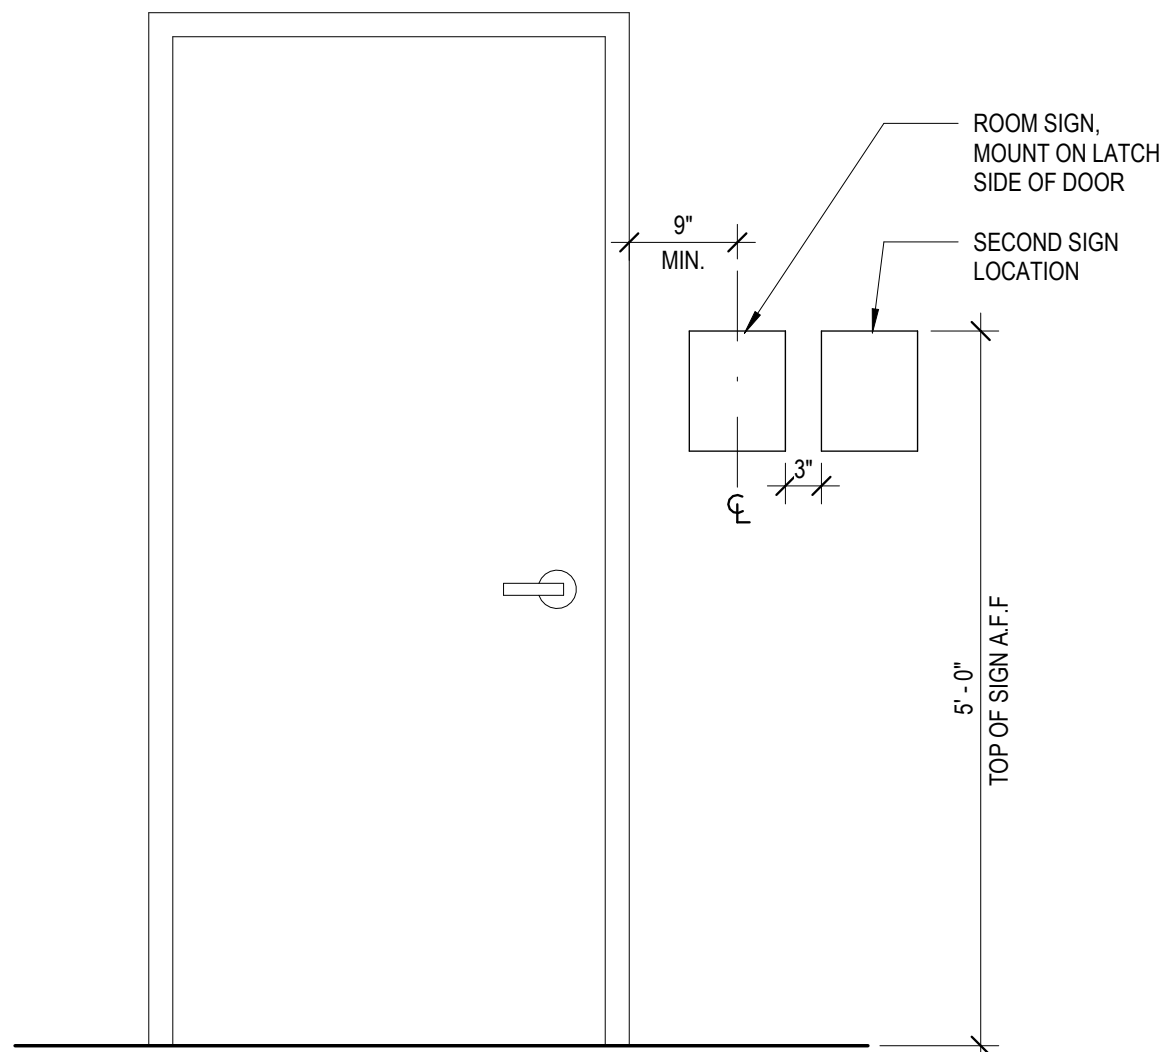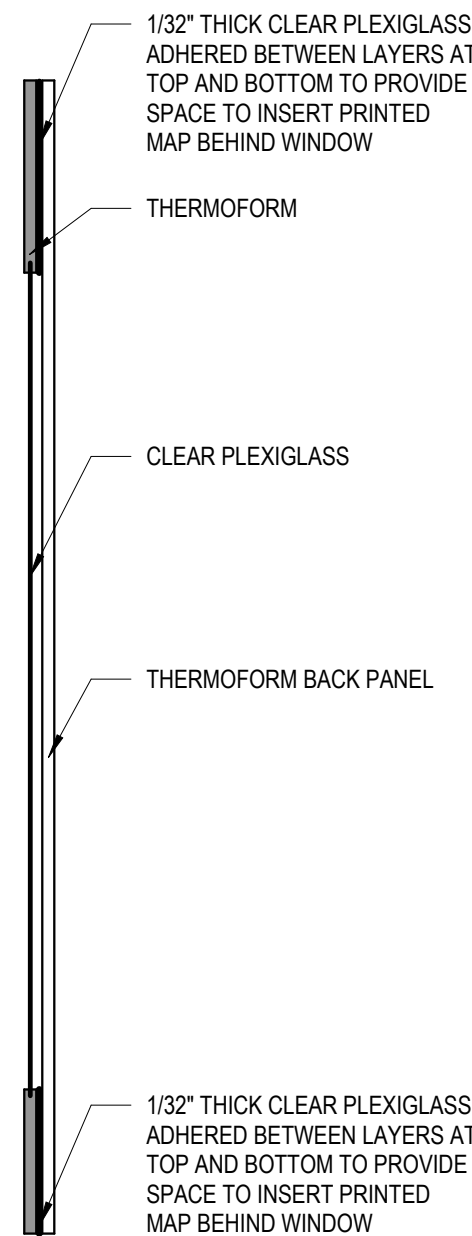


TYPICAL SIGNAGE (COORD. WITH PLANS)


SIGNAGE MOUNTING HEIGHT

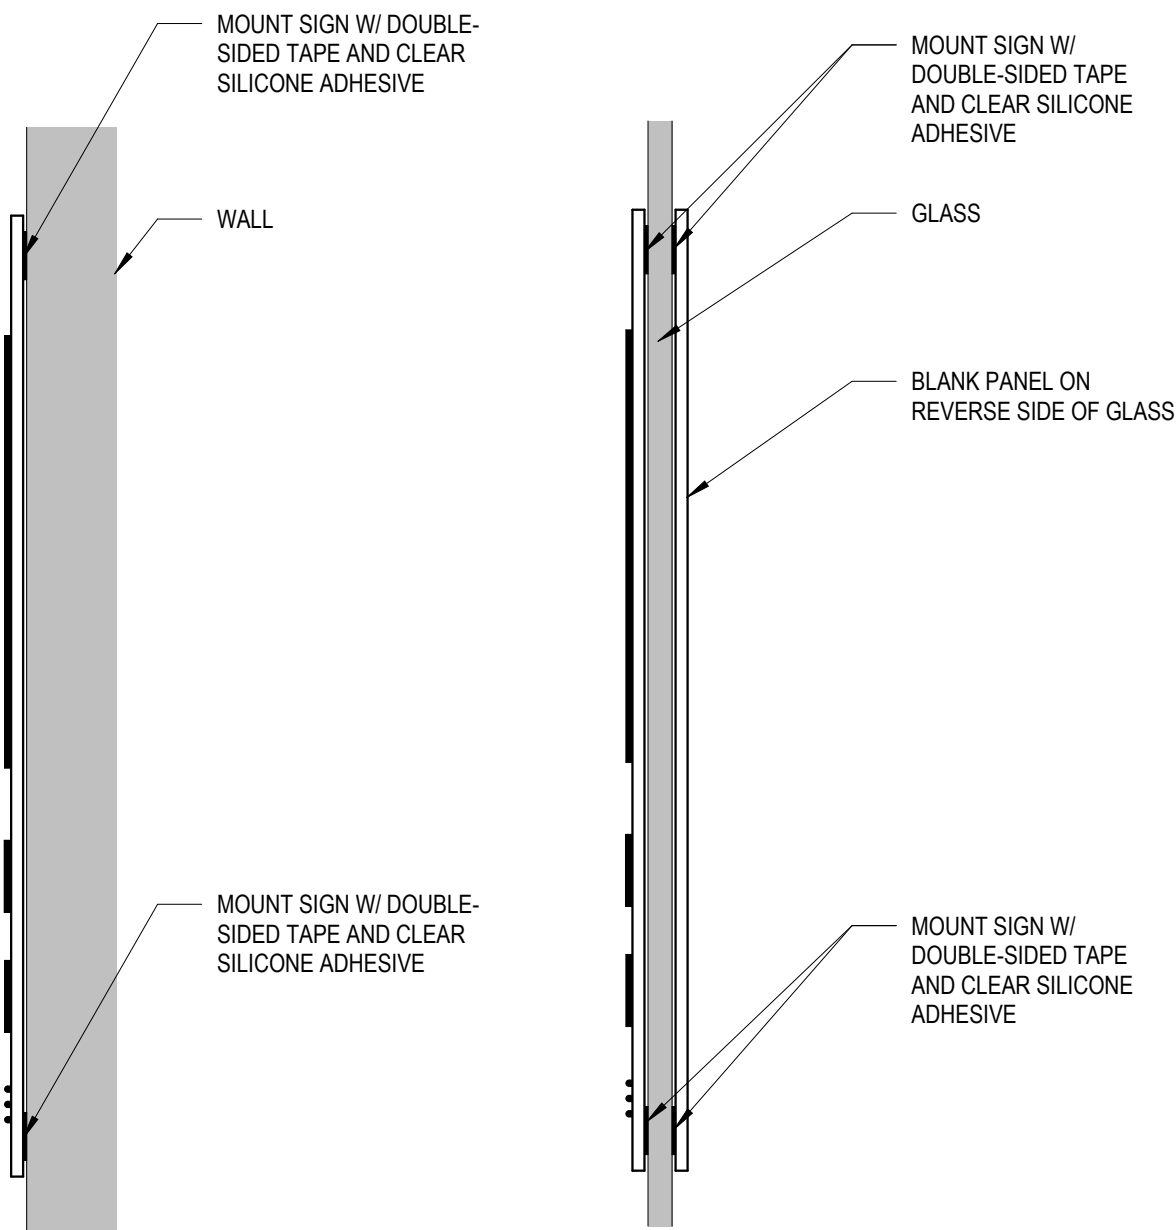

SIGNAGE MOUNTING TYPES

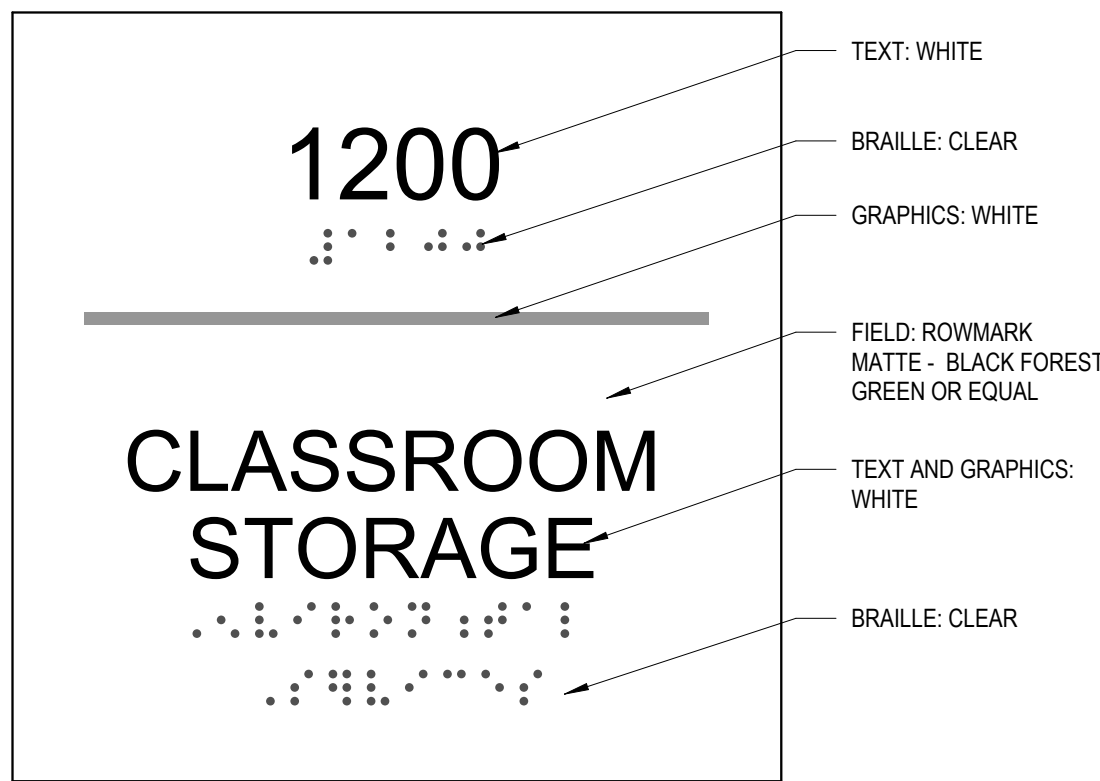

SIGNAGE COLOR SAMPLE

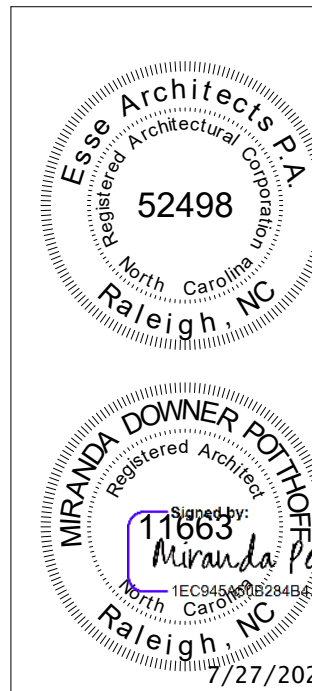

REVISIONS

Date: 07/27/26


MF-A132

SIGNAGE PLAN & DETAILS

LAKE MYRA COUNTY PARK
Wake County, NC

Susan Hatchell
Landscape Architecture, PLLC
711 W. North Street, Raleigh, NC 27603
p: 919-838-9600 f: 919-838-9700

Esse Architects
832 FISHING ROAD | RALEIGH, NORTH CAROLINA 27608

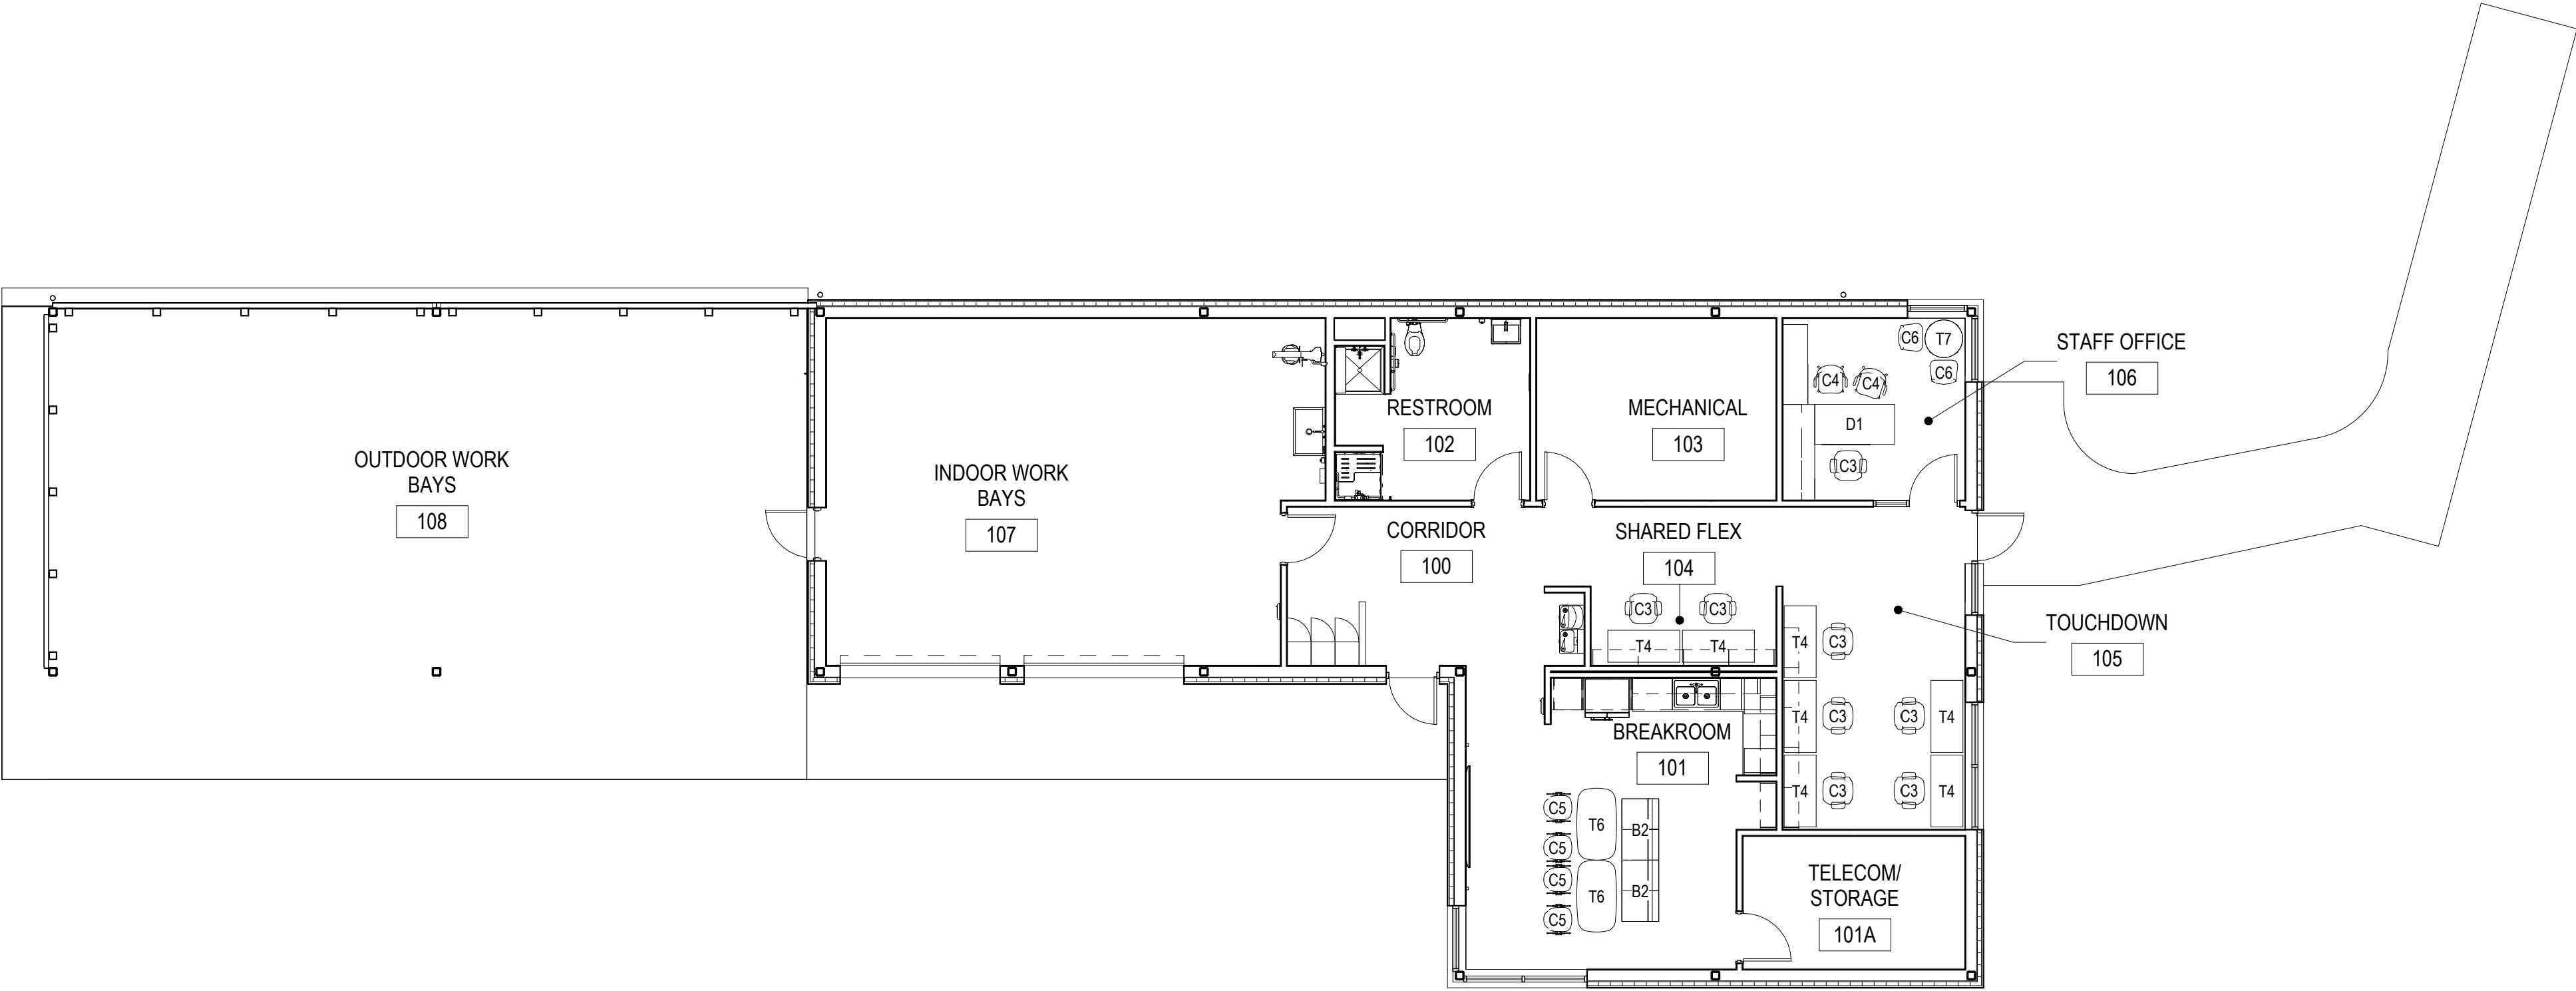

1 MAINTENANCE FACILITY - FURNITURE PLAN
MF-A140 1/8" = 1'-0"
FOR GC'S REFERENCE AND COORDINATION ONLY


FURNITURE SCHEDULE		
MARK	DESCRIPTION	QUANTITY
B2	UPHOLSTERED BOOTH SEATING	2
C3	UPHOLSTERED TASK SEATING W/ CASTERS	8
C4	GUEST CHAIR	2
C5	CAFE CHAIR	4
C6	CONFERENCE CHAIR W/ ARMS - UPHOLSTERED SEAT	2
D1	WORKSTATION WITH FIXED WORKSURFACE, ADJUSTABLE HEIGHT COMPUTER WORKSTATION, AND FILE STORAGE	1
T4	FREE STANDING WORKSTATION W/ INTEGRATED CHARGING	7
T6	CAFE TABLE	2
T7	24" D TABLE	1

Susan Hatchell
Landscape Architecture, PLLC
711 W. North Street, Raleigh, NC 27603
p: 919-838-9600 f: 919-838-9700







FURNITURE PLAN

LAKE MYRA COUNTY PARK
Wake County, NC

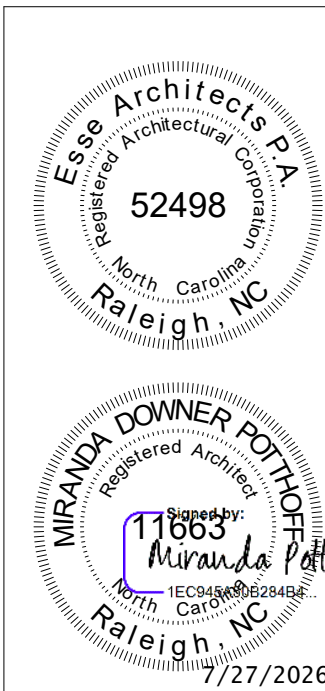


REVISIONS

Date: 07/27/26
MF-A140

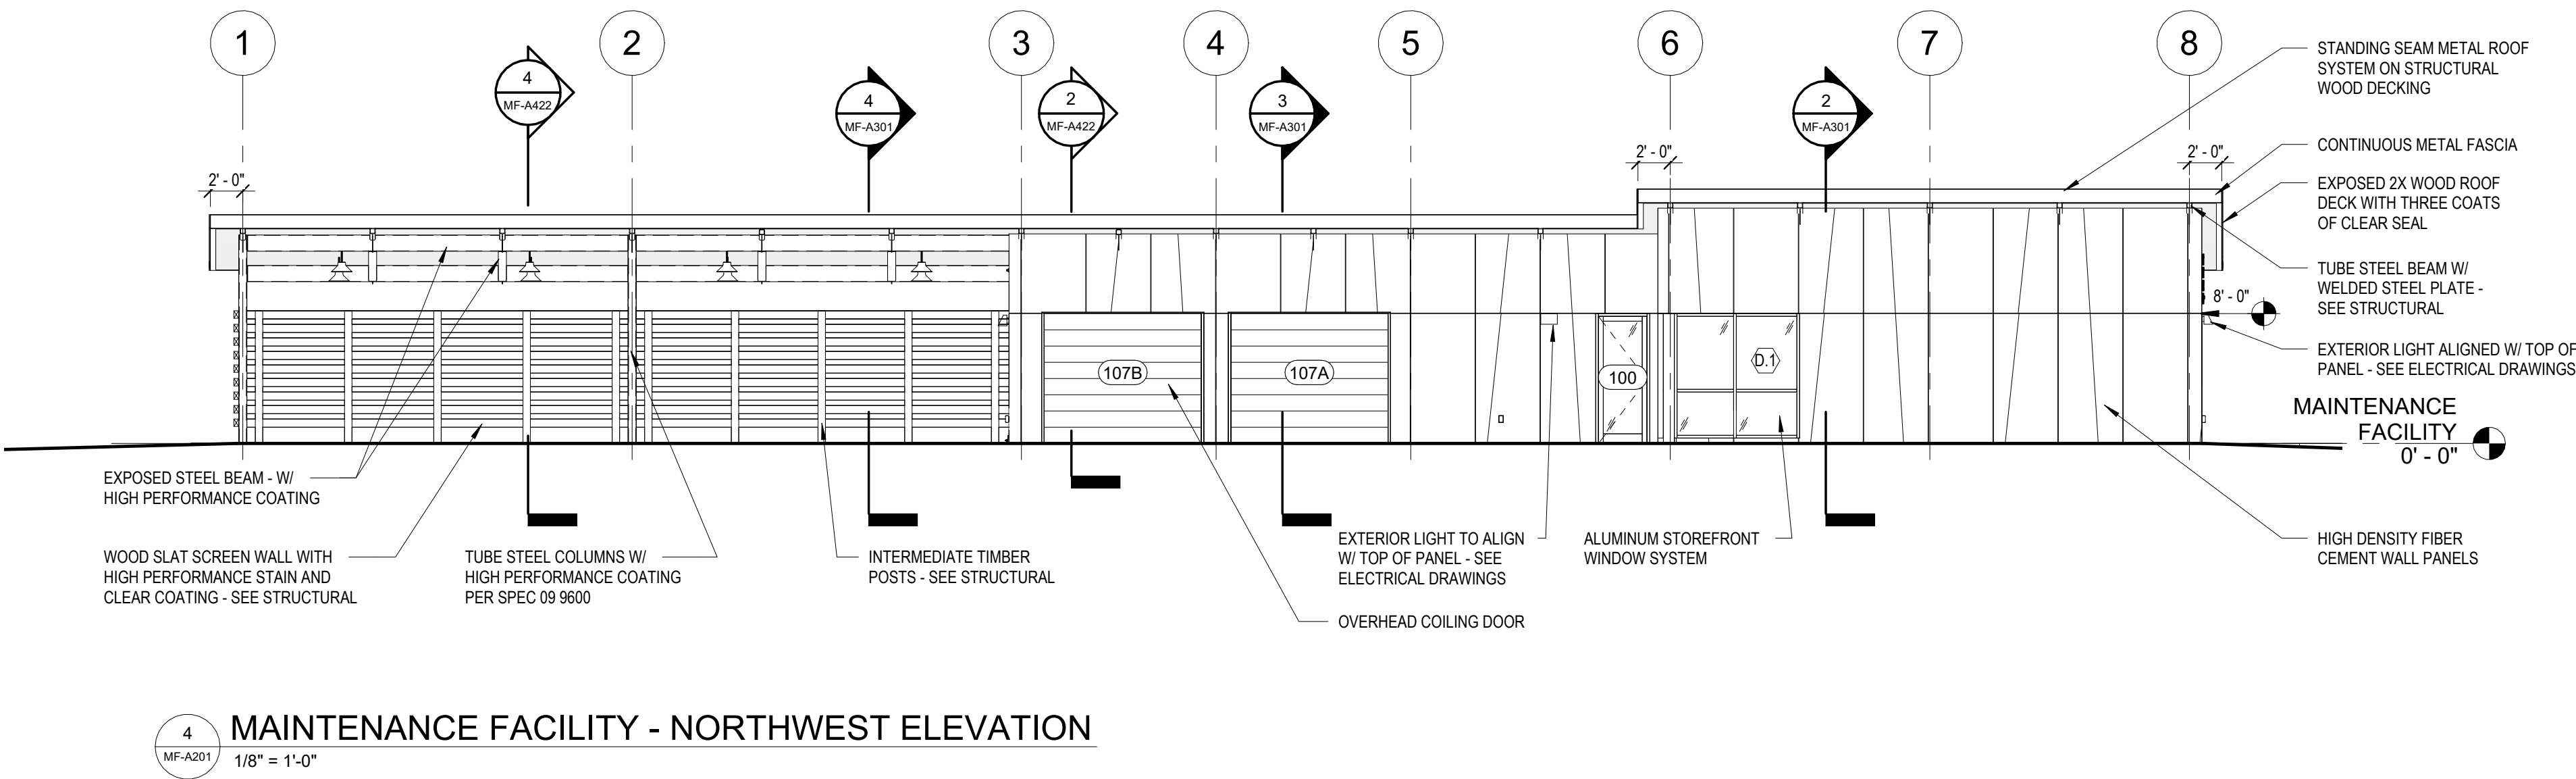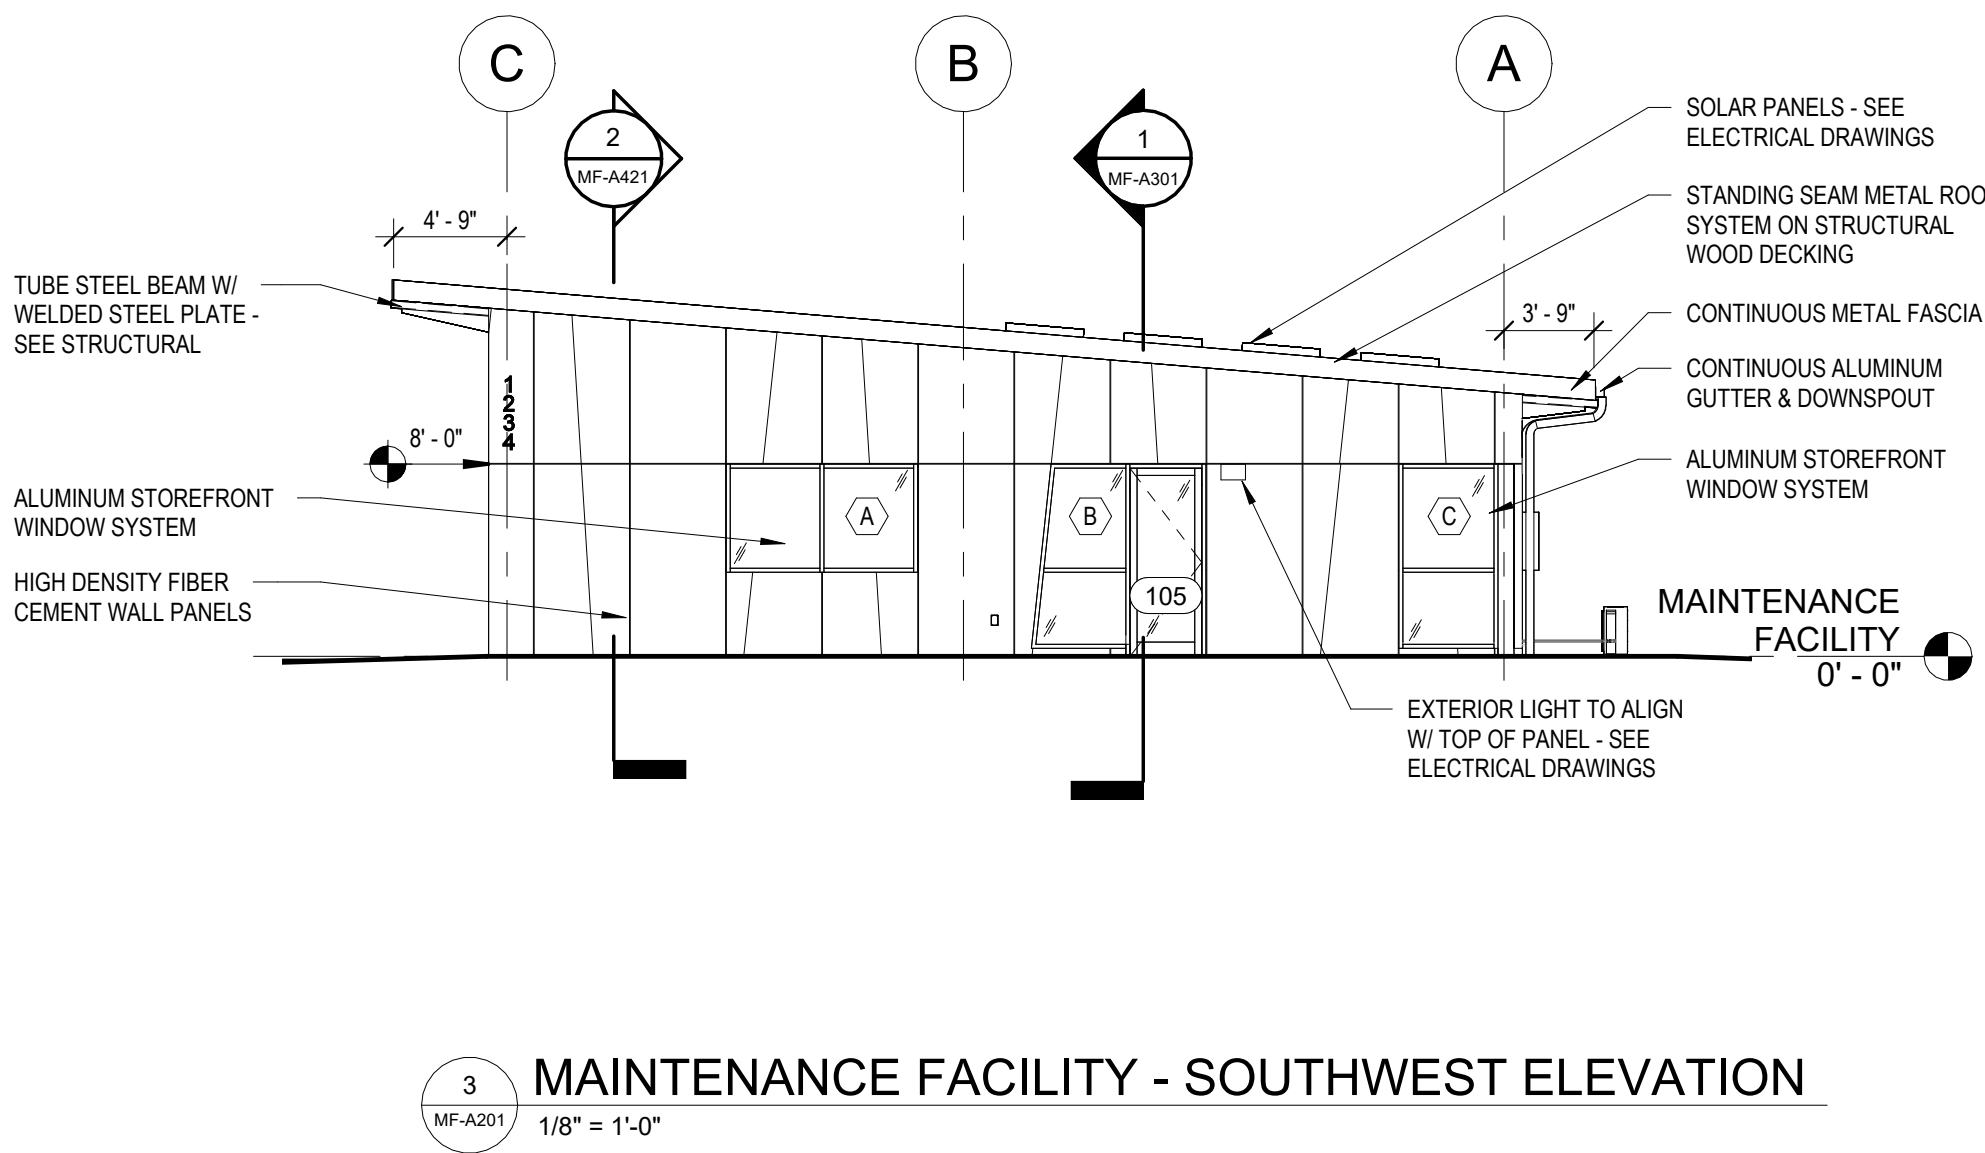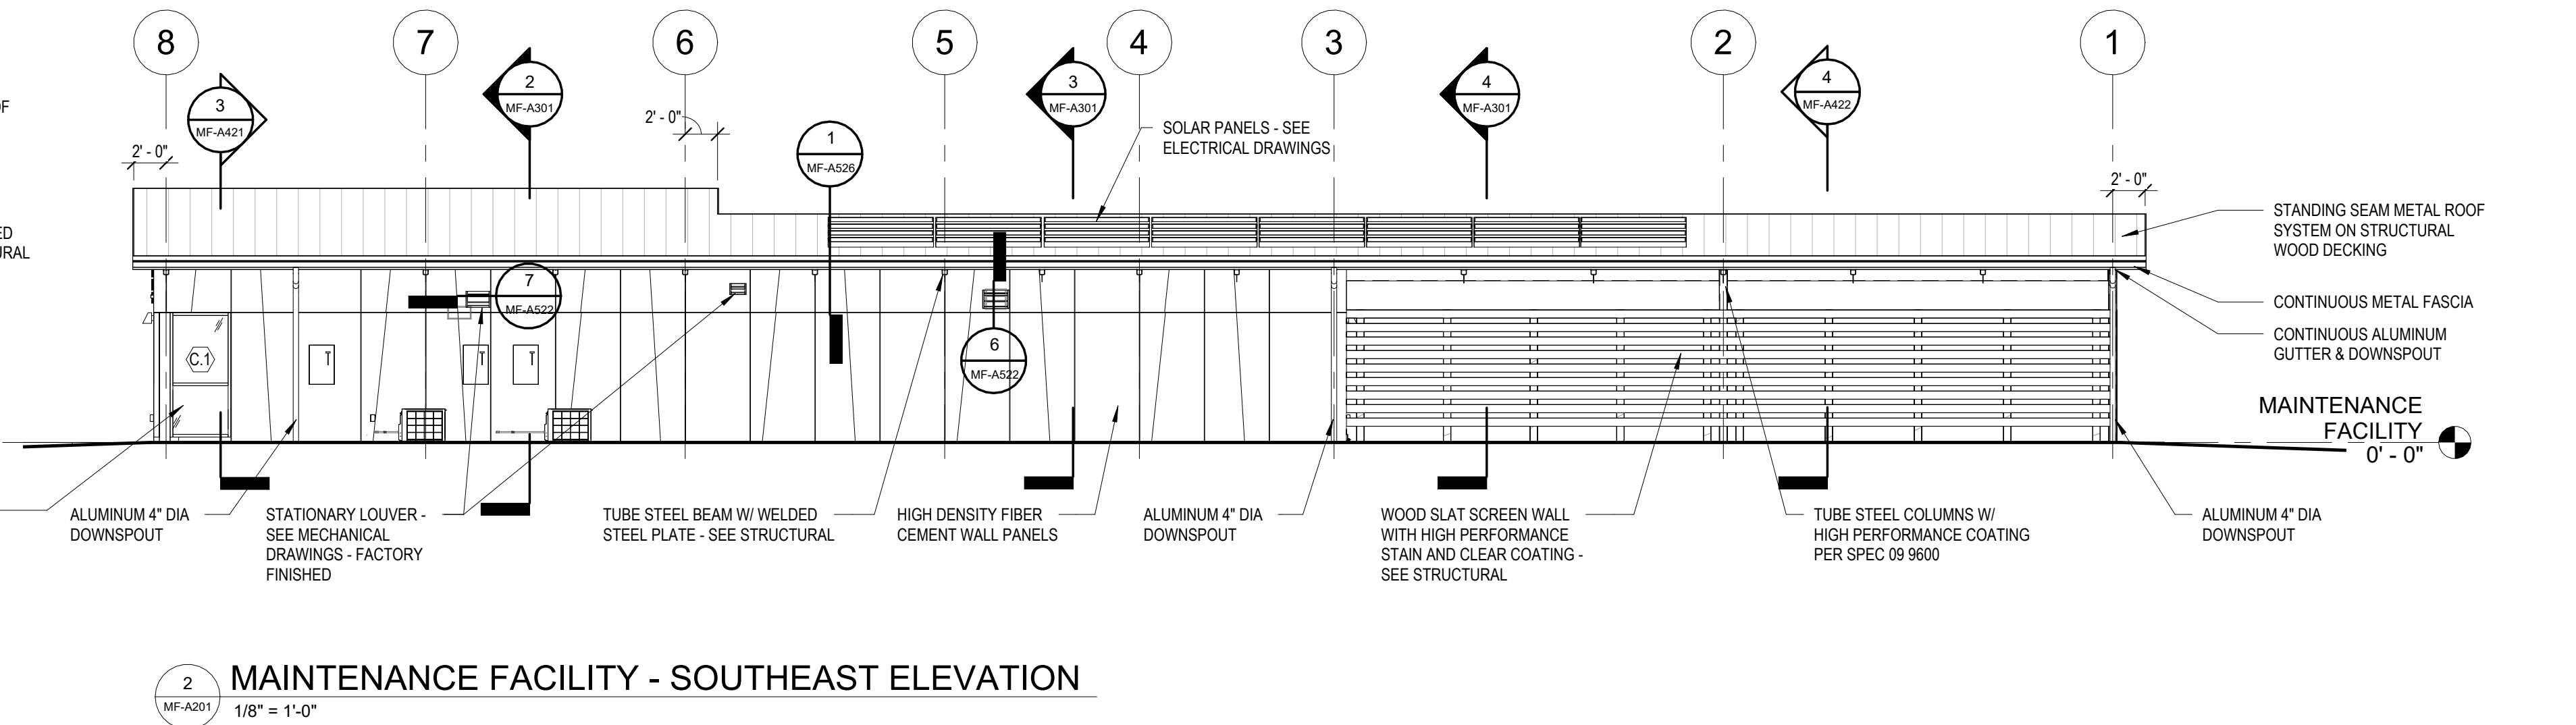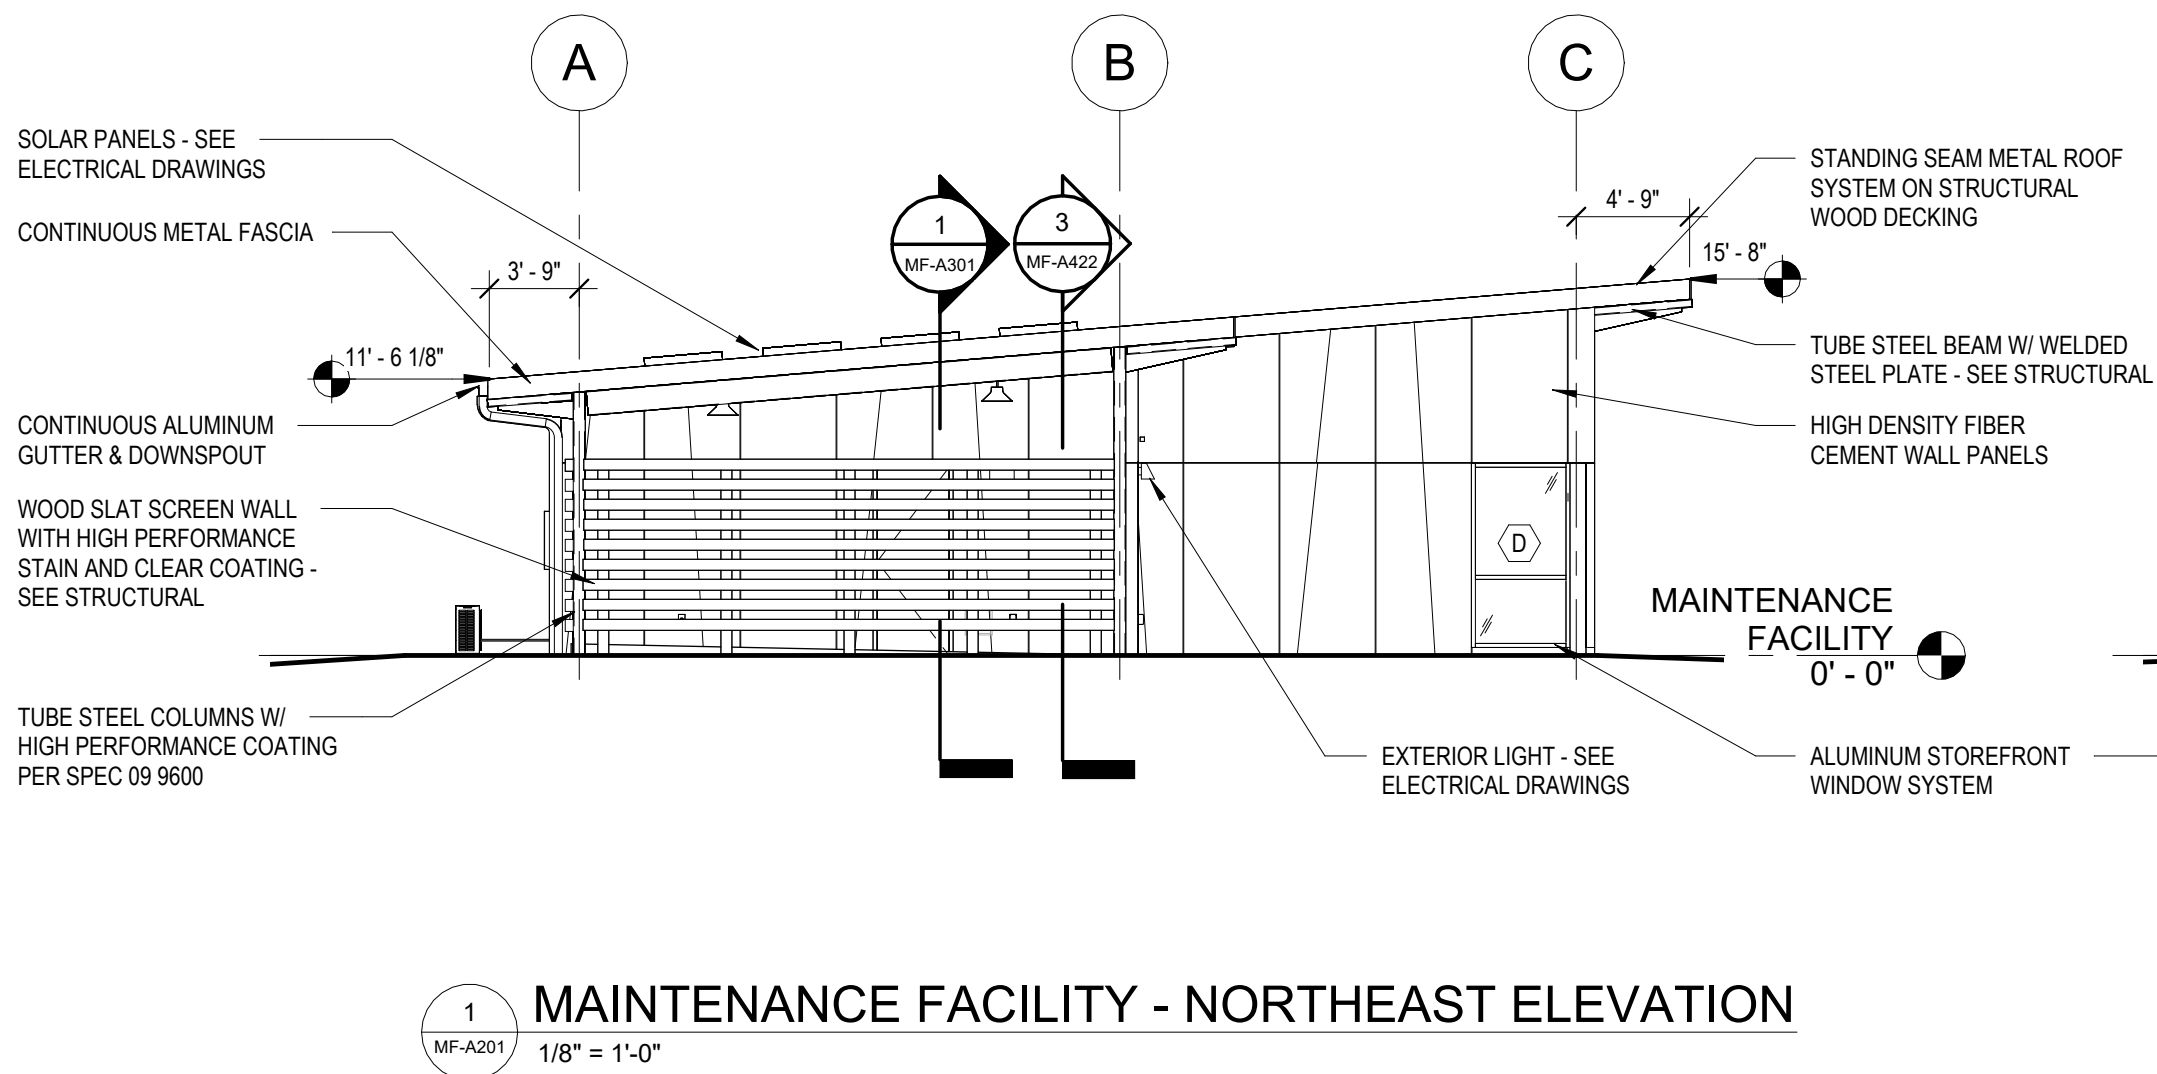

EXTERIOR MATERIAL SCHEDULE - MAINTENANCE FACILITY			
WALLS		STEEL	
FIBER CEMENT PANELS	SWISSPEARL - AVERA - AV100+AV060	EXPOSED STRUCTURE	HIGH PERFORMANCE COATING - SW 7048 - URBANE BRONZE
		DOORS AND FRAMES	HIGH PERFORMANCE COATING - SEE DOOR SCHEDULE FOR FINISH
ROOF		GLAZING	
STANDING SEAM METAL PANELS	PAC-CLAD - TITE-LOCK - GRANITE	VISION GLASS	LOW-E CLEAR GLASS
SOFFITS	EXPOSED WOOD DECKING WITH THREE COATS CLEAR SEAL		
STOREFRONT, GUTTERS, DOWNSPOUTS, AND TRIM			
STOREFRONT	PAINTED SHERWIN WILLIAMS SW 6438 - DILL		
GUTTERS AND DOWNSPOUTS	HIGH PERFORMANCE COATING - SW 7048 - URBANE BRONZE		
NOTES:			
1. ALL FINISHES NOTED HERE REPRESENT THE BASIS OF DESIGN - SEE SPECIFICATIONS FOR THREE EQUALS			
2. ALL EXTERIOR PAINTS TO BE HIGH-PERFORMANCE COATINGS PER SPEC SECTION 09 9600.			

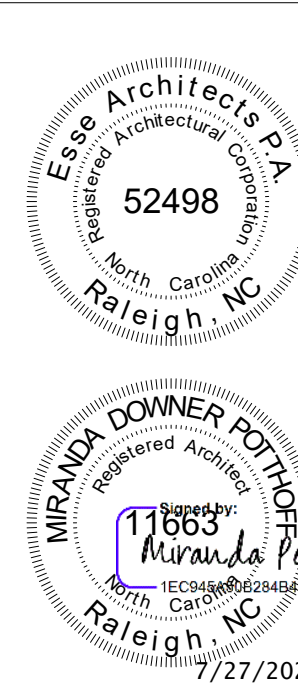

Susan Hatchell
Landscape Architecture, PLLC
711 W. North Street, Raleigh, NC 27603
p: 919-838-9600 f: 919-838-9700




EXTERIOR
ELEVATIONS


LAKE MYRA COUNTY PARK
Wake County, NC

REVISIONS

Date: 07/27/26
MF-A201

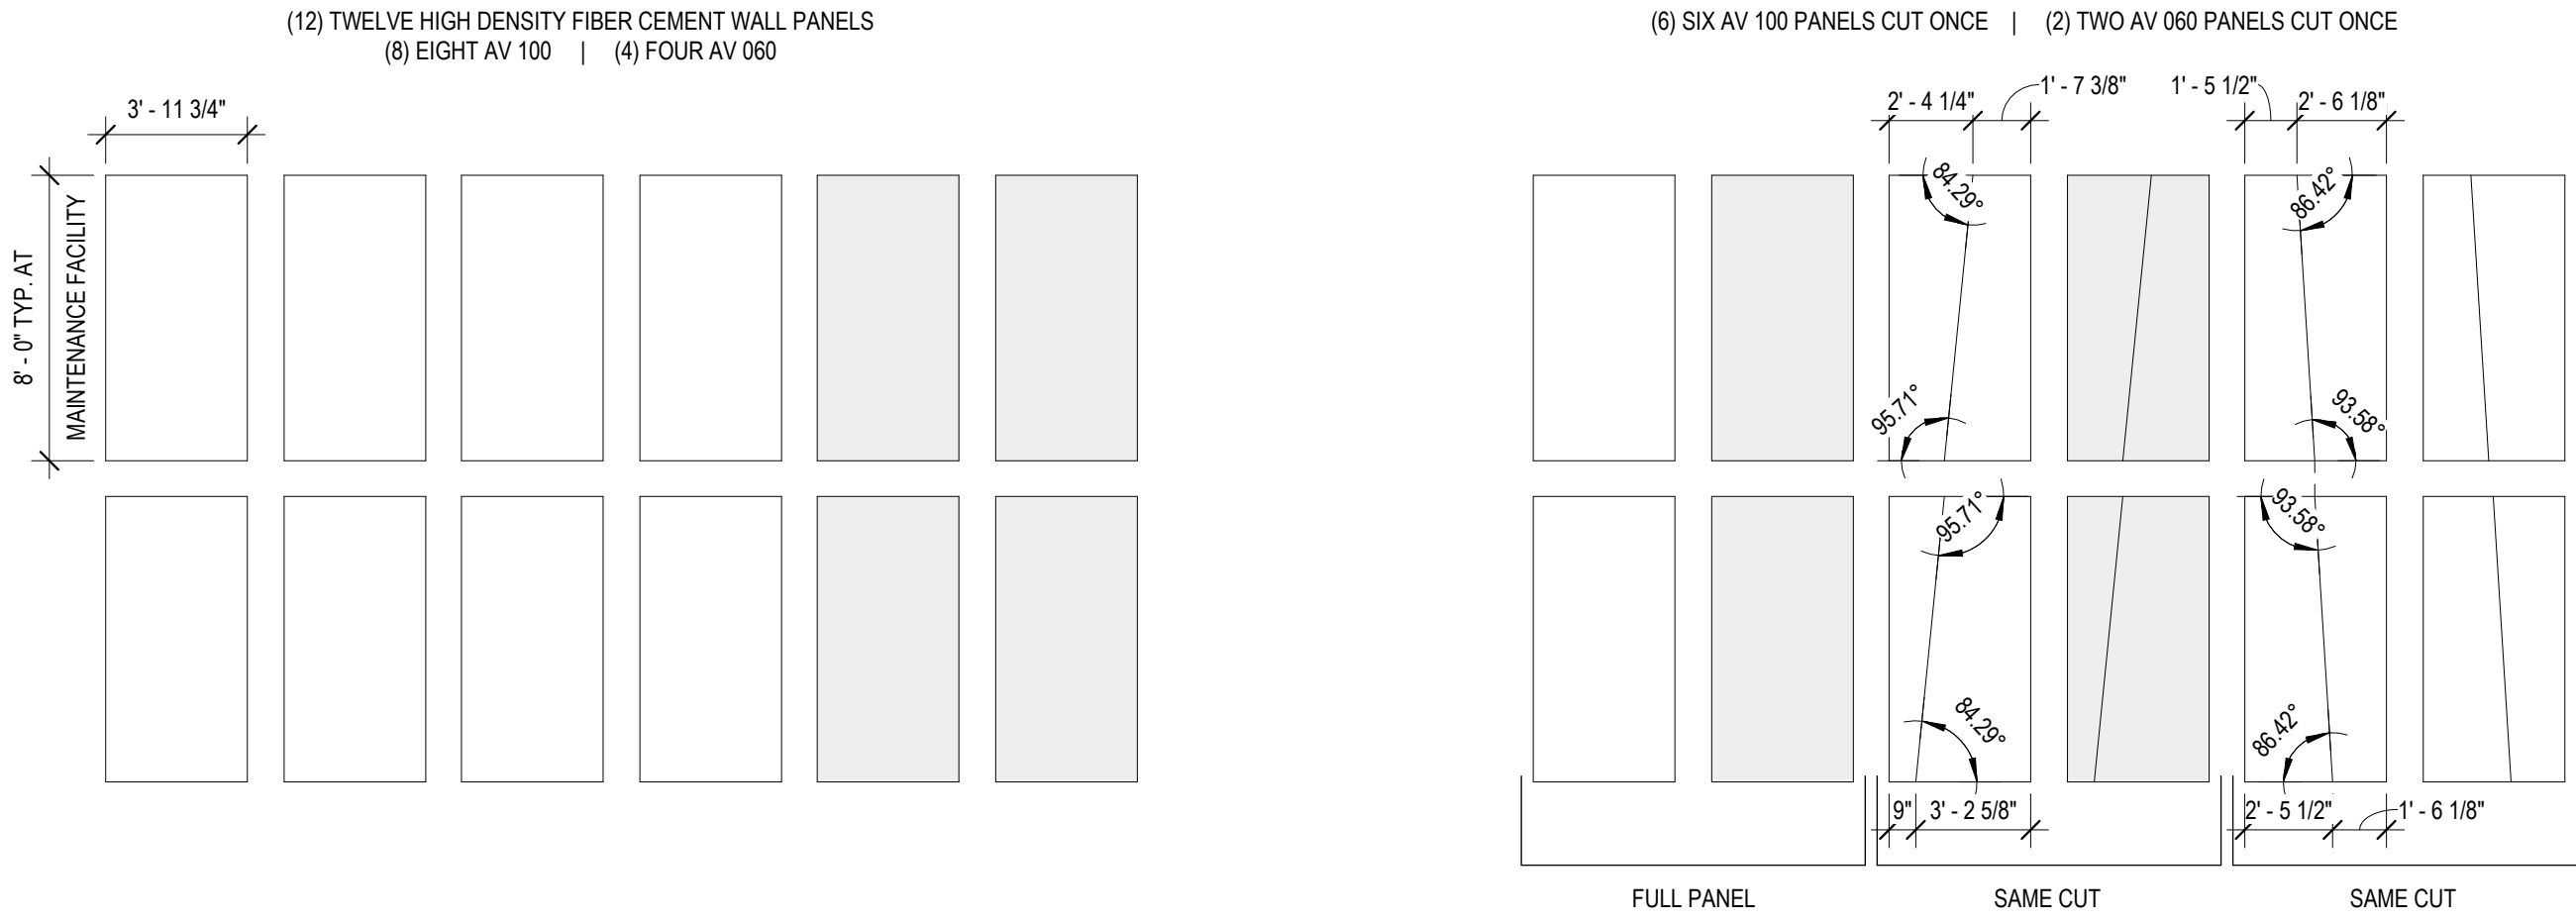


1 MAINTENANCE FACILITY EXTERIOR WALL PATTERN - EXPLODED
MF-A202 3/16" = 1'-0"

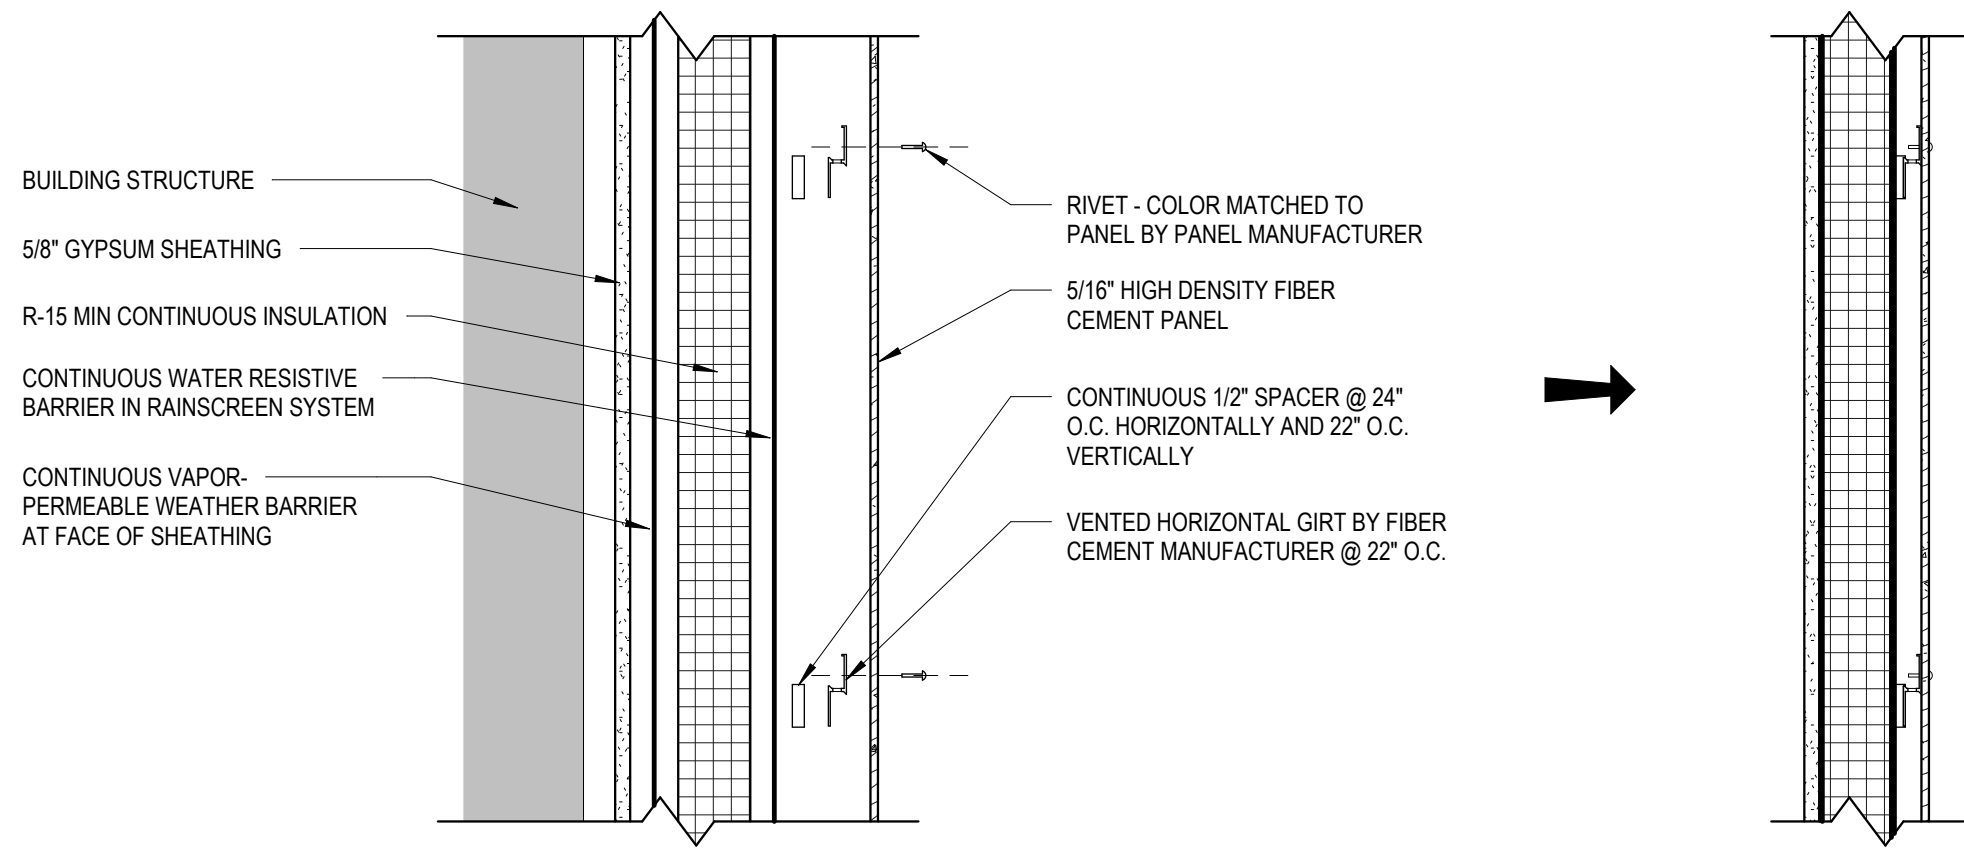


SECTION VIEW


2 EXPLODED PANEL ATTACHMENT
MF-A202 1 1/2" = 1'-0"

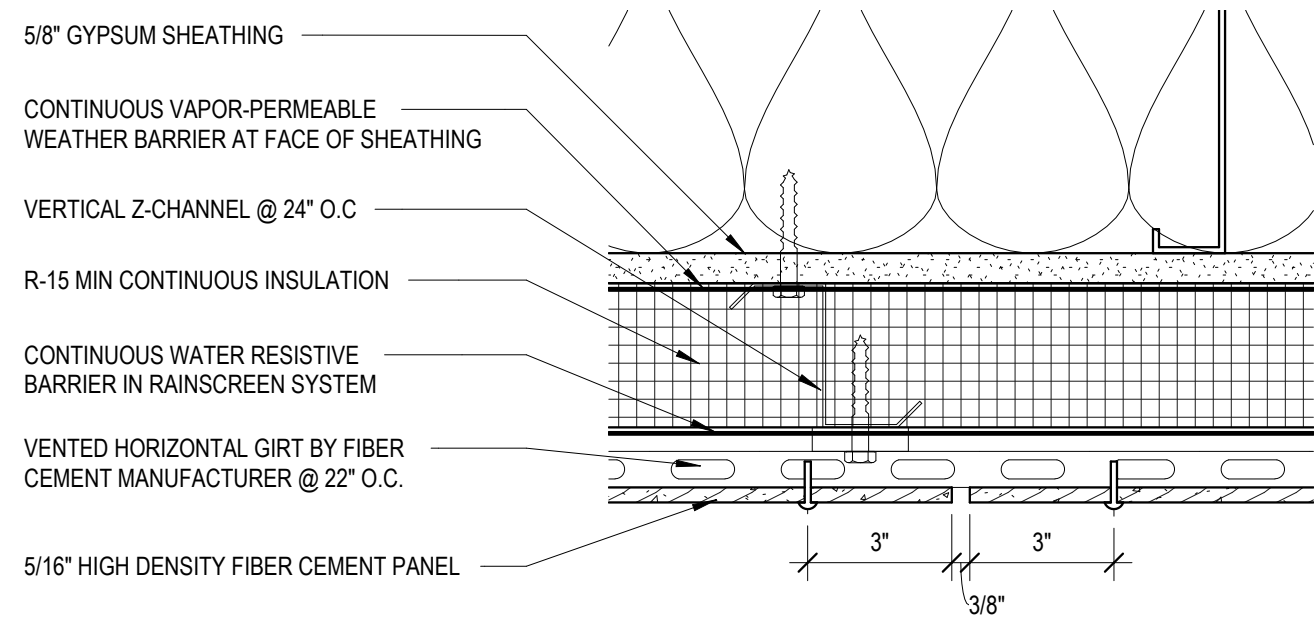

3 DETAIL @ VERTICAL PANEL JOINT
MF-A202 3" = 1'-0"

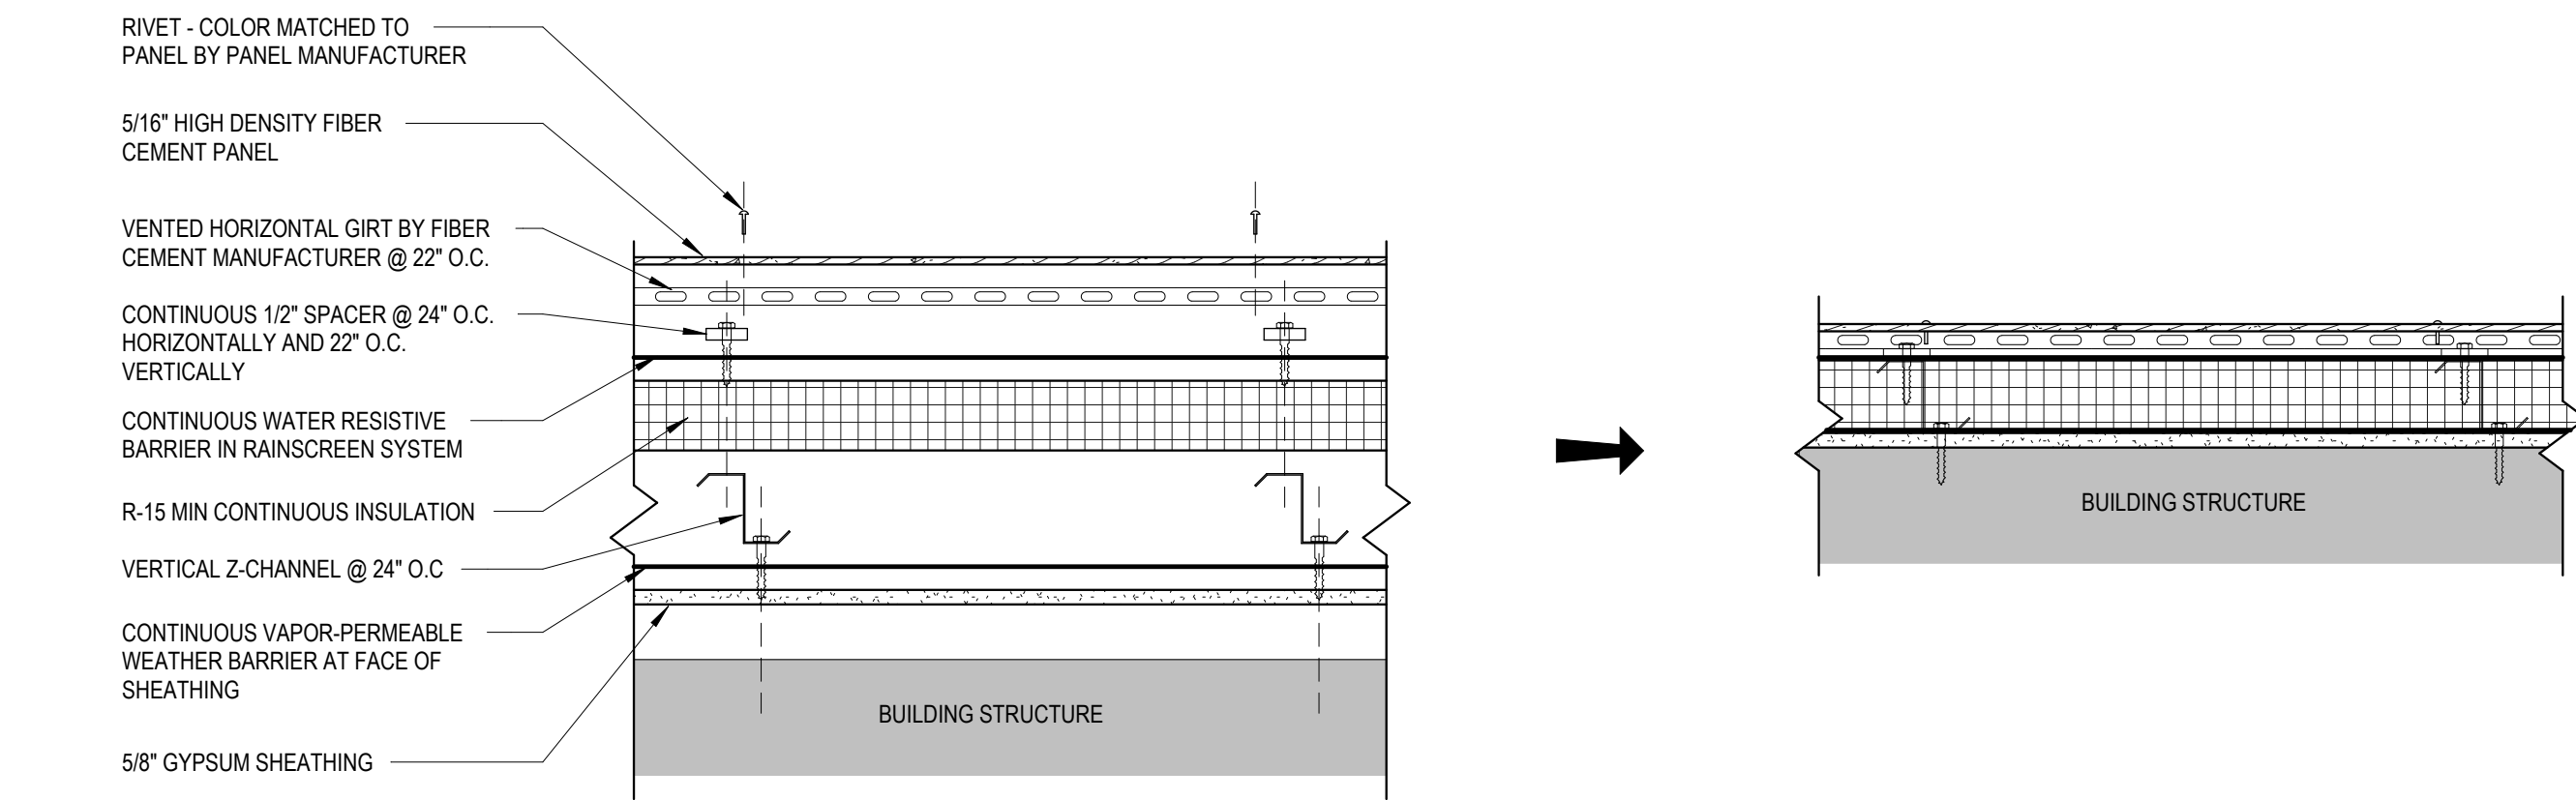

PLAN VIEW

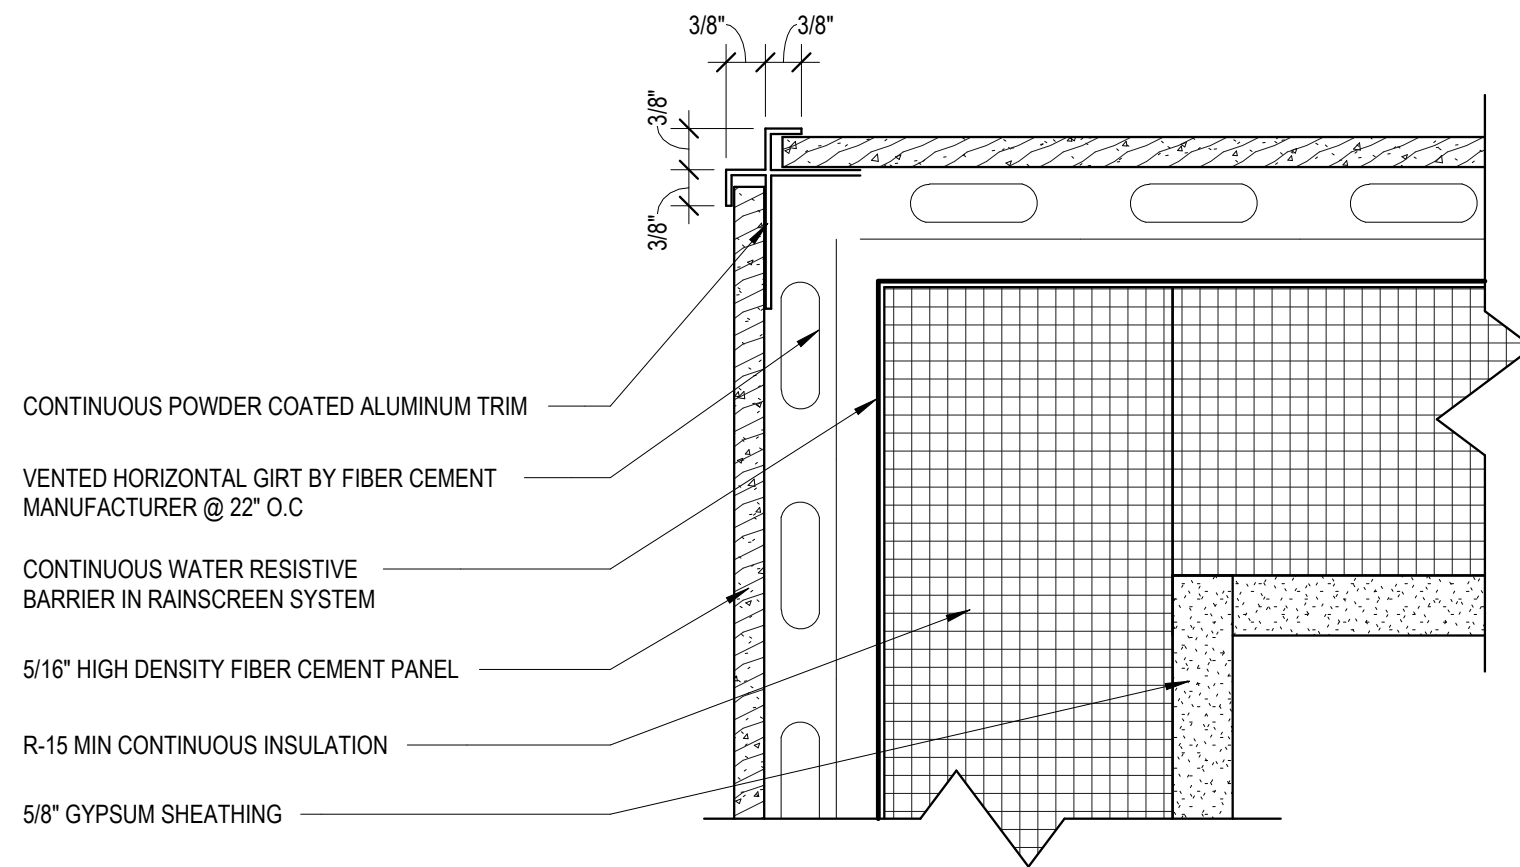

4 CORNER TRIM DETAIL
MF-A202 6" = 1'-0"

NOTE: PROVIDE CONTINUOUS POWDER COATED ALUMINUM TRIM ON ALL OUTSIDE CORNERS INCLUDING ABOVE 90 DEGREE STOREFRONT WINDOWS SEE FLOOR PLAN AND DETAILS FOR LOCATION CALLOUTS.

Susan Hatchell
Landscape Architecture, PLLC
711 W. North Street, Raleigh, NC 27603
p: 919-838-9600 f: 919-838-9700

Esse Architects
832 PERSHING ROAD | RALEIGH, NORTH CAROLINA 27608


EXTERIOR PANEL
LAYOUT

LAKE MYRA COUNTY PARK
Wake County, NC

REVISIONS

Date: 07/27/26

MF-A202

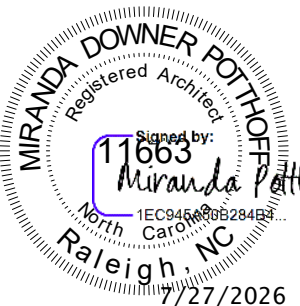




- NOTES:
1. IMAGE IS FOR REFERENCE, CONFIRM LAYOUT THROUGH SHOP DRAWINGS
 2. CENTER VERTICAL PANEL JOINTS WITH THE CENTER OF STEEL BEAMS ABOVE
 3. SEE MF-202 FOR HIGH DENSITY FIBER CEMENT PANEL PATTERN AND PLACEMENT

Susan Hatchell
Landscape Architecture, PLLC
711 W. North Street, Raleigh, NC 27603
p: 919-838-9600 f: 919-838-9700



EXTERIOR PANEL
LAYOUT


LAKE MYRA COUNTY PARK
Wake County, NC

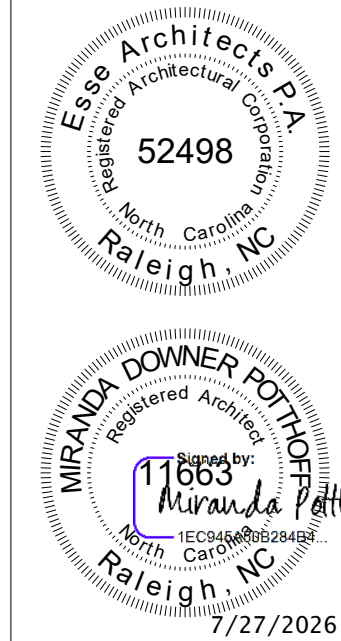


REVISIONS

Date: 07/27/26


MF-A203

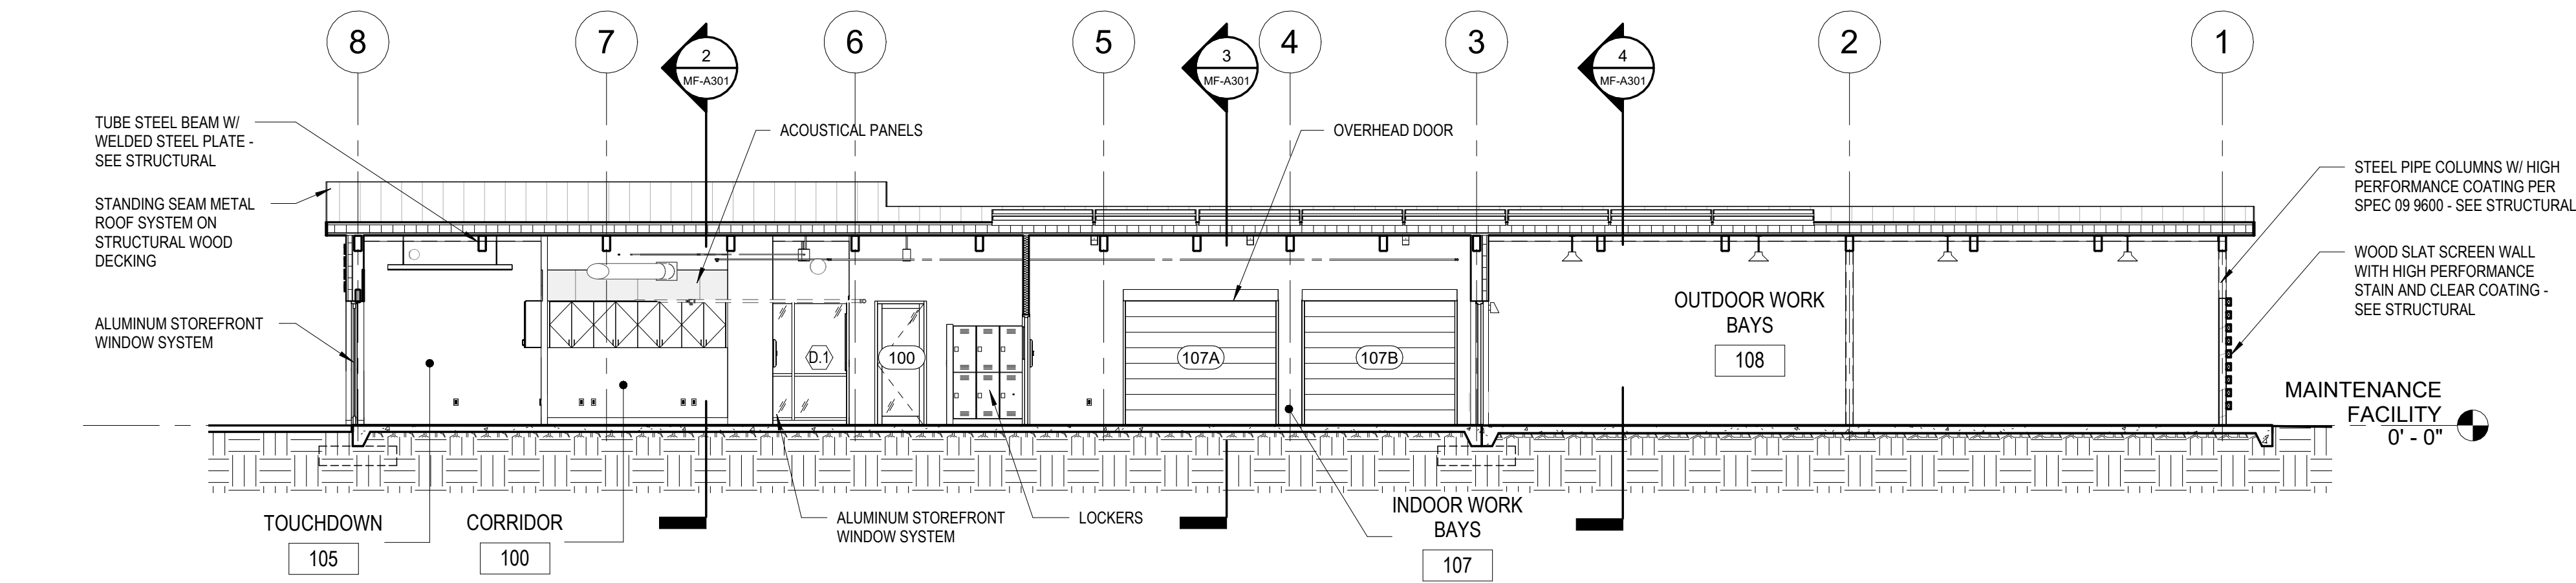


1 MAINTENANCE FACILITY - LONGITUDINAL SECTION
1/8" = 1'-0"

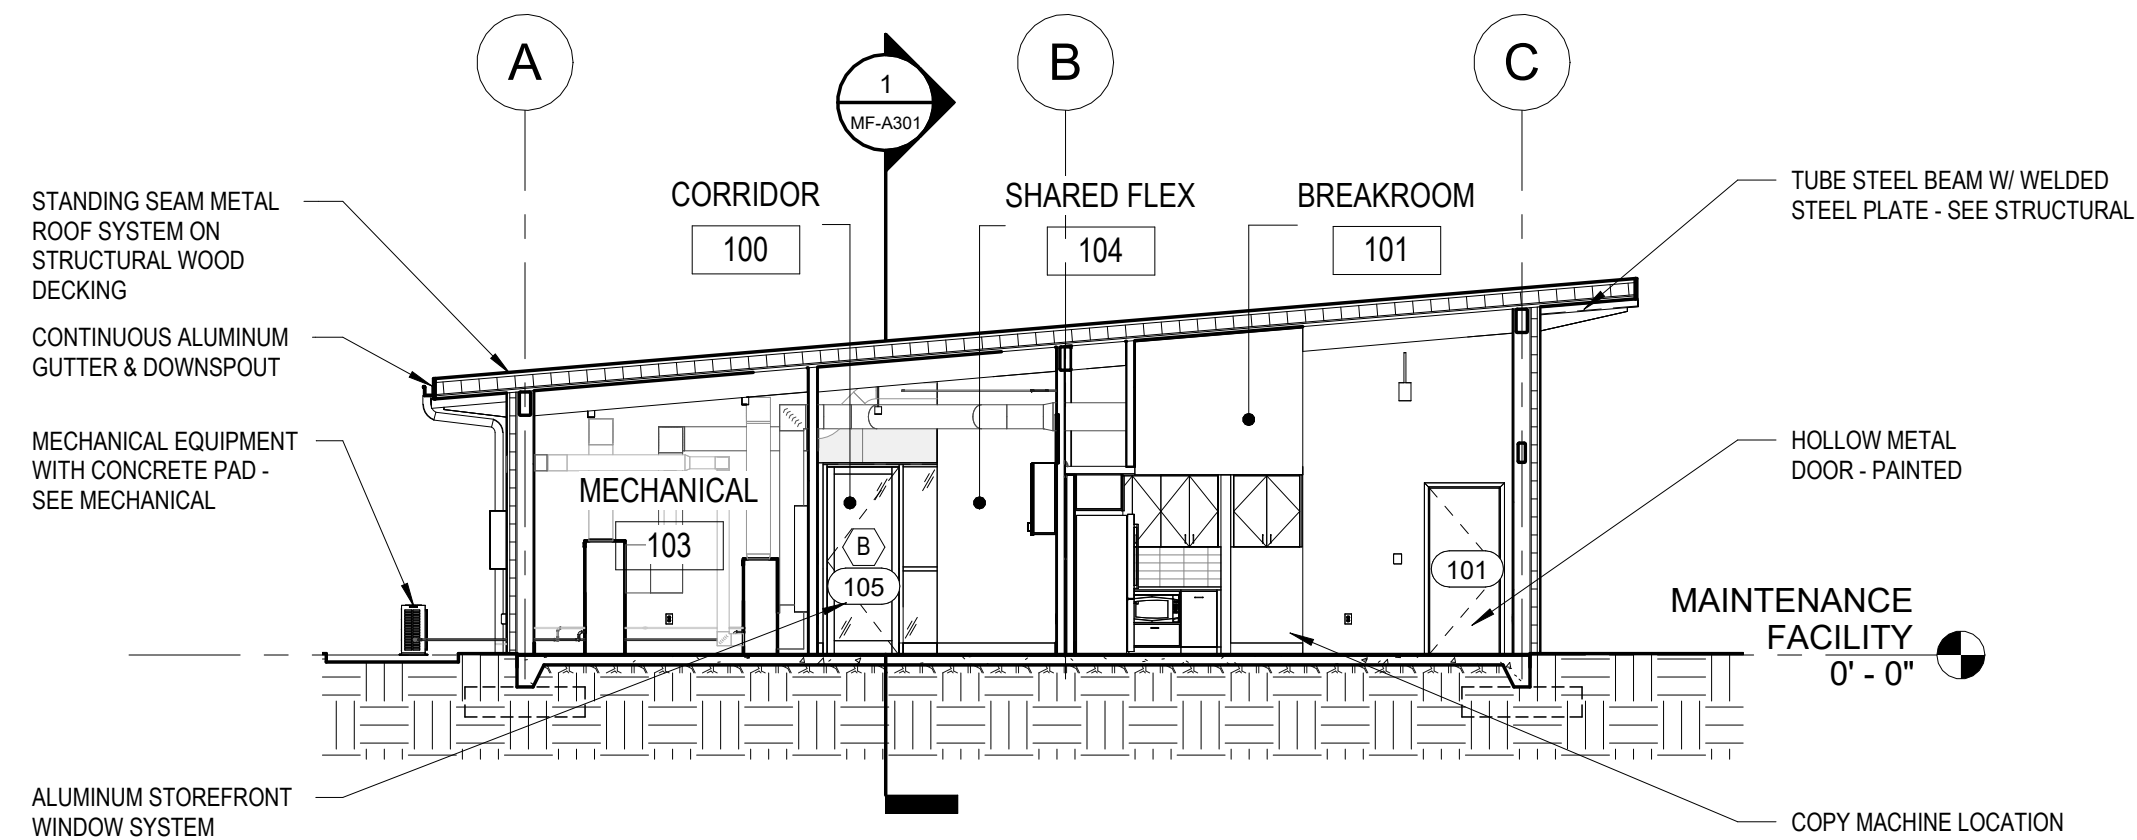

2 MAINTENANCE FACILTY - TRANSVERSE SECTION THROUGH BREAKROOM
1/8" = 1'-0"

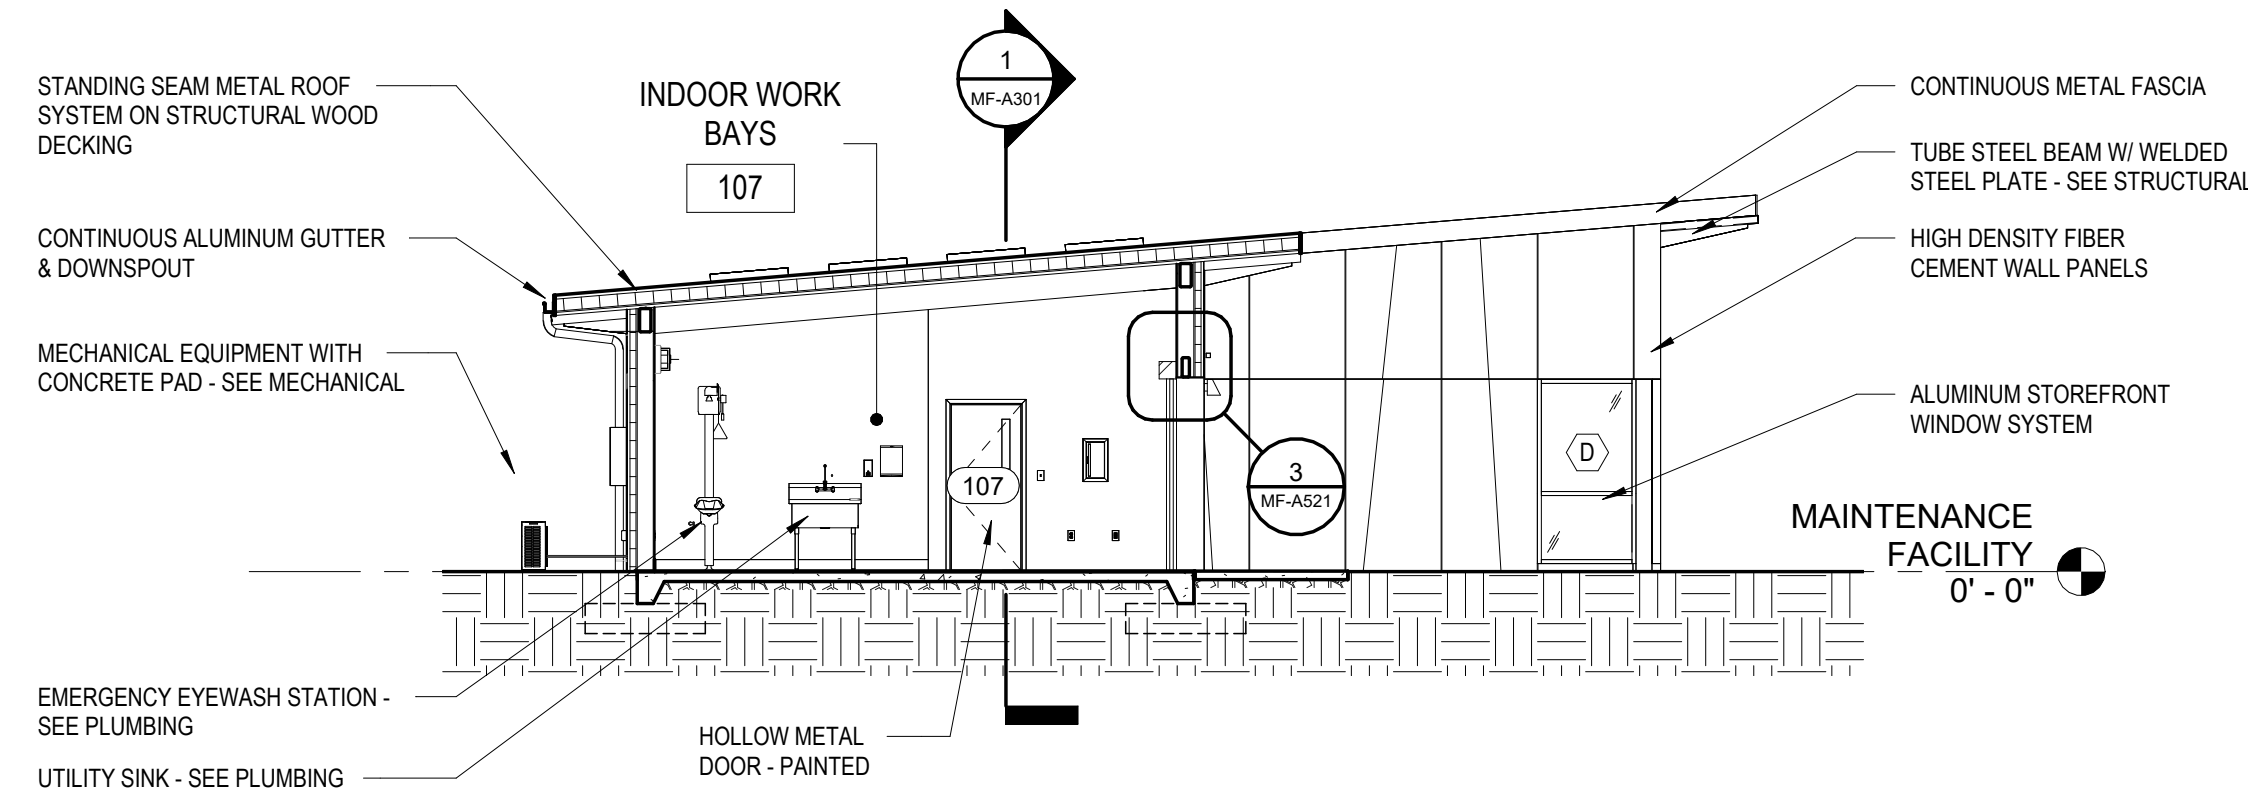

3 MAINTENANCE FACILITY - TRANSVERSE SECTION THROUGH INDOOR WORK BAYS
1/8" = 1'-0"

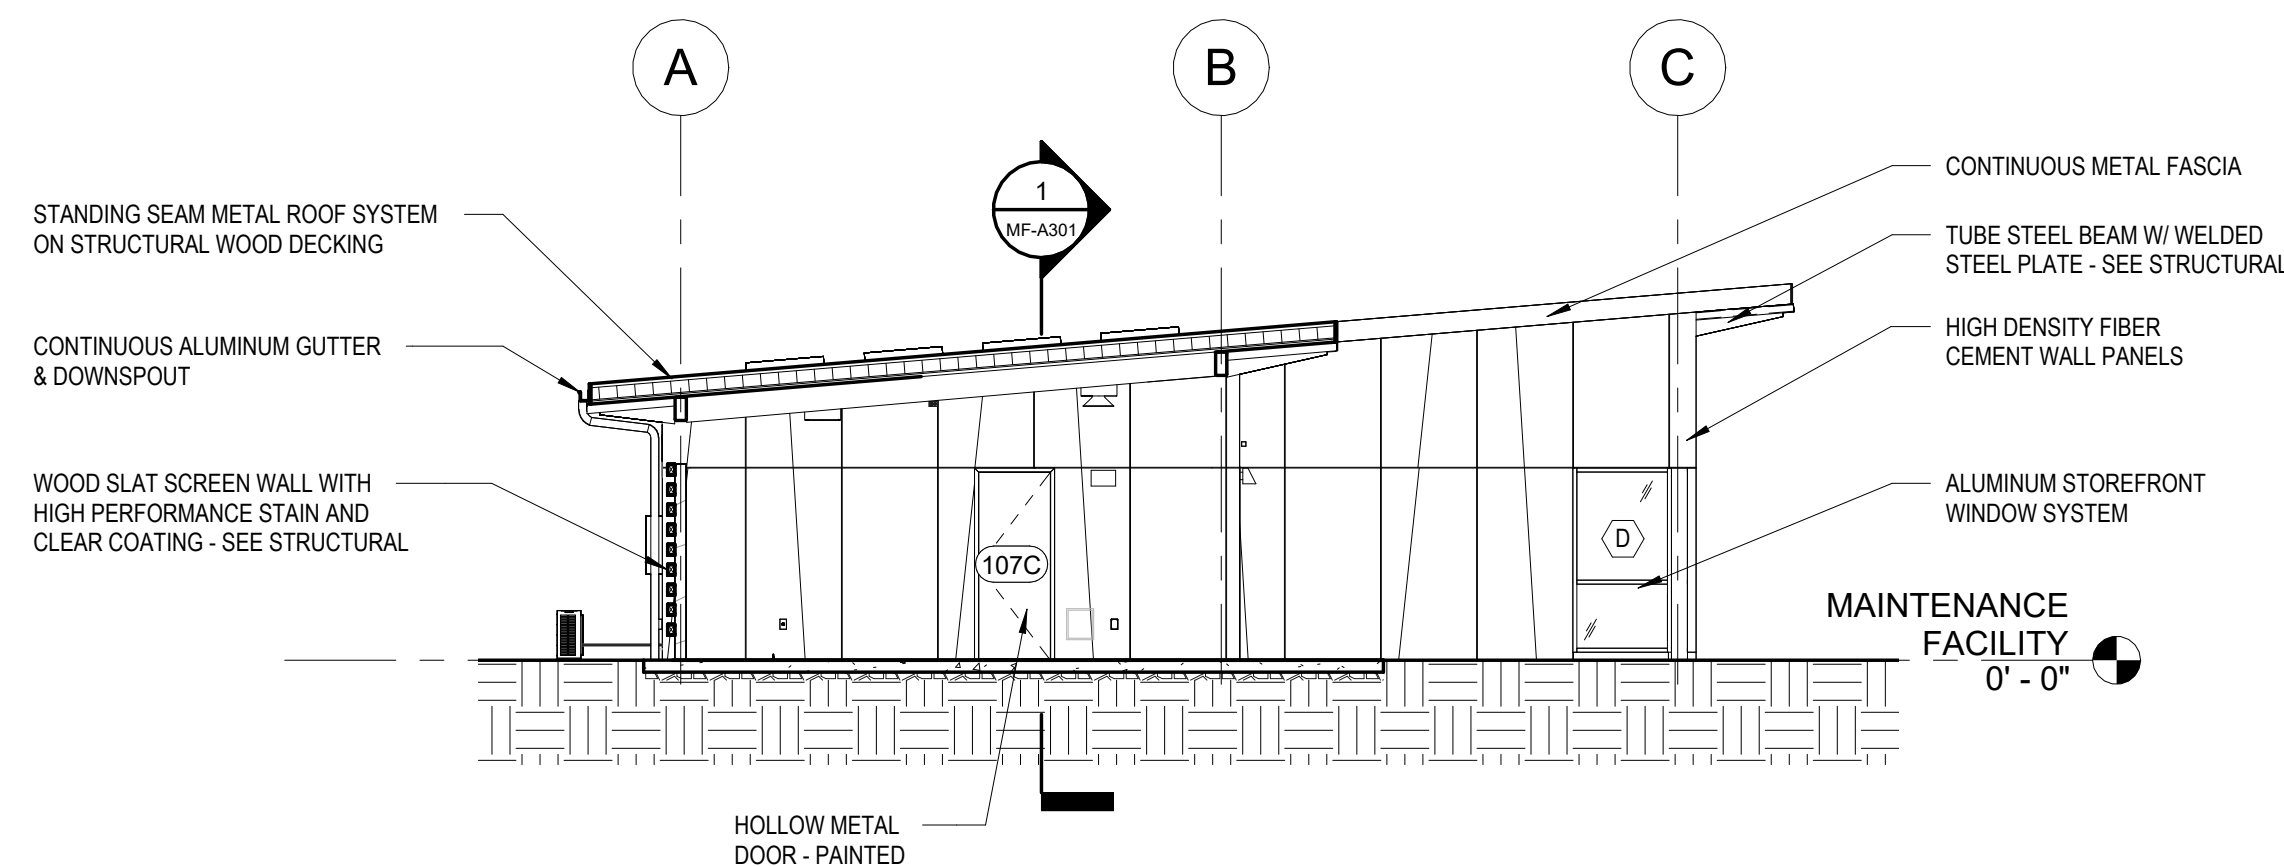


4 MAINTENANCE FACILITY - TRANSVERSE SECTION THROUGH OUTDOOR WORK BAYS
1/8" = 1'-0"

Susan
Hatchell
Landscape Architecture, PLLC
711 W. North Street, Raleigh, NC 27603
p: 919-838-9600 f: 919-838-9700

Esse
Architects
832 FRESHWIND ROAD | RALEIGH, NORTH CAROLINA 27608

BUILDING SECTIONS

LAKE MYRA COUNTY PARK
Wake County, NC

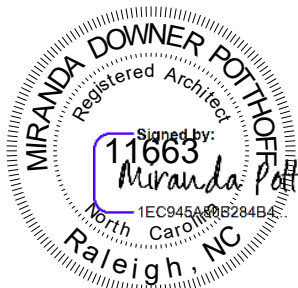


REVISIONS


Date: 07/27/26

MF-A301


NOTE: FLUSH VALVE
MUST BE MOUNTED
TO THE WIDE SIDE
OF THE STALL.

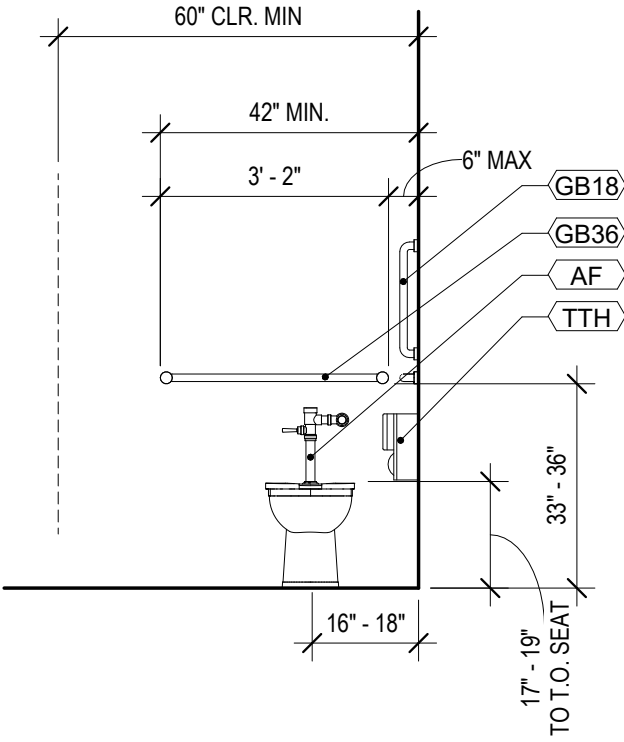


A
ADA TOILET STALL,
FRONT ELEVATION

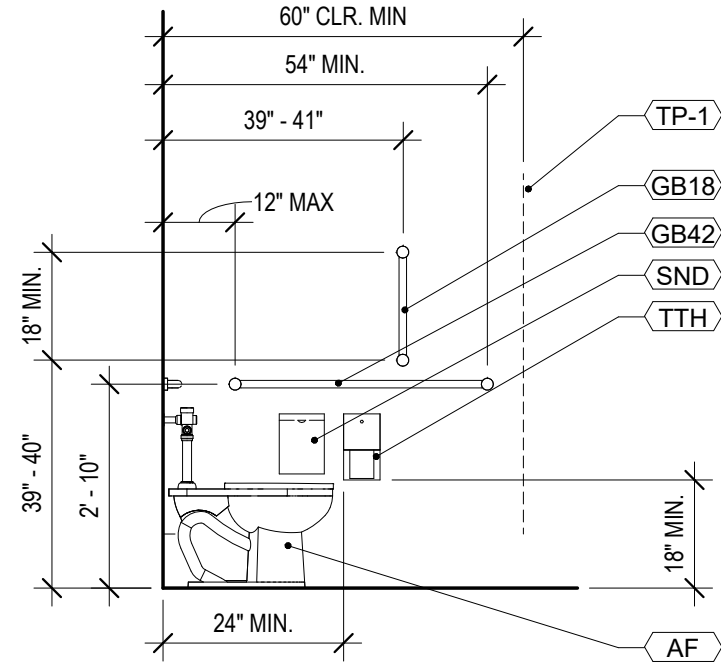


A
ADA TOILET STALL,
SIDE ELEVATION

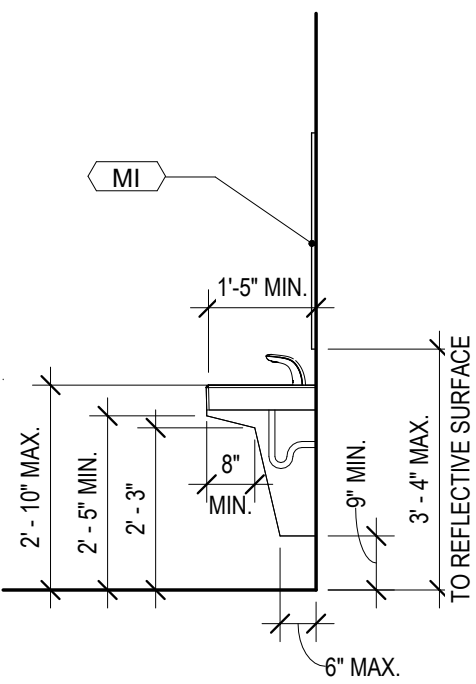


E
ADA WALL - MOUNTED SINK,
SIDE ELEVATION

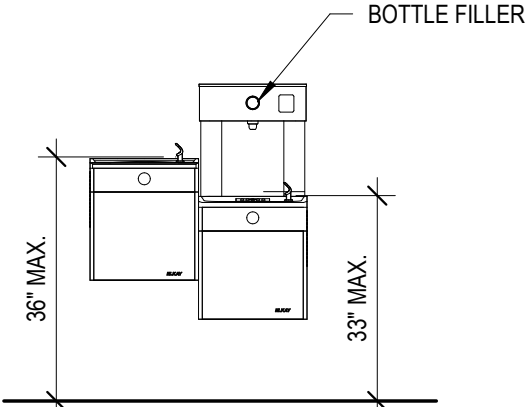


J
ADA WATER FOUNTAIN,
FRONT ELEVATION

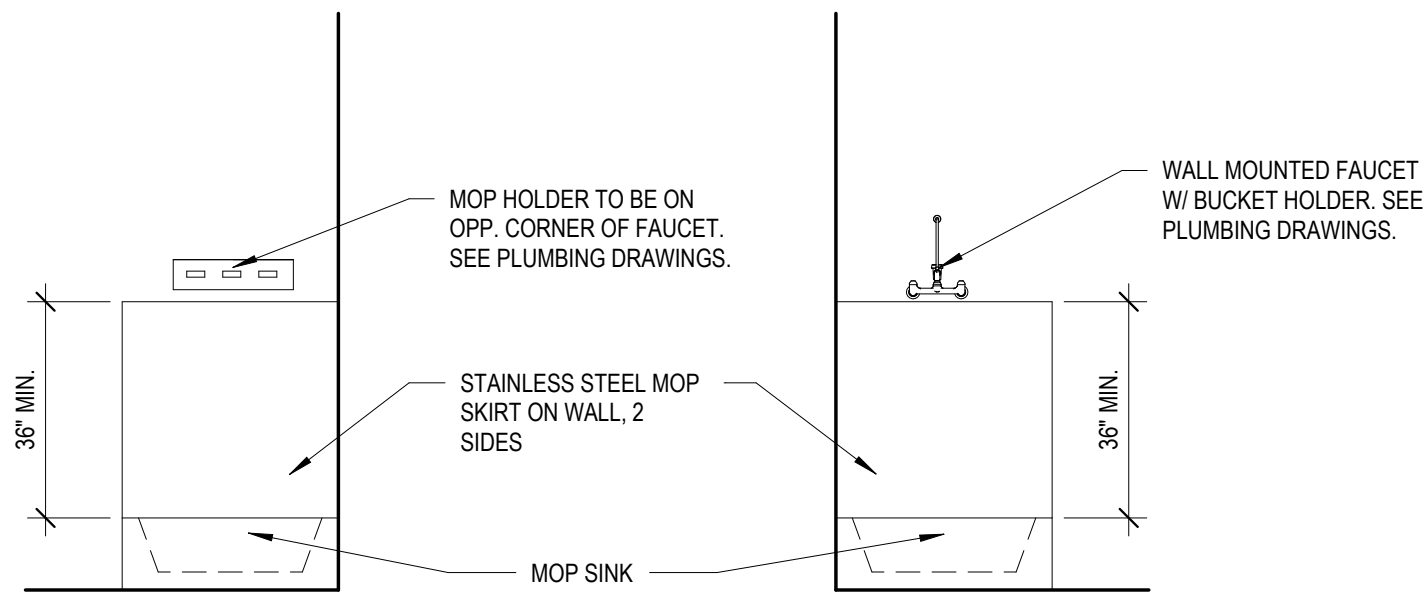

K
MOP SINK,
SIDE ELEVATIONS

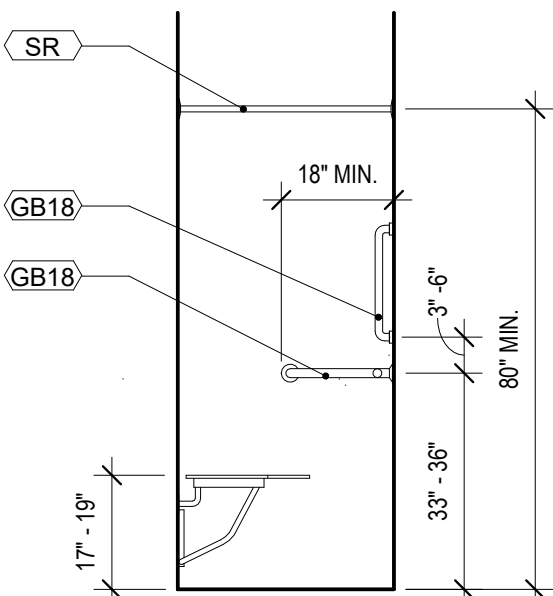


F
ADA TRANSFER SHOWER,
BACK WALL ELEVATION

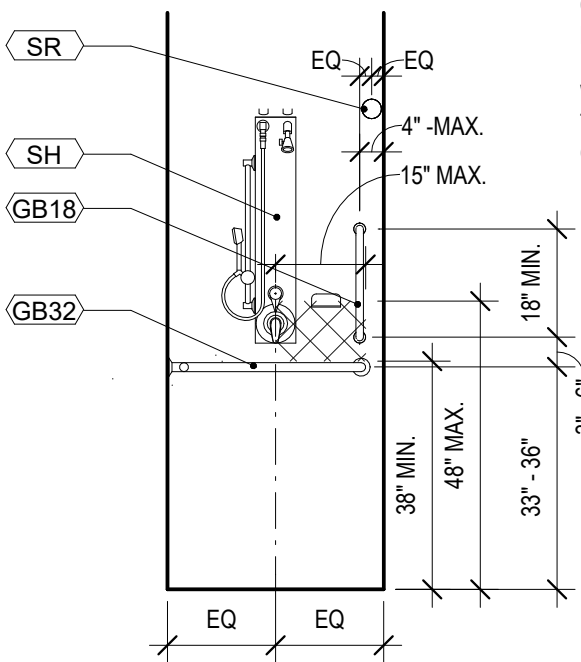

F
ADA TRANSFER SHOWER,
CONTROL WALL ELEVATION

CONTROLS ARE REQUIRED TO BE
LOCATED ON CONTROL WALL. THE
HORIZONTAL PLACEMENT MUST BE
WITHIN 15" OF THE CENTERLINE OF
THE SEAT LOCATED ON THE
OPPOSING WALL.

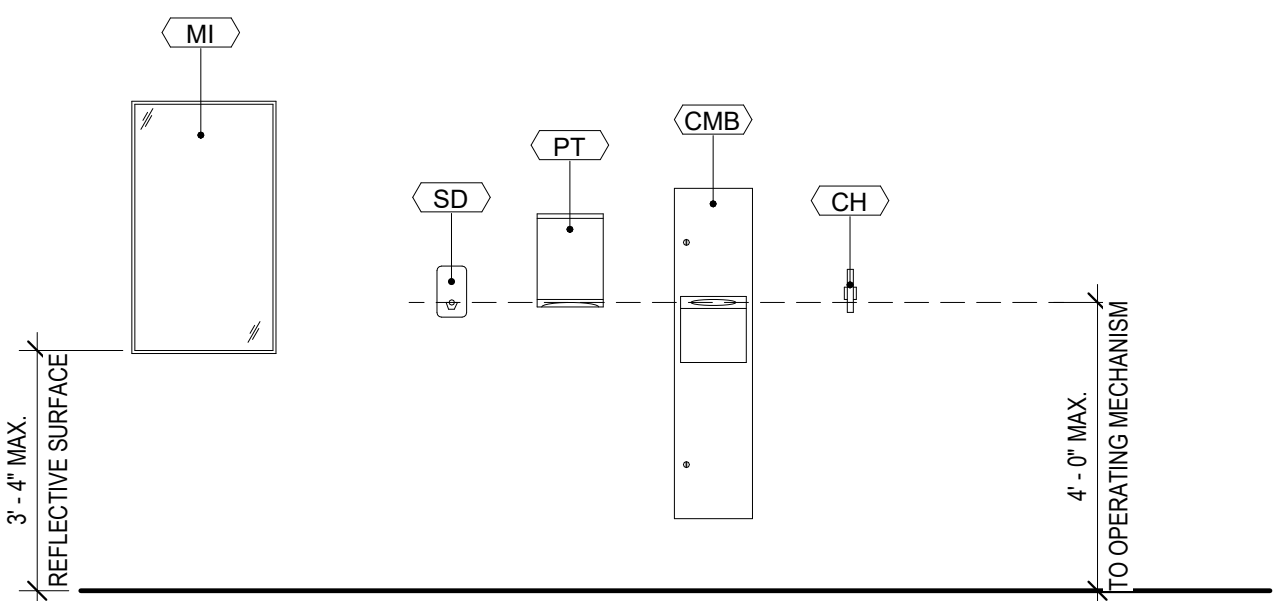


TOILET ACCESSORY MOUNTING HEIGHTS

SYMBOL LEGEND	
X-X	FINISH TAG
X	TOILET ASSEMBLY TAG. SEE A400 FOR ADDITIONAL INFORMATION
#	PARTITION TAG

#	TOILET ACCESSORIES LEGEND
AF	ACCESSIBLE FIXTURE
ASH	ACCESSIBLE SHOWER HEAD
CF	CLEAR FLOOR SPACE 30" x 52"
CH	COAT HOOK
CMB	COMBINED PAPER TOWEL/TRASH
FD	FLOOR DRAIN - SEE PLUMBING DRAWINGS
FDS	FOLD-DOWN SEAT
GB	GRAB BAR
GB18	GRAB BAR 18" LONG (VERTICAL)
GB24	GRAB BAR 24" LONG (SIDE WALLS)
GB32	GRAB BAR 32" LONG (REAR WALLS)
GB36	GRAB BAR 36" LONG (REAR WALLS)
GB42	GRAB BAR 42" LONG (SIDE WALLS)
MI	MIRROR 24" X 36"
PT	PAPER TOWEL DISPENSER
SD	SOAP DISPENSER
SH	SHOWER HEAD
SR	SHOWER ROD
TD	67" ACCESSIBLE TURNING DIAMETER
TH	TOWEL HOOK
TTH	TOILET TISSUE HOLDER
US	UTILITY SHELF

NOTES:

1. PLUMBING CONTRACTOR TO PROVIDE PROTECTIVE INSULATION AT HOT PIPES BELOW LAVATORY PER ACCESSIBILITY CODE.
2. FLUSH CONTROL VALVES AT ACCESSIBLE TOILETS TO BE MOUNTED ON THE WIDE SIDE OF TOILET STALL OR ROOM.
3. SEE SPECIFICATIONS FOR DETAILS OF TOILET ACCESSORIES.
4. ALL TOILET PARTITIONS ARE FLOOR MOUNTED AND OVERHEAD BRACED.
5. SLOPE FLOOR TILE TO DRAIN WITH MUD BED. THRESHOLDS SLOPE IN DOOR OPENINGS SHALL NOT EXCEED 1:8 SLOPE OR 1/2" IN HEIGHT PER ACCESSIBILITY CODE.

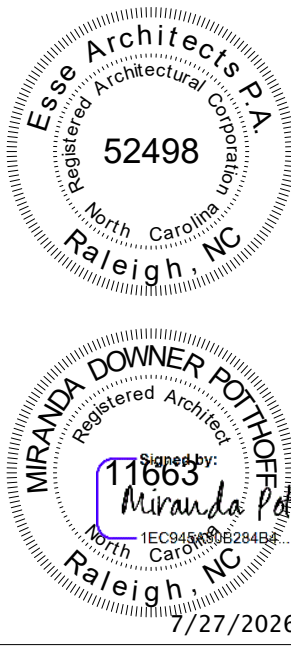

Susan Hatchell
Landscape Architecture, PLLC
711 W. North Street, Raleigh, NC 27603
p: 919-838-9600 f: 919-838-9700




TYPICAL TOILET AND
BATH ACCESSORIES

LAKE MYRA COUNTY PARK
Wake County, NC


REVISIONS

Date: 07/27/26


MF-A400

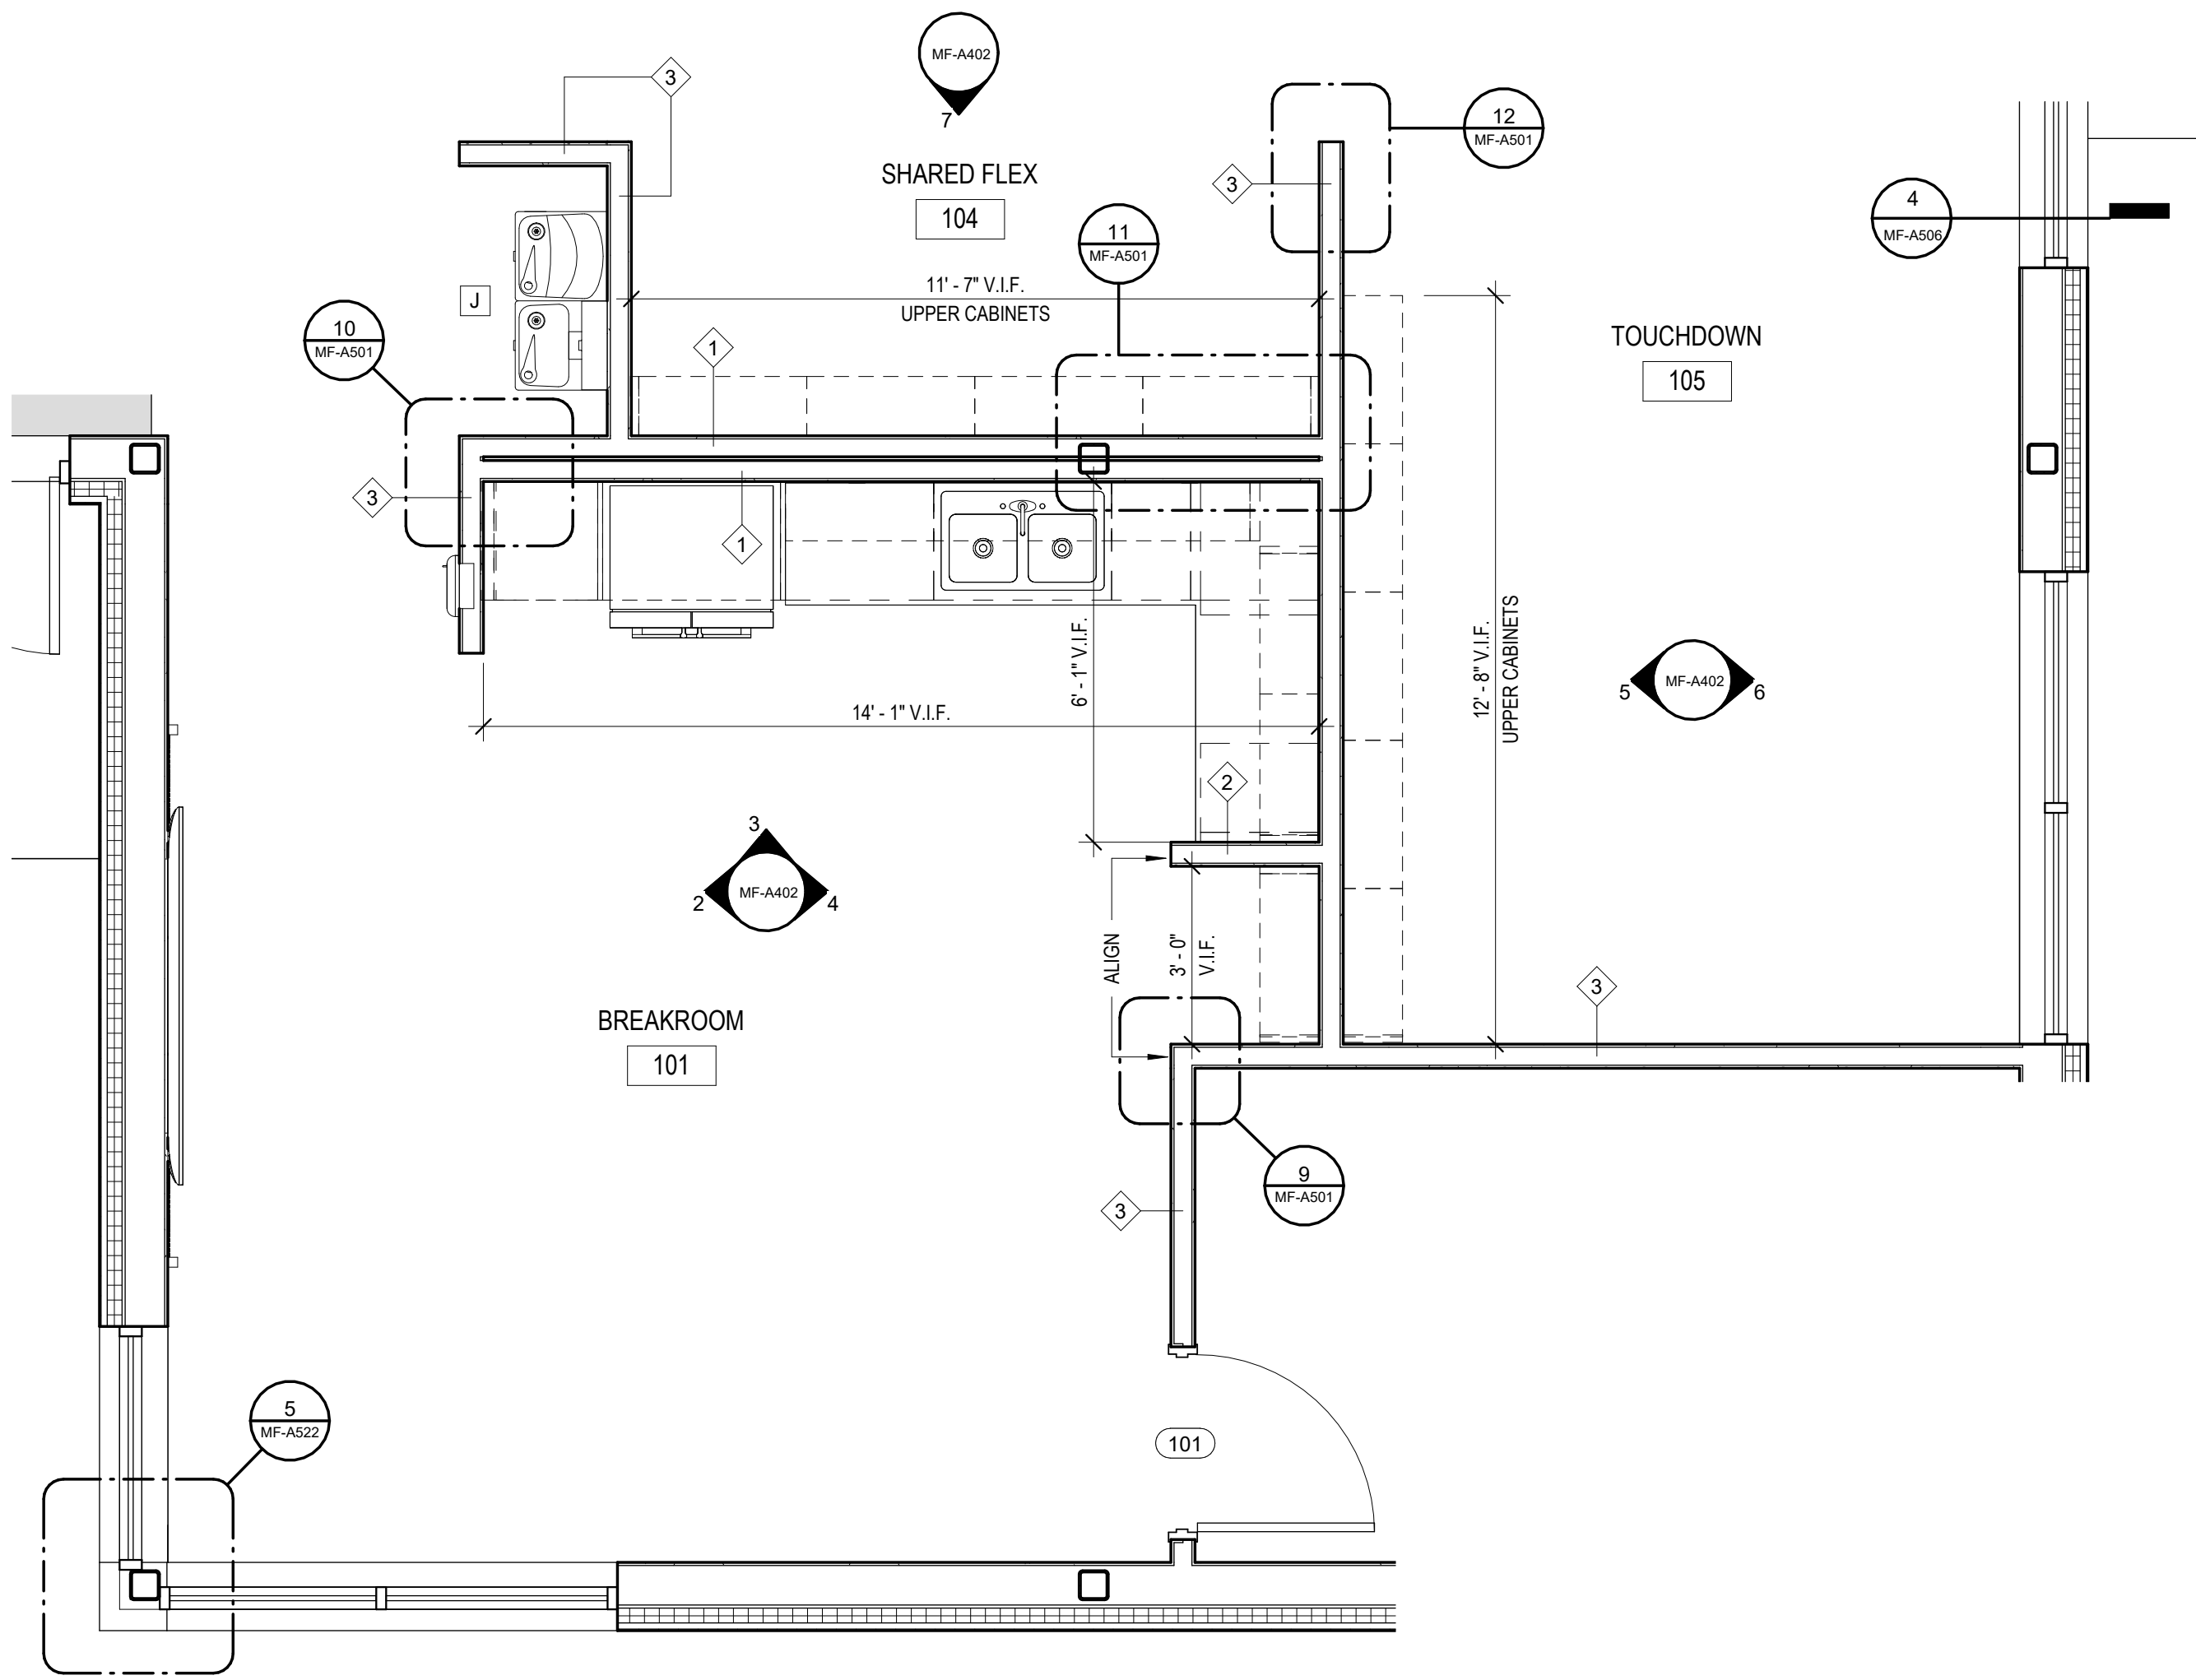


1 BREAKROOM, SHARED FLEX & TOUCHDOWN (101, 104, 105) - ENLARGED PLAN
MF-A402 3/8" = 1'-0"

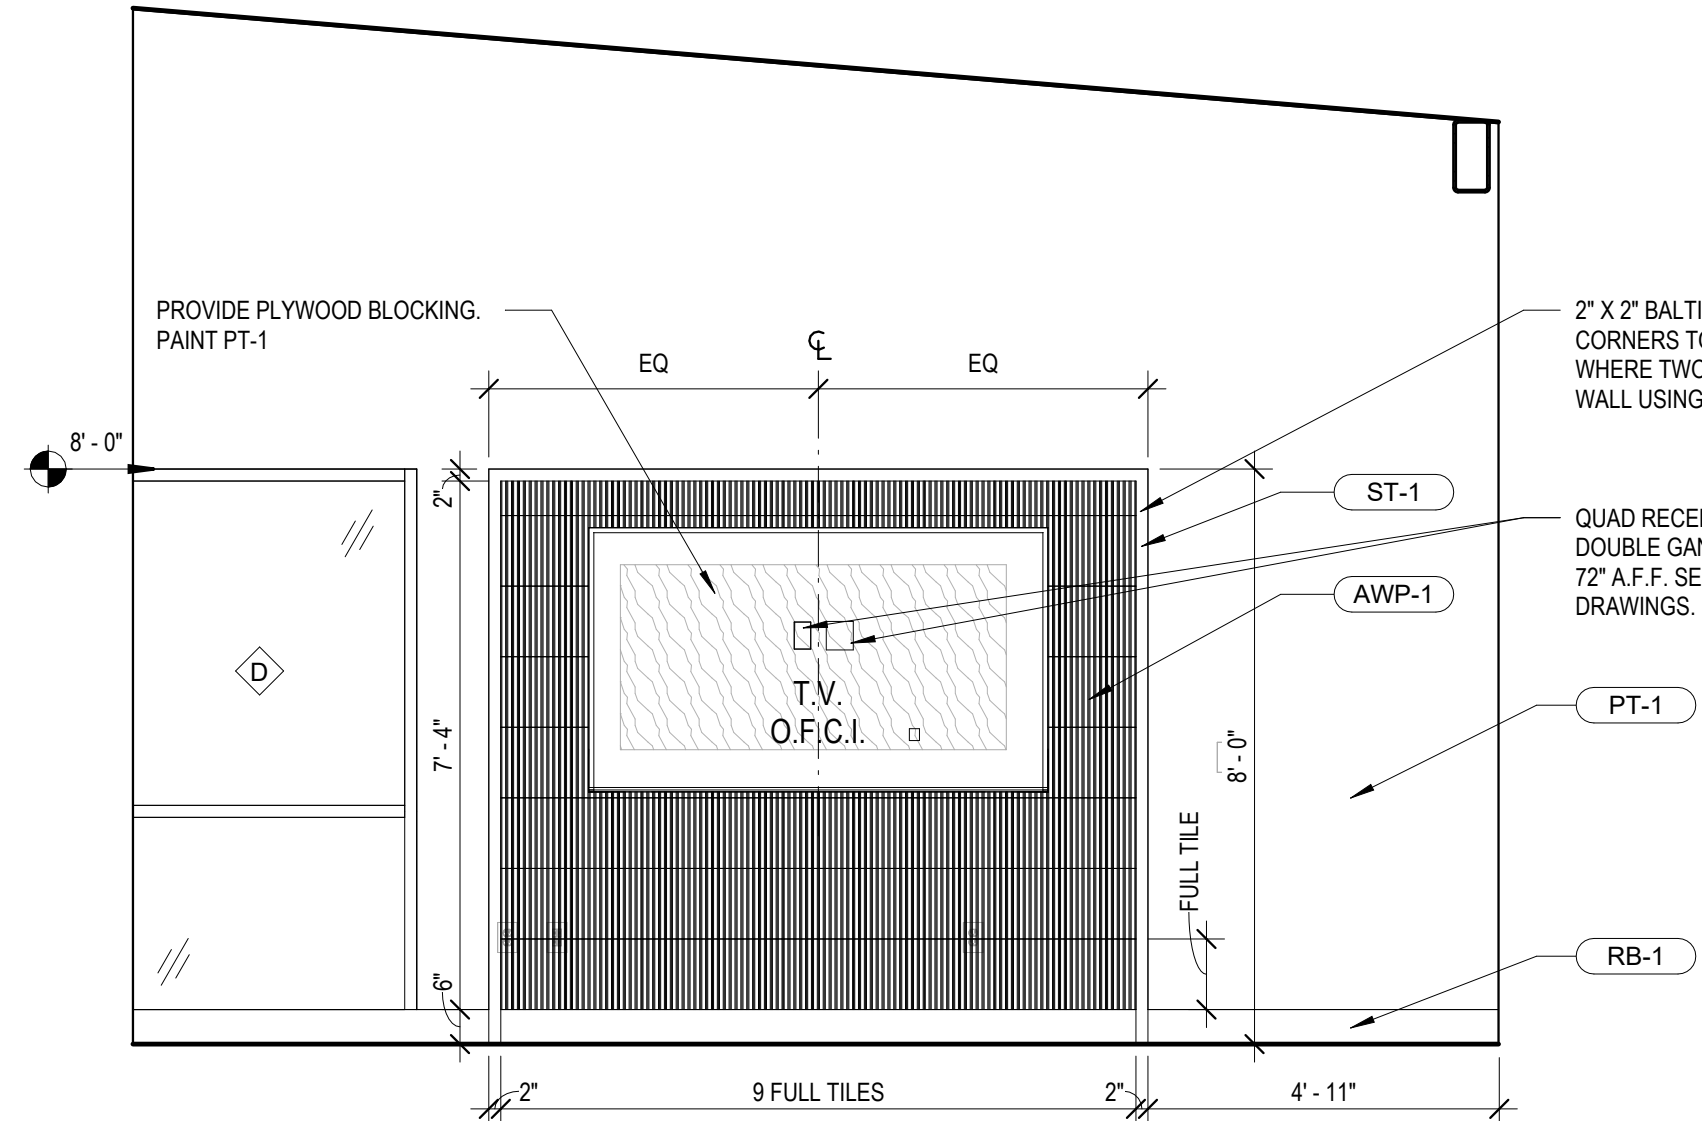


2 BREAKROOM (101) - WEST ELEVATION
MF-A402 3/8" = 1'-0"

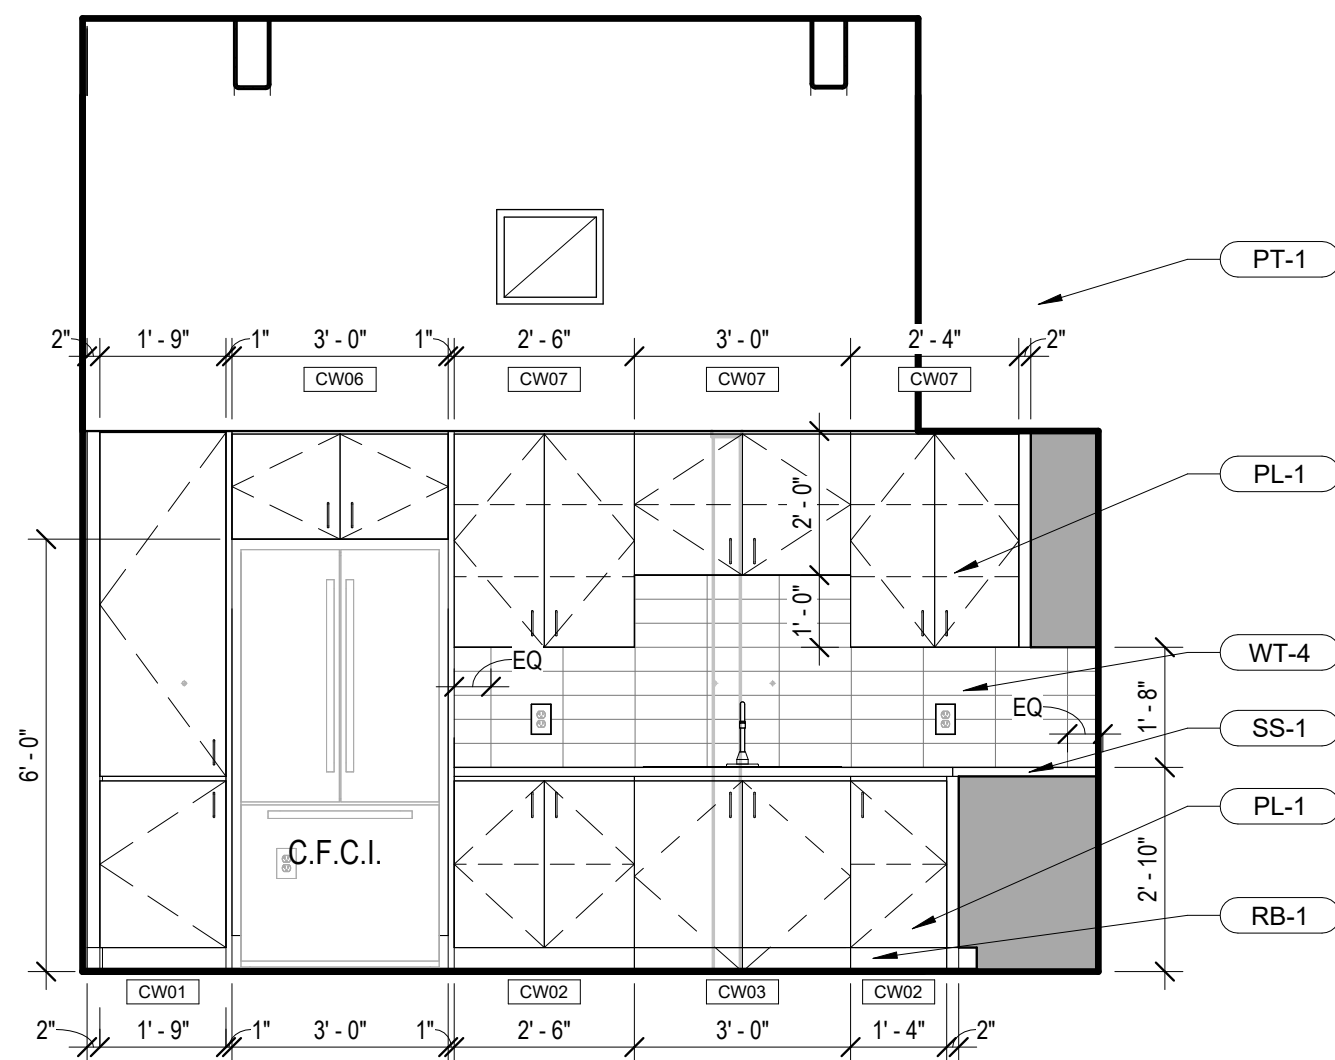


3 BREAKROOM (101) - NORTH ELEVATION
MF-A402 3/8" = 1'-0"

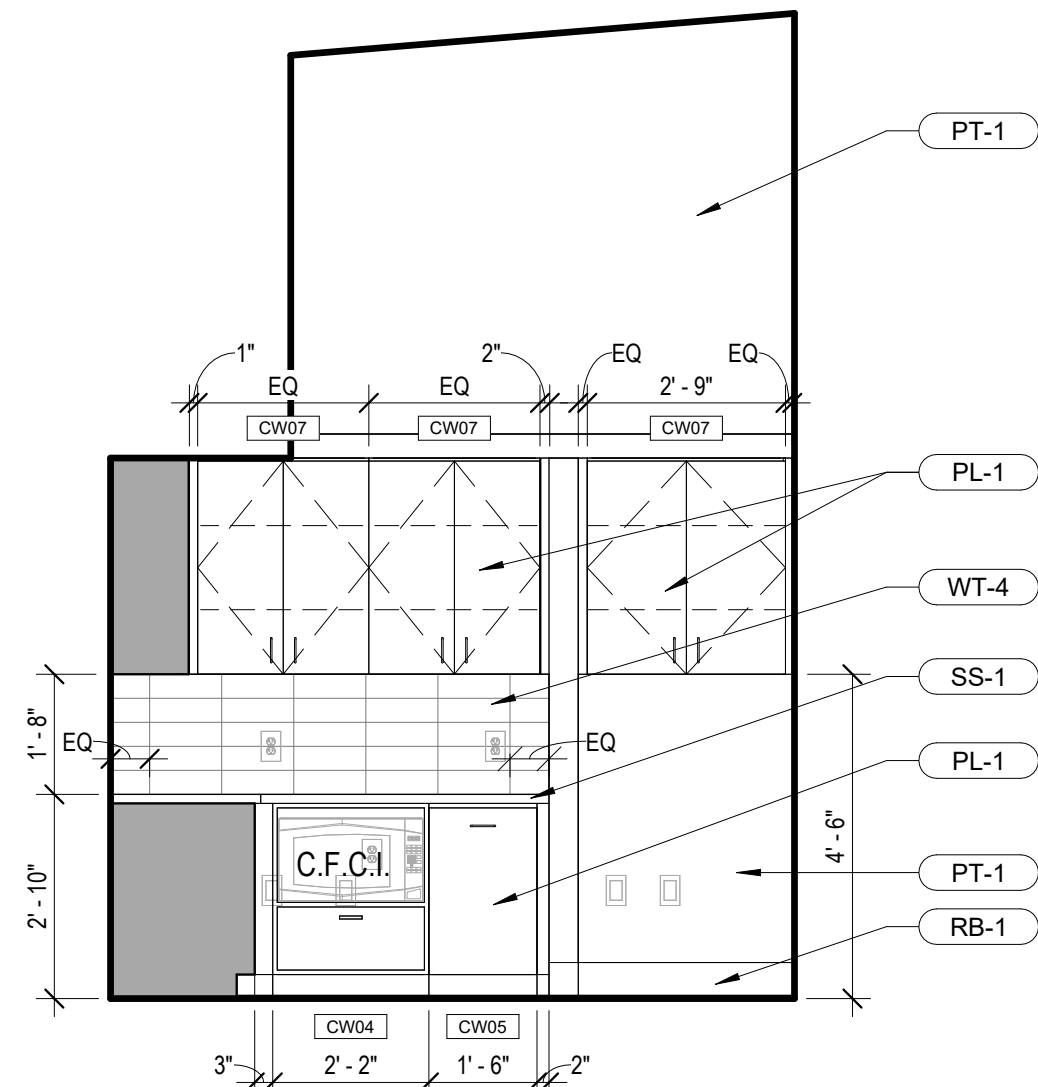


4 BREAKROOM (101) - EAST ELEVATION
MF-A402 3/8" = 1'-0"

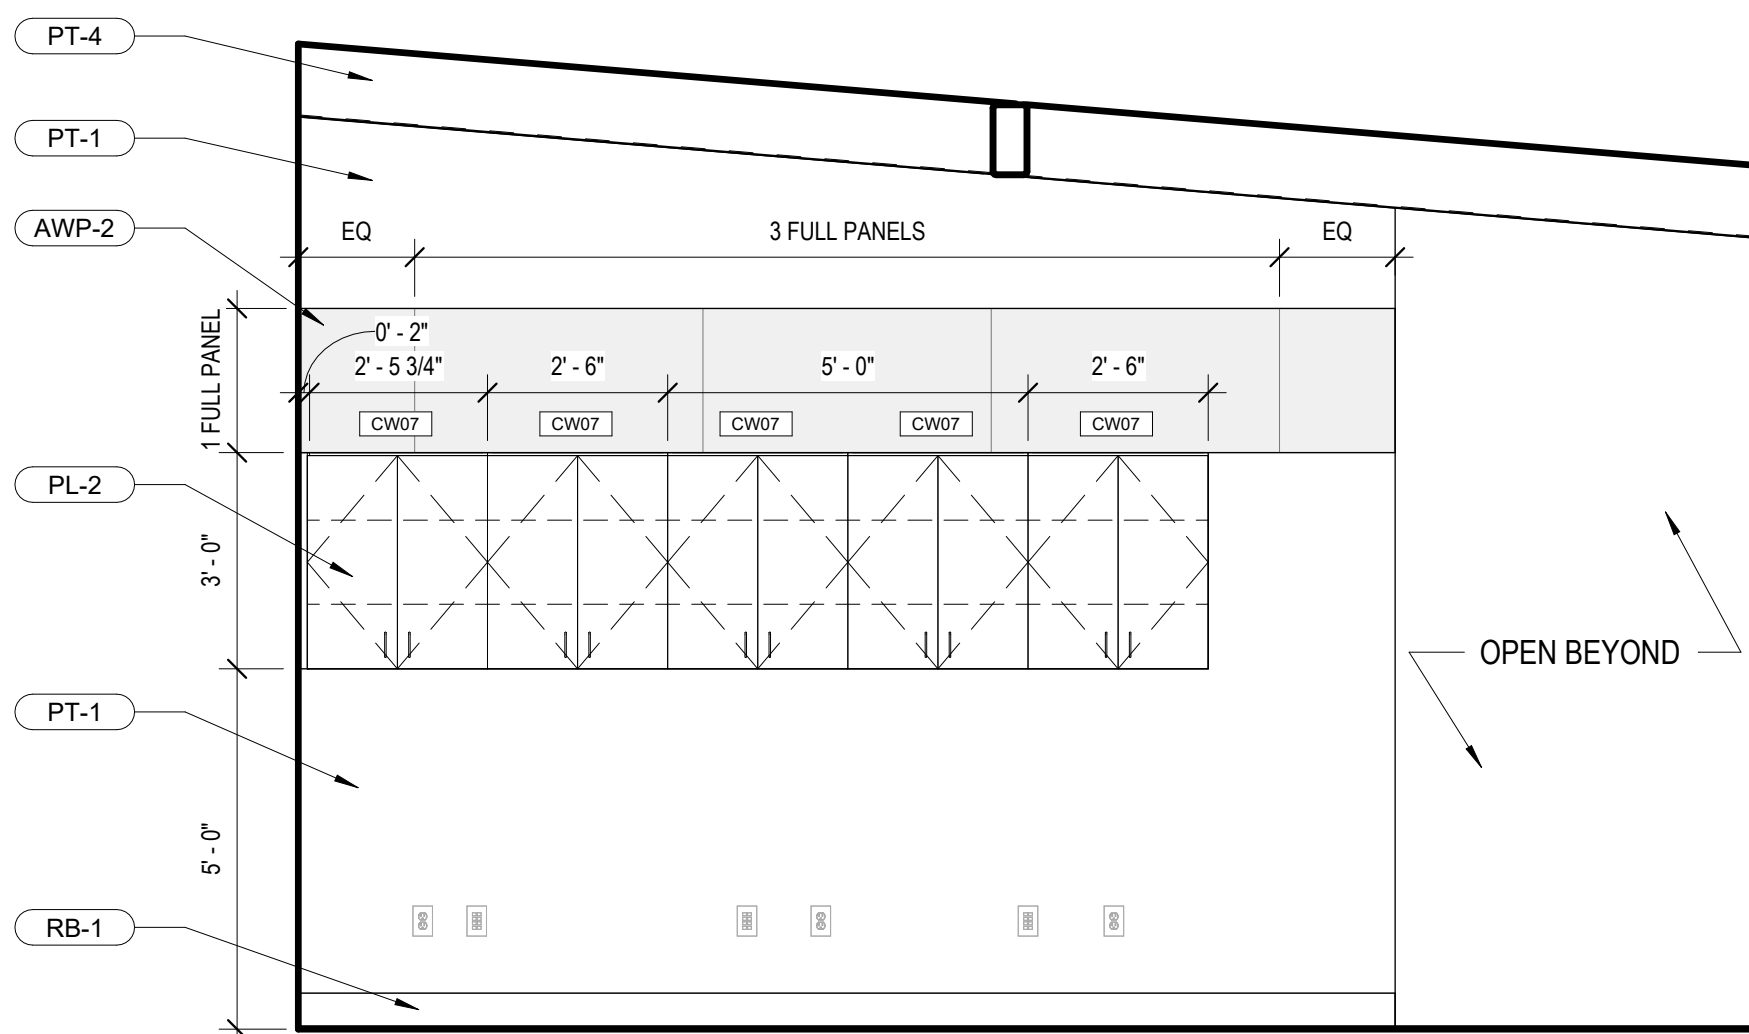

5 TOUCHDOWN (105) - WEST ELEVATION
MF-A402 3/8" = 1'-0"

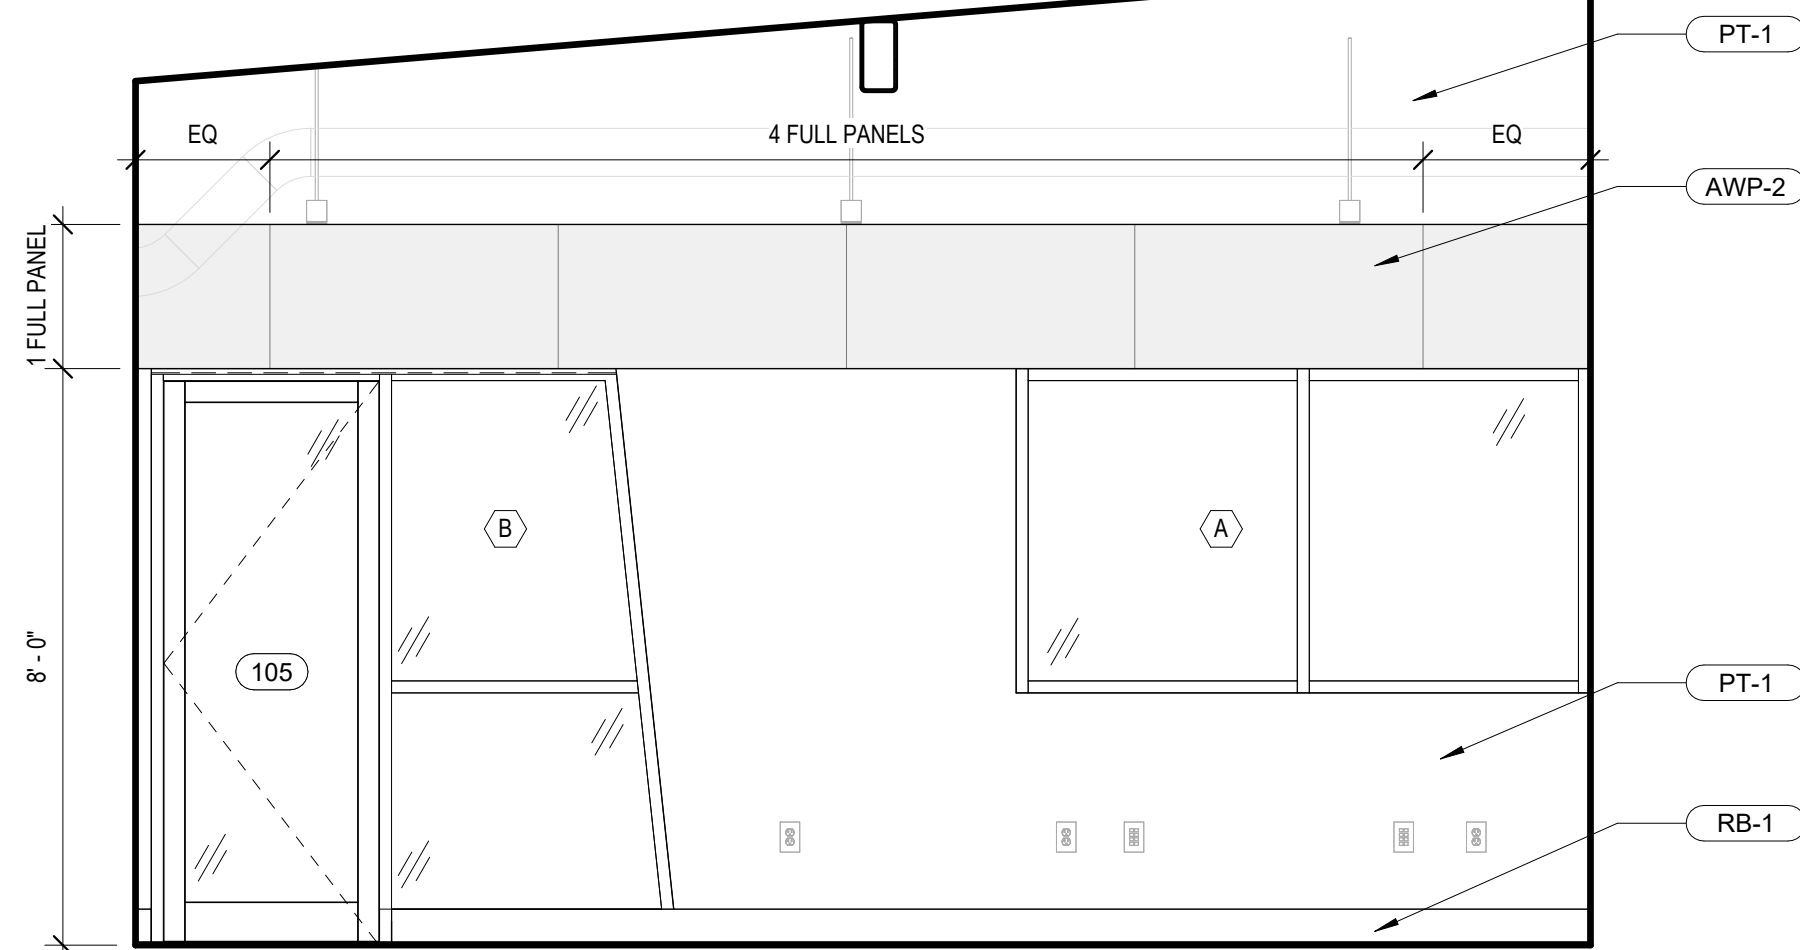

6 TOUCHDOWN (105) - EAST ELEVATION
MF-A402 3/8" = 1'-0"

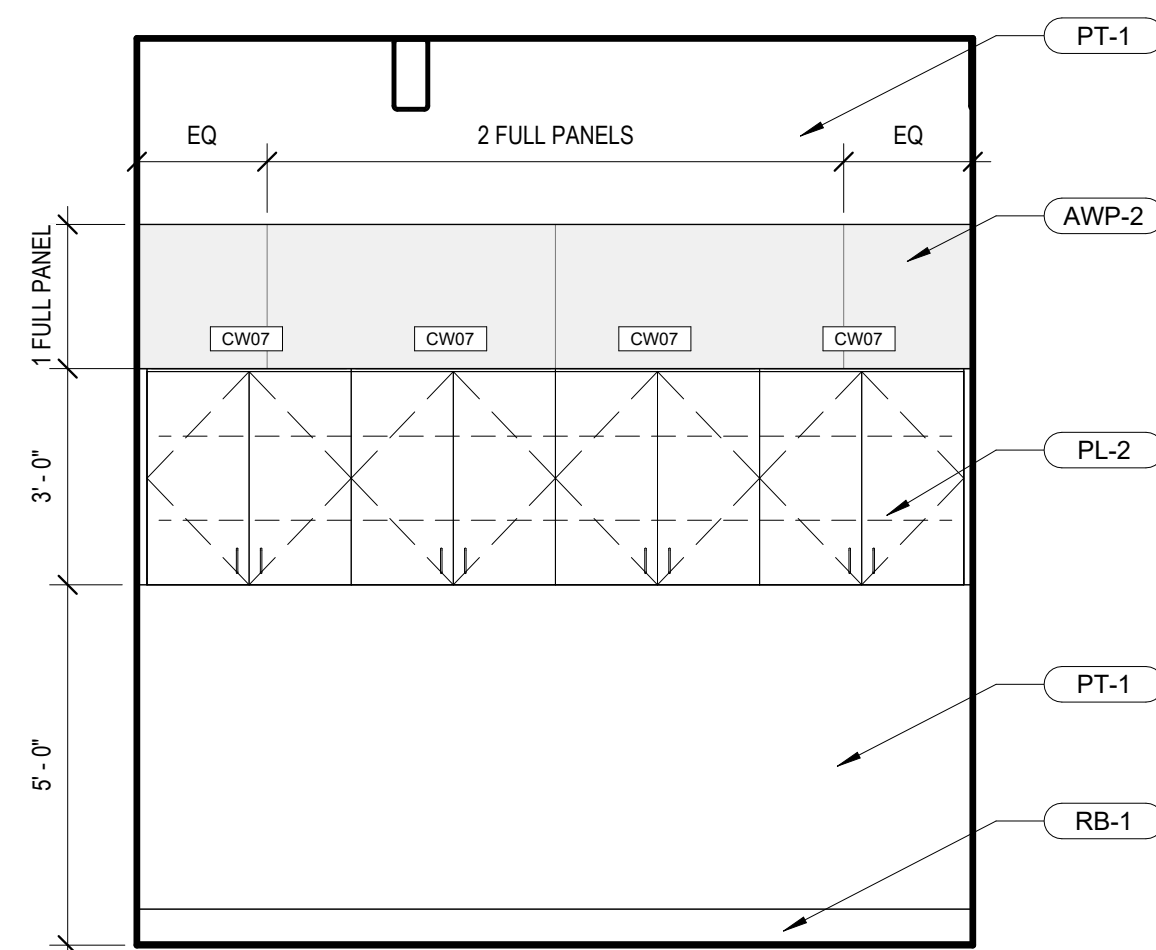

7 SHARED FLEX (104) - SOUTH ELEVATION
MF-A402 3/8" = 1'-0"

SYMBOL LEGEND	
X-X	FINISH TAG
CWXX	CASEWORK TAG
#	PARTITION TAG
GENERAL CASEWORK NOTES	
1. CASEWORK DIMENSIONS SHALL BE FIELD VERIFIED PRIOR TO UNIT FABRICATION AND INSTALLATION.	
2. COUNTERTOPS, UNLESS OTHERWISE NOTED, SHALL HAVE A 4" HIGH BACKSPLASH AND SIDE SPLASH SCRIBED TO CONFORM TO THE SURFACE OF ABUTTING WALLS AT BACKS AND ENDS. COUNTERTOPS AND BACKSPLASH SHALL BE CAULKED TO THE WALL.	
3. GC SHALL COORDINATE WITH CASEWORK FABRICATOR AND APPROPRIATE SUBCONTRACTORS FOR INSTALLATION OF PLUMBING FIXTURES AND EQUIPMENT WITH ASSOCIATED PIPING AND FITTINGS, AND FOR INSTALLATION OF ELECTRICAL RECEPTACLES, LIGHT FIXTURES, ETC. WITHIN THE CASEWORK.	
4. PROVIDE WALL MOUNTED ANGLE SUPPORTS (FINISH TO MATCH THE COLOR AND MATERIAL OF ADJACENT WALL) WHERE NECESSARY FOR SUPPORT OF COUNTERTOPS ABOVE KNEE SPACES.	
5. PROVIDE SCHEDULED BASE ALONG BOTTOM OF EXPOSED FRONTS, BACKS, SIDES, AND ENDS OF ALL AFFIXED CASEWORK, VERTICAL SUPPORTS, KNEE SPACES, ETC. (U.N.O.)	
6. PROVIDE CONCEALED BLOCKING FOR MOUNTING OF ALL SHELVING, HOOKS, DISPENSERS, ETC.	
7. ALL OPENINGS IN COUNTERS SHALL BE CUT IN, NOT SEALED.	

Susan Hatchell
Landscape Architecture, PLLC
711 W. North Street, Raleigh, NC 27603
p: 919-838-9600 f: 919-838-9700

Esse Architects
832 FISHING ROAD | RALEIGH, NORTH CAROLINA 27608


INTERIOR
ELEVATIONS

LAKE MYRA COUNTY PARK
Wake County, NC


REVISIONS

Date: 07/27/26

MF-A402

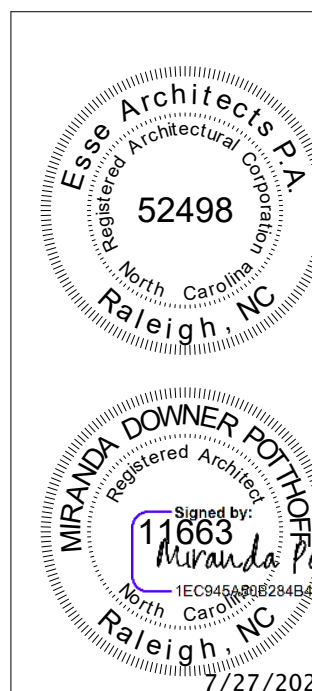

7/27/2026

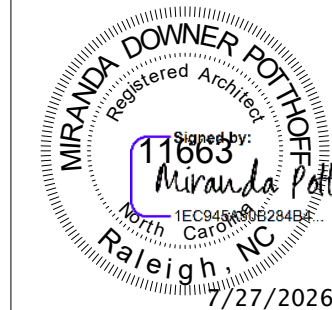


WALL SECTIONS

LAKE MYRA COUNTY PARK
Wake County, NC

REVISIONS

Date: 07/27/26

MF-A422

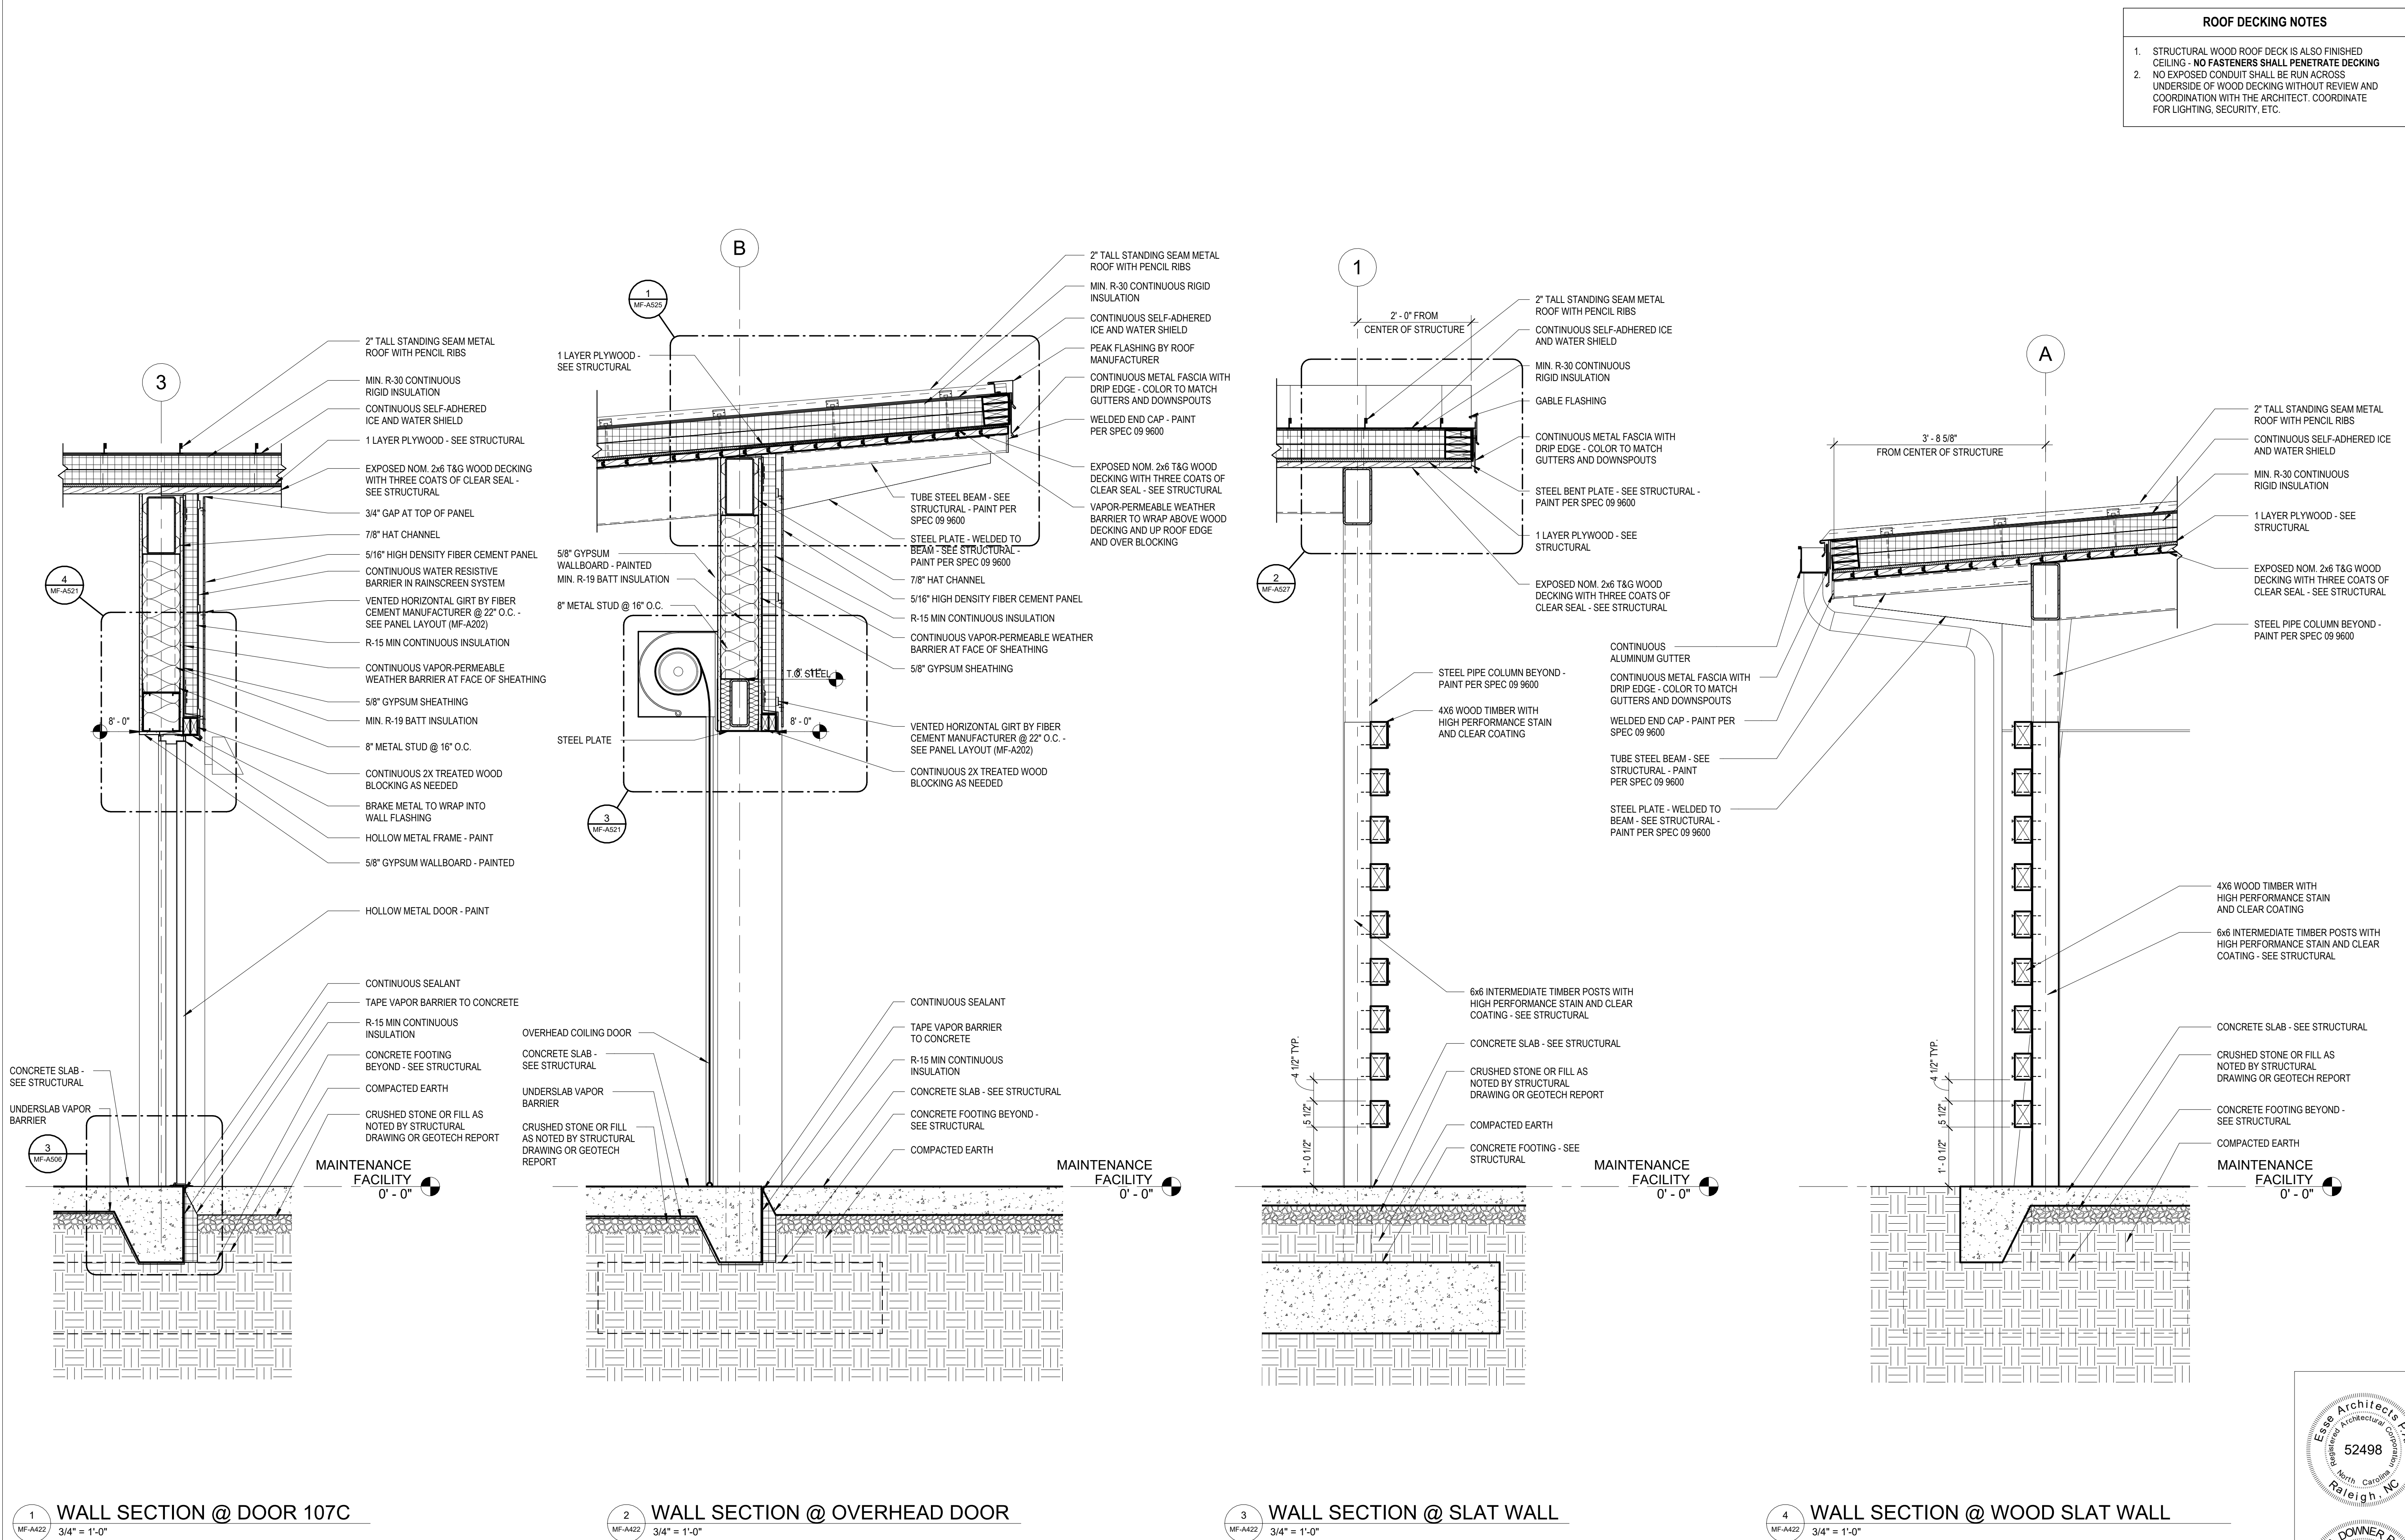










PLAN DETAILS


LAKE MYRA COUNTY PARK
Wake County, NC

REVISIONS


Date: 07/27/26

MF-A501

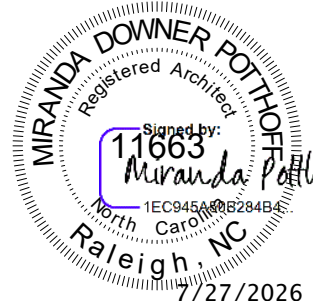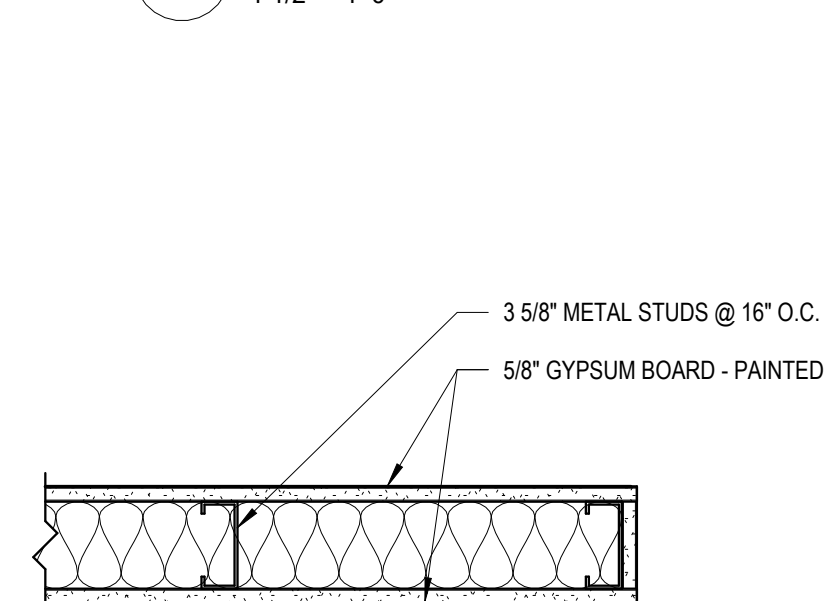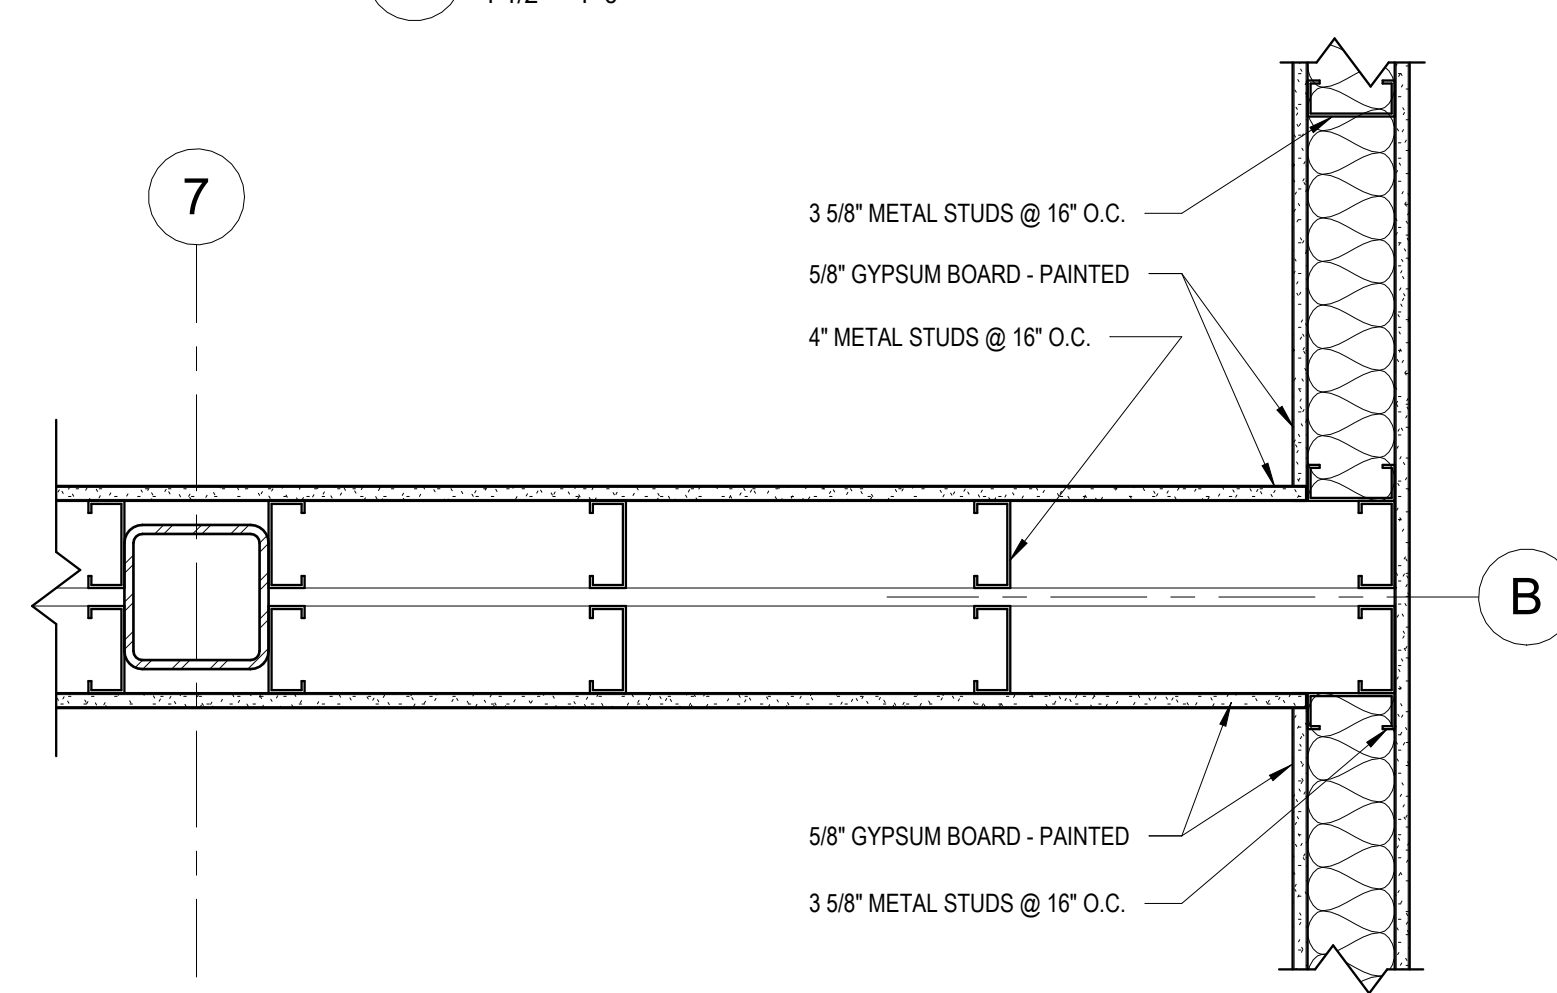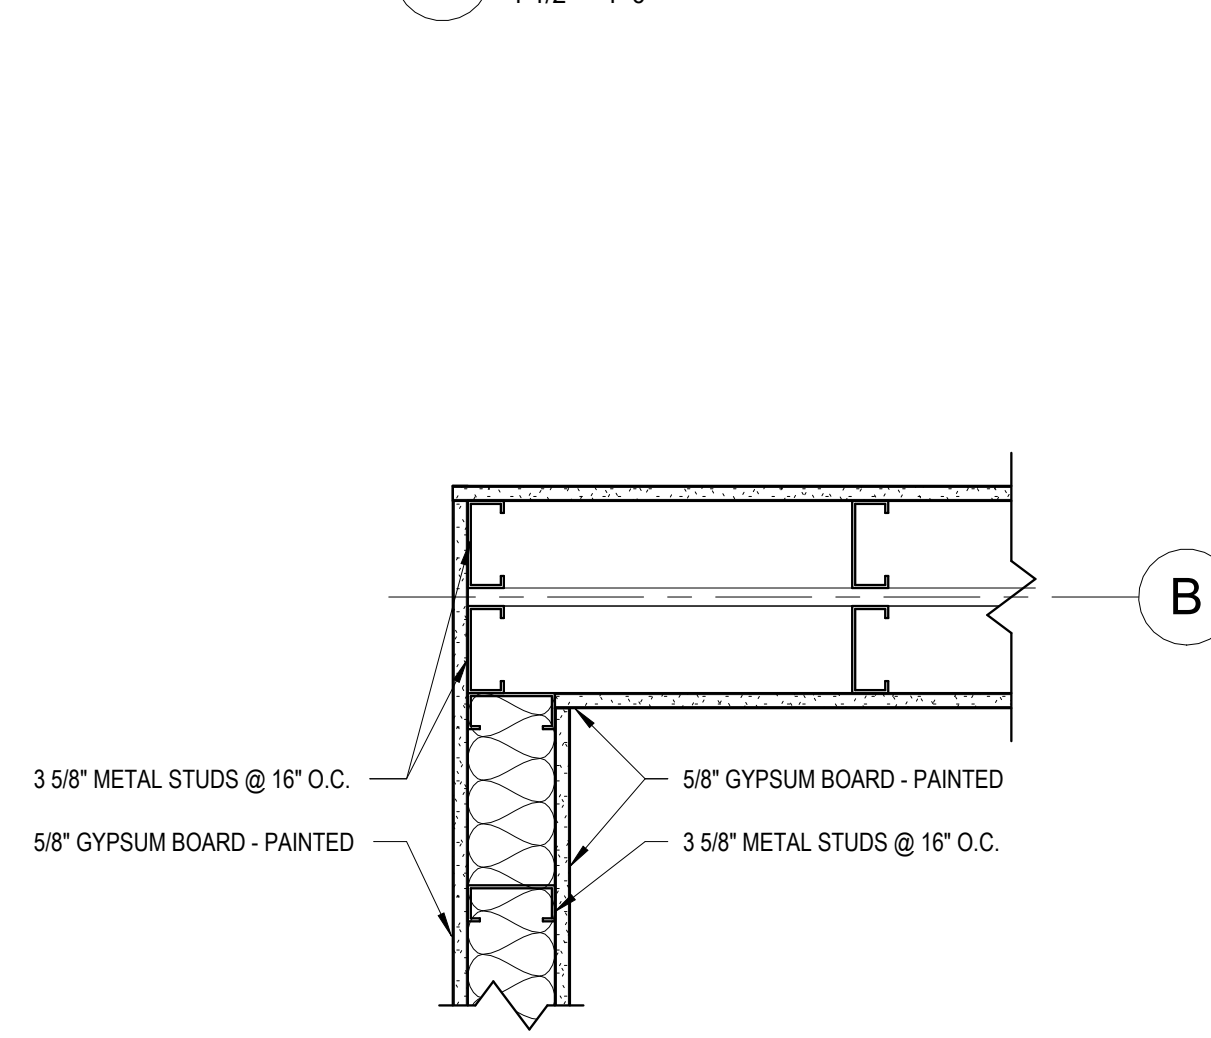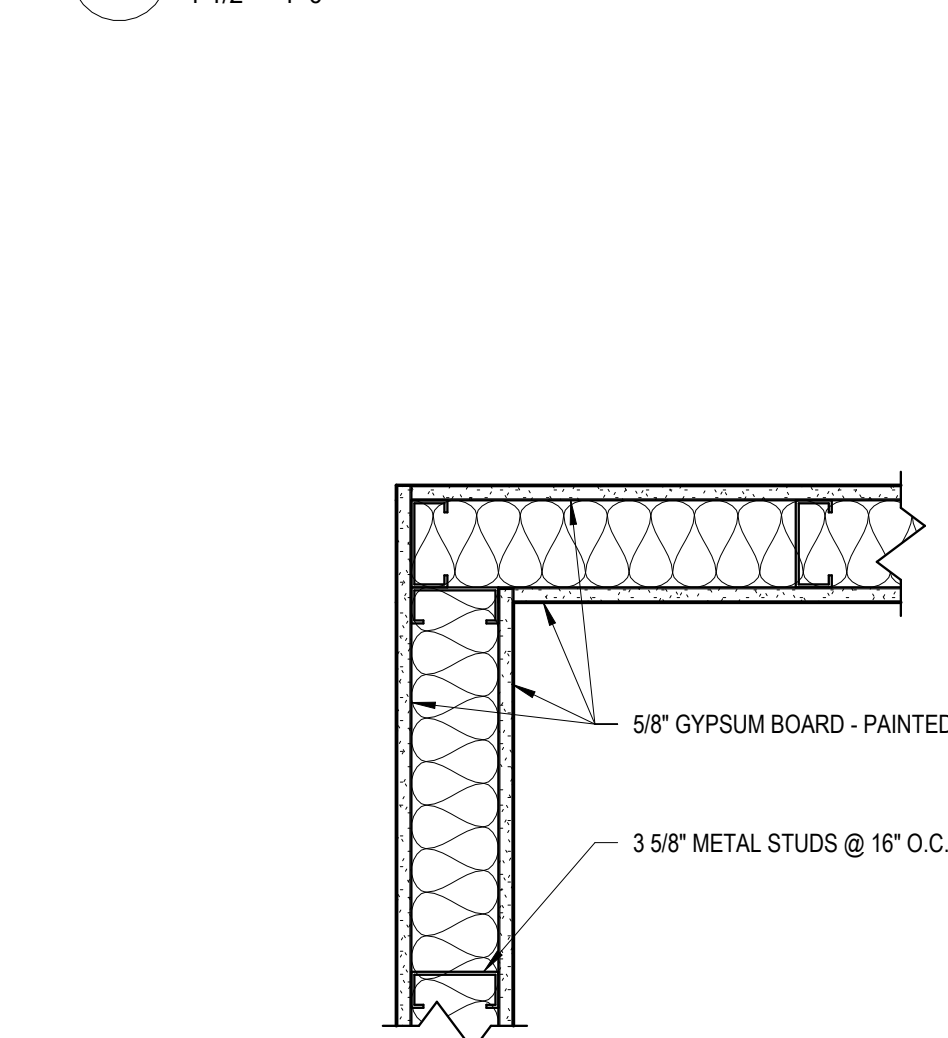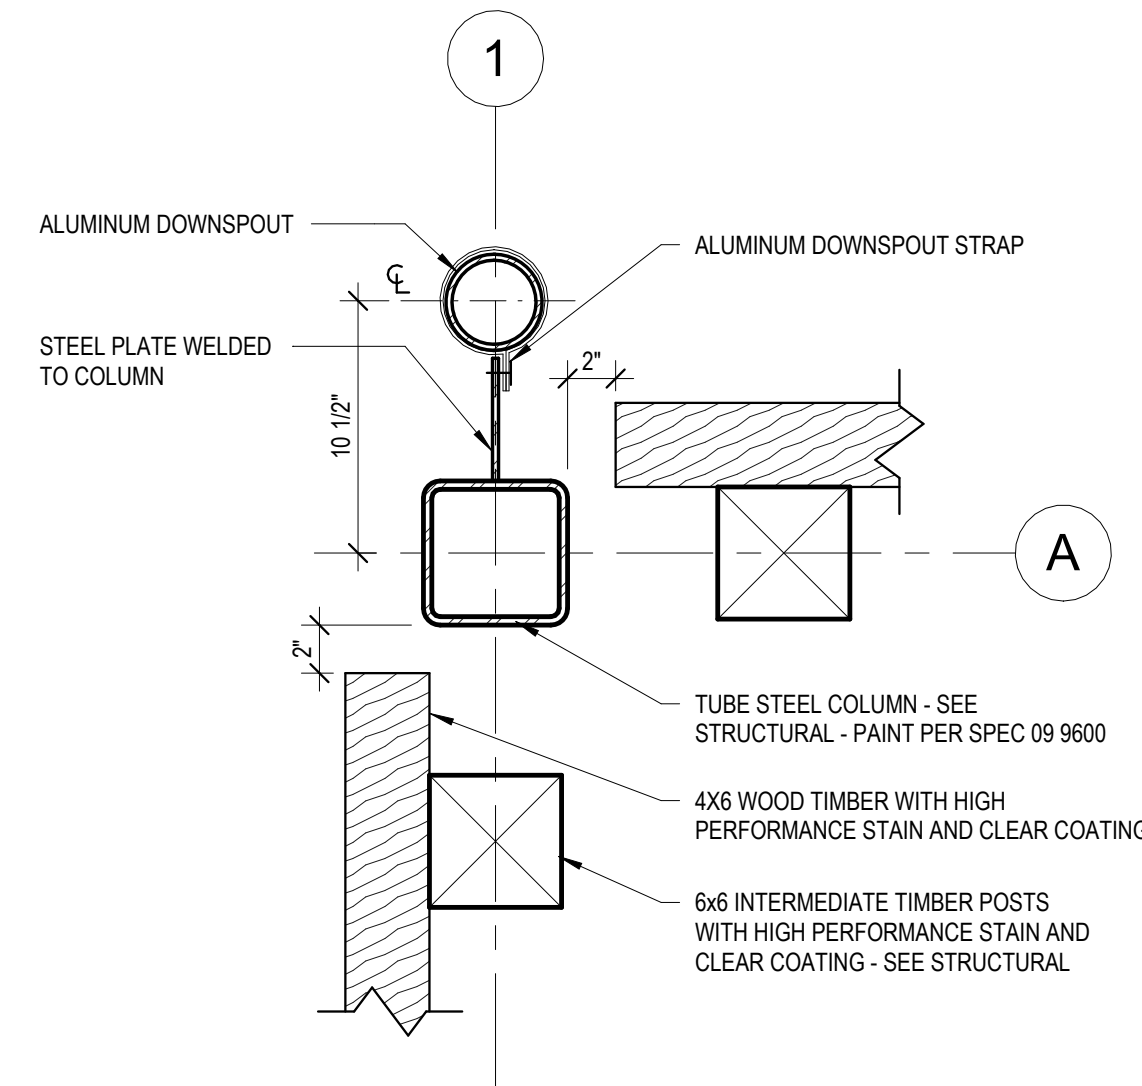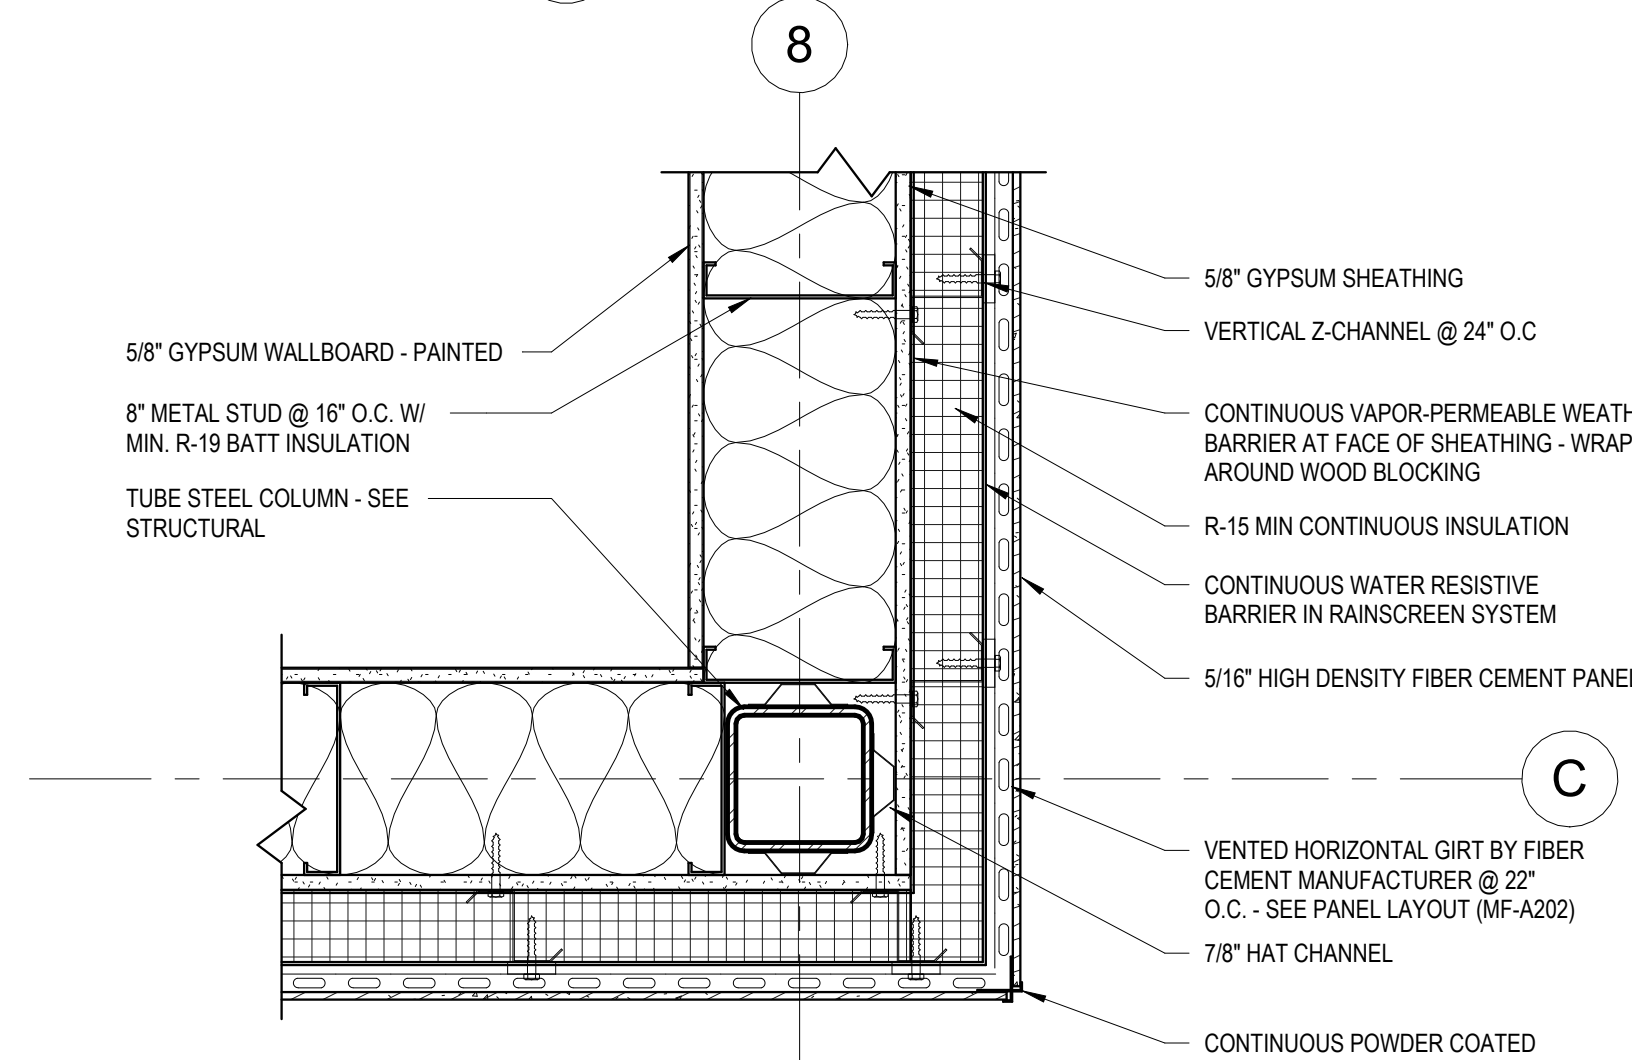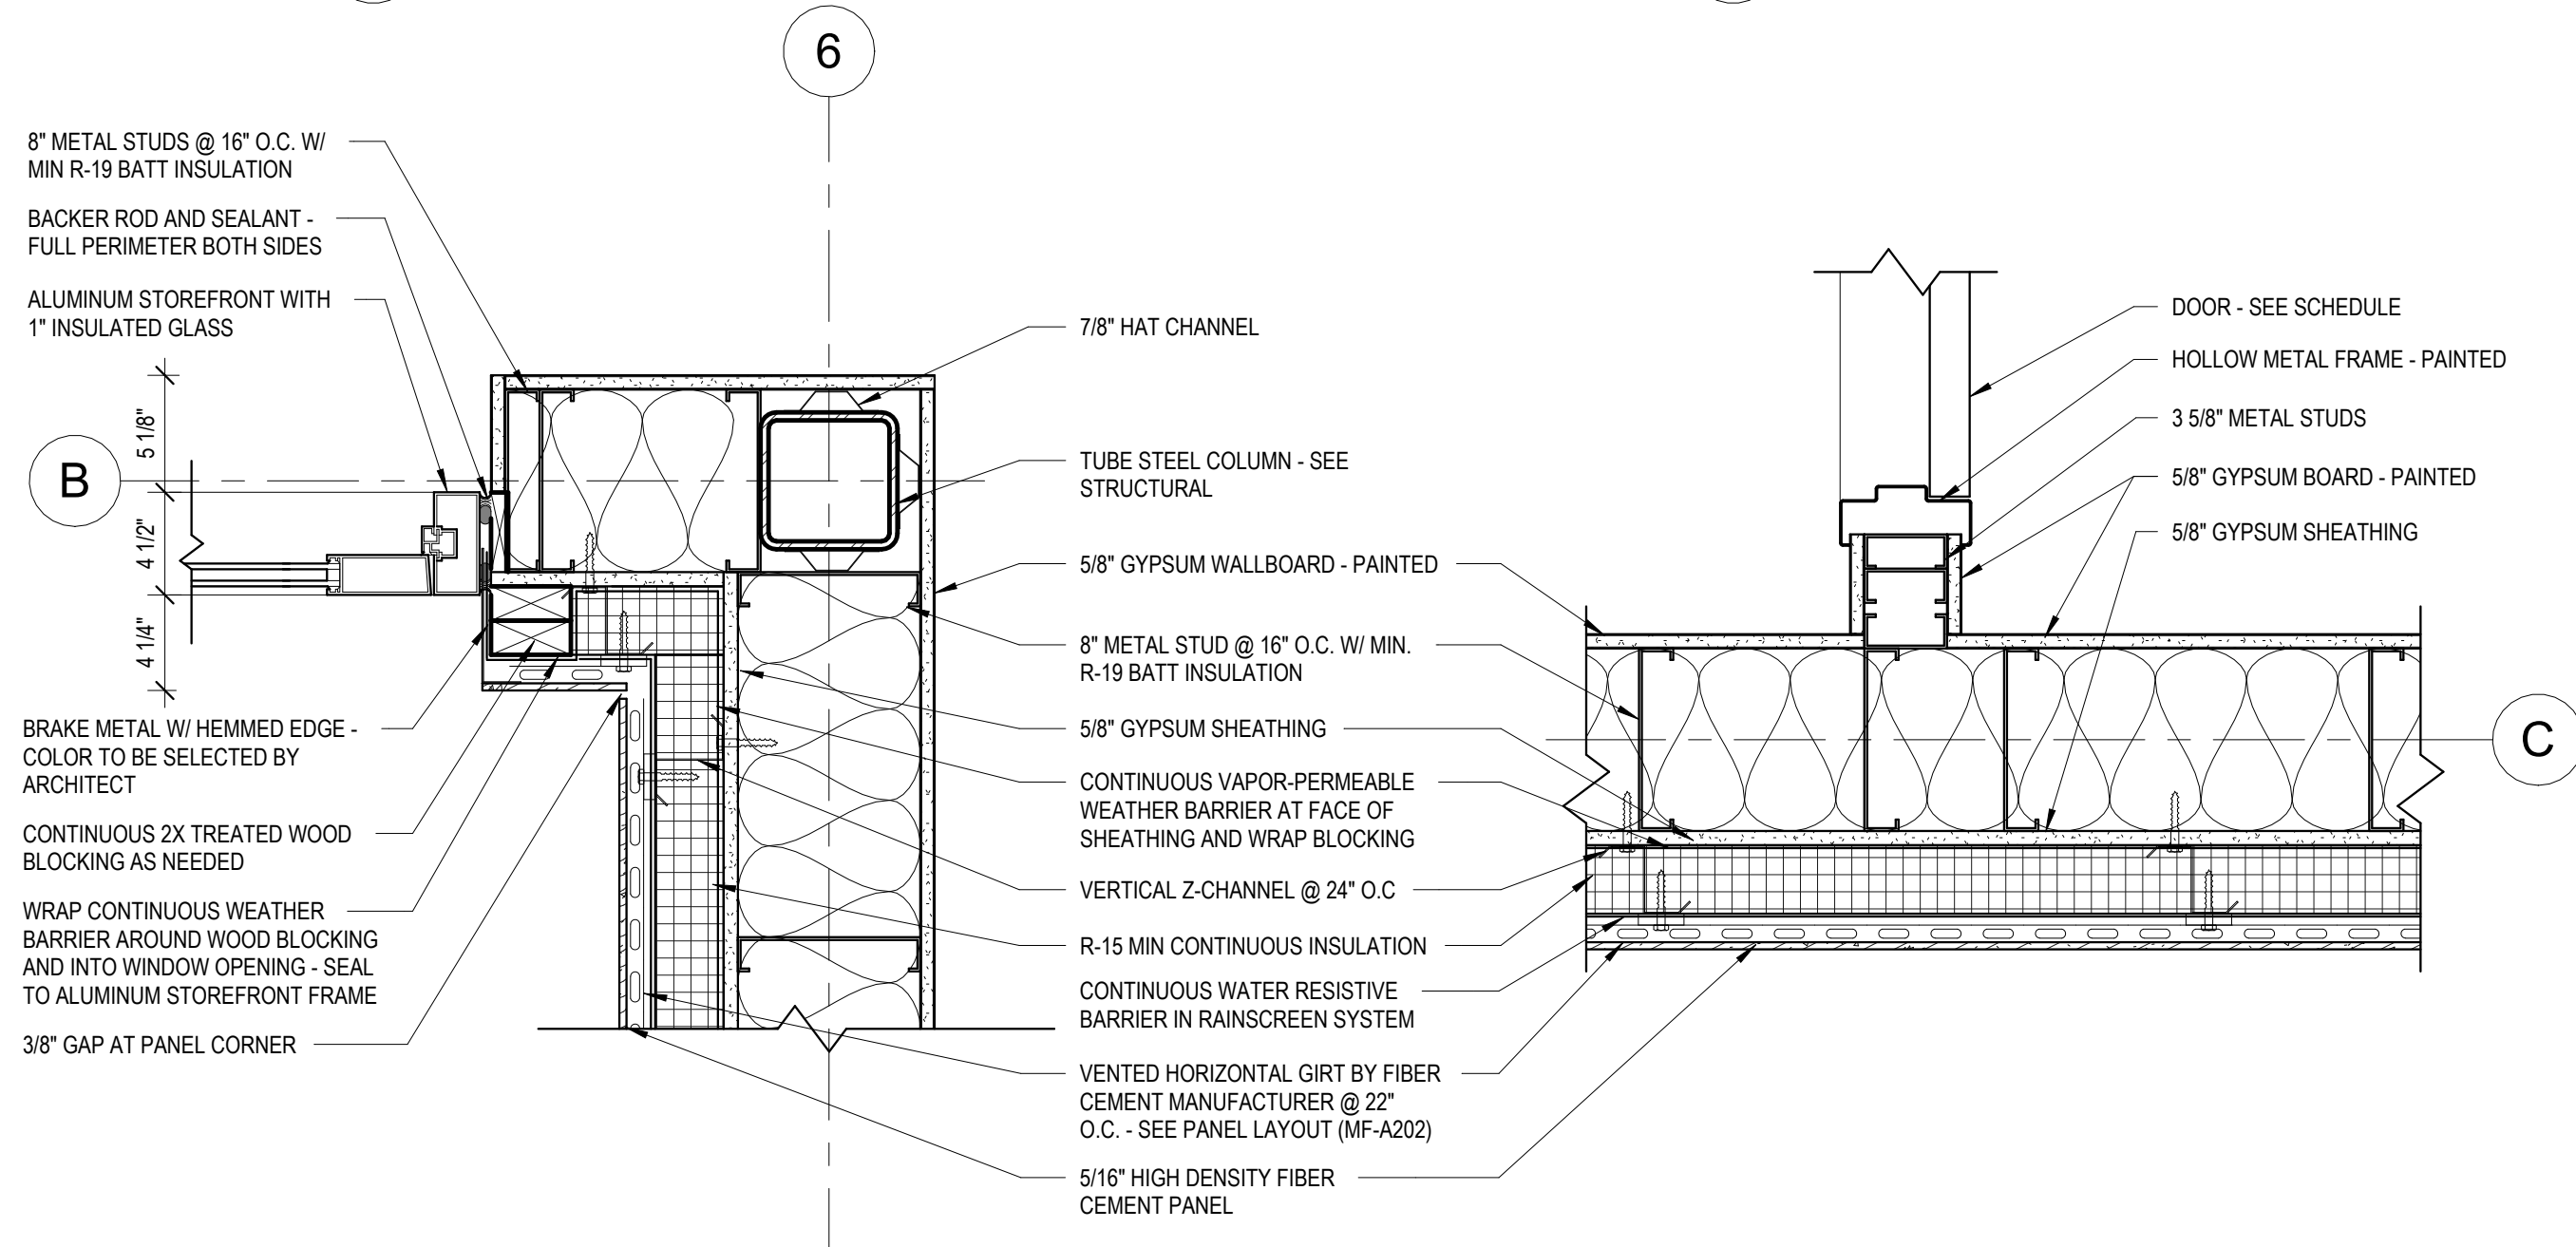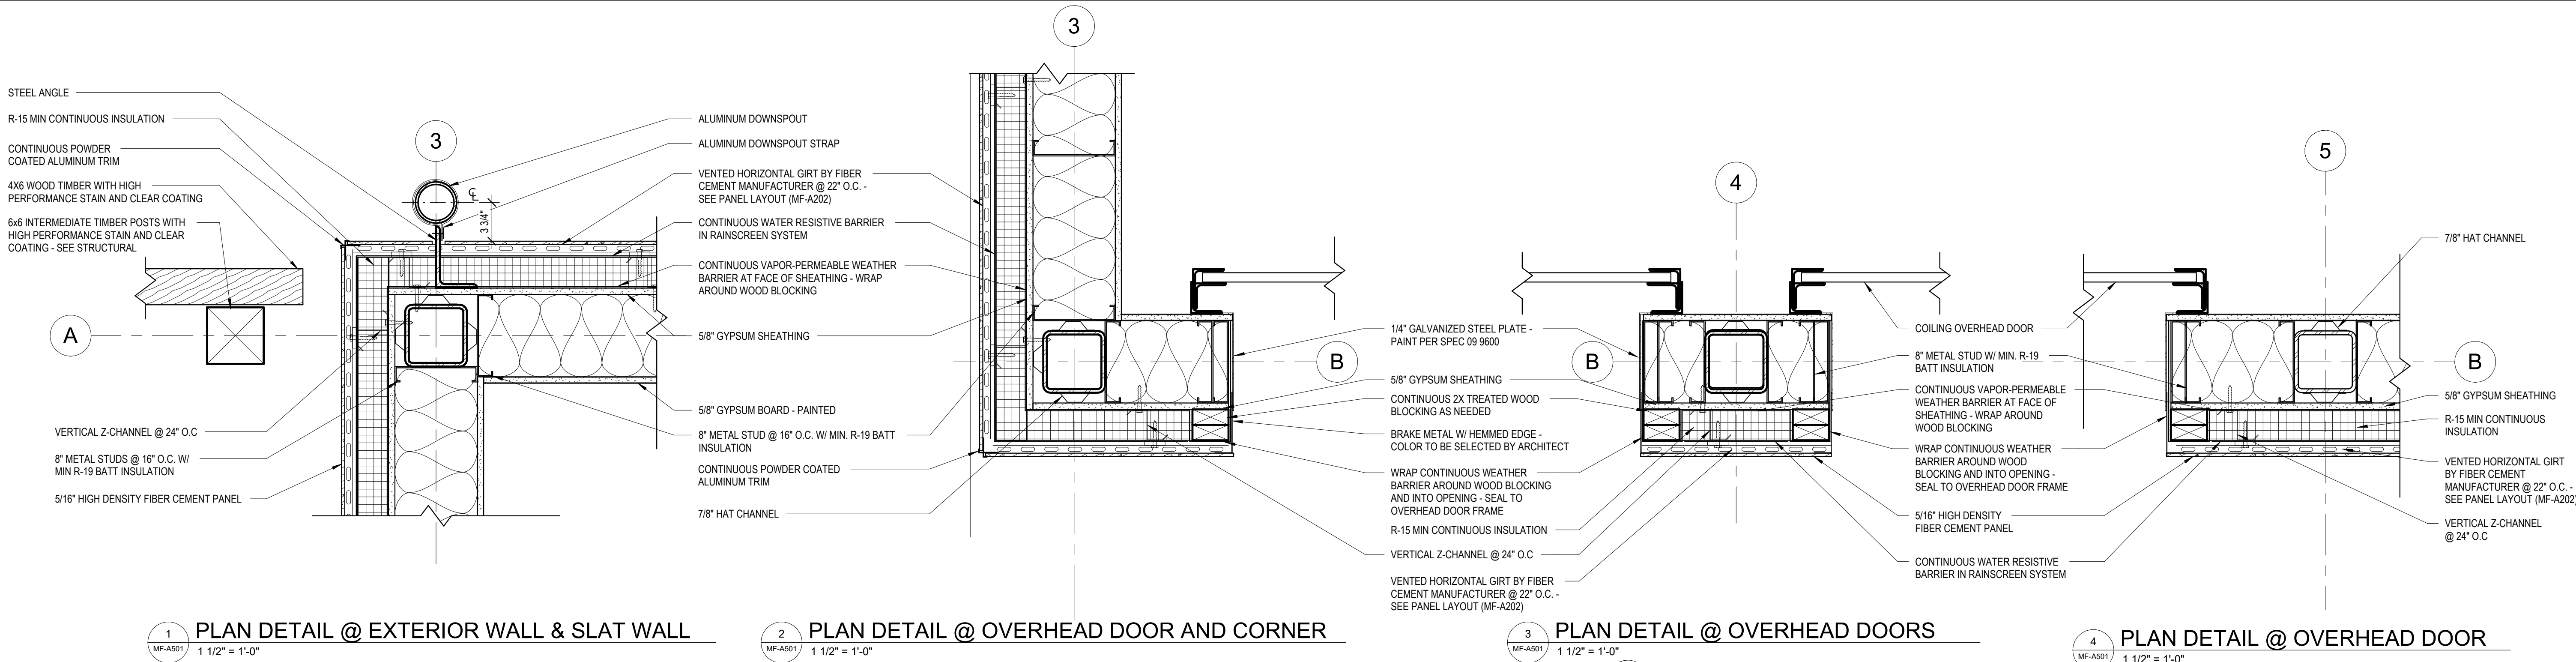


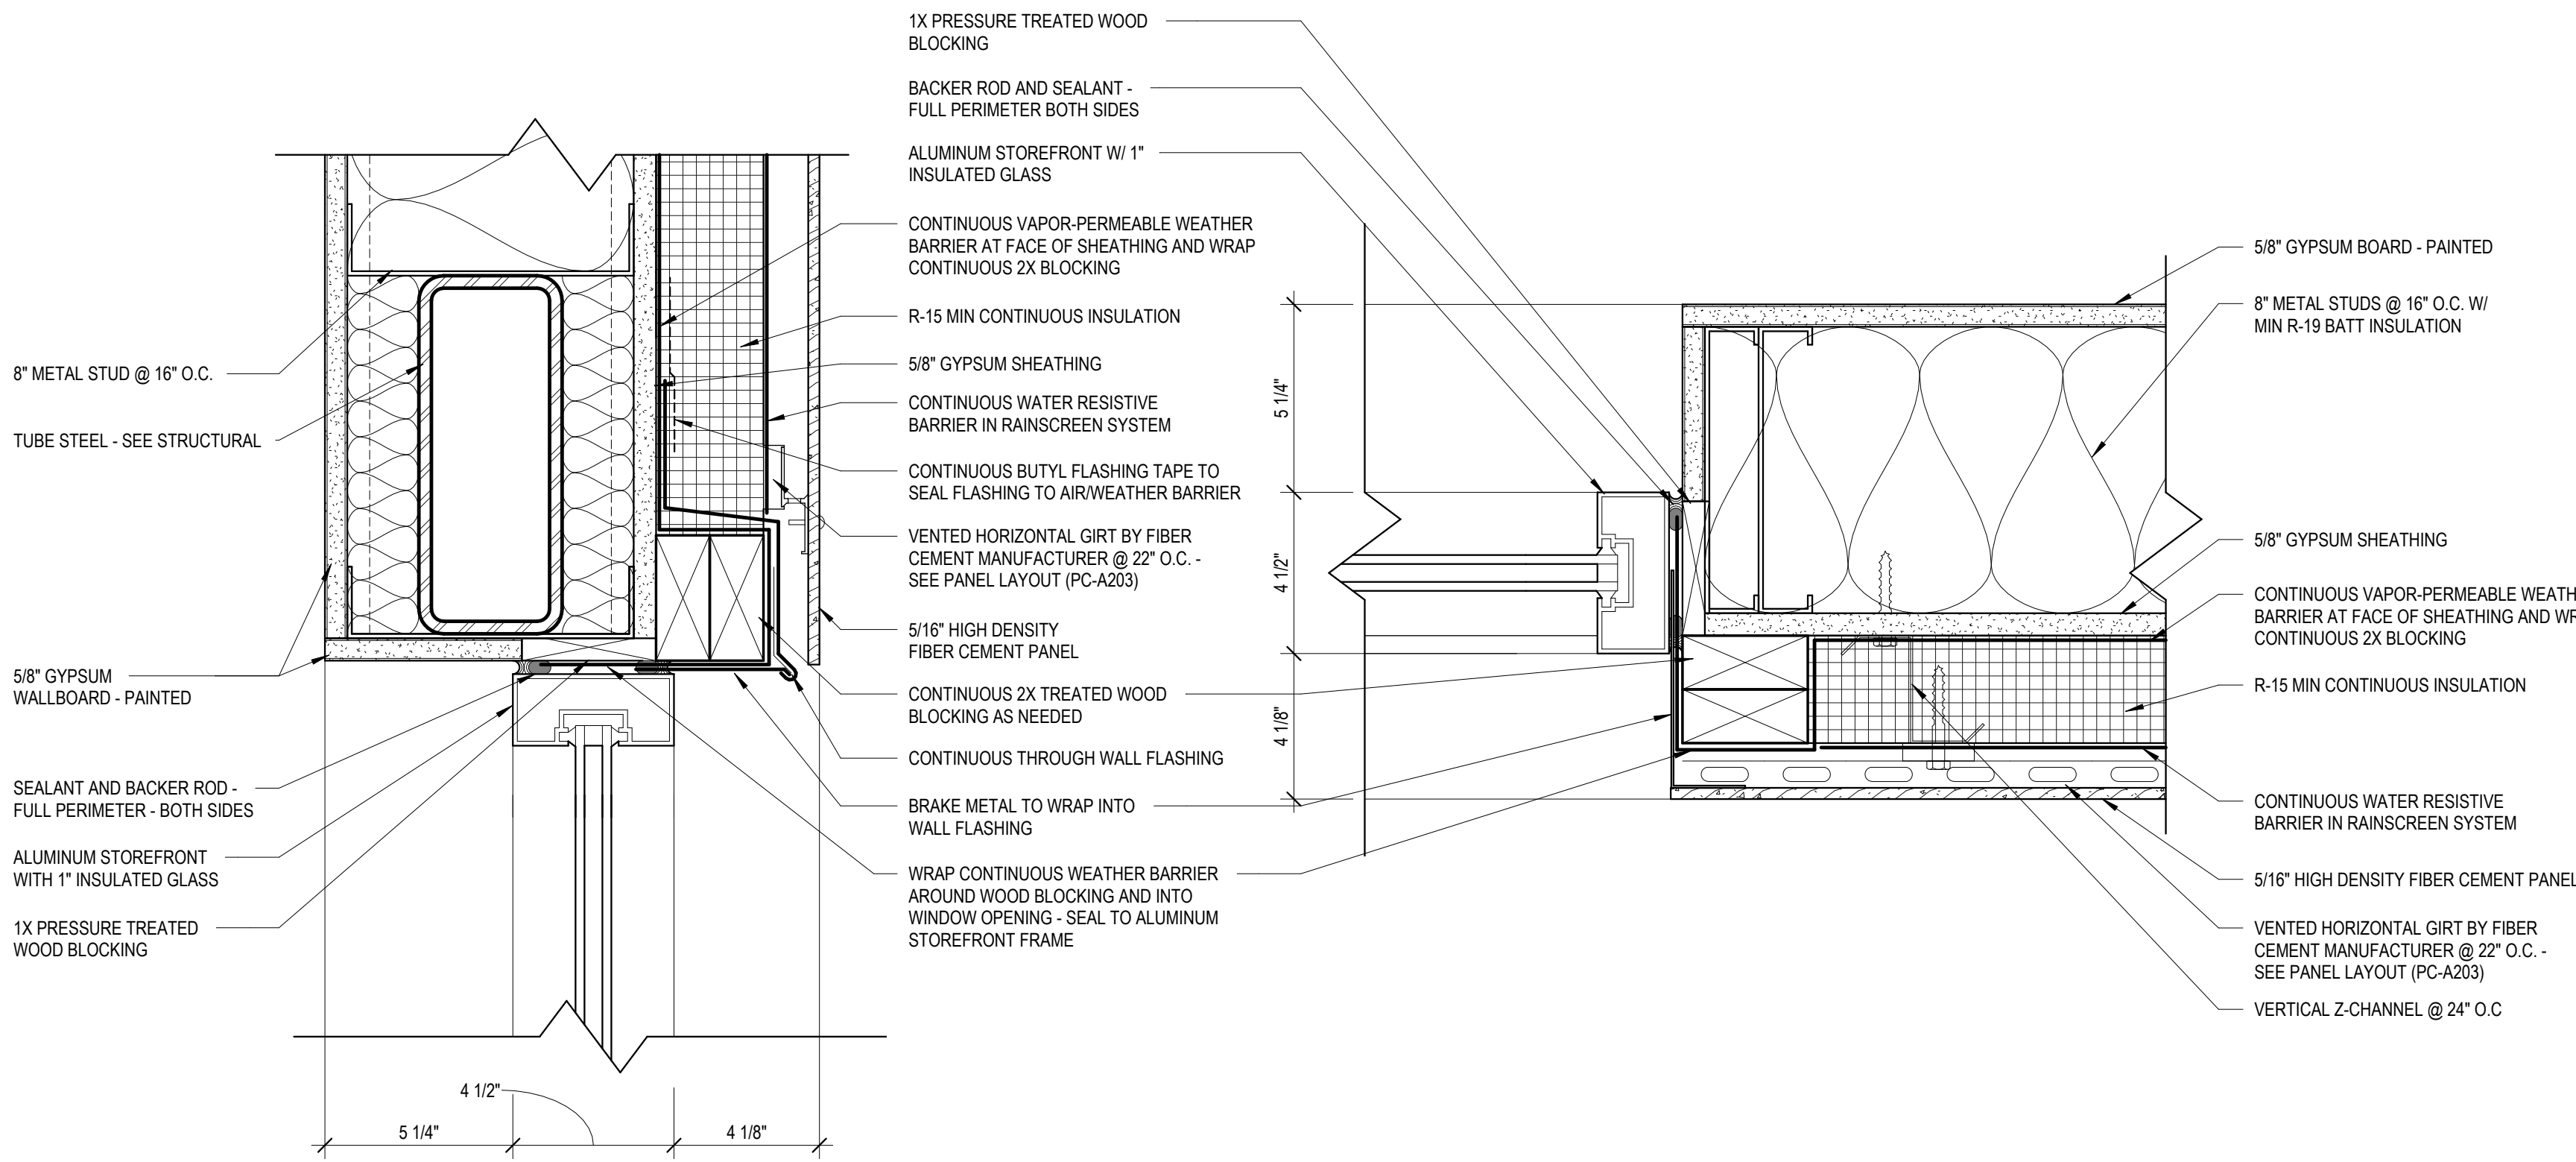


1
MF-A505
AIR BARRIER DETAIL @ WINDOW HEAD
3\" = 1'-0"

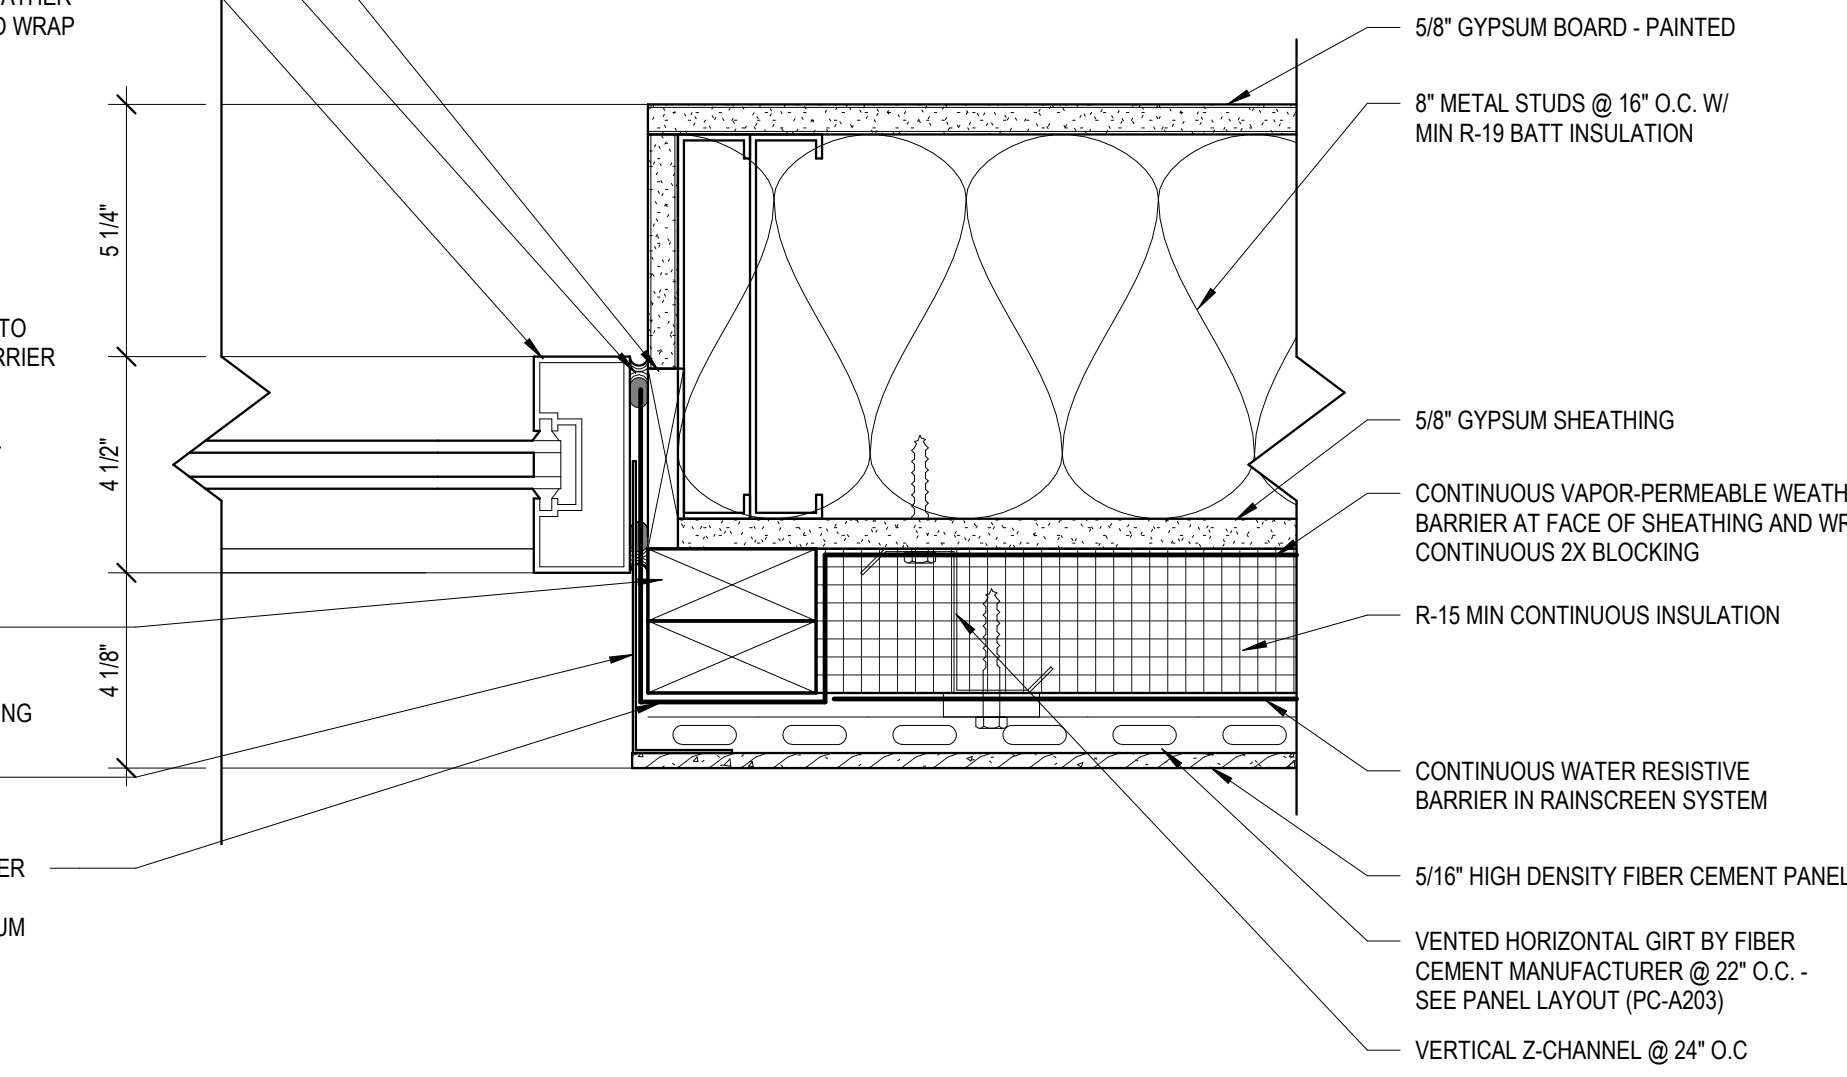


2
MF-A505
AIR BARRIER DETAIL @ WINDOW JAMB
3\" = 1'-0"

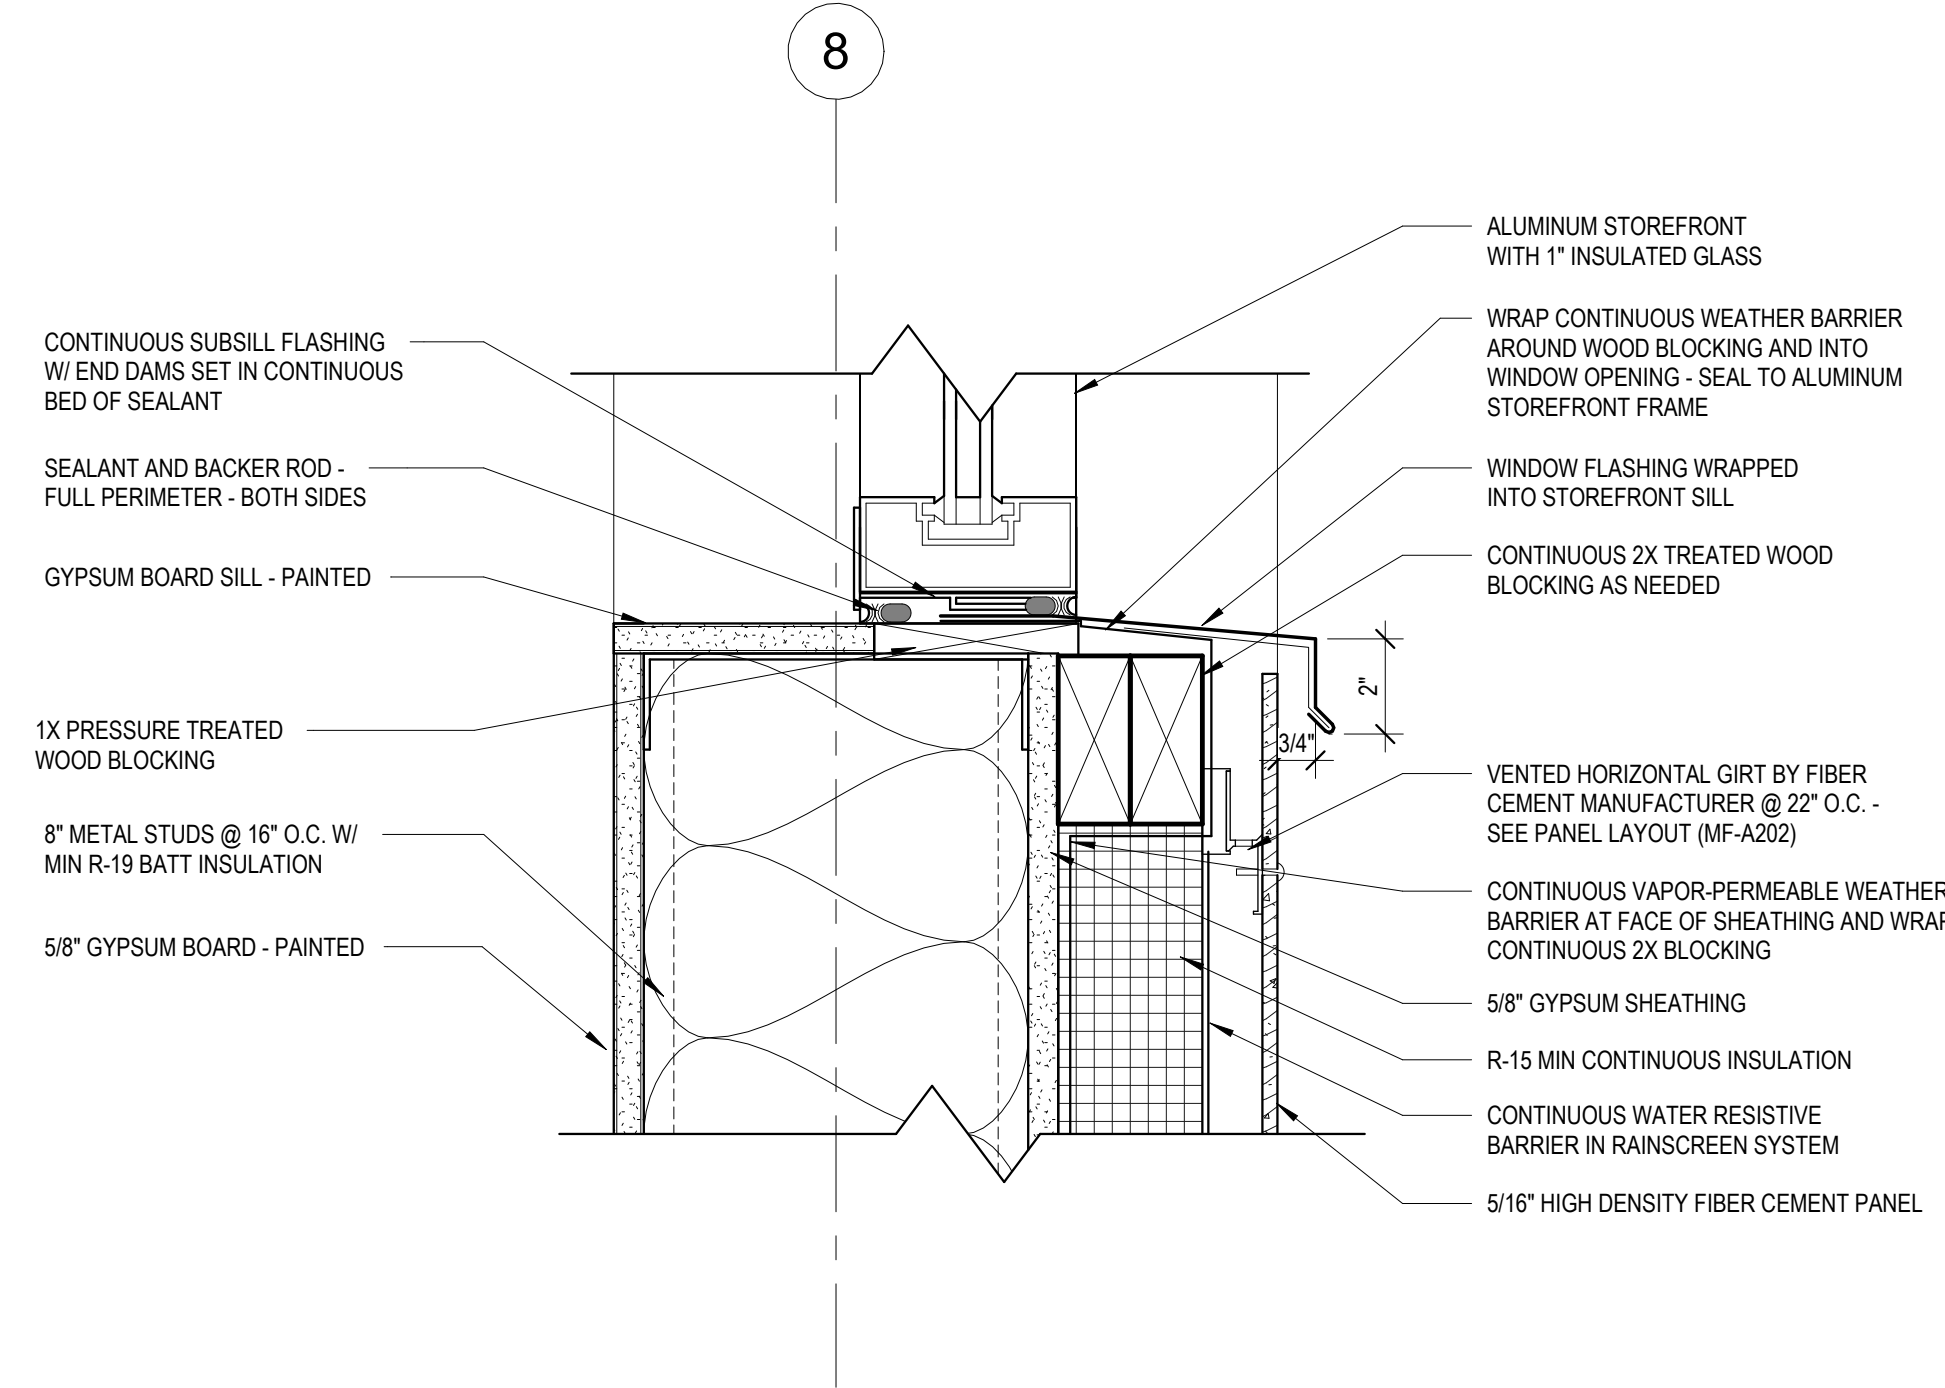

3
MF-A505
AIR BARRIER DETAIL @ WINDOW SILL
3\" = 1'-0"

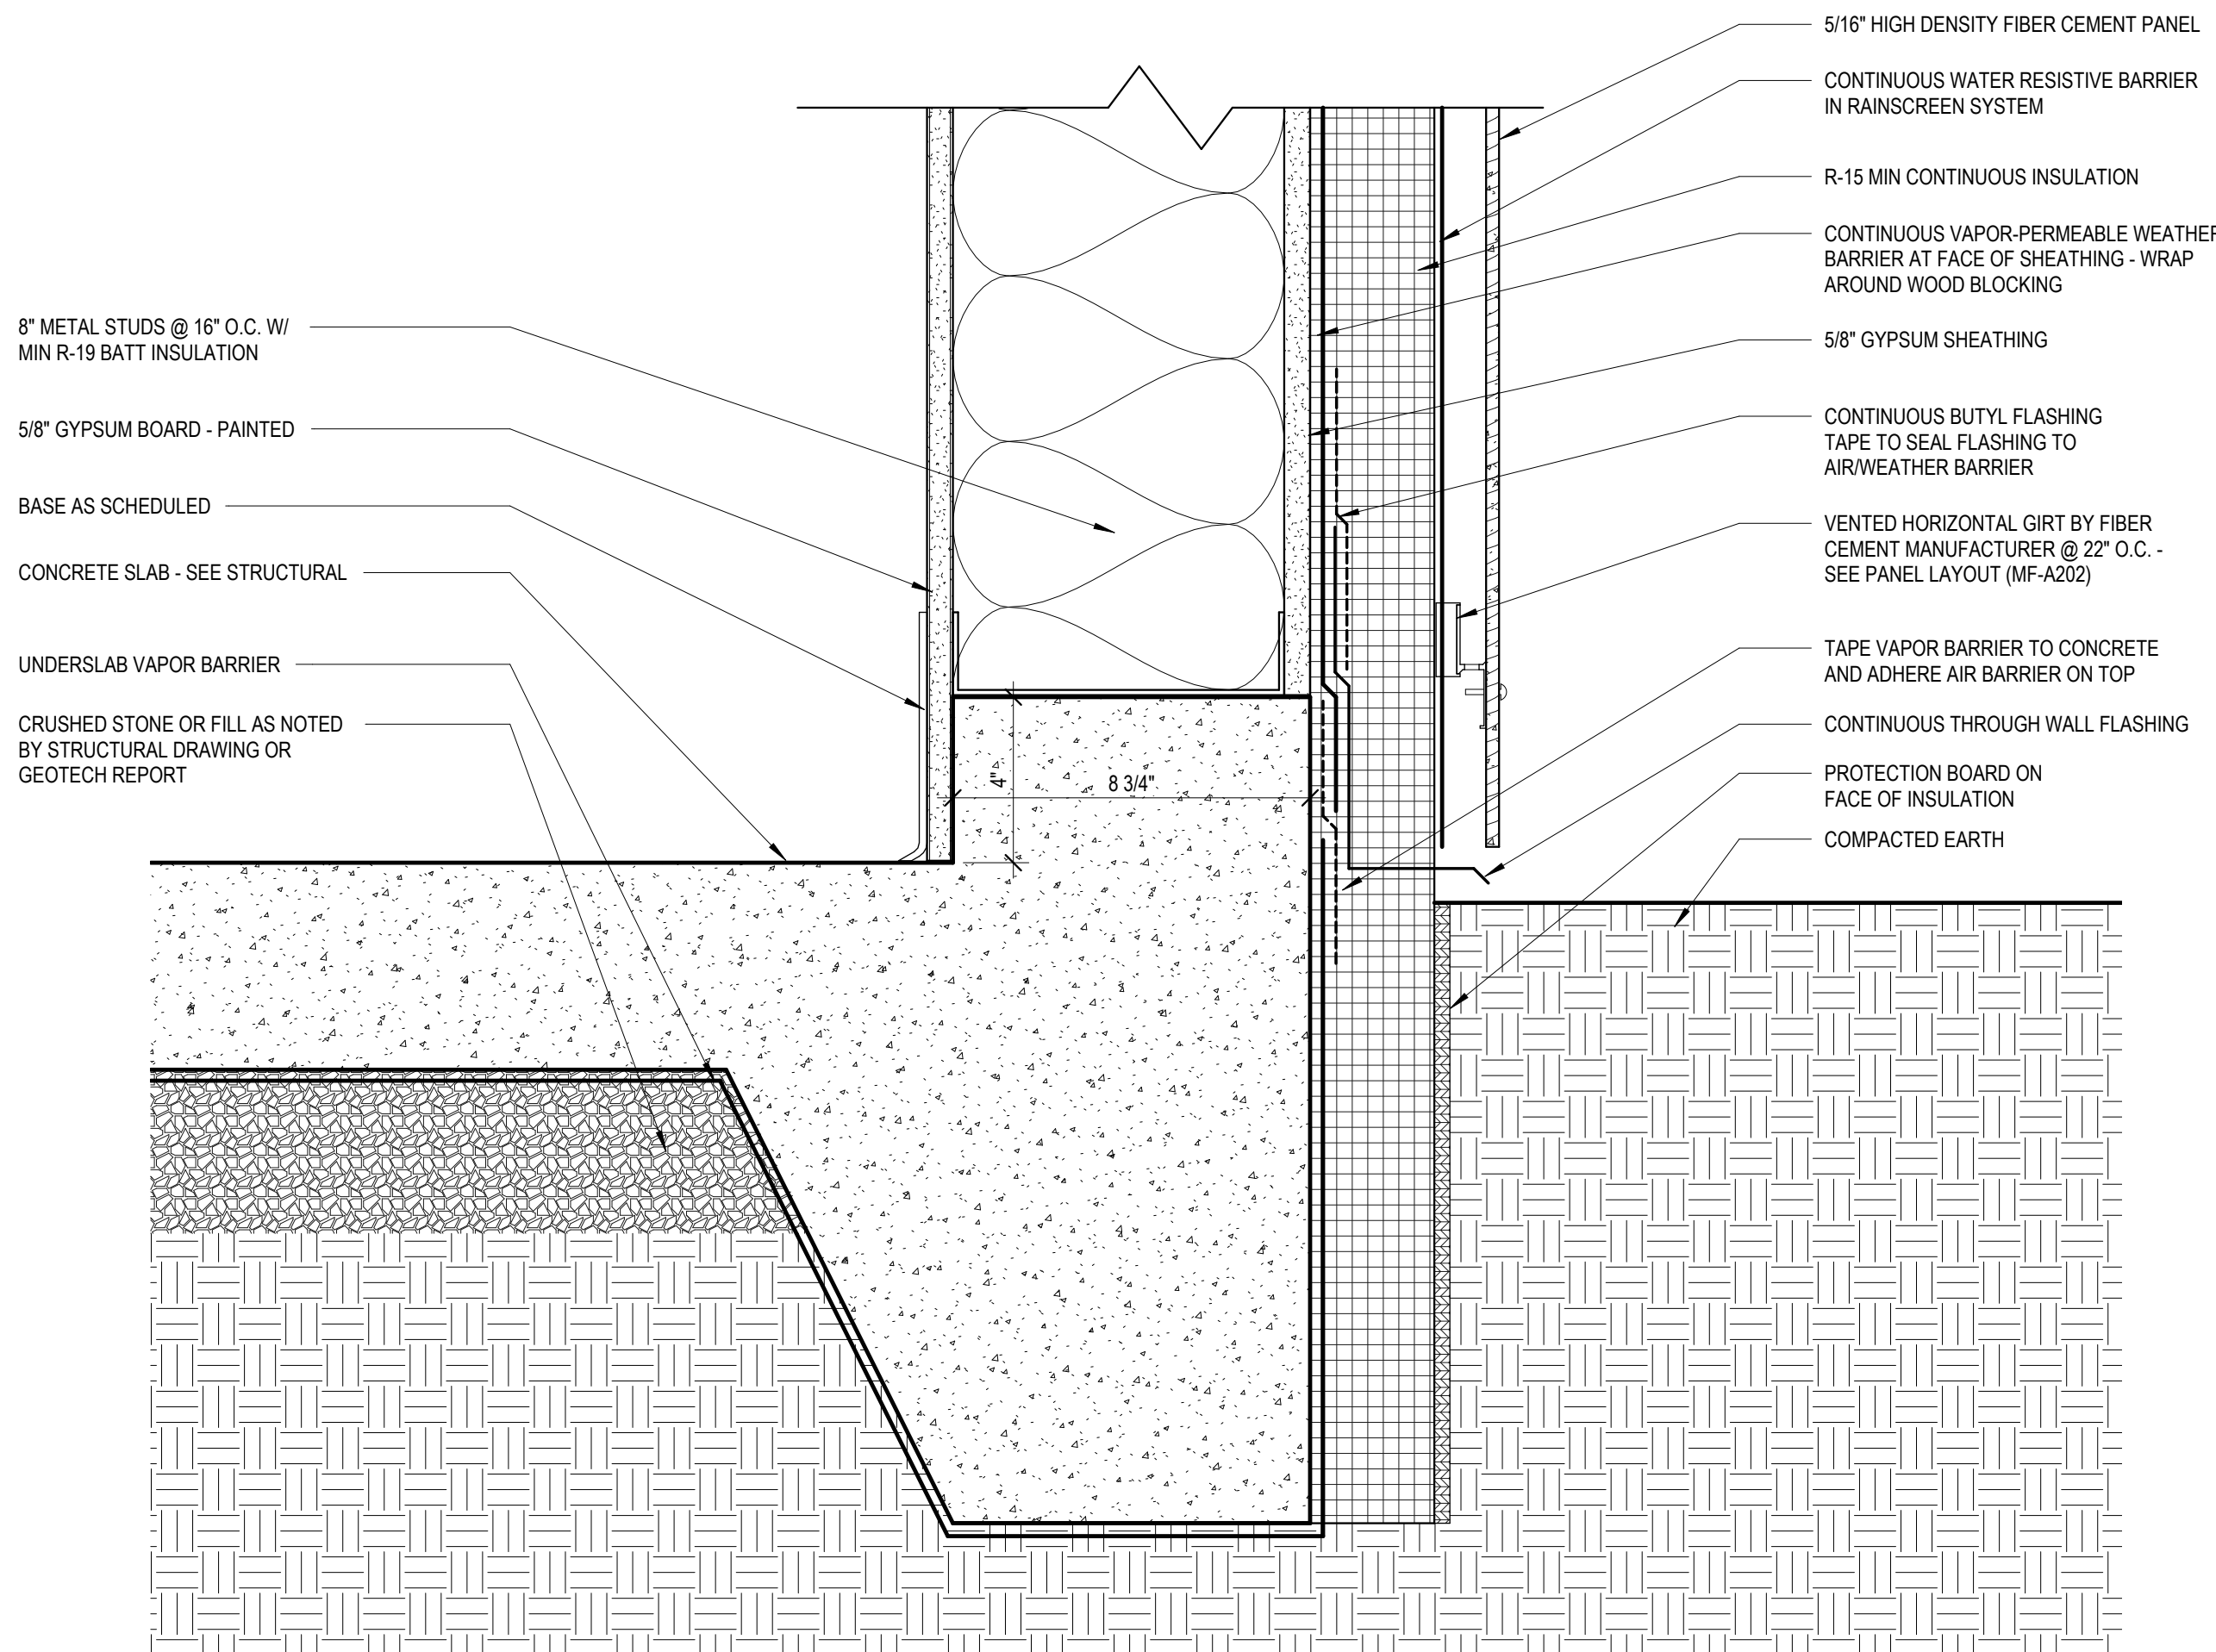

4
MF-A505
TYP. DETAIL @ BASE OF WALL
3\" = 1'-0"

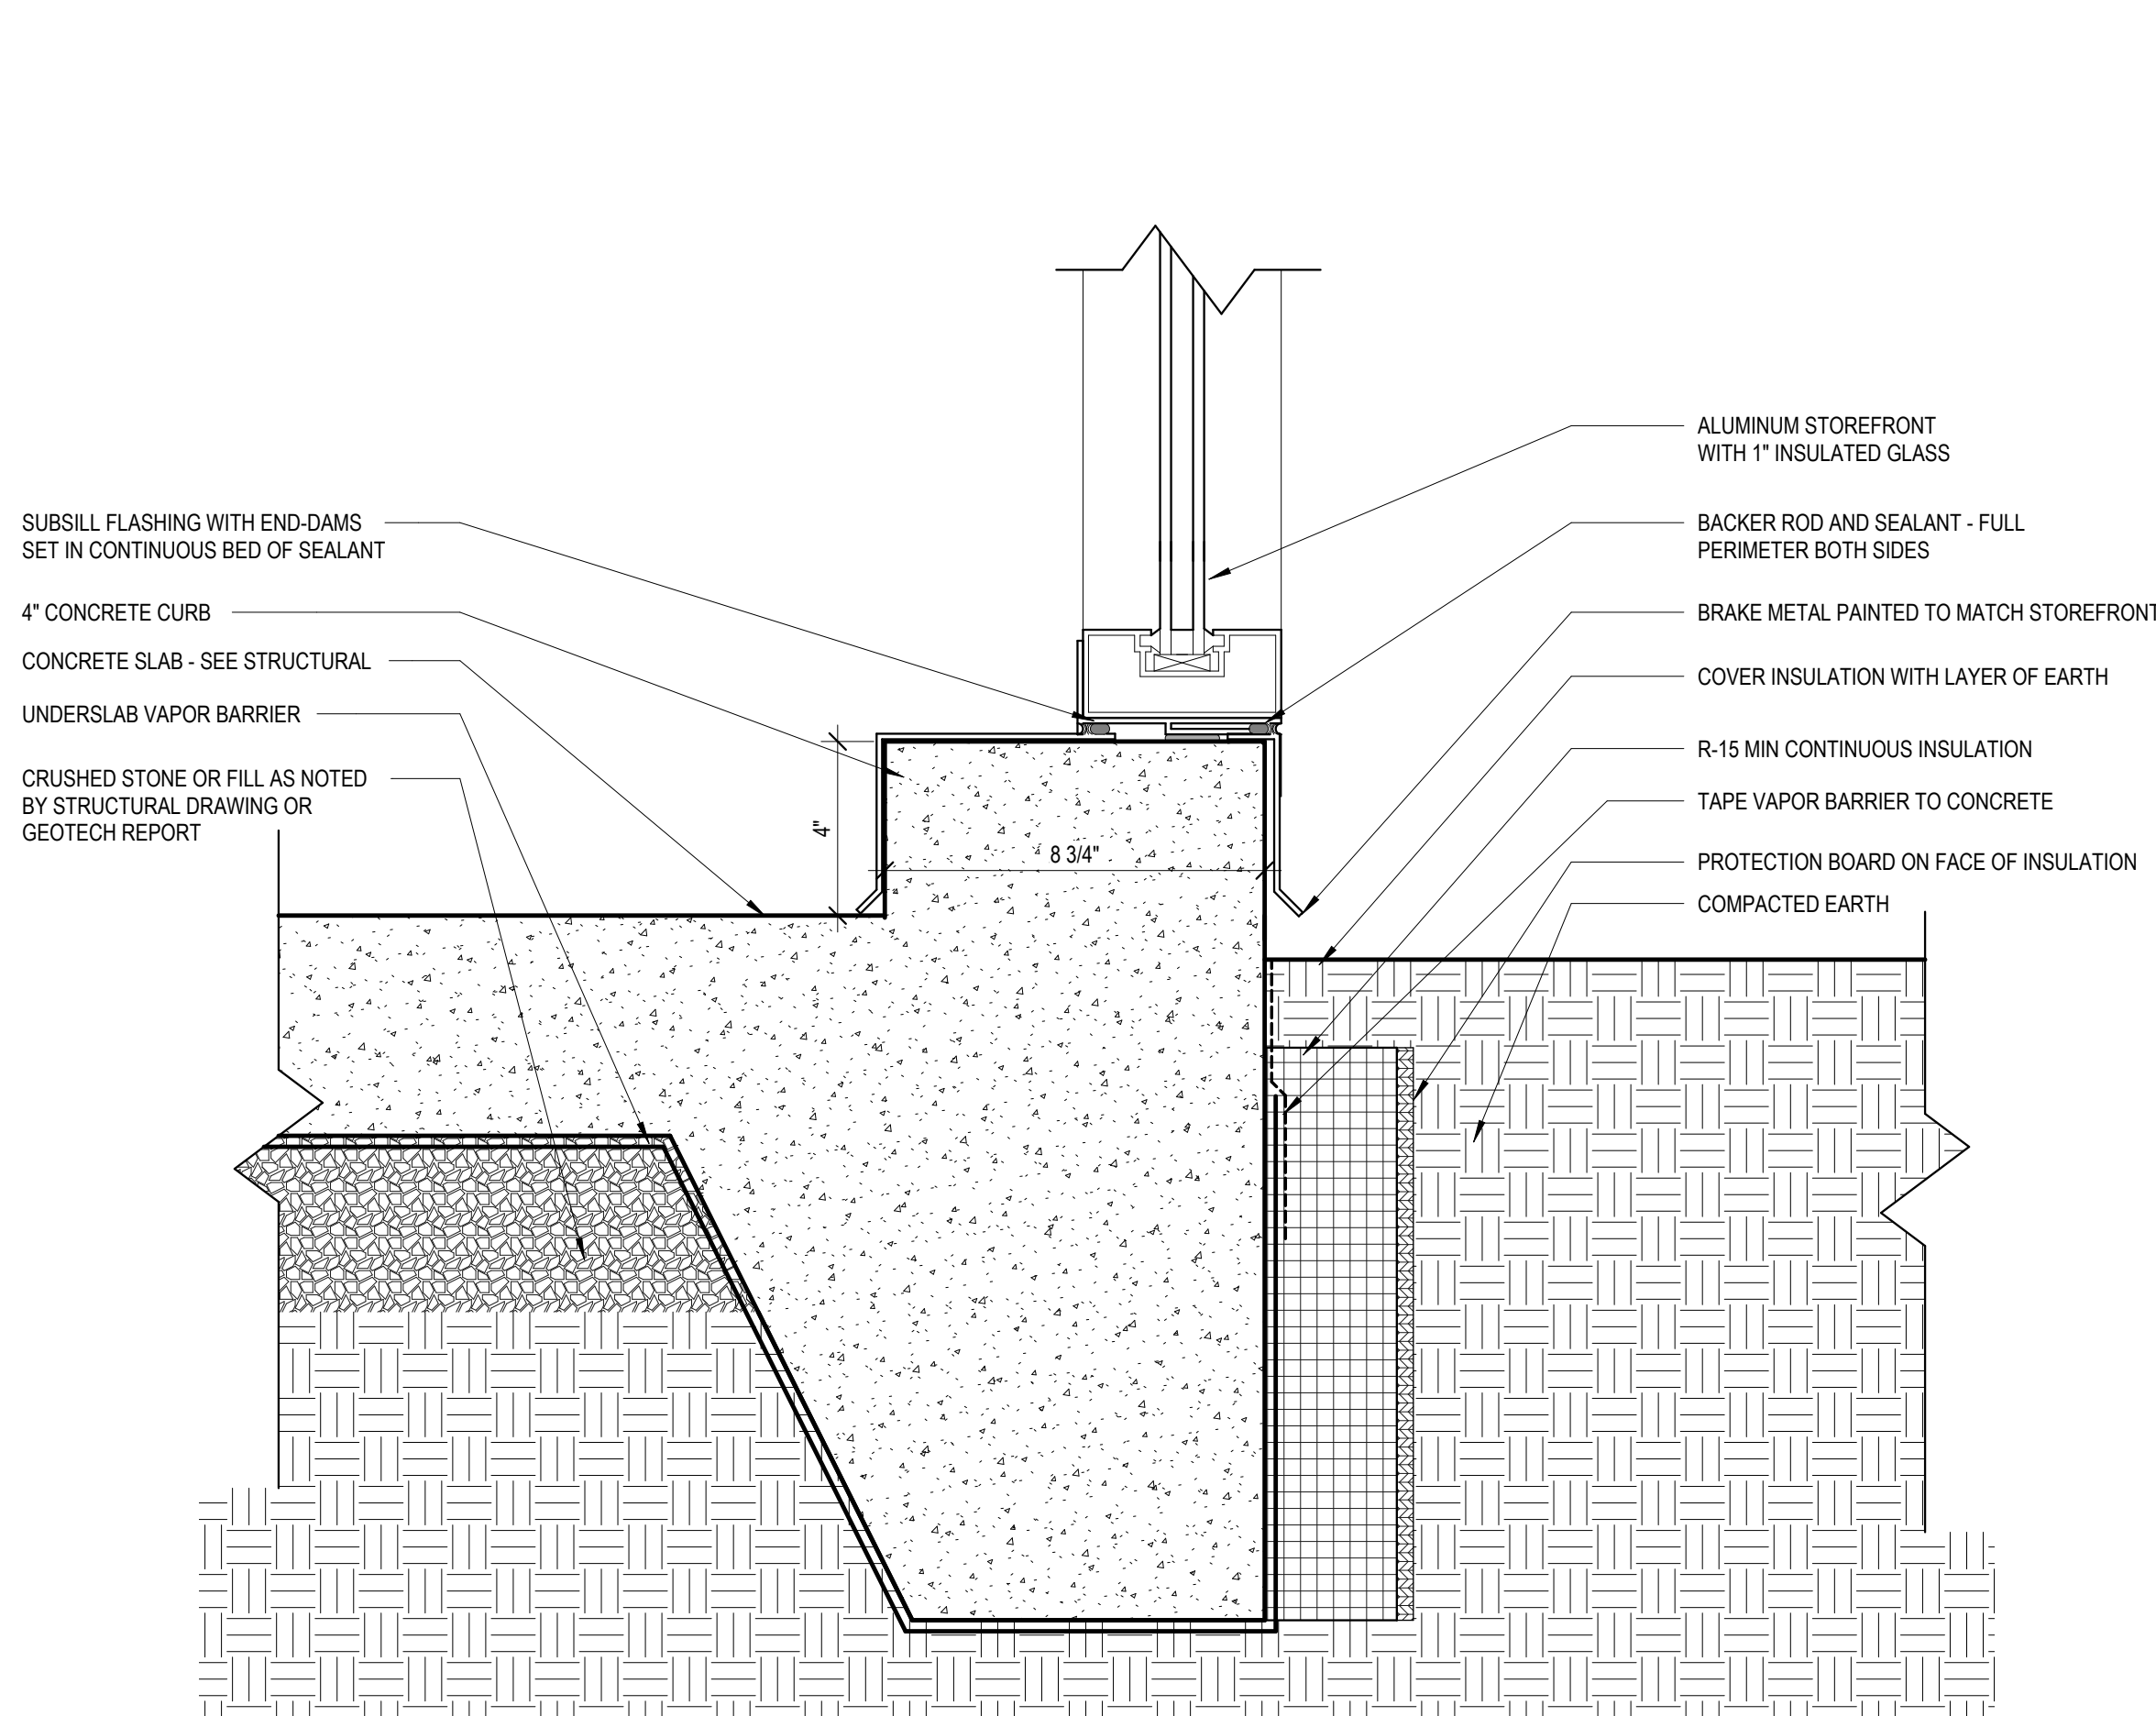

5
MF-A505
TYP. DETAIL @ BASE OF STOREFRONT
3\" = 1'-0"

Susan
Hatchell
Landscape Architecture, PLLC
711 W. North Street, Raleigh, NC 27603
p: 919-838-9600 f: 919-838-9700




AIR BARRIER
DETAILS

LAKE MYRA COUNTY PARK
Wake County, NC


REVISIONS

Date: 07/27/26


MF-A505

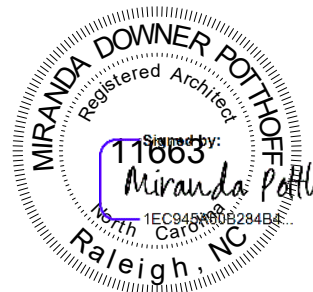


7/27/2026

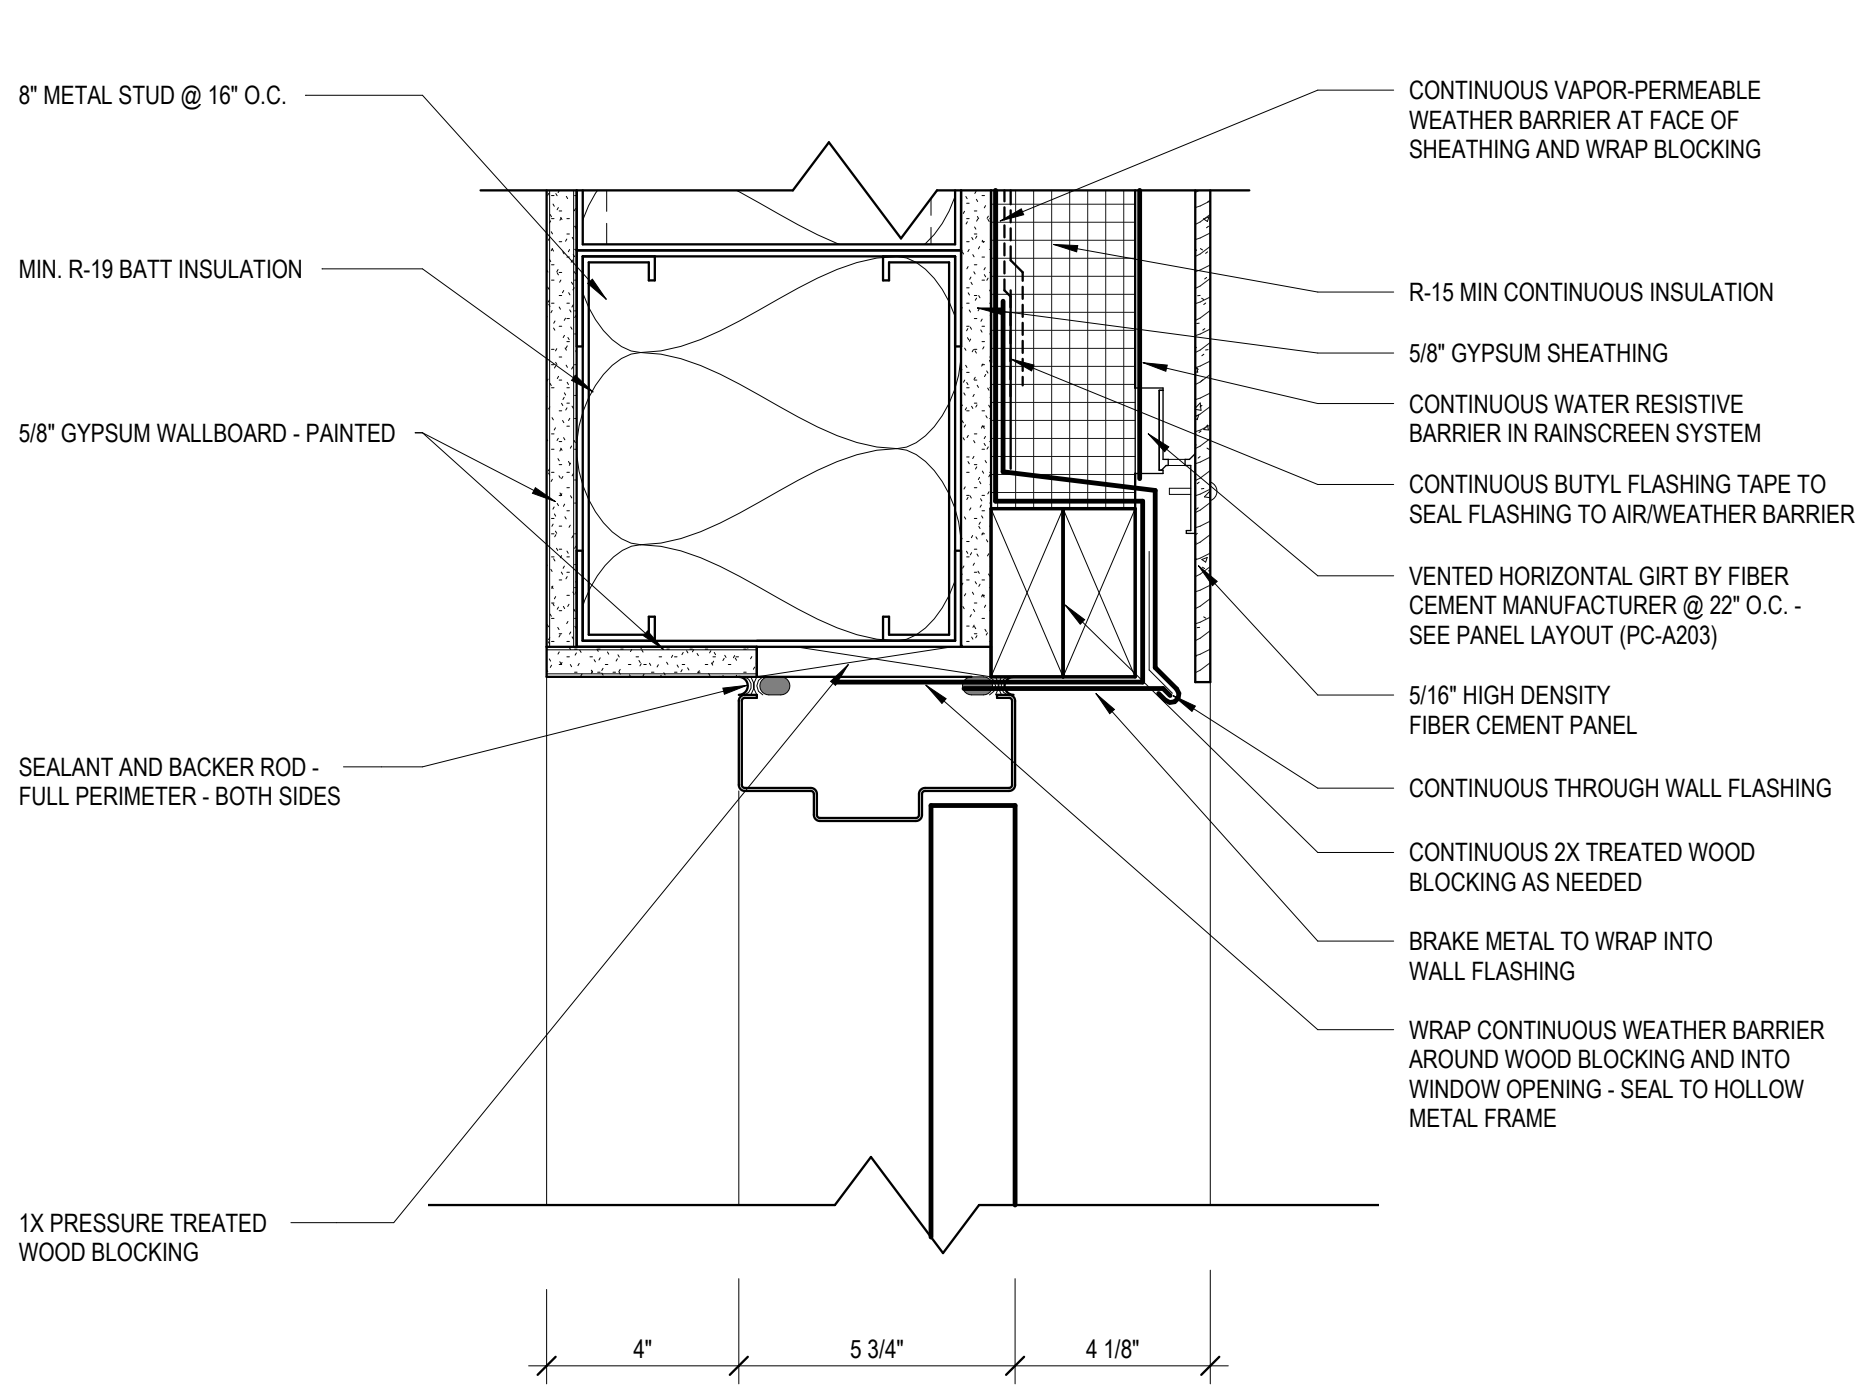


1 AIR BARRIER DETAIL @ HM DOOR HEAD
MF-A506 3" = 1'-0"

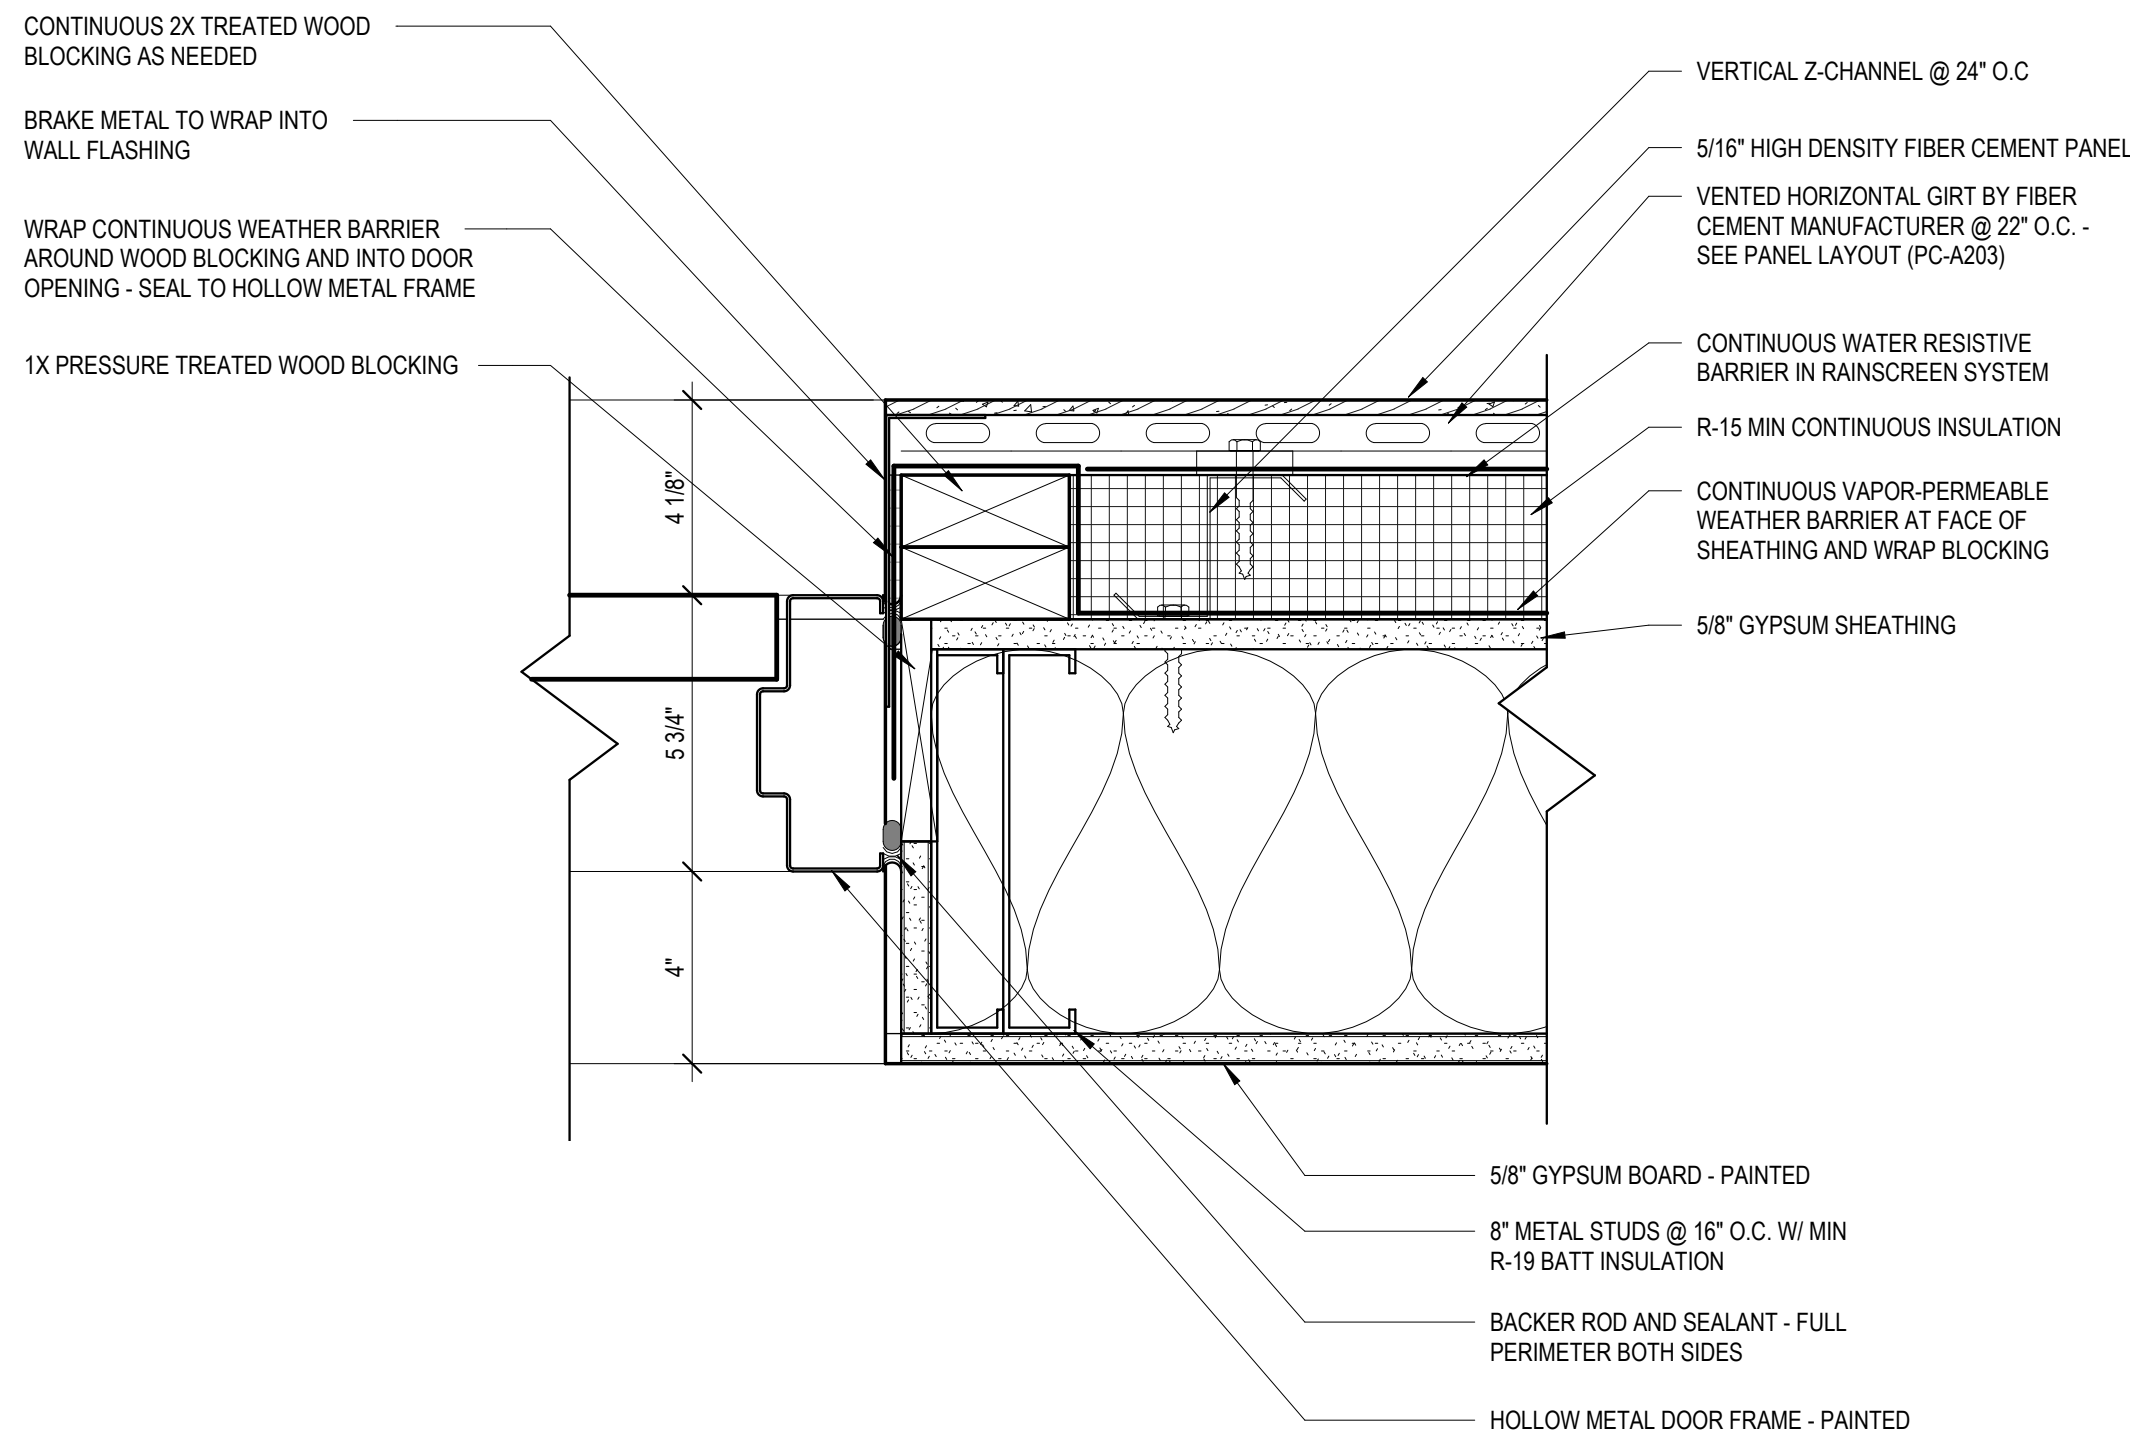

2 AIR BARRIER DETAIL @ HM DOOR JAMB
MF-A506 3" = 1'-0"

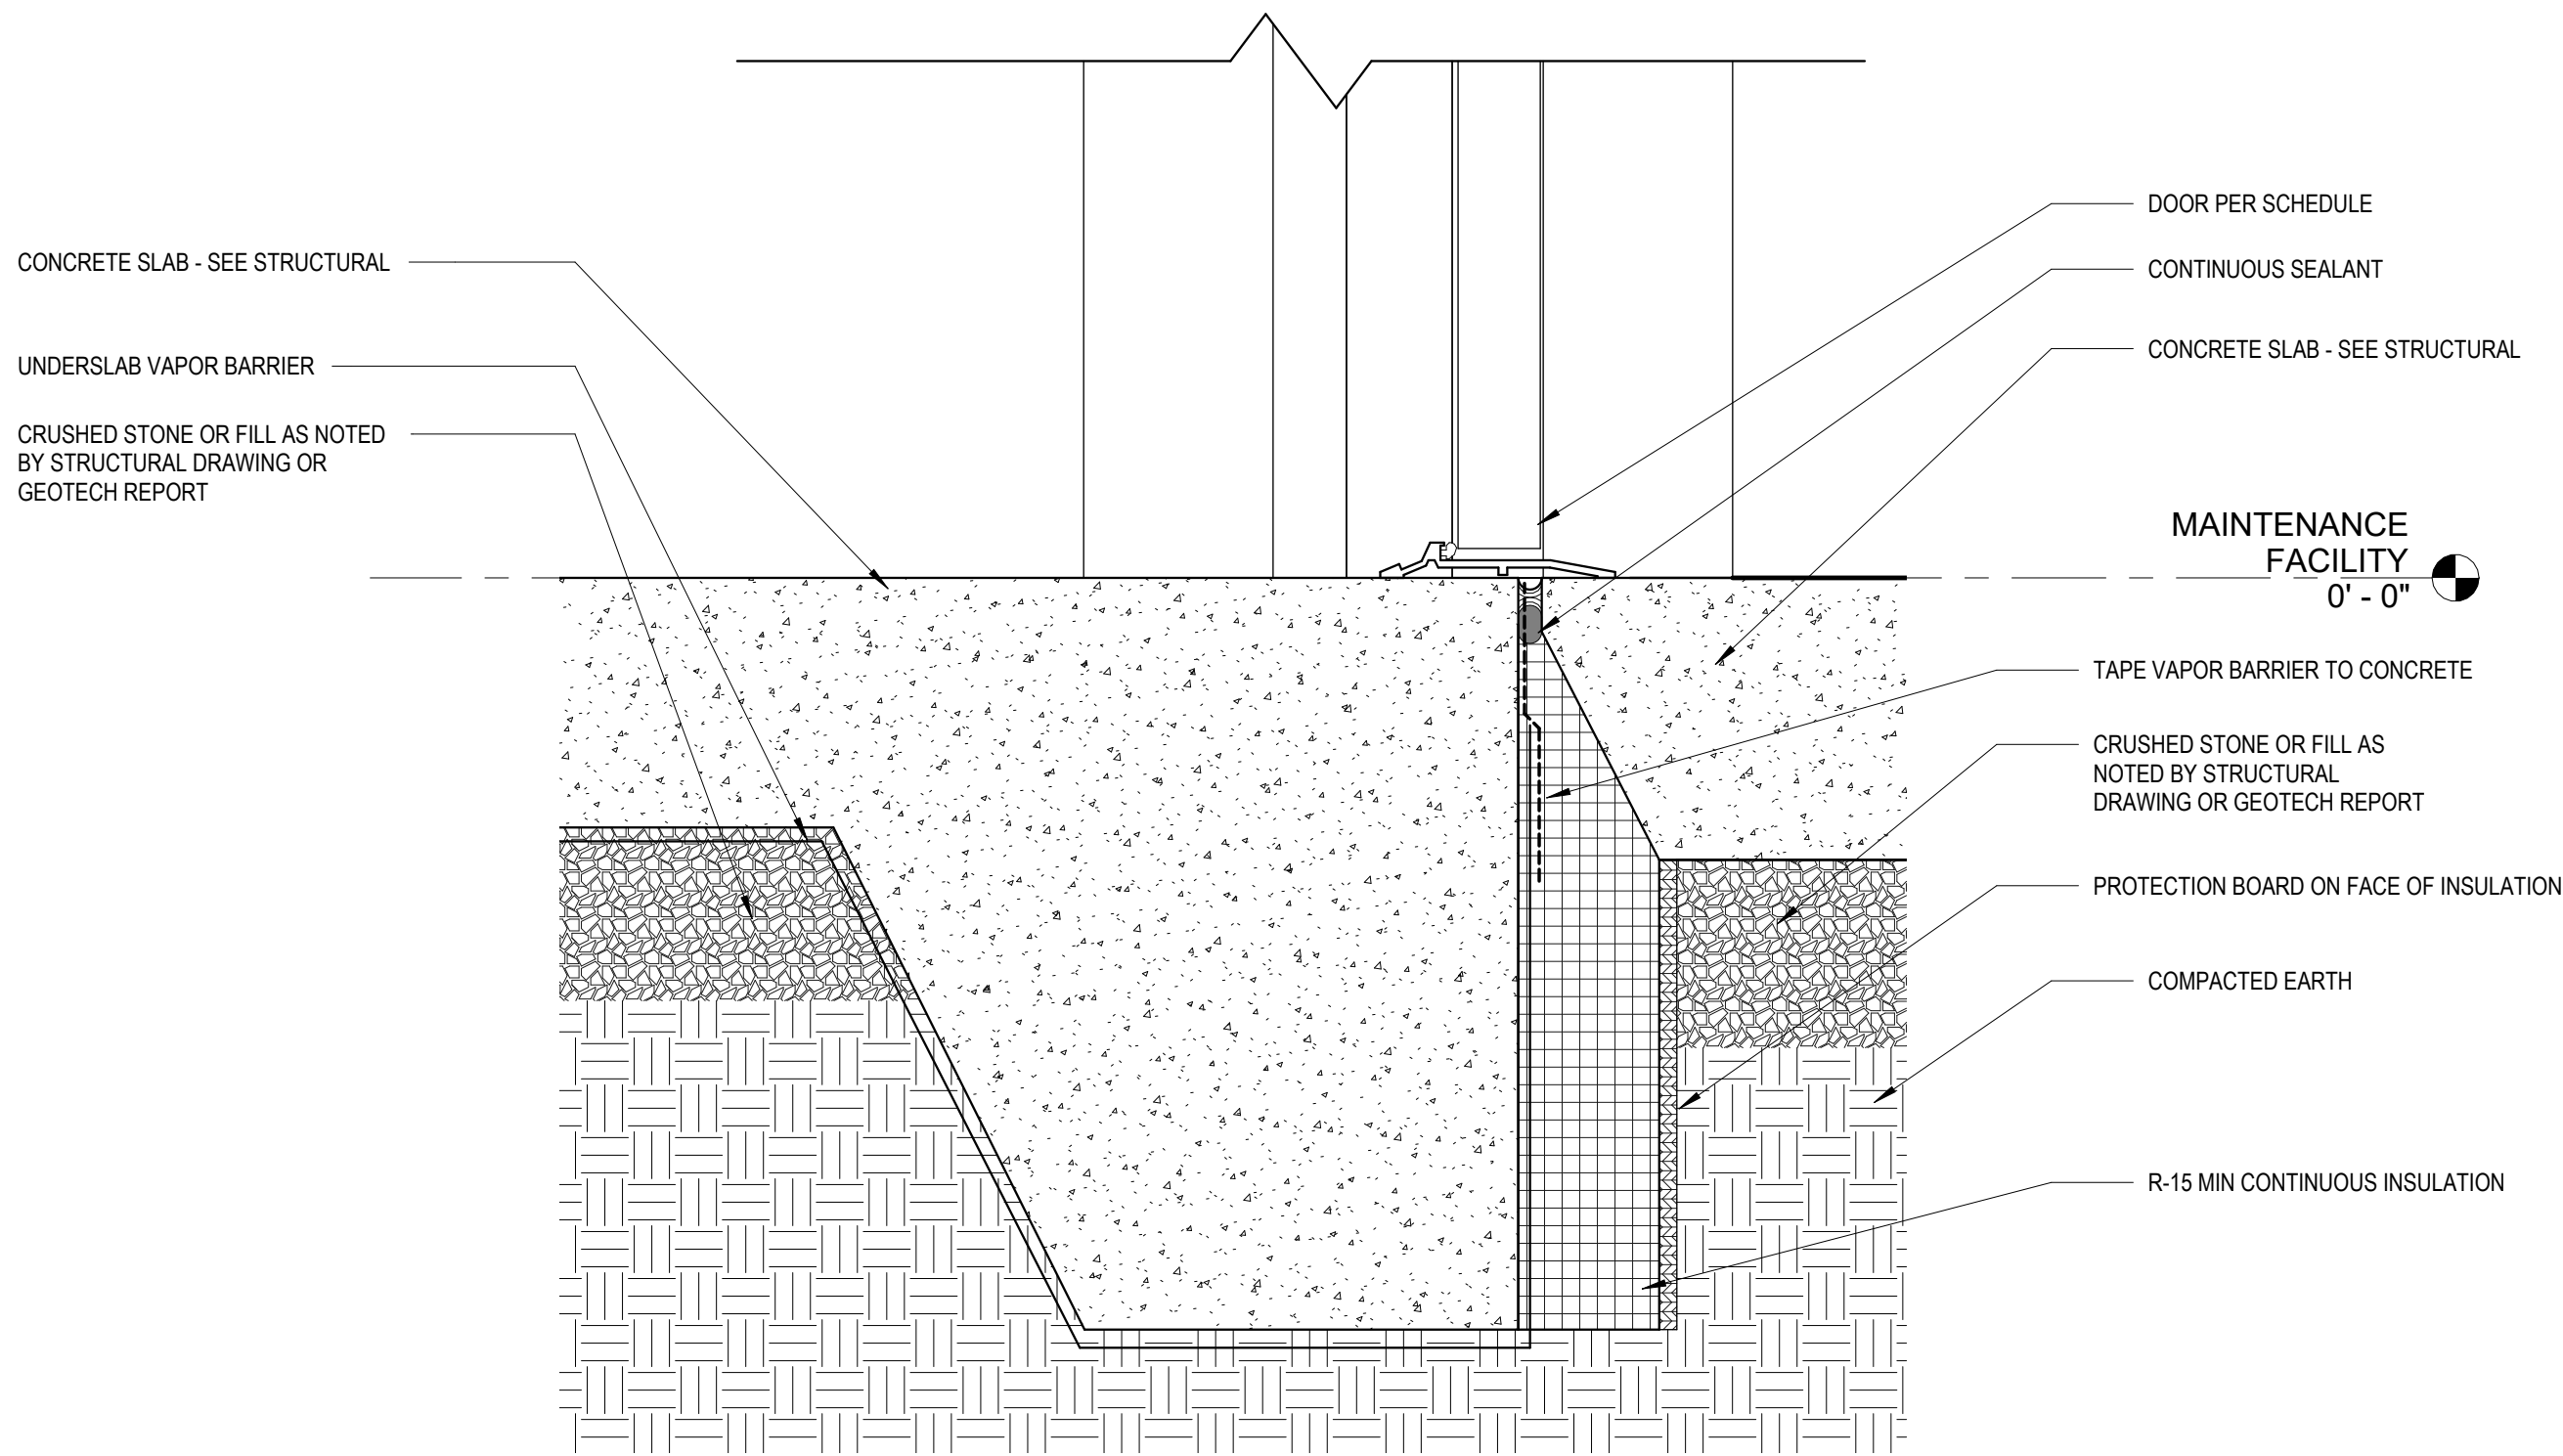

3 TYP. DETAIL @ BASE OF DOOR
MF-A506 3" = 1'-0"

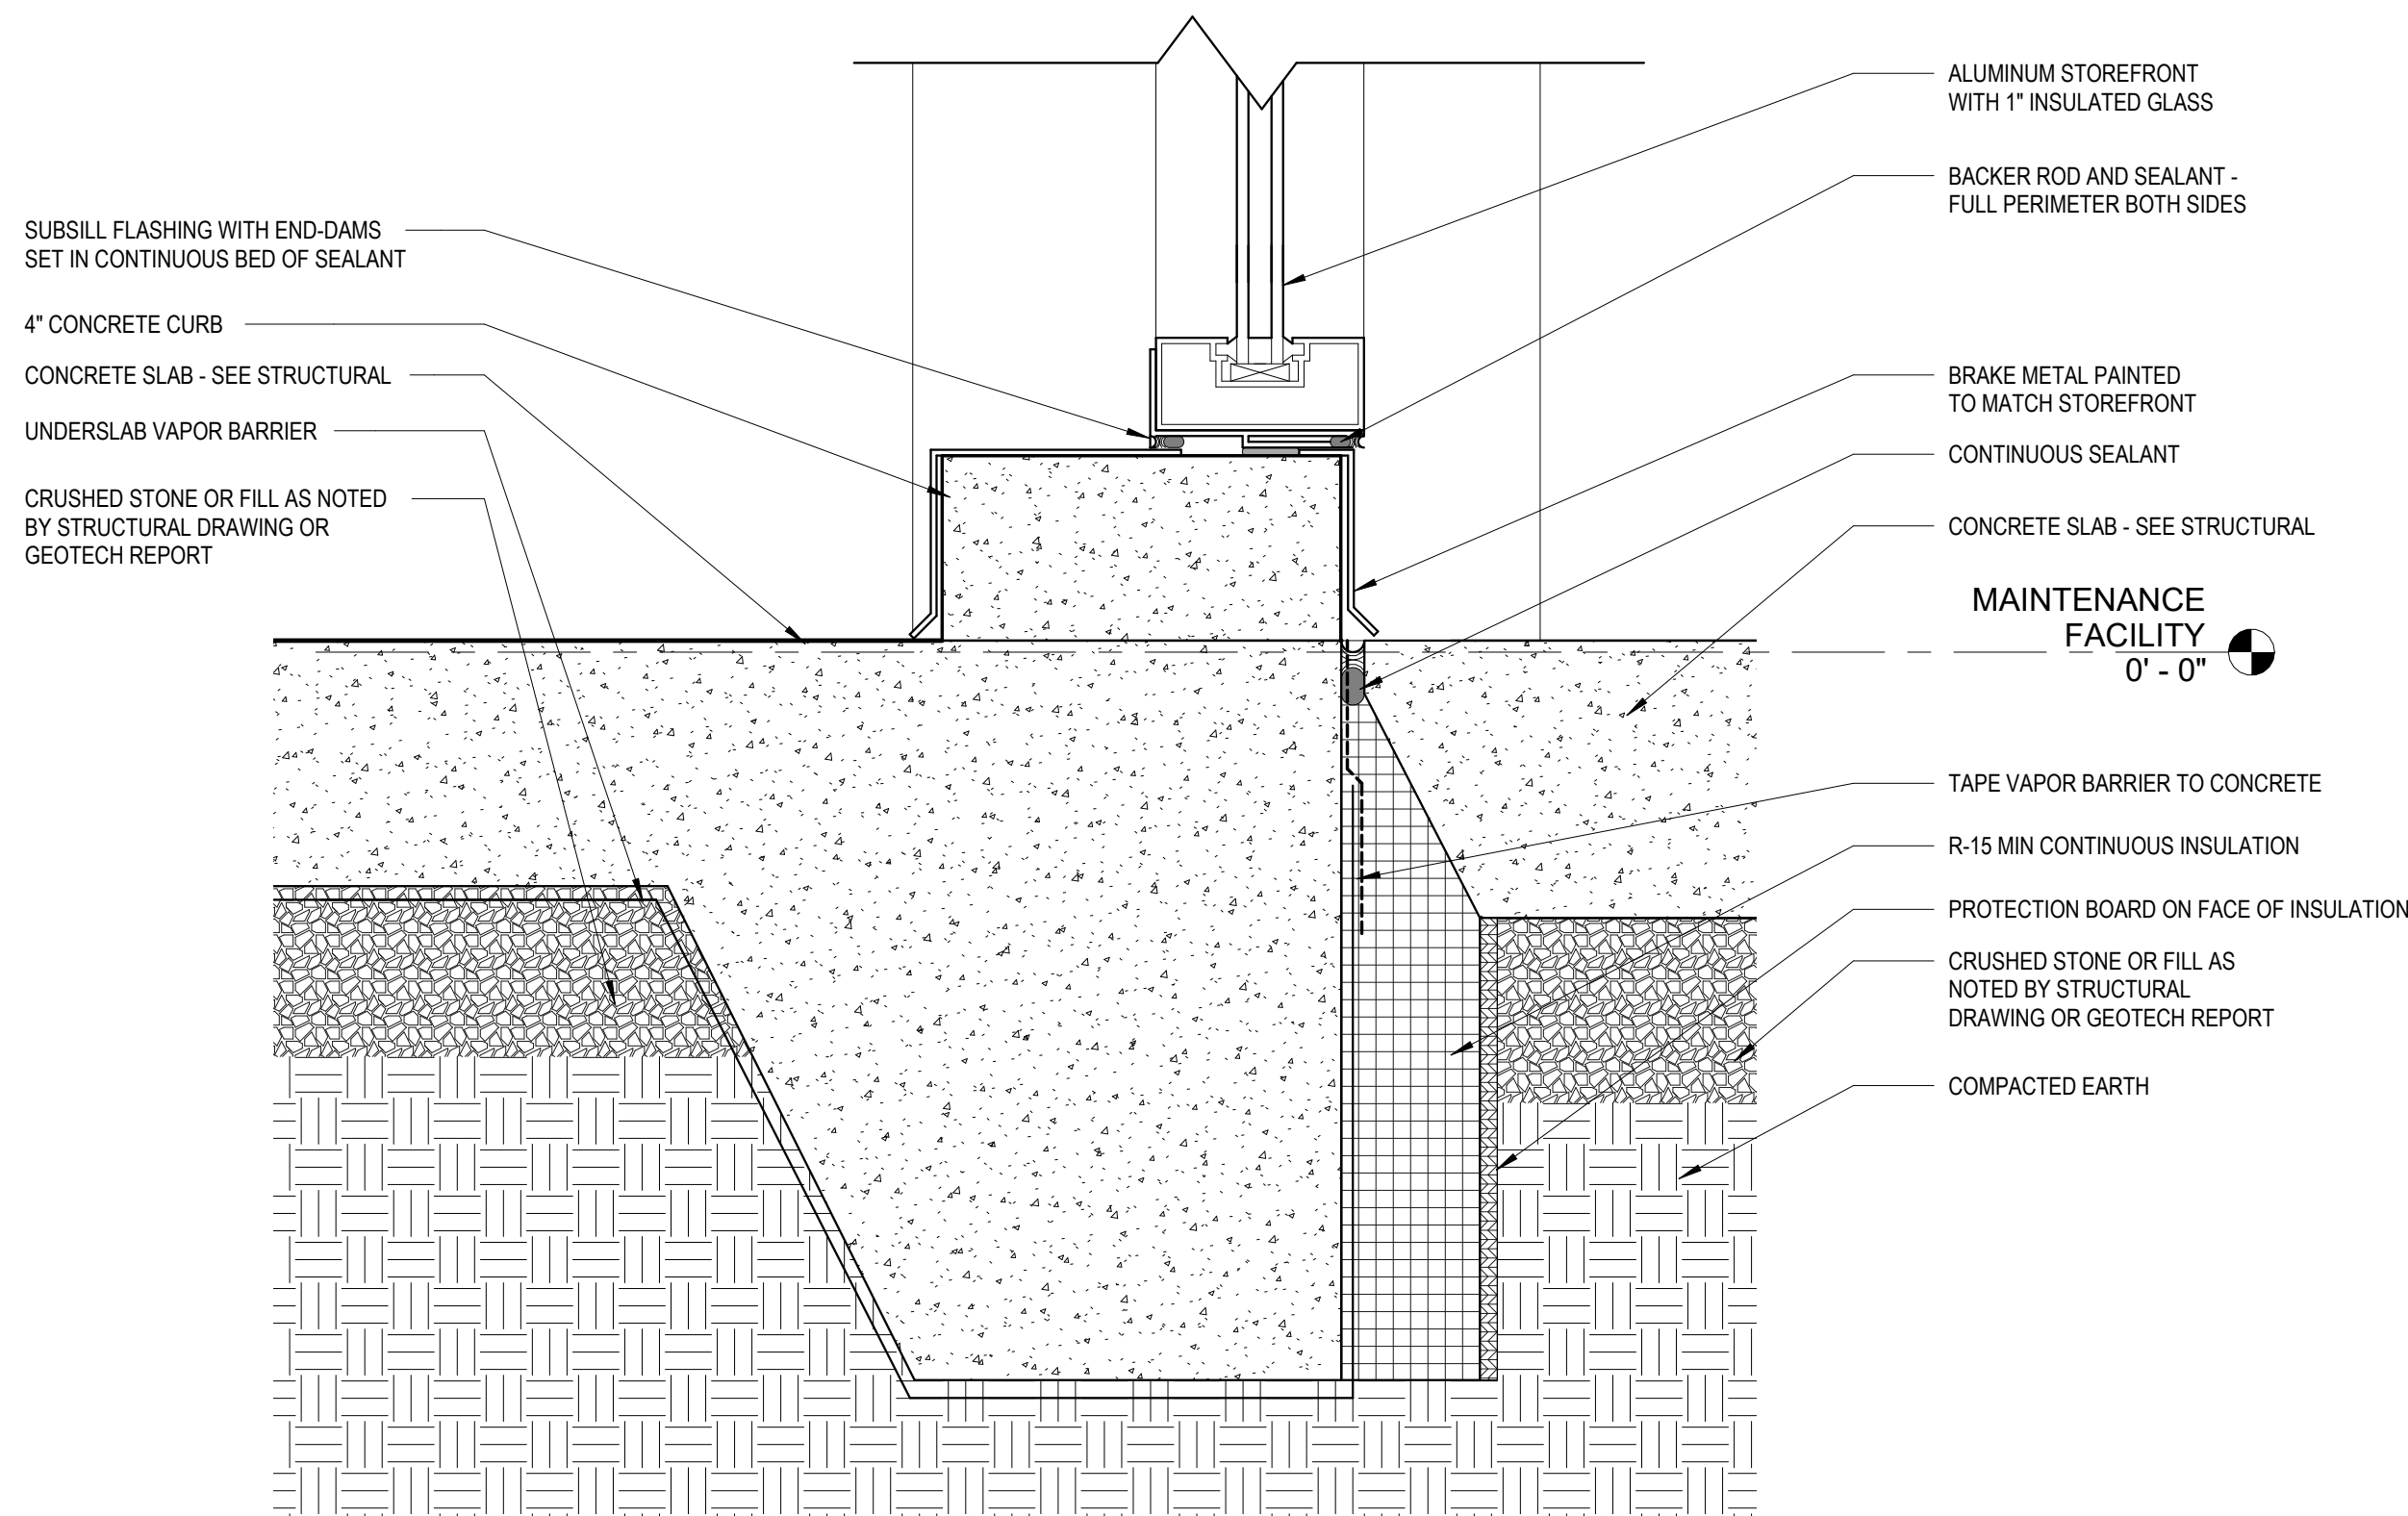

4 ENLARGED CURB DETAIL @ TYP. STOREFRONT
MF-A506 3" = 1'-0"

Susan Hatchell
Landscape Architecture, PLLC
711 W. North Street, Raleigh, NC 27603
p: 919-838-9600 f: 919-838-9700

Esse Architects
832 FISHING ROAD | RALEIGH, NORTH CAROLINA 27608


AIR BARRIER
DETAILS


LAKE MYRA COUNTY PARK
Wake County, NC

REVISIONS


Date: 07/27/26

MF-A506

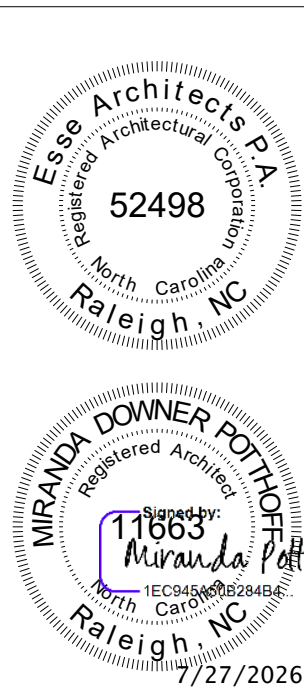


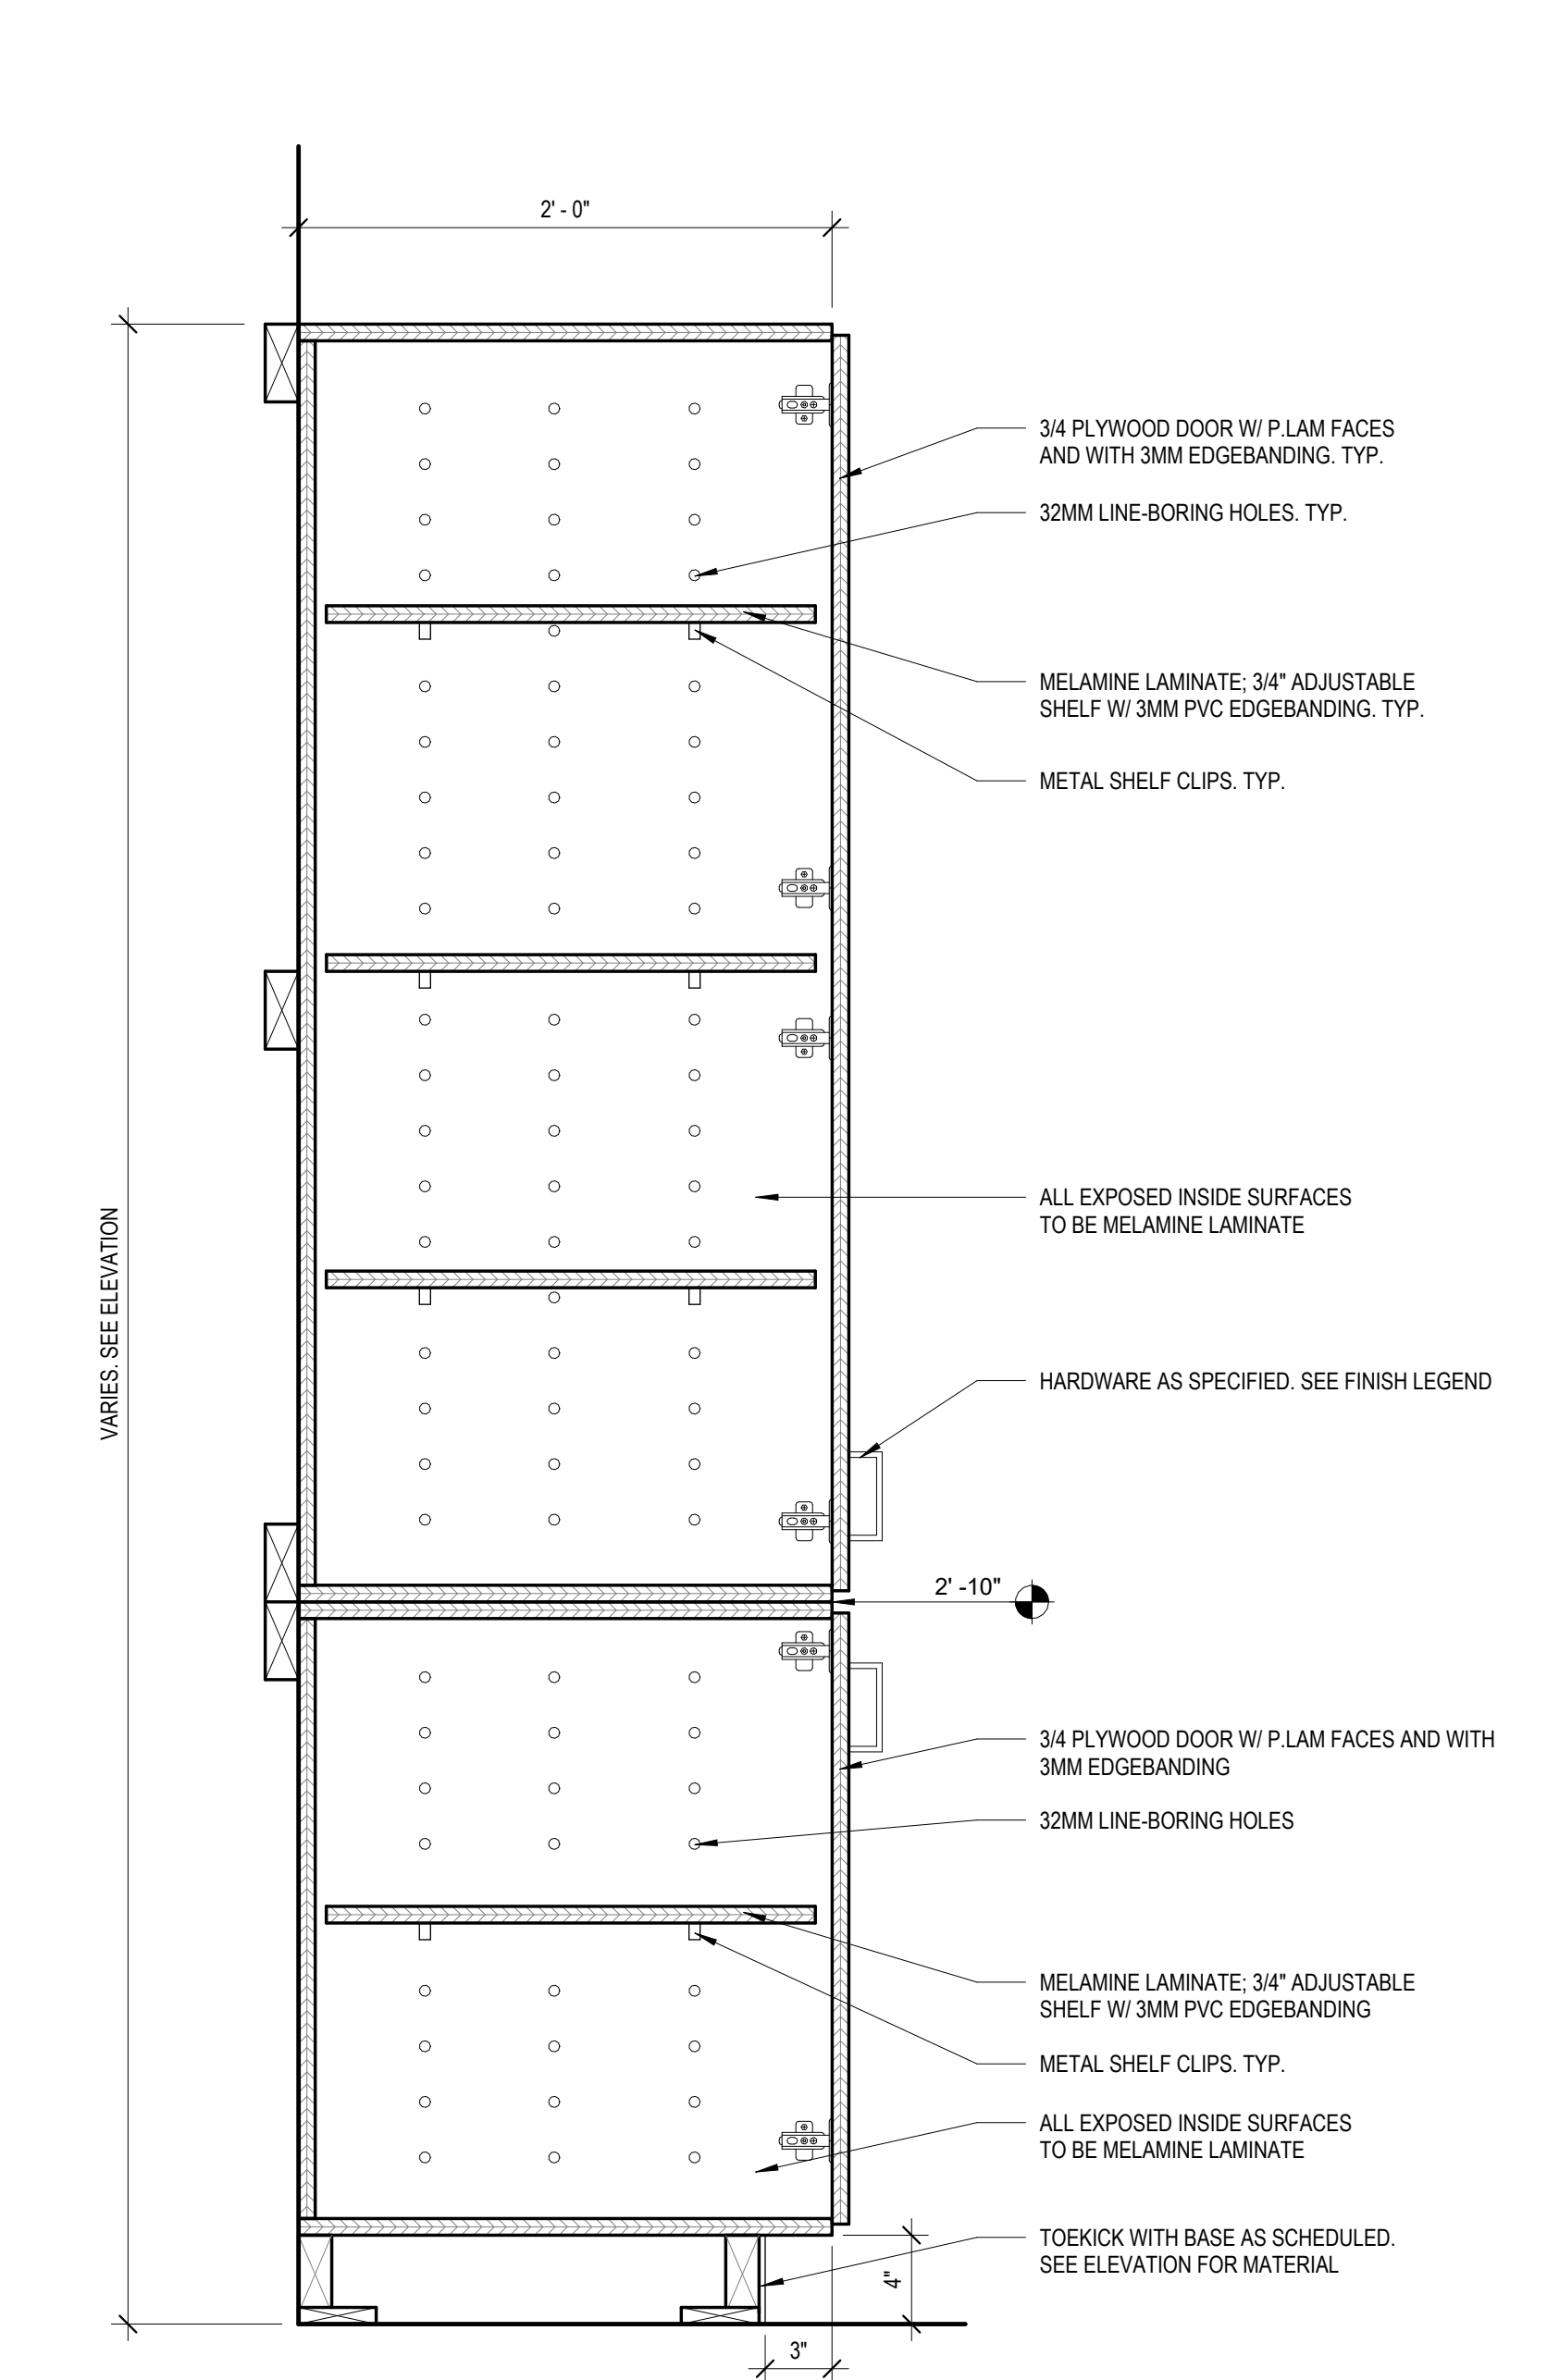


1 TYP. PANTRY W/ ADJUSTABLE SHELVING (CW01)
MF-A510 1 1/2" = 1'-0"

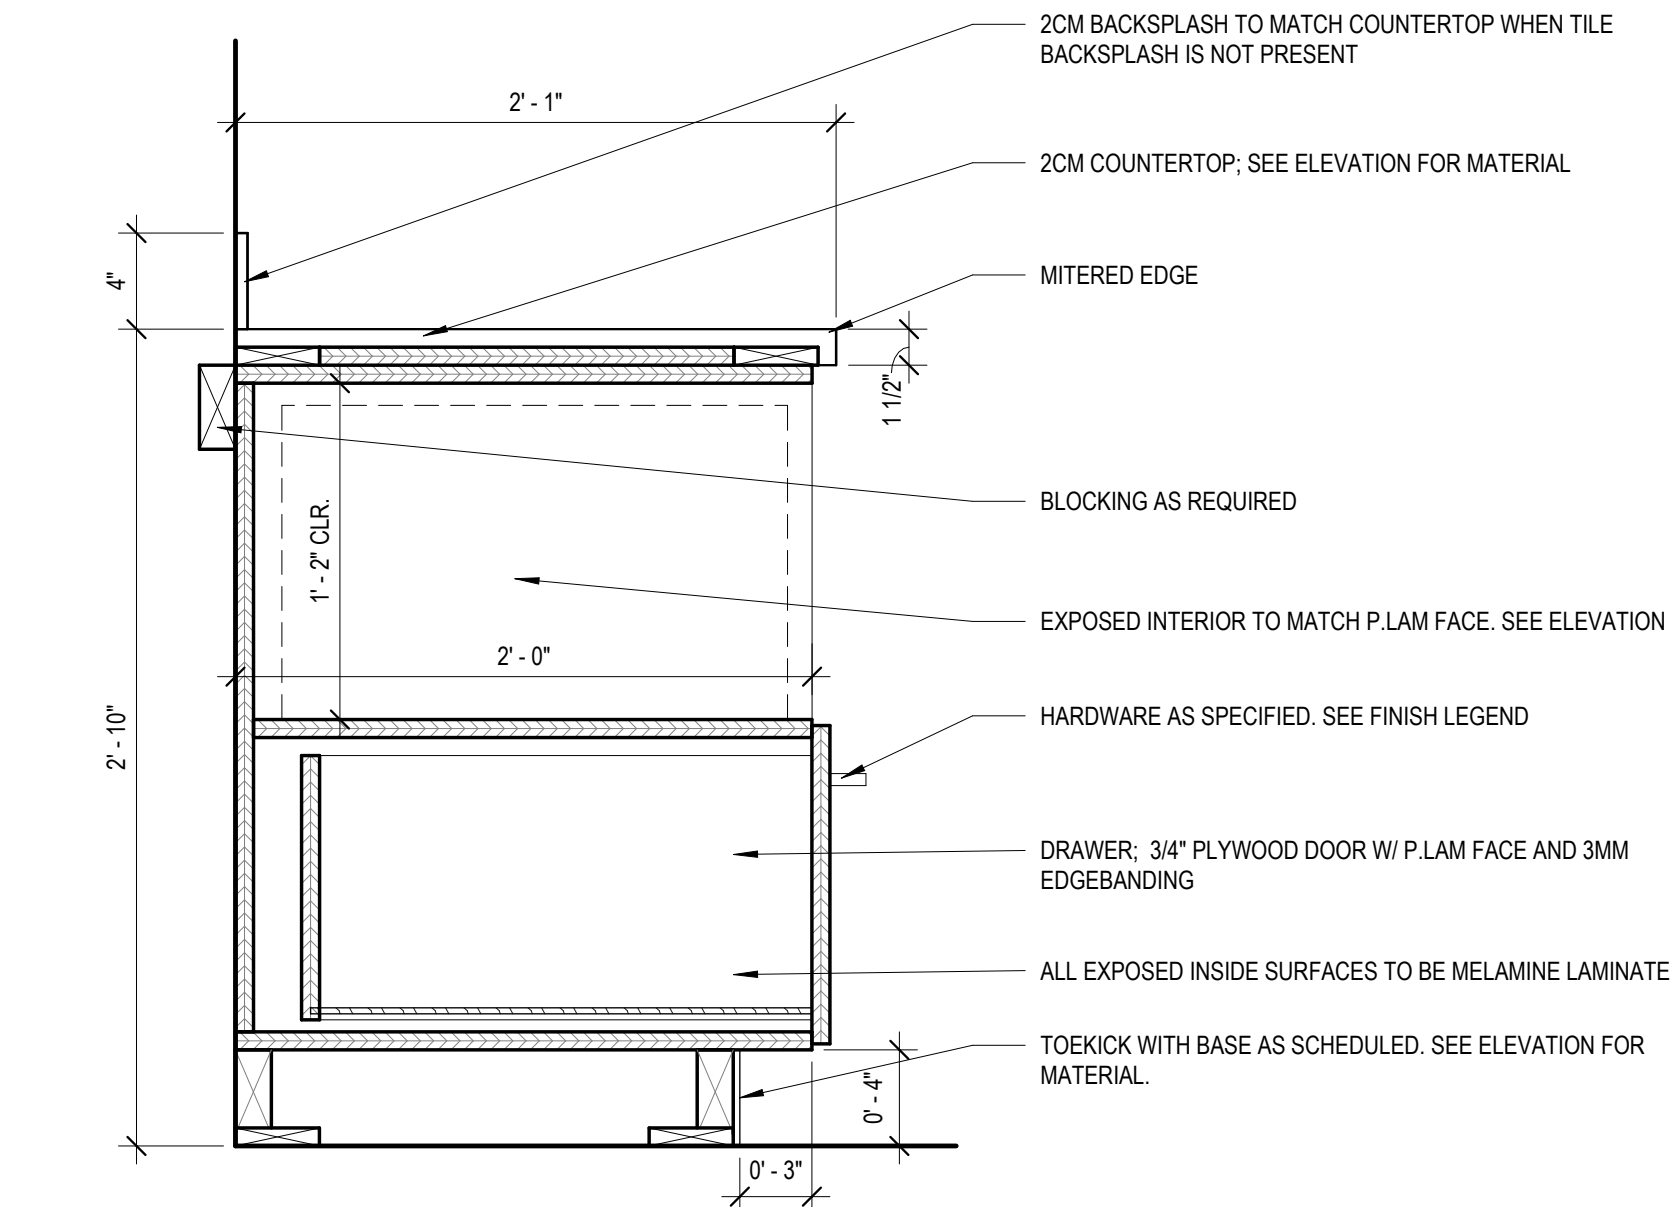


6 TYP. BASE CABINET W/ MICROWAVE SHELF (CW04)
MF-A510 1 1/2" = 1'-0"

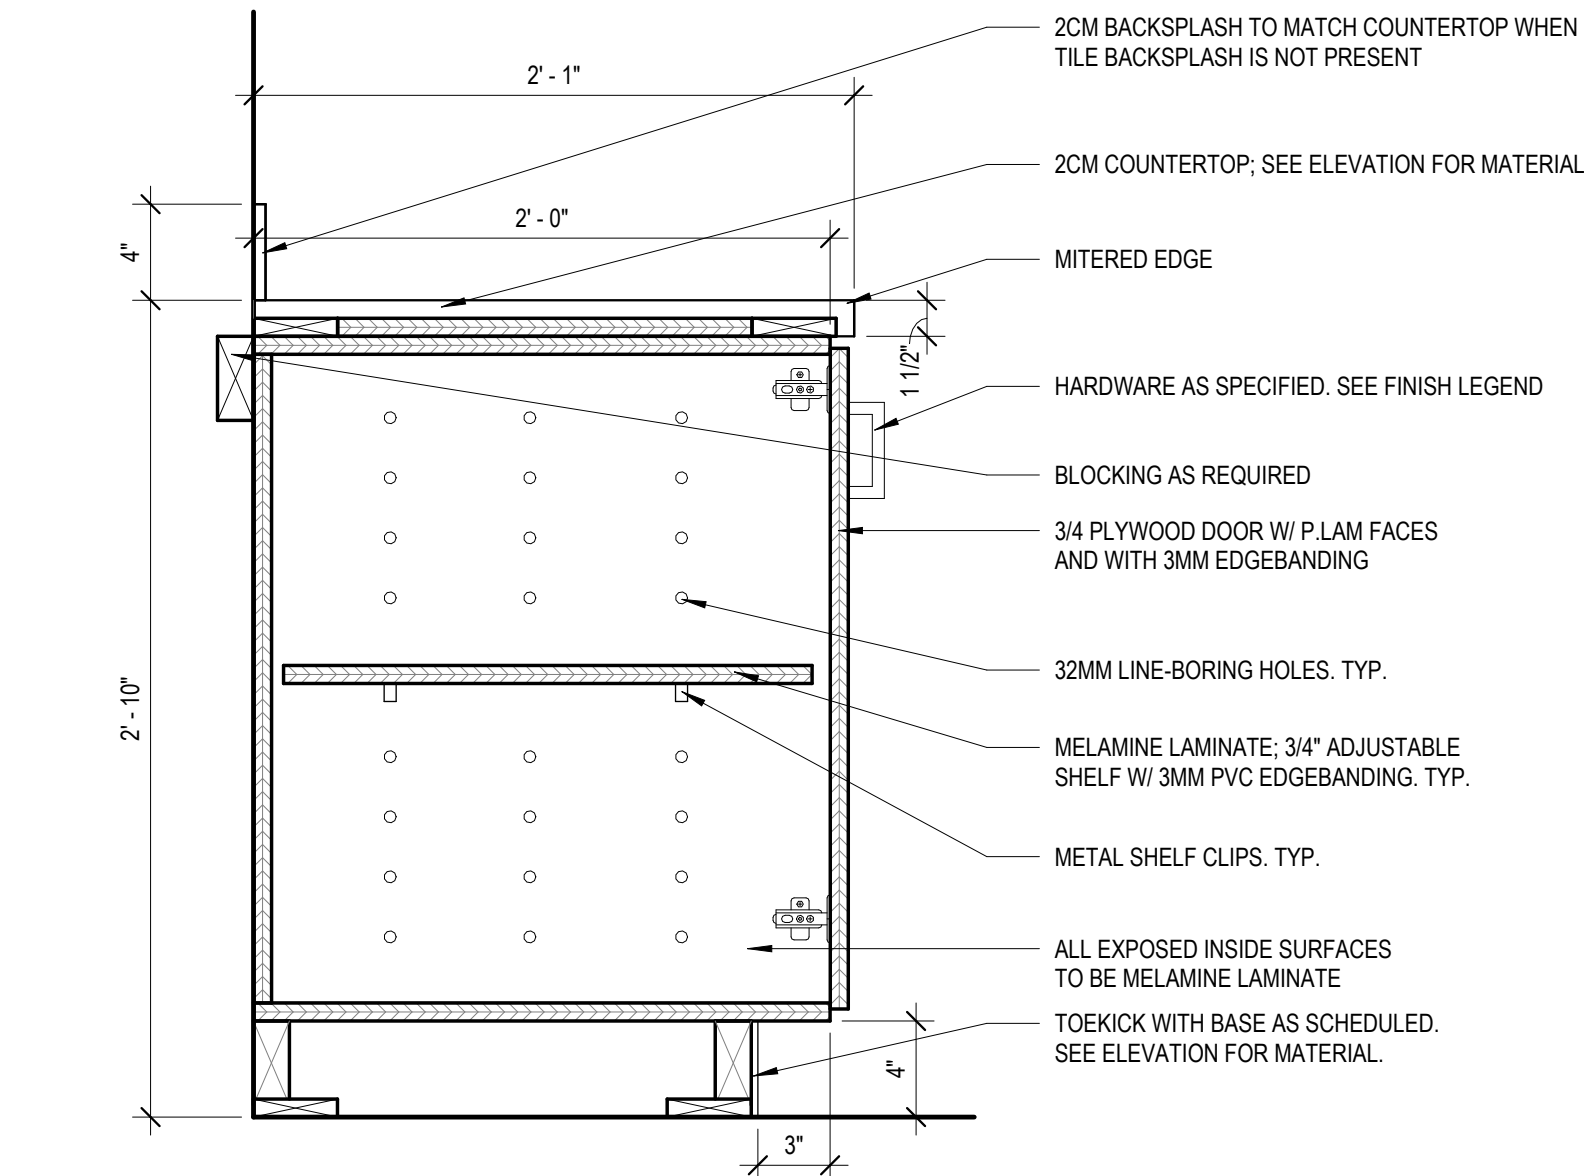


2 TYP. BASE CABINET W/ ADJUSTABLE SHELVING (CW02)
MF-A510 1 1/2" = 1'-0"

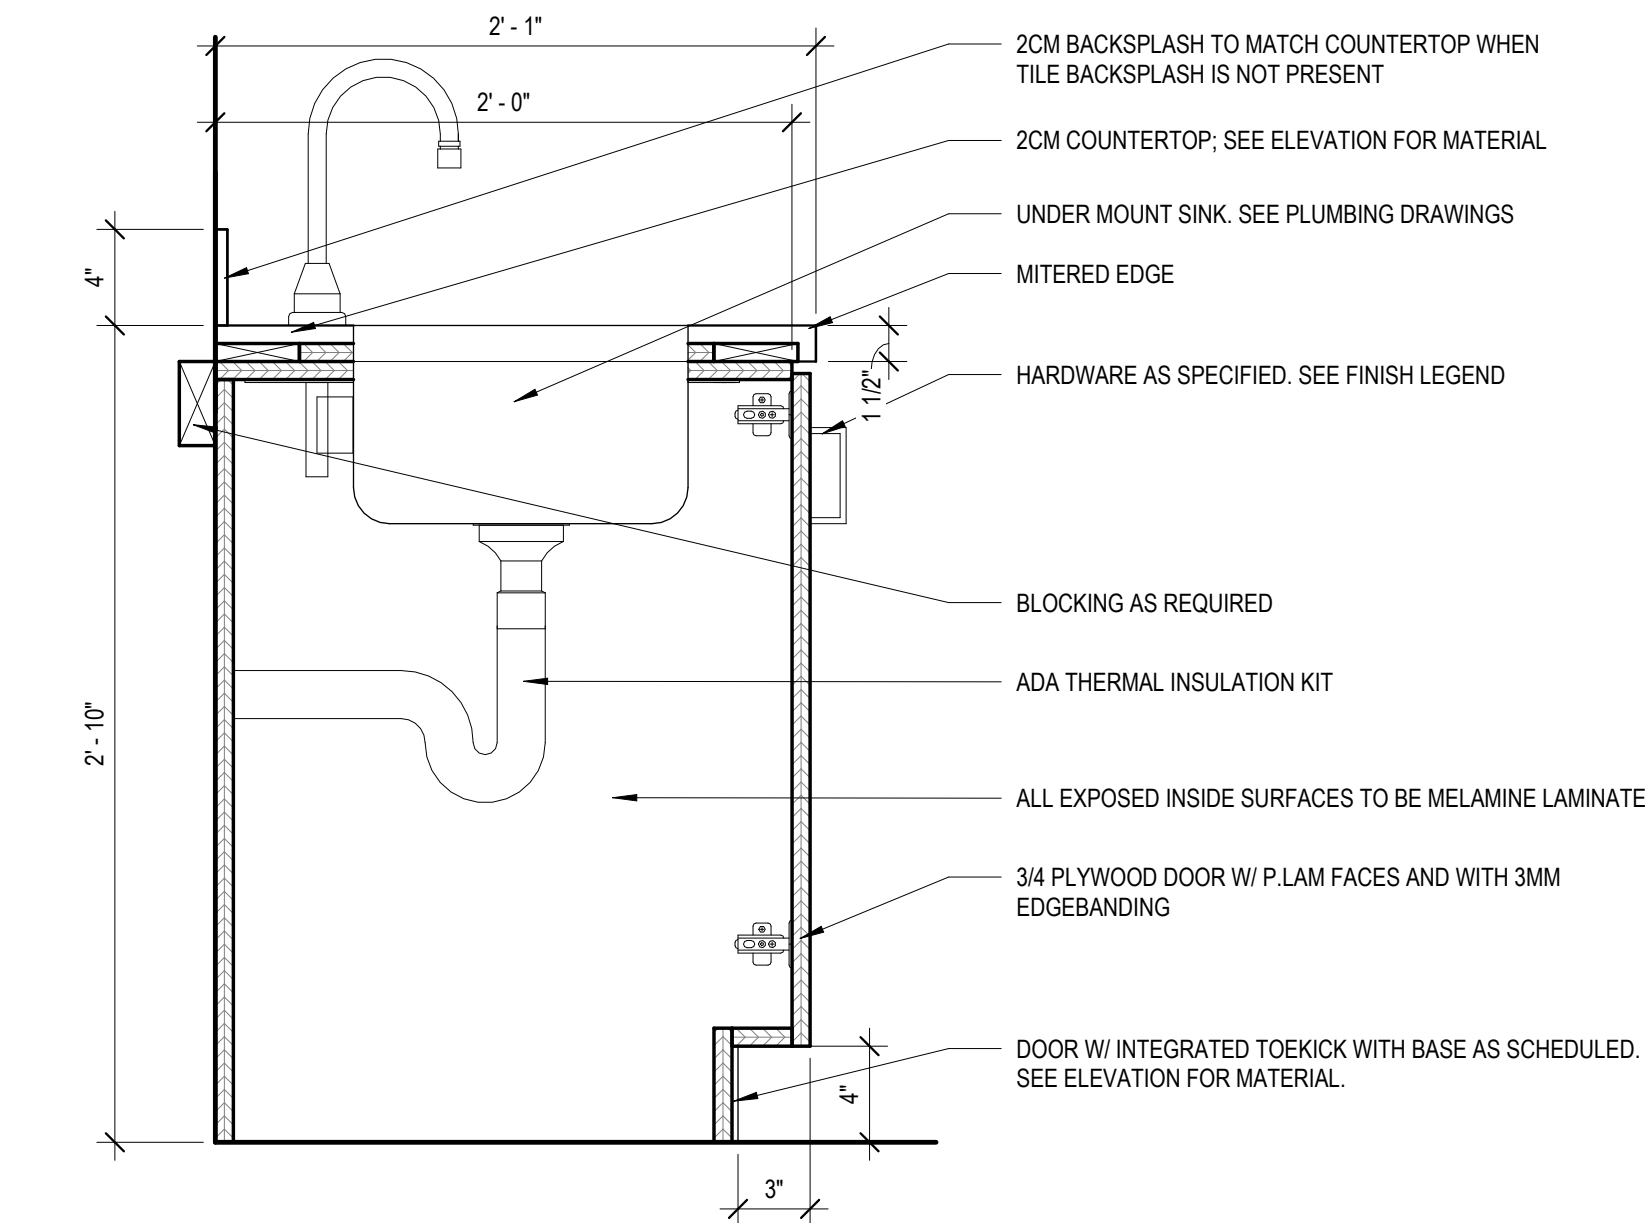


4 TYP. SINK W/ INTEGRATED TOE KICK (CW03)
MF-A510 1 1/2" = 1'-0"

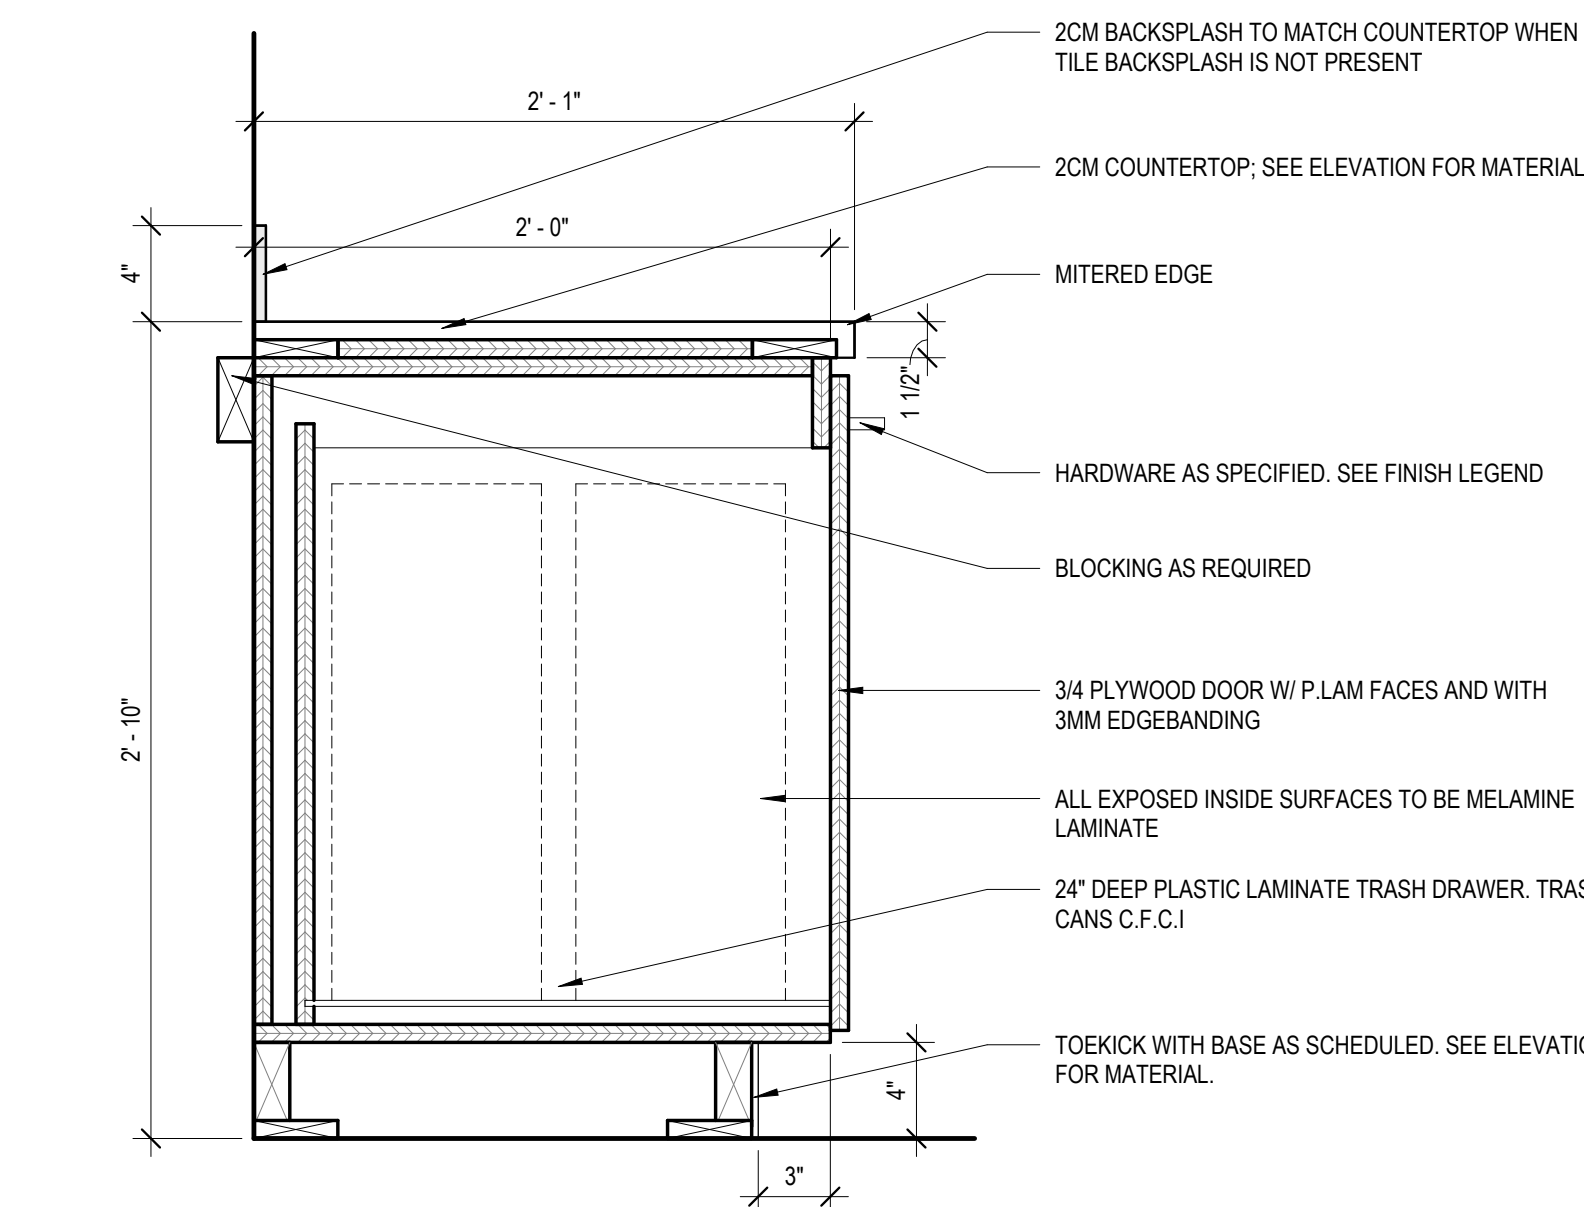


7 TYP. BASE CABINET W/ PULL OUT TRASH & RECYCLING (CW05)
MF-A510 1 1/2" = 1'-0"

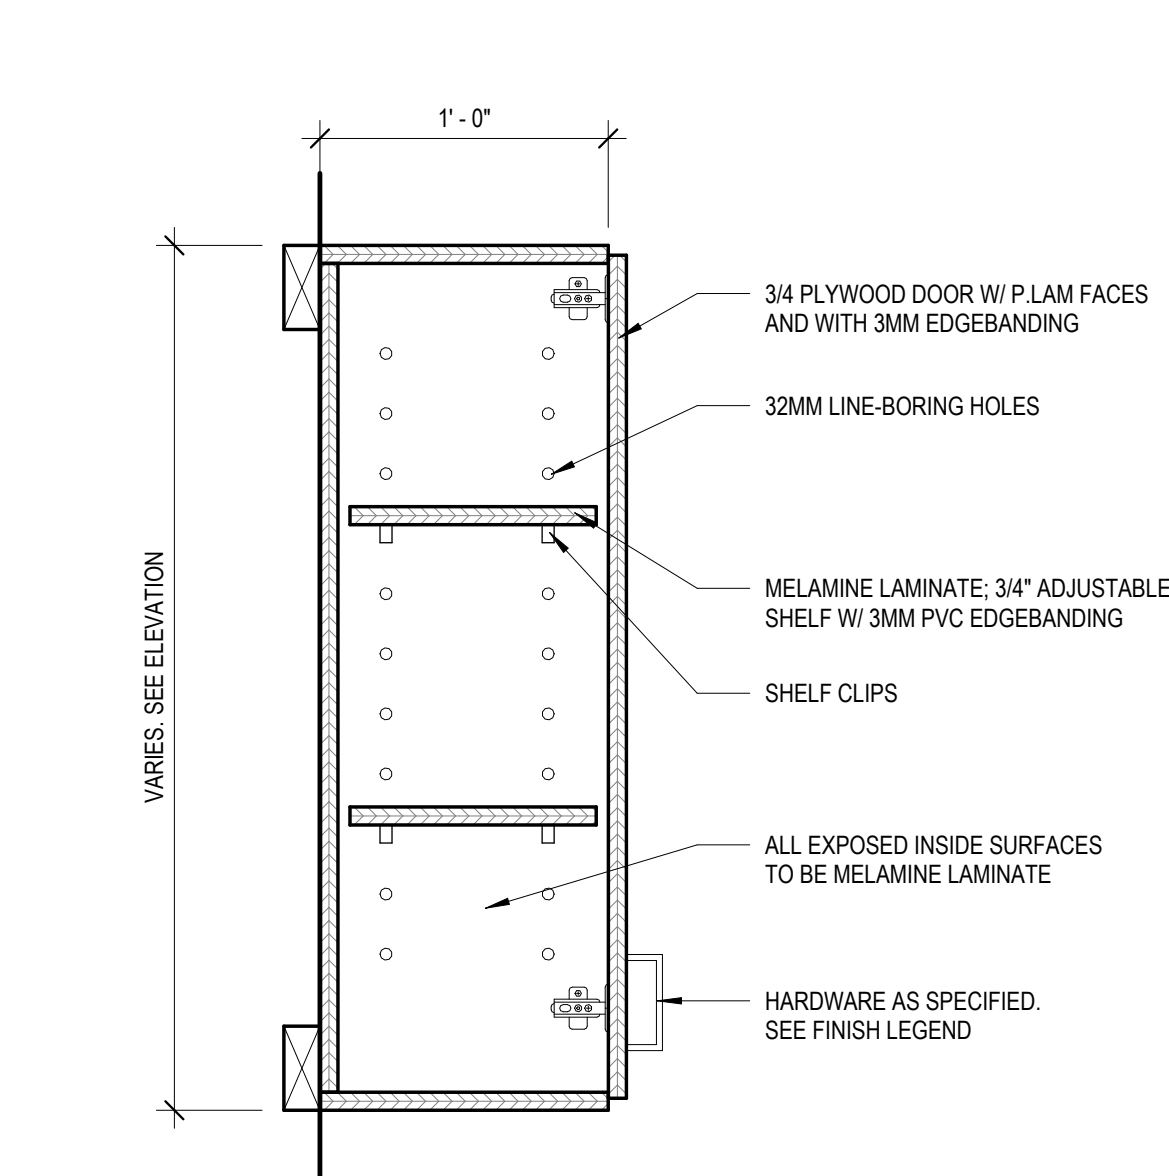

3 TYP. UPPER CABINET W/ SHELVING (CW07)
MF-A510 1 1/2" = 1'-0"

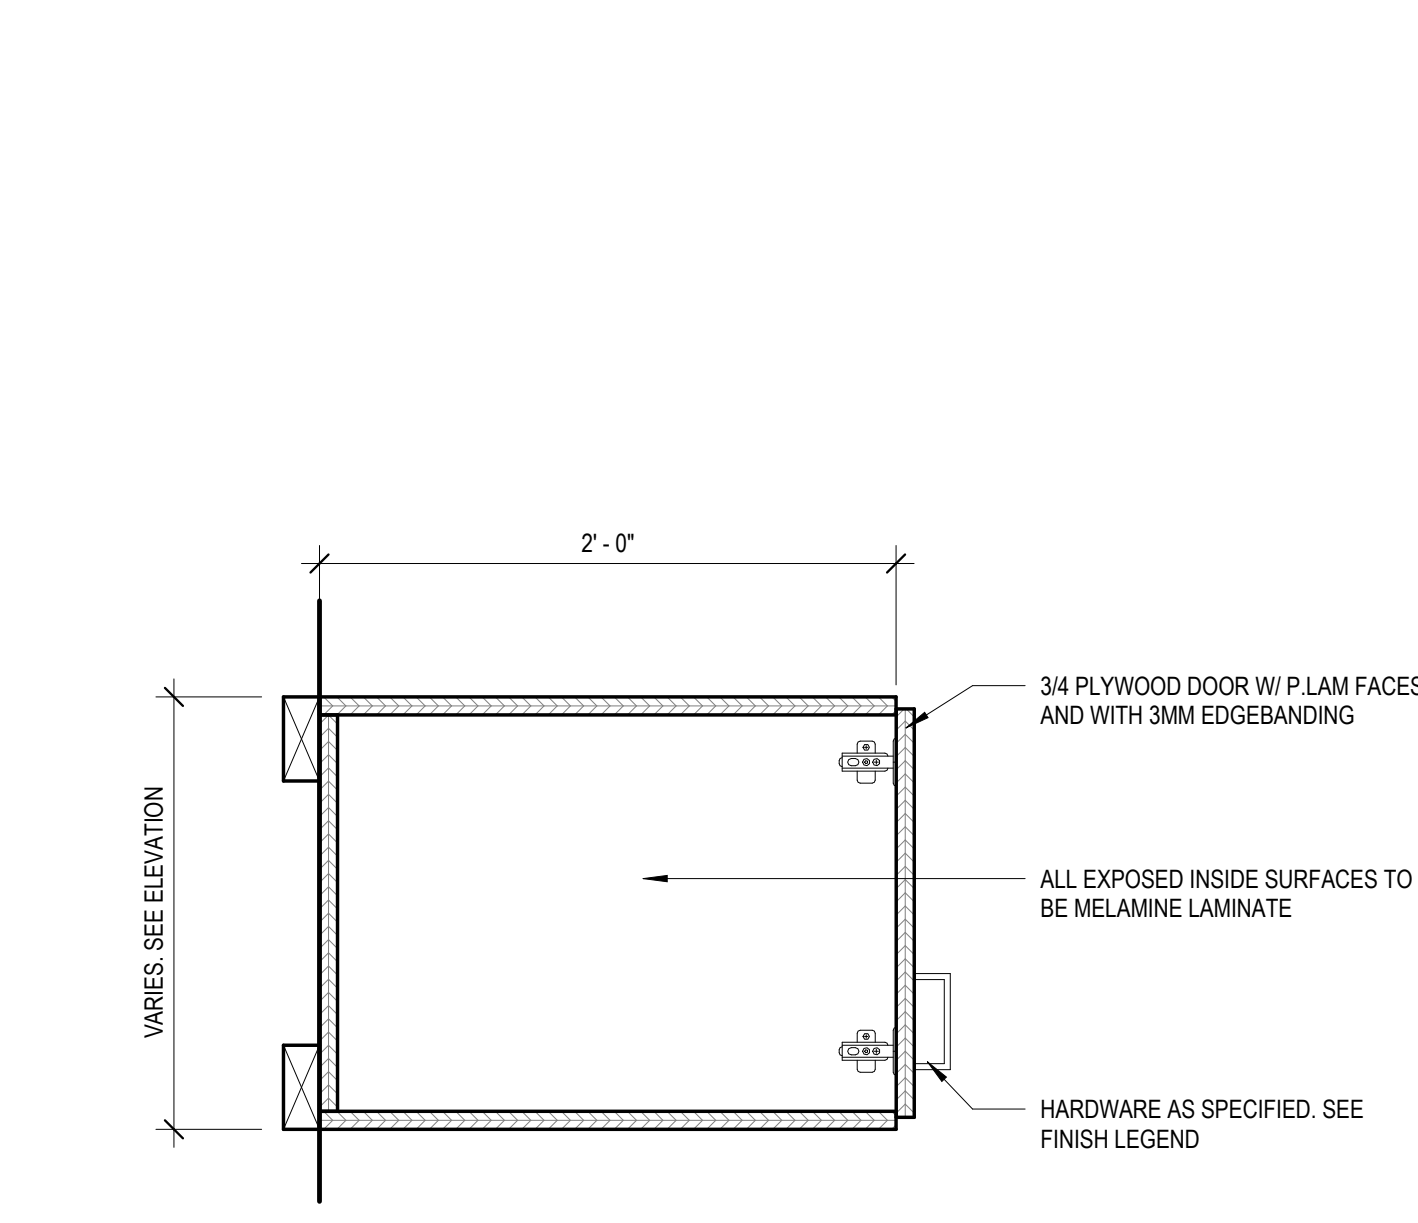

5 TYP. UPPER CABINET @ REFRIGERATOR (CW06)
MF-A510 1 1/2" = 1'-0"

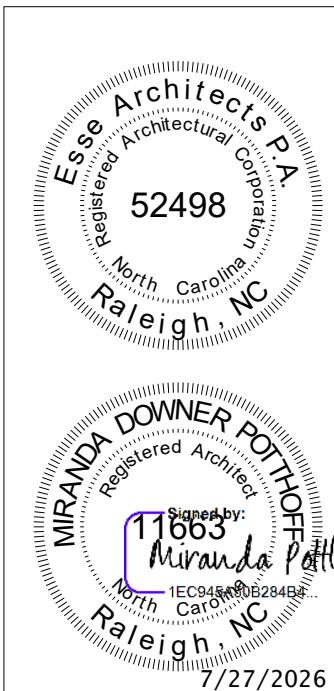

REVISIONS	


Date: 07/27/26
MF-A510

MILLWORK DETAILS


LAKE MYRA COUNTY PARK
Wake County, NC

Susan Hatchell
Landscape Architecture, PLLC
711 W. North Street, Raleigh, NC 27603
p: 919-838-9600 f: 919-838-9700




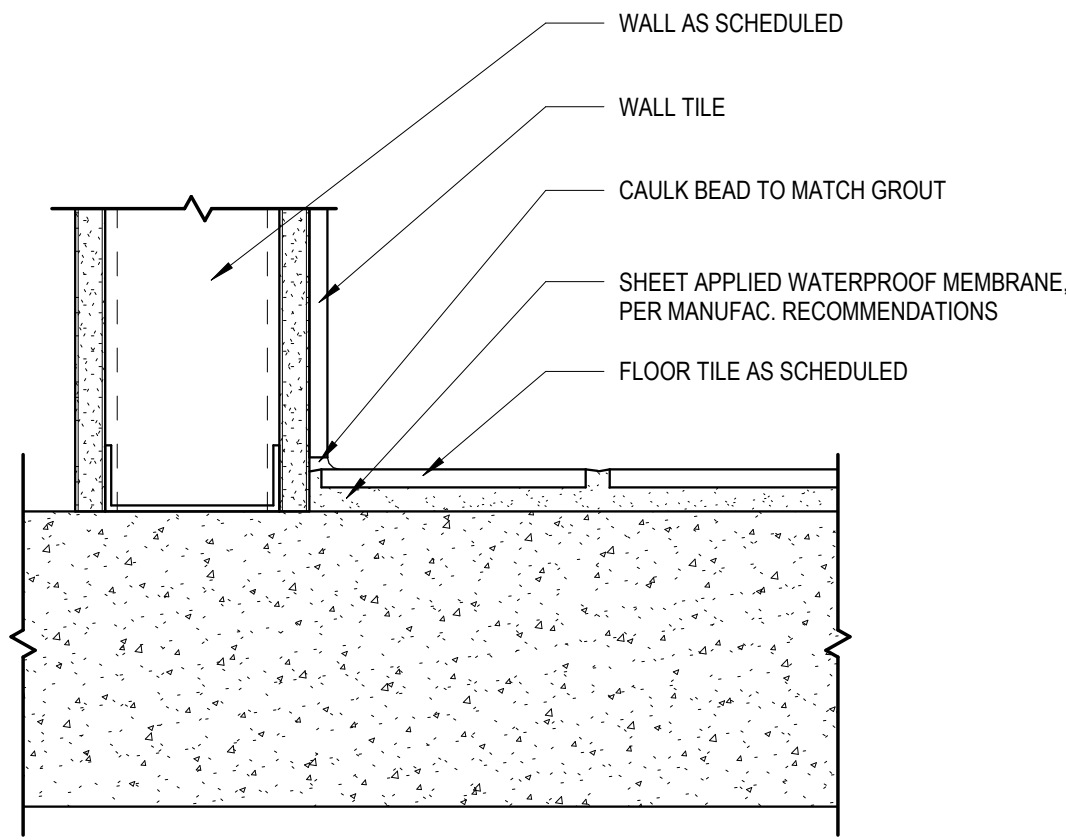


1 TYP. FLOOR TO WALL TILE TRANSITION
3" = 1'-0"

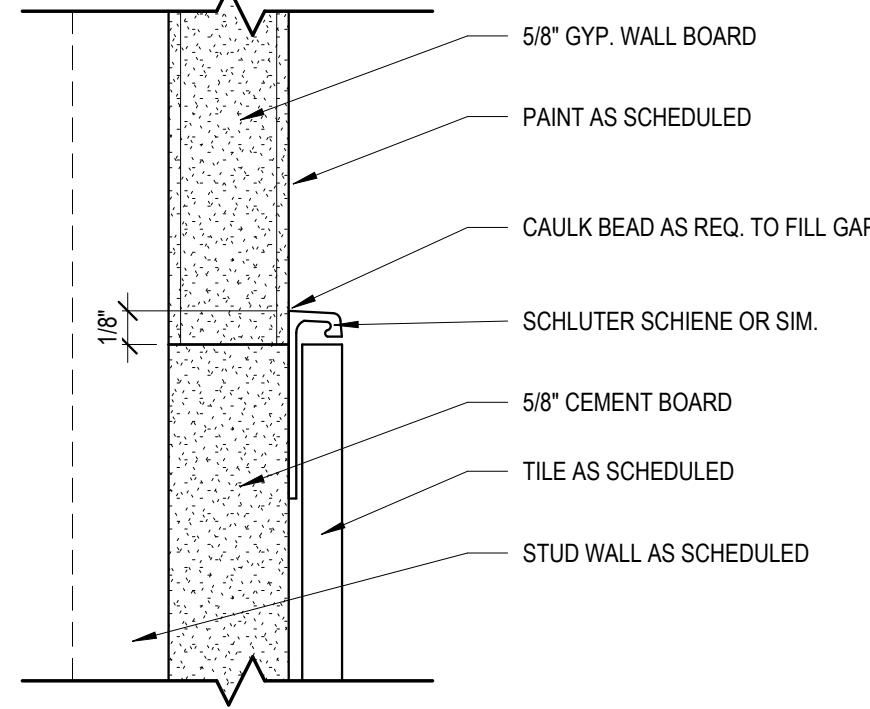


2 TYP. MID WALL TILE TERMINATION
12" = 1'-0"

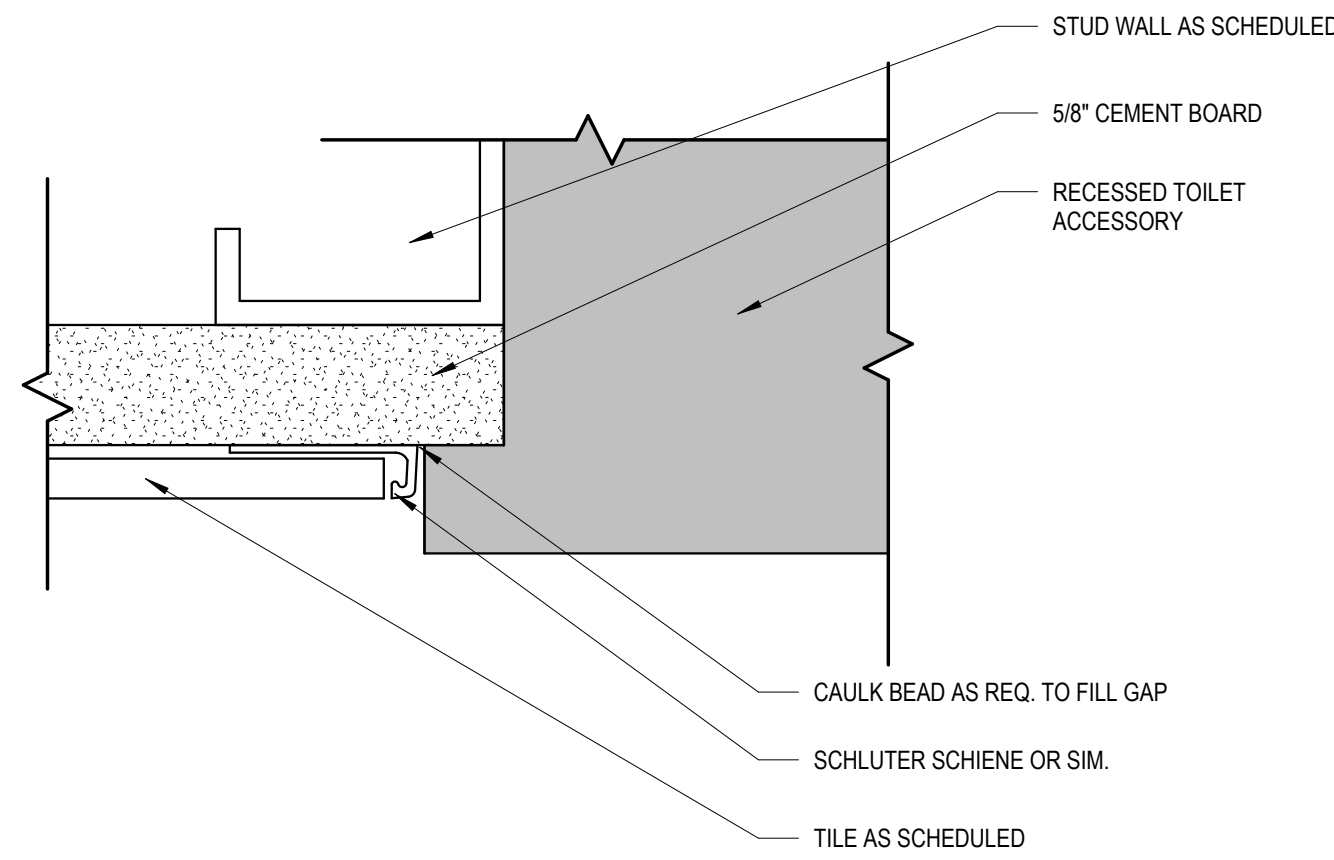


3 TYP. TILE TERMINATION @ TOILET ACCESSORY
12" = 1'-0"

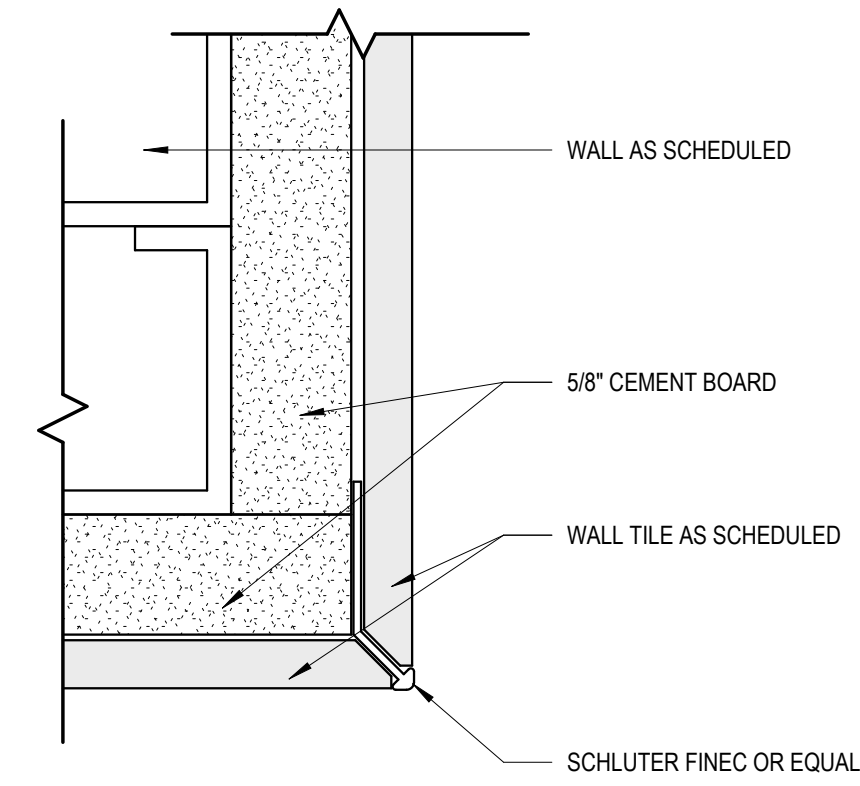

4 TYP. WALL TILE OUTSIDE CORNER
12" = 1'-0"

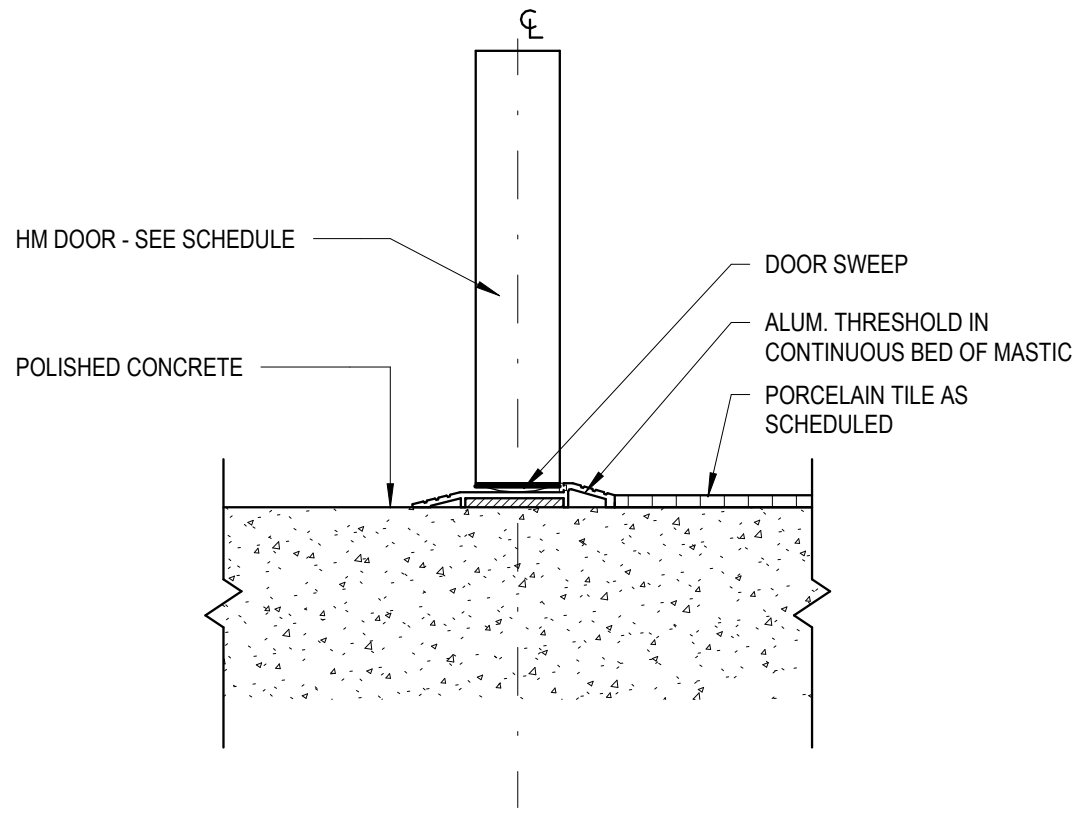

5 TRANSITION - CONCRETE TO TILE
3" = 1'-0"

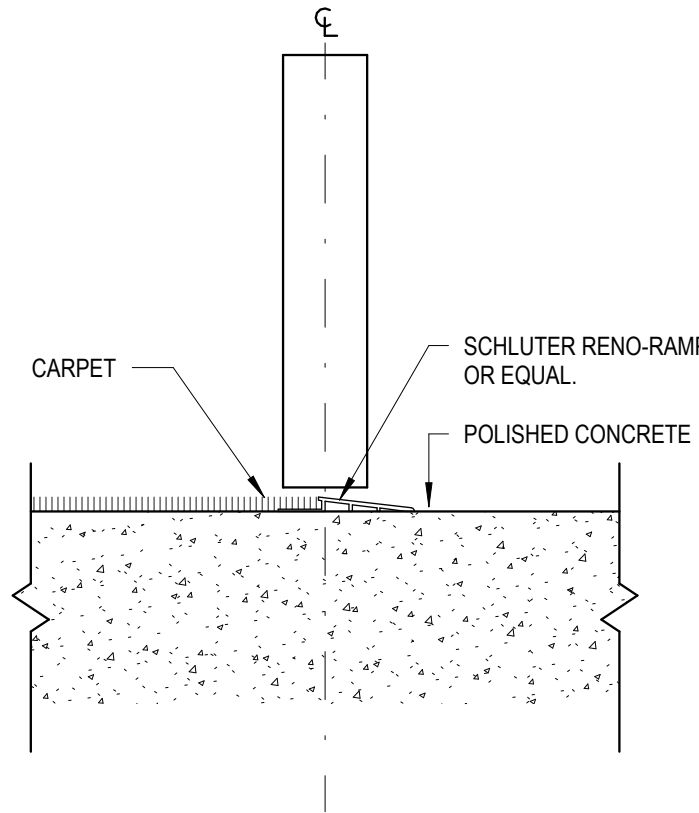

6 TRANSITION - CARPET TO CONCRETE
3" = 1'-0"

Susan
Hatchell
Landscape Architecture, PLLC
711 W. North Street, Raleigh, NC 27603
p: 919-838-9600 f: 919-838-9700

Esse
Architects
832 FRESHING ROAD | RALEIGH, NORTH CAROLINA 27608


INTERIOR DETAILS


LAKE MYRA COUNTY PARK
Wake County, NC

REVISIONS


Date: 07/27/26

MF-A511

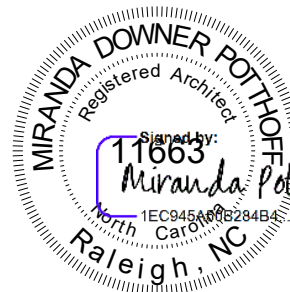


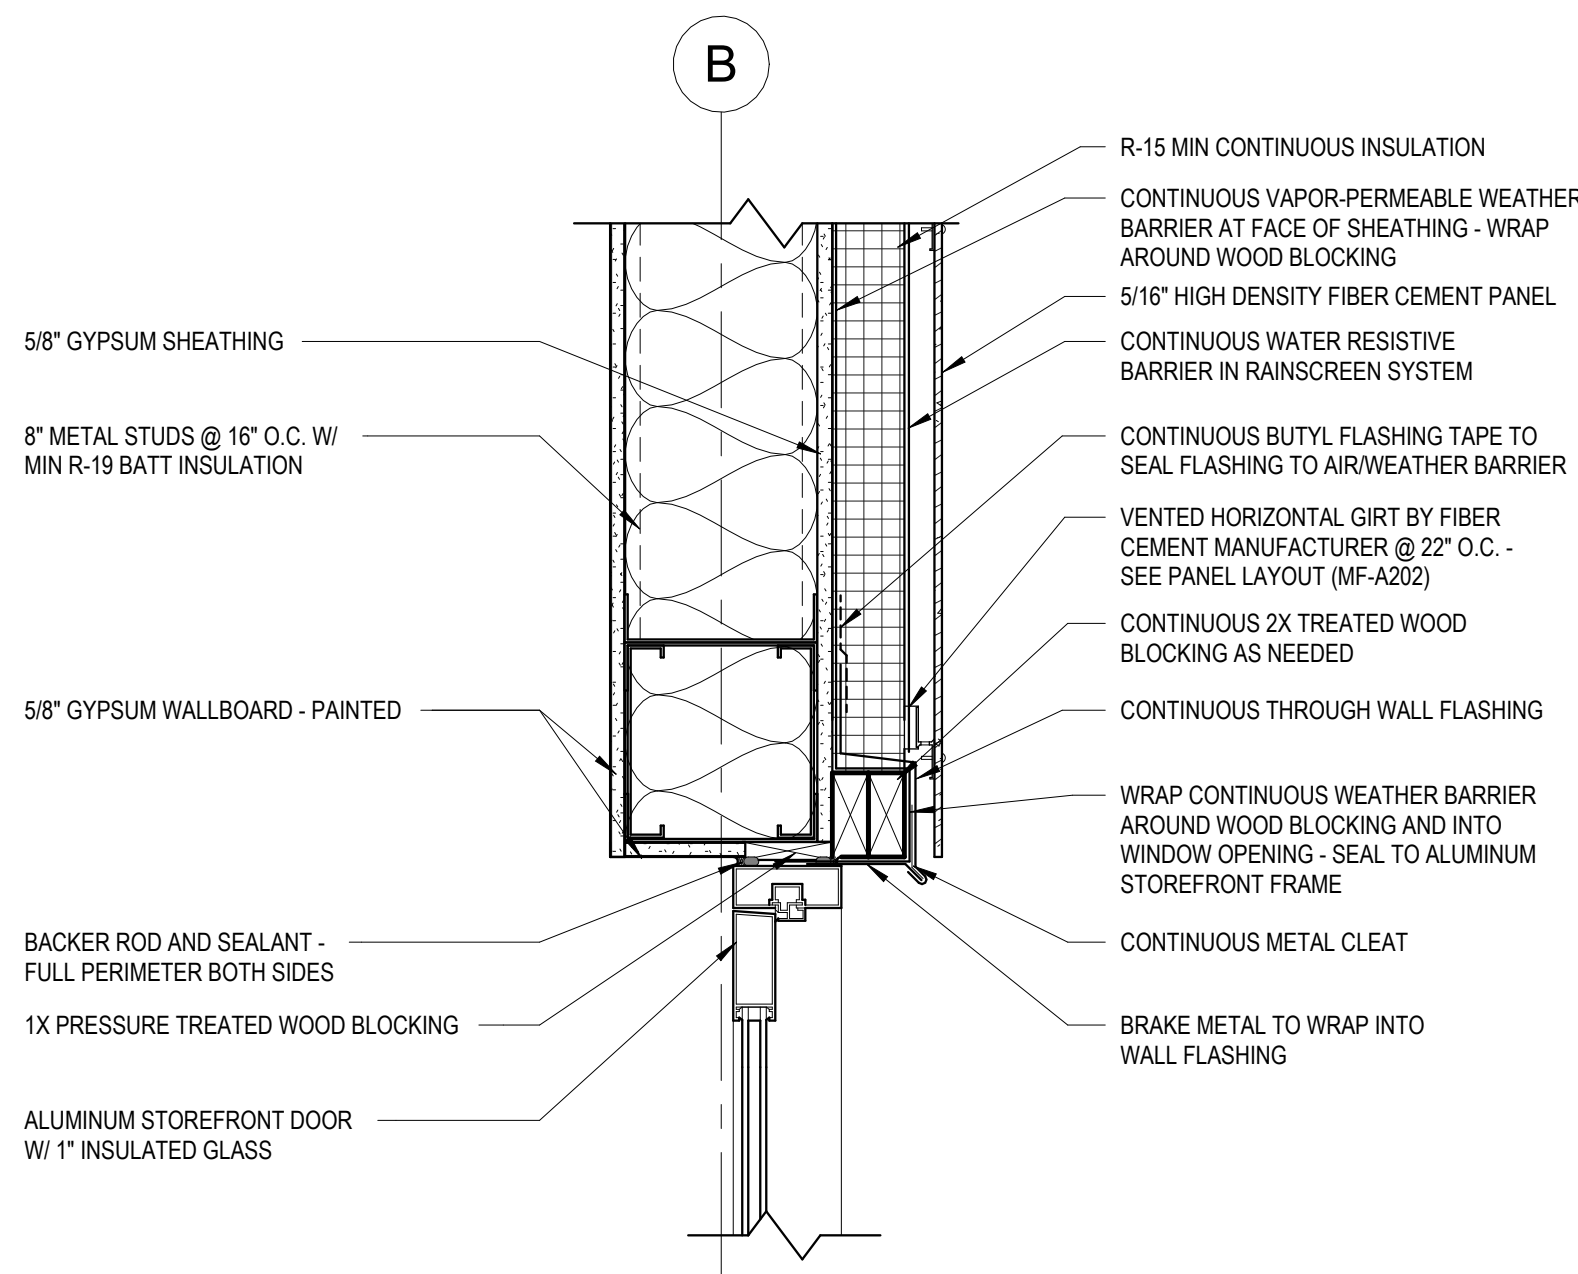


1 HEAD DETAIL @ MAINTENANCE ENTRY
MF-A521 1 1/2" = 1'-0"

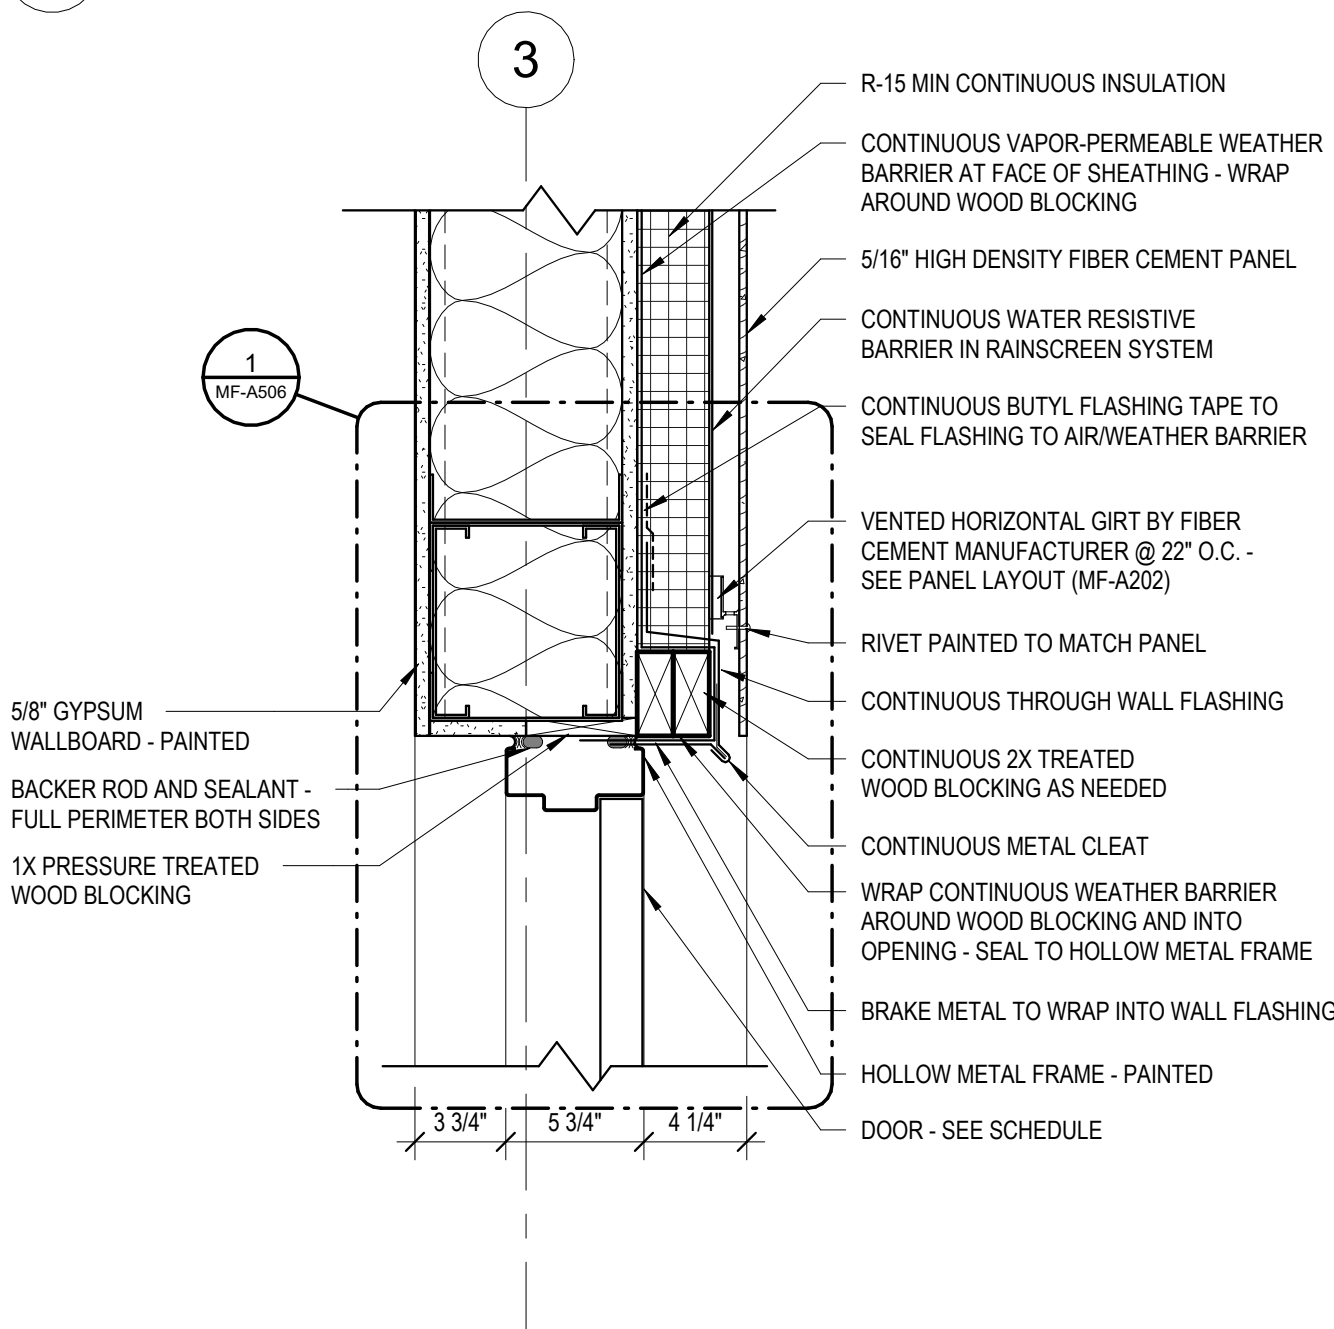

4 HEAD DETAIL @ EXTERIOR DOOR
MF-A521 1 1/2" = 1'-0"

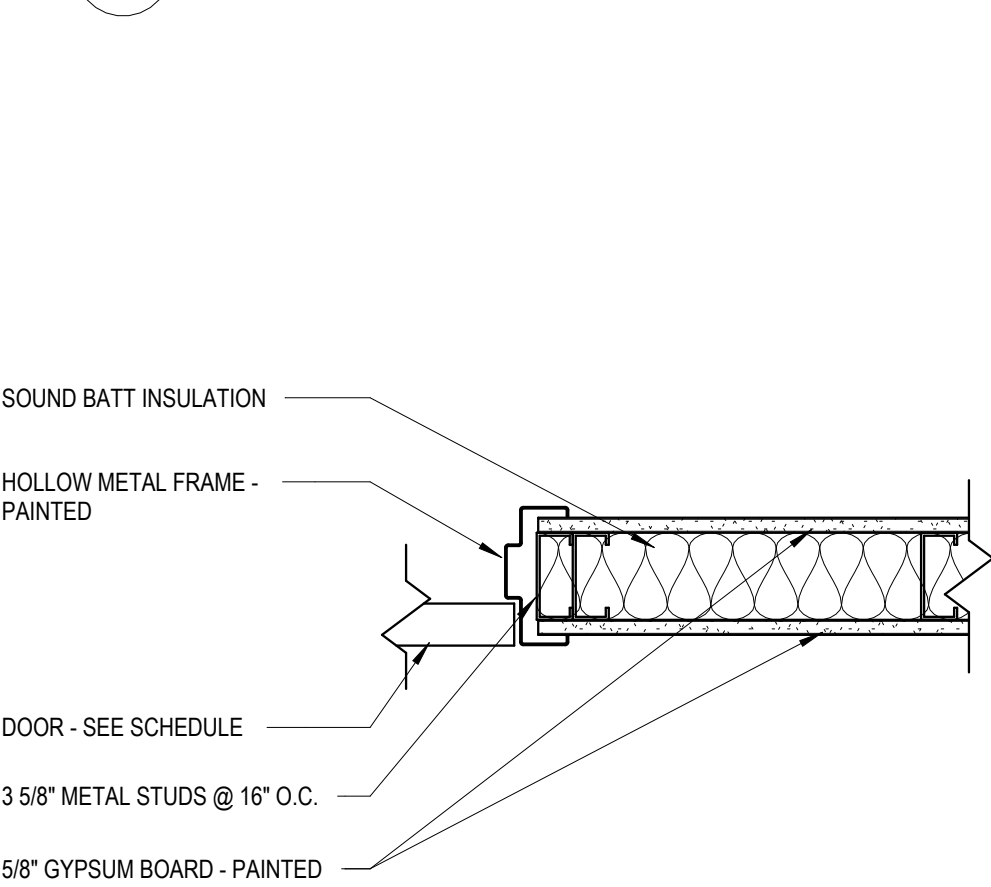


7 JAMB DETAIL @ INTERIOR DOOR
MF-A521 1 1/2" = 1'-0"

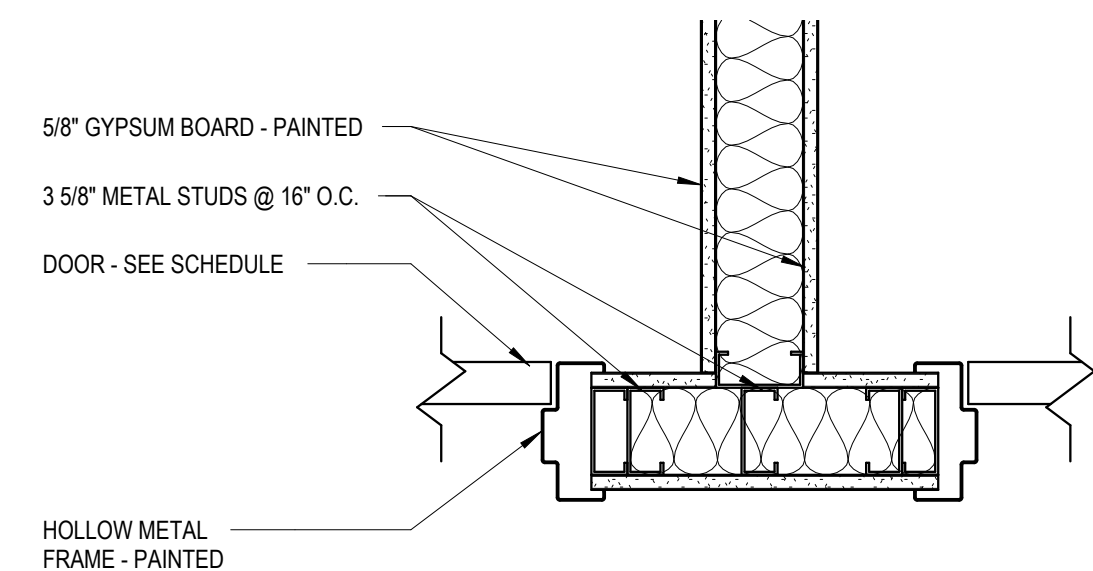


8 JAMB DETAIL @ CLOSE PROXIMITY DOORS
MF-A521 1 1/2" = 1'-0"


2 JAMB DETAIL @ DOORS 105 & 106
MF-A521 1 1/2" = 1'-0"

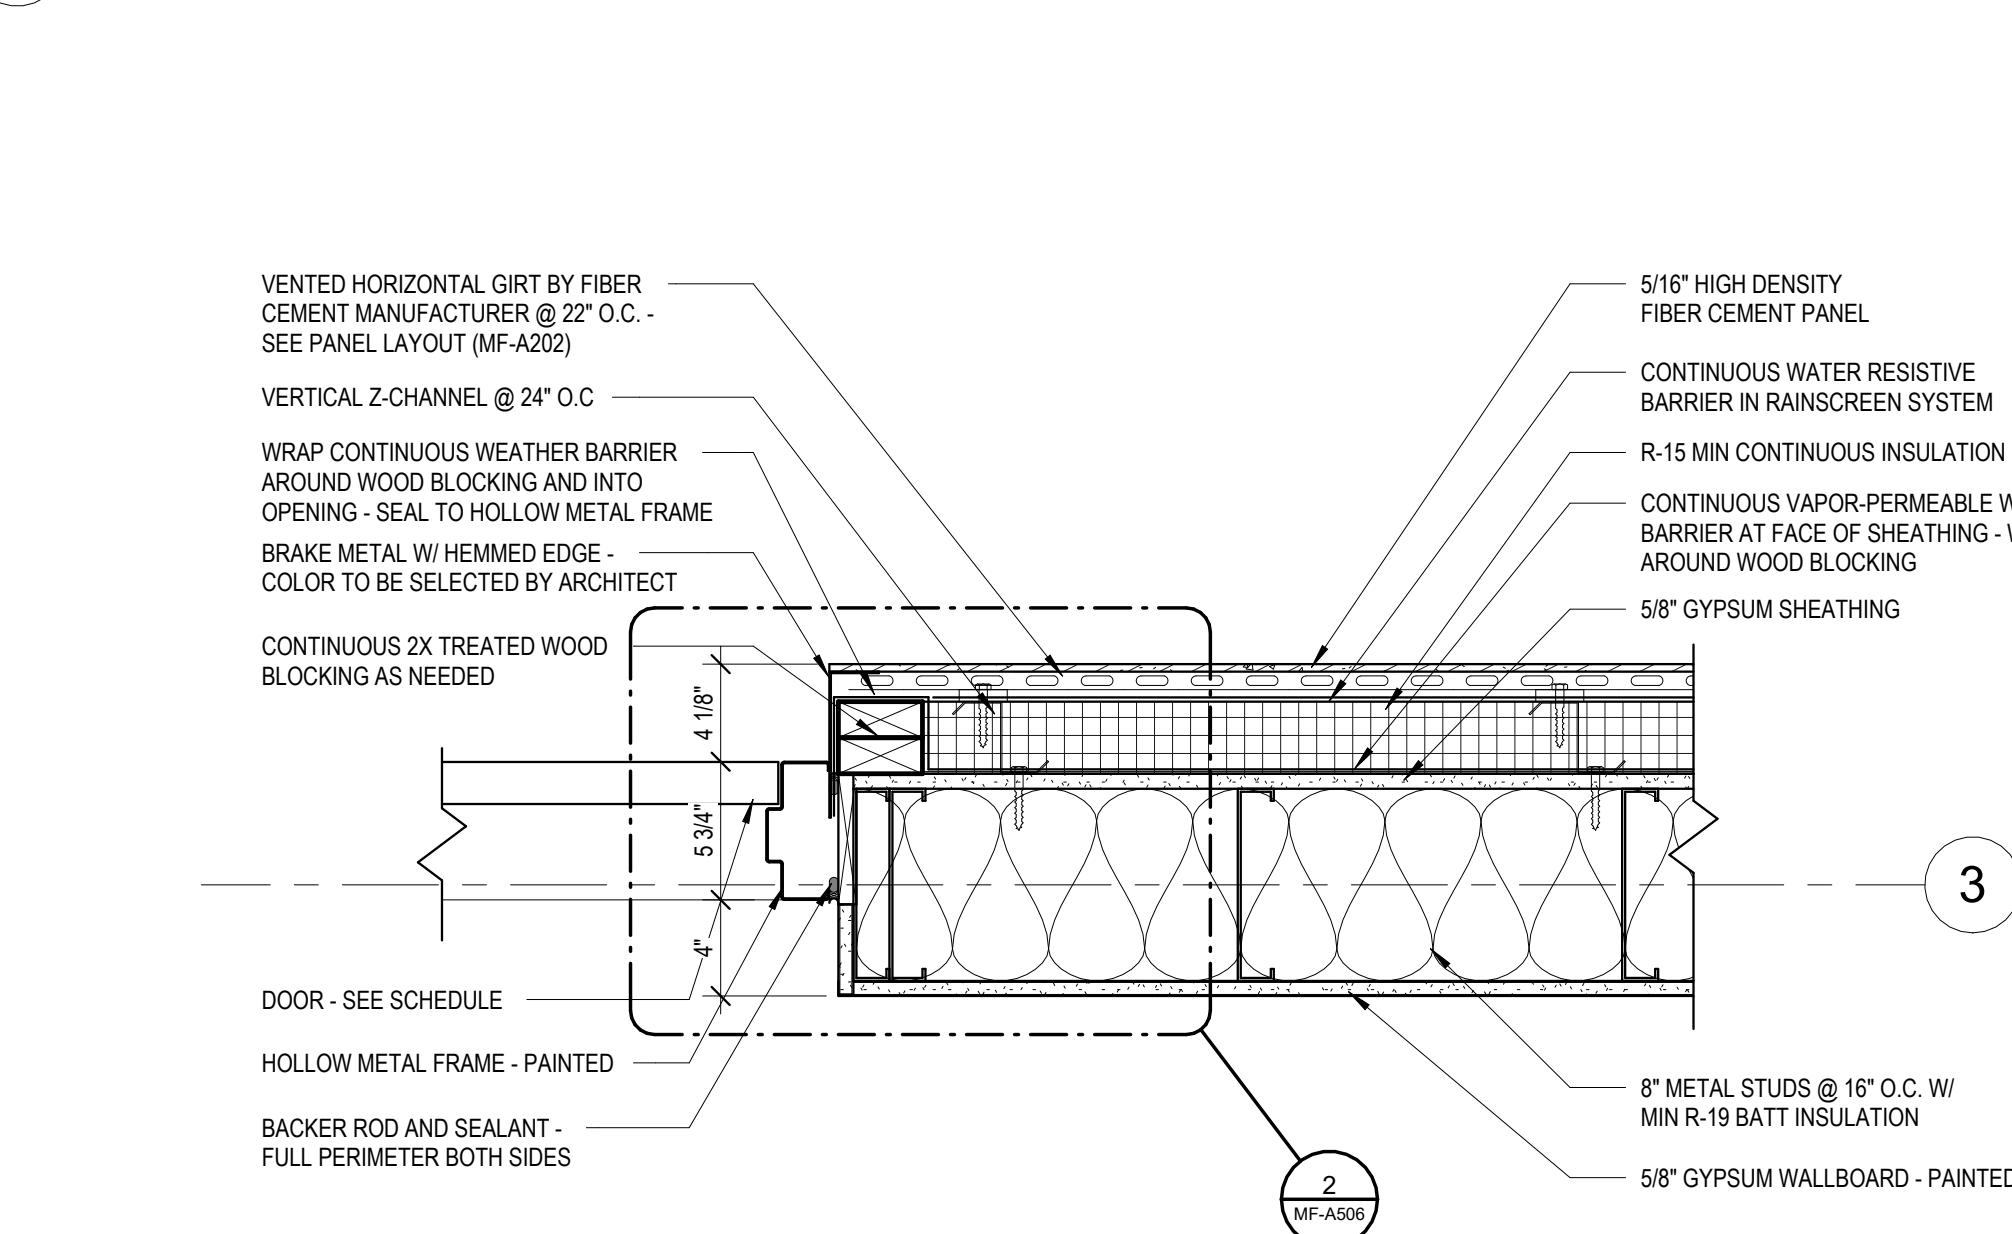


5 JAMB DETAIL @ HM EXTERIOR DOOR
MF-A521 1 1/2" = 1'-0"

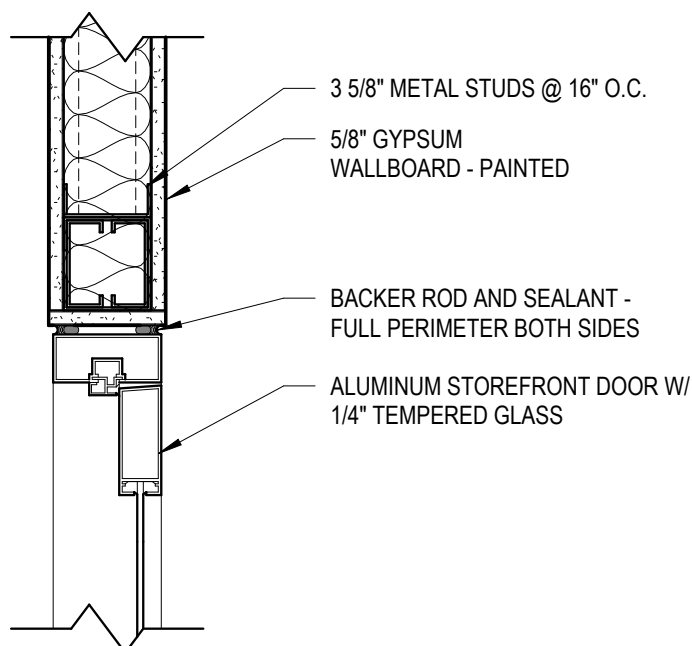


9 HEAD DETAIL @ OFFICE DOOR
MF-A521 1 1/2" = 1'-0"

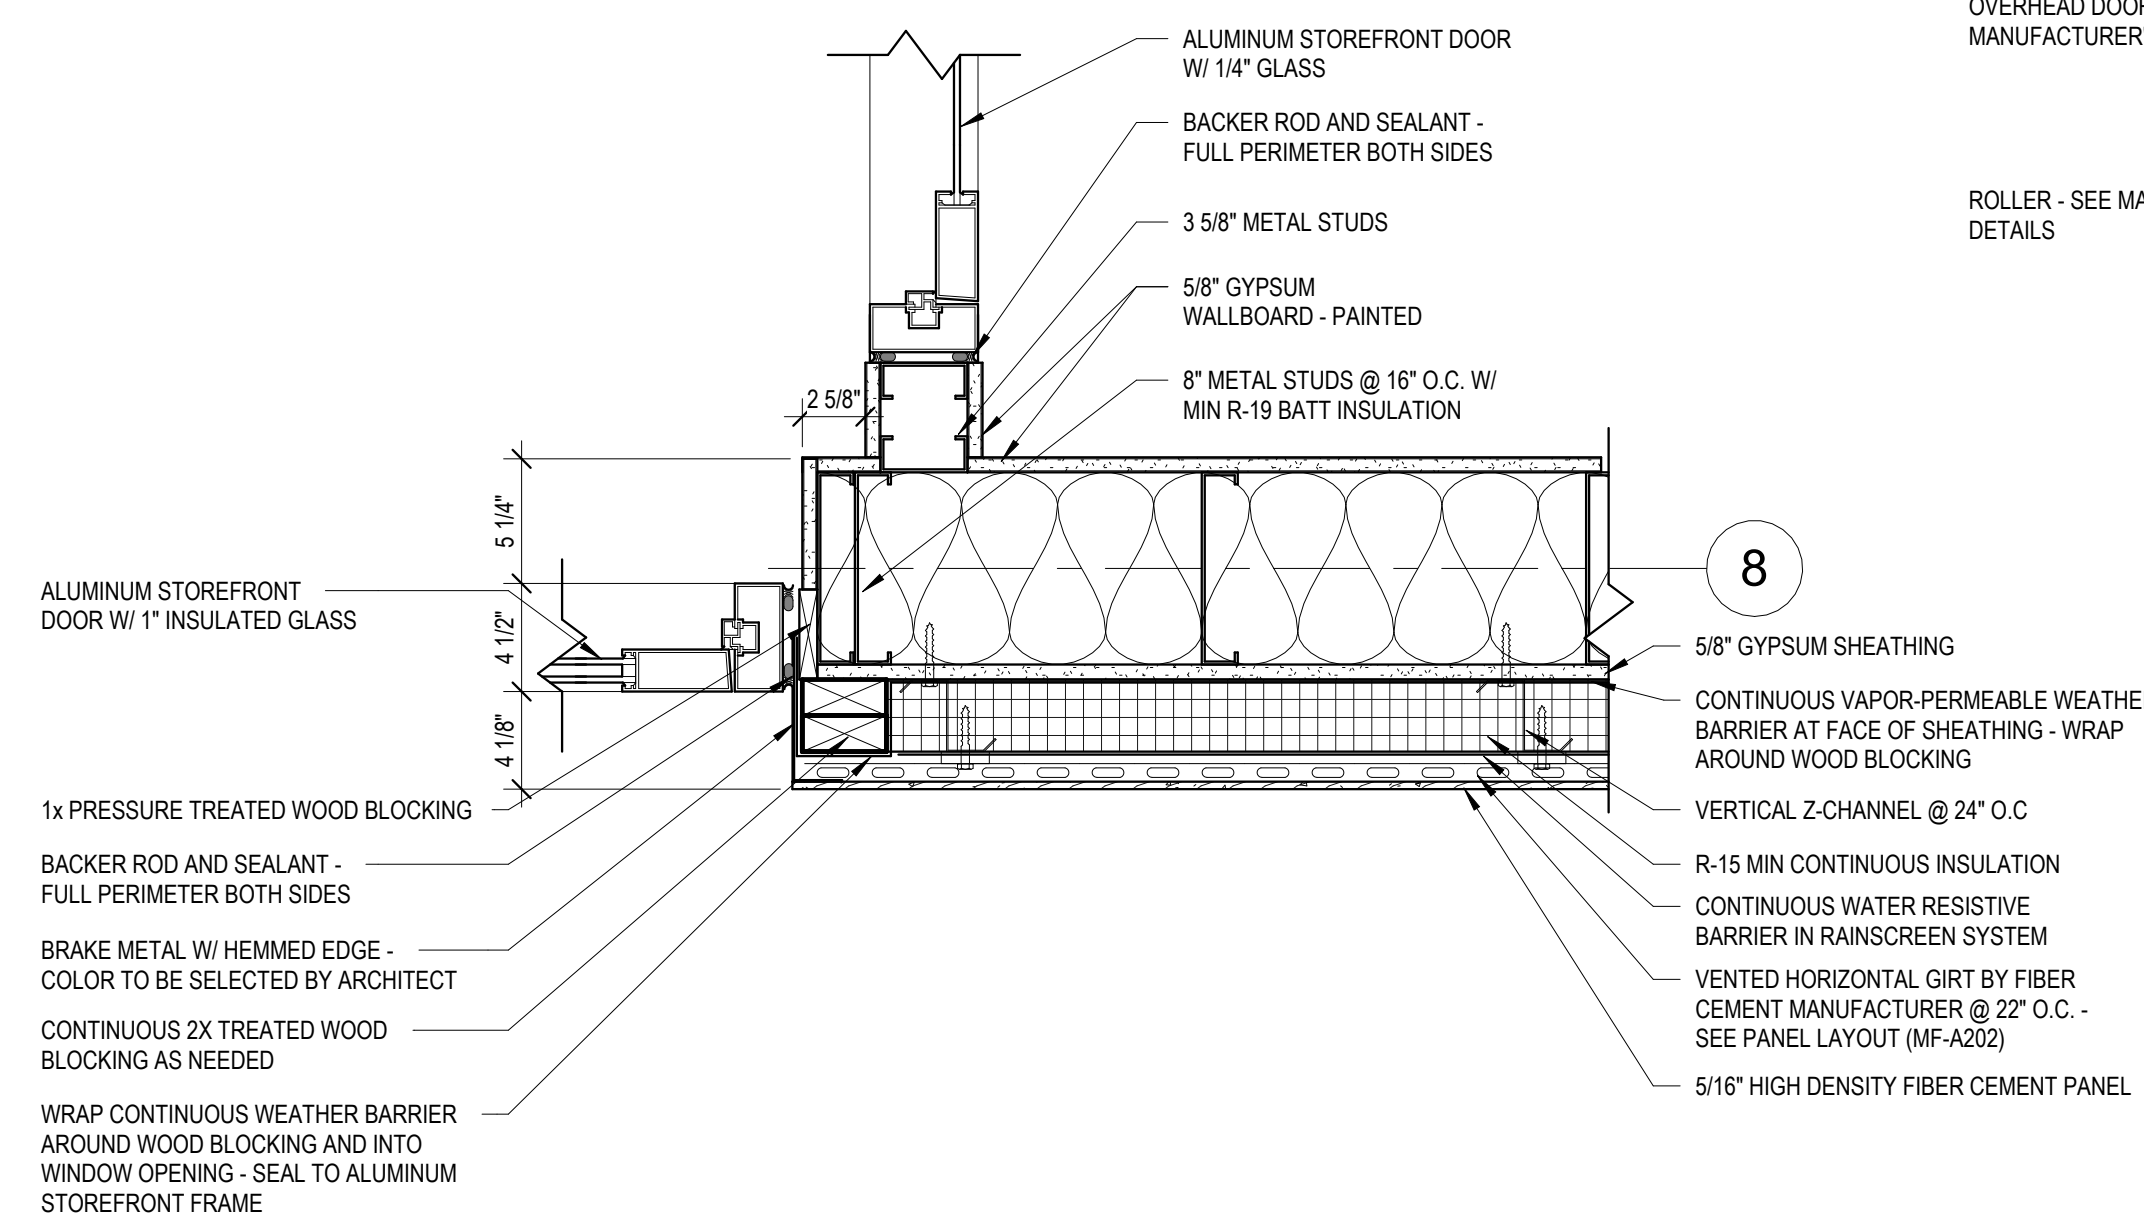


3 HEAD DETAIL @ OVERHEAD DOOR
MF-A521 1 1/2" = 1'-0"

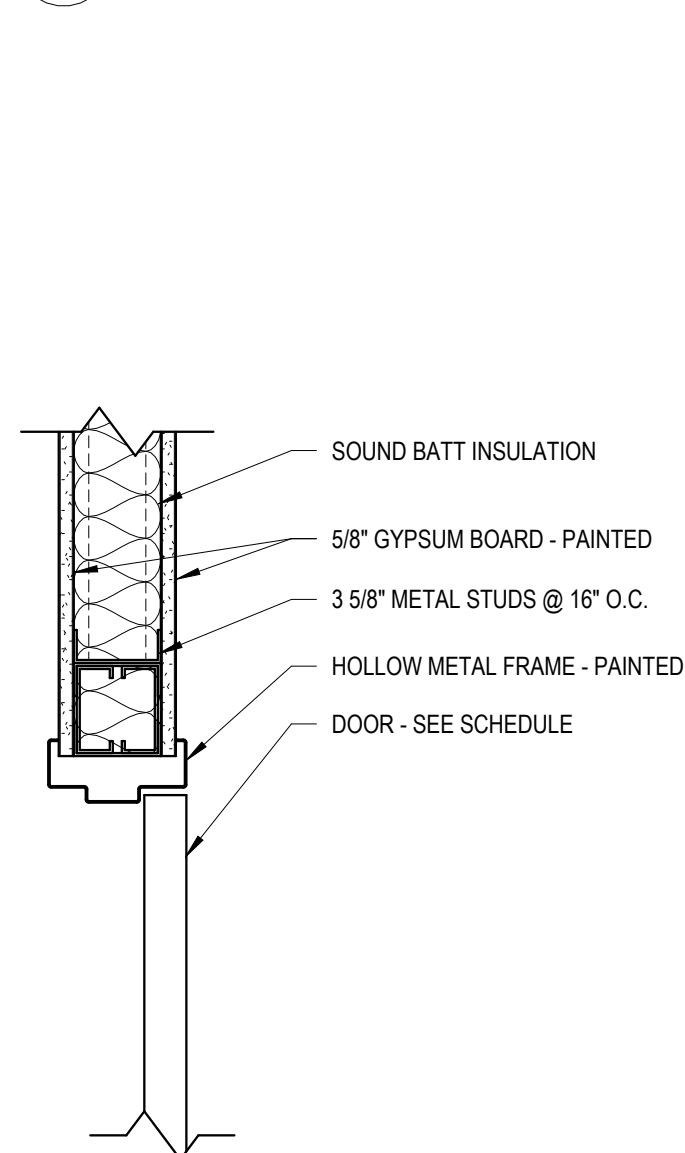

6 HEAD DETAIL @ INTERIOR DOOR
MF-A521 1 1/2" = 1'-0"

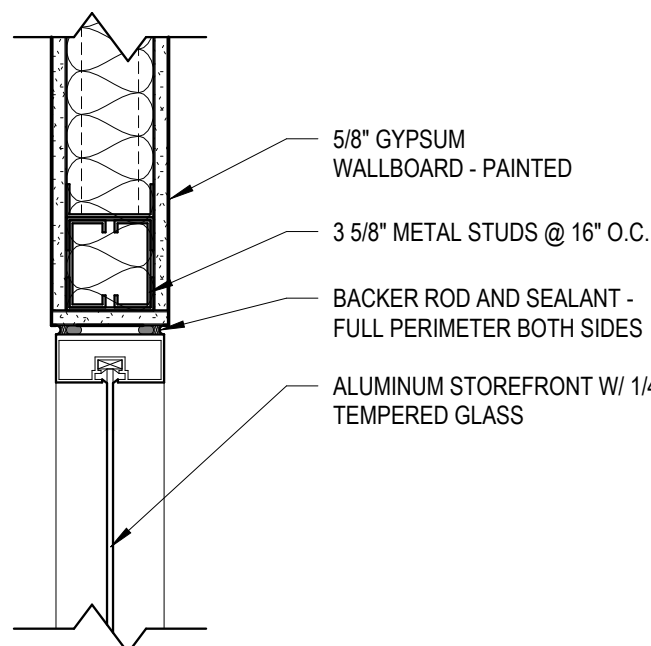

10 HEAD DETAIL @ OFFICE SIDELIGHT
MF-A521 1 1/2" = 1'-0"

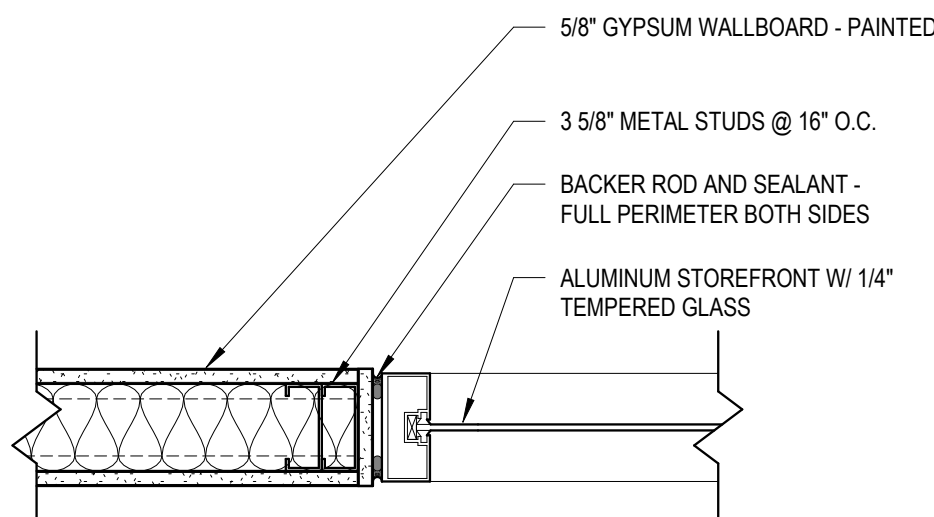

11 JAMB DETAIL @ OFFICE SIDELIGHT
MF-A521 1 1/2" = 1'-0"

Susan Hatchell
Landscape Architecture, PLLC
711 W. North Street, Raleigh, NC 27603
p: 919-838-9600 f: 919-838-9700




HEAD, JAMB AND
SILL DETAILS

LAKE MYRA COUNTY PARK
Wake County, NC


REVISIONS

Date: 07/27/26


MF-A521

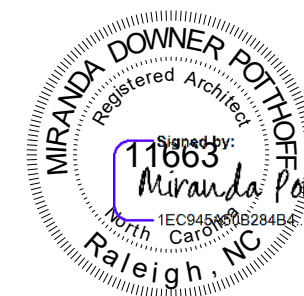


7/27/2026

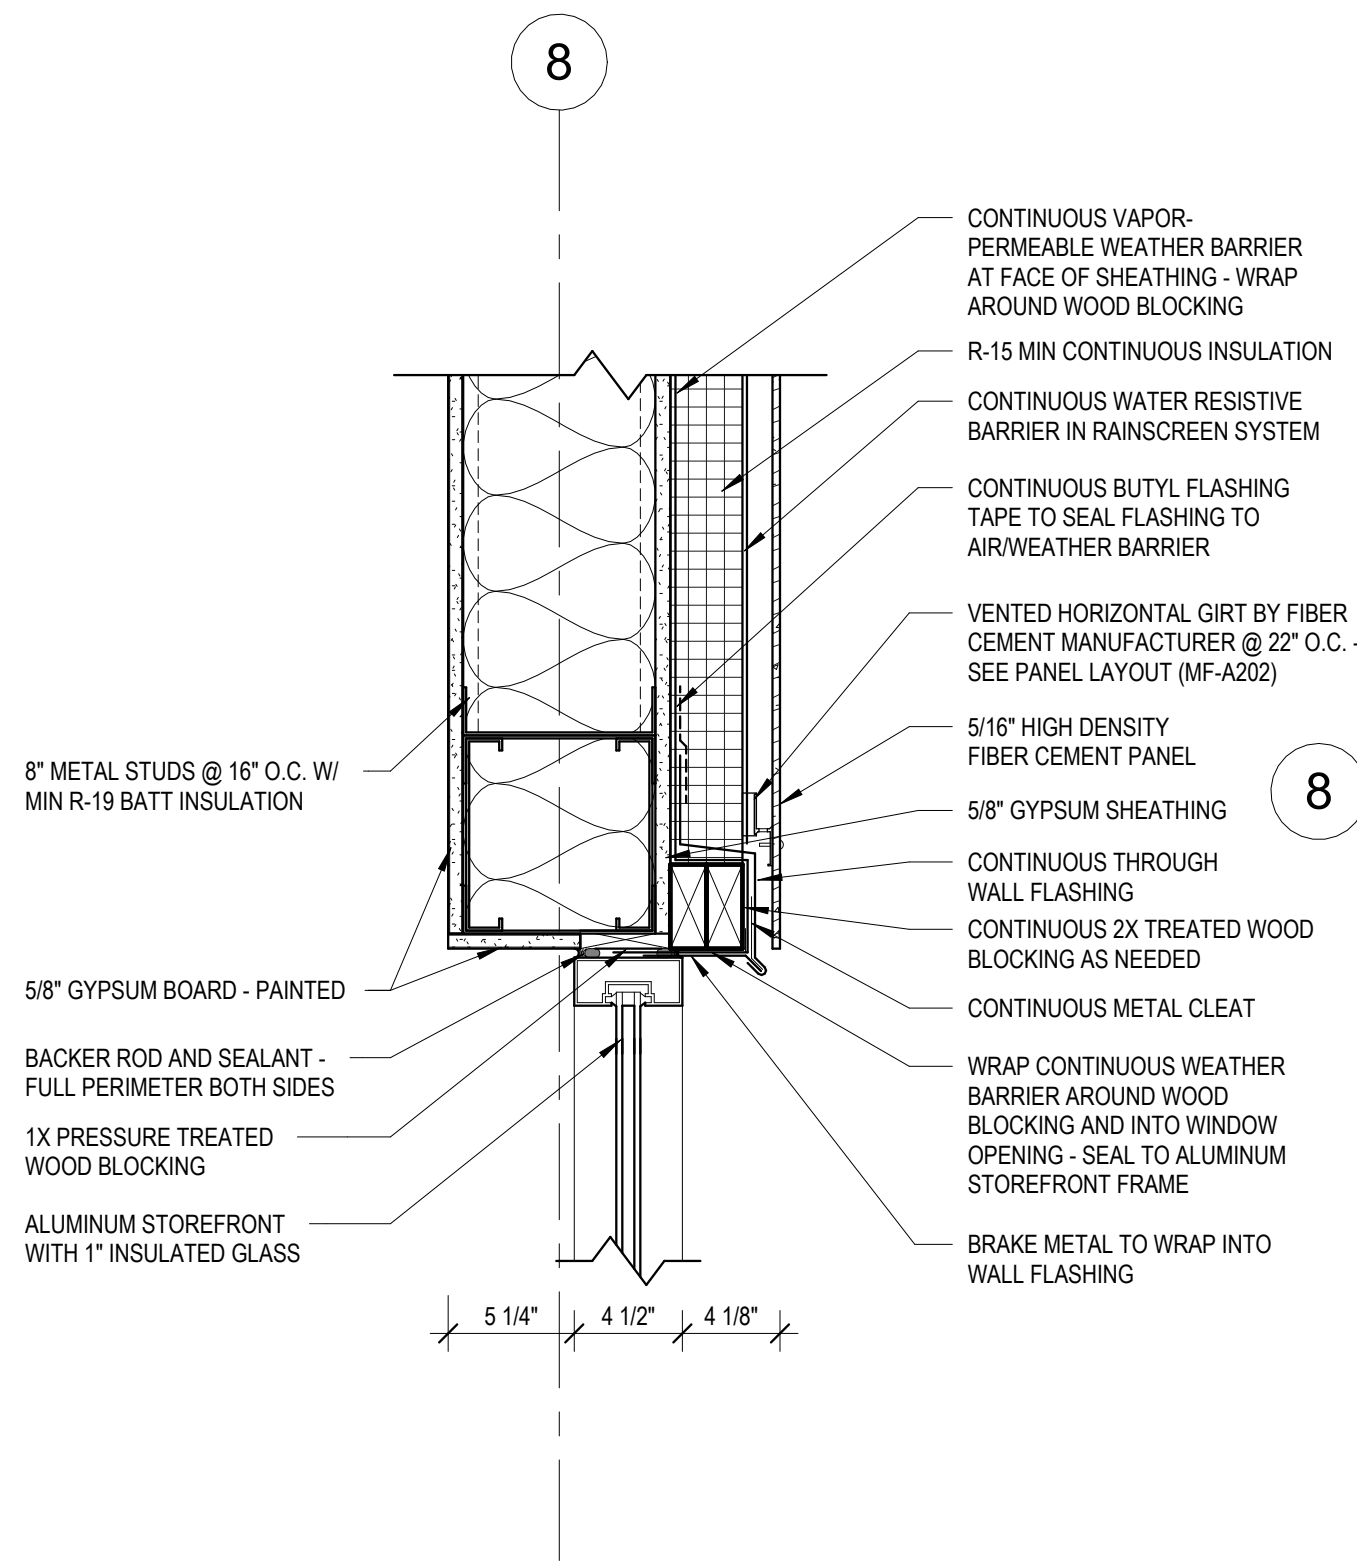


1 HEAD DETAIL @ TYP. WINDOW
MF-A522 1 1/2" = 1'-0"

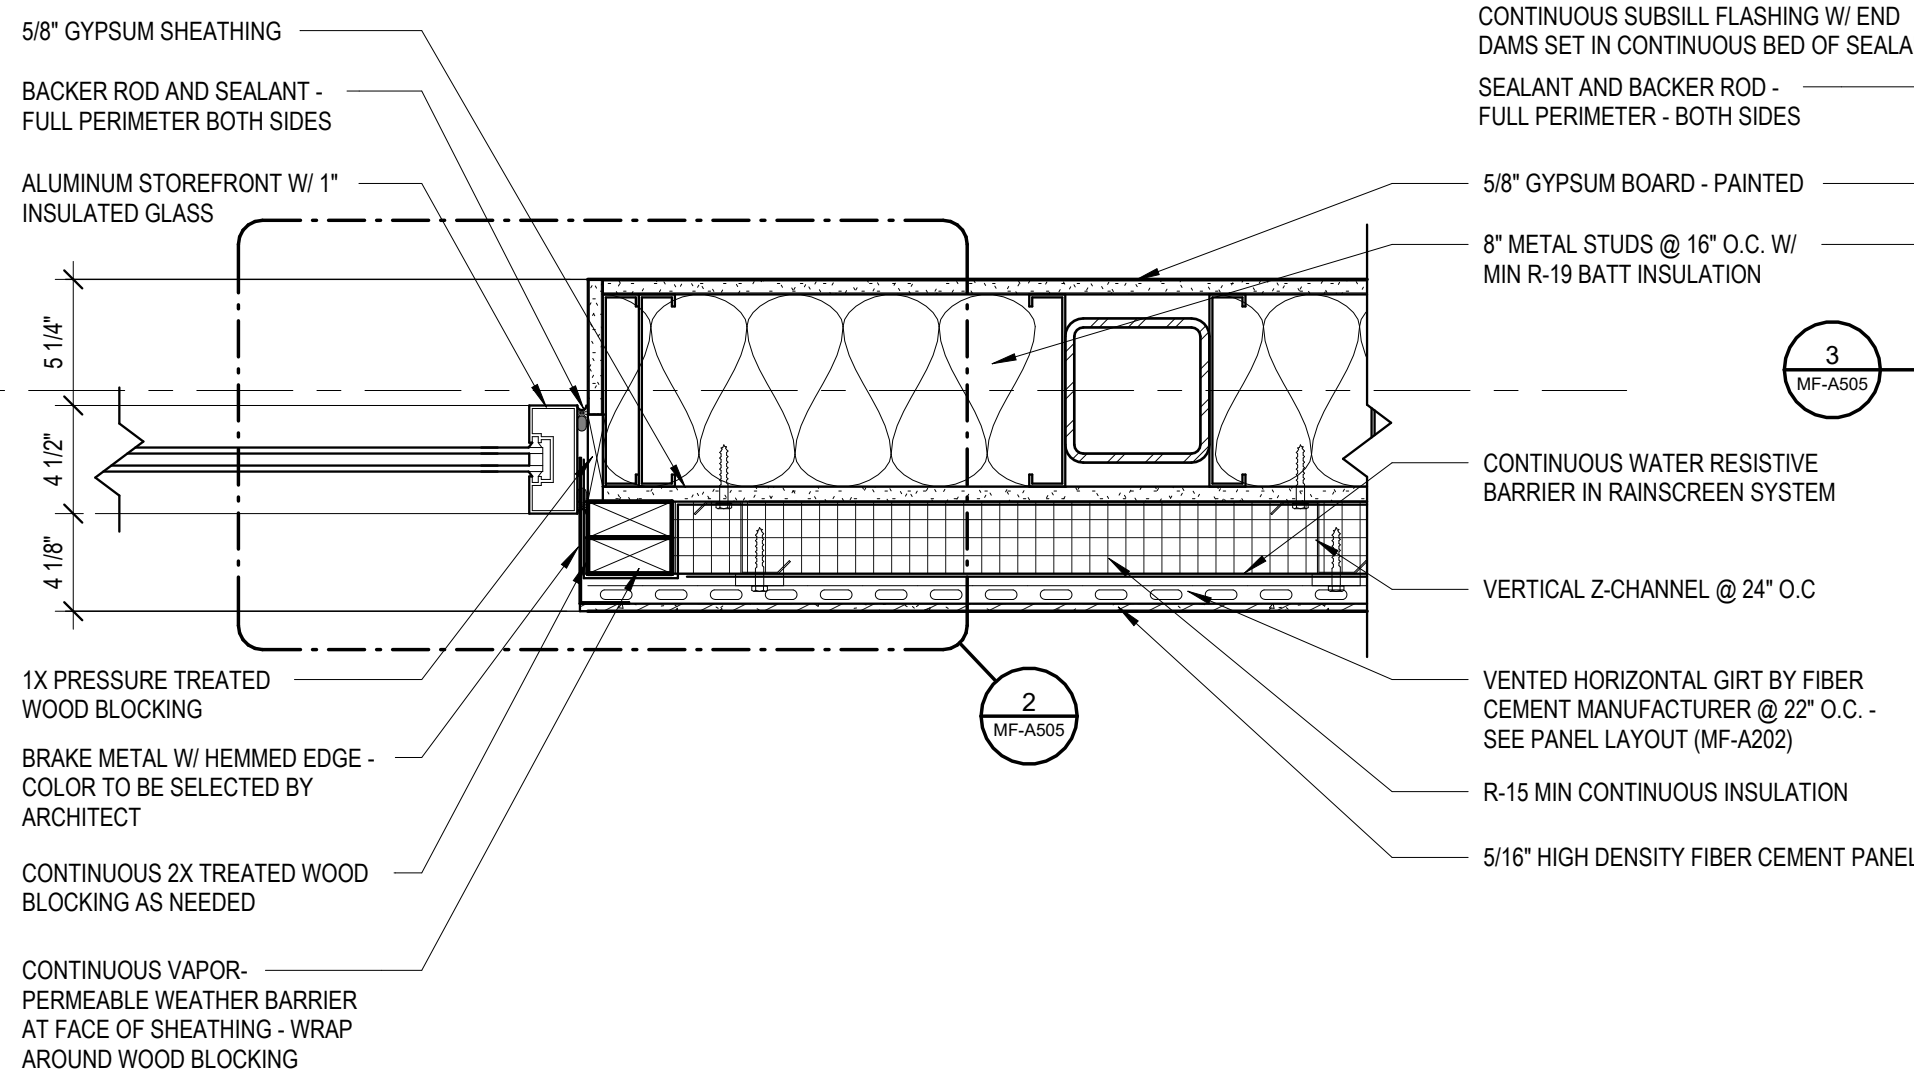


2 JAMB DETAIL @ TYP. WINDOW
MF-A522 1 1/2" = 1'-0"

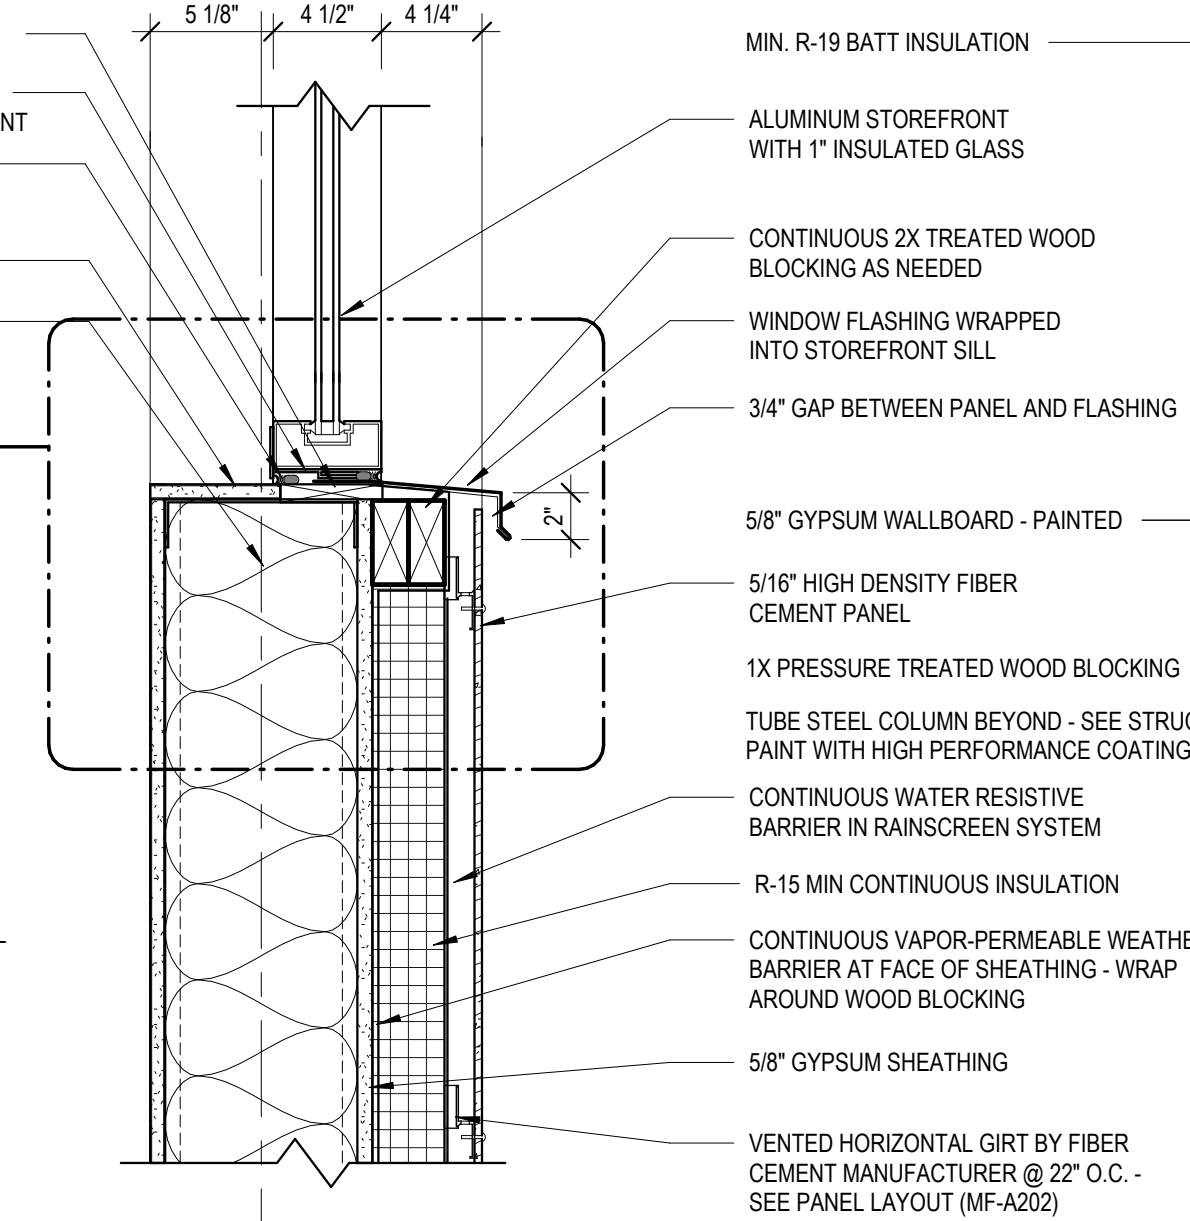


3 SILL DETAIL @ HALF HEIGHT WINDOW
MF-A522 1 1/2" = 1'-0"

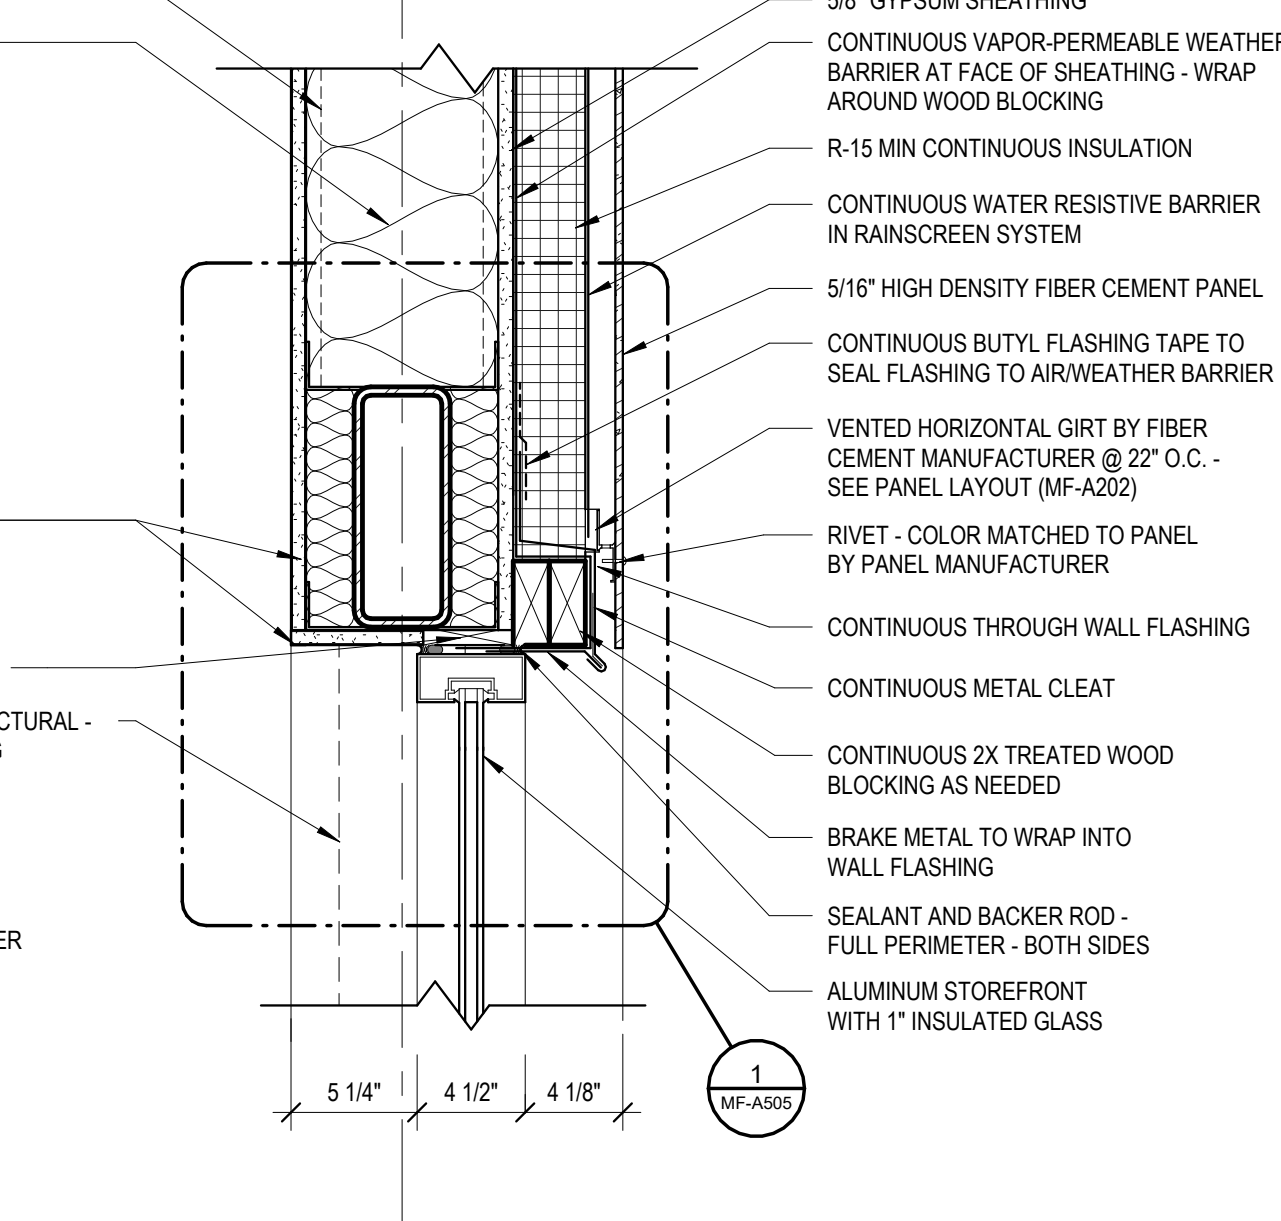


4 HEAD DETAIL @ 90 DEGREE WINDOW
MF-A522 1 1/2" = 1'-0"

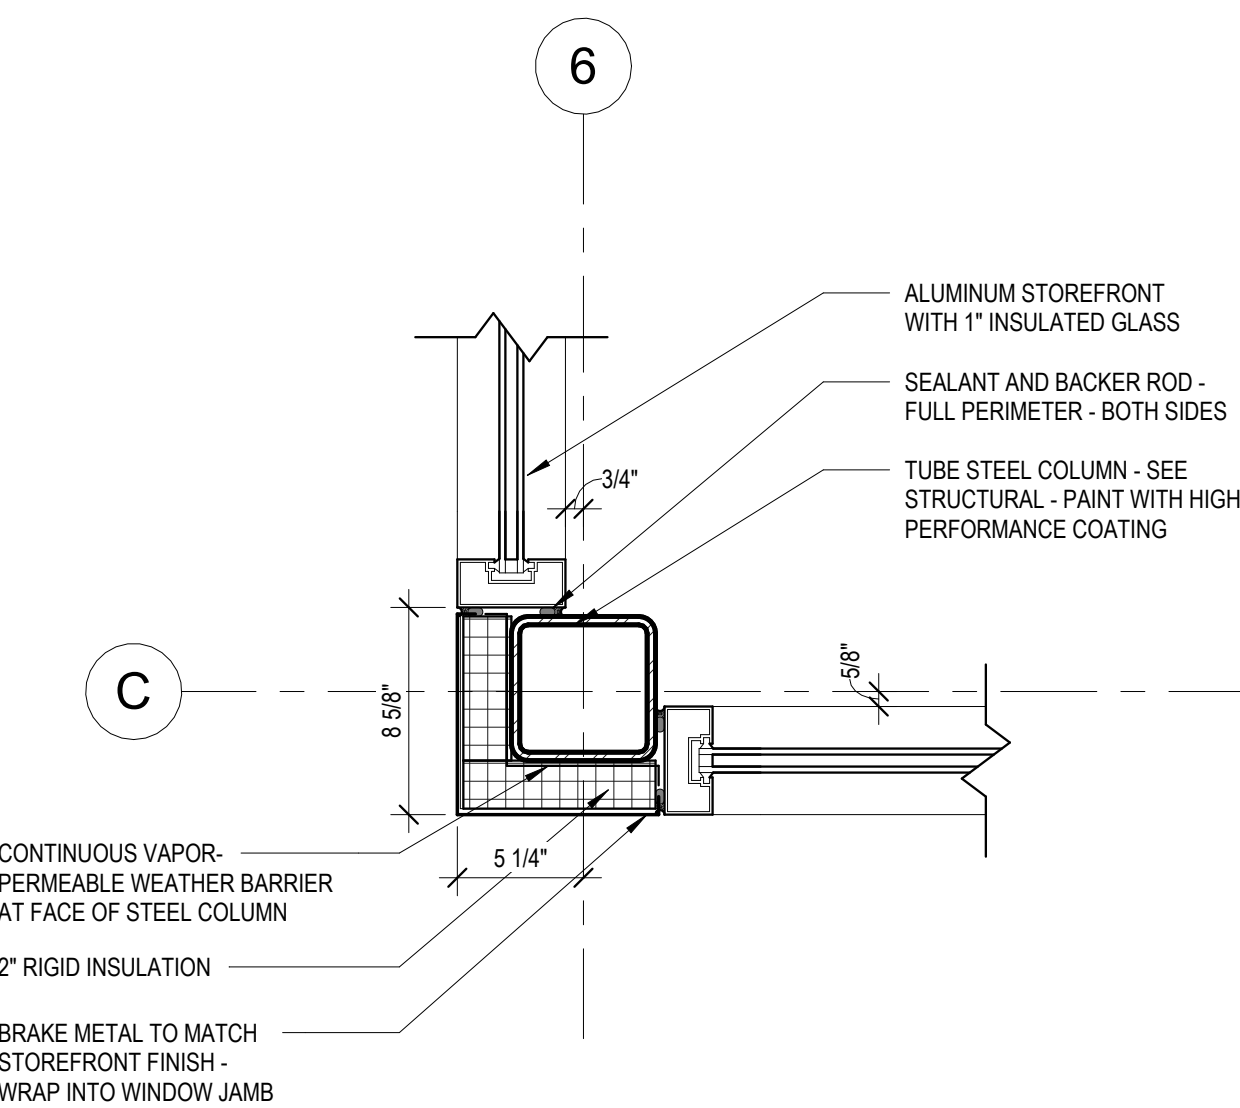

5 JAMB DETAIL @ 90 DEGREE WINDOW
MF-A522 1 1/2" = 1'-0"

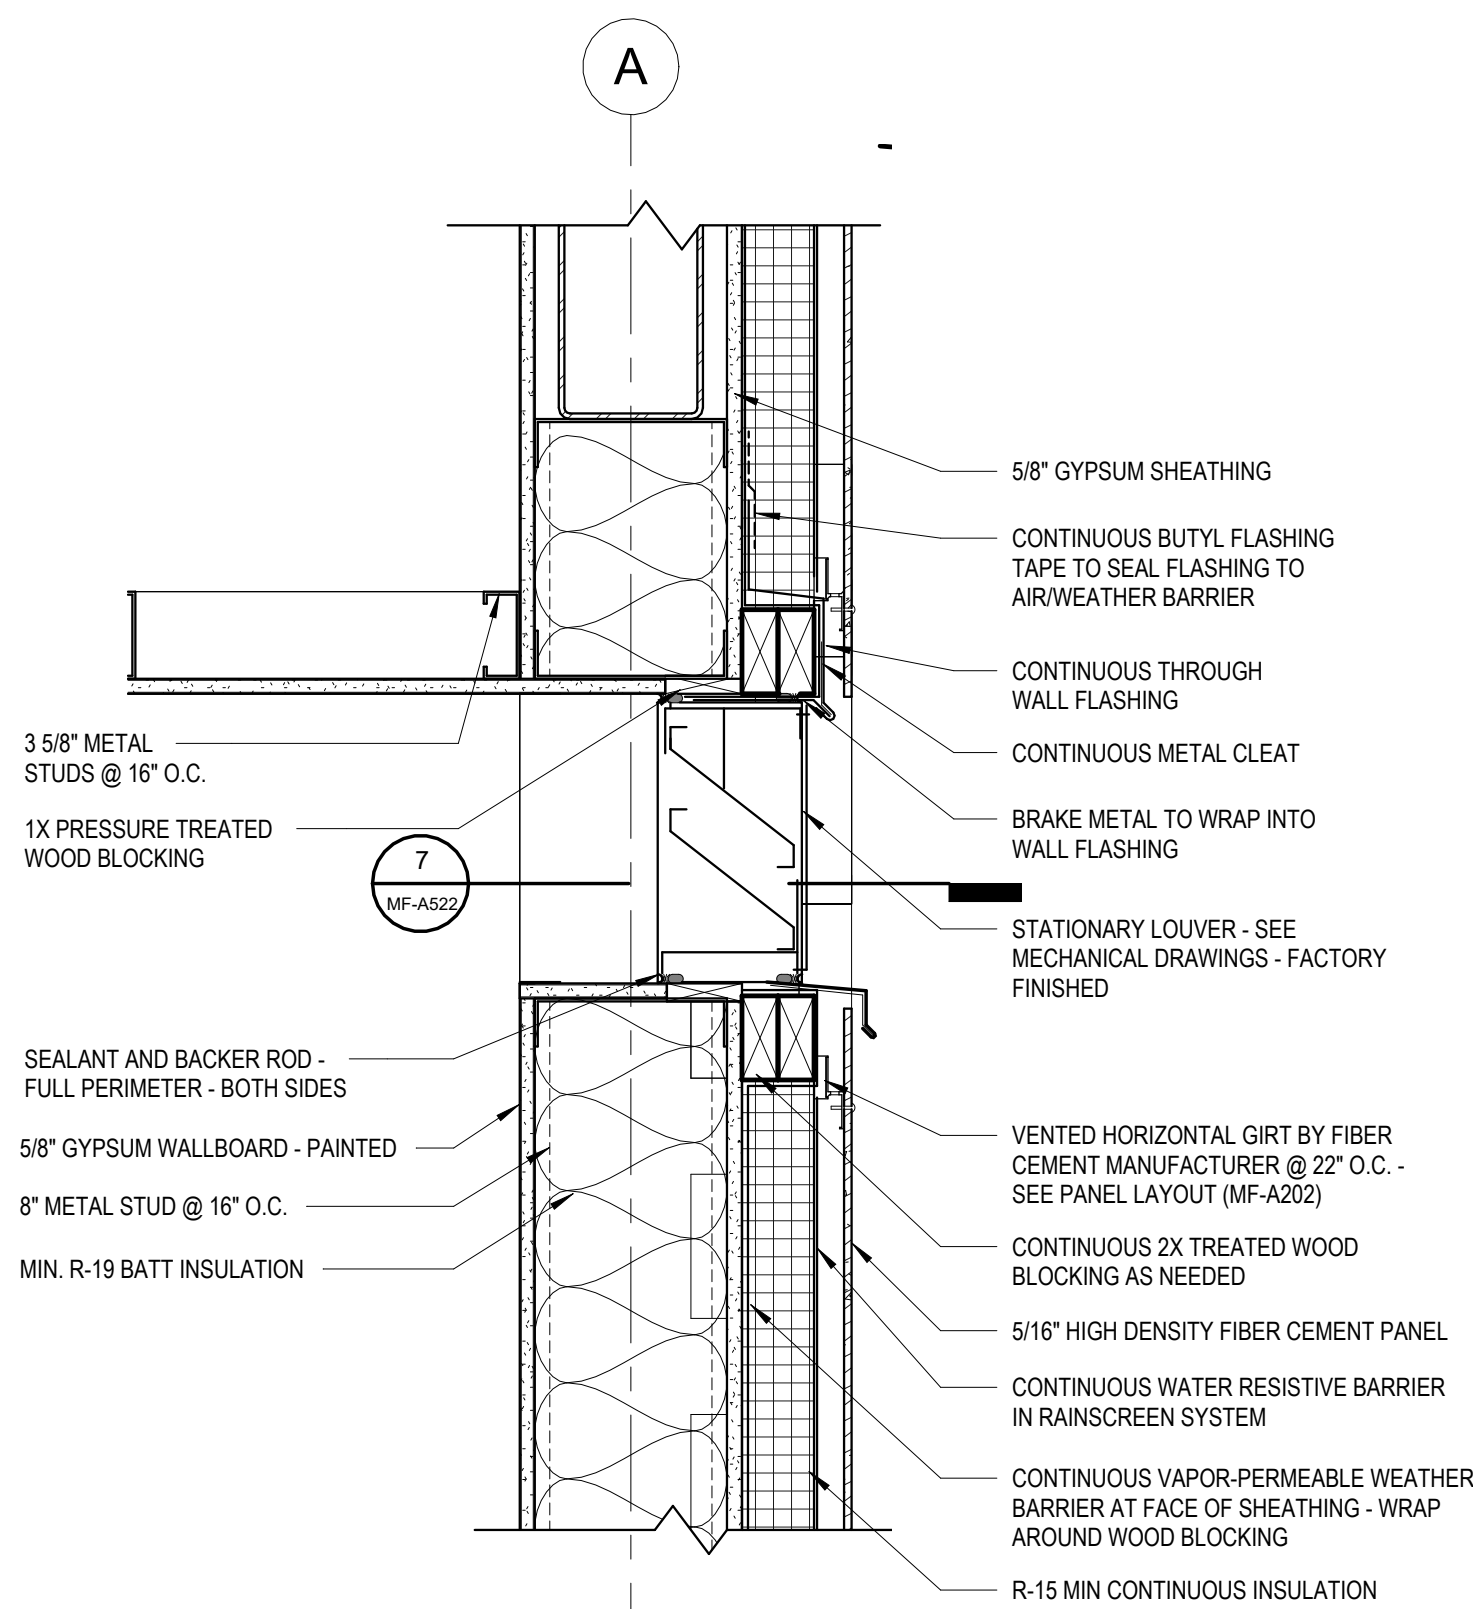

6 DETAIL @ WALL LOUVER
MF-A522 1 1/2" = 1'-0"

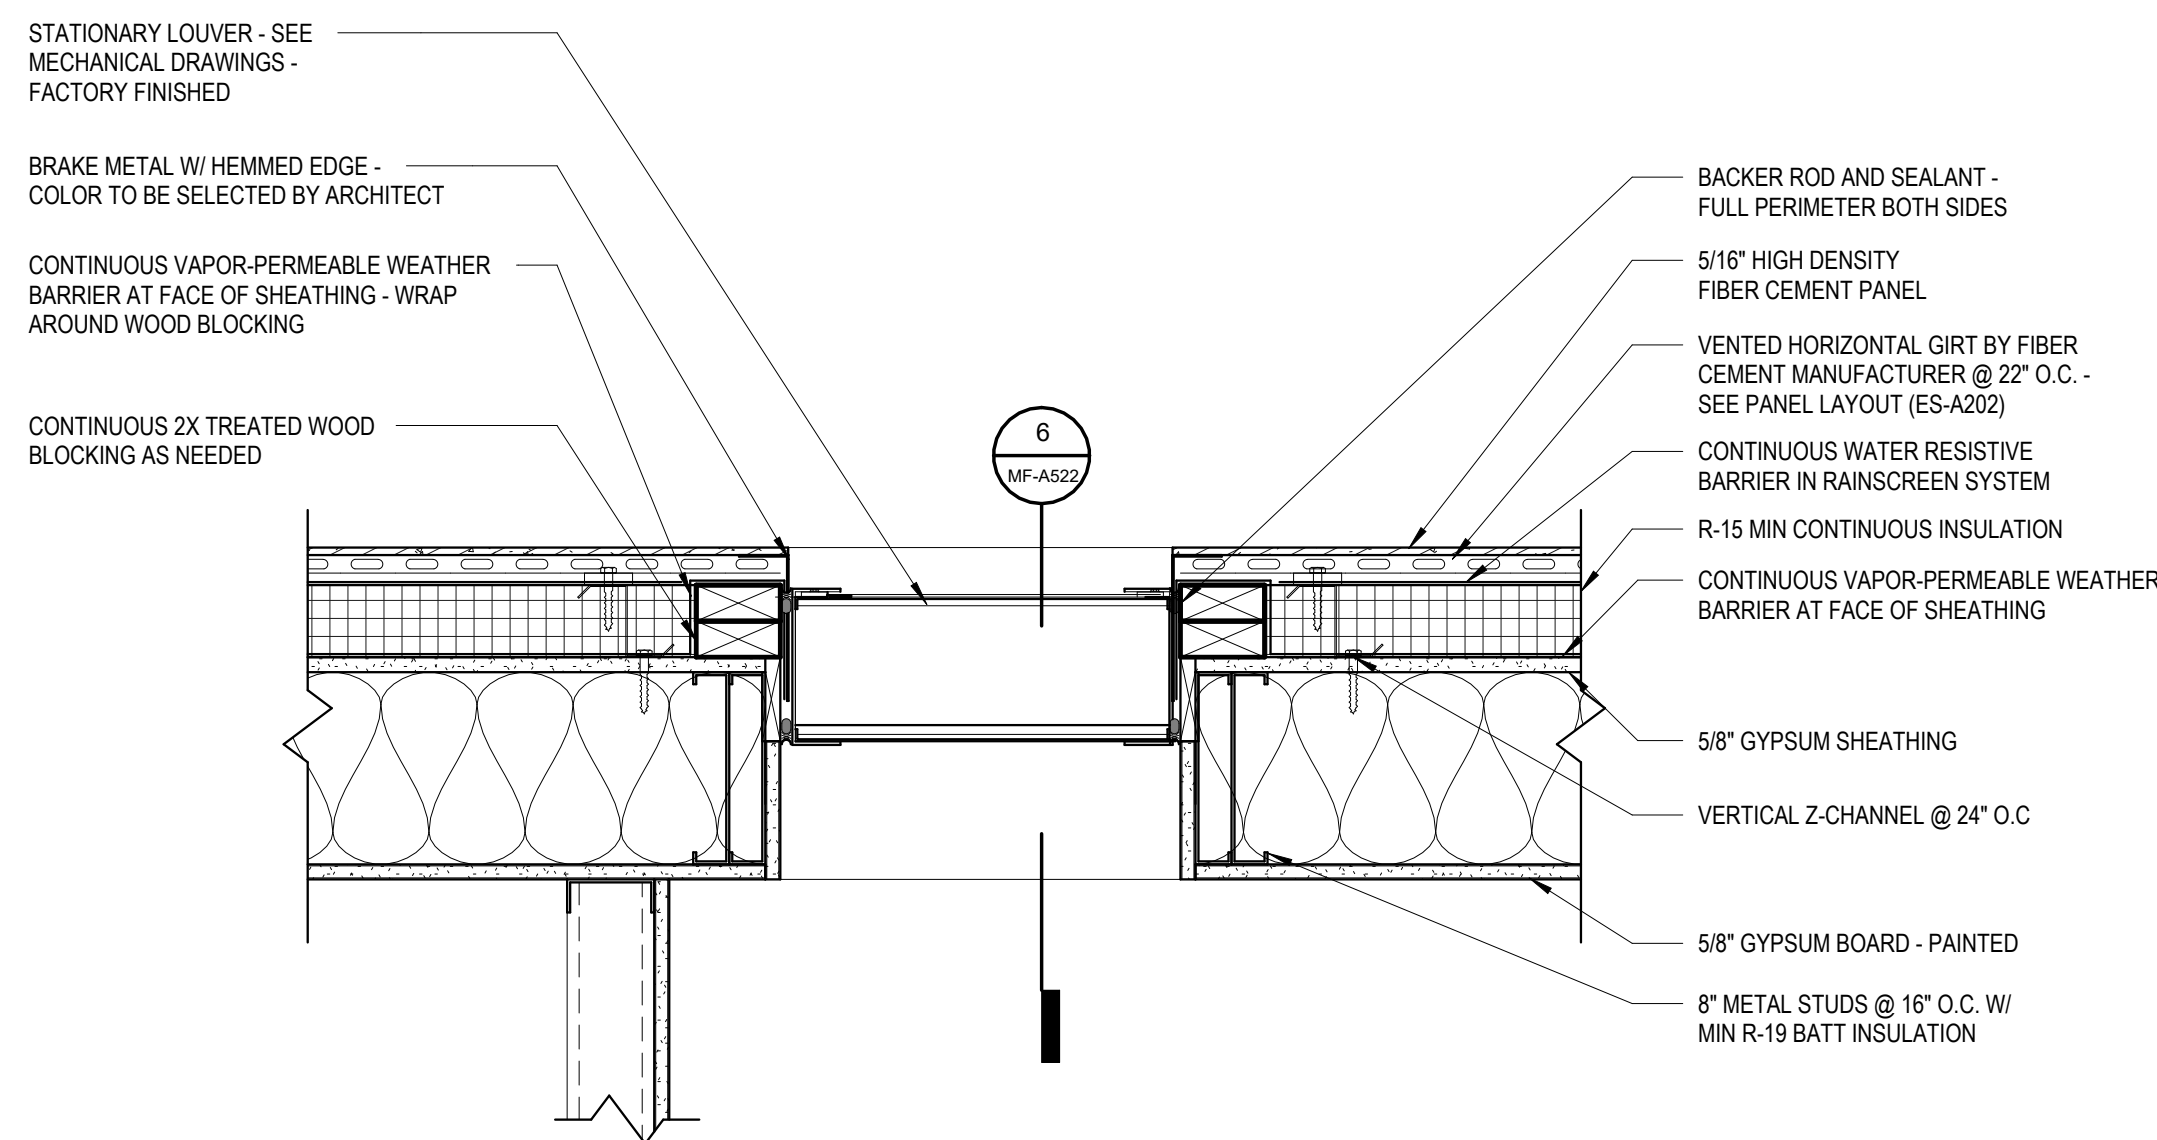

7 LOUVER PLAN DETAIL
MF-A522 1 1/2" = 1'-0"

Susan Hatchell
Landscape Architecture, PLLC
711 W. North Street, Raleigh, NC 27603
p: 919-838-9600 f: 919-838-9700

Esse Architects
832 PERSHING ROAD | RALEIGH, NORTH CAROLINA 27608


HEAD, JAMB AND
SILL DETAILS


LAKE MYRA COUNTY PARK
Wake County, NC

REVISIONS


Date: 07/27/26

MF-A522

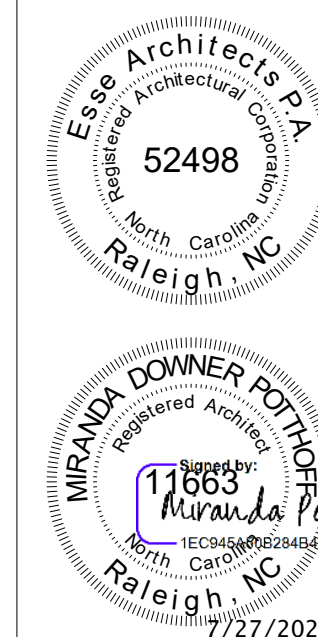

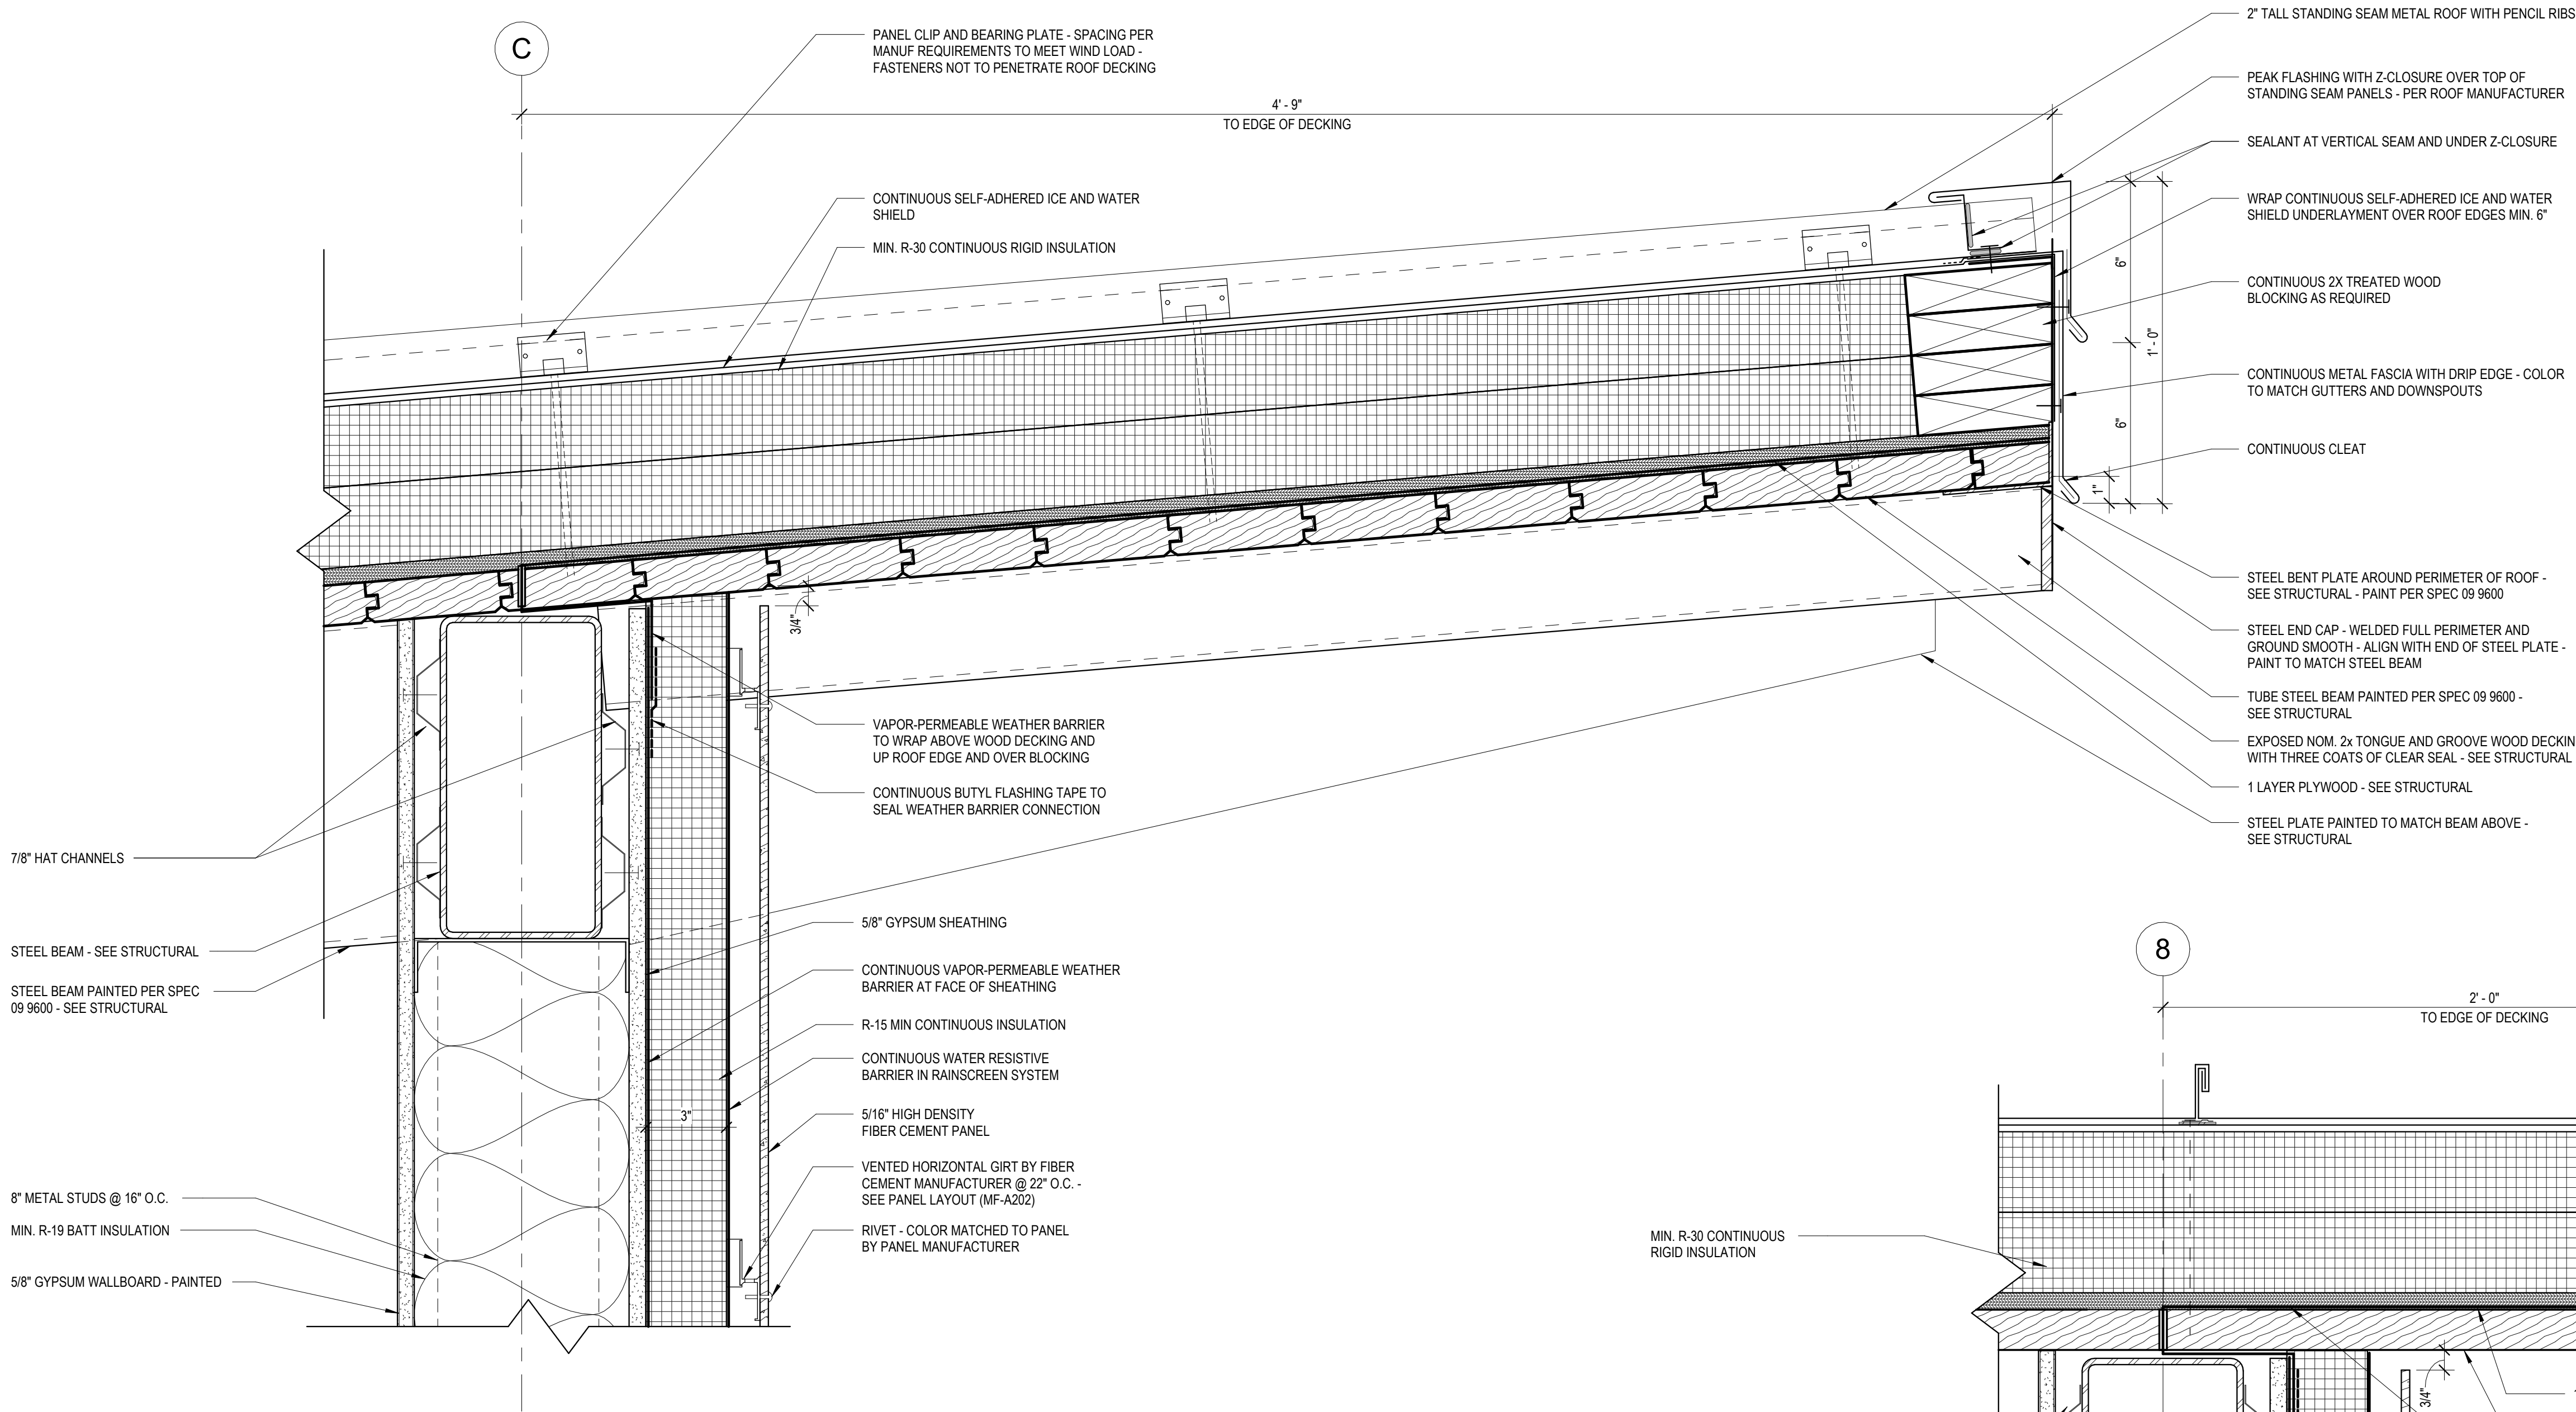


- ROOF DECKING NOTES**
1. STRUCTURAL WOOD ROOF DECK IS ALSO FINISHED CEILING - **NO FASTENERS SHALL PENETRATE DECKING**
 2. NO EXPOSED CONDUIT SHALL BE RUN ACROSS UNDERSIDE OF WOOD DECKING WITHOUT REVIEW AND COORDINATION WITH THE ARCHITECT. COORDINATE FOR LIGHTING, SECURITY, ETC.

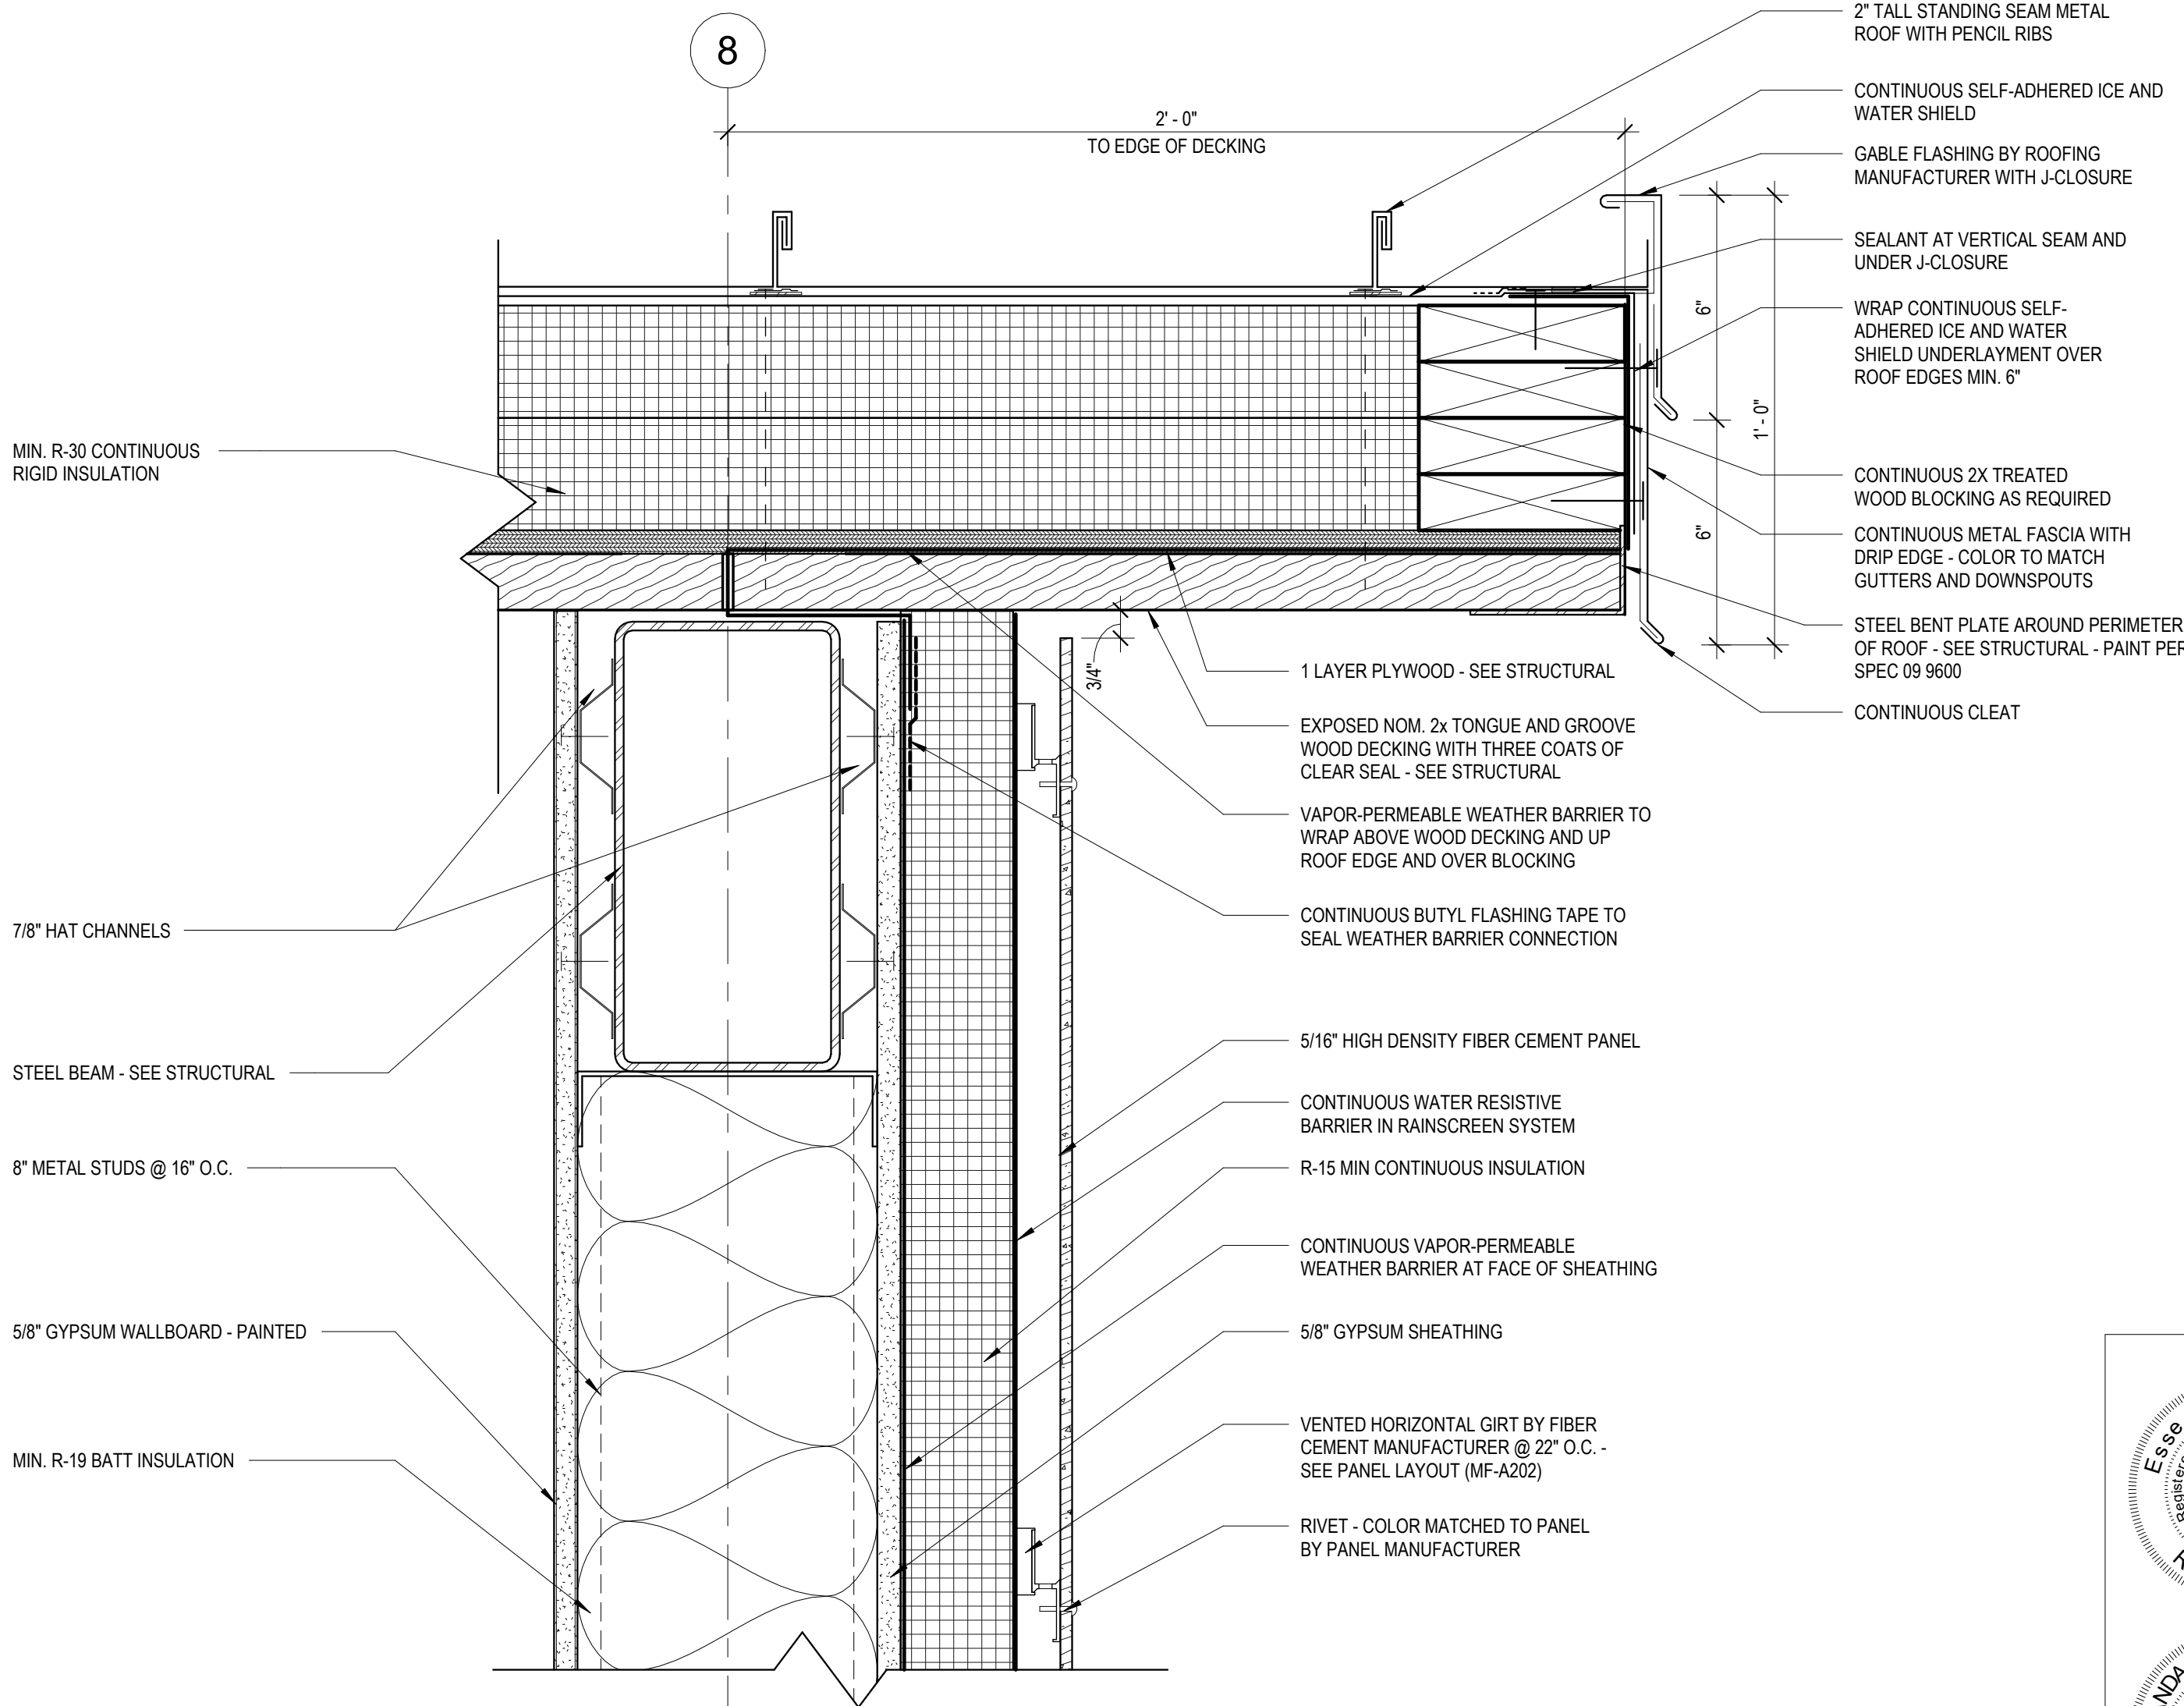

1 ROOF DETAIL @ UPPER SIDE
MF-A525 3" = 1'-0"

2 ROOF DETAIL @ SIDE
MF-A525 3" = 1'-0"

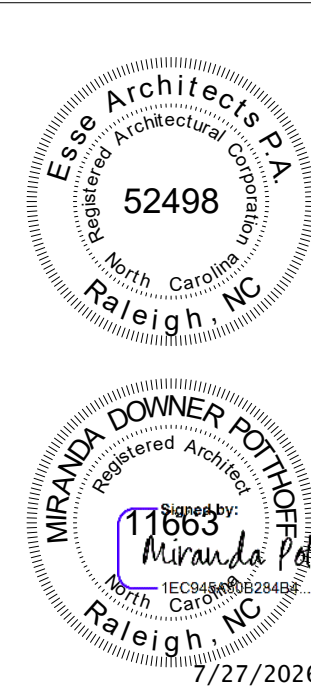

Susan Hatchell
Landscape Architecture, PLLC
711 W. North Street, Raleigh, NC 27603
p: 919-838-9600 f: 919-838-9700




ROOF DETAILS

LAKE MYRA COUNTY PARK
Wake County, NC

REVISIONS

Date: 07/27/26
MF-A525

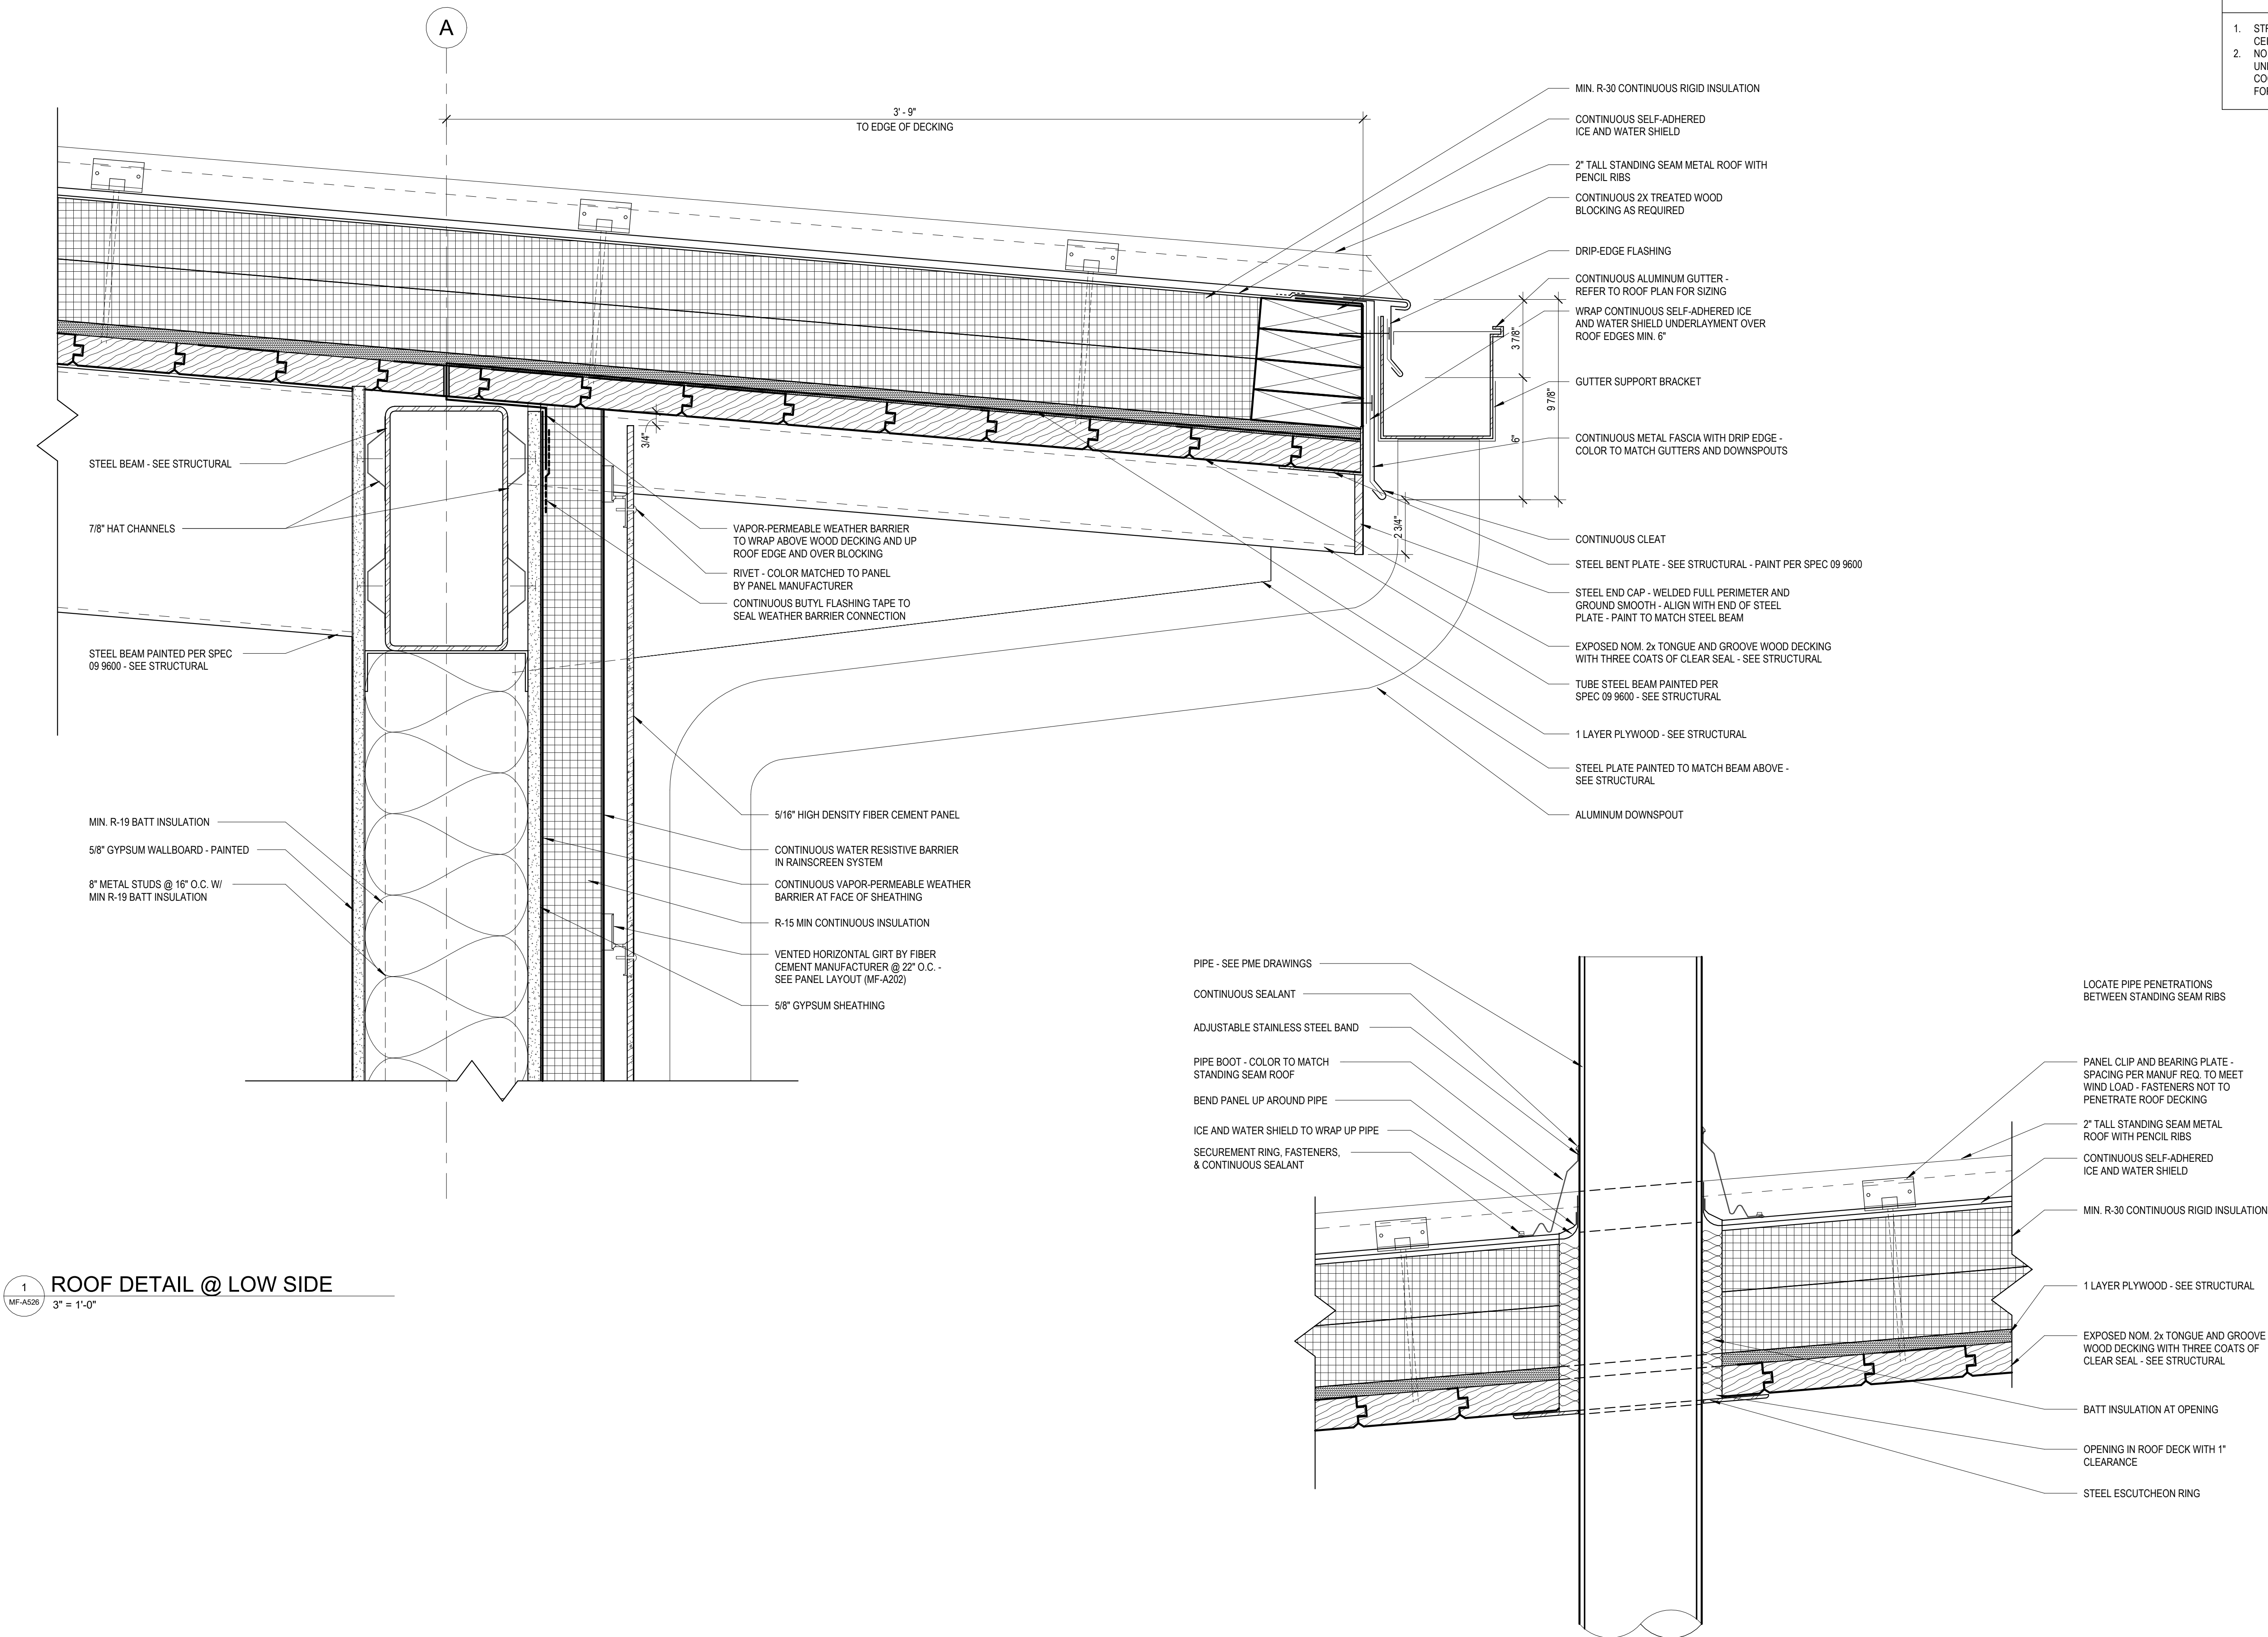

- ROOF DECKING NOTES**
1. STRUCTURAL WOOD ROOF DECK IS ALSO FINISHED. CEILING - **NO FASTENERS SHALL PENETRATE DECKING**
 2. NO EXPOSED CONDUIT SHALL BE RUN ACROSS UNDERSIDE OF WOOD DECKING WITHOUT REVIEW AND COORDINATION WITH THE ARCHITECT. COORDINATE FOR LIGHTING, SECURITY, ETC.

1
MF-A526
3" = 1'-0"

ROOF DETAIL @ LOW SIDE

2
MF-A526
3" = 1'-0"

ROOF DETAIL @ PENETRATION

Susan Hatchell
Landscape Architecture, PLLC
711 W. North Street, Raleigh, NC 27603
p: 919-838-9600 f: 919-838-9700



ROOF DETAILS

LAKE MYRA COUNTY PARK
Wake County, NC

REVISIONS

Date: 07/27/26

MF-A526




ROOF DETAILS

LAKE MYRA COUNTY PARK
Wake County, NC

REVISIONS

Date: 07/27/26

MF-A527

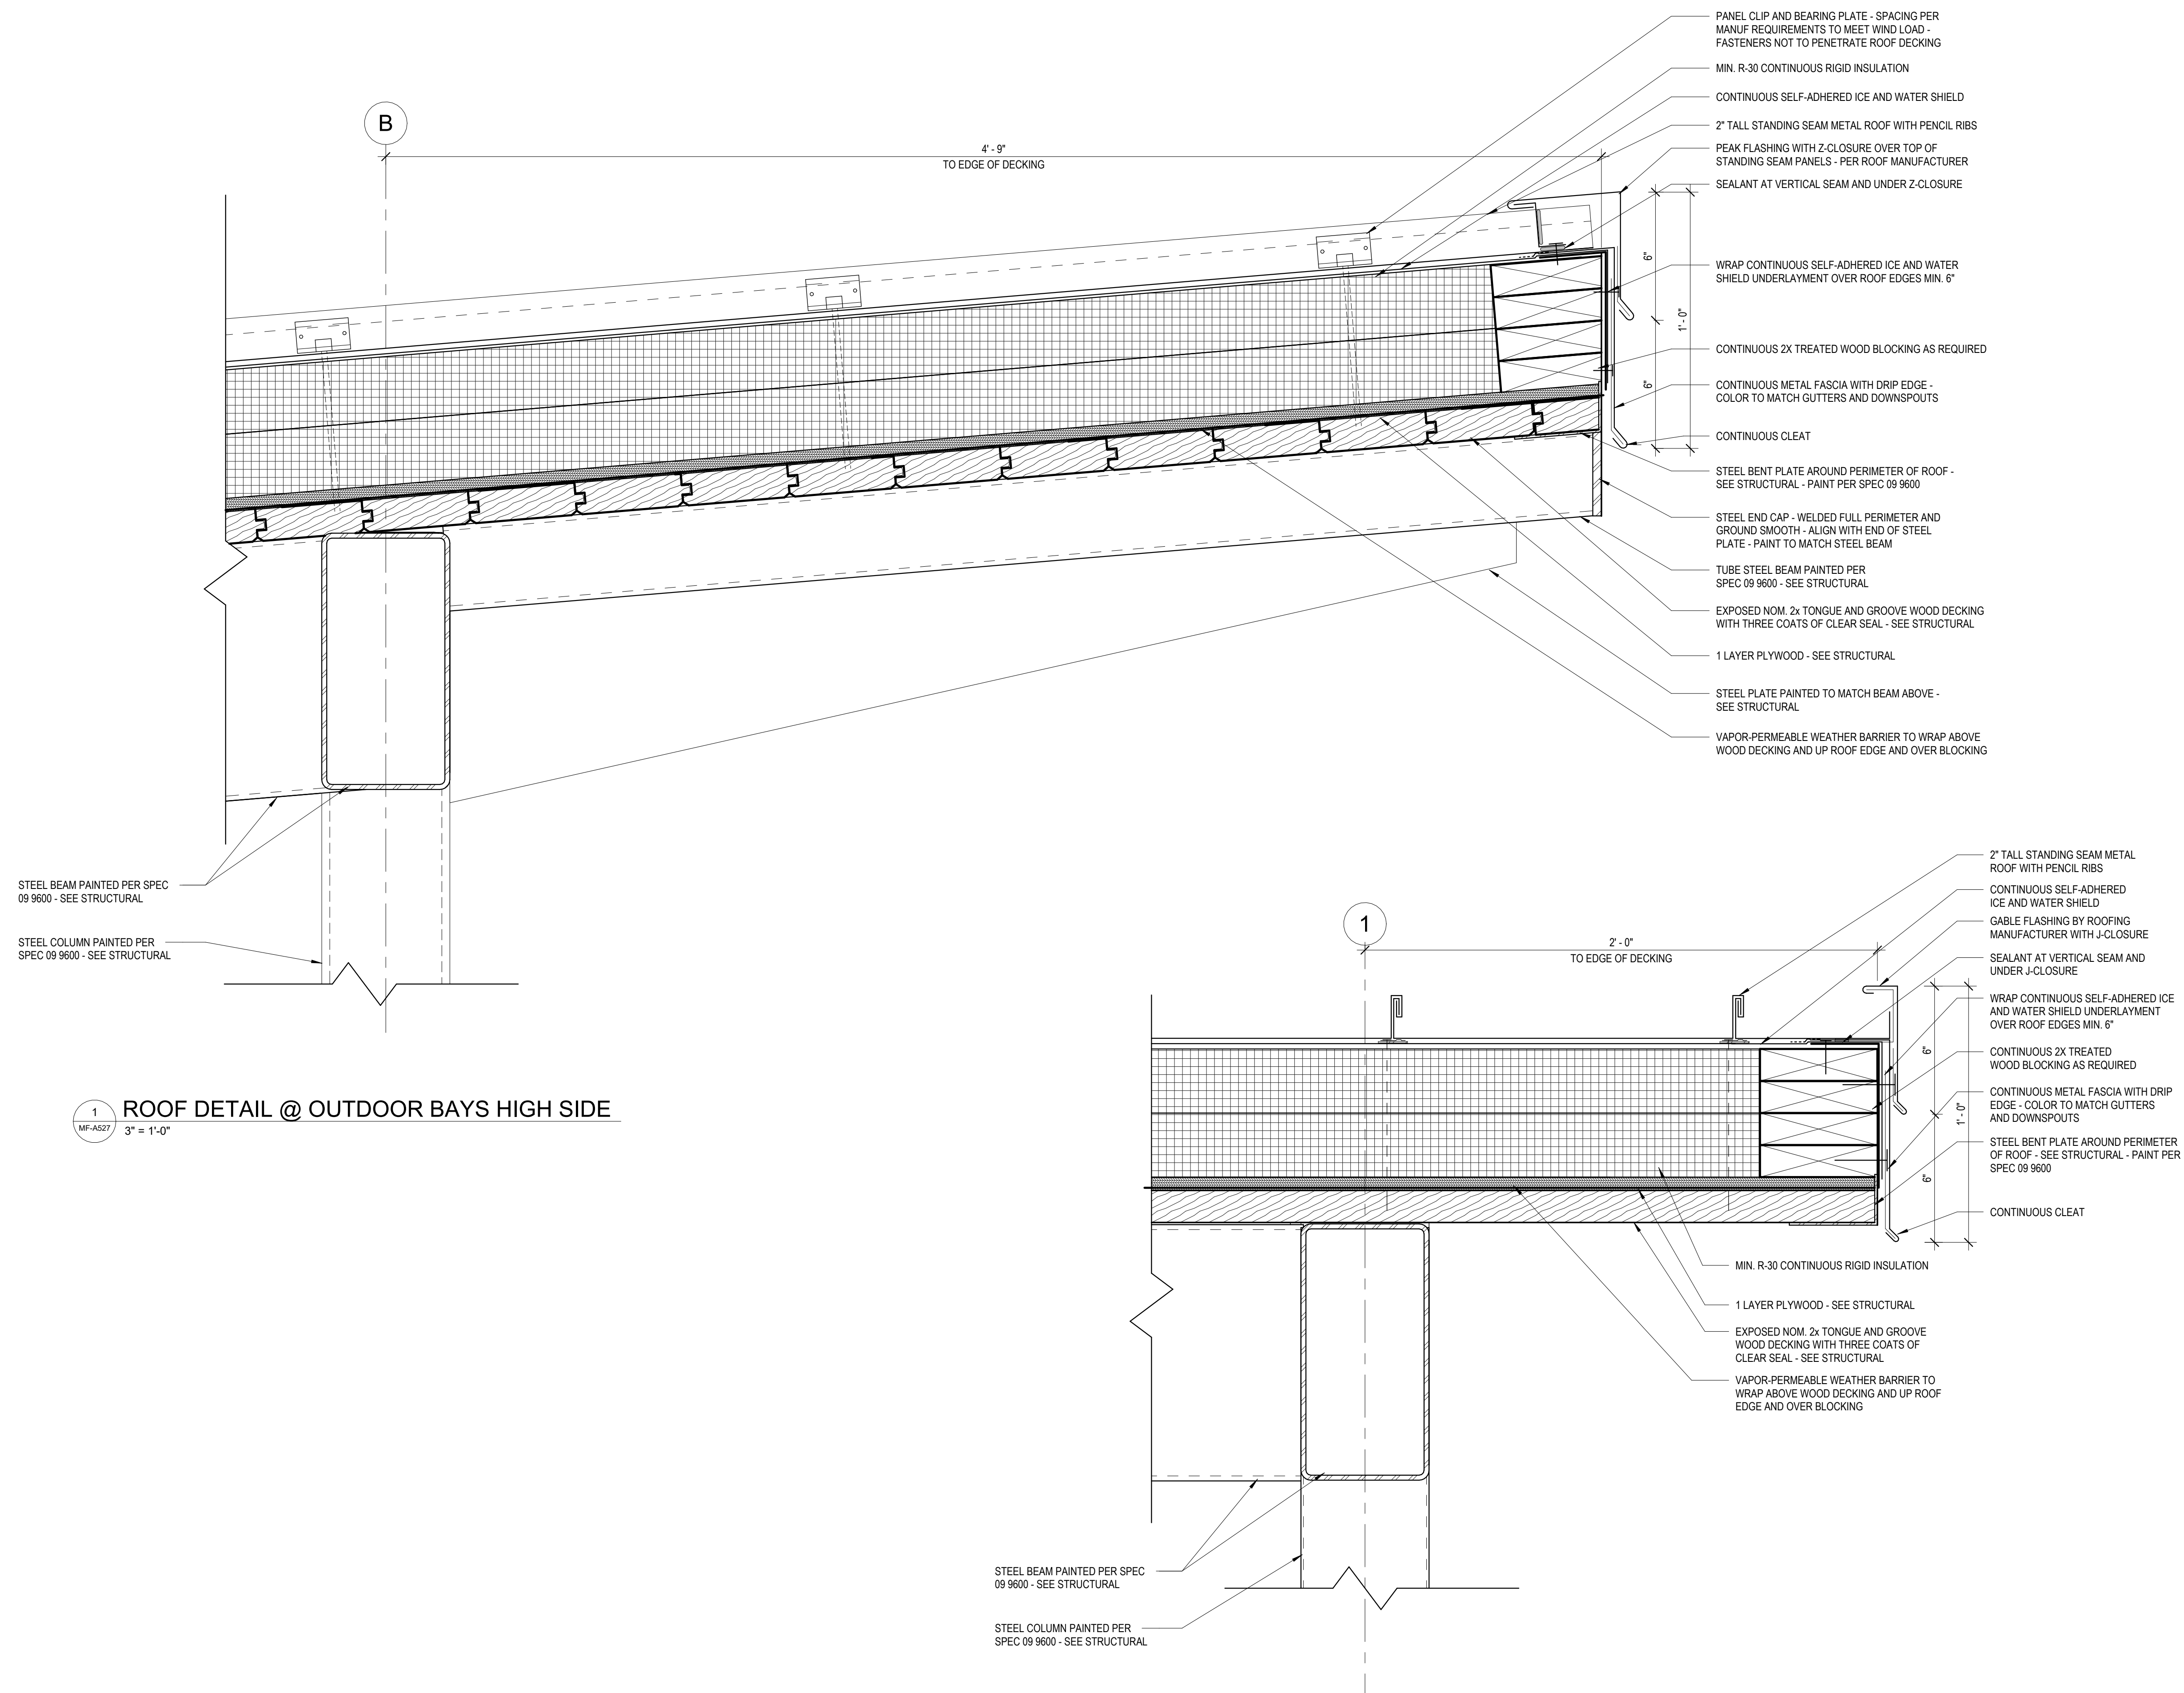


1 ROOF DETAIL @ OUTDOOR BAYS HIGH SIDE
MF-A527 3" = 1'-0"

2 ROOF DETAIL @ OUTDOOR BAYS SIDE
MF-A527 3" = 1'-0"



DOOR HARDWARE NOTES:

1. CARD READERS, DOOR CONTACTS, AND POWER SUPPLIES TO BE BY THE OWNER'S SECURITY VENDOR.
2. THE BALANCE OF DOOR HARDWARE IS IN THE GENERAL CONTRACTOR'S SCOPE.
3. DOORS WITH CARD READERS WILL ALSO RECEIVE DOOR CONTACTS.


DOOR ELEVATIONS

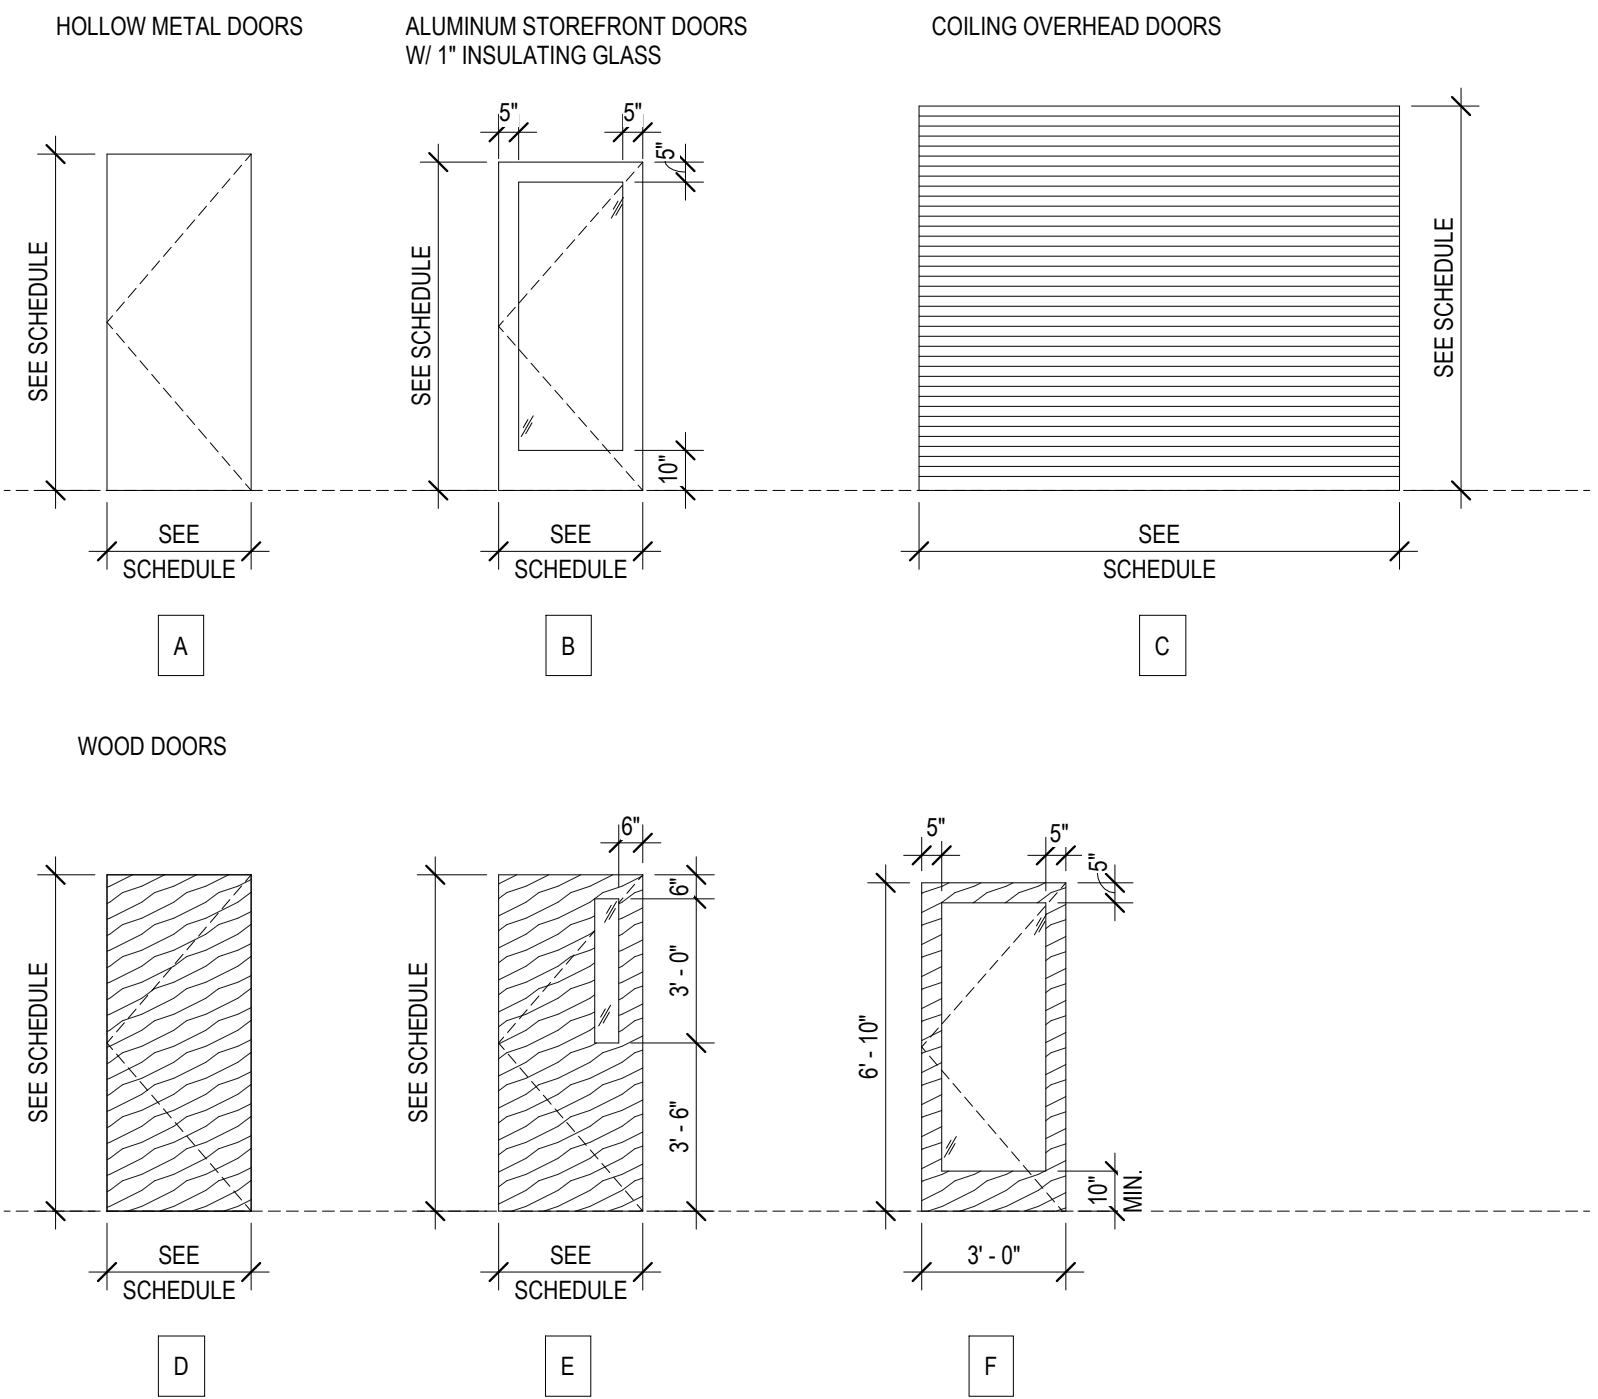

FRAME ELEVATIONS

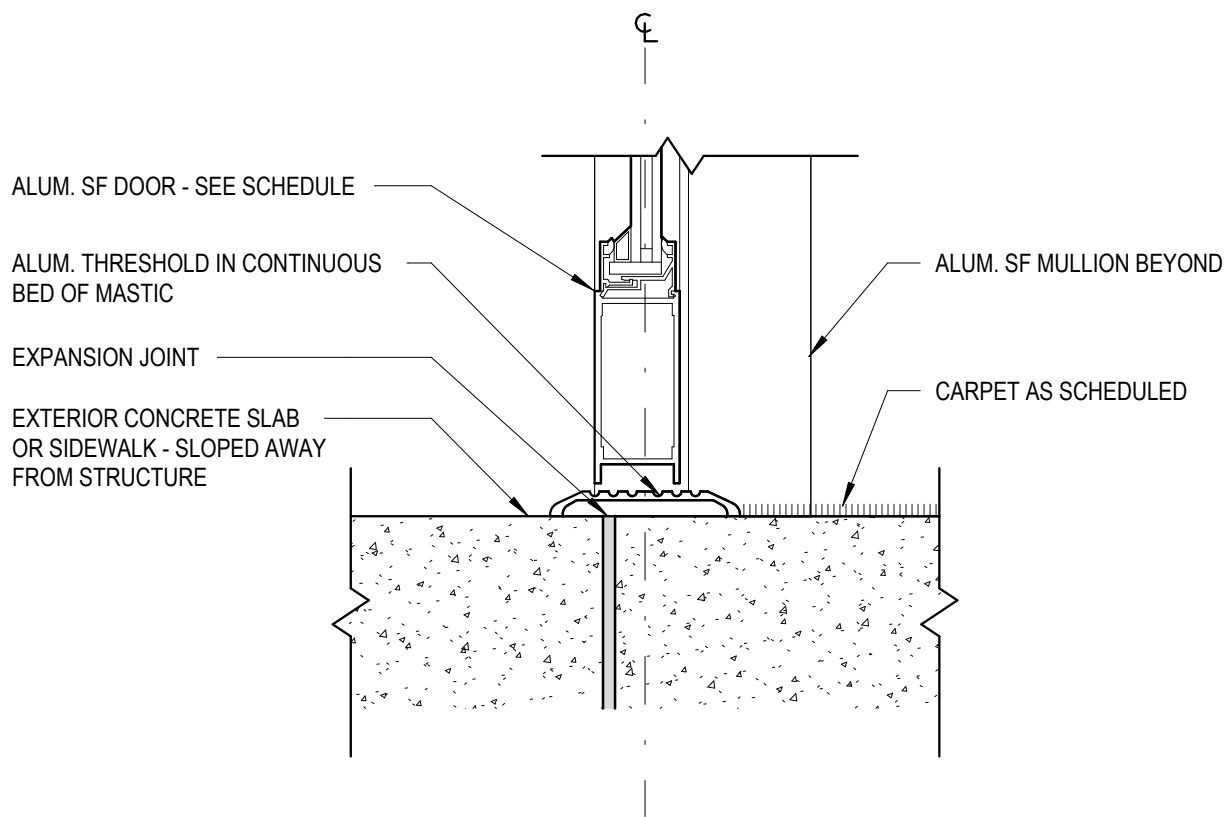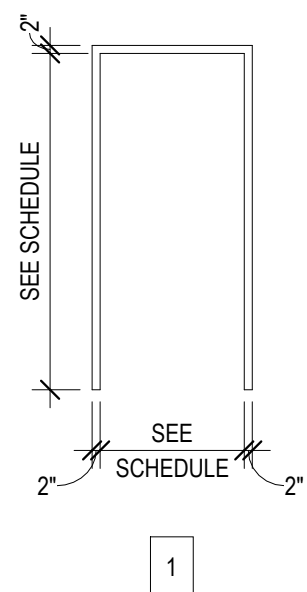


1	EXT. PAVING TO INT. CONCRETE & STOREFRONT
MF-A601	3" = 1'-0"

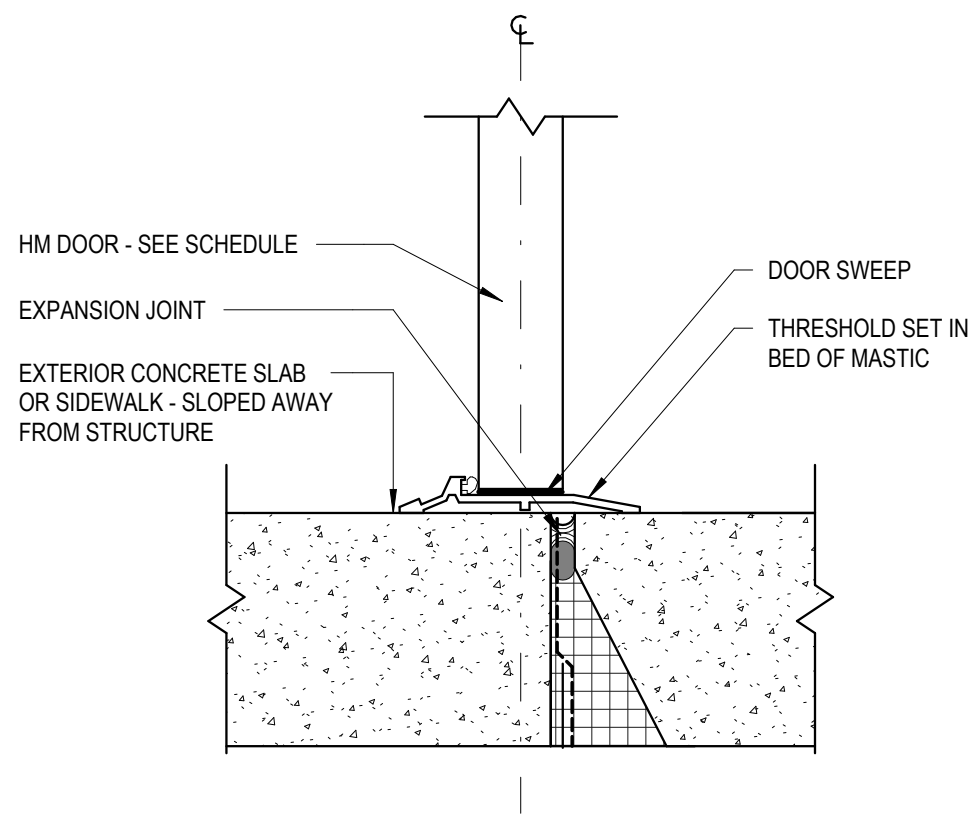


2 EXT. PAVING TO INT. PAVING @ HM DOOR
MF-A601 3" = 1'-0"

WINDOW ELEVATIONS

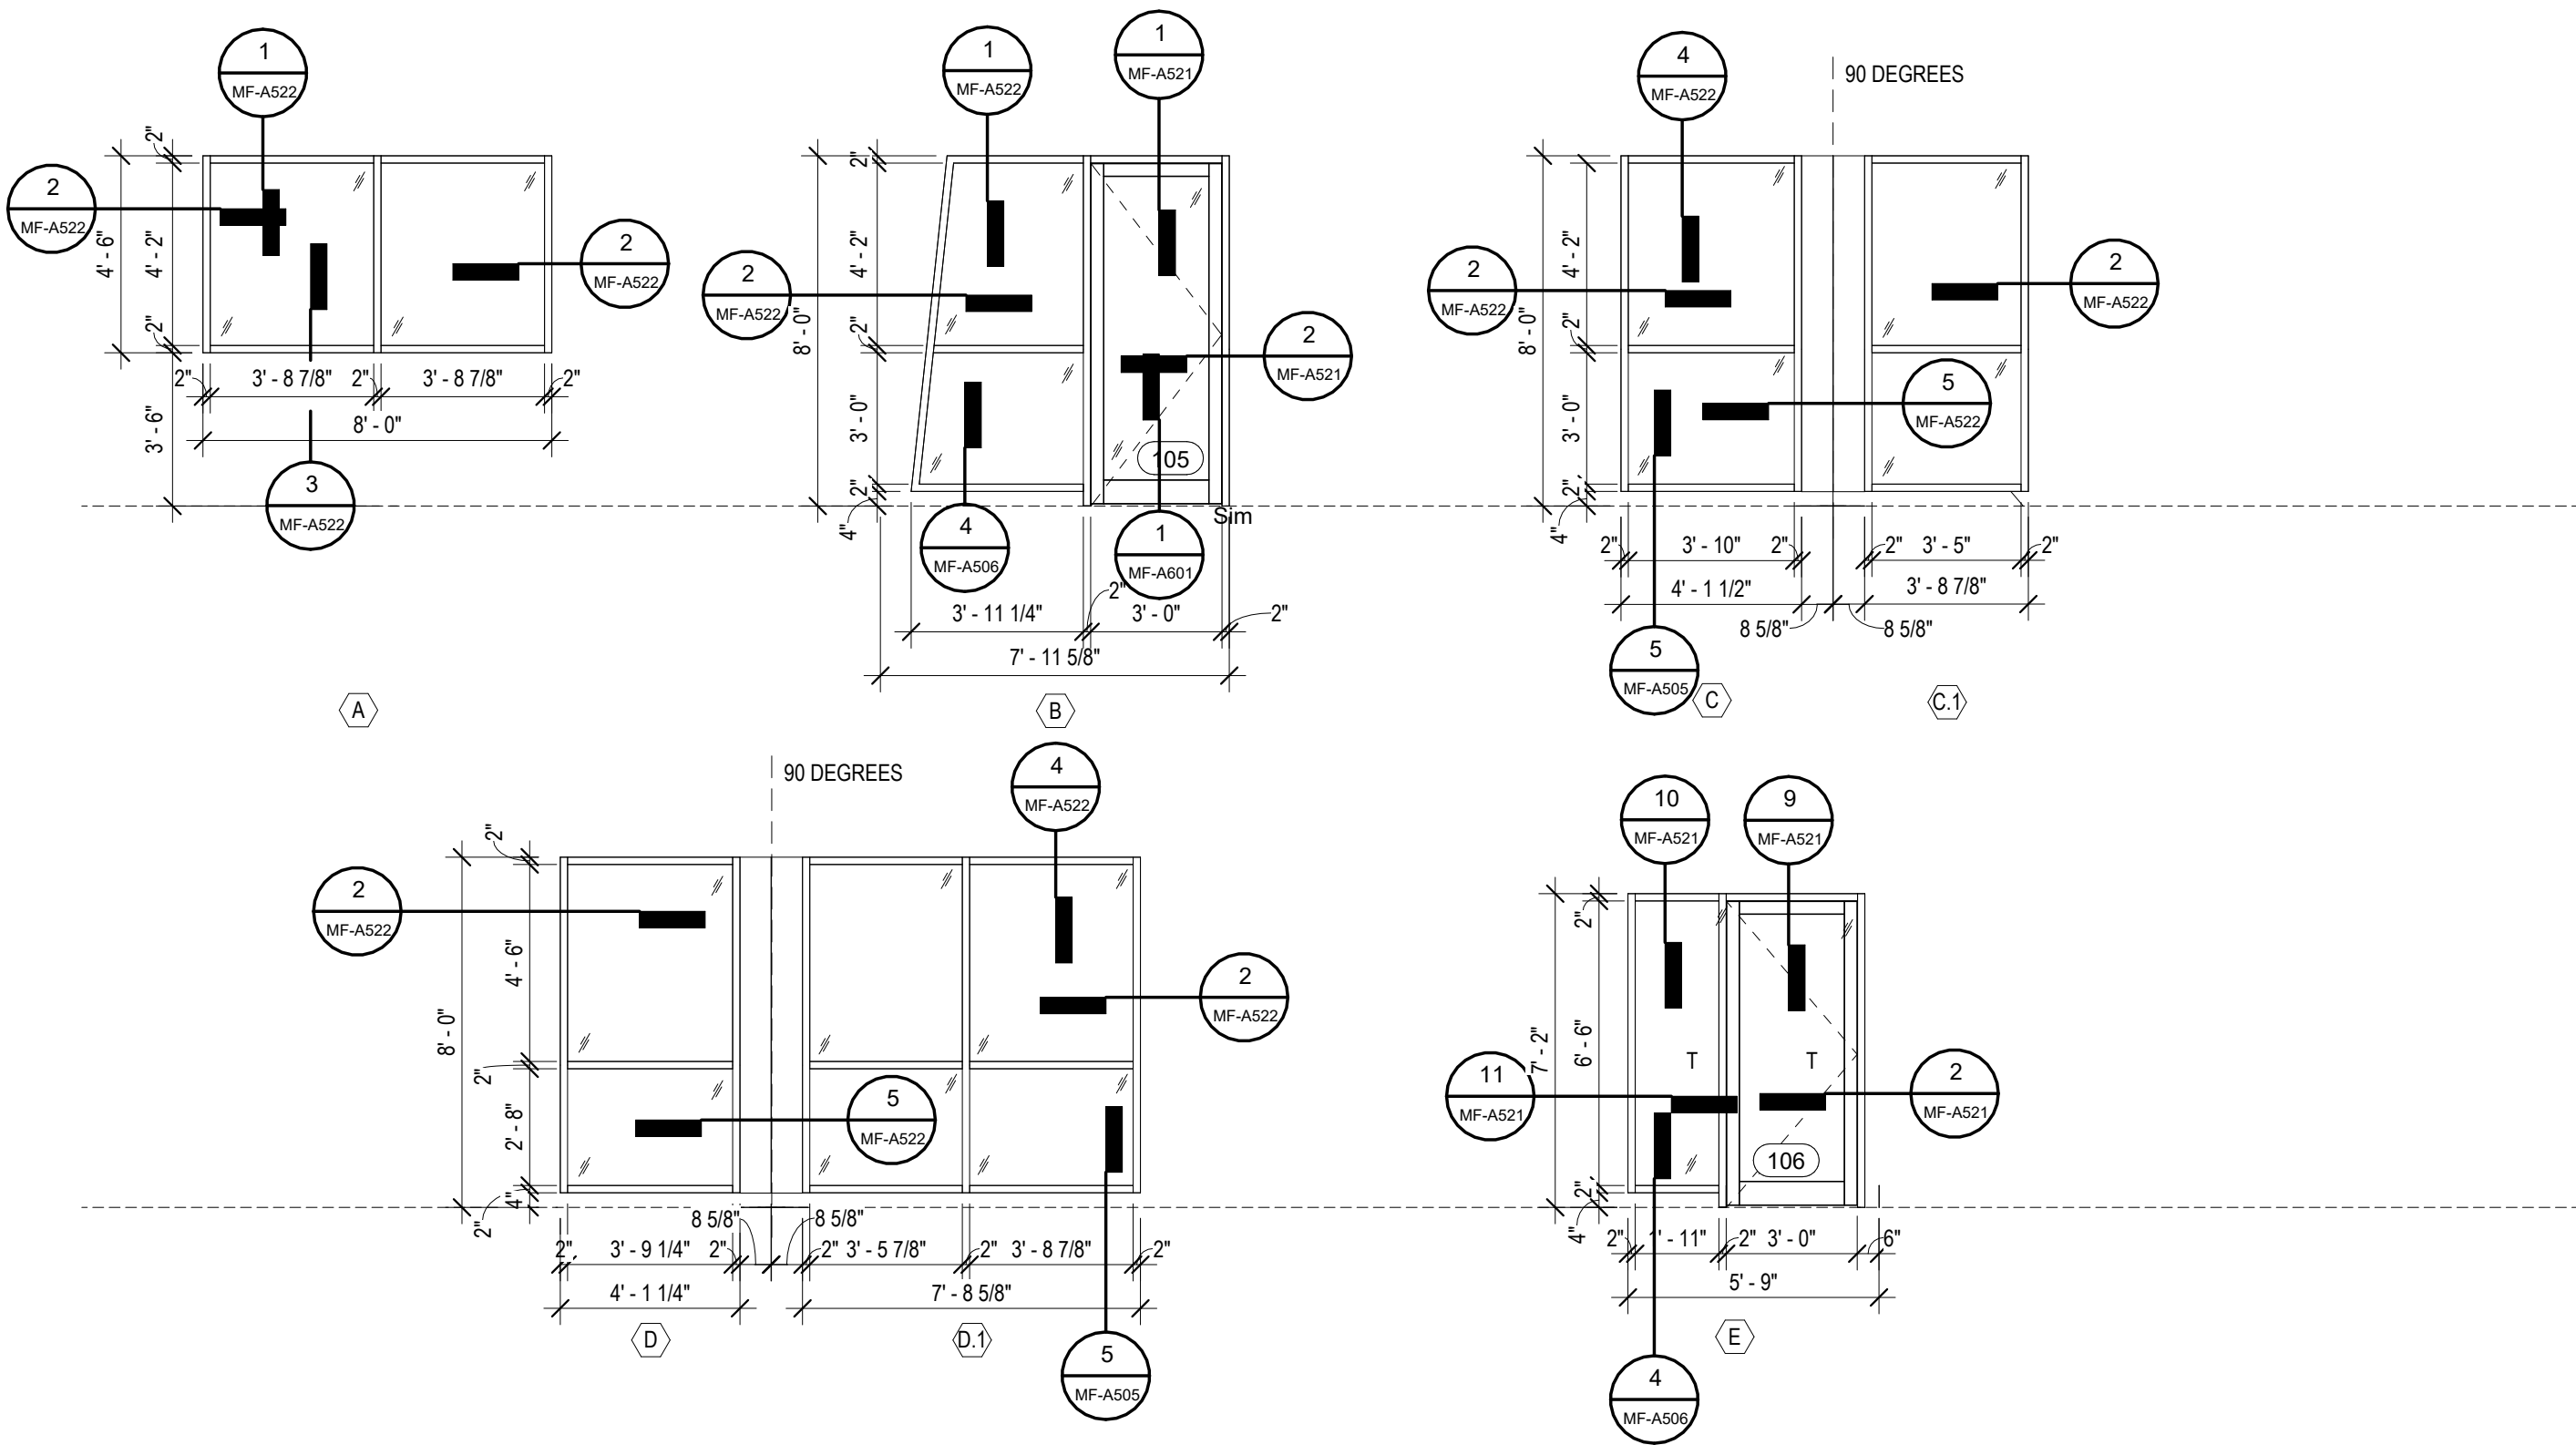

GENERAL GLAZING NOTES

1. ALL EXTERIOR GLAZING TO BE 1" INSULATED GLASS W/ LOW-E AND ARGON FILL.
2. ALL STOREFRONT MULLIONS SHALL BE FACTORY PAINTED.
3. ALL GLASS TO BE FULLY TEMPERED.

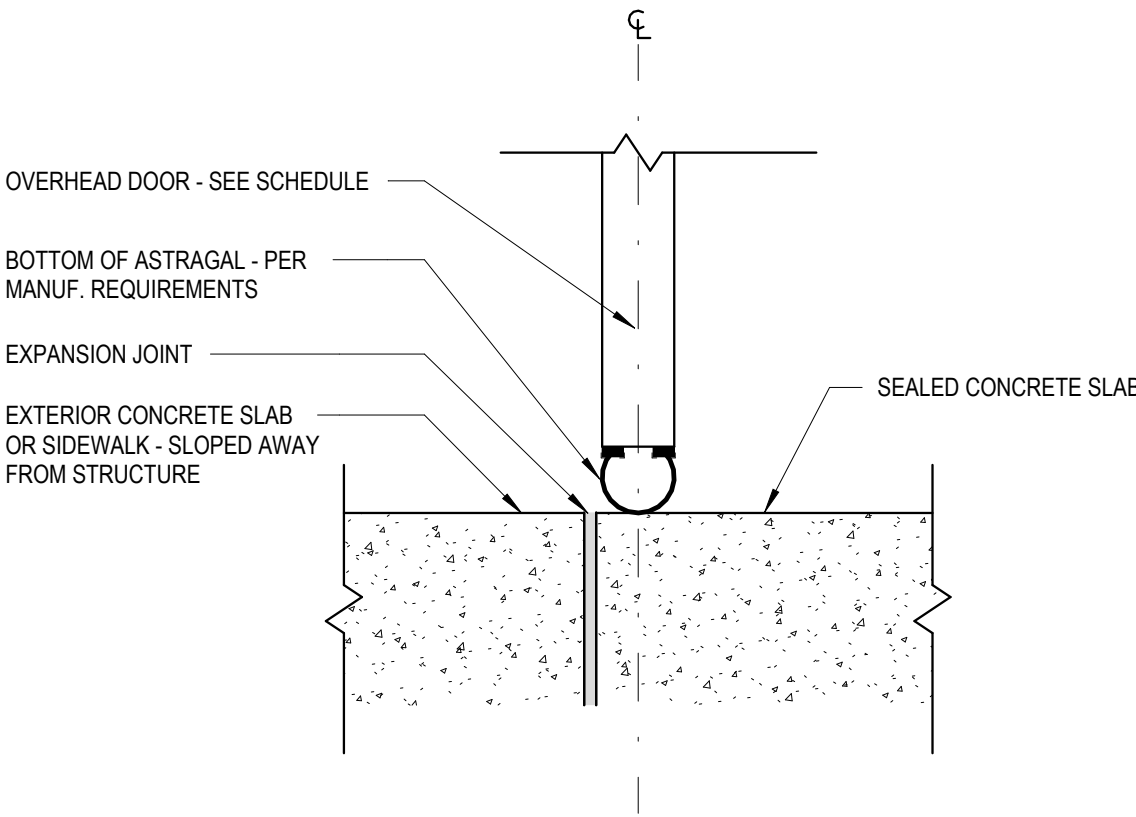

3 EXT. PAVING TO INT. CONCRETE @ OVERHEAD DOOR
MF-A601 3" = 1'-0"

Susan Hatchell
Landscape Architecture, PLLC
711 W. North Street, Raleigh, NC 27603
p: 919-838-9600 f: 919-838-9700

Esse Architects
632 PERSHING ROAD | RALEIGH, NORTH CAROLINA 27608

DOOR AND WINDOW SCHEDULES

LAKE MYRA COUNTY PARK
Wake County, NC

REVISIONS



Date: 07/27/26

MF-A601

GENERAL NOTES:

1.

THE STRUCTURAL DRAWINGS MUST BE USED IN CONJUNCTION WITH THE ARCHITECTURAL, CIVIL, MECHANICAL, PLUMBING, AND ELECTRICAL DRAWINGS, AND THE SPECIFICATIONS. THE CONTRACTOR MUST VERIFY THE REQUIREMENTS OF OTHER TRADES AS TO SLEEVES, CHASES, HANGERS, INSERTS, ANCHORS, HOLES, AND ADDITIONAL ITEMS TO BE PLACED OR SET IN THE STRUCTURAL WORK.
2.

THIS STRUCTURE HAS BEEN DESIGNED IN ACCORDANCE WITH THE PROVISIONS OF THE NORTH CAROLINA STATE BUILDING CODE, 2018 EDITION.
3.

THE CONTRACTOR MUST PROVIDE TEMPORARY SHORING AND BRACING REQUIRED TO ERECT AND HOLD THE STRUCTURE IN PROPER ALIGNMENT UNTIL PERMANENT SUPPORTS AND LATERAL BRACING ARE IN PLACE.
4.

DISCREPANCIES WITHIN DRAWINGS, BETWEEN THE SPECIFICATIONS AND THE DRAWINGS, OR WITHIN THE SPECIFICATIONS, MUST BE BROUGHT TO THE ATTENTION OF THE ARCHITECT AND ENGINEER DURING THE BIDDING PROCESS IN TIME TO PERMIT CLARIFICATION BY ADDENDUM. IF INCONSISTENCIES, DISCREPANCIES OR CONTRADICTIONS IN THE CONTRACT DOCUMENTS ARE DISCOVERED AFTER THE CLOSE OF BIDDING QUESTIONS, THE CONTRACTOR MUST BE DEEMED BY SUBMITTAL OF THEIR BID, TO HAVE BID THE MOST COSTLY AS TO LABOR, MATERIALS, DURATION, SEQUENCE AND METHOD OF CONSTRUCTION TO PROVIDE THE WORK.
5.

THESE STRUCTURAL DRAWINGS ARE ISSUED ON THE DATE INDICATED FOR THE PURPOSE DESIGNATED. THESE DRAWINGS MUST NOT BE ISSUED OR RELEASED FOR ANY OTHER PURPOSE WITHOUT THE WRITTEN AUTHORIZATION OF THE STRUCTURAL ENGINEER OF RECORD.
6.

DETAILS LABELED "TYPICAL DETAIL" WITHIN THE DOCUMENTS APPLY TO SITUATIONS ON THE PROJECT THAT MAY OCCUR THROUGHOUT THE PROJECT. SUCH DETAILS APPLY WHETHER OR NOT THE DETAIL IS SPECIFICALLY REFERENCED AT EACH INSTANCE. NOTIFY ENGINEER IF CLARIFICATIONS ARE REQUIRED REGARDING THE APPLICABILITY OF THE "TYPICAL DETAIL."
7.

DESIGN CRITERIA:

CLASSIFICATION OF BUILDING
RISK CATEGORY..... II

SUPERIMPOSED ROOF DEAD LOADS - UNIFORM:
INSULATION AND ROOF MEMBRANE..... 3 PSF
CEILING..... 2 PSF
DUCTS, LIGHTS, MISC. MECHANICAL..... 3 PSF
SOLAR PANEL ALLOWANCE..... 10 PSF

SUPERIMPOSED FLOOR DEAD LOADS - UNIFORM:
FLOOR FINISH..... 3 PSF
CEILING..... 2 PSF
DUCTS, LIGHTS, MISC. MECHANICAL..... 3 PSF

LIVE LOADS - UNIFORM:
SLAB ON GRADE..... 100 PSF
FLOOR..... 80 PSF
ROOF..... 20 PSF
CLASSROOMS..... 40 PSF
OFFICES..... 50 PSF
PARTITION ALLOWANCE..... 15 PSF
BALCONIES AND DECKS..... 100 PSF

STORAGE..... 125 PSF
MECHANICAL SPACE..... 150 PSF
STAIRWAYS..... 100 PSF

LIVE LOAD REDUCTION OF THE UNIFORMLY DISTRIBUTED FLOOR
LIVE LOADS HAS BEEN UTILIZED WHERE PERMITTED BY CODE.

LIVE LOADS - CONCENTRATED:
ROOFS..... 300#

UNLESS OTHERWISE NOTED, CONCENTRATED LOADS ARE APPLIED
UNIFORMLY OVER 2'-6" x 2'-6" AREA.

RAIN LOADS:
RAIN INTENSITY (15 MINUTE)..... 6.25 IN/HR

SNOW LOADS:
GROUND SNOW LOAD (Pg)..... 15 PSF
SLOPED ROOF LOAD (Pf)..... 11 PSF
IMPORTANCE FACTOR (Is)..... 1.0
THERMAL FACTOR (Ct)..... 1.0
EXPOSURE FACTOR (Ce)..... 1.0

GENERAL NOTES (CONT):

WIND LOADS:
BASIC WIND SPEED (Vult)..... 116 MPH
ALLOWABLE STRESS DESIGN WIND SPEED (Vasd)..... 90 MPH
EXPOSURE CATEGORY..... B
INTERNAL PRESSURE COEFFICIENT..... ±0.18
COMPONENT AND CLADDING PRESSURES:
WALLS, ZONE 5 (10 SF)..... 16 PSF
ROOF, ZONE 3 (10 SF)..... 56 PSF
ULTIMATE WIND BASE SHEARS (FOR MWFRS):
Vx..... 16 KIPS
Vy..... 36 KIPS

SEISMIC LOADS:
SITE CLASSIFICATION..... C
SEISMIC DESIGN CATEGORY..... B
IMPORTANCE FACTOR (IE)..... 1.0
SPECTRAL RESPONSE ACCELERATIONS:
Ss..... 0.112..... S1..... 0.057
Sms..... 0.146..... Sm1..... 0.085
Sds..... 0.097..... Sd1..... 0.057
ANALYSIS PROCEDURE..... EQUIVALENT LATERAL FORCE

LATERAL FORCE RESISITNG SYSTEM
STEEL SYSTEMS NOT SPECIFICALLY DETAILED..... R=3
FOR SEISMIC REISTANCE
RESPONSE MODIFICATION COEFFICIENT (R)..... 3.0
SEISMIC RESPONSE COEFFICIENT (Cs)..... 0.03
ULTIMATE SEISMIC BASE SHEAR (V)..... 6 KIPS

LATERAL DESIGN CONTROL
CONTROLLING LATERAL LOADS..... WIND

SHOP DRAWINGS AND SUBMITTALS:

1.

SHOP DRAWINGS AND SUBMITTALS MUST BEAR THE CONTRACTOR'S REVIEW STAMP WITH CHECKER'S INITIALS BEFORE BEING SUBMITTED TO THE ARCHITECT FOR APPROVAL.
2.

WHEN THE CONTRACTOR HAS BEEN AUTHORIZED TO USE THE ARCHITECT'S AND / OR ENGINEER'S DRAWINGS AS SHOP DRAWINGS, THE CONTRACTOR MUST REMOVE ALL TITLE BLOCKS, PROFESSIONAL SEALS, AND ANY OTHER REFERENCE TO THE ARCHITECT AND / OR ENGINEER FROM THAT SHOP DRAWING.

SITE PREPARATION, CONTROLLED FILL AND SURCHARGE NOTES:

1.

OBTAIN AND BECOME THOROUGHLY FAMILIAR WITH THE CONDITIONS AND RECOMMENDATIONS DESCRIBED IN THE SUBSURFACE EXPLORATION AND GEOTECHNICAL ENGINEERING REPORT. THIS REPORT IS NOT A PART OF THE CONTRACT DOCUMENTS, AND MAY NOT BE REPRESENTATIVE OF ALL SITE CONDITIONS WHICH MAY BE ENCOUNTERED.
2.

SITE PREPARATION AND CONTROLLED FILL MUST INCLUDE THE AREA ENCLOSED BY A LINE DRAWN 5 FEET OUTSIDE THE BUILDING FOOTPRINT.
3.

REMOVE ALL VEGETATION, ROOT MAT, TOPSOIL, ASPHALT PAVING AND AGGREGATE BASE MATERIAL. BASE BID ON 10 INCHES AVERAGE DEPTH.
4.

THE EXPOSED SUBGRADE MUST BE PROOF ROLLED WITH A LARGE RUBBER-TIRED ROLLER OR LOADED DUMP TRUCK; PERFORM AT LEAST TWO PASSES IN EACH OF TWO PERPENDICULAR DIRECTIONS.
5.

EXCAVATE SOFT SPOTS REVEALED BY PROOF ROLLING AS DIRECTED.
6.

PRIOR TO PLACEMENT OF ANY FILL MATERIAL, SETTLEMENT PLATES MUST BE INSTALLED ON THE PREPARED SUBGRADE. SEE PLAN FOR LOCATIONS AND DETAILS.
7.

FILL WITH SATISFACTORY STRUCTURAL FILL MATERIALS TO THE SPECIFIED ELEVATIONS.
8.

FILL MUST BE PLACED IN LOOSE LIFTS NOT EXCEEDING 8 INCHES, WHEN MECHANICAL COMPACTION EQUIPMENT IS USED OR 4 INCHES WHEN HAND COMPACTION EQUIPMENT IS USED AND MUST BE COMPACTED TO AT LEAST 95 PERCENT OF THE STANDARD PROCTOR MAXIMUM DRY DENSITY (ASTM D698).
9.

PLACE SURCHARGE FILL IN ONE FOOT LOOSE LIFTS, UP TO THE SPECIFIED ELEVATION. THE DEPTH OF SURCHARGE IS BASED ON A SOIL UNIT WEIGHT OF 120 POUNDS PER CUBIC FOOT. FOR LESS DENSE MATERIALS, PROVIDE ADDITIONAL SURCHARGE OR PROVIDE COMPACTION AS REQUIRED TO YIELD THE EQUIVALENT TOTAL WEIGHT OF SURCHARGE.
10.

THE CONTRACTOR MUST SECURE AND PAY FOR THE SERVICES OF A LICENSED LAND SURVEYOR TO MONITOR THE SETTLEMENT PLATES. ELEVATION READINGS MUST BE TAKEN ON THE SURFACE OF THE PLATE AND THE TOP OF THE BAR AT THE TIME OF INSTALLATION. SUBSEQUENT READINGS MUST BE OBTAINED ON TOP OF THE BAR A MINIMUM OF THREE TIMES PER WEEK DURING THE PLACEMENT OF ANY FILL, TWO TIMES PER WEEK FOR A PERIOD OF TWO WEEKS AFTER COMPLETION OF FILL, AND ONE TIME PER WEEK THEREAFTER.
11.

DURATION OF THE READINGS MUST BE ASSUMED TO BE 90 DAYS AFTER COMPLETION OF THE FILL. SUBMIT ELEVATION READINGS TO THE [ARCHITECT] [ENGINEER] [CONTRACTING OFFICER] ON A WEEKLY BASIS.

FOUNDATION NOTES:

1.

FOUNDATIONS HAVE BEEN DESIGNED IN ACCORDANCE WITH THE RECOMMENDATIONS IN THE [SUBSURFACE EXPLORATION AND GEOTECHNICAL ENGINEERING REPORT PREPARED BY ESP ASSOCIATES, INC., DATED AUGUST 29, 2025.
2.

FOUNDATIONS HAVE BEEN DESIGNED FOR A NET ALLOWABLE SOIL BEARING PRESSURE OF 2,500 PSF.
3.

TOP OF FOOTING ELEVATIONS MUST BE A MINIMUM DEPTH OF 1'-0" BELOW LOWEST ADJACENT SOIL GRADE.
4.

PRIOR TO PLACING FOUNDATION CONCRETE, ALL FOUNDATION EXCAVATIONS MUST BE INSPECTED BY THE OWNER'S GEOTECHNICAL TESTING AGENCY TO EXPLORE THE EXTENT OF LOOSE, SOFT, EXPANSIVE, OR OTHERWISE UNSATISFACTORY SOIL MATERIAL AND TO VERIFY DESIGN BEARING PRESSURE. DIRECTION FOR CORRECTIVE ACTION WILL BE PROVIDED BY THE OWNER'S GEOTECHNICAL TESTING AGENCY WHERE UNSATISFACTORY SOILS ARE PRESENT.
5.

NO UNBALANCED BACKFILLING MUST BE DONE AGAINST MASONRY OR CONCRETE WALLS UNLESS WALLS ARE SECURELY BRACED AGAINST OVERTURNING, EITHER BY TEMPORARY CONSTRUCTION BRACING OR BY PERMANENT CONSTRUCTION.
6.

CONTROL GROUNDWATER AND SURFACE RUNOFF THROUGHOUT THE CONSTRUCTION PROCESS. INUNDATION AND LONG TERM EXPOSURE OF BEARING SURFACES WHICH RESULT IN DETERIORATION OF BEARING MUST BE PREVENTED.

CAST-IN-PLACE CONCRETE NOTES:

1.

CONCRETE MUST BE IN ACCORDANCE WITH AMERICAN CONCRETE INSTITUTE (ACI) 301 AND 318.
2.

CONCRETE MUST BE NORMAL WEIGHT UNLESS OTHERWISE DENOTED AS LW (LIGHTWEIGHT) AND MUST OBTAIN 28 DAY COMPRESSIVE STRENGTHS AS FOLLOWS:
A. SLAB-ON-GRADE..... 3,500 PSI
B. COLUMNS AND WALLS..... 4,000 PSI
C. CONCRETE NOT OTHERWISE NOTED..... 3,000 PSI
3.

REINFORCING MATERIALS MUST BE AS FOLLOWS:
A. REINFORCING BARS - ASTM A615, GRADE 60, DEFORMED.
B. WELDED REINFORCING BARS - ASTM A706, GRADE 60.
C. WELDED WIRE REINFORCEMENT - ASTM A1064, WELDED STEEL WIRE REINFORCEMENT; PROVIDE SHEET TYPE, ROLL TYPE IS NOT ACCEPTABLE.
4.

ALL REINFORCING STEEL AND EMBEDDED ITEMS SUCH AS ANCHOR RODS AND WELD PLATES MUST BE ACCURATELY PLACED AND ADEQUATELY TIED AND SUPPORTED BEFORE CONCRETE IS PLACED TO PREVENT DISPLACEMENT BEYOND PERMITTED TOLERANCES.
5.

CONCRETE COVER TO REINFORCING STEEL MUST EQUAL THE FOLLOWING, UNLESS OTHERWISE NOTED:
A. SURFACES AGAINST EARTH..... 3"
B. SURFACES NOT CAST AGAINST EARTH, BUT EXPOSED TO EARTH OR WEATHER IN THE FINAL CONDITION
#5 AND SMALLER..... 1 1/2"
#6 AND LARGER..... 2"
C. BEAMS, GIRDERS, COLUMNS, AND WALLS ABOVE FINISHED FIRST FLOOR..... 1 1/2"
D. ELEVATED SLABS..... 3/4"
6.

LAP CONTINUOUS REINFORCING STEEL 57 X BAR DIAMETER, TYPICAL UNLESS OTHERWISE NOTED.
7.

LAP CONTINUOUS REINFORCING STEEL PER SCHEDULES AND TYPICAL DETAILS.
8.

DO NOT EMBED CONDUIT AND PIPING IN OR PENETRATE THROUGH CAST-IN-PLACE CONCRETE ELEMENTS UNLESS OTHER NOTED.

CONCRETE MIX DESIGN NOTES:


1.

MIX DESIGNS COMPRESSIVE STRENGTHS (fc) BASED ON 28 DAY DESIGN STRENGTH, UNLESS OTHERWISE NOTED.
2.

CONCRETE NOT OTHERWISE NOTED:
A. MINIMUM COMPRESSIVE STRENGTH (fc) = 4000 PSI
3.

FOUNDATIONS (SPREAD FOOTINGS, MAT FOOTINGS):
A. EXPOSURE CLASS = ACI 318 F0, S0, W0, C1
B. MINIMUM COMPRESSIVE STRENGTH (fc) = 3,000PSI
C. MAXIMUM W/CM = 0.5
D. BLENDED HYDRAULIC CEMENT = ASTM C595 TYPE 1L
E. SLUMP = 5" MAX PLUS OR MINUS 1", OR 8" MAX, PLUS OR MINUS 1" FOR CONCRETE WITH A VERIFIED SLUMP OF 3" PLUS OR MINUS 1" BEFORE ADDING HIGH-RANGE WATER-REDUCING OR PLASTICIZING ADMIXTURE
F. AIR CONTENT = NO REQUIREMENTS
G. AGGREGATE = NORMAL WEIGHT, ¾" NOMINAL
H. LIMIT WATER-SOLUBLE, CHLORIDE-ION CONTENT IN HARDENED CONCRETE TO 0.1 PERCENT BY WEIGHT OF CEMENT
4.

INTERIOR FLOOR SLAB-ON-GRADE:
A. EXPOSURE CLASS = ACI 318 F0, S0, W0, C0
B. MINIMUM COMPRESSIVE STRENGTH (fc) = 3,500PSI
C. MAXIMUM W/CM = 0.5
D. BLENDED HYDRAULIC CEMENT = ASTM C595 TYPE 1L
E. SLUMP = 5" MAX PLUS OR MINUS 1", OR 8" MAX, PLUS OR MINUS 1" FOR CONCRETE WITH A VERIFIED SLUMP OF 3" PLUS OR MINUS 1" BEFORE ADDING HIGH-RANGE WATER-REDUCING OR PLASTICIZING ADMIXTURE
F. AIR CONTENT = DO NOT ALLOW AIR CONTENT IN TROWEL FINISHED FLOORS TO EXCEED 3%
G. AGGREGATE = NORMAL WEIGHT, ¾" NOMINAL
H. LIMIT WATER-SOLUBLE, CHLORIDE-ION CONTENT IN HARDENED CONCRETE TO 0.3 PERCENT BY WEIGHT OF CEMENT

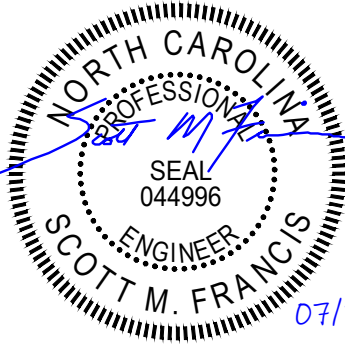

IMEG RESERVES PROPRIETARY RIGHTS, INCLUDING COPYRIGHTS, TO THIS DRAWING AND THE DATA SHOWN THEREON. SAID DRAWING AND/OR DATA ARE THE EXCLUSIVE PROPERTY OF IMEG AND SHALL NOT BE USED OR REPRODUCED FOR ANY OTHER PROJECT WITHOUT THE EXPRESS WRITTEN APPROVAL AND PARTICIPATION OF IMEG. ©2025 IMEG CONSULTANTS CORP. North Carolina Design Registration #F-1507

Susan Hatchell
Landscape Architecture, PLLC
711 W. North Street, Raleigh, NC 27603
p: 919-838-9600 f: 919-838-9700



GENERAL NOTES

LAKE MYRA COUNTY PARK
Wake County, NC

REVISIONS

Date07/27/2026

MF-S001

STRUCTURAL STEEL NOTES:

1. STRUCTURAL STEEL MUST BE IN ACCORDANCE WITH THE AMERICAN INSTITUTE OF STEEL CONSTRUCTION (AISC) 360.
2. STRUCTURAL STEEL FABRICATOR MUST PARTICIPATE IN THE AISC QUALITY CERTIFICATION PROGRAM AND BE A DESIGNATED AISC-CERTIFIED PLANT.
3. STRUCTURAL STEEL INSTALLER MUST PARTICIPATE IN THE AISC QUALITY CERTIFICATION PROGRAM AND BE A DESIGNATED AISC-CERTIFIED ERECTOR.
4. STRUCTURAL STEEL MUST COMPLY WITH THE FOLLOWING SPECIFICATIONS:

A. STRUCTURAL STEEL SHAPES, PLATES AND BARS UNLESS OTHERWISE NOTED - ASTM A572, Fy = 50 KSI

B. STRUCTURAL STEEL W-SHAPES - ASTM A992, Fy = 50 KSI

C. HOLLOW STRUCTURAL SECTIONS (HSS):

a. SQUARE & RECTANGULAR - ASTM A500, GRADE C, Fy = 50 KSI

b. ROUND - ASTM A500, GRADE C, Fy = 46 KSI

D. ANCHOR RODS - ASTM F1554, GRADE [36] [55]

E. HIGH STRENGTH BOLTS - ASTM F3125, TYPE A325 (TYPICAL UON)

F. FULLY PRETENSIONED BOLTS - ASTM F1852 (TWIST-OFF TYPE)

G. WASHERS - ASTM F436

H. NUTS - ASTM A563

I. HEADED STUDS - ASTM A29, GRADE 1010 THROUGH 1020
5. UNLESS OTHERWISE NOTED, ALL REQUIRED DESIGN STRENGTHS AND REACTIONS INDICATED ARE BASED ON THE "LOADING COMBINATIONS USING STRENGTH DESIGN OR LOAD AND RESISTANCE FACTOR DESIGN" PER SECTION 1605.2 OF THE BUILDING CODE.
6. STRUCTURAL STEEL FRAME IS CONSIDERED AS UNRESTRAINED FOR FIRE PROTECTION PURPOSES.
7. ALL STEEL CONNECTIONS AND MEMBER REINFORCEMENT MUST BE DESIGNED BY FABRICATOR'S QUALIFIED PROFESSIONAL ENGINEER FOR LOADS INDICATED ON THE DRAWINGS, PER OPTION 3B OF ANSI/AISC 303 AND COMPLETE THE FOLLOWING:

A. SUBMIT STRUCTURAL CALCULATIONS SIGNED AND SEALED BY THE QUALIFIED PROFESSIONAL ENGINEER REGISTERED IN THE NORTH CAROLINA RESPONSIBLE FOR THEIR PREPARATION.

B. THE PROFESSIONAL ENGINEER RESPONSIBLE FOR CONNECTION DESIGN MUST REVIEW THE SHOP DRAWINGS PRIOR TO SUBMITTAL TO VERIFY THAT THE CONNECTIONS AS DETAILED ON THE SHOP DRAWINGS COMPLY WITH THE CONNECTION DESIGN REQUIREMENTS OF THE FINAL CALCULATIONS.

C. A REVIEW LETTER, SIGNED AND SEALED BY THE PROFESSIONAL ENGINEER RESPONSIBLE FOR CONNECTION DESIGN MUST BE PROVIDED WITH THE SHOP DRAWINGS AND CALCULATION SUBMITTAL STATING THAT THIS REVIEW AND VERIFICATION HAS BEEN COMPLETED.
8. HIGH STRENGTH BOLTS MAY BE TIGHTENED TO THE "SNUG TIGHT" CONDITION, UNLESS OTHERWISE NOTED.
9. BOLTED CONNECTIONS MAY USE NON-STANDARD HOLES, EXCEPT IN THE FOLLOWING LOCATIONS:

A. AXIAL CONNECTIONS IDENTIFIED ON PLAN.

B. ALL FRAMING CONNECTIONS AT BRACED FRAMES AND MOMENT FRAMES.

C. CONNECTIONS IDENTIFIED ON PLAN WITH FULL DEPTH STIFFENER PLATES.

STRUCTURAL STEEL NOTES (CONT):

10. PROVIDE ANGLE FRAMING AROUND OPENINGS LARGER THAN 6 INCHES IN ANY DIMENSION (INCLUDING ROOF DRAINS) TO SUPPORT STEEL DECK. REFERENCE PLANS AND TYPICAL DETAILS FOR SIZING REQUIREMENTS.
11. WELDING MUST BE IN ACCORDANCE WITH AWS D1.1, "STRUCTURAL WELDING CODE - STEEL." WELD ELECTRODES MUST BE E70XX LOW HYDROGEN. UNLESS OTHERWISE NOTED, PROVIDE CONTINUOUS FILLET WELDS WITH MINIMUM SIZE REQUIRED BY TABLE J2.4 AISC 360.
12. INSTALLATION OF HEADED COMPOSITE STUDS MUST CONFORM TO THE REQUIREMENTS OF AWS D1.1, SECTIONS 9.4 AND 9.5. HEADED COMPOSITE STUDS MUST BE TESTED IN ACCORDANCE WITH AWS D1.1, SECTIONS 9.6, 9.7, AND 9.8 BY A QUALIFIED TESTING AGENCY.
13. COORDINATE ALL MEMBER LOCATIONS, UNIT WEIGHTS, OPENING SIZES, AND CURB DIMENSIONS FOR MECHANICAL EQUIPMENT WITH THE ACTUAL EQUIPMENT FURNISHED.
14. SHOP PRIME STEEL SURFACES, EXCEPT THE FOLLOWING:

A. SURFACES EMBEDDED IN CONCRETE OR MORTAR. EXTEND PRIMING OF PARTIALLY EMBEDDED MEMBERS TO A DEPTH OF 2 INCHES.

B. SURFACES TO BE WELDED.

C. SURFACES TO RECEIVE SPRAYED FIRE-RESISTIVE MATERIALS.

D. GALVANIZED SURFACES.

E. SURFACES ENCLOSED IN INTERIOR CONSTRUCTION.
15. CLEAN ALL STEEL SURFACES TO BE PAINTED. REMOVE LOOSE RUST, MILL SCALE, SPATTER, SLAG, OR FLUX DEPOSITS. PREPARE SURFACES IN ACCORDANCE WITH SSPC-SP3 SPECIFICATION AND STANDARD.
16. HOT-DIP GALVANIZE AFTER FABRICATION THE FOLLOWING:


A. ANGLES AND PLATES SUPPORTING MASONRY IN EXTERIOR WALLS.

B. LINTELS AND LINTEL ASSEMBLIES SUPPORTING MASONRY IN EXTERIOR WALLS.

C. ALL STEEL EXPOSED TO WEATHER IN THE FINAL CONSTRUCTION.

D. ITEMS IDENTIFIED AS GALVANIZED ON ARCHITECTURAL OR STRUCTURAL DRAWINGS.

E. STEEL IN CONTACT WITH PT WOOD.
17. STEEL MEMBERS MUST BE SPLICED ONLY WHERE INDICATED.
18. LOCATE CONSTRUCTION JOINTS FOR SLABS ON METAL DECK MIDWAY BETWEEN BEAMS WHERE THE JOINT IS PARALLEL TO THE BEAM SPAN. LOCATE JOINTS WITHIN THE MIDDLE THIRD SPAN WHERE THE JOINT IS PERPENDICULAR TO THE BEAM SPAN. ANY STOP IN CONCRETE WORK MUST BE MADE WITH VERTICAL BULKHEADS, UNLESS OTHERWISE SHOWN. REINFORCING TO BE CONTINUOUS THROUGH JOINTS.
19. ALL STAIR LANDINGS, STAIRS, AND STAIR SUPPORTS TO BE DESIGNED BY STAIR MANUFACTURER. LAYOUT OF STAIRS, LANDINGS, HANDRAILS, ETC. SHALL COMPLY WITH ARCHITECTURAL DRAWINGS. STRUCTURAL DESIGN CALCULATIONS AND DRAWINGS STAMPED BY A REGISTERED ENGINEER SHALL BE SUBMITTED TO THE STRUCTURAL EOR FOR REVIEW OF LOADING. ARCHITECT AND STAIR MANUFACTURER ARE RESPONSIBLE TO REVIEW FOR CODE AND ADA COMPLIANCE. STAIR MANUFACTURER SHALL PROVIDE ALL POSTS AND CONNECTIONS TO SUPPORT STAIRS. POSTS AND HANGERS MUST BE LOCATED IN PARTITION WALLS AND LOAD THE STRUCTURE CONCENTRICALLY.

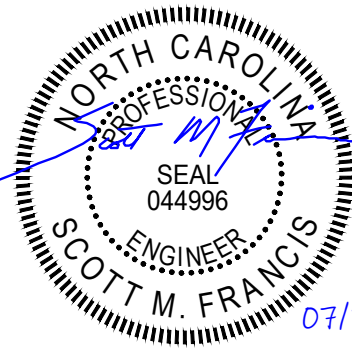

IMEG RESERVES PROPRIETARY RIGHTS, INCLUDING COPYRIGHTS, TO THIS DRAWING AND THE DATA SHOWN THEREON. SAID DRAWING AND/OR DATA ARE THE EXCLUSIVE PROPERTY OF IMEG AND SHALL NOT BE USED OR REPRODUCED FOR ANY OTHER PROJECT WITHOUT THE EXPRESS WRITTEN APPROVAL AND PARTICIPATION OF IMEG. ©2025 IMEG CONSULTANTS CORP. North Carolina Design Registration #F-1507

Susan Hatchell
Landscape Architecture, PLLC
711 W. North Street, Raleigh, NC 27603
p: 919-838-9600 f: 919-838-9700



GENERAL NOTES

LAKE MYRA COUNTY PARK
Wake County, NC

REVISIONS

Date07/27/2026

MF-S002

ROUGH CARPENTRY NOTES:

1. ROUGH CARPENTRY MUST BE IN ACCORDANCE WITH THE AMERICAN WOOD COUNCIL (AWC) "NATIONAL DESIGN SPECIFICATION FOR WOOD CONSTRUCTION."
2. UNLESS OTHERWISE NOTED, USE 'COMMON' NAILS AND ALL NAILING MUST CONFORM TO THE "FASTENING SCHEDULE" TABLE 2304.10.1 OF THE BUILDING CODE.
3. WOOD FRAMING MEMBERS MUST COMPLY WITH PS 20 "AMERICAN SOFTWOOD LUMBER STANDARD" AND THE FOLLOWING REQUIREMENTS:

A. MOISTURE CONTENT - SEASONED, WITH 19 PERCENT MAXIMUM MOISTURE CONTENT.

B. GRADE - NO. 2, OR BETTER UNLESS OTHERWISE NOTED.

C. SPECIES - [SPRUCE-PINE-FIR UNDER NLGA RULES] [SPRUCE-PINE-FIR (SOUTH) UNDER WWPA RULES] [SOUTHERN PINE GRADED UNDER SPIB RULES].
4. WOOD STRUCTURAL PANELS (WSP) MUST COMPLY WITH PS 1 "U.S. PRODUCT STANDARD FOR CONSTRUCTION AND INDUSTRIAL PLYWOOD" FOR PLYWOOD CONSTRUCTION PANELS AND THE FOLLOWING REQUIREMENTS:

A. EXTERIOR WALL AND SHEAR WALL SHEATHING: [7/16"] INCH, APA RATED SHEATHING, [EXTERIOR EXPOSURE] [EXPOSURE 1] DURABILITY CLASSIFICATION.

B. FLOOR SHEATHING: [23/32"] INCH, TONGUE-AND-GROOVE, APA RATED SHEATHING, [EXTERIOR EXPOSURE] [EXPOSURE 1] DURABILITY CLASSIFICATION.

C. ROOF SHEATHING: [9/16"] INCH, APA RATED SHEATHING, [EXTERIOR EXPOSURE] [EXPOSURE 1] DURABILITY CLASSIFICATION. PROVIDE TONGUE-AND-GROOVE EDGES OR USE "PLY-CLIPS" AT MID-SPAN BETWEEN EACH SUPPORT.
5. ALL WOOD FRAMING MEMBERS PERMANENTLY EXPOSED TO THE WEATHER AND ALL SILL PLATES IN CONTACT WITH CONCRETE MUST BE PRESERVATIVE-TREATED. REFER TO THE SPECIFICATIONS.
6. STEEL PLATE CONNECTORS MUST COMPLY WITH ASTM A 36 SPECIFICATIONS (Fy= 36 KSI). BOLTS CONNECTING WOOD MEMBERS MUST COMPLY WITH ASTM A307 COMMON STEEL BOLTS, AND MUST BE 1/2 INCH DIAMETER, UNLESS OTHERWISE NOTED.
7. METAL FRAMING ANCHORS, HOLD DOWNS, HURRICANE TIES, HANGERS, ETC. MUST COMPLY WITH ASTM A653 AND BE CAPABLE OF SUPPORTING THE REACTIONS SHOWN. WHERE PRODUCTS OF A SPECIFIC MANUFACTURER ARE SHOWN, EQUAL PRODUCTS OF ANOTHER MANUFACTURER MAY BE USED IF APPROVED.
8. PROVIDE BRIDGING FOR ALL FLOOR JOISTS AND ROOF RAFTERS. MAXIMUM SPACING MUST BE 8'-0", UNLESS OTHERWISE NOTED.
9. PROVIDE DOUBLE JOISTS UNDER ALL PARTITIONS WHICH RUN PARALLEL WITH JOISTS, AND UNDER ALL CONCENTRATED LOADS FROM FLOORS ABOVE UNLESS OTHERWISE INDICATED. PROVIDE MULTIPLE STUDS WHERE INDICATED ON THE PLANS.
10. PROVIDE HEADERS OF THE SAME CROSS SECTION AS JOISTS OR RAFTERS TO FRAME AROUND ALL OPENINGS TO SUPPORT SHEATHING, UNLESS OTHERWISE NOTED OR DETAILED ON THE DRAWINGS.
11. UNLESS OTHERWISE NOTED, ATTACH BLOCKING AND NAILERS TO STEEL FRAMING USING 3/16 INCH DIAMETER POWDER ACTUATED FASTENERS AT 24 INCHES ON CENTER OR 1/2 INCH DIAMETER BOLTS AT 48 INCHES ON CENTER. STAGGER FASTENERS TO ALTERNATE SIDES OF BEAM WEB.
12. WHERE MULTIPLE FRAMING MEMBERS ARE INDICATED, SCAB CONTINGENT MEMBERS TOGETHER WITH 16d NAILS AT 12 INCHES ON CENTER, ALTERNATING AT 2 INCHES FROM EACH EDGE.
13. ALL CONNECTION HARDWARE IN CONTACT WITH PRESERVATIVE TREATED WOOD MUST BE HOT-DIP GALVANIZED COATED.
14. POWDER ACTUATED FASTENERS (PAF) MUST HAVE A MINIMUM ALLOWABLE CAPACITY INTO THE BASE MATERIAL AS FOLLOWS UNLESS OTHERWISE NOTED:

A. STEEL: SHEAR = 600 LBS
TENSION = 250 LBS

B. CONCRETE: SHEAR = 260 LBS
TENSION = 255 LBS

STRUCTURAL DELEGATED DESIGN ELEMENT NOTES:

1. THE FOLLOWING BUILDING ELEMENTS REQUIRE DELEGATED DESIGN AND ENGINEERING BY A SPECIALTY STRUCTURAL ENGINEER:

A. GLAZING ASSEMBLY CONNECTIONS TO THE STRUCTURE

B. STRUCTURAL STEEL CONNECTIONS

C. MECHANICAL, ELECTRICAL, AND PLUMBING SUPPORTS AND DISTRIBUTIONS SYSTEMS, INCLUDING BRACING AND ATTACHMENTS
- REFERENCE SPECIFICATIONS FOR COMPLETE REQUIREMENTS
2. SUBMIT COMPLETE CALCULATIONS AND SHOP DRAWINGS, SIGNED AND SEALED BY THE PROFESSIONAL ENGINEER REGISTERED IN THE STATE OF NORTH CAROLINA RESPONSIBLE FOR THE DESIGN, INCLUDING DESIGN LOADINGS AND REACTIONS APPLIED TO THE SUPPORTING STRUCTURE. INCLUDE A SUMMARY OF THE CONTROLLING LOAD CASES FOR EACH LOCATION.
3. IN ADDITION TO THEIR OWN DEAD WEIGHT AND THE DEAD LOADS SHOWN OR INDICATED IN THE DRAWINGS, MEMBERS MUST BE DESIGNED TO SUPPORT THE LOADS INDICATED IN THE GENERAL NOTES.
4. CONNECTION DETAILS SHOWN ARE SCHEMATIC ONLY. ALL CONNECTIONS MUST BE DESIGNED AND DETAILED BY THE MANUFACTURER TO SUIT THE SPECIFIED LOADS. CONNECTIONS MUST ACCOUNT FOR THERMAL MOVEMENT, DEFLECTION, CREEP, MANUFACTURING TOLERANCES, AND ERECTION TOLERANCES. DETAIL ALL CONNECTIONS ON SHOP DRAWINGS.
5. THE CONTRACTOR MUST BE RESPONSIBLE FOR THE COORDINATION OF ALL SPECIALTY STRUCTURAL ELEMENTS AND COST ASSOCIATED WITH A CONTRACTOR INITIATED CHANGE IN BUILDING STRUCTURE, INCLUDING CONSTRUCTION COSTS AND RE-ENGINEERING COSTS.

WOOD DECK NOTES:

1. ROOF DECKING SHALL BE AS NOTED ON PLANS, TONGUE AND GROOVE CONTINUOUS LAY UP (NO LAPS).
2. ALL EXTERIOR EXPOSED STRUCTURAL WOOD DECKING AND BLOCKING, AND SHEATHING IS TO BE EXTERIOR GRADE PRESSURE PRESERVATIVE TREATED, MIN. RETENTION 0.25 PCF.
3. WOOD DECKING TO BE STRESS RATED DOUG FIR OR SPRUCE-PINE-FIR #1 OR BETTER.
4. SCREW LENGTH TO FIT APPLICATION. ALL SCREWS SHALL PENETRATE A MINIMUM OF 1 3/4" BUT NOT MORE THAN THE FULL THICKNESS OF THE MEMBER. INSTALL PER MANUFACTURER'S INSTRUCTIONS. NOTE: SIMPSON STRONG DRIVE SCREWS ARE DEFINED AS SELF-TAPPING. OTHER SCREWS TYPES MAY REQUIRE PRE-DRILLING. MINIMUM SCREW/BOLT SIZE #12, U.O.N.
5. STRUCTURAL MEMBERS WHOSE STRENGTH IS IMPAIRED BY IMPROPER CUTTING, DRILLING, OR EXCESSIVE DEFECTS SHALL BE REPLACED OR REINFORCED IN A MANNER ACCEPTABLE TO THE ARCHITECT.
6. FASTEN WOOD DECKING TO SUPPORTS WITH NOT LESS THAN #14 SCREWS AT 4" O.C.
7. WOOD STRUCTURAL PANELS (WSP) MUST COMPLY WITH PS 1 "U.S. PRODUCT STANDARD FOR CONSTRUCTION AND INDUSTRIAL PLYWOOD" FOR PLYWOOD CONSTRUCTION PANELS AND THE FOLLOWING REQUIREMENTS:

A. EXTERIOR WALL SHEATHING, SIZE INDICATED ON THE DRAWINGS APA RATED SHEATHING, EXPOSURE 1 DURABILITY CLASSIFICATION.
8. FIELD TREAT ALL CUTS AND ABRASIONS IN TREATED TIMBERS IN ACCORDANCE WITH THE AMERICAN WOOD PRESERVERS ASSOCIATION STANDARD M4. TRIM ALL CUTS AND ABRASIONS BEFORE FIELD TREATMENT. COAT ALL DEPRESSIONS OR OPENINGS AROUND BOLT HOLES, JOINTS OR GAPS INCLUDING RECESSES FORMED BY COUNTER BORING, WITH PRESERVATIVE TREATMENT USED FOR TIMBER
9. UNLESS OTHERWISE NOTED, ATTACHED BLOCKING AND NAILERS TO THE STEEL FRAMING USING 3/16 INCH DIAMETER POWDER ACTUATED FASTENERS AT 24 INCHES ON CENTER, STAGGER FASTENERS AT ALTERNATE SIDES OF BEAM WEB.
10. WHERE MULTIPLE FRAMING MEMBERS ARE INDICATED: SCAB CONTINGENT MEMBERS TOGETHER WITH 16d NAILS AT 12 INCHES ON CENTER, ALTERNATING AT 2 INCHES FROM EACH EDGE.

POST-INSTALLED ANCHOR NOTES:

1. ANCHORS TO BE POST-INSTALLED ONLY WHERE INDICATED ON CONSTRUCTION DOCUMENTS. ANY SUBSTITUTE OF CAST-IN ANCHOR TO POST-INSTALLED ANCHORS MUST BE SUBMITTED AS A REQUEST FOR DEVIATION TO THE ENGINEER OF RECORD PRIOR TO CONSTRUCTION.
2. ALL POST INSTALLED ANCHORS INDICATED ON THE DRAWINGS ARE BY HILTI, INC. AND MUST BE CONSIDERED THE BASIS OF DESIGN PRODUCT. WHERE NOT EXPLICITLY INDICATED IN THE DRAWINGS, THE FOLLOWING ANCHORS/ADHESIVES MUST BE USED:

A. ANCHORAGE TO CONCRETE

1. ADHESIVE ANCHORS FOR CRACKED AND UNCRACKED CONCRETE USE:

a. HILTI HIT-HY 200 SAFE SET SYSTEM WITH HILTI HOLLOW DRILL BIT (TE-CD OR TE-YD) AND VC 20/40 VACUUM SYSTEM (VC 20-U OR VC40U) WITH STEEL THREADED ROD PER ICC ESR-3187.

2. SCREW ANCHORS FOR CRACKED AND UNCRACKED CONCRETE USE:

a. HILTI KWIK HUS EZ SCREW ANCHORS PER ICC ESR-3027.

B. REBAR DOWELING INTO CONCRETE

1. ADHESIVE ANCHORS FOR CRACKED AND UNCRACKED CONCRETE USE:

a. HILTI HIT-HY 200 SAFE SET SYSTEM WITH HILTI HOLLOW DRILL BIT (TE-CD OR TE-YD) AND VC 20/40 VACUUM SYSTEM (VC 20-U OR VC 40-U) WITH CONTINUOUSLY DEFORMED REBAR PER ICC ESR-3187.

C. ANCHORAGE TO SOLID GROUTED MASONRY

1. ADHESIVE ANCHORS USE:

a. HILTI HIT-HY 270 MASONRY ADHESIVE ANCHORING SYSTEM (ICC PENDING).

b. STEEL ANCHOR ELEMENT MUST BE HILTI HAS-E CONTINUOUSLY THREADED ROD.

2. MECHANICAL ANCHORS USE:

a. HILTI KWIK HUS EZ SCREW ANCHORS PER ICC ESR 3056.

D. ANCHORAGE TO HOLLOW / MULTI-WYTHE MASONRY

1. ADHESIVE ANCHORS USE:

a. HILTI HIT-HY 270 MASONRY ADHESIVE ANCHORING SYSTEM PERICCESR-3342.

b. STEEL ANCHOR ELEMENT MUST BE HILTI HAS-E CONTINUOUSLY THREADED ROD OR CONTINUOUSLY DEFORMED STEEL REBAR.

c. THE APPROPRIATE SIZE SCREEN TUBE MUST BE USED PER ADHESIVE MANUFACTURER'S RECOMMENDATION.

3. ALTERNATE POST INSTALLED ANCHOR PRODUCTS MAY BE SUBMITTED TO THE ENGINEER FOR REVIEW AND POSSIBLE APPROVAL. ALL SUBSTITUTION REQUESTS MUST BE ACCOMPANIED BY AN ICC ESR SHOWING COMPLIANCE WITH THE RELEVANT BUILDING CODE FOR SEISMIC USES, LOAD RESISTANCE, INSTALLATION CATEGORY, AND COMPREHENSIVE INSTALLATION INSTRUCTIONS. ADHESIVE ANCHOR EVALUATION WILL ALSO CONSIDER CREEP, IN-SERVICE TEMPERATURE AND INSTALLATION TEMPERATURE. ALTERNATE PRODUCTS MAY REQUIRE MODIFICATIONS TO ANCHOR DIAMETER, SPACING, AND EMBEDMENT.

4. INSTALL ANCHORS PER THE MANUFACTURER INSTRUCTIONS, AS INCLUDED IN THE ANCHOR PACKAGING.

5. THE CONTRACTOR MUST ARRANGE FOR AN ANCHOR MANUFACTURER'S REPRESENTATIVE TO PROVIDE ONSITE INSTALLATION TRAINING FOR ALL OF THEIR ANCHORING PRODUCTS SPECIFIED. THE STRUCTURAL ENGINEER OF RECORD MUST RECEIVE DOCUMENTED CONFIRMATION THAT ALL OF THE CONTRACTOR'S PERSONNEL WHO INSTALL ANCHORS ARE TRAINED PRIOR TO THE COMMENCEMENT OF ANCHOR INSTALLATION.

6. ANCHOR CAPACITY IS DEPENDANT UPON SPACING BETWEEN ADJACENT ANCHORS AND PROXIMITY OF ANCHORS TO EDGE OF CONCRETE. INSTALL ANCHORS IN ACCORDANCE WITH SPACING AND EDGE CLEARANCES INDICATED ON THE DRAWINGS.

7. EXISTING REINFORCING BARS IN THE CONCRETE STRUCTURE MAY CONFLICT WITH SPECIFIC ANCHOR LOCATIONS. UNLESS NOTED ON THE DRAWINGS THAT THE BARS CAN BE CUT, THE CONTRACTOR MUST LOCATE THE POSITION OF THE REINFORCING BARS AT THE LOCATIONS OF THE CONCRETE ANCHORS, BY FERROSCAN OR GPR.

8. ALL POST INSTALLED ANCHORS REQUIRE CONTINUOUS INSPECTIONS BY THE OWNER'S MATERIALS TESTING AGENCY TO VERIFY INSTALLATION HAS BEEN PERFORMED IN ACCORDANCE WITH THE MANUFACTURER'S WRITTEN INSTRUCTIONS.

ABBREVIATIONS

AFF	ABOVE FINISHED FLOOR	KCJ	KEYED CONSTRUCTION JOINT
ARCH	ARCHITECT	Ld	REBAR TENSION
BD	BAR DIAMETER		DEVELOPMENT LENGTH
BF	BRACED FRAME	Ldc	REBAR COMPRESSION
BEJ	BUILDING EXPANSION JOINT		DEVELOPMENT LENGTH
BLDG	BUILDING	Ldh	HOKED REBAR TENSION
BM	BEAM		DEVELOPMENT LENGTH
BOD	BOTTOM OF DECK	Ls	REBAR TENSION SPLICE
BOS	BOTTOM OF STEEL		LENGTH
BOT, B	BOTTOM	Lsc	REBAR COMPRESSION SPLICE
BRG	BEARING		LENGTH
BTWN	BETWEEN	L	LOW
C TO C	CENTER TO CENTER	LLH	LONG LEG HORIZONTAL
CFMF	COLD-FORMED METAL FRAMING	LLV	LONG LEG VERTICAL
		LSH	LONG SIDE HORIZONTAL
CJ	CONTROL JOINT	LSV	LONG SIDE VERTICAL
CL	CENTERLINE	LTWT	LIGHTWEIGHT
CLR	CLEAR	LWC	LIGHTWEIGHT CONCRETE
CMU	CONCRETE MASONRY UNIT	MAS	MASONRY
COL	COLUMN	MATL	MATERIAL
CONC	CONCRETE	MAX	MAXIMUM
CONN	CONNECTION	MECH	MECHANICAL
CONSTR	CONSTRUCTION	MF	MOMENT FRAME
CONT	CONTINUOUS	MFR	MANUFACTURER
COORD	COORDINATE	MID	MIDDLE
CTR	CENTER	MIN	MINIMUM
CTRD	CENTERED	MOD	MODIFY
DBA	DEFORMED BAR ANCHOR	MOS	MIDDEPTH OF SLAB
DBL	DOUBLE	NOM	NOMINAL
DC	DIAPHRAGM CHORD	NS	NEAR SIDE
DCJ	DOWELED CONSTRUCTION JOINT	NTS	NOT TO SCALE
		OC	ON CENTER
DIA, Ø	DIAMETER	OPH	OPPOSITE HAND
DIST	DISTANCE	OPNG	OPENING
DJ	DOUBLE JOIST	PAF	POWDER ACTUATED
DWGS	DRAWINGS		FASTENER
EA	EACH	PAR	PARALLEL
EF	EACH FACE	PC	PIECE
EJ	EXPANSION JOINT	PEMB	PRE-ENGINEERED METAL BUILDING
EL	ELEVATION		
ELEV	ELEVATOR	PEN	PENETRATE, PENETRATION
EMBED	EMBEDMENT	PERP	PERPENDICULAR
EOD	EDGE OF DECK	PL	PLATE
EOS	EDGE OF SLAB	PT	POST-TENSIONED (CONC)
EQ	EQUAL		PRESSURE TREATED (WOOD)
EW	EACH WAY	R	RADIUS
EXIST	EXISTING	REF	REFERENCE, REFER TO
EXP	EXPANSION	REINF	REINFORCE, REINFORCED, REINFORCING
EXT	EXTERIOR		
FD	FLOOR DRAIN	REQD	REQUIRED
FDN	FOUNDATION	REQMTS	REQUIREMENTS
FO	FACE OF	SCHED	SCHEDULE
FF EL	FINISHED FLOOR ELEVATION	SF	STEPPED FOOTING
FIN	FINISH	SGB	STEPPED GRADE BEAM
FIN FLR	FINISHED FLOOR	SIM	SIMILAR
FOB	FACE OF BUILDING	SJ	SAWED JOINT
FOC	FACE OF CONCRETE	SL	SLOPE
FOM	FACE OF MASONRY	SOG	SLAB-ON-GRADE
FOS	FACE OF SLAB/ STUD	SPF	SIDEPLATE FRAME
FRMG	FRAMING	STD	STANDARD
FTG	FOOTING	STIFF	STIFFENER
FS	FAR SIDE	TBE	TRUSS BEARING ELEVATION
FV, ±	FIELD VERIFY	T&B	TOP & BOTTOM
GALV	GALVANIZED	T&G	TONGUE AND GROOVE
GC	GENERAL CONTRACTOR	THK	THICKNESS
GEN	GENERAL	TOC	TOP OF CONCRETE
GR BM	GRADE BEAM	TOF	TOP OF FOOTING
H	HIGH	TOM	TOP OF MASONRY
HK	HOOK	TOCP	TOP OF CONCRETE PEDESTAL
HORIZ	HORIZONTAL	TOS	TOP OF STEEL
HSS	HOLLOW STRUCTURAL SECTION	TS	THICKENED SLAB
		TS/STR	THICKENED SLAB AT STAIR
HSA	HEADED STUD ANCHOR	TYP	TYPICAL
HT	HEIGHT	UON	UNLESS OTHERWISE NOTED
HVY	HEAVY	VERT	VERTICAL
INT	INTERIOR	W/	WITH
JBE	JOIST BEARING ELEVATION	WP	WORKING POINT
JT	JOINT	WSP	WOOD STRUCTURAL PANEL(S)
KCJ	KEYED CONSTRUCTION JOINT	WWR	WELDED WIRE REINFORCING

IMEG RESERVES PROPRIETARY RIGHTS, INCLUDING COPYRIGHTS, TO THIS DRAWING AND THE DATA SHOWN THEREON. SAID DRAWING AND/OR DATA ARE THE EXCLUSIVE PROPERTY OF IMEG AND SHALL NOT BE USED OR REPRODUCED FOR ANY OTHER PROJECT WITHOUT THE EXPRESS WRITTEN APPROVAL AND PARTICIPATION OF IMEG. ©2025 IMEG CONSULTANTS CORP. North Carolina Design Registration #F-1507

Susan Hatchell
Landscape Architecture, PLLC
711 W. North Street, Raleigh, NC 27603
p. 919-838-9600 f. 919-838-9700


GENERAL NOTES

LAKE MYRA COUNTY PARK
Wake County, NC

REVISIONS

Date07/27/2026

MF-S003

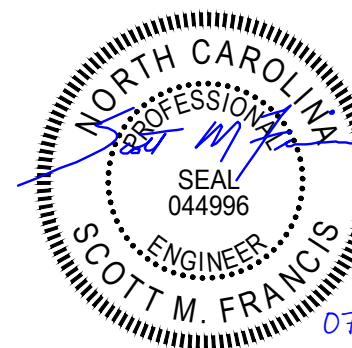

IMEG RESERVES PROPRIETARY RIGHTS,
INCLUDING COPYRIGHTS, TO THIS DRAWING AND
THE DATA SHOWN THEREON. SAID DRAWING
AND/OR DATA ARE THE EXCLUSIVE PROPERTY OF
IMEG AND SHALL NOT BE USED OR REPRODUCED
FOR ANY OTHER PROJECT WITHOUT THE EXPRESS
WRITTEN APPROVAL AND PARTICIPATION OF IMEG.
©2025 IMEG CONSULTANTS CORP.

GENERAL NOTES


LAKE MYRA COUNTY PARK
Wake County, NC

REVISIONS

Date07/27/2026

MF-S004


Susan Hatchell
Landscape Architecture, PLLC
711 W. North Street, Raleigh, NC 27603
p: 919-838-9600 f: 919-838-9700

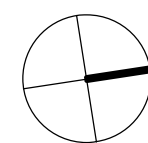

A1

MAINTENANCE FACILITY ROOF FRAMING PLAN

1/8" = 1'-0"

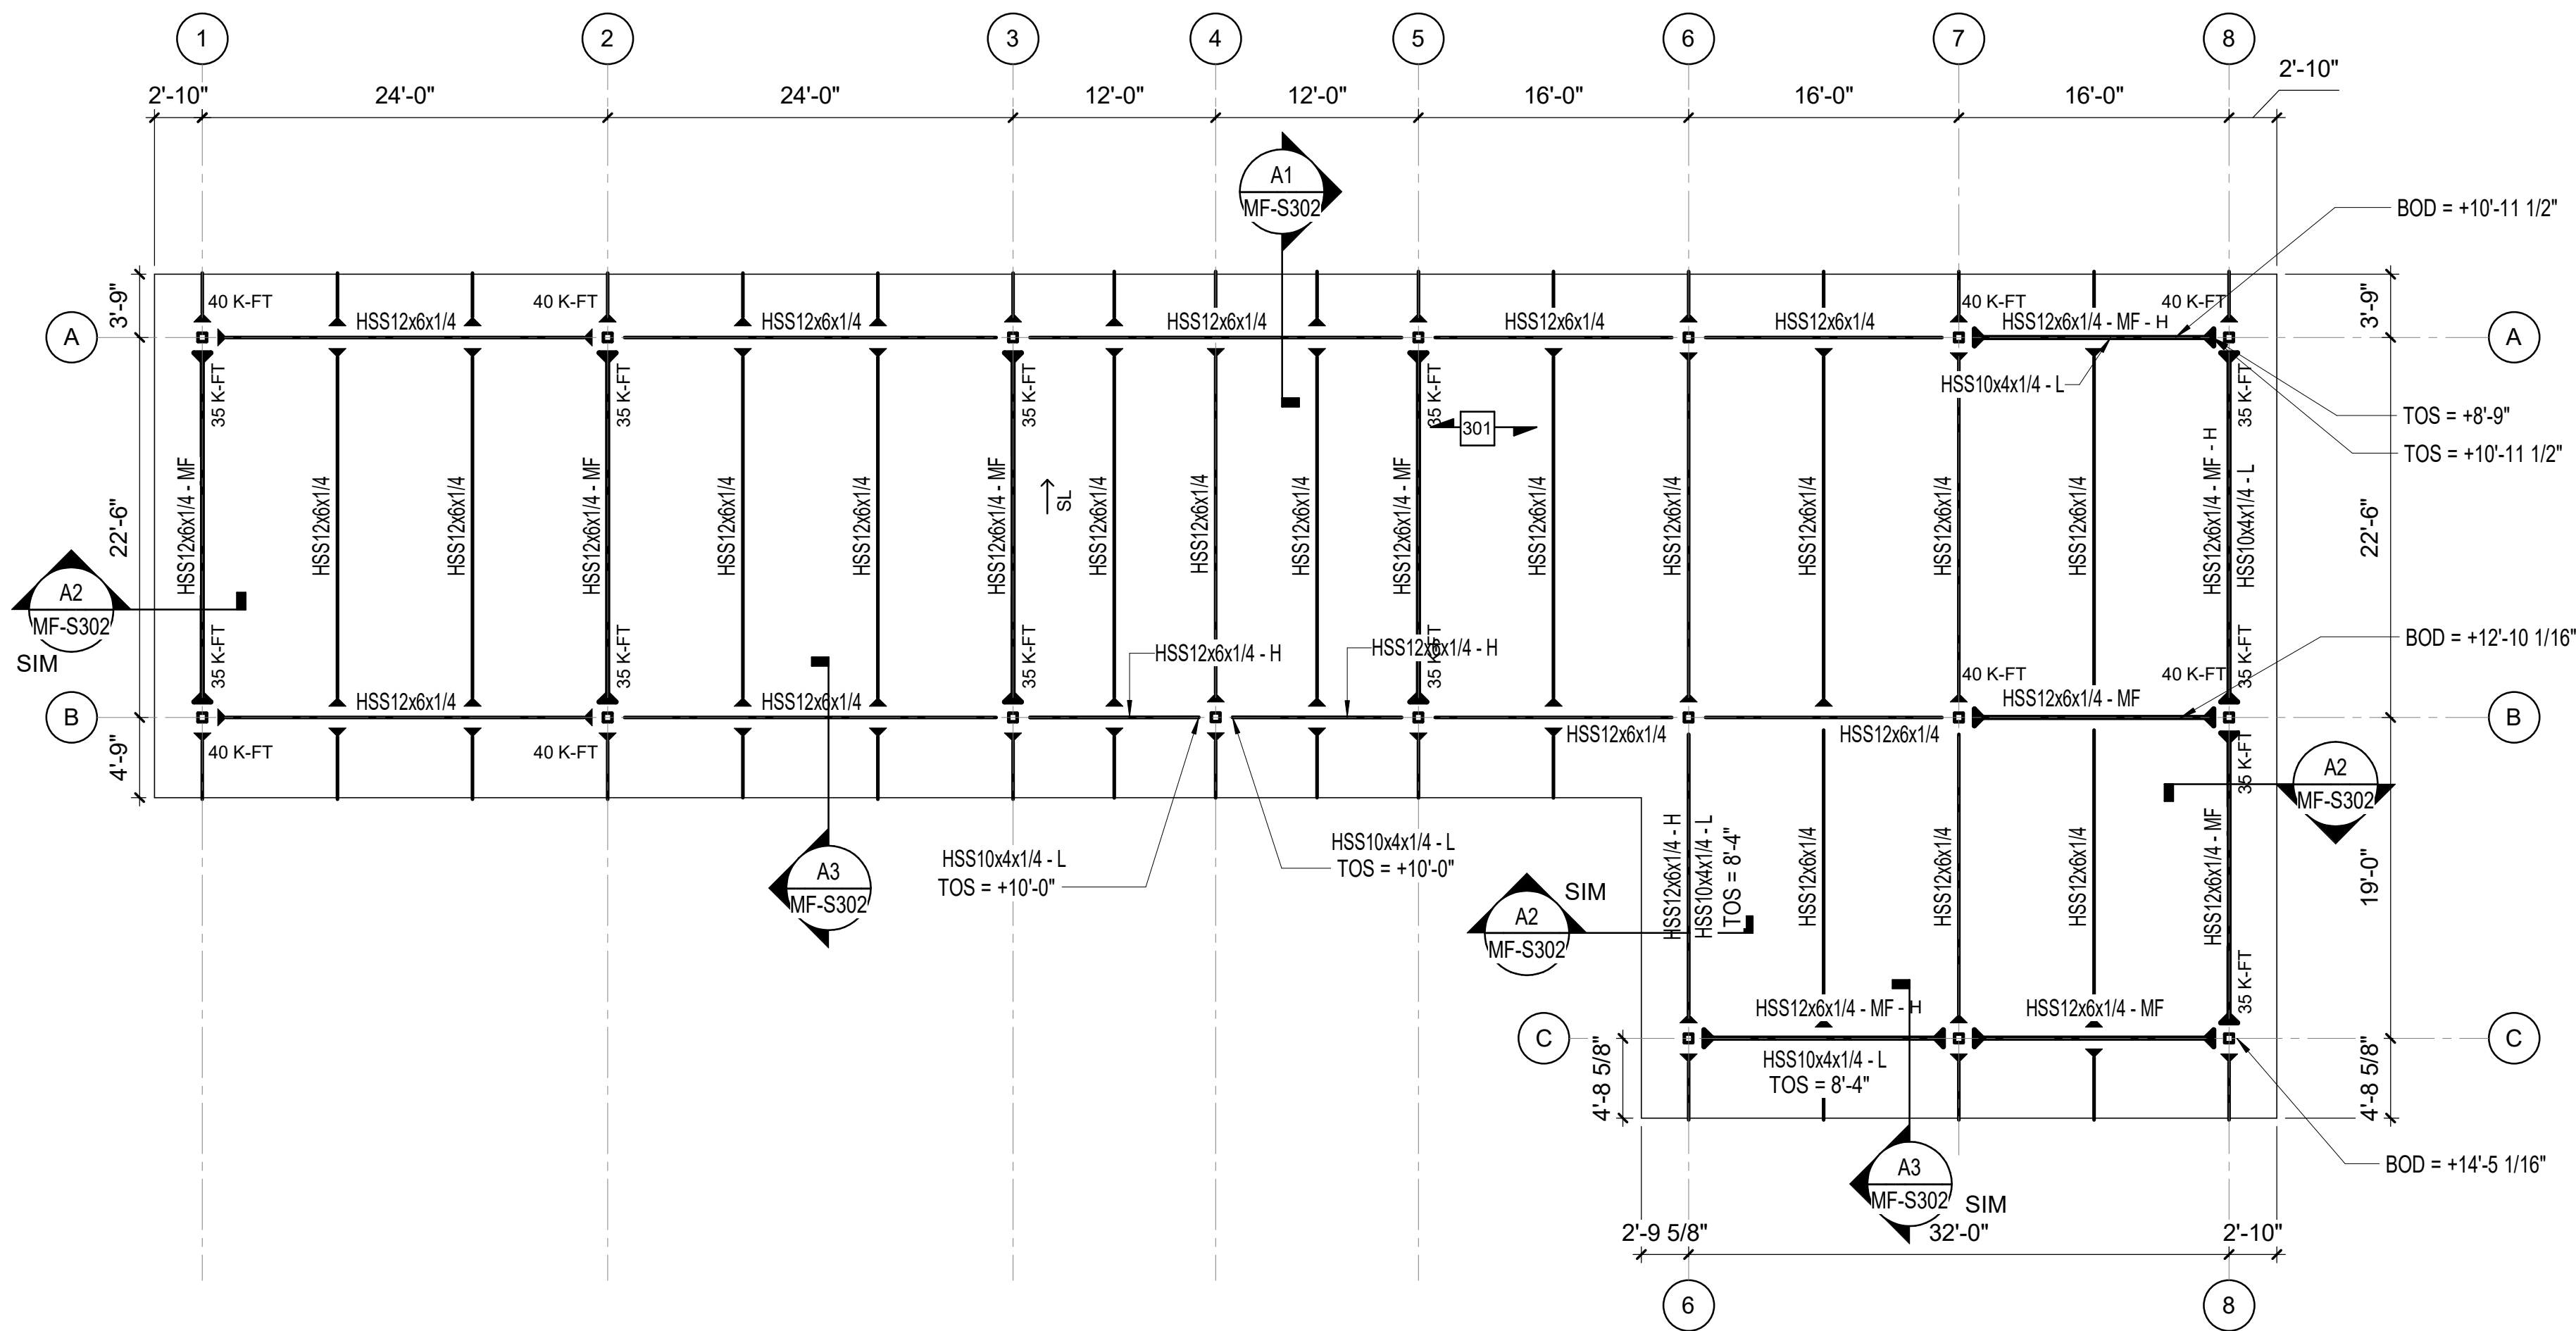


FRAMING PLAN NOTES

- A. REFERENCE FOUNDATION PLAN AND ARCHITECTURAL DRAWINGS FOR DIMENSIONS NOT SHOWN.
- B. TOP OF FINISHED FLOOR ELEVATION MUST BE AS NOTED ON SLAB PLANS.
- C. COMPOSITE STEEL BEAM FRAMING MUST BE EQUALLY SPACED BETWEEN POINTS OF KNOWN DIMENSIONS (NOT TO EXCEED 10'-0" ON-CENTER).
- D. CONCRETE ON ELEVATED METAL DECKS MUST BE POURED TO THE THICKNESS INDICATED.
- E. AT STEEL ROOF FRAMING, BOTTOM OF DECK ELEVATIONS ARE SHOWN ON PLAN. INTERMEDIATE ELEVATIONS MUST BE STRAIGHT LINES BETWEEN GIVEN ELEVATIONS. INTERPOLATE AS REQUIRED FOR INTERMEDIATE BEARING ELEVATIONS, UNLESS OTHERWISE NOTED.
- F. COORDINATE AND VERIFY ALL MEMBER LOCATIONS, DIMENSIONS, WEIGHTS, OPENING SIZES, AND CURB DIMENSIONS FOR ALL MECHANICAL EQUIPMENT WITH THE ACTUAL EQUIPMENT FURNISHED. INCLUDE THIS INFORMATION ON THE JOIST AND STRUCTURAL STEEL SHOP DRAWINGS.

KEY NOTES

301 2x6 TONGUE AND GROOVE WOOD DECKING WITH 9/16" PLYWOOD.

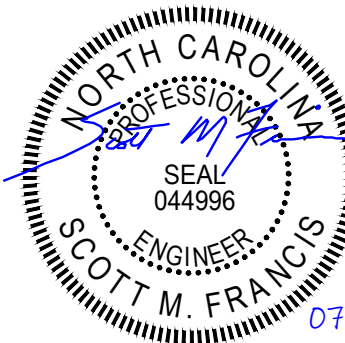

lynchmykins
now **IMEG**

301 N WEST STREET, SUITE 105
RALEIGH, NC 27603
919.782.1833 www.imegcorp.com

IMEG RESERVES PROPRIETARY RIGHTS, INCLUDING COPYRIGHTS, TO THIS DRAWING AND THE DATA SHOWN THEREON. SAID DRAWING AND/OR DATA ARE THE EXCLUSIVE PROPERTY OF IMEG AND SHALL NOT BE USED OR REPRODUCED FOR ANY OTHER PROJECT WITHOUT THE EXPRESS WRITTEN APPROVAL AND PARTICIPATION OF IMEG.
©2025 IMEG CONSULTANTS CORP.
North Carolina Design Registration #F-1507

MAINTENANCE
FACILITY ROOF
FRAMING PLAN

LAKE MYRA COUNTY PARK
Wake County, NC

REVISIONS


Date07/27/2026

MF-S102


Susan Hatchell
Landscape Architecture, PLLC
711 W. North Street, Raleigh, NC 27603
p: 919-838-9600 f: 919-838-9700

lynchmykins
now **IMEG**


301 N WEST STREET, SUITE 105
RALEIGH, NC 27603
919.782.1833 www.imegcorp.com

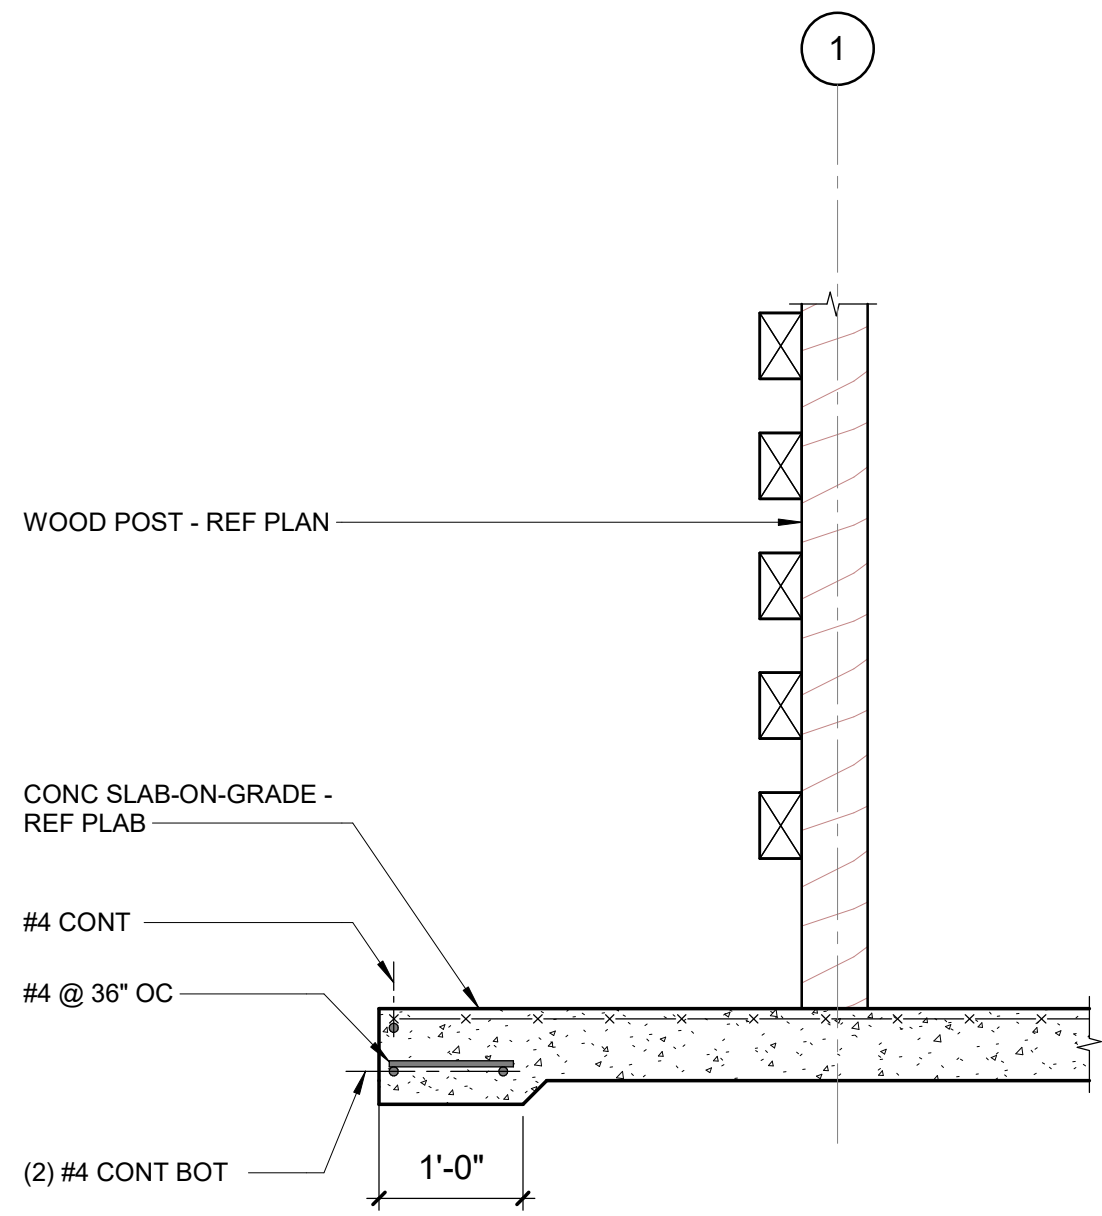


B1 SECTION
3/4" = 1'-0"

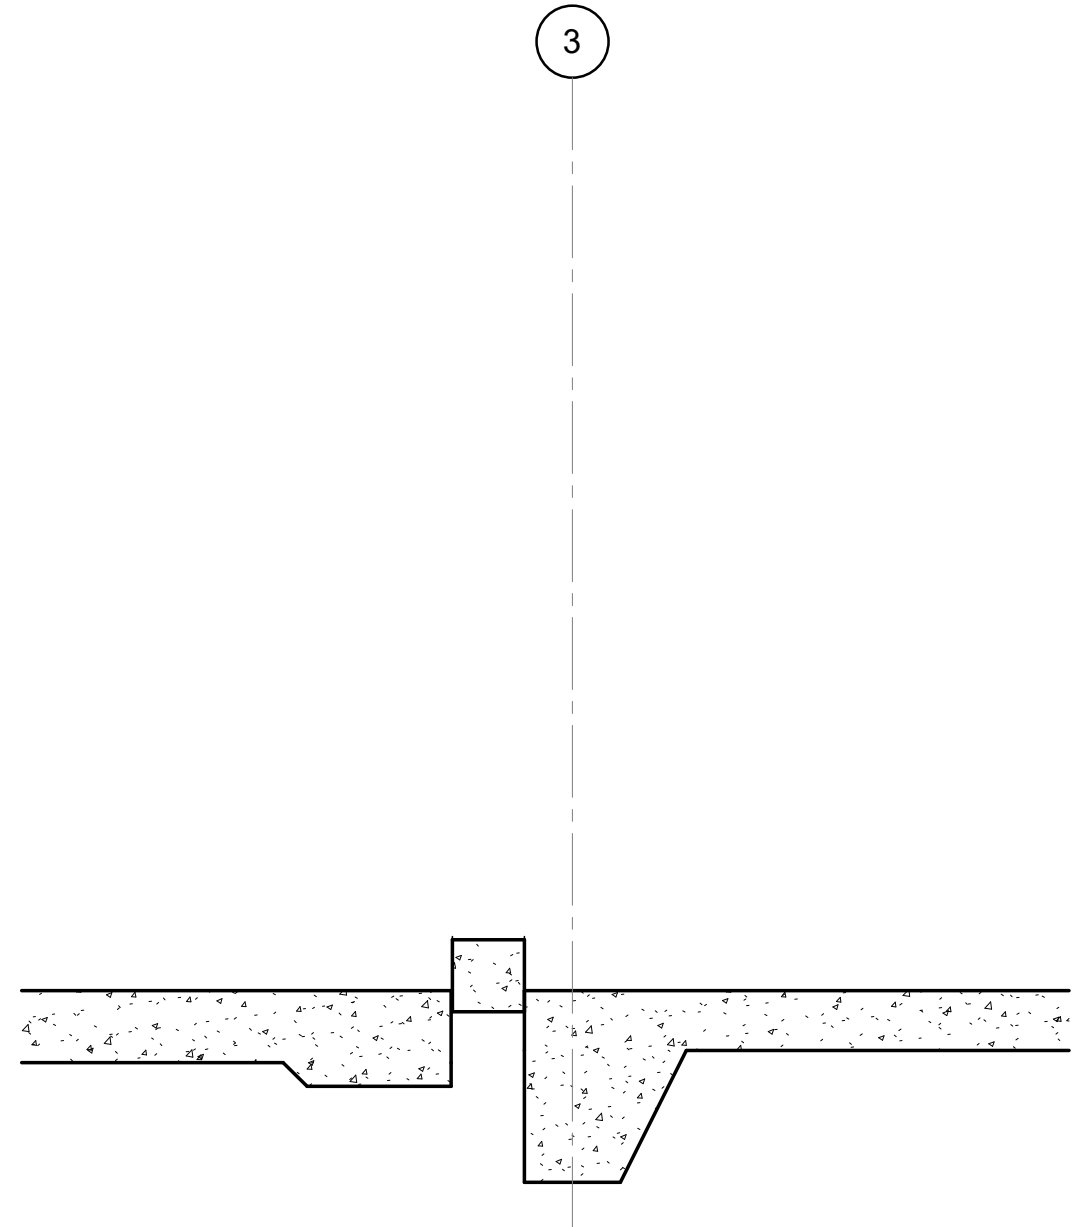

B2 SECTION
3/4" = 1'-0"

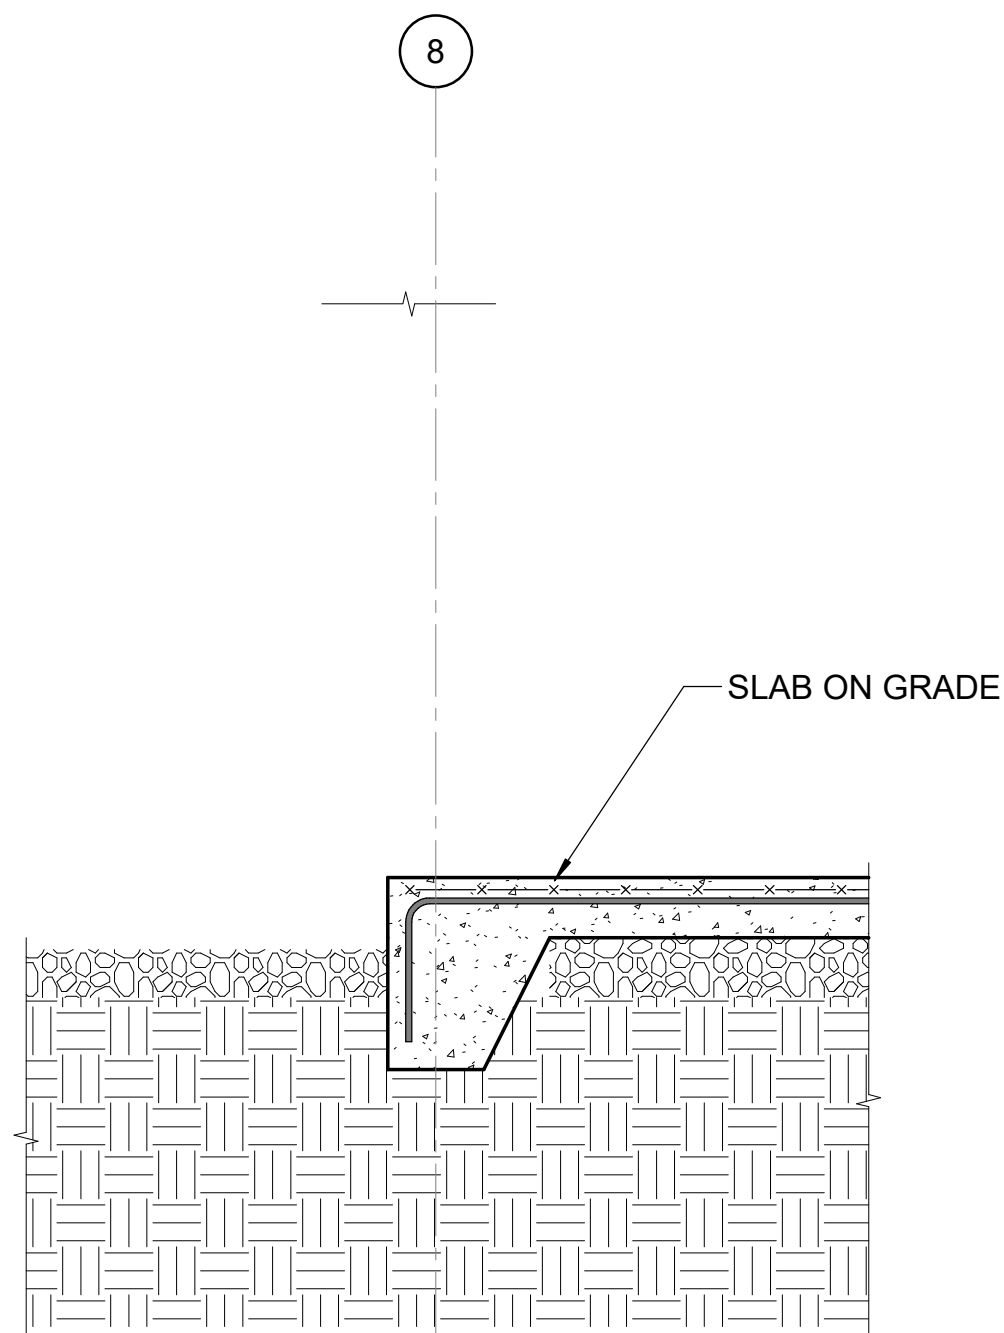


A1 SECTION AT SLAB EDGE
3/4" = 1'-0"

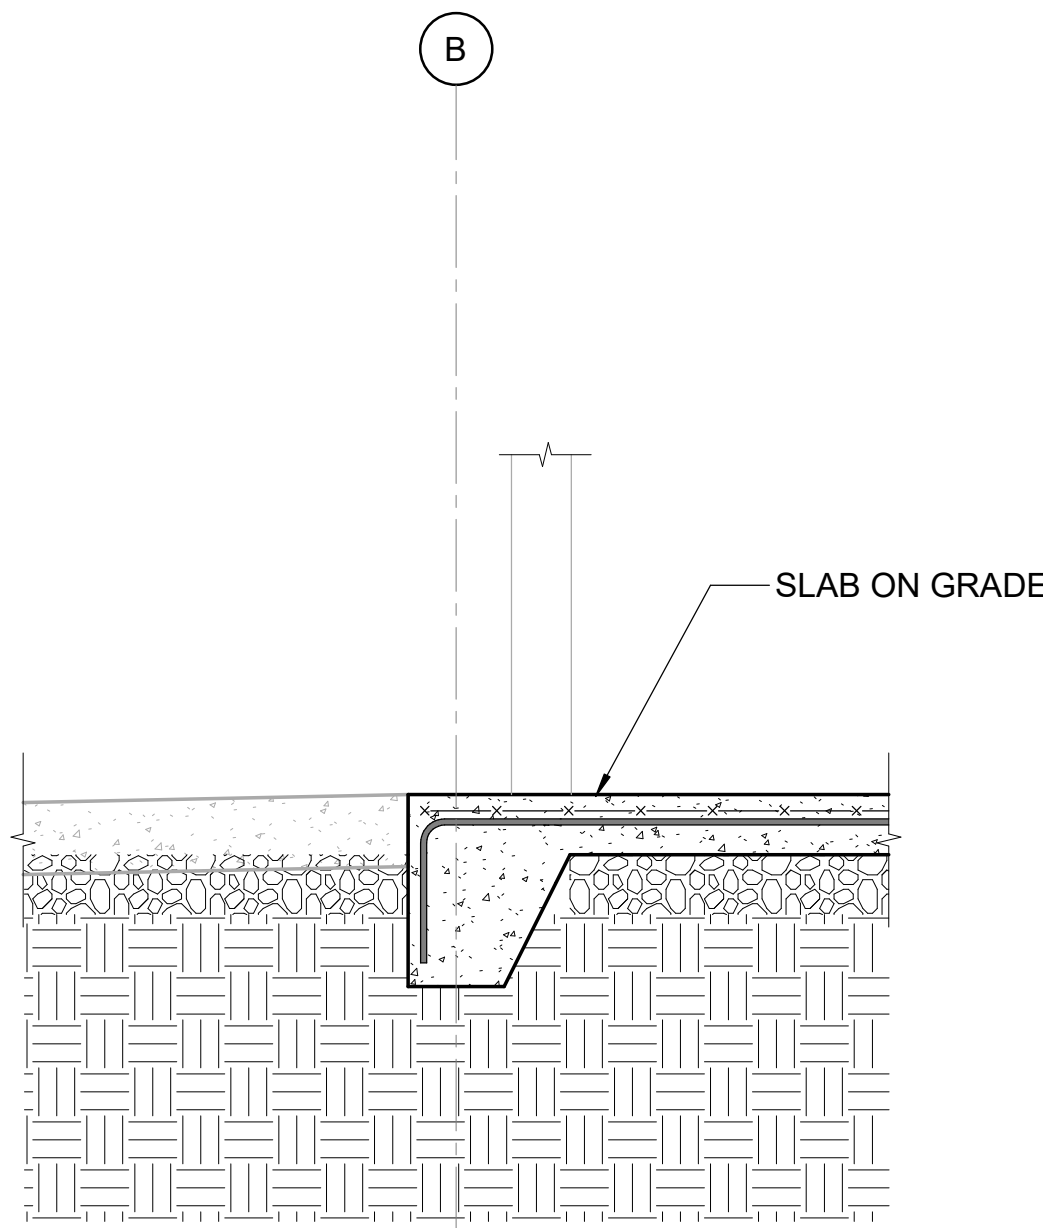


A2 SECTION AT SLAB EDGE
3/4" = 1'-0"

FOR DETAILS
NOT NOTED REF
A1 / MF-S301

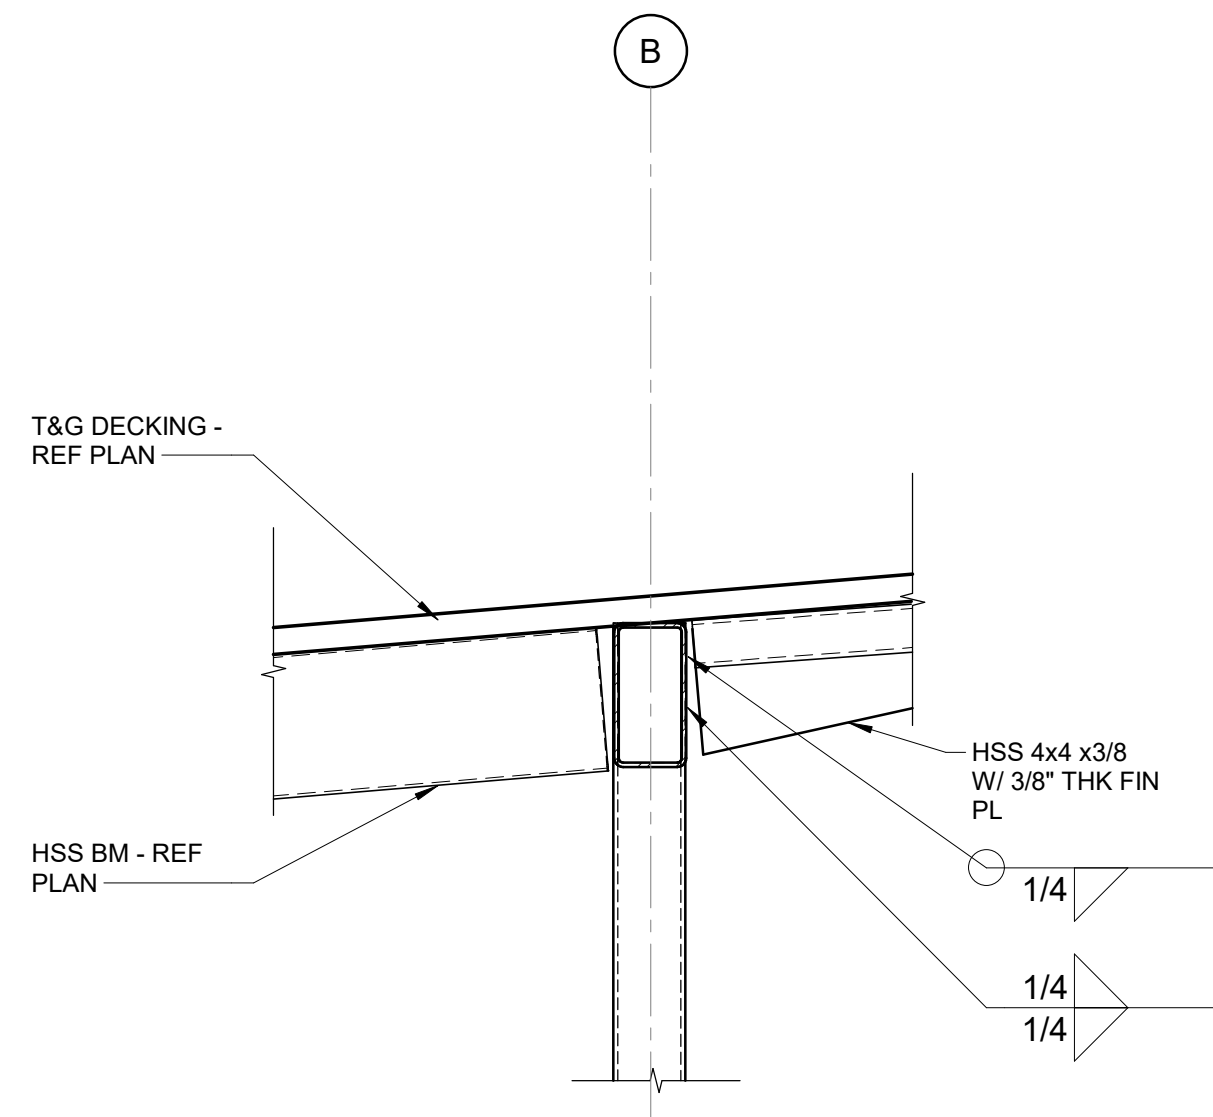

A3 CONNECTION DETAIL
3/4" = 1'-0"

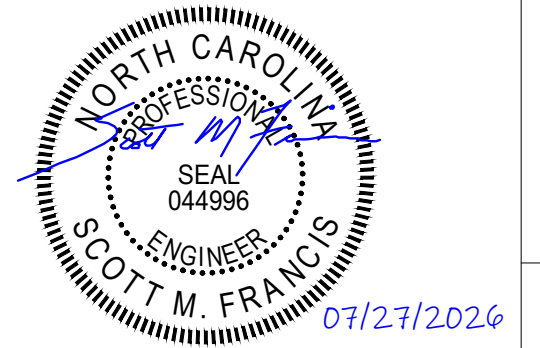


IMEG
 301 N WEST STREET, SUITE 105
 RALEIGH, NC 27603
 919.782.1833 www.imegcorp.com
IMEG RESERVES PROPRIETARY RIGHTS, INCLUDING COPYRIGHTS, TO THIS DRAWING AND THE DATA SHOWN THEREON. SAID DRAWING AND/OR DATA ARE THE EXCLUSIVE PROPERTY OF IMEG AND SHALL NOT BE USED OR REPRODUCED FOR ANY OTHER PROJECT WITHOUT THE EXPRESS WRITTEN APPROVAL AND PARTICIPATION OF IMEG. ©2025 IMEG CONSULTANTS CORP. North Carolina Design Registration #F-1507

Susan Hatchell
 Landscape Architecture, PLLC
 711 W. North Street, Raleigh, NC 27603
 p: 919-838-9600 f: 919-838-9700


lynch mykins
 now **IMEG**
 301 N WEST STREET, SUITE 105
 RALEIGH, NC 27603
 919.782.1833 www.imegcorp.com

SECTIONS


LAKE MYRA COUNTY PARK
Wake County, NC

REVISIONS


Date 07/27/2026
 MF-S301

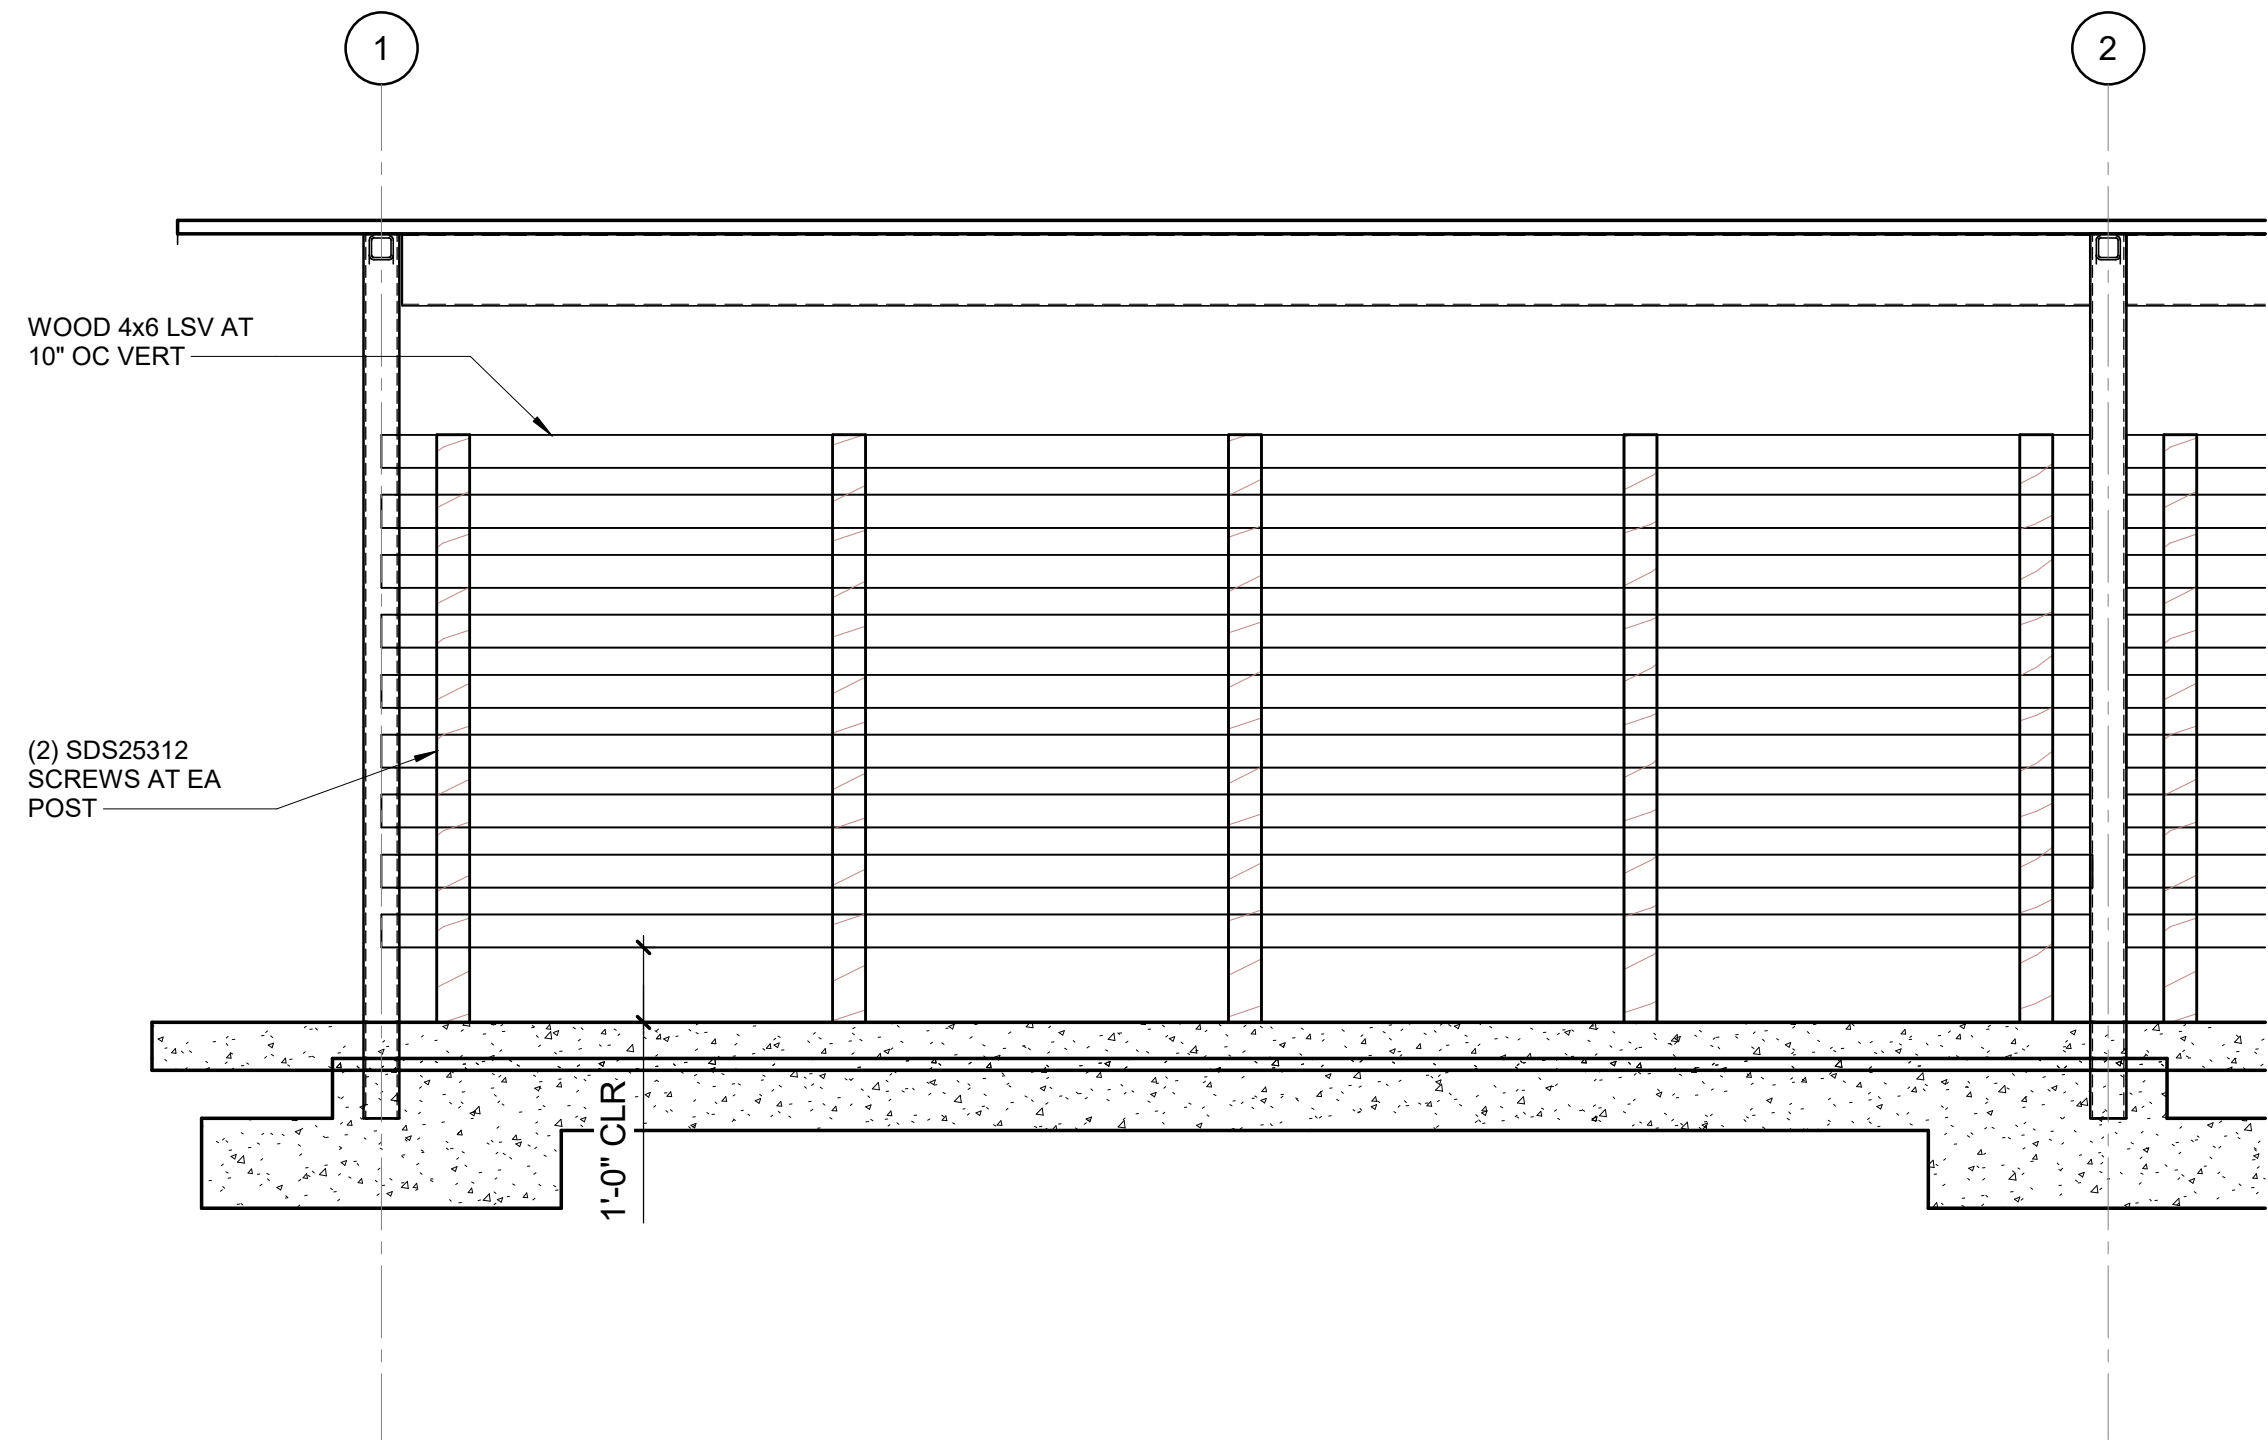


B1 SCREENWALL ELEVATION
3/8" = 1'-0"

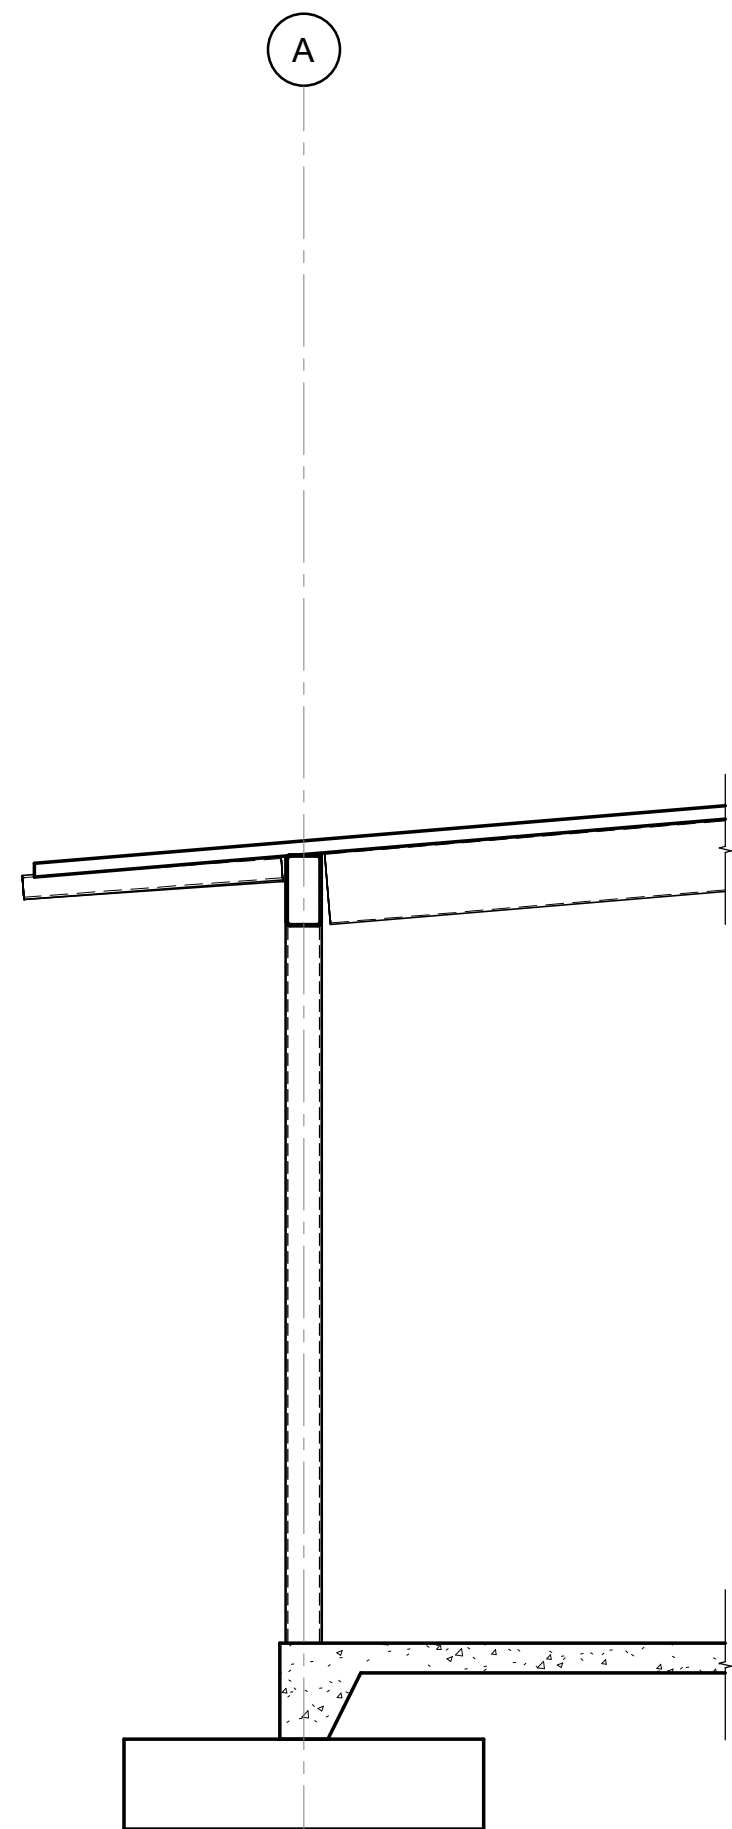


A1 SECTION
3/8" = 1'-0"

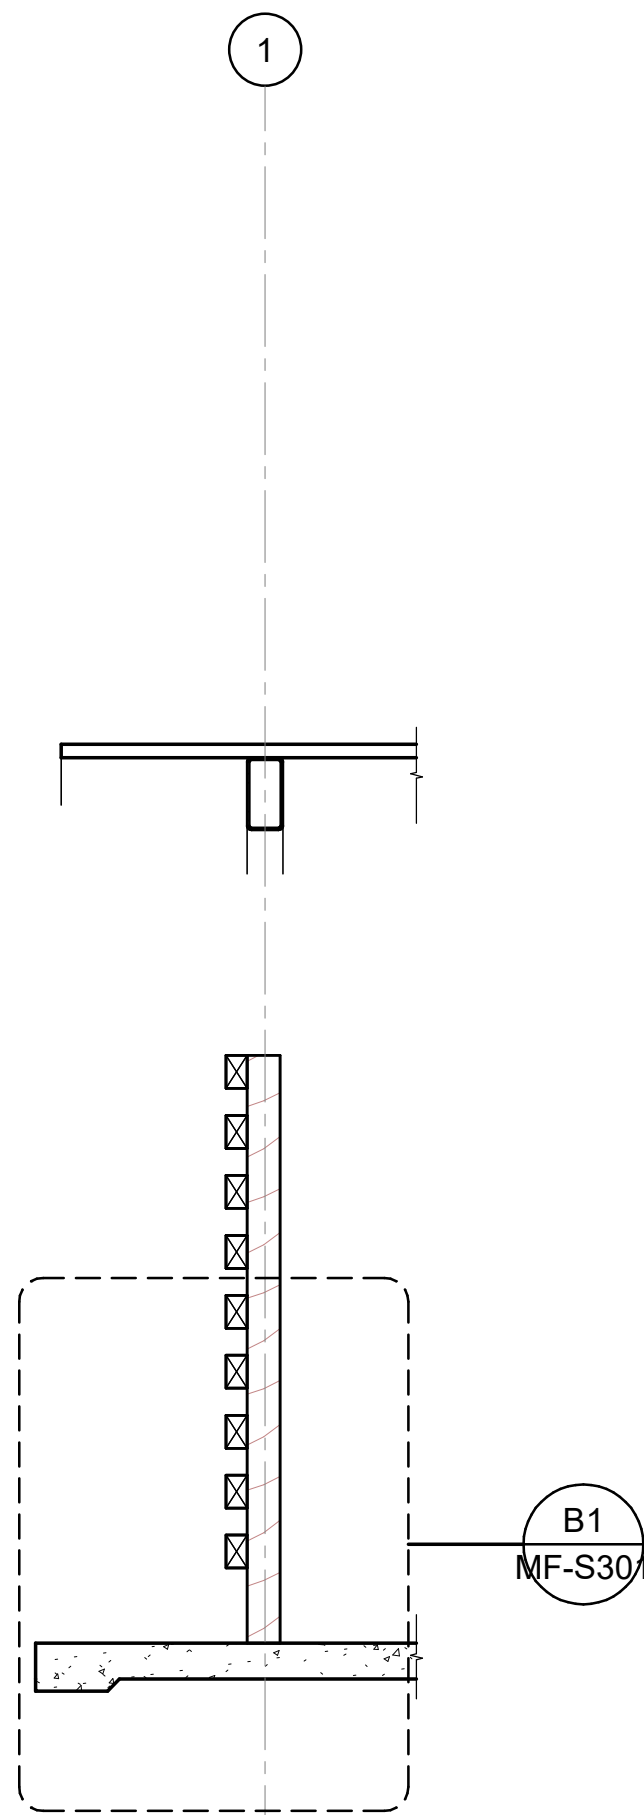

A2 SECTION
3/8" = 1'-0"

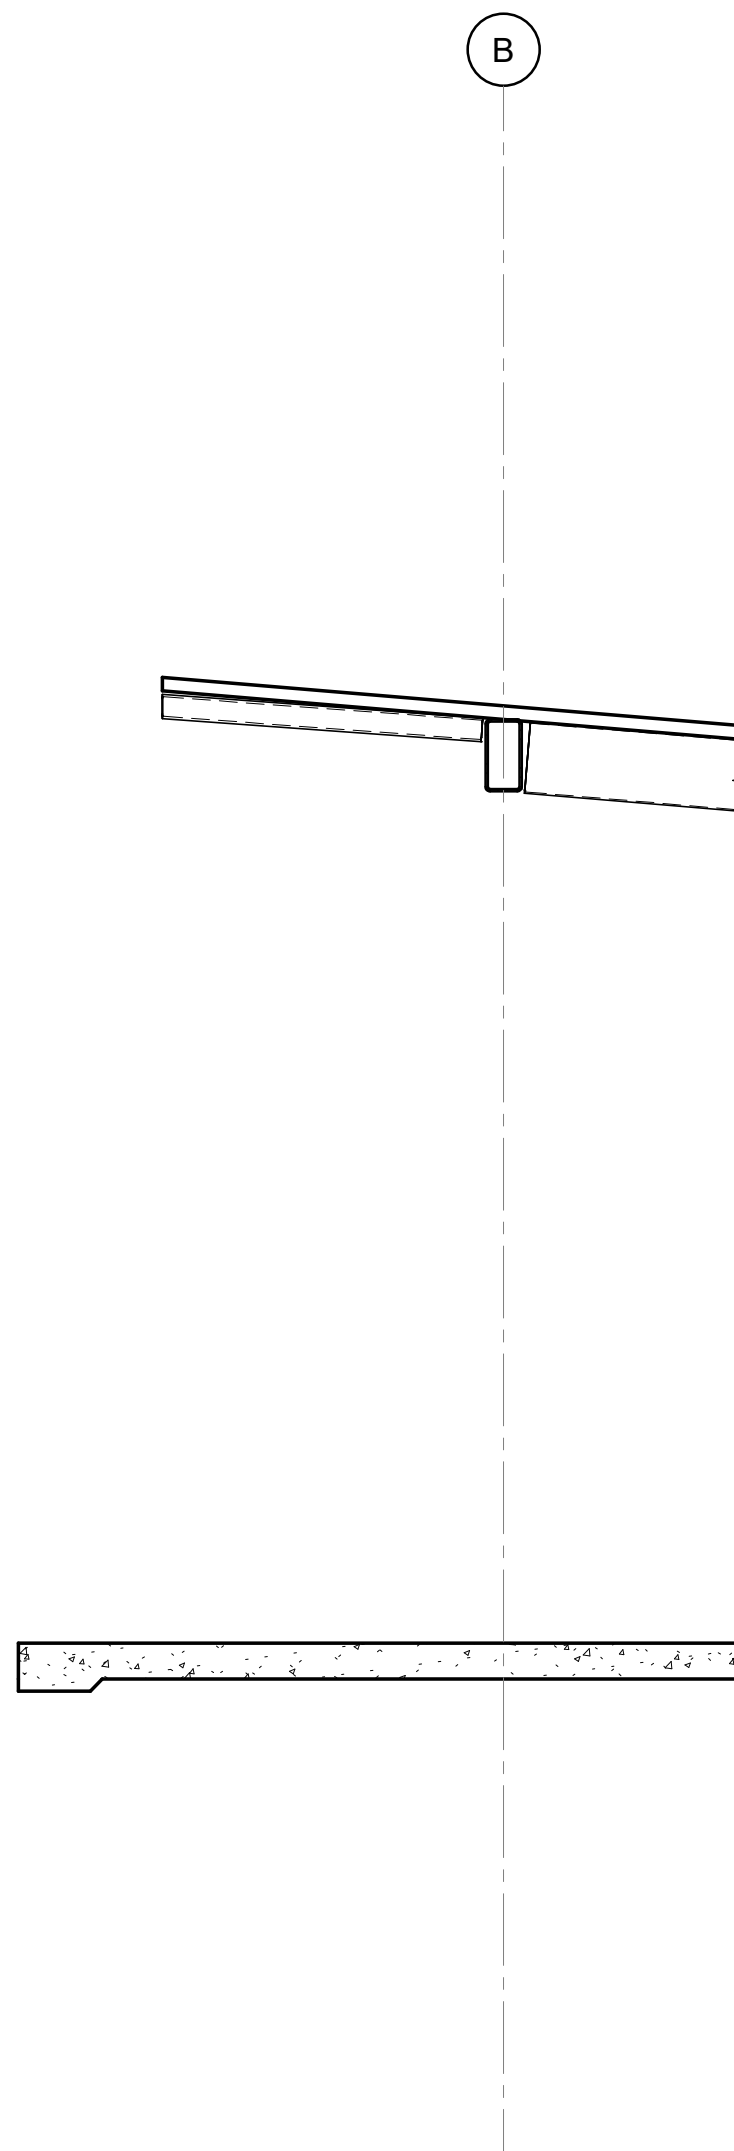

A3 SECTION
3/8" = 1'-0"

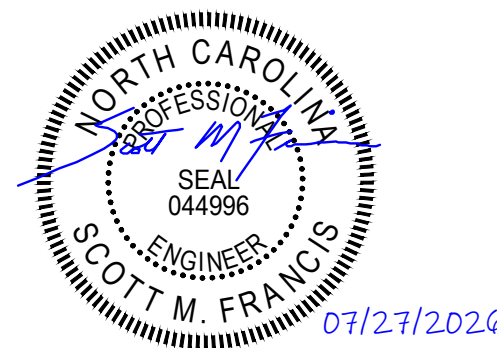

lynchmykins
now **IMEG**

301 N WEST STREET, SUITE 105
RALEIGH, NC 27603
919.782.1833 www.imegcorp.com

IMEG RESERVES PROPRIETARY RIGHTS, INCLUDING COPYRIGHTS, TO THIS DRAWING AND THE DATA SHOWN THEREON. SAID DRAWING AND/OR DATA ARE THE EXCLUSIVE PROPERTY OF IMEG AND SHALL NOT BE USED OR REPRODUCED FOR ANY OTHER PROJECT WITHOUT THE EXPRESS WRITTEN APPROVAL AND PARTICIPATION OF IMEG. ©2025 IMEG CONSULTANTS CORP. North Carolina Design Registration #F-1507

Susan Hatchell
Landscape Architecture, PLLC
711 W. North Street, Raleigh, NC 27603
p: 919-838-9600 f: 919-838-9700

lynchmykins
now **IMEG**


301 N WEST STREET, SUITE 105
RALEIGH, NC 27603
919.782.1833 www.imegcorp.com

SECTIONS


LAKE MYRA COUNTY PARK
Wake County, NC

REVISIONS

Date 07/27/2026
MF-S302

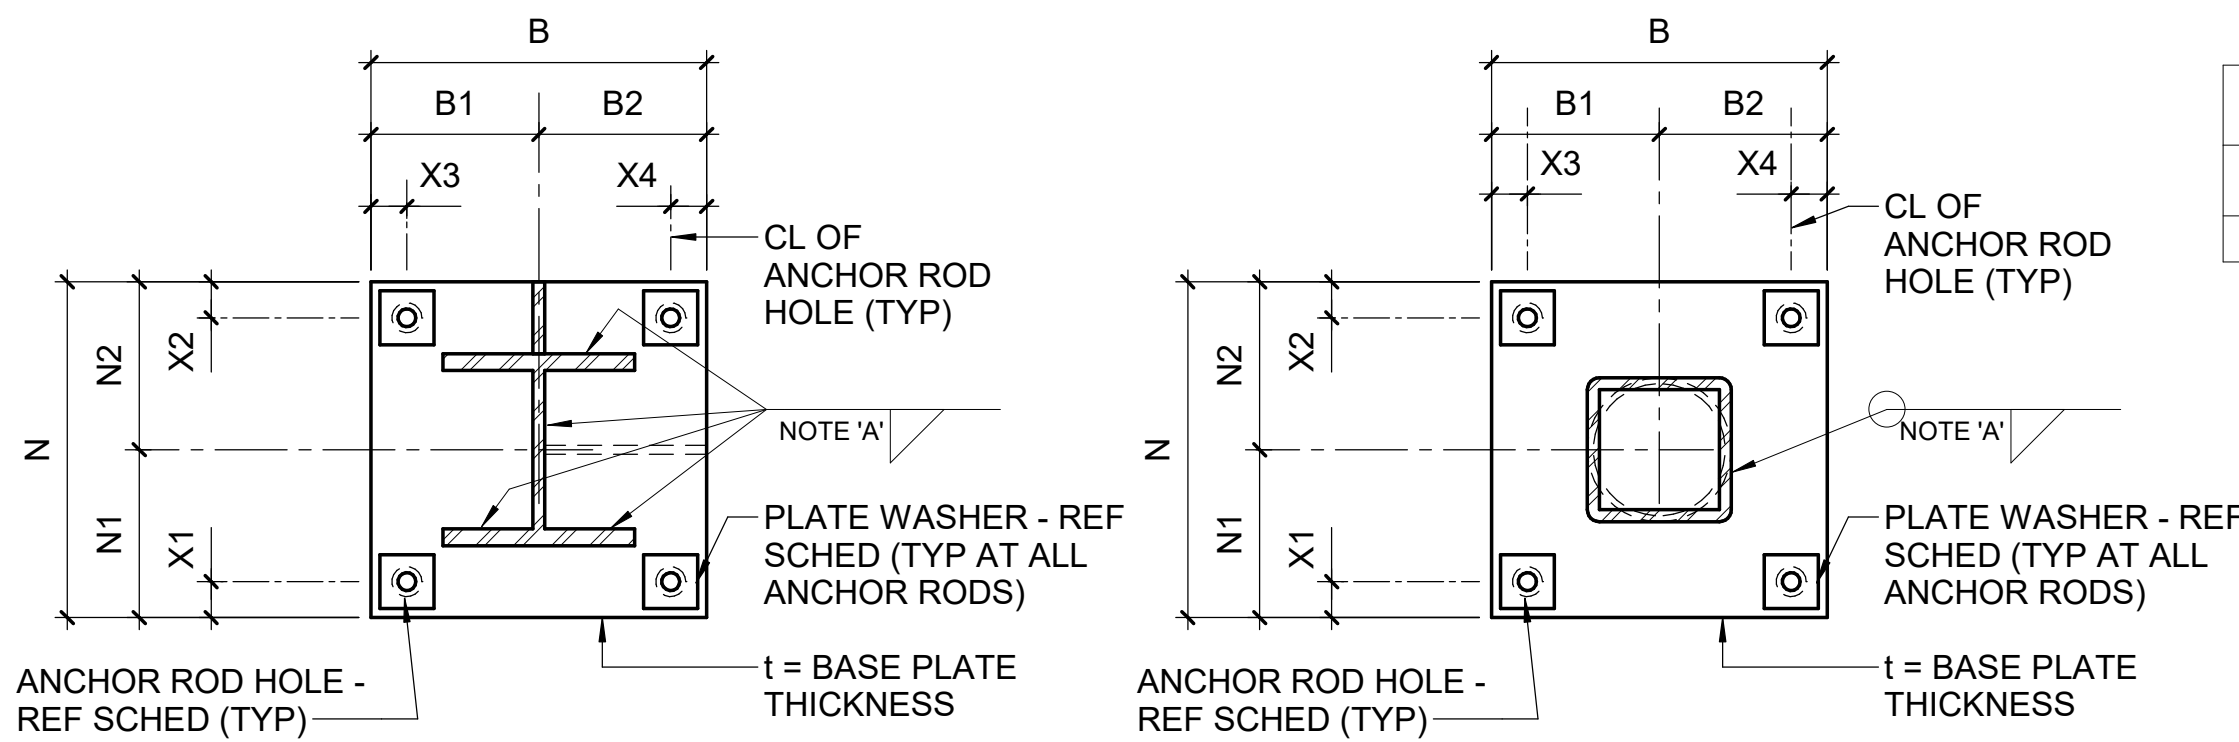


COLUMN BASE PLATE SCHEDULE - GRAVITY COLUMNS														
MARK	BASE PLATE DIMENSIONS										ANCHOR RODS			REMARKS
	B	N	t	B1	B2	N1	N2	X1	X2	X3	X4	DIAMETER	QUANTITY	
BPG-1	16"	16"	3/4"	8"	8"	8"	8"	1 1/2"	1 1/2"	1 1/2"	1 1/2"	3/4"	4	9"

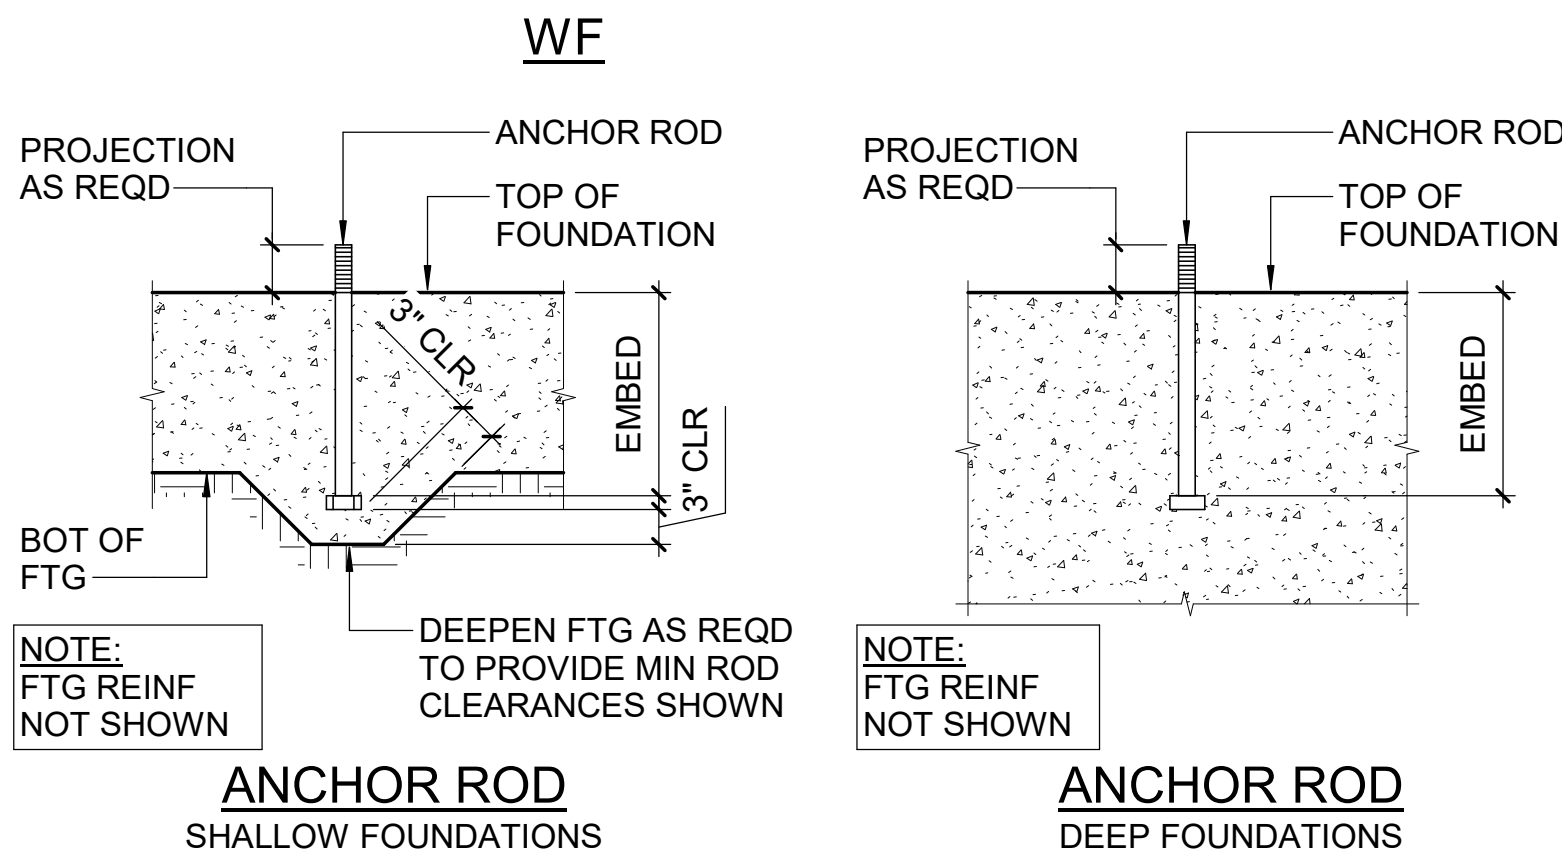


ANCHOR ROD HOLES AND WASHER SCHEDULE						
ANCHOR ROD	OVERSIZED HOLE WITH PLATE WASHER				STANDARD HOLE	
	BASE PLATE HOLE	WASHER SIZE	WASHER HOLE	WASHER THICKNESS	BASE PLATE HOLE	WASHER
3/4"Ø	1 5/16"Ø	2" SQ	13/16"Ø	1/4"	1 1/16"Ø	ASTM F844
7/8"Ø	1 9/16"Ø	2 1/2" SQ	15/16"Ø	5/16"	1 3/16"Ø	ASTM F844
1"Ø	1 13/16"Ø	3" SQ	1 1/16"Ø	3/8"	1 1/2"Ø	ASTM F844

NOTE:
A. PROVIDE MINIMUM SIZE WELD PER AISC TABLE J2.4.
B. GENERAL CONTRACTOR'S OPTION TO USE STANDARD OR OVERSIZED HOLES IN GRAVITY COLUMN BASE PLATES. NO WELDING REQUIRED AT PLATE WASHERS USED WITH OVERSIZED HOLES.


C1 GRAVITY COLUMN BASE PLATE AND ANCHOR ROD DETAILS

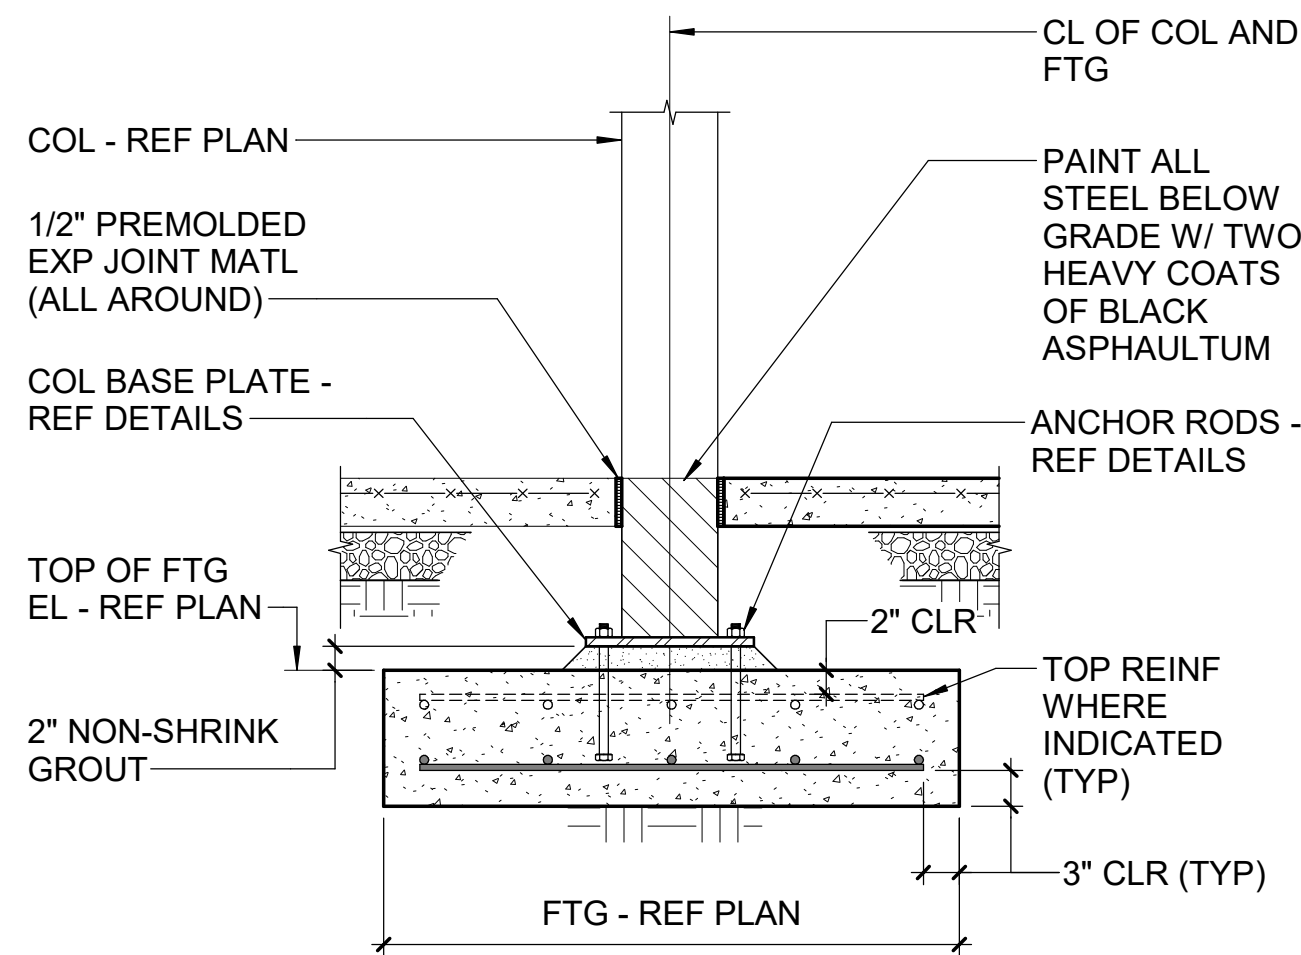


B1 TYPICAL COLUMN & FOOTING DETAIL

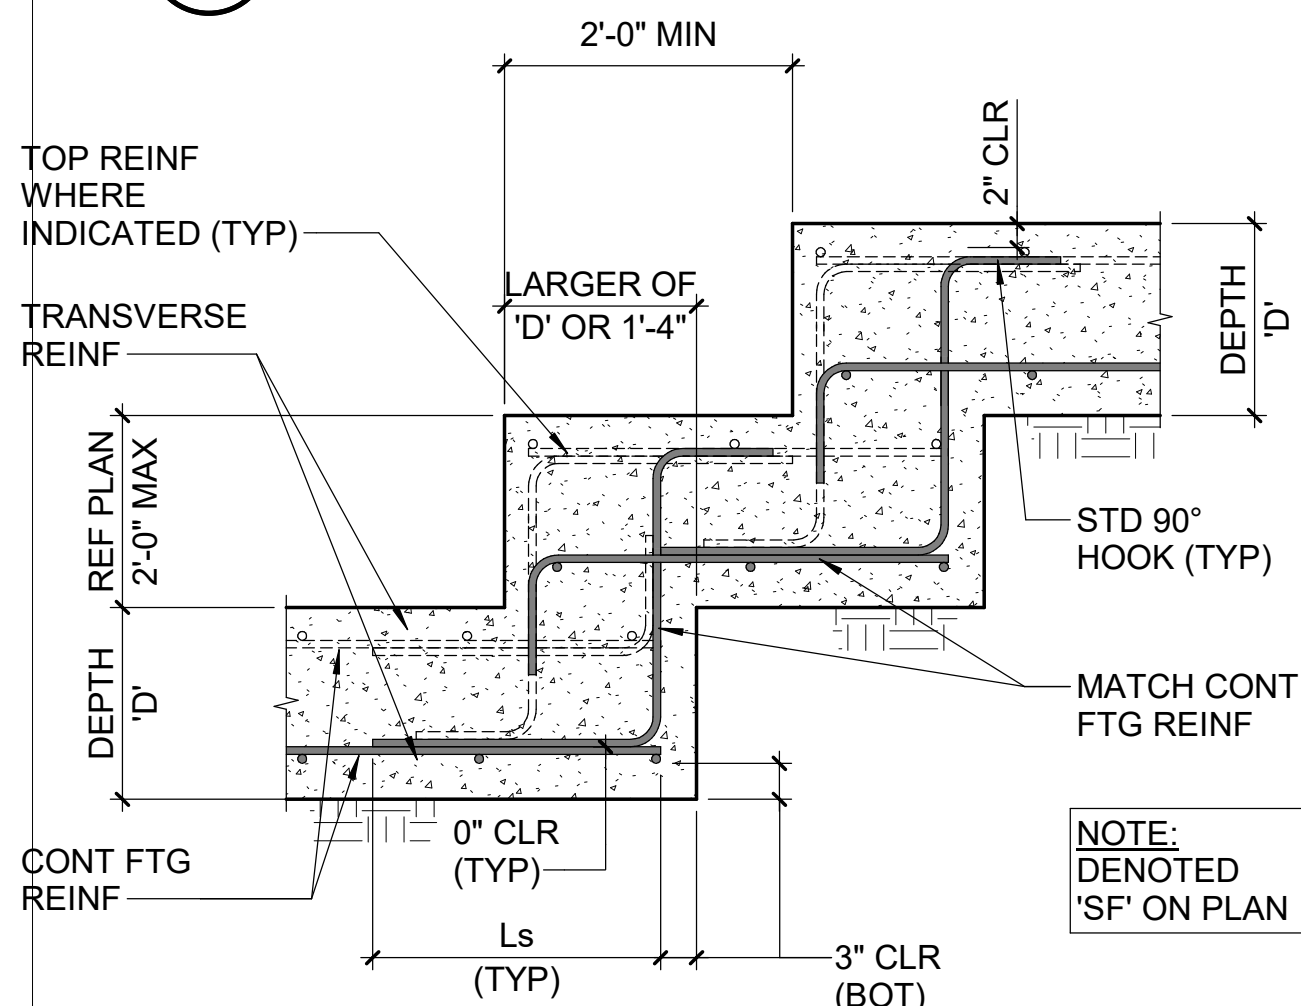


A1 TYPICAL STEPPED WALL FOOTING DETAIL

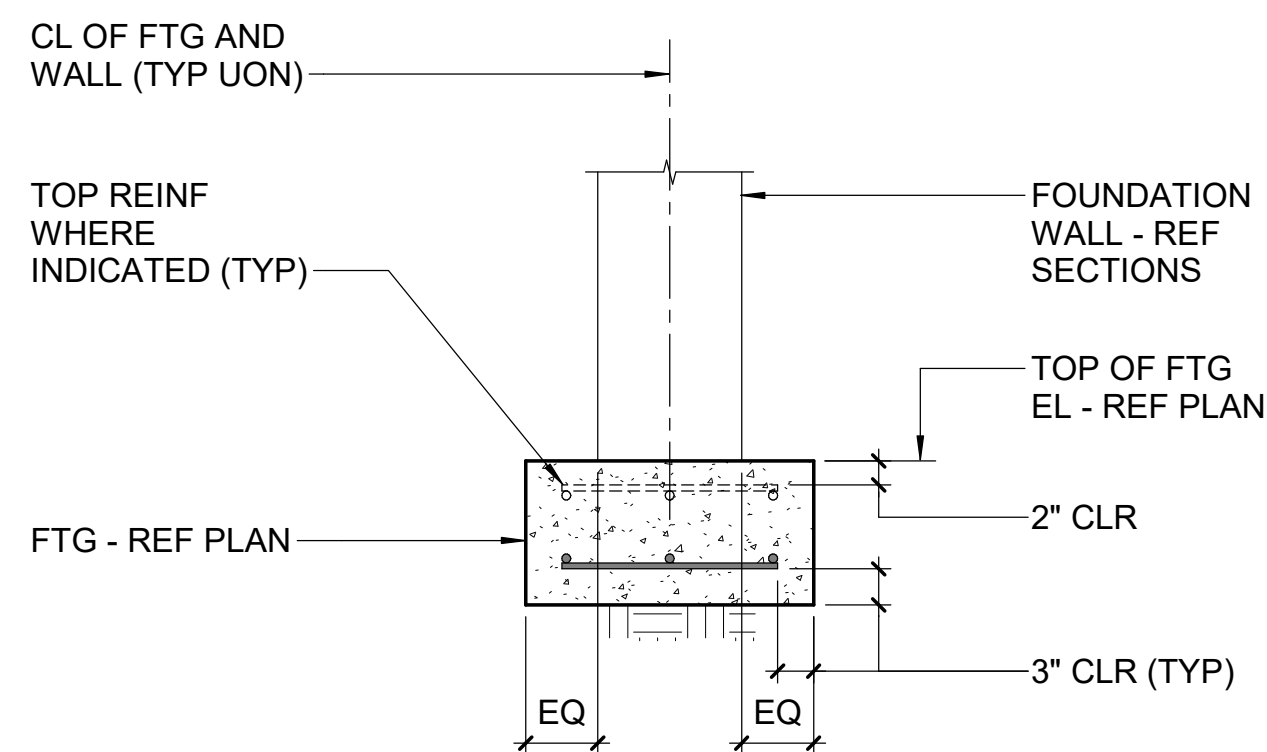



B2 TYPICAL WALL FOOTING DETAIL

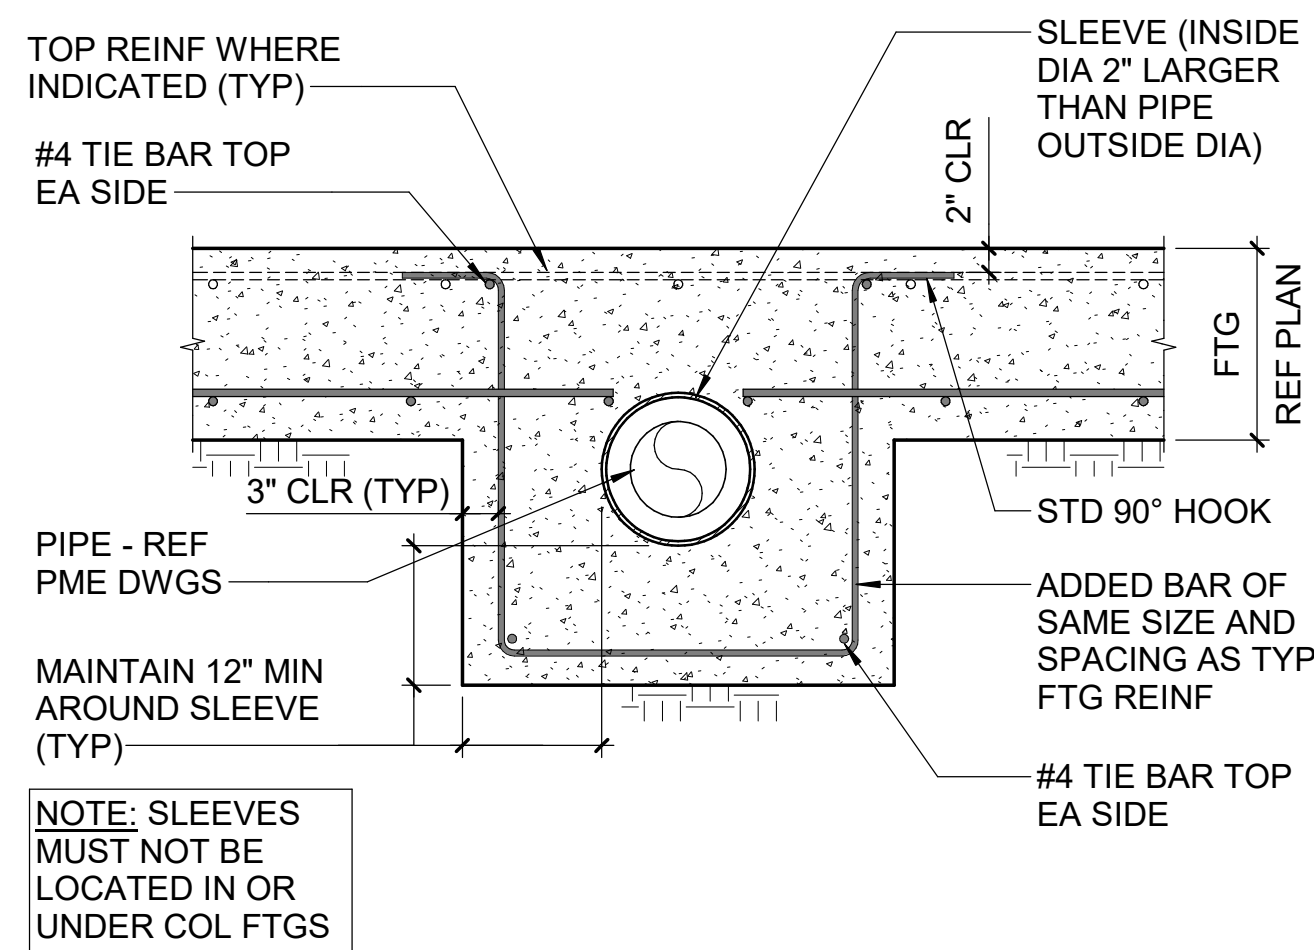

A2 TYPICAL PIPE SLEEVE AT WALL FOOTING DETAILS

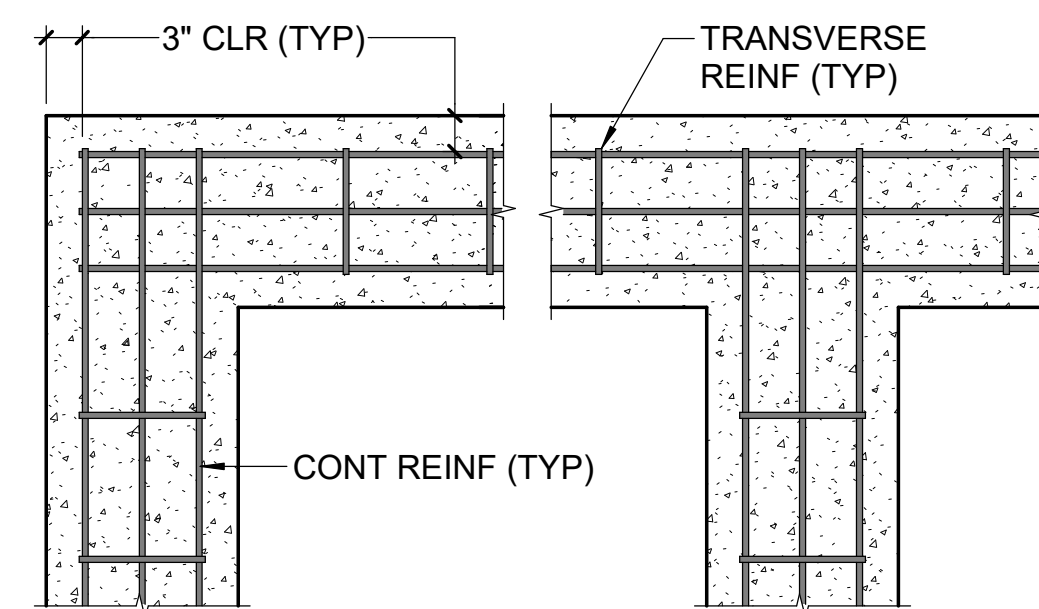

B3 TYPICAL WALL FOOTING CORNER & INTERSECTION DETAILS

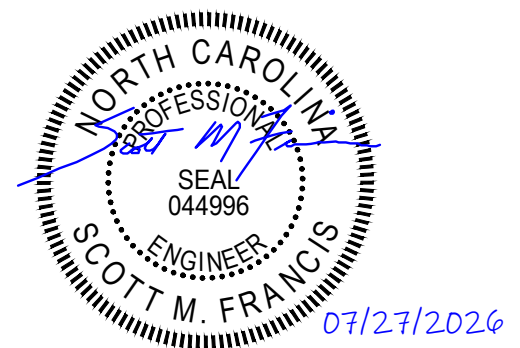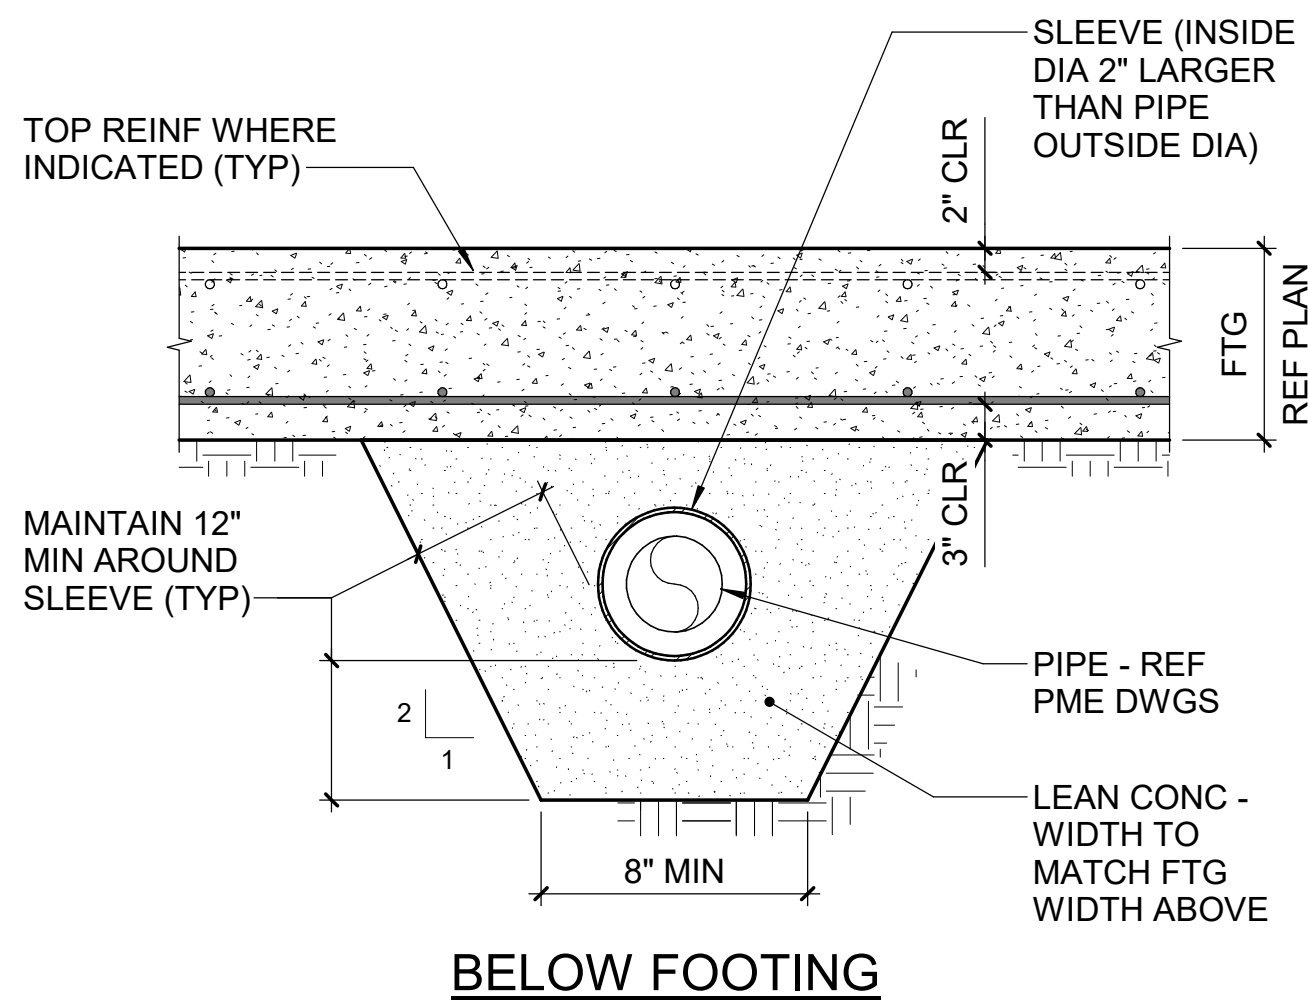

lynchmykins
now
IMEG
301 N WEST STREET, SUITE 105
RALEIGH, NC 27603
919.782.1833 www.imegcorp.com

IMEG RESERVES PROPRIETARY RIGHTS, INCLUDING COPYRIGHTS, TO THIS DRAWING AND THE DATA SHOWN THEREON. SAID DRAWING AND/OR DATA ARE THE EXCLUSIVE PROPERTY OF IMEG AND SHALL NOT BE USED OR REPRODUCED FOR ANY OTHER PROJECT WITHOUT THE EXPRESS WRITTEN APPROVAL AND PARTICIPATION OF IMEG.
©2025 IMEG CONSULTANTS CORP.
North Carolina Design Registration #F-1507

Susan Hatchell
Landscape Architecture, PLLC
711 W. North Street, Raleigh, NC 27603
p: 919-838-9600 f: 919-838-9700




TYPICAL DETAILS

LAKE MYRA COUNTY PARK
Wake County, NC

REVISIONS

Date 07/27/2026

MF-S501

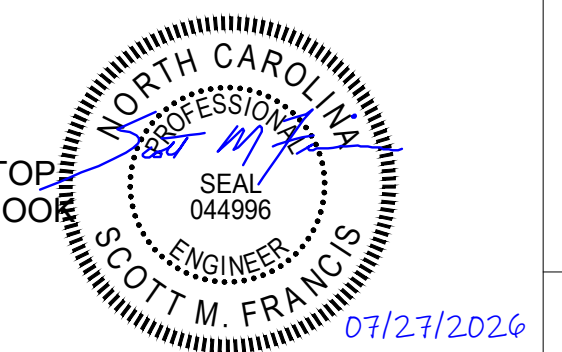

301 N WEST STREET, SUITE 105
RALEIGH, NC 27603
919.782.1833 www.imegcorp.com

IMEG RESERVES PROPRIETARY RIGHTS,
INCLUDING COPYRIGHTS, TO THIS DRAWING AND
THE DATA SHOWN THEREON. SAID DRAWING
AND/OR DATA ARE THE EXCLUSIVE PROPERTY OF
IMEG AND SHALL NOT BE USED OR REPRODUCED
FOR ANY OTHER PROJECT WITHOUT THE EXPRESS
WRITTEN APPROVAL AND PARTICIPATION OF IMEG.
©2025 IMEG CONSULTANTS CORP.
North Carolina Design Registration #C-1507

TYPICAL DETAILS

LAKE MYRA COUNTY PARK
Wake County, NC


REVISIONS

Date07/27/2026


MF-S502

Susan Hatchell
Landscape Architecture, PLLC
711 W. North Street, Raleigh, NC 27603
p: 919-838-9600 f: 919-838-9700




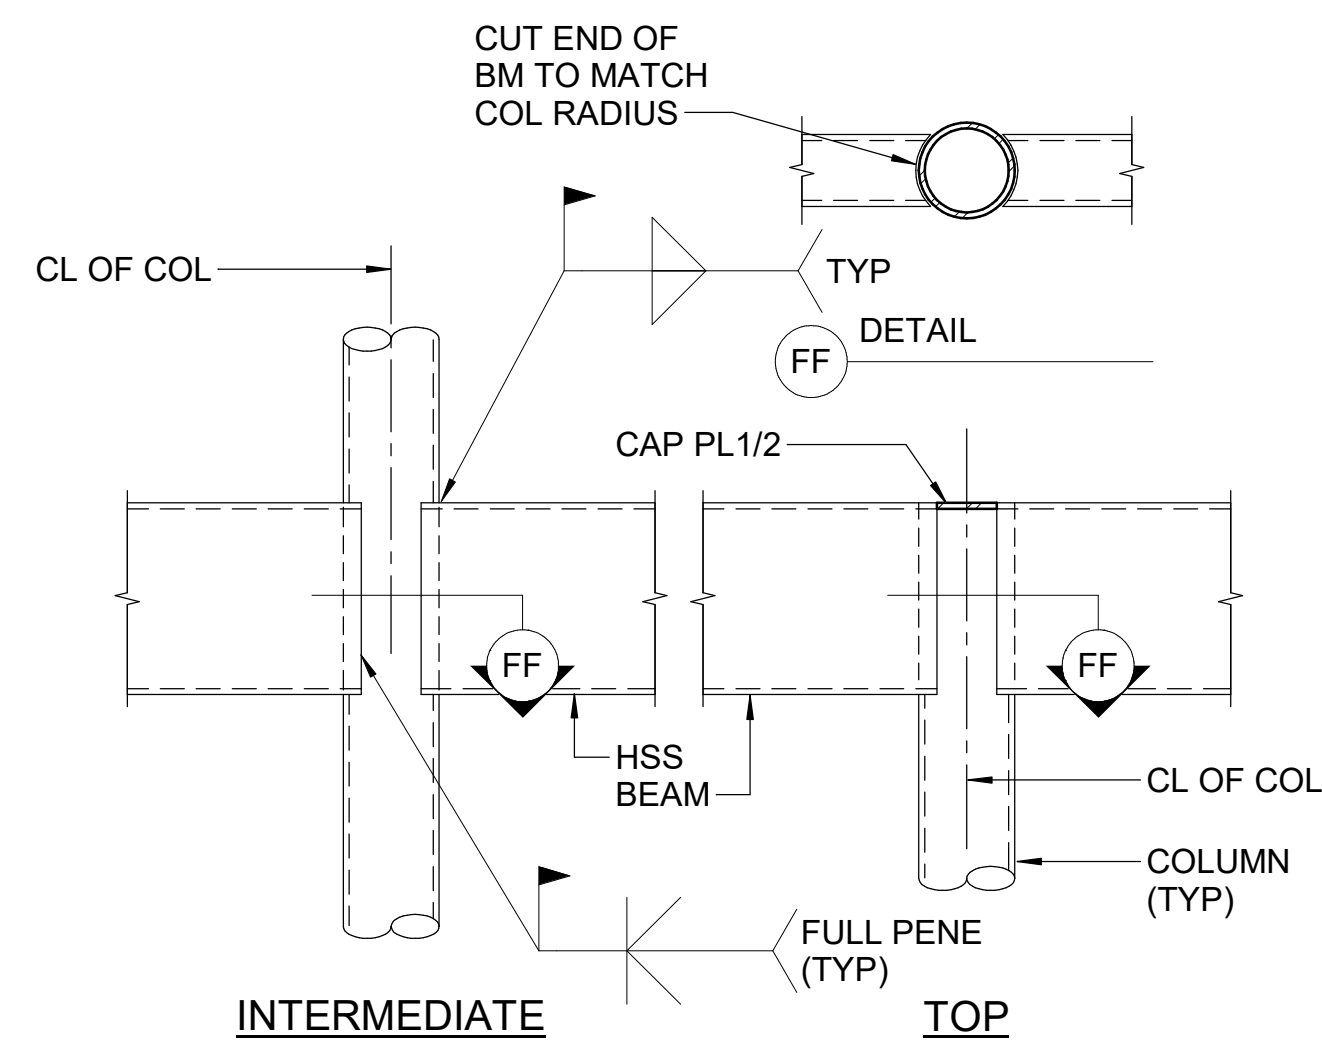


B1 TYPICAL HSS BEAM TO HSS ROUND COLUMN MOMENT CONNECTION DETAILS
NTS

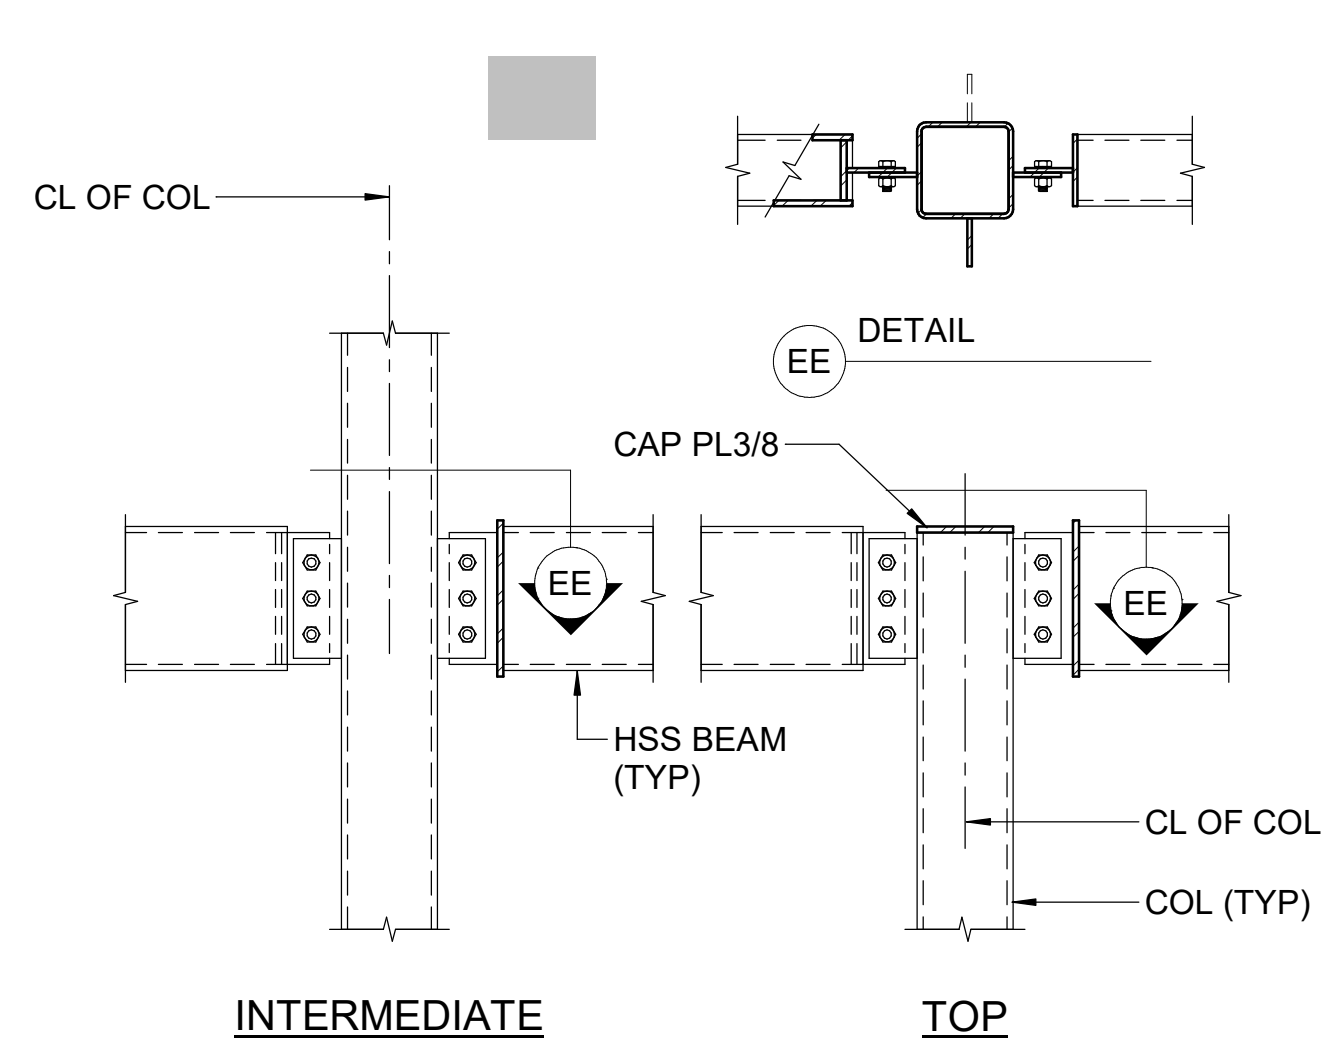


B2 TYPICAL HSS BEAM TO HSS COLUMN CONNECTION DETAILS
NTS

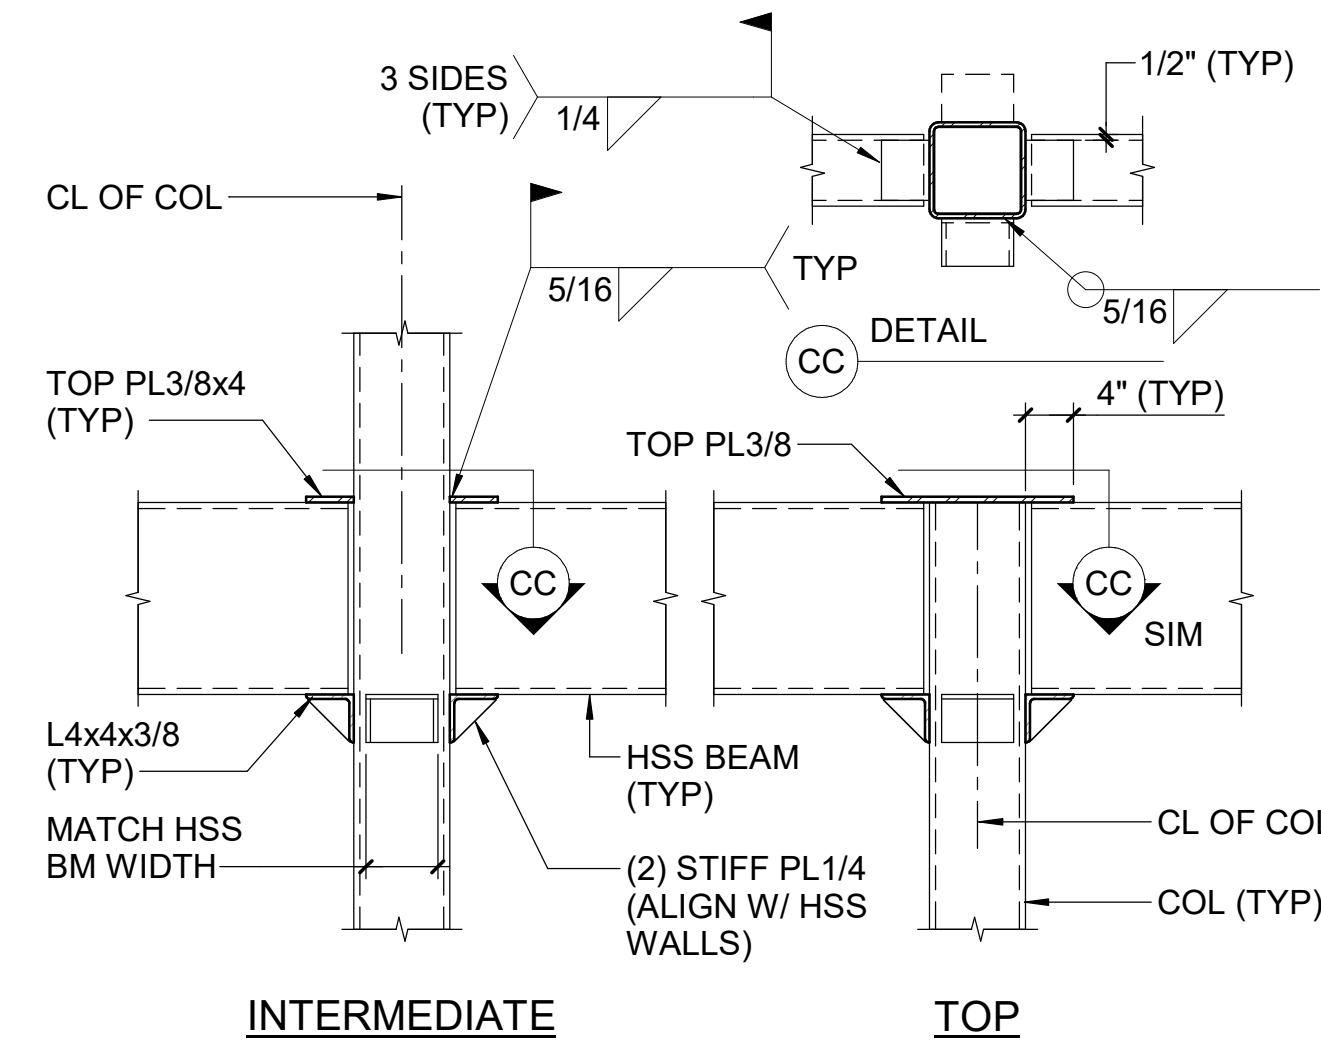


B3 TYPICAL HSS BEAM TO HSS COLUMN CONNECTION DETAILS
NTS

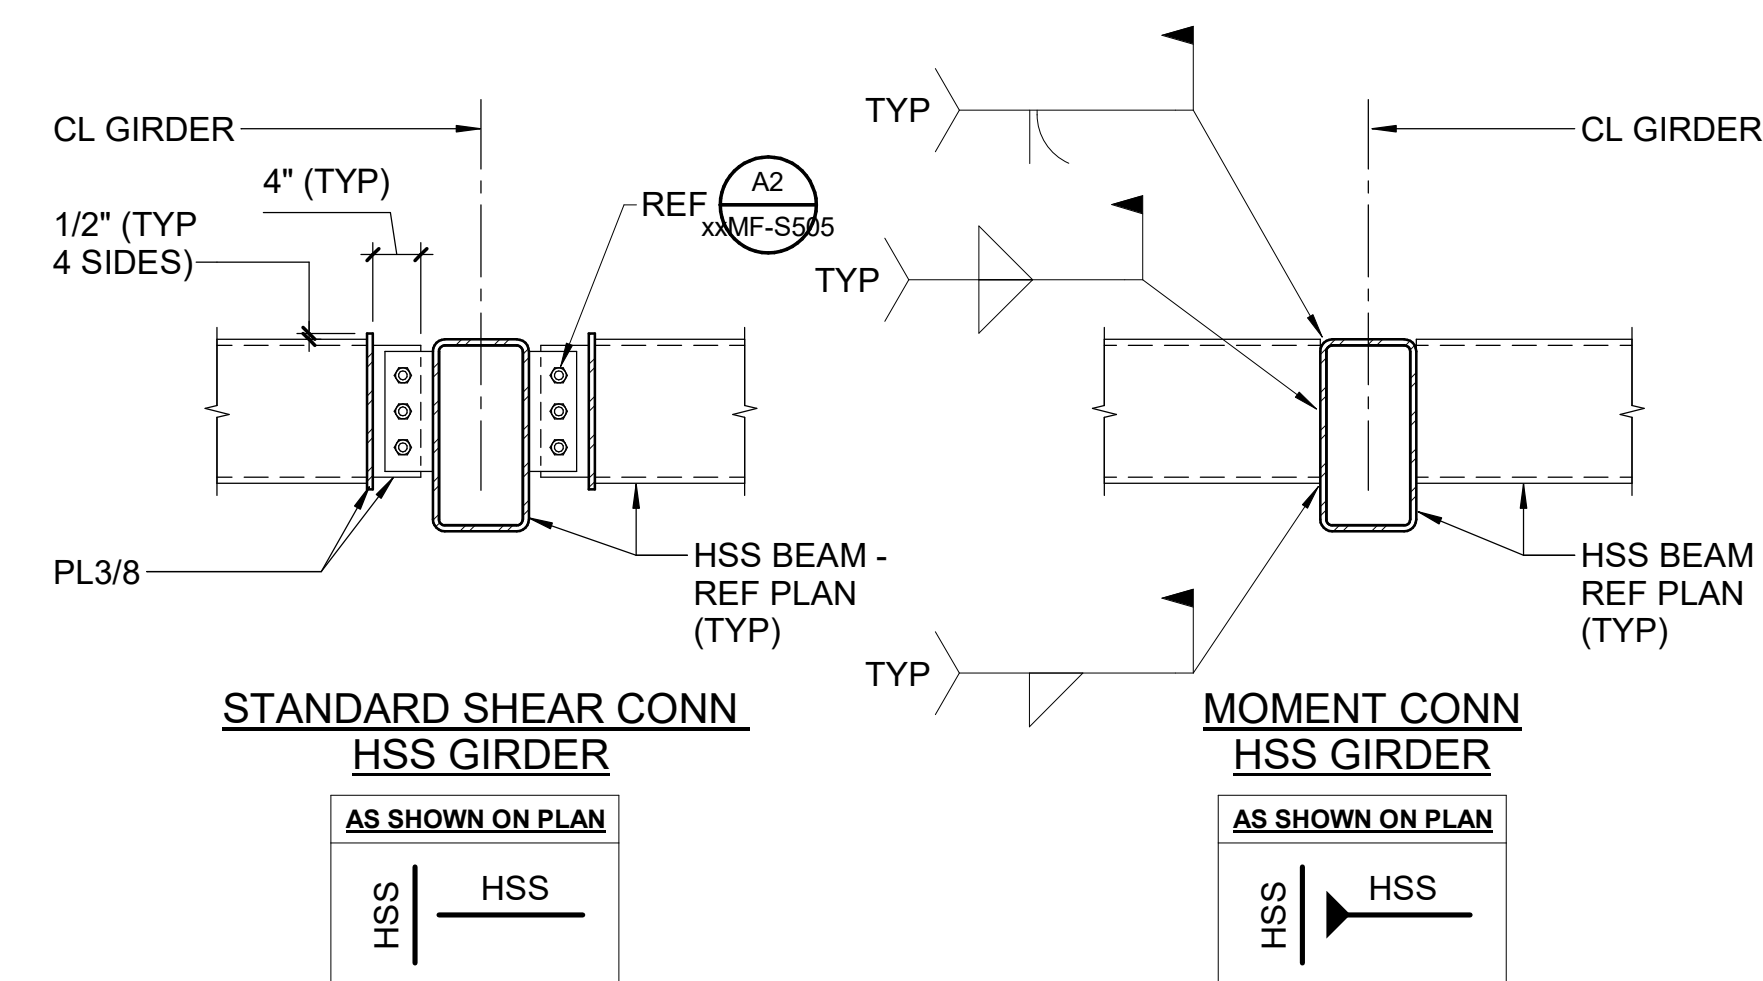

A1 TYPICAL HSS BEAM TO GIRDER CONNECTION DETAILS
NTS

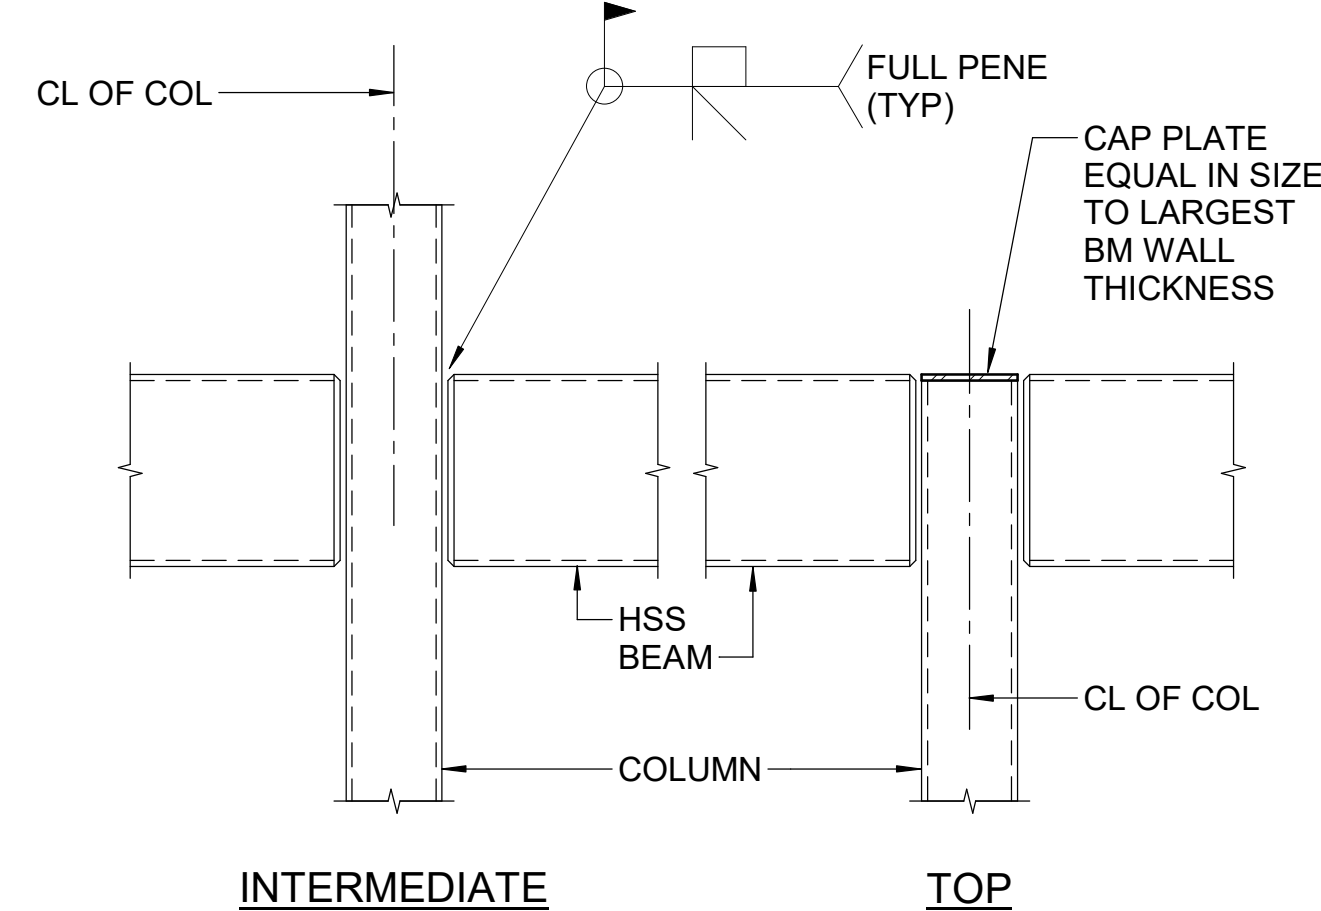

A2 TYPICAL HSS BEAM TO HSS COLUMN MOMENT CONNECTION DETAILS
NTS

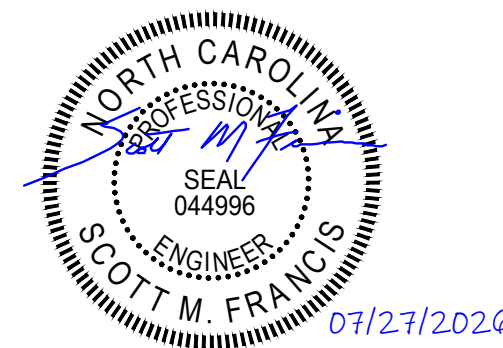

lynchmykins
now **IMEG**
301 N WEST STREET, SUITE 105
RALEIGH, NC 27603
919.782.1833 www.imegcorp.com
IMEG RESERVES PROPRIETARY RIGHTS, INCLUDING COPYRIGHTS, TO THIS DRAWING AND THE DATA SHOWN THEREON. SAID DRAWING AND/OR DATA ARE THE EXCLUSIVE PROPERTY OF IMEG AND SHALL NOT BE USED OR REPRODUCED FOR ANY OTHER PROJECT WITHOUT THE EXPRESS WRITTEN APPROVAL AND PARTICIPATION OF IMEG.
©2025 IMEG CONSULTANTS CORP.
North Carolina Design Registration #F-1507

Susan Hatchell
Landscape Architecture, PLLC
711 W. North Street, Raleigh, NC 27603
p: 919-838-9600 f: 919-838-9700


lynchmykins
now **IMEG**
301 N WEST STREET, SUITE 105
RALEIGH, NC 27603
919.782.1833 www.imegcorp.com

TYPICAL DETAILS


LAKE MYRA COUNTY PARK
Wake County, NC

REVISIONS


Date 07/27/2026
MF-S503

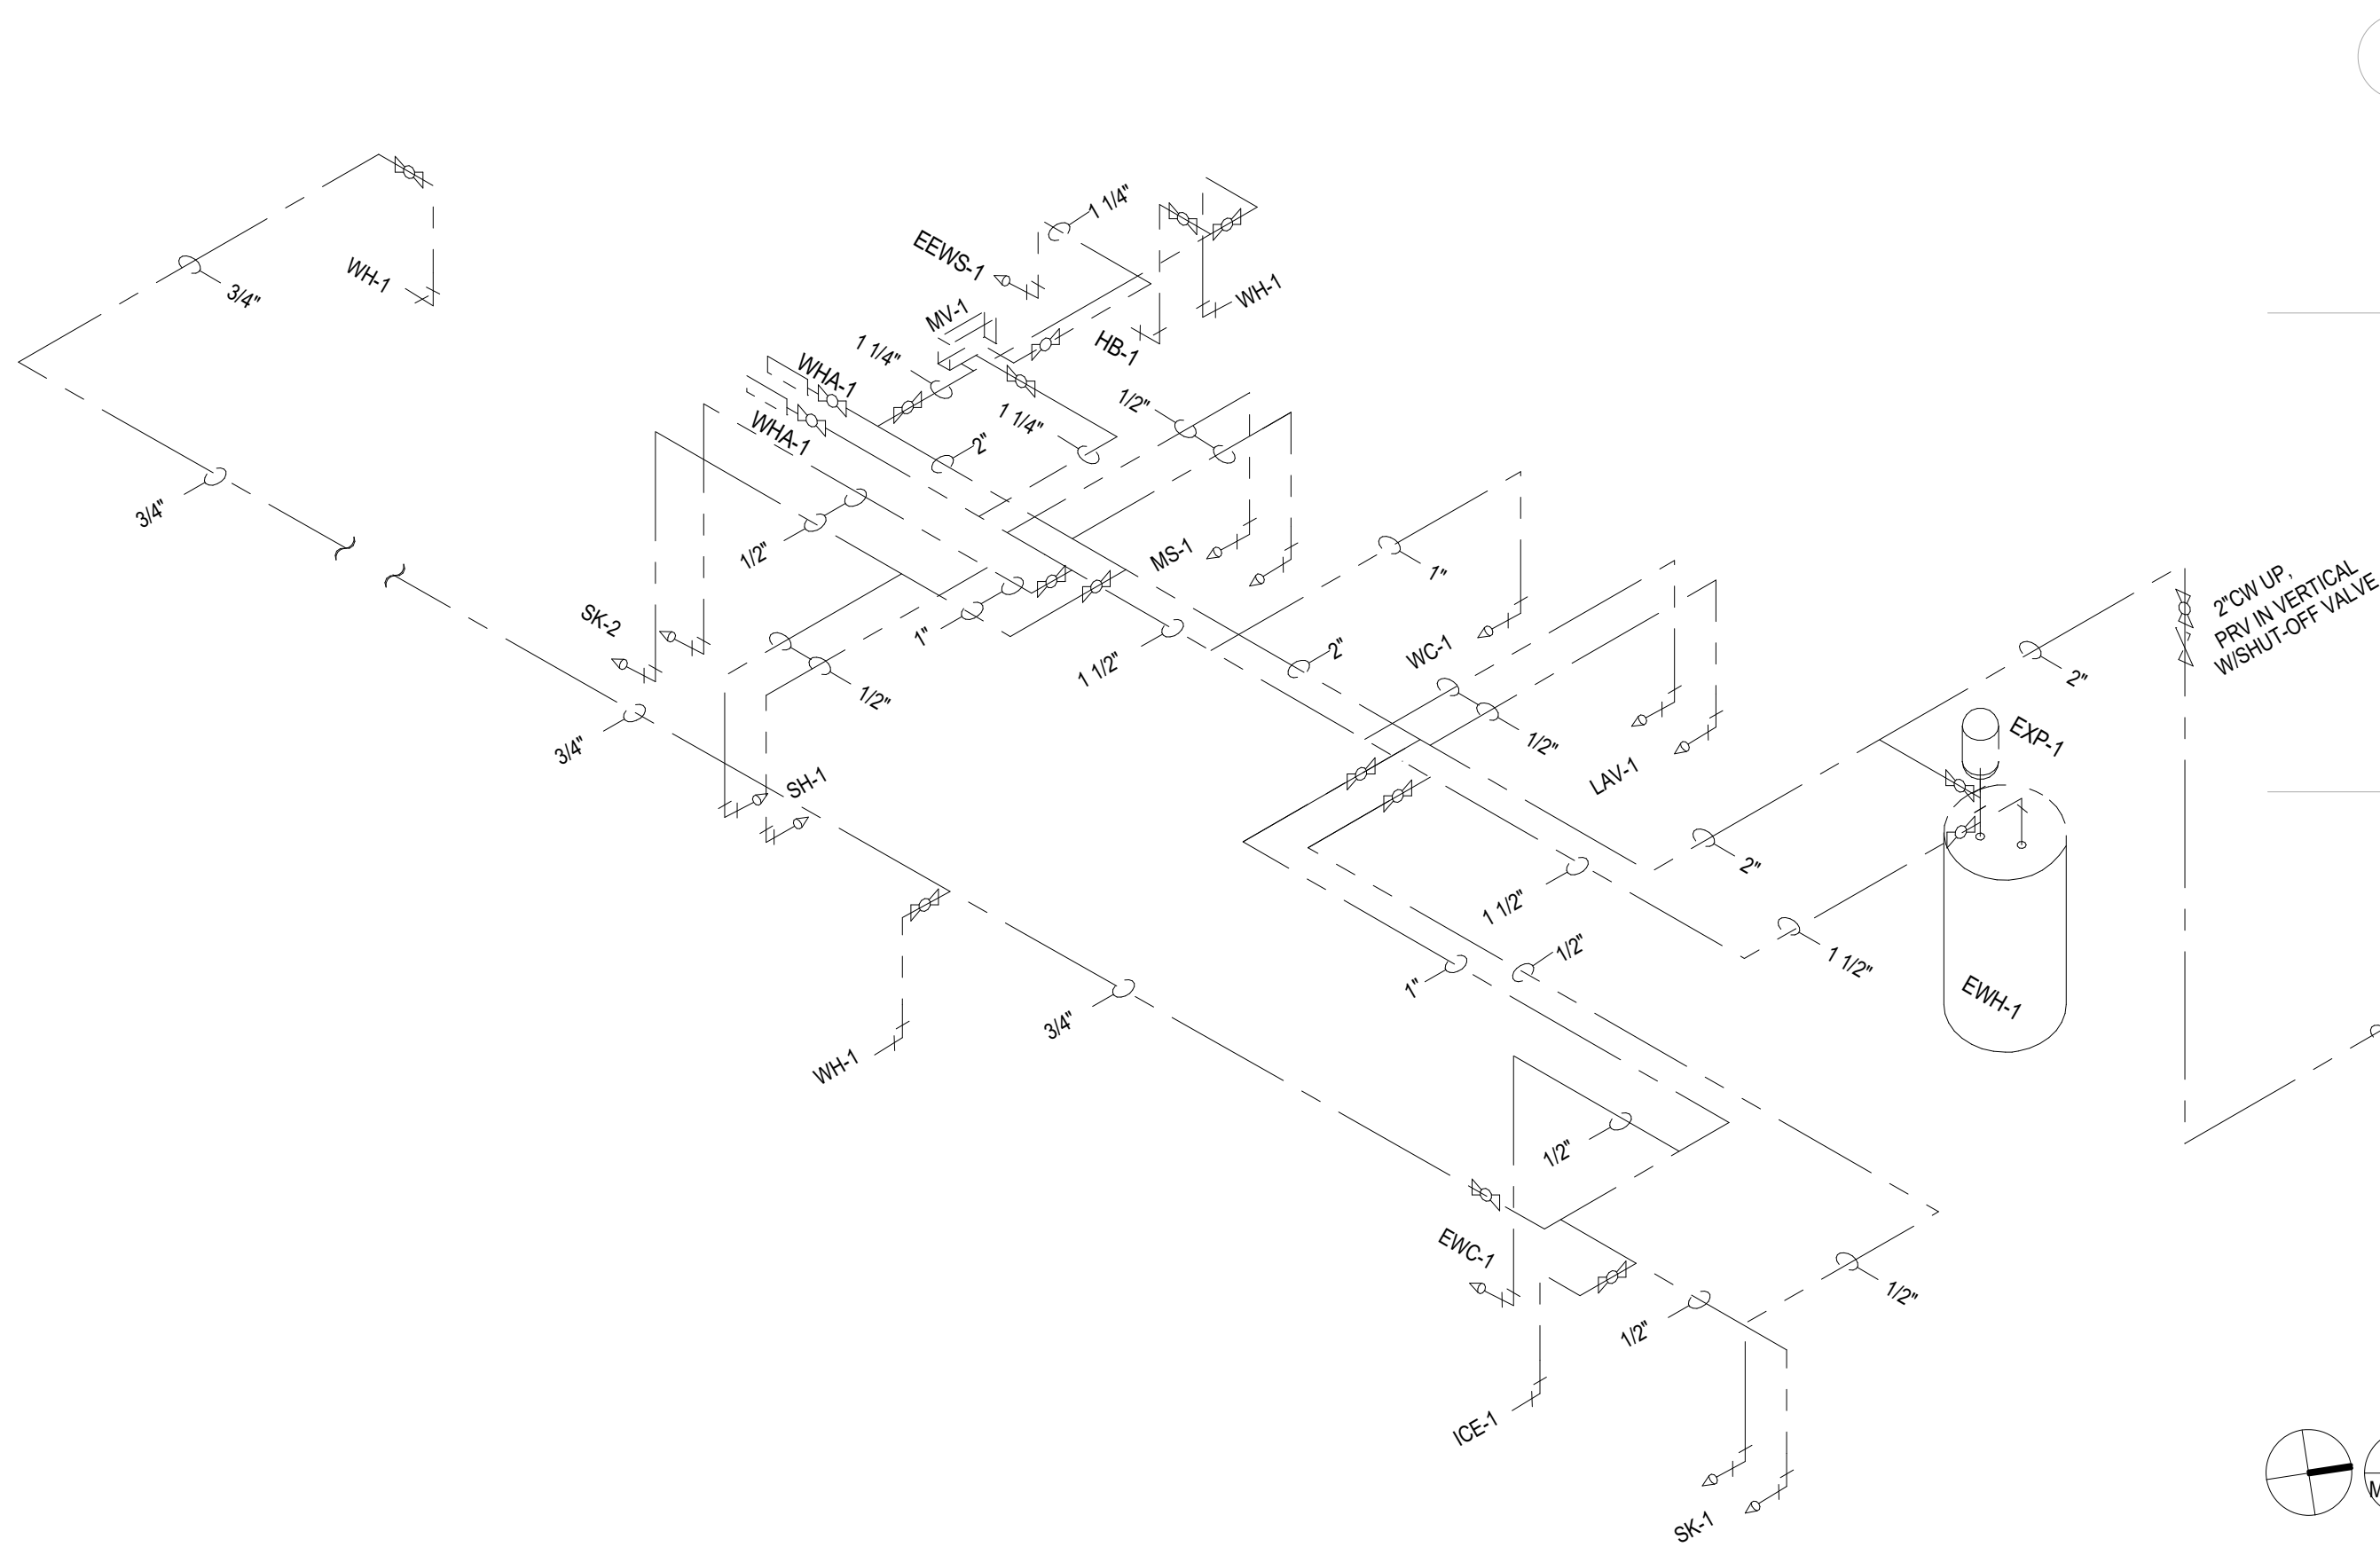


4 MF - WATER SUPPLY RISER DIAGRAM
MF-P105 NOT TO SCALE

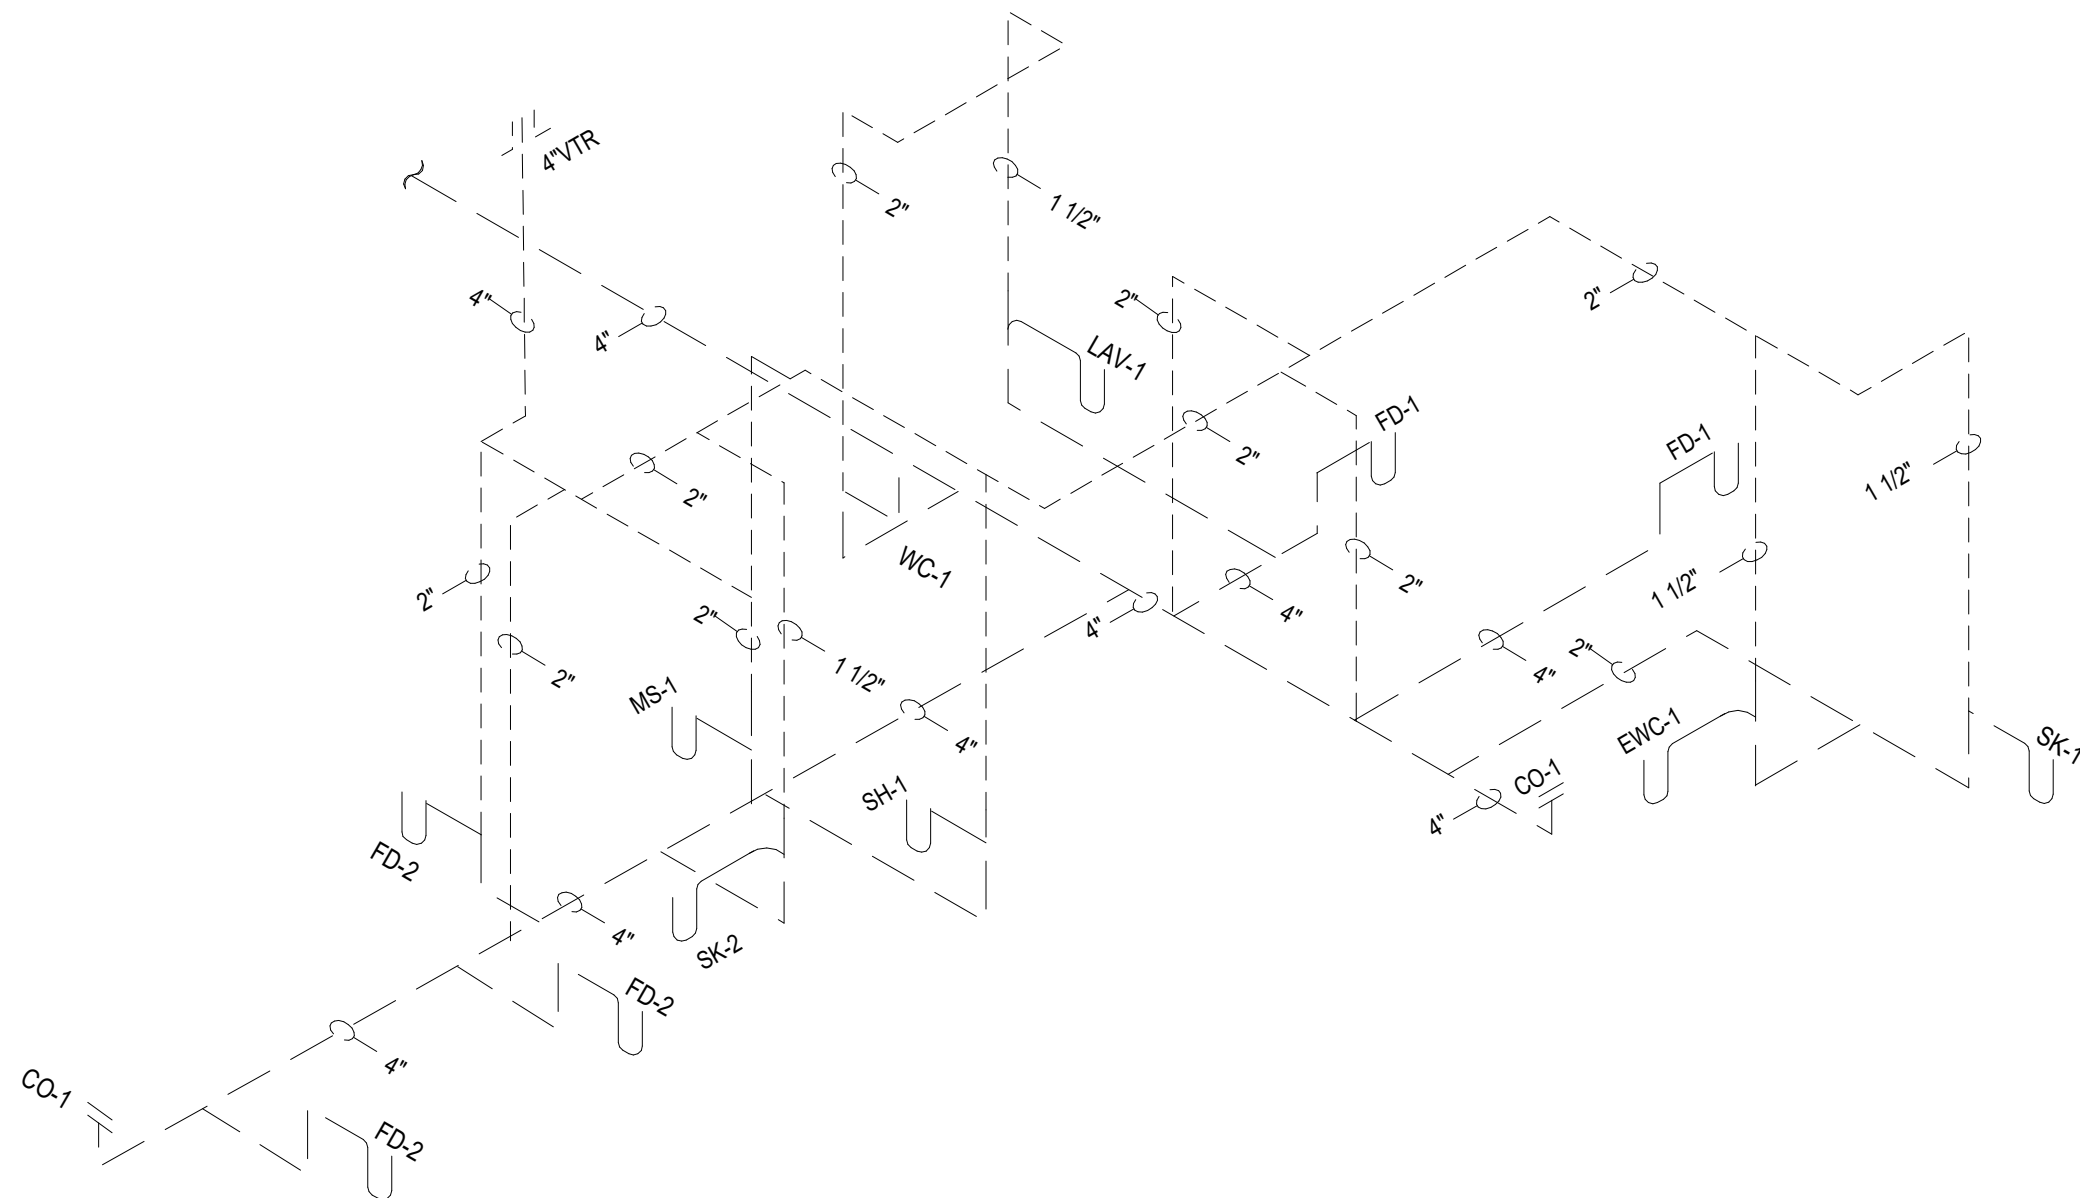

3 MF - WASTE AND VENT RISER DIAGRAM
MF-P105 NOT TO SCALE

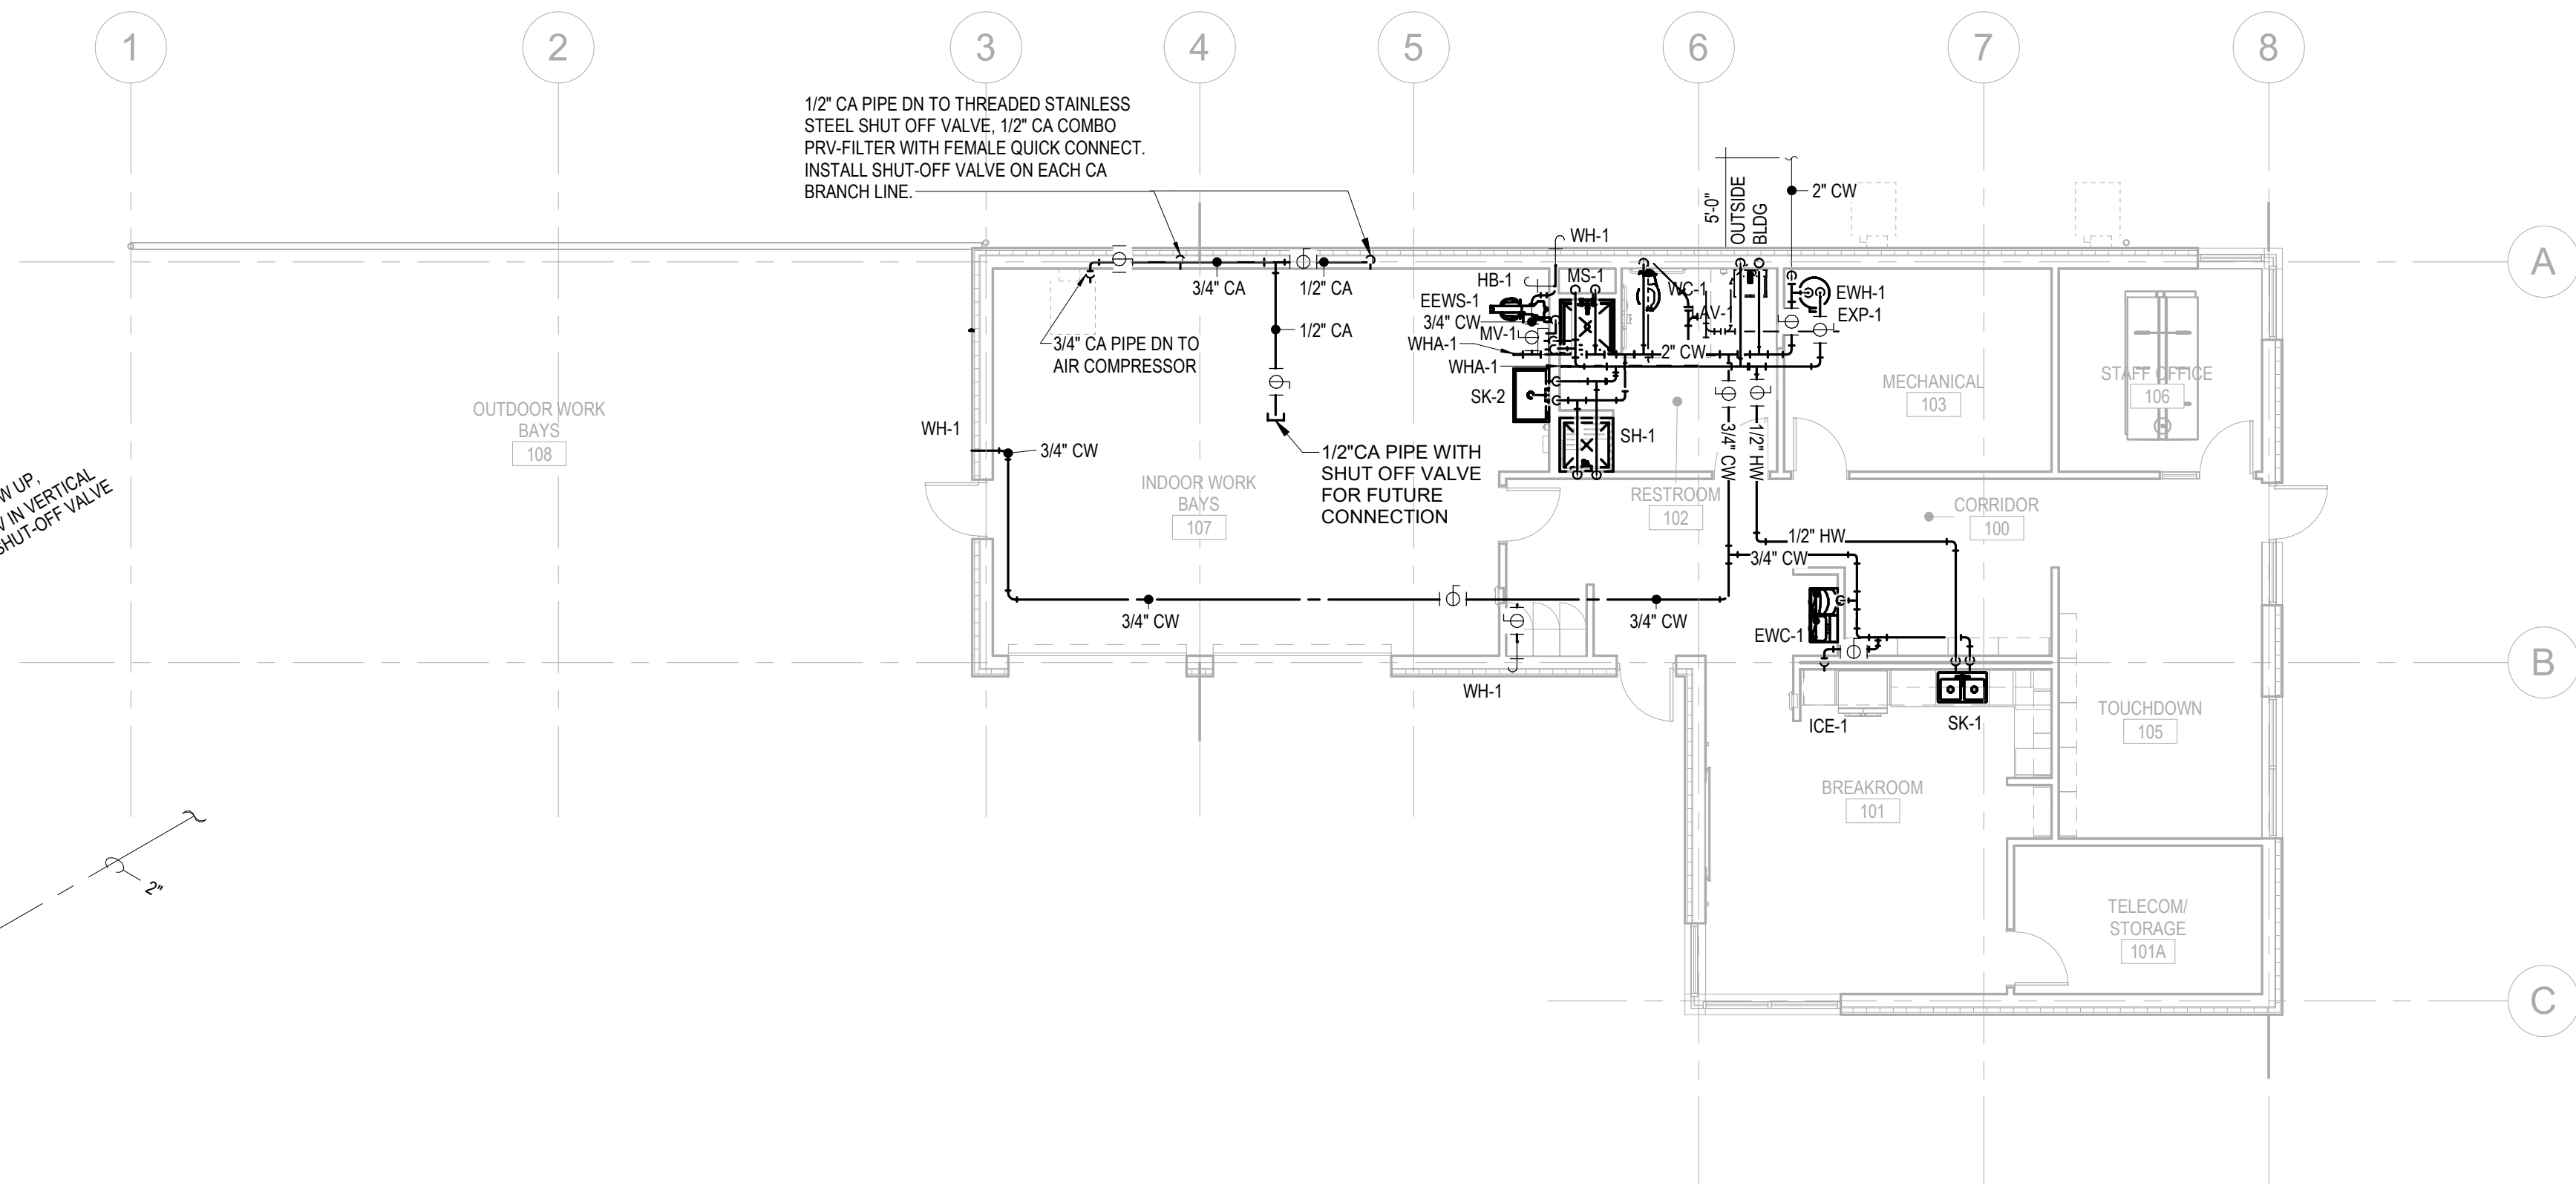

2 DOMESTIC WATER PLAN
MF-P105 1/8" = 1'-0"

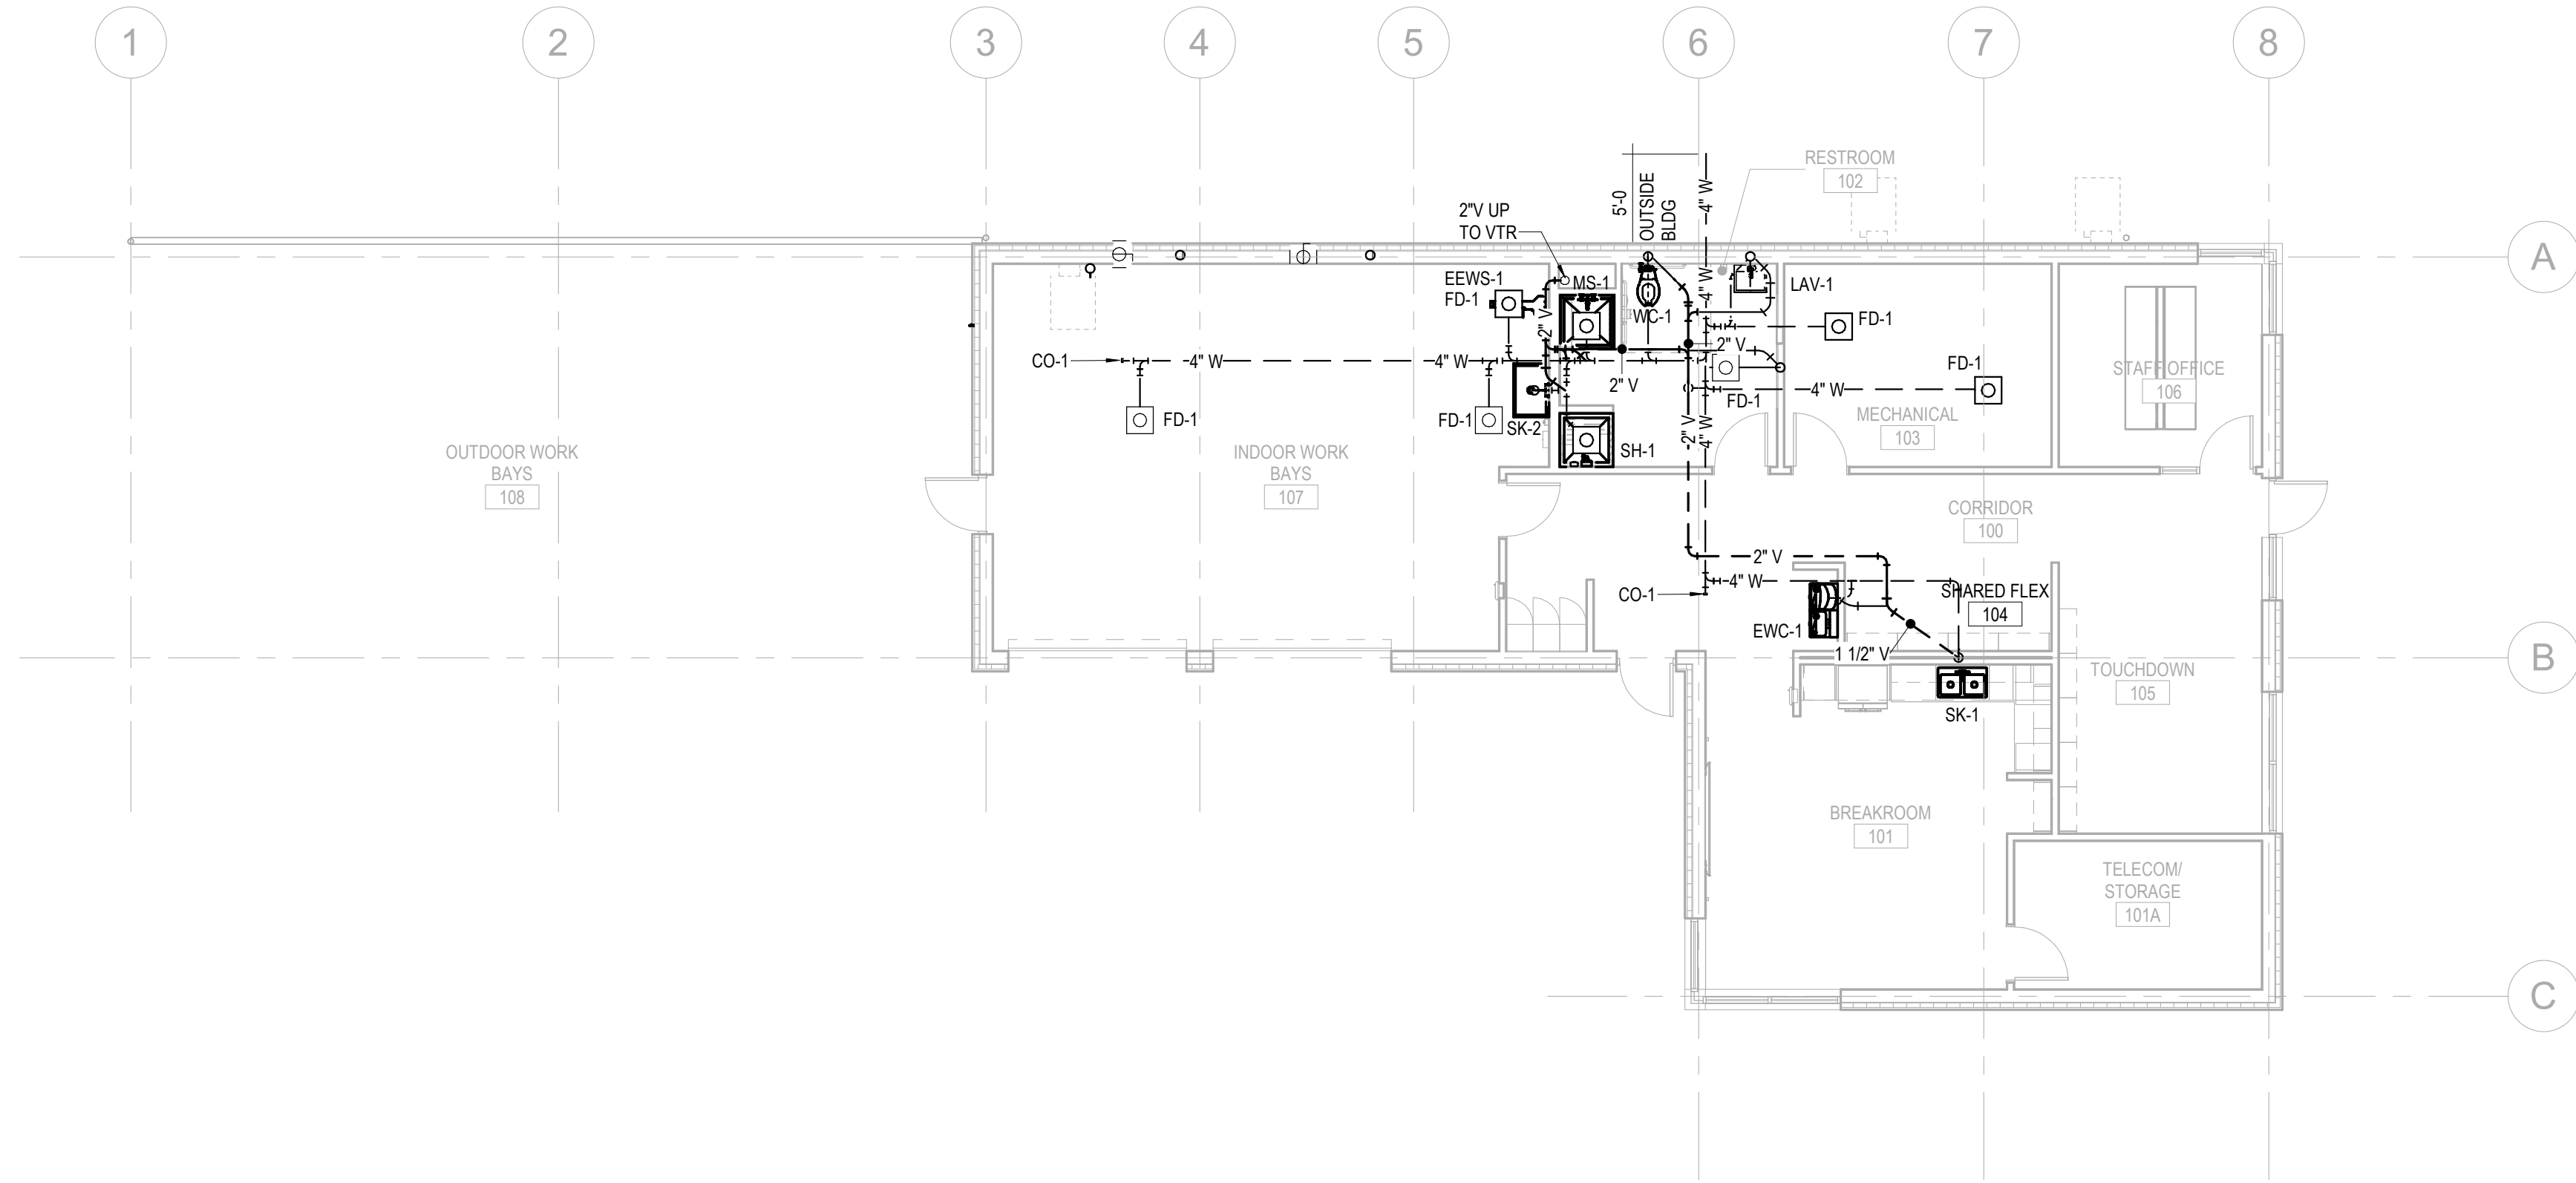


1 DWV PLAN
MF-P105 1/8" = 1'-0"

Susan Hatchell
Landscape Architecture, PLLC
711 W. North Street, Raleigh, NC 27603
p: 919-838-9600 f: 919-838-9700

Wooten
120 North Boylan Avenue • Raleigh, NC 27603-1423
(919) 828-0331 • www.wootencompany.com
License Number: 7-9715


FLOOR
PLANS

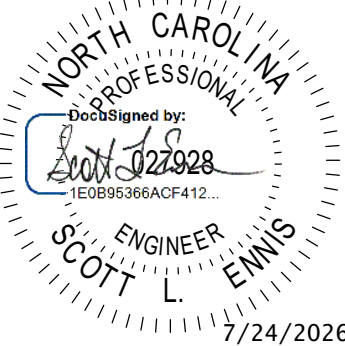


LAKE MYRA COUNTY PARK
Wake County, NC

REVISIONS


Date: 07/27/26
MF-P105

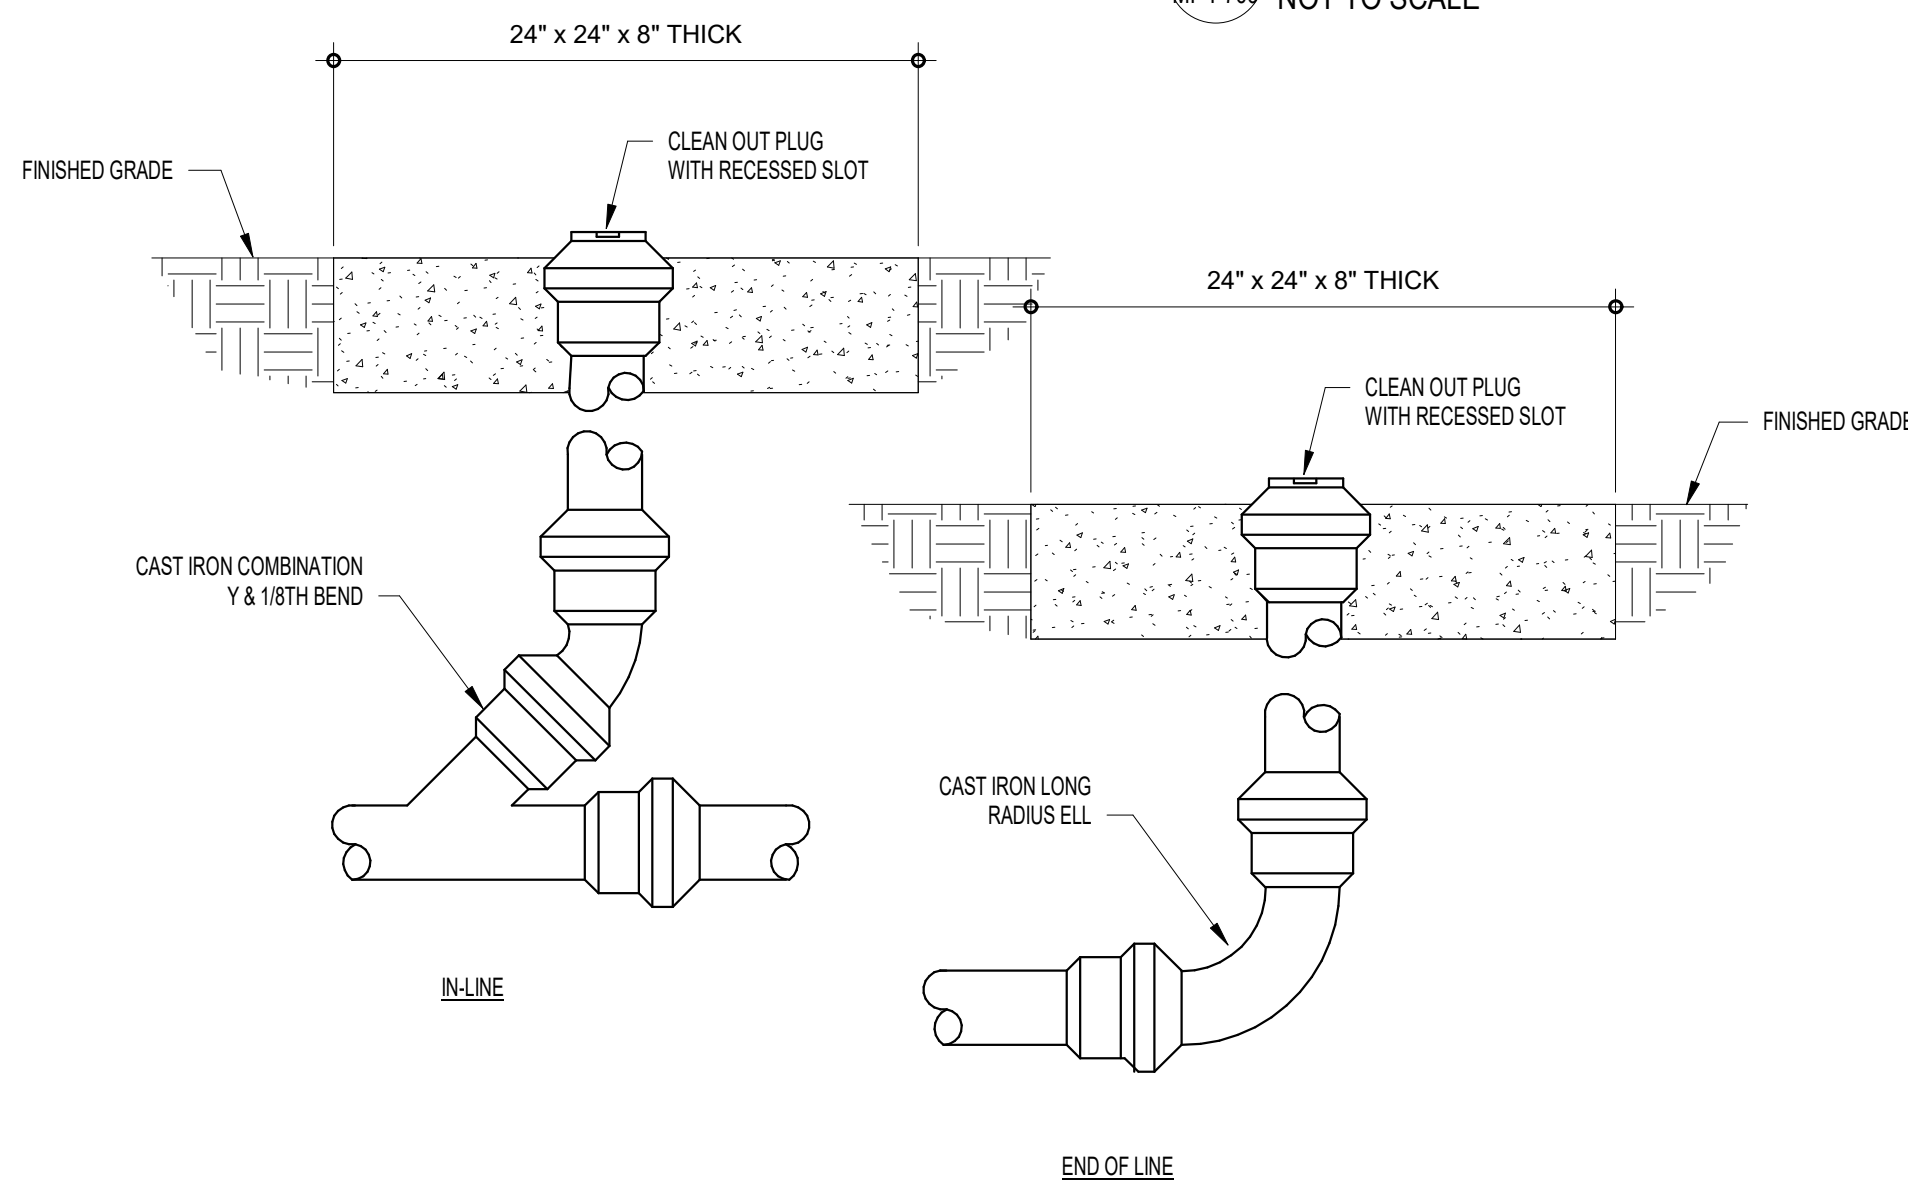


4 EXTERIOR CLEANOUT DETAIL
MF-P700 NOT TO SCALE

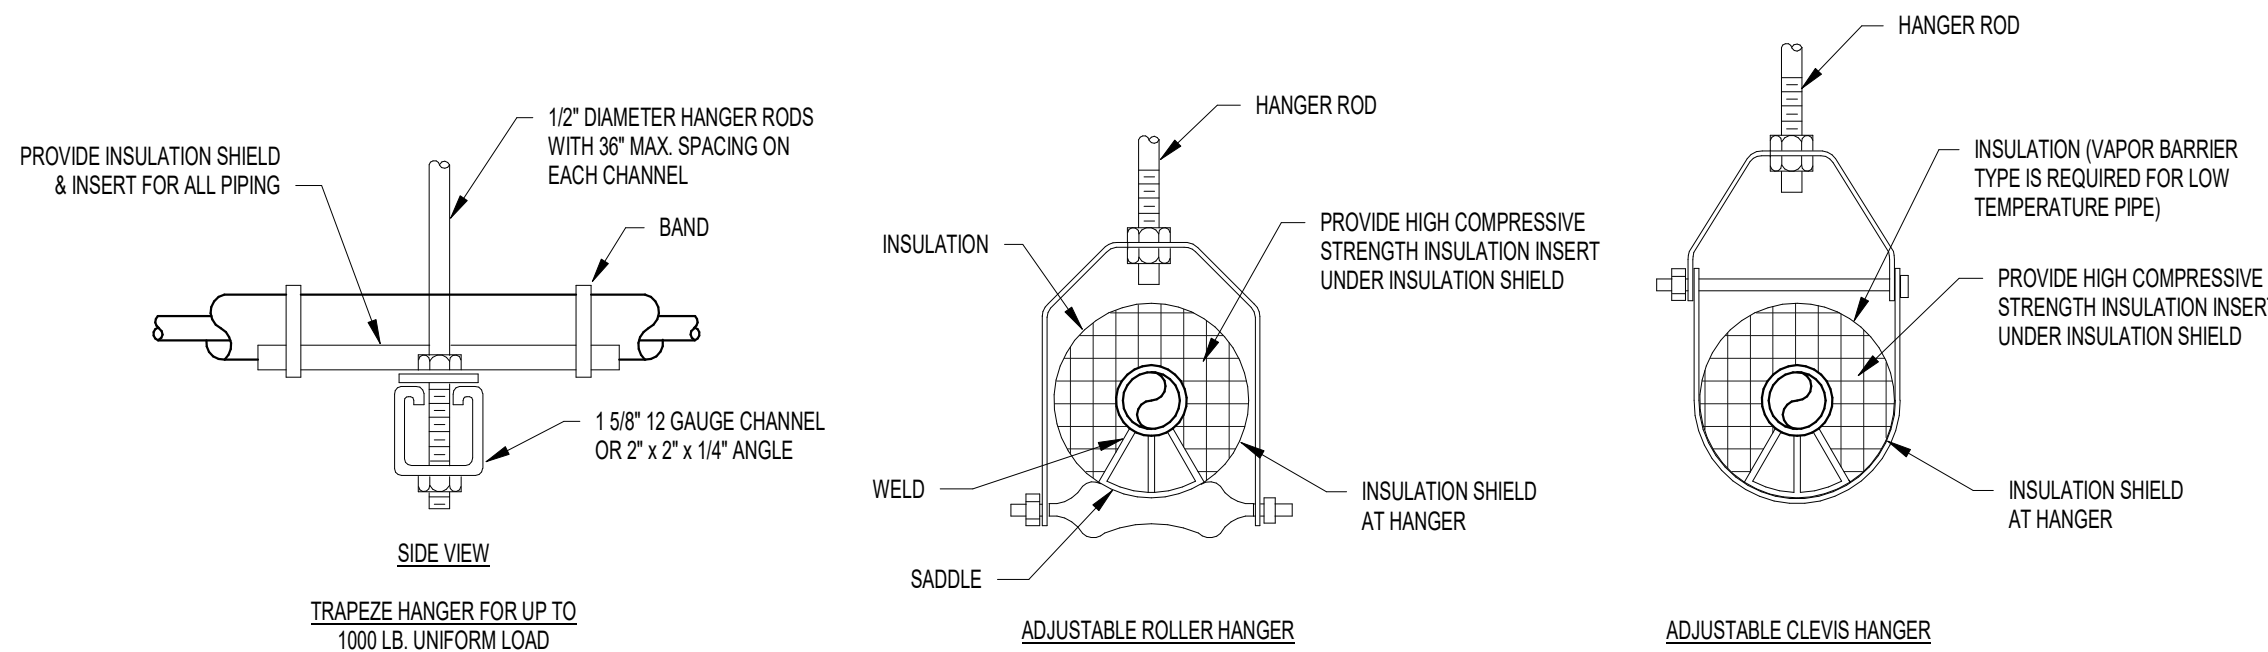


6 PIPE HANGER DETAIL - A
MF-P700 NOT TO SCALE

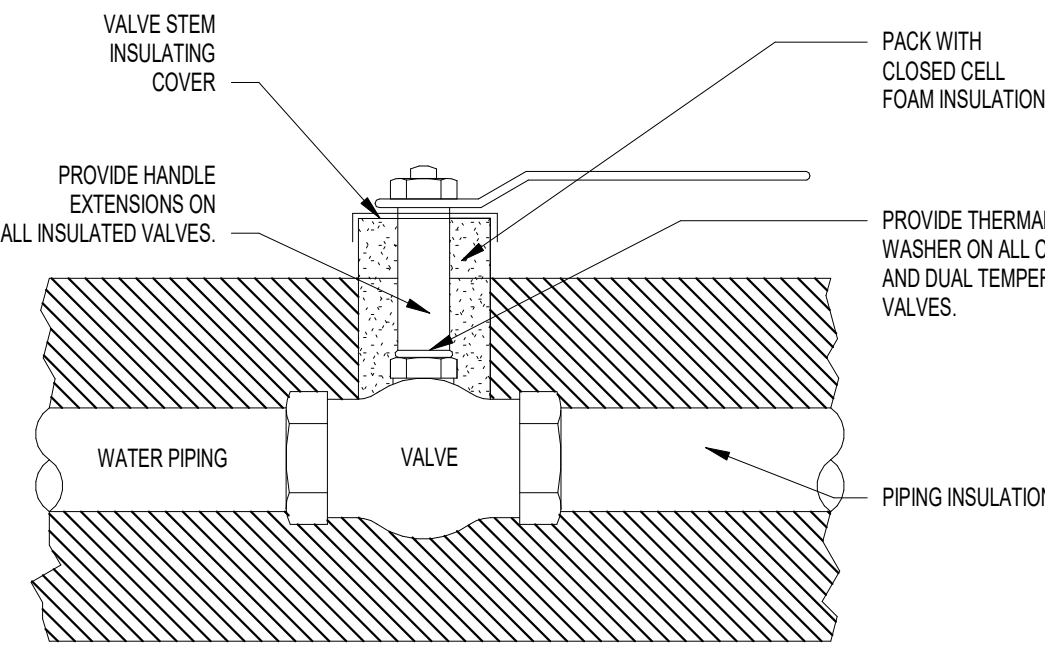


3 TYPICAL BALL VALVE INSTALLATION DETAIL
MF-P700 NOT TO SCALE

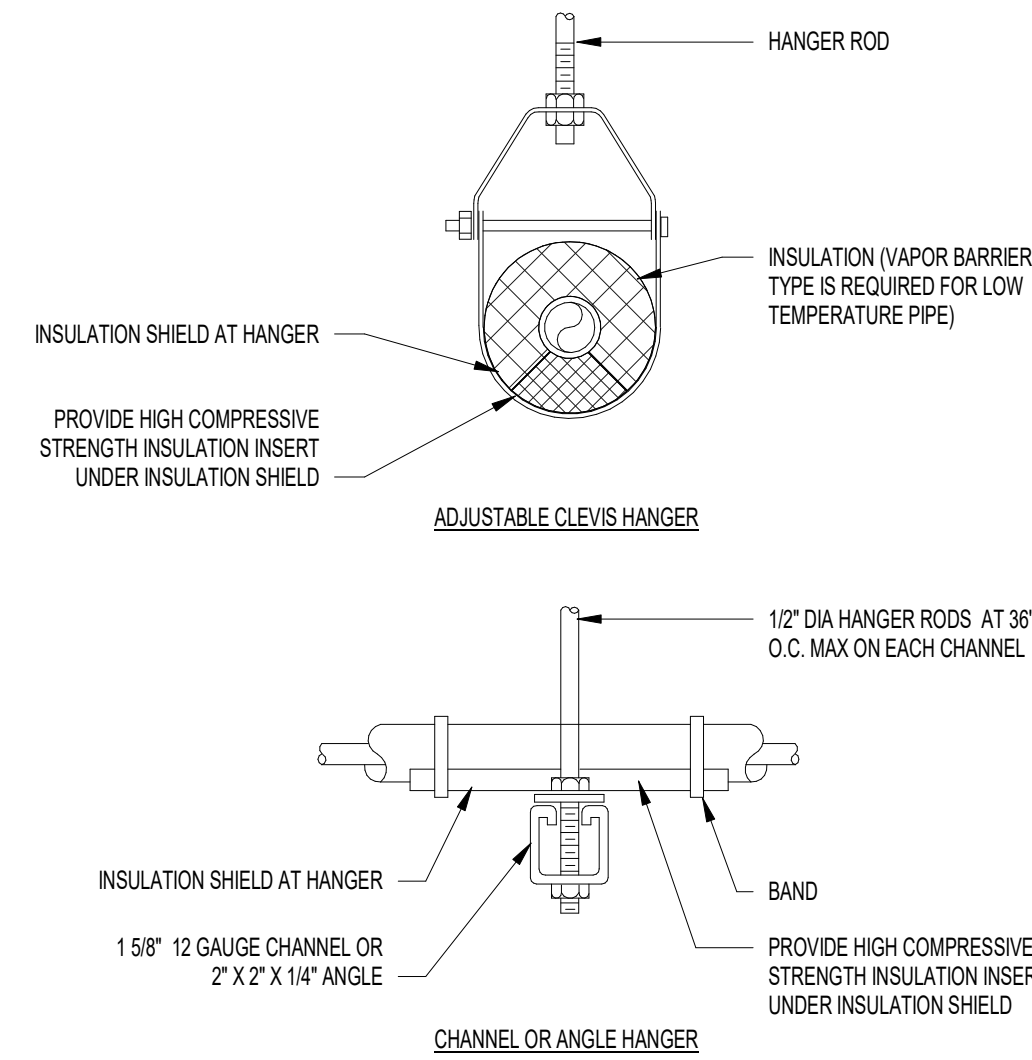



5 PIPE HANGER DETAIL
MF-P700 NOT TO SCALE

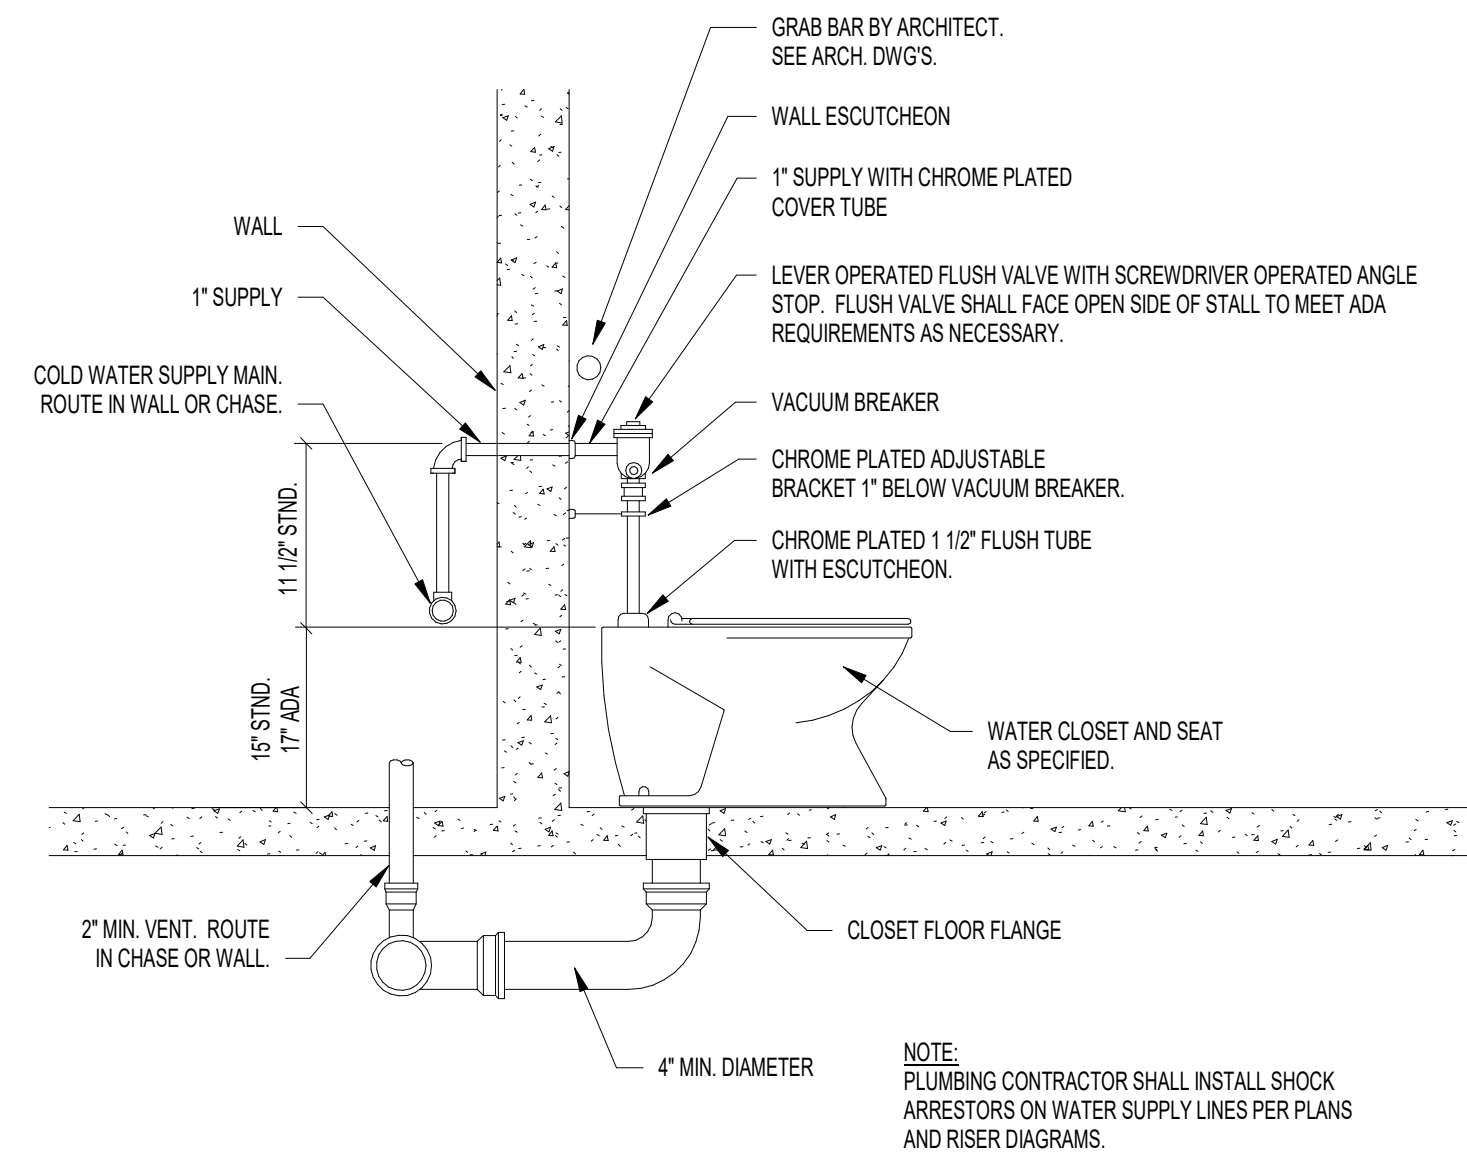

2 FLOOR MOUNTED WATER CLOSET DETAIL
MF-P700 NOT TO SCALE

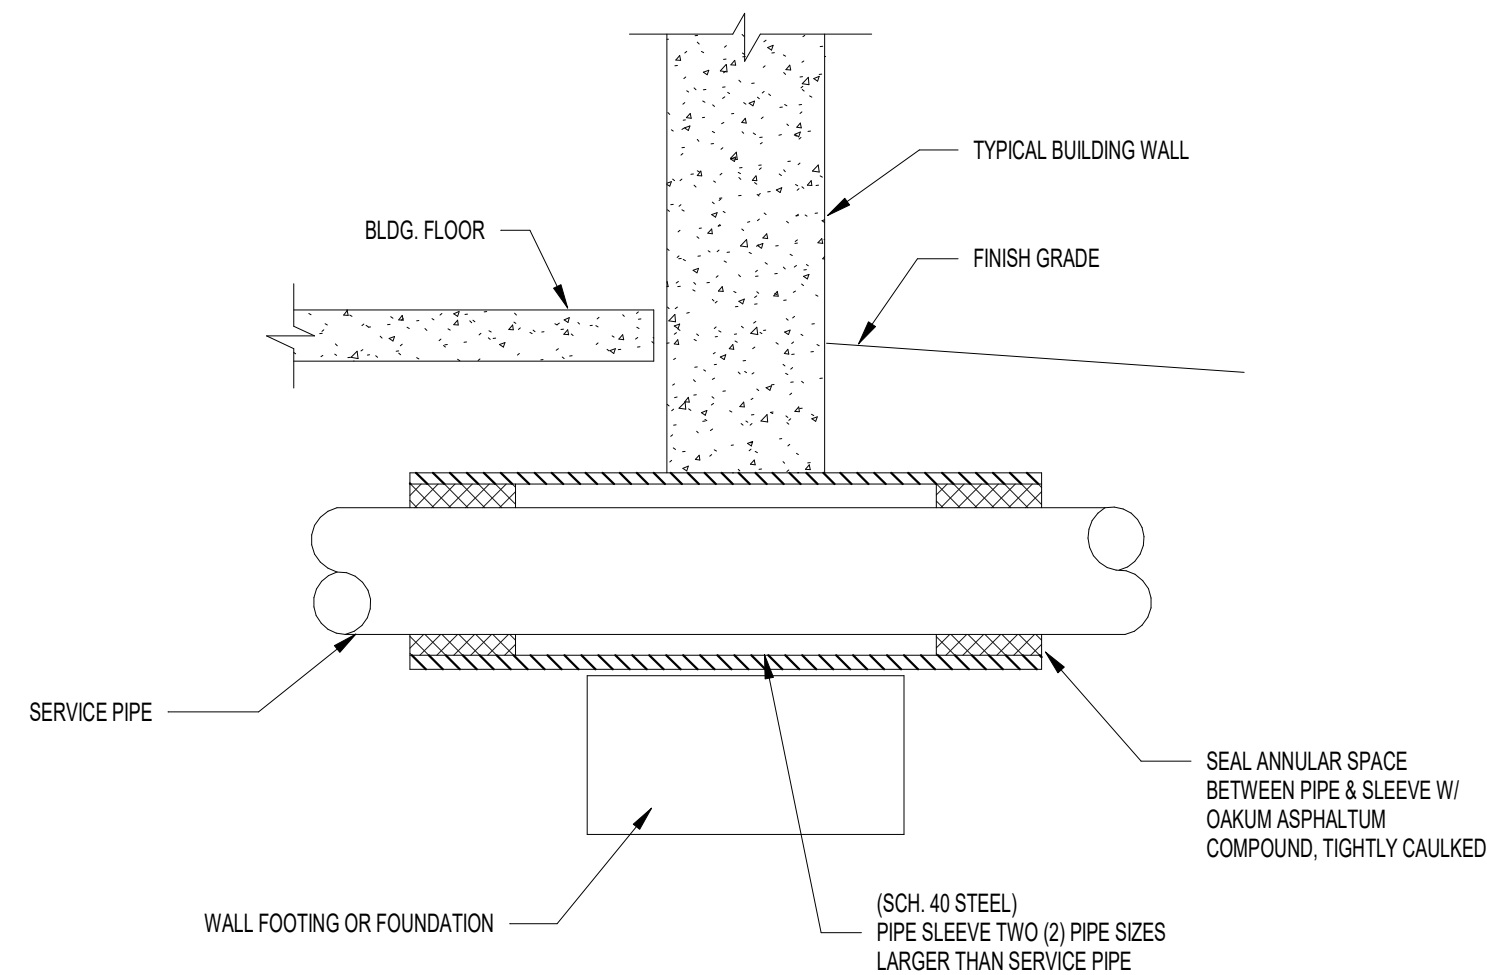


1 TYPICAL PIPE SLEEVE DETAIL - MAINTENANCE FACILITY
MF-P700 NOT TO SCALE

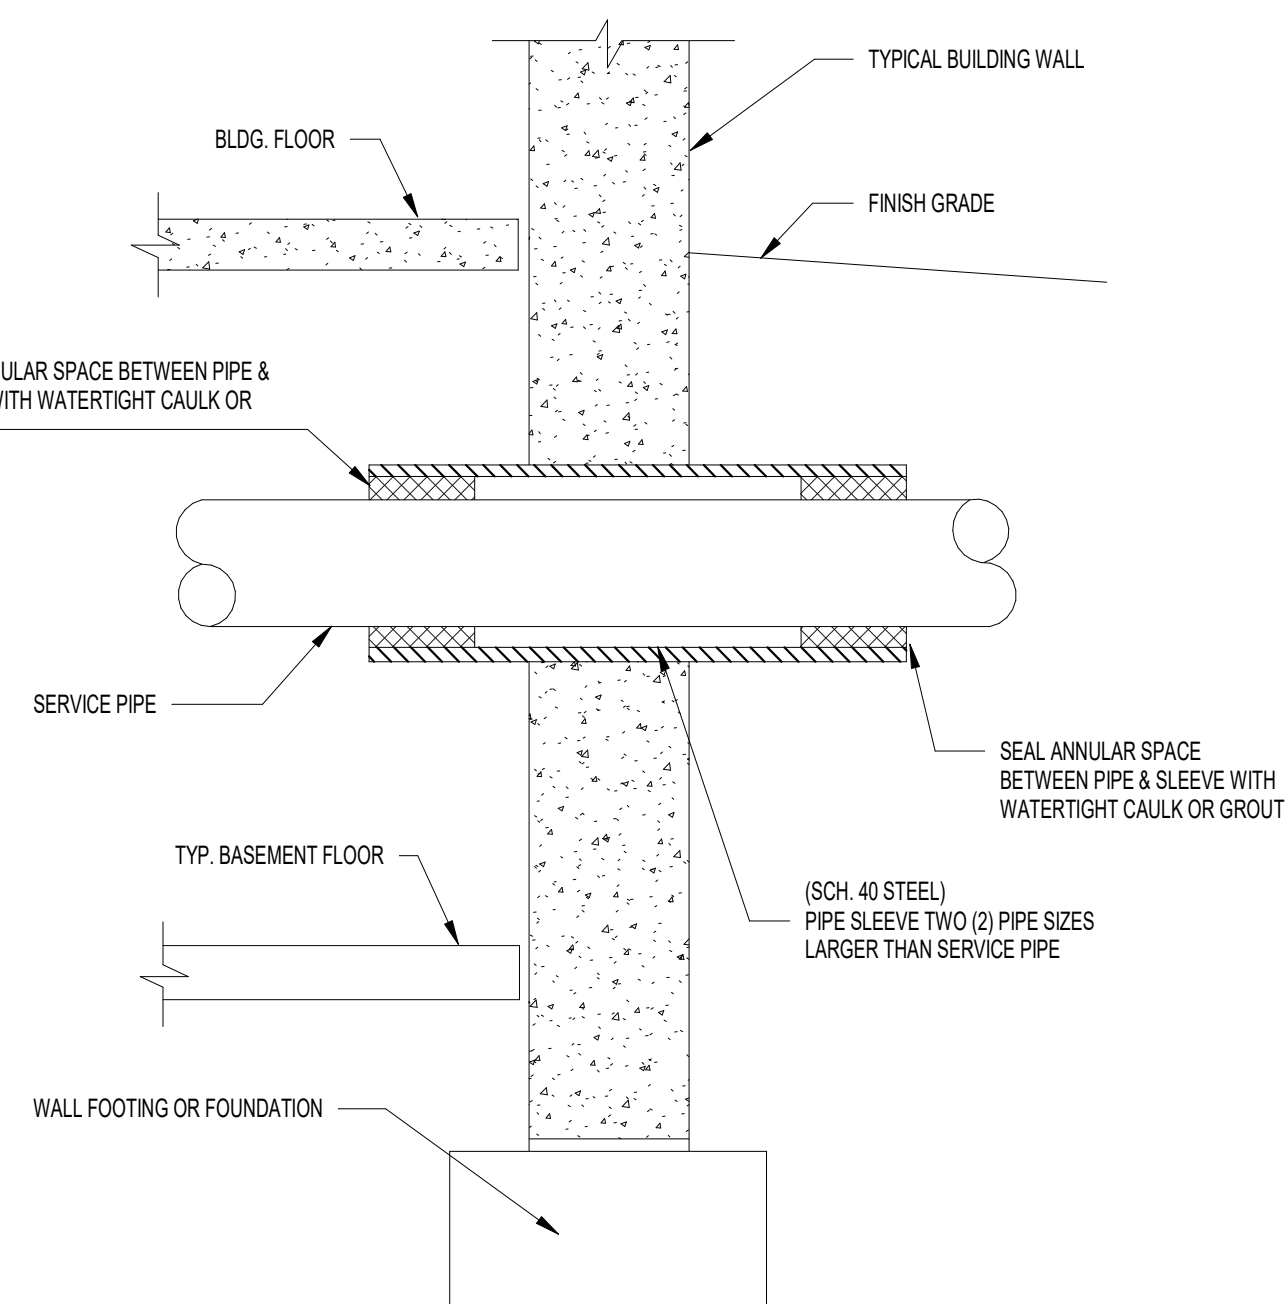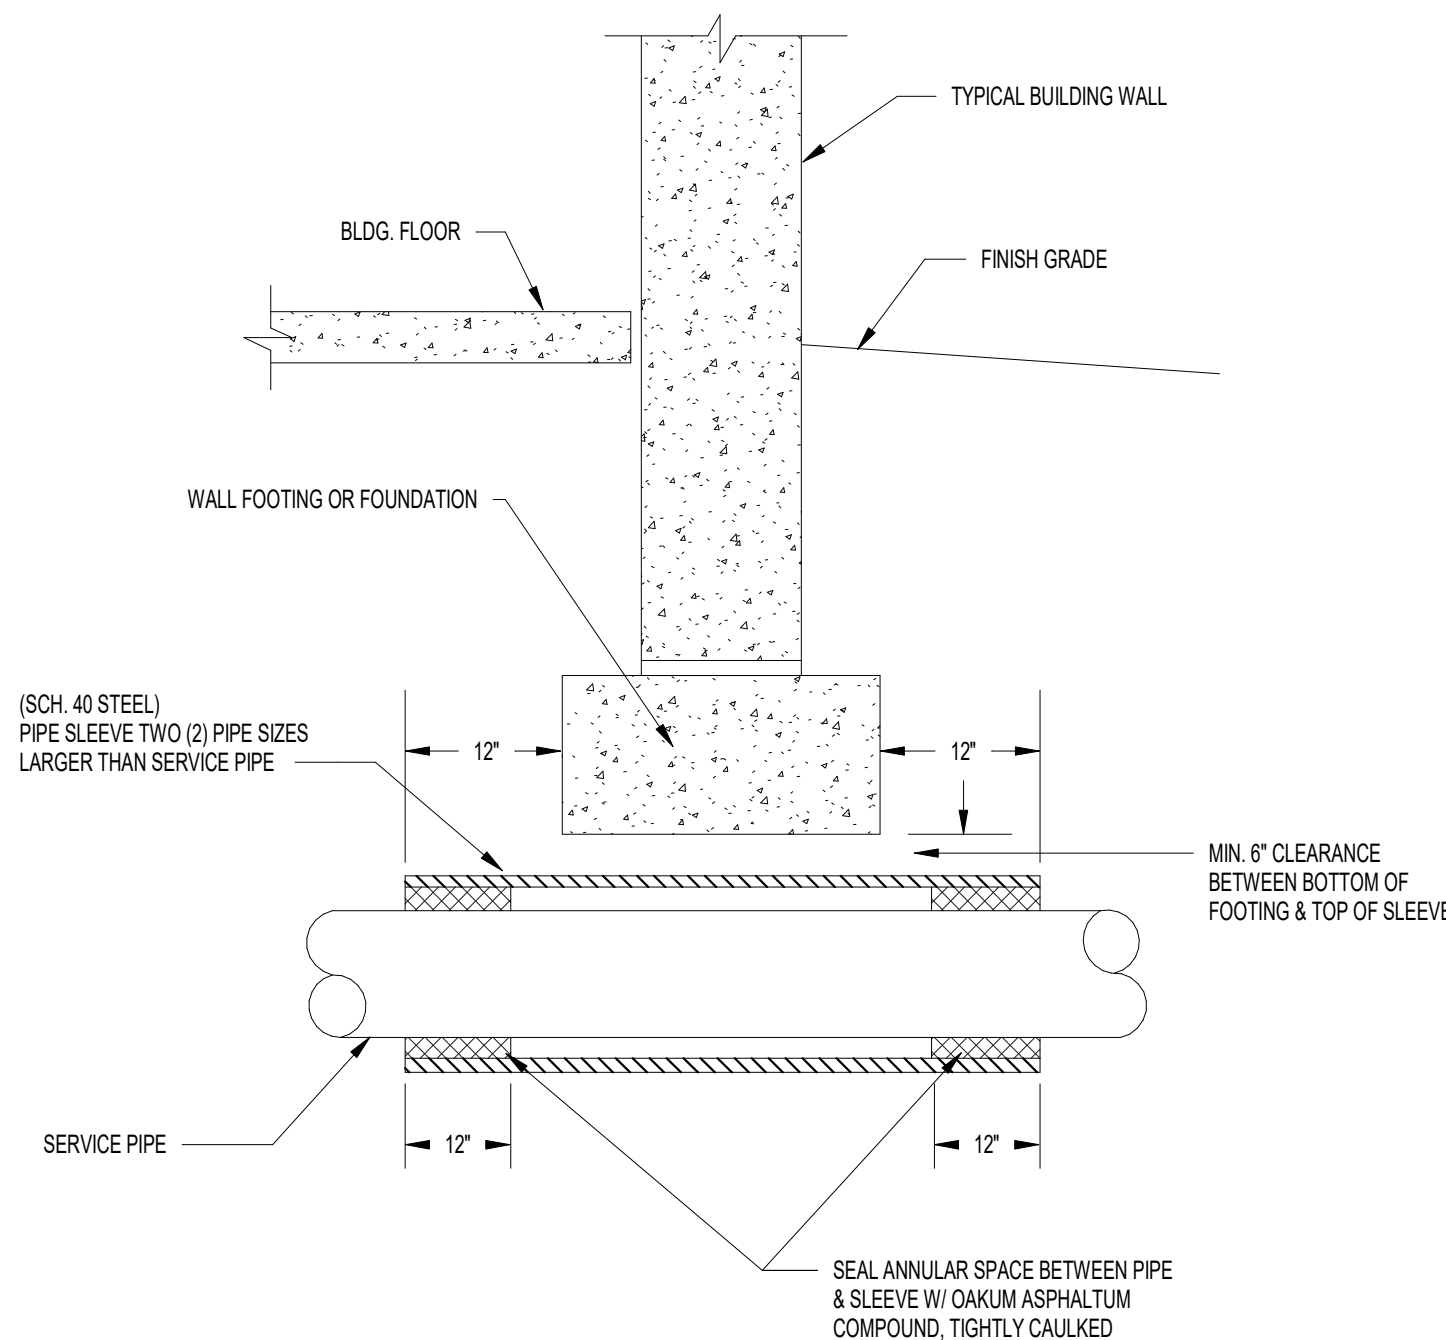

Susan Hatchell
Landscape Architecture, PLLC
711 W. North Street, Raleigh, NC 27603
p: 919-838-9600 f: 919-838-9700

Wooten
120 North Boylan Avenue • Raleigh, NC 27603-1423
(919) 828-0031 • newwoodcompany.com
License Number: 1749115

DETAILS

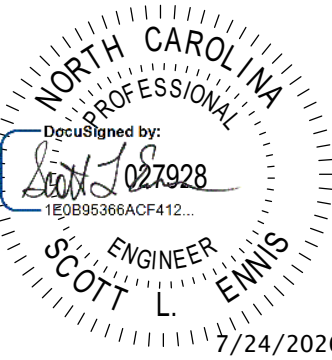

LAKE MYRA COUNTY PARK
Wake County, NC

REVISIONS	


Date: 07/27/26
MF-P700

* NOTE *


ALL OF GENERAL NOTES ON THIS SHEET ARE TO BE APPLIED TO ALL OTHER DRAWINGS IN THIS SET. THE SYMBOLS AND ABBREVIATIONS SHOWN ON THIS SHEET MAY OR MAY NOT BE USED IN THIS SET OF DRAWINGS.

THE PIPING IN A LEGIBLE MANNER AT NO GREATER DISTANCE THAN 10'-0" ON CENTER. ALL PIPING IN BLUE, HOT HEATING WATER- RED, DHW MAKEUP- GREEN.


18. A MANUAL AIR VENT SHALL BE INSTALLED AT EVERY HIGH POINT OF THE ENTIRE HYDRONIC PIPING SYSTEM.
19. DO NOT INSTALL HYDRONIC PIPING OR DUCTWORK OVER AND ELECTRICAL SWITCHGEAR OR PANEL BOXES.
20. THE MECHANICAL CONTRACTOR SHALL PROVIDE ALL ACCESS DOORS AS REQUIRED FOR CODE COMPLIANCE. MAINTENANCE. THE DRYWALL CONTRACTOR WILL PROVIDE THE REQUIRED FINISHES.
21. FLEXIBLE PIPE CONNECTIONS SHALL BE PROVIDED AT ALL HYDRONIC PIPING CONNECTIONS AT CHILLER PLANT.
22. ALL BELT DRIVEN EQUIPMENT SHALL BE PROVIDED WITH A NEW BELT AT FINAL COMPLETION AND A NEW BELT AT 5 YEARS.
23. PIPING SHALL BE COLOR CODED AS FOLLOWS WITH FLOW ARROWS AND LABELS AT 10 FOOT INTERVALS. PENETRATIONS: SEE SPECIFICATIONS FOR COLORS.
24. ALL DETAILS ARE APPLICABLE TO THE INSTALLATION OF THE MECHANICAL SYSTEMS ON THIS PROJECT.
25. ALL EXPOSED DOUBLE WALL ROUND DUCTWORK SHALL BE PROVIDED WITH "PAINT GRIP" FINISH. DUCTWORK SHALL BE PAINTED TO MATCH THE FINISH OF THE SURFACE IT IS EXPOSED TO.

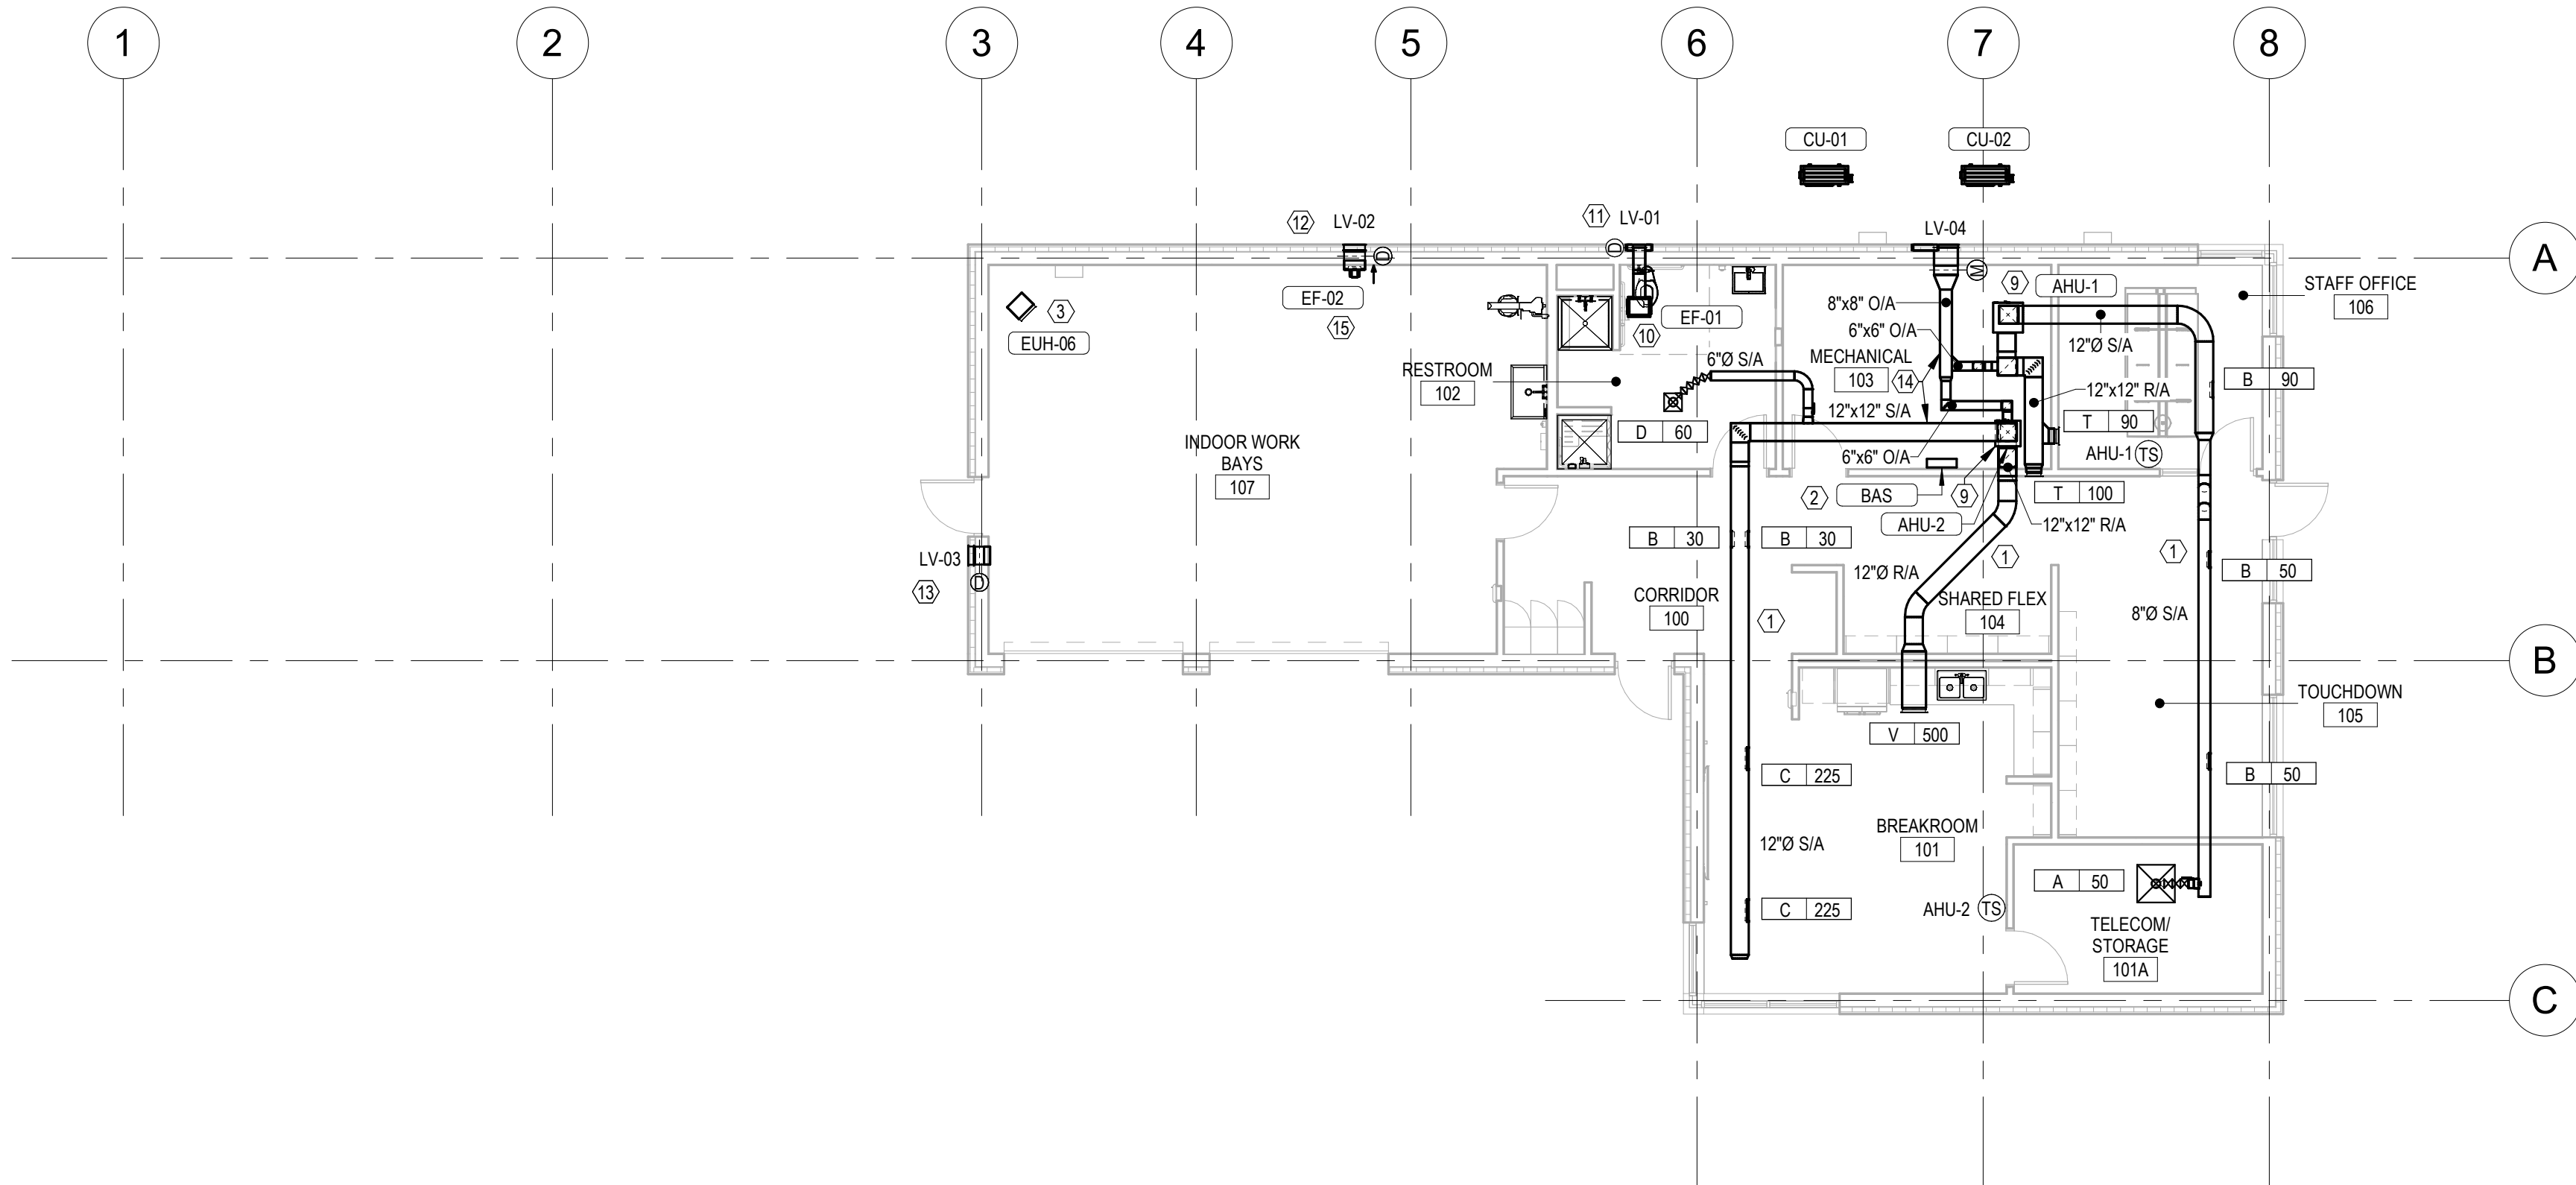

3 HVAC PLAN
MF-M101
1/8" = 1'-0"

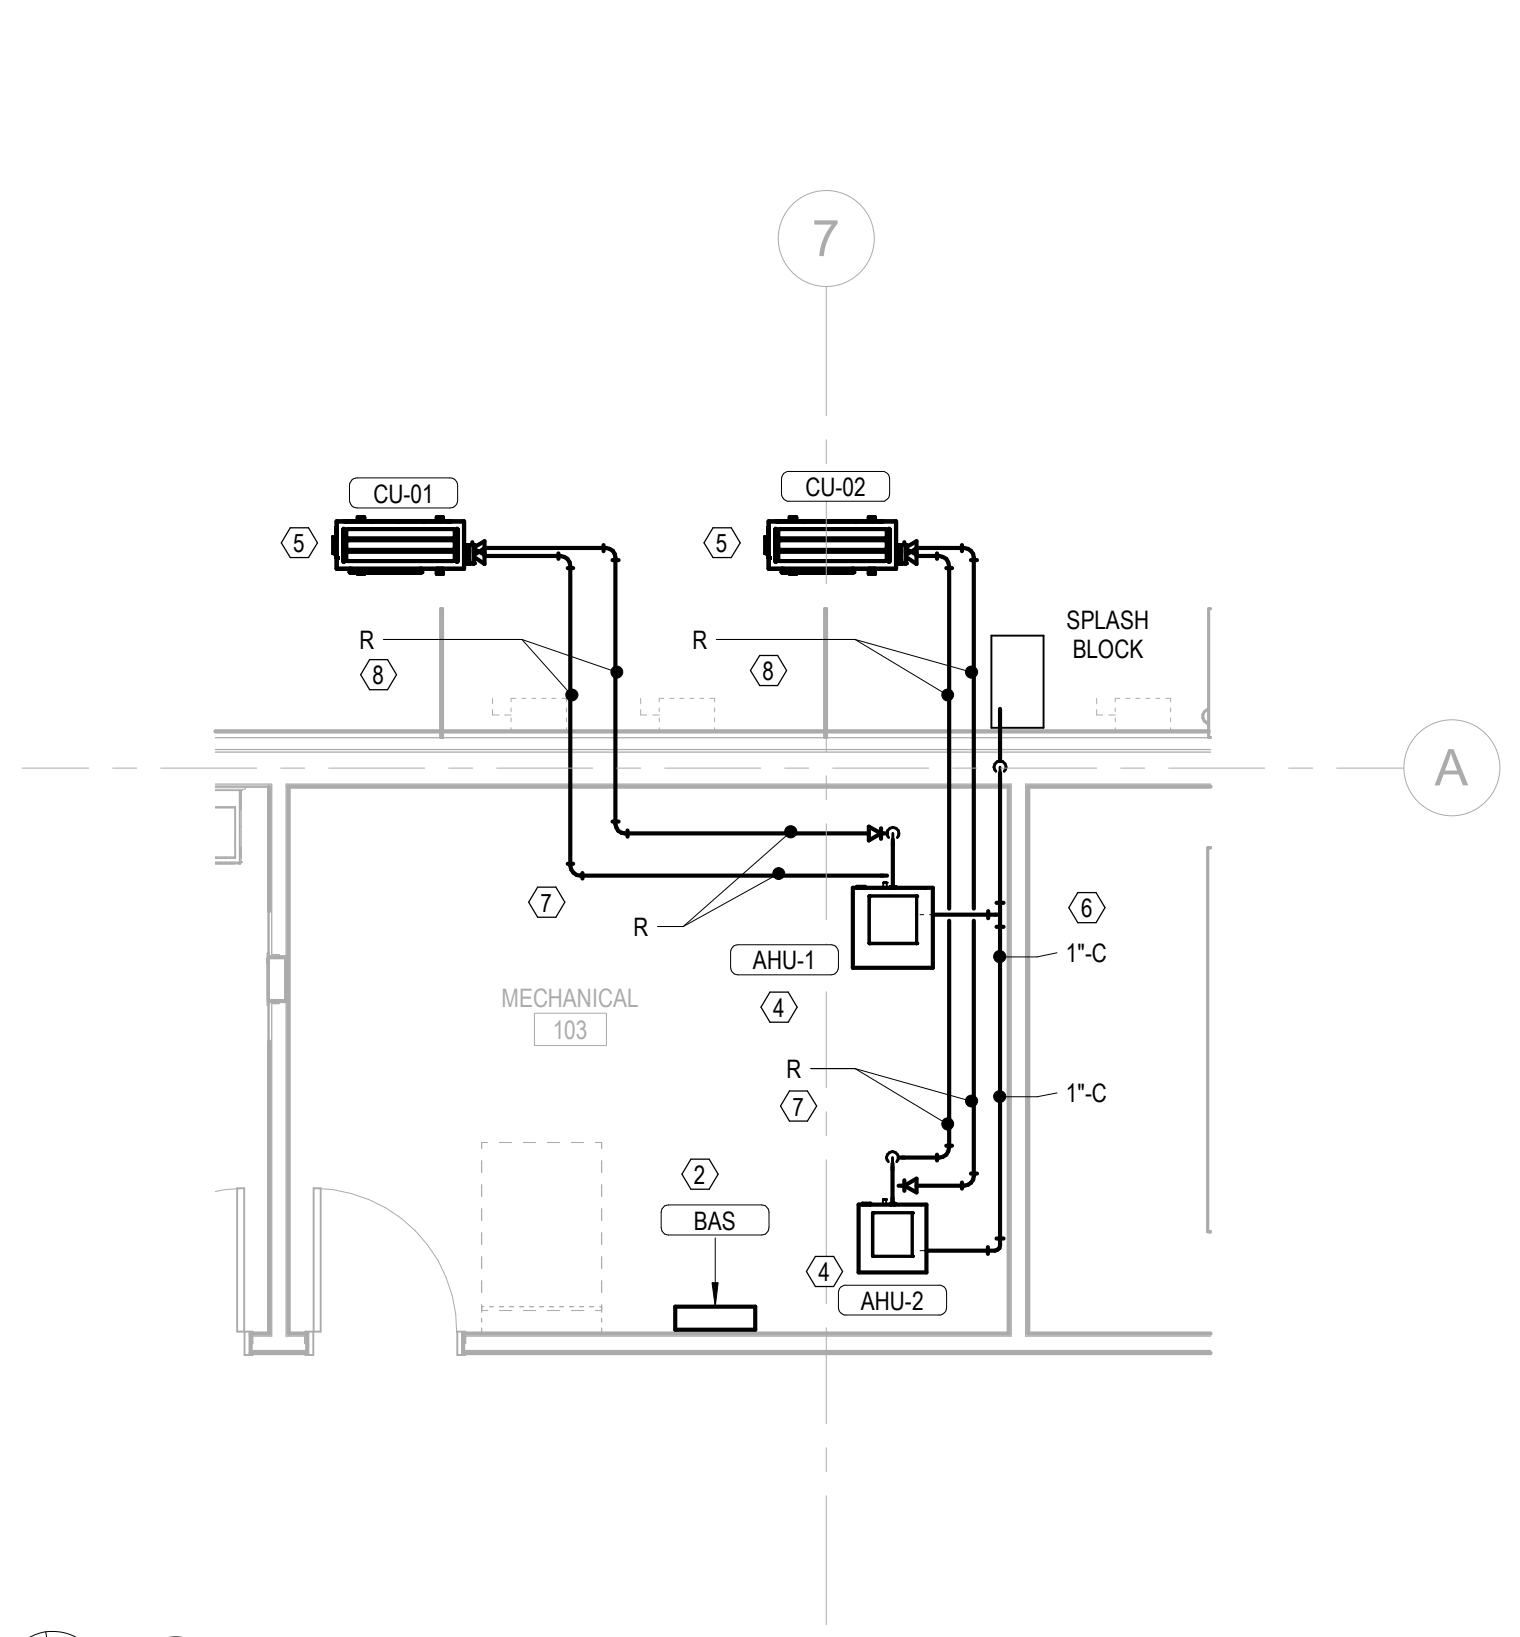

2 PIPING PLAN CALLOUT
MF-M101
1/4" = 1'-0"

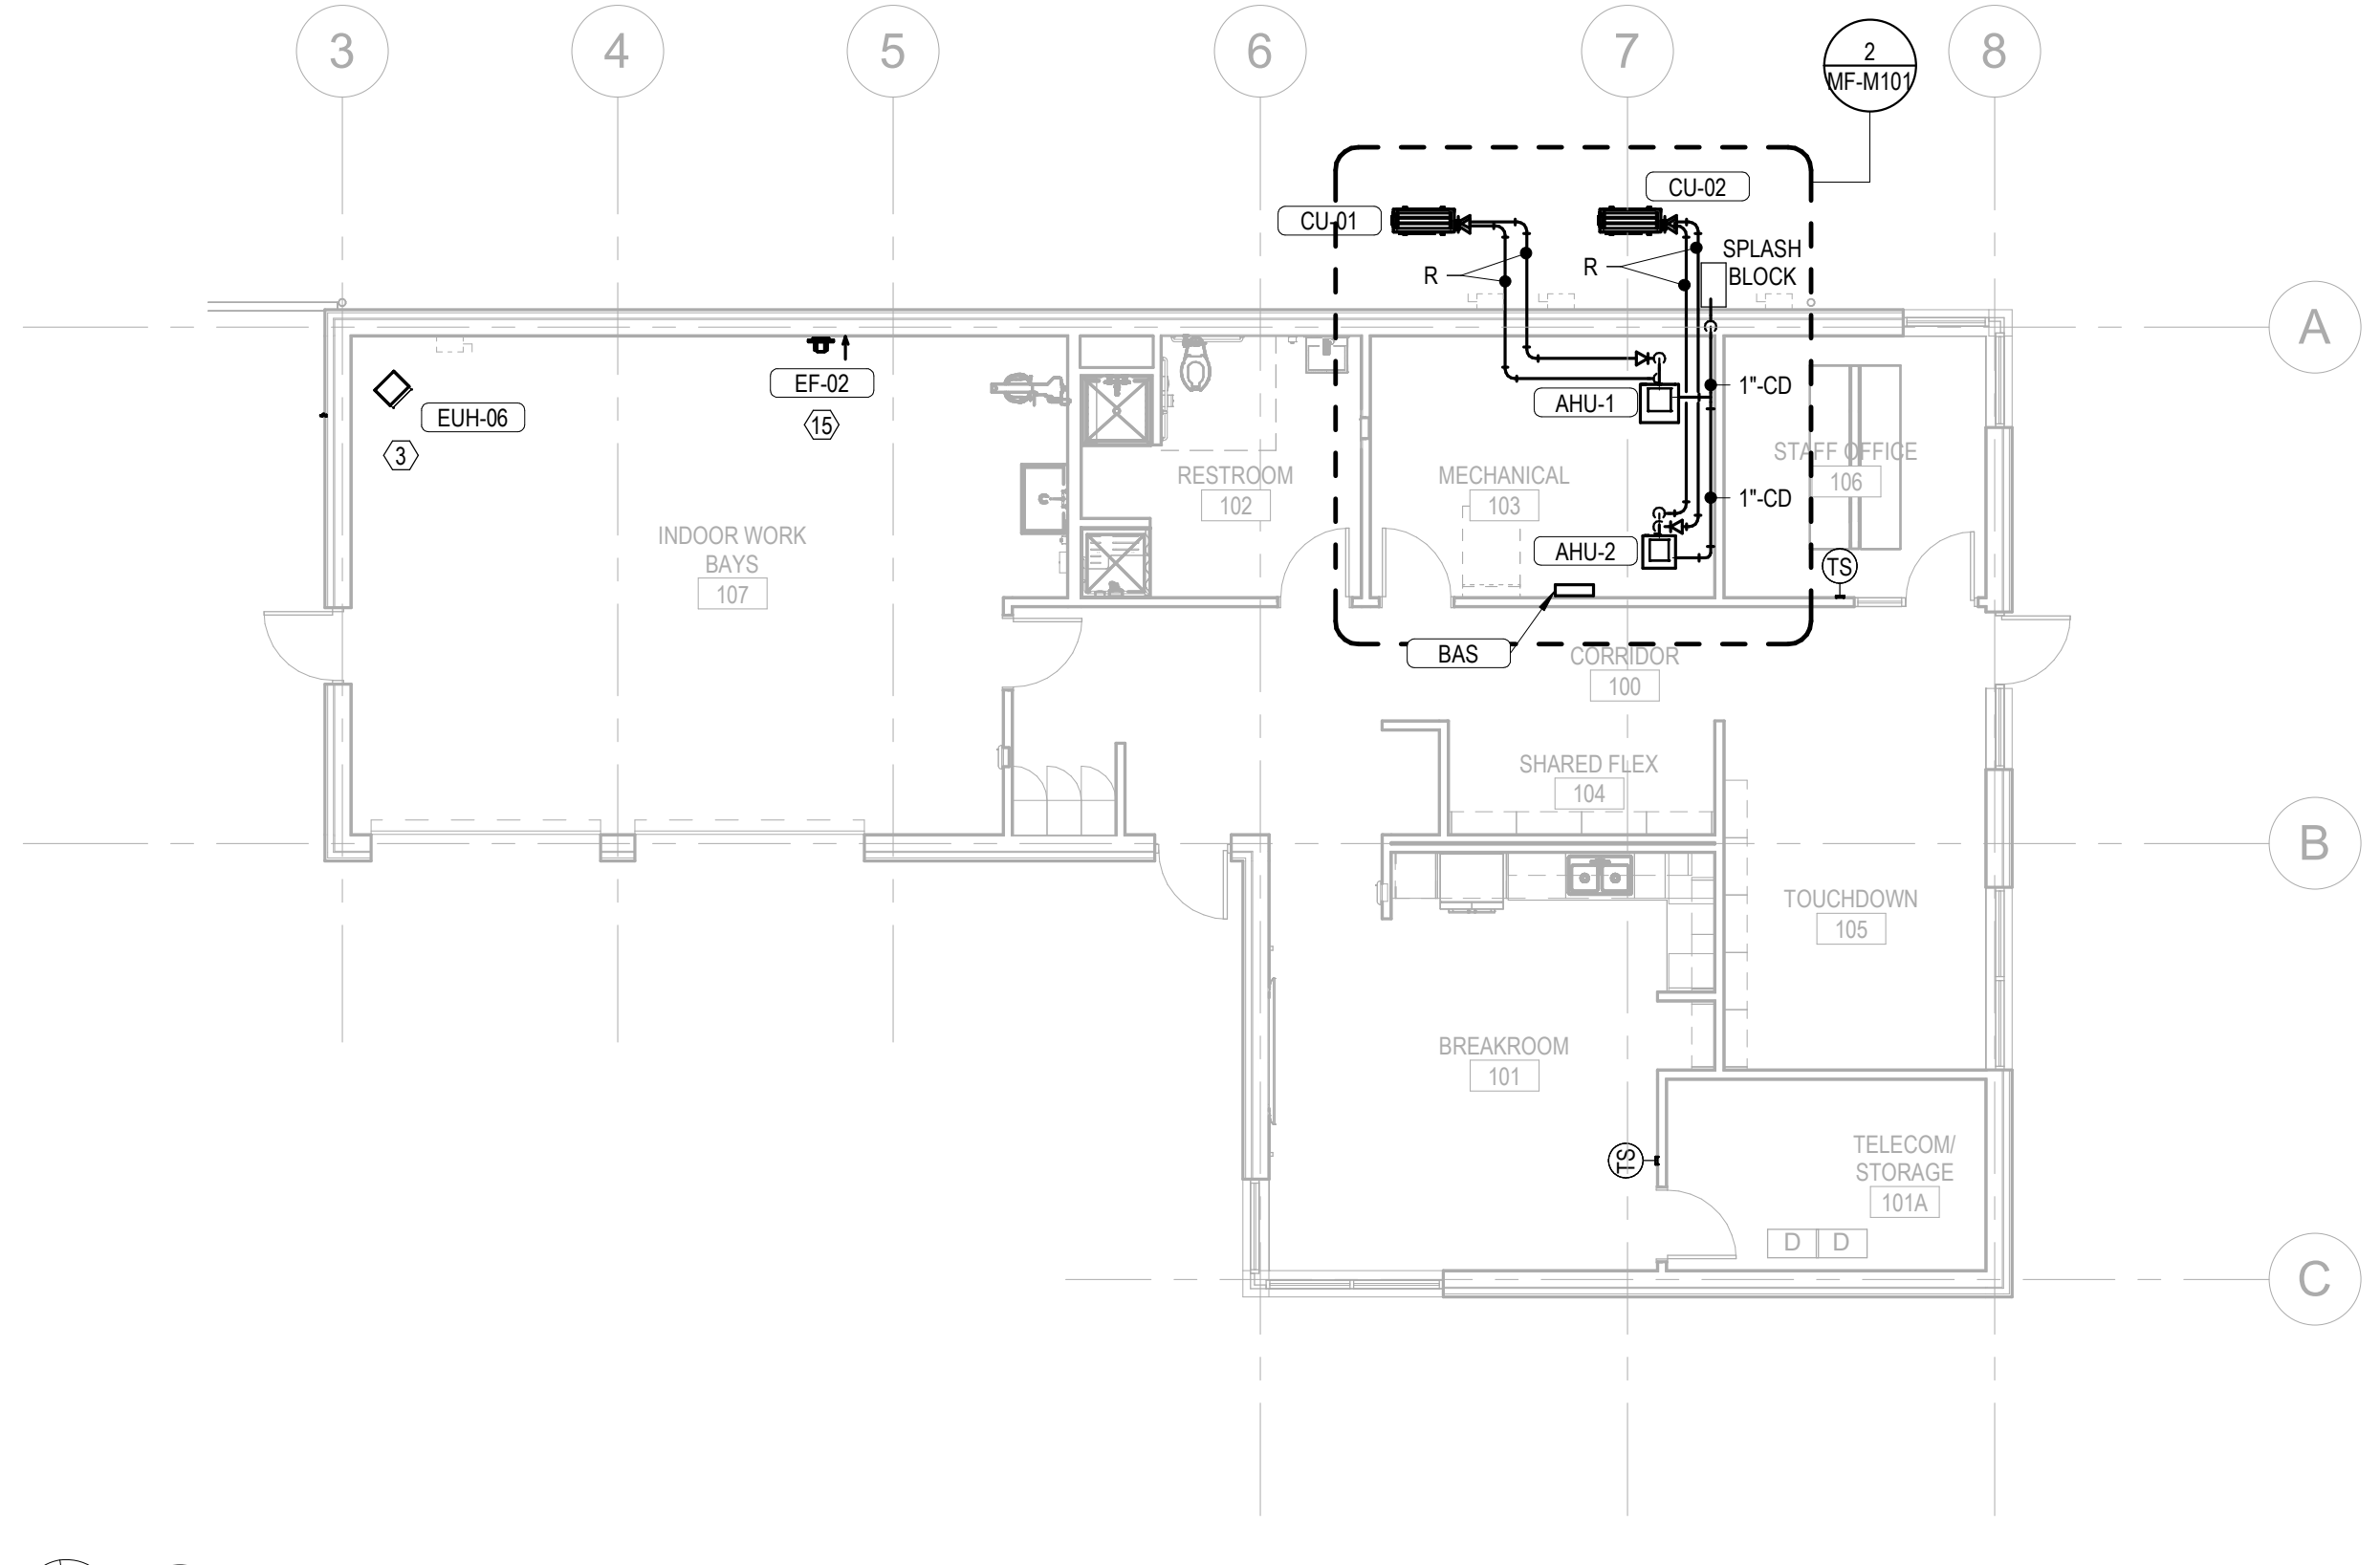

1 PIPING PLAN
MF-M101
1/8" = 1'-0"

KEY NOTES

- 1 EXPOSED DUCTWORK IS ROUND DOUBLE WALLED PER SPECIFICATION.
- 2 INSTALL BAS PANEL IN MECHANICAL ROOM.
- 3 INSTALL UNIT HEATER HIGH IN WORK BAY PER MANUFACTURER'S INSTALLATION INSTRUCTIONS AND CLEARANCES.
- 4 INSTALL AHU PER MANUFACTURER'S INSTALLATION INSTRUCTIONS AND CLEARANCES. PROVIDE REFRIGERANT PIPING FROM HEAT PUMP AT EXTERIOR. PROVIDE CONDENSATE DRAIN PIPING.
- 5 INSTALL HEAT PUMP ON CONCRETE HOUSEKEEPING PAD PER MANUFACTURER'S INSTALLATION INSTRUCTIONS AND CLEARANCES.
- 6 ROUTE CONDENSATE FROM AHU TO EXTERIOR AS INDICATED. DISCHARGE ONTO SPLASH BLOCK SLOPING AWAY FROM BUILDING.
- 7 ROUTE REFRIGERANT PIPING DOWN FROM AHU AND ROUTE LOW THROUGH MECHANICAL ROOM AS INDICATED.
- 8 EXIT REFRIGERANT PIPING LOW THROUGH EXTERIOR WALL AND ROUTE ACROSS GROUND TO HEAT PUMP AS INDICATED.
- 9 INSTALL AIR HANDLING UNIT PER MANUFACTURER'S INSTALLATION INSTRUCTIONS AND CLEARANCES. PROVIDE SUPPLY DUCT TRANSITION AS REQUIRED. PROVIDE RETURN PLENUM ON RETURN AIR INLET. CONNECT RETURN DUCTWORK INTO PLENUM.
- 10 INSTALL EXHAUST FAN PER MANUFACTURER'S INSTALLATION INSTRUCTIONS AND CLEARANCES.
- 11 LOUVER TO BE MOUNTED AT 9'-2" A.F.F. AS MEASURED TO BOTTOM OF LOUVER. MAINTAIN 10' BETWEEN EXHAUST AIR DISCHARGE AND OUTSIDE AIR INTAKE LOCATIONS.
- 12 LOUVER TO BE MOUNTED HIGH IN WORK BAY AT 8'-3" A.F.F. AS MEASURED TO BOTTOM OF LOUVER. MAINTAIN 10' BETWEEN EXHAUST AIR DISCHARGE AND OUTSIDE AIR INTAKE LOCATIONS.
- 13 LOUVER TO BE MOUNTED LOW IN WORK BAY AT 12' A.F.F. AS MEASURED TO BOTTOM OF LOUVER. MAINTAIN 10' BETWEEN EXHAUST AIR DISCHARGE AND OUTSIDE AIR INTAKE LOCATIONS.
- 14 EXPOSED DUCTWORK IN MECHANICAL ROOM SHALL BE SINGLE-WALL RECTANGULAR CONSTRUCTION WITH WRAP INSULATION. ROUTE HIGH THROUGH SPACE. MAINTAIN MINIMUM 6'-8" CLEAR BELOW DUCTWORK.
- 15 INSTALL EXHAUST FAN PER MANUFACTURER'S INSTALLATION INSTRUCTIONS AND CLEARANCES.

Susan Hatchell
Landscape Architecture, PLLC
711 W. North Street, Raleigh, NC 27603
p: 919-838-9600 f: 919-838-9700


Wooten
120 North Boylan Avenue • Raleigh, NC 27603-1423
(919) 828-0031 • info@wootencompany.com
License Number: 7-9715

FLOOR PLAN


DESIGNED BY
SCOTT L. EWING
ENGINEER
NORTH CAROLINA PROFESSIONAL
022328
1E0B9336AC4F412
7/24/2026

LAKE MYRA COUNTY PARK
Wake County, NC

REVISIONS	
Date: 07/27/26	
MF-M101	

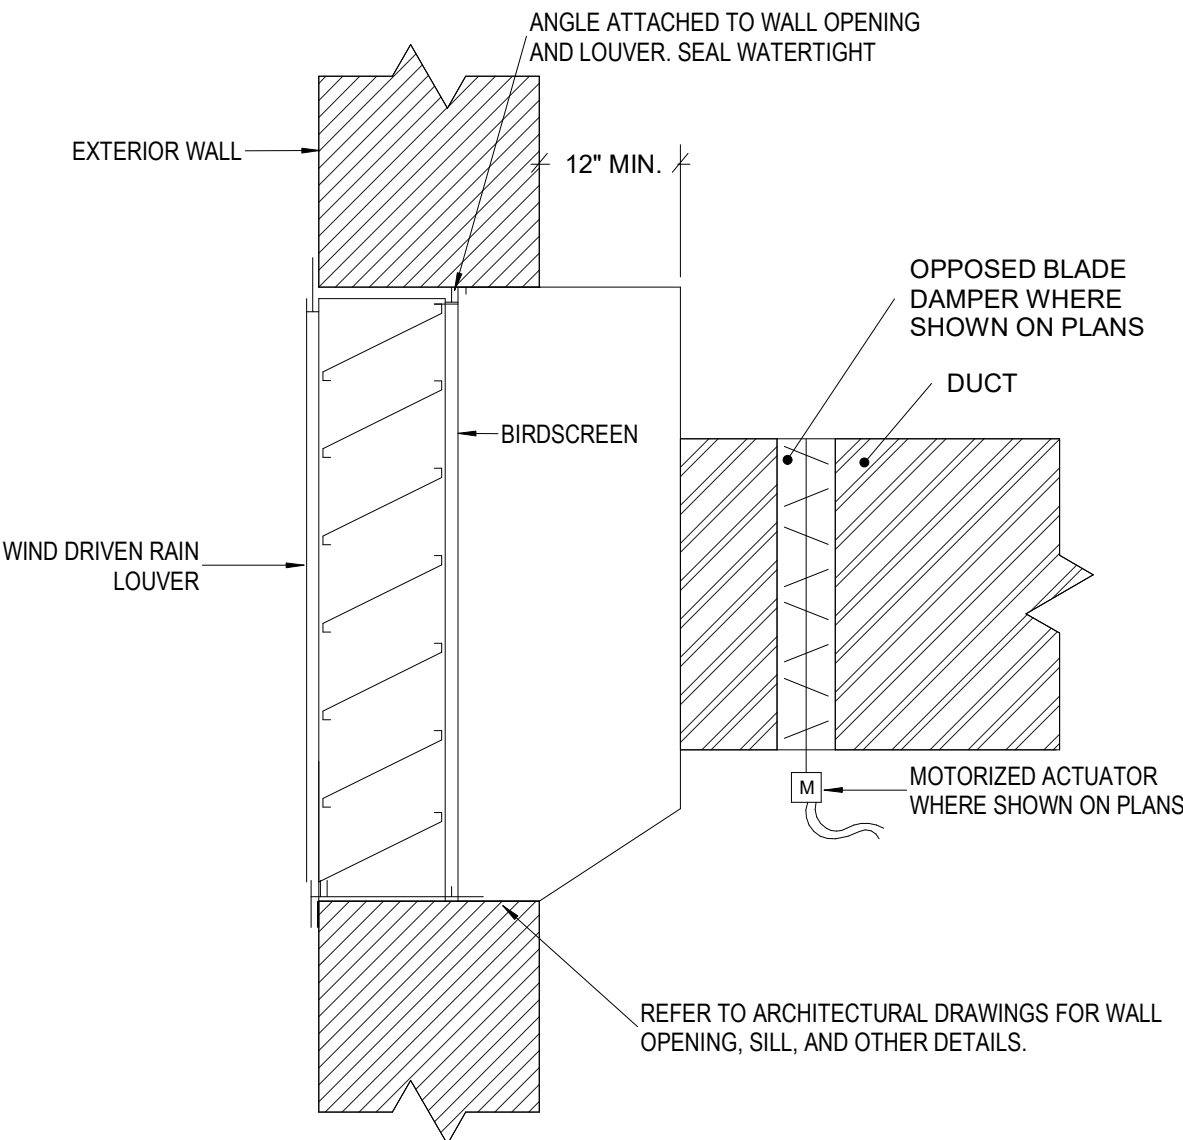


1
MF-M601
DETAIL - OUTSIDE AIR/EXHAUST LOUVER
NOT TO SCALE

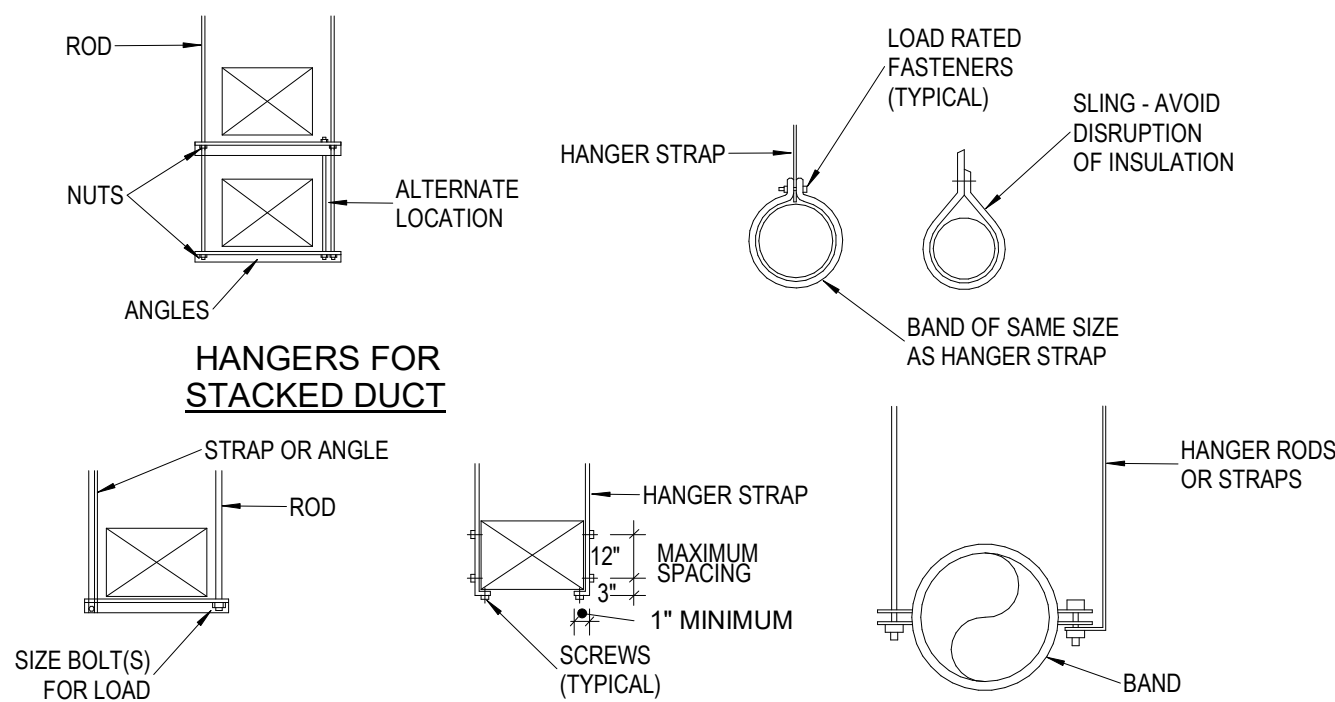


TRAPEZE HANGERS STRAP HANGERS ROUND DUCT SUPPORT

- NOTES:
- REINFORCEMENT MAY BE USED FOR ATTACHMENT IF IT QUALIFIES FOR BOTH DUTIES.
 - DO NOT EXCEED LOAD RATINGS FOR METHOD USED. FROM SMACNA DUCT STANDARDS


2
MF-M601
DETAIL - TYPICAL DUCT HANGERS
NOT TO SCALE

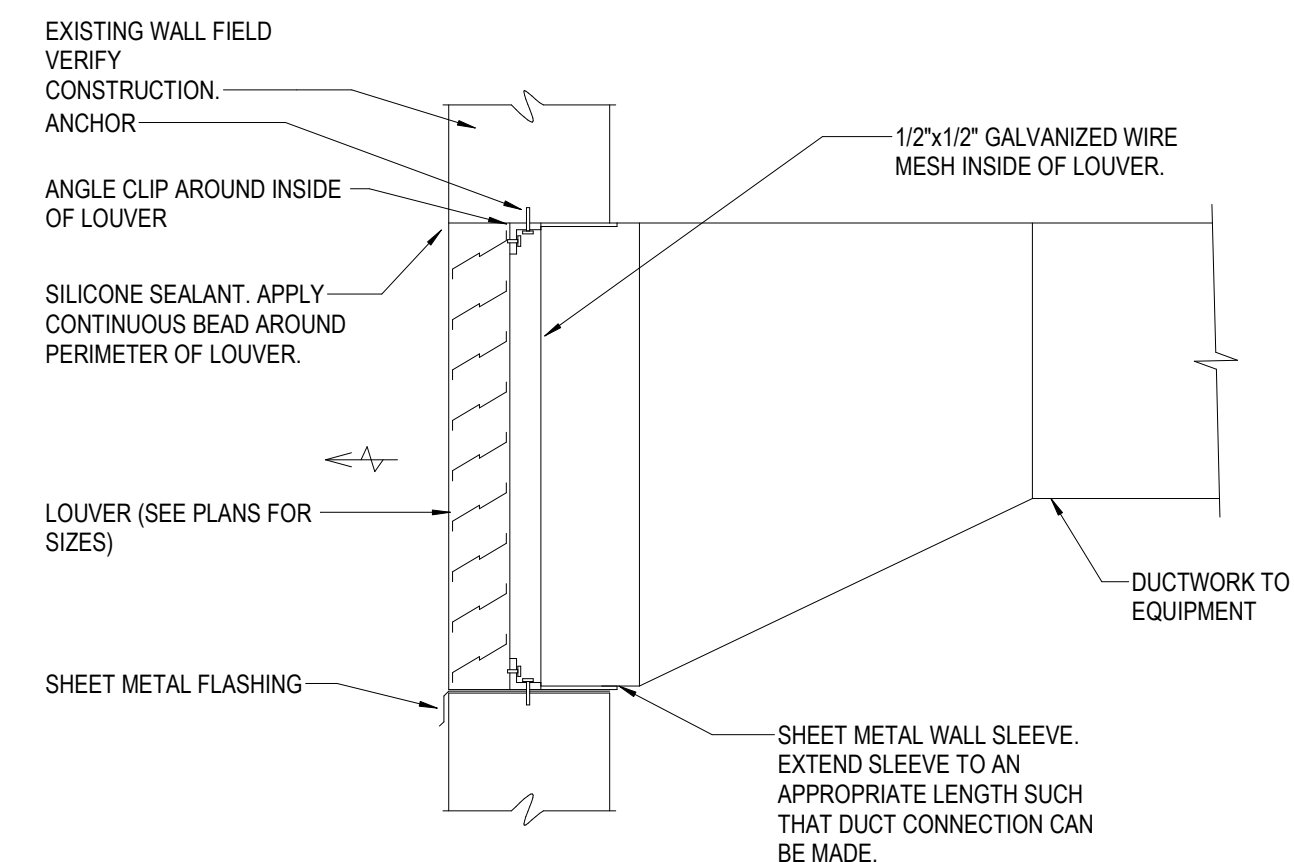

3
MF-M601
LOUVER ASSEMBLY DETAIL
NOT TO SCALE

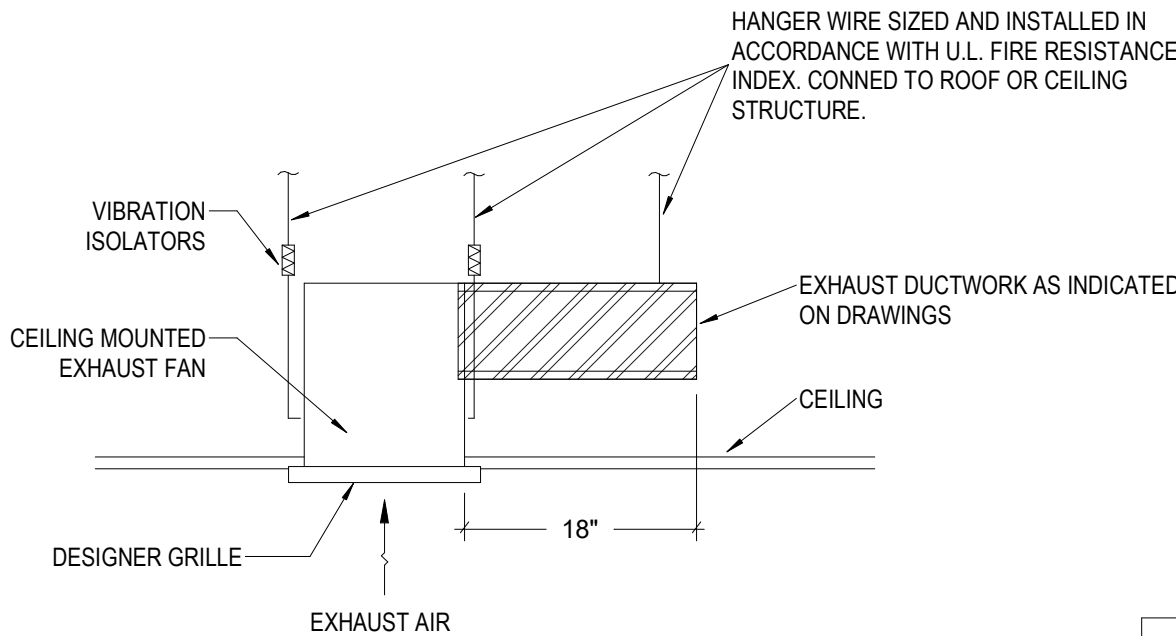


4
MF-M601
DETAIL - CEILING MOUNTED EXHAUST FAN
NOT TO SCALE

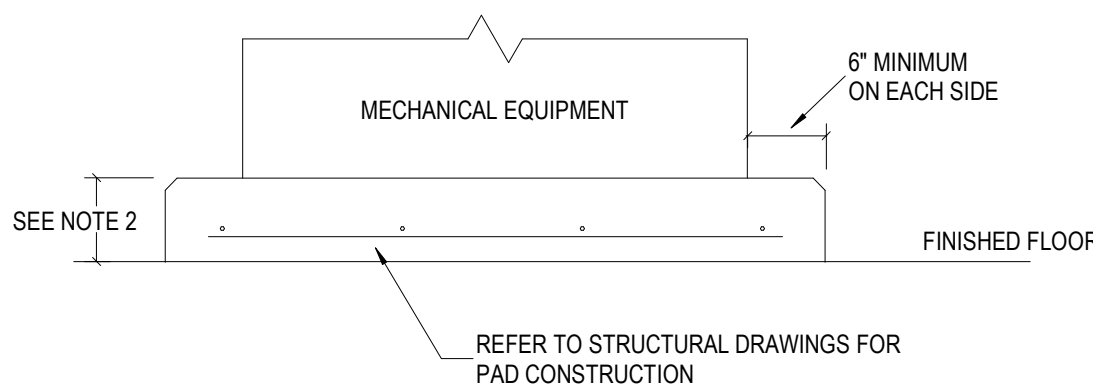


- NOTES:
- ACTUAL PAD SIZE TO BE DETERMINED BY CONTRACTOR, AFTER ALL EQUIPMENT HAS BEEN REVIEWED.
 - PAD SHALL BE 6" HIGH FOR BOILERS AND 4" HIGH FOR ALL AHU'S AND OTHER MECHANICAL EQUIPMENT.

5
MF-M601
DETAIL - MECHANICAL EQUIPMENT SUPPORT PAD
NOT TO SCALE

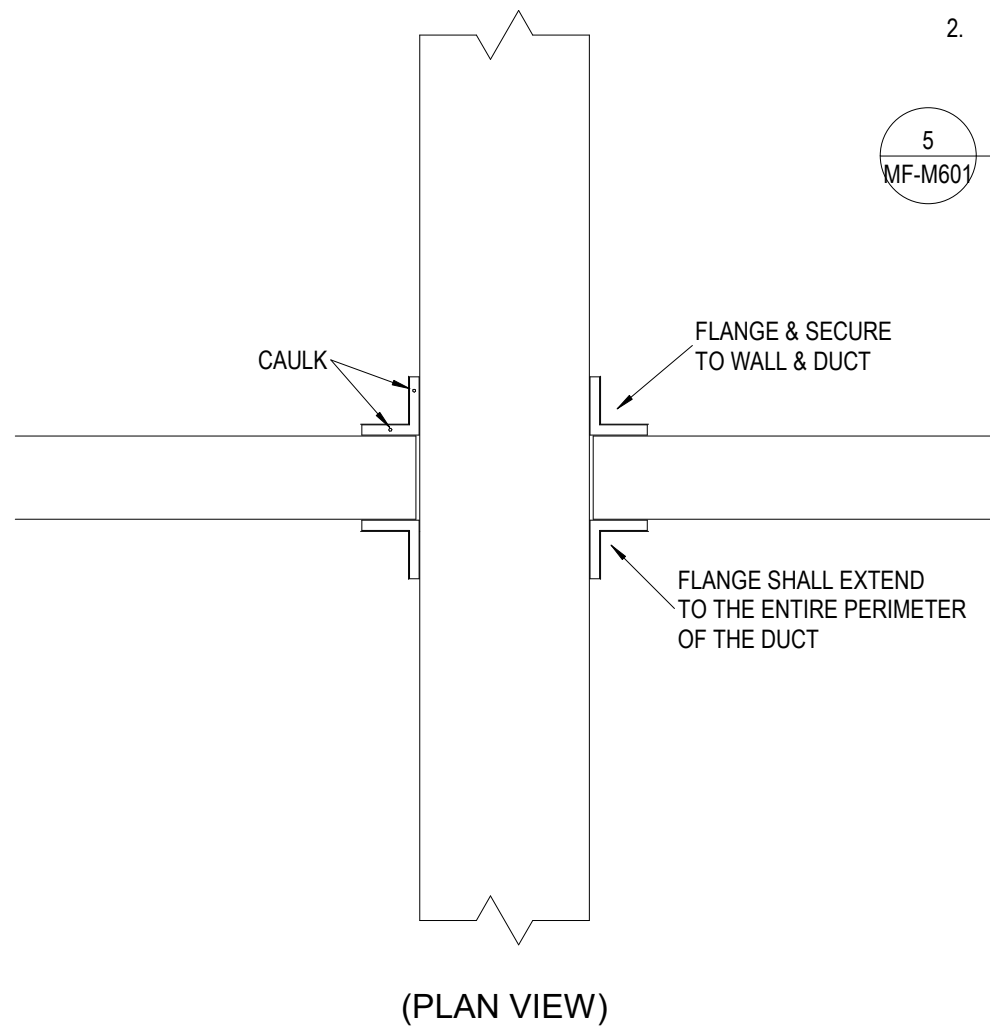

6
MF-M601
DETAIL - NON-RATED DUCT PENETRATION
NOT TO SCALE

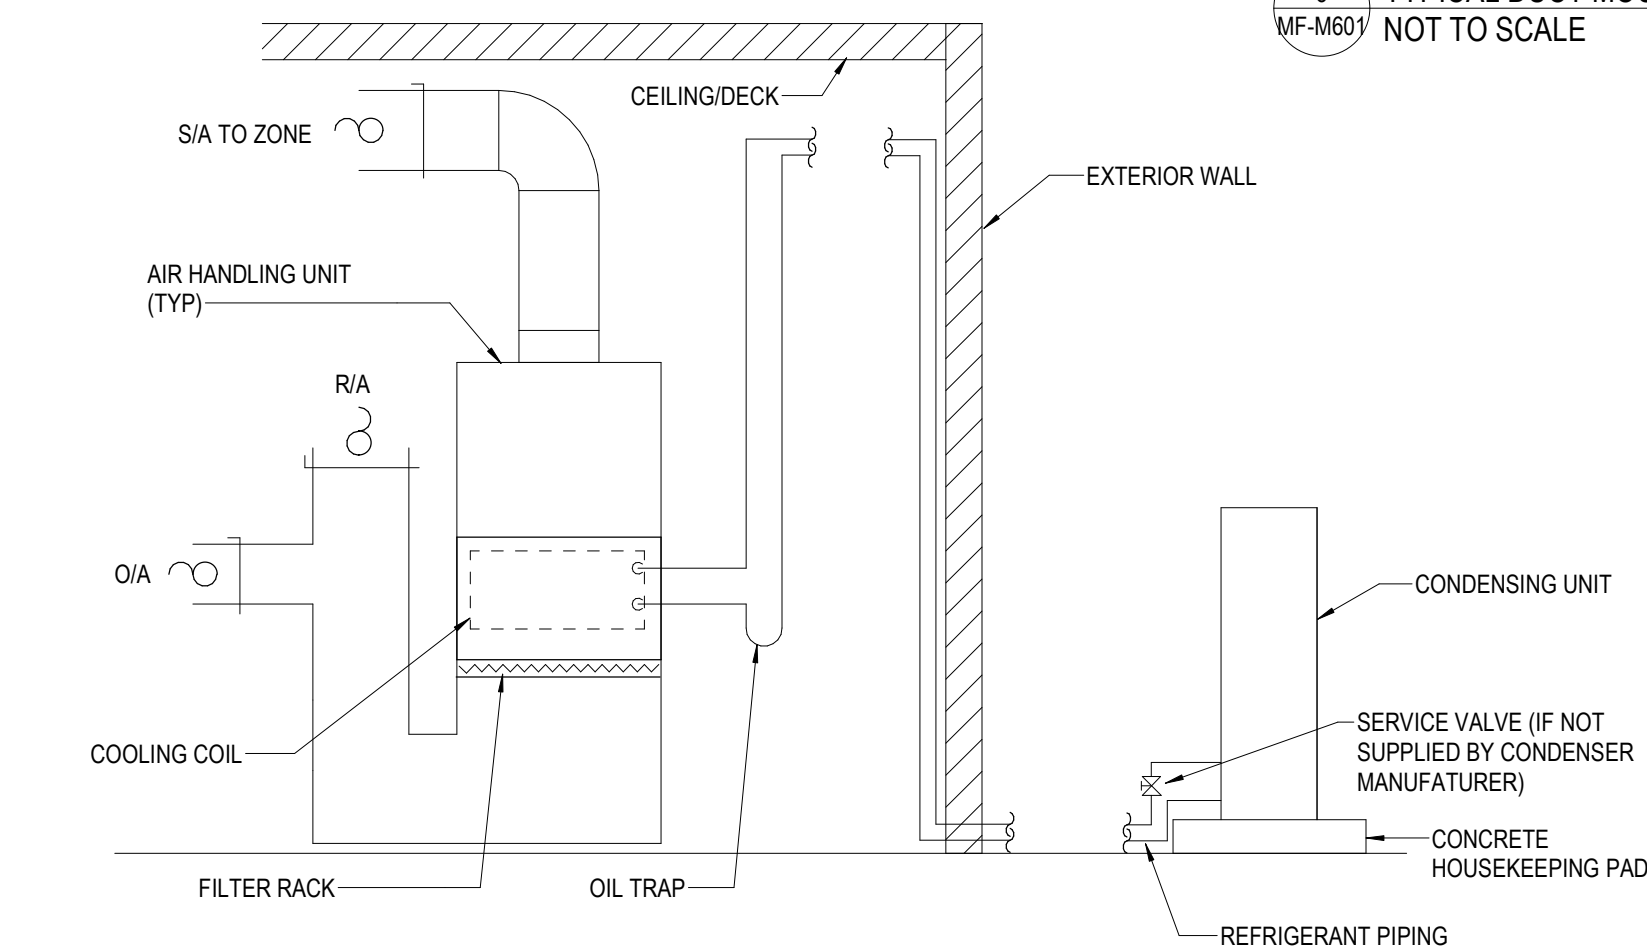

7
MF-M601
DETAIL - SPLIT SYSTEM INSTALLATION W/ VERTICAL AHU
NOT TO SCALE

Maintenance Building Unit Heater Schedule										
Identity	Manufacturer	Model	Heating Airflow Design		Electric Heat		Electrical		Product Weight	Remarks
			Output	Airflow	Rating	Load	Voltage	Phase		

GENERAL NOTES:

- BASIS OF DESIGN IS MARKEL.
- EQUIVALENTS: REZNOR, BERKO, INDEECO OR AS LISTED IN SPECIFICATIONS.
- MOUNTING HEIGHTS ARE TO BOTTOM OF UNIT.

REMARKS:

- PROVIDE WALL-MOUNTED 24V THERMOSTAT.
- PROVIDE HANGING BRACKET.
- PROVIDE FACTORY MOUNTED DISCONNECT SWITCH.
- BAS CONTRACTOR TO PROVIDE T-STAT.

Maintenance Building Outdoor Split System Schedule														
Identity	Manufacturer	Model	Nominal Tons	Rated Cooling Capacity	Rated Heating Capacity	Efficiency	Refrigerant Type	Refrigerant Charge	Electrical		MCA	MOCP	Product Weight	Remarks
									Voltage	Phase				
CU-01	Mitsubishi	PUZ-AK12NL-U1	1.0	12,000 Btu/h	19,000 Btu/h	20.0 SEER2, 9.8 HSPF2	R-454B	4.4 lbm	208 V	1	16.0 A	27.0 A	99 lb	
CU-02	Mitsubishi	PUZ-AK18NL-U1	1.5	18,000 Btu/h	23,000 Btu/h	18.6 SEER2, 8.6 HSPF2	R-454B	4.4 lbm	208 V	1	16.0 A	27.0 A	99 lb	

GENERAL NOTES:

- PROVIDE NEOPRENE VIBRATION ISOLATION PADS AND CONCRETE HOUSEKEEPING PAD.
- PERFORMANCE BASED ON 80 DB, 67 WB, AMBIENT 95 DB, 75 WB.
- PROVIDE HAIL GUARDS FOR CONDENSER COILS.
- REFRIGERANT LINE SIZES AS RECOMMENDED BY THE EQUIPMENT MANUFACTURER BASED ON HORIZONTAL AND VERTICAL RUNS.

Maintenance Building Indoor Split System Schedule															
Identity	Manufacturer	Model	Product Type	Nominal Capacity	Design Airflow Rate	Outdoor Air Intake Flow	Supply Fan ESP	Aux Heat KW	Aux Heat MCA	Aux Heat MOCP	AHU Motor MCA	Electrical		Product Weight	Remarks
												Voltage	Phase		

GENERAL NOTES:

- MAXIMUM COIL FACE VELOCITY OF 500 FPM. MAXIMUM FILTER FACE VELOCITY OF 300 FPM.
- PROVIDE WITH A DOUBLE SLOPED STAINLESS STEEL DRAIN PAN UNDER ALL COIL SECTIONS. EXTEND PIPING TO FLOOR DRAIN.
- ALL FANS SHALL BE INTERNALLY ISOLATED.
- ALL UNITS SHALL HAVE AN FILTER SECTION WITH 2" MERV-8 FILTERS. PROVIDE ONE SET IN THE UNIT AND THREE EXTRA SETS. ONE EXTRA SET SHALL BE INSTALLED AFTER THE SYSTEM IS BALANCED AND THE BUILDING IS CLEAN. TWO FINAL SETS ARE FOR FUTURE, TURN OVER TO OWNER.
- ALL AIR HANDLERS SHALL BE U.L. LISTED.

REMARKS:

- PROVIDE UNIT WITH AUXILIARY ELECTRIC HEAT ACCESSORY KIT.
- AIR HANDLING UNIT SHALL BE POWERED SEPARATELY FROM OUTDOOR UNIT. PROVIDE SEPARATE POWER KIT SPTB1.
- HEATER SHALL BE POWERED SEPARATELY FROM AIR HANDLING UNIT.
- PROVIDE AUXILIARY HEAT LOCKOUT ACCESSORY TO PREVENT ELECTRIC HEAT FROM OPERATING ABOVE PROGRAMMED SET OUTSIDE TEMPERATURE.

Maintenance Building Fan Schedule												
Identity	Manufacturer	Model	Product Type	Fan Design				Fan Drive Type	Weight	Electrical		Remarks
				Capacity	TSP	bhp	RPM			Voltage	Phase	

GENERAL NOTES:

- PROVIDE ALL DUCT TRANSITIONS FOR FANS.
- THE UNIT HOUSING SHALL BE CONSTRUCTED OF ALUMINUM.
- ALL FANS TO BE U.L. LISTED.
- PROVIDE WITH INTEGRAL DISCONNECT.
- EXTERNALLY OR INTERNALLY MOUNTED DISCONNECT SWITCH FURNISHED BY DIVISION 23 AND INSTALLED BY DIVISION 26.
- EXTERNALLY MOUNTED STARTER FURNISHED BY DIVISION 23 INSTALLED BY DIVISION 26.
- PROVIDE OVERLOAD PROTECTION FOR ALL FANS. COORDINATE WITH DIVISION 26.
- PROVIDE SPEED CONTROLLERS FOR ALL DIRECT DRIVE FANS.
- ESP DOES NOT INCLUDE FACTORY BACKDRAFT DAMPER. THIS PRESSURE DROP SHALL BE ADDED BY THE MANUFACTURER TO THE ESP LISTED WHEN SELECTING FANS.

REMARKS:

- PROVIDE HANGING VIBRATION ISOLATION KIT WITH NEOPRENE ISOLATORS.
- FAN SHALL OPERATE CONTINUOUSLY DURING OCCUPIED HOURS. PROVIDE TIME CLOCK TO CONTROL FAN OPERATION. COORDINATE OPERATING HOURS WITH PARK STAFF.
- PROVIDE DISCONNECT SWITCH, NEMA-1 INDOORS, NEMA 3R OUTDOORS, TOGGLE, MOUNTED AND WIRED.
- SPARK-A RESISTANT CONSTRUCTION.
- PROVIDE DISCONNECT SWITCH, OSHA MOTOR SIDE GUARD, WALL HOUSING, AND CAST ALUMINUM CONSTRUCTION.
- PROVIDE CARBON MONOXIDE SENSOR FOR CONTROLLING FAN.
- PROVIDE WITH REVERSE ACTING THERMOSTAT.

Maintenance Building Master Louver Schedule									
Tag	Manf.	Model	Purpose	CFM	Size	Minimum Free Area (Sq.ft.)	Max FPM	Remarks	

GENERAL NOTES:

- PROVIDE FRAMED 1/2" x 1/2" ALUMINUM BIRD SCREEN FOR ALL LOUVERS
- ALL LOUVERS SHALL BE RATED FOR THE PROJECT WIND ZONE. REFER TO STRUCTRAL DRAWINGS.
- LOUVERS SHALL HAVE 3 COAT 70% PVDF FINISH (AAMA 2605) WITH A DRY FILM THICKNESS OF 2.0 mil MINIMUM. PROVIDE STANDARD AND CUSTOM COLOR CHARTS WITH SUBMITTAL. COLOR SHALL BE SELECTED BY ARCHITECT FROM THE FULL RANGE.
- ALL LOUVERS SHALL BE AMCA 500L CERTIFIED FOR AIR PERFORMANCE, WATER PENETRATION, AND WIND DRIVEN RAIN AND BEAR APPROPRIATE SEAL. ALL LOUVERS SHALL BE RATED AS RAIN PENETRATION CLASS A FOR THE FACE VELOCITY AT THE CFM SCHEDULED.
- EQUIVALENTS BY RUSKIN, ARROW, AIROLITE, NAILOR, RELIABLE, POTTORFF, OR AS LISTED IN THE SPECIFICATIONS

REMARKS:

- PROVIDE MOTORIZED DAMPER TO OPEN WHEN ASSOCIATED FAN RUNS

Maintenance Building Grilles, Registers & Diffusers Schedule									
ID Type	Service	Manf.	Model	Type	Border Application	Neck Size	Face Size	Remarks	

GENERAL NOTES:

- BASIS OF DESIGN IS PRICE. EQUIVALENTS BY TITUS, KRUEGER, TUTTLE AND BAILEY, NAILOR, OR AS LISTED IN SPECIFICATIONS
- PROVIDE VOLUME DAMPERS AT TAKE OFF FOR EACH GRILLE
- ALL AIR DISTRIBUTION DEVICES SHALL BE ALUMINUM
- THE PRICE MODELS SCHEDULED HERE ARE BASIS OF DESIGN, INCLUDING GENERATED NOISE. PROPOSED SUBSTITUTIONS WILL BE JUDGED BY THOSE CRITERIA ALSO
- WHERE LOCATED IN HARD CEILINGS. PROVIDE ALUMINUM MOUNT FRAME/PLASTER FRAME FOR HARD CEILING THAT ALLOWS DIFFUSER/GRILLE WITH FLEX CONNECTION TO BE LIFTED OUT OF FRAME TO ACCESS CEILING SPACE. TYPICAL OF ALL HARD CEILING LOCATIONS. REFER TO ARCHITECTURAL REFLECTED CEILING PLAN
- FOR SIDE WALL GRILLES, PROVIDE REMOTE CABLE OPERATED, GEAR DRIVEN BALANCING DAMPER OPERABLE FROM FACE OF DIFFUSER


REMARKS:

- PROVIDE WITH WHITE ENAMEL FINISH. COLOR AND FINISH SELECTION SHALL BE REVIEWED AND APPROVED BY ARCHITECT.
- PROVIDE WITH TRIM TO MATCH CEILING TYPE. REFER TO ARCHITECTURAL REFLECTED CEILING PLANS FOR CEILINGS
- PROVIDE DIFFUSER/GRILLE WITH ROUND NECK OR PROVIDE SQUARE TO ROUND TRANSITION
- ALL CEILING MOUNTED RETURN GRILLES SHALL BE FULL FACED. NO LAY-IN PANELS ALLOWED
- PROVIDE OPPOSED BLADE ALUMINUM DAMPER
- TRANSFER GRILLE. SIZE PER DUCT ON PLAN.
- WHERE MOUNTED ON A WALL OR OTHER FINISHED ARCHITECTURAL SURFACE, PROVIDE CONCEALED MOUNTING BRACKET OPTION IN LIEU OF COUNTERSUNK SCREW TYPE.

Electrical Abbreviations	
1P 1 Pole (2P, 3P, 4P, ETC.)	
A, Amp Amperes	
AC Above Counter	
ACLG Above Ceiling	
ADO Automatic Door Opener	
AF Amp Frame	
AFF Above Finished Floor	
AFG Above Finished Grade	
AFI Arc Fault Circuit Interrupter	
AHU Air Handling Unit	
AL Aluminum	
ALT Alternate	
AMP Ampere	
AMPL Amplifier	
ANNUN Annunciator	
APPROX Approximately	
AQ-STAT Aquastat	
ARCH Architect, Architectural	
AS Amp Switch	
AT Amp Trip	
ATS Automatic Transfer Switch	
AUTO Automatic	
AUX Auxiliary	
AV Audio Visual	
AWG American Wire Gauge	
BATT Battery	
BD Board	
BLDG Building	
BMS Building Management System	
C Conduit	
CAB Cabinet	
CAT Catalog	
CATV Cable Television	
CB Circuit Breaker	
CCTV Closed Circuit Television	
CKT Circuit	
CLG Ceiling	
COMB Combination	
CMPR Compressor	
CONN Connection	
CONST Construction	
CONT Continuation Or Continuous	
CONTR Contractor	
CONV Converter	
CP Circulating Pump	
CRT Cathode-Ray Tube	
CT Current Transformer	
CTR Center	
CU Copper	
DCP Domestic Water Circulating Pump	
DEPT Department	
DET Detail	
DIA Diameter	
DISC Disconnect	
DIST Distribution	
DN Down	
DPR Damper	
DS Safety Disconnect Switch	
DT Double Throw	
DWG Drawing	
EC Electrical Contractor	
ELEC Electric, Electrical	
ELEV Elevator	
ELU Emergency Lighting Unit	
EM Emergency	
EMS Energy Management System	
EMT Electrical Metallic Tubing	
EP Electric Pneumatic	
EQUIP Equipment	
EWEC Electric Water Cooler	
EXIST Existing	
EXH Exhaust	
EXP Explosion Proof	
FA Fire Alarm	
FABP Fire Alarm Booster Power Supply Panel	
FACP Fire Alarm Control Panel	
FCU Fan Coil Unit	
FIXT Fixture	
FLR Floor	
FLUOR Fluorescent	
FU Fuse	
FUDS Fused Safety Disconnect Switch	
GA Gauge	
GAL Gallon	
GALV Galvanized	
GC General Contractor	
GEN Generator	
GFI Ground Fault Circuit Interrupter	
GFP Ground Fault Protector	
GND Ground	
GRS Galvanized Rigid Steel (Conduit)	
GYP BD Gypsum Board	
HOA Hands-Off-Automatic Switch	
HORIZ Horizontal	
HP Horsepower	
HPF High Power Factor	
HT Height	
HTG Heating	
HTR Heater	
HV High Voltage	
HVAC Heating, Ventilating And Air Conditioning	
IC Interrupting Capacity	
IG Isolated Ground	
IMC Intermediate Metal Conduit	
INCAND Incandescent	
IR Infrared	
IWV Interlock With Junction Box	
KV Kilovolt	
KVA Kilovolt-Ampere	
KVAR Kilovolt-Ampere Reactive	
KW Kilowatt	
KWH Kilowatt Hour	
LCC Locate Or Location	
LT Light	
LTG Lighting	
LTNG Lightning	
LV Low Voltage	
MAX Maximum	
MAG.S Magnetic Starter	
M/C Momentary Contact	
MC Mechanical Contractor	

ELECTRICAL SYMBOL LEGEND	
	TYPICAL FIXTURE DESIGNATIONS "A" INDICATES FIXTURE TYPE, SEE LIGHT FIXTURE SCHEDULE FOR DESCRIPTION.
	"E" INDICATES EMERGENCY BATTERY W/ LIGHT FIXTURE
	LIGHT FIXTURES, WITH FIXTURE DESIGNATION
	WALL MOUNTED EXIT SIGN. SHADED AREAS INDICATE NUMBER OF FACES, DIRECTION ARROWS AS INDICATED.
	CEILING MOUNTED EXIT SIGN. SHADED AREAS INDICATE NUMBER OF FACES, DIRECTION ARROWS AS INDICATED.
	WALL MOUNTED EMERGENCY BATTERY UNIT.
	TOGGLE SWITCH, MOUNT CENTER AT 48" AFF.
	THREE-WAY SWITCH, MOUNT CENTER AT 48" AFF.
	DIMMING SWITCH 0-10V, MOUNT CENTER AT 48" AFF.
	OCCUPANCY SENSOR WALL SWITCH, MOUNT CENTER AT 48" AFF.
	CEILING MOUNTED OCCUPANCY SENSOR
	HOME RUN TO PANEL WITH PANEL DESIGNATION (SBPG) & CIRCUIT NUMBER (6), 3/4" UNLESS NOTED OTHERWISE. SEE RISER DIAGRAM & PANELBOARD SCHEDULES FOR WIRE & CONDUIT SIZES.
	WIRING IN CONDUIT CONCEALED IN WALLS AND ABOVE CEILING.
	WIRING IN CONDUIT UNDERFLOOR OR UNDERGROUND.
	10'-0" DRIVEN GROUND ROD
	DUPLEX RECEPTACLE, MOUNT CENTER AT 18" AFF UNLESS NOTED OTHERWISE.
	SINGLE RECEPTACLE, RATING SHALL MATCH BREAKER SIZE
	PANELBOARD, SEE SCHEDULES & DETAILS.
	DISCONNECT SWITCH
	JUNCTION BOX
	CONCEALED SERVICE FLOOR BOX WITH DUPLEX RJ45
	CONCEALED SERVICE FLOOR BOX WITH DUPLEX RJ45
	DATA/DATA JACK, DATA JACK, CENTER AT 18" AFF.

SEE LIGHT FIXTURE SCHEDULE SHEET 'ES-E001'

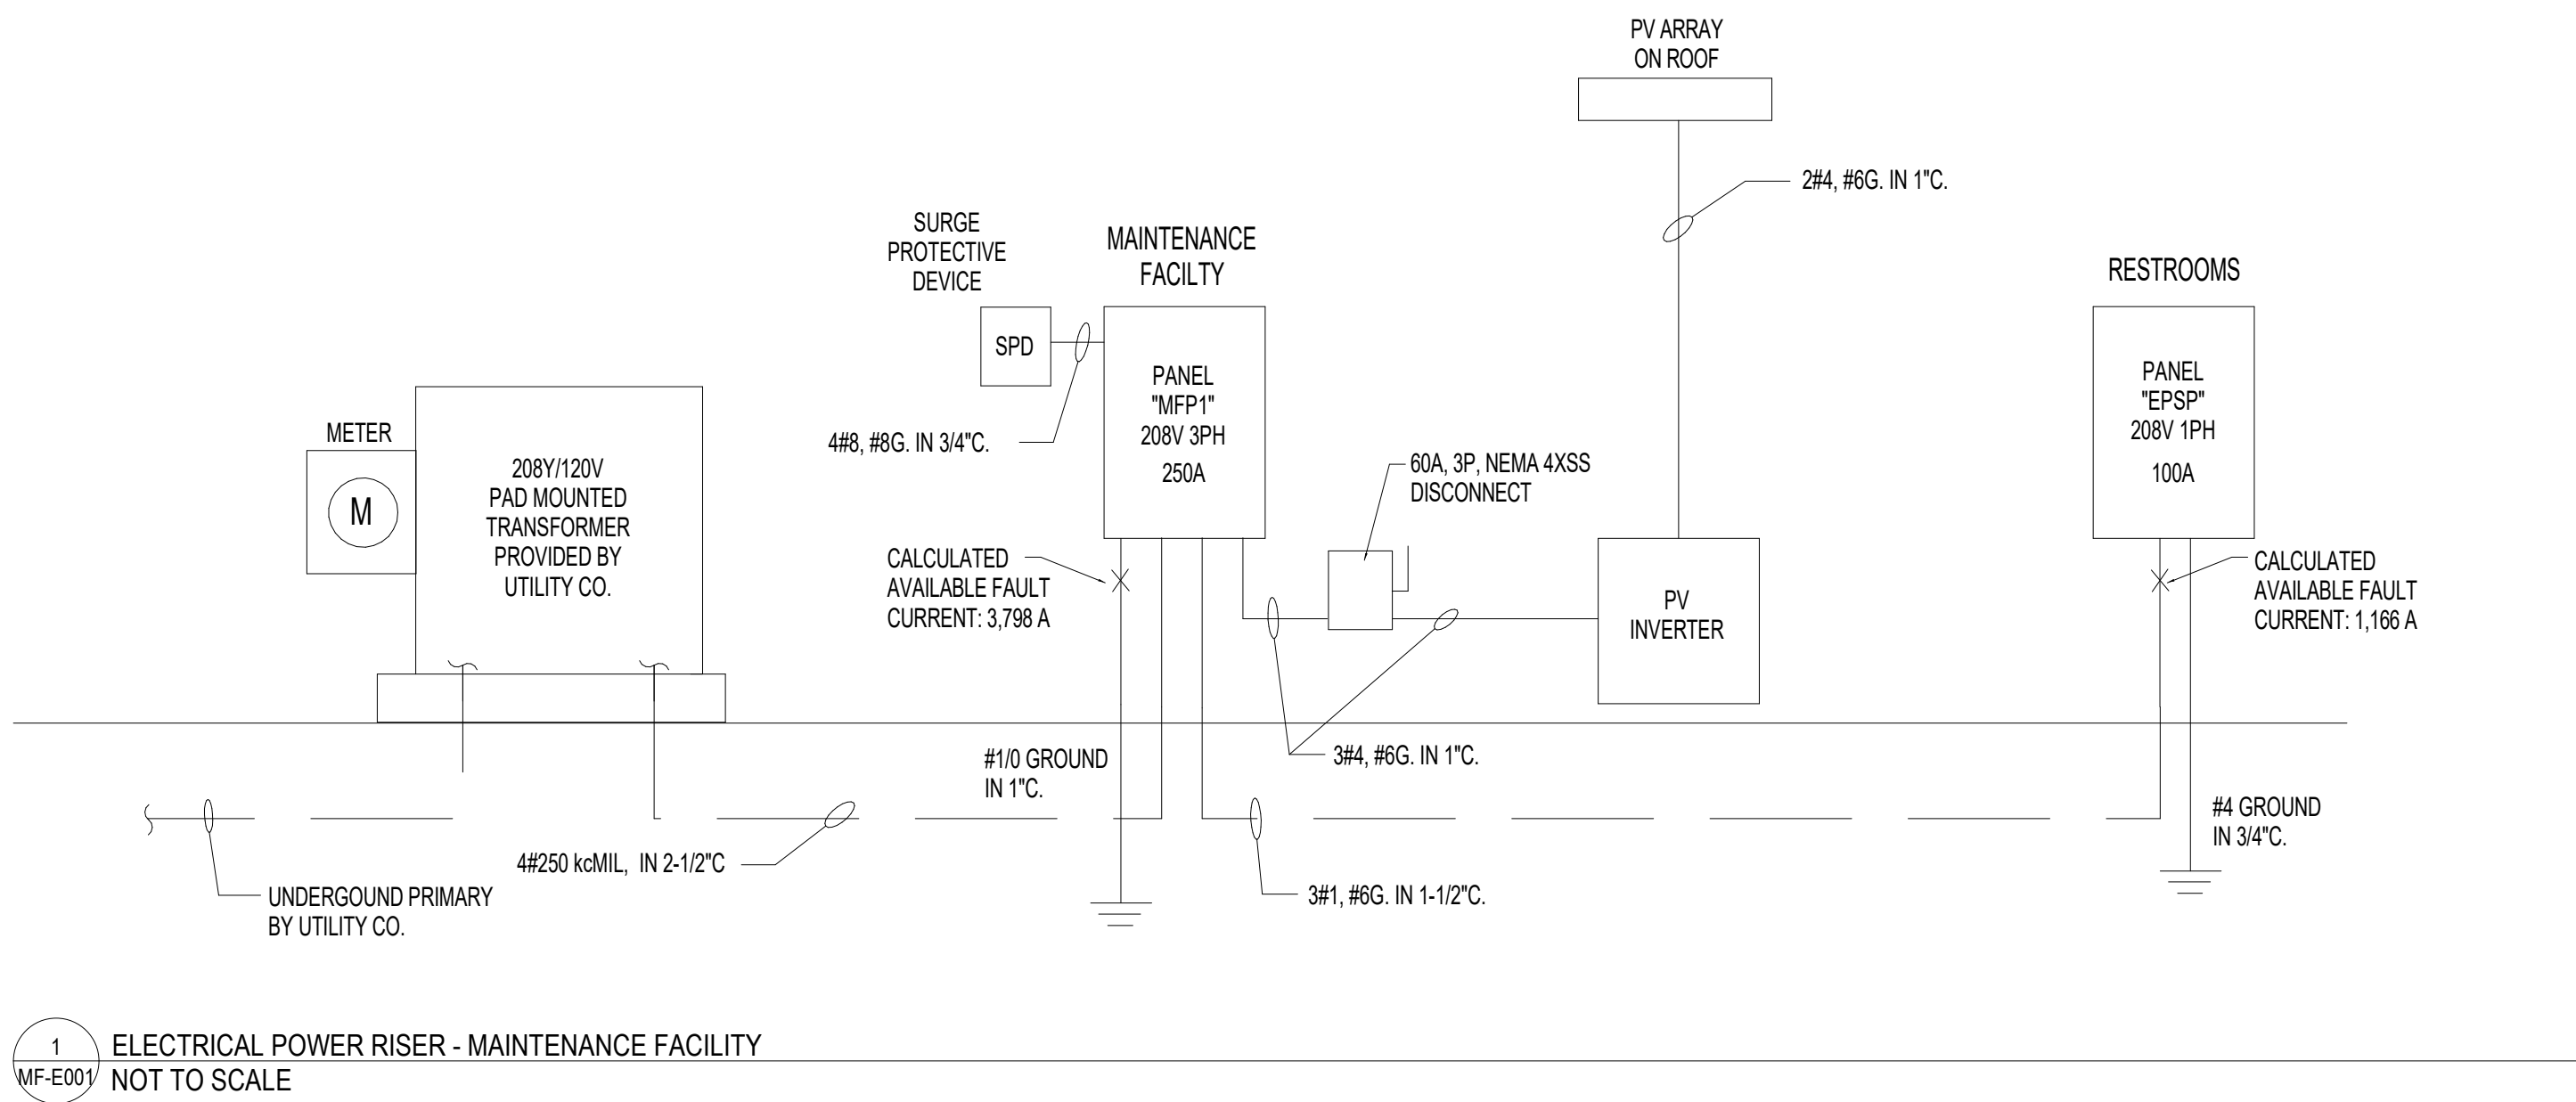

Electrical General Notes

- A Conductors operating at 50 volts or greater shall be in raceway. Raceway within the structure above the floor slab shall be metal. Raceway below the floor slab and underground raceway outside the structure shall be PVC.
- B Low voltage cables or conductors operating at less than 50 volts shall be in metal raceway where installed within walls or inaccessible spaces. Low voltage cables may be run in cable tray where noted. Low voltage cables may be run in cable support hooks above accessible ceilings where noted. Low voltage cable shall be plenum rated in plenum spaces.
- B Low voltage cables or conductors operating at less than 50 volts shall be in metal raceway. Low voltage cables may be run in cable tray where noted. Low voltage cable shall be plenum rated in plenum spaces.
- C Coordinate locations of devices with architectural elevations and details. Architectural elevations and details take precedence over locations shown on electrical drawings.
- D Provide cable or conduit and wire as required to achieve circuiting shown. Size conductors per NEC ampacity and wire fill criteria. Provide dedicated neutral and ground conductors for circuiting, unless noted otherwise. Increase branch circuit and/or feeder conductors including equipment grounding conductors proportionally for no more than 3% voltage drop on branch circuits and 2% on feeders per energy code.
- E It is the responsibility of this contractor to coordinate installation of electrical systems and those requiring electrical connections to maintain NEC required clearances, included but not limited to areas above accessible ceilings.
- F Coordinate with other trades for proper installation of equipment. Consult the drawings of other trades or crafts to avoid conflicts with equipment, etc. Conflicts shall be resolved prior to rough-in and at no additional cost to the owner.
- G Leave the site clean and ready for occupancy. Remove dirt, debris, empty cartons, tools, conduit and wire scraps, and miscellaneous spare equipment and materials used in this division of the work during construction. Components shall be free of dust, grit, and foreign materials and left as new before final acceptance of work.
- H The symbols and abbreviations shown on this sheet may or may not be used in this set of drawings.
- I Perform work to comply with the standard practices for good workmanship published by National Electrical Contractors Association (NECA). Comply with the latest enforced edition of the National Electrical Code (NEC), local codes, amendments, and ordinances.
- J Field coordinate final mechanical and equipment locations along with connection requirements and control wiring prior to rough-in. Adjust corresponding circuit breaker ratings and branch circuiting accordingly.
- K Electrical work shall be performed under the supervision of a licensed master electrician. Procure permits and licenses and pay fees associated with this work.
- L Materials furnished for this project shall be new, commercial grade, free of defects, and listed by a nationally recognized testing laboratory unless noted otherwise.
- M Provide complete operation & maintenance manual including approved submittal drawings, warranty information for product supplied, and manufactures operation and maintenance instructions.
- N The contractor is responsible for making final wiring terminations to pre-installed receptacles in office furniture. Contractor is responsible for wiring and installing voice/data devices in office furniture. Coordinate placement of devices with furniture lay-out.
- O Security system to be provided under separate contract. It is the responsibility of this contractor to provide conduit provisions, back boxes, rough-ins, sleeves and power to head end equipment for exact requirements prior to start of work.
- P Conduit and wire shall not be installed below floor slab unless indicated on plan by dashed conduit.
- Q Contractor shall be responsible for wiring electrical items shown on drawings except for items listed in note 'R' below.
- R TV outlets, volume controls, nurse call dome lights, nurse call devices, telephone outlets, data outlets, and fire alarm devices shall consist of a back box with conduit stubbed above the accessible ceiling, see stub up detail. Verify size of back box required with device to be installed. Locate back boxes 6" from adjacent power receptacle intended for computer use.
- S Furnish and install conduit from back boxes for the following devices into the accessible ceiling space in the corridor, unless noted otherwise:
1/2" TV outlets
1/2" Volume controls
1/2" Door security devices (card readers, door strikes etc.)
1/2" Nurse call dome lights
3/4" Nurse call devices
3/4" Telephone outlets
3/4" Information outlets
3/4" Fire alarm devices

MAINTENANCE FACILITY ELECTRICAL SHEET INDEX	
MF-E001	COVER SHEET
MF-E101	POWER AND LIGHTING PLANS
MF-E102	ROOF PLAN
MF-E501	DETAILS

MAINTENANCE FACILITY

ELECTRICAL SYSTEM AND EQUIPMENT

METHOD OF COMPLIANCE:

ENERGY CODE: PRESCRIPTIVE_ X _ PERFORMANCE_ _____
ASHRAE 90.1: PRESCRIPTIVE_ _____ PERFORMANCE_ _____

LIGHTING SCHEDULE

Lamp type required in fixture - See Fixture Schedule.
Number of lamps in fixture - See Fixture Schedule.
Ballast type used in the fixture - See Specifications.
Number of ballasts in fixture - See Specifications.
Total wattage per fixture - Varies - See Fixture Schedule

Total interior wattage specified versus allowed: 684 watts versus 3962 watts (whole building)
Total exterior wattage specified versus allowed: 197 watts versus 1014 watts

ADDITIONAL PRESCRIPTIVE COMPLIANCE

_____ 406.2 More Efficient HVAC Performance
X 406.3 Reduced Lighting Power Density
_____ 406.4 Enhanced Lighting Controls
_____ 406.5 On-Site Supply of Renewable Energy
_____ 406.6 Provision of Dedicated Outdoor HVAC Air System
_____ 406.7 High Efficiency Service Water Heating


DESIGNER STATEMENT:

To the best of my knowledge and belief, the design of this building complies with the electrical system and equipment requirements of the 2018 North Carolina State Building Code, Energy Conservation Code.

Susan Hatchell
Landscape Architecture, PLLC
711 W. North Street, Raleigh, NC 27603
p: 919-838-9600 f: 919-838-9700

Wooten
120 North Boylan Avenue • Raleigh, NC 27603-1423
(919) 828-0331 • newwoodcompany.com
License Number: 749115

COVER SHEET


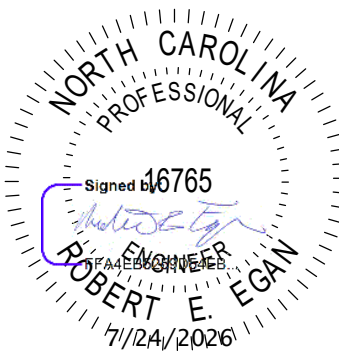


LAKE MYRA COUNTY PARK
Wake County, NC

REVISIONS

Date: 07/27/26

MF-E001

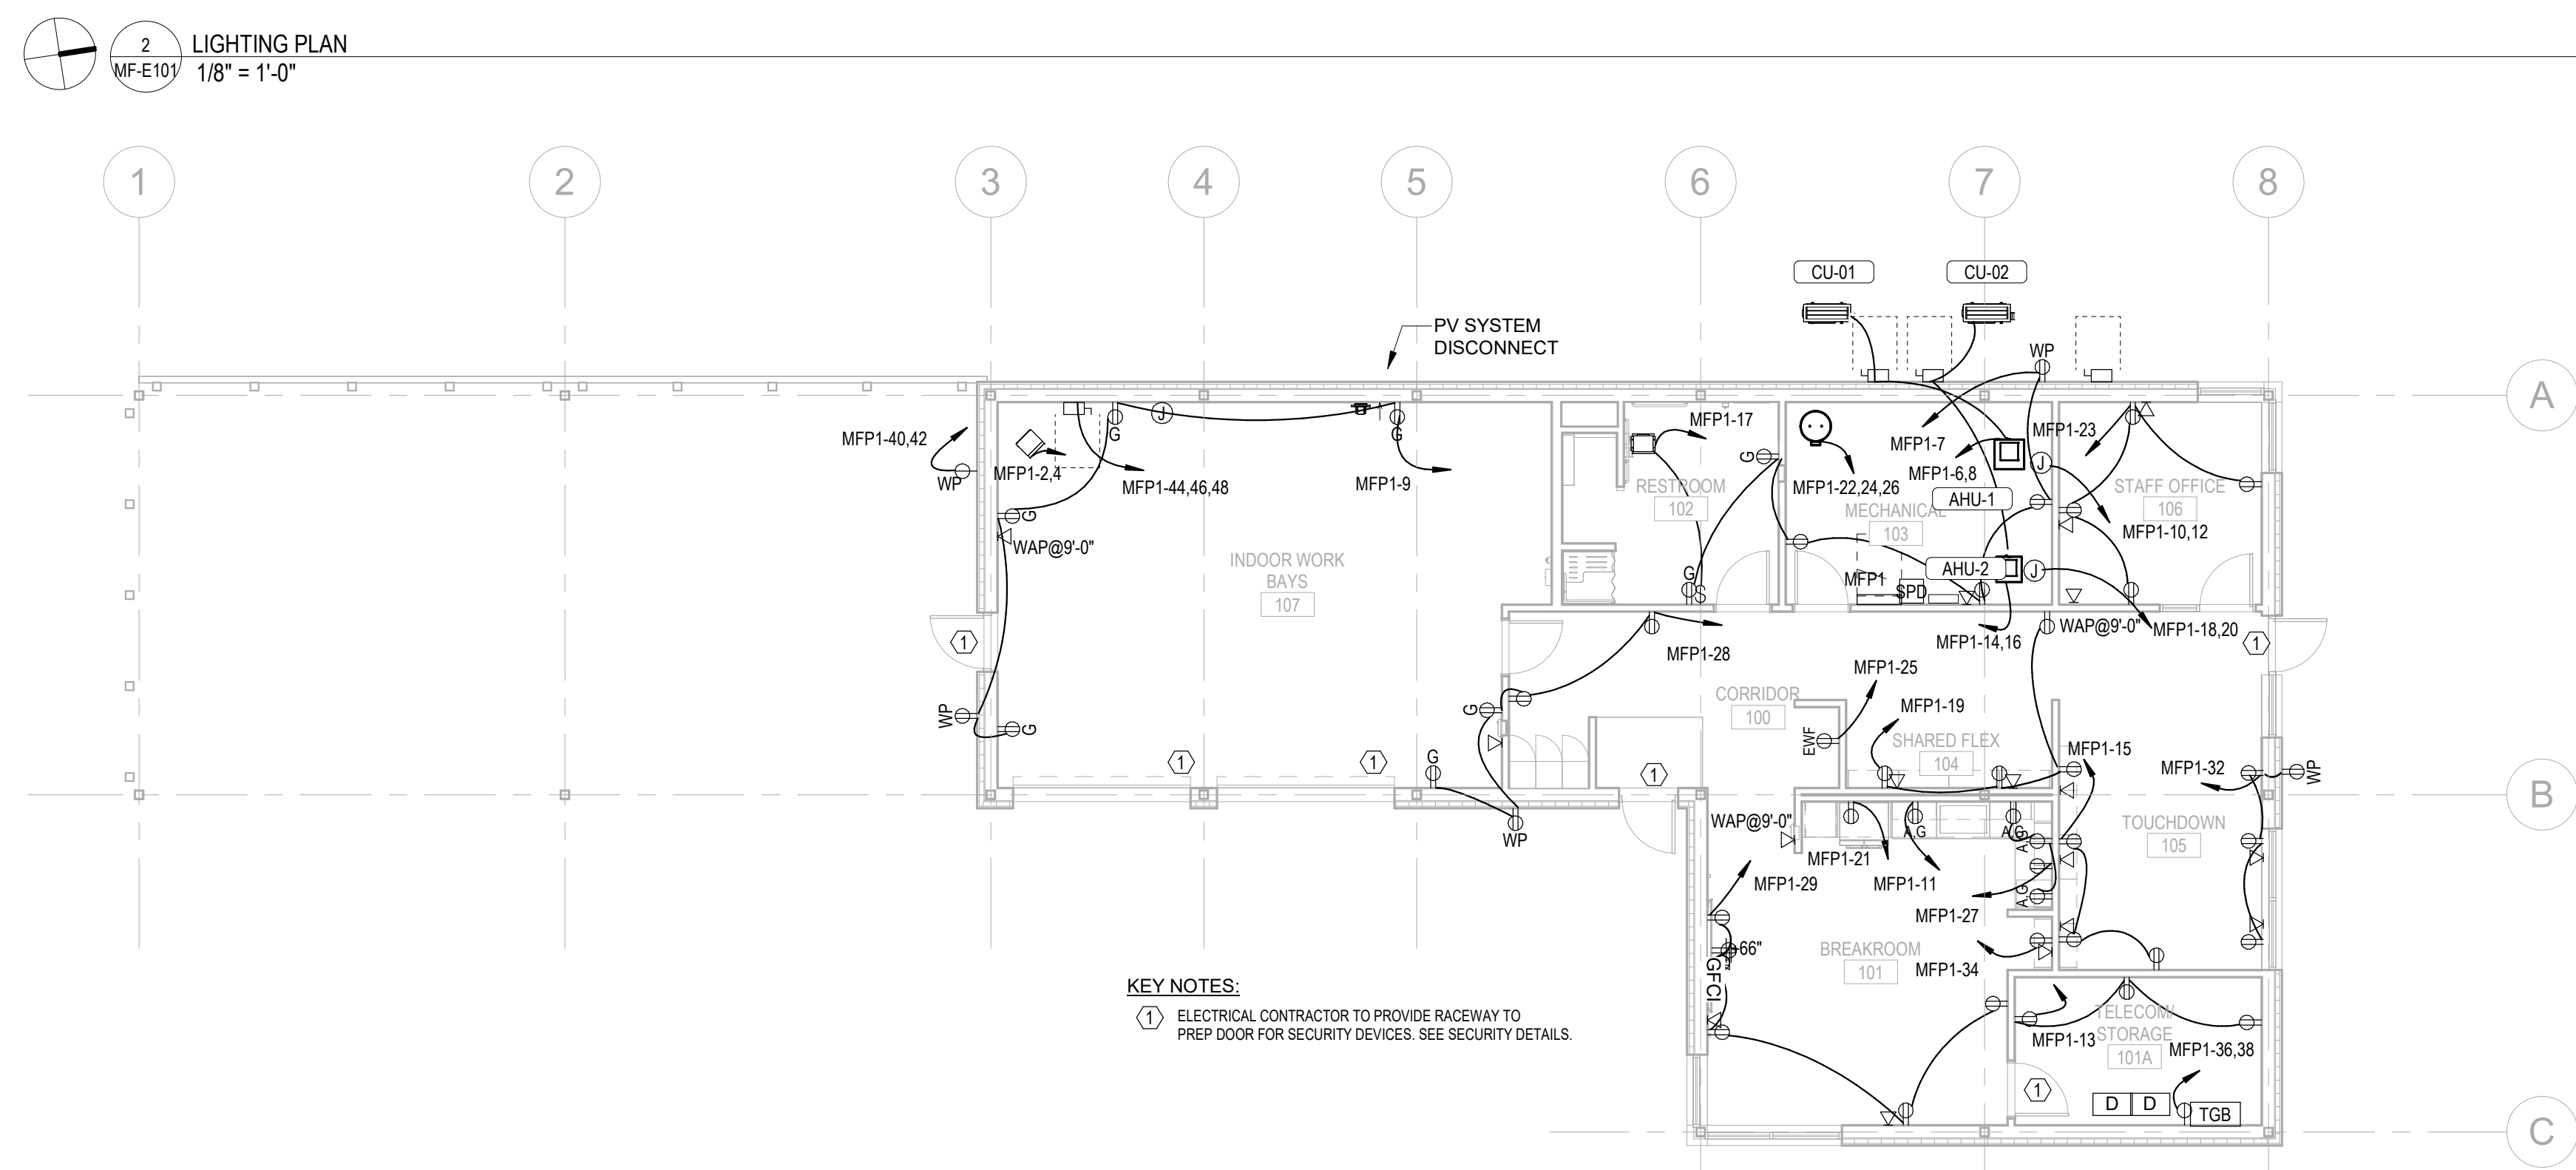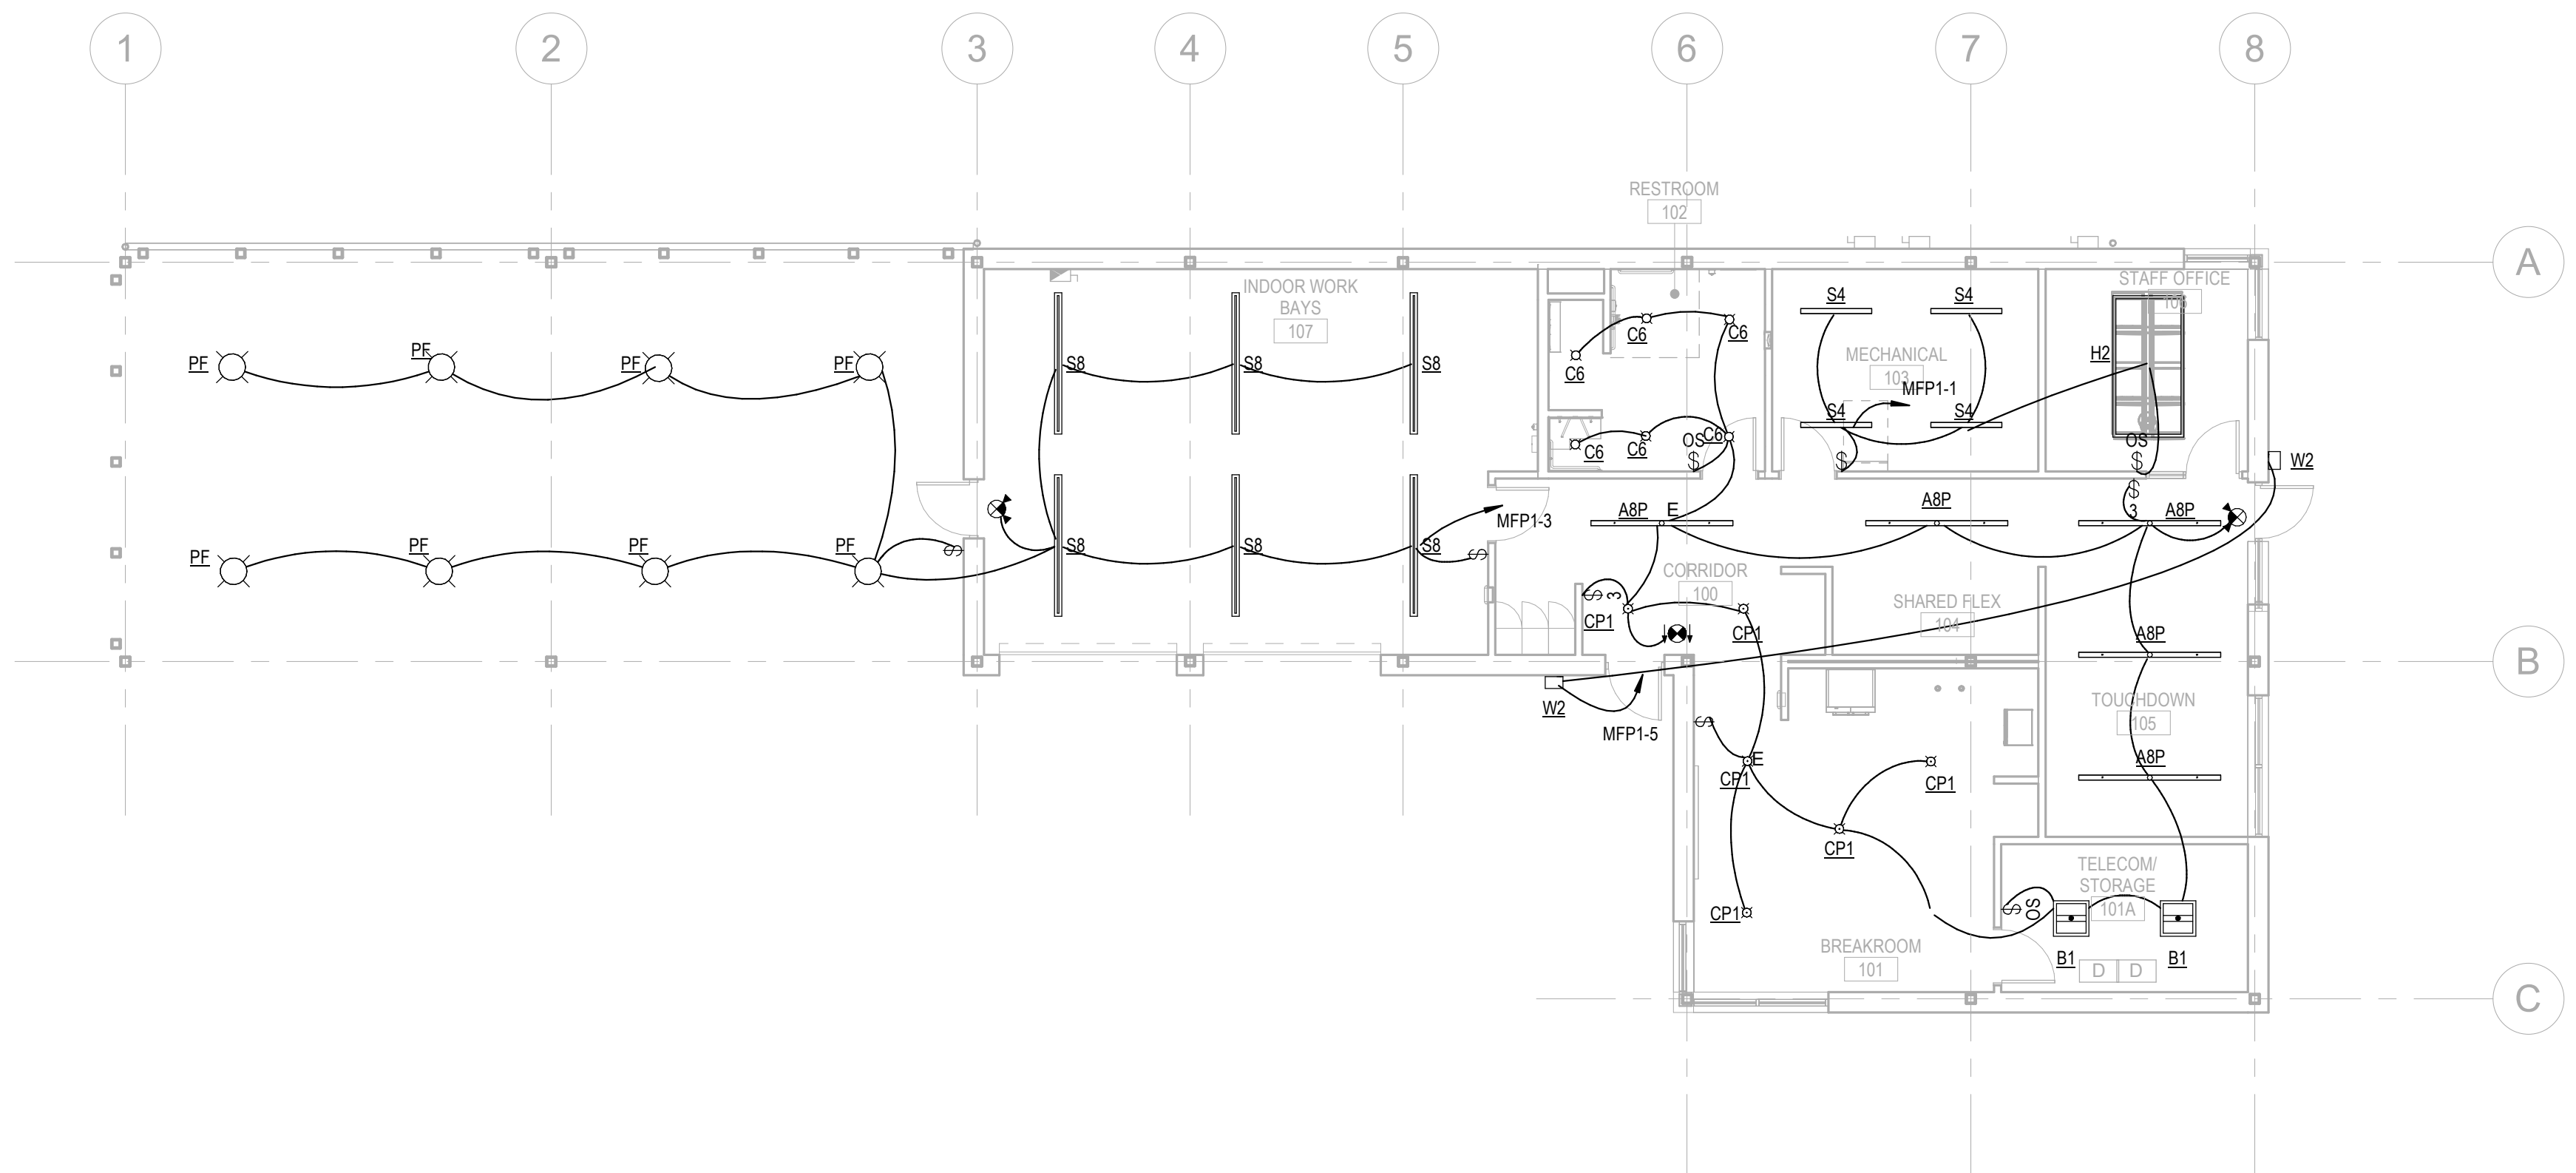

Panel Name: MFP1

Location: MECHANICAL 103

Supply:

Mounting Surface

Enclosure: Type 1

Voltage: 208Y120/30, 4W

Mains Type: MCB

Mains Rating: 250 A


SCCR: 22000

Kct	Description	Rating	Poles	Wire Size	Phase A Load (VA)	Phase B Load (VA)	Phase C Load (VA)	Wire Size	Poles	Rating	Description	Ckt	
1	LIGHTING	20	1	2#12, #12G, 3/4"	693	4492		2#4, #10G, 1"	2	60	UNIT HEATER WORK BAYS 108	2	
3	LIGHTING WORK BAYS 108	20	1	2#12, #12G, 3/4"		627	4492					4	
5	OUTSIDE - WALL LIGHTS	20	1	2#12, #12G, 3/4"			33	1456				6	
7	REC - MECHANICAL 104	20	1	2#12, #12G, 3/4"	1080	1456		2#12, #12G, 3/4"	2	20	AHU/CU-1	8	
9	REC - INDOOR WORK BAYS 108	20	1	2#12, #12G, 3/4"		900	1900					10	
11	REC - BREAKROOM 101	20	1	2#12, #12G, 3/4"			180	1900			AHU-1 AUX HTR	12	
13	REC - TELECOM/ STORAGE 101	20	1	2#12, #12G, 3/4"	540	3120		2#8, #10G, 3/4"	2	40	AHU//CU-2	14	
15	REC - TOUCHDOWN 102	20	1	2#12, #12G, 3/4"		540	3120					16	
17	EF-1 RESTROOM 107	20	1	2#12, #12G, 3/4"			180	1900				18	
19	REC - CORRIDOR 106	20	1	2#12, #12G, 3/4"	720	1900		2#10, #10G, 3/4"	2	30	AHU-2 AUX.HTR	20	
21	REFRIGERATOR	20	1	2#12, #12G, 3/4"		375	3333					22	
23	REC STAFF OFFICE 106	20	1	2#12, #12G, 3/4"			720	3333			ELECTRIC WATER HEATER MECHANICAL 104	24	
25	REC - CORRIDOR 100	20	1	2#12, #12G, 3/4"	180	3333		3#8, #10G, 3/4"	3	40		26	
27	MICROWAVE BREAKROOM 101	20	1	2#12, #12G, 3/4"		180	900				REC 107, 100	28	
29	REC-BREAKROOM 101	20	1	2#12, #12G, 3/4"			900	540			REC BREAKROOM 101	30	
31	PANEL 'EPSP'	150	3	4-1/0, #6G, 1-1/2"	8869	720		2#12, #12G, 3/4"	1	20	REC STAFF OFFICE 105	32	
33						7700	180	2#12, #12G, 3/4"	1	20	COPIER	34	
35							6425	250	3#12, #12G, 3/4"	2	20	REC- TELECOM 101A	36
37					0	250						38	
39	SURGE PROTECTION	40	3	#4#8, #6G, 3/4"		0	600	3#12, #12G, 3/4"	2	20	CART CHARGER	40	
41												42	
43					0	2200		0	600			44	
45						0	2200					46	
47	SPARE	20	1	--			0	2200			COMPRESSOR	48	
49	SPACE	--	1	--	--	0		--		1	20	SPARE	50
51	SPACE	--	1	--				--		1	20	SPARE	52
53	SPACE	--	1	--			--	0	--	1	20	SPARE	54
Connected Load:					30 kVA	27 kVA	21 kVA						
Connected Current:					235 A	234 A	172 A						
Load Classification				Connected	Factor	Demand							
Motor				85 VA	125.00%	106 VA							
Other				14850 VA	100.00%	14850 VA							
Lighting - Interior				2062 VA	125.00%	2578 VA							
Receptacle - General				10965 VA	95.52%	10493 VA							
Receptacle - Dedicated				1700 VA	100.00%	1700 VA							
Electric Water Heating				14500 VA	125.00%	18125 VA							
HVAC				9152 VA	100.00%	9152 VA							
Electric Heat				16283 VA	125.00%	20354 VA							
Non-Concurrent				7600 VA	5.00%	380 VA							
Notes: Service entrance rated.													
Provide GFI breaker for circuit, 21.													

Susan Hatchell
Landscape Architecture, PLLC
711 W. North Street, Raleigh, NC 27603
p: 919-838-9600 f: 919-838-9700

Wooten
120 North Boylan Avenue • Raleigh, NC 27603-1423
(919) 928-0531 • thewootencompany.com
License Number: F-0115

POWER AND LIGHTING PLANS

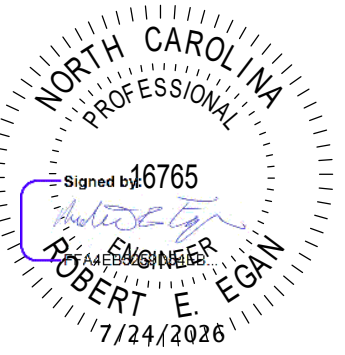


LAKE MYRA COUNTY PARK
Wake County, NC


REVISIONS

Date: 07/27/26

MF-E101

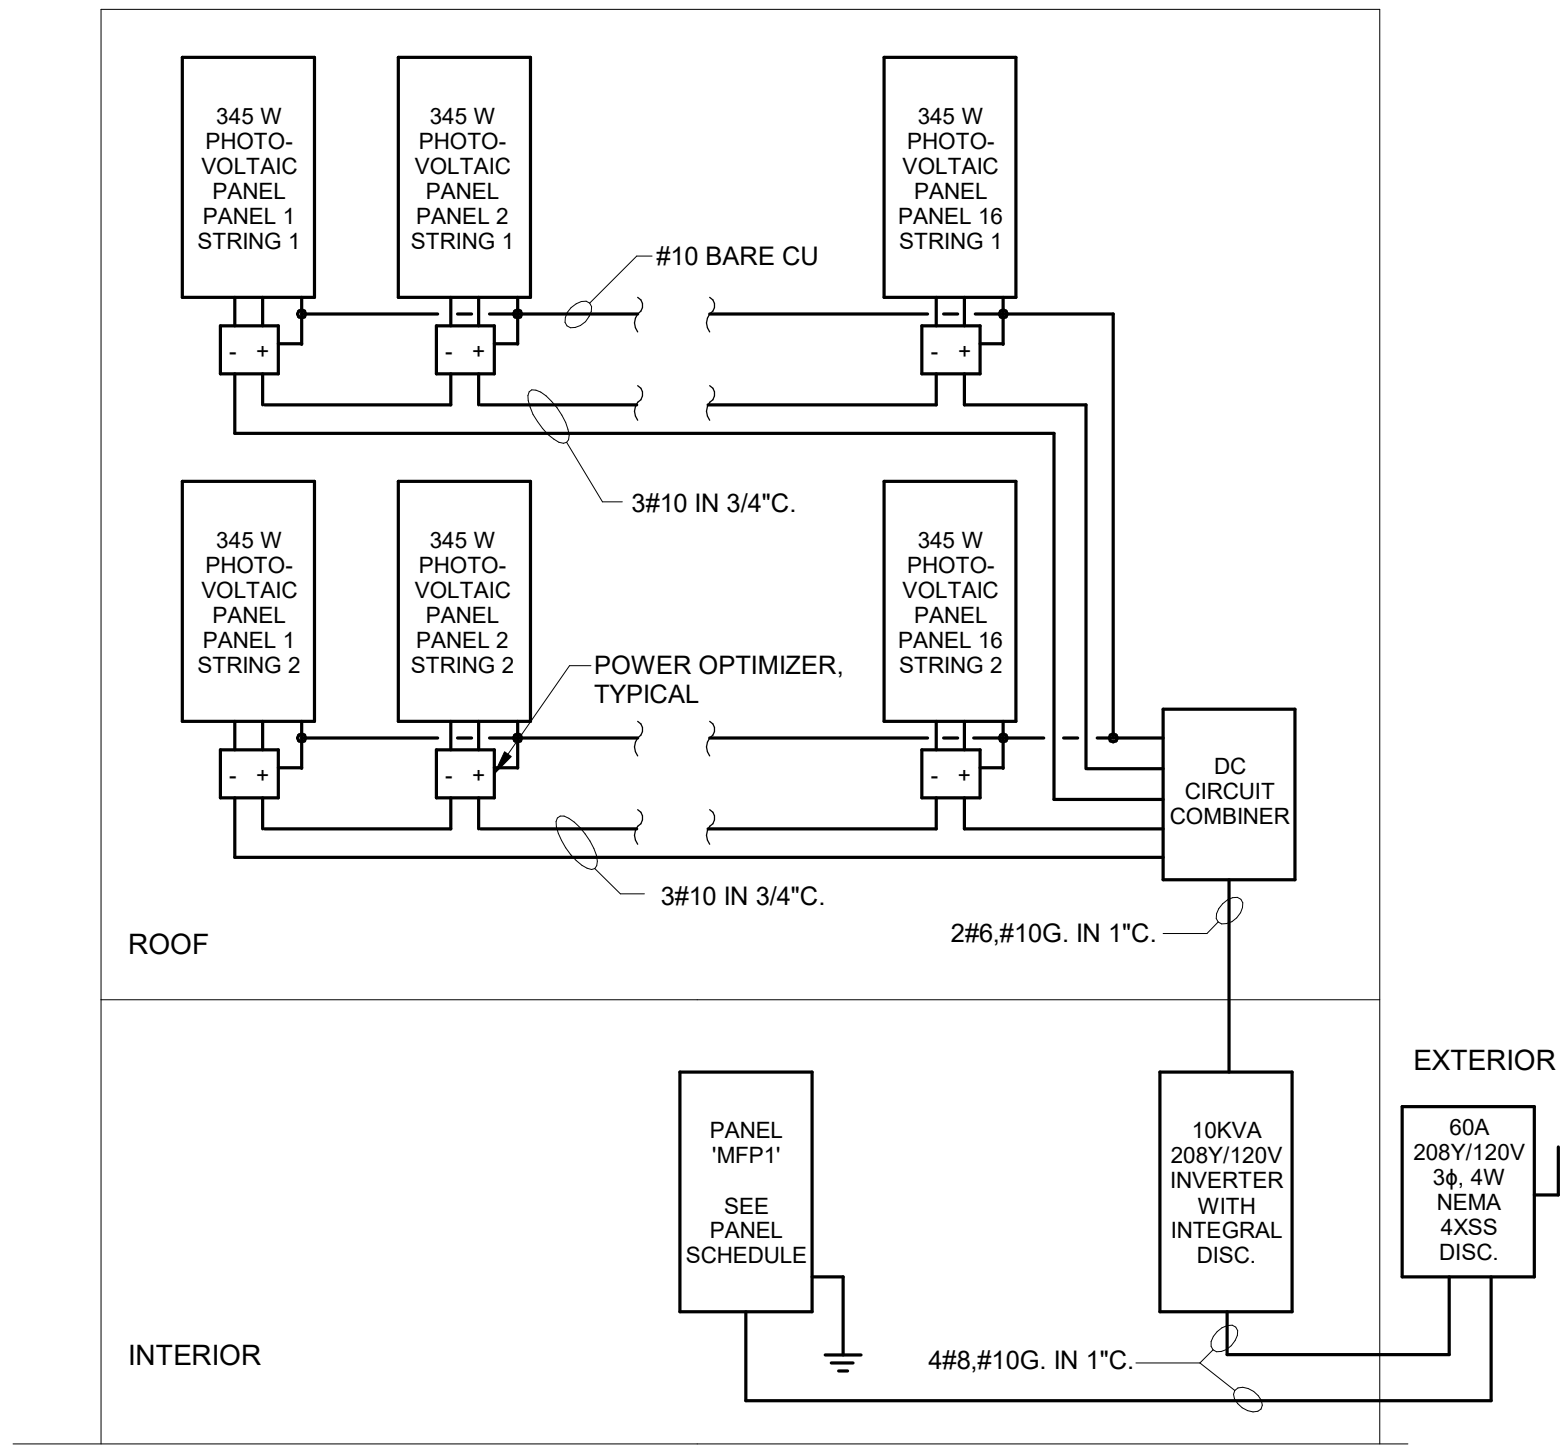

2 PV RISER DIAGRAM MAINTENANCE BUILDING
MF-E102 NOT TO SCALE

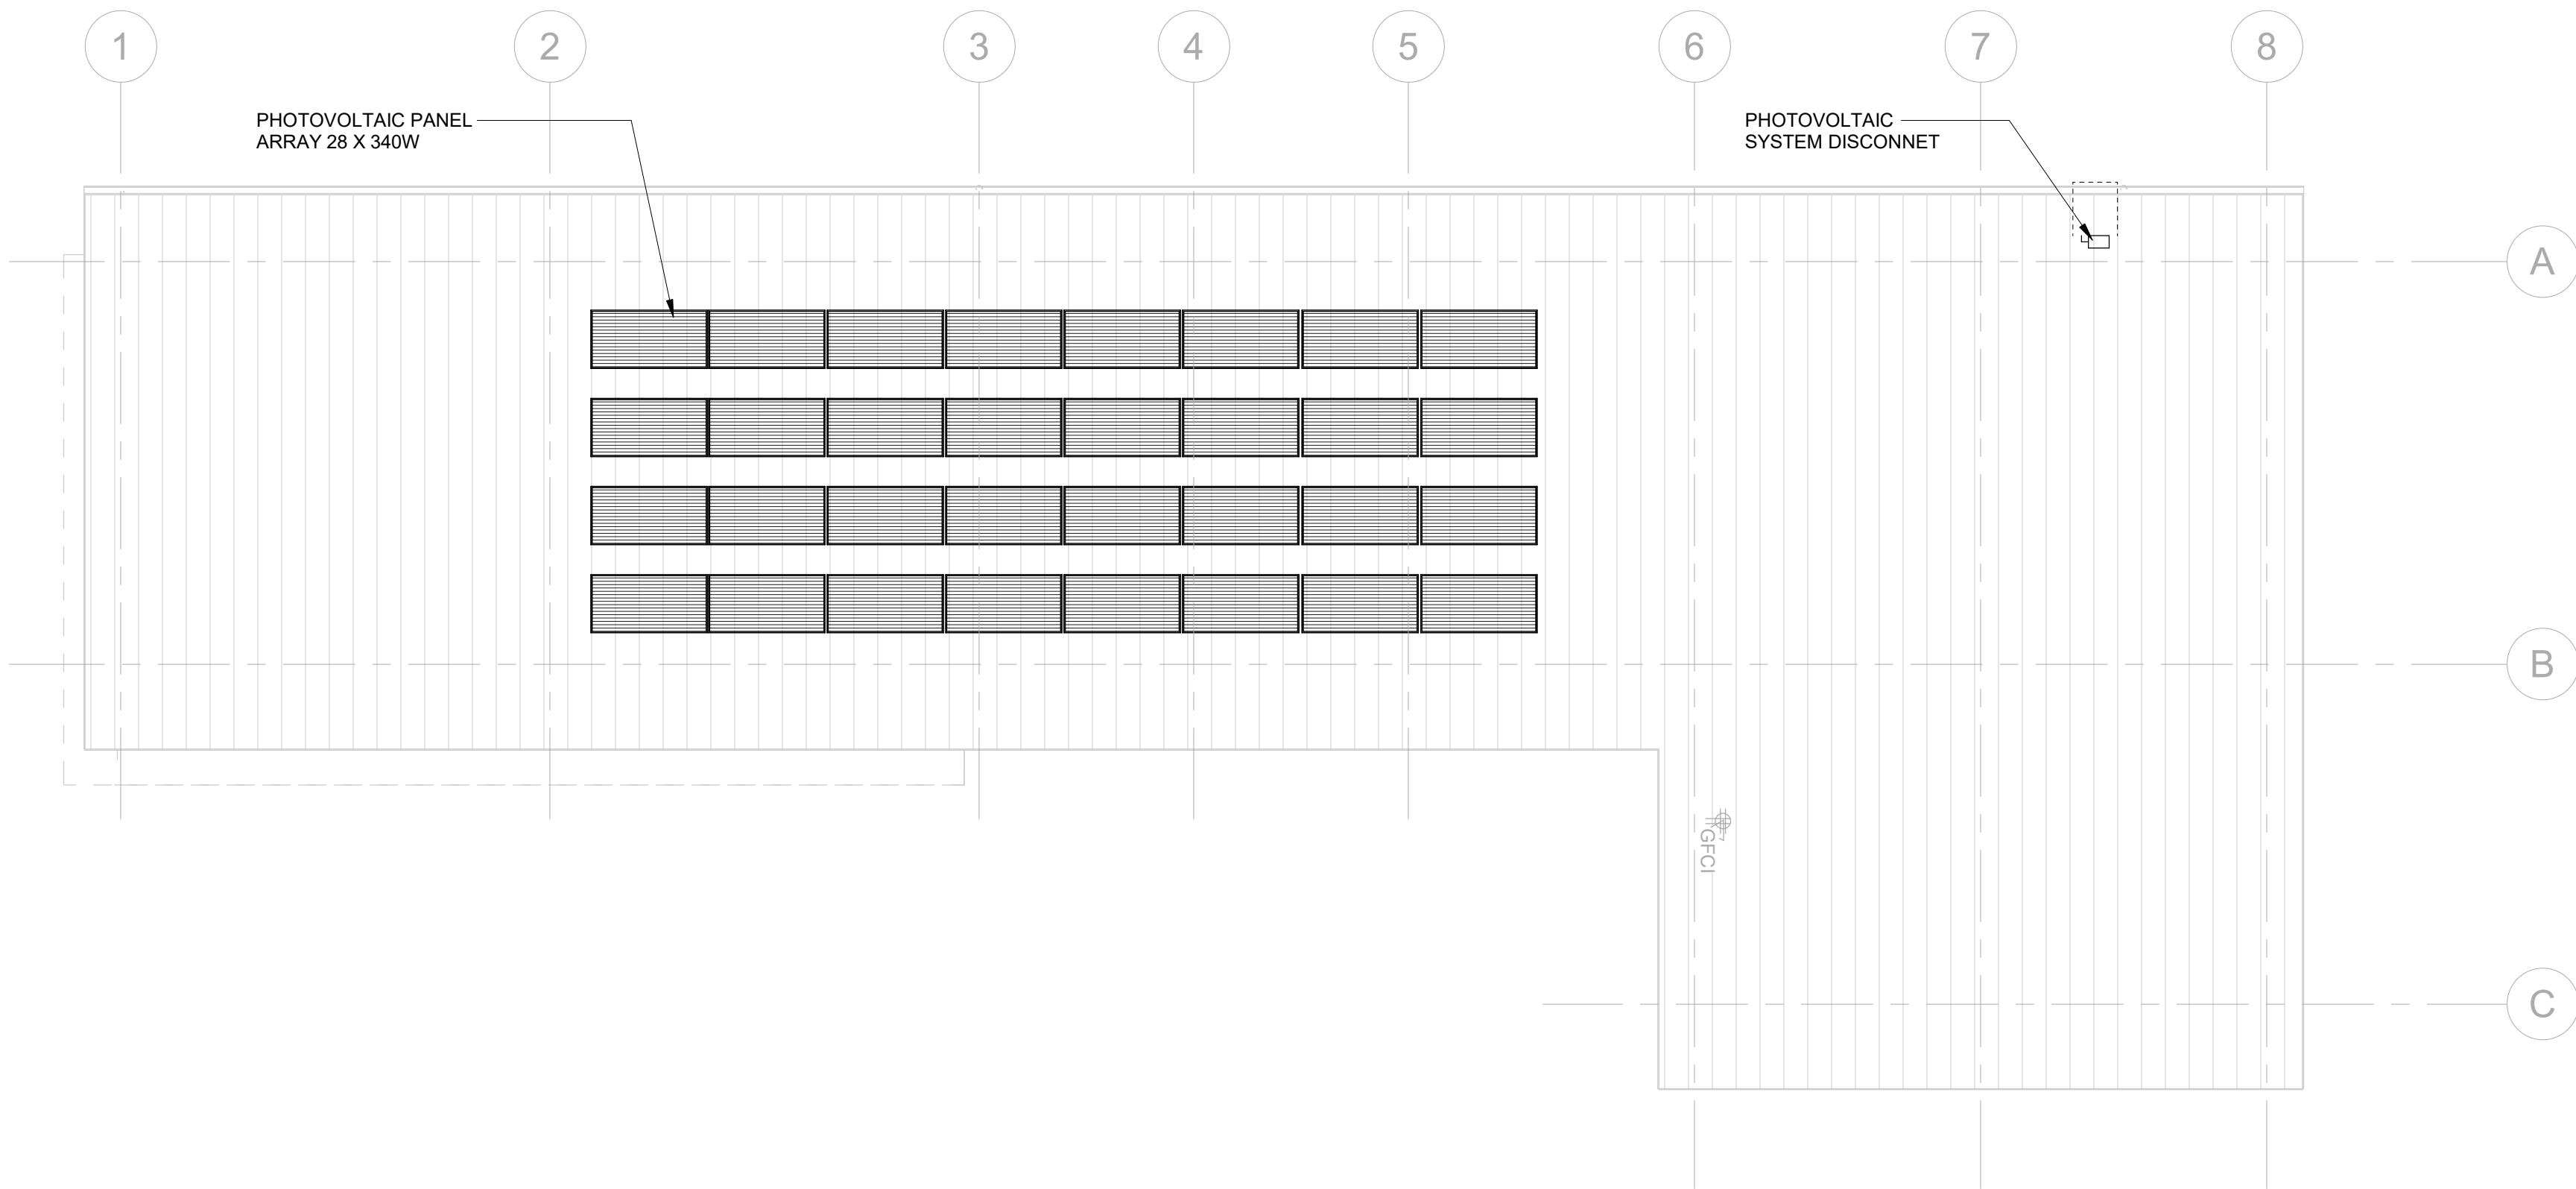

1 MAINTENANCE BUILDING ROOF PLAN
MF-E102 1/8" = 1'-0"

NOTE:
All photovoltaic system components shall bear UL or other North Carolina recognized third party testing agency labels. UL 1703 for flat plate photovoltaic panels and UL 1741 for inverters and interconnection system equipment.

Susan Hatchell
Landscape Architecture, PLLC
711 W. North Street, Raleigh, NC 27603
p: 919-838-9600 f: 919-838-9700

Wooten
120 North Boylan Avenue • Raleigh, NC 27603-1423
(919) 828-0031 • www.wootencompany.com
License Number: 749715


ROOF PLAN

NORTH CAROLINA
PROFESSIONAL
Signed by: 16765
ROBERT E. EGAN
7/24/2026


LAKE MYRA COUNTY PARK
Wake County, NC

REVISIONS	

Date: 07/27/26
MF-E102

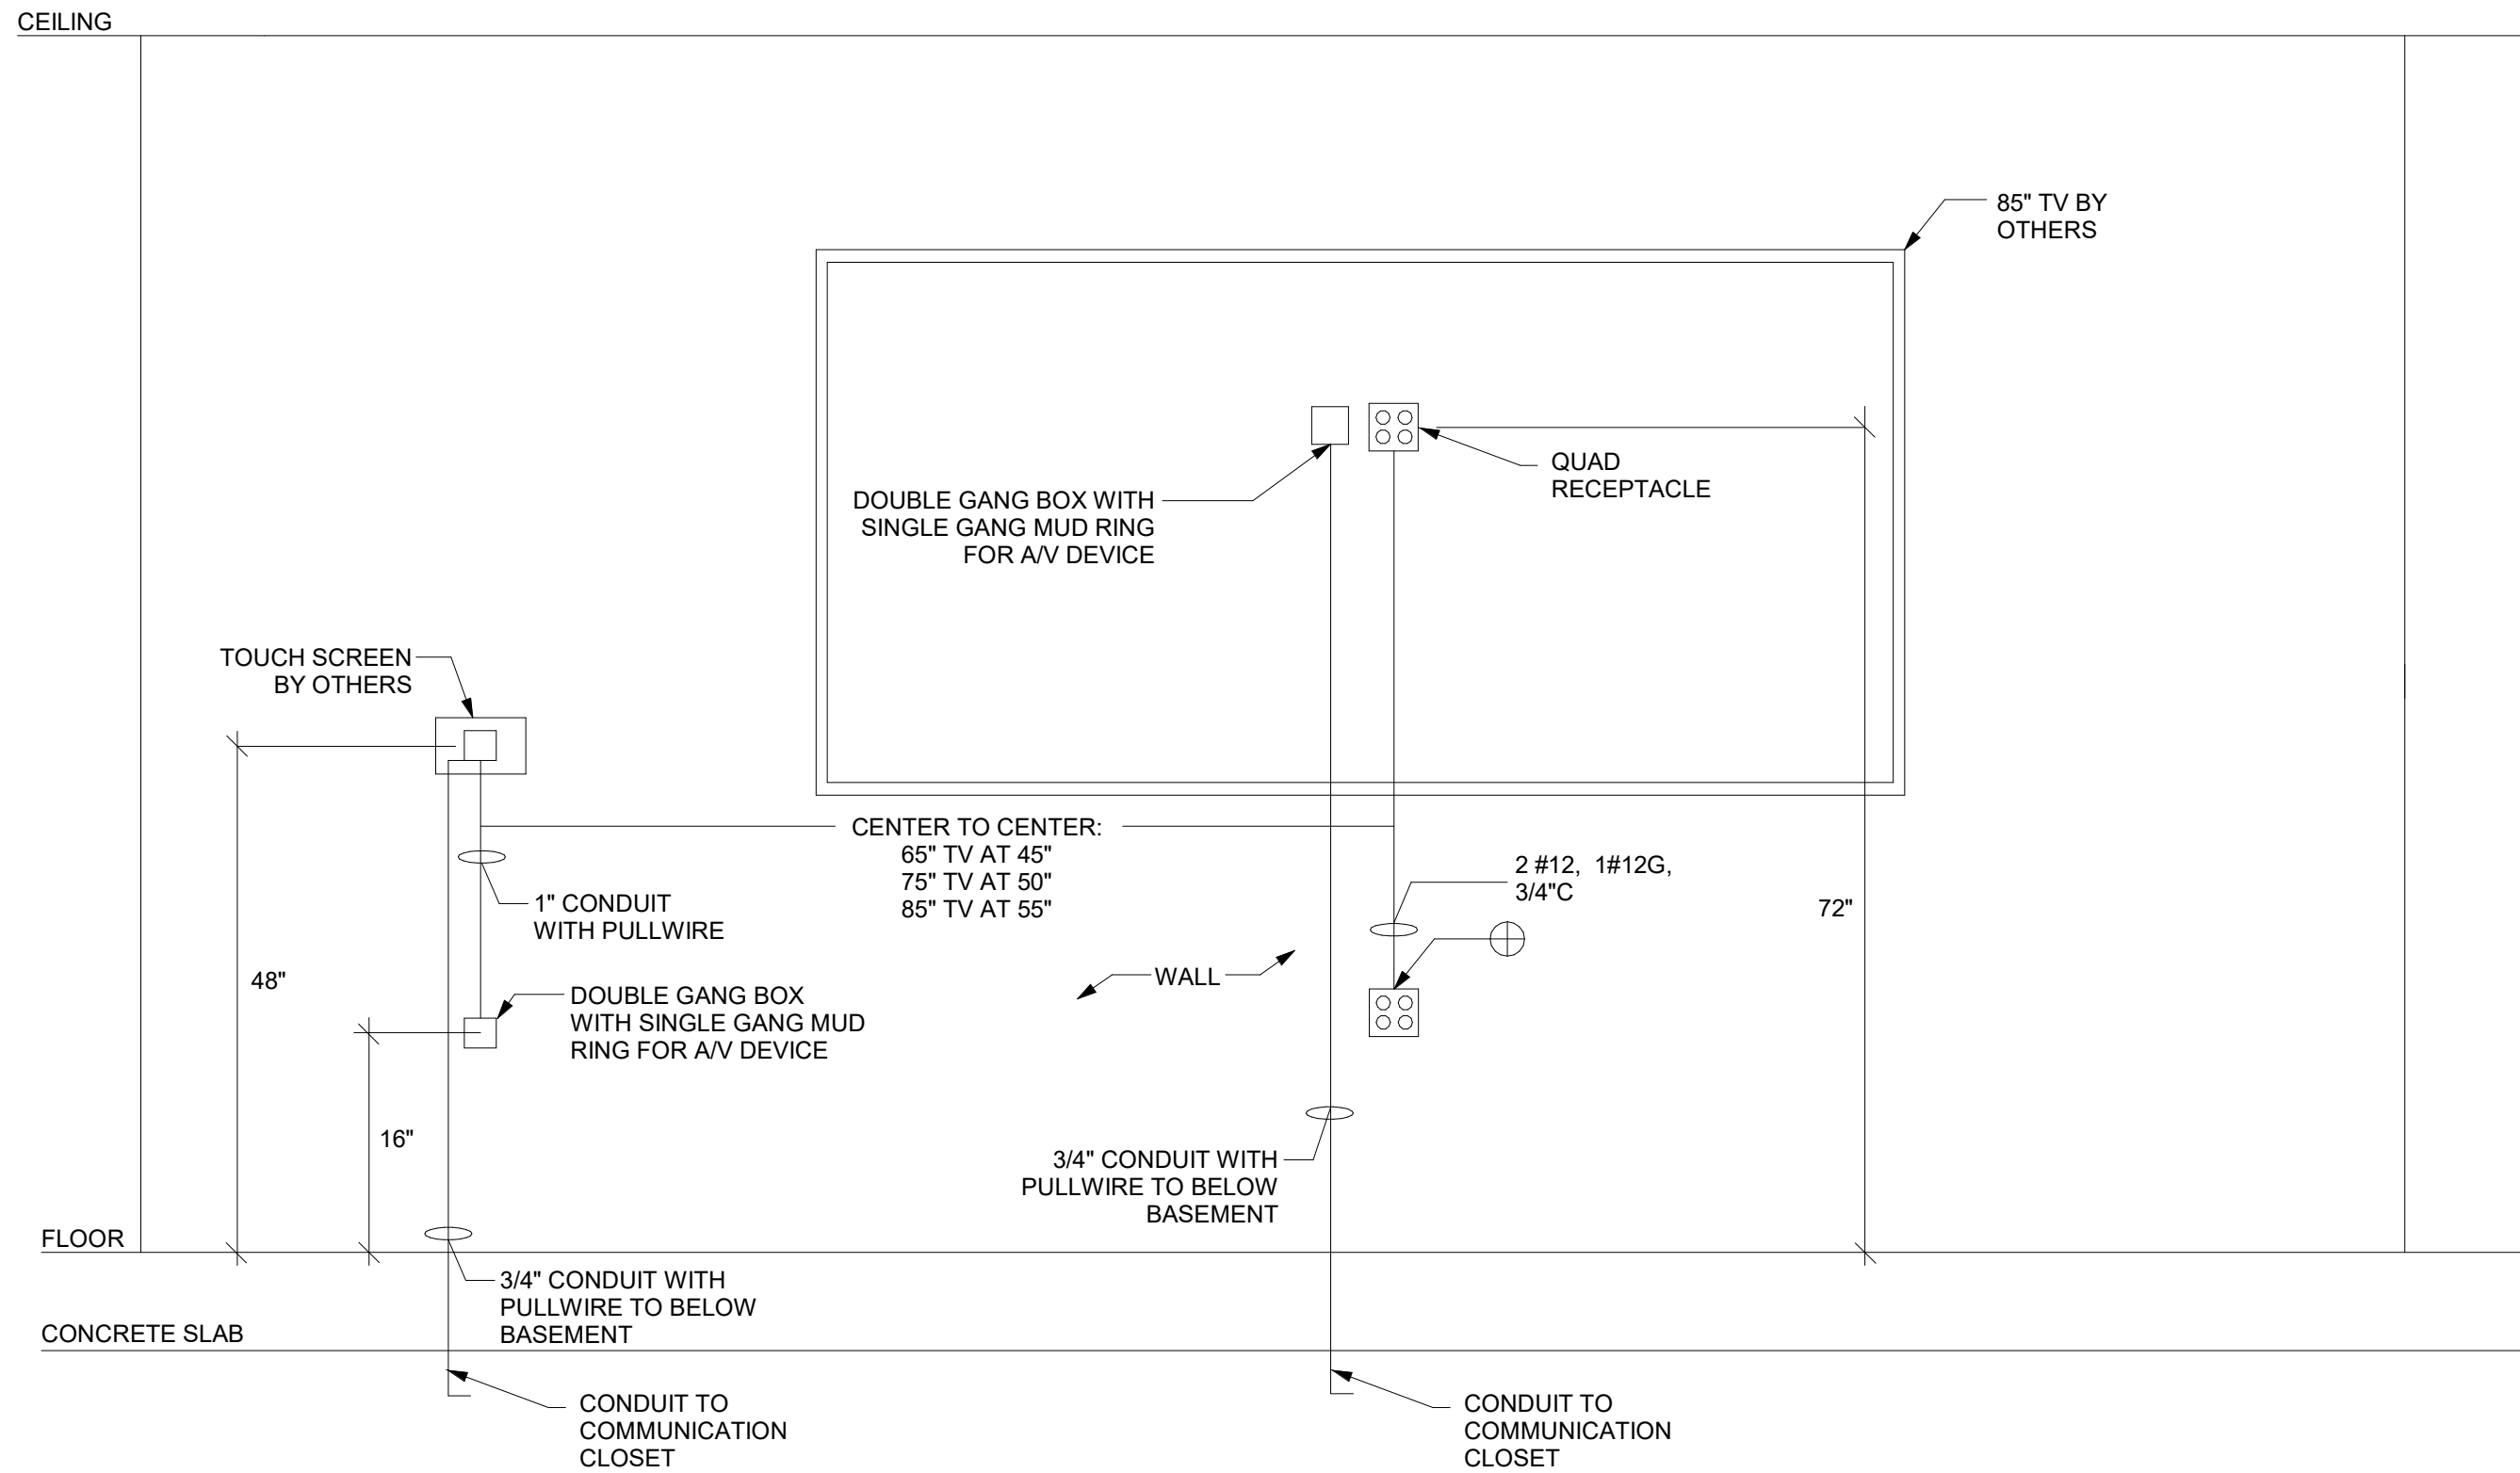

1 AV MOUNTING HEIGHT DETAIL
MF-E501 NOT TO SCALE

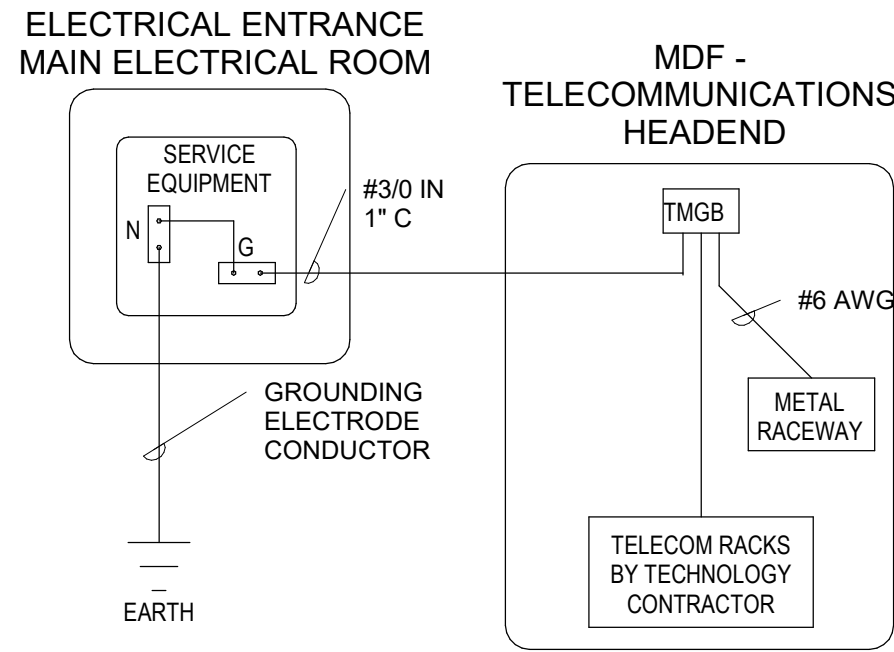


NOTES:

- A. IT IS THE INTENT FOR THE TELECOMMUNICATION GROUNDING SYSTEM TO UTILIZE THE "GROUND ELECTRODE CONDUCTOR (GEC)" ASSOCIATED WITH THE ELECTRICAL SERVICE ENTRANCE TO THE PROJECT SITE.
- B. FROM THE GEC, THE ELECTRICAL CONTRACTOR SHALL INSTALL A BONDING CONDUCTOR WHICH WILL CONNECT THE GEC TO A TELECOMMUNICATIONS MAIN GROUNDING BUS BAR (TMGB) LOCATED IN MDF ROOM. THE BONDING CONDUCTOR SHALL BE BONDED TO THE GEC AND THE TMGB. ADDITIONALLY, THE TMGB SHALL BE BONDED TO THE CLOSEST

TELECOMMUNICATIONS GROUNDING SYSTEM TO BE PROVIDED BY THE ELECTRICAL CONTRACTOR


4 DETAIL - TELECOMMUNICATIONS SYSTEM GROUNDING
MF-E501 NOT TO SCALE

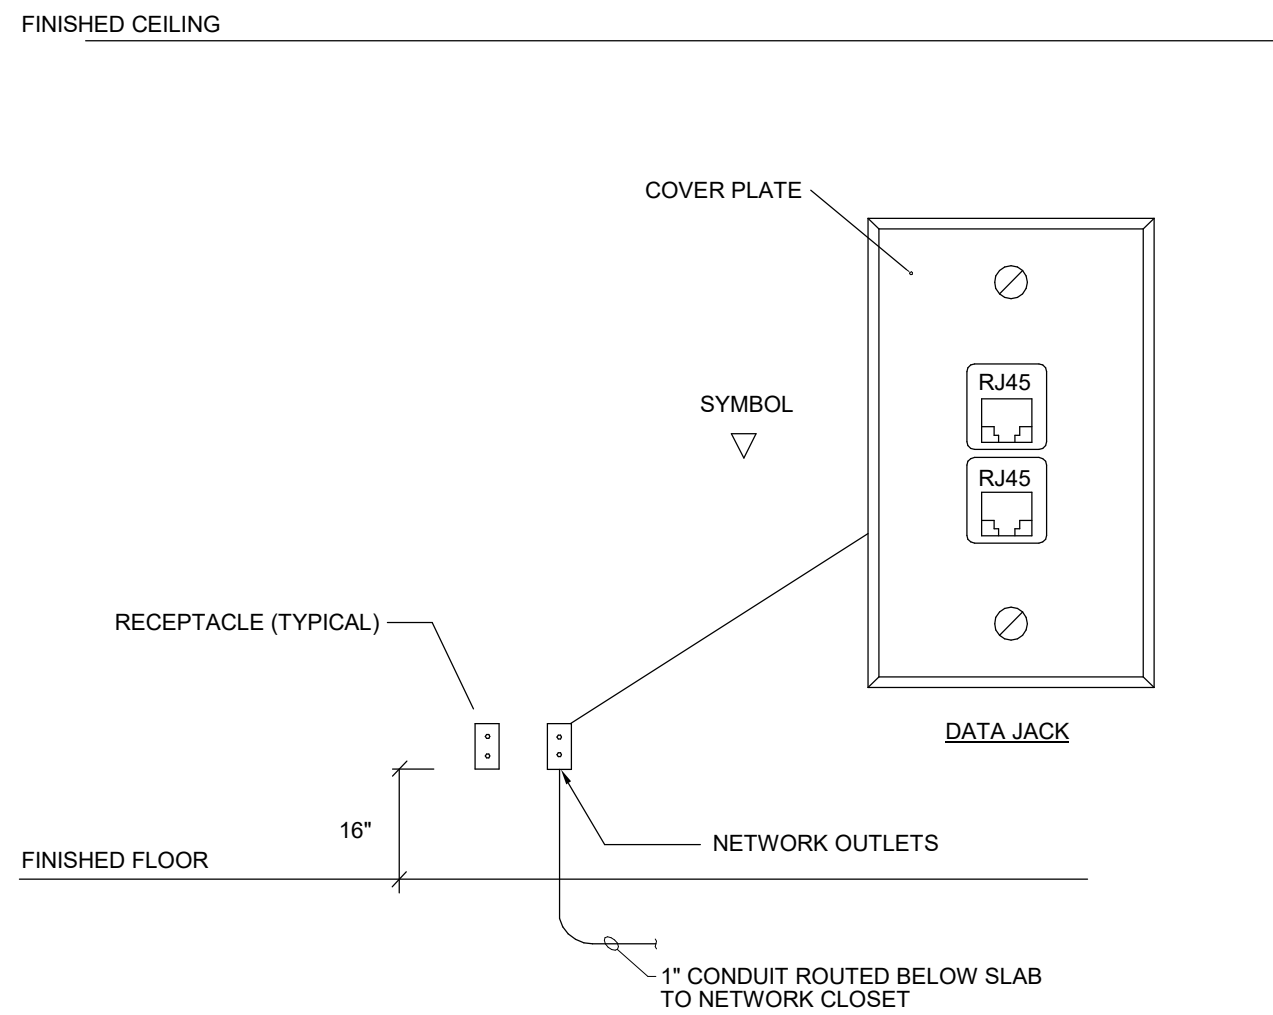

GENERAL NOTES:

- A. ELECTRICAL CONTRACTOR SHALL PROVIDE ALL CONDUIT, BOXES AND RECEPTACLES.
- B. ALL CAT-6 WIRING, FACEPLATES AND RJ45 CONNECTORS BY DATA CONTRACTOR.
- C. PROVIDE AN EMPTY CONDUIT WITH BLANK FACEPLATE AND PULL STRING.
- D. VERIFY LOCATIONS OF CASEWORK, CHALK BOARDS AND TACK BOARDS PRIOR TO INSTALLATION.

3 DETAIL - TYPICAL NETWORK OUTLET
MF-E501 NOT TO SCALE

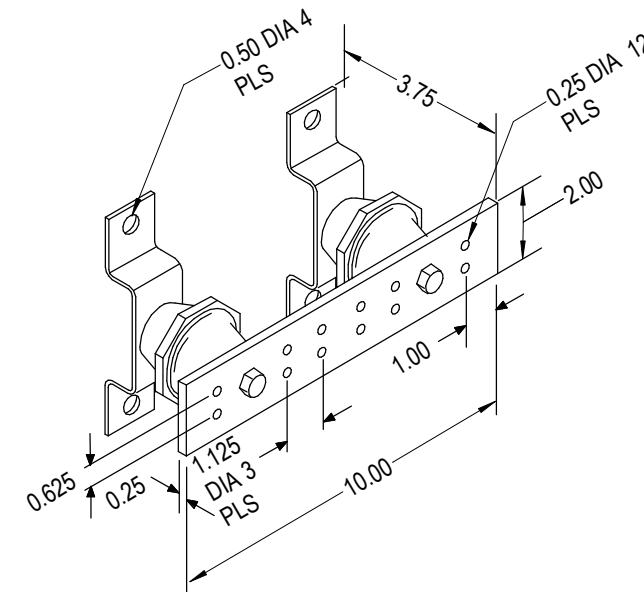

TGB

GENERAL NOTES:


1. MOUNT BACKBOARD MOUNTED BUSBARS @ 8'-6" AFF. UNLESS DIRECTED OTHERWISE BY OWNER.
2. THIS GROUNDING DETAIL IS APPLICABLE TO MDF(MAIN TELECOM) & IDF(TELECOM) CLOSETS.

2 DETAIL - TELECOMMUNICATIONS GROUNDING
MF-E501 NOT TO SCALE

Susan Hatchell
Landscape Architecture, PLLC
711 W. North Street, Raleigh, NC 27603
p: 919-838-9600 f: 919-838-9700

Wooten
120 North Boylan Avenue • Raleigh, NC 27603-1423
(919) 828-0031 • hewoodcompany.com
License Number: 7-9715

DETAILS

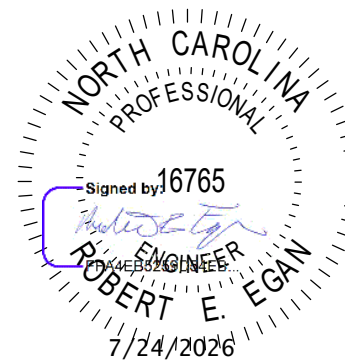

LAKE MYRA COUNTY PARK
Wake County, NC

REVISIONS

Date: 07/27/26

MF-E501