


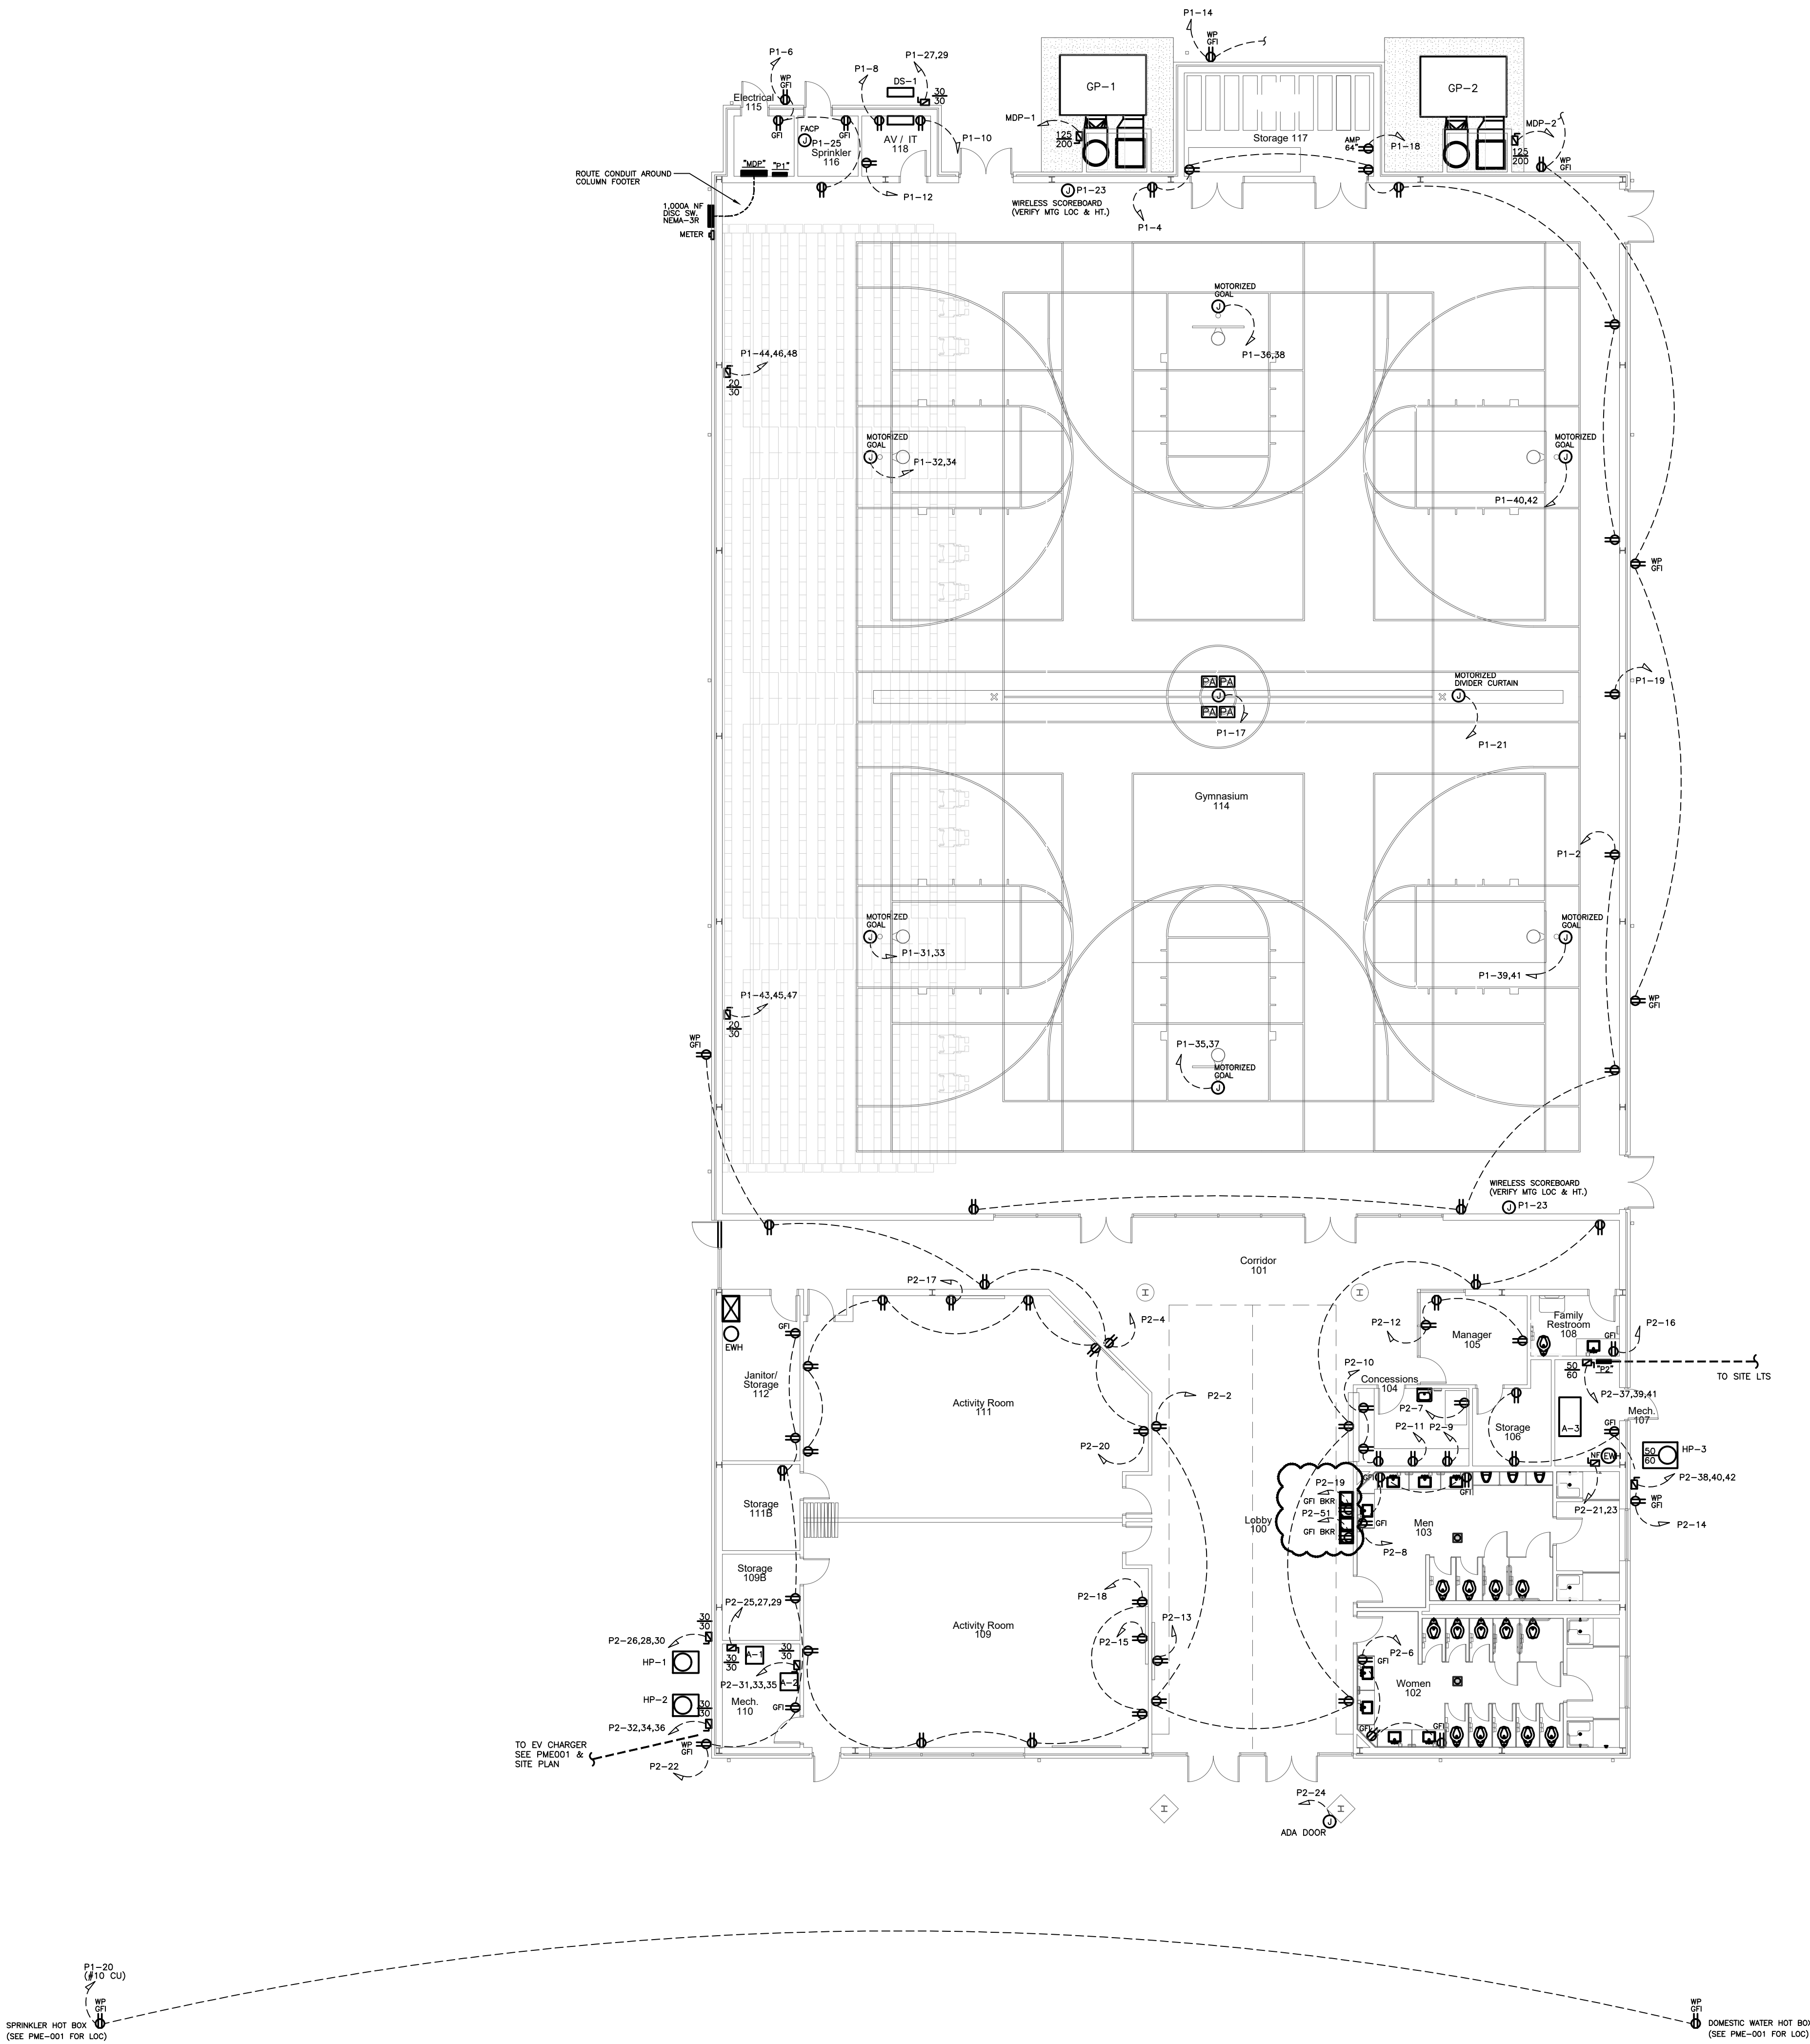

POWER PLAN (BASE BID)
SCALE: 3/32" = 1'-0"


Project No. 22207
Date: July 2023
Drawing no. E 101

ENGINEERING
S O U R C E of NC, P.A.
102-42 Regency Blvd. Greenville, NC 27834
E-mail Address: generalinfo@engrsource.com
Tel (252) 438-0238 • Fax (252) 438-0462 • Twp (252) 438-0462

8/31/23
D. Hite
Pitt County Office Park

THIS DRAWING IS THE PROPERTY OF ENGINEERING SOURCE OF NC, P.A. THIS DRAWING IS NOT TO BE COPIED IN WHOLE OR IN PART. THIS DRAWING OR THE INFORMATION HEREUPON IS NOT TO BE USED ON ANY OTHER PROJECT AND MUST BE RETURNED TO ENGINEERING SOURCE OF NC, P.A. UPON REQUEST. DO NOT SCALE THESE DRAWINGS. REFER TO ARCHITECTURAL DRAWINGS FOR EXACT DIMENSIONS.

COMMUNITY CENTER AND GYMNASIUM FOR
Pitt County Office Park
403 Government Circle, Greenville, NC 27834

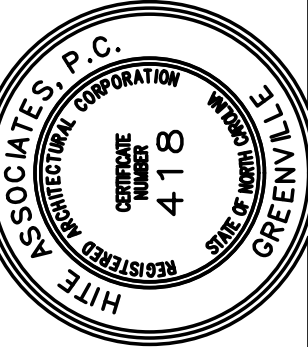

Hite associates
ARCHITECTURE / PLANNING / TECHNOLOGY
2600 Meridian Drive / Greenville, NC 27834 / tel (252) 757-0333

Rev	Date	Description
1	8/31/23	PRE-BID MTC & ADDENDUM #1
2		
3		
4		
5		
6		
7		
8		
9		
10		