


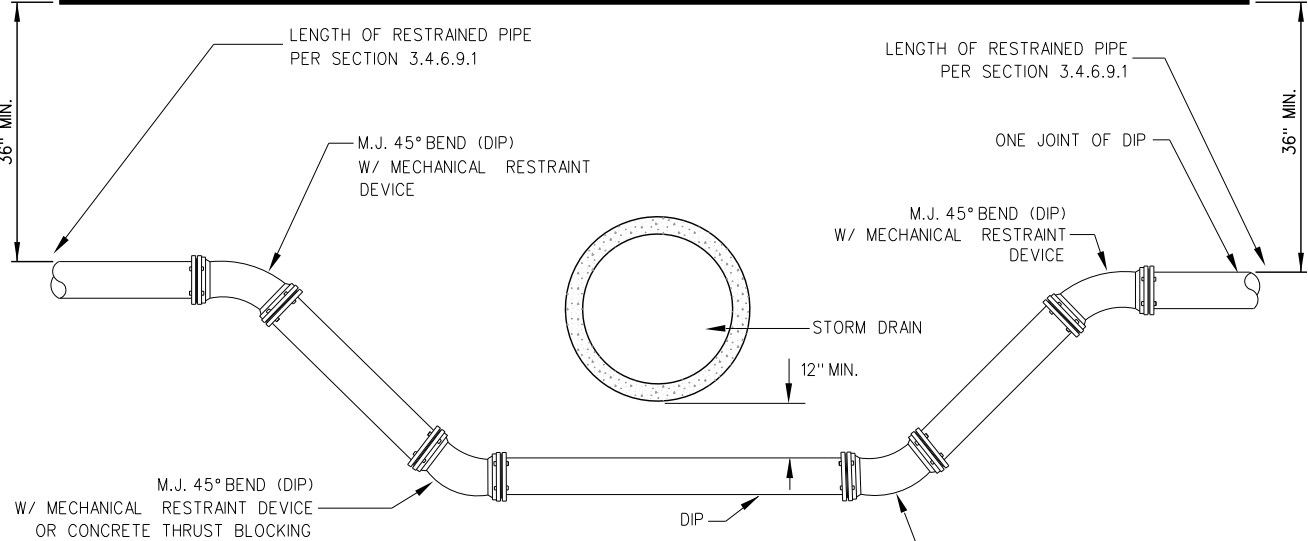

NOTES:

PLACE CONC. BLOCKING SUCH THAT IT WILL NOT INTERFERE WITH REMOVAL OF BOLTS.

PIPE DIAMETER GREATER THAN 12" SEE GUC ENGINEERING DEPT.



PIPE LENGTHS SHALL BE AS REQUIRED TO CONSTRUCT CROSSING.

ALL JOINTS TO BE RESTRAINED IN ACCORDANCE WITH MANUAL.

WATER MAIN AND STORM DRAIN CROSSING


201.2 WATER MAIN STORM DRAIN CROSSING (W-14)

SCALE: None

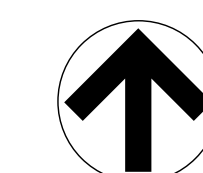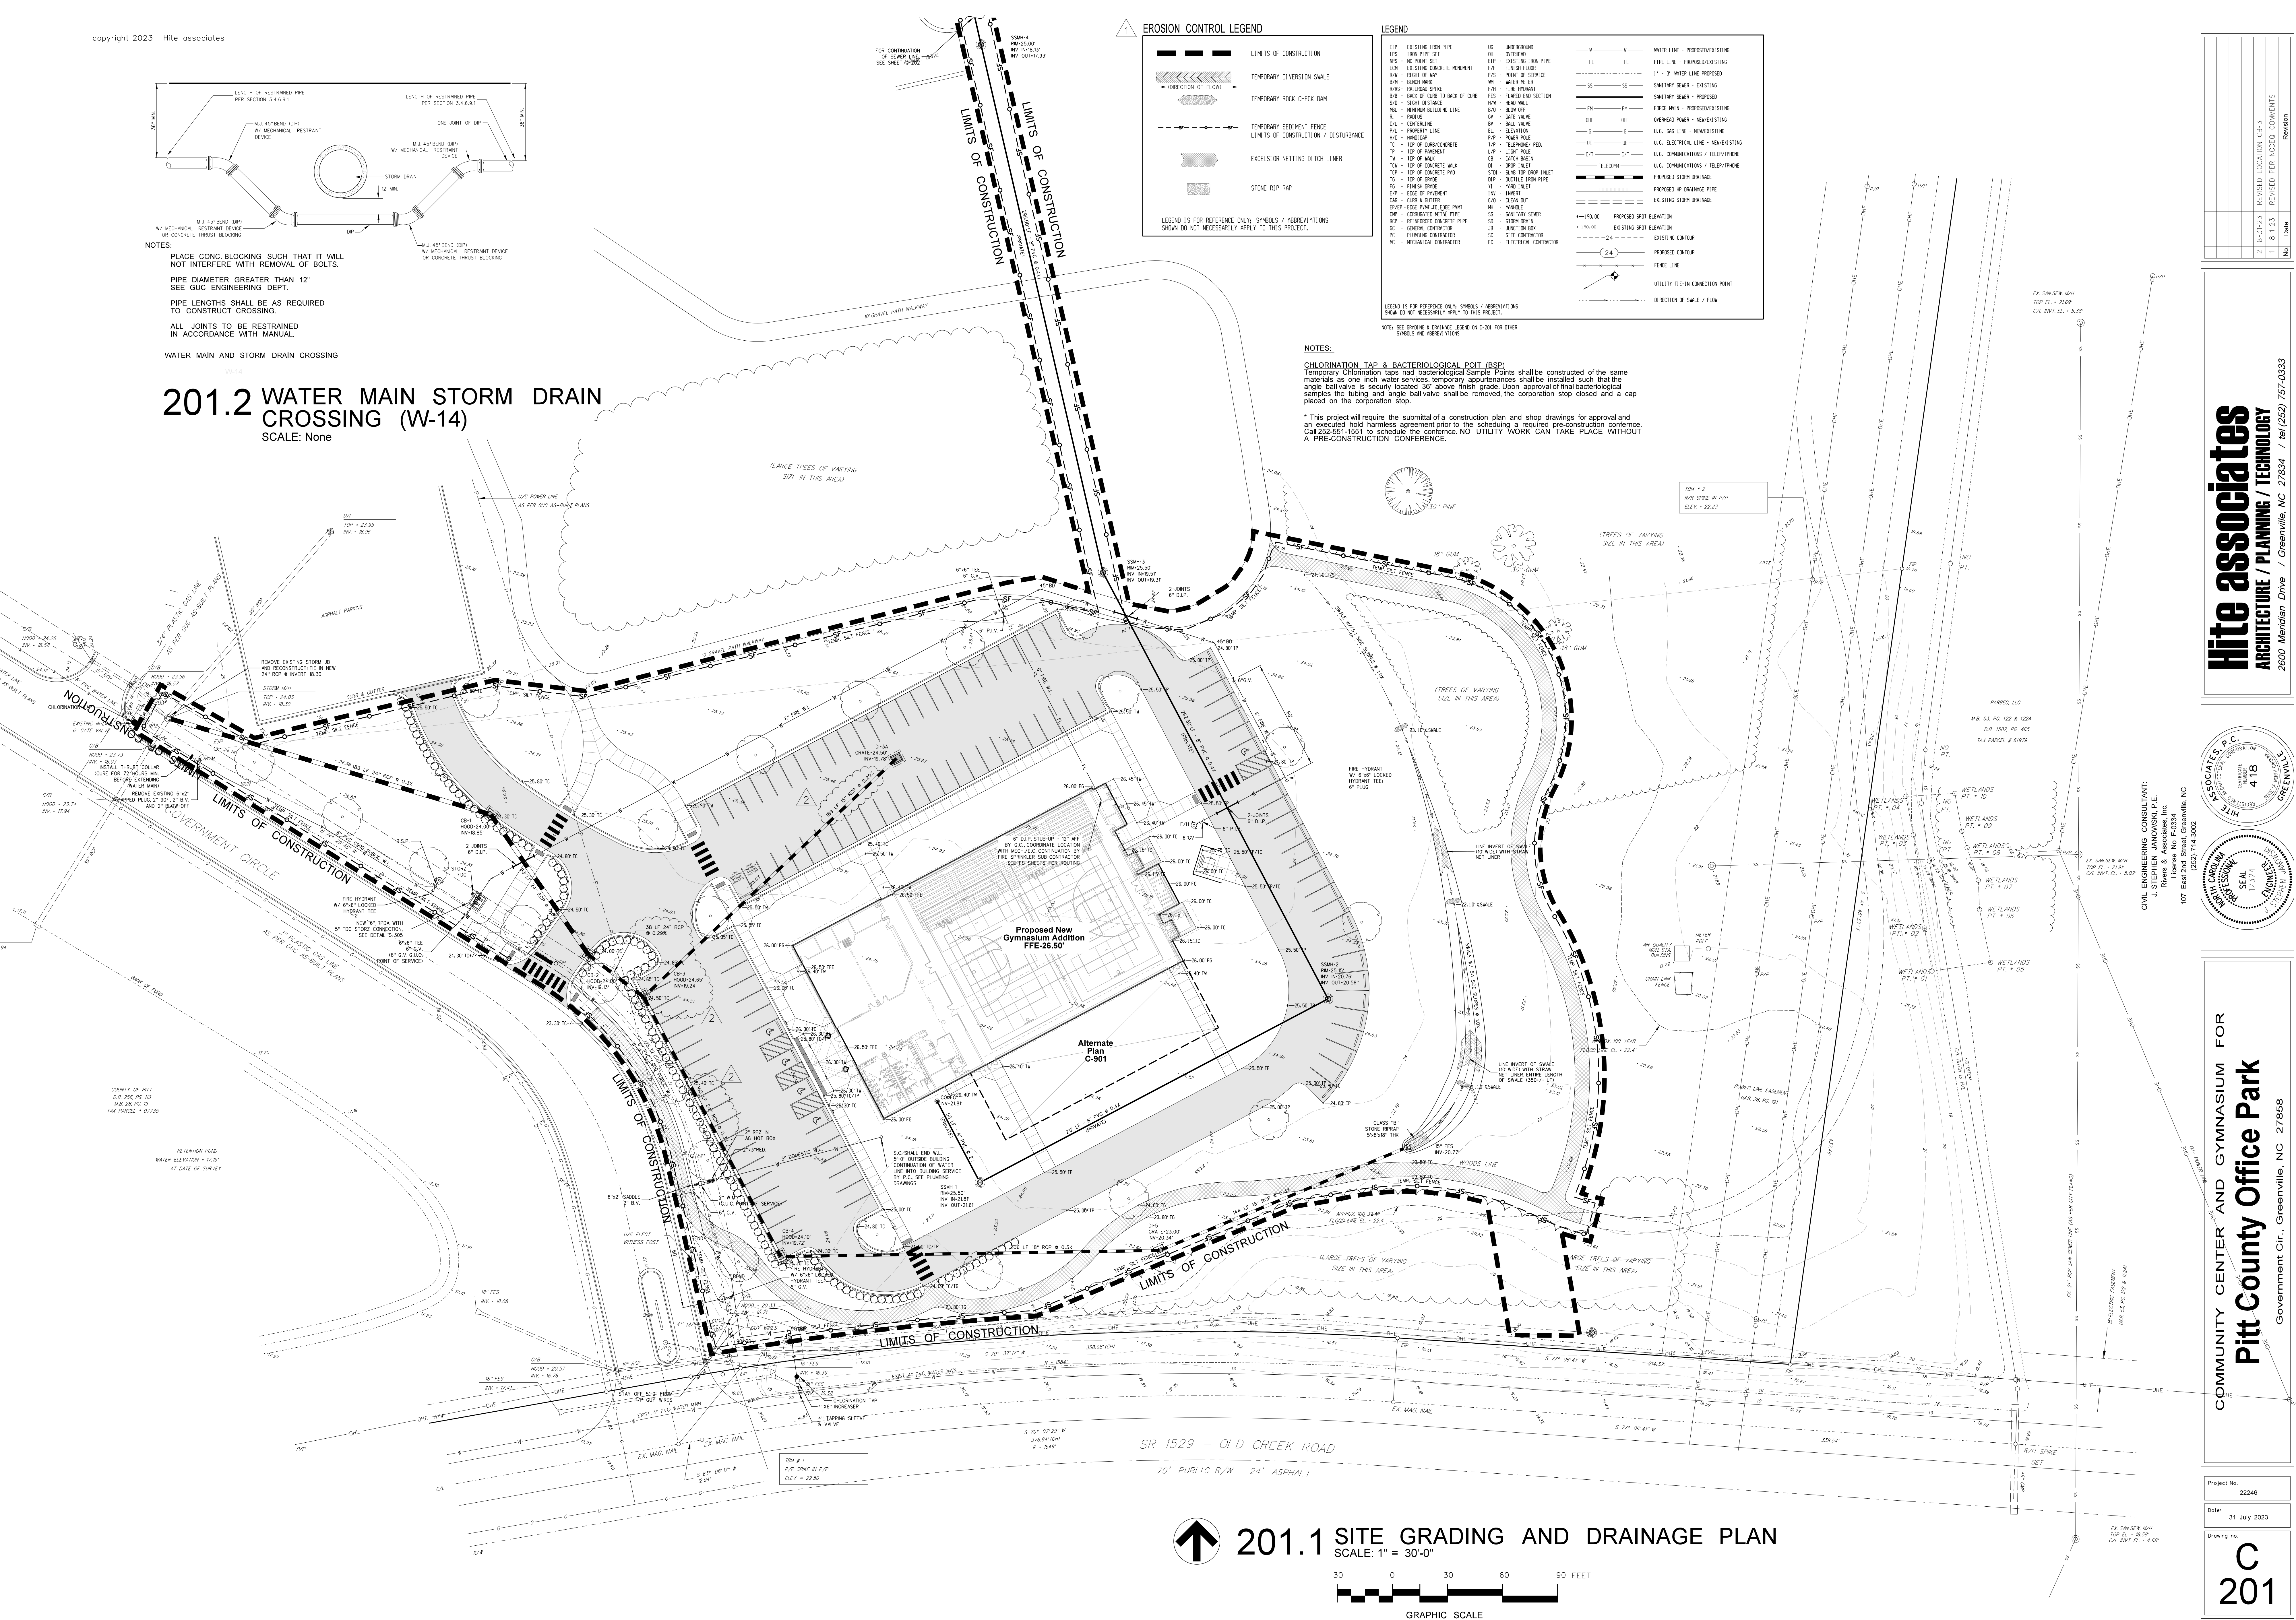


201.1 SITE GRADING AND DRAINAGE PLAN

SCALE: 1" = 30'-0"

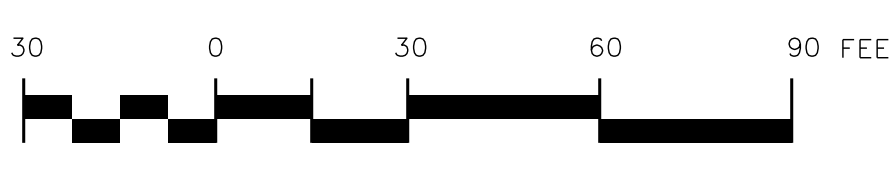


GRAPHIC SCALE

EROSION CONTROL LEGEND

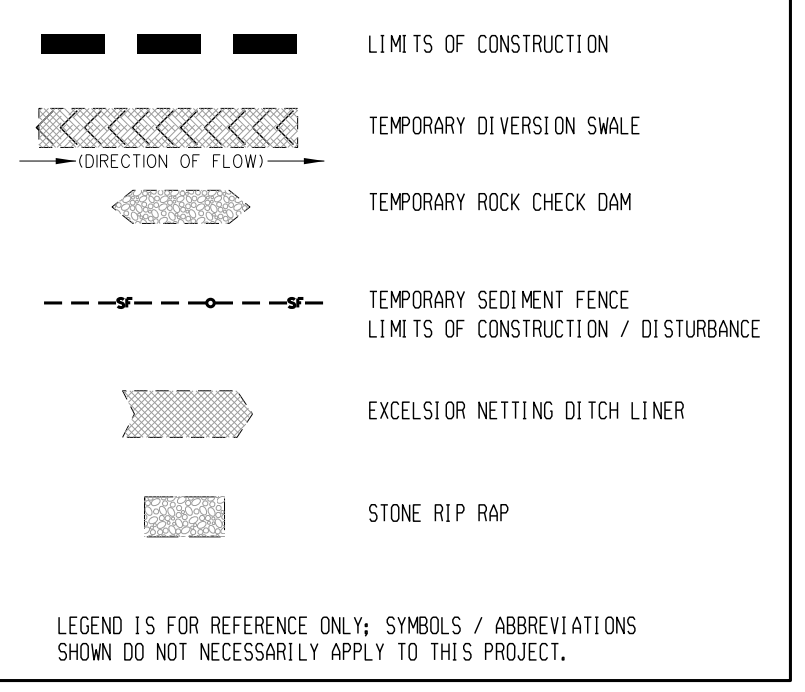

LEGEND

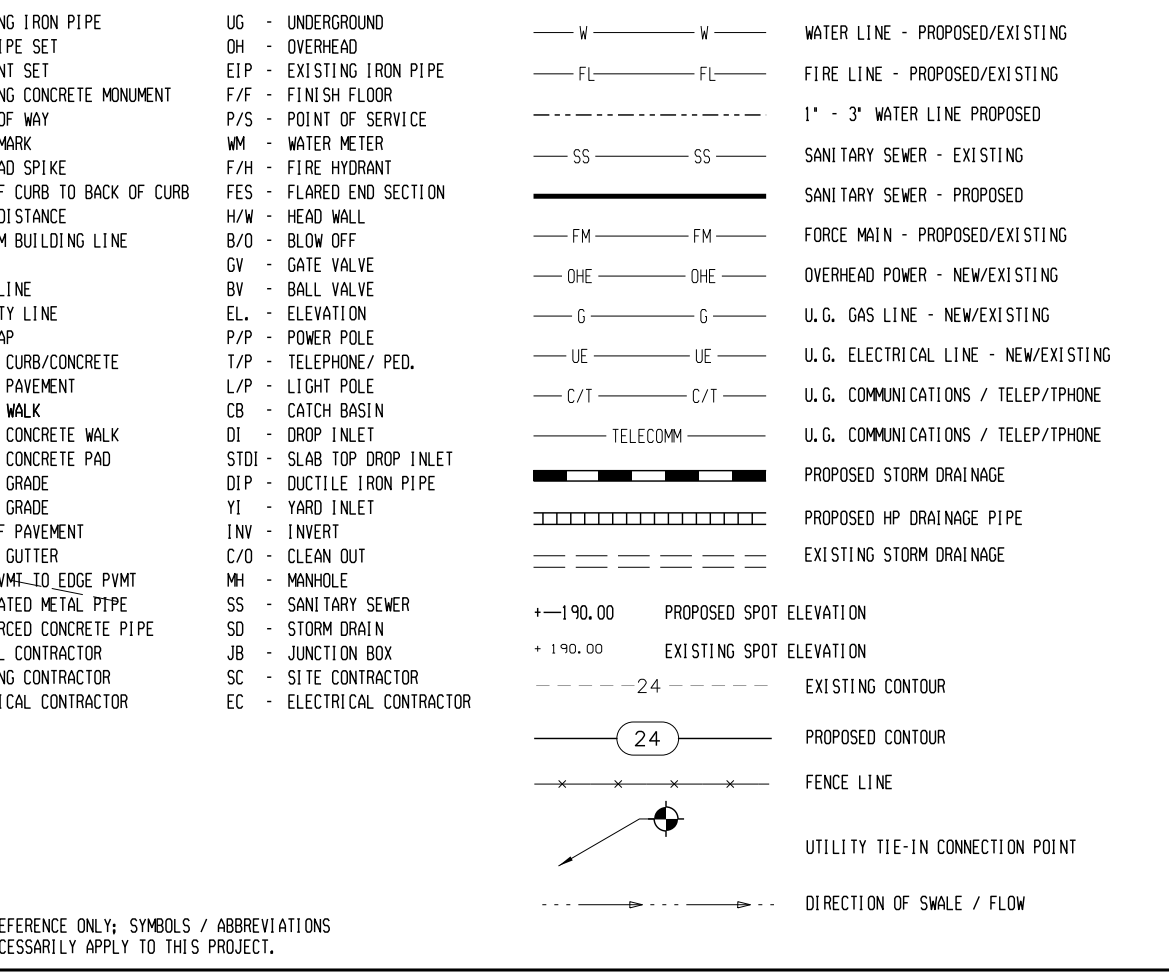

NOTES:


CHLORINATION TAP & BACTERIOLOGICAL POINT (BSP)

Temporary Chlorination taps and bacteriological Sample Points shall be constructed of the same materials as one inch water services. Temporary appearances shall be installed such that the angle ball valve is securely located 30" above finish grade. Upon approval of final bacteriological samples the tubing and angle ball valve shall be removed, the corporation stop closed and a cap placed on the corporation stop.

* This project will require the submittal of a construction plan and shop drawings for approval and an executed hold harmless agreement prior to the scheduling of a pre-construction conference. Call 252-551-1551 to schedule the conference. NO UTILITY WORK CAN TAKE PLACE WITHOUT A PRE-CONSTRUCTION CONFERENCE.

2	18-31-23	REVISED LOCATION CB-3
1	8-1-23	REVISED PER NCECO COMMENTS
No.	Date	Revision

Hite associates
ARCHITECTURE / PLANNING / TECHNOLOGY
2600 Meridian Drive / Greenville, NC 27834 / tel (252) 757-0333

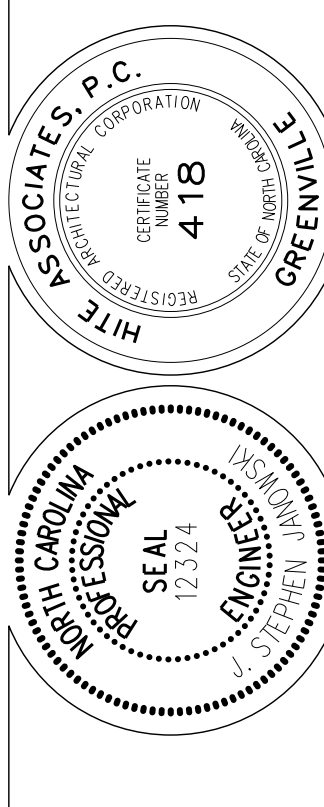

COMMUNITY CENTER AND GYMNASIUM FOR
Pitt County Office Park
Government Ctr., Greenville, NC 27858

Project No.	22246
Date:	31 July 2023
Drawing no.	C 201