


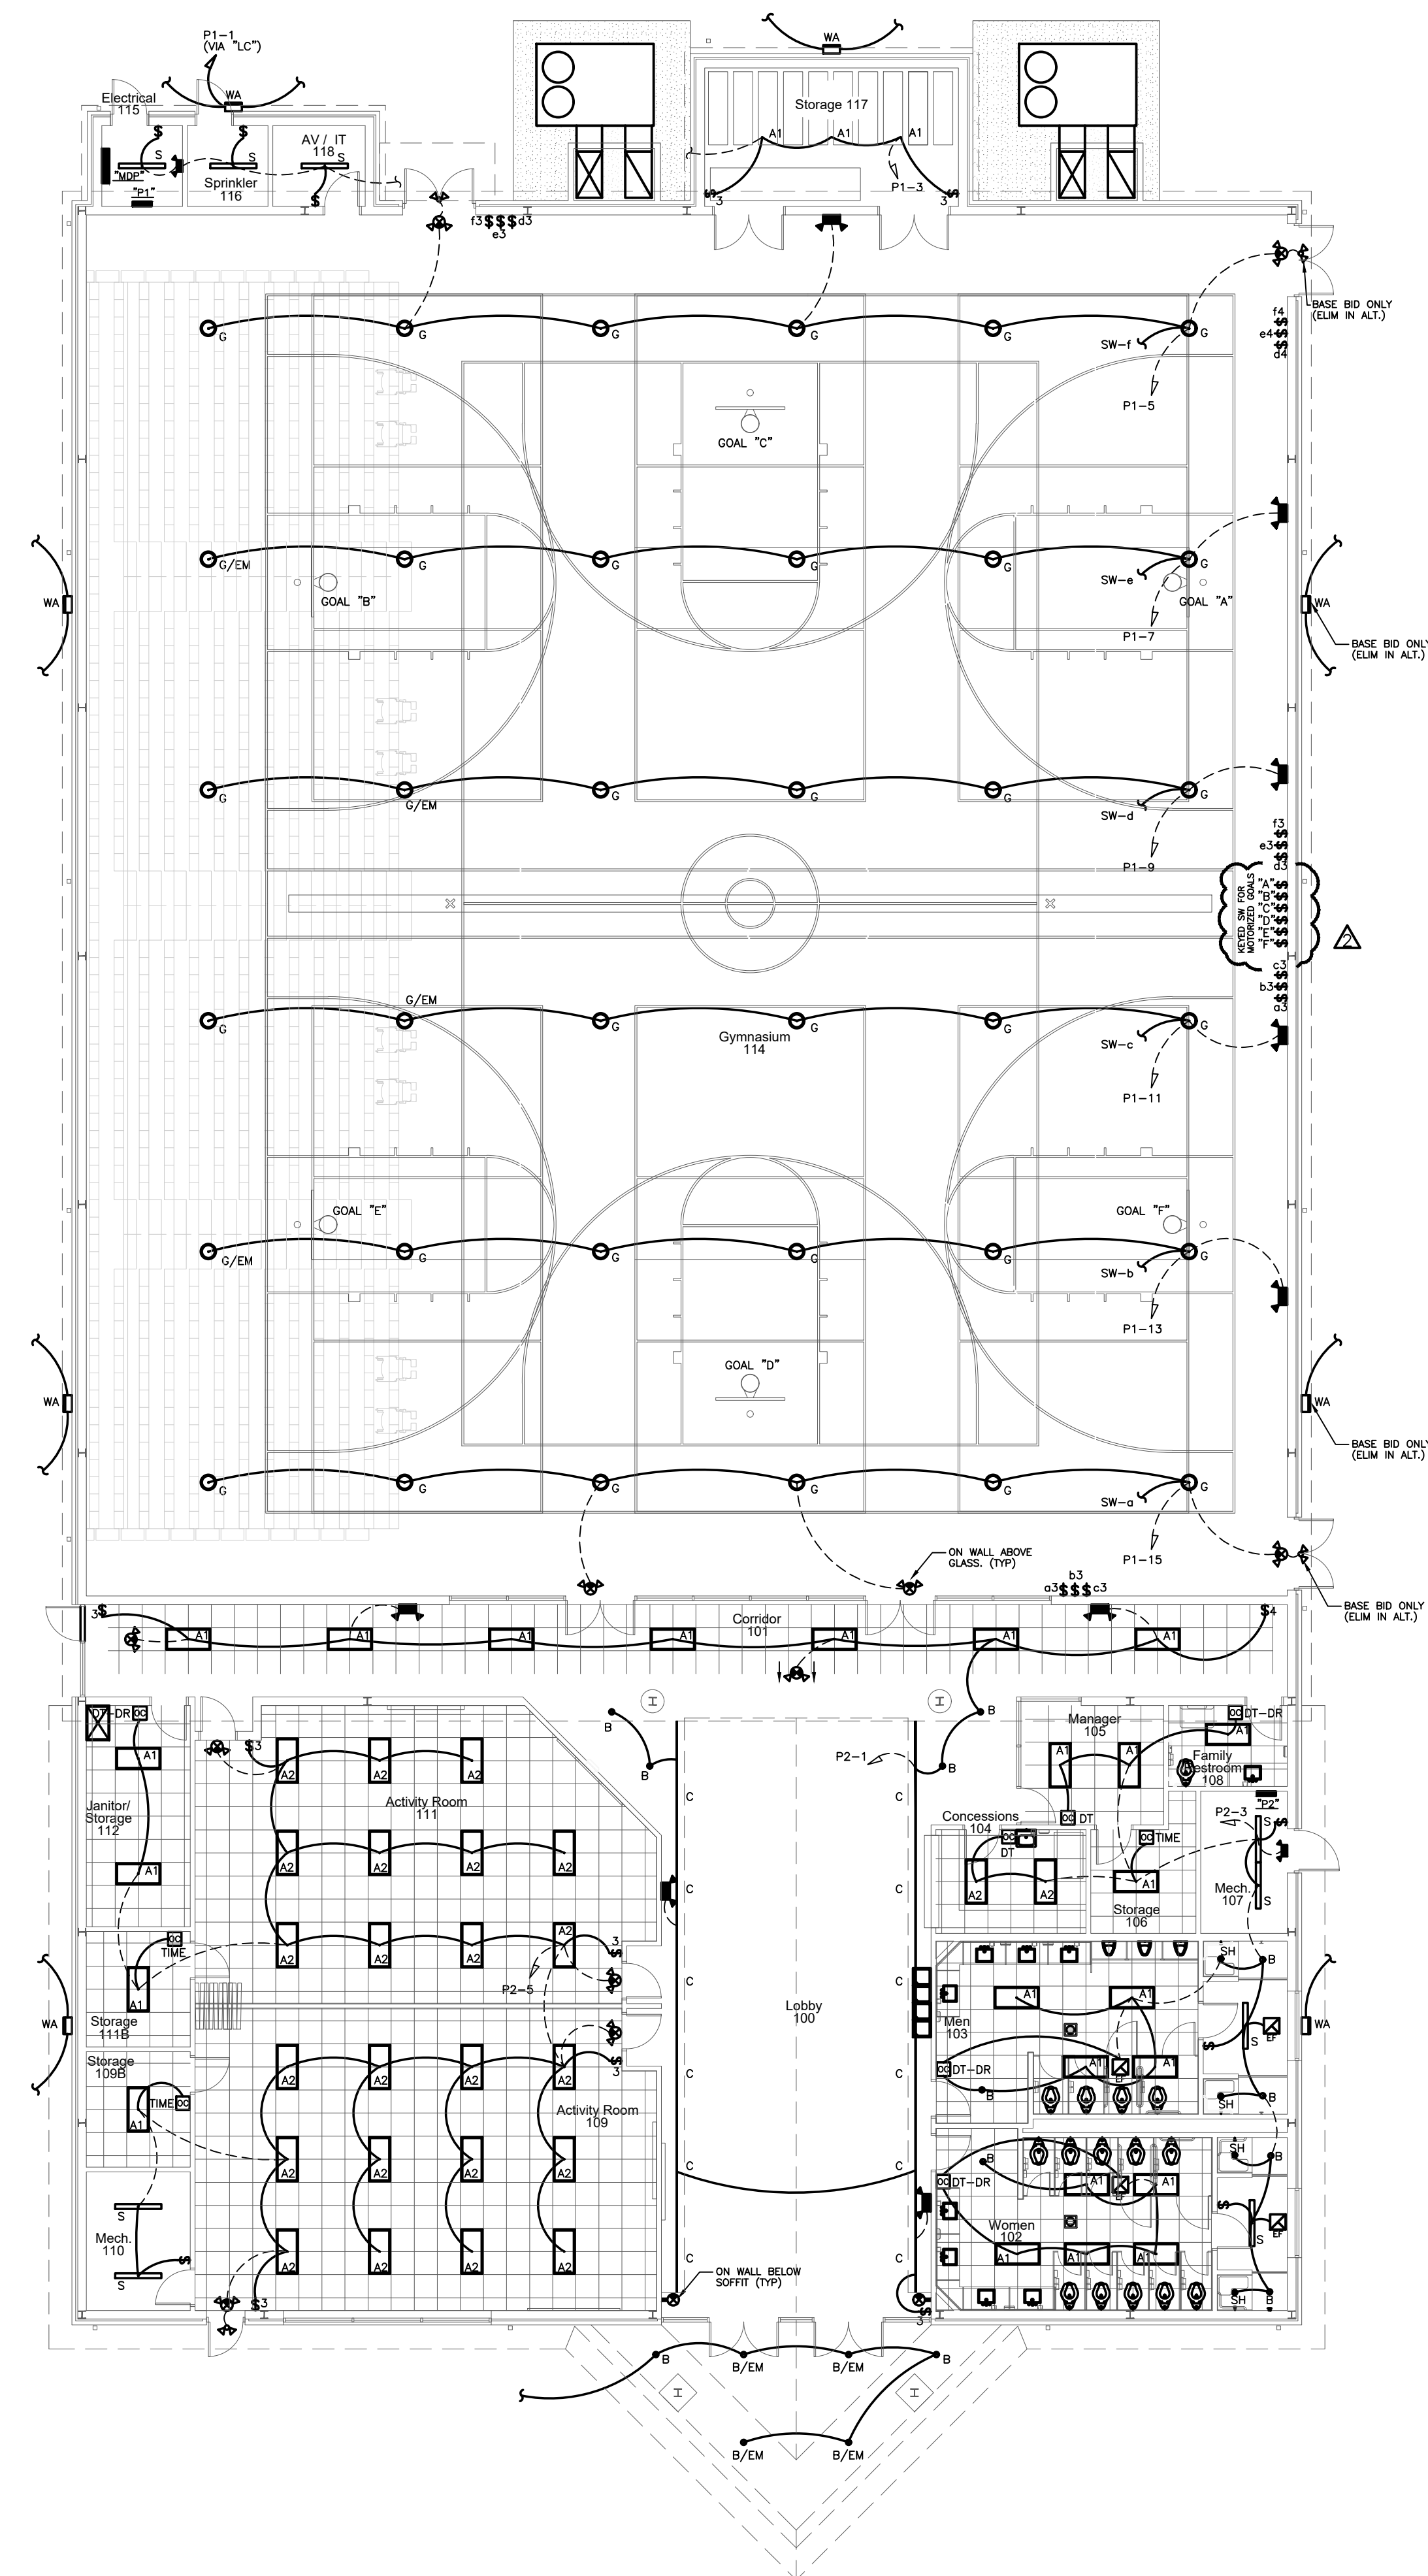

LIGHTING PLAN (BASE BID)
SCALE: 3/32" = 1'-0"