

## ROOM FINISH SCHEDULE


| BASE / ALTERNATE | MARK | AREA              | FLOOR         | BASE      | WALLS              | CEILING                     | CLG HEIGHT    | REMARKS         |
|------------------|------|-------------------|---------------|-----------|--------------------|-----------------------------|---------------|-----------------|
| BASE BID         | 100  | LOBBY             | LCT           | 4" RUBBER | PAINTED GYPBOARD   | PAINTED GYPBOARD            | VARIABLES     |                 |
| BASE BID         | 101  | CORRIDOR          | LCT           | 4" RUBBER | PAINTED GYPBOARD   | PAINTED GYPBD./ACOUST. TILE | 9'-11"/10'-0" |                 |
| BASE BID         | 102  | A WOMEN           | CER TILE      | CER TILE  | PAINTED / CER TILE | VINYL FACED GYPSUM PANEL    | 10'-0"        |                 |
| BASE BID         | 102  | B SHOWERS         | CER TILE      | CER TILE  | PAINTED / CER TILE | PNT M.R. GYPBOARD           | 9'-0"         |                 |
| BASE BID         | 103  | A MEN             | CER TILE      | CER TILE  | PAINTED / CER TILE | VINYL FACED GYPSUM PANEL    | 10'-0"        |                 |
| BASE BID         | 103  | B SHOWERS         | CER TILE      | CER TILE  | PAINTED / CER TILE | PNT M.R. GYPBOARD           | 9'-0"         |                 |
| BASE BID         | 104  | CONCESSIONS       | LCT           | 4" RUBBER | PAINTED GYPBOARD   | ACOUSTICAL TILE             | 10'-0"        |                 |
| BASE BID         | 105  | MANAGER           | LCT           | 4" RUBBER | PAINTED GYPBOARD   | ACOUSTICAL TILE             | 10'-0"        |                 |
| BASE BID         | 106  | STORAGE           | LCT           | 4" RUBBER | PAINTED GYPBOARD   | ACOUSTICAL TILE             | 10'-0"        |                 |
| BASE BID         | 107  | MECHANICAL        | SEALED CONC.  | NONE      | NONE               | EXPOSED STRUCTURE           | VARIABLES     |                 |
| BASE BID         | 108  | FAMILY RESTROOM   | CER TILE      | CER TILE  | PAINTED / CER TILE | VINYL FACED GYPSUM PANEL    | 9'-0"         |                 |
| BASE BID         | 109  | A ACTIVITY ROOM   | SPORTS FLOOR  | 4" RUBBER | PAINTED GYPBOARD   | ACOUSTICAL TILE             | 10'-0"        | SPEC SECT 09624 |
| BASE BID         | 109  | B STORAGE         | LCT           | 4" RUBBER | PAINTED GYPBOARD   | ACOUSTICAL TILE             | 10'-0"        |                 |
| BASE BID         | 110  | MECHANICAL        | SEALED CONC.  | NONE      | NONE               | EXPOSED STRUCTURE           | VARIABLES     |                 |
| BASE BID         | 111  | A ACTIVITY ROOM   | SPORTS FLOOR  | 4" RUBBER | PAINTED GYPBOARD   | ACOUSTICAL TILE             | 10'-0"        | SPEC SECT 09624 |
| BASE BID         | 111  | B STORAGE         | LCT           | 4" RUBBER | PAINTED GYPBOARD   | ACOUSTICAL TILE             | 10'-0"        |                 |
| BASE BID         | 112  | JANITOR / STORAGE | CER TILE      | CER TILE  | PAINTED / CER TILE | VINYL FACED GYPSUM PANEL    | 10'-0"        |                 |
| BASE BID         | 113  | NOT USED          | NOT USED      | NOT USED  | NOT USED           | NOT USED                    | NOT USED      |                 |
| BASE BID         | 114  | GIMNASIUM         | WOOD FLOORING | 4" RUBBER | PAINTED GYPBOARD   | PNT STRUCT / SIMPLE SAVER   | 10'-0"        | SPEC SECT 09550 |
| BASE BID         | 115  | ELECTRICAL        | SEALED CONC.  | NONE      | NONE               | EXPOSED STRUCTURE           | VARIABLES     |                 |
| BASE BID         | 116  | SPRINKLER RISER   | SEALED CONC.  | NONE      | NONE               | EXPOSED STRUCTURE           | VARIABLES     |                 |
| BASE BID         | 117  | STORAGE           | LCT           | 4" RUBBER | PAINTED GYPBOARD   | ACOUSTICAL TILE             | 10'-0"        |                 |
| BASE BID         | 118  | AV / IT           | SEALED CONC.  | NONE      | NONE               | EXPOSED STRUCTURE           | VARIABLES     |                 |
| ALTERNATE        | 119  | CORRIDOR          | LCT           | 4" RUBBER | PAINTED GYPBOARD   | ACOUSTICAL TILE             | 10'-0"        |                 |
| ALTERNATE        | 120  | STORAGE           | LCT           | 4" RUBBER | PAINTED GYPBOARD   | ACOUSTICAL TILE             | 10'-0"        |                 |
| ALTERNATE        | 121  | A ACTIVITY ROOM   | SPORTS FLOOR  | 4" RUBBER | PAINTED GYPBOARD   | ACOUSTICAL TILE             | 10'-0"        | SPEC SECT 09624 |
| ALTERNATE        | 121  | B STORAGE         | LCT           | 4" RUBBER | PAINTED GYPBOARD   | ACOUSTICAL TILE             | 10'-0"        |                 |
| ALTERNATE        | 121  | C MECHANICAL      | SEALED CONC.  | NONE      | NONE               | EXPOSED STRUCTURE           | VARIABLES     |                 |
| ALTERNATE        | 122  | A ACTIVITY ROOM   | SPORTS FLOOR  | 4" RUBBER | PAINTED GYPBOARD   | ACOUSTICAL TILE             | 10'-0"        | SPEC SECT 09624 |
| ALTERNATE        | 122  | B STORAGE         | LCT           | 4" RUBBER | PAINTED GYPBOARD   | ACOUSTICAL TILE             | 10'-0"        |                 |
| ALTERNATE        | 123  | MECHANICAL        | SEALED CONC.  | NONE      | NONE               | EXPOSED STRUCTURE           | VARIABLES     |                 |
| ALTERNATE        | 124  | A ACTIVITY ROOM   | SPORTS FLOOR  | 4" RUBBER | PAINTED GYPBOARD   | ACOUSTICAL TILE             | 10'-0"        | SPEC SECT 09624 |
| ALTERNATE        | 124  | B STORAGE         | LCT           | 4" RUBBER | PAINTED GYPBOARD   | ACOUSTICAL TILE             | 10'-0"        |                 |
| ALTERNATE        | 125  | STORAGE           | LCT           | 4" RUBBER | PAINTED GYPBOARD   | ACOUSTICAL TILE             | 10'-0"        |                 |

NOTES

- |   |                                                                                                                                      |
|---|--------------------------------------------------------------------------------------------------------------------------------------|
| 1 | GYPSBOARD CEILINGS AND BULKHEADS: PAINT FLAT WHITE LATEX, NO TEXTURE, USE STRAIGHT CORNER BEADS, NO BULLNOSE EXCEPT WHERE INDICATED. |
|---|--------------------------------------------------------------------------------------------------------------------------------------|

## WALL LEGEND

- |                                                                                   |                                                                                                                                                              |
|-----------------------------------------------------------------------------------|--------------------------------------------------------------------------------------------------------------------------------------------------------------|
|  | BRICK AND METAL CLADDING WITH AIRSPACE OVER XPS INSULATION ON 5/8" SHEATHING ON 8" METAL STUDS WITH INSULATION AS SPECIFIED. INTERIOR FINISHES AS SCHEDULED. |
|  | 8" METAL STUD WALL WITH GYPBOARD EACH SIDE WITH SOUND ATTENUATION BATTS                                                                                      |
|  | 3 5/8" METAL STUD WALL WITH GYPBOARD EACH SIDE WITH SOUND ATTENUATION BATTS                                                                                  |
|  | TWO HOUR RATED FIRE BARRIER                                                                                                                                  |

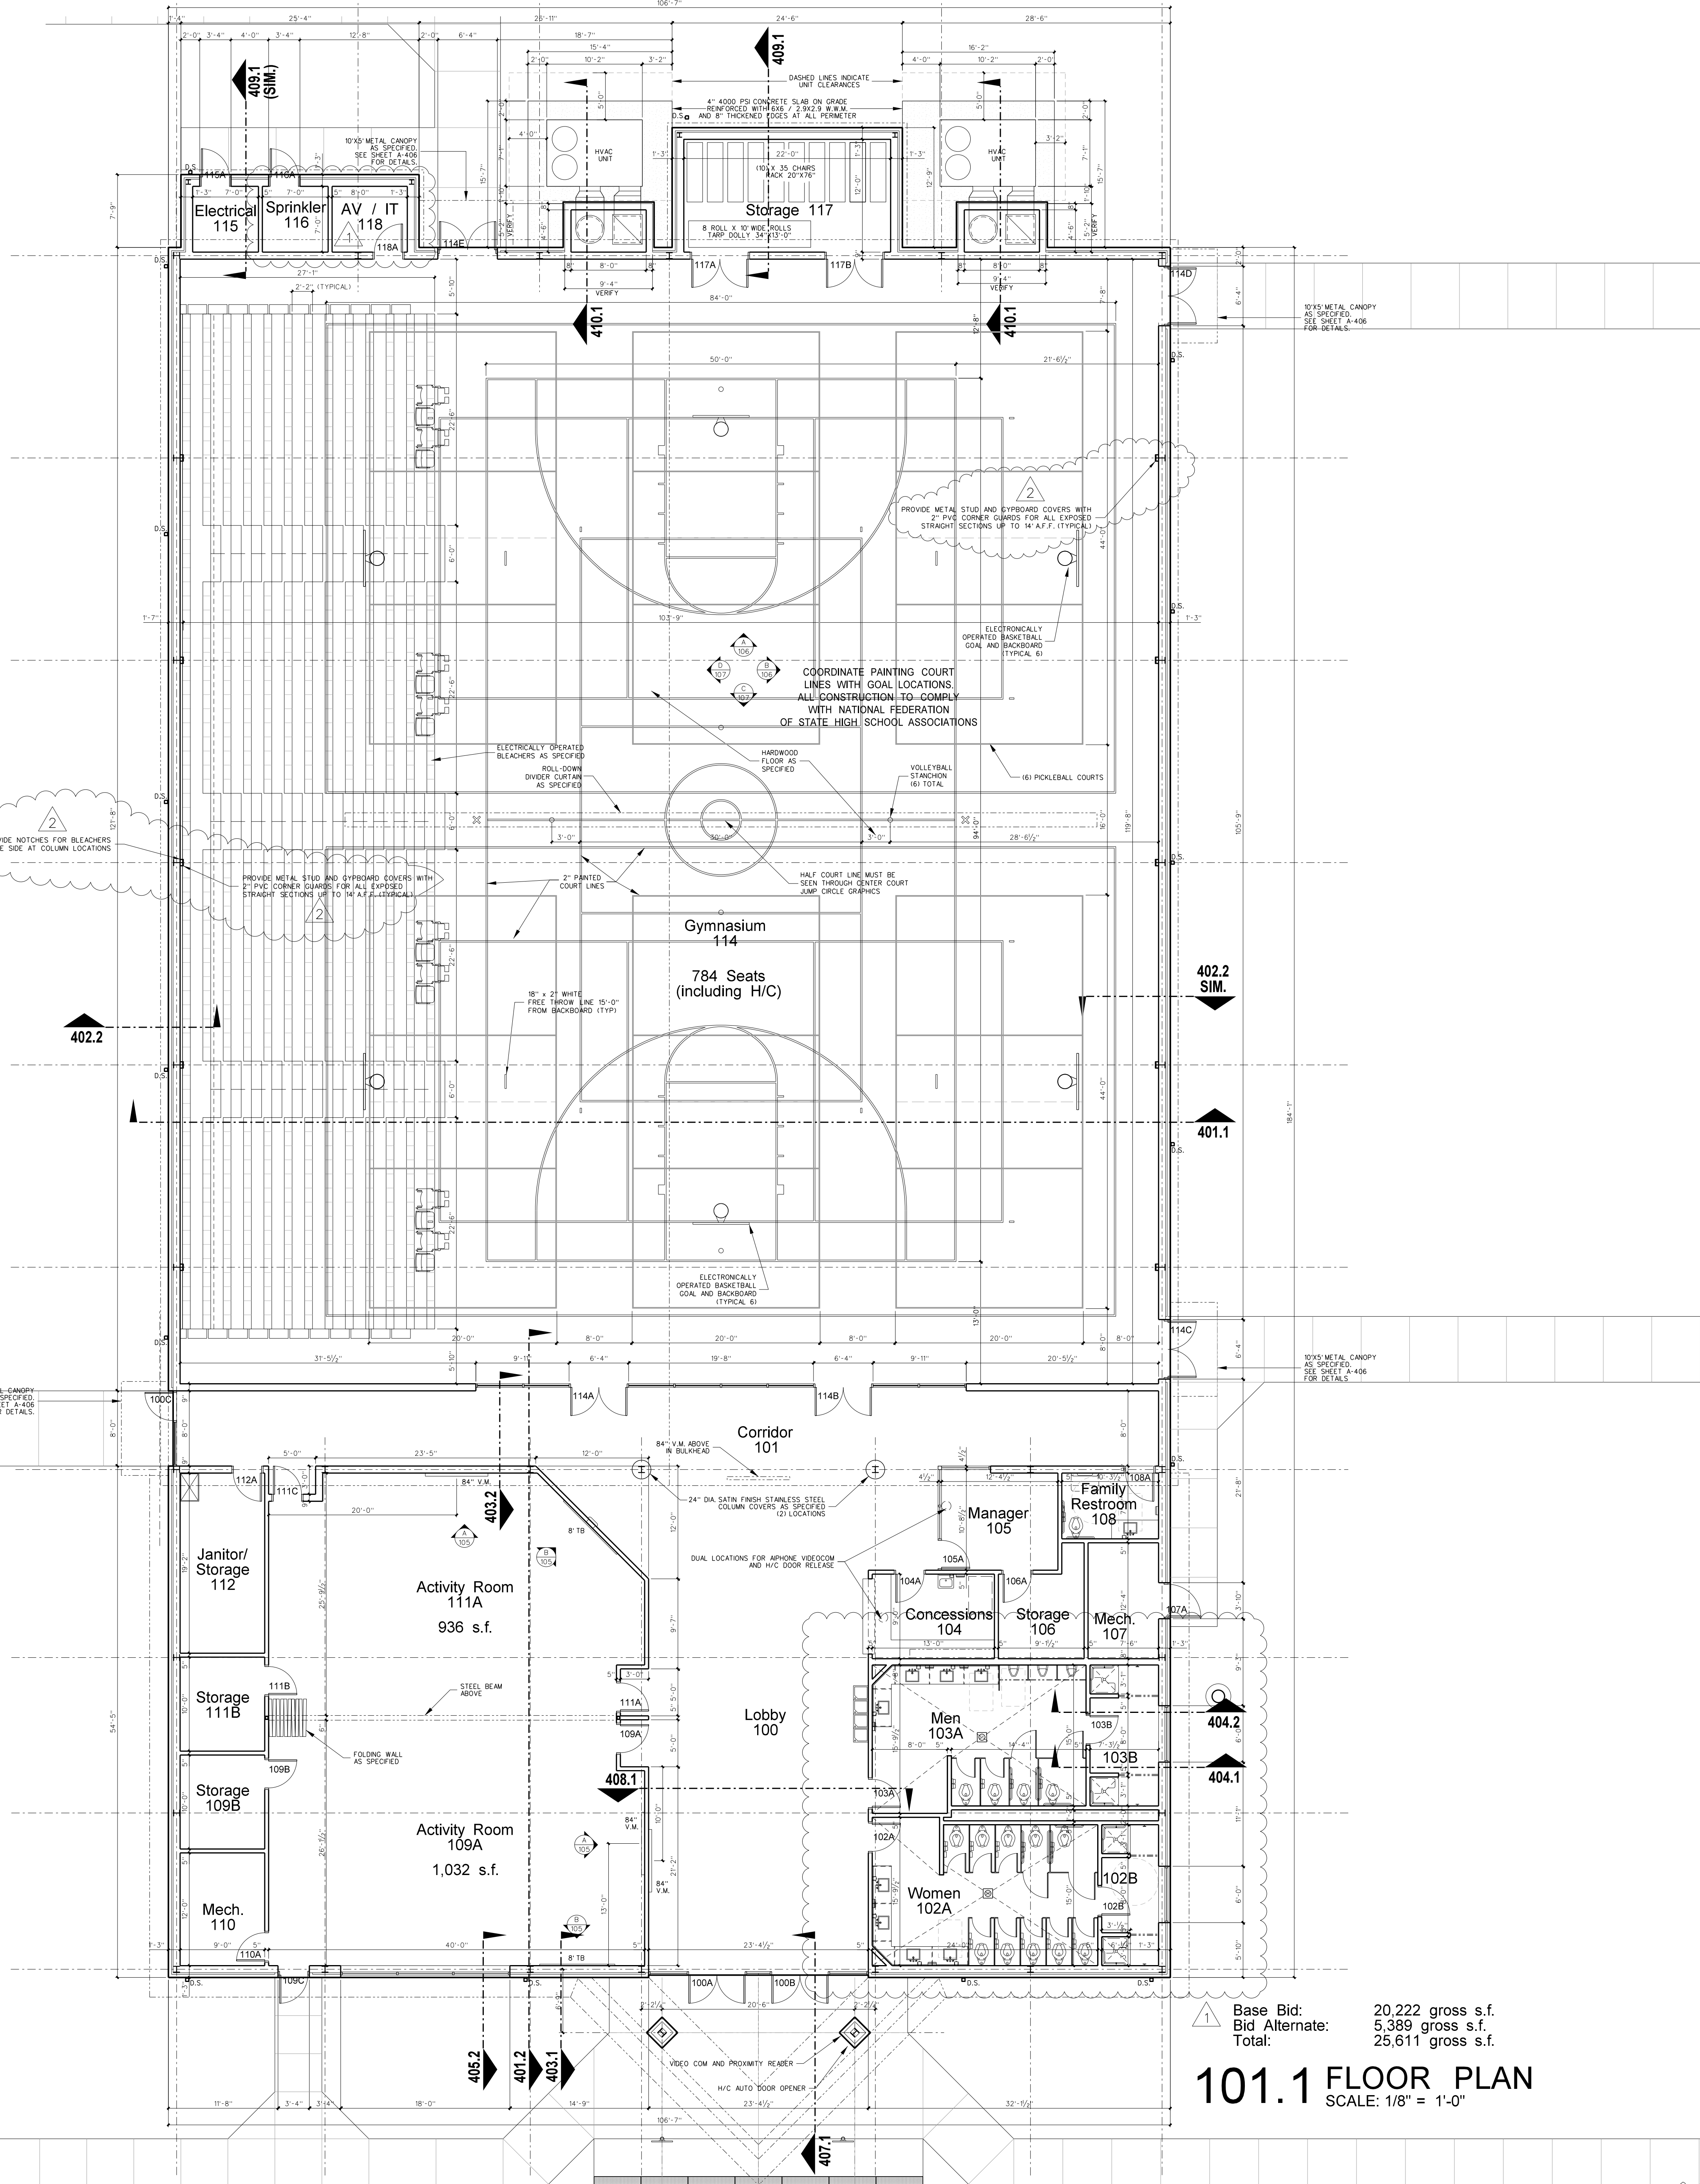

|                |                   |
|----------------|-------------------|
| Base Bid:      | 20,222 gross s.f. |
| Bid Alternate: | 5,389 gross s.f.  |
| Total:         | 25,611 gross s.f. |

101.1 FLOOR PLAN  
SCALE: 1/8" = 1'-0"