

ROOM FINISH SCHEDULE


| BASE / ALTERNATE | MARK | AREA              | FLOOR         | BASE      | WALLS              | CEILING                    | CLG HEIGHT    | REMARKS         |
|------------------|------|-------------------|---------------|-----------|--------------------|----------------------------|---------------|-----------------|
| BASE BID         | 100  | LOBBY             | LCT           | 4" RUBBER | PAINTED GYPBOARD   | PAINTED GYPBOARD           | VARIES        |                 |
| BASE BID         | 101  | CORRIDOR          | LCT           | 4" RUBBER | PAINTED GYPBOARD   | PAINTED GYPBD./ACOUS. TILE | 9'-11"/10'-0" |                 |
| BASE BID         | 102  | A WOMEN           | CER TILE      | CER TILE  | PAINTED / CER TILE | VINYL FACED GYPSUM PANEL   | 10'-0"        |                 |
| BASE BID         | 102  | B SHOWERS         | CER TILE      | CER TILE  | PAINTED / CER TILE | PNT M.R. GYPBOARD          | 9'-0"         |                 |
| BASE BID         | 103  | A MEN             | CER TILE      | CER TILE  | PAINTED / CER TILE | VINYL FACED GYPSUM PANEL   | 10'-0"        |                 |
| BASE BID         | 103  | B SHOWERS         | CER TILE      | CER TILE  | PAINTED / CER TILE | PNT M.R. GYPBOARD          | 9'-0"         |                 |
| BASE BID         | 104  | CONCESSIONS       | LCT           | 4" RUBBER | PAINTED GYPBOARD   | ACOUSTICAL TILE            | 10'-0"        |                 |
| BASE BID         | 105  | MANAGER           | LCT           | 4" RUBBER | PAINTED GYPBOARD   | ACOUSTICAL TILE            | 10'-0"        |                 |
| BASE BID         | 106  | STORAGE           | LCT           | 4" RUBBER | PAINTED GYPBOARD   | ACOUSTICAL TILE            | 10'-0"        |                 |
| BASE BID         | 107  | MECHANICAL        | SEALED CONC.  | NONE      | NONE               | EXPOSED STRUCTURE          | VARIES        |                 |
| BASE BID         | 108  | FAMILY RESTROOM   | CER TILE      | CER TILE  | PAINTED / CER TILE | VINYL FACED GYPSUM PANEL   | 9'-0"         |                 |
| BASE BID         | 109  | A ACTIVITY ROOM   | SPORTS FLOOR  | 4" RUBBER | PAINTED GYPBOARD   | ACOUSTICAL TILE            | 10'-0"        | SPEC SECT 09624 |
| BASE BID         | 109  | B STORAGE         | LCT           | 4" RUBBER | PAINTED GYPBOARD   | ACOUSTICAL TILE            | 10'-0"        |                 |
| BASE BID         | 110  | MECHANICAL        | SEALED CONC.  | NONE      | NONE               | EXPOSED STRUCTURE          | VARIES        |                 |
| BASE BID         | 111  | A ACTIVITY ROOM   | SPORTS FLOOR  | 4" RUBBER | PAINTED GYPBOARD   | ACOUSTICAL TILE            | 10'-0"        | SPEC SECT 09624 |
| BASE BID         | 111  | B STORAGE         | LCT           | 4" RUBBER | PAINTED GYPBOARD   | ACOUSTICAL TILE            | 10'-0"        |                 |
| BASE BID         | 112  | JANITOR / STORAGE | CER TILE      | CER TILE  | PAINTED / CER TILE | VINYL FACED GYPSUM PANEL   | 10'-0"        |                 |
| BASE BID         | 113  | NOT USED          | NOT USED      | NOT USED  | NOT USED           | NOT USED                   | NOT USED      |                 |
| BASE BID         | 114  | GYMNASIUM         | WOOD FLOORING | 4" RUBBER | PAINTED GYPBOARD   | PNT STRUCT / SIMPLE SAVER  | VARIES        | SPEC SECT 09550 |
| BASE BID         | 115  | ELECTRICAL        | SEALED CONC.  | NONE      | NONE               | EXPOSED STRUCTURE          | VARIES        |                 |
| BASE BID         | 116  | SPRINKLER RISER   | SEALED CONC.  | NONE      | NONE               | EXPOSED STRUCTURE          | VARIES        |                 |
| BASE BID         | 117  | STORAGE           | LCT           | 4" RUBBER | PAINTED GYPBOARD   | ACOUSTICAL TILE            | 10'-0"        |                 |
| BASE BID         | 118  | AV / IT           | SEALED CONC.  | NONE      | NONE               | EXPOSED STRUCTURE          | VARIES        |                 |
| ALTERNATE        | 119  | CORRIDOR          | LCT           | 4" RUBBER | PAINTED GYPBOARD   | ACOUSTICAL TILE            | 10'-0"        |                 |
| ALTERNATE        | 120  | STORAGE           | LCT           | 4" RUBBER | PAINTED GYPBOARD   | ACOUSTICAL TILE            | 10'-0"        |                 |
| ALTERNATE        | 121  | A ACTIVITY ROOM   | SPORTS FLOOR  | 4" RUBBER | PAINTED GYPBOARD   | ACOUSTICAL TILE            | 10'-0"        | SPEC SECT 09624 |
| ALTERNATE        | 121  | B STORAGE         | LCT           | 4" RUBBER | PAINTED GYPBOARD   | ACOUSTICAL TILE            | 10'-0"        |                 |
| ALTERNATE        | 121  | C MECHANICAL      | SEALED CONC.  | NONE      | NONE               | EXPOSED STRUCTURE          | VARIES        |                 |
| ALTERNATE        | 122  | A ACTIVITY ROOM   | SPORTS FLOOR  | 4" RUBBER | PAINTED GYPBOARD   | ACOUSTICAL TILE            | 10'-0"        | SPEC SECT 09624 |
| ALTERNATE        | 122  | B STORAGE         | LCT           | 4" RUBBER | PAINTED GYPBOARD   | ACOUSTICAL TILE            | 10'-0"        |                 |
| ALTERNATE        | 123  | MECHANICAL        | SEALED CONC.  | NONE      | NONE               | EXPOSED STRUCTURE          | VARIES        |                 |
| ALTERNATE        | 124  | A ACTIVITY ROOM   | SPORTS FLOOR  | 4" RUBBER | PAINTED GYPBOARD   | ACOUSTICAL TILE            | 10'-0"        | SPEC SECT 09624 |
| ALTERNATE        | 124  | B STORAGE         | LCT           | 4" RUBBER | PAINTED GYPBOARD   | ACOUSTICAL TILE            | 10'-0"        |                 |
| ALTERNATE        | 125  | STORAGE           | LCT           | 4" RUBBER | PAINTED GYPBOARD   | ACOUSTICAL TILE            | 10'-0"        |                 |

NOTES

- 1 GYPBOARD CEILINGS AND BULKHEADS: PAINT FLAT WHITE LATEX, NO TEXTURE, USE STRAIGHT CORNER BEADS, NO BULLNOSE EXCEPT WHERE INDICATED

WALL LEGEND

- 1 BRICK AND METAL CLADDING WITH AIRSPACE OVER XPS INSULATION ON 5/8" SHEATHING ON 8" METAL STUDS WITH INSULATION AS SPECIFIED. INTERIOR FINISHES AS SCHEDULED.
- 2 8" METAL STUD WALL WITH GYPBOARD EACH SIDE WITH SOUND ATTENUATION BATTS
- 3 5/8" METAL STUD WALL WITH GYPBOARD EACH SIDE WITH SOUND ATTENUATION BATTS
- 4 TWO HOUR RATED FIRE BARRIER

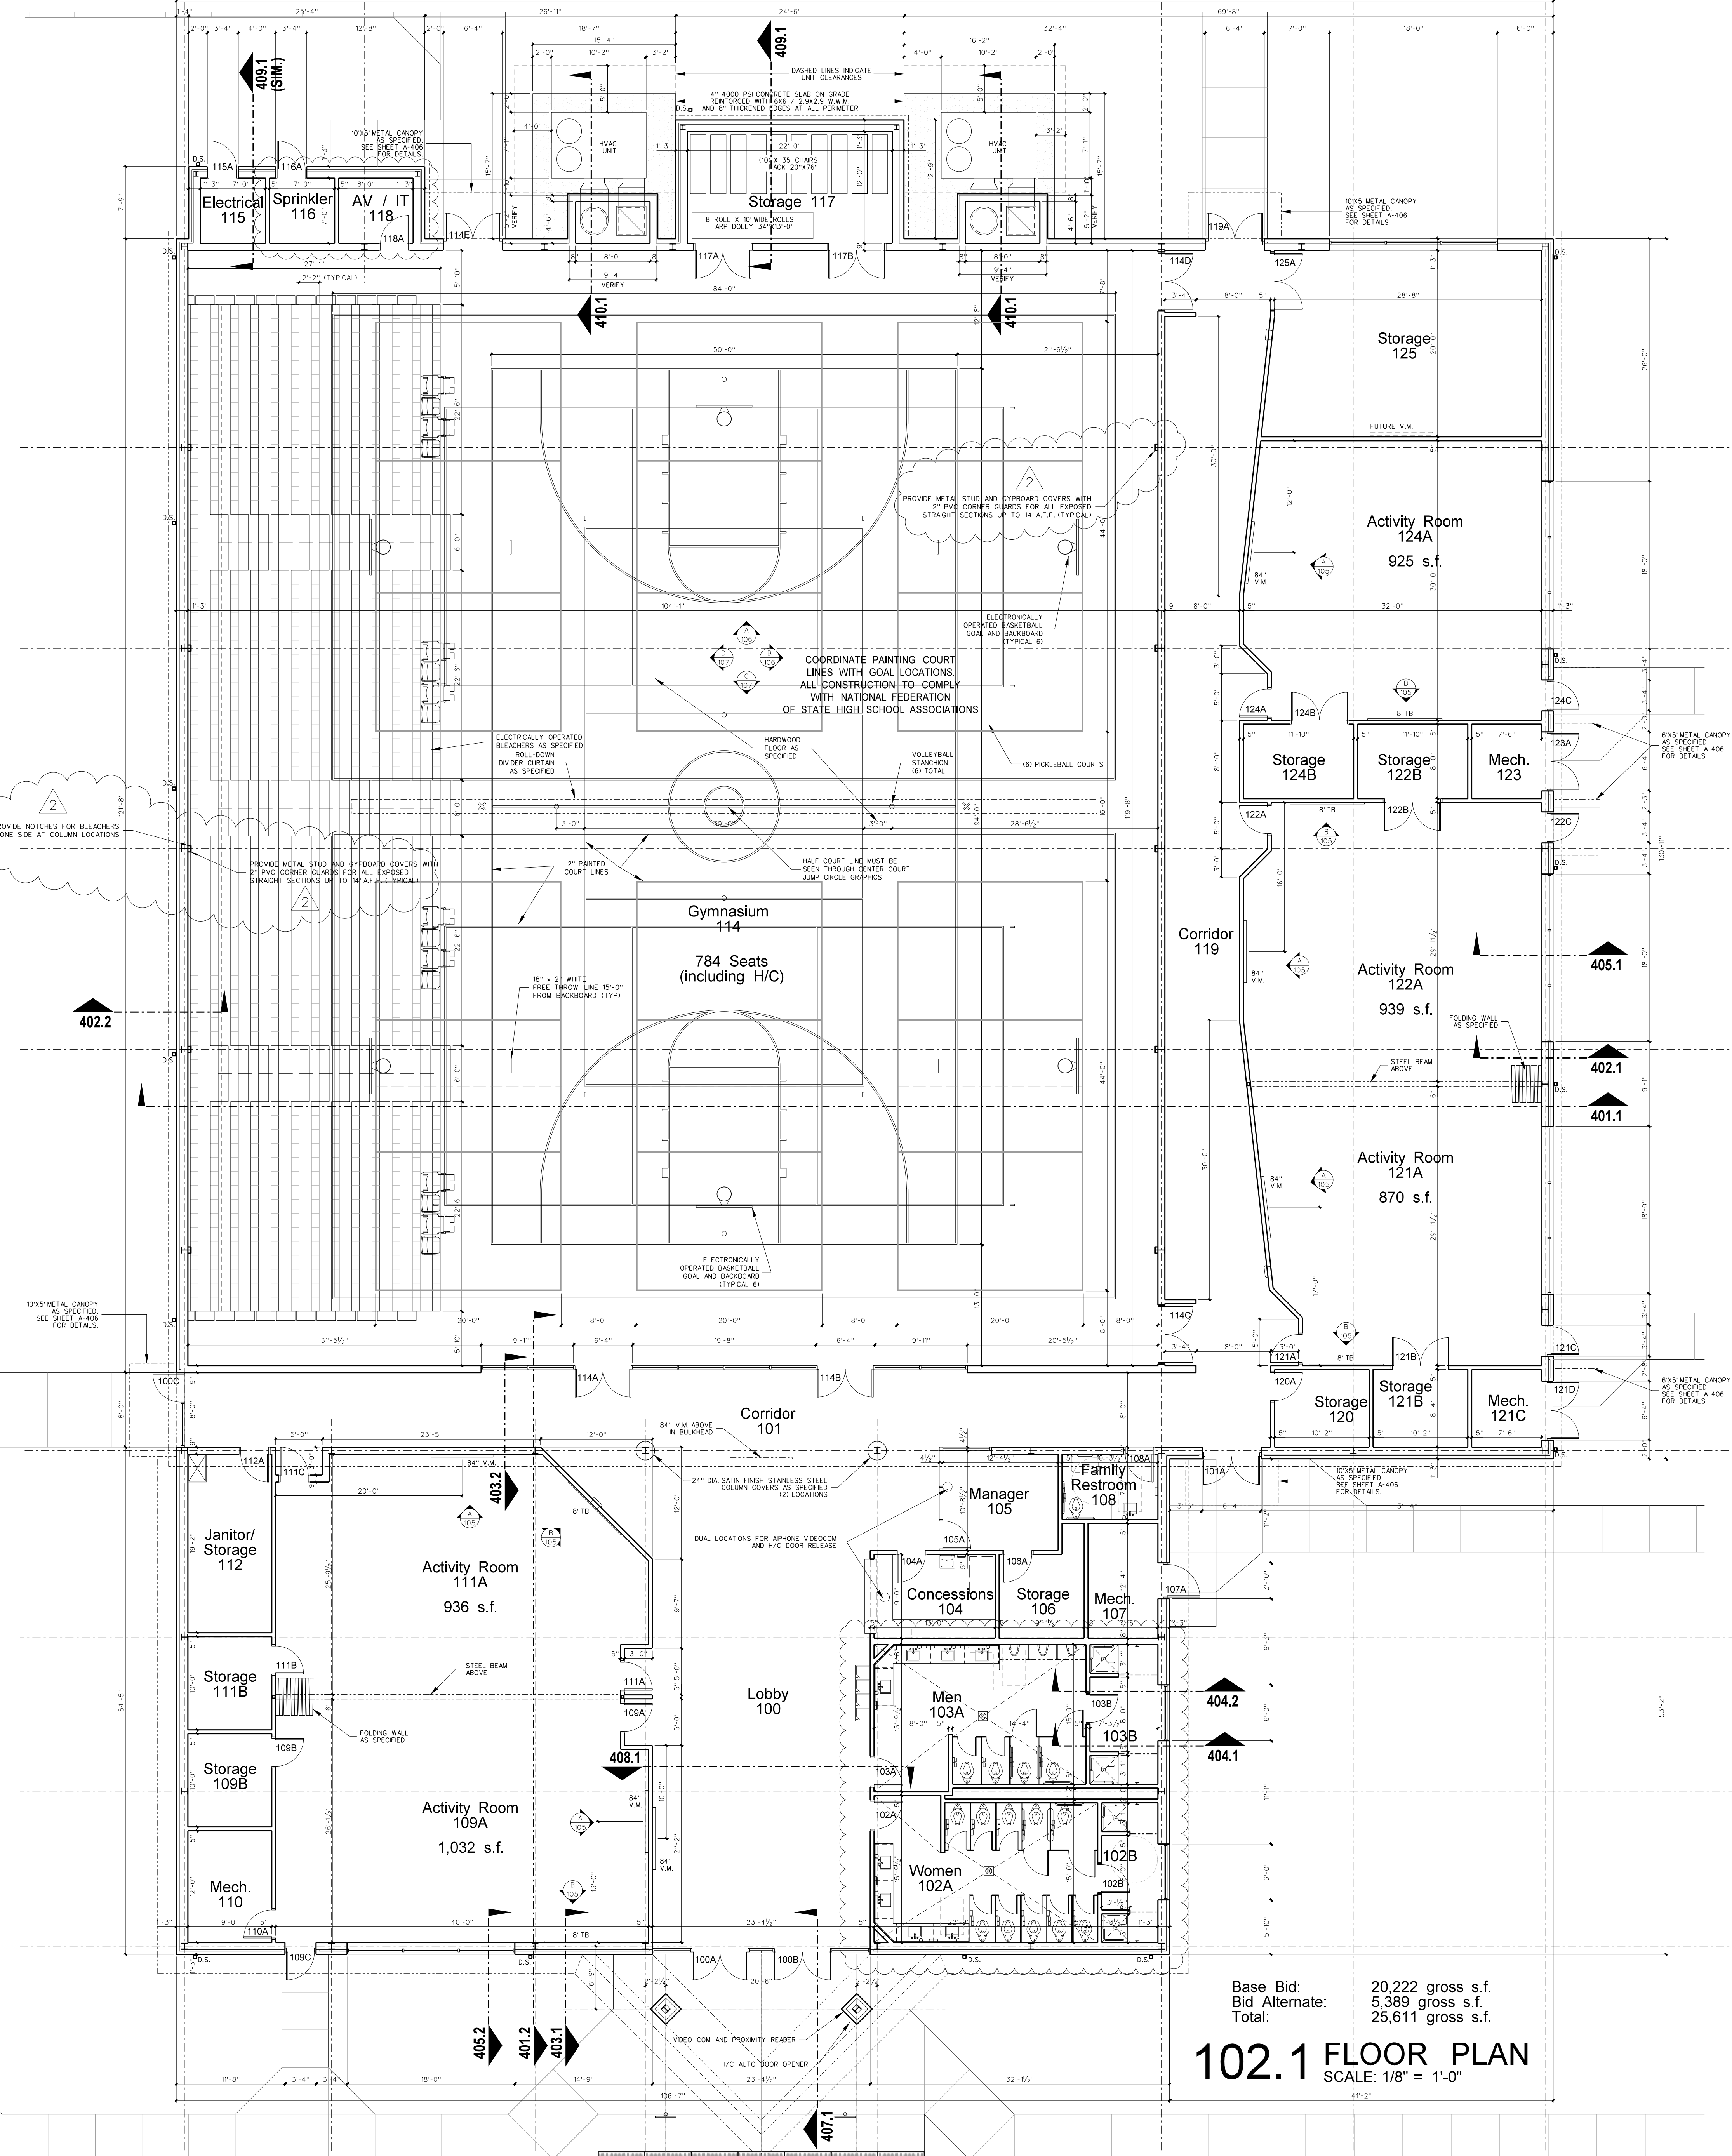

Base Bid: 20,222 gross s.f.  
Bid Alternate: 5,389 gross s.f.  
Total: 25,611 gross s.f.

102.1 FLOOR PLAN  
SCALE: 1/8" = 1'-0"

|             |              |
|-------------|--------------|
| Project No. | 22248        |
| Date:       | 31 July 2023 |
| Drawing no. | A 102        |
| ALTERNATE   |              |

**Hite associates**  
ARCHITECTURE / PLANNING / TECHNOLOGY  
2600 Meridian Drive / Greenville, NC 27834 / tel (252) 757-0333

COMMUNITY CENTER AND GYMNASIUM FOR  
**Pitt County Office Park**  
Government Ctr., Greenville, NC 27658

Project No. 22248  
Date: 31 July 2023  
Drawing no. A 102  
ALTERNATE