


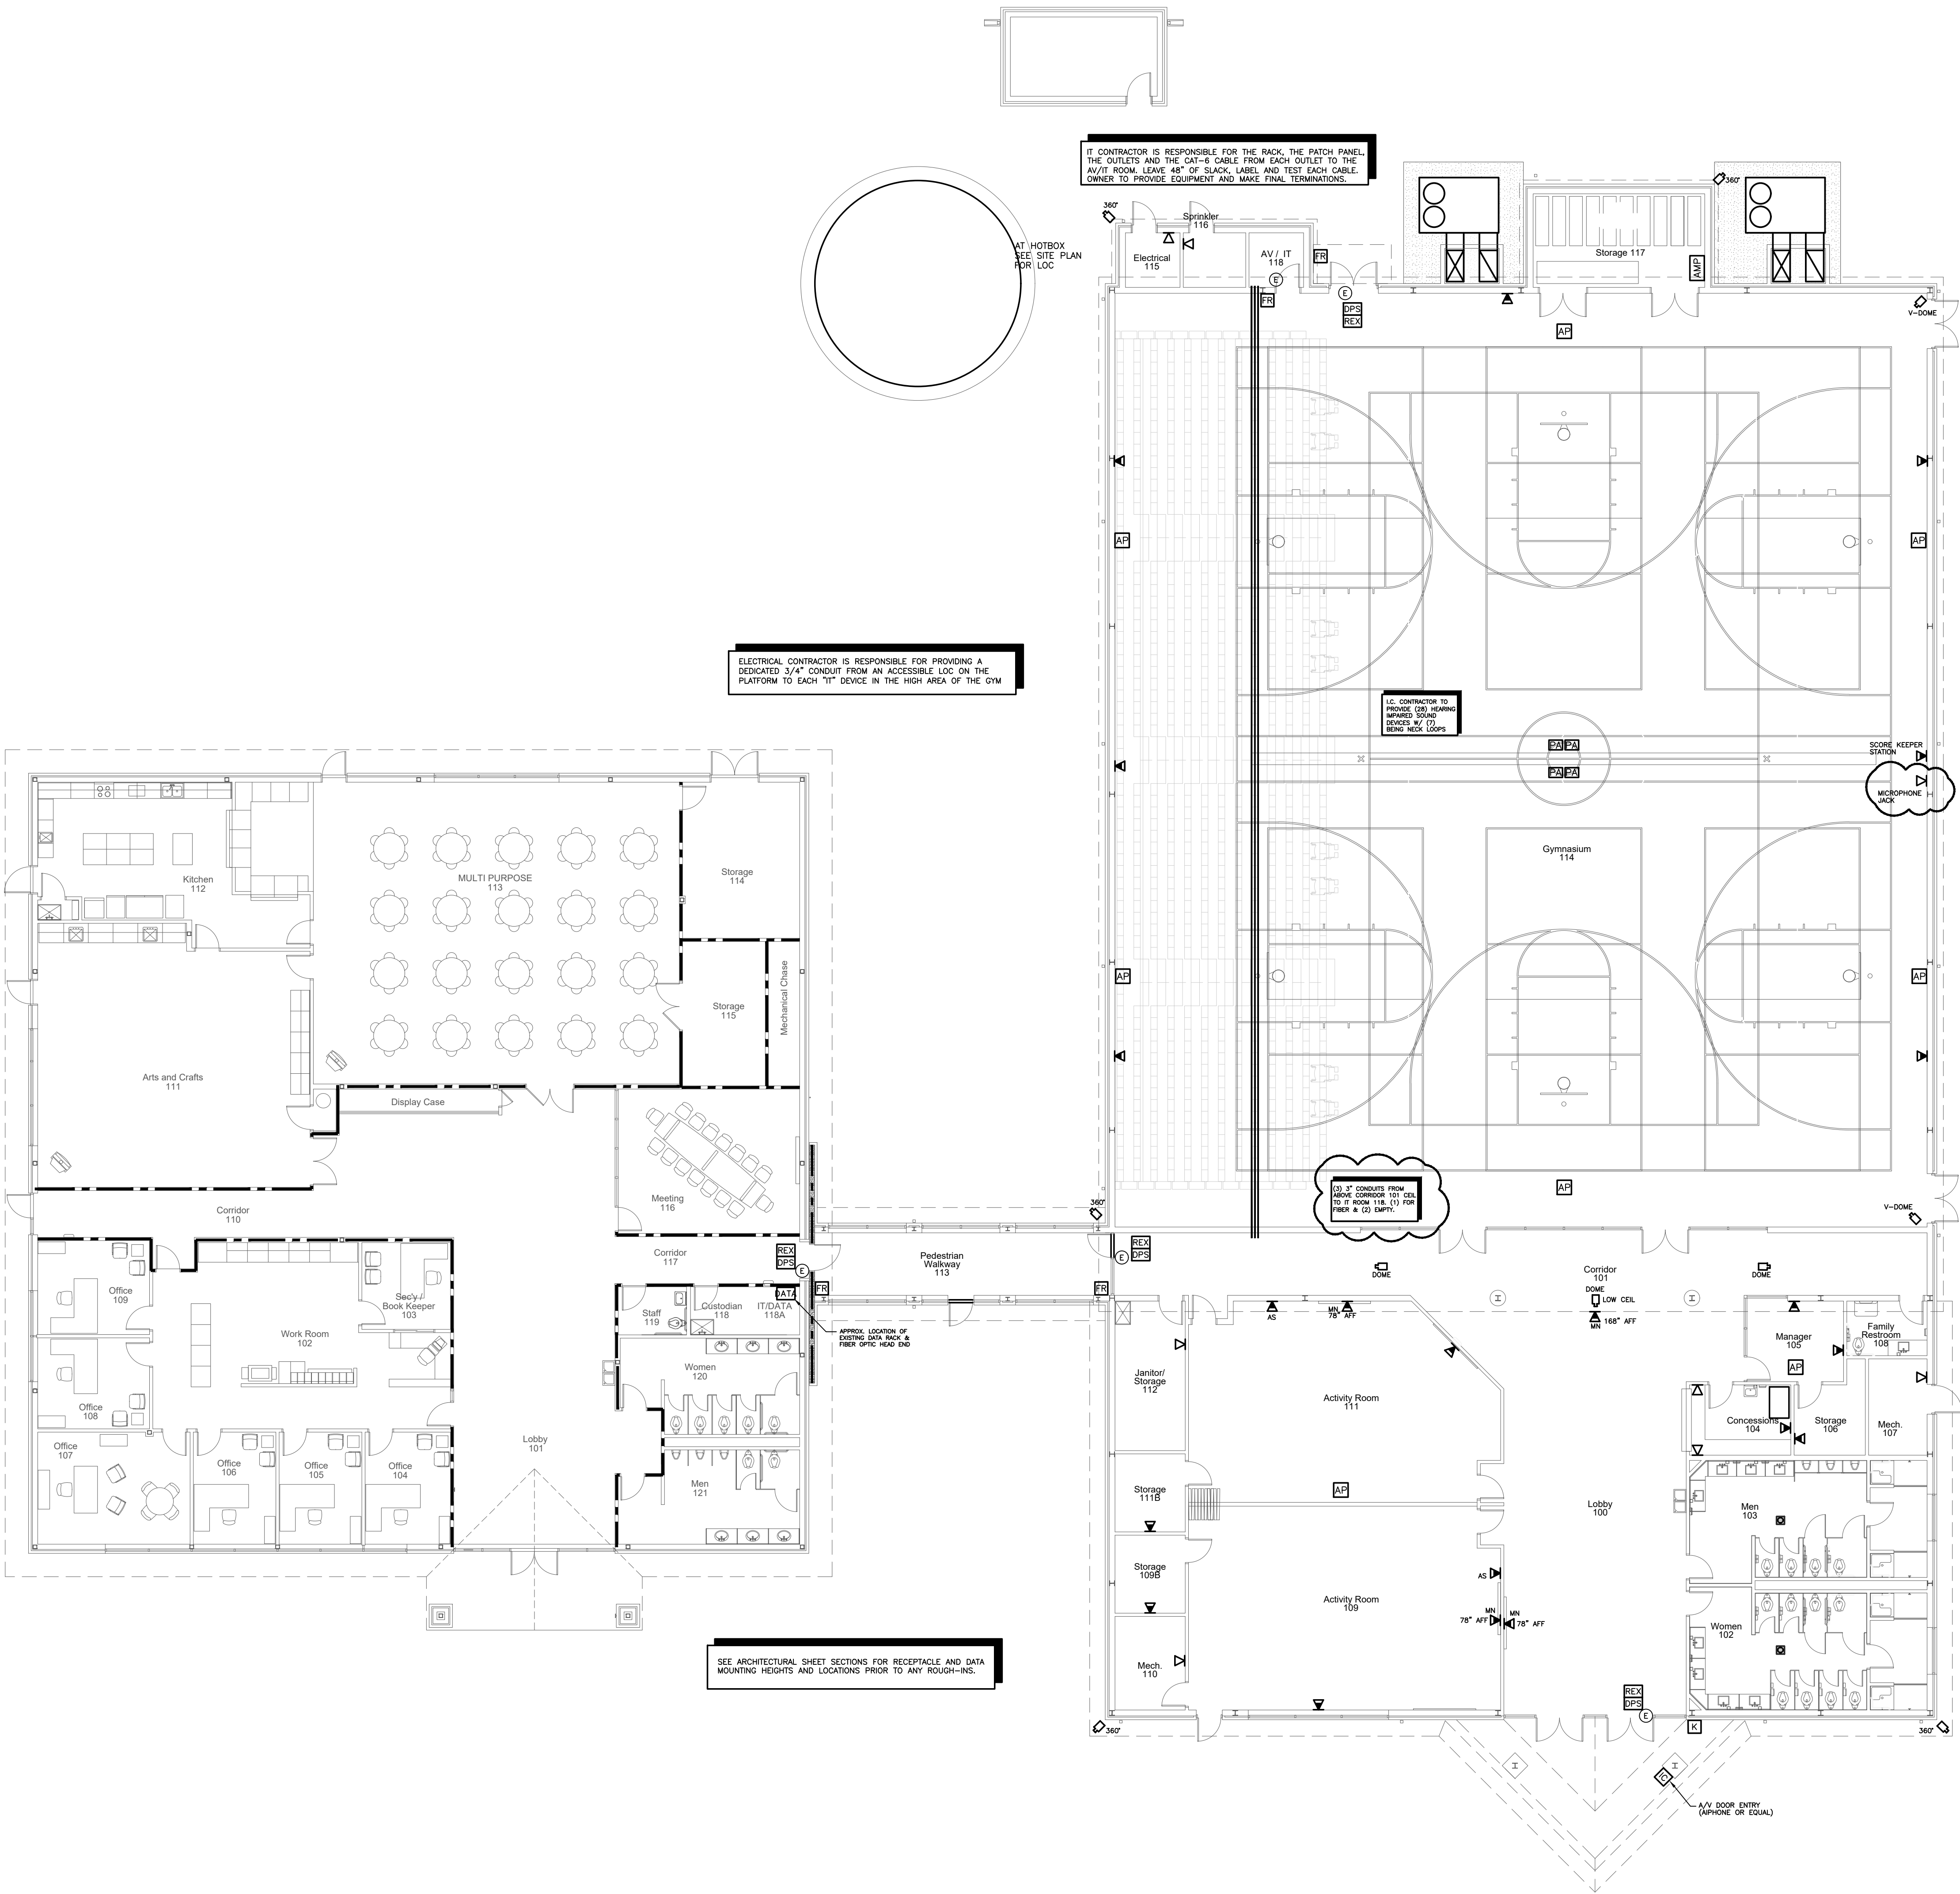

TECHNOLOGY PLAN (BASE BID)
SCALE: 3/32" = 1'-0"

Project No. ES22044

ENGINEERING
S O U R C E of NC, P.A.
102-A2 Regency Blvd., Greenville, NC 27834
E-Mail Address: generalm@engrsource.com
Tel (252) 438-0258 • Fax (252) 438-0462 • Twp 12-103

9/12/23


THIS DRAWING IS THE PROPERTY OF ENGINEERING SOURCE of NC, P.A. THIS DRAWING IS NOT TO BE COPIED IN WHOLE OR IN PART. THIS DRAWING OR THE INFORMATION HEREUPON IS NOT TO BE USED ON ANY OTHER PROJECT AND MUST BE RETURNED TO ENGINEERING SOURCE of NC, P.A. UPON REQUEST. DO NOT SCALE THESE DRAWINGS. REFER TO ARCHITECTURAL DRAWINGS FOR EXACT DIMENSIONS.

COMMUNITY CENTER AND GYMNASIUM FOR
Alice F. Keene District Park
4561 County Home Road, Greenville, NC 27858

Project No. 22207

Date: July 2023

Drawing no. IT 101

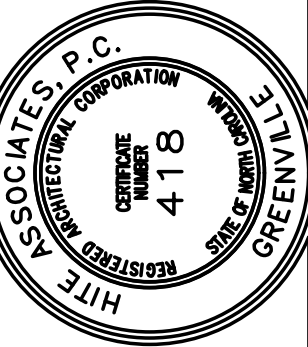

Hite associates
ARCHITECTURE / PLANNING / TECHNOLOGY
2600 Meridian Drive / Greenville, NC 27834 / tel (252) 757-0333

No.	Date	Revision
1	9/12/23	PRE-BID INFO & ADDENDUM #1